


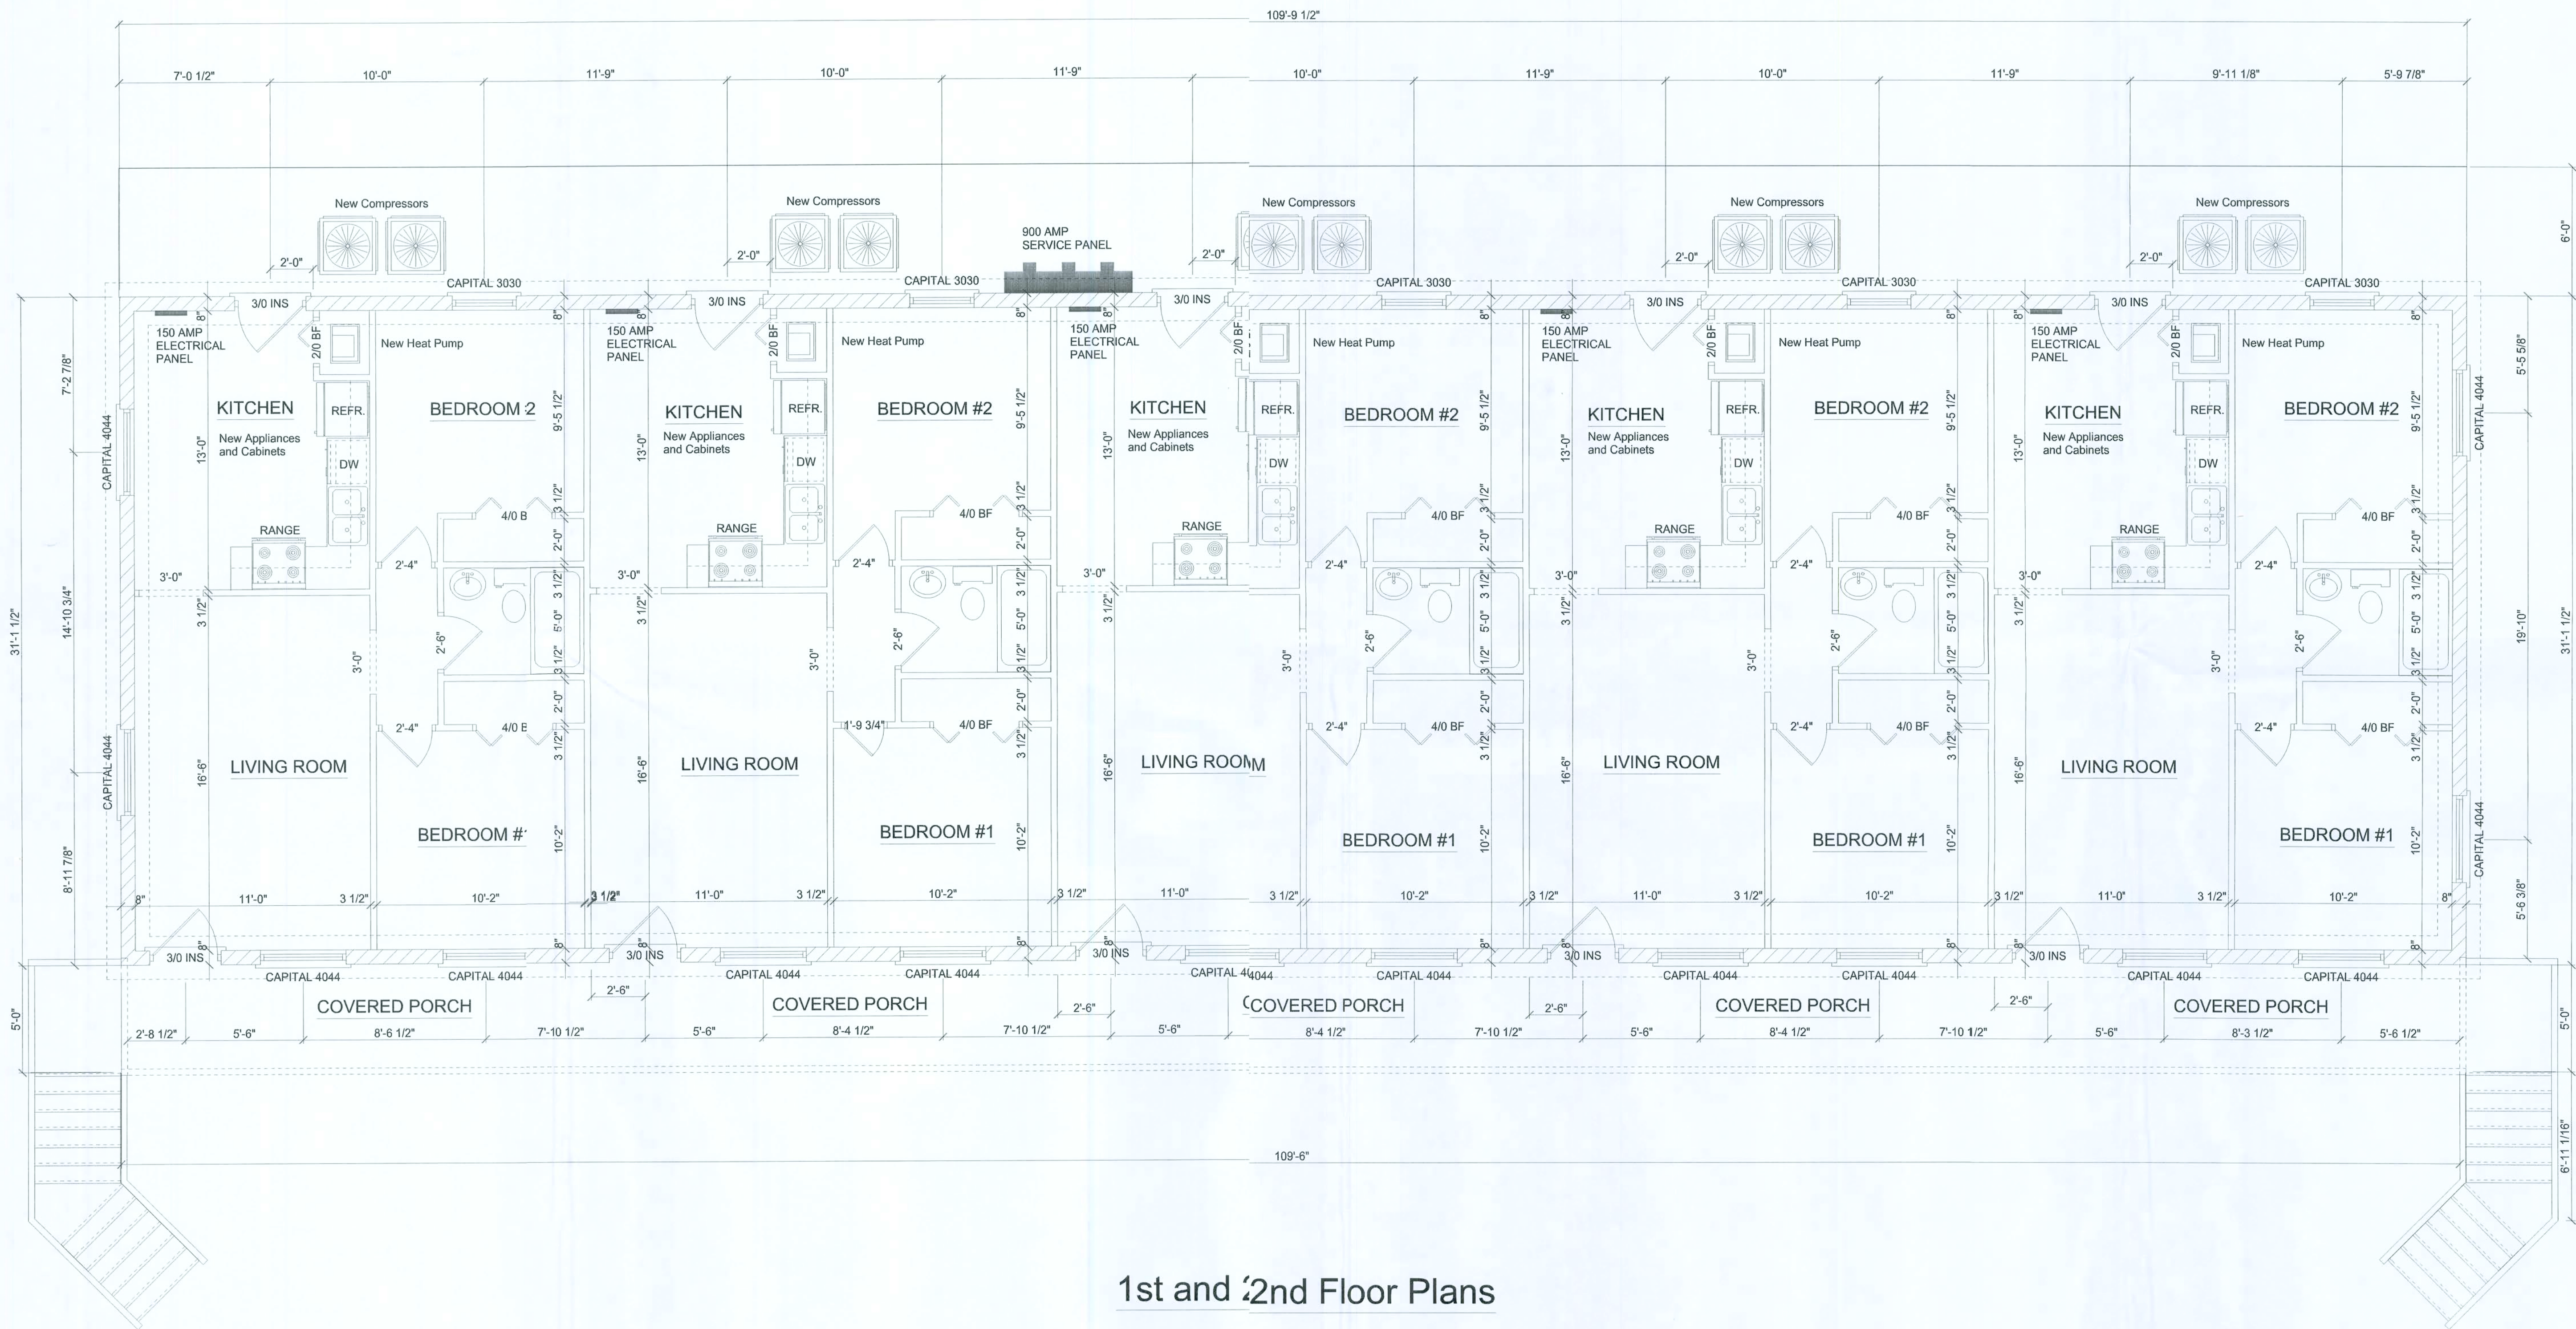

NOTES:


ALL WORK SHALL COMPLY WITH THE LATEST EDITIONS OF THE INTERNATIONAL BUILDING CODE AND ALL OTHER APPLICABLE LOCAL CODES AND ORDINANCES

AREA SUMMARY
Living Area 684 sf per unit
1st Floor 3414 SF
2nd Floor 3414 SF
Porches 550 SF
TOTAL AREA 7378 SF

East Side Renovation
Stephen Crawford Construction, Inc. Lake City, Florida.
PLANS BY: Stephen Crawford

MAIN FLOOR PLAN
SCALE 1/4" = 1'-0"

@ DATE
@ TIME
SHEET #

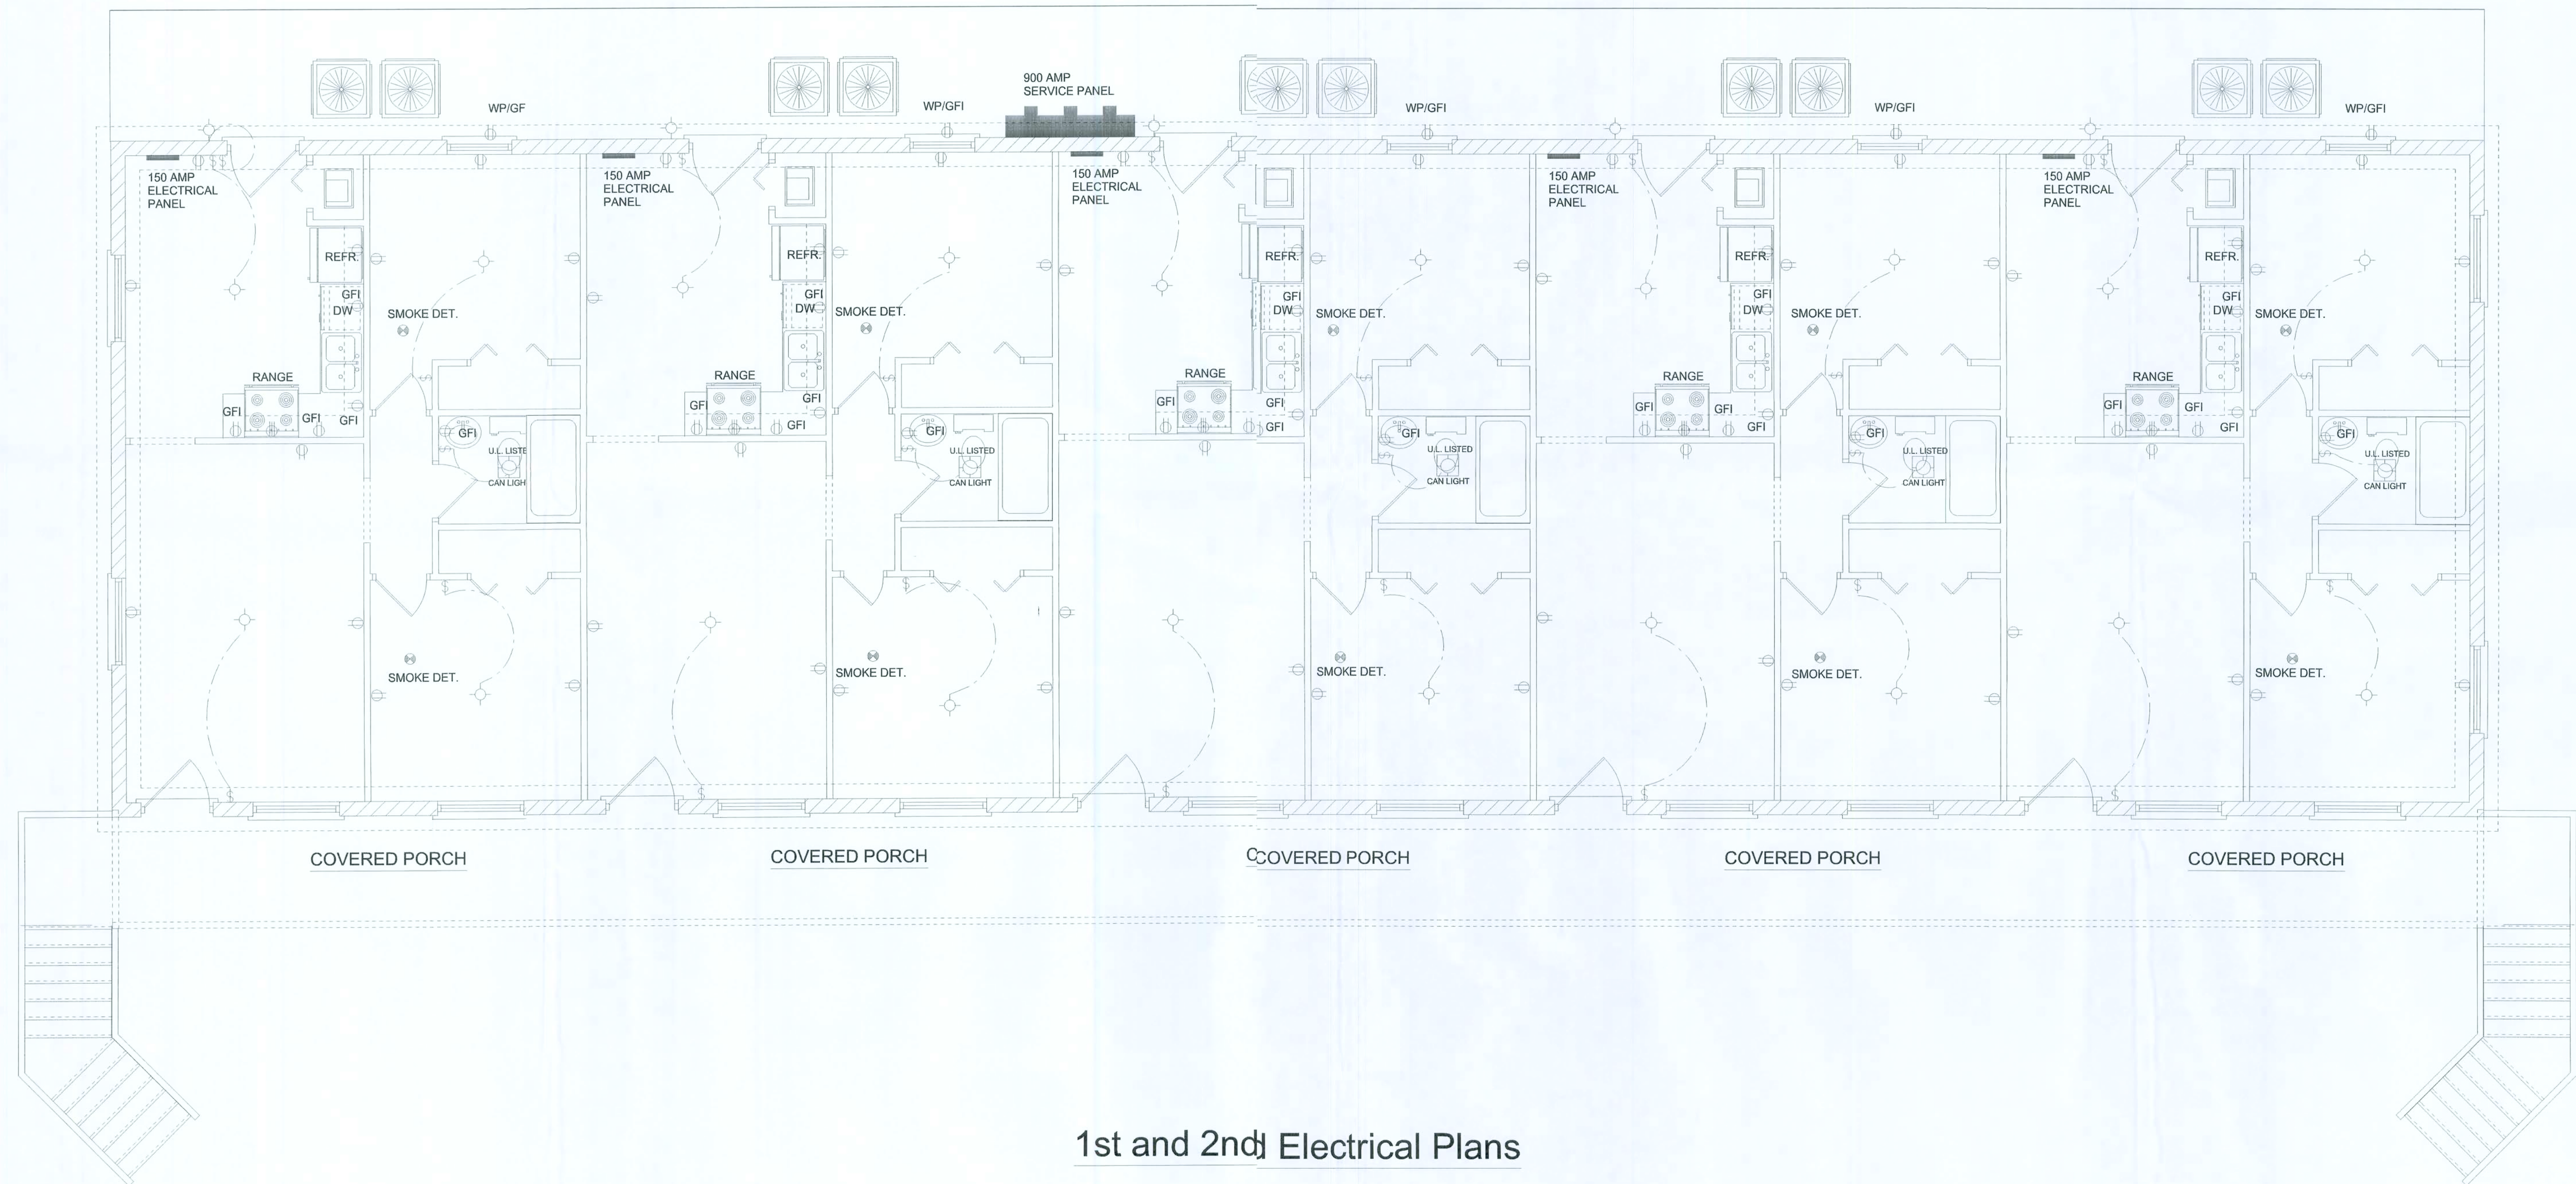

1st and 2nd Electrical Plans

ELECTRICAL PLAN
SCALE 1/4" = 1'-0"

@ DATE
@ TIME

SHEET #

2

East Side Renovation

Stephen Crawford Construction, Inc. Lake City, Florida.
PLANS BY: Stephen Crawford

AREA SUMMARY

Living Area 684 sf per unit
1st Floor 3414 SF
2nd Floor 3414 SF
Porches 550 SF
TOTAL AREA 7378 SF

NOTES:

ALL WORK SHALL COMPLY WITH
THE STANDARD BUILDING CODE
AND ALL OTHER APPLICABLE
LOCAL CODES AND ORDINANCES