


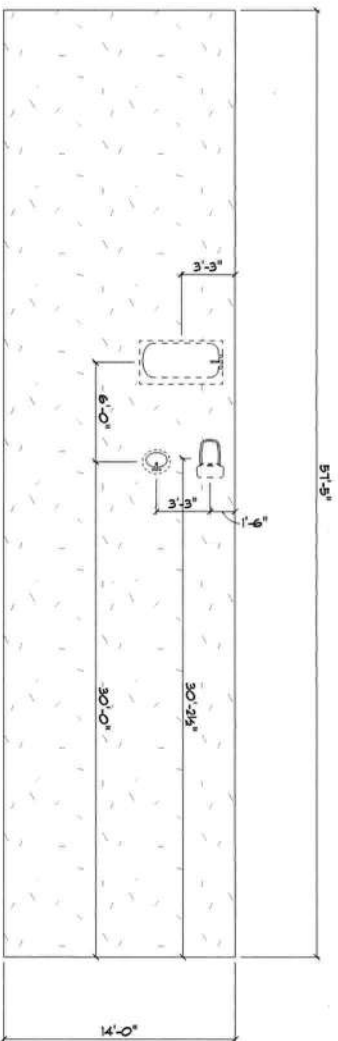

• BONUS AREA •
• PLUMBING PLAN •
SCALE: 3/16" = 1'-0"


NEW RESIDENCE
for
STANLEY & BEVERLY
POPE

6449 NW NOBLE RD
LAKE CITY, FL 32099

THOMAS H. RUFFO
2025 800 686 4737
LAKESIDE DESIGN GROUP
Call: (766) 867-1181
Email: tomruffo@gmail.com

ISSUED DATE: Wednesday, June 5, 2024
DRAWN BY: THOMAS H. RUFFO
CHECKED BY: []
BUILDING CONSTRUCTION

PLUMB DATE: []
JOB NUMBER: []
DRAWING NUMBER
A-3
OF 3 SHEETS

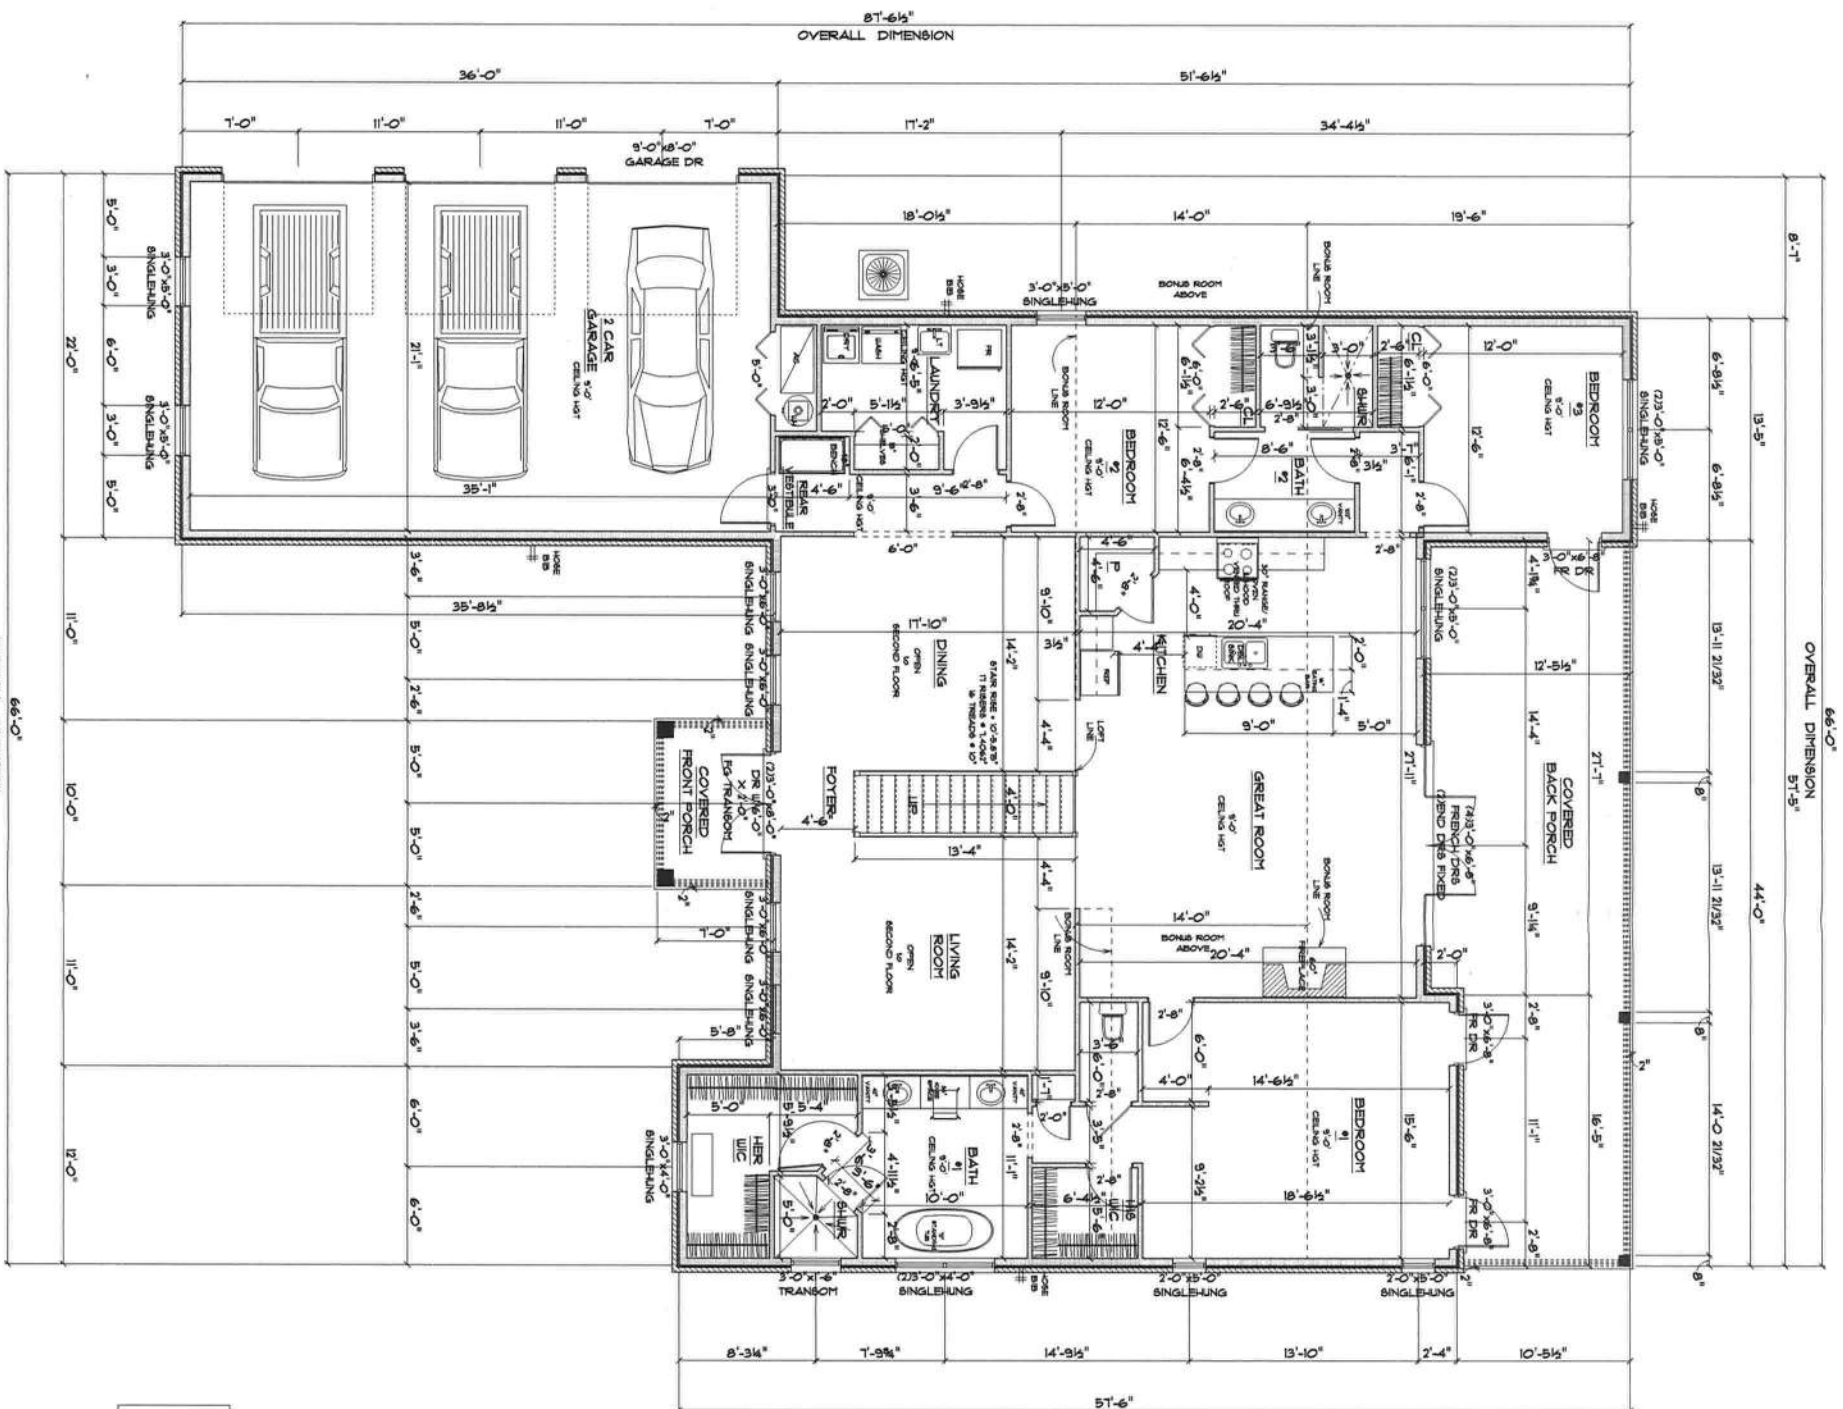

• MAIN LEVEL •
• FLOOR PLAN •

SCALE: 3/16" = 1'-0"

A/C LIVING AREA	292 S.F.
COVERED FRONT PORCH	231 S.F.
COVERED BACK PORCH	196 S.F.
TRANSOM	12 S.F.
TOTAL AREA UNDER ROOF	531 S.F.


IMPORTANT NOTES:
1. IT IS THE BUILDER'S RESPONSIBILITY TO VERIFY ALL GEOMETRY AND DIMENSIONS BEFORE ORDERING ANY MATERIALS OR BEGINNING CONSTRUCTION.
2. THESE PLANS ARE FOR LAYOUT AND DESIGN PURPOSES ONLY. ALL STRUCTURAL NOTES AND DETAILS TO BE PROVIDED BY AN ENGINEER.
3. ALL EXTERIOR WALLS ARE 8" CMU.
4. ALL INTERIOR DOORS ARE 6'-0".

NEW RESIDENCE
for
STANLEY & BEVERLY
POPE
649 N. NOBLE RD
LAKE CITY, TN 37093

THOMAS H. RUFFO
209 S. 4th St.
LAKE CITY, TN 37093
Cell: (615) 967-1181
Email: terradiff@gmail.com

PRINTED DATE:
Wednesday, June 5, 2024
DRAWN BY: [Signature]
CHECKED BY: [Signature]

PROJECT DATE:
JOB NUMBER:
DRAWING NUMBER
A-4
OF 3 SHEETS

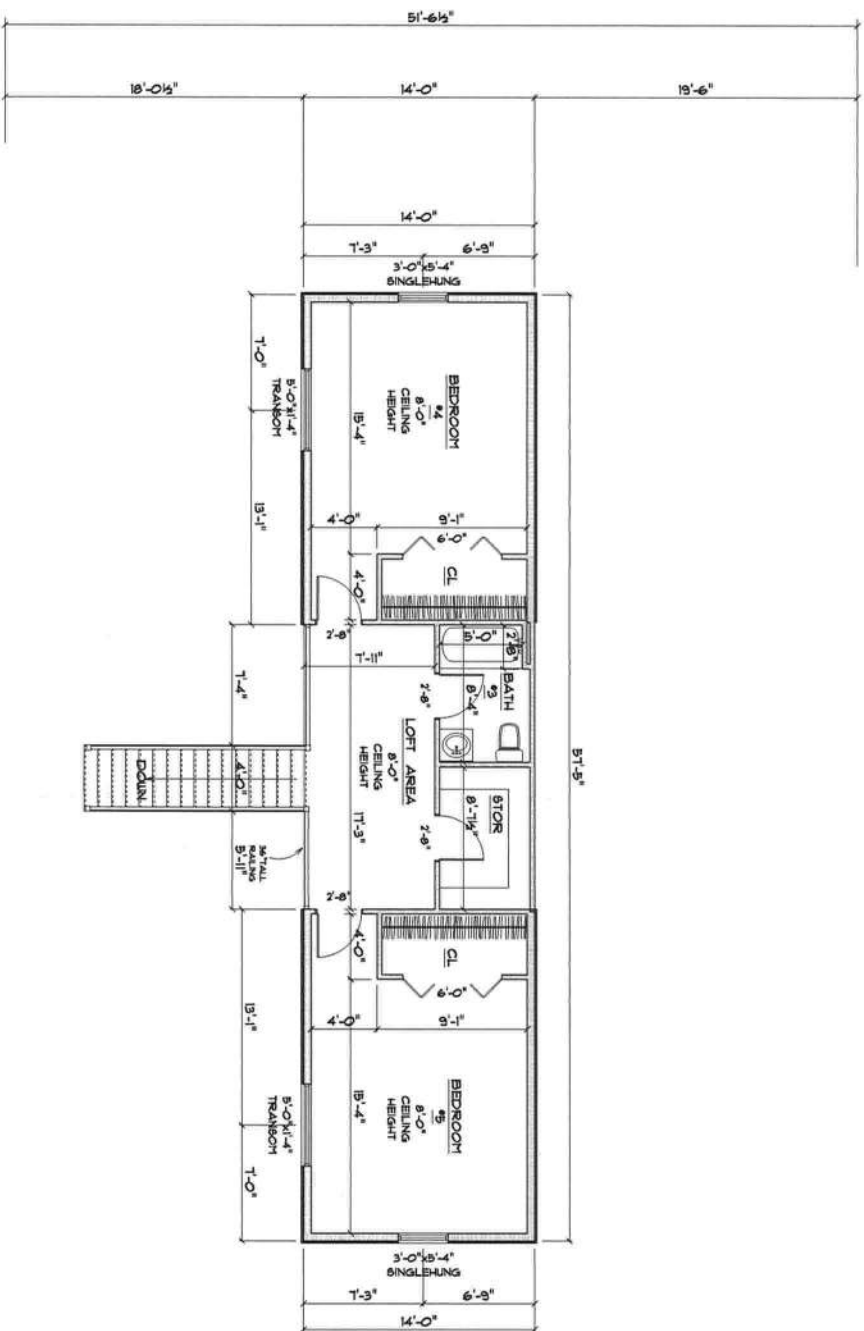

• BONUS AREA •
• FLOOR PLAN •
SCALE: 3/16" = 1'-0"

NEW RESIDENCE
for
STANLEY & BEVERLY
POPE

649 N. NOBEL RD
LAKE CITY, FL 32085

Team: H. Ruffo
2025 001 004 47
Lake City, FL 32085
Call: (386) 867-1181
Email: team@hcruffo.com

PRINTED DATE:
Wednesday, June 5, 2024
DRAWN BY: CHECKED BY:
Team: H. Ruffo

BONUS CONSTRUCTION


FINAL DATE:

JOB NUMBER:

DRAWING NUMBER

A-5


OF 9 SHEETS

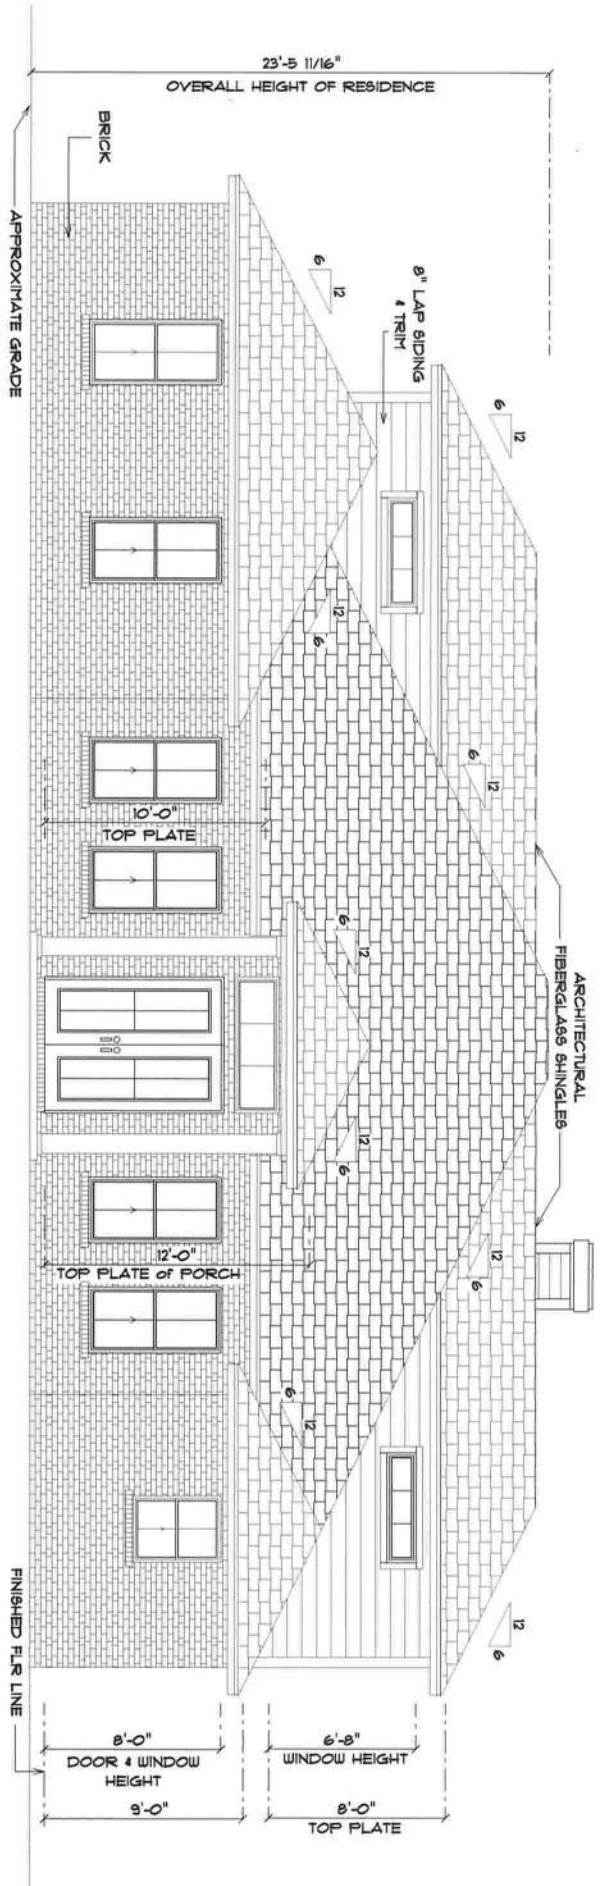

* FRONT ELEVATION *

SCALE : 1/4" = 1'-0"

NOTE: 18" OVERHANGS

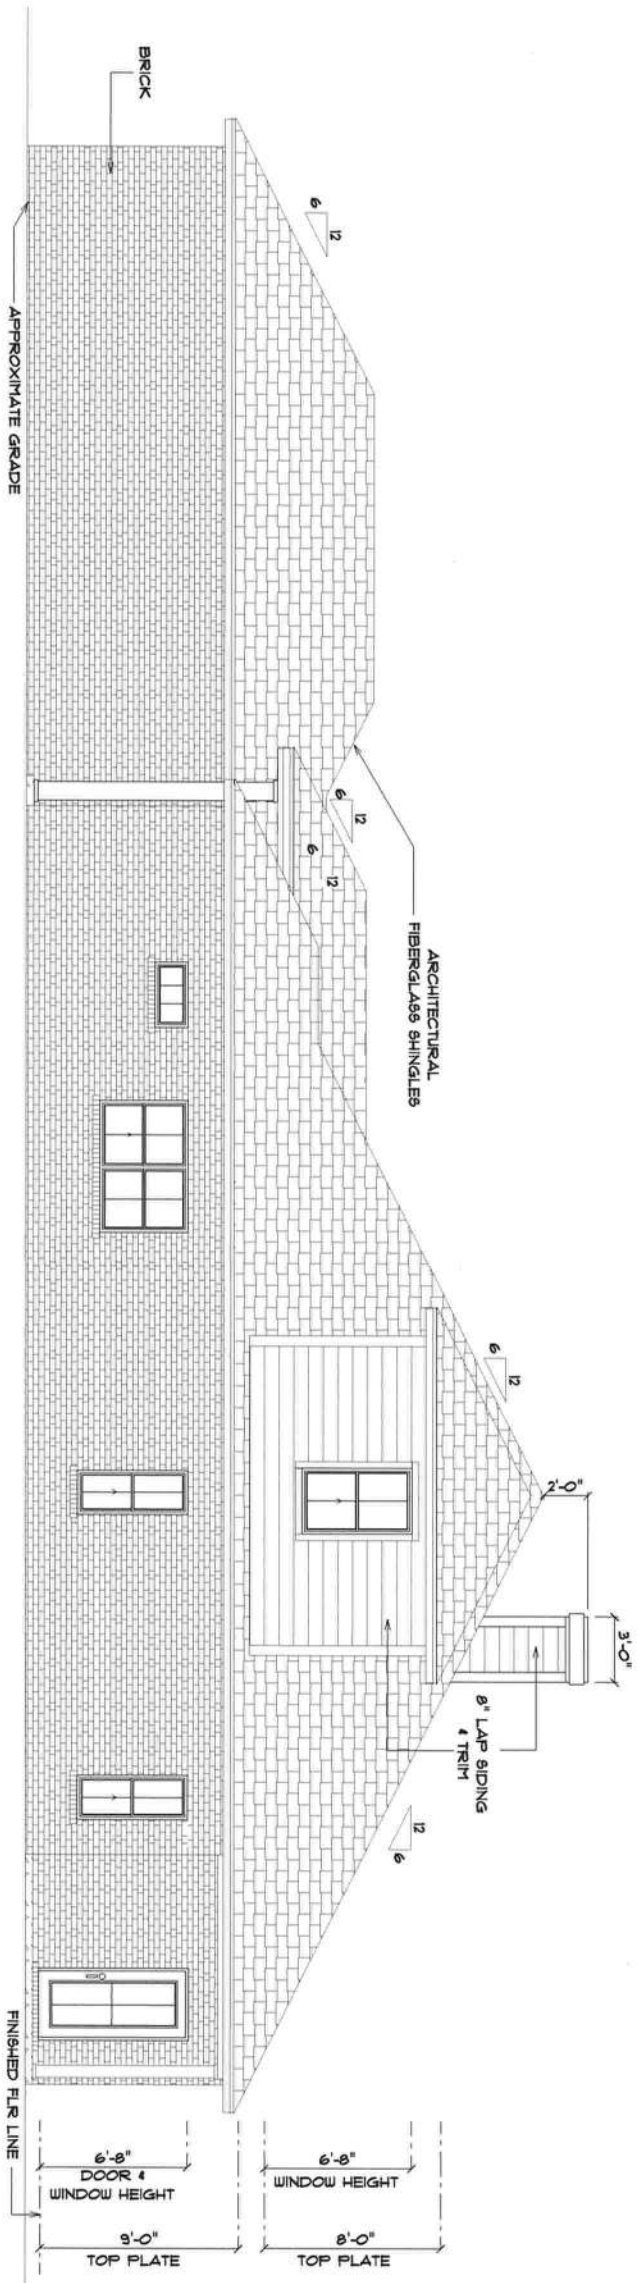

* RIGHT ELEVATION *

SCALE : 1/4" = 1'-0"

NOTE: 18" OVERHANGS

NEW RESIDENCE
for
STANLEY & BEVERLY
POPE

649 N. MOORE RD
LAKE CITY, 30028

THOMAS H. RUFFO
2025 SU DR 47
LAKE CITY, 30028
Cell: 706.467.1181
Email: thomashruffo@gmail.com

PROJECT DATE:
Wednesday, June 5, 2024

DRAWN BY: CHECKED BY:

THOMAS H. RUFFO

BUILDING CONSTRUCTION


PROJECT DATE:

JOB NUMBER:

DRAWING NUMBER:

A-6


OF 3 SHEETS

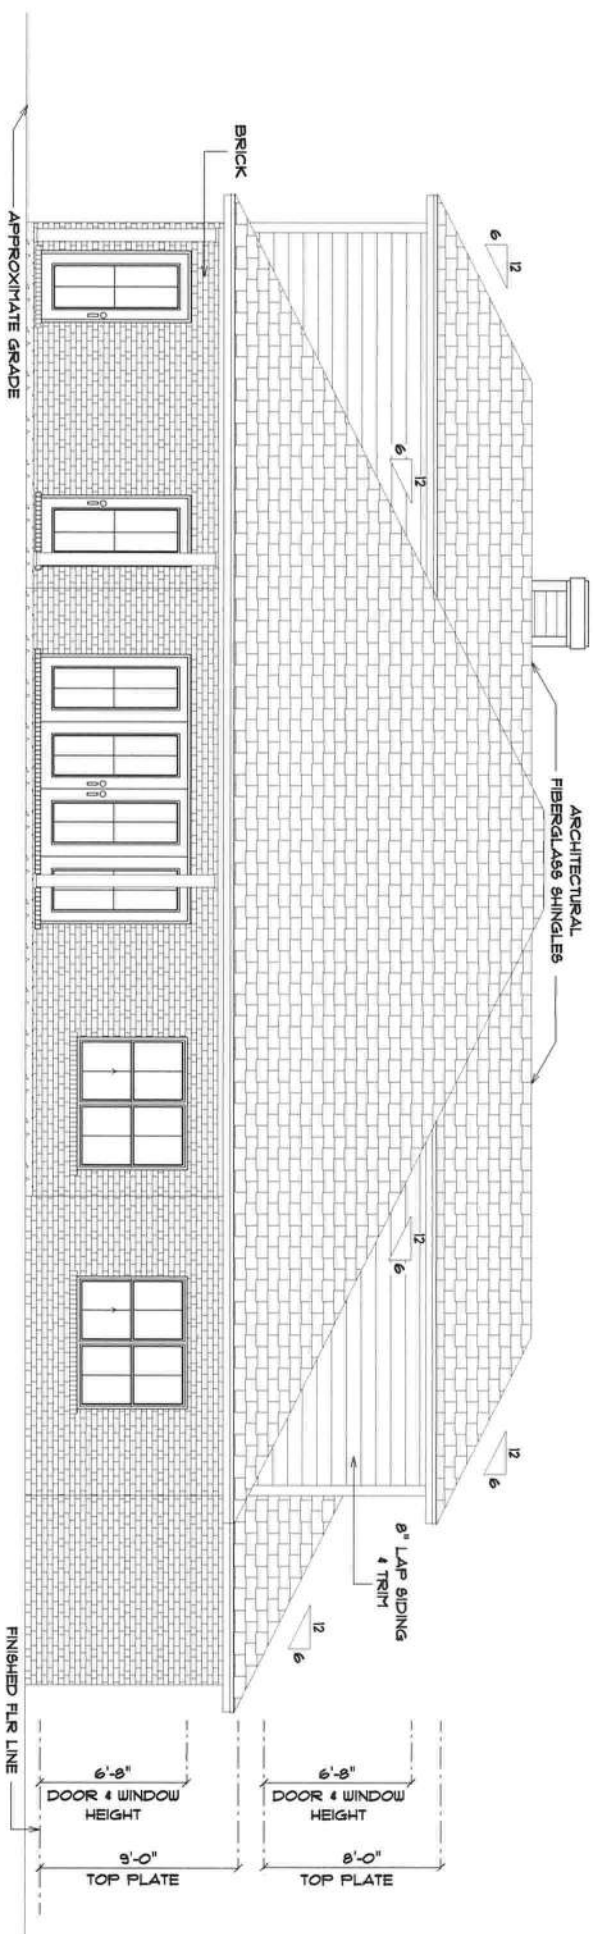

REAR ELEVATION

SCALE : 1/4" = 1'-0"

NOTE: 18" OVERHANGS

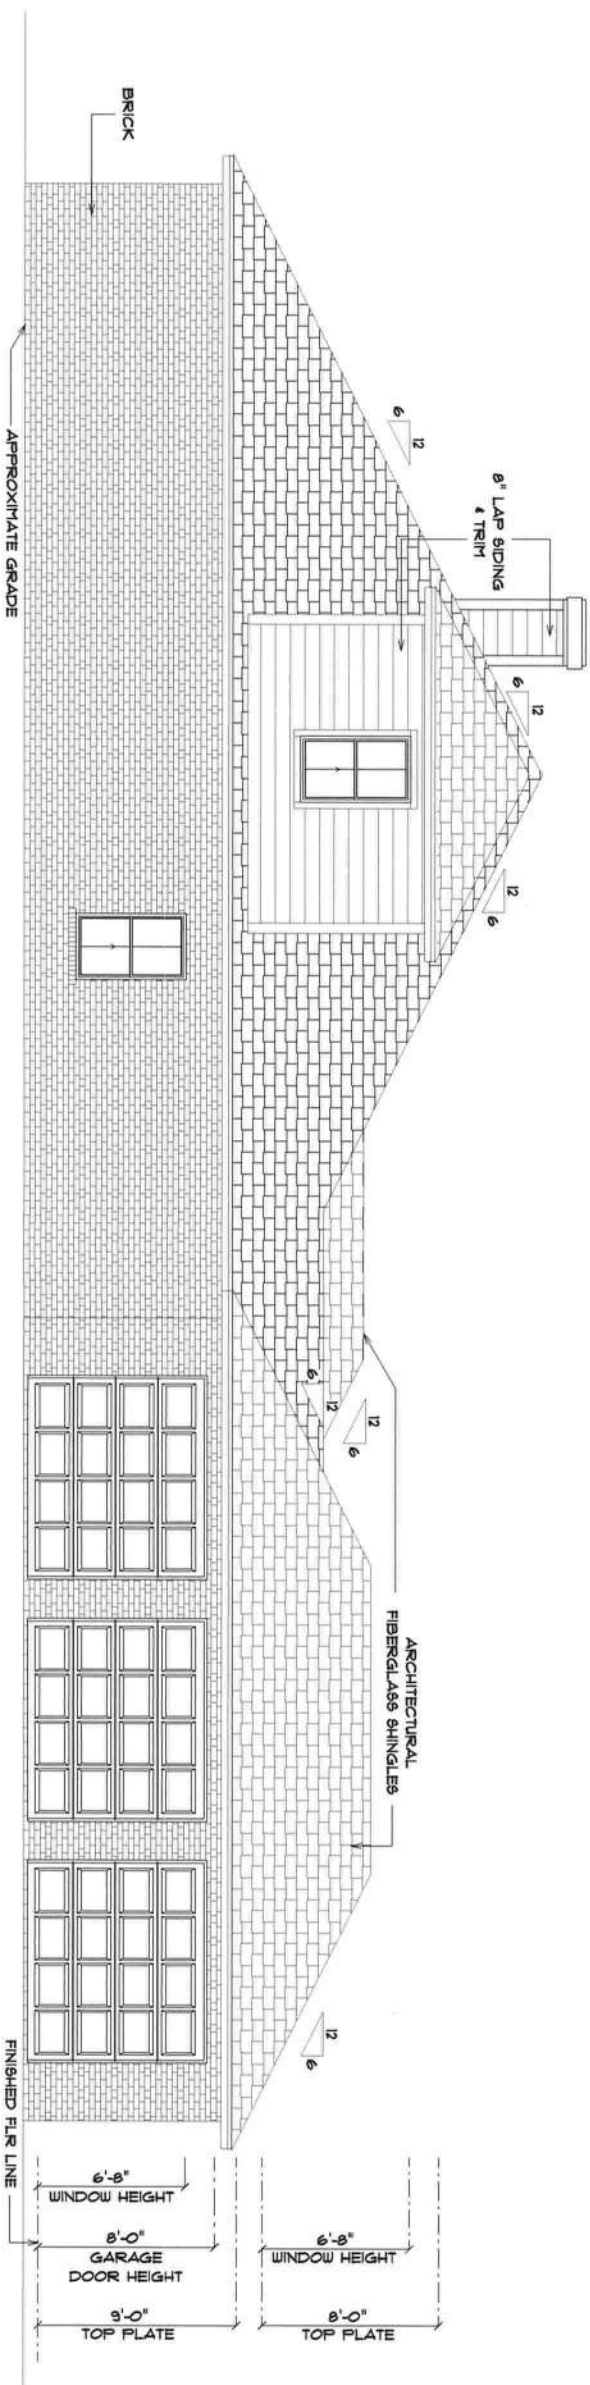

LEFT ELEVATION

SCALE : 1/4" = 1'-0"

NOTE: 18" OVERHANGS

NEW RESIDENCE
for
STANLEY & BEVERLY
POPE

649 N. NORTON RD.
LAKE CITY, 30026

Team: M. Ruffo
305 S.W. 47
Lake City, FL 32026
Cell: (904) 867-1181
Email: stanley@stgill.com

ISSUED DATE:
Wednesday, June 5, 2014

DRAWN BY: CHECKED BY:

Revised: M. Ruffo

BUILDING CONSTRUCTION


FINAL DATE:

JOB NUMBER:

DRAWING NUMBER


A-1

OF 9 SHEETS

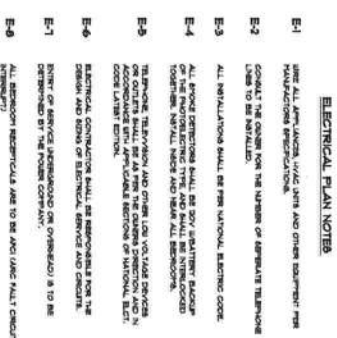[illegible]

SCALE : 3/16" = 1'-0"

OF 9 SHEETS

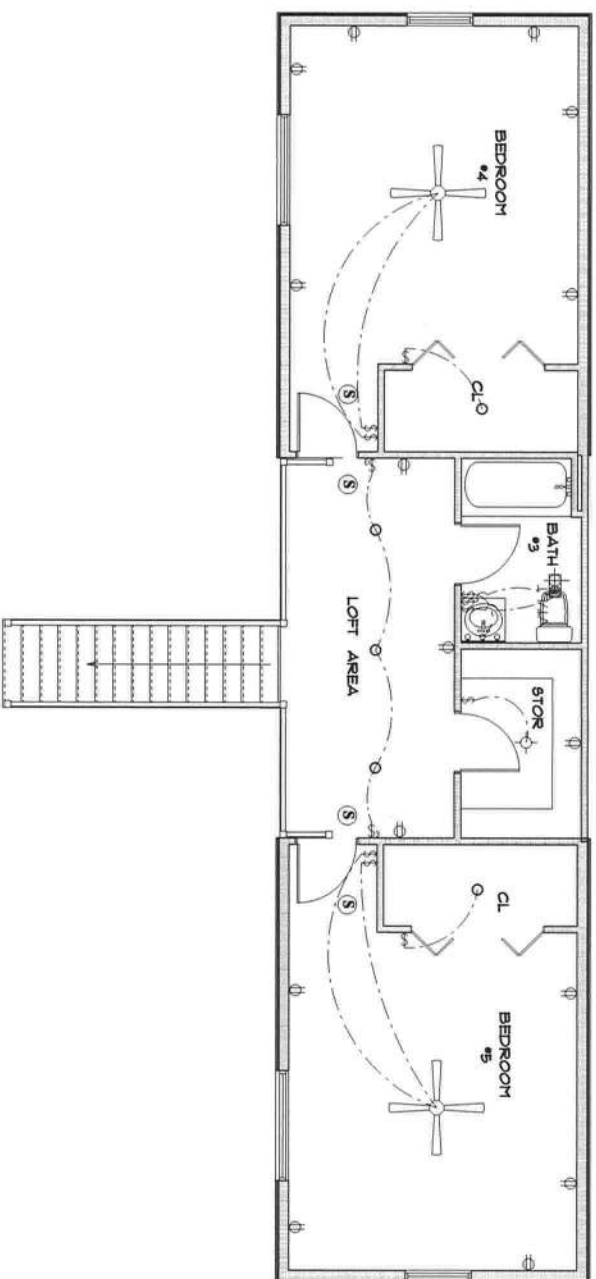

* BONUS AREA *

* E L E C T R I C P L A N *

SCALE : 3/16" = 1'-0"

NEW RESIDENCE	
for	
STANLEY & BEVERLY	
POPE	
649 NW NOBLE RD LAKE CITY, 30208	
Teresa H. Ruffo 209 SW 47 LAKE CITY, FL 32025 Phone: 407-526-1111 Email: terraruffo@gmail.com	
PRINTED DATE: Wednesday, June 5, 2024	
DRAWN BY: Teresa H. Ruffo	CHECKED BY:
BUILDING CONSTRUCTION	
PLANS DATE:	
JOB NUMBER:	
DRAWING NUMBER A-9	
OF 9 SHEETS	