
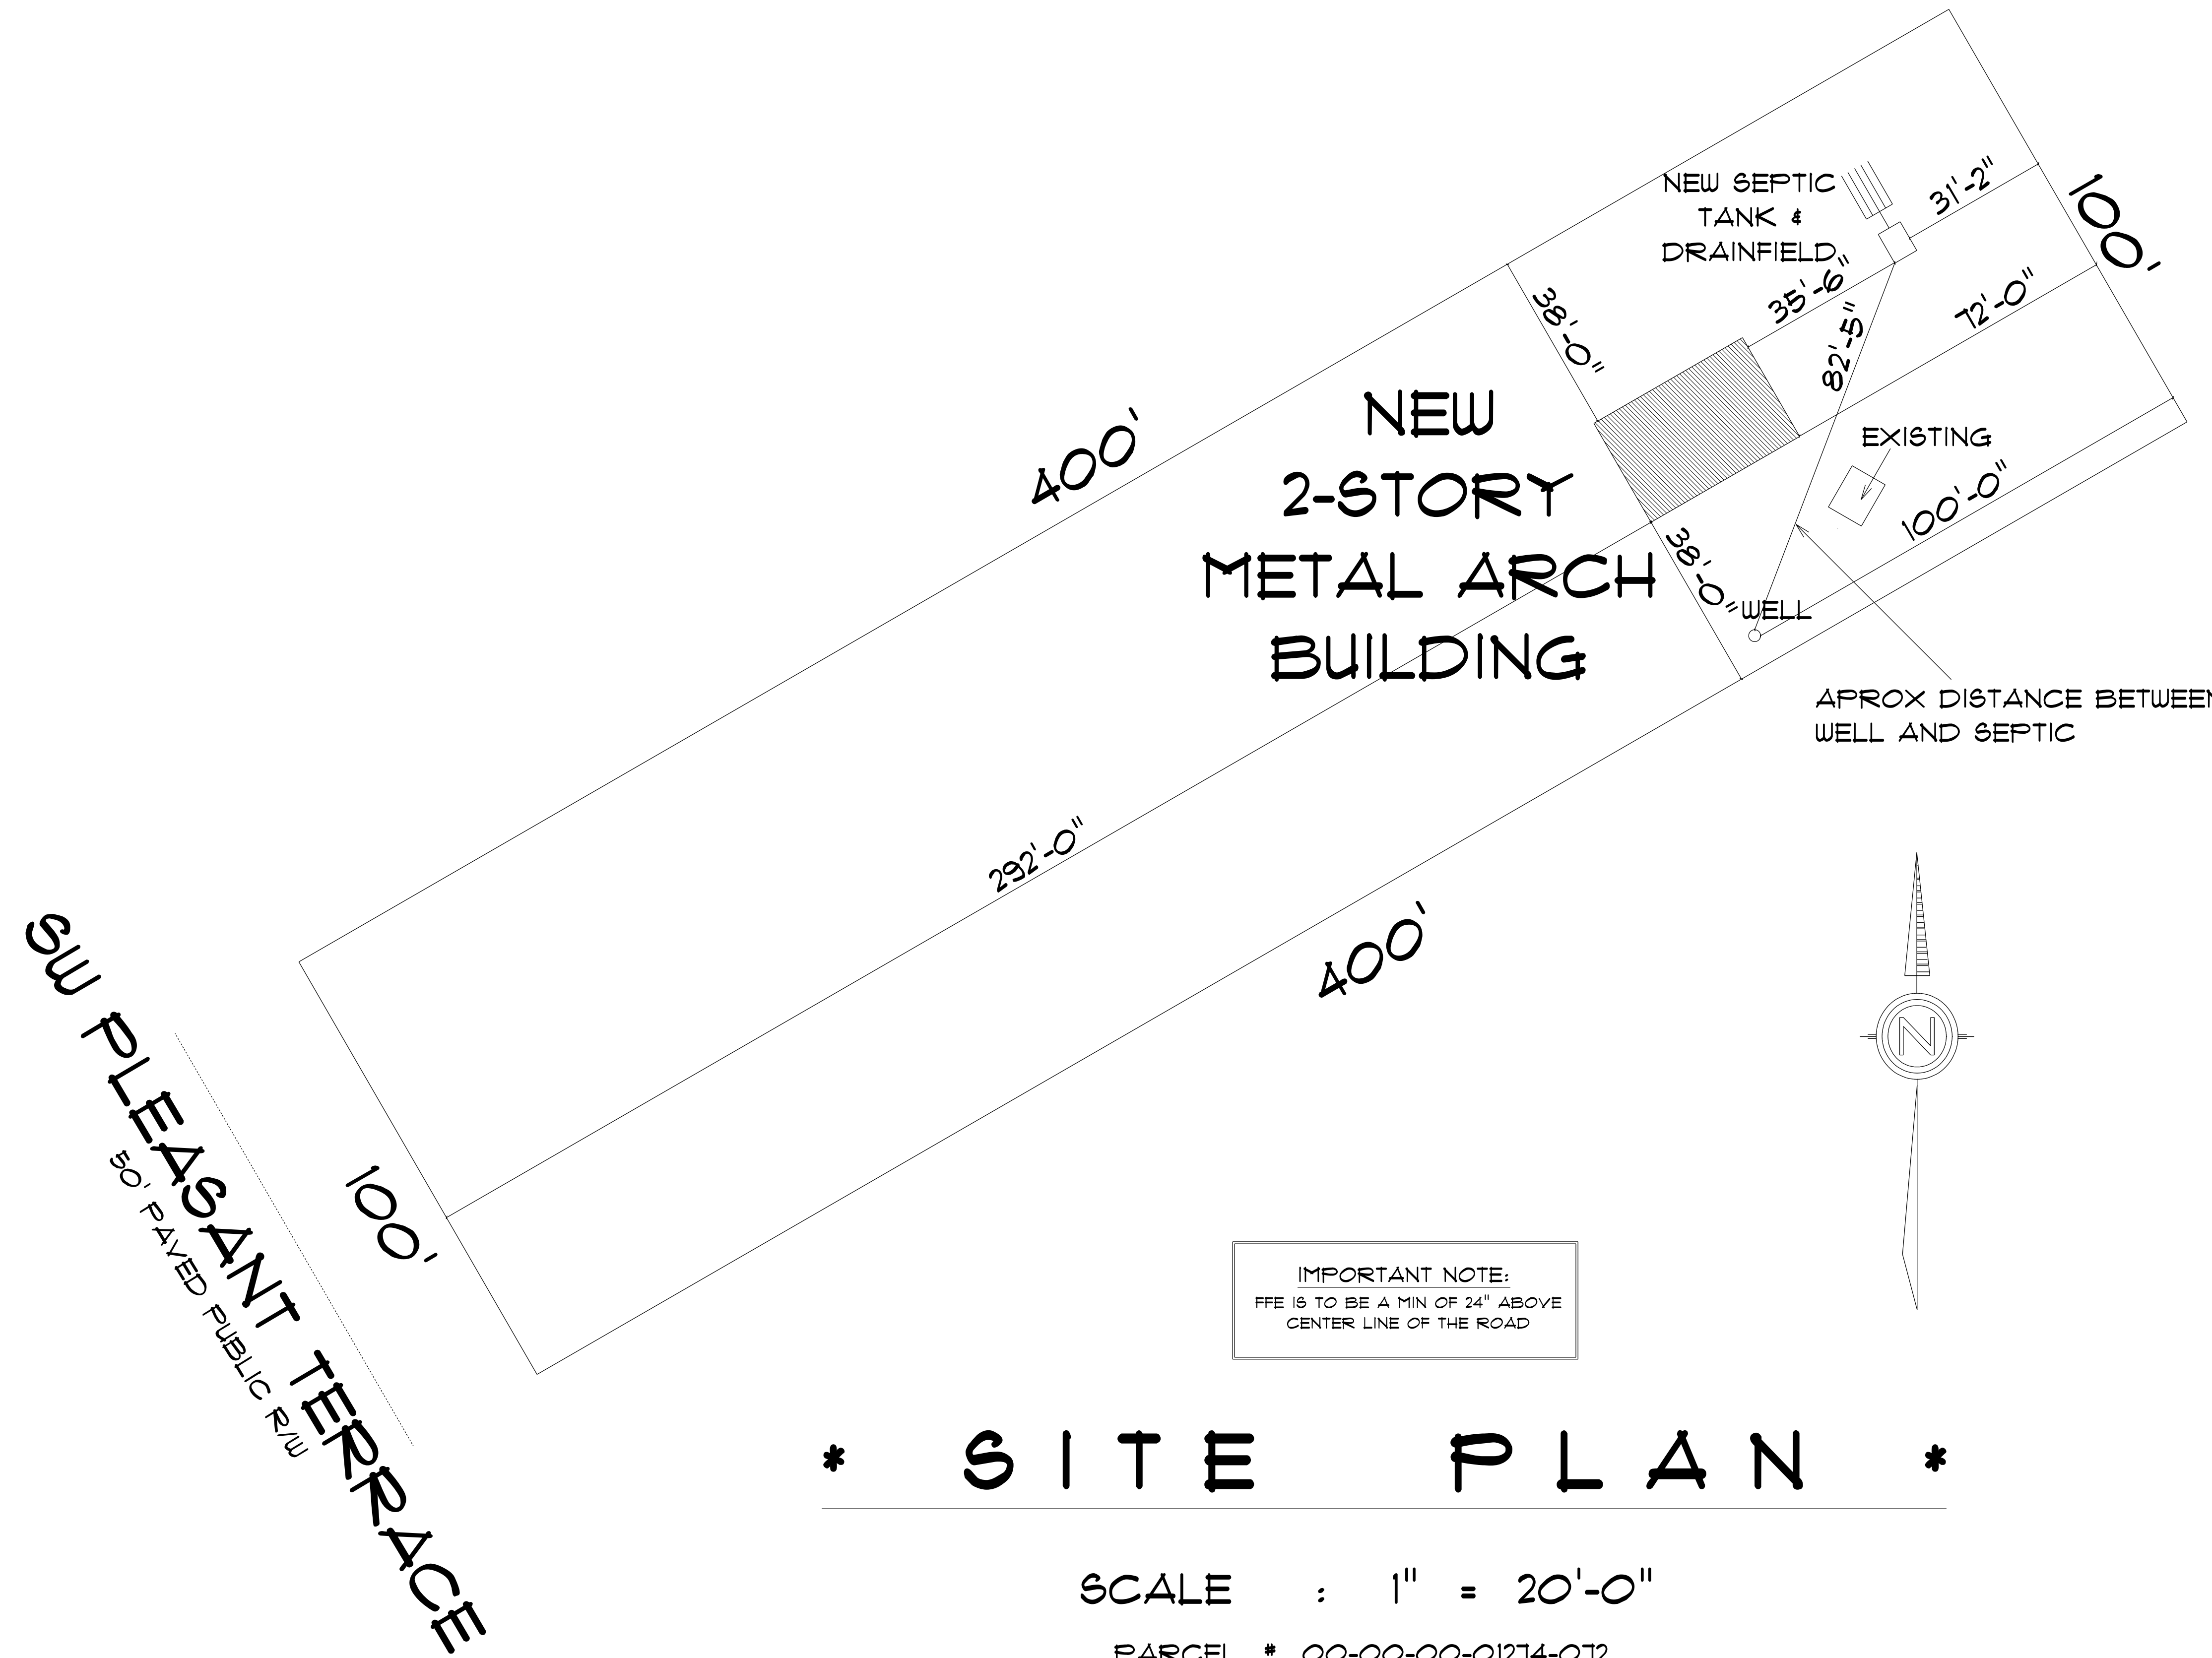


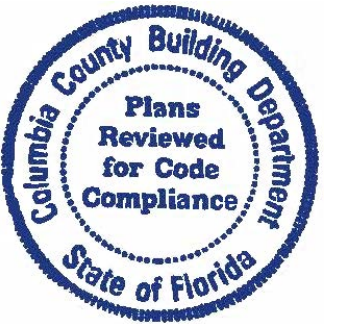

* SITE PLAN *

SCALE : 1" = 20'-0"

PARCEL # 00-00-00-01274-072

RESIDENCE
for
AMY FOUCHER
669 SW Pleasant Terrace
Ft. White, FL, 32038
Cell:
Email:

Teena M. Ruffo
2925 SW SR 47
Lake City Florida, 32025
Cell: (386) 867-1191
Email: teenaruffo@gmail.com

PRINTED DATE:
Tuesday, November 12, 2024


DRAWN BY: Teena & Kara CHECKED BY:

BUILDING CONTRACTOR

FINAL DATE:

JOB NUMBER:

DRAWING NUMBER
A - 1
OF 2 SHEETS

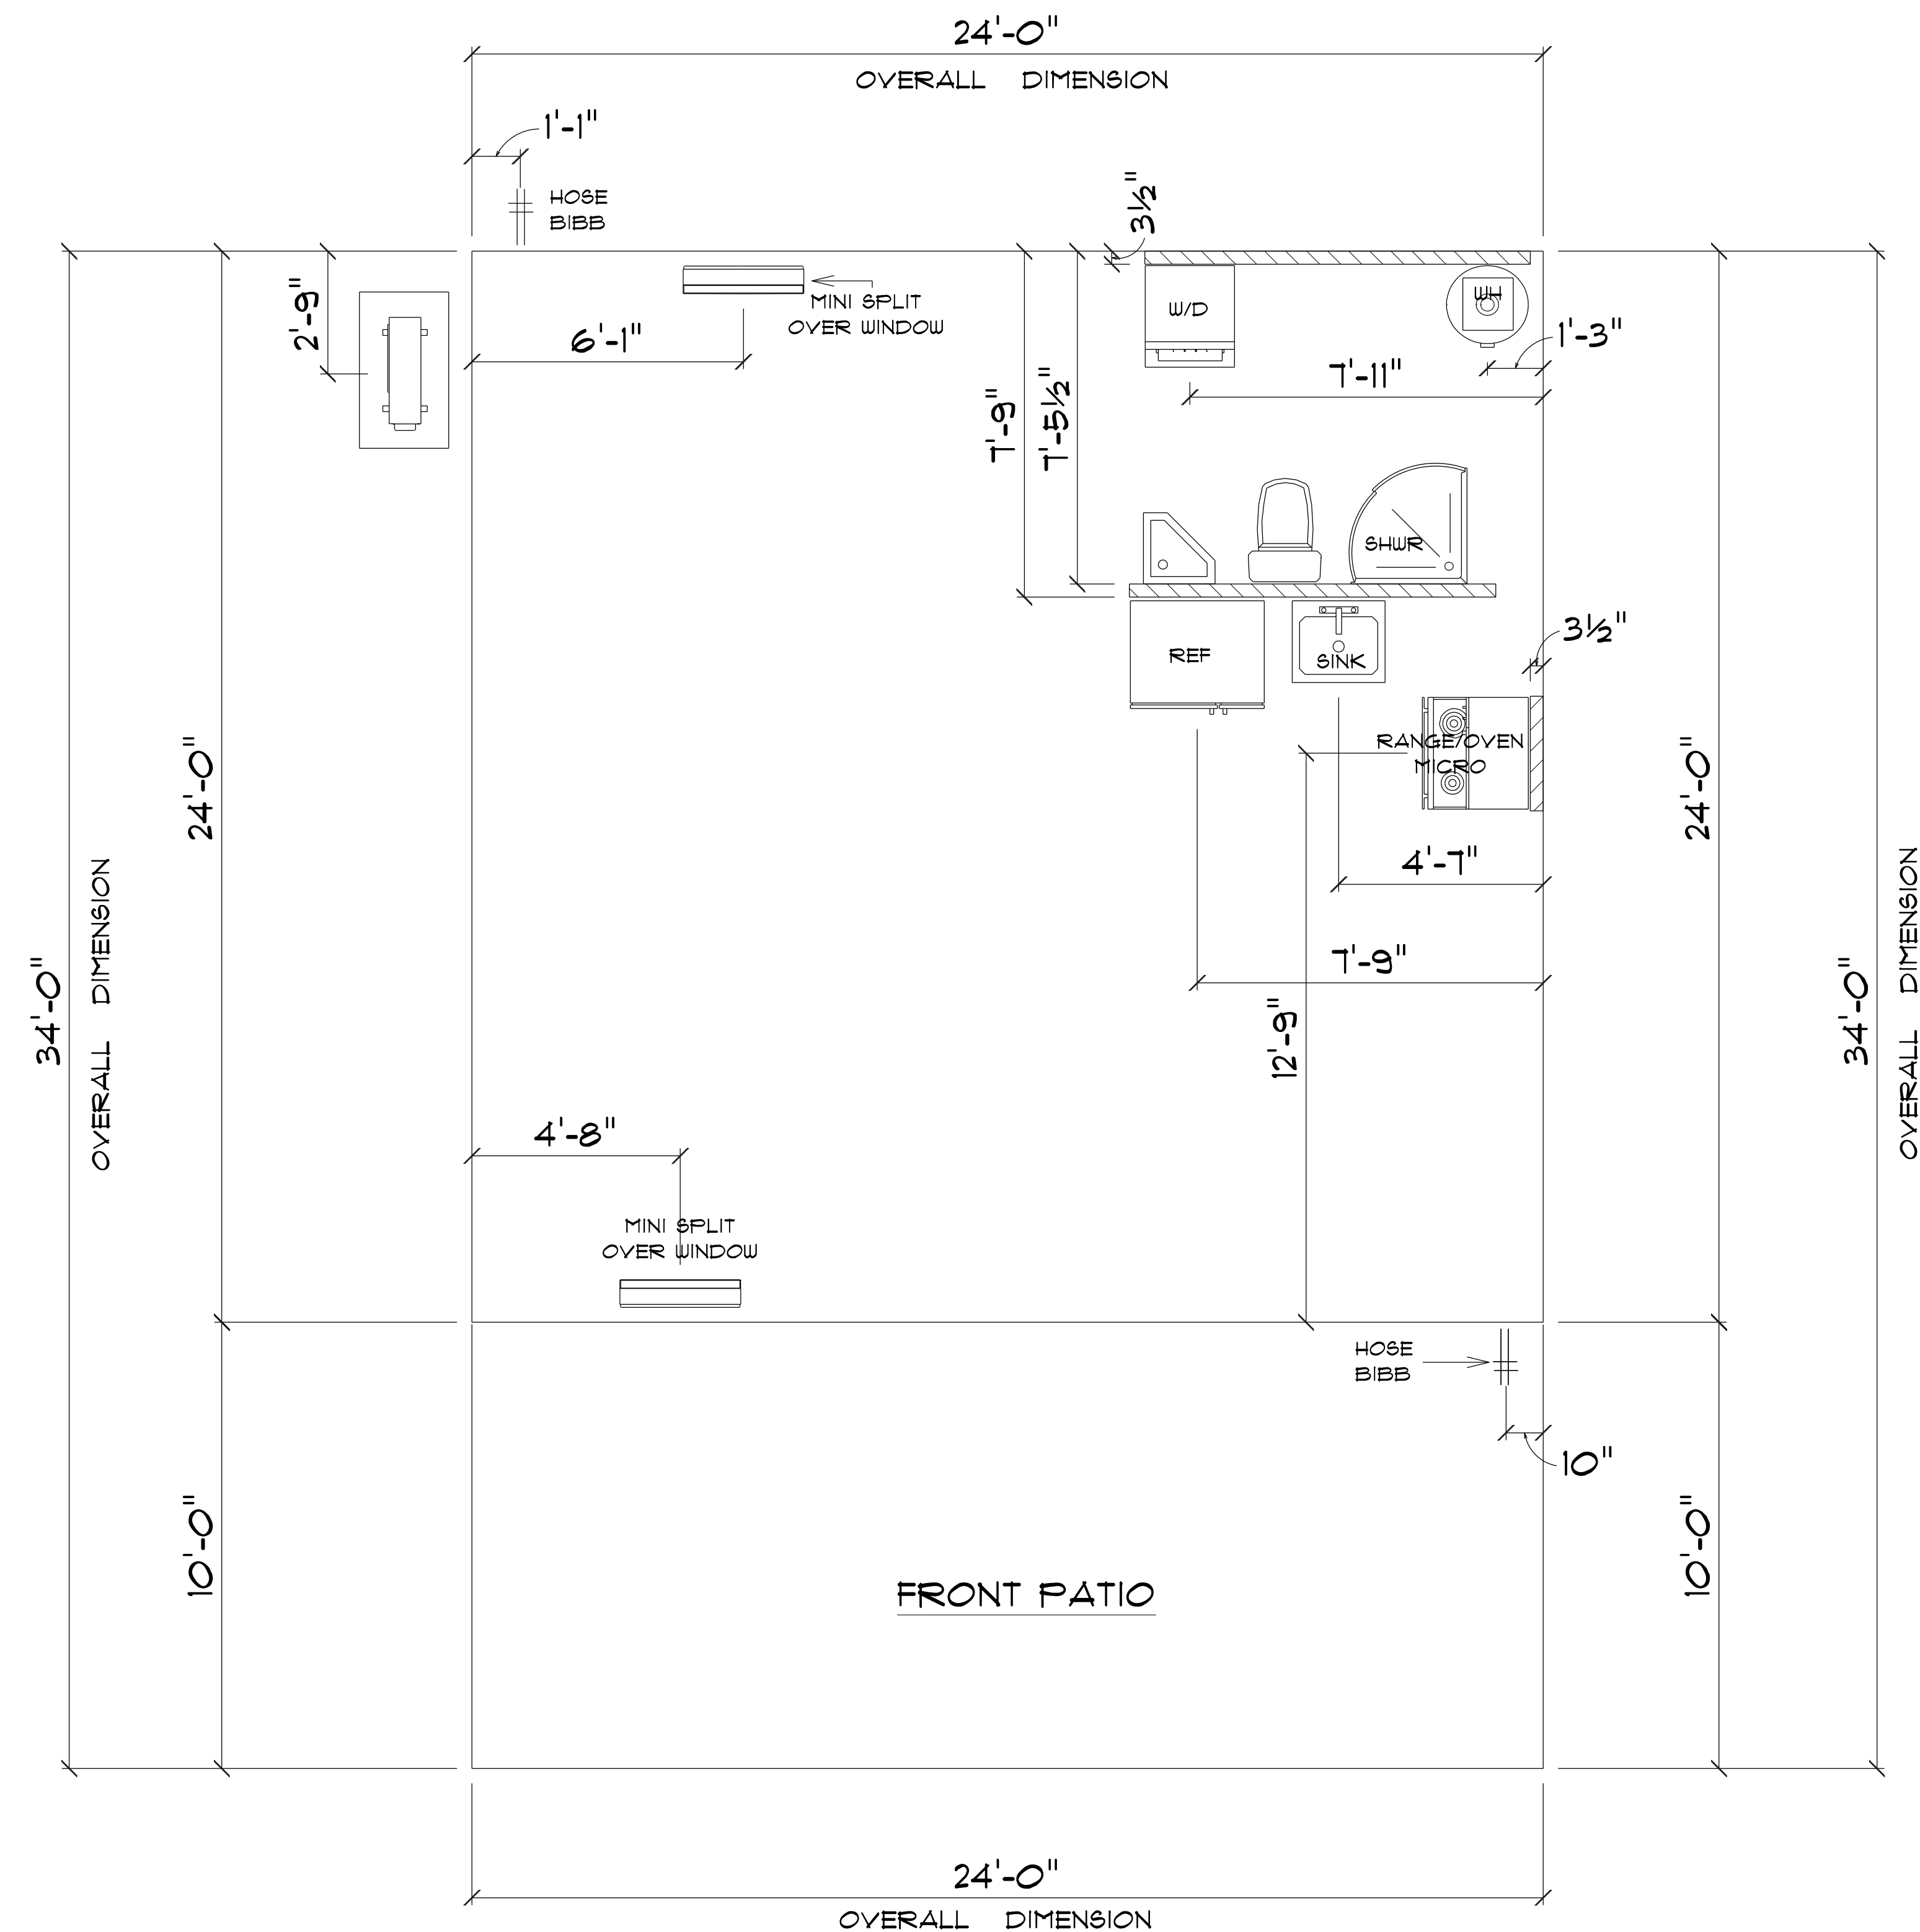

* PLUMBING & *
* FOUNDATION PLAN *

SCALE : 3/8" = 1'-0"

IMPORTANT NOTE:

1. IT IS THE BUILDERS RESPONSIBILITY TO VERIFY ALL GEOMETRY AND DIMENSIONS BEFORE ORDERING ANY MATERIALS OR BEGINNING CONSTRUCTION.
2. THESE PLANS ARE FOR LAYOUT AND DESIGN PURPOSES ONLY ALL STRUCTURAL NOTES AND DETAILS TO BE PROVIDED BY AN ENGINEER.
3. 2X6 EXTERIOR STUD WALLS 2X4 INTERIOR WALLS

MAIN A/C LIVING AREA	=	516 S.F.
LOFT AREA	=	226 S.F.
TOTAL AREA UNDER ROOF		= 802 S.F.

RESIDENCE
for
AMY FOUCHER

669 SW Pleasant Terrace
Ft. White, FL, 32038
Cell:
Email:

Teena M. Ruffo
2925 SW SR 47
Lake City Florida, 32025
Cell: (386) 861 - 1191
Email: teenaruffo@gmail.com

PRINTED DATE:
Tuesday, November 12, 2024

DRAWN BY: Teena & Kara CHECKED BY:

BUILDING CONTRACTOR


FINAL DATE:

JOB NUMBER:

DRAWING NUMBER

A - 2

OF 8 SHEETS

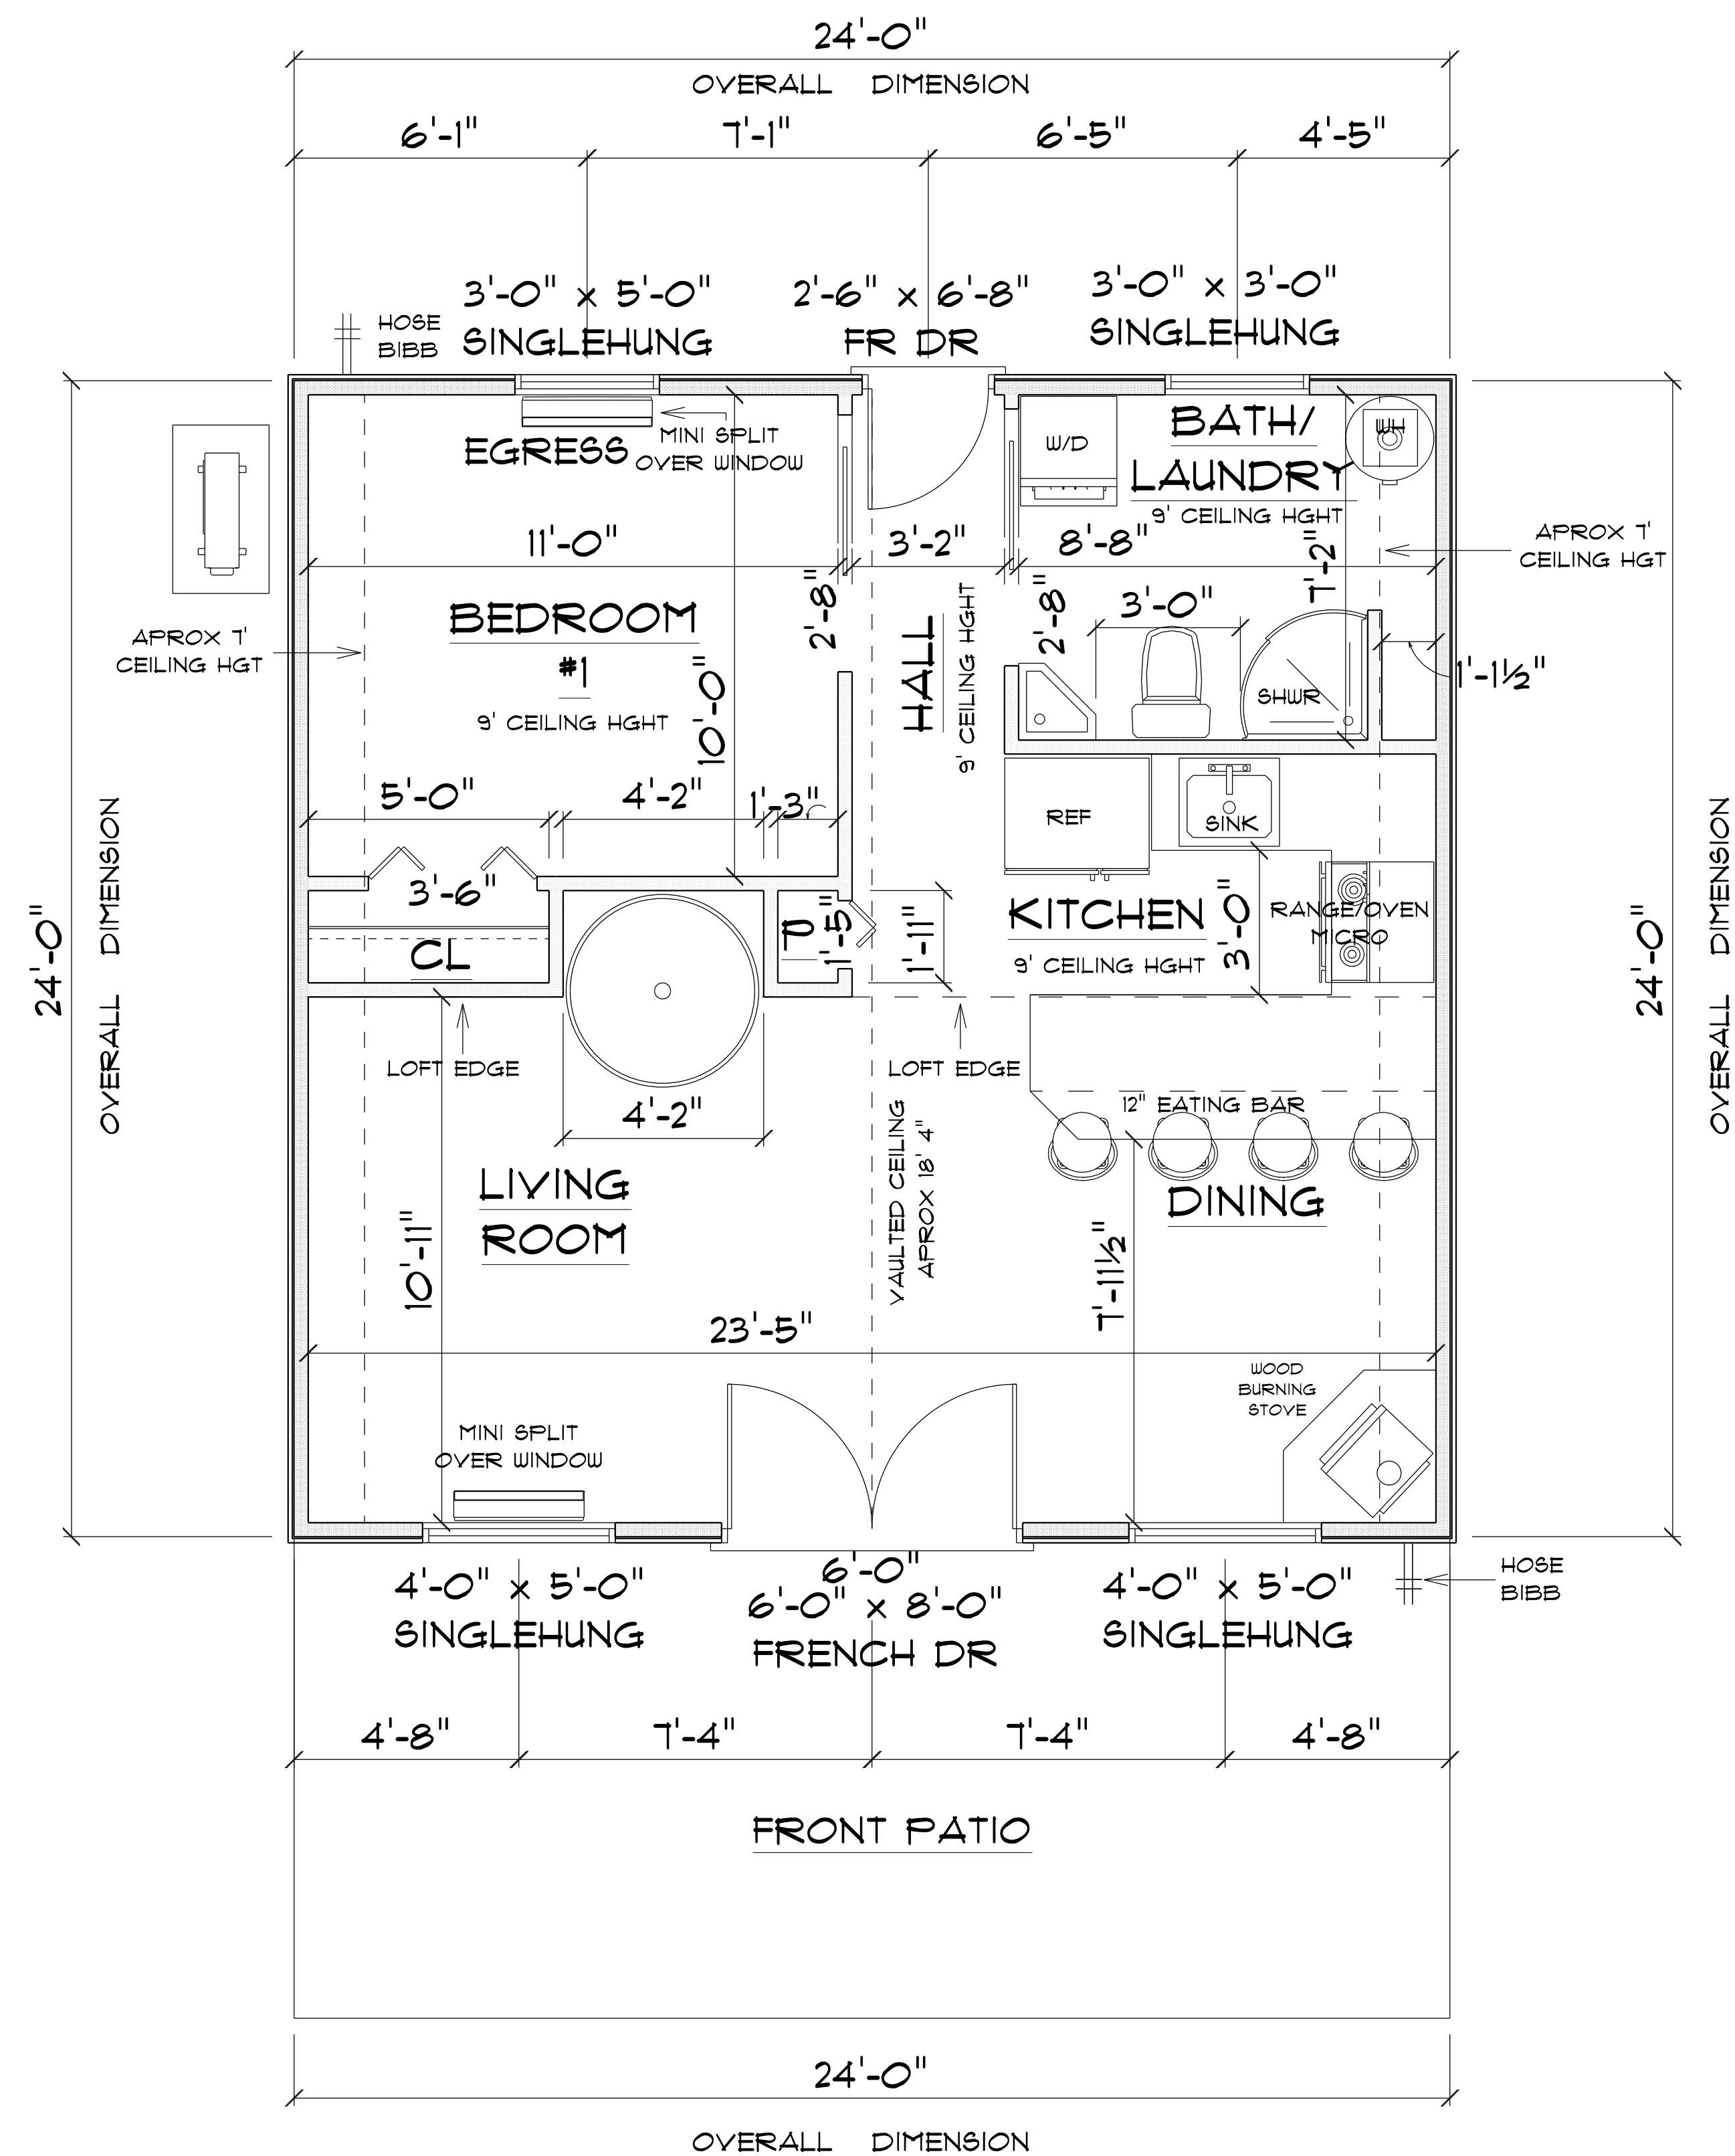


* MAIN FLOOR *

SCALE : 3/8" = 1'-0"

IMPORTANT NOTE:

1. IT IS THE BUILDERS RESPONSIBILITY TO VERIFY ALL GEOMETRY AND DIMENSIONS BEFORE ORDERING ANY MATERIALS OR BEGINNING CONSTRUCTION.
2. THESE PLANS ARE FOR LAYOUT AND DESIGN PURPOSES ONLY ALL STRUCTURAL NOTES AND DETAILS TO BE PROVIDED BY AN ENGINEER.
3. 2X6 EXTERIOR STUD WALLS 2X4 INTERIOR WALLS

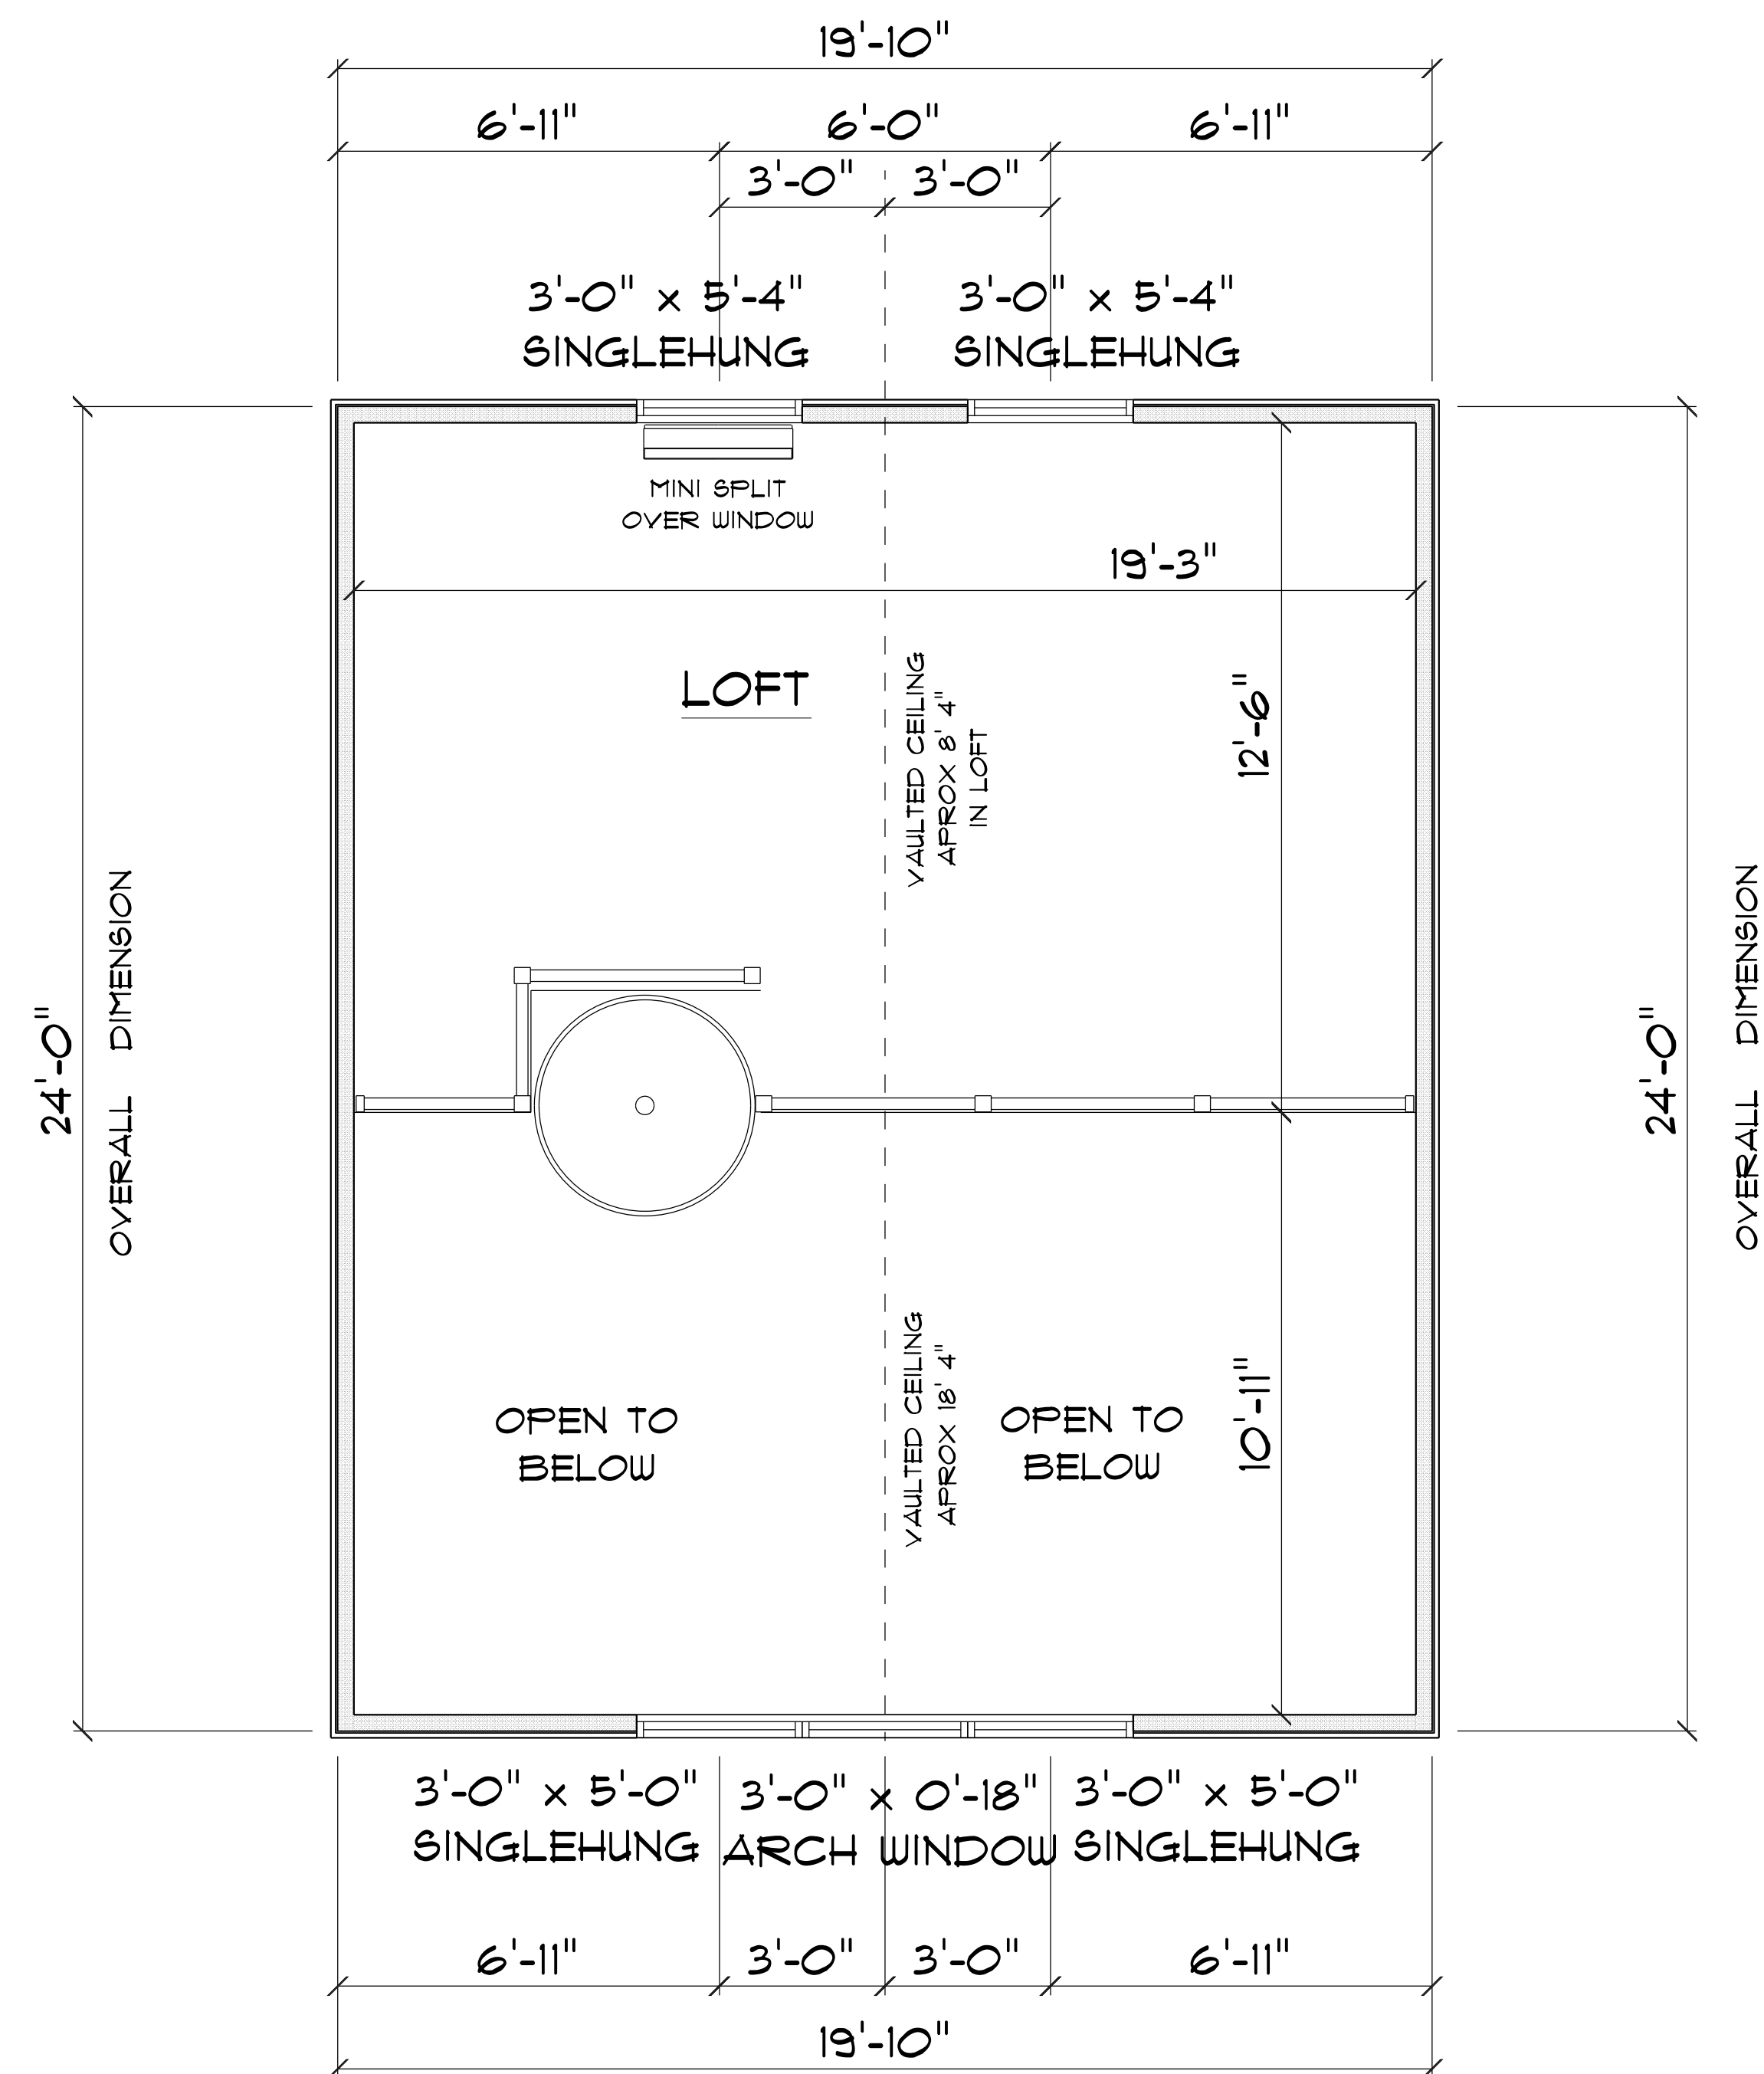

* SECOND FLOOR *

SCALE : 3/8" = 1'-0"

MAIN A/C LIVING AREA	=	576 S.F.
LOFT AREA	=	226 S.F.
TOTAL AREA UNDER ROOF		= 802 S.F.

RESIDENCE
for
AMY FOUCHER

669 SW Pleasant Terrace
Ft. White, FL, 32038
Cell: (386) 867-1191
Email: teanaruffo@gmail.com

Teana M. Ruffo
2925 SW SR 47
Lake City Florida, 32025
Cell: (386) 867-1191
Email: teanaruffo@gmail.com

PRINTED DATE:
Tuesday, November 12, 2024

DRAWN BY: Teana & Kara

CHECKED BY:

BUILDING CONTRACTOR


FINALS DATE:

JOB NUMBER:

DRAWING NUMBER

A - 3

OF 8 SHEETS

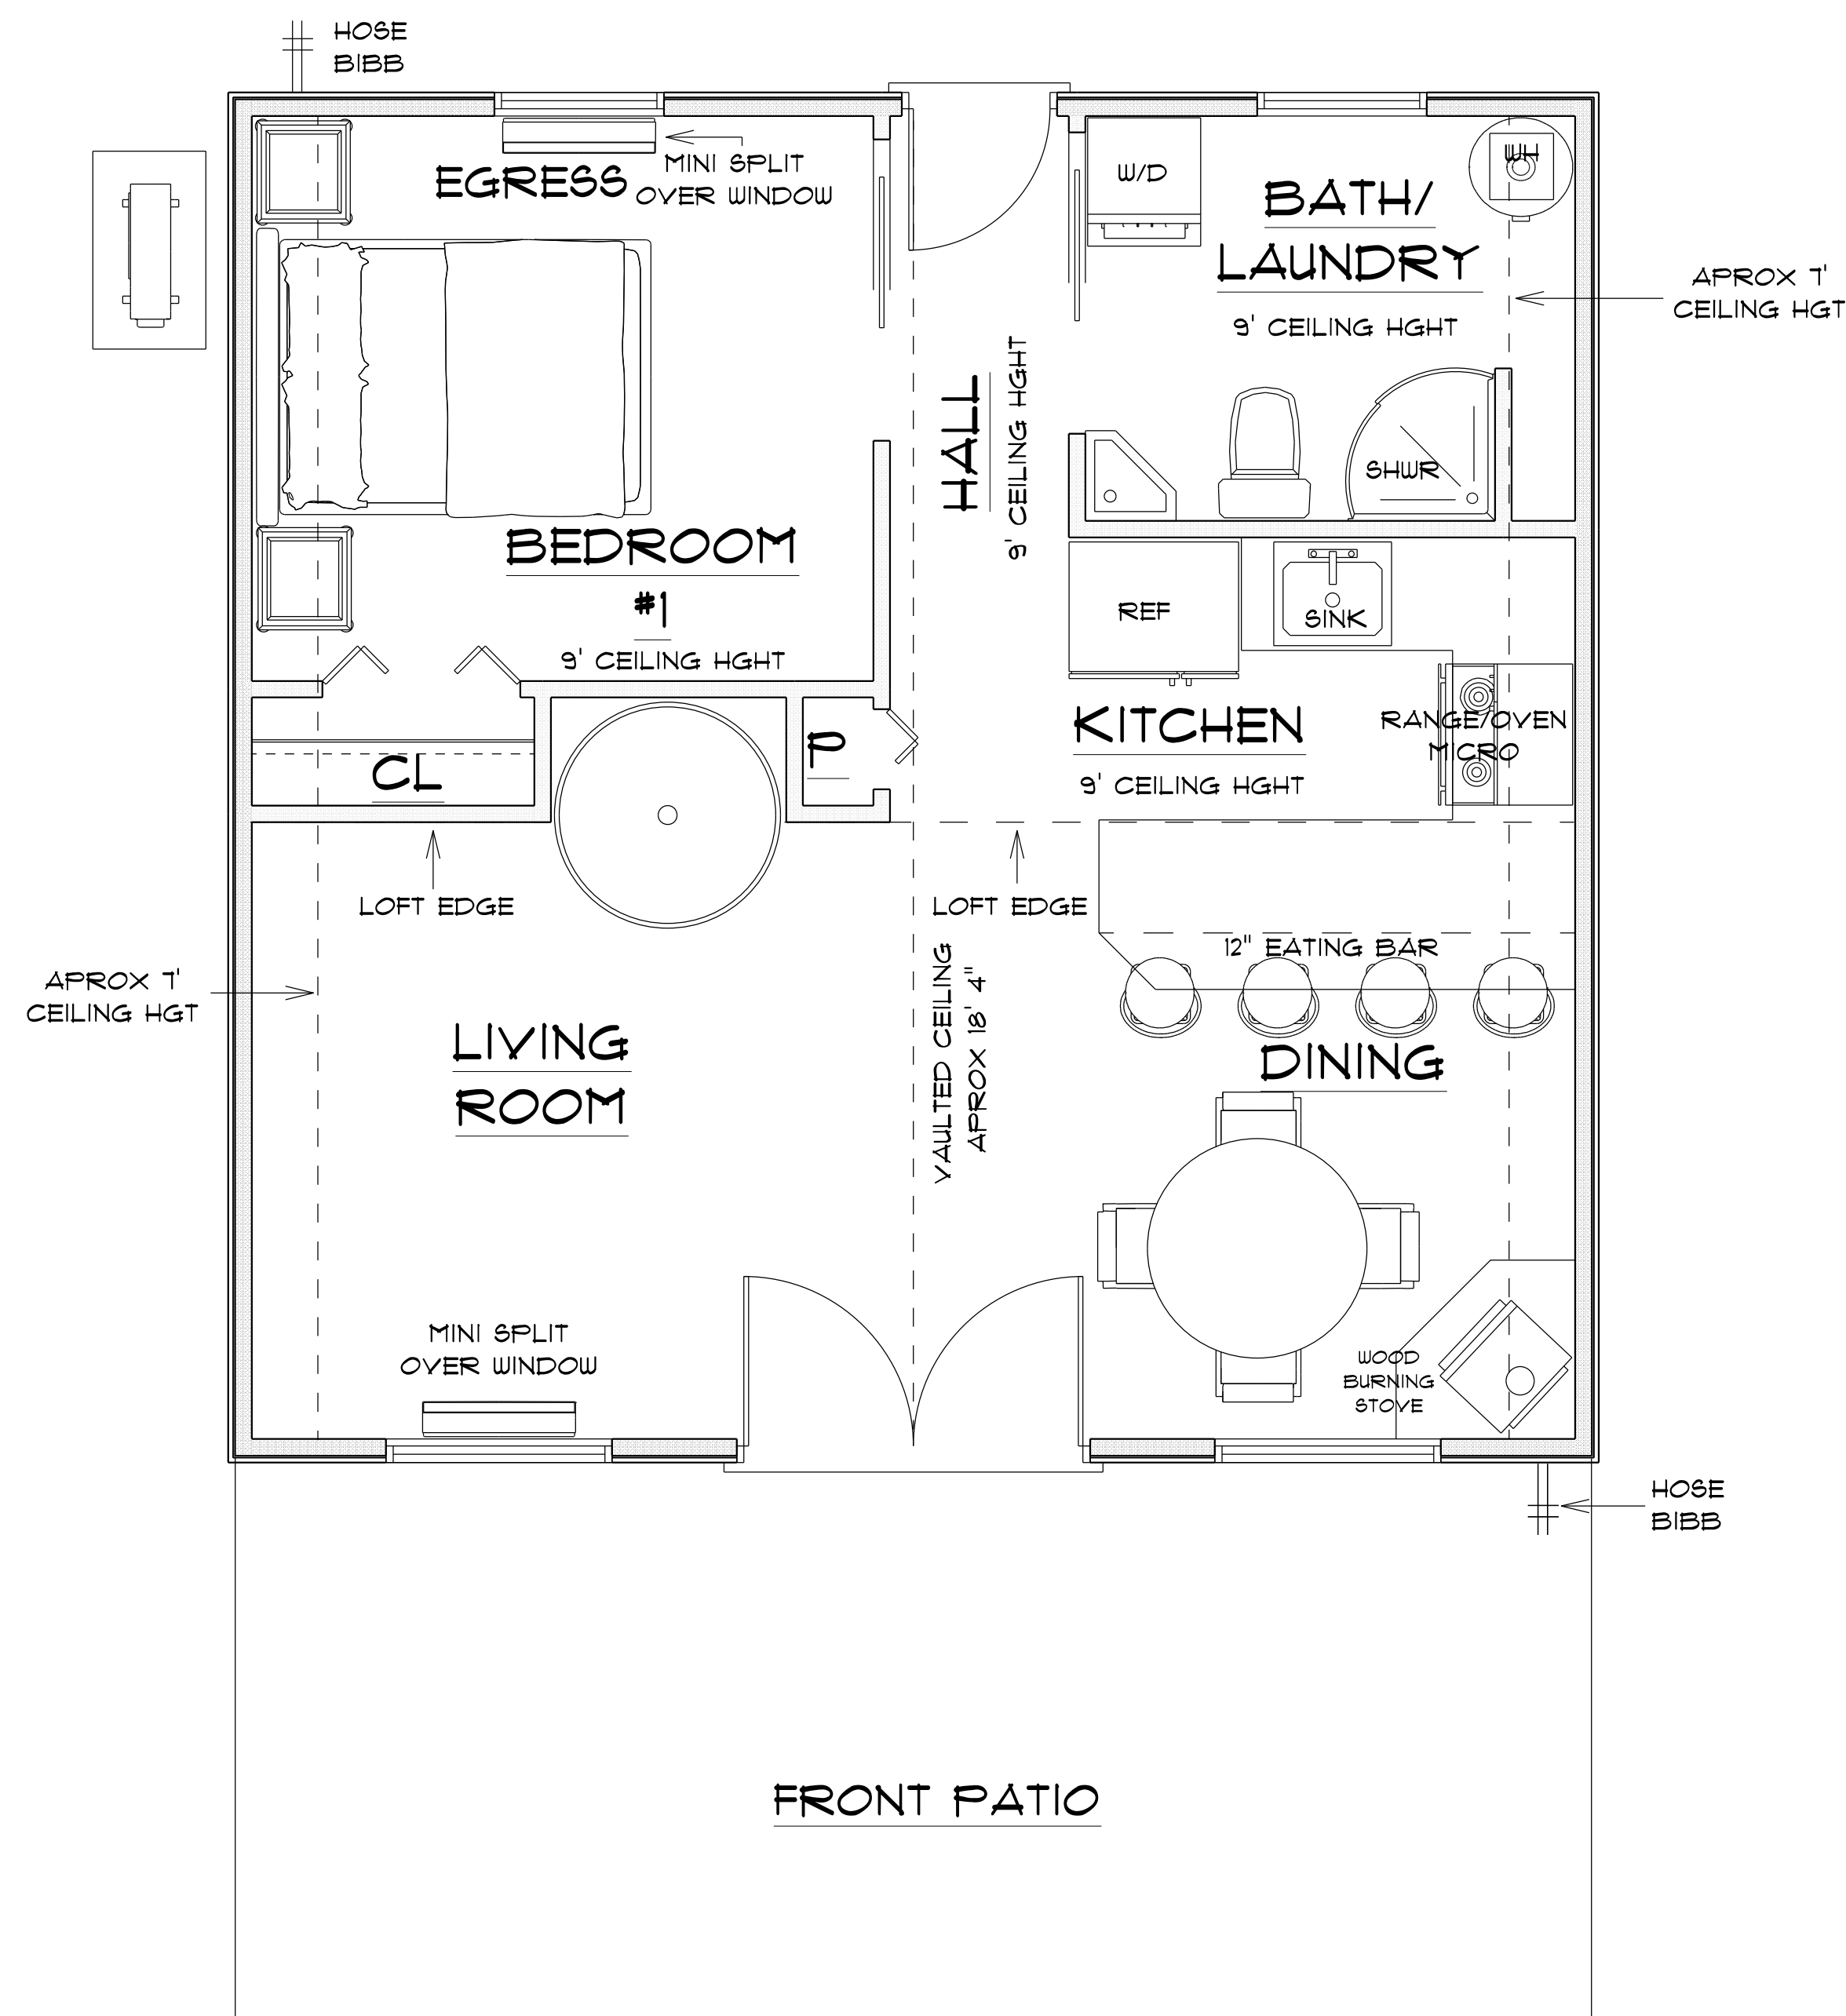


* MAIN FLOOR *

* NO DIMENSIONS *

IMPORTANT NOTE:

1. IT IS THE BUILDERS RESPONSIBILITY TO VERIFY ALL GEOMETRY AND DIMENSIONS BEFORE ORDERING ANY MATERIALS OR BEGINNING CONSTRUCTION.
2. THESE PLANS ARE FOR LAYOUT AND DESIGN PURPOSES ONLY ALL STRUCTURAL NOTES AND DETAILS TO BE PROVIDED BY AN ENGINEER.
3. 2X6 EXTERIOR STUD WALLS 2X4 INTERIOR WALLS

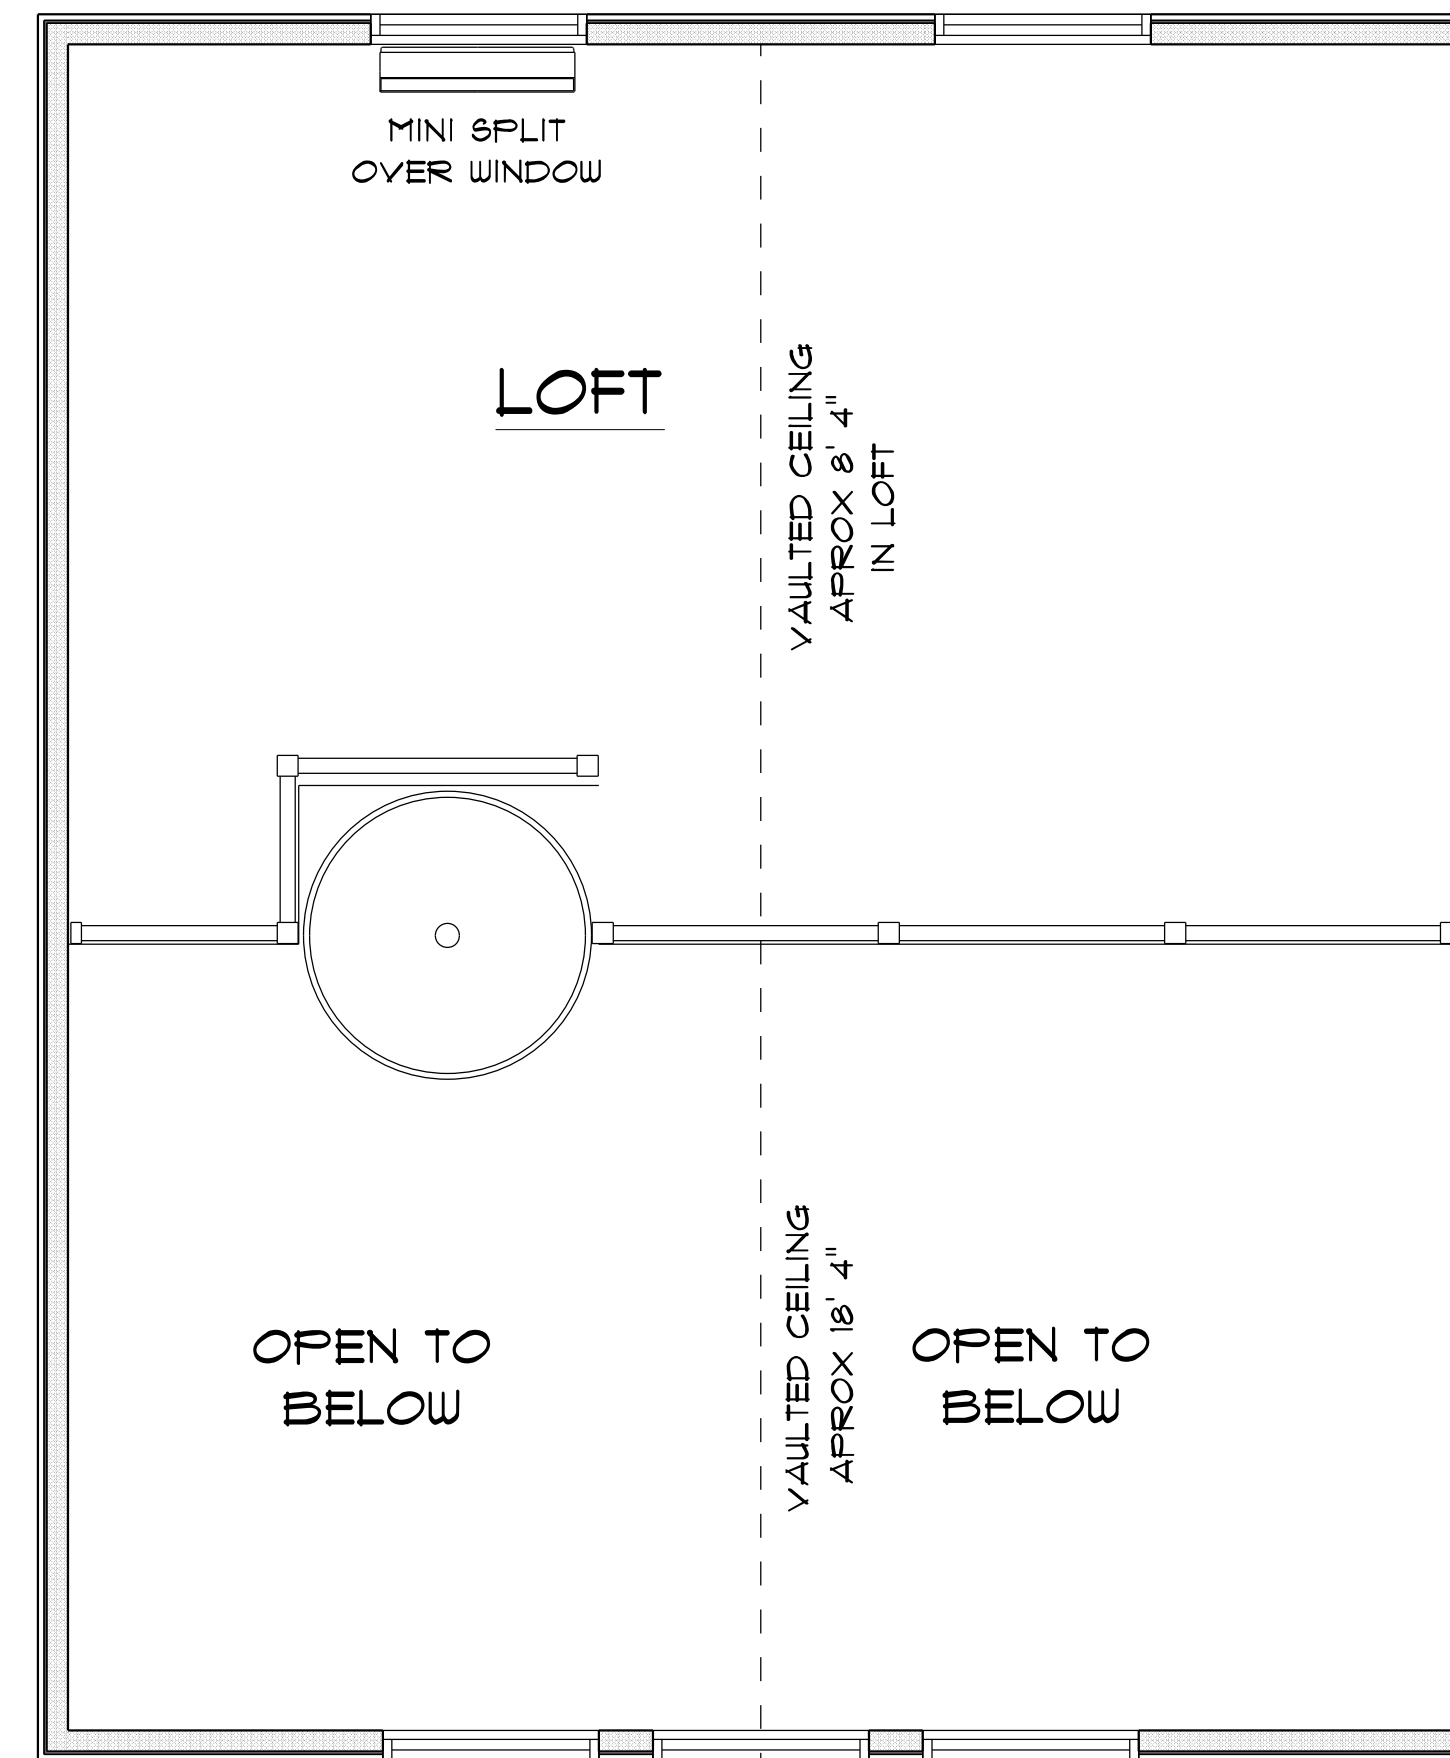

* SECOND FLOOR *

* NO DIMENSIONS *

SCALE : 3/8" = 1'-0"

MAIN A/C LIVING AREA	=	576 S.F.
LOFT AREA	=	226 S.F.
TOTAL AREA UNDER ROOF		= 802 S.F.

RESIDENCE
for
AMY FOUCHER

669 SW Pleasant Terrace
Ft. White, FL, 32038
Cell:
Email:

Teena M. Ruffo
2925 SW SR 47
Lake City Florida, 32025
Cell: (386) 867-1191
Email: teenaruffo@gmail.com

PRINTED DATE:
Tuesday, November 12, 2024

DRAWN BY: CHECKED BY:

Teena & Kara

BUILDING CONTRACTOR


FINAL DATE:

JOB NUMBER:


DRAWING NUMBER

A - 4

OF 8 SHEETS

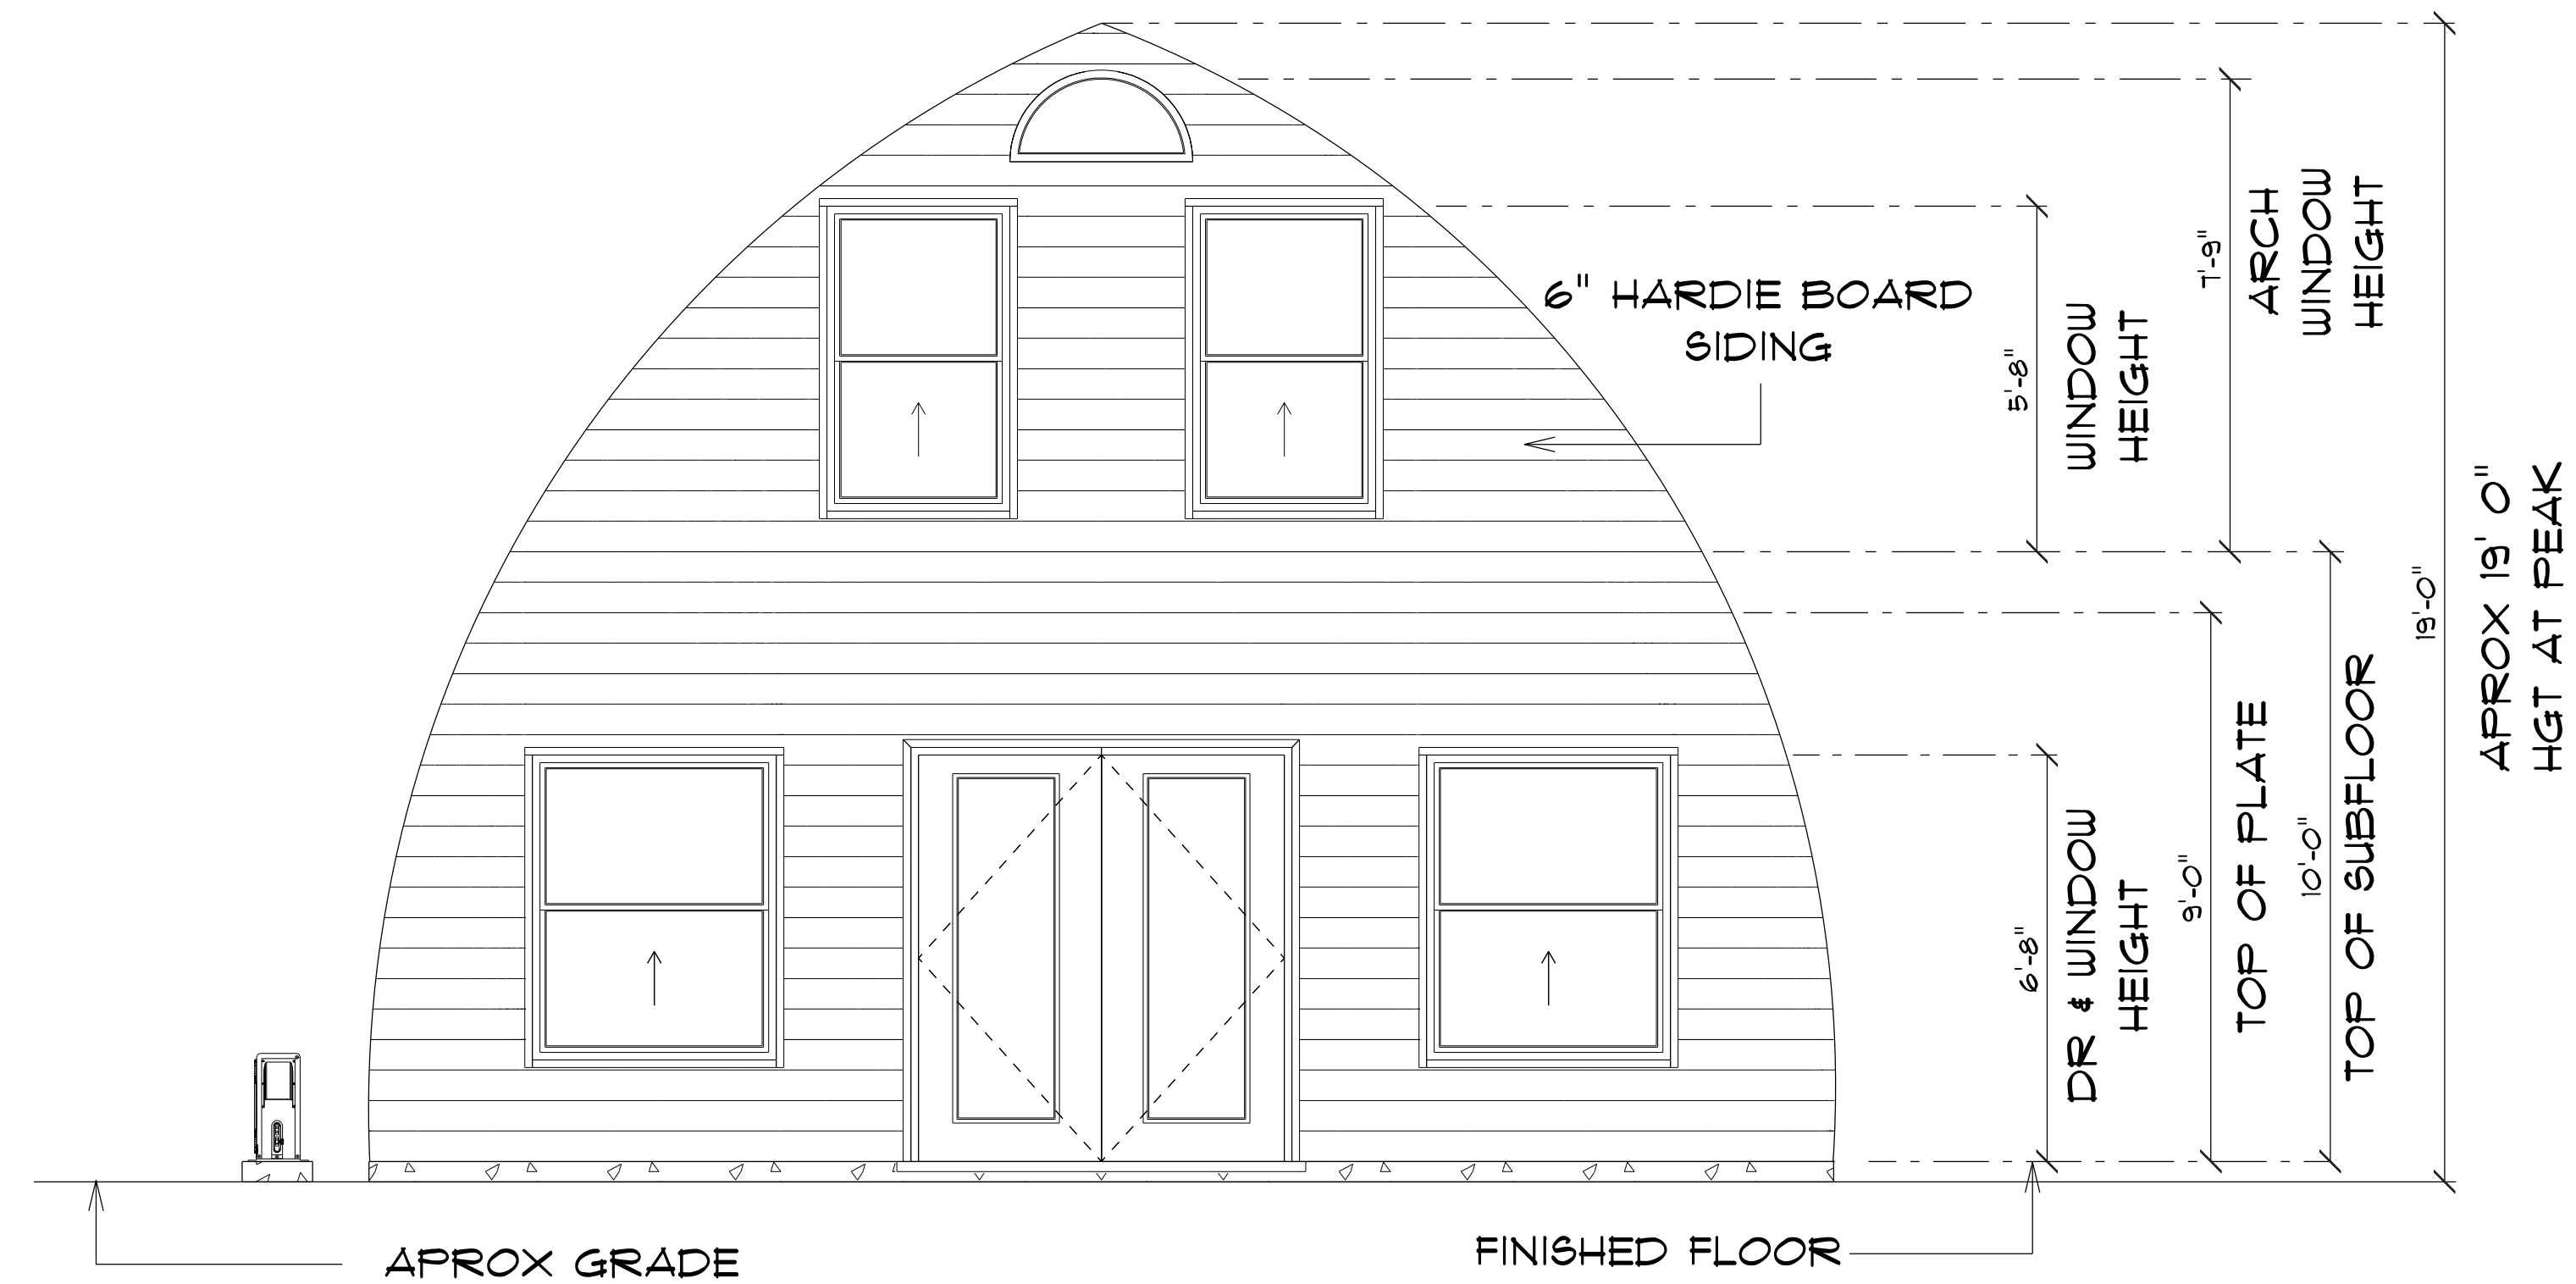

* FRONT ELEVATION *

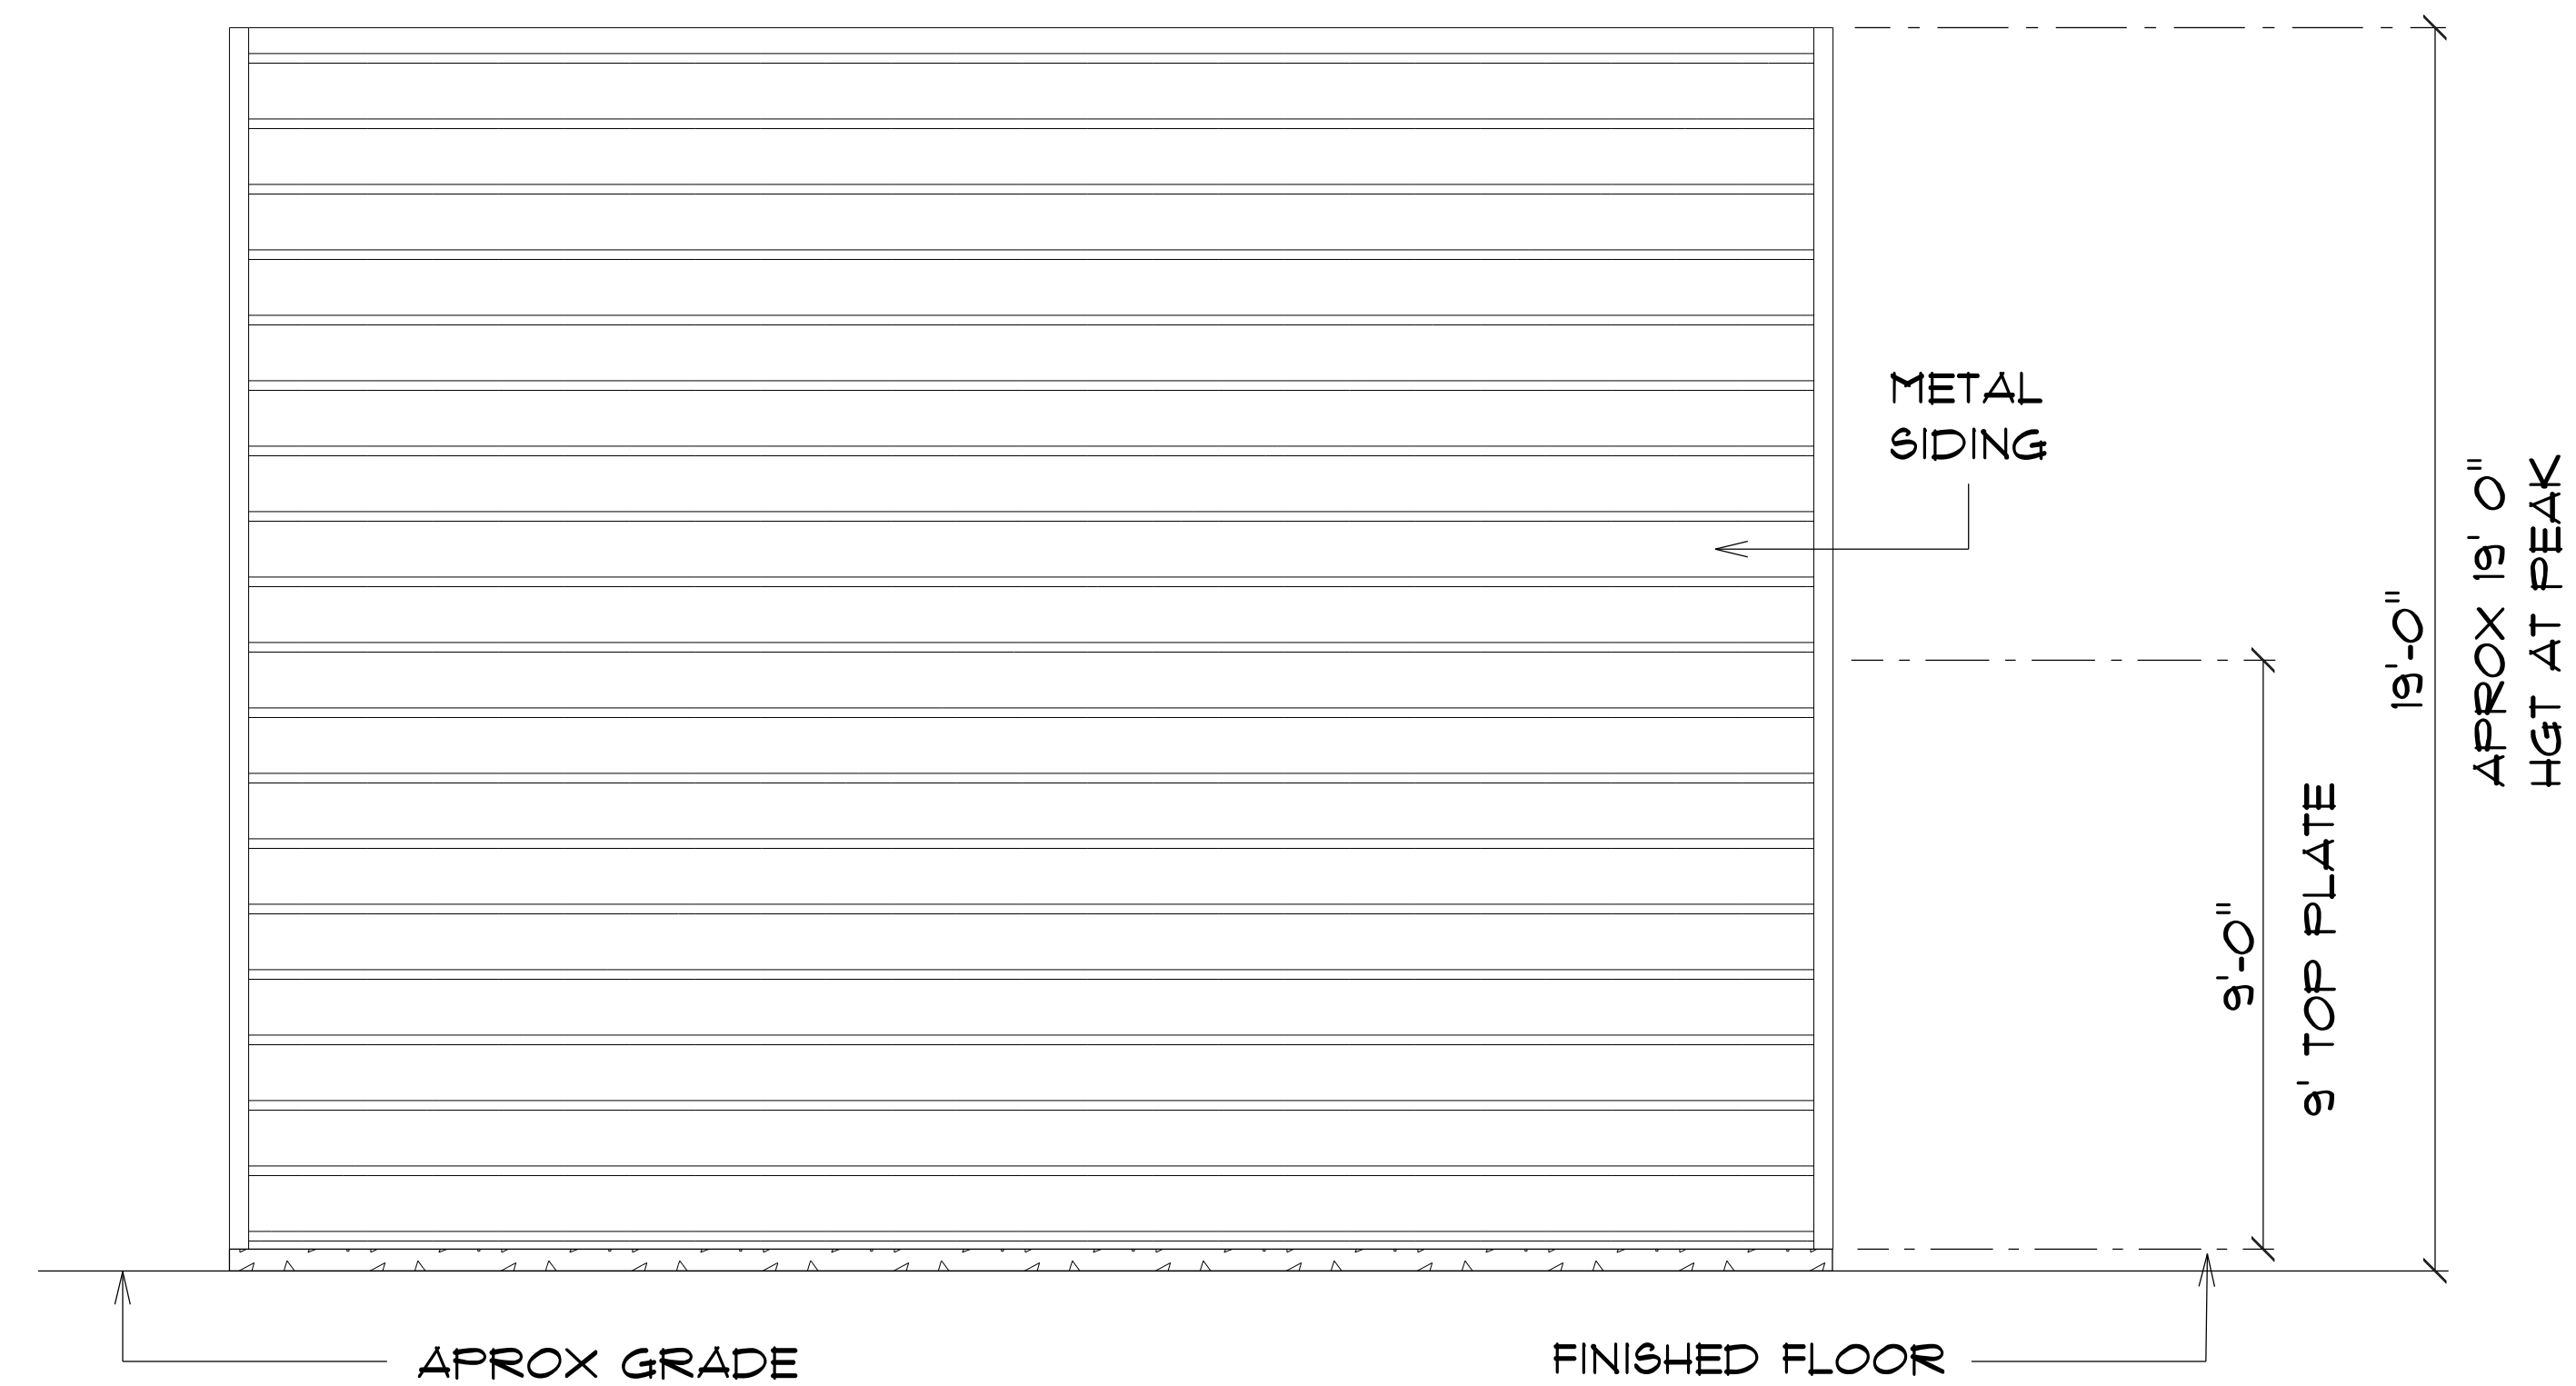

* RIGHT ELEVATION *

RESIDENCE
for
AMY FOUCHER

669 SW Pleasant Terrace
Ft. White, FL, 32038
Cell:
Email:

Teena M. Ruffo
2925 SW SR 47
Lake City Florida, 32025
Cell: (386) 867-1191
Email: teenaruffo@gmail.com

PRINTED DATE:
Tuesday, November 12, 2024

DRAWN BY: Teena & Kara CHECKED BY:

BUILDING CONTRACTOR


FINAL DATE:

JOB NUMBER:


DRAWING NUMBER

A - 5

OF 8 SHEETS

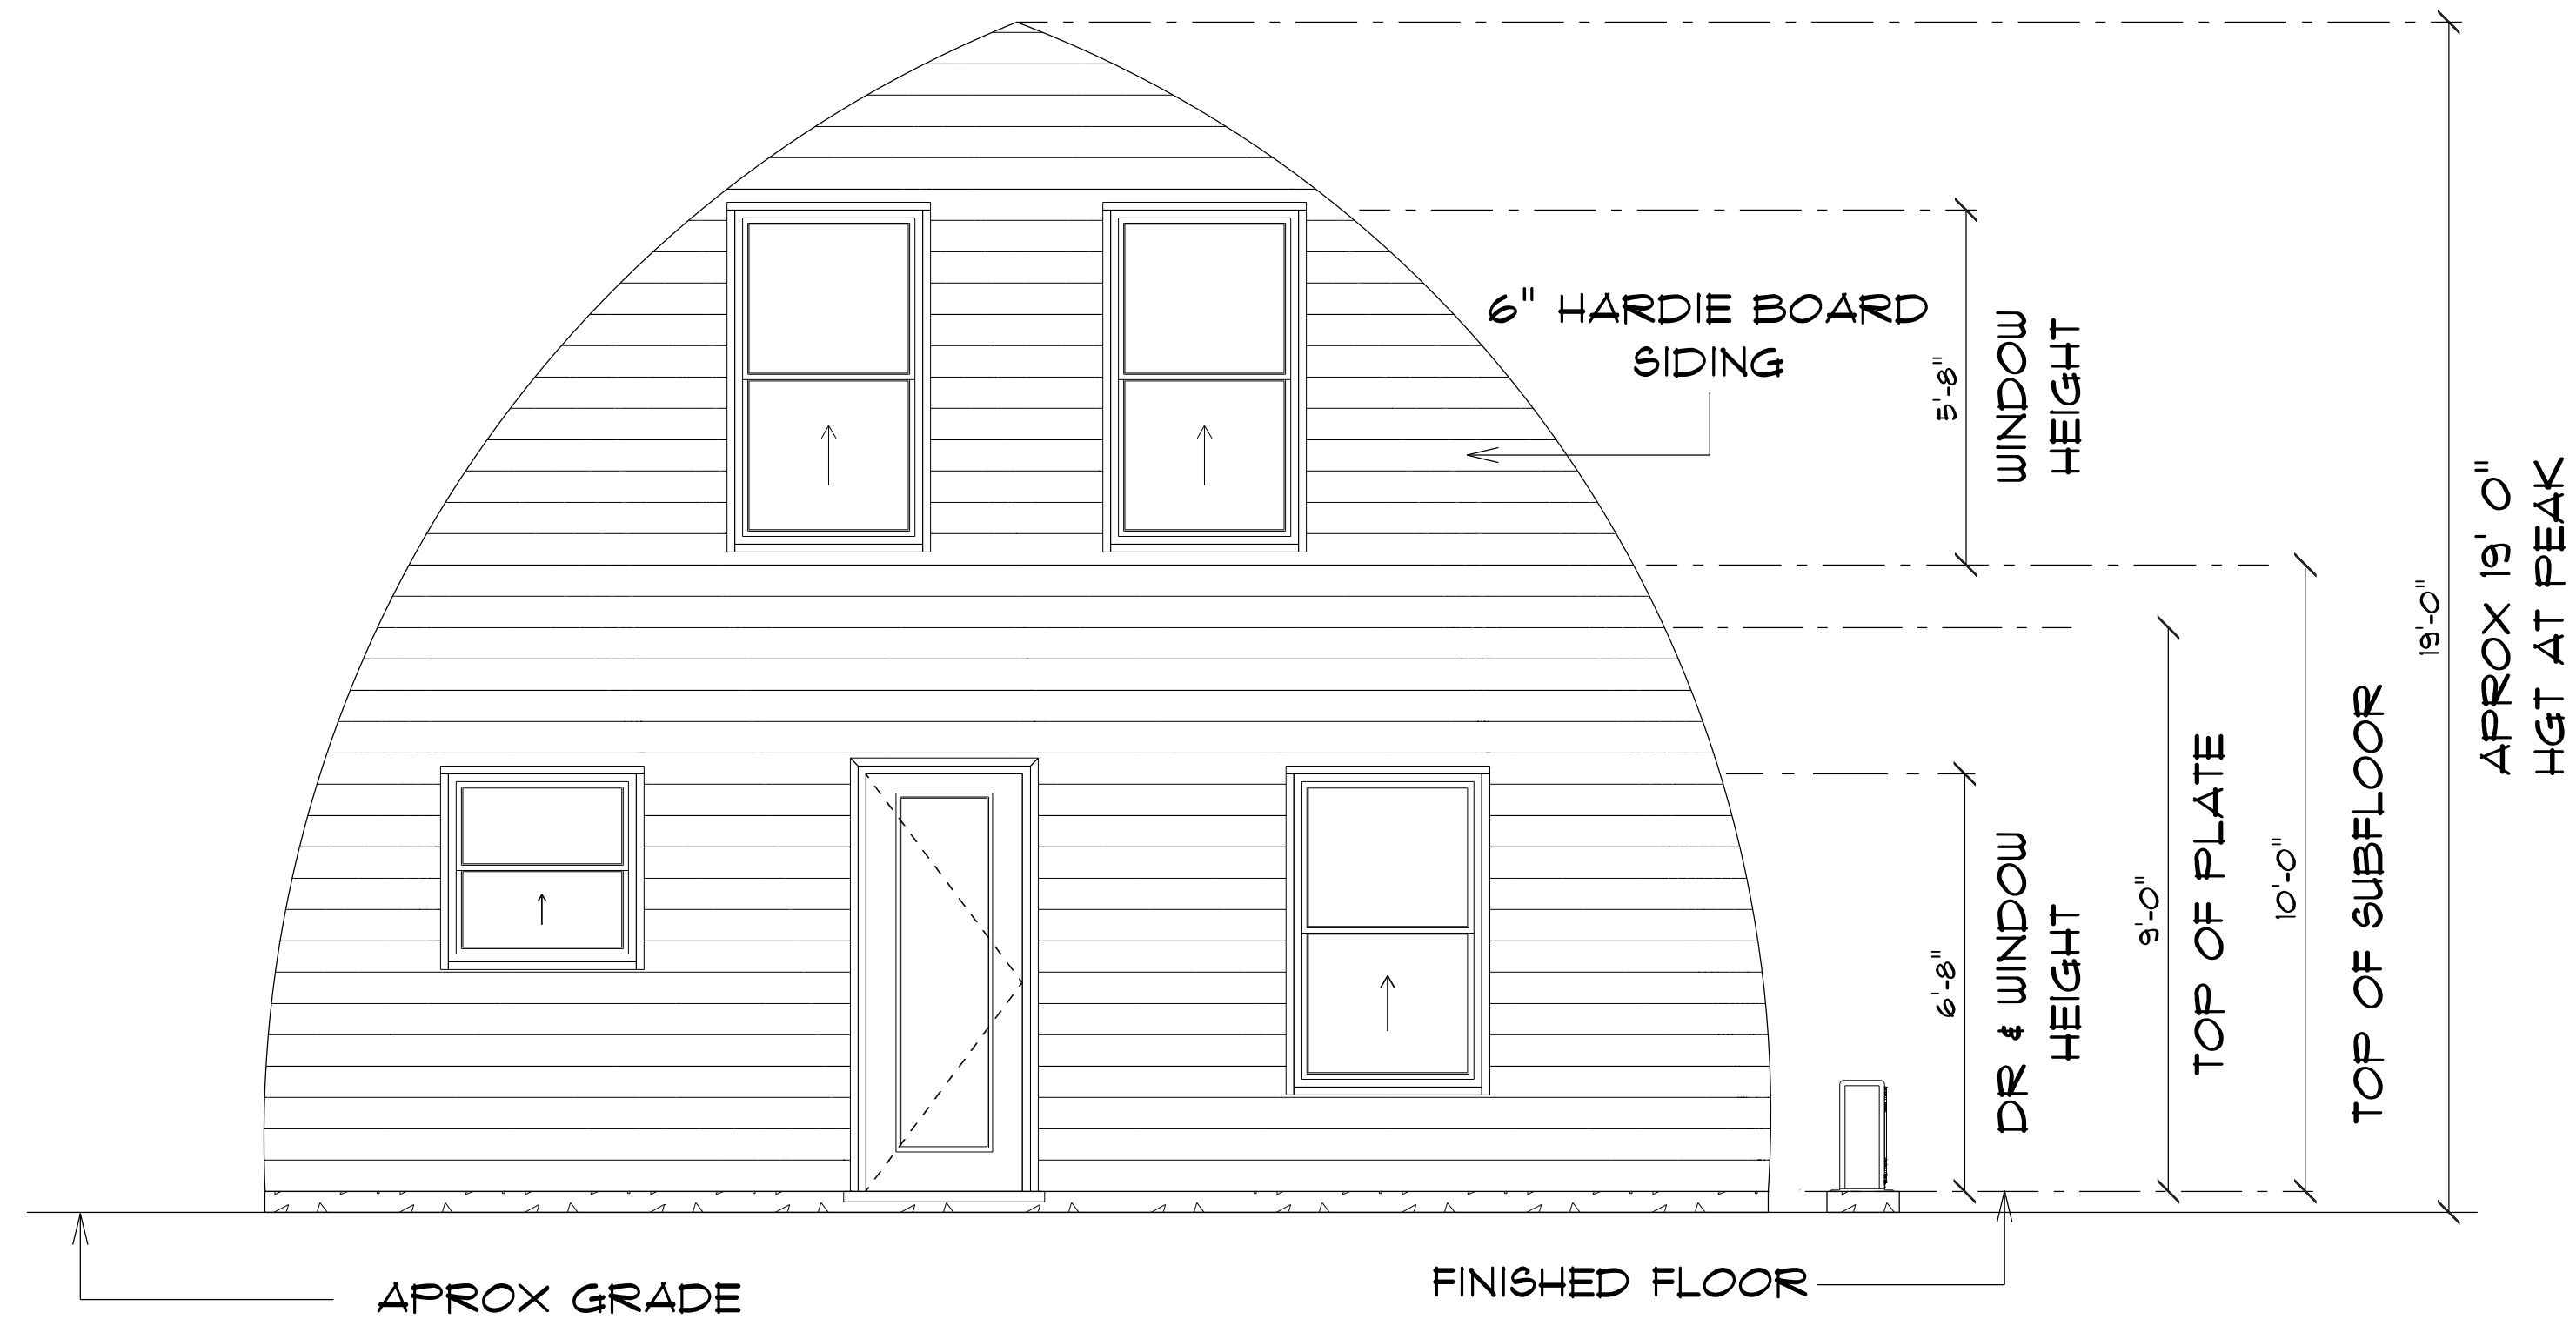

* REAR ELEVATION *

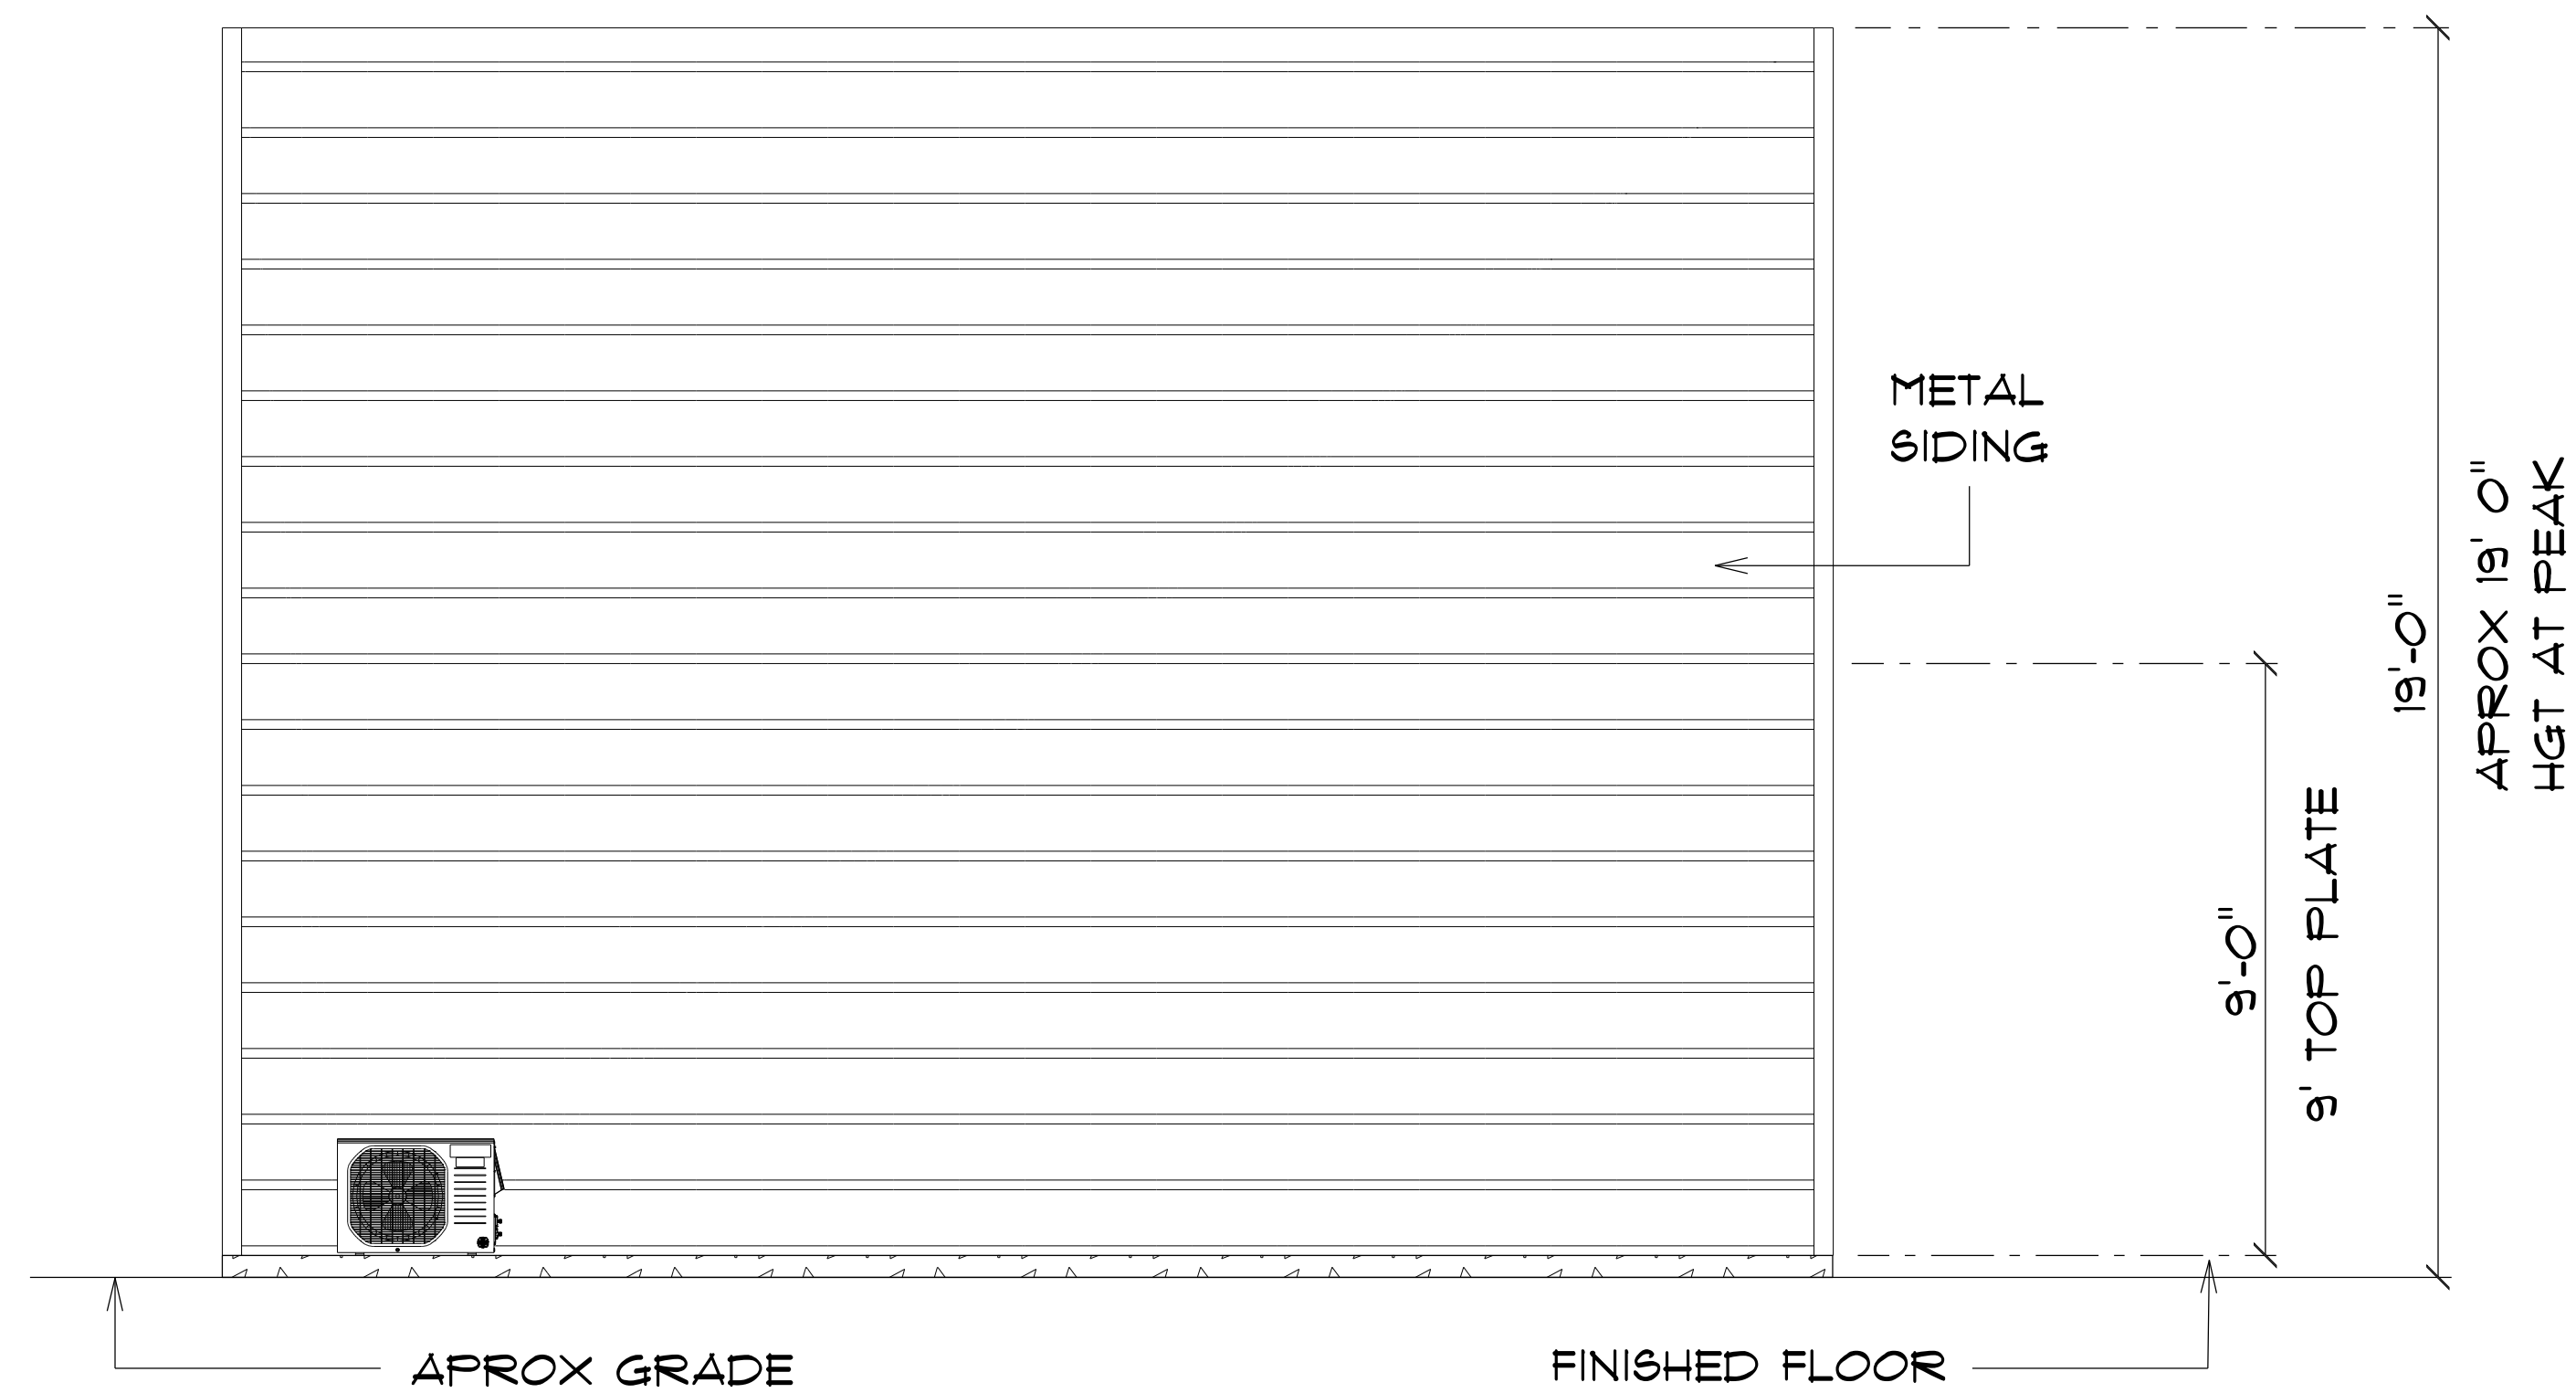

* LEFT ELEVATION *

RESIDENCE
for
AMY FOUCHER
669 SW Pleasant Terrace
Ft. White, FL, 32038
Cell:
Email:

Teena M. Ruffo
2925 SW SR 41
Lake City Florida, 32025
Cell: (386) 861 - 1191
Email: teenaruffo@gmail.com

PRINTED DATE:
Tuesday, November 12, 2024

DRAWN BY: Teena & Kara CHECKED BY:

BUILDING CONTRACTOR

FINAL& DATE:

JOB NUMBER:

DRAWING NUMBER

A - 6


OF 8 SHEETS

ELECTRICAL LEGEND		
ELECTRICAL	COUNT	SYMBOL
ceiling classic	1	
ceiling fan	3	
electrical panel	1	
GENERATOR INLET BOX	1	
outlet	25	
outlet 220v	4	
outlet gfi	6	
outlet up	2	
pendant large	2	
pot light	3	
smoke detector	2	
spotlight double	2	
switch	13	
switch 3 way	5	
vanity bar light O2	1	
vent light combo	1	

ELECTRICAL PLAN NOTES

- E-1
- WIRE ALL APPLIANCES, HVAC UNITS AND OTHER EQUIPMENT PER MANUFACTORS SPECIFICATIONS.
- E-2
- CONSULT THE OWNER FOR THE NUMBER OF SEPERATE TELEPHONE LINES TO BE INSTALLED.
- E-3
- ALL INSTALLATIONS SHALL BE PER NATIONAL ELECTRIC CODE.
- E-4
- ALL SMOKE DETECTORS SHALL BE 120V W/BATTERY BACKUP OF THE PHOTOELECTRIC TYPE, AND SHALL BE INTERLOCKED TOGETHER. INSTALL INSIDE AND NEAR ALL BEDROOMS.
- E-5
- TELEPHONE, TELEVVISION AND OTHER LOW VOLTAGE DEVICES OR OUTLETS SHALL BE AS PER THE OWNERS DIRECTION AND IN ACCORDANCE WITH APPLICABLE SECTIONS OF NATIONAL ELCT. CODE LATEST EDITION.
- E-6
- ELECTRICAL CONTRACTOR SHALL BE RESPONSIBLE FOR THE DESIGN AND SIZING OF ELECTRICAL SERVICE AND CIRCUITS.
- E-7
- ENTRY OF SERVICE UNDERGROUND OR OVERHEAD) IS TO BE DETERMINED BY THE POWER COMPANY.
- E-8
- ALL BEDROOM RECEPTICALS ARE TO BE AFCI (ARC FAULT CIRCUIT INTERRUPT)

MAIN A/C LIVING AREA	=	576 S.F.
LOFT AREA	=	226 S.F.
TOTAL AREA UNDER ROOF		= 802 S.F.

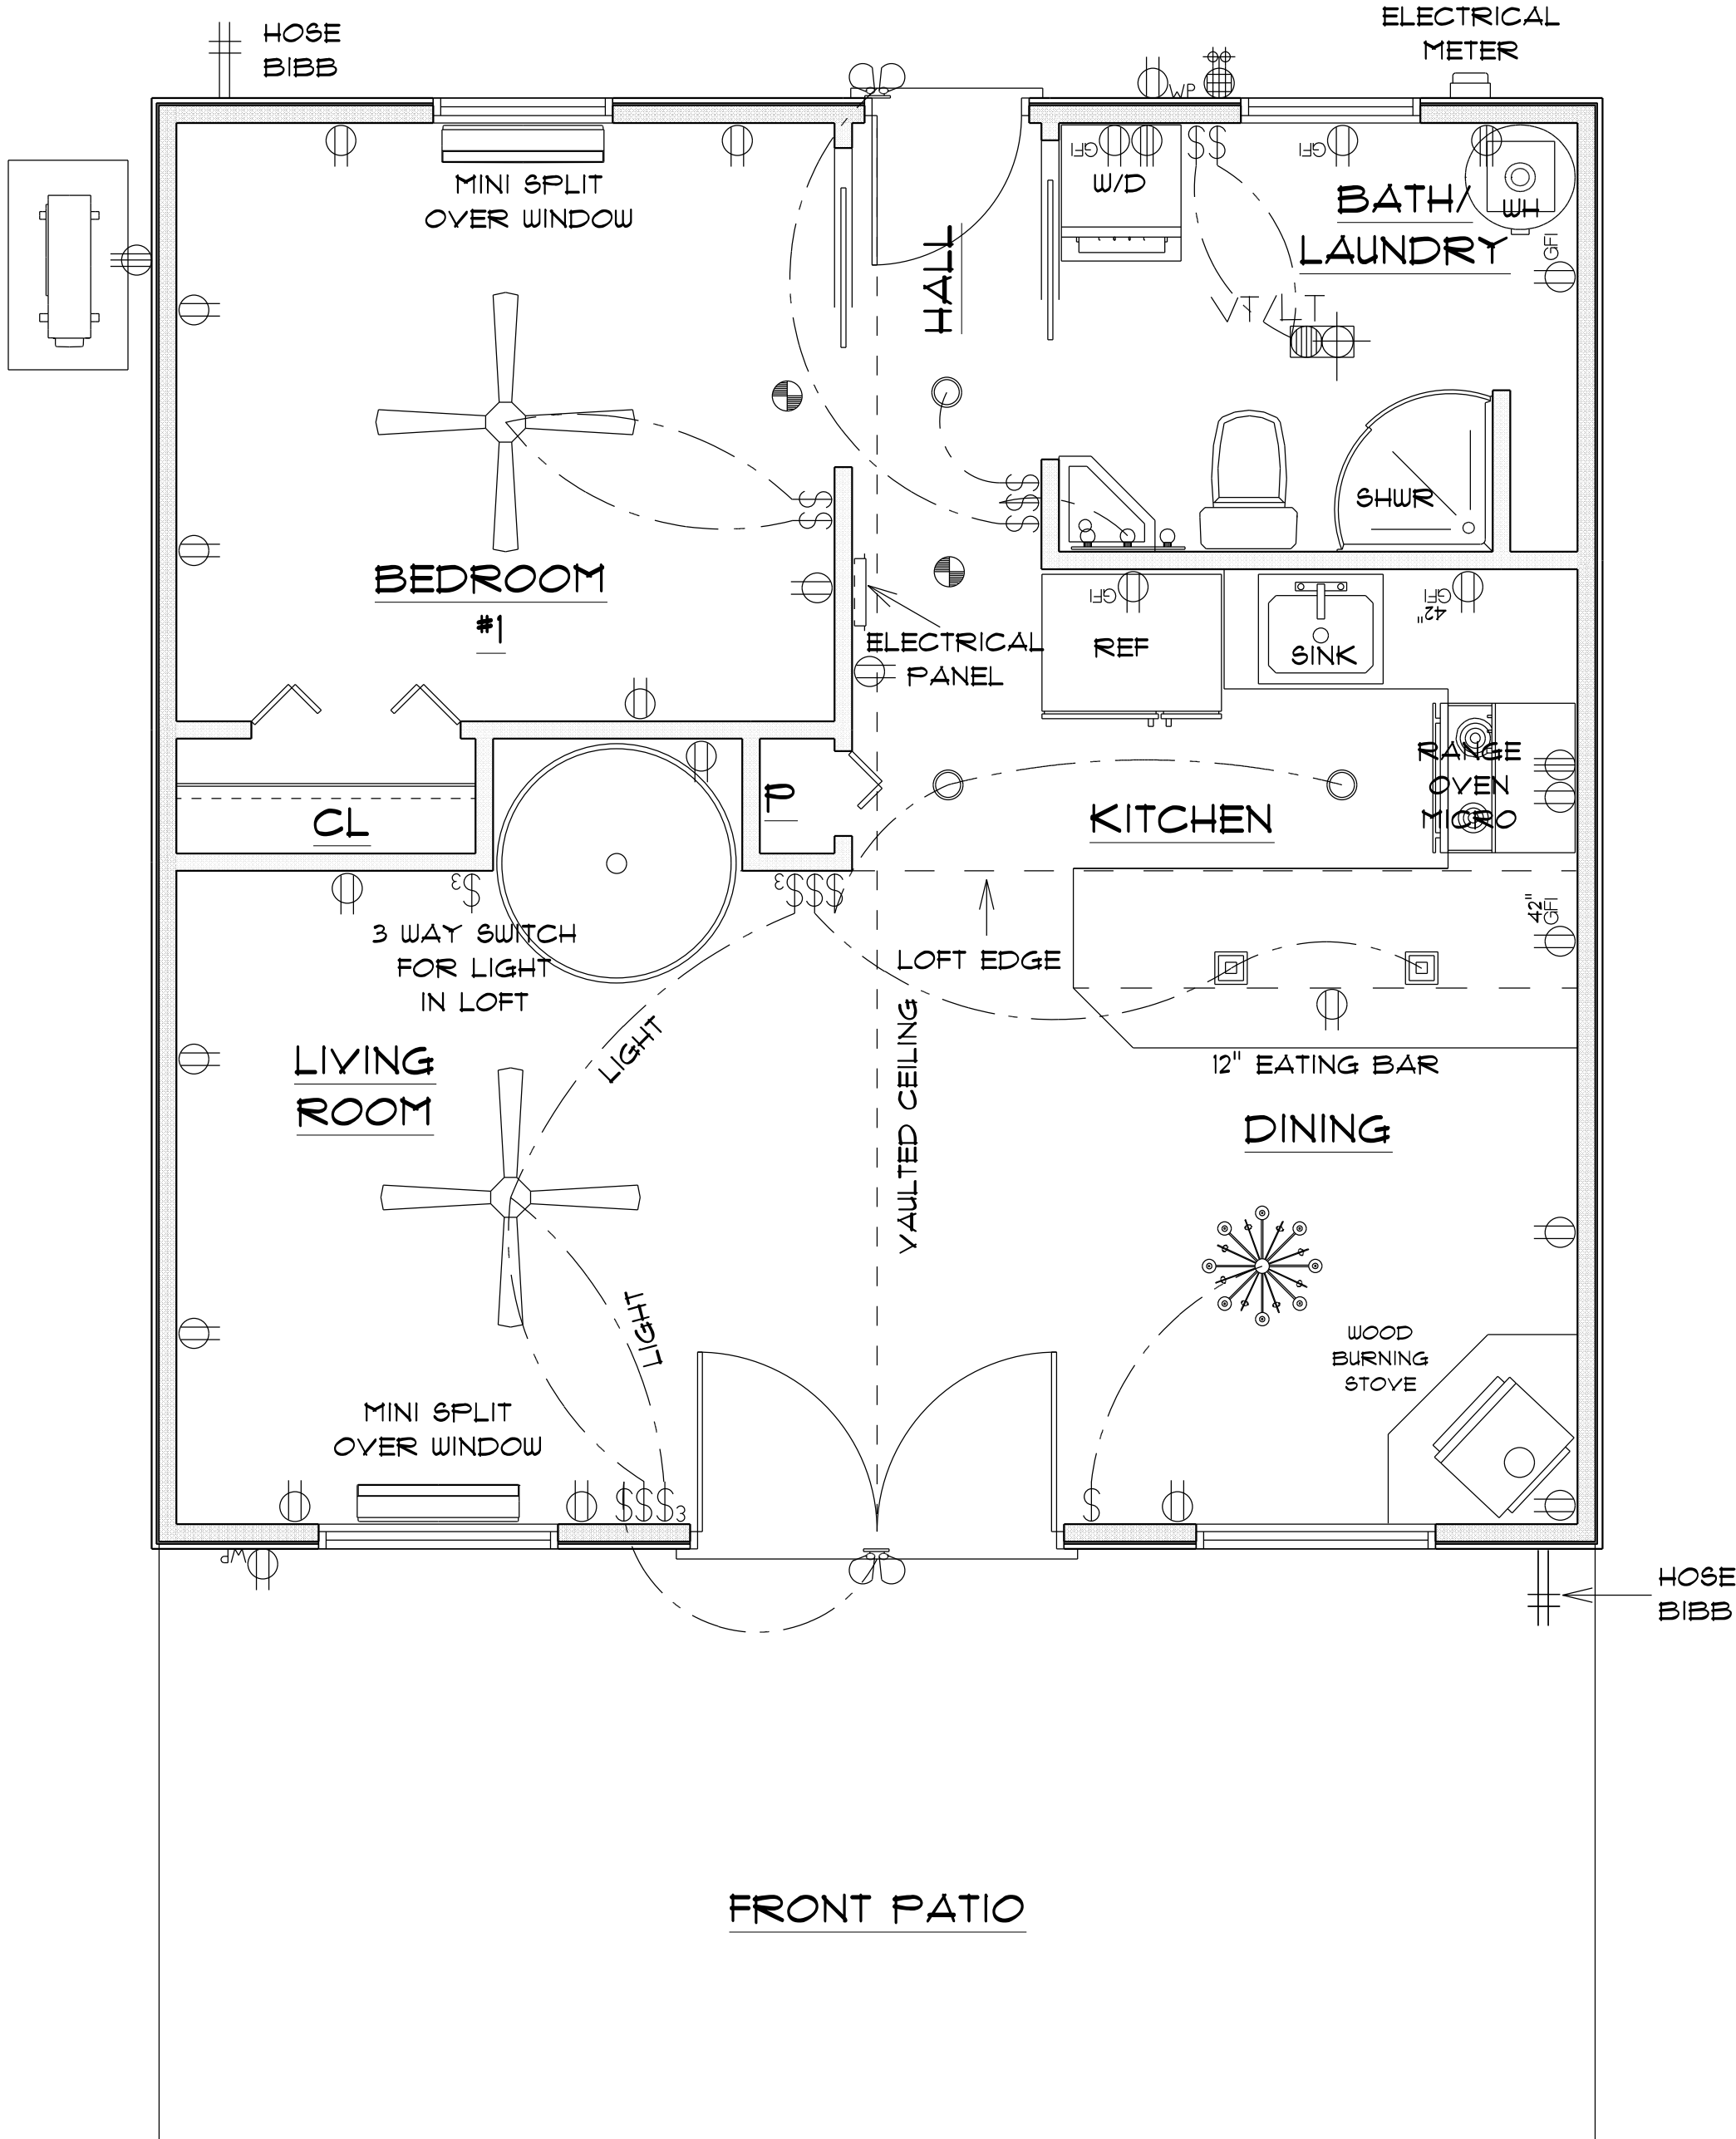

* MAIN FLOOR *
* ELECTRICAL PLAN *

SCALE : 3/8" = 1'-0"

IMPORTANT NOTE:

1. IT IS THE BUILDERS RESPONSIBILITY TO VERIFY ALL GEOMETRY AND DIMENSIONS BEFORE ORDERING ANY MATERIALS OR BEGINNING CONSTRUCTION.
2. THESE PLANS ARE FOR LAYOUT AND DESIGN PURPOSES ONLY ALL STRUCTURAL NOTES AND DETAILS TO BE PROVIDED BY AN ENGINEER.
3. 2X6 EXTERIOR STUD WALLS 2X4 INTERIOR WALLS

RESIDENCE
for
AMY FOUCHER
669 SW Pleasant Terrace
Ft. White, FL, 32038
Cell:
Email:

Teena M. Ruffo
2925 SW SR 47
Lake City Florida, 32025
Cell: (386) 867 - 1191
Email: teenaruffo@gmail.com

PRINTED DATE:
Tuesday, November 12, 2024

DRAWN BY: Teena & Kara


CHECKED BY:

BUILDING CONTRACTOR

FINAL& DATE:

JOB NUMBER:

DRAWING NUMBER
A - 1
OF 8 SHEETS

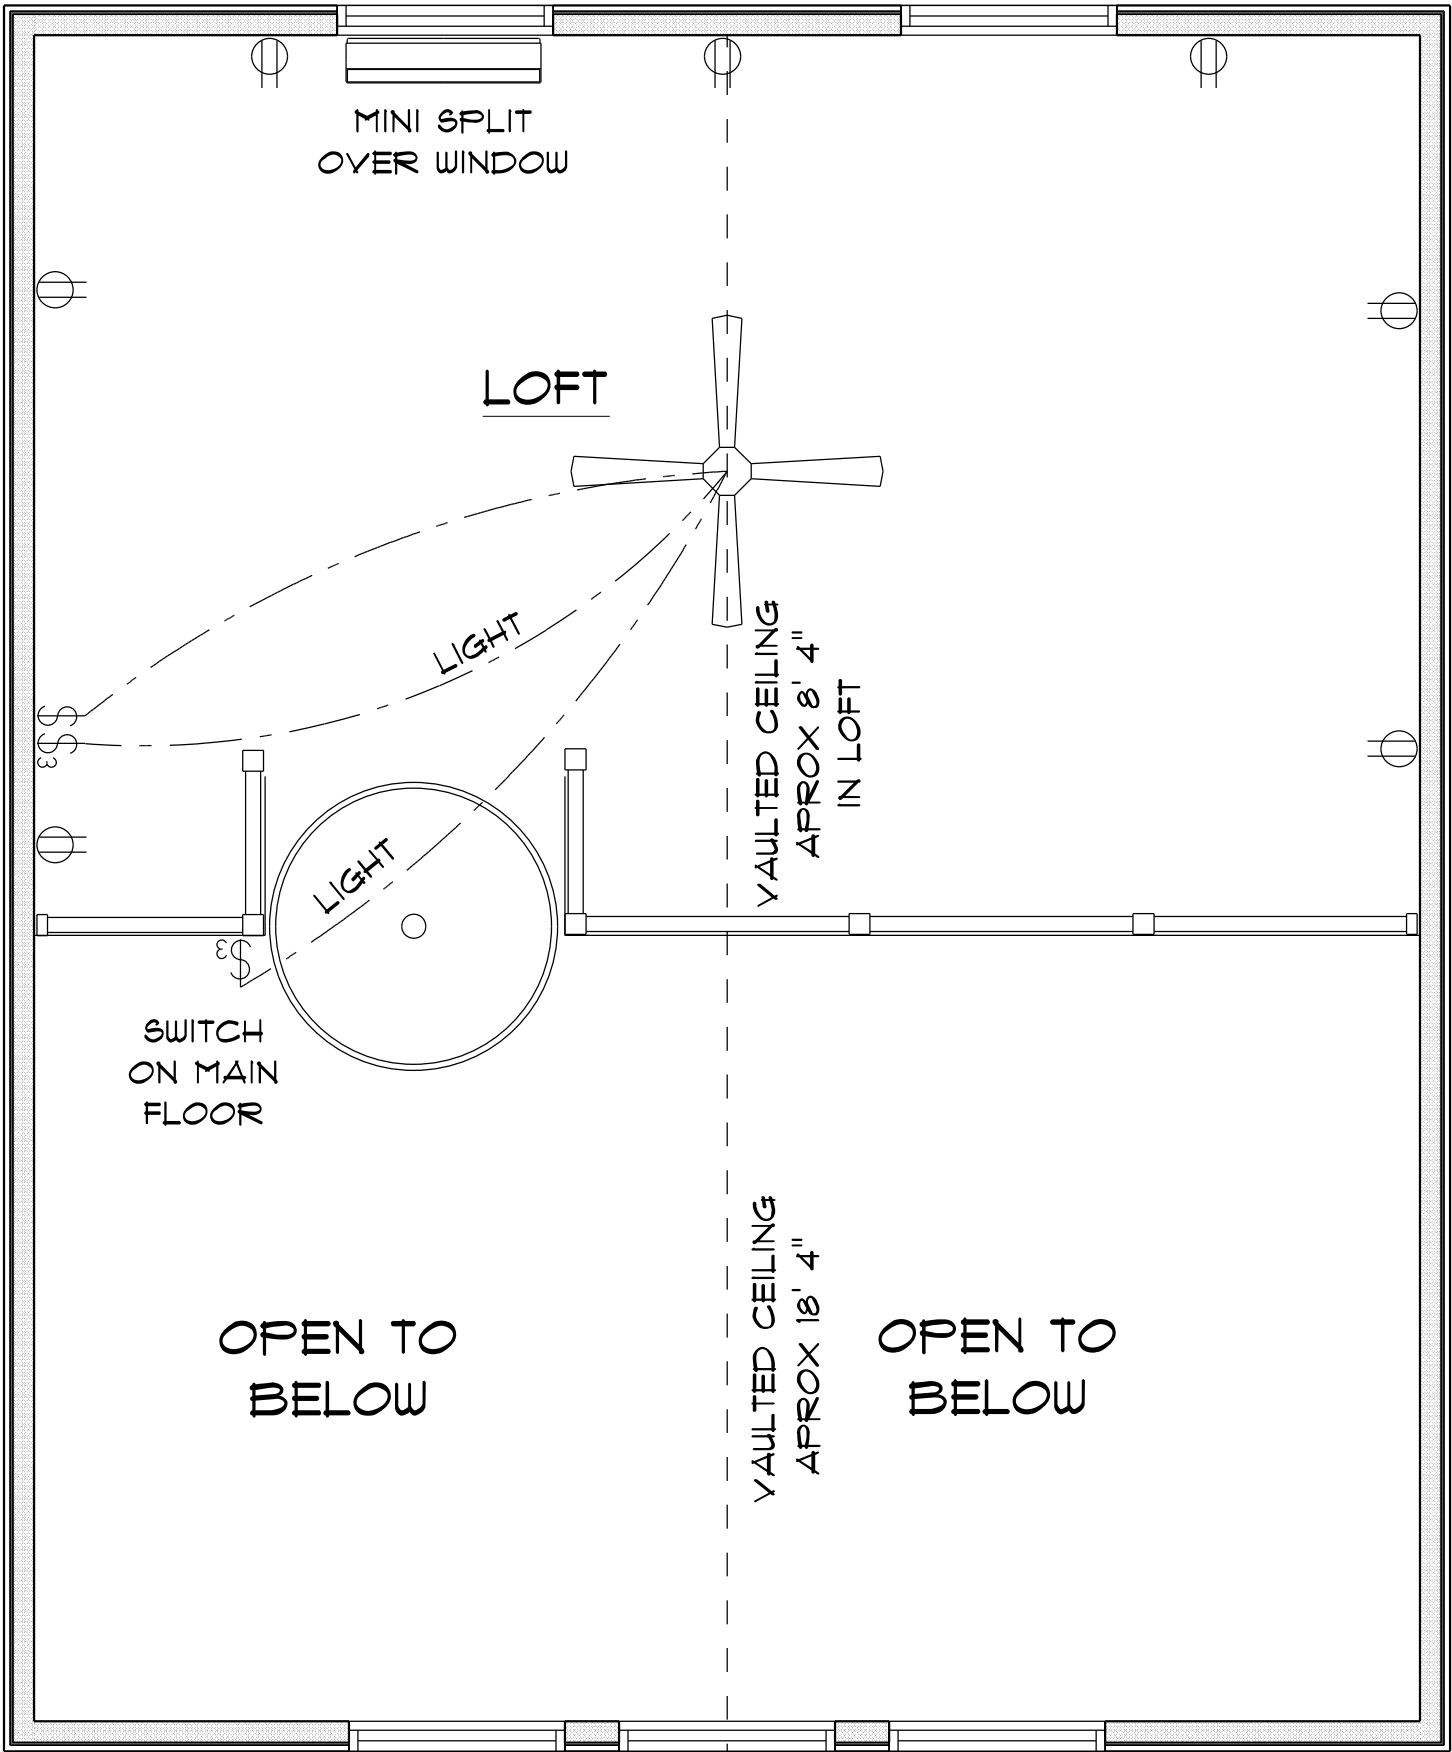

* SECOND FLOOR *

* ELECTRICAL PLAN *

RESIDENCE for AMY FOUCHER	
669 SW Pleasant Terrace Ft. White, FL, 32038 Cell: Email:	
Teena M. Ruffo 2925 SW SR 47 Lake City Florida, 32025 Cell: (386) 867 - 1191 Email: teenaruffo@gmail.com	
PRINTED DATE: Tuesday, November 12, 2024	
DRAWN BY: Teena & Kara	CHECKED BY:
BUILDING CONTRACTOR	
FINAL \$ DATE:	
JOB NUMBER:	
DRAWING NUMBER A - 8 OF 8 SHEETS	