


3230	H/C
212	FRONT PORCH
218	REAR PORCH
528	GARAGE
4188	TOTAL SQFT


Amaranthine Residential Design home plans were designed according to the 2007 Florida Building Code. All plans were designed to meet the minimum requirements of the building code and are not responsible for meeting the code and requirements of the building code, the building department or structural engineering, and general.

The purchaser and/or builder of this plan releases Amaranthine Residential Design from any claims or lawsuits that may arise during the construction of this home or any portion thereof. Amaranthine Residential Design warrants that the plans are a true and correct representation of the design and construction of the home as shown on the drawings. The purchaser is responsible for obtaining all necessary permits and approvals from the local building department and for ensuring that the construction of the home complies with all applicable codes and regulations. Amaranthine Residential Design is not responsible for any delays or cost overruns due to the purchaser's failure to obtain the necessary permits and approvals or for any other reasons. This service is not included in our plan prices.

All plans published and sold by Amaranthine Residential Design are protected under the United States Copyright Act of 1976 and the United States Patent and Trademark Office. The purchaser is granted a limited use of these plans for construction purposes only. Further distribution of these plans is strictly prohibited. Plans and modifications of plans are subject to change without notice.

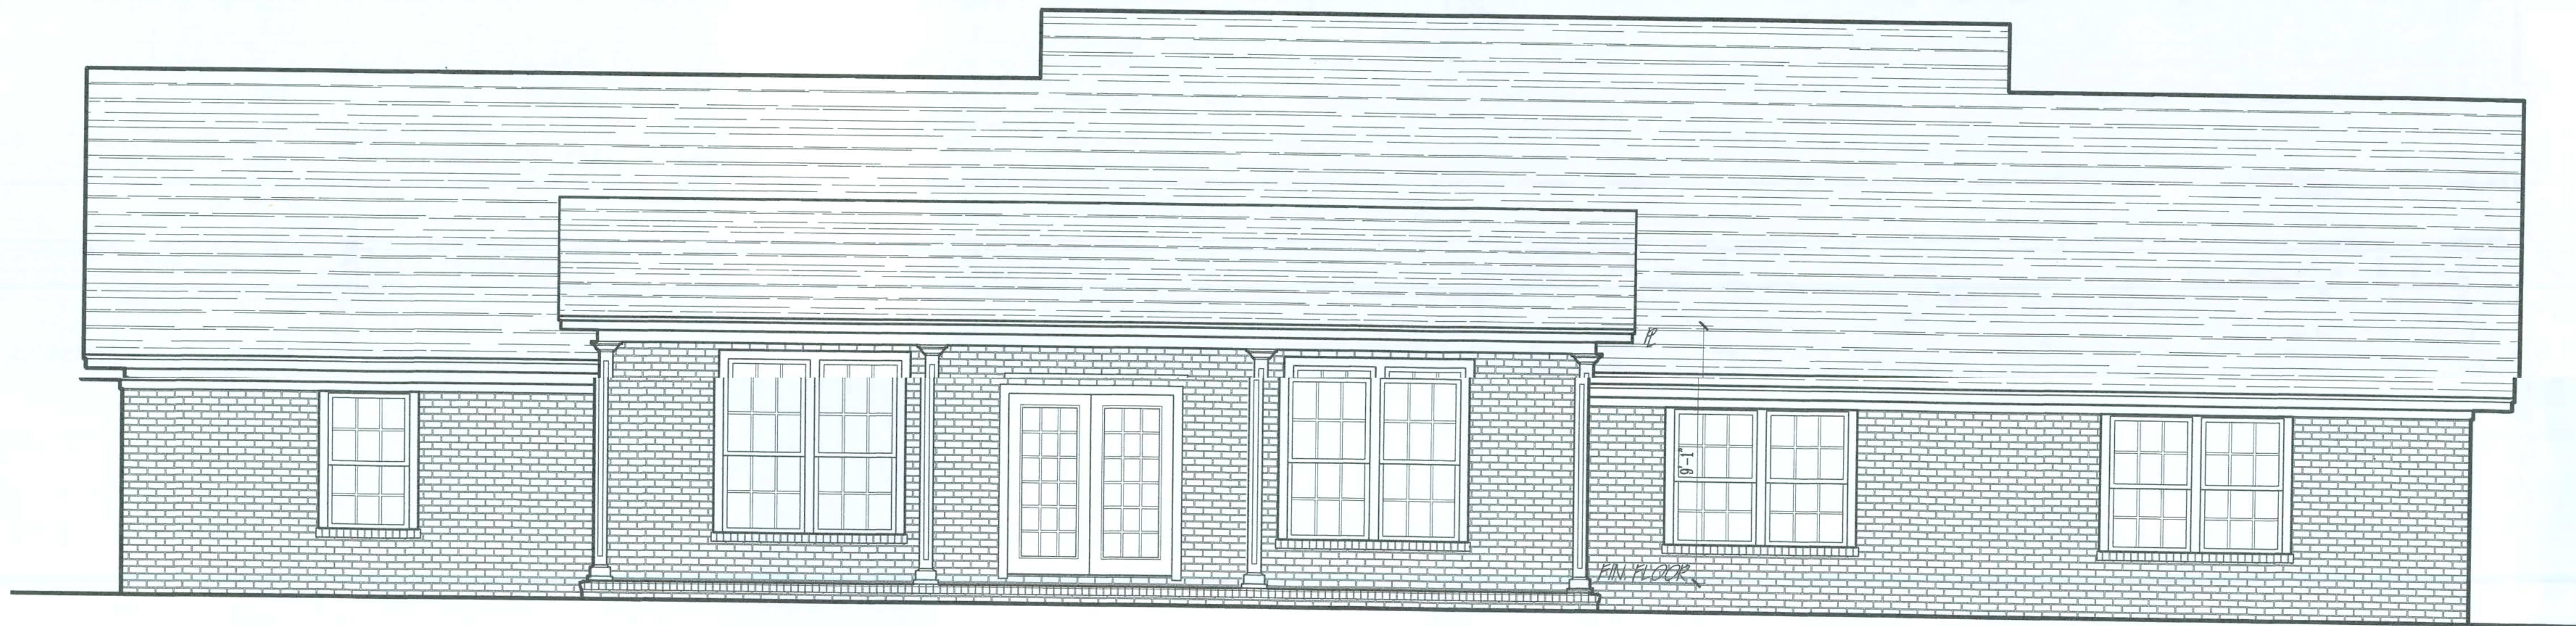

REAR ELEVATION
SCALE: 1/4"=1'-0"

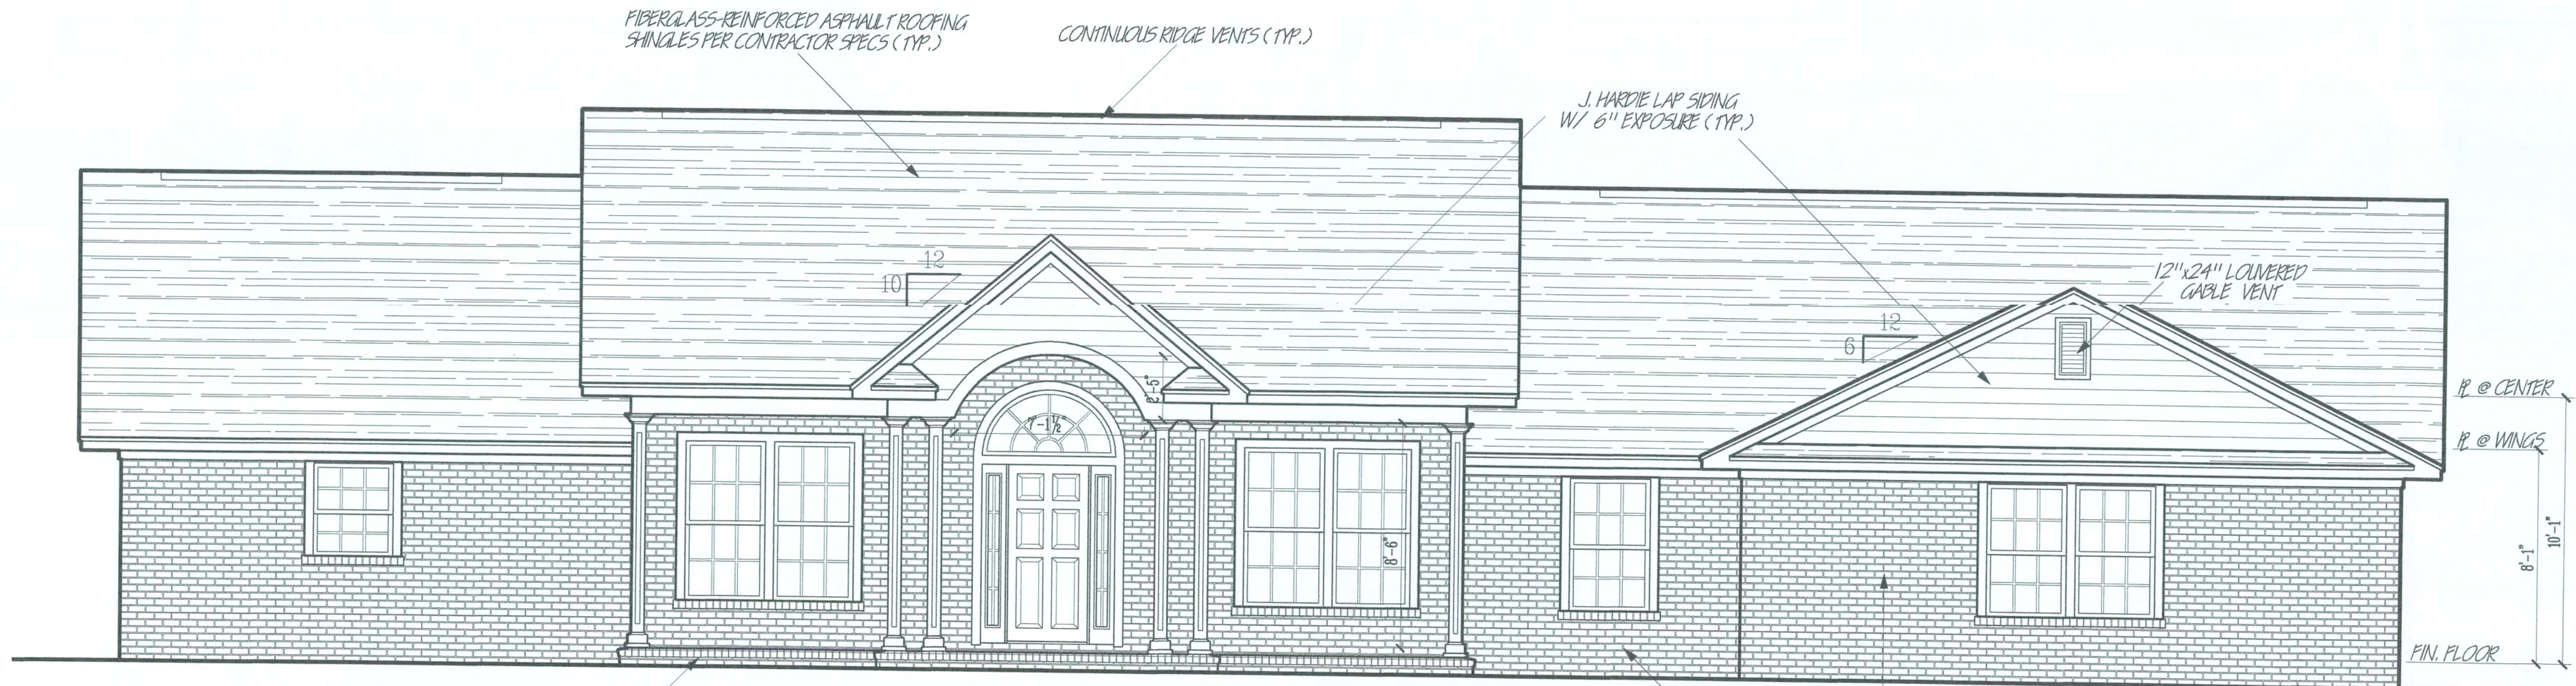


FRONT ELEVATION
SCALE: 1/4"=1'-0"




RICHARDSON
RESIDENCE

DRAWN BY:
SAF
PROJECT#:
0711-032
DATE:
1/17/2008
SHEET 1
OF 6

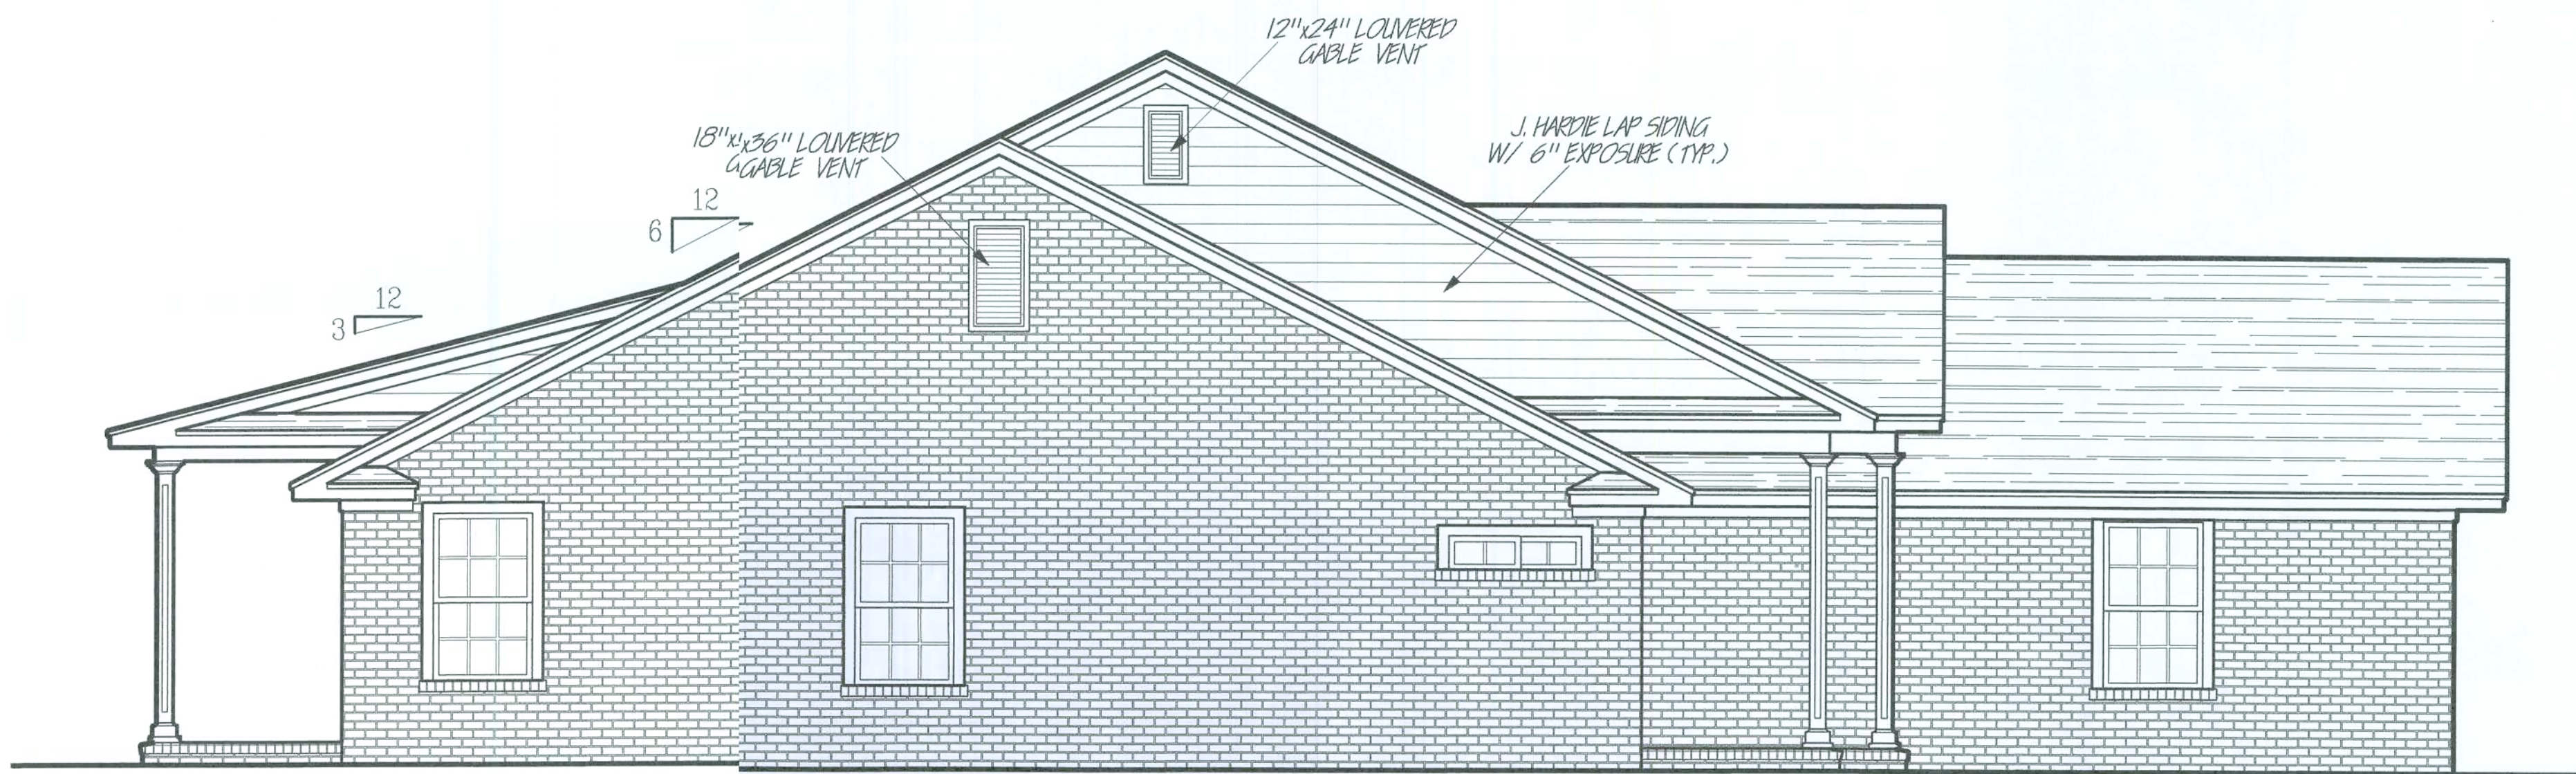


LEFT ELEVATION

SCALE: 1/4"=1'-0"

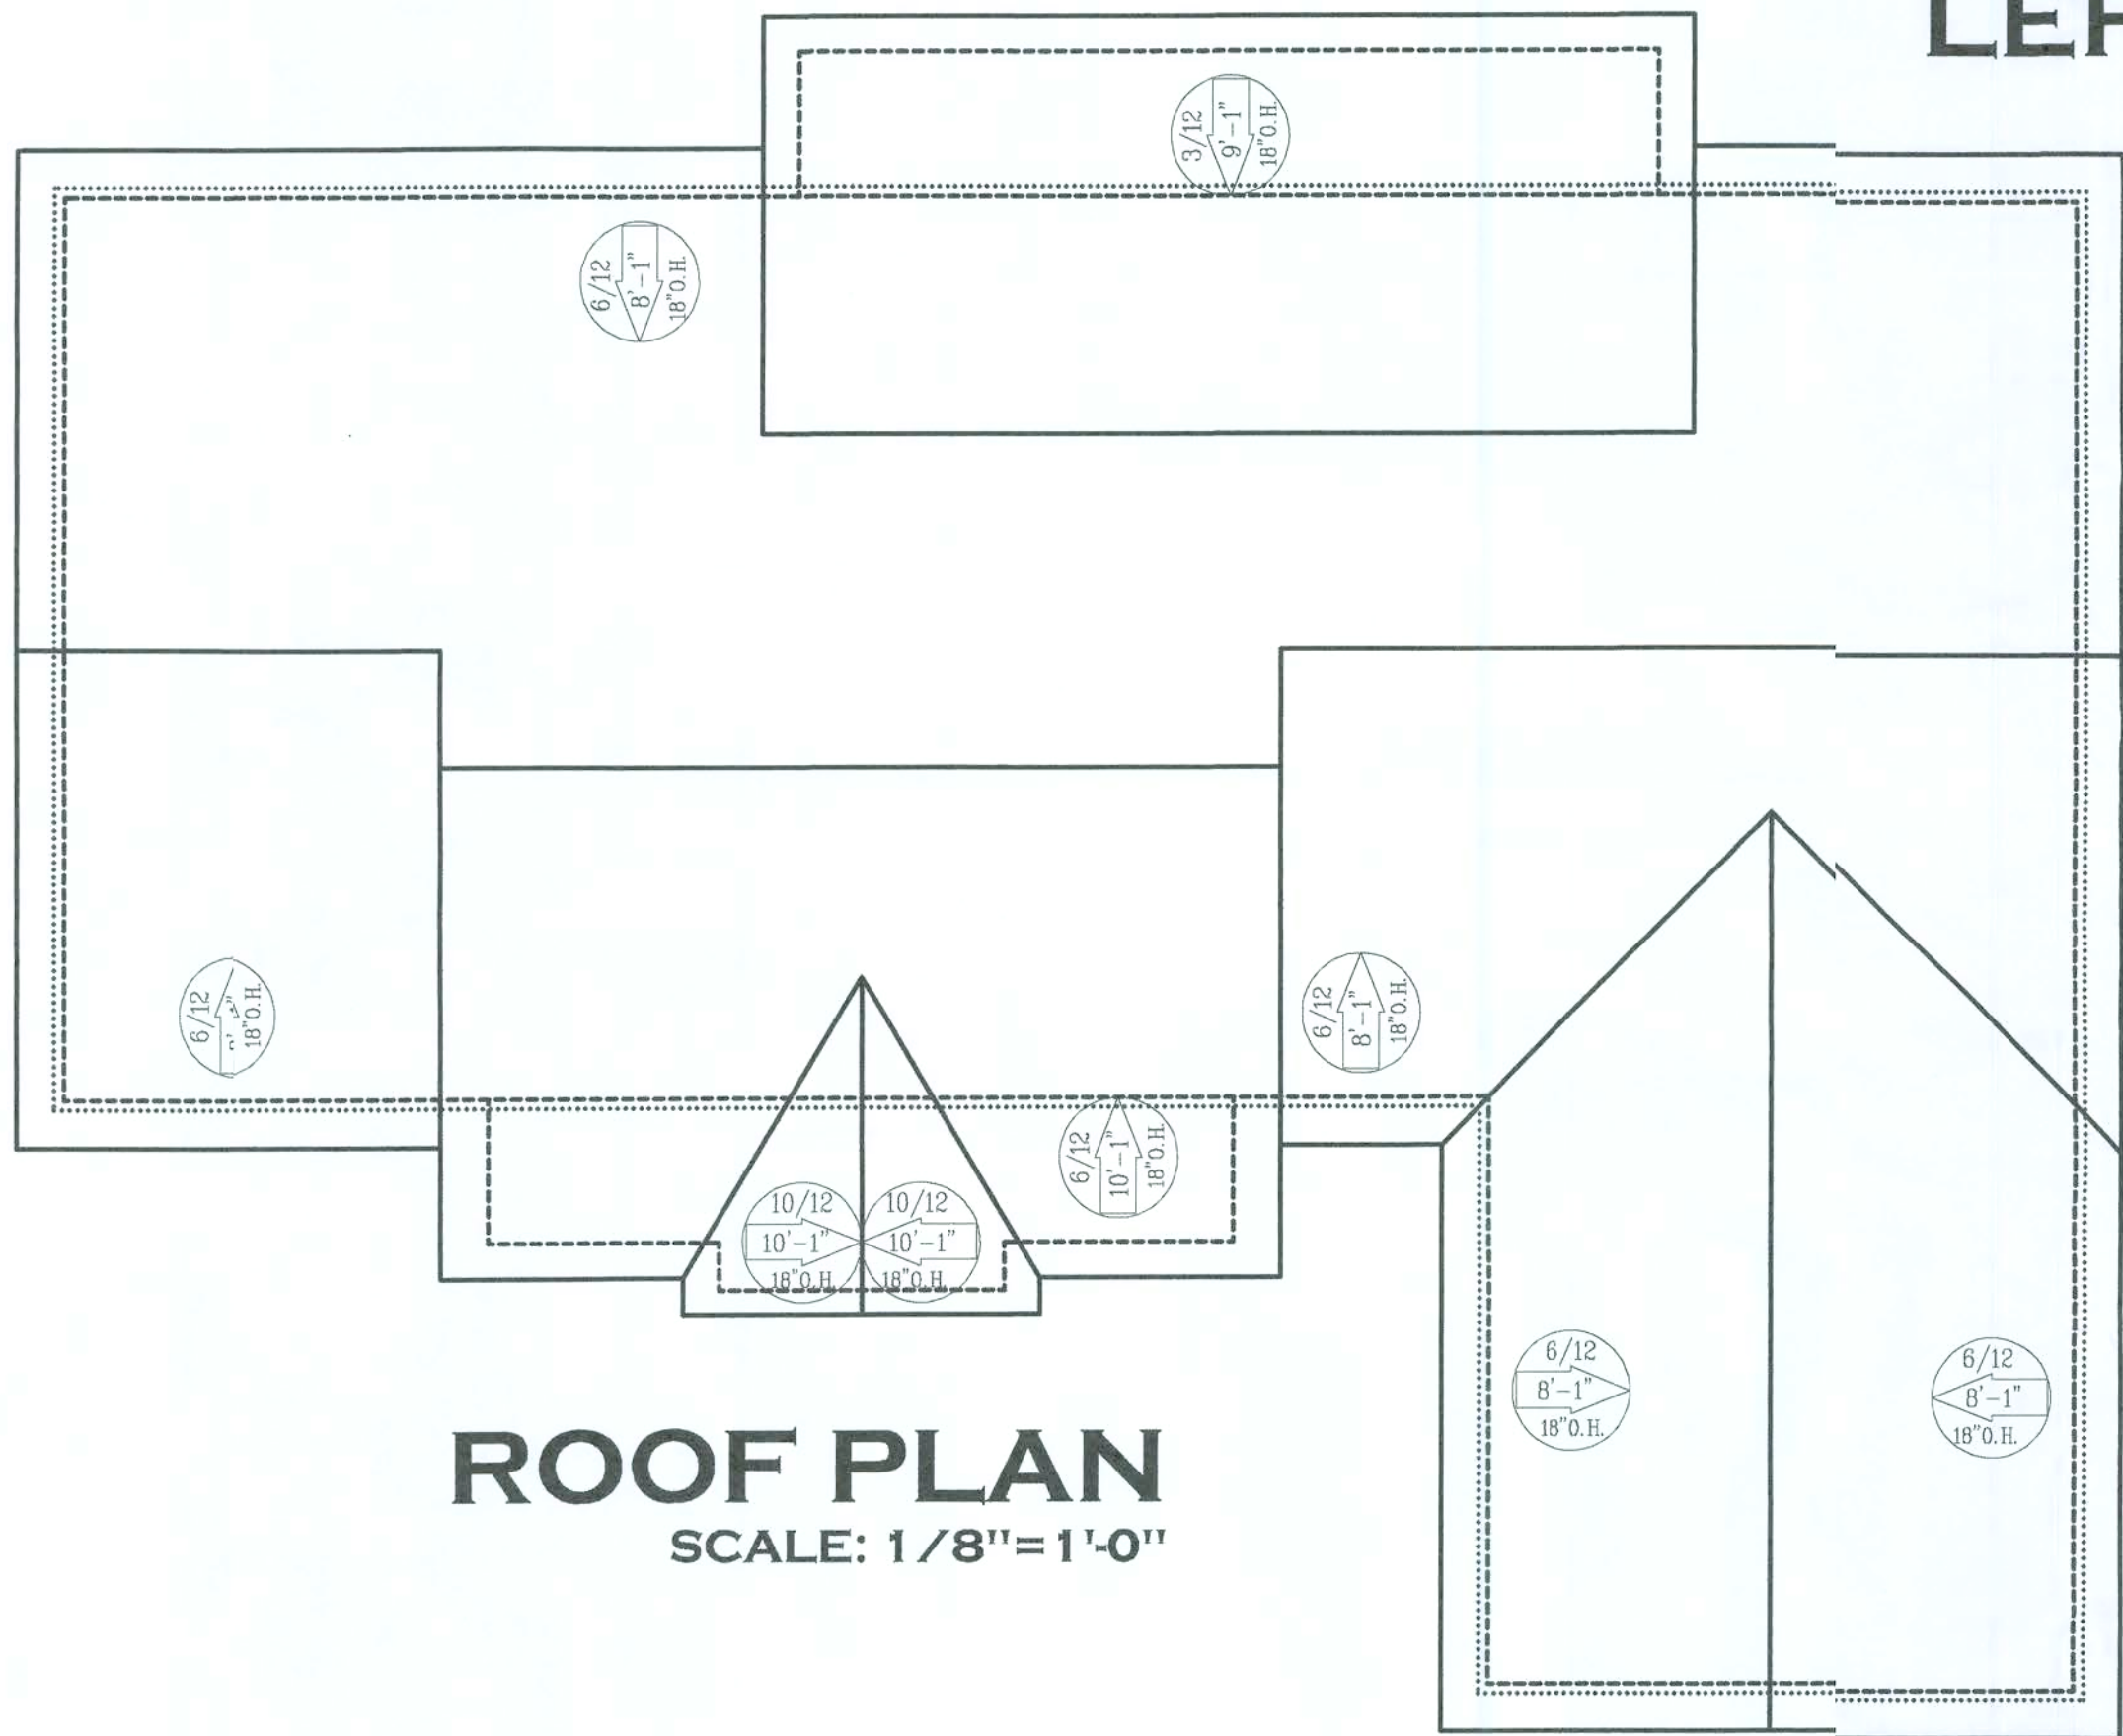

ROOF PLAN

SCALE: 1/8"=1'-0"

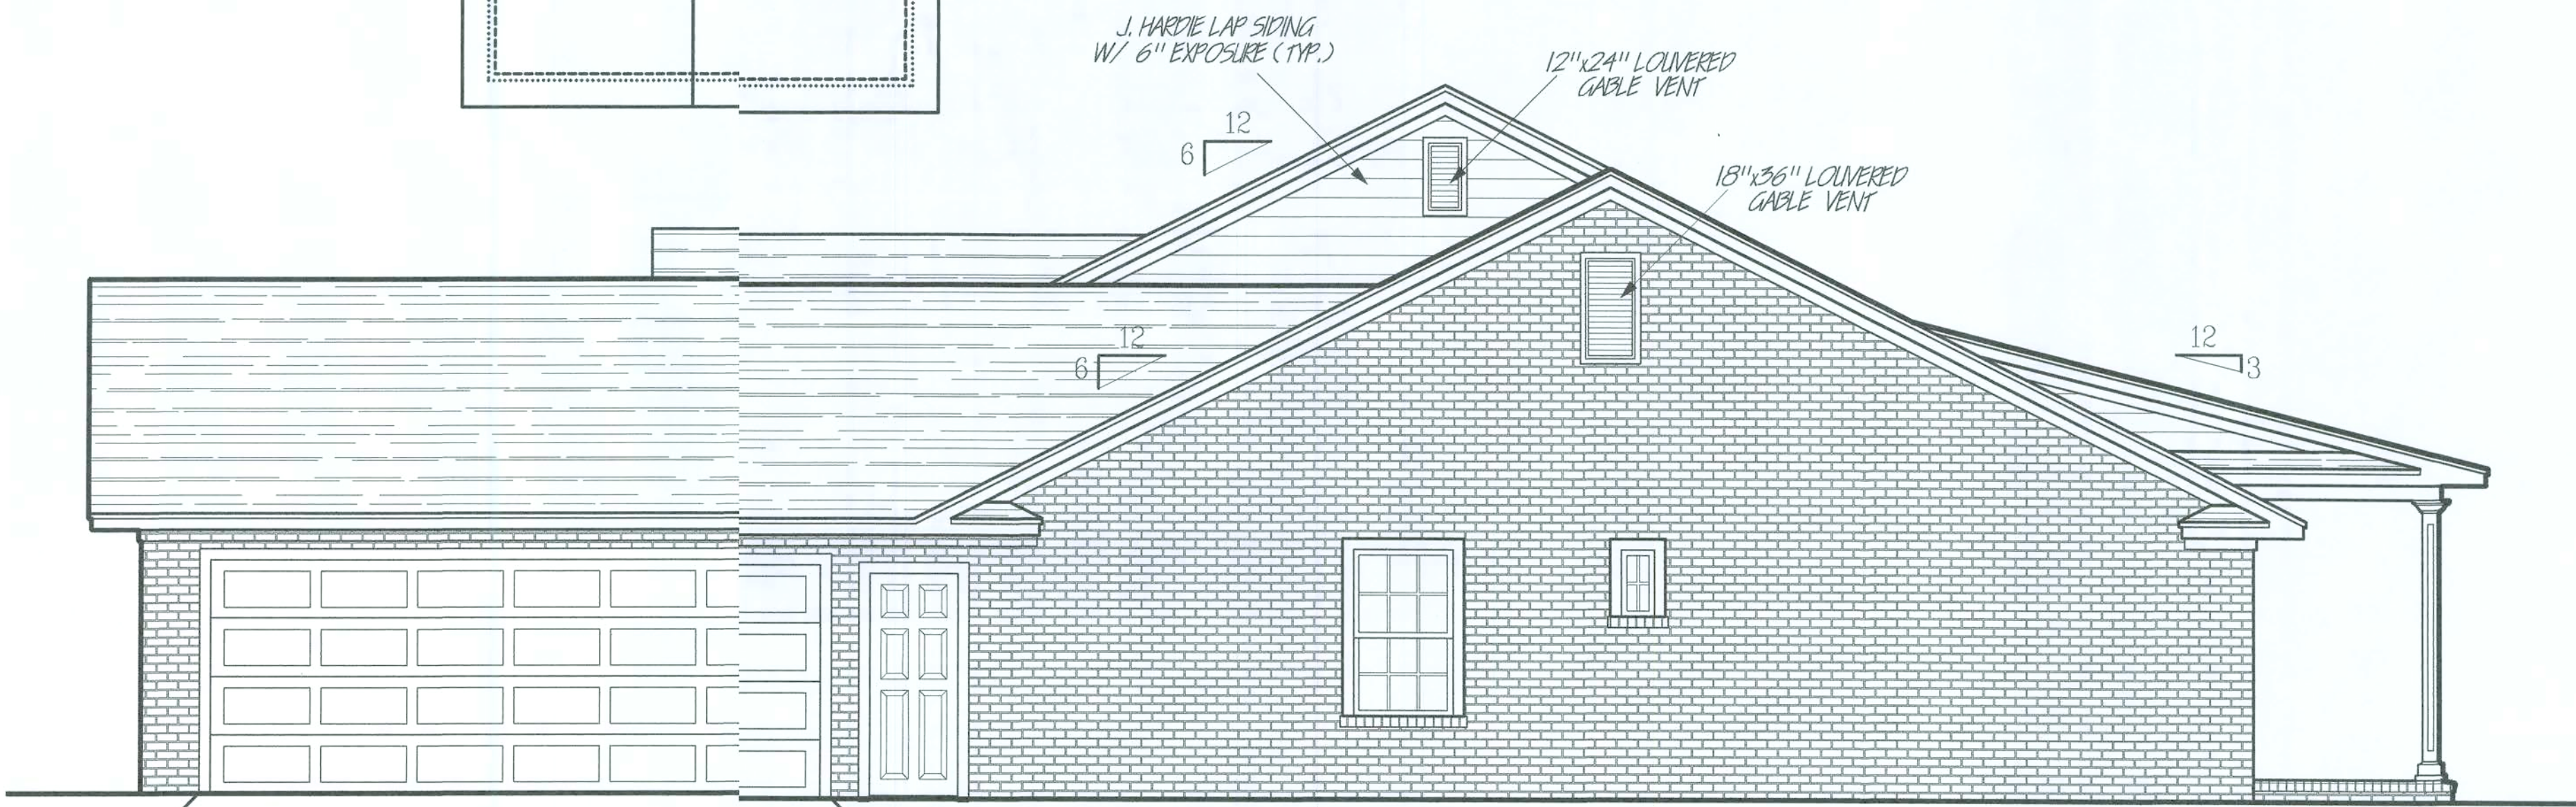

RIGHT ELEVATION


SCALE: 1/4"=1'-0"

3230	H/C
212	FRONT PORCH
218	REAR PORCH
528	GARAGE
4188	TOTAL SQFT

Annotations/Architectural details shown above were prepared according to the 2005 Florida Building Code. All dimensions are given in feet and inches and represent the finished condition of the building. The purchaser of these plans shall be responsible for verifying the scale and dimensions on the drawings, the building, capacity, structural integrity, and general structural integrity.

The purchaser and/or holder of this plan remains responsible for obtaining all necessary permits and approvals from the appropriate authorities. The purchaser and/or holder of this plan shall be responsible for obtaining all necessary permits and approvals from the appropriate authorities. The purchaser and/or holder of this plan shall be responsible for obtaining all necessary permits and approvals from the appropriate authorities.

All photographs and notes by Amaranthine Residential Design are protected under the Florida Copyright Act, Chapter 48, of the Code of Florida Regulations. The purchaser is granted a limited use of these plans for construction purposes only. Further reproduction or use of these plans is strictly prohibited. Prices and conditions of plans are subject to change without notice.

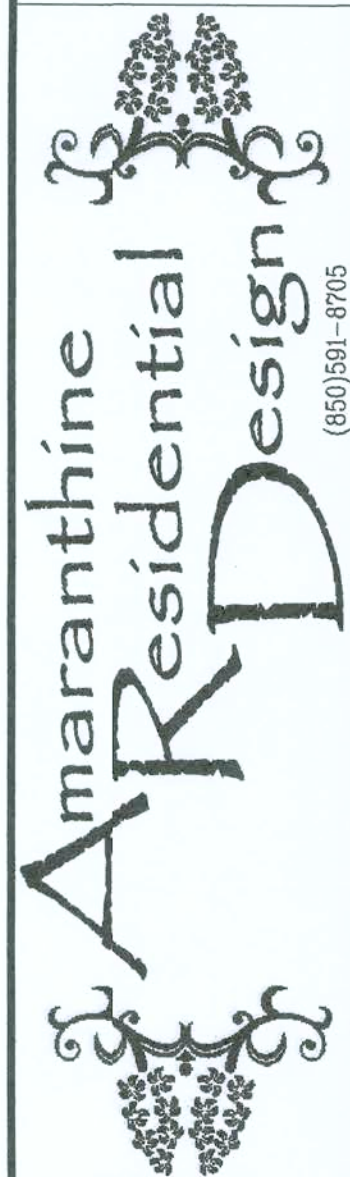

RICHARDSON
RESIDENCE


DRAWN BY:
SAF

PROJECT#:
0711-032

DATE:
1/17/2008

SHEET 2

OF 6

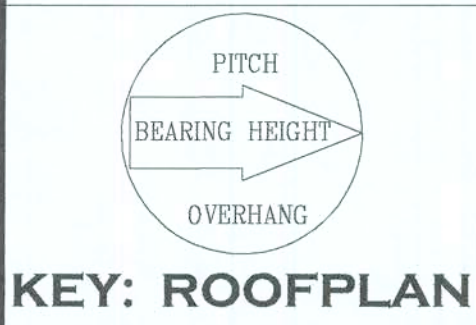


3230	H/C
212	FRONT PORCH
218	REAR PORCH
528	GARAGE
4188	TOTAL SQFT

Amarathine Residential Design home plans were created according to the 2000 Florida Building Code. All plans were designed to meet the minimum requirements of the Florida Building Code. The purchaser is responsible for verifying the scale and dimensions of the drawings, the building capacity of structural elements, and general structural integrity.

The purchaser and/or builder of this plan should consult the local building department for any codes or laws that may apply during the construction of this home or before occupancy. Amarathine Residential Design is not responsible for the construction of this home. The purchaser is responsible for the construction of this home. The purchaser is responsible for the construction of this home. The purchaser is responsible for the construction of this home.

All plans published and sold by Amarathine Residential Design are produced under the license of the American Institute of Architects. The purchaser is responsible for the construction of this home. The purchaser is responsible for the construction of this home. The purchaser is responsible for the construction of this home. The purchaser is responsible for the construction of this home.

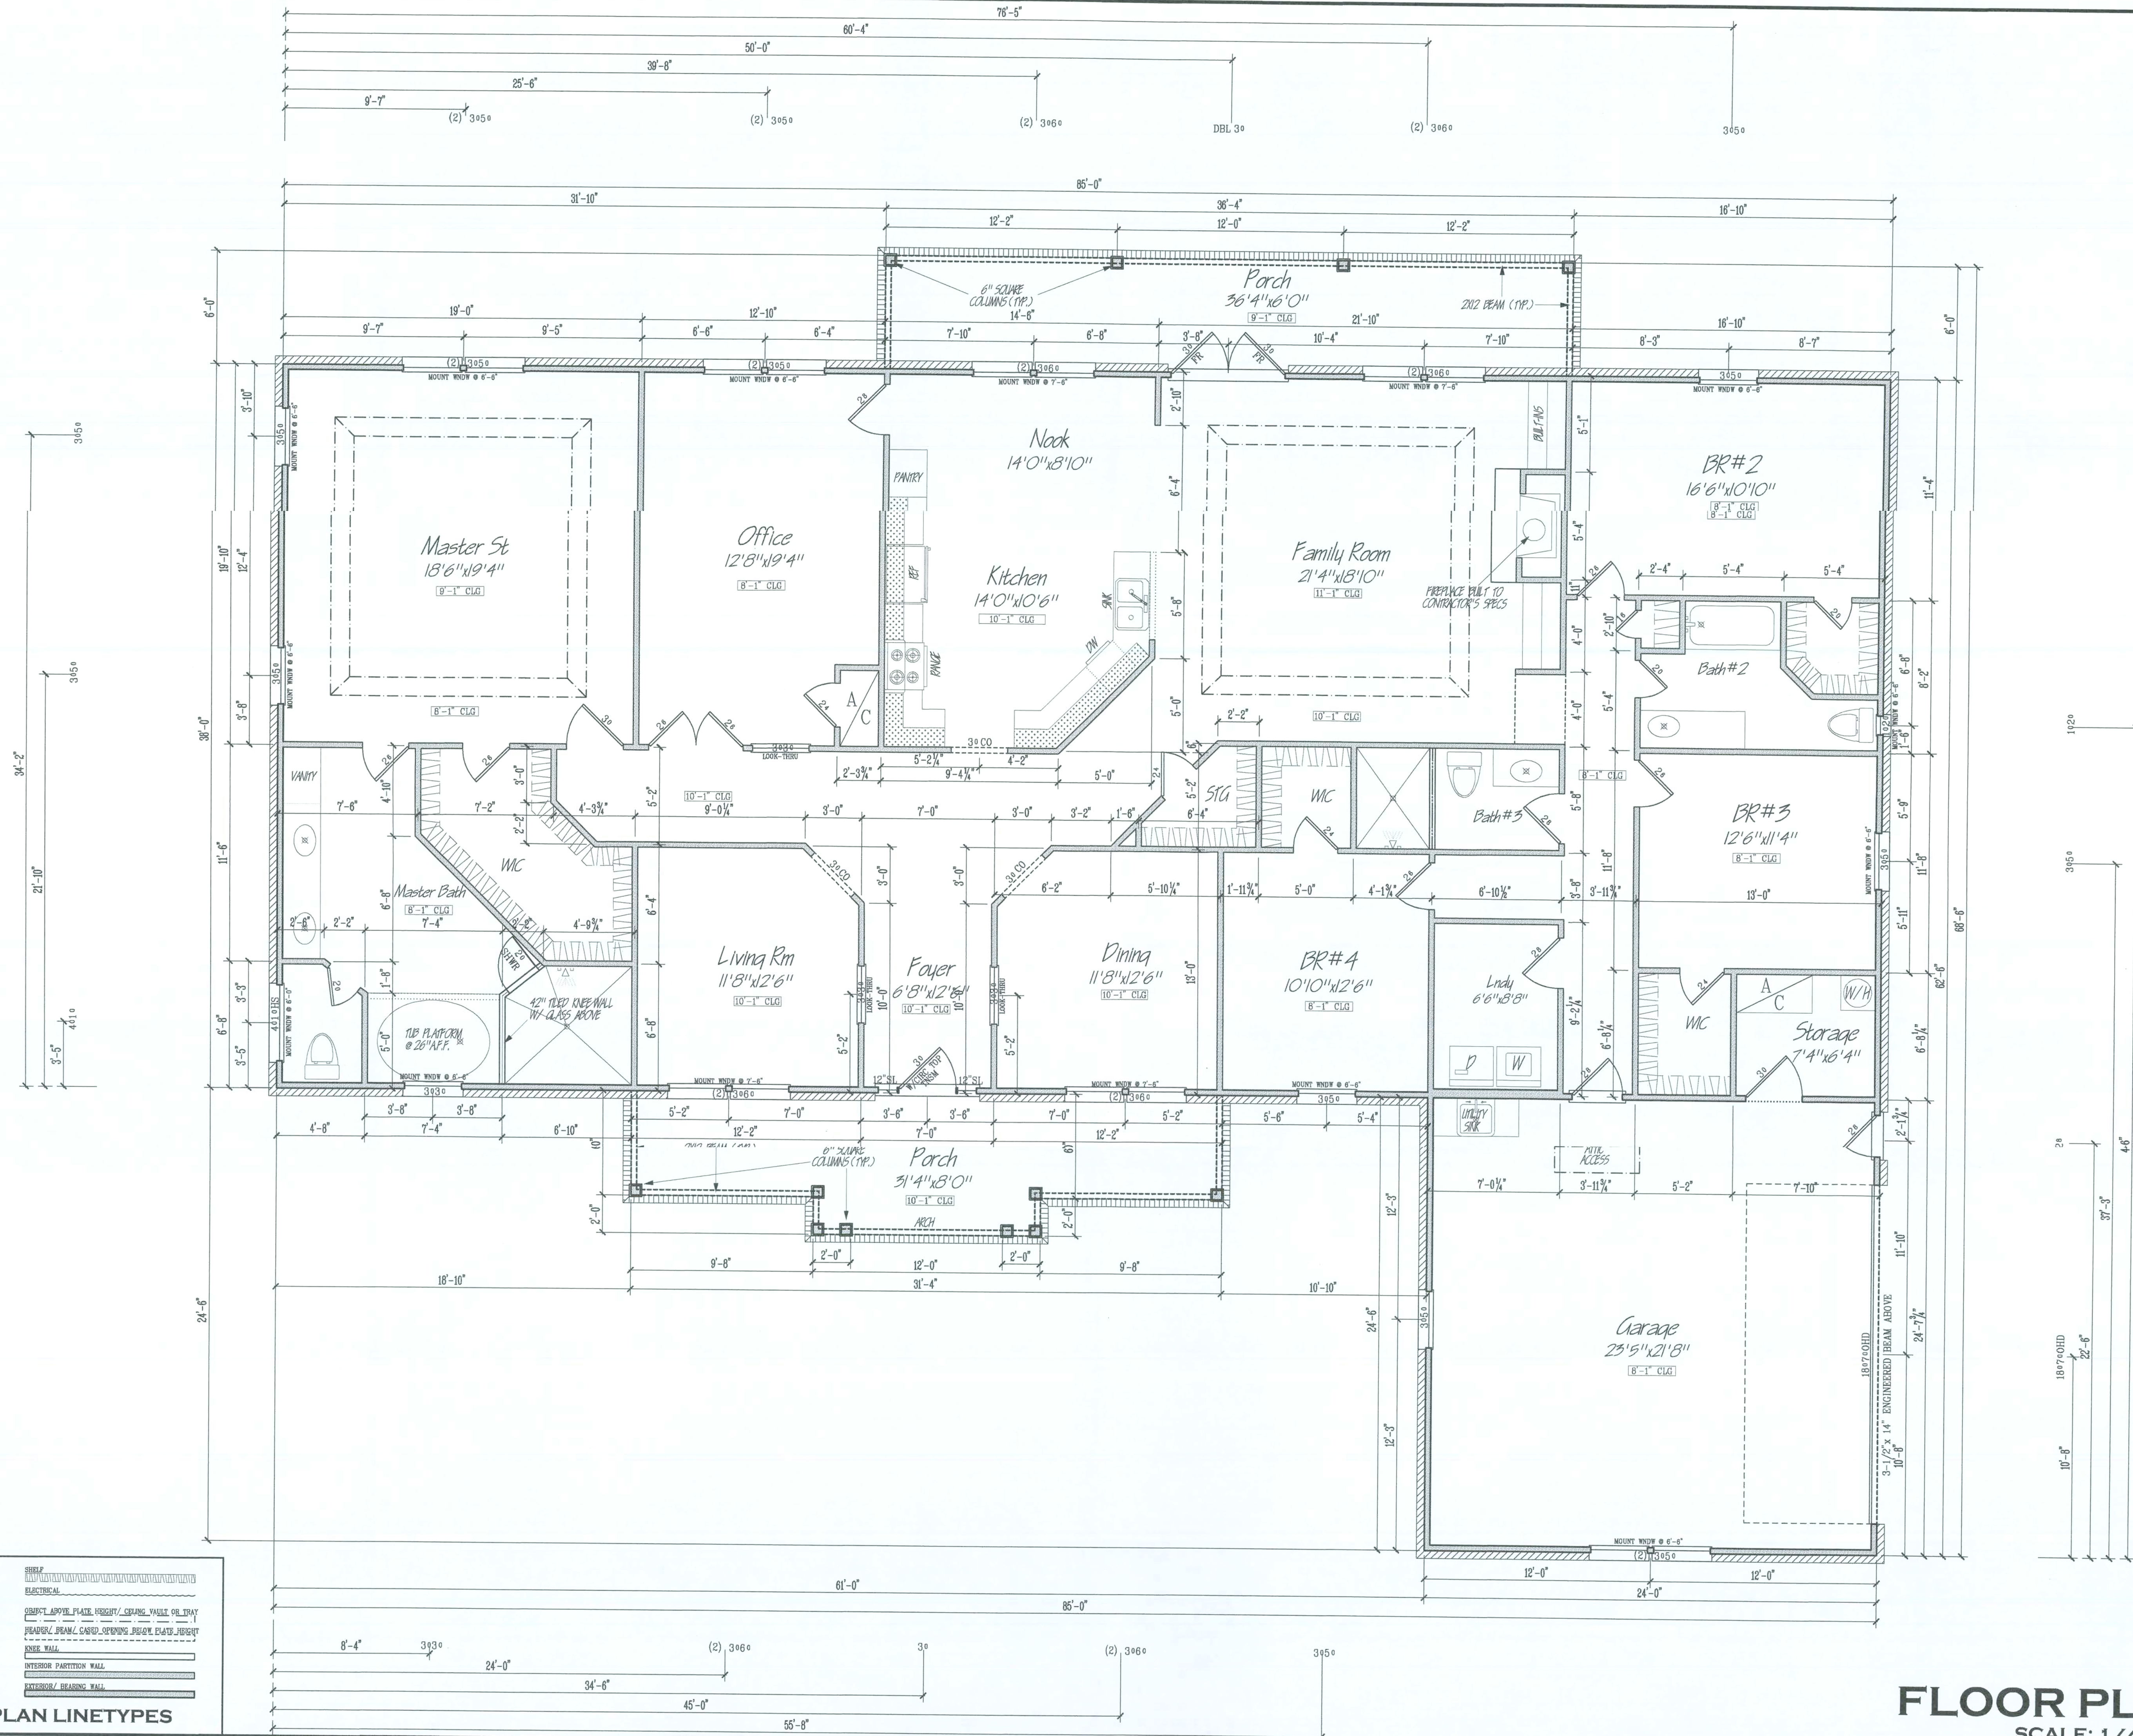

RICHARDSON
RESIDENCE

DRAWN BY:
SAF

PROJECT#:
0711-032

DATE:
1/17/2008


SHEET
OF
3
6

FLOOR PLAN
SCALE: 1/4"=1'-0"

Amersanthine Residential Design home plans were designed according to the 2007 Florida Building Code. All plans were designed to meet the municipality has its own regulations, codes, and requirements, the purchaser of these plans shall be responsible for verifying the scale and dimensions on the drawings, the loading capacity of structural elements, and general structural integrity.

The purchaser and/or builder of this plan releases Amaranthine Residential Design from any claims or lawsuits that may arise during the construction of this home or anytime thereafter. Amaranthine Residential Design authorizes the sale and use of these plans expressly upon the purchaser's obligation to determine the suitability of these plans for your specific site and application. Certain states require the seal of an architect and/or engineer. This service is not included in our plan prices.

All plans published and sold by Amaranthine Residential Design are protected under the Federal Copyright Act, Title 17 of the United States Code and Chapter 37 of the Code of Federal Regulation. The purchaser is granted a limited use of these plans for construction purposes only. Further distribution of these plans is strictly prohibited. Prices and conditions of plans are subject to change without notice.

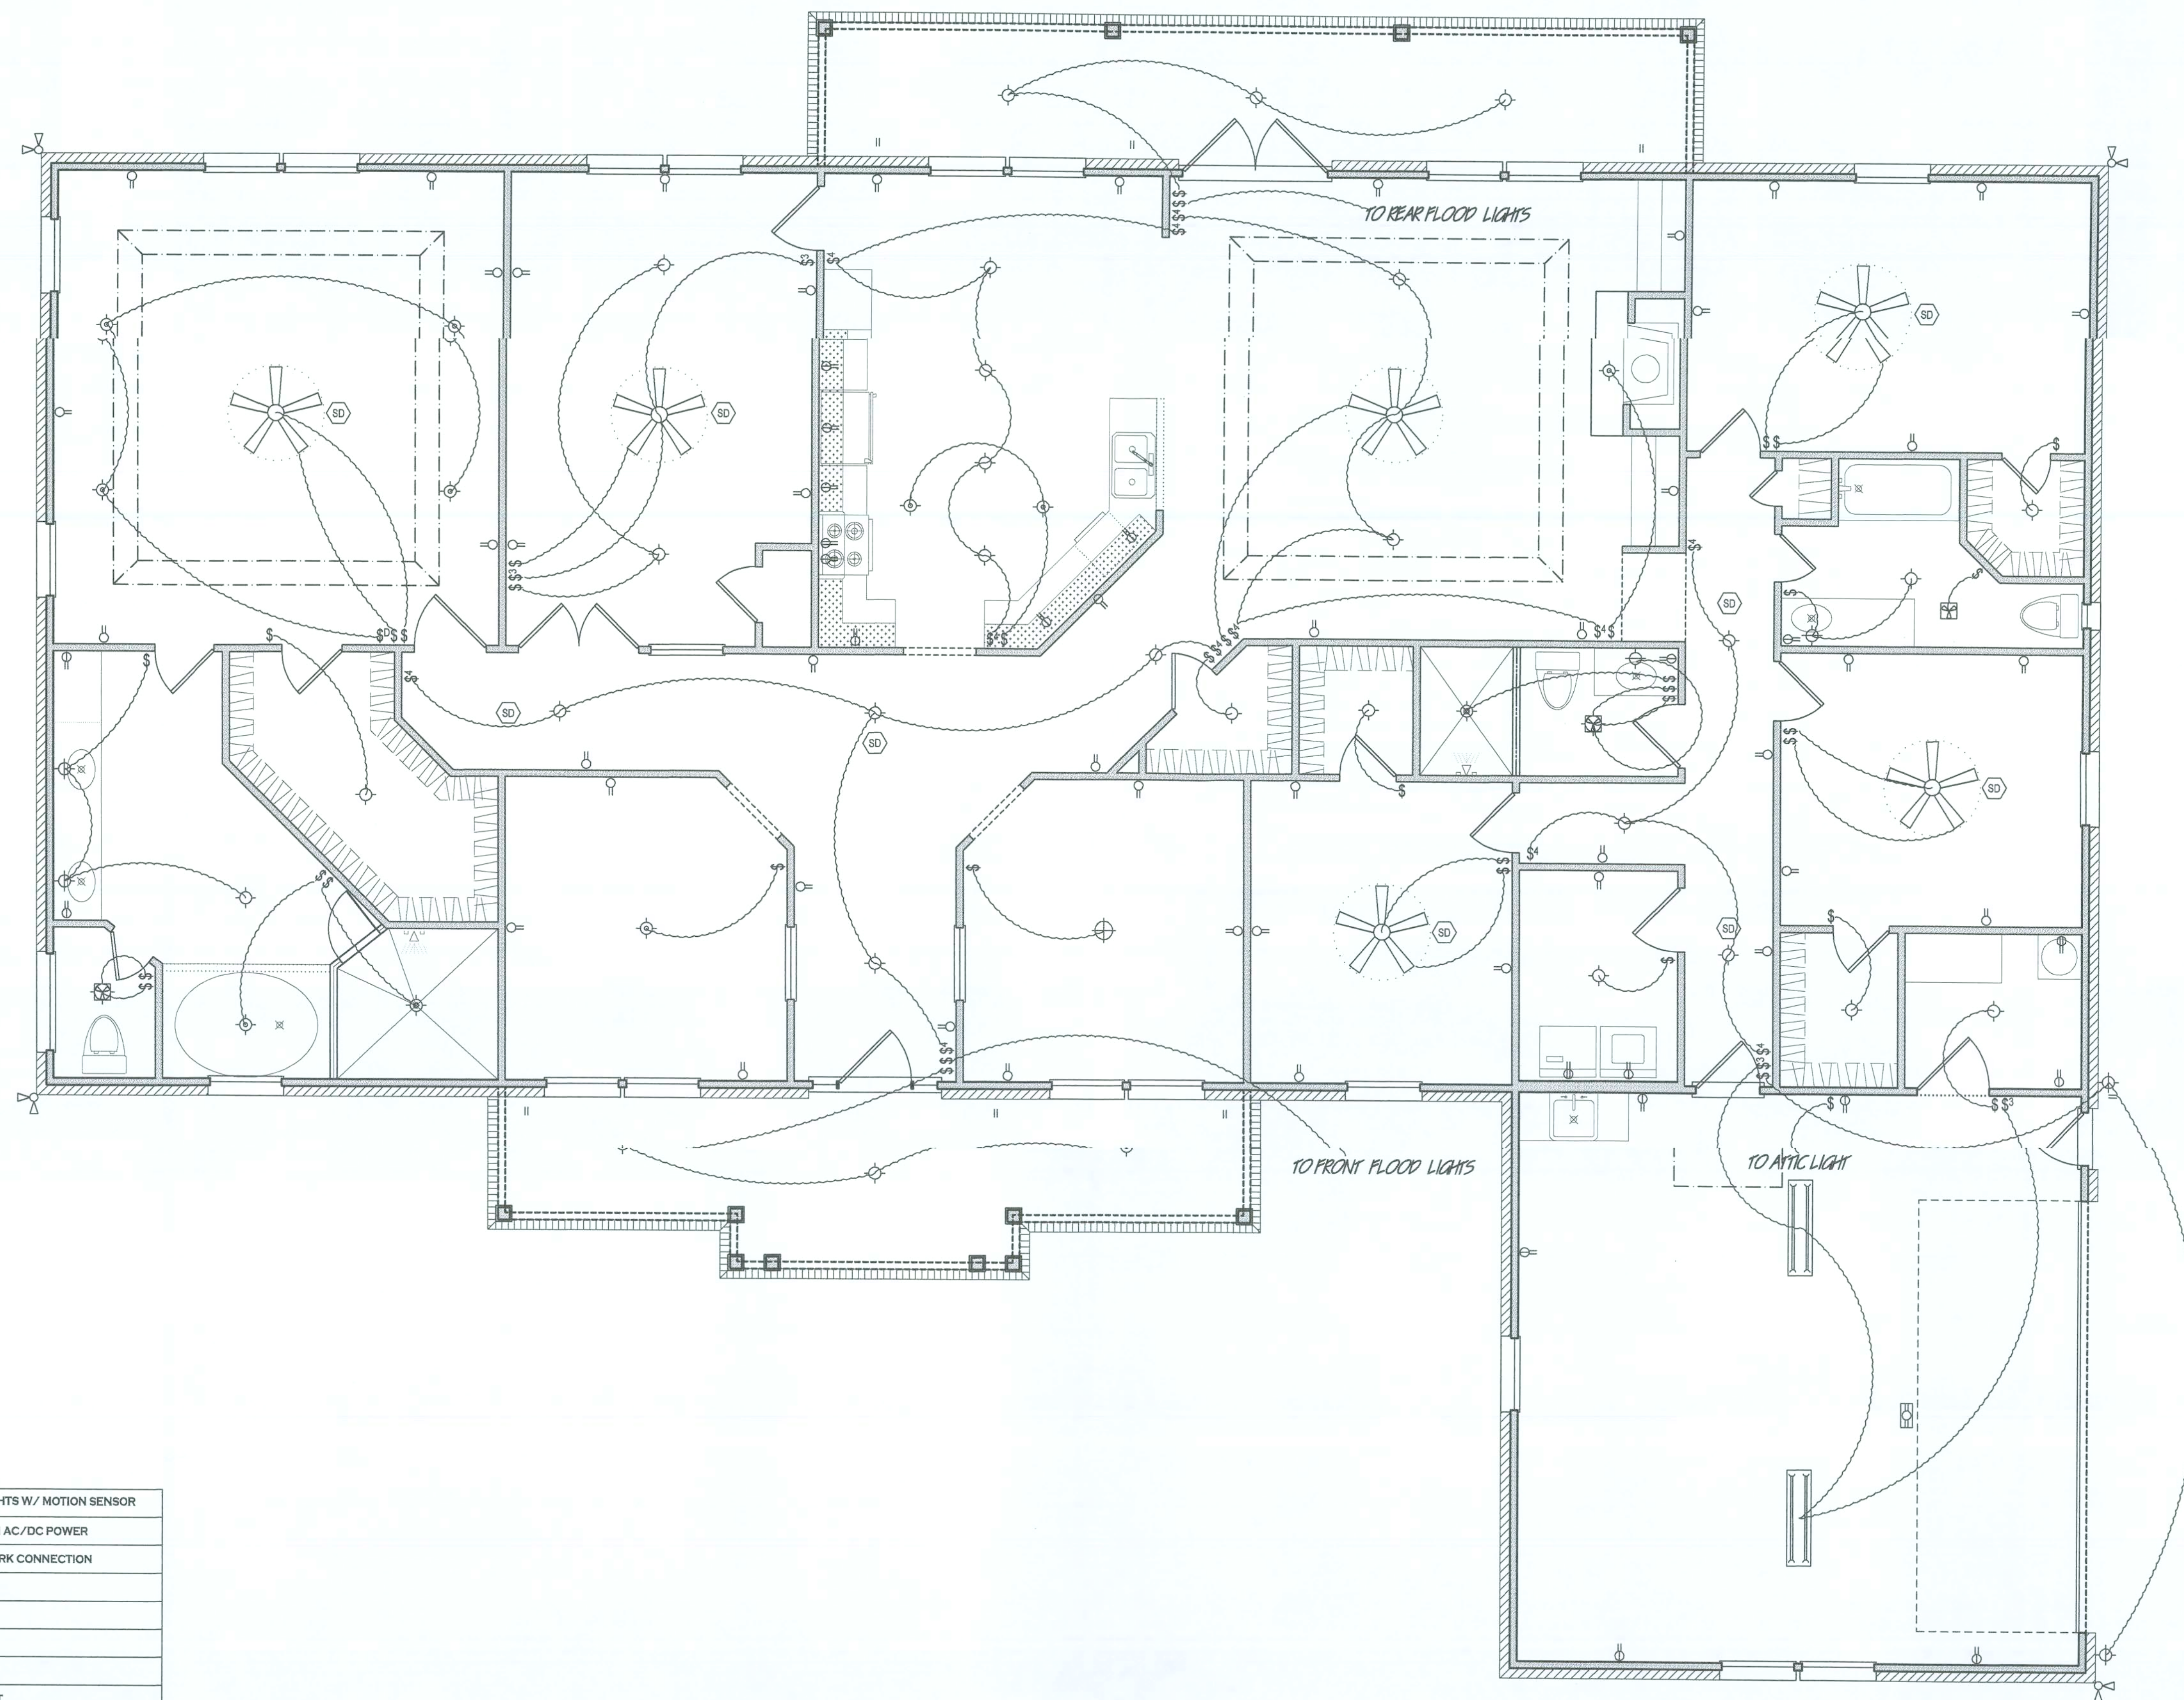

	TOGGLE SWITCH		EXTERIOR FLOOD LIGHTS W/ MOTION SENSOR
	3-WAY TOGGLE SWITCH		SMOKE DETECTOR ON AC/DC POWER
	4-WAY TOGGLE SWITCH		CAT 5/ HOME NETWORK CONNECTION
	DIMMER SWITCH		SPEAKER
	CEILING MOUNTED LIGHT		VOLUME CONTROL
	WALL MOUNTED LIGHT		CABLE TV OUTLET
	RECESSED LIGHT		TELEPHONE JACK
	CEILING MOUNTED PENDANT LIGHT		110 V DUPLEX OUTLET
	DECORATIVE SCONCE LIGHT		SWITCHED - 110 V DUPLEX OUTLET
	CHANDELIER		UNDER COUNTER DUPLEX
	CEILING MOUNTED FAN		220 V DUPLEX OUTLET
	UNDER-CABINET FLUORESCENT LIGHT		INTERIOR GFCI DUPLEX
	CEILING MOUNTED FLUORESCENT LIGHT		EXTERIOR W.P. GFCI DUPLEX
	EXHAUST FAN W/ LIGHT		OUTLET IN FLOOR
	EXHAUST FAN		OUTLET IN CEILING

Amaranthine
AR Residential
Design
(850) 591-4705

RICHARDSON
RESIDENCE

DRAWN BY:
SAF

PROJECT#:
0711-032

DATE:
1/17/2008

SHEET 4

OF 24c 6

ELECTRICAL PLAN

