




NOTE:
ALL INTERIOR RECEPTACLES SHALL BE A (ARC FAULT CIRCUIT INTERRUPT) PER NFPA 70C
NEC 408.11 3 NEC 210.12 & TEMP RESISTANT PER
NEC 408.11


ALL SMOKE DETECTORS BE A COMBO SM
(SMOKE & CARBON MONOXIDE DETECTOR
AND ALL WIRED TOGETHER SO IF ONE SMOKE
ALL ACTIVATE. Y ONE UNIT IS ACTUATED THEY

THE ELECTRICAL SERVICE OVERCURRENT
INSTALLED ON THE EXTERIOR OF STRUCTURE PROTECTION DEVICE SHALL BE
CONDUCTORS USED FROM THE EXTERIORS TO SERVE AS A DISCONNECT MEANS
PANEL SHALL HAVE FOUR-WIRE CONDUCTOR DISCONNECTING MEANS TO A PANEL OR SUB
SHALL BE USED AS AN EQUIPMENT GROUNDING, OF WHICH ONE CONDUCTOR
ROUND.

 
IT IS THE LICENSED ELECTRICAL CONTRACTOR'S
WORK PERFORMED AND EQUIPMENT INSTALLED RESPONSIBILITY TO INSURE THAT ALL
ELECTRIC CODE AND ALL OTHER LOCAL, STATE, FEDERAL AND THE 2008 NATIONAL
AL CODES AND ORDINANCES.

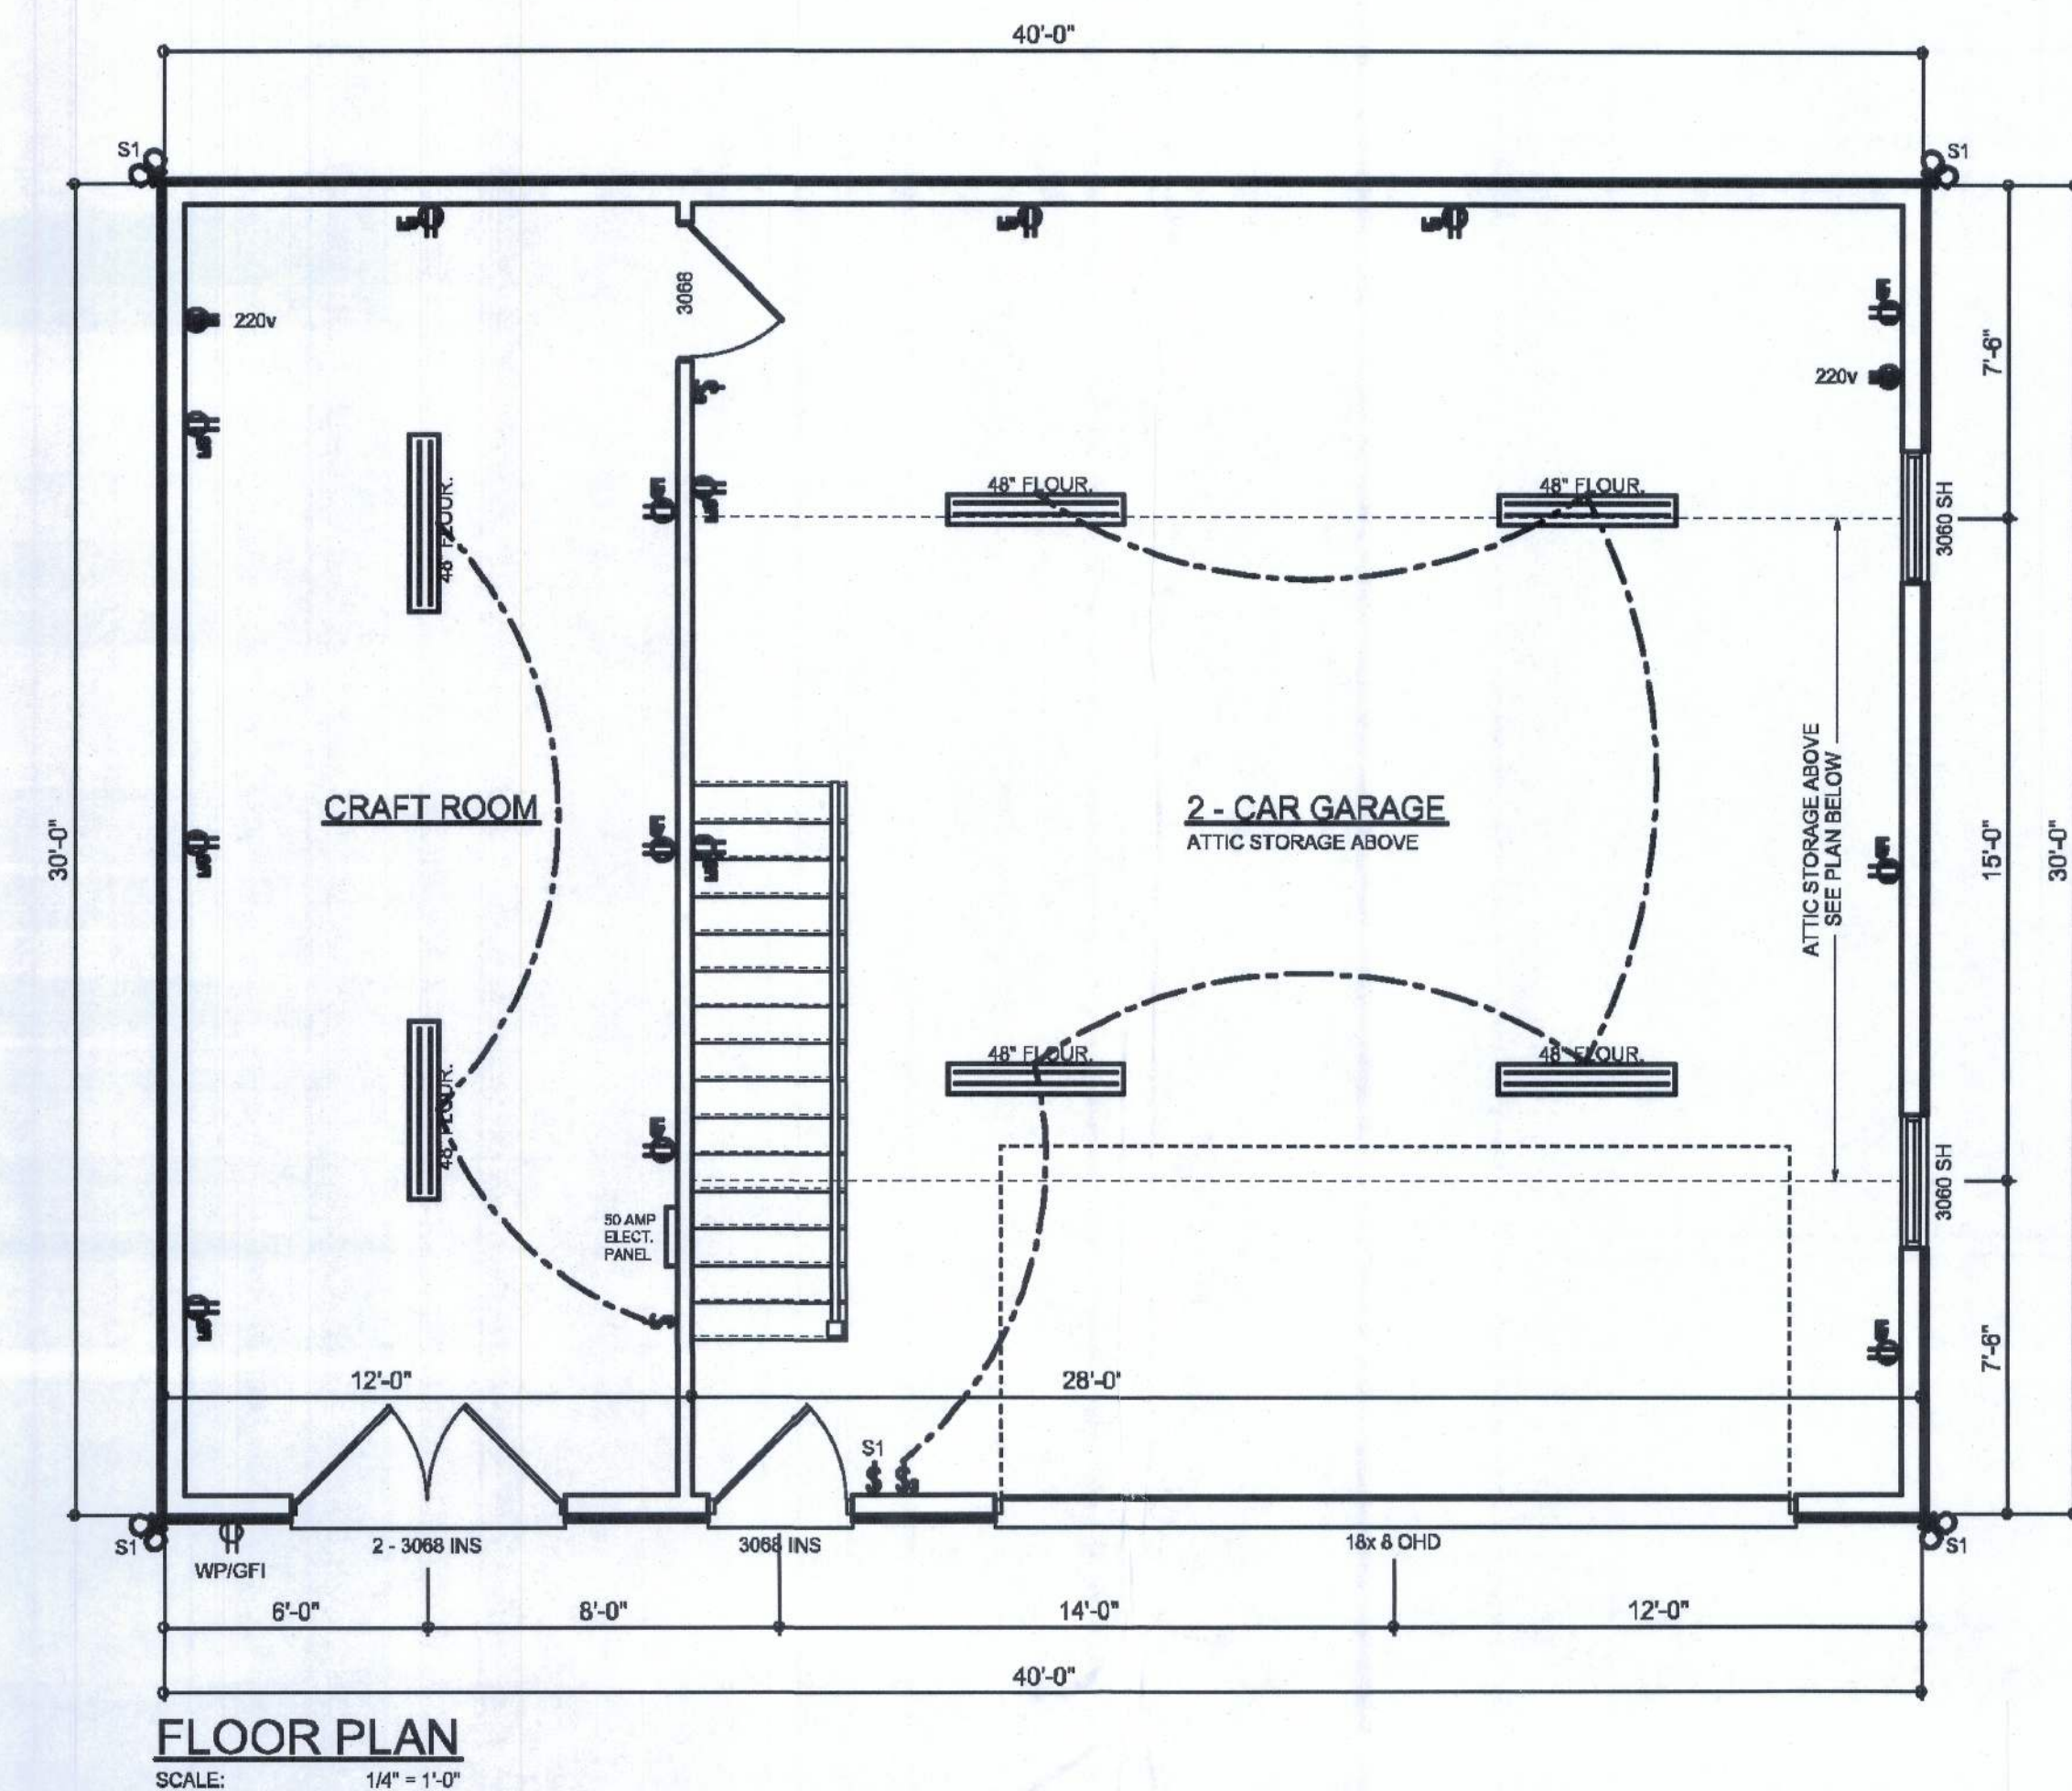

AREA SUMMARY		
CRAFT ROOM (CONDITIONED)	360	S.F.
2-CAR GARAGE AREA	840	S.F.
ATTIC STORAGE AREA	444	S.F.
TOTAL AREA	1,644	S.F.

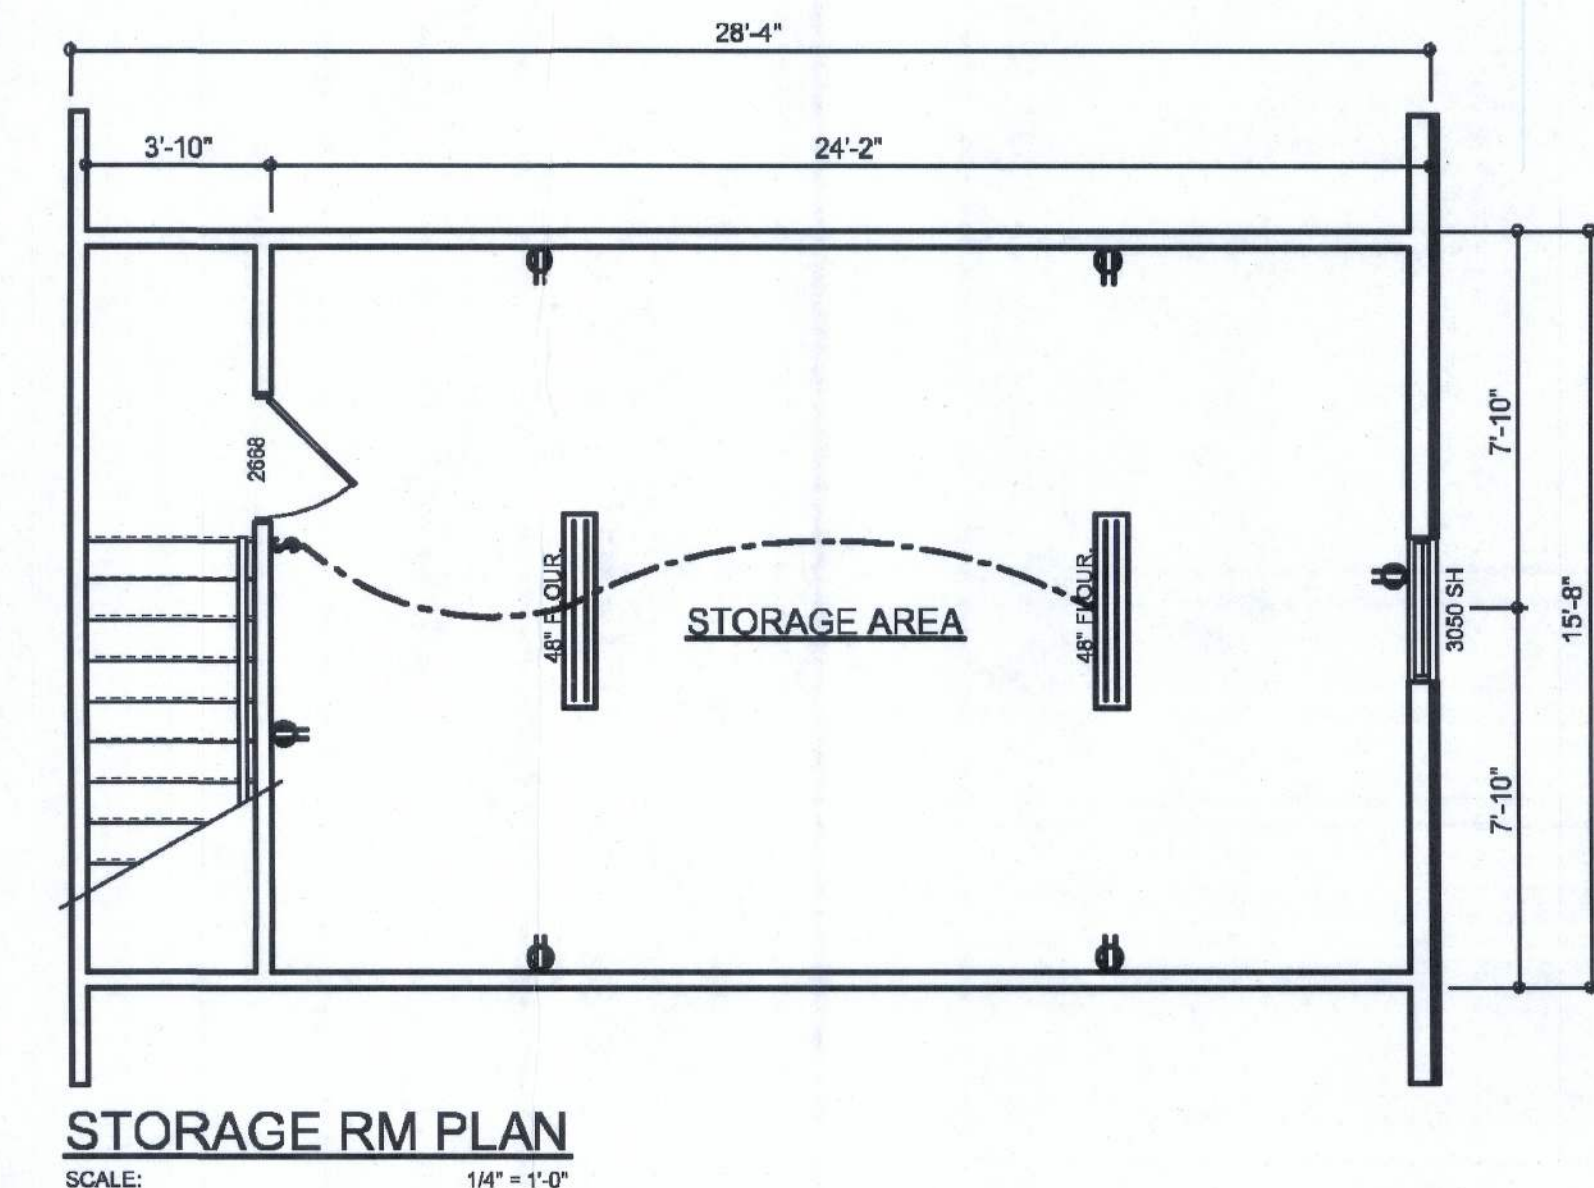

NOTE: ALL DRAWINGS NOT TO BE SCALED, WRITTEN DIMENSIONS TAKE PRECEDENCE OVER SCALED DIMENSIONS

FLOOR PLAN SCALE: 1/4" = 1'-0"	SECTION & DETAILS SCALE: 1/4" = 1'-0"
A DETACHED GARAGE FOR: THE GREYSTS PROJECT ADDRESS: STANLEY CRAWFORD CONSTRUCTION, INC. LAKE CITY, FLORIDA, 32056	
DESIGN INC. P.O. BOX 1513 LAKE CITY, FL 32056 (386) 758-8406 d@williamsinc.net	
	
JOB NUMBER	101203
SHEET NUMBER	A.2
OF 2 SHEETS	