


GENERAL NOTE:
CONNECT ALL HALF SHADED LIGHT
FIXTURES IN CORRIDORS & LOBBY
SO THEY REMAIN ON 24/7 PER
NFPA 101-7.8.1.

PROVIDE BATTERY PACK IN
PL FLUORESCENT
FIXTURE

MOUNT PHOTOCELL AS
HIGH AS POSSIBLE

PROVIDE BATTERY PACK IN
PL FLUORESCENT
FIXTURE

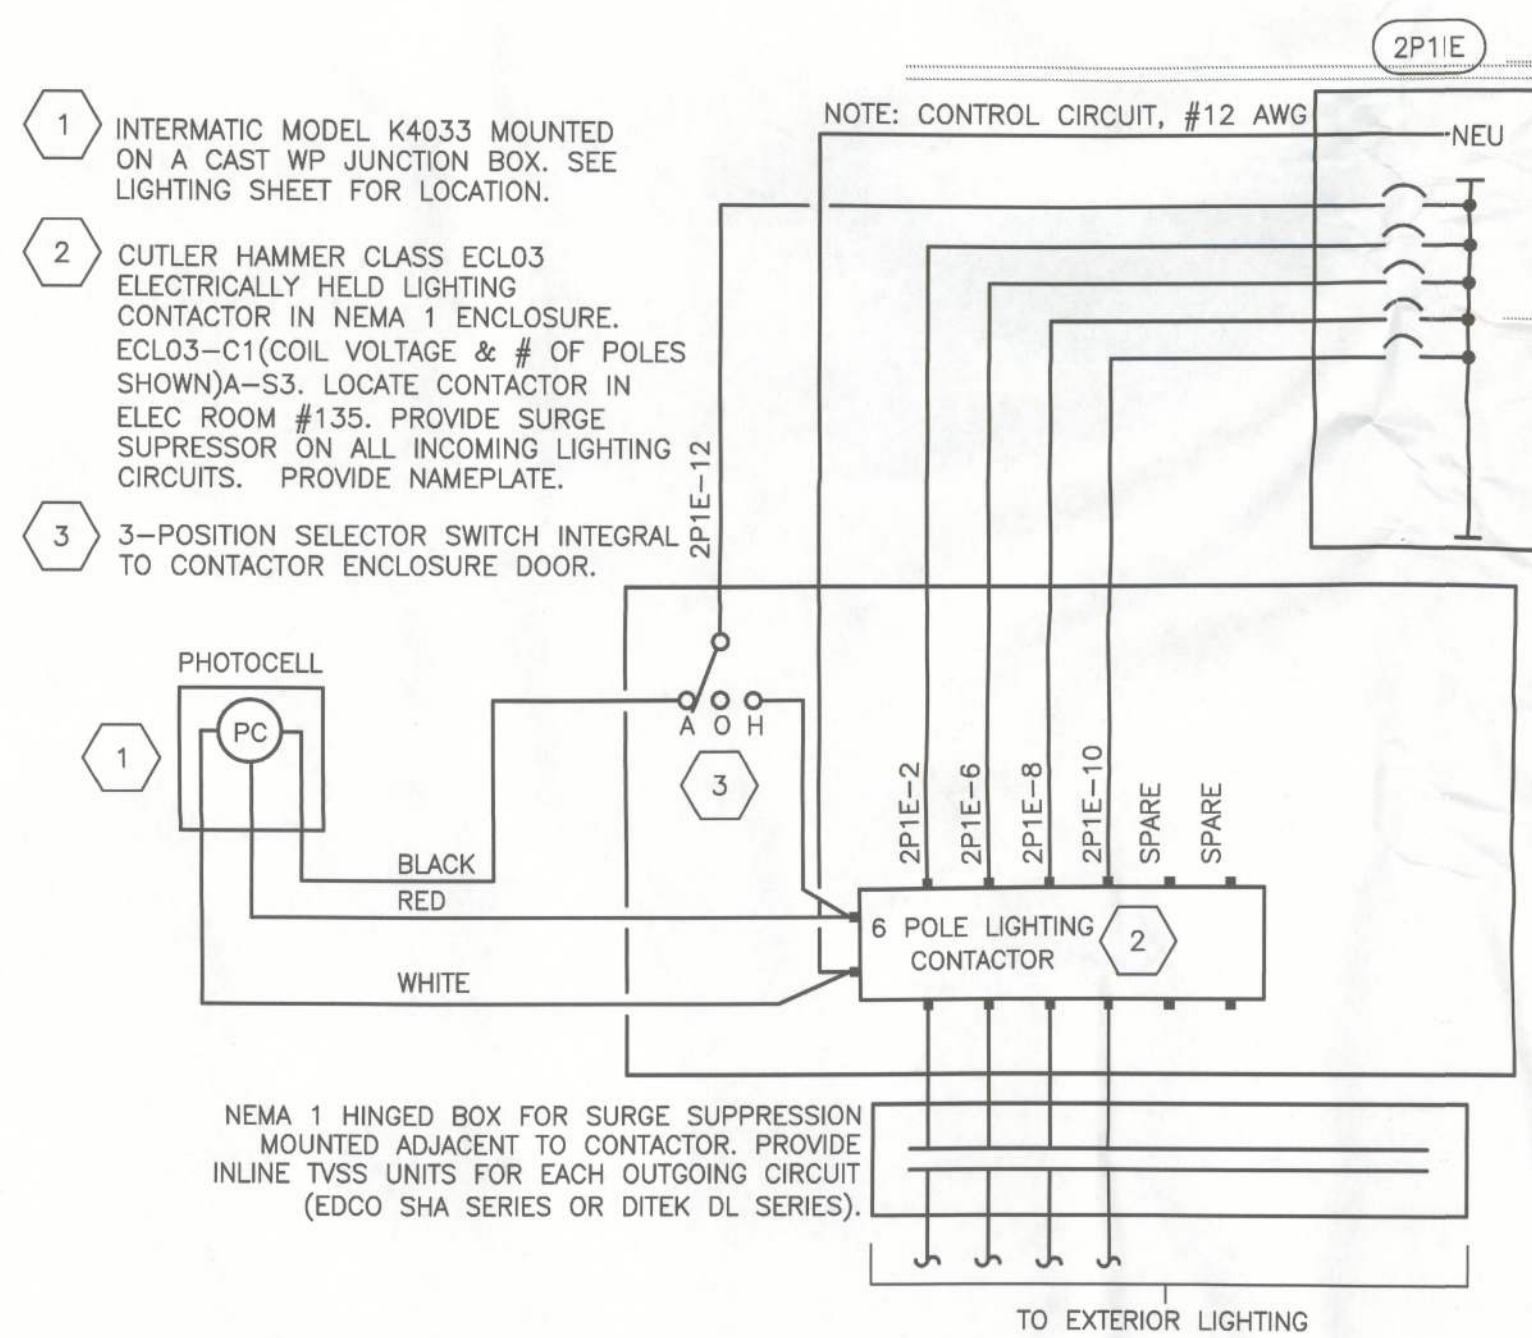

EXTERIOR LIGHTING CONTROL DIAGRAM
NOT TO SCALE

ELECTRICAL FLOOR PLAN - LIGHTING
SCALE: 1/8" = 1'-0"

