


Thomas M. Kelaher, P.E.
Structural Consultants
Florida Rg. No 40159
1108 S.E. 14th Terrace
Deerfield Beach, FL 33441
Phone (954) 360.9628
Fax (954) 360.0173
tkelaherengr@comcast.net

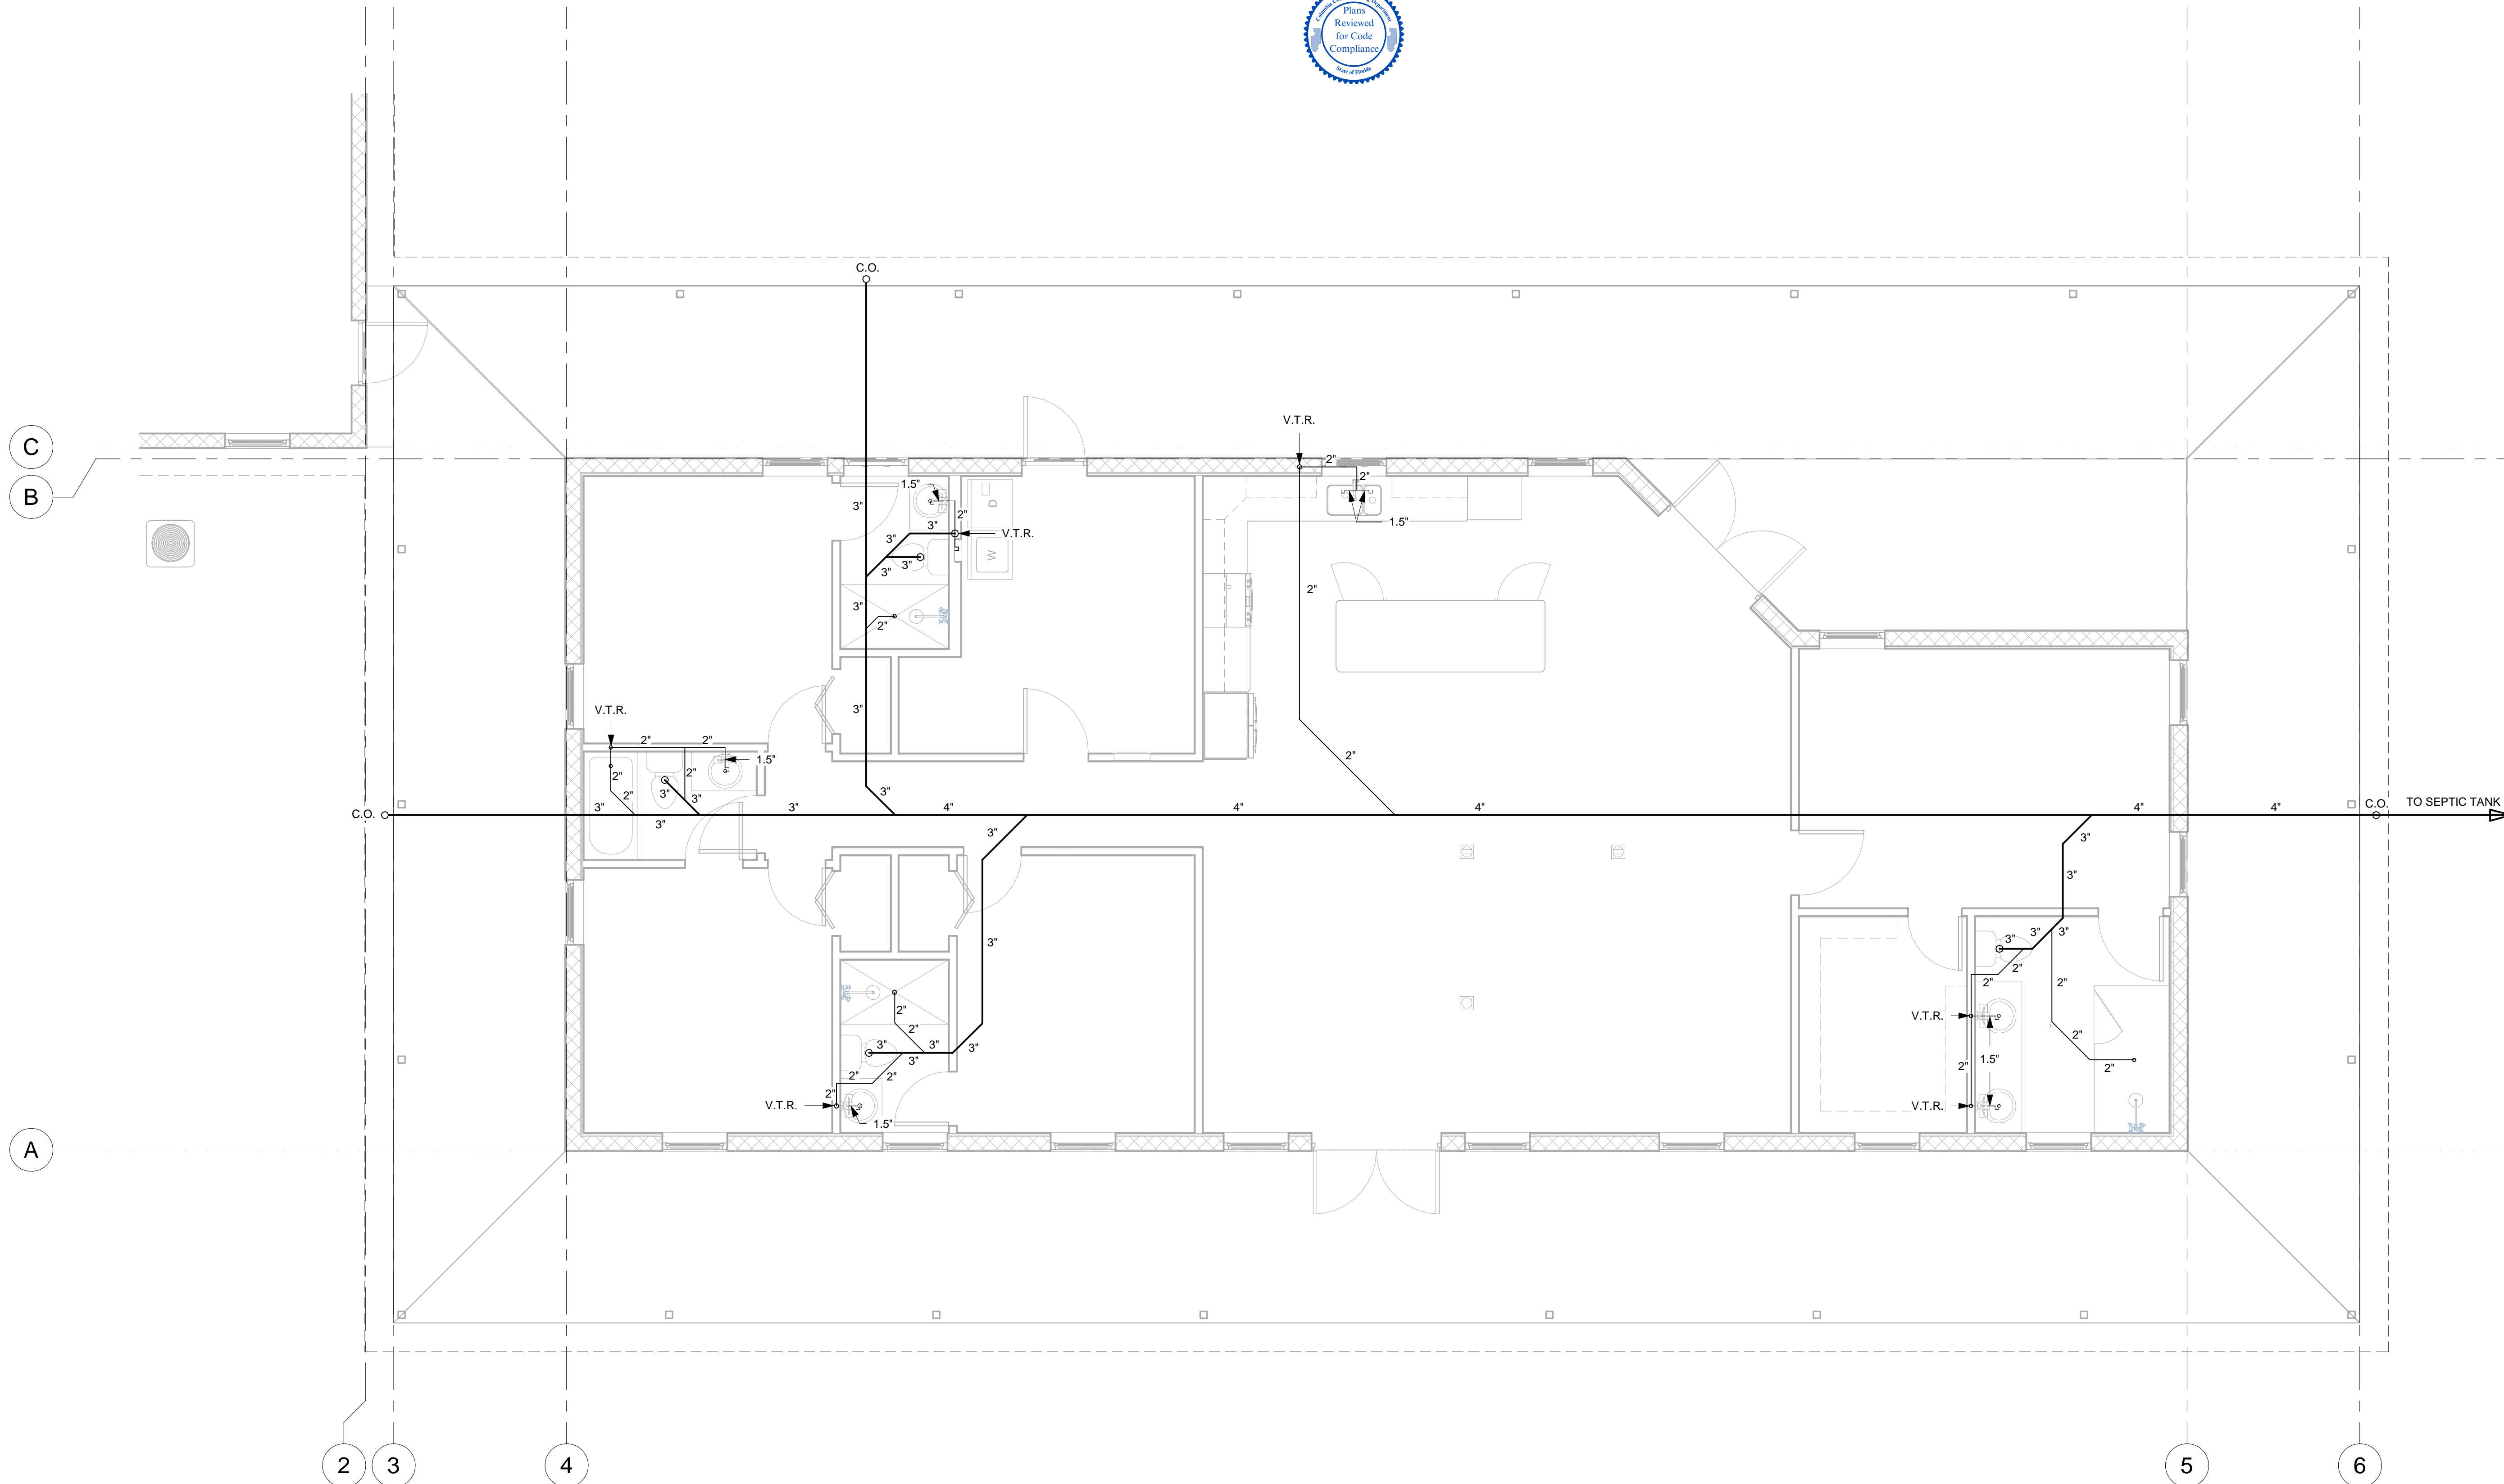

1 **Plumbing Plan - Sanitary**
1/4" = 1'-0"

**Dana & Carol (Wendy) Anderson
Residence**

SW Meadowlands Drive
Lake City, Florida

No.	Description	Date

Proposed Residence	
Plumbing - Sanitary Plan	
Project number	24-045
Date	12/25/2024
Drawn by	A.O.
Checked by	T.K.
P100	
Scale	1/4" = 1'-0"