


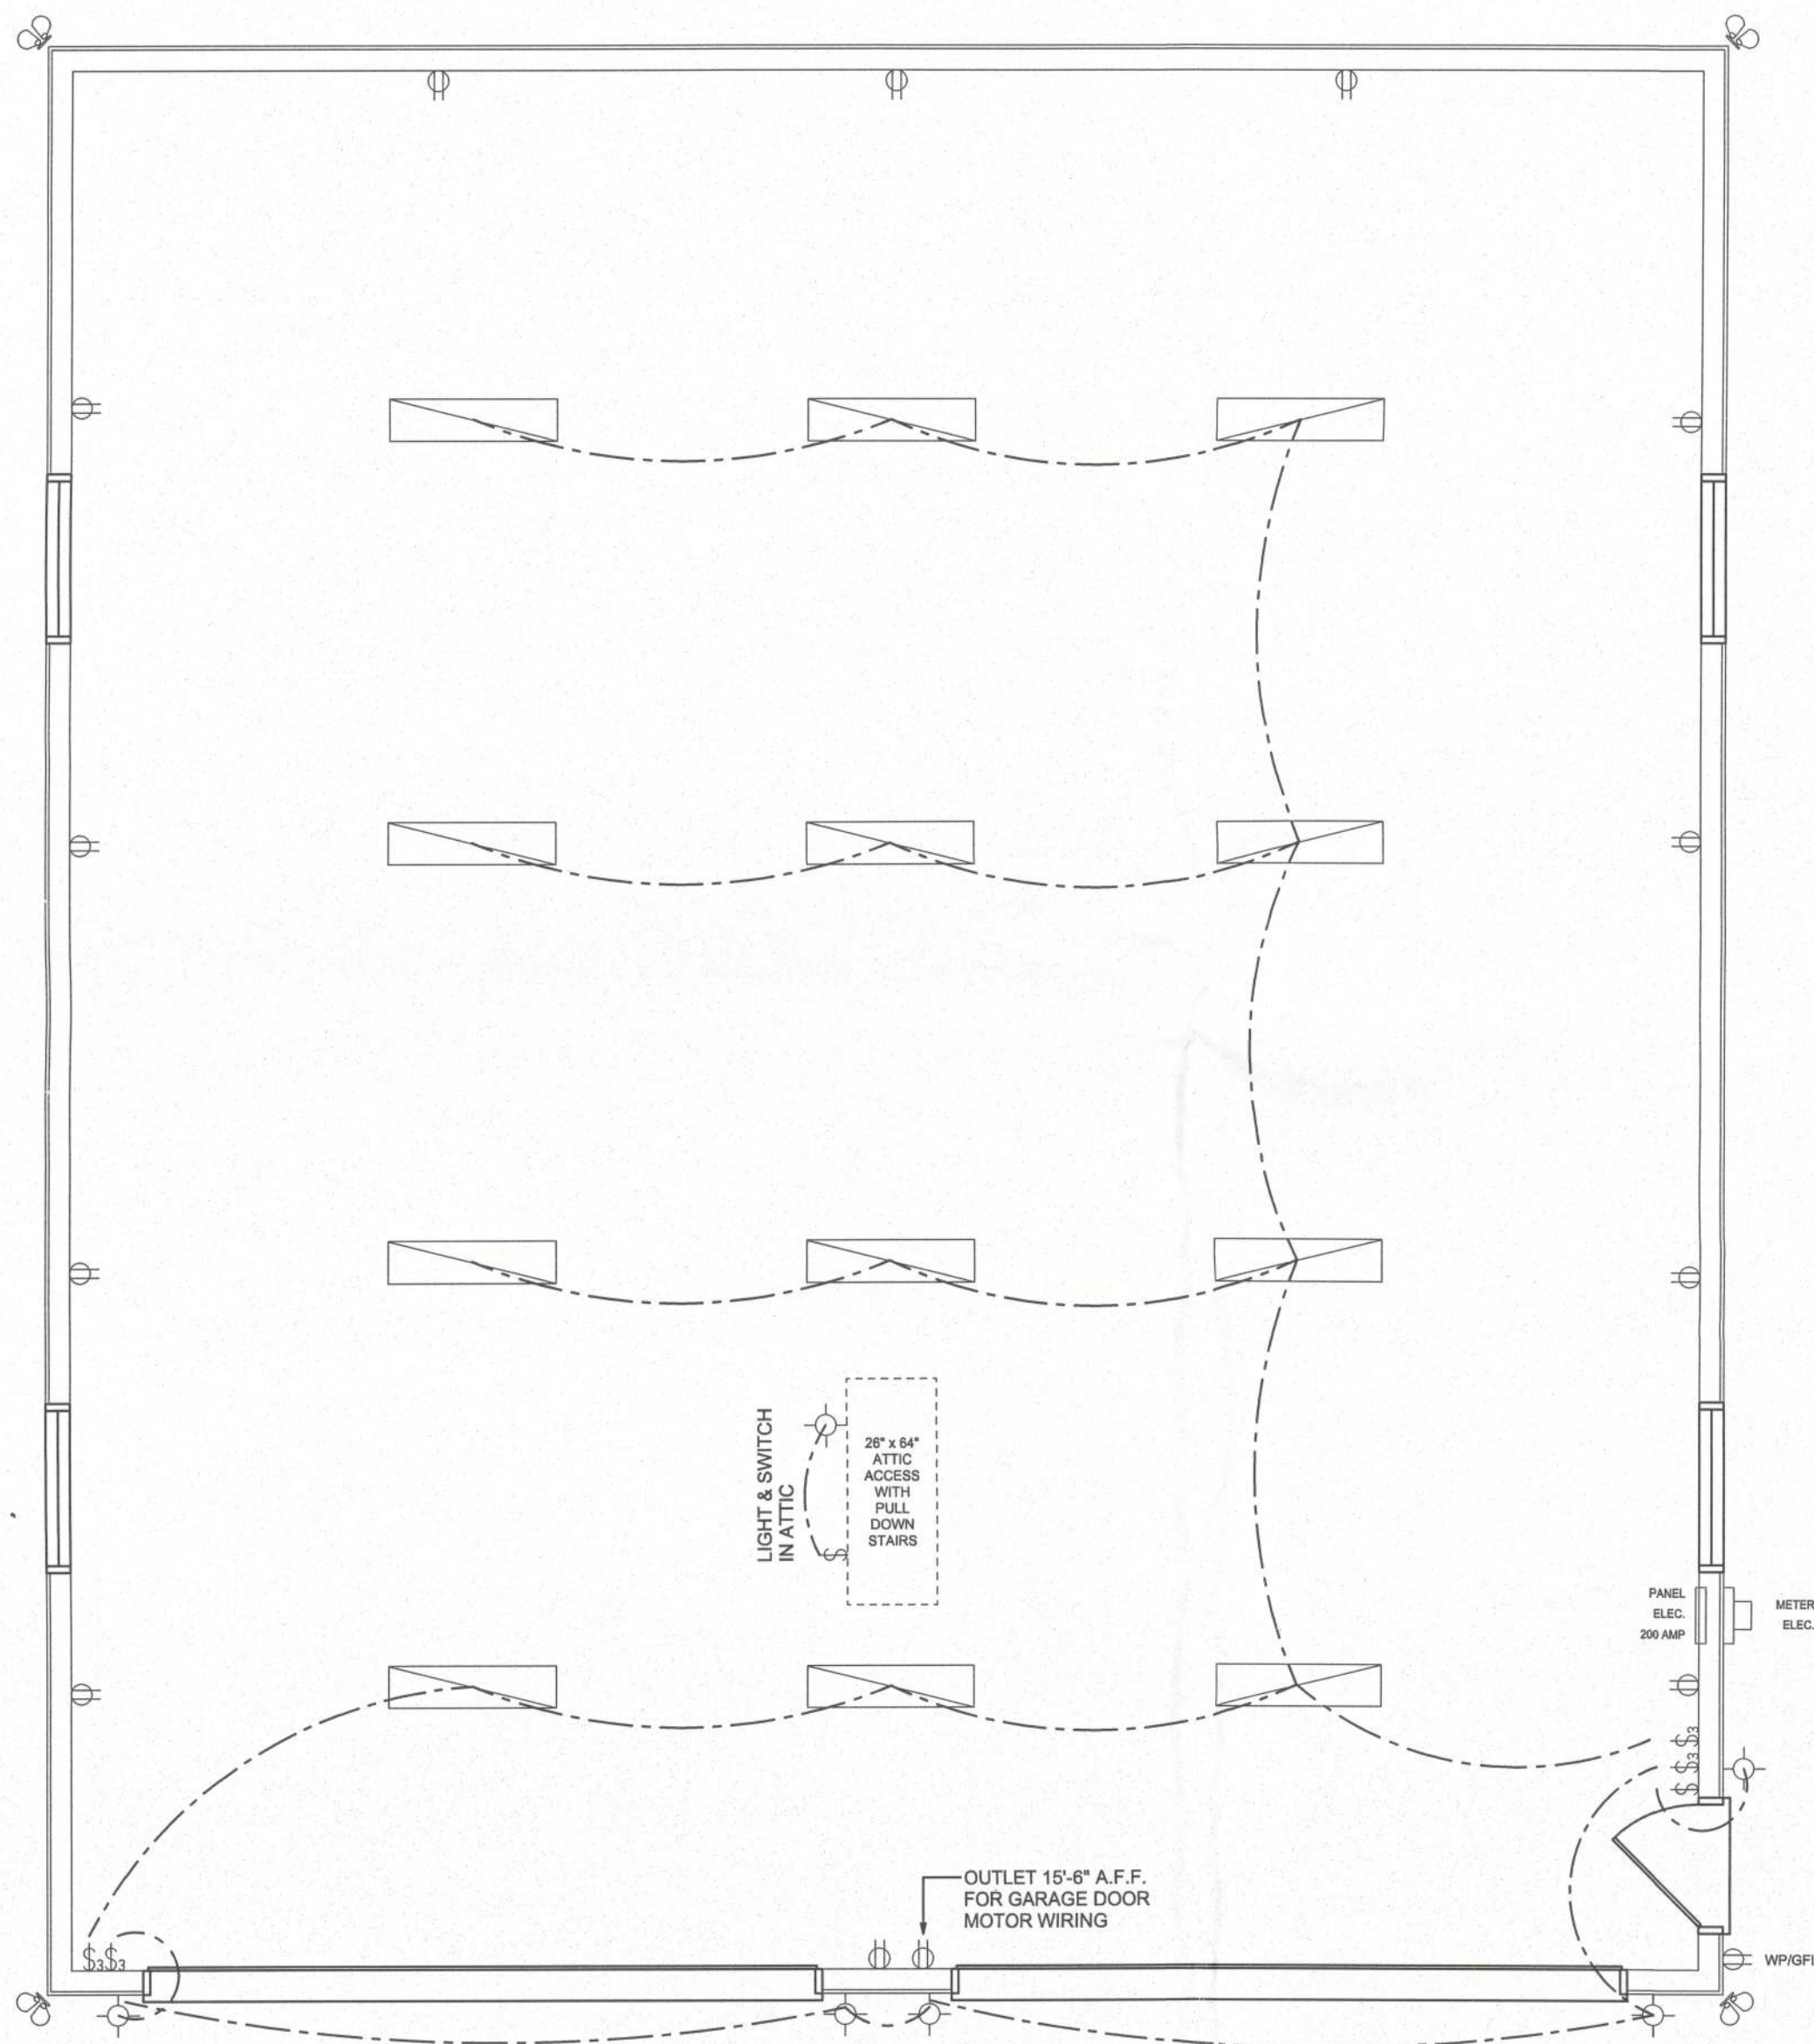


ELECTRICAL PLAN
SCALE: 1/4" = 1'-0"

ELECTRICAL LEGEND	
	CEILING FAN (PRE-WIRE FOR LIGHT KIT)
	DOUBLE SECURITY LIGHT
	RECESSED CAN LIGHT
	BATH EXHAUST FAN
	LIGHT FIXTURE
	DUPLEX OUTLET
	220v OUTLET
	GFI DUPLEX OUTLET
	SMOKE DETECTOR (see note below)
	WALL SWITCH
	3 WAY WALL SWITCH
	WATER PROOF GFI OUTLET
	2 OR 4 TUB FLUORESCENT FIXTURE

NOTE:
ALL BEDROOM RECEPTACLES SHALL BE AFCI
(ARC FAULT CIRCUIT INTERRUPT)

ALL SMOKE DETECTORS SHALL HAVE BATTERY BACKUP POWER
AND ALL WIRED TOGETHER SO IF ANY ONE UNIT IS ACTUATED THEY
ALL ACTIVATE.

NOTE!
UPER grounding required per N.E.C.
Arc fault breakers required per N.E.C.
GFCI breakers required per N.E.C.
Tamper resistant receptacles required per N.E.C.

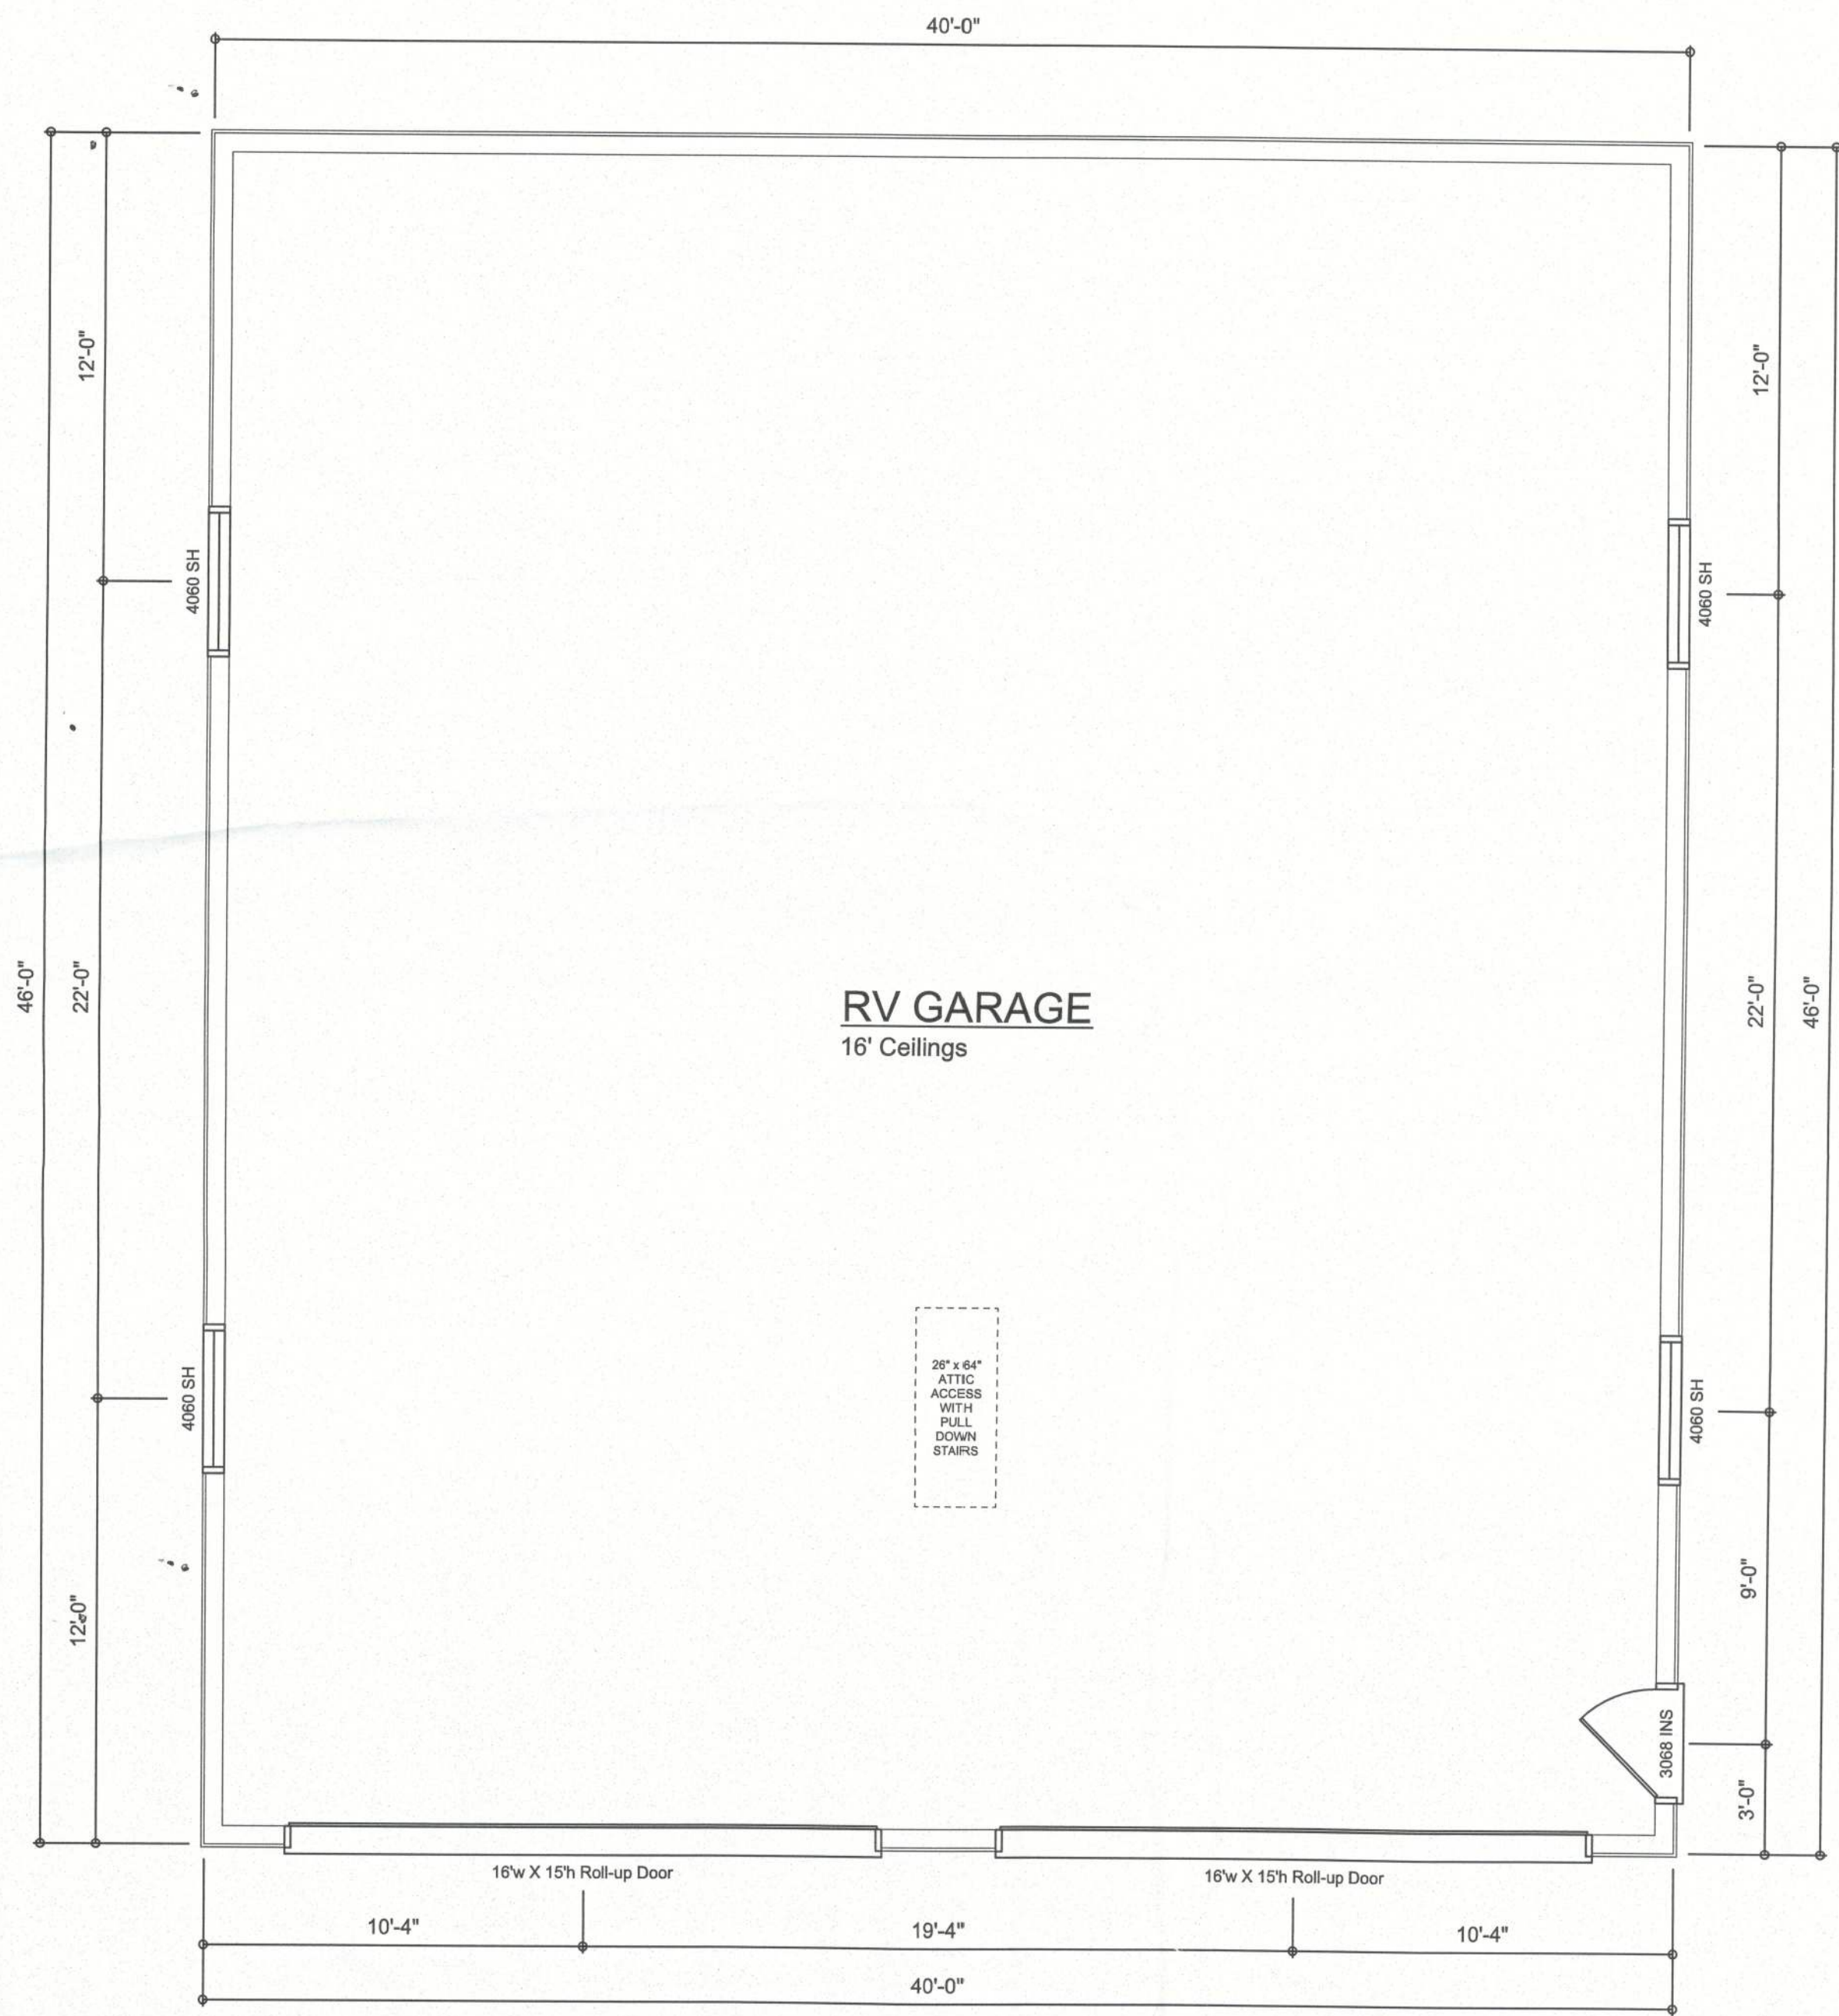

DIMENSIONED PLAN
SCALE: 1/4" = 1'-0"

REVISIONS SCHEDULE	
April 17, 2012	ORIGINAL DRAWINGS

A CUSTOM GARAGE PLAN FOR:
RICK & JESSICA BICKNELL
234 SW WINDSOR DR, LAKE CITY, FL 32025

PREMIER BUILDING
"Building Your Structural Future"
386 - 965 - 0985

J.M. DESIGN ASSOCIATES
SOLUTIONS THROUGH DESIGN
263 SW ERIN GLN.
LAKE CITY, FL 32025
jmorris@jmad.net

SHEET NUMBER
FLOOR PLAN &
ELECTRICAL
OF 6 SHEETS