



* PLAN SITE *

SCALE: 1" = 30'-0"

**NEW RESIDENCE
FOR
BETTY BOTO**

Teresa P. Ruffo
2025 661 661 471
Lakewood, Colorado, 80026
Cell: (303) 661-1191
Email: teresa@original.com


ISSUED DATE	ISSUED BY
Friday, May 18, 2023	

and M. Ruffo

RECEIVED DATE:	
----------------	--

AND AFTER:

A-1

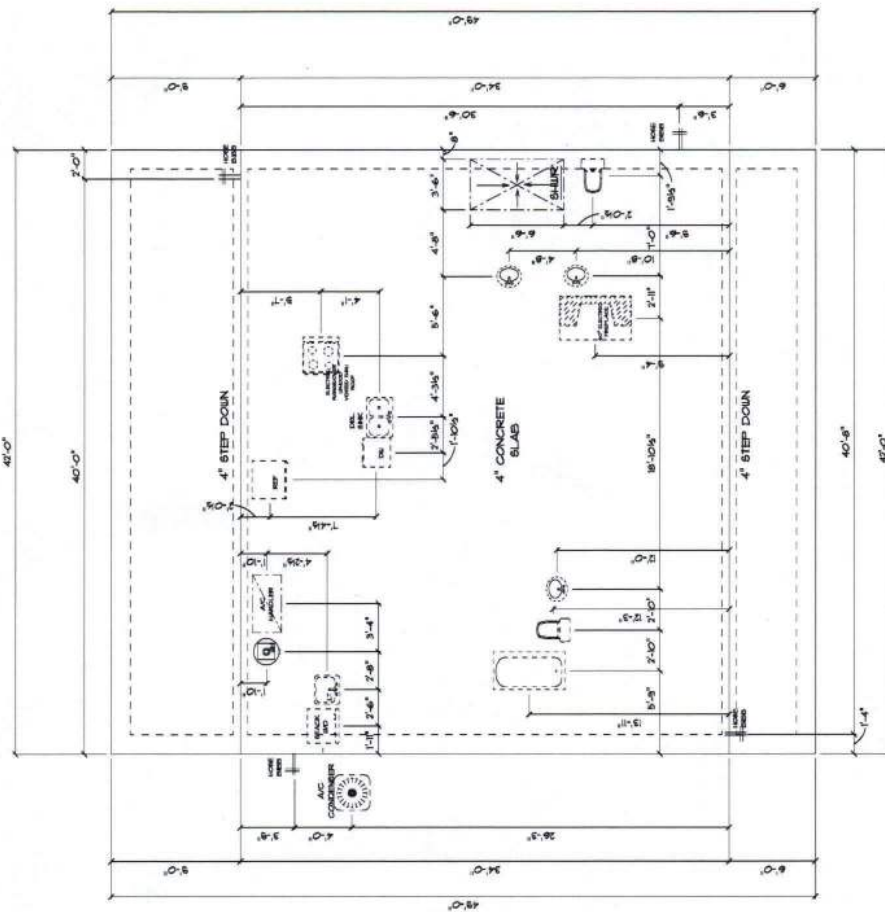

* FOUNDATION & * * PLUMBING PLAN *

SCALE : 1/4" = 1'-0"

IMPORTANT NOTE:
1. IT IS THE BUILDERS RESPONSIBILITY TO VERIFY ALL GEOMETRY AND DIMENSIONS BEFORE ORDERING ANY MATERIALS OR BEGINNING CONSTRUCTION.
2. THESE PLANS ARE FOR LAYOUT AND DESIGN PURPOSES ONLY. ALL STRUCTURAL NOTES AND DETAILS TO BE PROVIDED BY AN ENGINEER.

NEW RESIDENCE
FOR
BETTY BOTO

Owner: Mr. & Mrs.
John & Mary Boto
1234 Oak Street, Suite 100
Anytown, CA 90210
Phone: (555) 123-4567
Email: john@boto.com

Drawn by: J. Smith
Checked by: M. Jones
Date: 10/26/2023


Project: New Residence
Job Number: 12345

Sheet: 1 of 1
Drawing Number: A-2

Scale: 1/4" = 1'-0"

Job Number: 12345

Sheet: 1 of 1

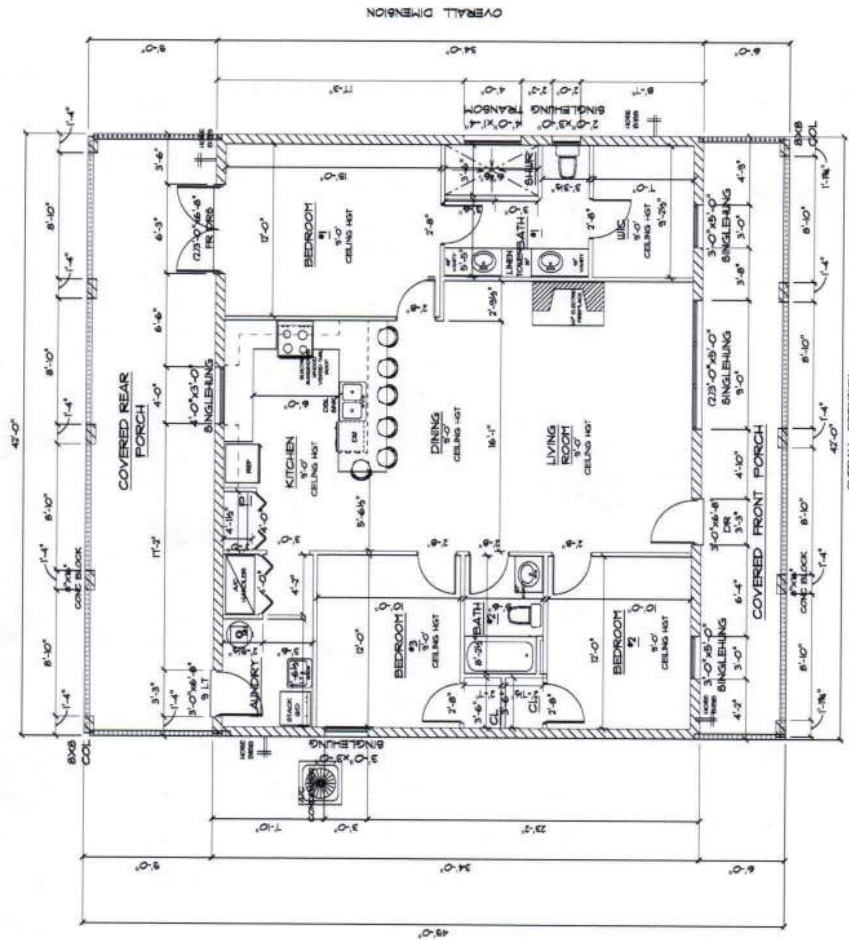

* FLOOR PLAN *

SCALE : 1/4" = 1'-0"

IMPORTANT NOTE:
 1. IT IS THE BUILDERS RESPONSIBILITY TO VERIFY ALL GEOMETRY AND DIMENSIONS BEFORE ORDERING ANY MATERIALS OR BEGINNING CONSTRUCTION.
 2. THESE PLANS ARE FOR LAYOUT AND DESIGN PURPOSES ONLY ALL STRUCTURAL NOTES AND DETAILS TO BE PROVIDED BY AN ENGINEER.

A/C LIVING AREA	= 1428 S.F.
COVERED BACK PORCH	= 355 S.F.
COVERED FRONT PORCH	= 235 S.F.
TOTAL AREA UNDER ROOF	= 2018 S.F.

NEW RESIDENCE
FOR
BETTY BOTO

DESIGNED BY: MARY
2020 MAY 10
LAW OFFICE: 1000
CITY: CHICAGO, ILL.
STATE: ILLINOIS

PRINTED DATE:
2020 MAY 10, 2020


DESIGNED BY:
CHECKED BY:
DATE: 2020 MAY 10, 2020

SCALE: 1/4" = 1'-0"


DATE: 2020 MAY 10, 2020

PROJECT NO.: A-3

OF 6 SHEETS

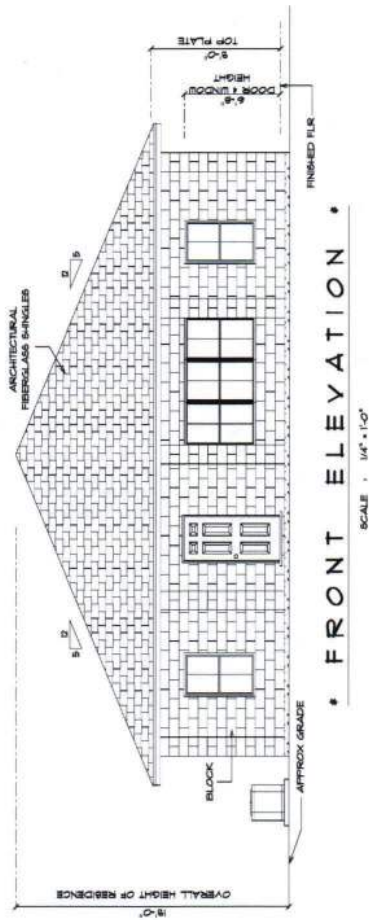

NOTE:
24" OVERHANG ON ALL EAVES

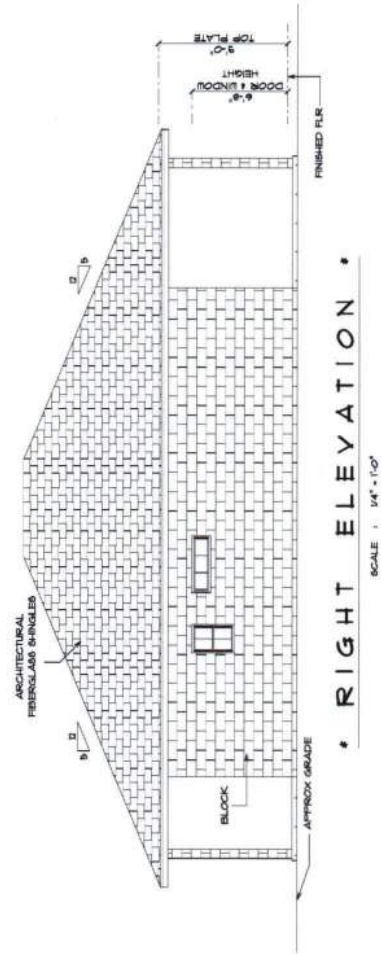


NEW RESIDENCE
FOR
PRINT 8010

Owner: J. R. Ruffo
2025 04 04 11
Arch: J. R. Ruffo
Civil: J. R. Ruffo
Elect: J. R. Ruffo


PRINTED DATE:
FRI May 19, 2023
DRAWING NO.:
SHEET NO.:
SHEET TOTAL:

SCALE: 1/4" = 1'-0"
SHEET NO.:
SHEET TOTAL:

DRAWING NUMBER
A-4
OF 8 SHEETS

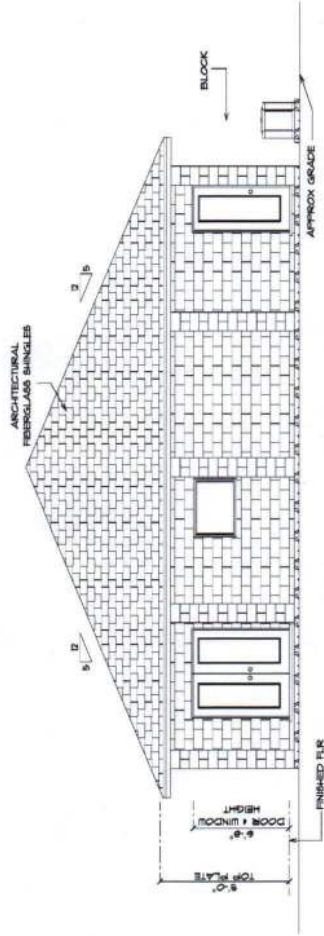

• REAR ELEVATION •
SCALE : 1/4" = 1'-0"

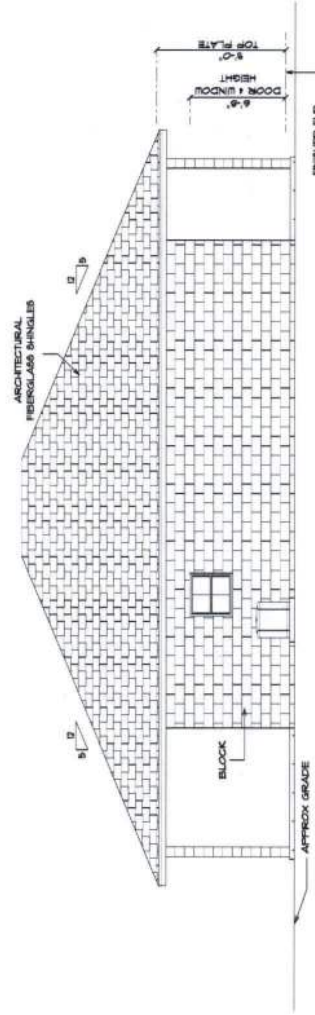

• LEFT ELEVATION •
SCALE : 1/4" = 1'-0"


NEW RESIDENCE
FOR
REBTY. BOTO

Owner: Mr. BOTO
Architect: Mr. BOTO
City: BOTO, BOTO
State: BOTO, BOTO

DESIGNED BY:
DRAWN BY:
CHECKED BY:
DATE: 11/11/11

TOTAL SHEETS:
JOB NUMBER:

DRAWING NUMBER:
A-5
OF 8 SHEETS

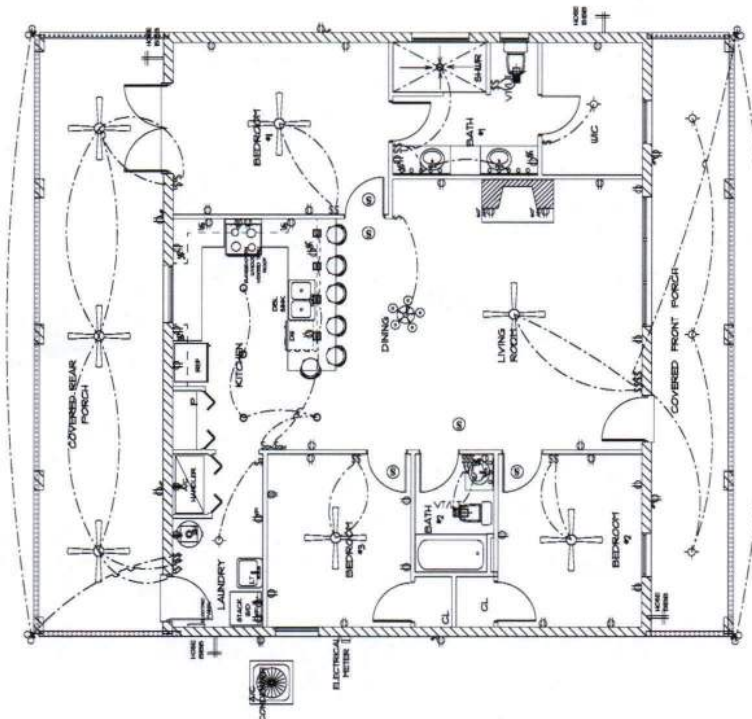

* ELECTRIC PLAN *

SCALE : 1/4" = 1'-0"

ELECTRICAL LEGEND	
ELECTRICAL	COUNT/SYMBOL
ceiling fan globe 01	1
ceiling light 12	1
pendant large	4
pot light	5
spotlight double	4
Smoke Detector	5
electrical panel	1
dimmer switch	2
light	5
outlet	20
outlet 220v	5
outlet gfi	10
outlet up	6
switch	20
switch 3 way	5
vent light combo	2
vanity bar light 01	2
vanity bar light 02	1
***	***

- ELECTRICAL PLAN NOTES**
- #1. WIRE ALL APPLIANCES, HVAC UNITS AND OTHER EQUIPMENT PER MANUFACTURER SPECIFICATIONS.
 - #2. ALL INSTALLATIONS SHALL BE PER NATIONAL ELECTRIC CODE.
 - #3. ALL KNIFE SWITCHES, CIRCUIT BREAKERS, AND ALL OTHER ELECTRICAL EQUIPMENT SHALL BE INSTALLED IN ACCORDANCE WITH THE NATIONAL ELECTRIC CODE.
 - #4. THE ELECTRICAL CONTRACTOR SHALL BE RESPONSIBLE FOR THE DESIGN AND LAYOUT OF ALL ELECTRICAL SYSTEMS AND SHALL BE RESPONSIBLE FOR THE DESIGN AND LAYOUT OF ALL ELECTRICAL SYSTEMS AND SHALL BE RESPONSIBLE FOR THE DESIGN AND LAYOUT OF ALL ELECTRICAL SYSTEMS.
 - #5. ELECTRICAL CONTRACTOR SHALL BE RESPONSIBLE FOR THE DESIGN AND LAYOUT OF ALL ELECTRICAL SYSTEMS AND SHALL BE RESPONSIBLE FOR THE DESIGN AND LAYOUT OF ALL ELECTRICAL SYSTEMS.
 - #6. ENTRY OF SERVICE UNDERGROUND OR OVERHEAD IS TO BE DETERMINED BY THE POWER COMPANY.
 - #7. ALL BEDROOM RECEPTALS ARE TO BE 20 AMP (AFC) FAULT CIRCUIT INTERRUPTER.
 - #8. 10% OF ALL PERMANENT LIGHTS TO BE ENERGY EFFICIENT.

NEW REMEDANCE
FOR
RETRY 8070

Name: J. R. R. R. Last: City, Florida, 32000 Date: 11/11/2020 Email: jerry@remedance.com	
PROJECT NO.: 1111111111	DRAWN BY: J. R. R. R.
CHECKED BY: J. R. R. R.	DATE: 11/11/2020
TOTAL SHEETS: 1 SHEET NO.: 1	
PROJECT NAME: REMEDANCE	