


These drawings, as instruments of service, are the sole property of the architect, and may not be used, copied or reproduced in whole or in part for use on or incorporated within any other job without specific and individual authorization by the architect.

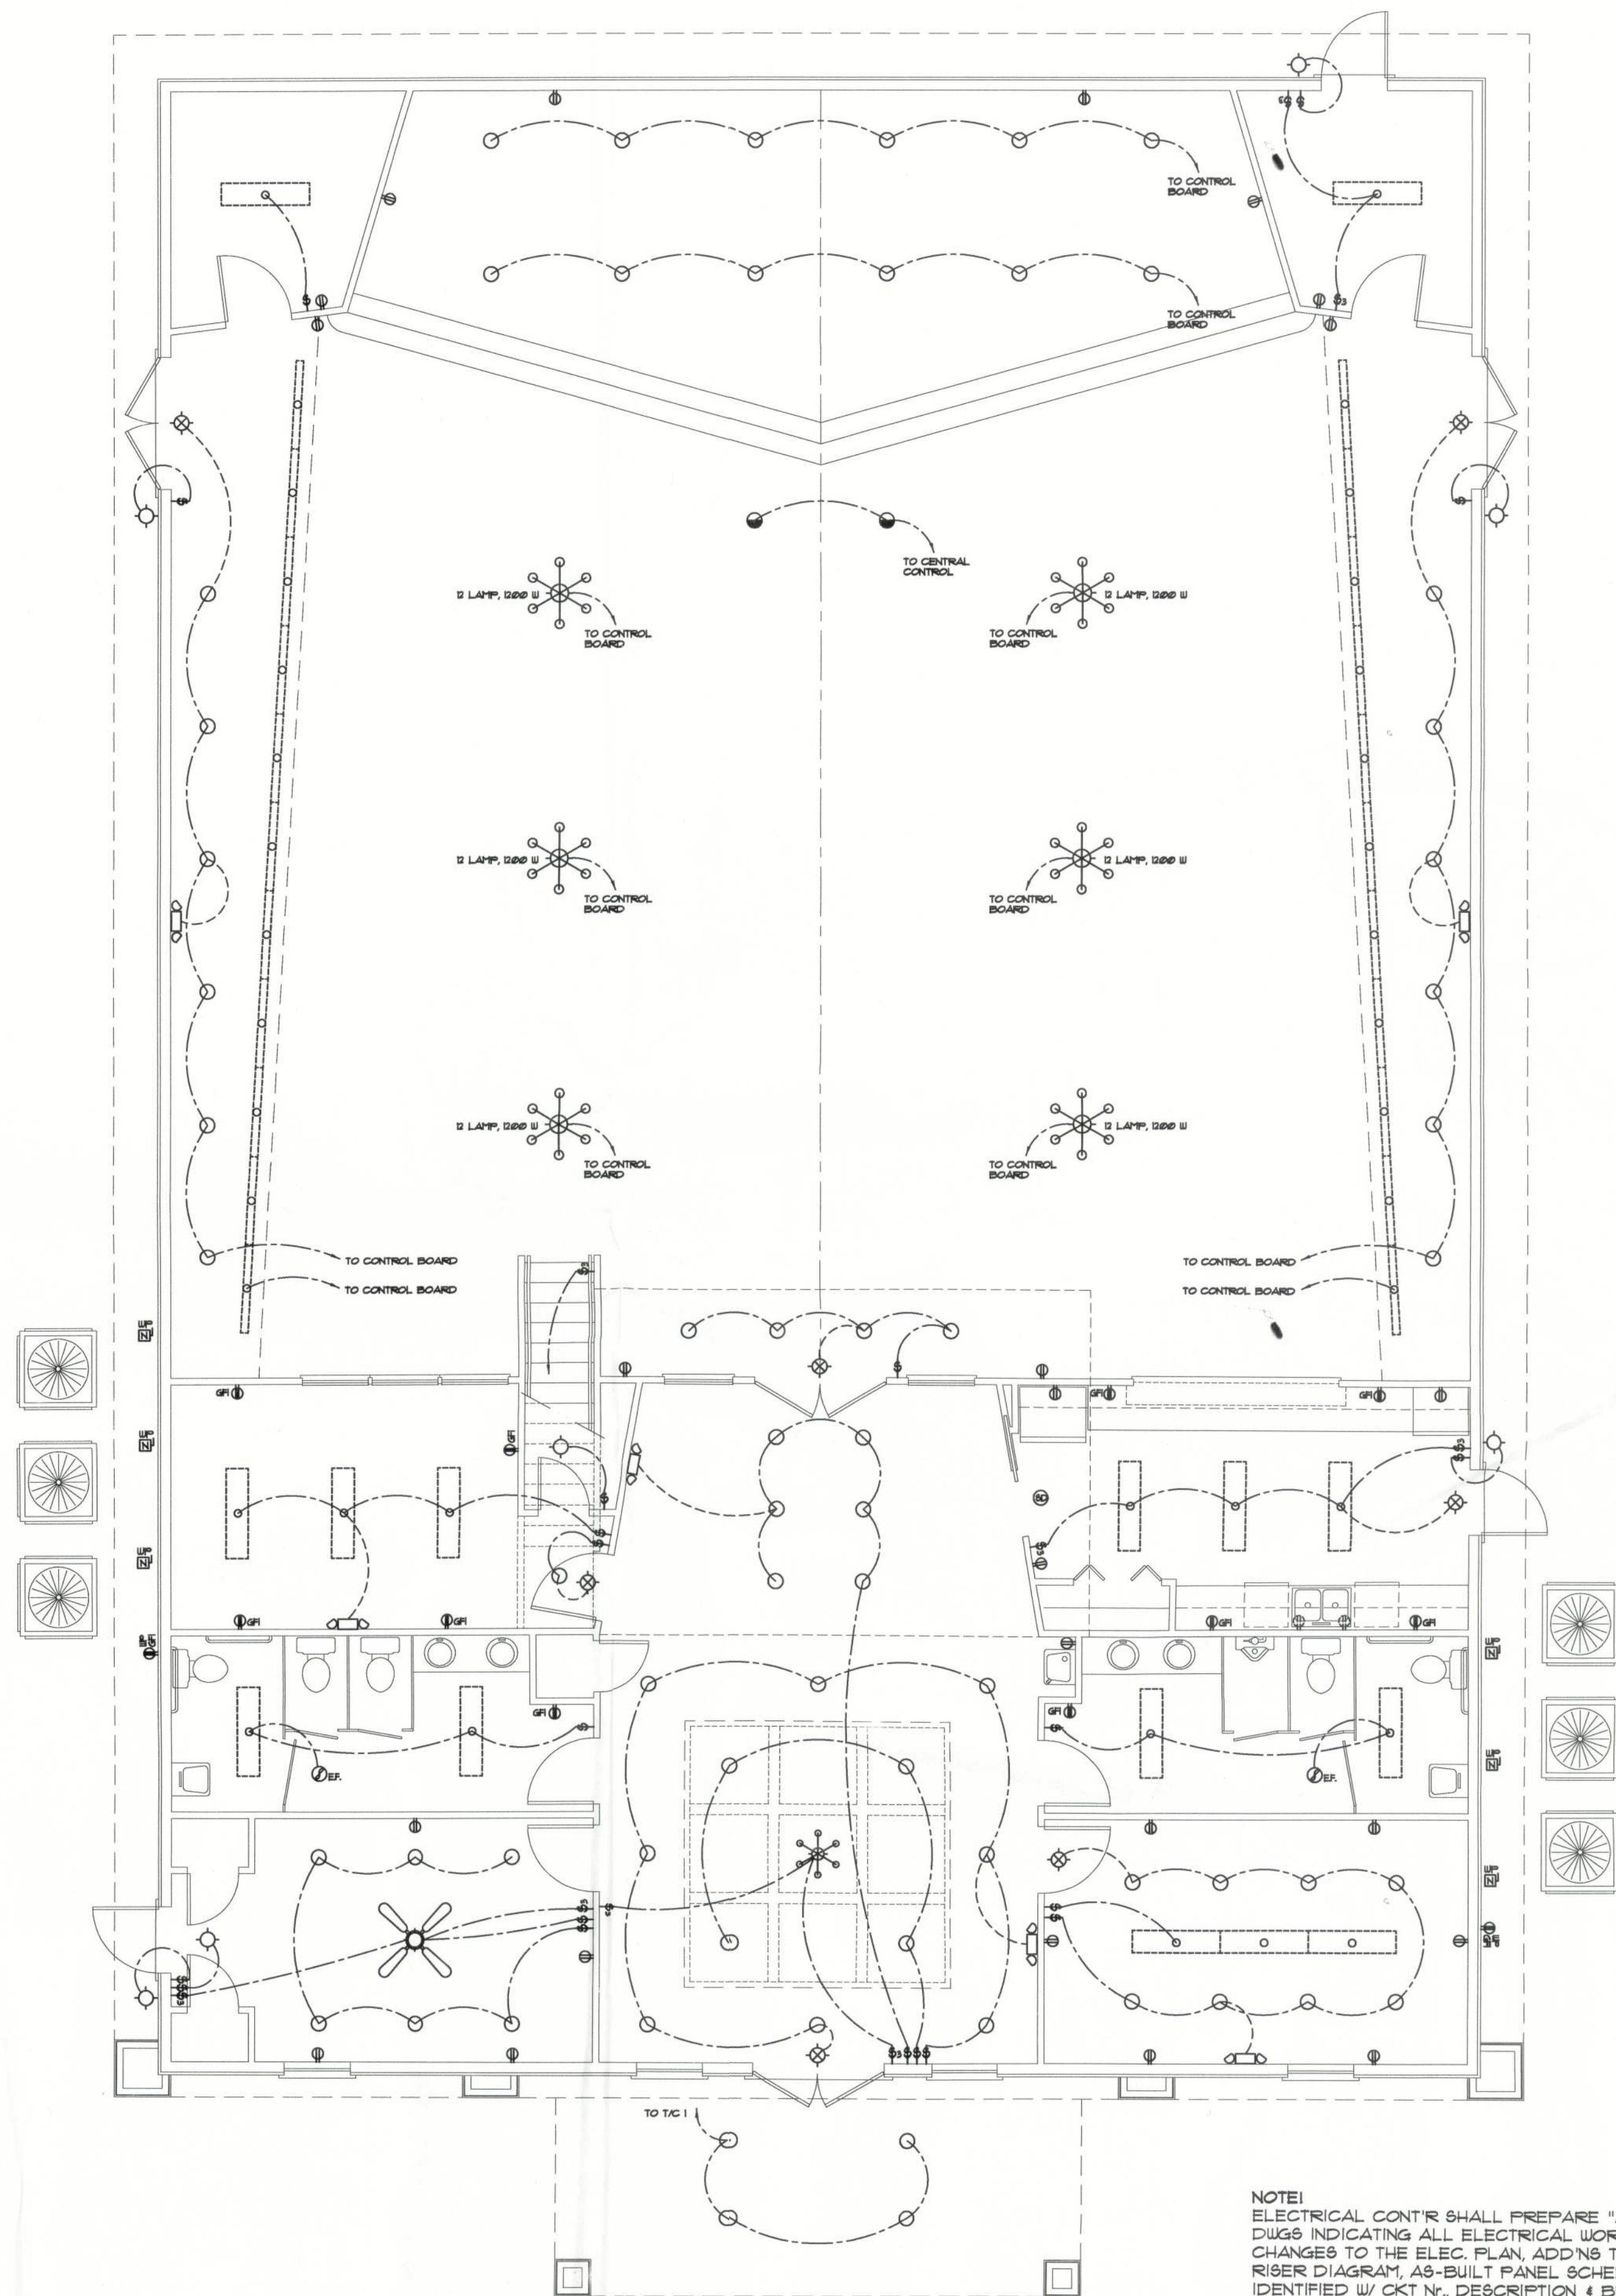


ELECTRICAL PLAN

SCALE: 3/16" = 1'-0"

NOTE:
EMERGENCY LIGHTING AND EXIT SIGNS SHALL BE PROVIDED
AS DIRECTED BY THE FIRE MARSHAL, AND SHALL BE WIRED
PER NEC 100-12F.

NOTE:
ELECTRICAL CONTR. SHALL PREPARE "AS-BUILT" SHOP
DRG'S INDICATING ALL ELECTRICAL WORK INCLUDING ANY
CHANGES TO THE ELEC. PLAN, ADDING TO THE ELEC. PLAN,
RISER DIAGRAM, AS-BUILT PANEL SCHEDULE W/ ALL CKTS
IDENTIFIED W/ CKT N., DESCRIPTION & BRKR. SERVICE ENT.
& ALL UNDERGROUND WIRE LOCATIONS/ROUTING/DEPTH.
RISER DIA. SHALL INCLUDE WIRE SIZES/TYPE & EQUIPMENT
TYPE W/ RATINGS & LOADS.
CONTRACTOR SHALL PROVIDE 1 COPY OF AS-BUILT DRG'S
TO OWNER & 1 COPY TO THE PERMIT ISSUING AUTHORITY.

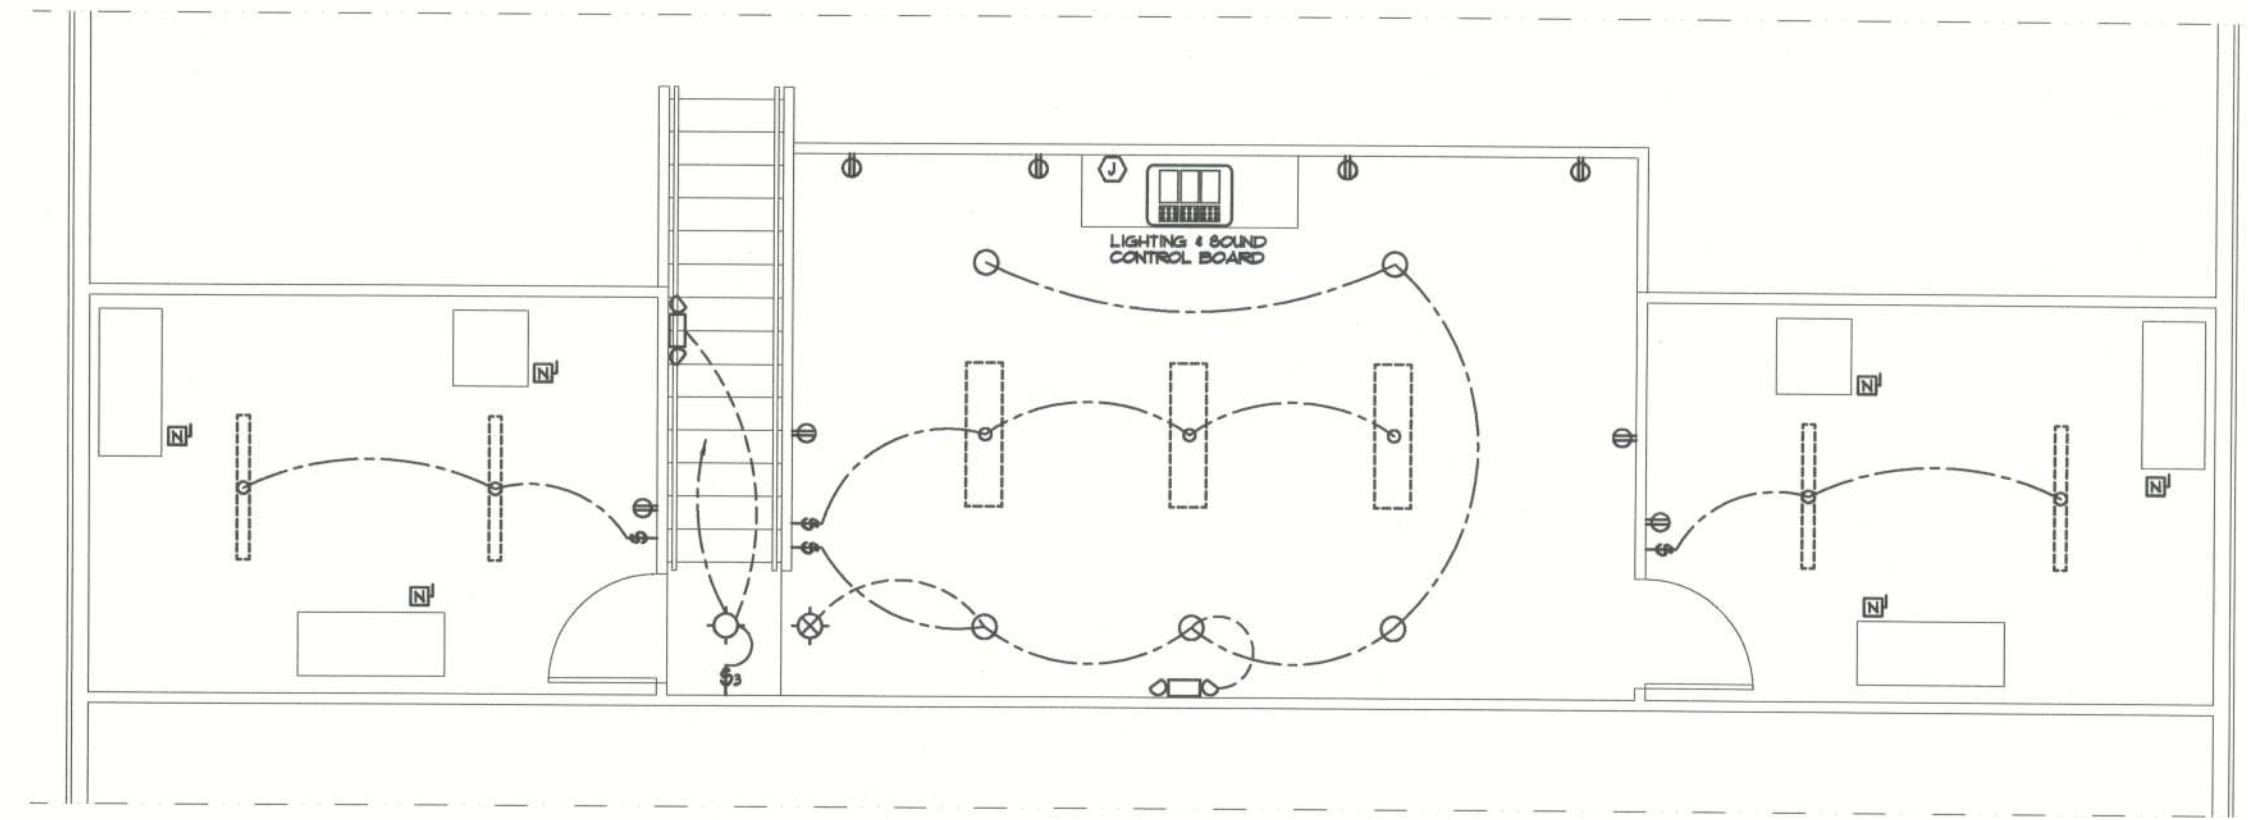

MEZZANINE ELECTRICAL PLAN

SCALE: 3/16" = 1'-0"

Electrical SYMBOLS

POWER

- ⊕ DUPLEX WALL RECEPTACLE
- ⊕ DUPLEX WALL RECEPT., BELOW COUNTER
- ⊕ 240V OUTLET
- ⊕ GFI GND FAULT INTERRUPTER DUPLEX RECEPT.
- ⊕ GFI WEATHER PROOF GFI DUPLEX RECEPT.
- ⊕ ELECTRICAL PANEL
- ⊕ ELECTRICAL PANEL
- ⊕ EXHAUST FAN
- ⊕ SMOKE DETECTOR, 120V
- ⊕ NON-FUSED DISC. SWITCH
- ⊕ NON-FUSED WEATHER-PROOF DISC. SWITCH
- ⊕ JUNCTION BOX

LIGHTING

- ⊕ SPST WALL SWITCH
- ⊕ DPDT WALL SWITCH (3-WAY)
- ⊕ DIMMER WALL SWITCH (600 W)
- ⊕ INC. CHANDELIER, 600W
- ⊕ 2 LAMP FLU. PRISMATIC WRAP SURFACE FIXTURE
- ⊕ 2 LAMP FLU. PRISMATIC WRAP SURFACE FIXTURE
- ⊕ INC. LIGHT FIXTURE - 60 W INC.
- ⊕ HIGH HAT DOWN LIGHT - 15W INC.
- ⊕ HIGH HAT EYEBALL - 500W QUARTZ
- ⊕ SWITCH/FIXTURE WIRING
- ⊕ CONTROL WIRE / LOW VOLTAGE
- ⊕ TIME CLOCK
- ⊕ EXIT LIGHT W/ BAT. PACK, GREEN LETTERS ON WHITE FACE
- ⊕ DUAL HEAD EMERGENCY LIGHT W/ BAT. PACK
- ⊕ CEILING FAN W/ LIGHT KIT

REVISION:

Copyright 2012
N.P. Geisler, Architect

DRAWN:

mpg

WORSHIP CENTER for:
CROSS POINT COMMUNITY CHURCH
COLUMBIA COUNTY, FLORIDA
ELECTRICAL PLAN

Calculating
40 Years of Service
1972 - 2012
N.P. Geisler, Architect
AR0007005

**NICHOLAS
PAUL
GEISLER
ARCHITECT**
N.C.A.R.B. Certified
1758 NW Broward Rd.
Coral Gables, FL 33134
305-436-4365

DATE:

30 JUL 2012

COMM:

2K1239

SHEET:

E.1
S.3

13 OF 32

AR0007005