 
 
 
 



REVISIONS		
05/17/04	TMR	
05/19/04	TMR	
08/31/04	TMR	

SOFTPLAN
ARCHITECTURAL DESIGN SOFTWARE


ELECTRICAL	COUNT	SYMBOL
ceiling fan	2	
200 amp service panel	1	
light	5	
cable tv outlet	4	
ceiling fan	2	
electric meter	1	
fluorescent lt fixture	1	
gfi waterproof outlet	2	
light	12	
outlet	28	
outlet 220v	3	
outlet gfi	3	
smoke detector	5	
switch	22	
switch 3 way	6	
telephone	4	
vent light combo	2	

ELECTRICAL PLAN NOTES

- E-1 WIRE ALL APPLIANCES, HVAC UNITS AND OTHER EQUIPMENT PER MANUFACTURER'S SPECIFICATIONS.
- E-2 CONSULT THE OWNER FOR THE NUMBER OF SEPERATE TELEPHONE LINES TO BE INSTALLED.
- E-3 ALL INSTALLATIONS SHALL BE PER NATIONAL ELECTRIC CODE.
- E-4
- E-5 ALL SMOKE DETECTORS SHALL BE 120V W/BATTERY BACKUP OF THE PHOTOELECTRIC TYPE, AND SHALL BE INTERLOCKED TOGETHER. INSTALL INSIDE AND NEAR ALL BEDROOMS.
- E-6 TELEPHONE, TELEVISION AND OTHER LOW VOLTAGE DEVICES OR OUTLETS SHALL BE AS PER THE OWNER'S DIRECTION AND IN ACCORDANCE WITH APPLICABLE SECTIONS OF NATIONAL ELCT. CODE LATEST EDITION.
- E-7 ELECTRICAL CONTRACTOR SHALL BE RESPONSIBLE FOR THE DESIGN AND SIZING OF ELECTRICAL SERVICE AND CIRCUITS.
- E-8 ENTRY OF SERVICE UNDERGROUND OR OVERHEAD) IS TO BE DETERMINED BY THE POWER COMPANY.
- ALL BEDROOM RECEPTALS ARE TO BE AFCI (ARC FAULT CIRCUIT INTERRUPT)

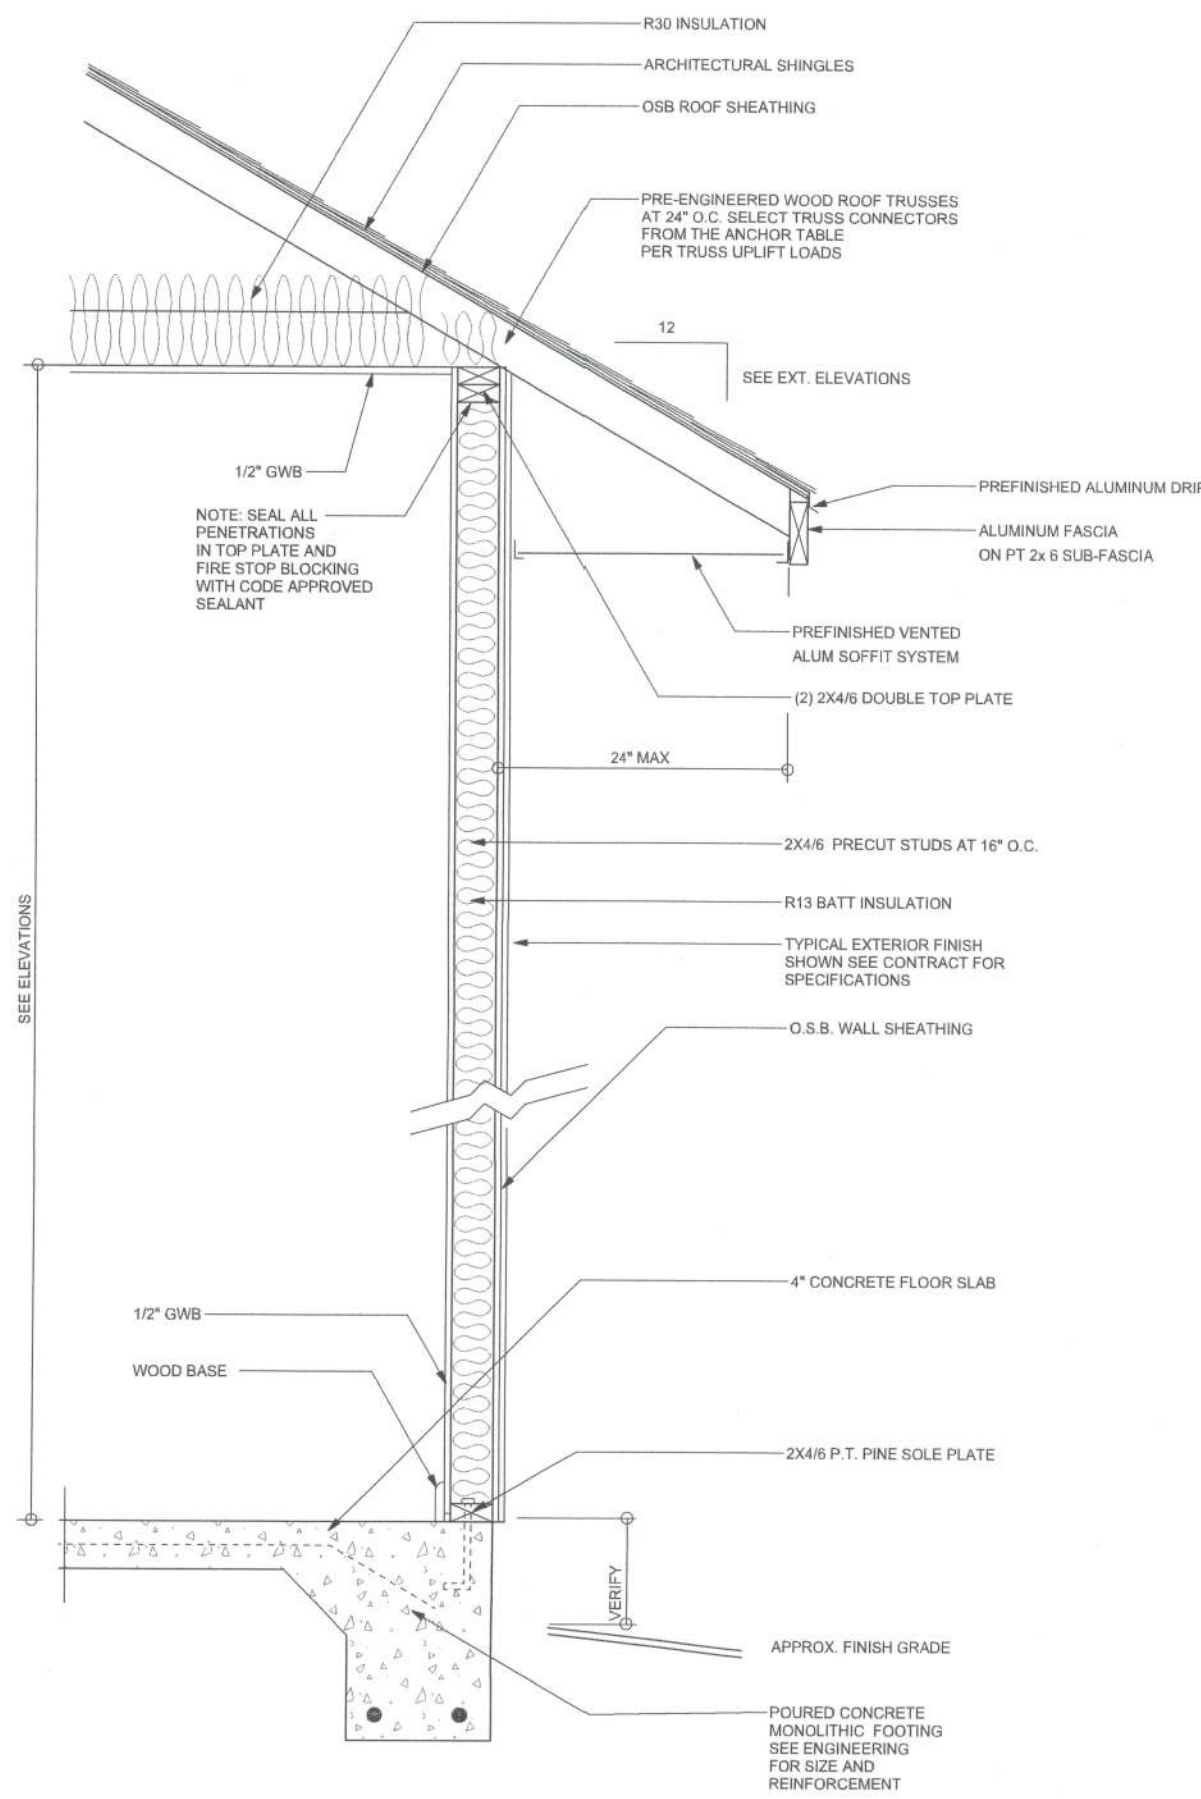


TYPICAL DESIGN WALL SECTION
NON - STRUCTURAL DATA
SCALE: 3/4\" = 1'-0"

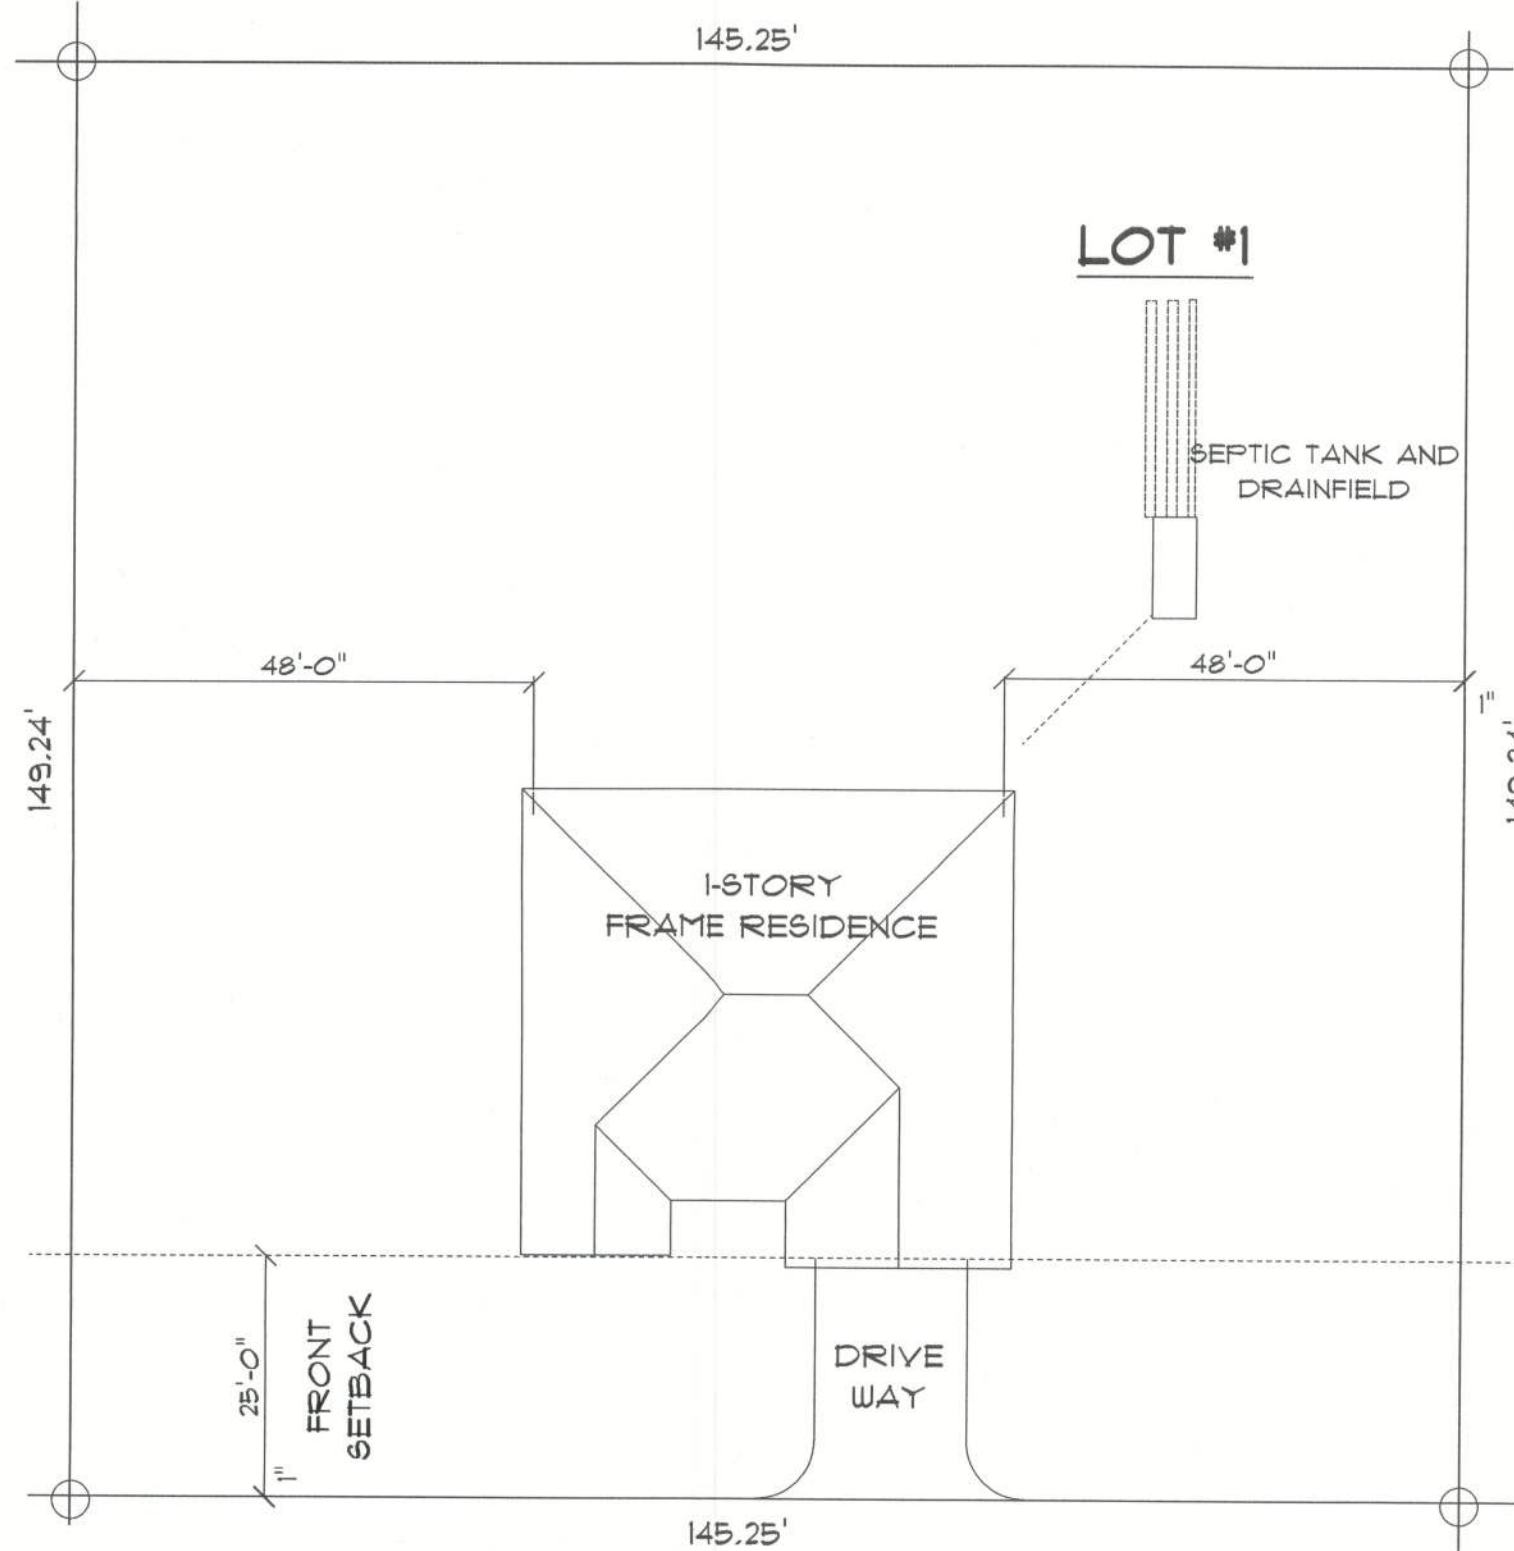

* SITE PLAN *

SCALE : 1" = 20'

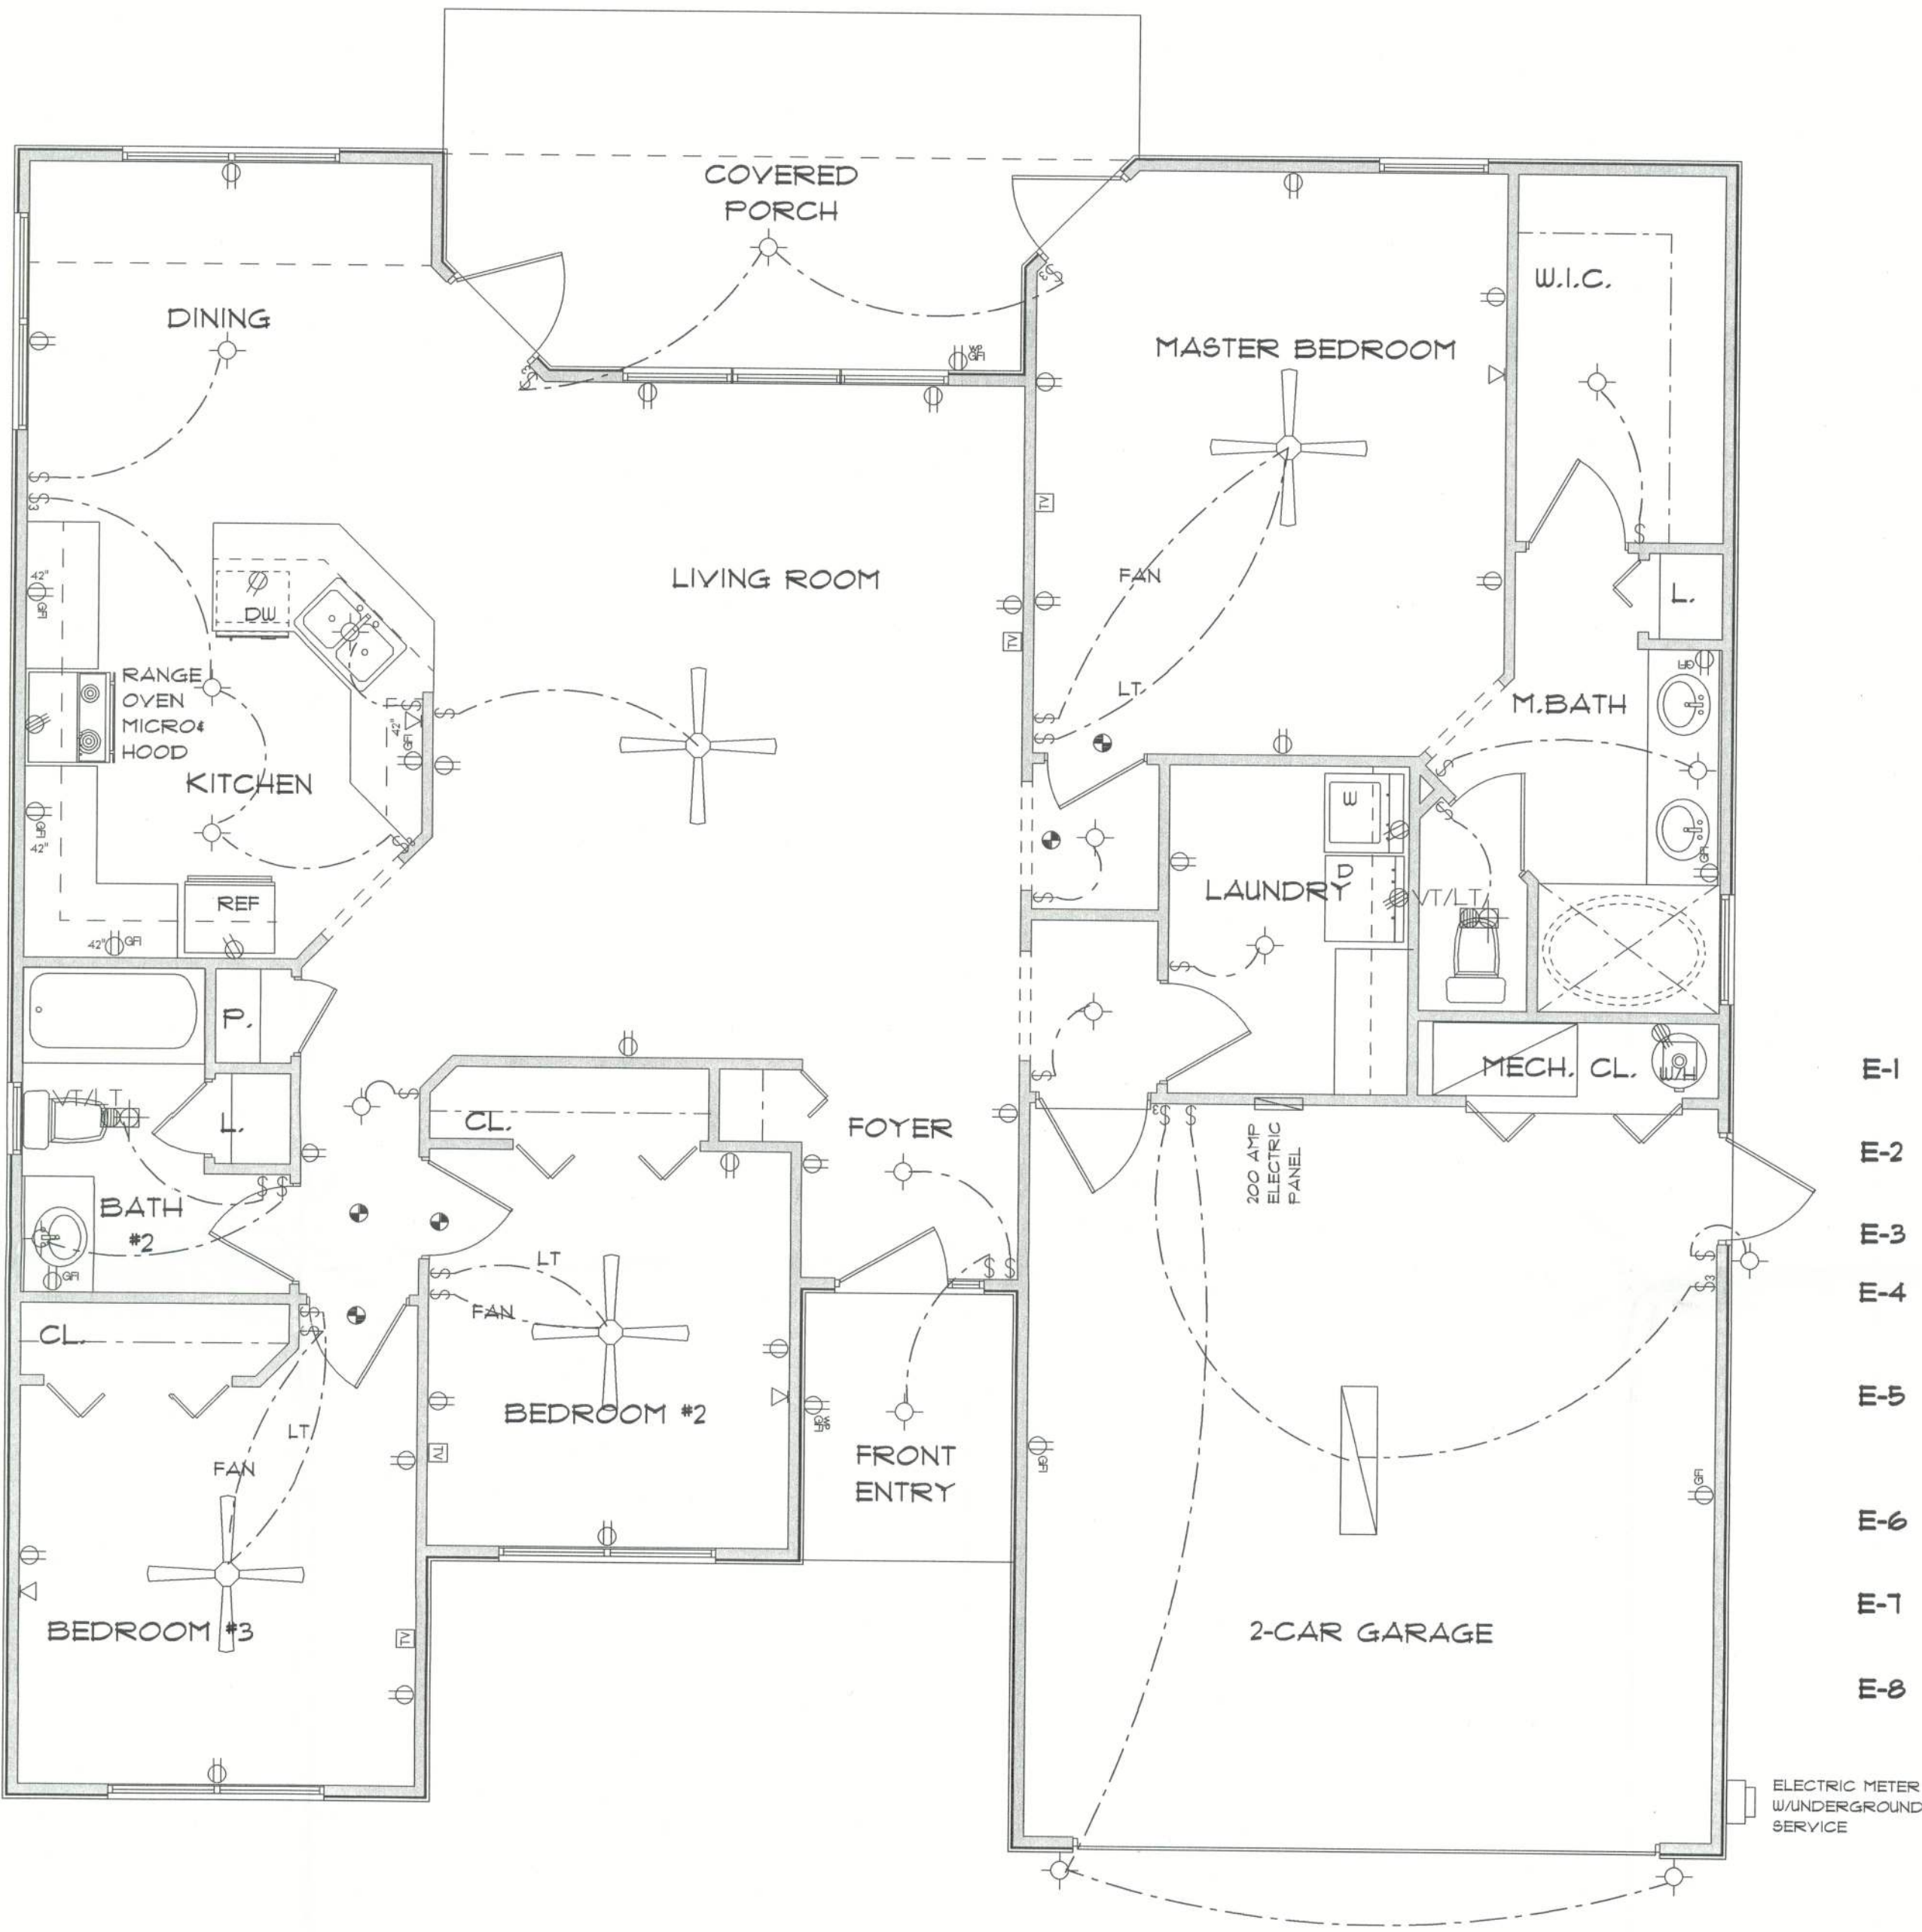

* ELECTRICAL PLAN *

SCALE : 1/4" = 1'-0"

"THE SAMUEL"

COUNTRY SIDE
ESTATES
LOT #1
LAKE CITY
FLORIDA

Teresa M. Ruffo
251 NW Hall of Fame Dr.
Lake City, Florida 33005
Phone: (386) 755 - 9993
Cell: (386) 867 - 1191
Email: esagestreet@aol.net

PRINTED DATE: August 31, 2004	
DRAWN BY: Teresa M. Ruffo	CHECKED BY:
DESIGNED BY: <i>Teresa M. Ruffo</i>	
FINALS DATE: MAY 2004	
JOB NUMBER:	
DRAWING NUMBER A-2	
OF 2 SHEETS	