



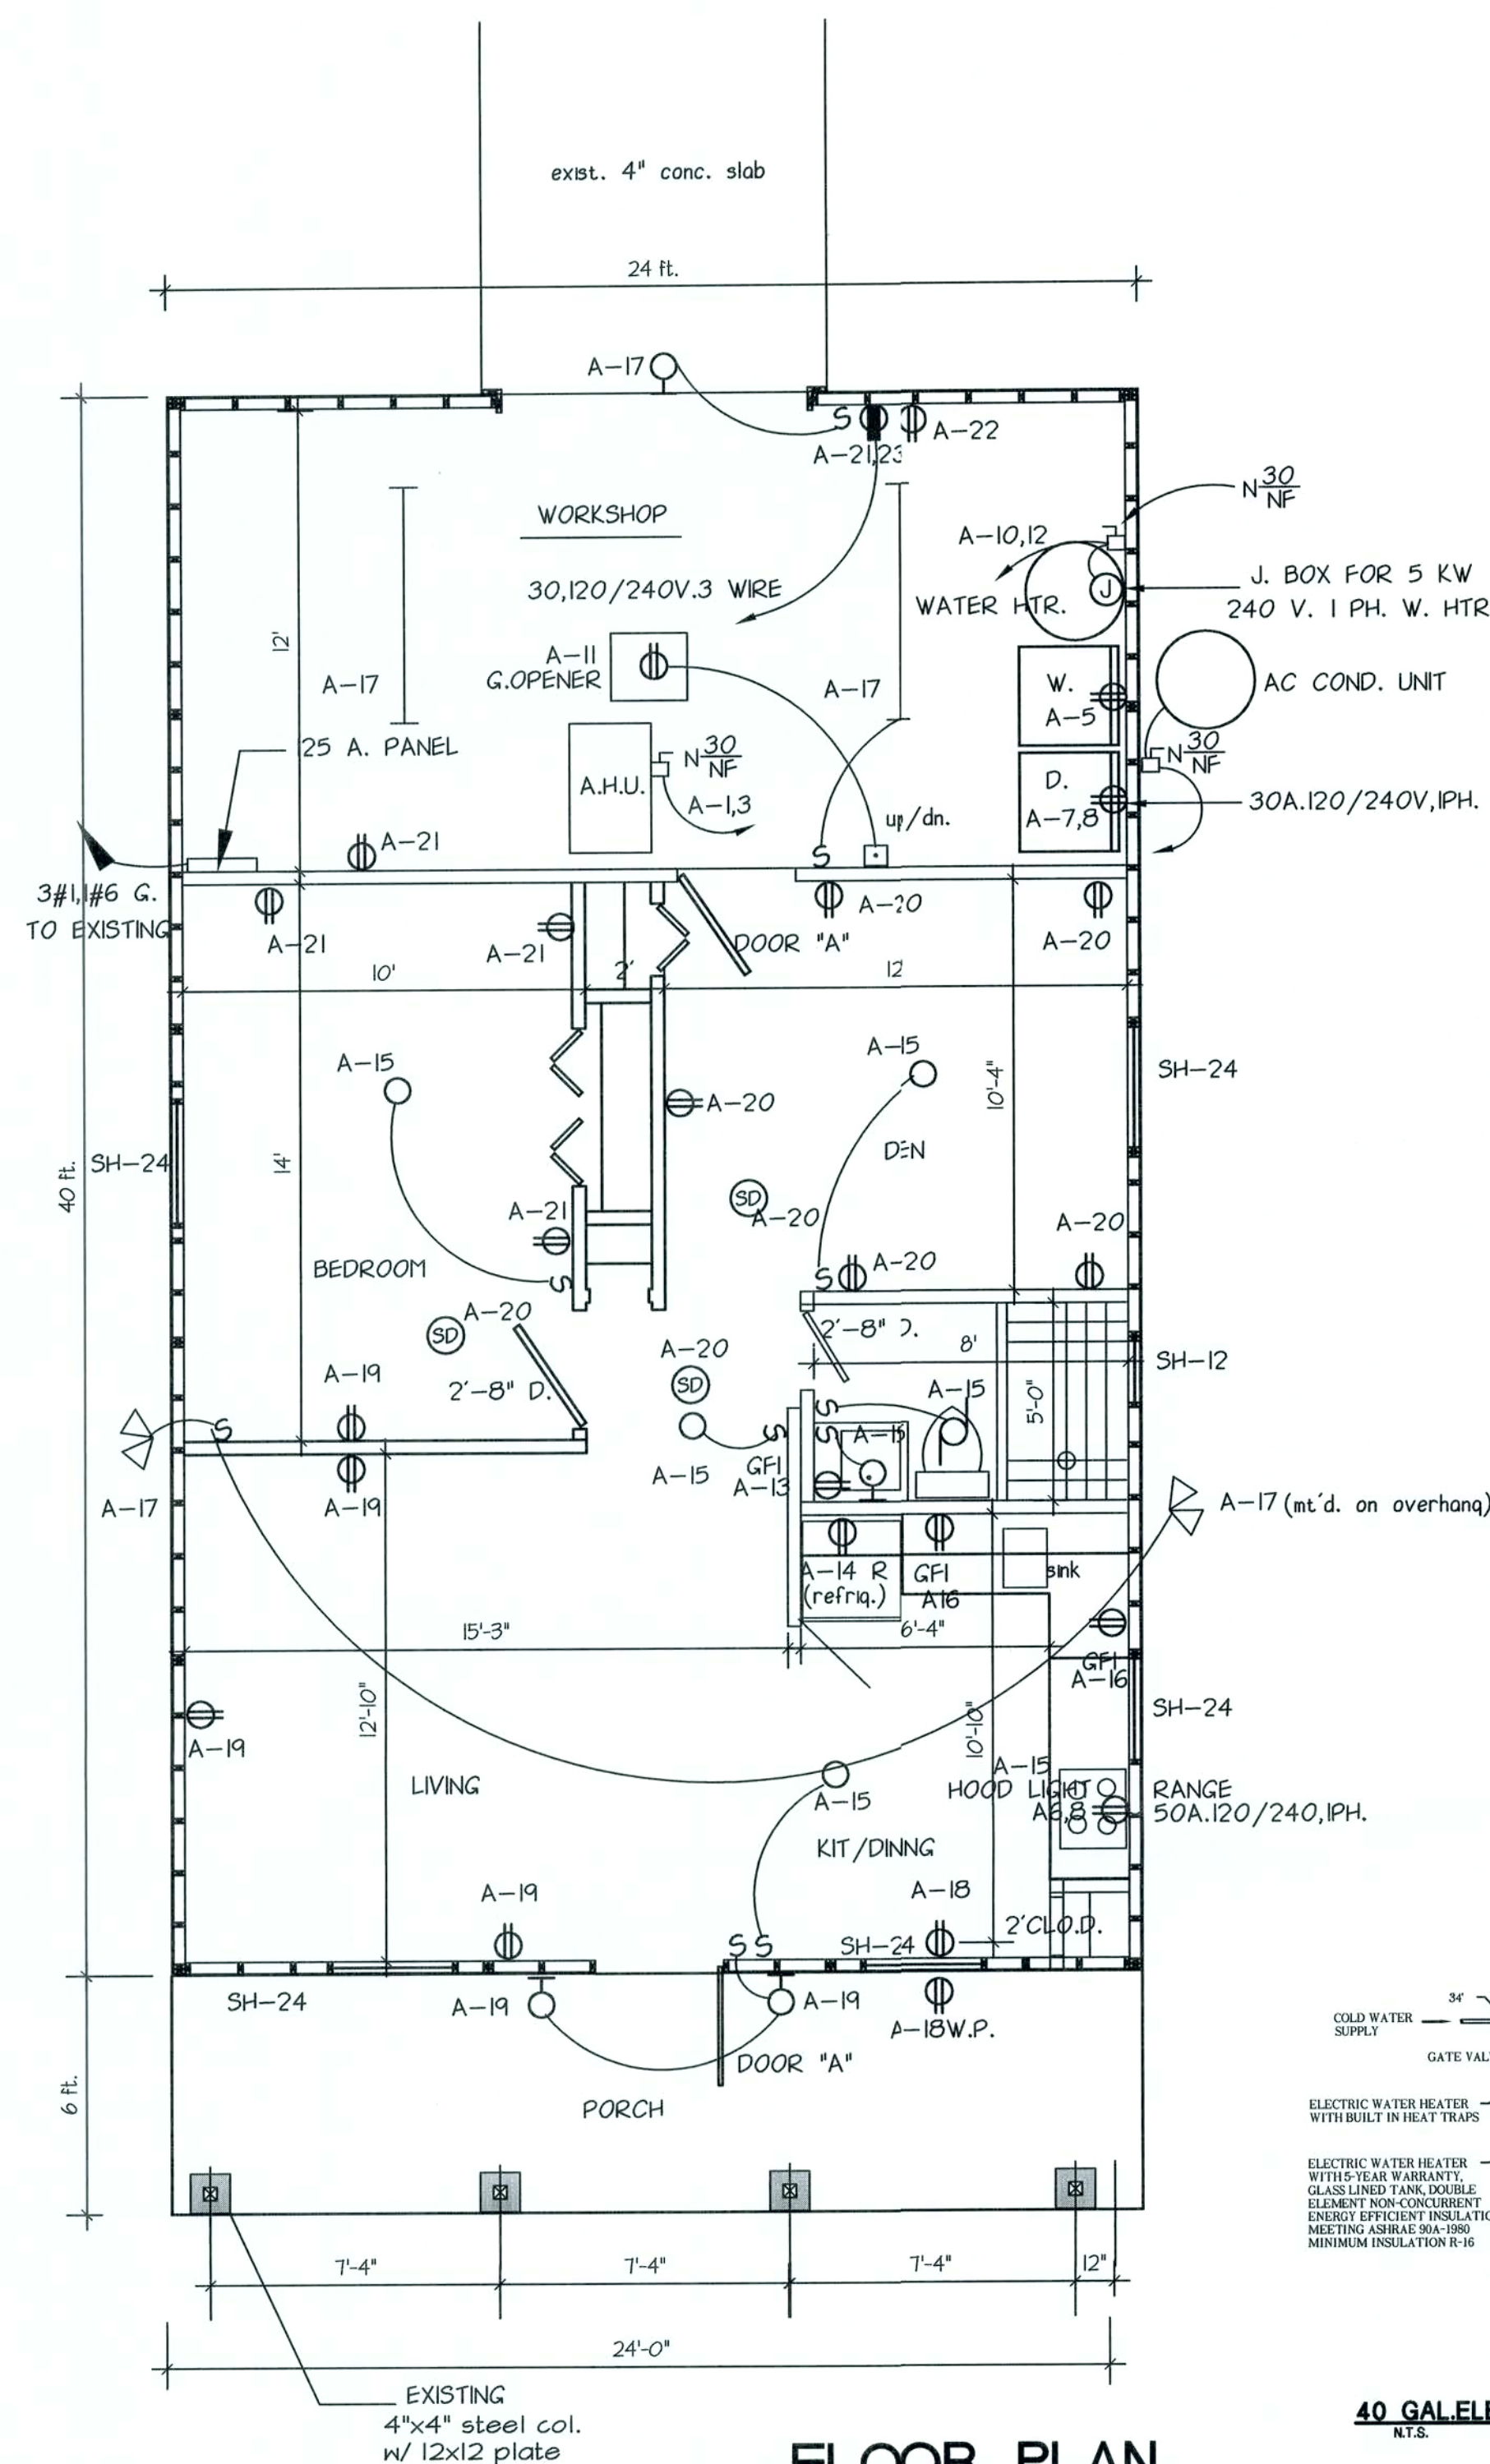


FLOOR PLAN
SCALE: 1/4"=1'-0"


DOOR "A" IS A 36"x80"x1 3/8" HONEYCOMB CORE STEEL DOOR

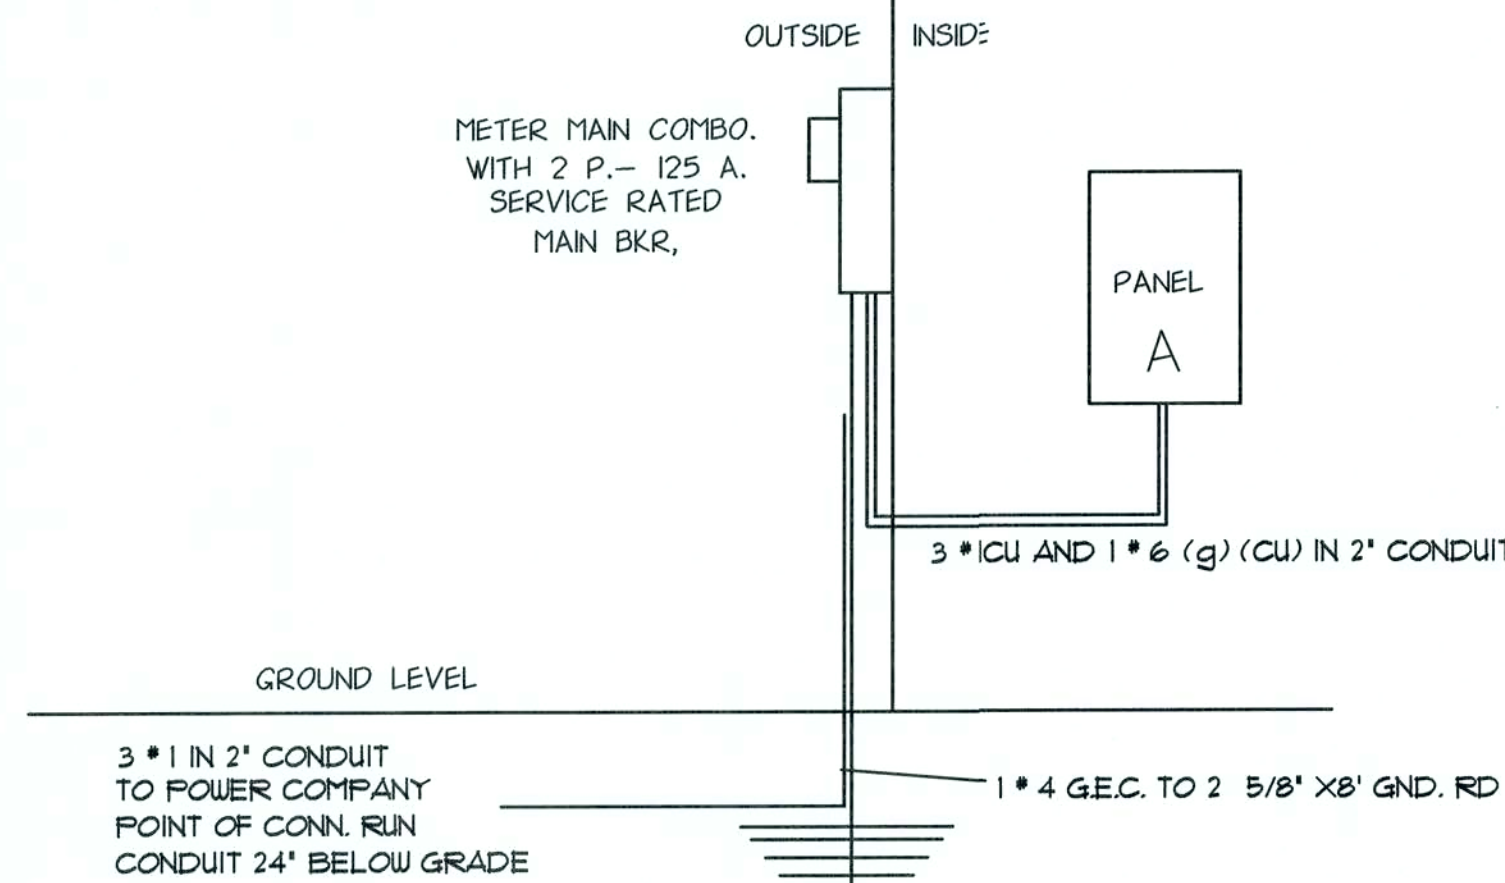


ELECTRICAL RISER
NO SCALE

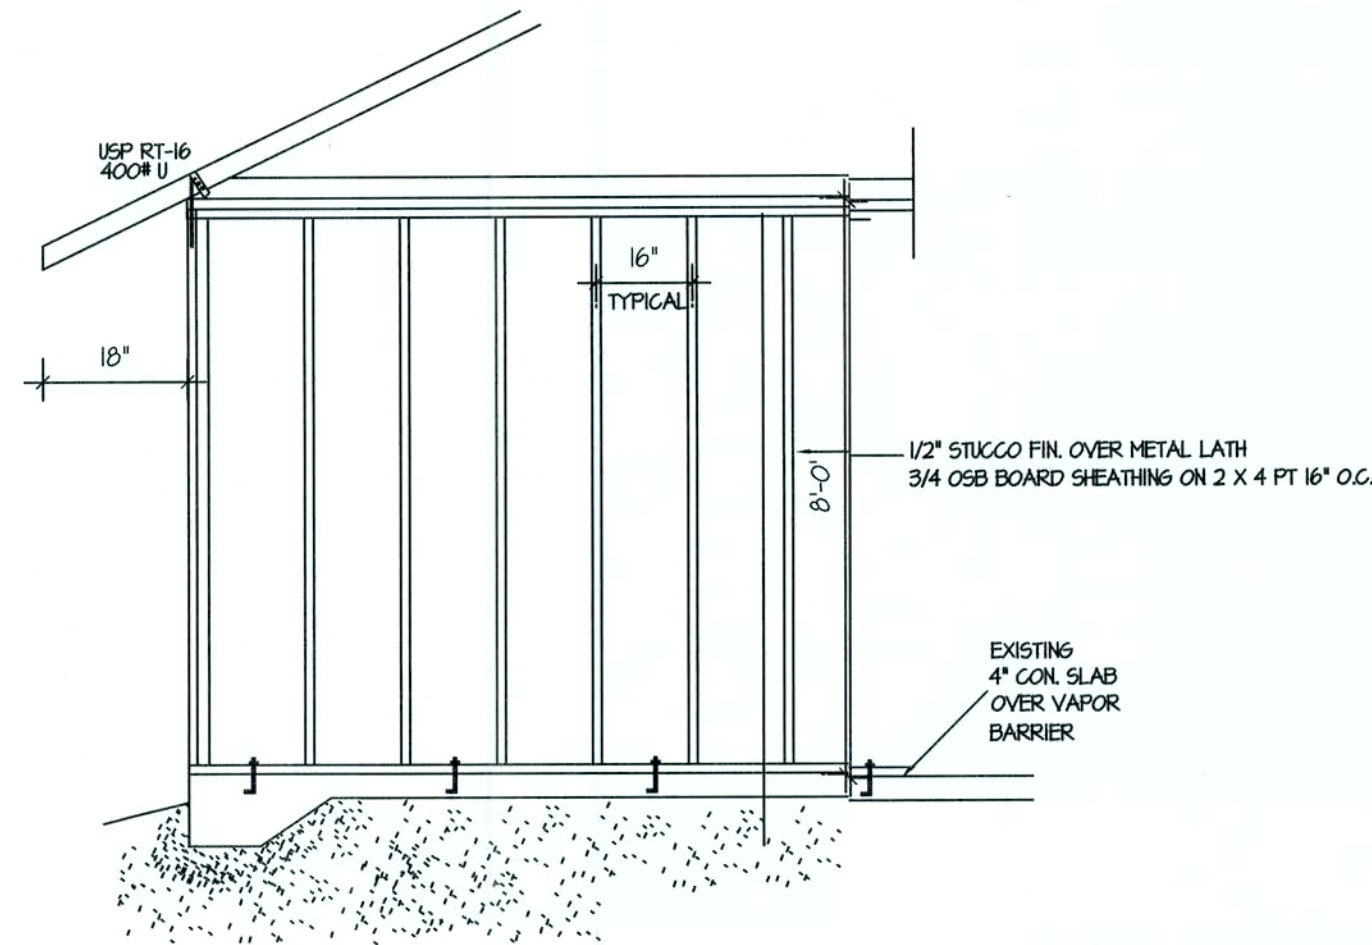


TYPICAL WALL SECTION
no scale

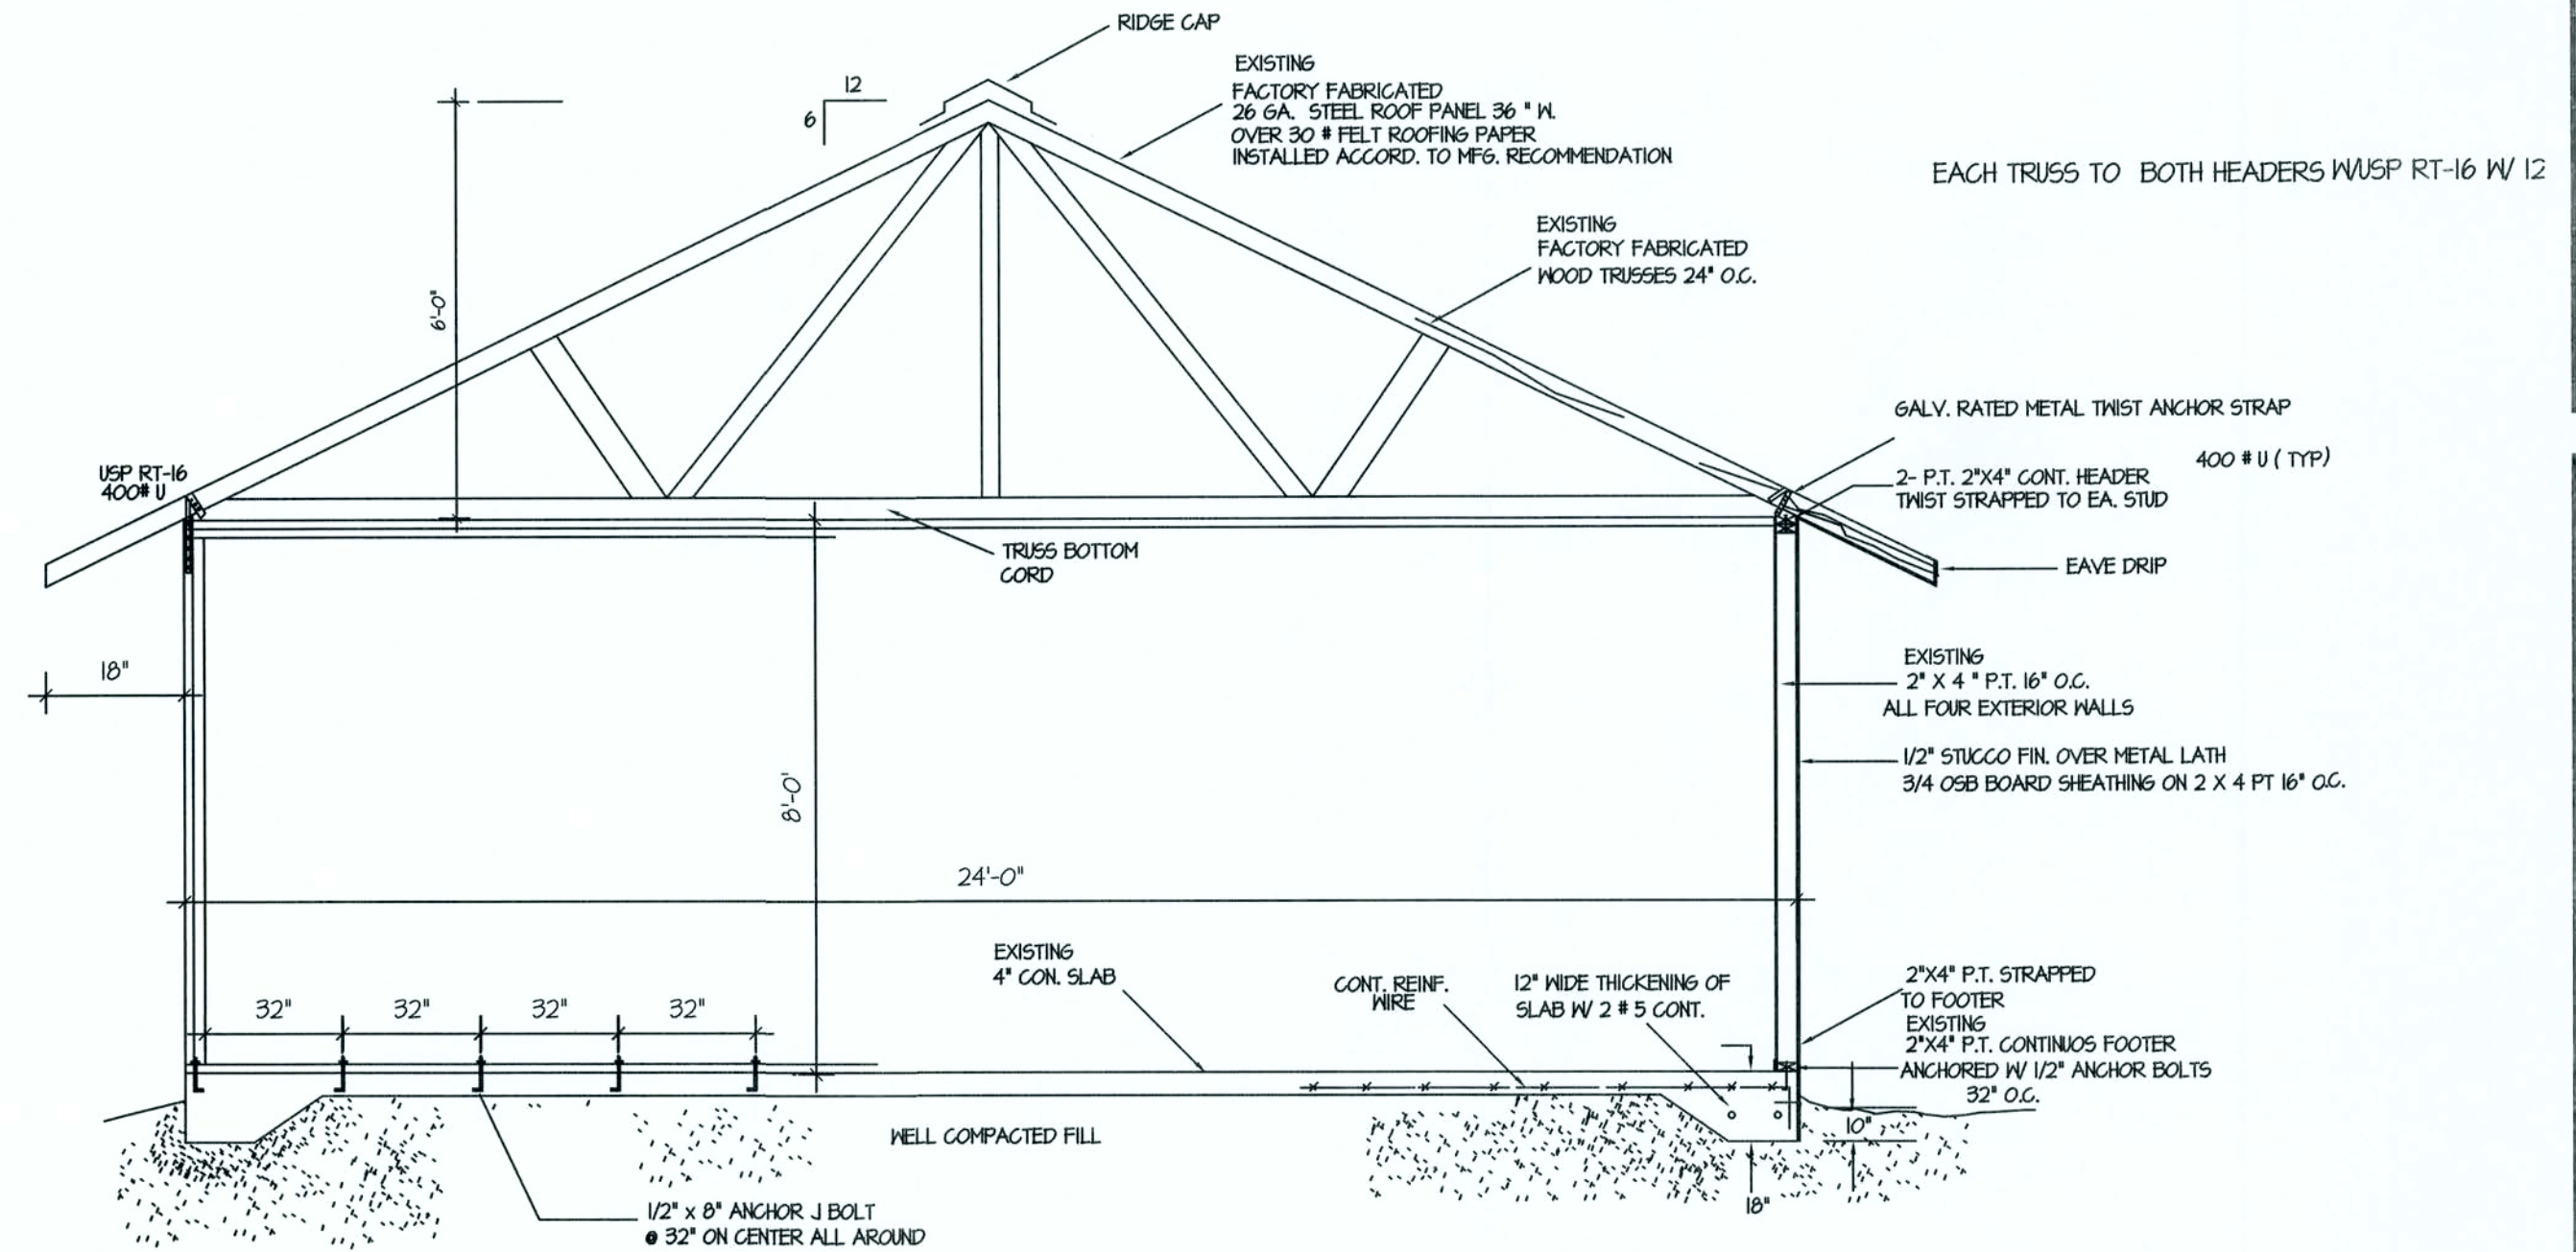


TYPICAL WALL SECTION AT GABLE END
no scale

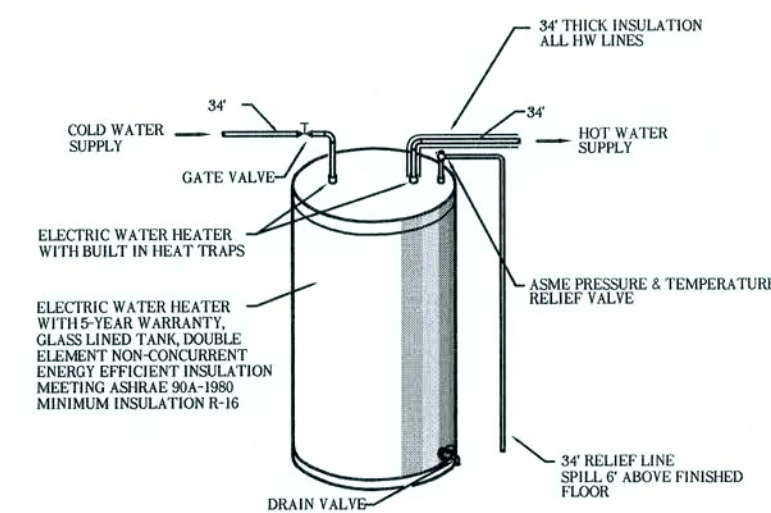


40 GALE ELECTRIC WATER HEATER DETAIL
N.T.S.

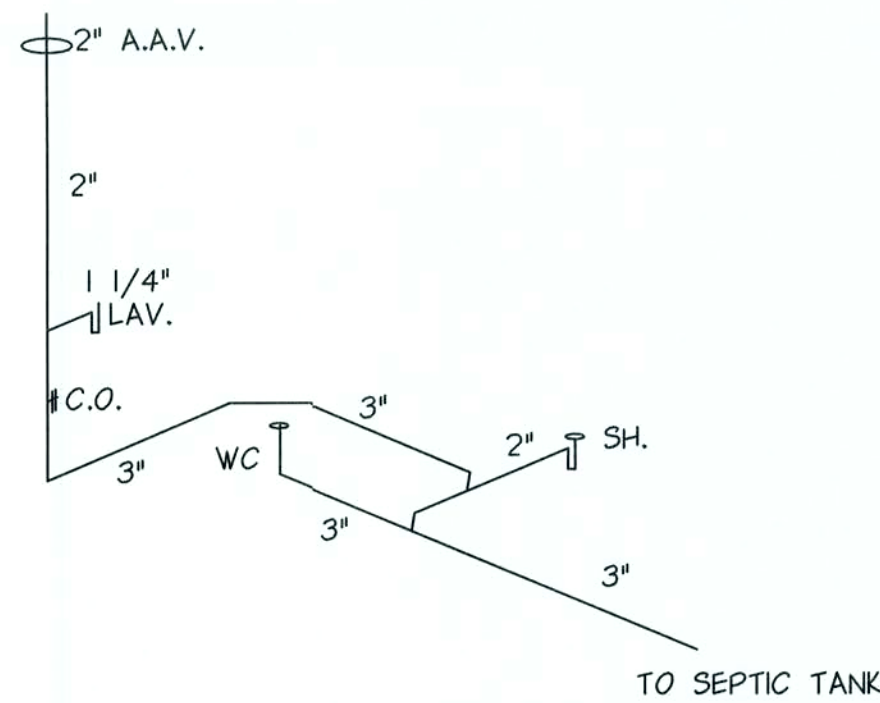

SANITARY ISOMETRIC

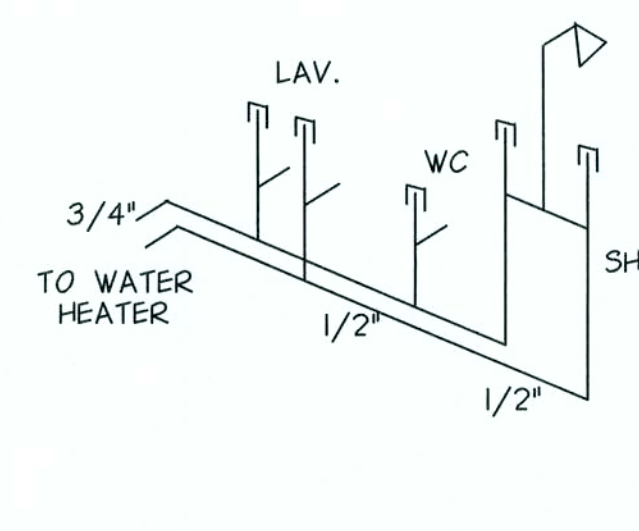

WATER ISOMETRIC

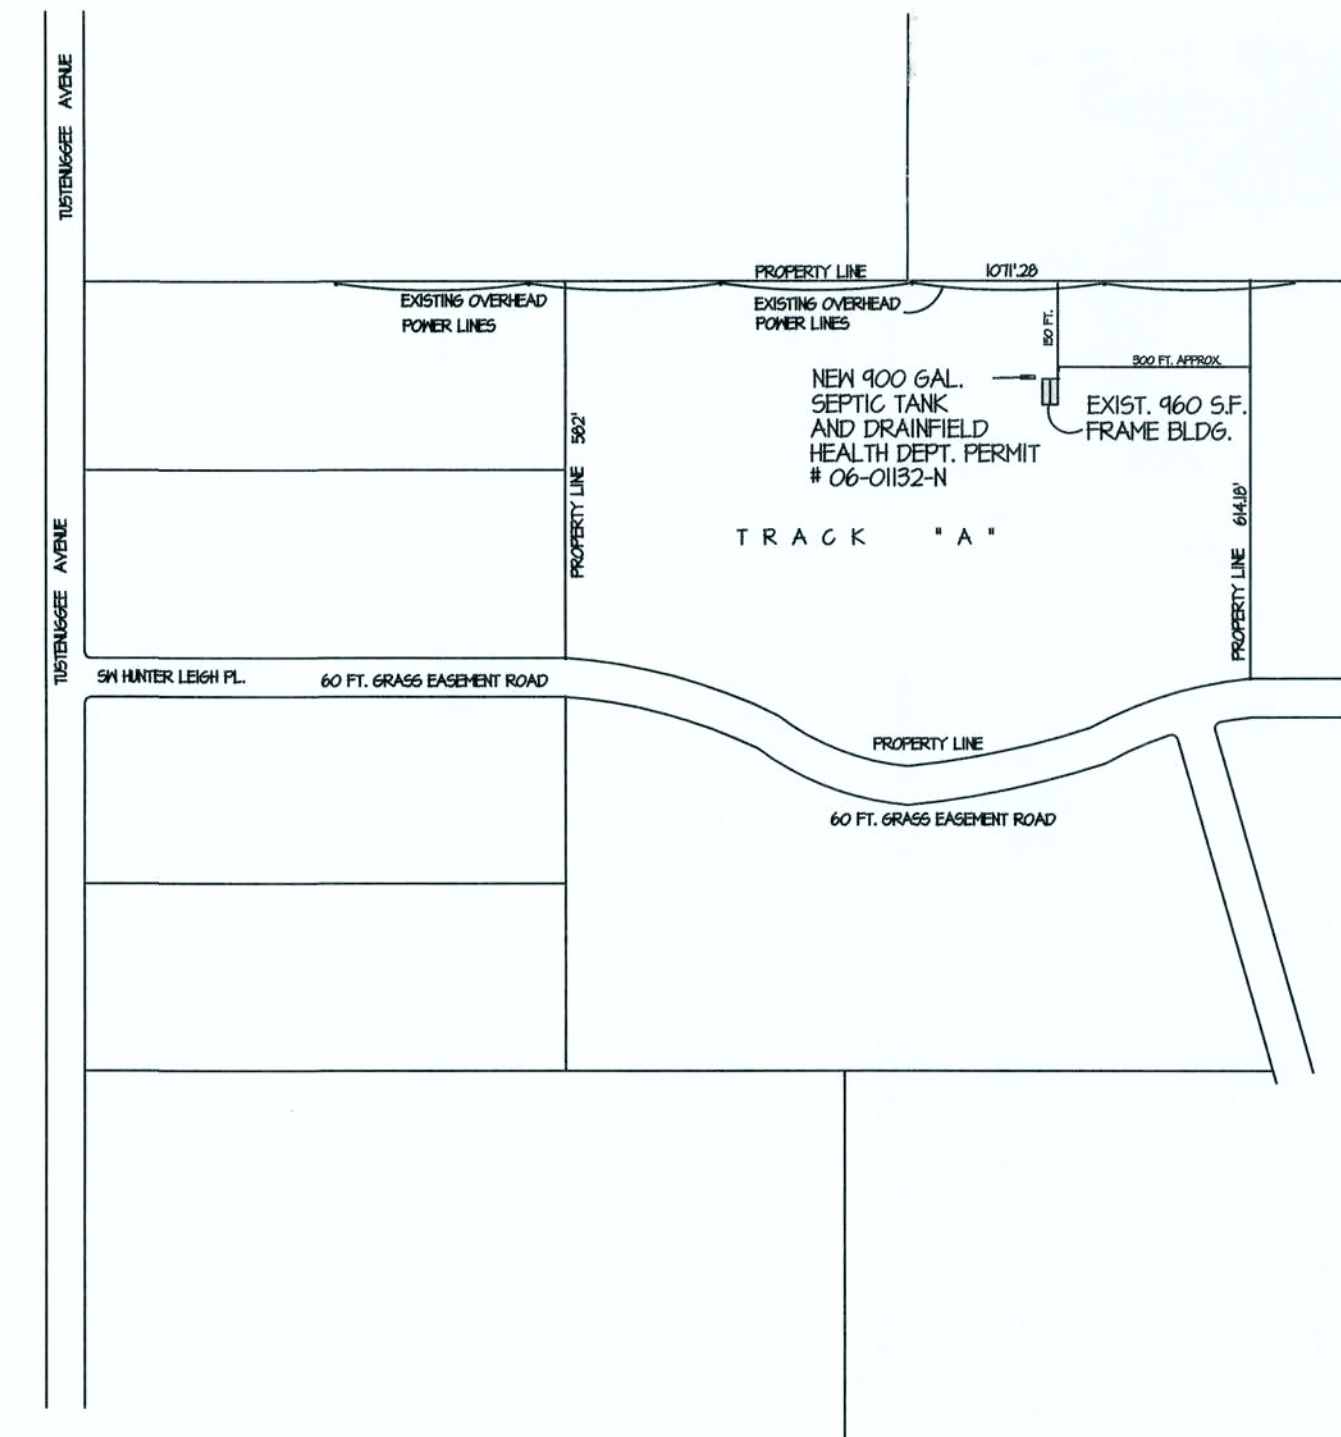

SITE PLAN
SCALE: 1"= 300 ft.

LEGAL DESCRIPTION
IN COLUMBIA COUNTY, FLORIDA
COMM. AT NE COR OF NW 1/4 OF SEC. RUN WEST 783.17 FOR POB, CONTAIN. 1071.28 FT.
S. 582.02 FT. TO N. R/W OF 60 FT. PRIVATE EASE., E. ALONG R/W 1134.44 FT. N. 613.81 FT. TO POB
AKA PARCEL "A" MELISSA'S SECRET GARDEN UNR ORB 1045-1536, TP * 05-65-09607-210

LOCATION GARAGE WALL MAIN M.L.O.						120 240 1 V. 3 W. AIC RATING 10K MOUNT FLUSH					
A. 125 PANEL 'A'											
CKT	SERVES	C.B.	P	K.V.A.	ROMEX	CKT	SERVES	C.B.	P	K.V.A.	ROMEX
1	AHU (**)	25	2	5.4	#10	2	CU (**)	20	2	2.5	#12
3						4					
5	WASHER	20	1	1.5	#12	6	RANGE	50	2	12.0	#6
7	DRYER	30	2	5.0	#10	8					
9						10	WATER HEATER	30	2	5.0	#10
11	OVERHEAD DOOR	20	1	1.2	#12	12					
13	BATH REC.	20	1	(*)	#12	14	REFRIGERATOR	20	1	1.4	#12
15	GENERAL LTS.	20	1	(*)	#12	16	SMALL APPLIANCES	20	1	1.5	#12
17	GENERAL LTS.	20	1	(*)	#12	18	SMALL APPLIANCES	20	1	1.5	#12
19	GENERAL RECS.	20	1	(*)	#12	20	GENERAL RECS.	20	1	(*)	#12
21	GENERAL RECS.	20	1	(*)	#12	22	GENERAL RECS.	20	1	(*)	#12
23	30A RECEPT.	20	1	(*)	#12	24	SPACE	-	-	-	-
25	SPACE	-	-	-	-	26	SPACE	-	-	-	-
27	SPACE	-	-	-	-	28	SPACE	-	-	-	-
29	SPACE	-	-	-	-	30	SPACE	-	-	-	-
31	SPACE	-	-	-	-	32	SPACE	-	-	-	-

* AFCI


REVISIONS:

ENRIQUE RECIO TEL. 305 710 5114
355 SW HUNTER LEIGH PL.
COLUMBIA CITY, FLORIDA
PROPERTY ID 05-65-17-09607-201

SHEET NO.


1

OF 2

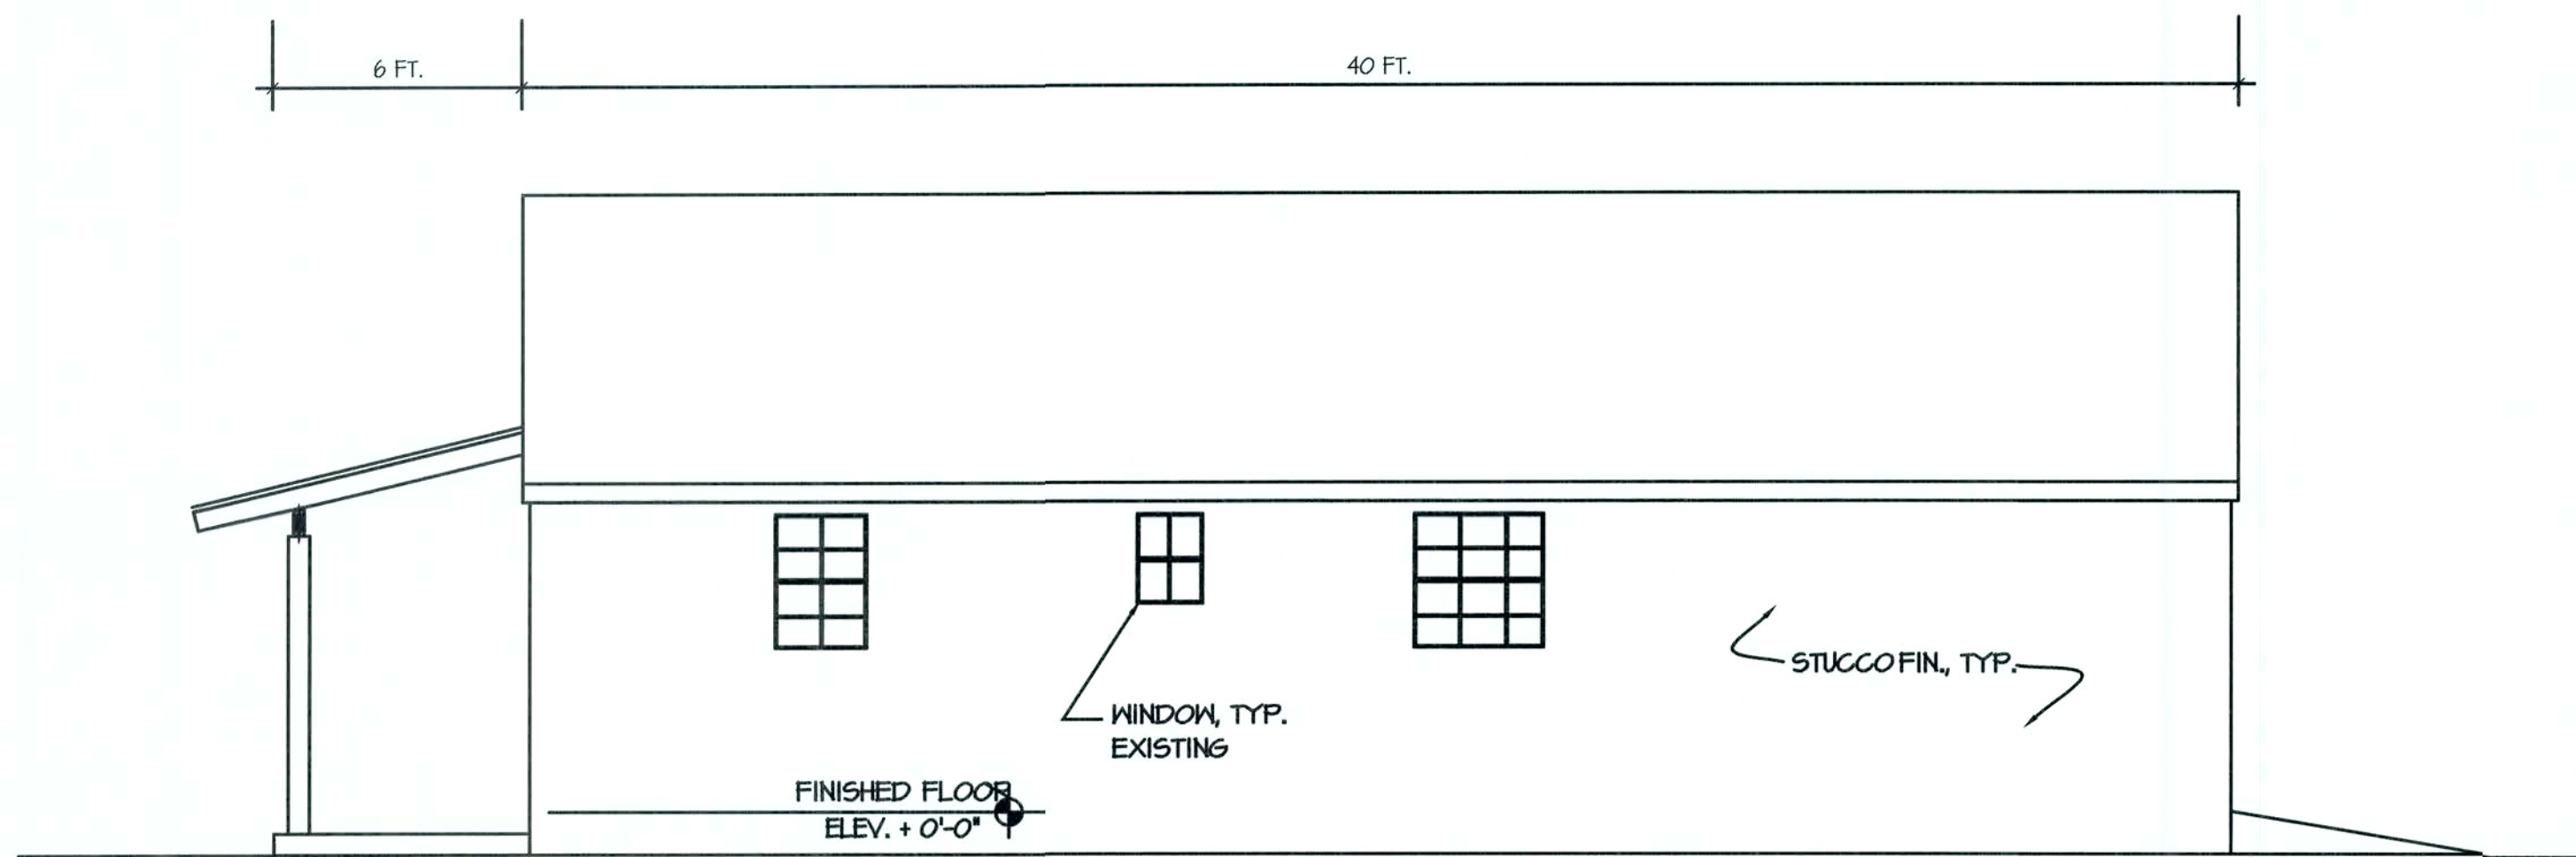


EXIST. WEST ELEVATION

SCALE: 1/4"=1'-0"

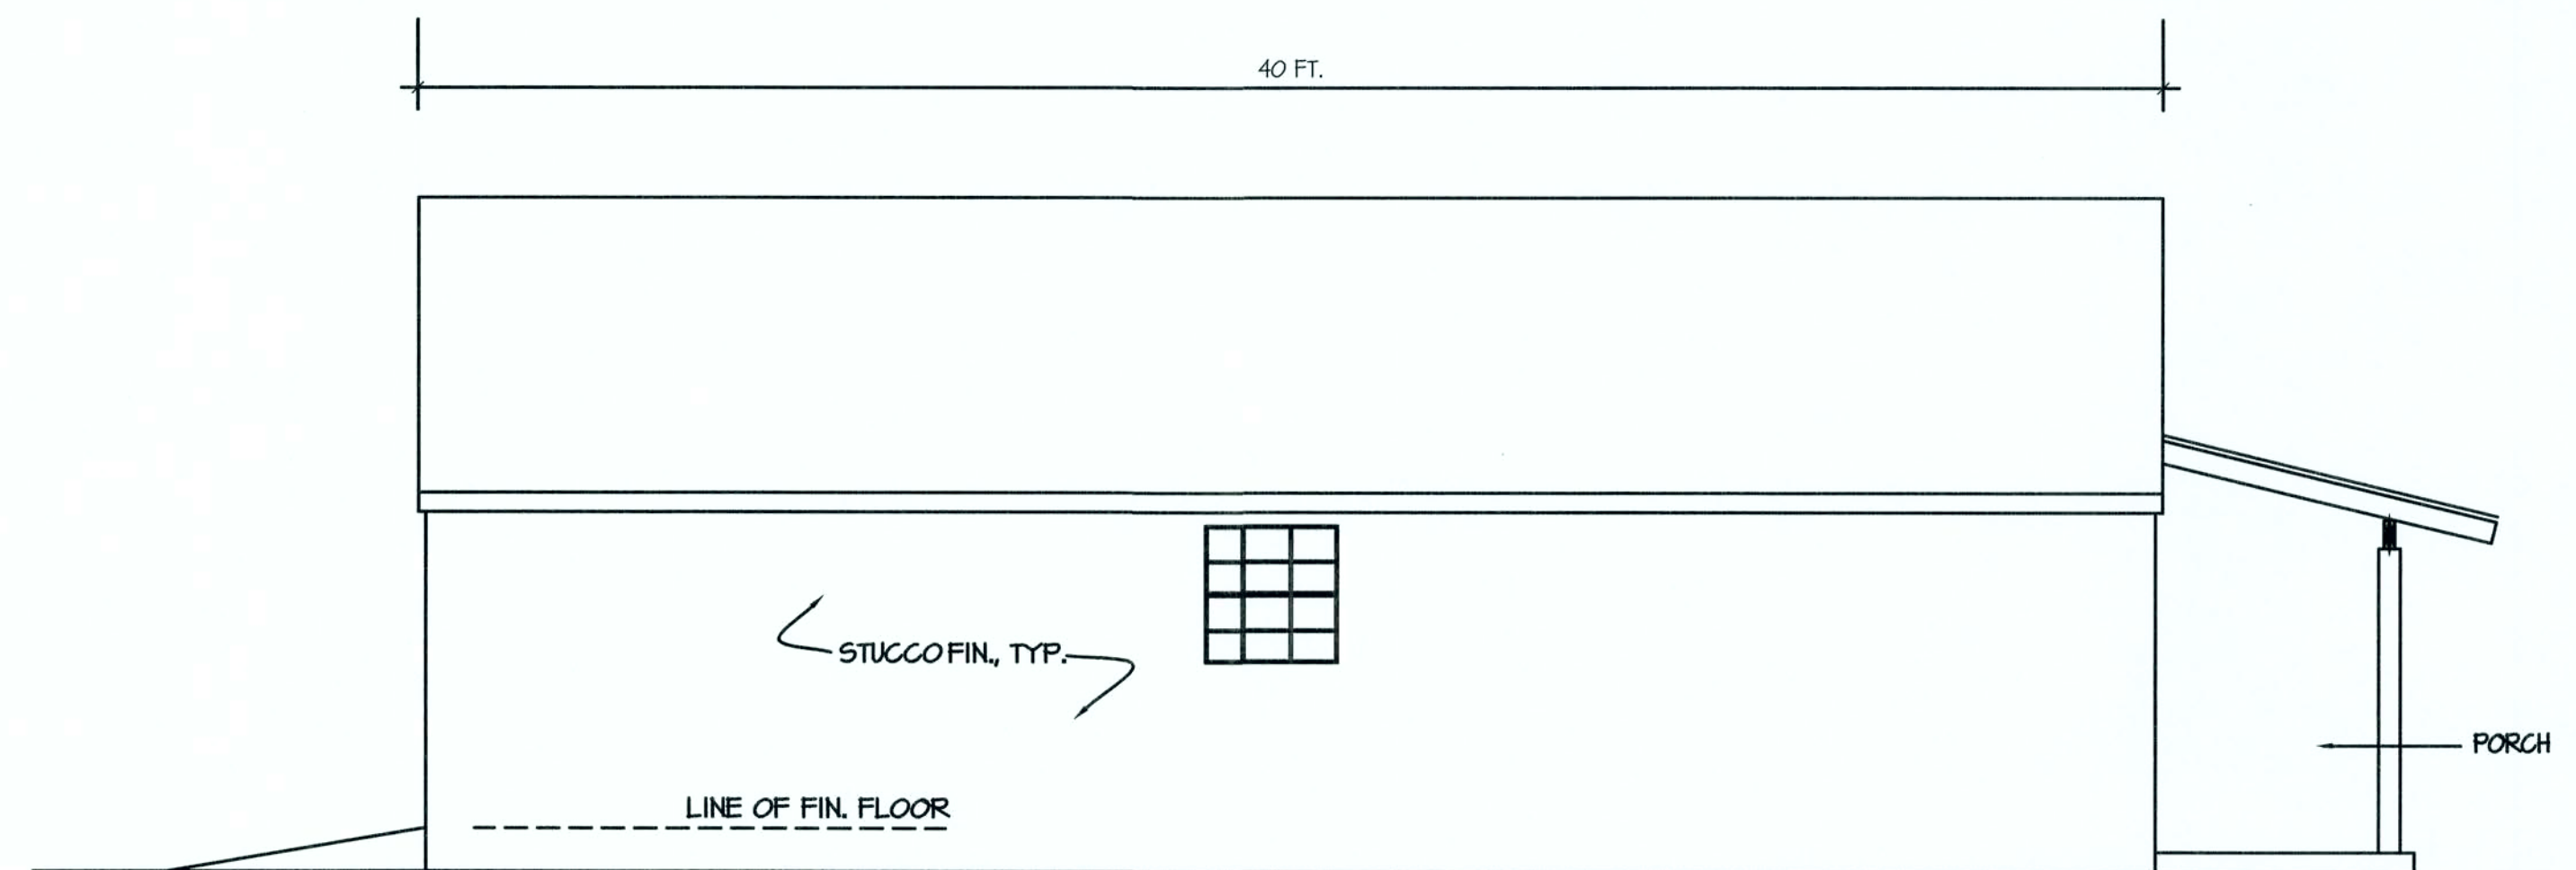


EXIST. EAST ELEVATION

SCALE: 1/4"=1'-0"

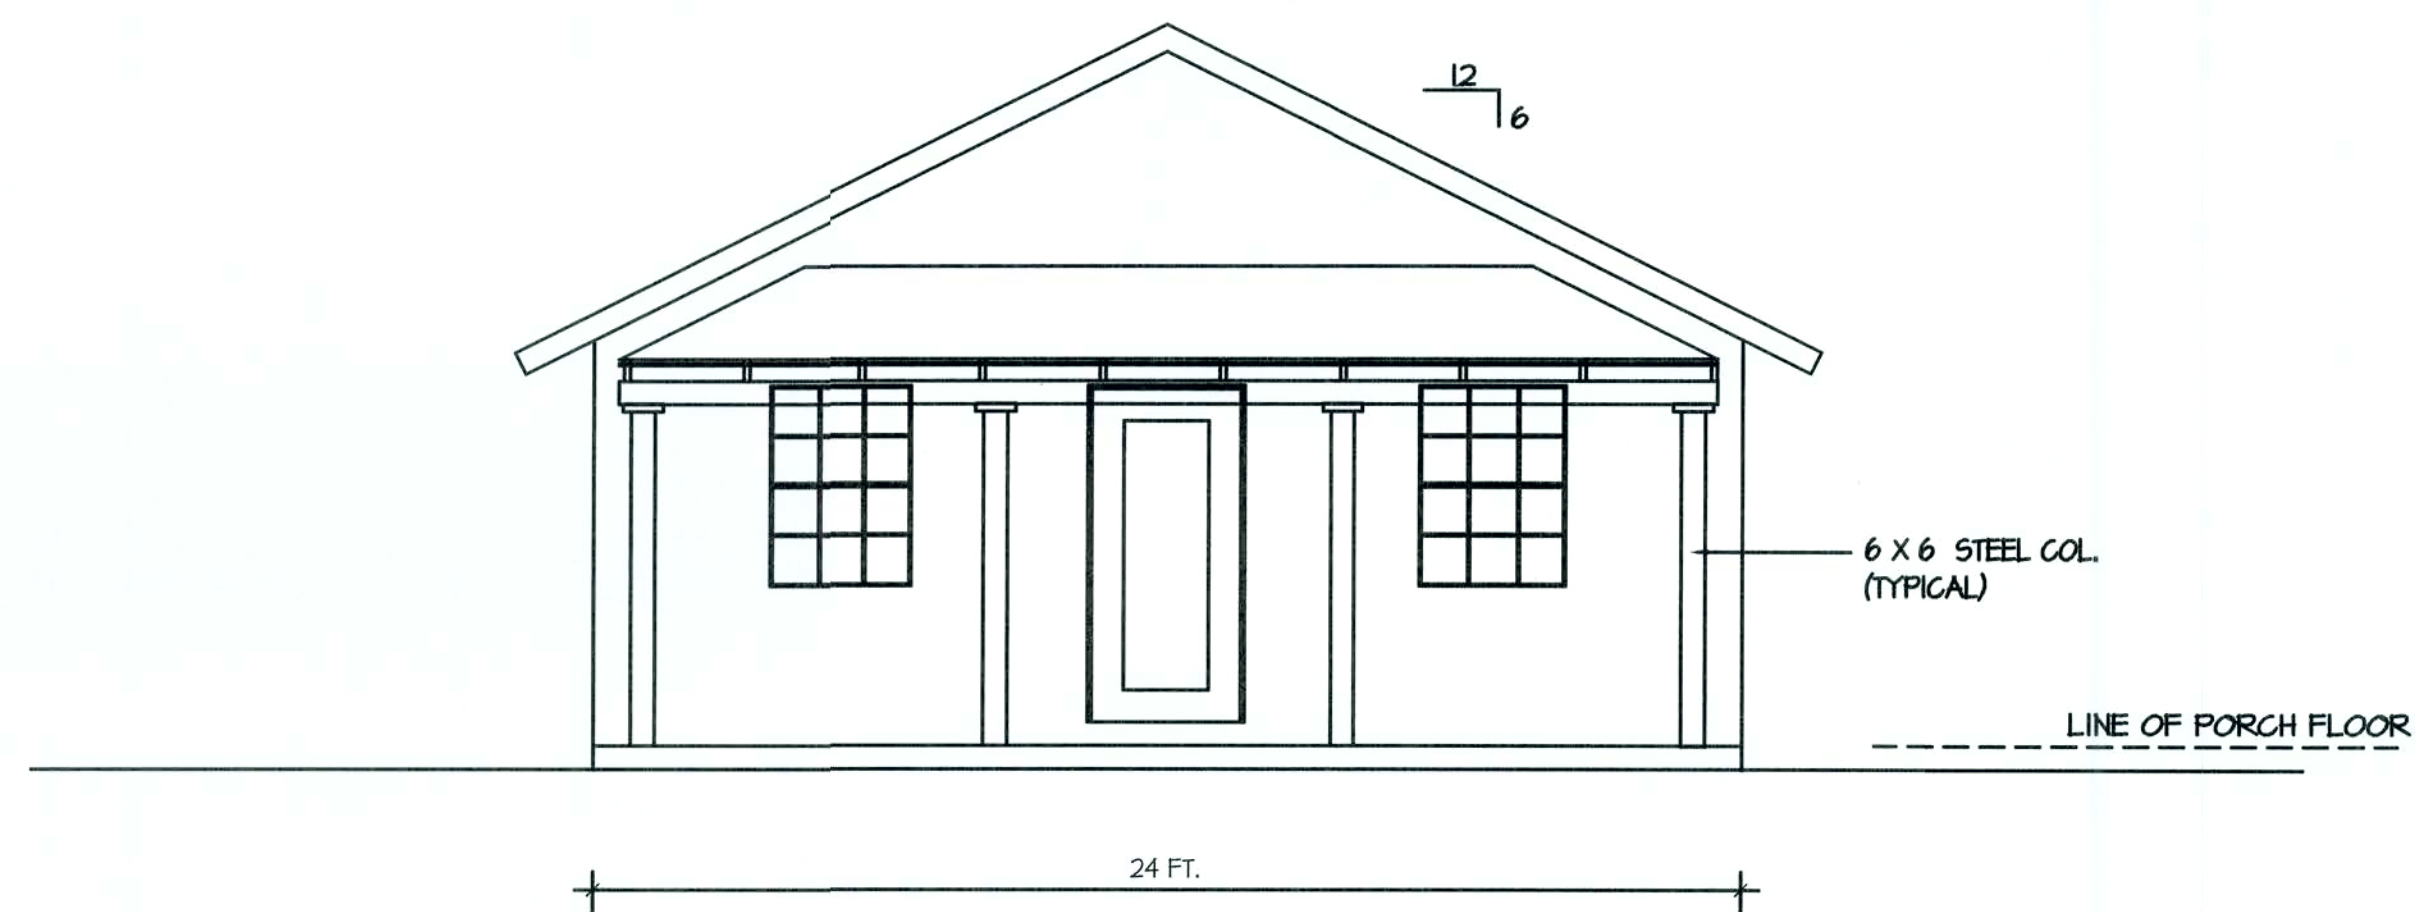

EXIST. NORTH ELEVATION

SCALE: 1/4"=1'-0"

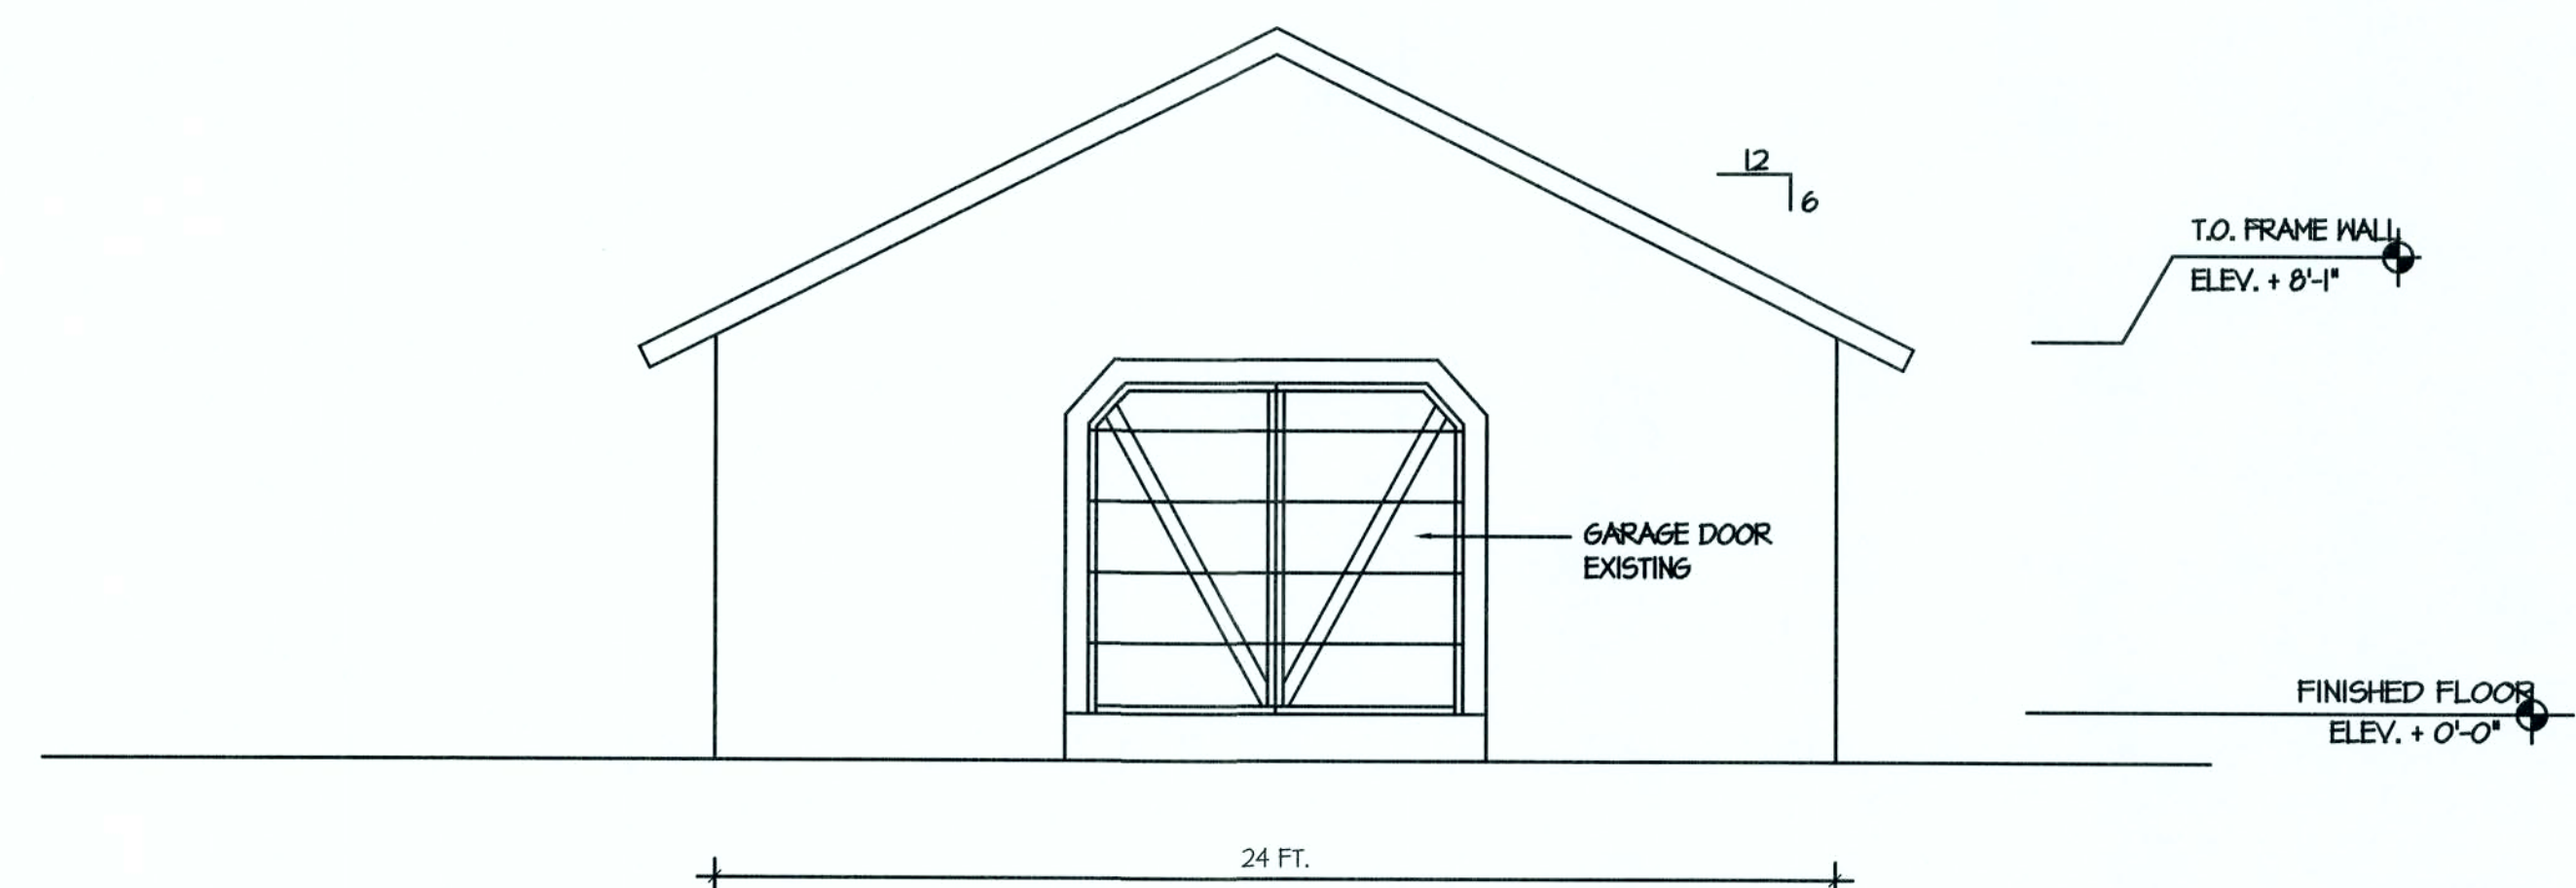

EXISTING SOUTH ELEVATION

SCALE: 1/4"=1'-0"


ENRIQUE RECIO TEL. 305 710 5114
355 SW HUNTER LEIGH PL.
COLUMBIA CTY. FLORIDA
PROPERTY ID 05-68-17-09607-201

SHEET NO.

2


OF 2

FILE COPY

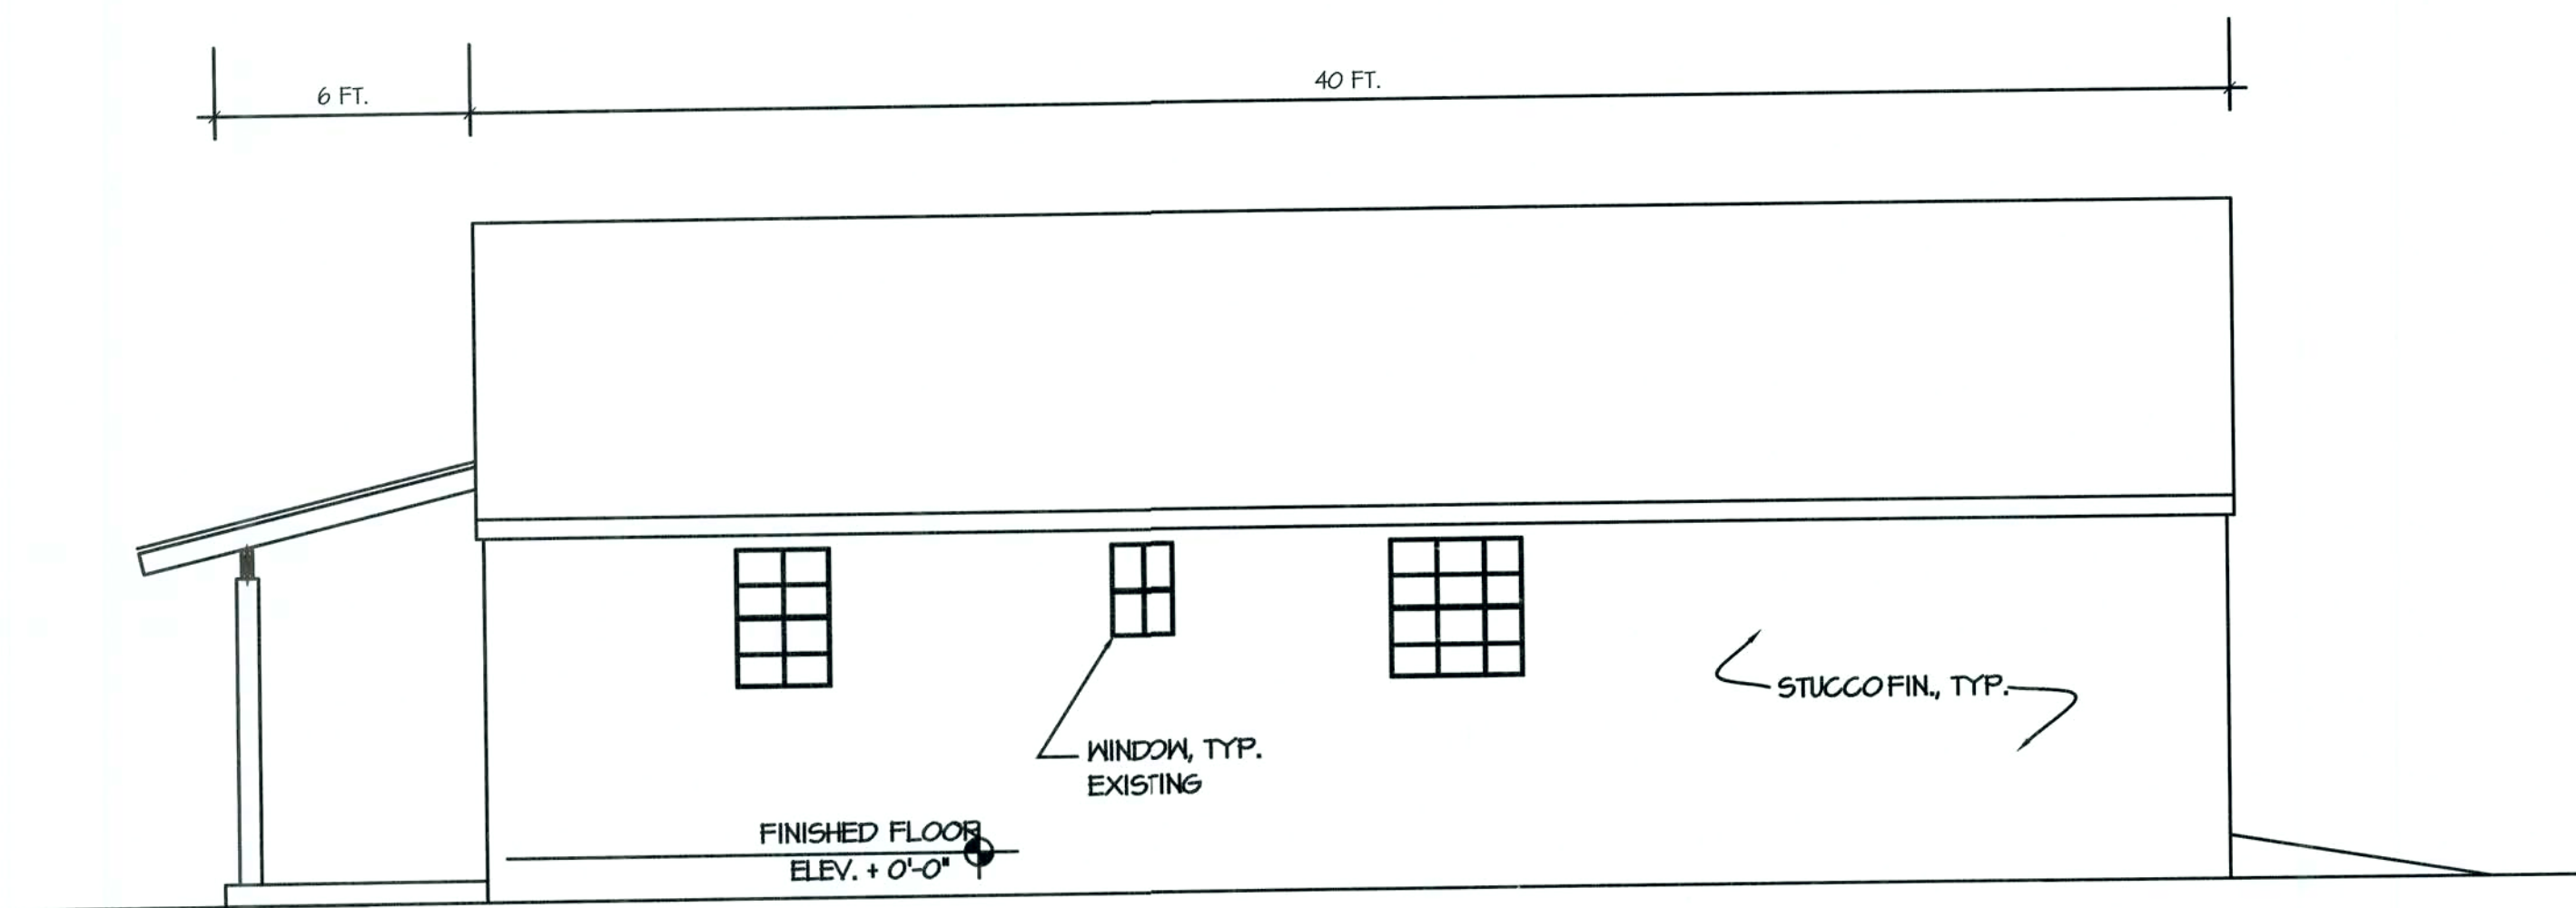


EXIST. WEST ELEVATION

SCALE: 1/4"=1'-0"

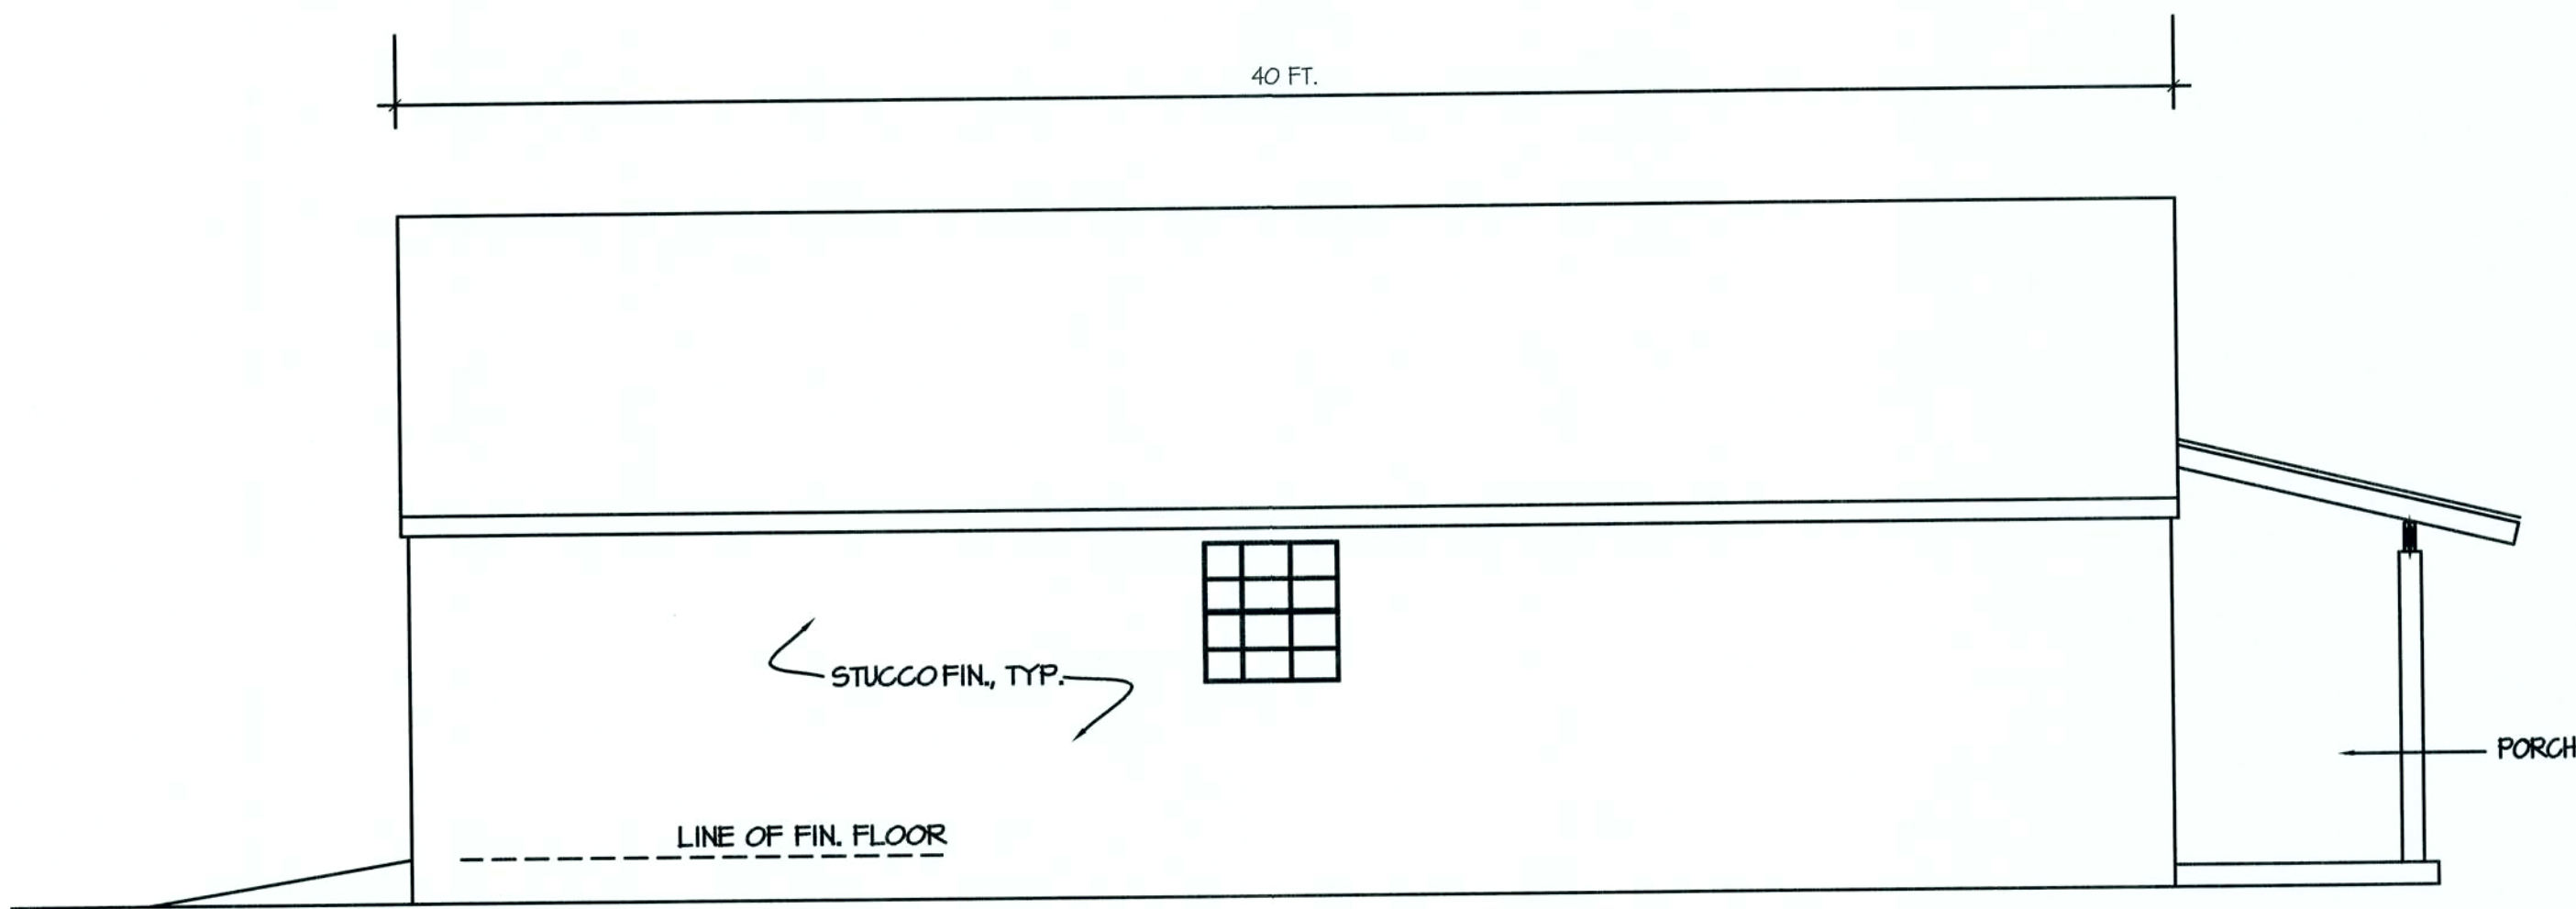


EXIST. EAST ELEVATION

SCALE: 1/4"=1'-0"

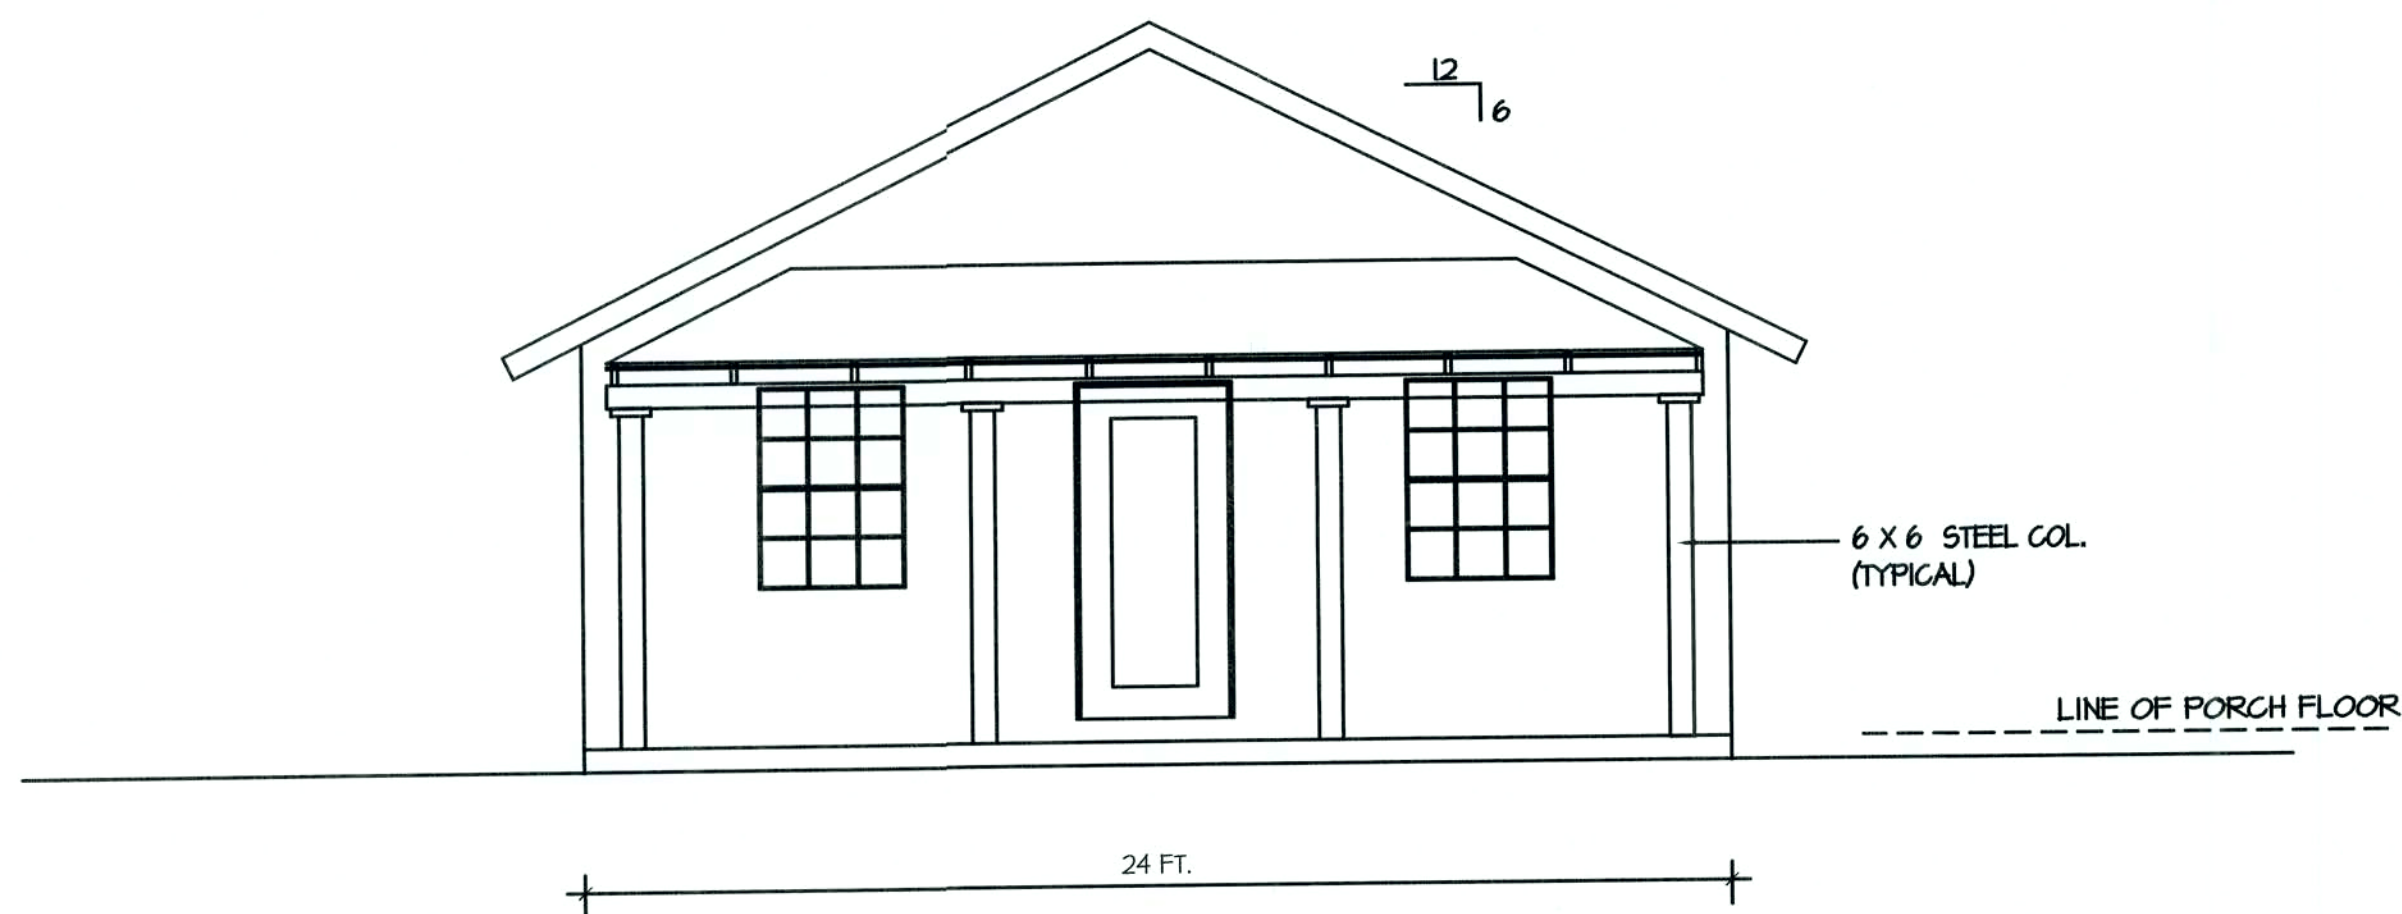

EXIST. NORTH ELEVATION

SCALE: 1/4"=1'-0"

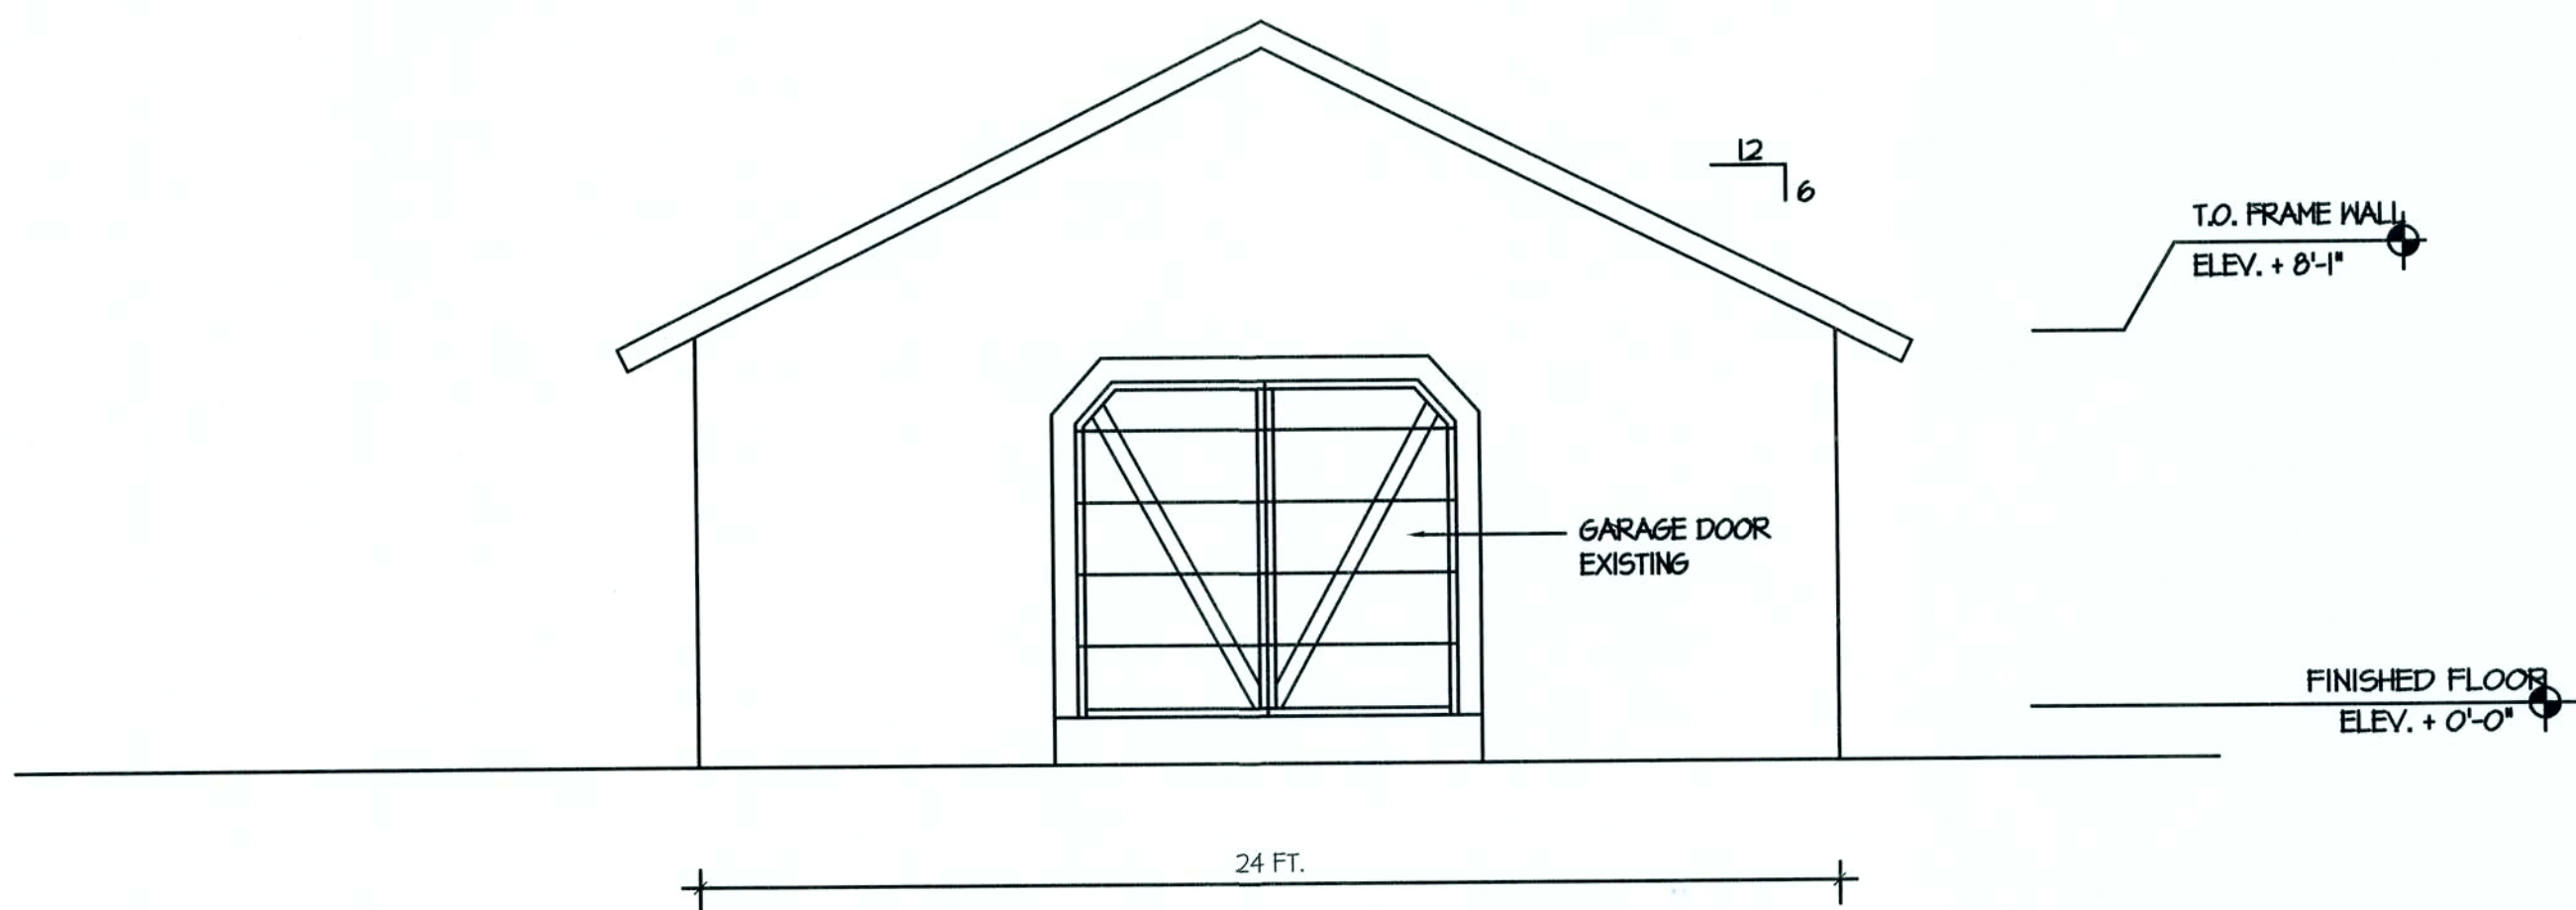

EXISTINGSOUTH ELEVATION

SCALE: 1/4"=1'-0"

ENRIQUE RECIO TEL. 305 710 5114
355 SW HUNTER LEIGH PL
COLUMBIA CTY. FLORIDA
PROPERTY ID 05-68-17-09607-201

SHEET NO.

2

OF 2

FILE COPY




SCALE: 1/4"=1'-0"




no scale



no scale

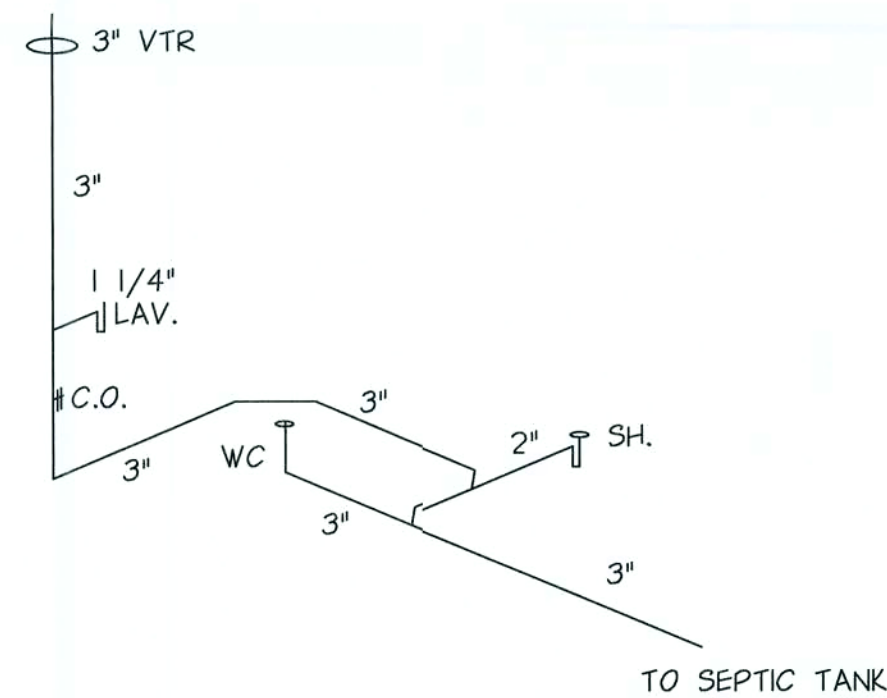

SANITARY ISOMETRIC

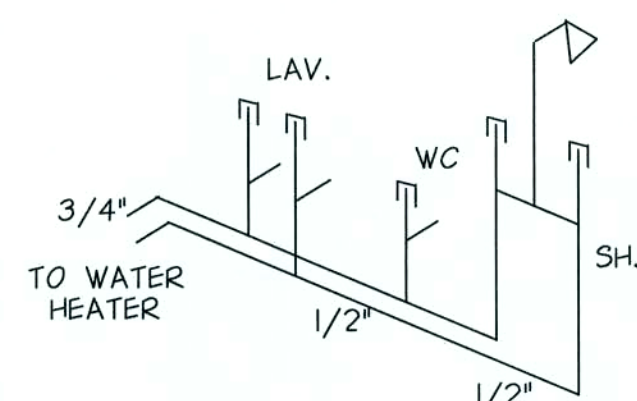

WATER ISOMETRIC



SITE PLAN

SCALE: 1" = 300 ft.



NO SCALE

LOCATION GARAGE WALL						120 240 1 V 3 W.					
MAIN MLO.						AIRC MOUNT 10K FLUSH					
A. 125 PANEL 'A'											
CKT	SERVICES	C.B.	P	K.V.A.	ROMEX	CKT	SERVICES	C.B.	P	K.V.A.	ROMEX
1	AHU (**)	25	2	5.4	# 10	3	CU (**)	20	2	2.5	# 12
3						4					
5	WASHER	20	1	1.5	# 12	6	RANGE	50	2	12.0	# 6
7	DRYER	30	2	5.0	# 10	8					
9						10	WATER HEATER	30	2	5.0	# 10
11	GARAGE DOOR	20	1	1.2	# 12	12					
13	BATH REC	20	1	(*)	# 12	14	REFRIGERATOR	20	1	1.4	# 12
15	GENERAL LTS.	20	1	(*)	# 12	16	SMALL APPLIANCES	20	1	1.5	# 12
17	GENERAL LTS.	20	1	(*)	# 12	18	SMALL APPLIANCES	20	1	1.5	# 12
19	GENERAL REGS.	20	1	(*)	# 12	20	GENERAL REGS.	20	1	(*)	# 12
21	GENERAL REGS.	20	1	(*)	# 12	22	GENERAL REGS.	20	1	(*)	# 12
23	30A RECEPT.	20	1	(*)	# 12	24	SPACE	-	-	-	-
25	SPACE	-	-	-	-	26	SPACE	-	-	-	-
27	SPACE	-	-	-	-	28	SPACE	-	-	-	-
29	SPACE	-	-	-	-	30	SPACE	-	-	-	-
31	SPACE	-	-	-	-	32	SPACE	-	-	-	-

LEGAL DESCRIPTION

IN COLUMBIA COUNTY, FLORIDA
COMM. AT NE COR OF NW 1/4 OF SEC. RUN WEST 183.17 FOR POB, CONT'W. 107.128 FT.
S. 582.02 FT. TO N. RW OF 60 FT. PRIVATE EASE, E. ALONG RW 1134.44 FT. N. 613.81 FT. TO POB FT.
AKA PARCEL 'A' MELISSA'S SECRET GARDEN UNR ORB 1045-1536. TP * 05-65-03607-210

ENRIQUE RECIO TEL. 305 710 5114
355 SW HUNTER LEIGH PL.
COLUMBIA CTY. FLORIDA
PROPERTY ID 05-6S-17-09607-201

SHEET NO.

1

OF 2