



FRONT ELEVATION
SCALE: 1/4" = 1'-0"



REAR ELEVATION
SCALE: 1/4" = 1'-0"

REVISIONS SCHEDULE			
PROPOSAL		June 20th, 2023	
REVISIONS		Aug. 29th, 2023	
REVERSED DRWG		Sept. 25th, 2023	

CUSTOM HOME FOR:

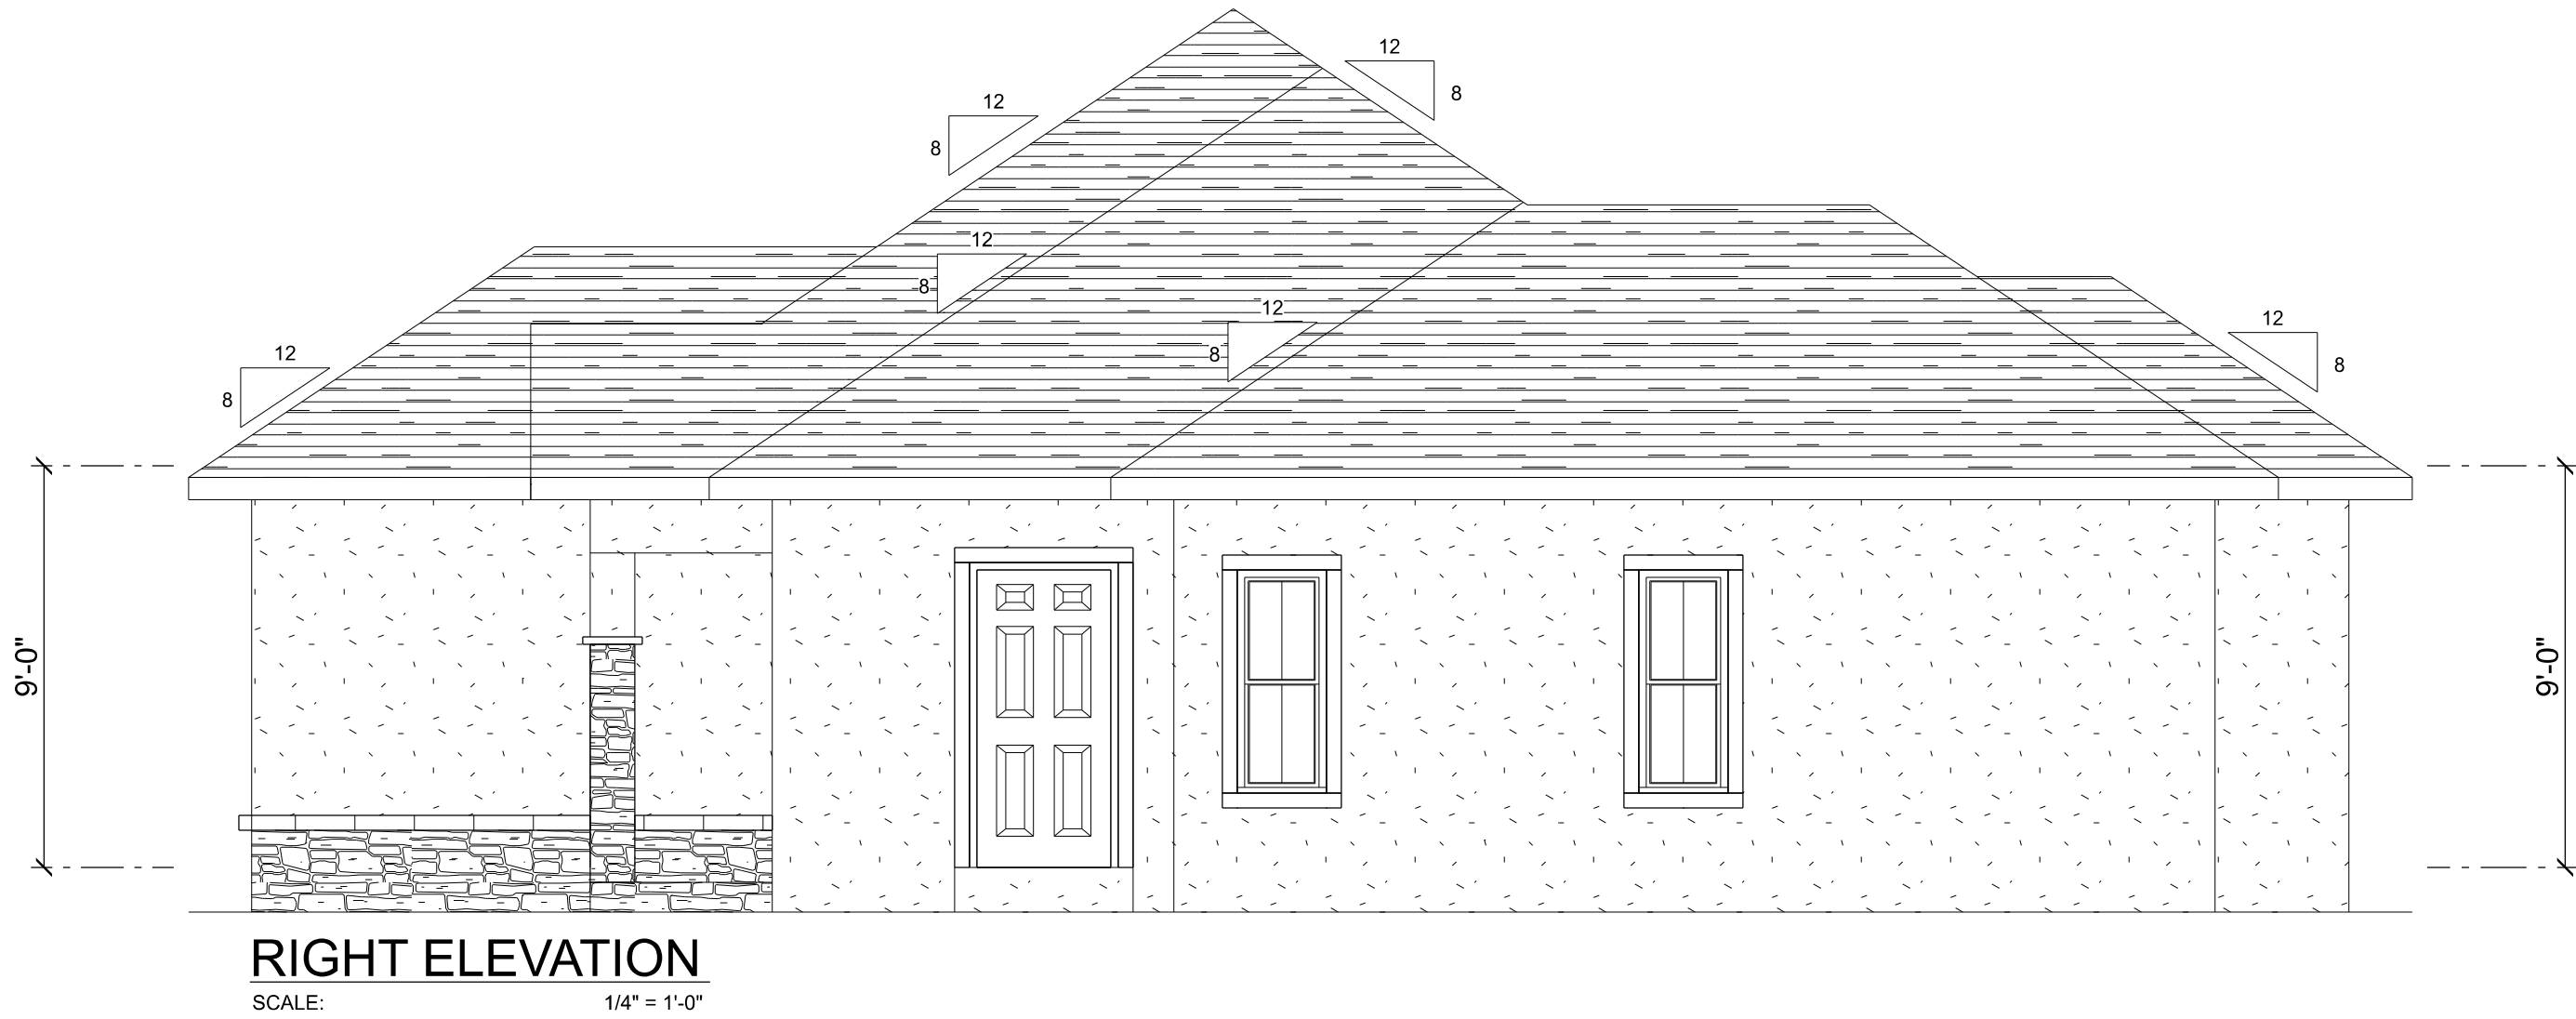
COPPOCK RESIDENCE

BRADFORD COUNTY, FL


RIDGEPOINT

DESIGN

566 SW ARLINGTON BLVD STE 101, LAKE CITY, FL 32025
P: 386-288-1188
E: RIDGEPOINTDESIGN@GMAIL.COM



RIGHT ELEVATION
SCALE: 1/4" = 1'-0"

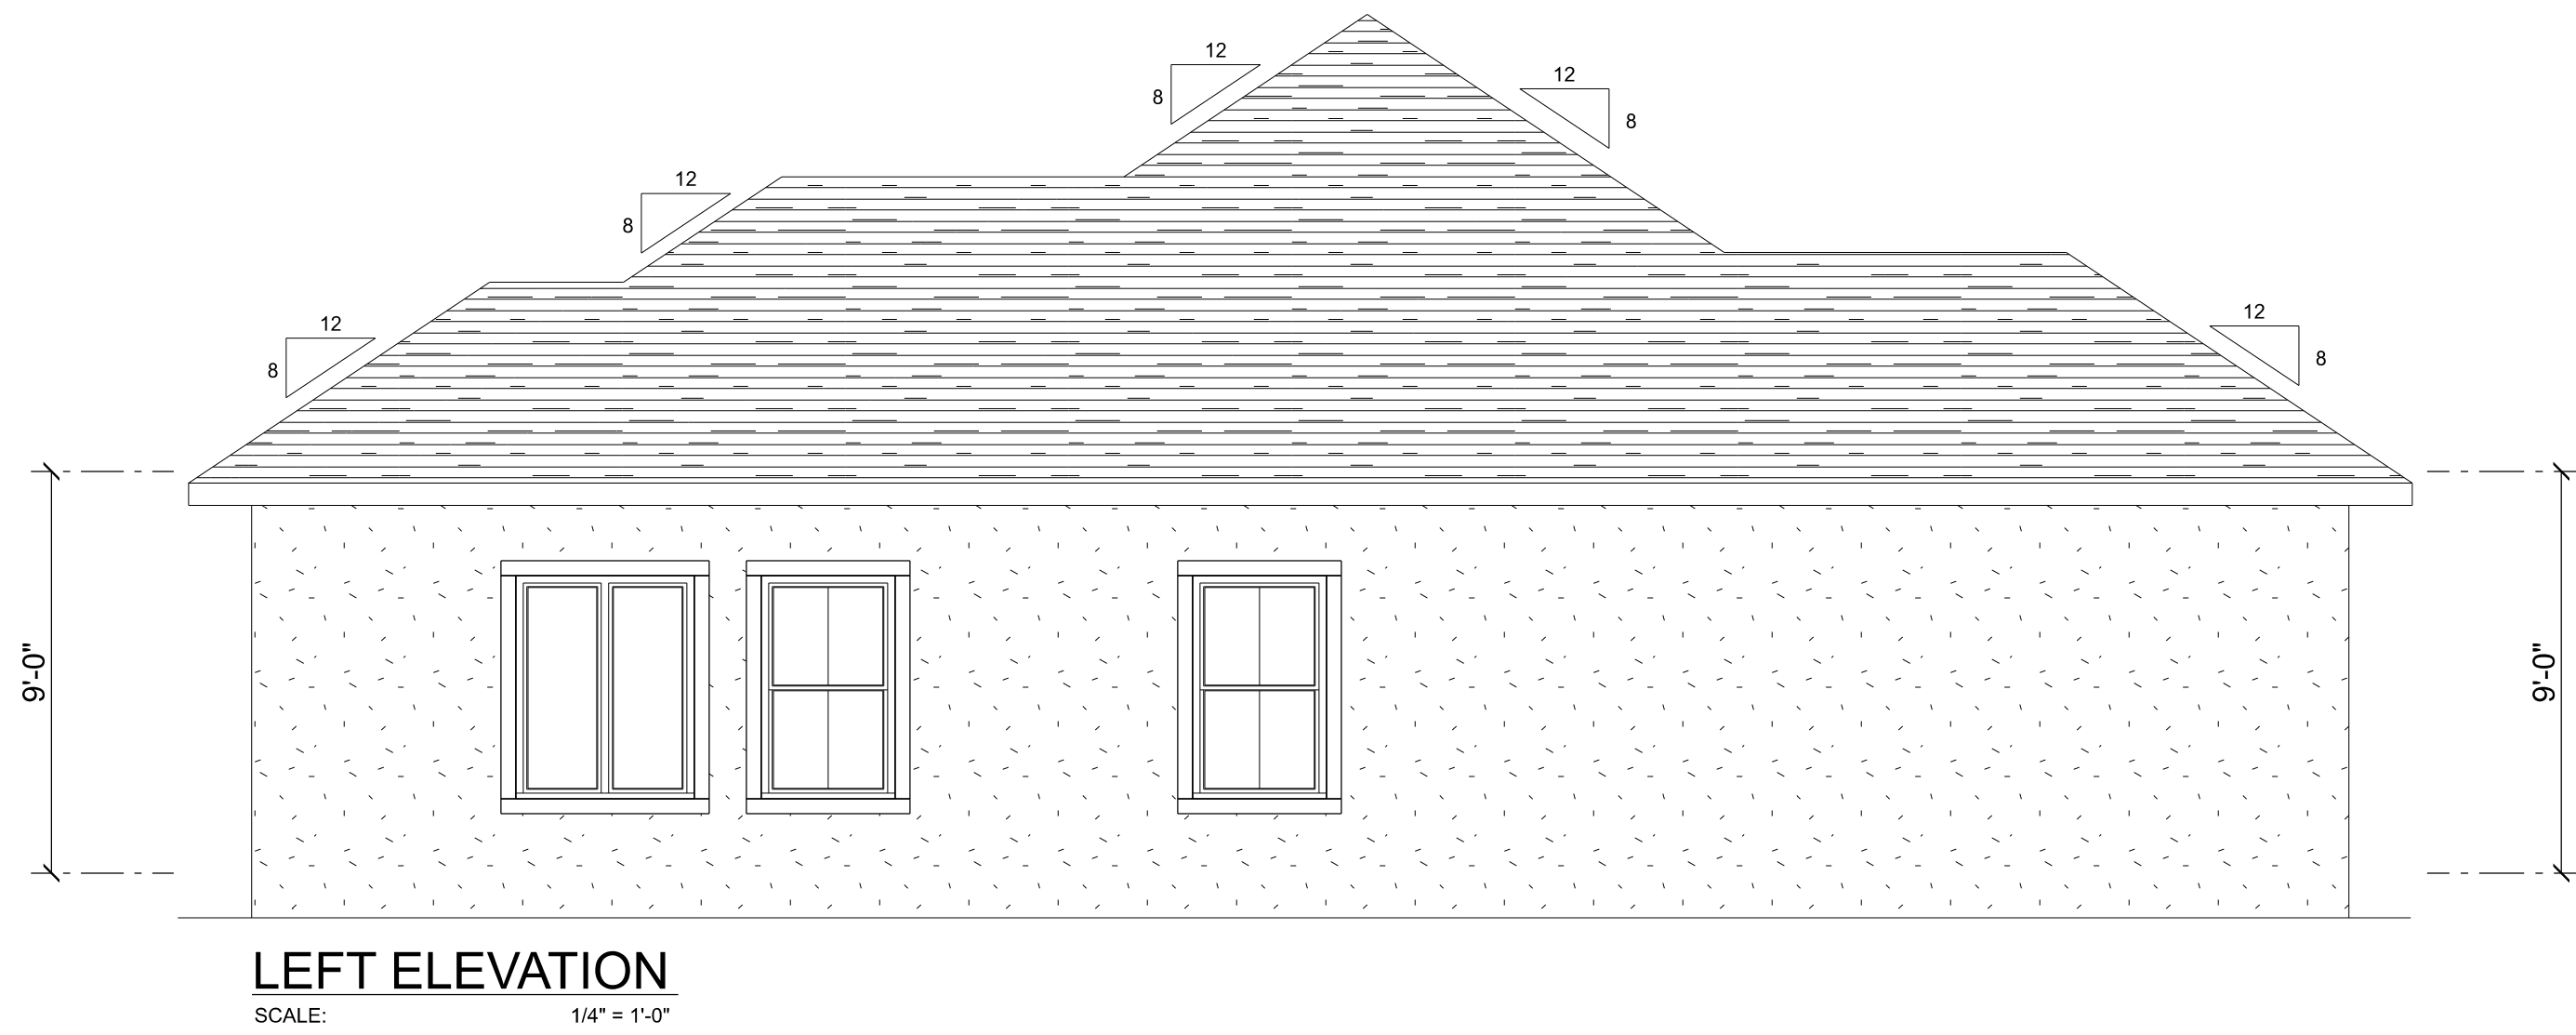


LEFT ELEVATION
SCALE: 1/4" = 1'-0"

REVISIONS SCHEDULE			
PROPOSAL		June 20th, 2023	
REVISIONS		Aug. 29th, 2023	
REVERSED DRWG		Sept. 25th, 2023	


CUSTOM HOME FOR:

COPPOCK RESIDENCE

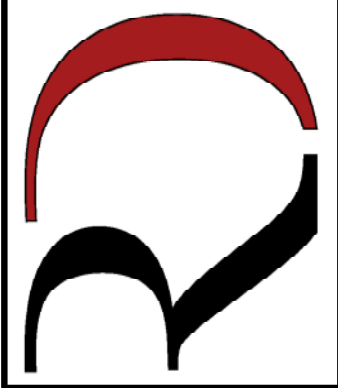
BRADFORD COUNTY, FL

 RIDGEPOINT
DESIGN

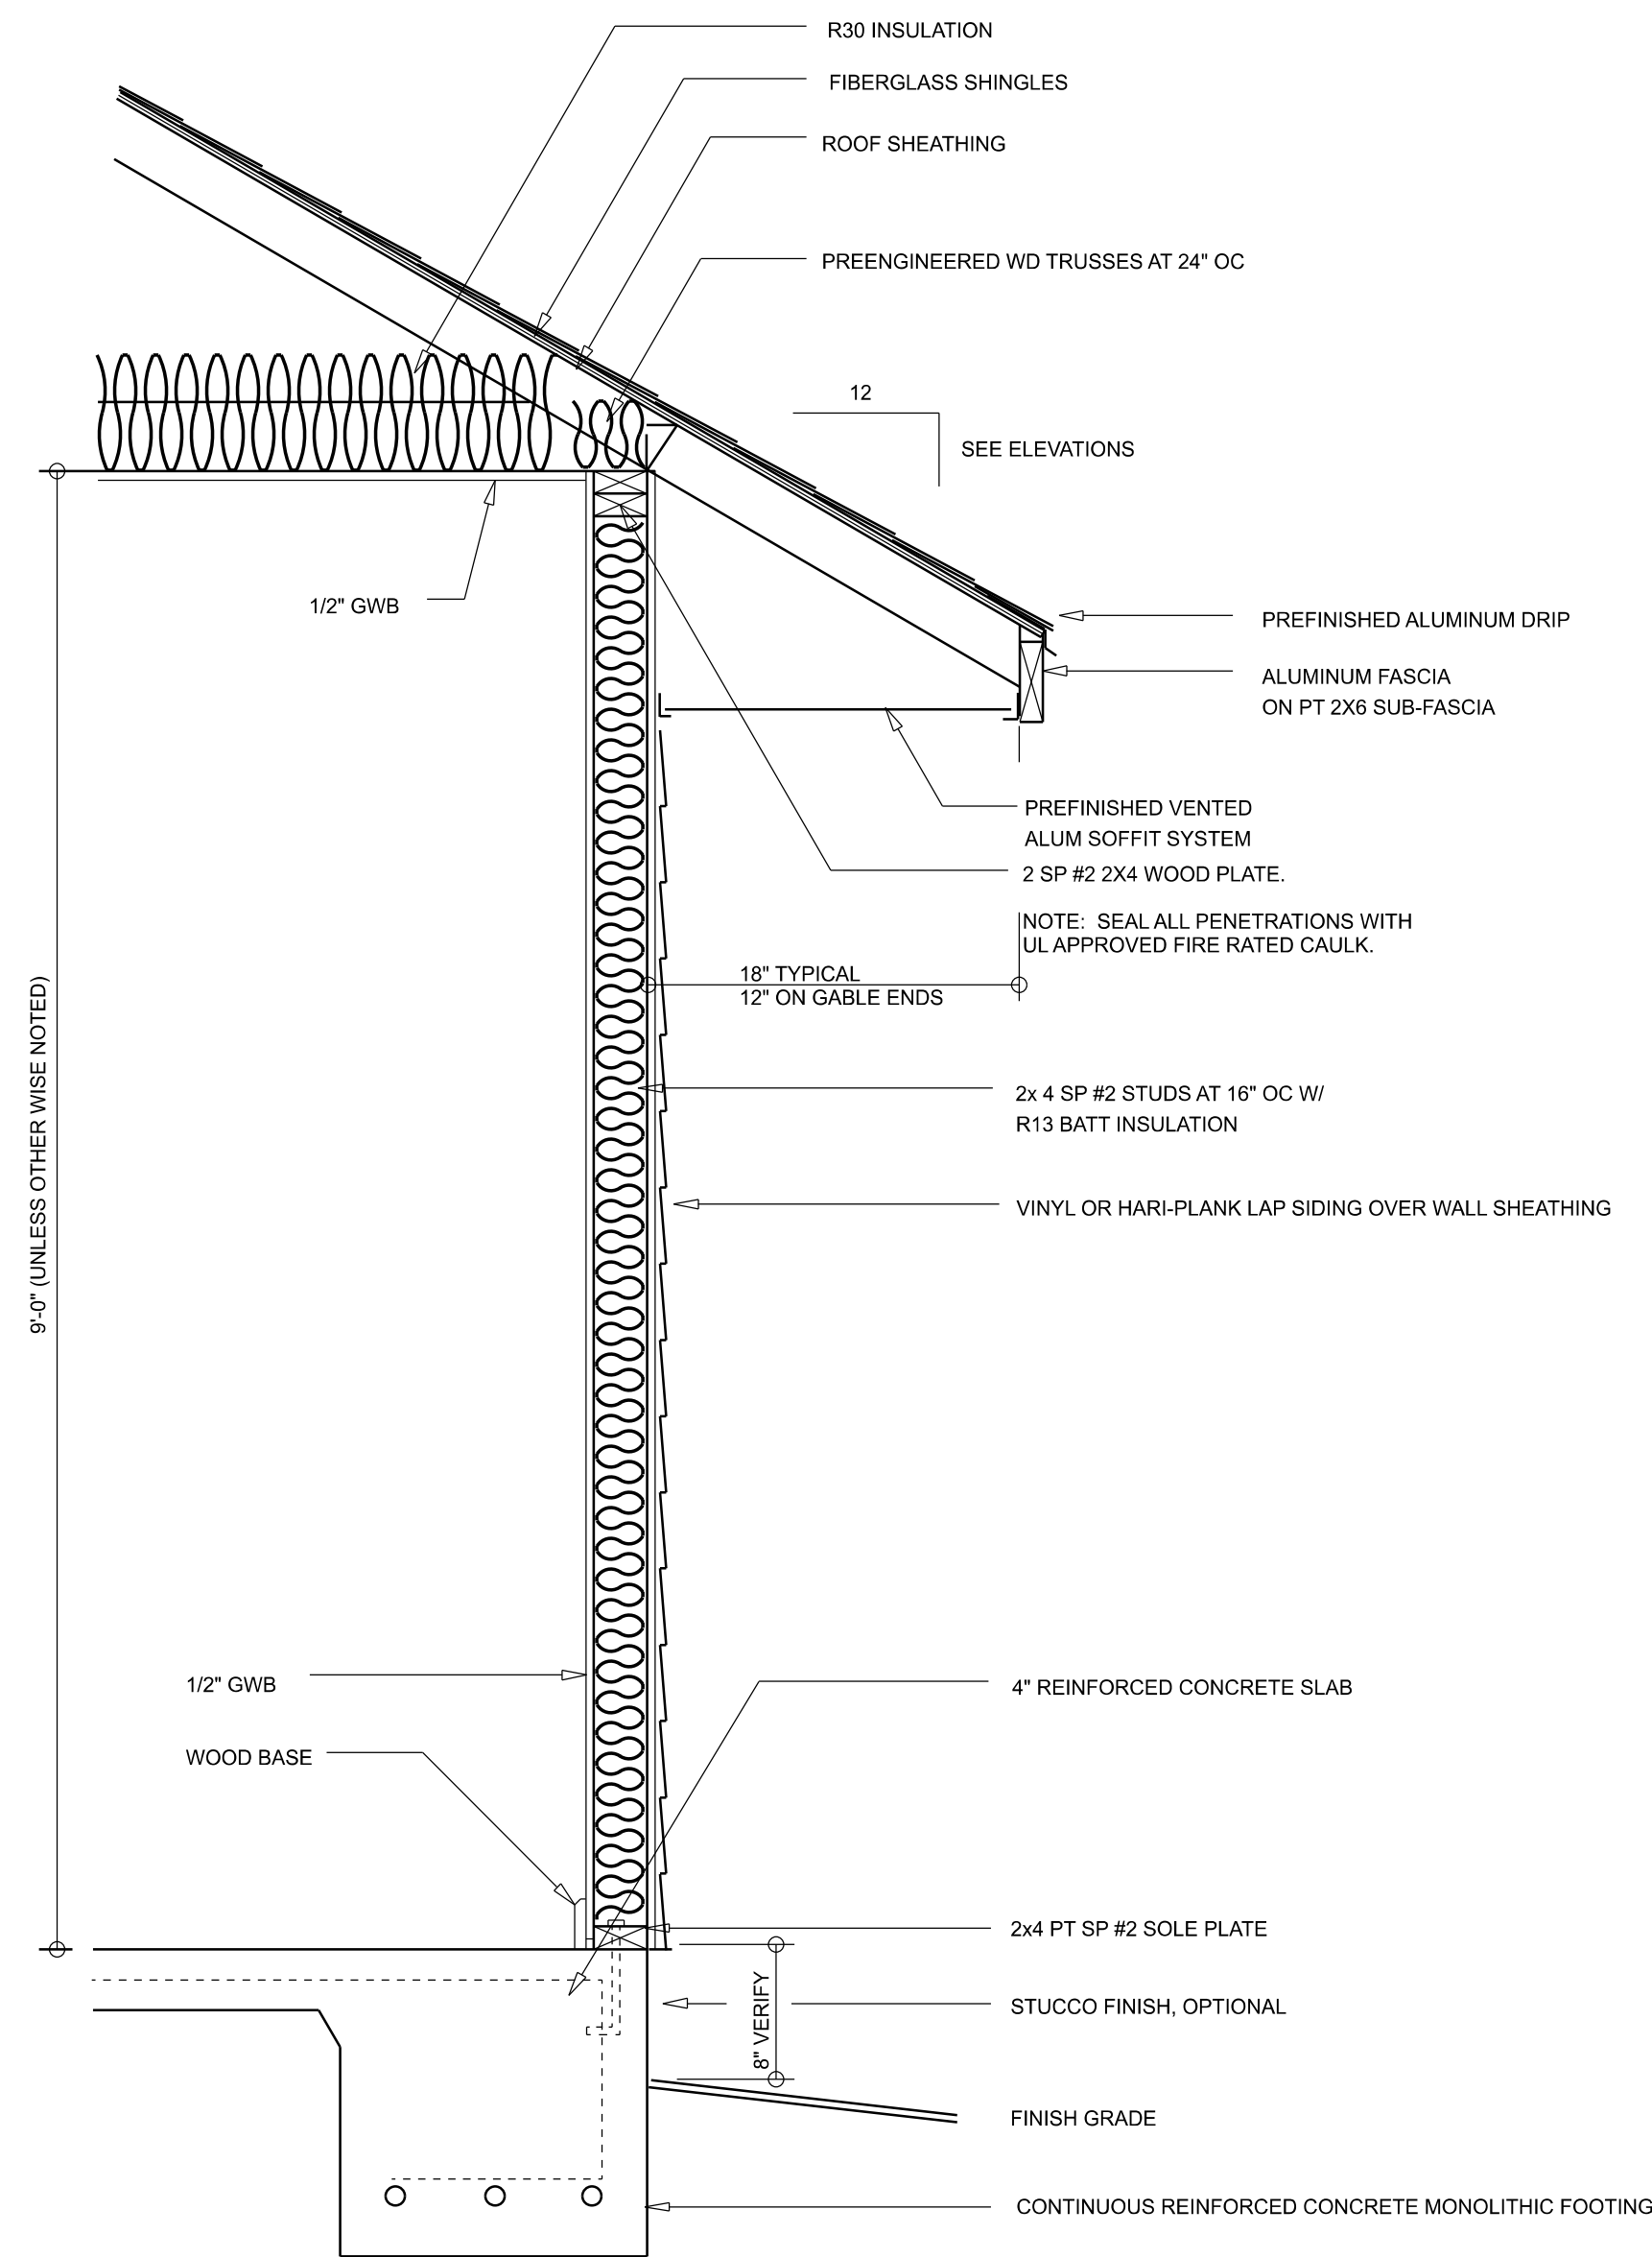566 SW ARLINGTON BLVD STE 101, LAKE CITY, FL 32025
P: 386-288-1188
E: RIDGEPOINTDESIGN@GMAIL.COM



TYPICAL WALL SECTION
SCALE: 1" = 1'-0"

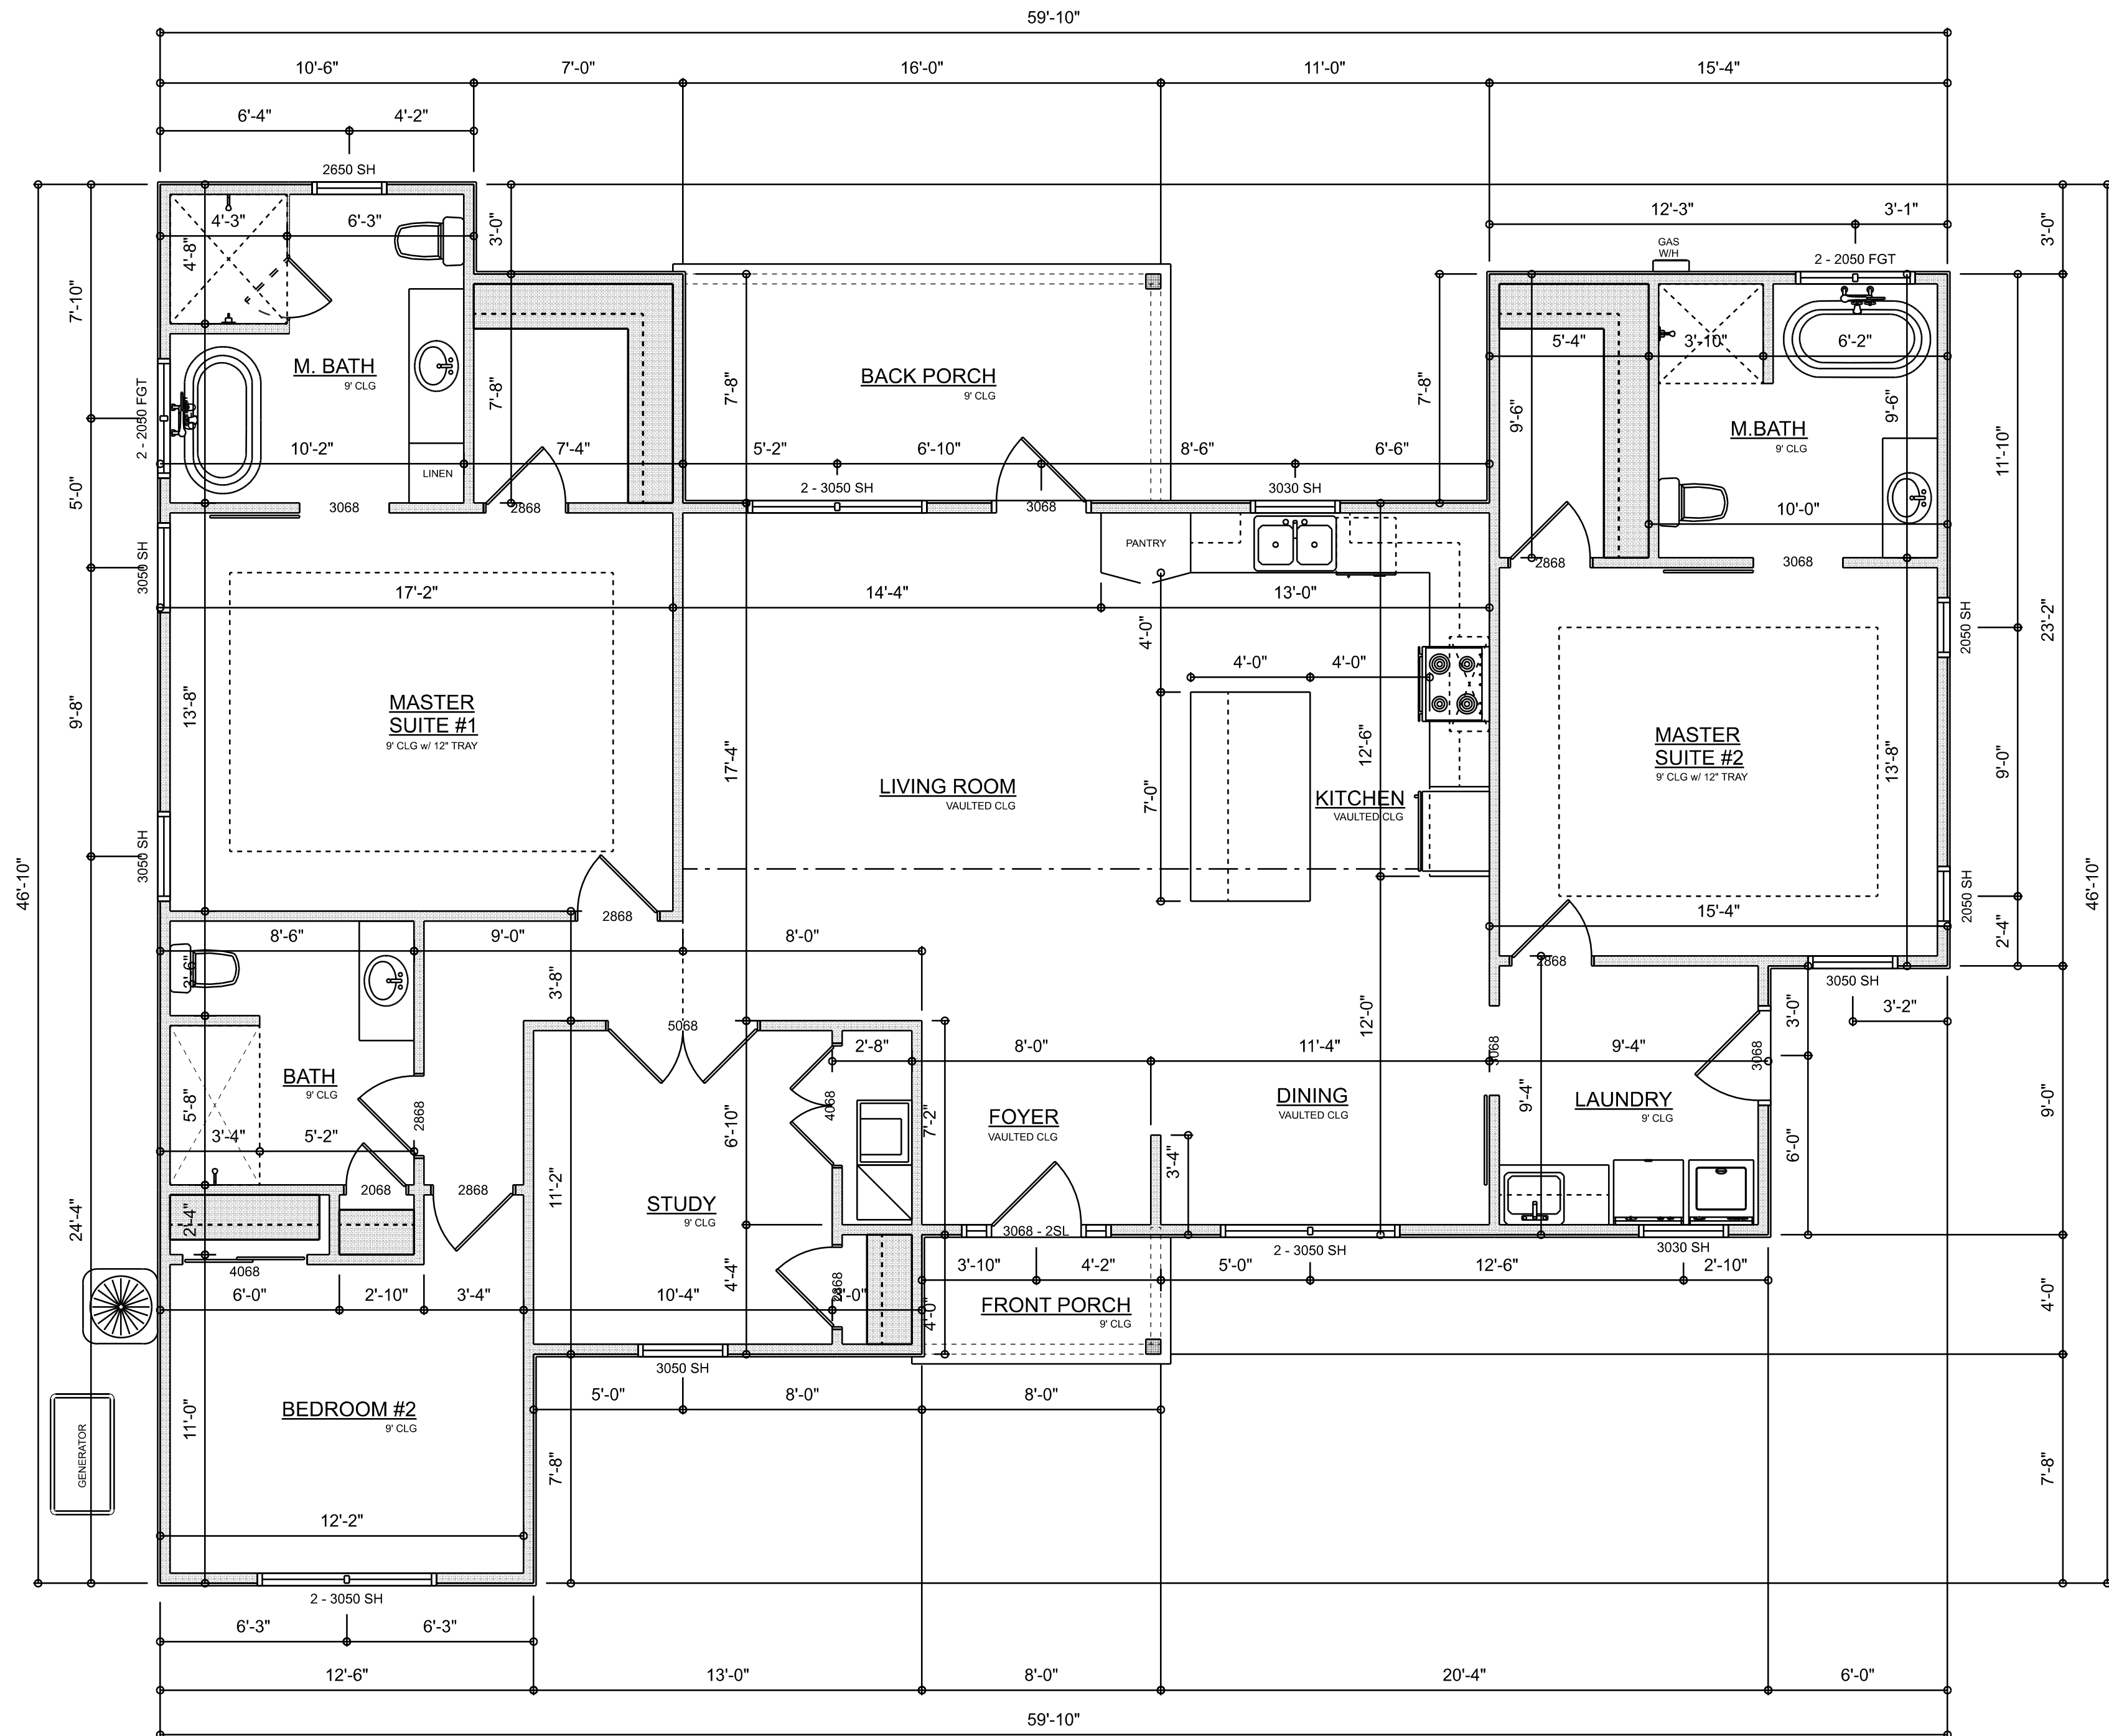










DIMENSIONED FLOOR PLAN
SCALE: 1/4" = 1'-0"

AREA SUMMARY		
LIVING	1,893	S.F.
BACK PORCH	123	S.F.
ENTRY PORCH	34	S.F.
TOTAL AREA	2,050	S.F.

REVISIONS SCHEDULE			
PROPOSAL	June 20th, 2023		
REVISIONS	Aug. 29th, 2023		
REVERSED DRWG	Sept. 25th, 2023		

CUSTOM HOME FOR:
COPPOCK RESIDENCE
BRADFORD COUNTY, FL

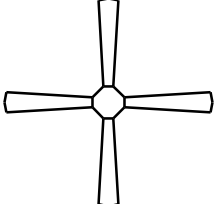        RIDGEPOINT DESIGN
566 SW ARLINGTON BLVD STE 101, LAKE CITY, FL 32025
P: 386-288-1188
E: RIDGEPOINTDESIGN@GMAIL.COM

ELECTRICAL LEGEND		
ELECTRICAL	COUNT	SYMBOL
CEILING FAN	6	
CAN LIGHT 6inch	25	
CHANDELIER	1	
LED CEILING LIGHT 1x4	1	
PENDANT LIGHT	3	
EXTERIOR SCONCE	2	
MOTION SECURITY LIGHT	4	
AC DISCONNECT	2	
CARBON DETECTOR	2	
EXHAUST FAN	3	
OUTLET	30	
OUTLET 220v	2	
OUTLET GFI	10	
OUTLET WP	4	
SMOKE DETECTOR	7	
STANDARD LIGHT	3	
SWITCH	32	
SWITCH 3 WAY	17	
VANITY BAR LIGHT - SMALL	3	
CABLE TV OUTLET	5	

ELECTRICAL PLAN NOTES:

INSTALLATION SHALL BE PER LATEST NAT'L ELECTRIC CODE.

WIRE ALL APPLIANCES, HVAC UNITS AND OTHER EQUIPMENT PER MANUF. SPECIFICATIONS

CONSULT WITH THE OWNER FOR THE NUMBER OF SEPERATE TELEPHONE LINES TO BE INSTALLED

ALL SMOKE DETECTORS SHALL BE 120v W/ BATTERY BACKUP OF THE PHOTOELECTRIC TYPE, AND SHALL BE INTERLOCKED TOGETHER. INSTALL INSIDE AND NEAR ALL BEDROOMS

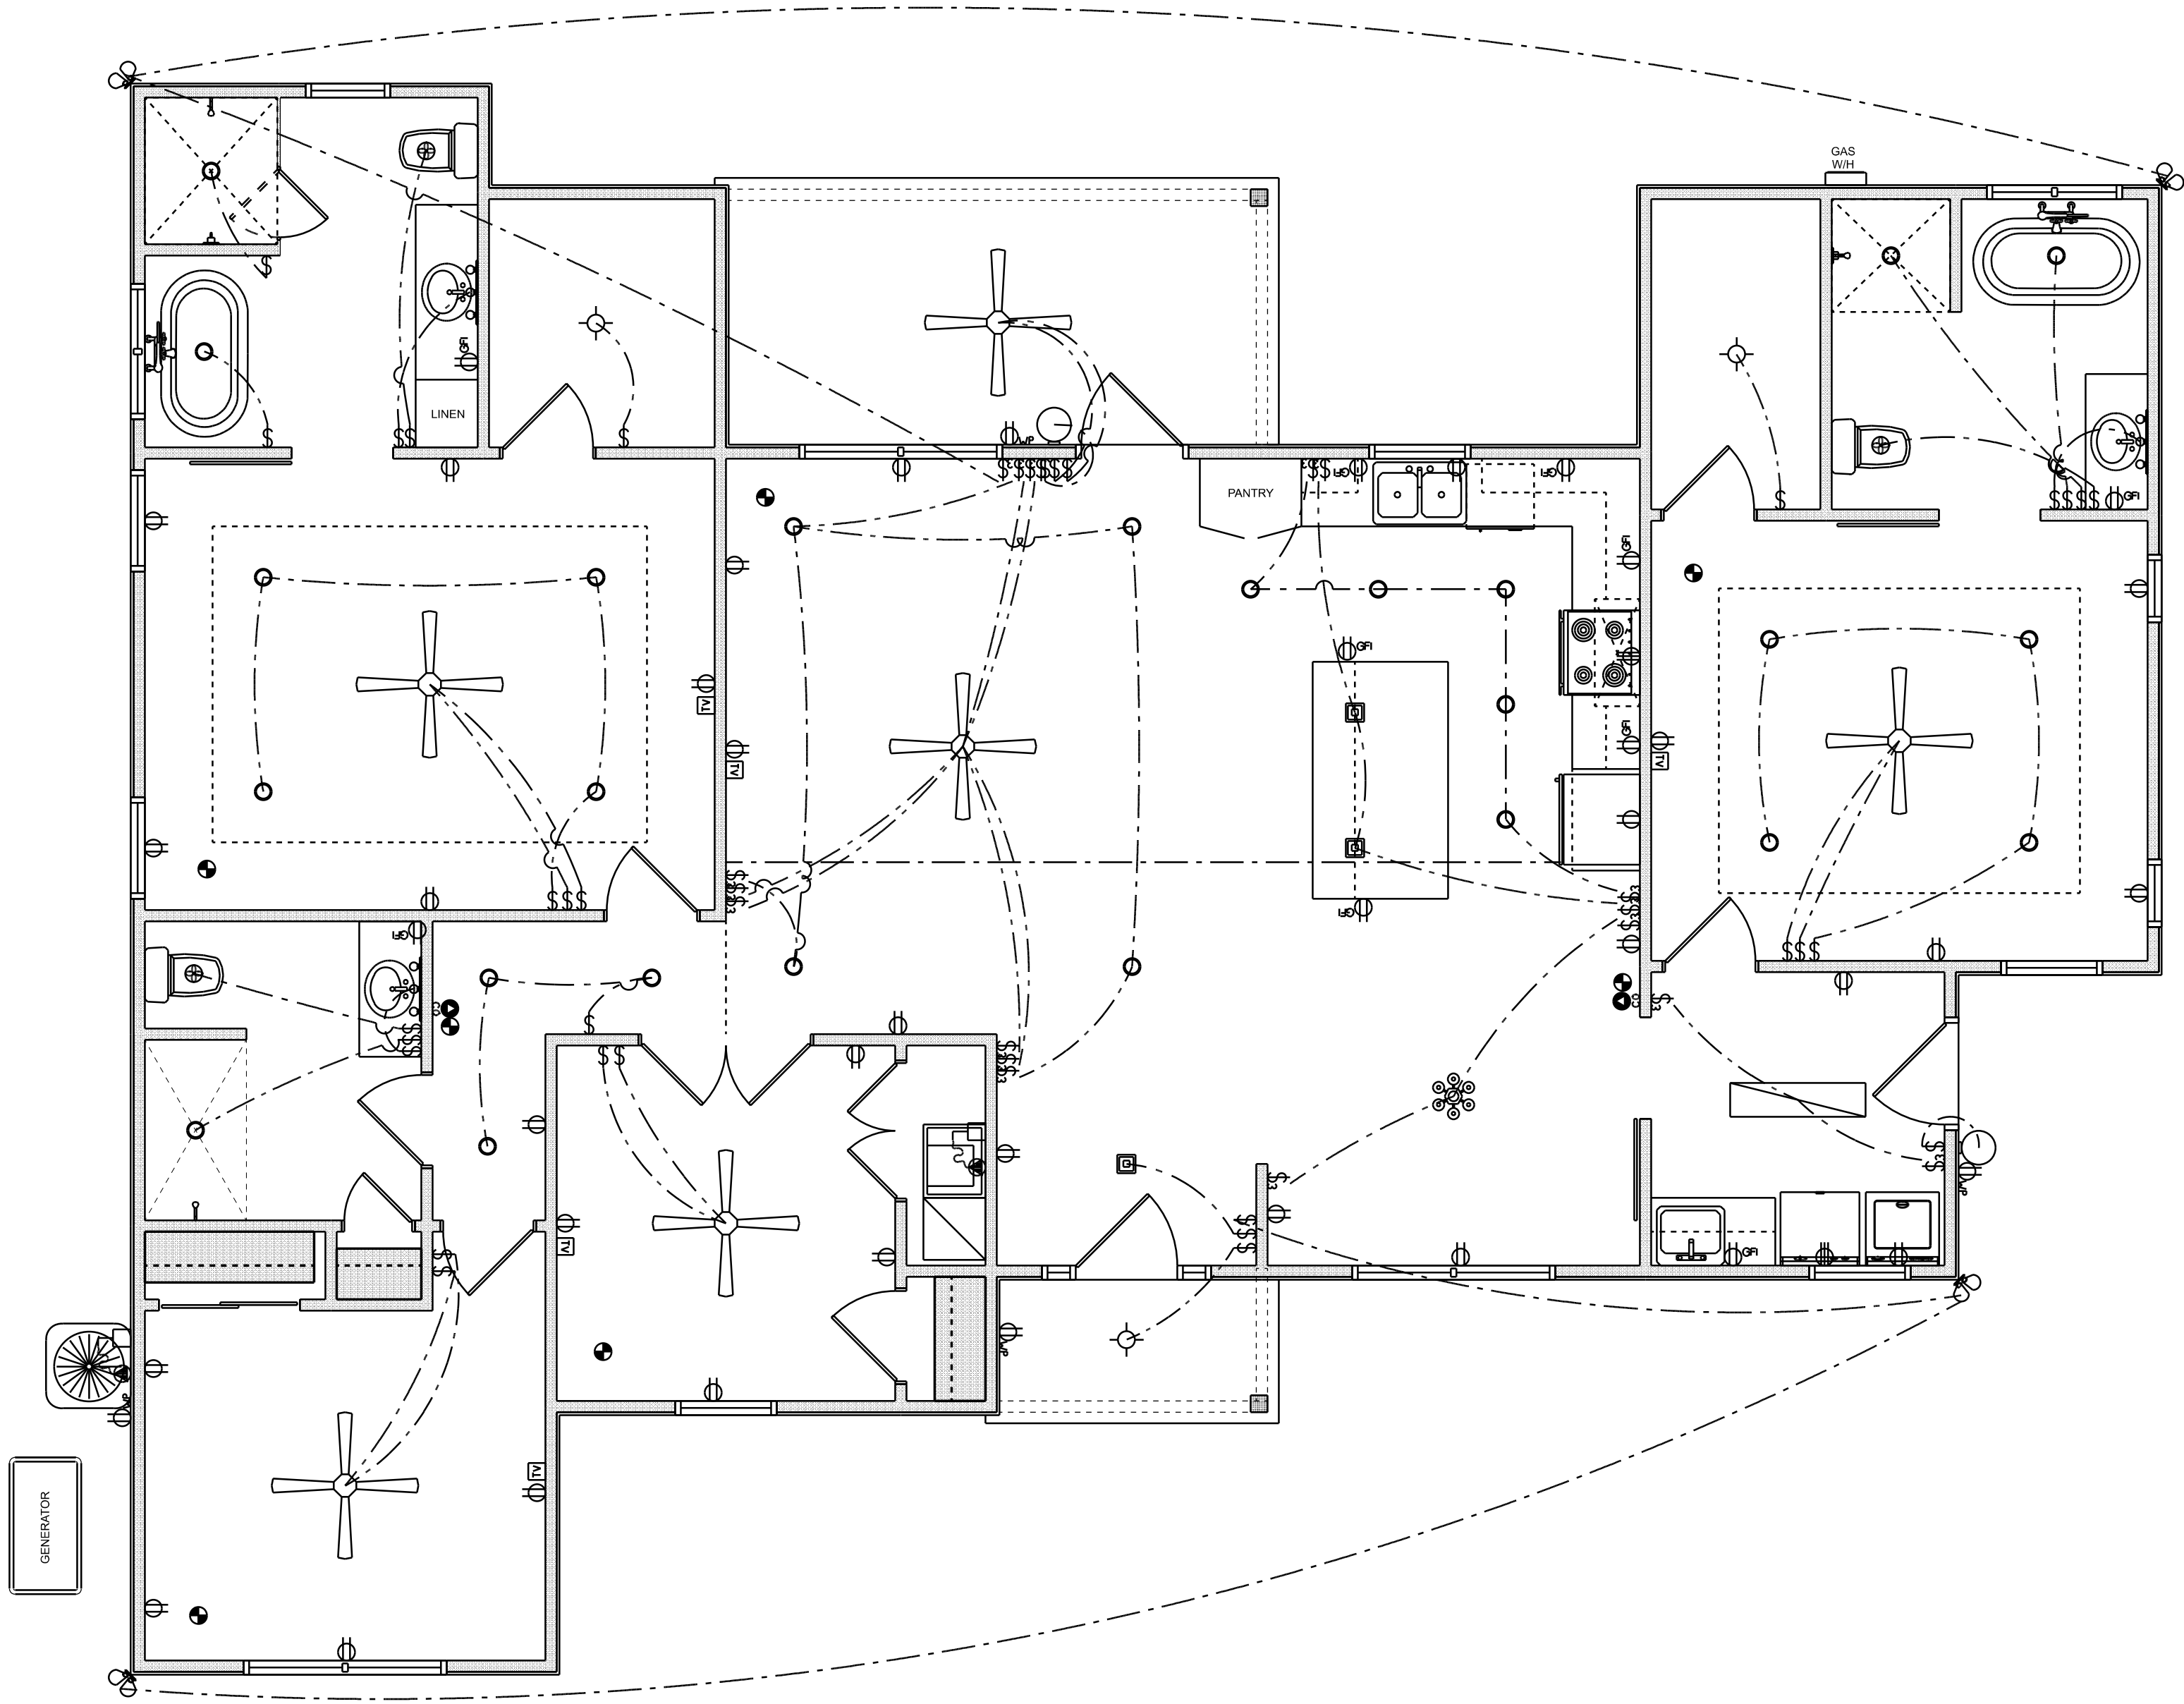
TELEPHONE, TELEVISION AND OTHER LOW VOLTAGE DEVICES OR OUTLETS SHALL BE AS PER THE OWNER'S DIRECTIONS, & IN ACCORDANCE W/ APPLICABLE SECTIONS OF NEC-LATEST EDITION.

ALL RECEPTICALS, NOT OTHERWISE NOTED, SHALL BE ARC FAULT INTERRUPTER TYPE, EXCEPT DEDICATED OUTLETS

ALL RECEPTICALS IN WET AREAS SHALL BE GROUND FAULT INTERRUPTER TYPE (GFI)

ALL EXTERIOR RECEPTICALS SHALL BE WEATHERPROOF GROUD FAULT INTERRUPTER TYPE (WP/GFI)


NOTE:
ELECTRICAL CONTR SHALL PREPARE "AS-BUILT" SHOP DWGS INDICATING ALL ELECTRICAL WORK, INCLUDING ANY CHANGES TO THE ELEC. PLAN, ADD'NS TO THE ELEC. PLAN, RISER DIAGRAM, AS-BUILT PANEL SCHEDULE W/ ALL CKTS IDENTIFIED W/ CKT N°. DESCRIPTION & BRKR, SERVICE ENT. & ALL UNDERGROUND WIRE LOCATIONS/ROUTING / DEPTH. RISER DIA. SHALL INCLUDE WIRE SIZES/TYPE & EQUIPMENT TYPE W/ RATINGS & LOADS.
CONTRACTOR SHALL PROVIDE 1 COPY OF AS-BUILT DWGS TO OWNER & 1 COPY TO THE PERMIT ISSUING AUTHORITY



ELECTRICAL PLAN
SCALE: 1/4" = 1'-0"

REVISIONS SCHEDULE			
PROPOSAL	June 20th, 2023		
REVISIONS	Aug. 29th, 2023		
REVERSED DRWG	Sept. 25th, 2023		

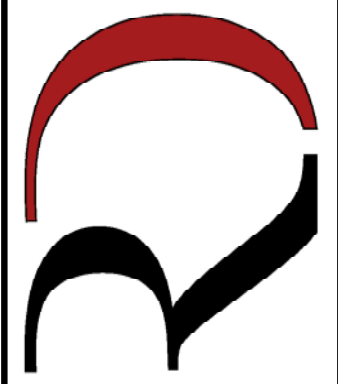CUSTOM HOME FOR:
COPPOCK RESIDENCE
BRADFORD COUNTY, FL

**RIDGEPOINT
DESIGN**

566 SW ARLINGTON BLVD STE 101, LAKE CITY, FL 32025
P: 386-788-1188
E: RIDGEPOINTDESIGN@GMAIL.COM