


REVISIONS		
MAY 3, 2004	TMR	
NOV 30, 2004	TMR	

SOFTPLAN
ARCHITECTURAL DESIGN SOFTWARE

ELECTRICAL	COUNT	SYMBOL
chandelier	2	☼
vanity bar light	2	*****
wall mount l	5	⊙
12 x 48 fluorescent lt fixture	8	▬
Garbage disposal	1	⊙
automatic garage dr opener	2	⊙
cable tv outlet	5	⊙
ceiling fan	8	✦
able flood lights	8	⊙
dimmer switch	3	⊙
garage dr opener	2	⊙
gfi waterproof outlet	5	⊙
light	1	⊙
outlet	42	⊙
outlet 220v	4	⊙
outlet gfi	14	⊙
recessed can light	4	⊙
smoke detector	5	⊙
split receptacle	9	⊙
switch	32	⊙
switch 3 way	12	⊙
telephones	4	⊙
vent light combo	2	⊙

ELECTRICAL PLAN NOTES

- E-1 WIRE ALL APPLIANCES HVAC UNITS AND OTHER EQUIPMENT PER MANUFACTURERS SPECIFICATIONS.
- E-2 CONSULT THE OWNER FOR THE NUMBER OF SEPARATE TELEPHONE LINES TO BE INSTALLED.
- E-3 ALL INSTALLATIONS SHALL BE PER NATIONAL ELECTRIC CODE.
- E-4 ALL SMOKE DETECTORS SHALL BE 90V W/BATTERY BACKUP OF THE PHOTOELECTRIC TYPE AND SHALL BE INTERLOCKED TOGETHER. INSTALL INSIDE AND NEAR ALL BEDROOMS.
- E-5 TELEPHONE, TELEVISION AND OTHER LOW VOLTAGE DEVICES OR OUTLETS SHALL BE AS PER THE OWNERS DIRECTION AND IN ACCORDANCE WITH APPLICABLE SECTIONS OF NATIONAL ELCT. CODE LATEST EDITION.
- E-6 ELECTRICAL CONTRACTOR SHALL BE RESPONSIBLE FOR THE DESIGN AND SIZING OF ELECTRICAL SERVICE AND CIRCUITS.
- E-7 ENTRY OF SERVICE UNDERGROUND OR OVERHEAD IS TO BE DETERMINED BY THE POWER COMPANY.
- E-8 ALL BEDROOM RECEPTALS ARE TO BE AFCI (ARC FAULT CIRCUIT INTERRUPT)

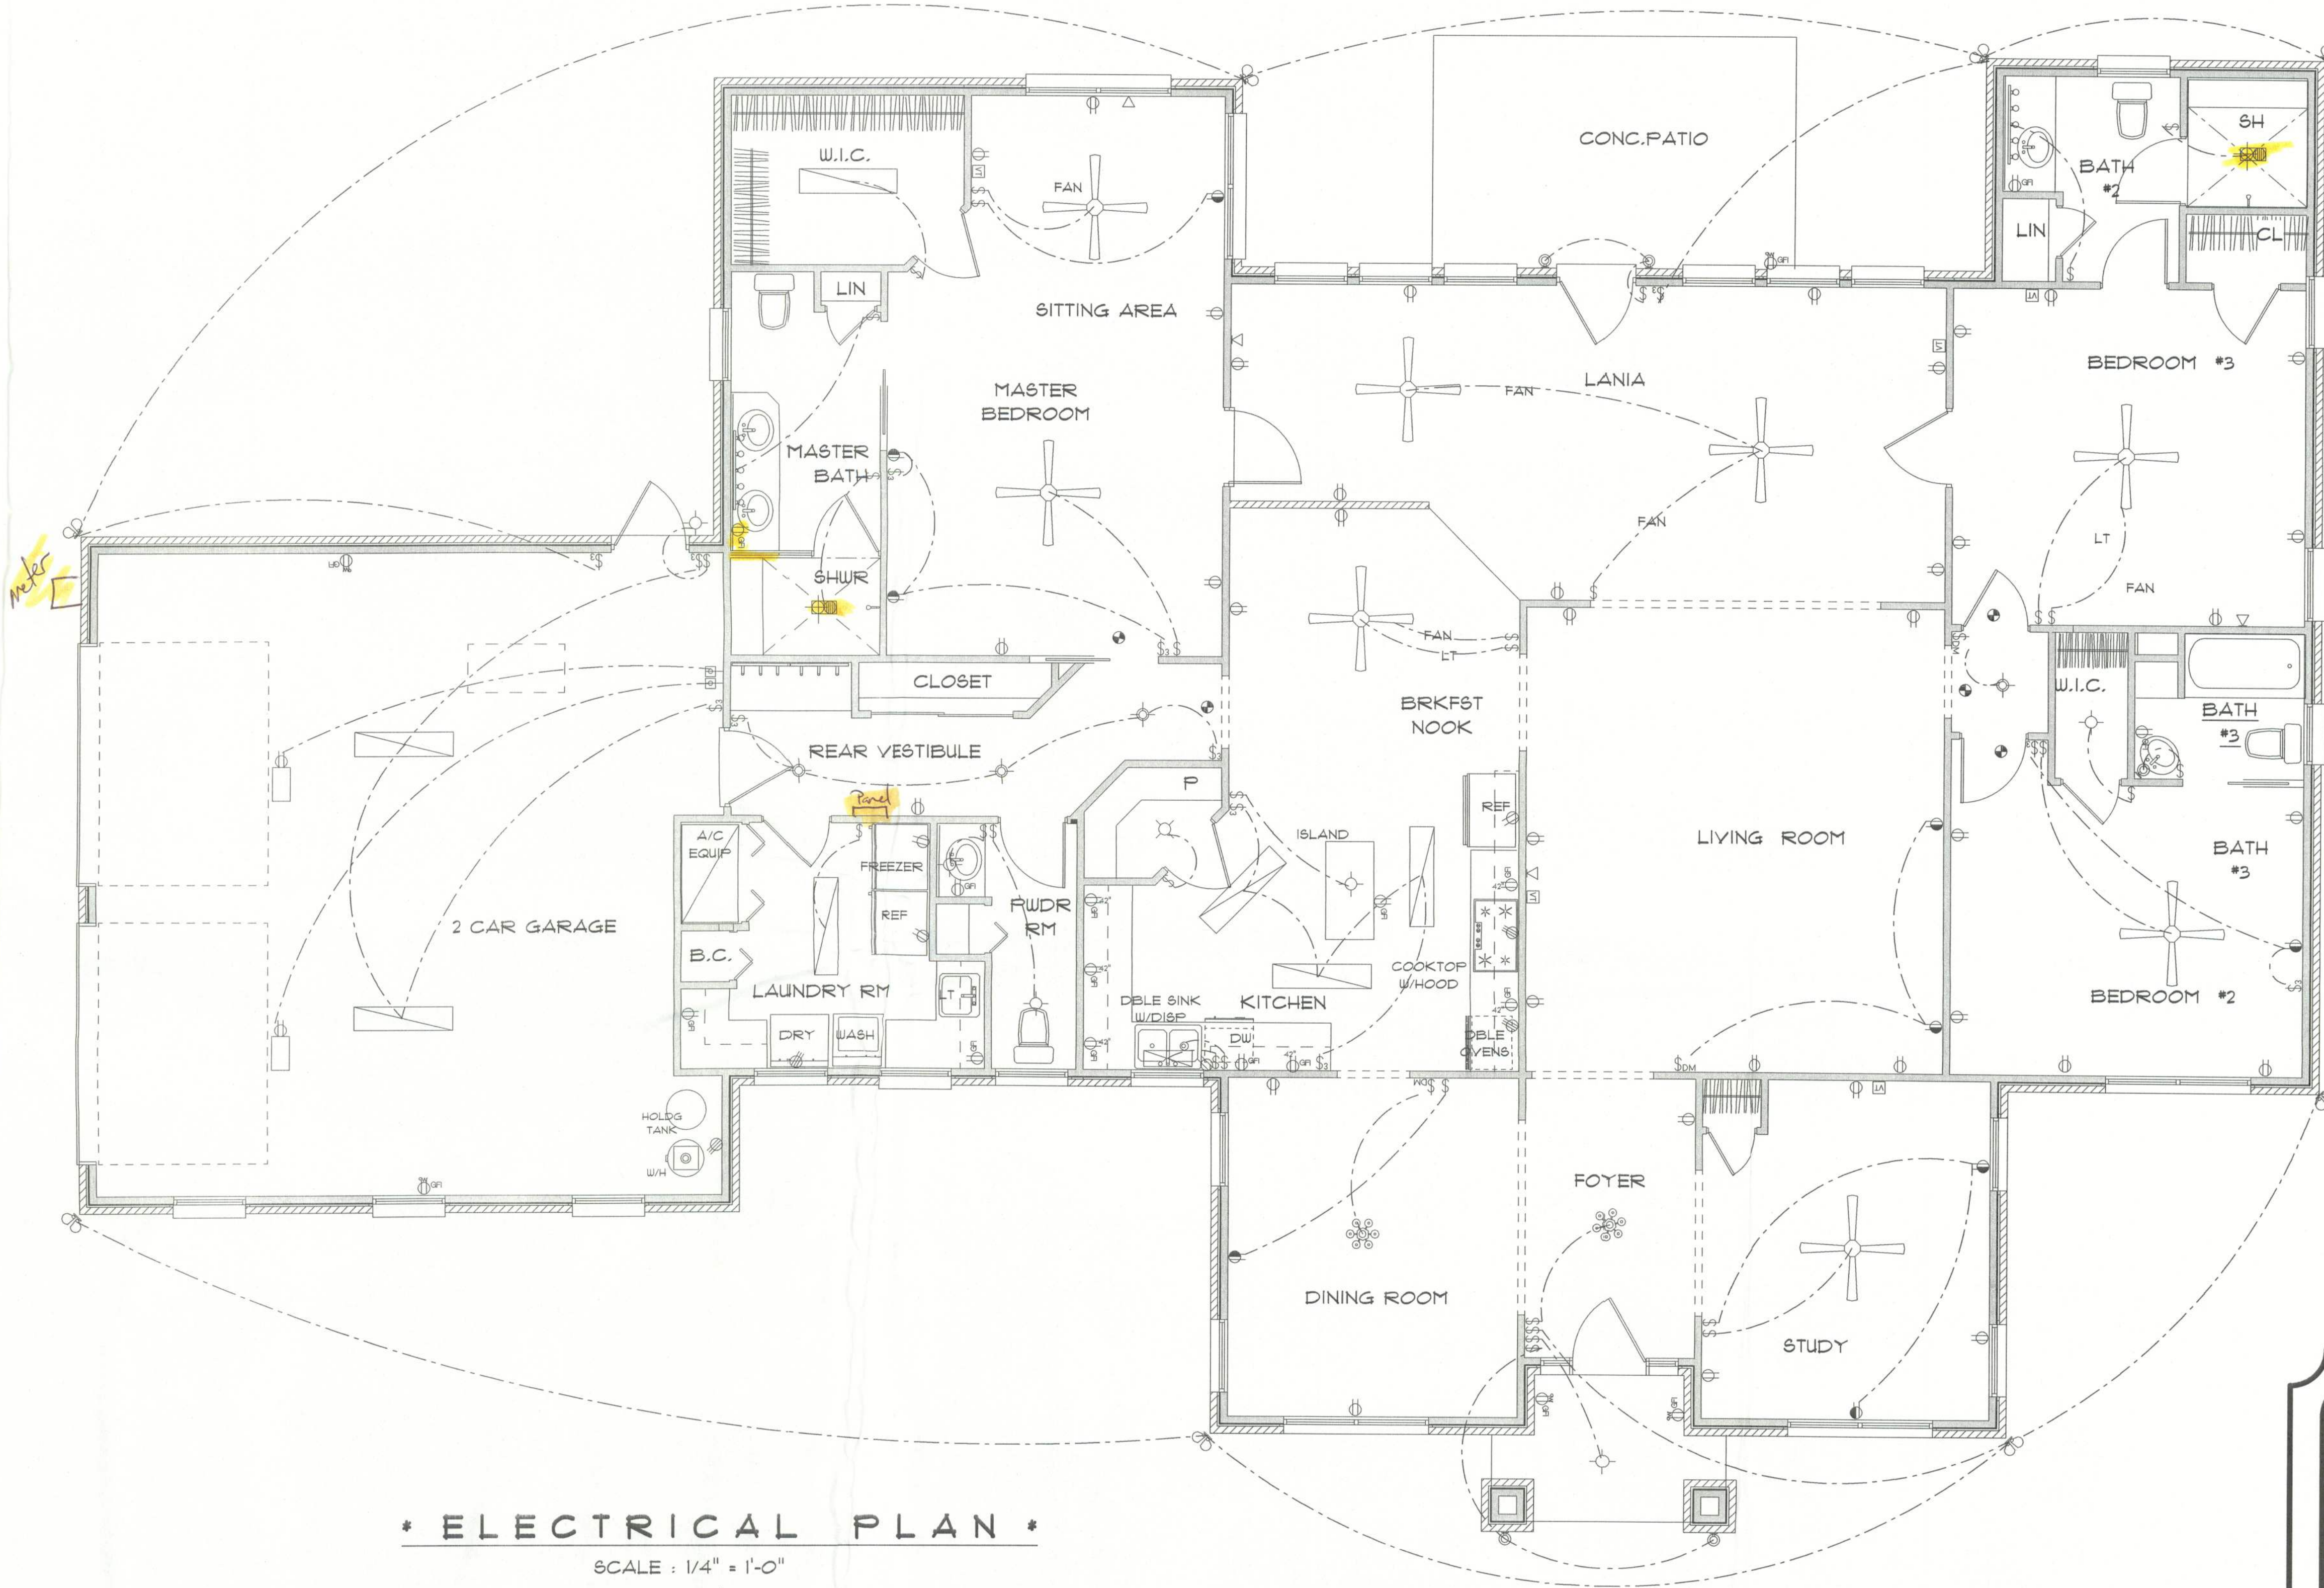

* ELECTRICAL PLAN *

SCALE : 1/4" = 1'-0"

RESIDENCE
for
GENEVIEVE SCIRICA

In
MAGNOLIA PLACE
ELLISVILLE, FLA.

Teresa M. Ruffo
251 NW Hall of Fame Dr.
Lake City, Florida 32055
Phone: (386) 755 - 9993
Cell: (386) 861 - 1191
Email: eadystreet@aol.net

PRINTED DATE: December 01, 2004	CHECKED BY: Teresa M. Ruffo
BUILDING CONTRACTOR Bryan Zacher Construction	
FINALS DATE: DECEMBER 2004	
JOB NUMBER:	
DRAWING NUMBER A-4 OF 4 SHEETS	