


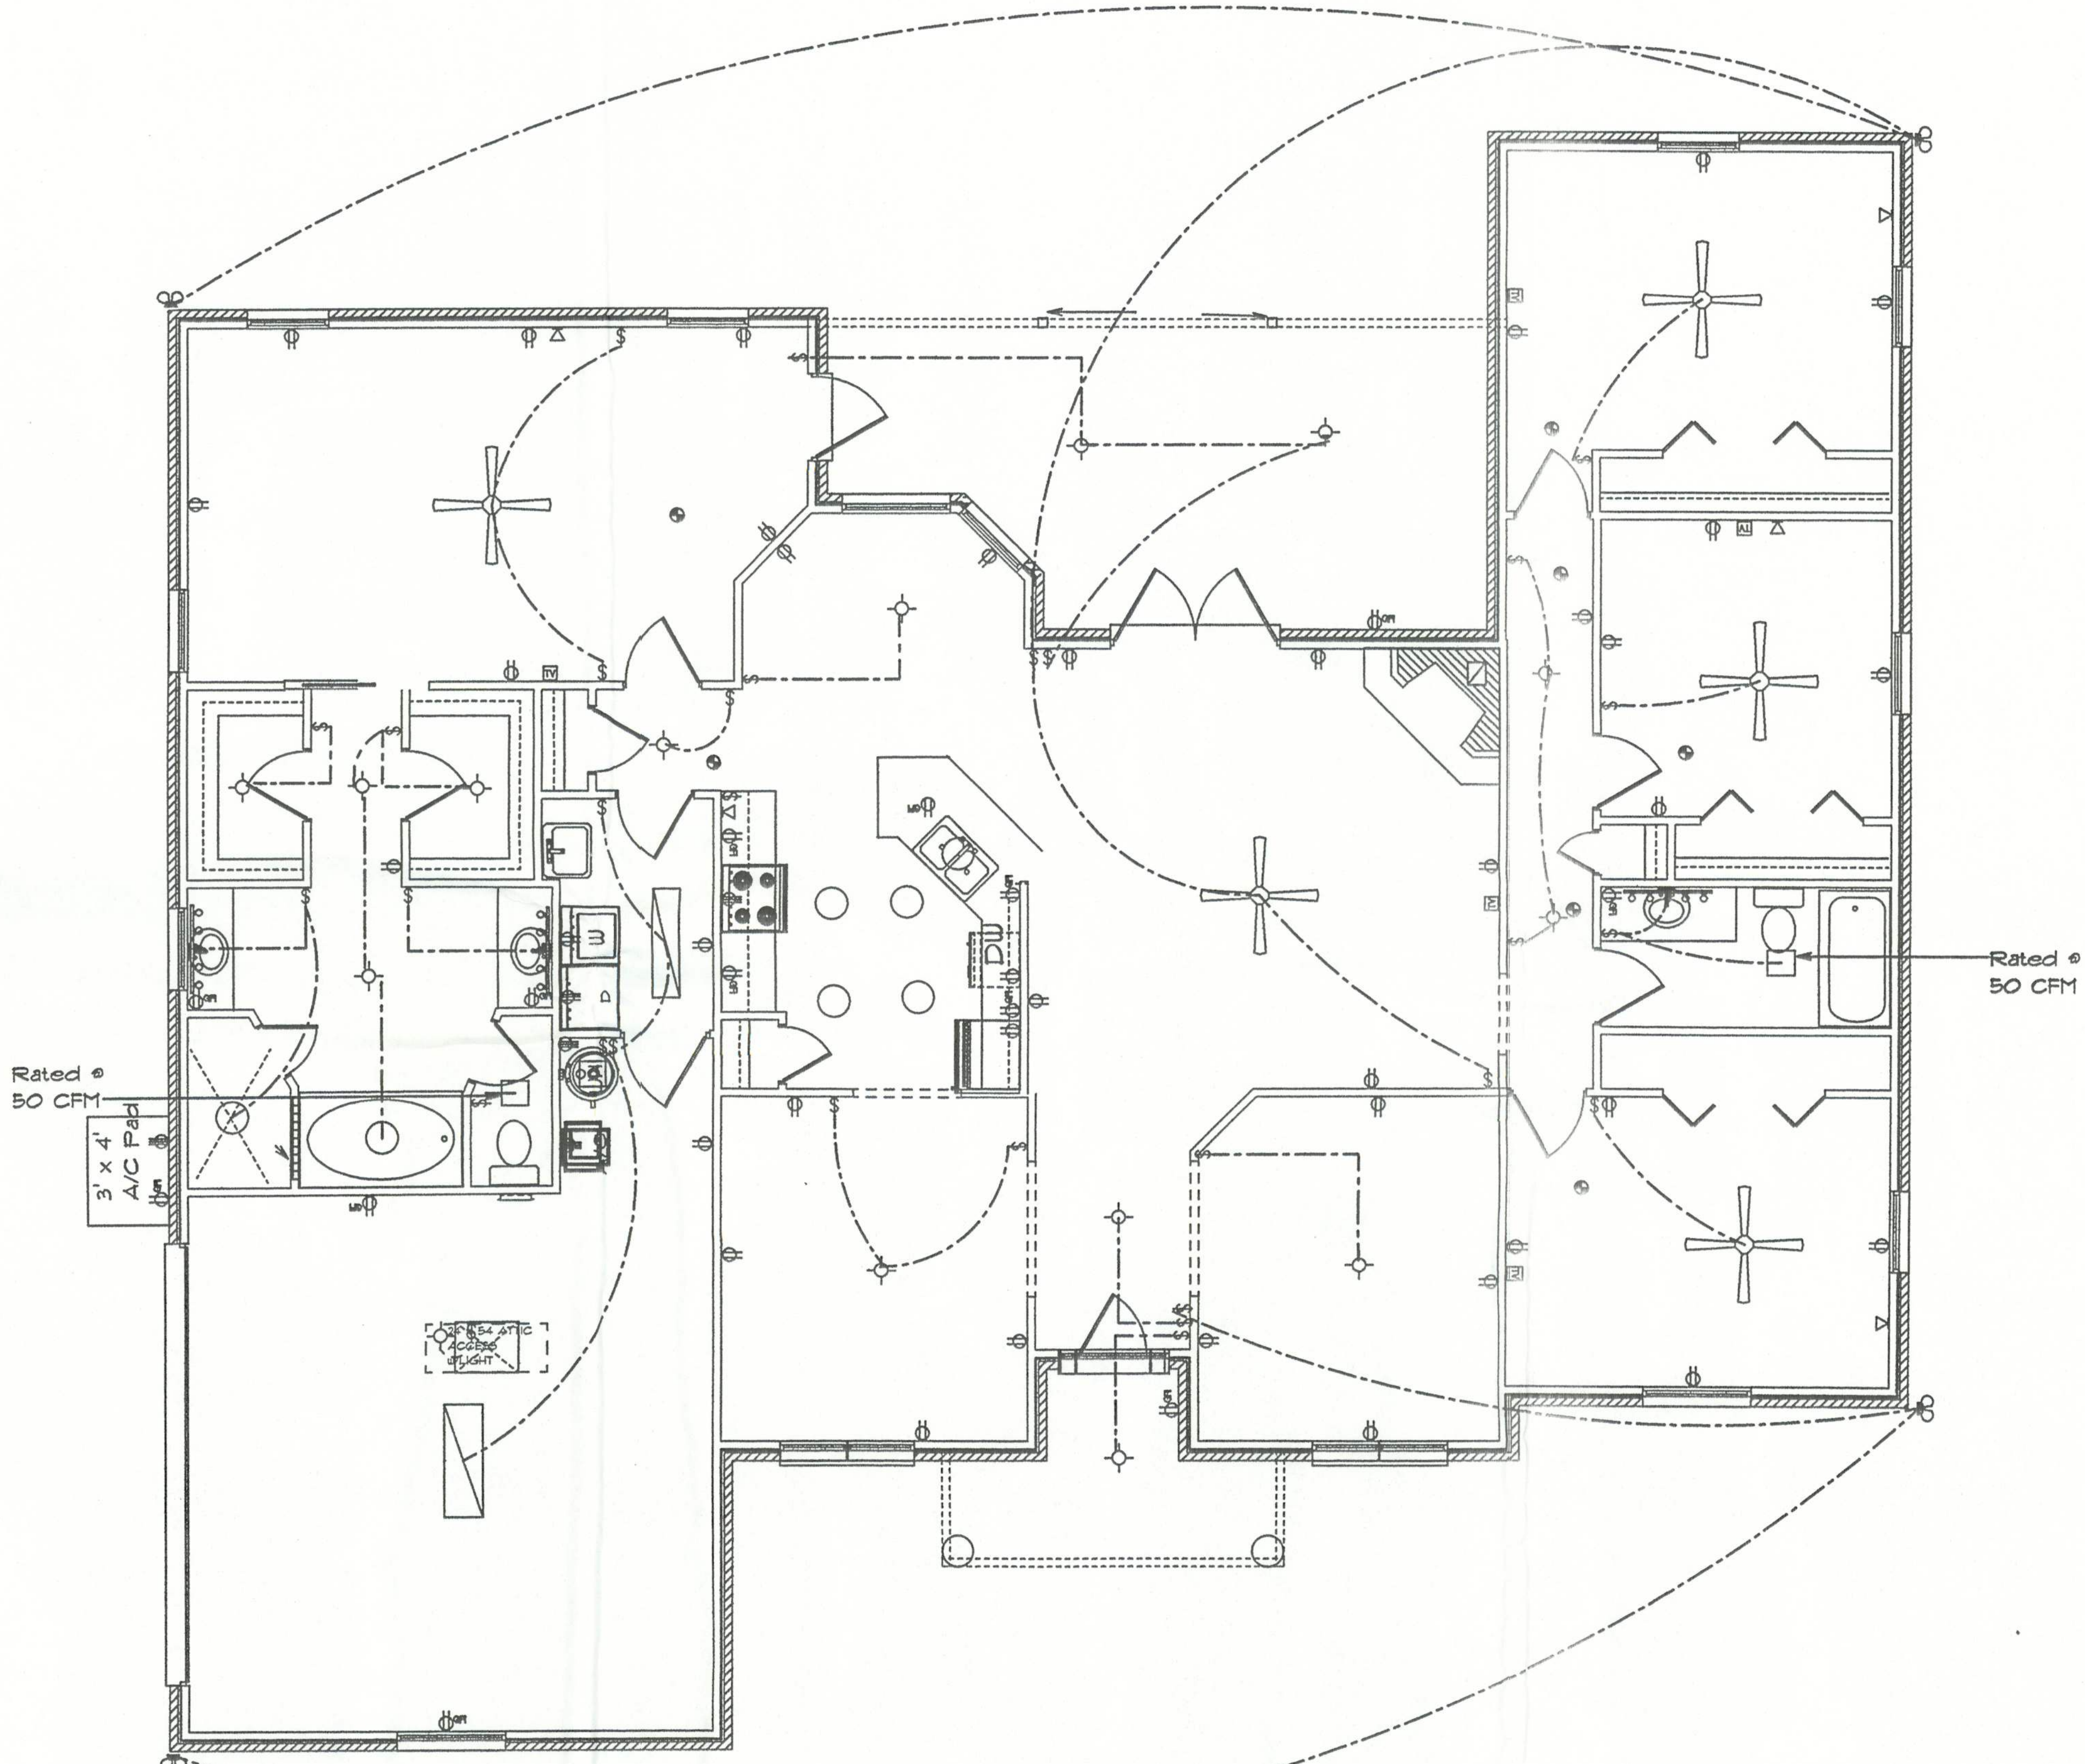

ELECTRICAL PLAN

ELECTRICAL	COUNT	SYMBOL
ceiling fan	5	
Recessed Light	7	
ceiling lamp large	1	
ceiling lamp small	1	
ceiling light vent square	2	
110 outlet-dishwasher	1	
110 outlet-refrig	1	
110 outlet-washer	1	
220 Outlet-Dryer	1	
220 outlet-WH	1	
220 outlet-air handler	1	
220 outlet-stove	1	
220V outlet-AC	1	
Light-Attic Access	1	
double spotlight	4	
vanity bar light	3	
electrical panel	1	
Light	3	
cable tv outlet	5	
light	11	
outlet	36	
outlet gfi	12	
smoke detector	7	
switch	29	
telephone	5	

Label
7/8/05

Mackenzie Model
This plan Designed For
Lot 14 Arbor Greene @
Emerald Lakes

SCALE 1/4" = 1'

DRAWN BY Susan Holton

APPROVED GG

DATE 1/7/2005

Drawn For:
Eagle / Kiraly

DRAWING# A-4

GTC DESIGN GROUP
GARY GILL P.E.
PE# 51942 ACT# 9423