

NOTE:
SHEATHING ON BOTH SIDES OF WALL
DOUBLES THE EFFECTIVE SHEARWALL
LENGTH.

NOTE:
ALL BRANCH CIRCUITS THAT SUPPLY 125-VOLT, SINGLE PHASE
15 AND 20 AMP OUTLETS INSTALLED IN DWELLING UNIT BEDROOMS
SHALL BE PROTECTED BY AN ARC FAULT CIRCUIT INTERRUPTER
LISTED TO PROVIDE PROTECTION OF THE ENTIRE BRANCH CIRCUIT.

ELECTRICAL PLAN NOTES

WIRE ALL APPLIANCES, HVAC UNITS AND OTHER EQUIPMENT
PER MANUF. SPECIFICATIONS.

CONSULT THE OWNER FOR THE NUMBER OF SEPARATE
TELEPHONE LINES TO BE INSTALLED.


INSTALLATION SHALL BE PER NATL. ELECTRIC CODE.

ALL SMOKE DETECTORS SHALL BE 120V W/ BATTERY
BACKUP OF THE PHOTOELECTRIC TYPE, AND SHALL
BE INTERLOCKED TOGETHER. INSTALL INSIDE AND
NEAR ALL BEDROOMS.

TELEPHONE, TELEVISION AND OTHER LOW VOLTAGE
DEVICES OR OUTLETS SHALL BE AS PER THE OWNER'S
DIRECTIONS, & IN ACCORDANCE W/ APPLICABLE
SECTIONS OF NEC-LATEST EDITION.

ELECTRICAL CONTR. SHALL PREPARE "AS-BUILT" SHOP
DWGS INDICATING ALL ELECTRICAL WORK, INCLUDING ANY
CHANGES TO THE ELEC. PLAN, ADDS TO THE ELEC. PLAN,
RISER DIAGRAM, AS-BUILT PANEL SCHEDULE W/ ALL CKT'S
IDENTIFIED W/ CKT N., DESCRIPTION & BRKR. SERVICE ENT.
& ALL UNDERGROUND WIRE LOCATIONS/ROUTING/DEPTH.
RISER DIA. SHALL INCLUDE WIRE SIZES/TYPE & EQUIPMENT
TYPE W/ RATINGS & LOADS.
CONTRACTOR SHALL PROVIDE 1 COPY OF AS-BUILT DWGS
TO OWNER & 1 COPY TO THE PERMIT ISSUING AUTHORITY.

ELECTRICAL	SYMBOL
ceiling fan spotlights 2	
Light-Attic Access	
chandelier	
double spotlight	
fluorescent fixture	
wall mount 1	
cable tv outlet	
fan	
light	
outlet	
outlet 220v	
outlet gfi	
split receptacle	
switch	
switch 3 way	
switch double	
telephone	
fluorescent light 1 x 4	

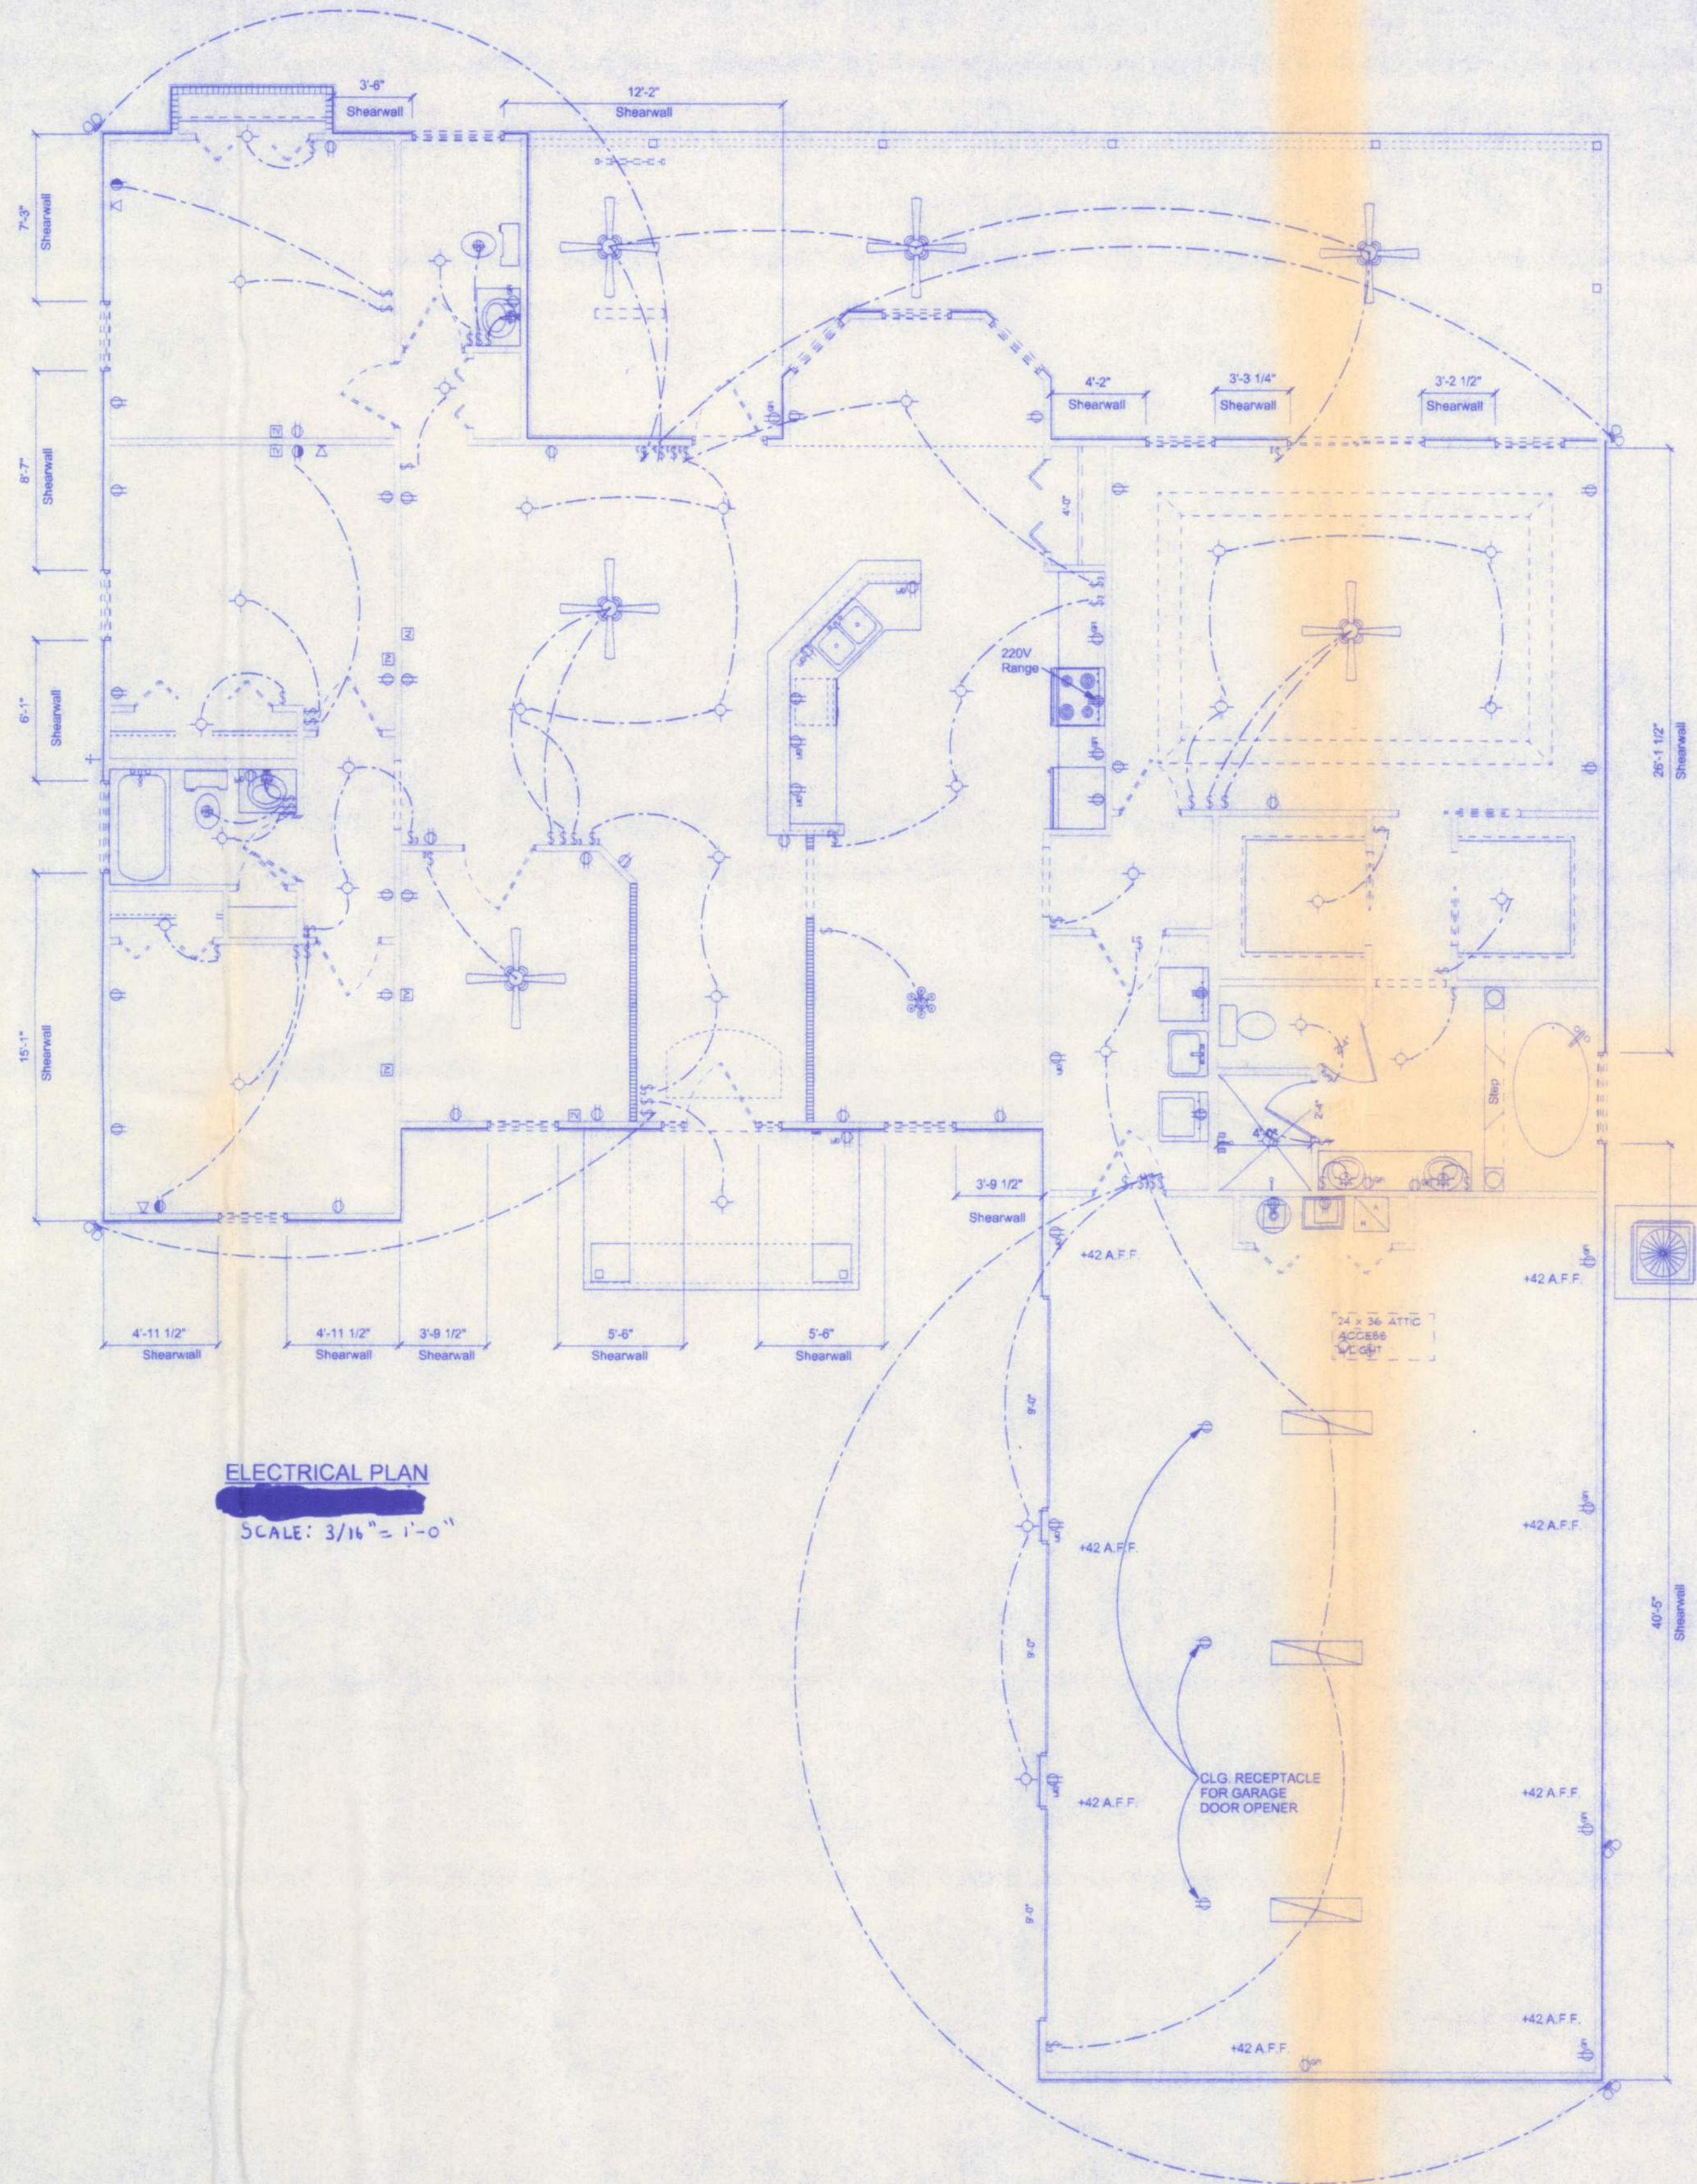

161 N.W. MADISON STREET
SUITE #102
LAKE CITY, FL 32055
(386)758-4209

CERTIFICATE OF AUTHORIZATION # 00008701

DATE
9/22/05

DRAWN BY
W.H.F.

REVISIONS

SHEET
A-5

OF
7

PROJECT NO.

LAUREL LAKES LOT #8

W.H.F.
9/24/05