


DOOR SCHEDULE	
N _{o.}	SIZE & TYPE
1	3' - 0" FRONT ENTRY WITH 2 LITES
1	6' - 0" DBL 3/0 FRENCH EXTERIOR 14 LITE
1	3' - 0" FRENCH EXTERIOR 14 LITE
1	* 3' - 0" 9 LITE ENTRY DOOR EXTERIOR
2	3' - 0" COLONIAL INTERIOR
5	2' - 8" COLONIAL INTERIOR
5	2' - 8" COLONIAL INTERIOR
2	2' - 0" COLONIAL INTERIOR
2	4' - 0" BIFOLD COLONIAL INTERIOR
2	9' - 7' GARAGE
1	2' - 0' SHOWER

* 20 MIN. FIRE RATED STEEL

WINDOW SCHEDULE	
N _{o.}	SIZE & TYPE
2	3' 0" - 5' 0" DBL SINGLE HUNG
13	3' 0" - 5' 0" SINGLE HUNG
2	3' 0" - 4' 0" SINGLE HUNG TEMP.
2	3' 0" - 3' 0" SINGLE HUNG
1	1' 0" - 3' 0" SOLID
2	2' 0" - 3' 0" SINGLE HUNG ARCH
1	3' 0" - 3' 0" SINGLE HUNG ARCH

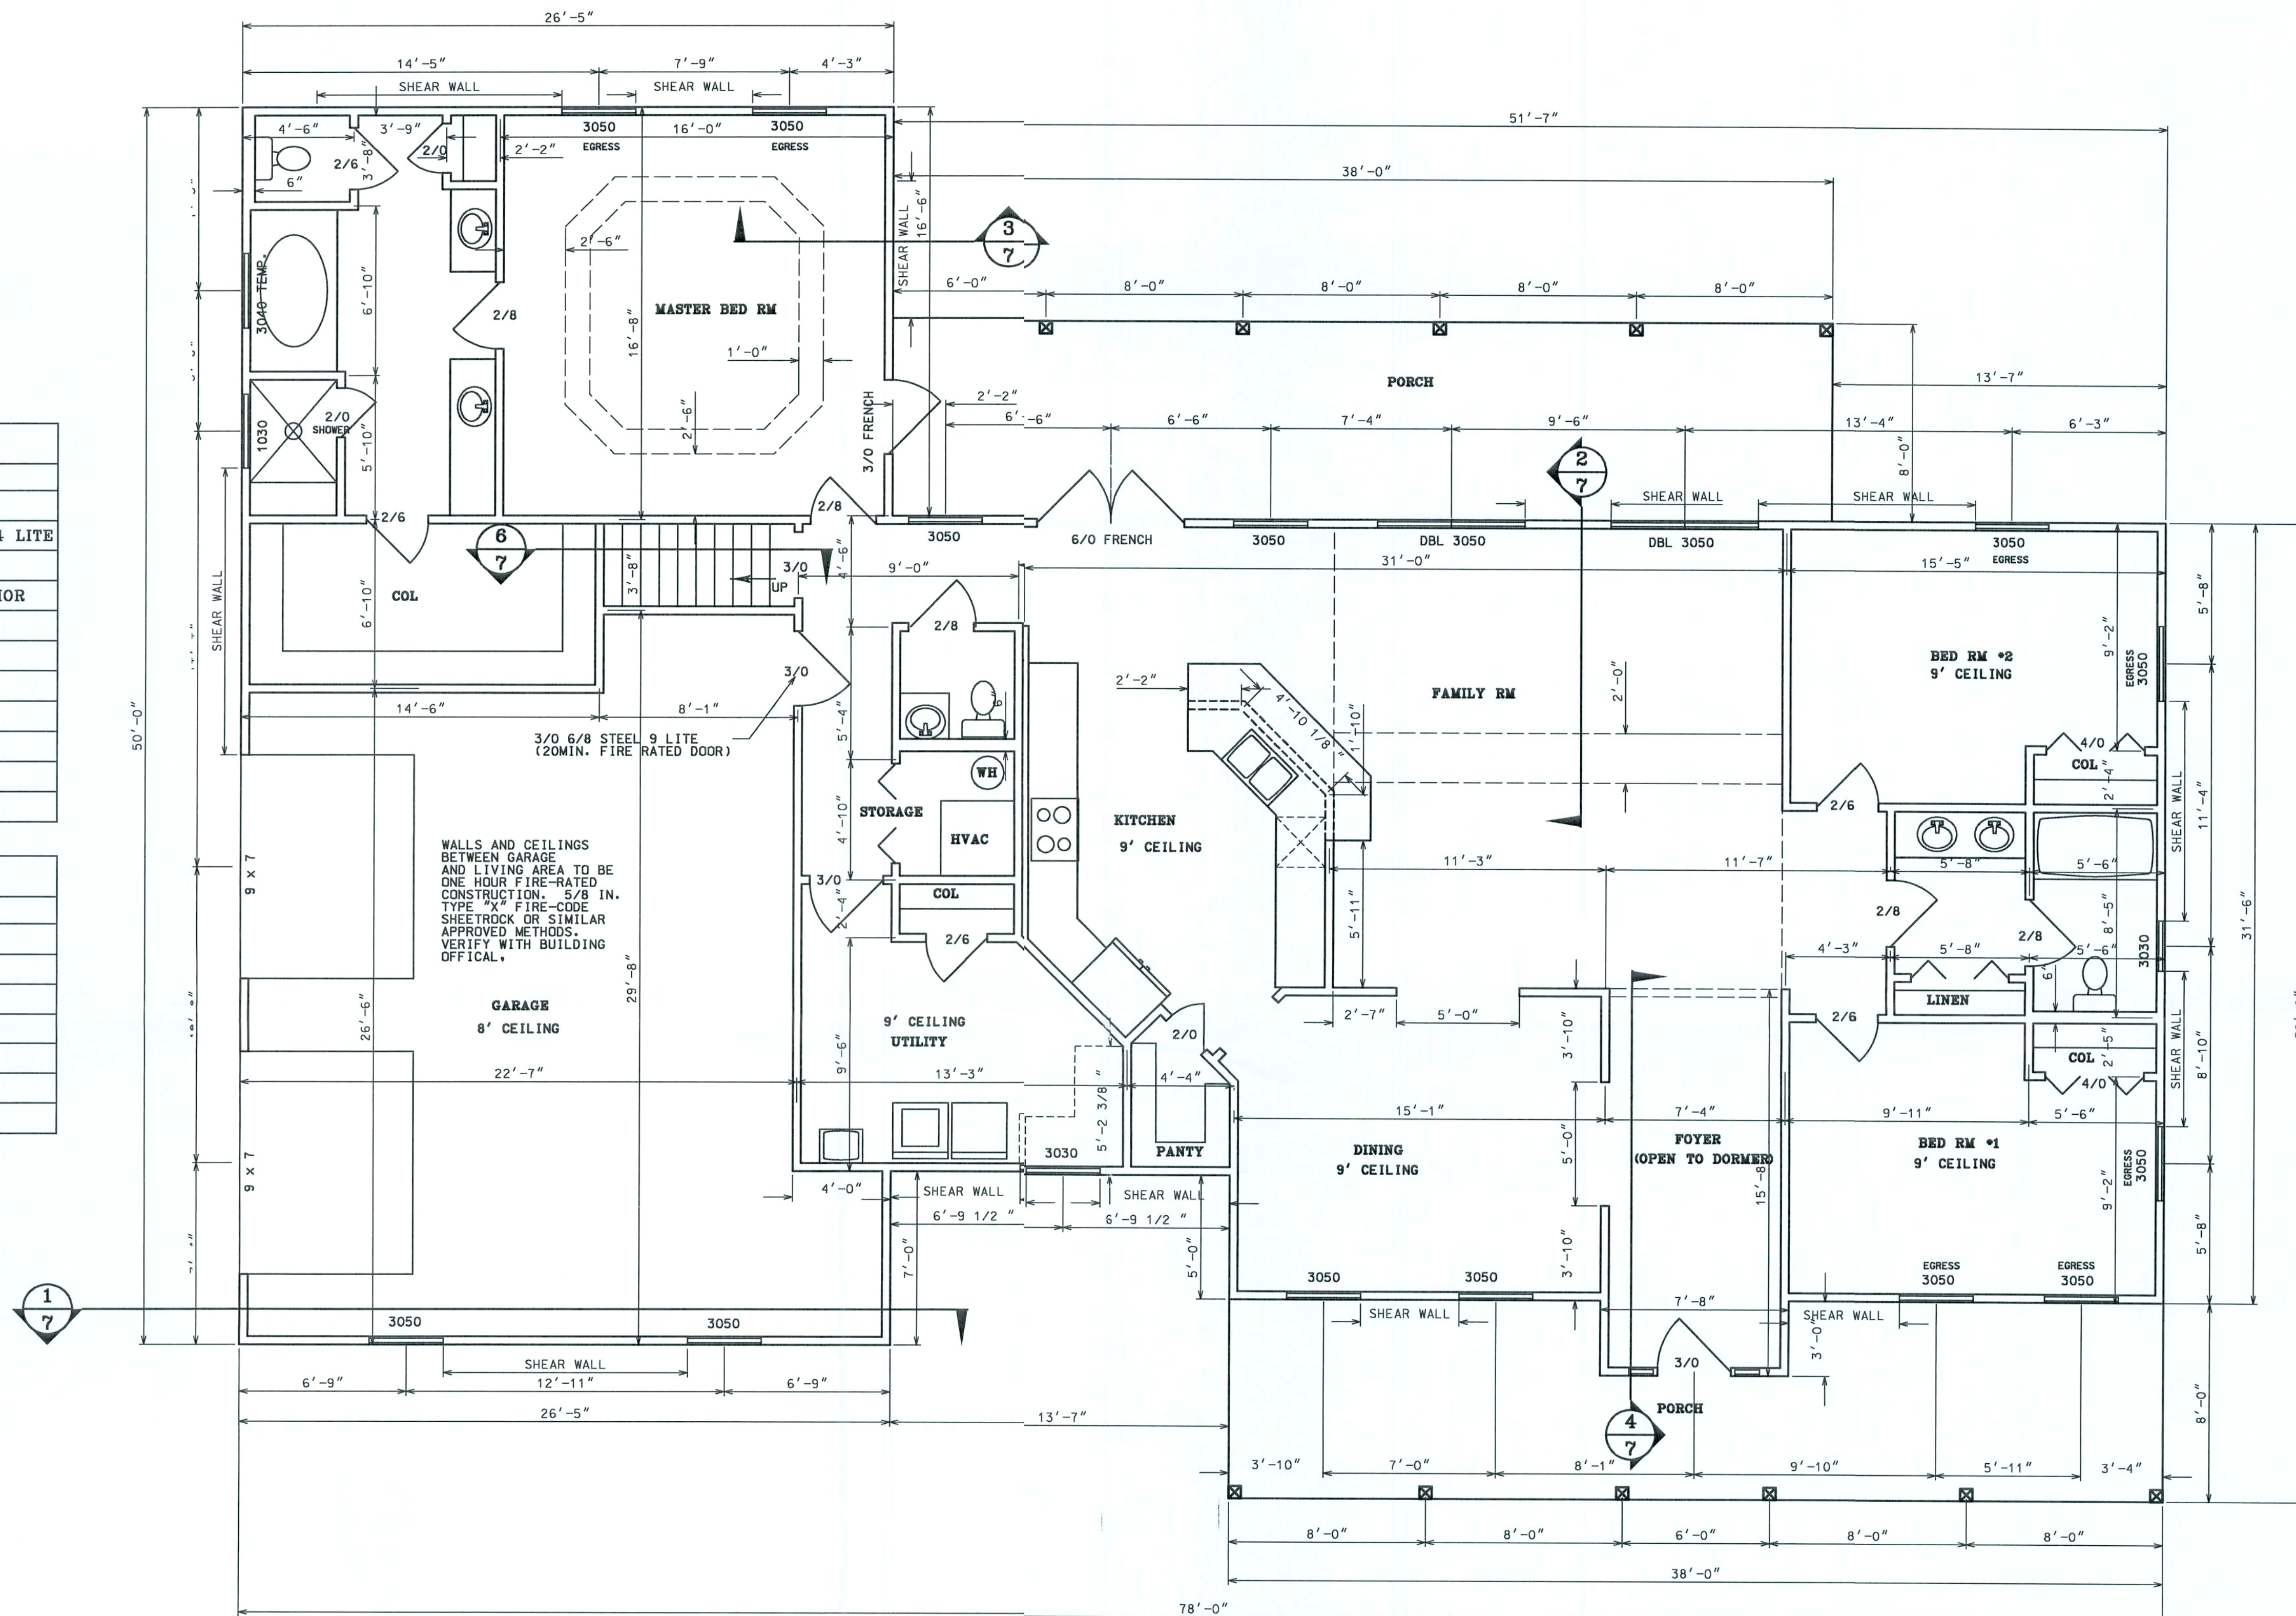

HEATED AREA	2230 SF
BONUS RM AREA	464 SF
GARAGE AREA	647 SF
PORCH AREA	608 SF
TOTAL AREA	3949 SF



HAYGOOD HOMES INC.

12592 So. U.S. HWY 441
LAKE CITY FL. 32025
OFFICE (386) 752-3496
MOBILE (386) 303-1981
CR-C1326715


JOHN AND JESSICA MacLAREN

LAKE CITY FLORIDA


FLOOR PLAN

PLAN No.	SCALE	DATE	SHEET No.
P 0601	1/4" = 1'	02/23/06	3


...:\Projects\MacLaren\Floorpl.dgn 2/25/2006 10:06:19 AM

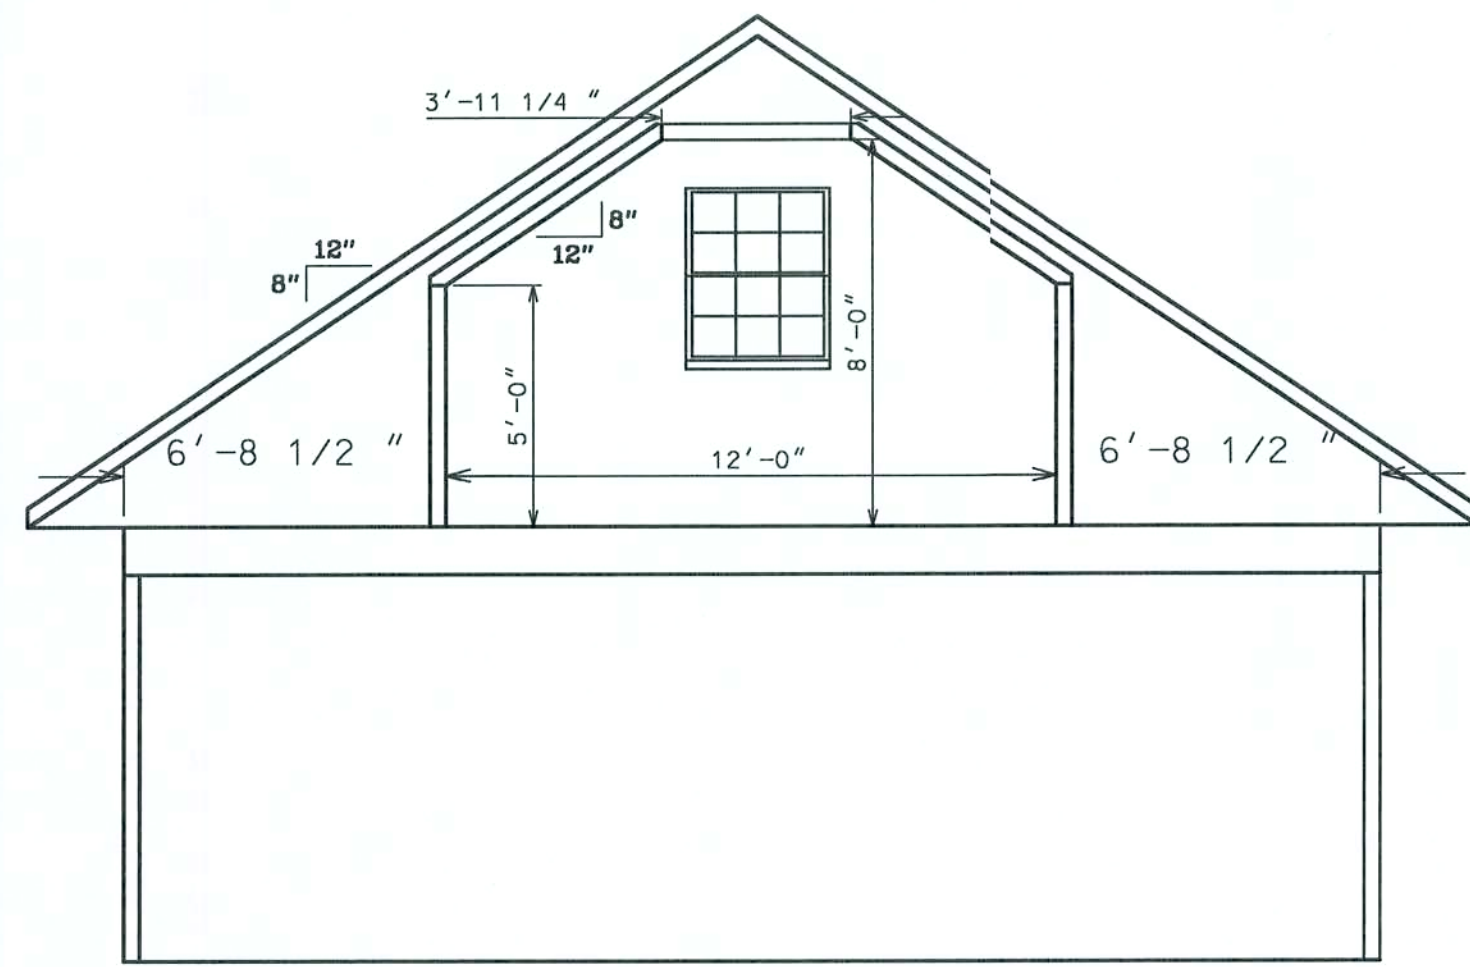


BONUS ROOM (1/7)

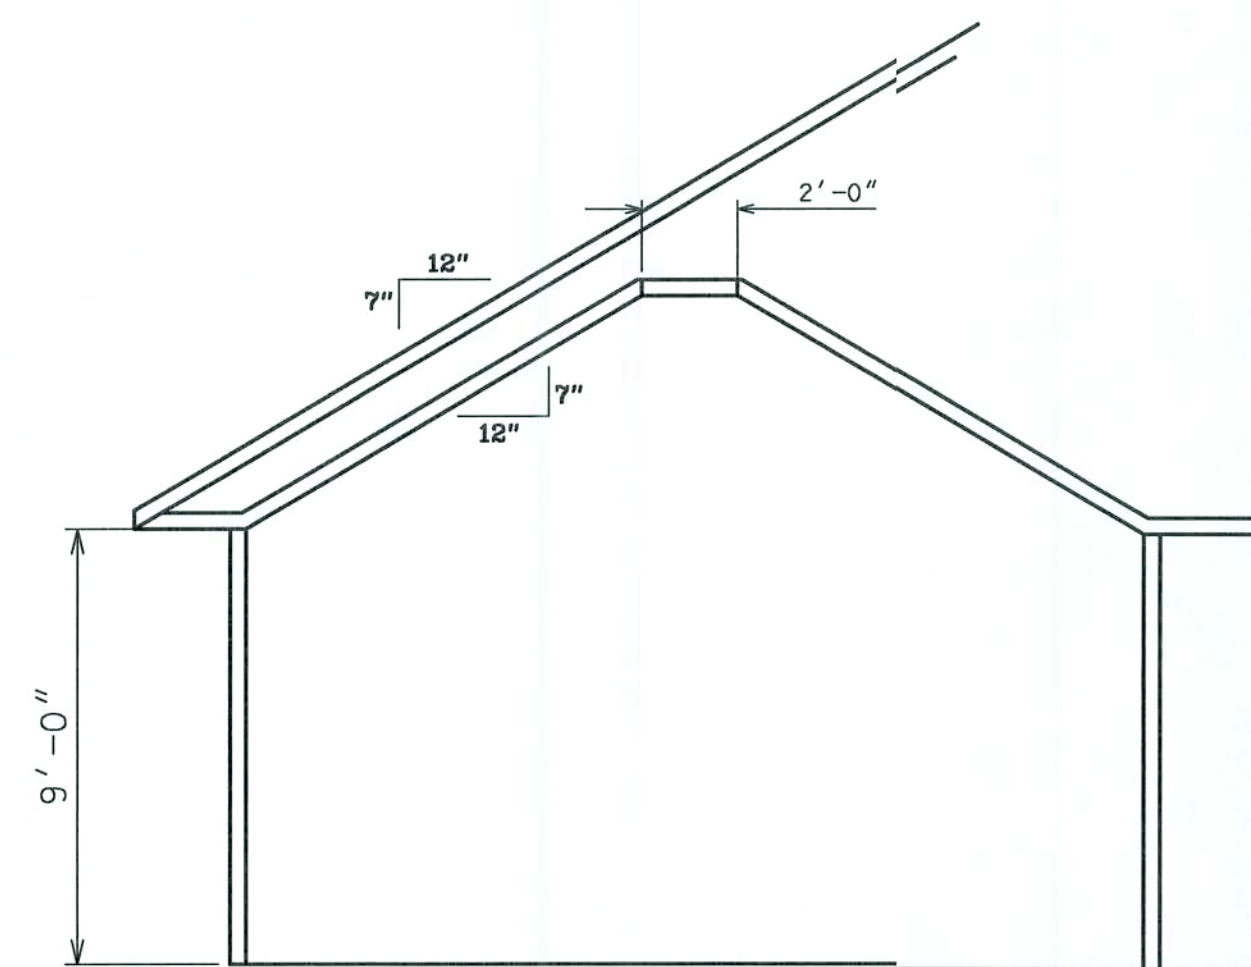


FAMILY ROOM (2/7)

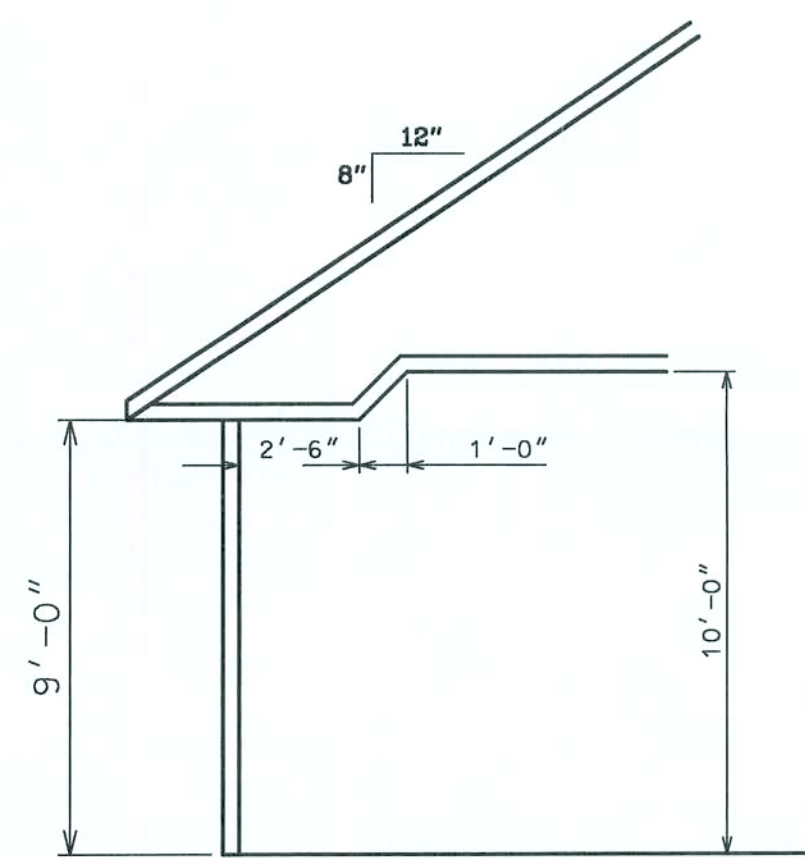

FAMILY ROOM (3/7)

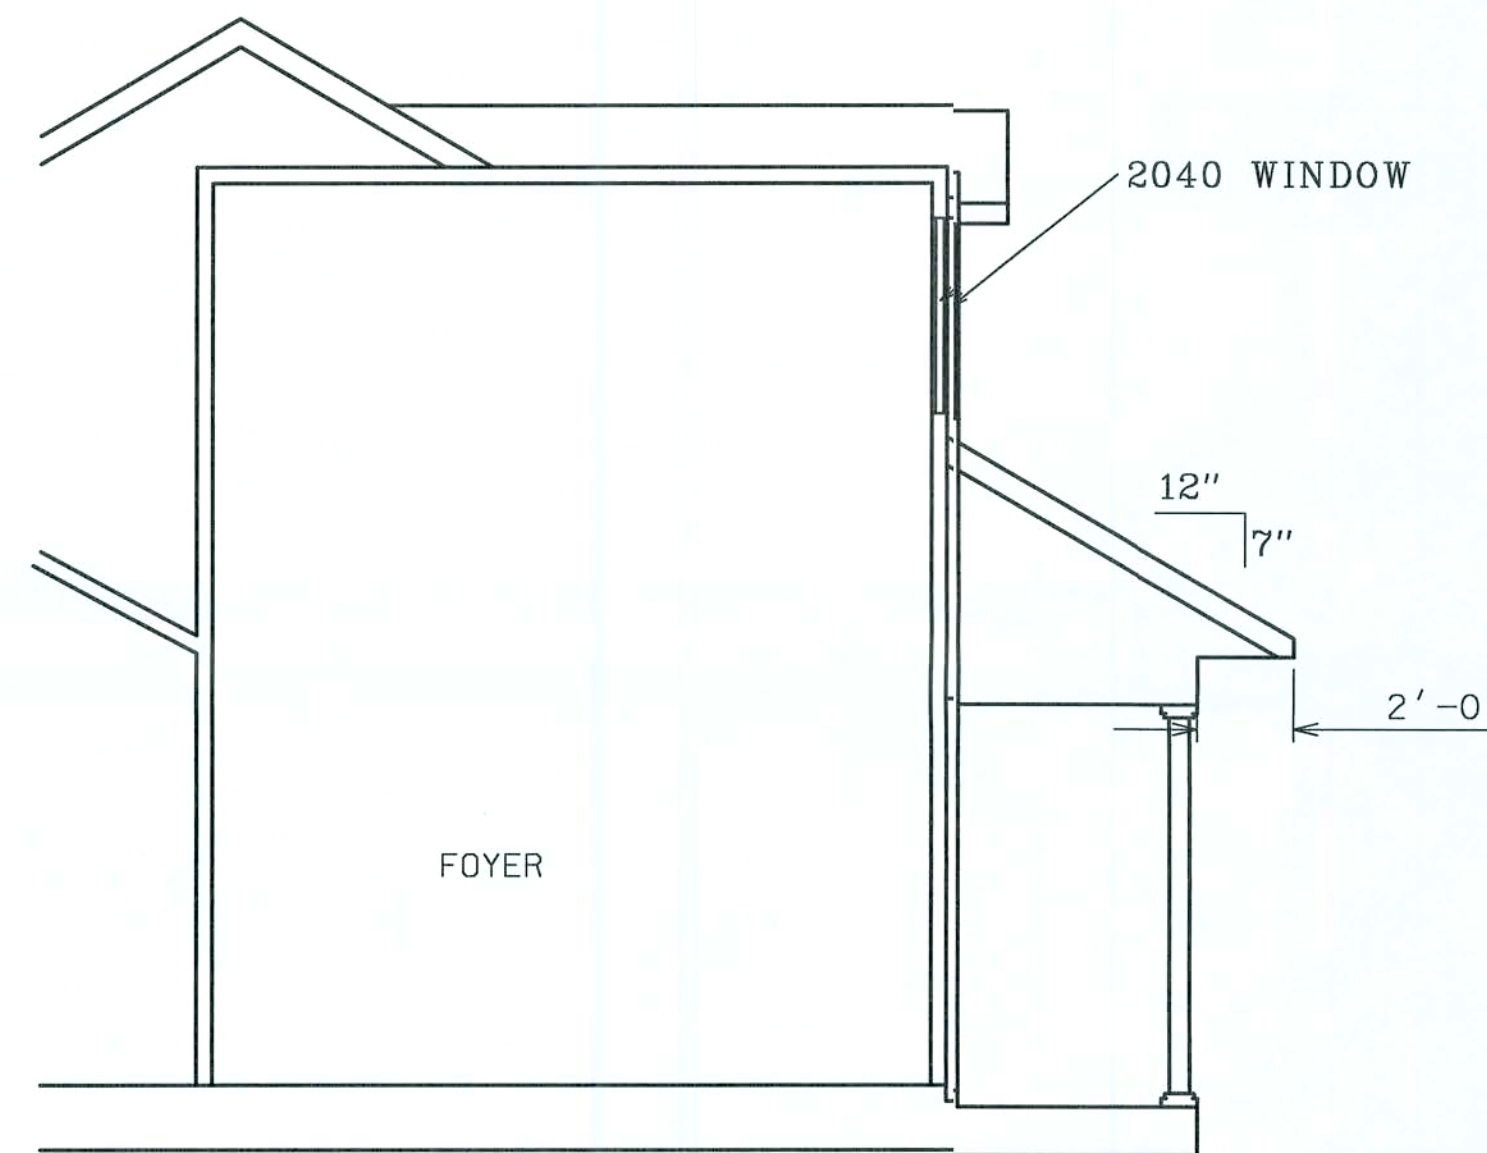

FOYER DETAIL (4/7)

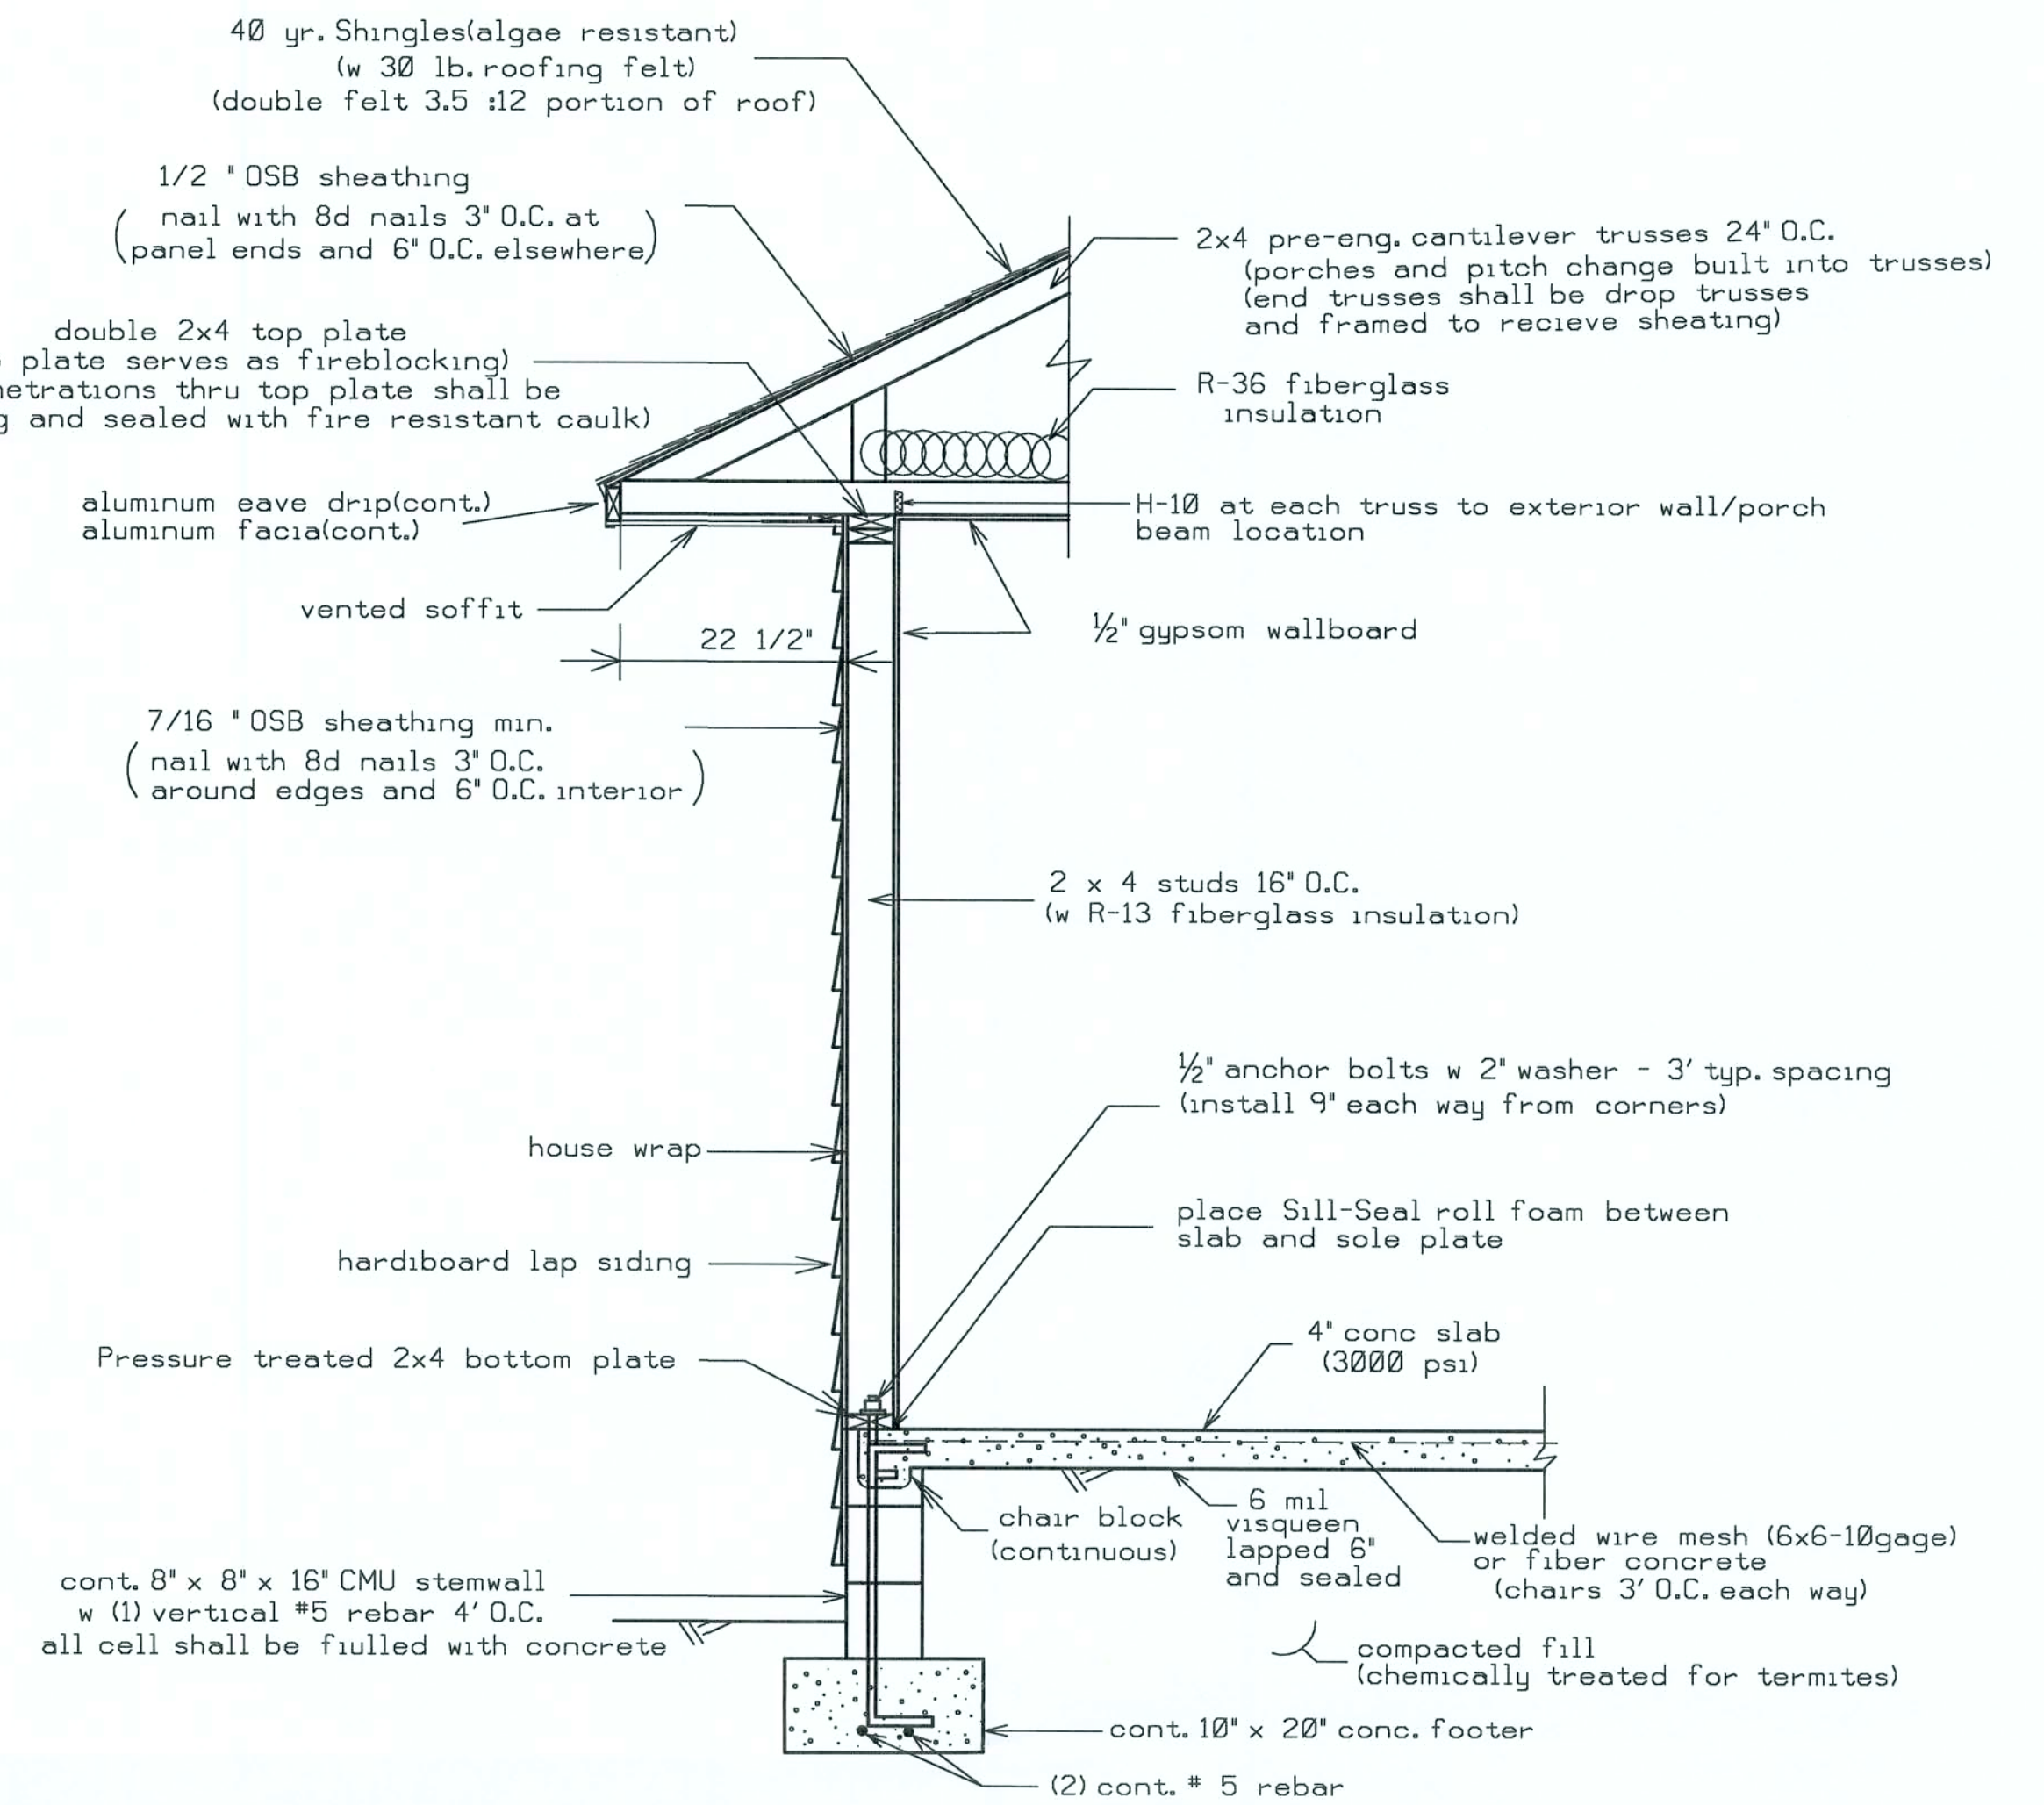


FOOTER DESIGN 1000 PSF


WALL DETAIL(TYP.) (N.T.S.)

HEADER SIZES/MATERIAL SHALL BE AS FOLLOWS:


WINDOW AND DOOR OPENINGS(2 - #2 SYP 2X12's with 1/2" plywood between)
PORCH BEAMS (2 - #2 SYP 2X10's with 1/2" plywood between)

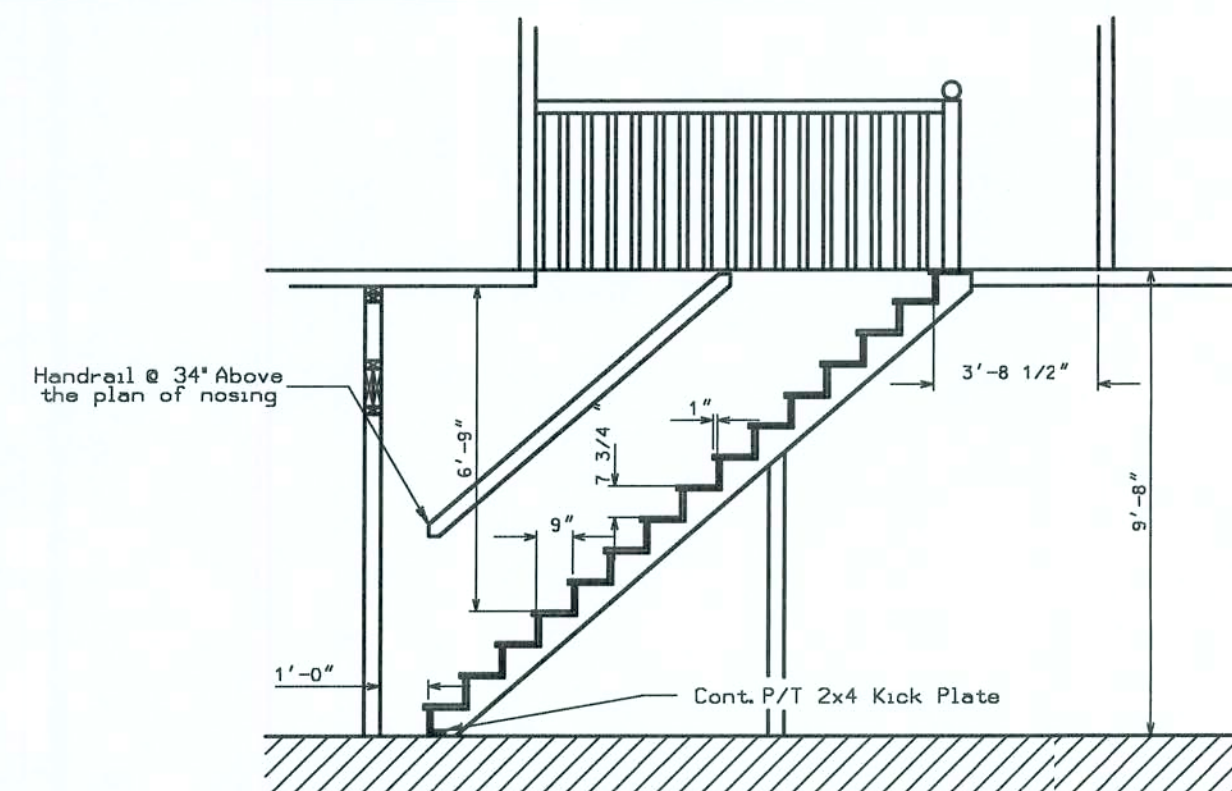


STAIR DETAIL (6/7)


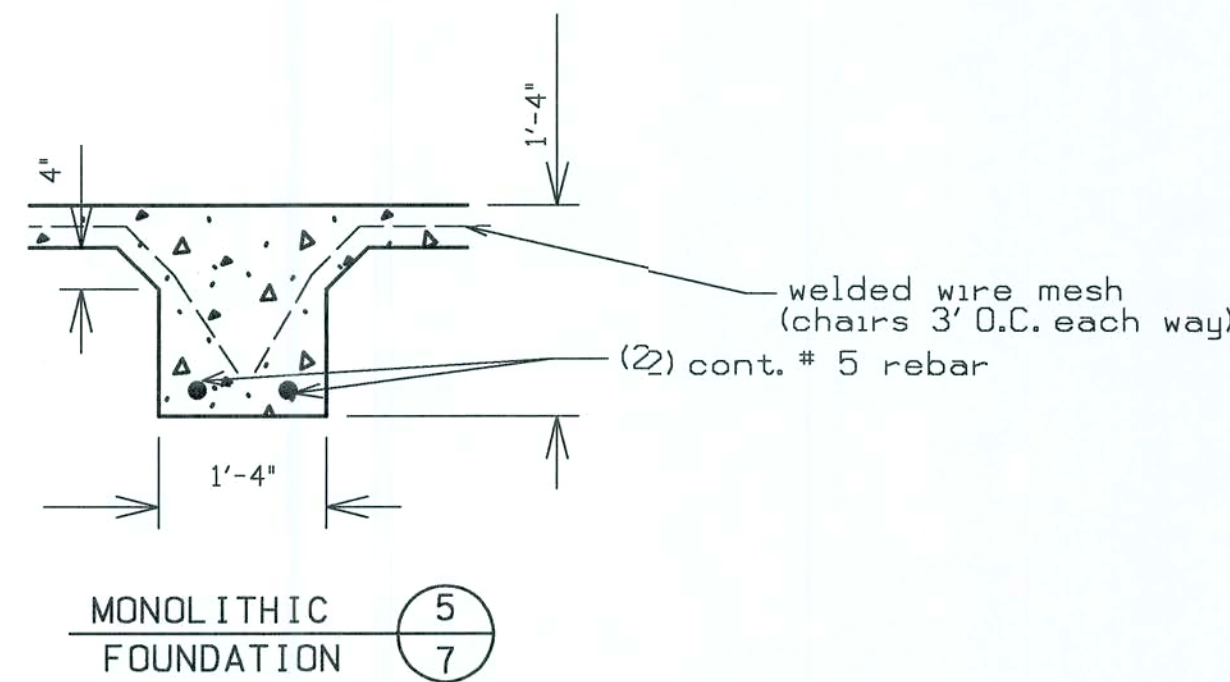


MONOLITHIC FOUNDATION (5/7)

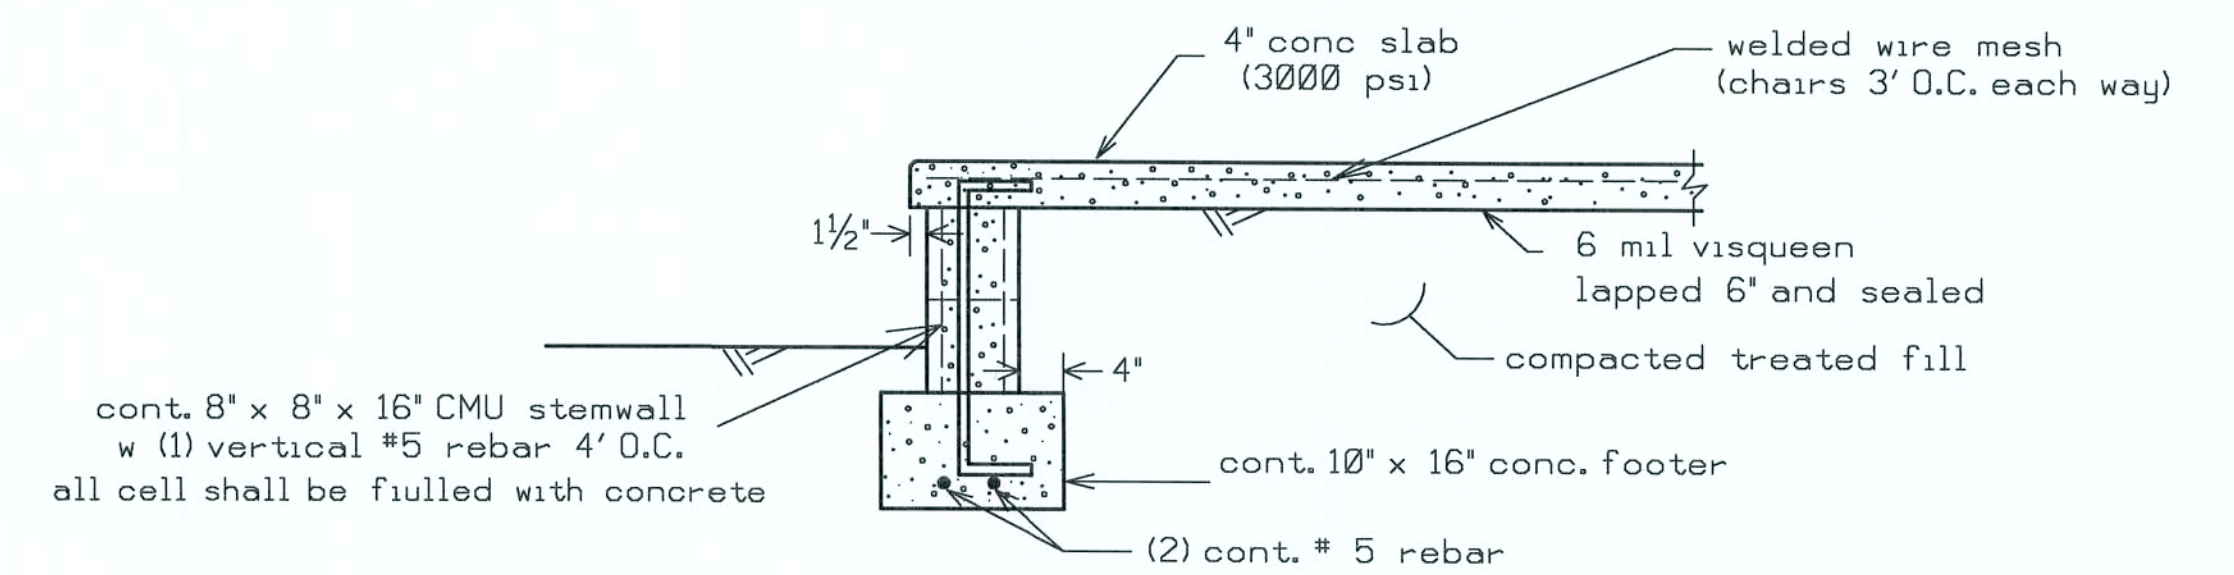

PORCH FOUNDATION (N.T.S.)

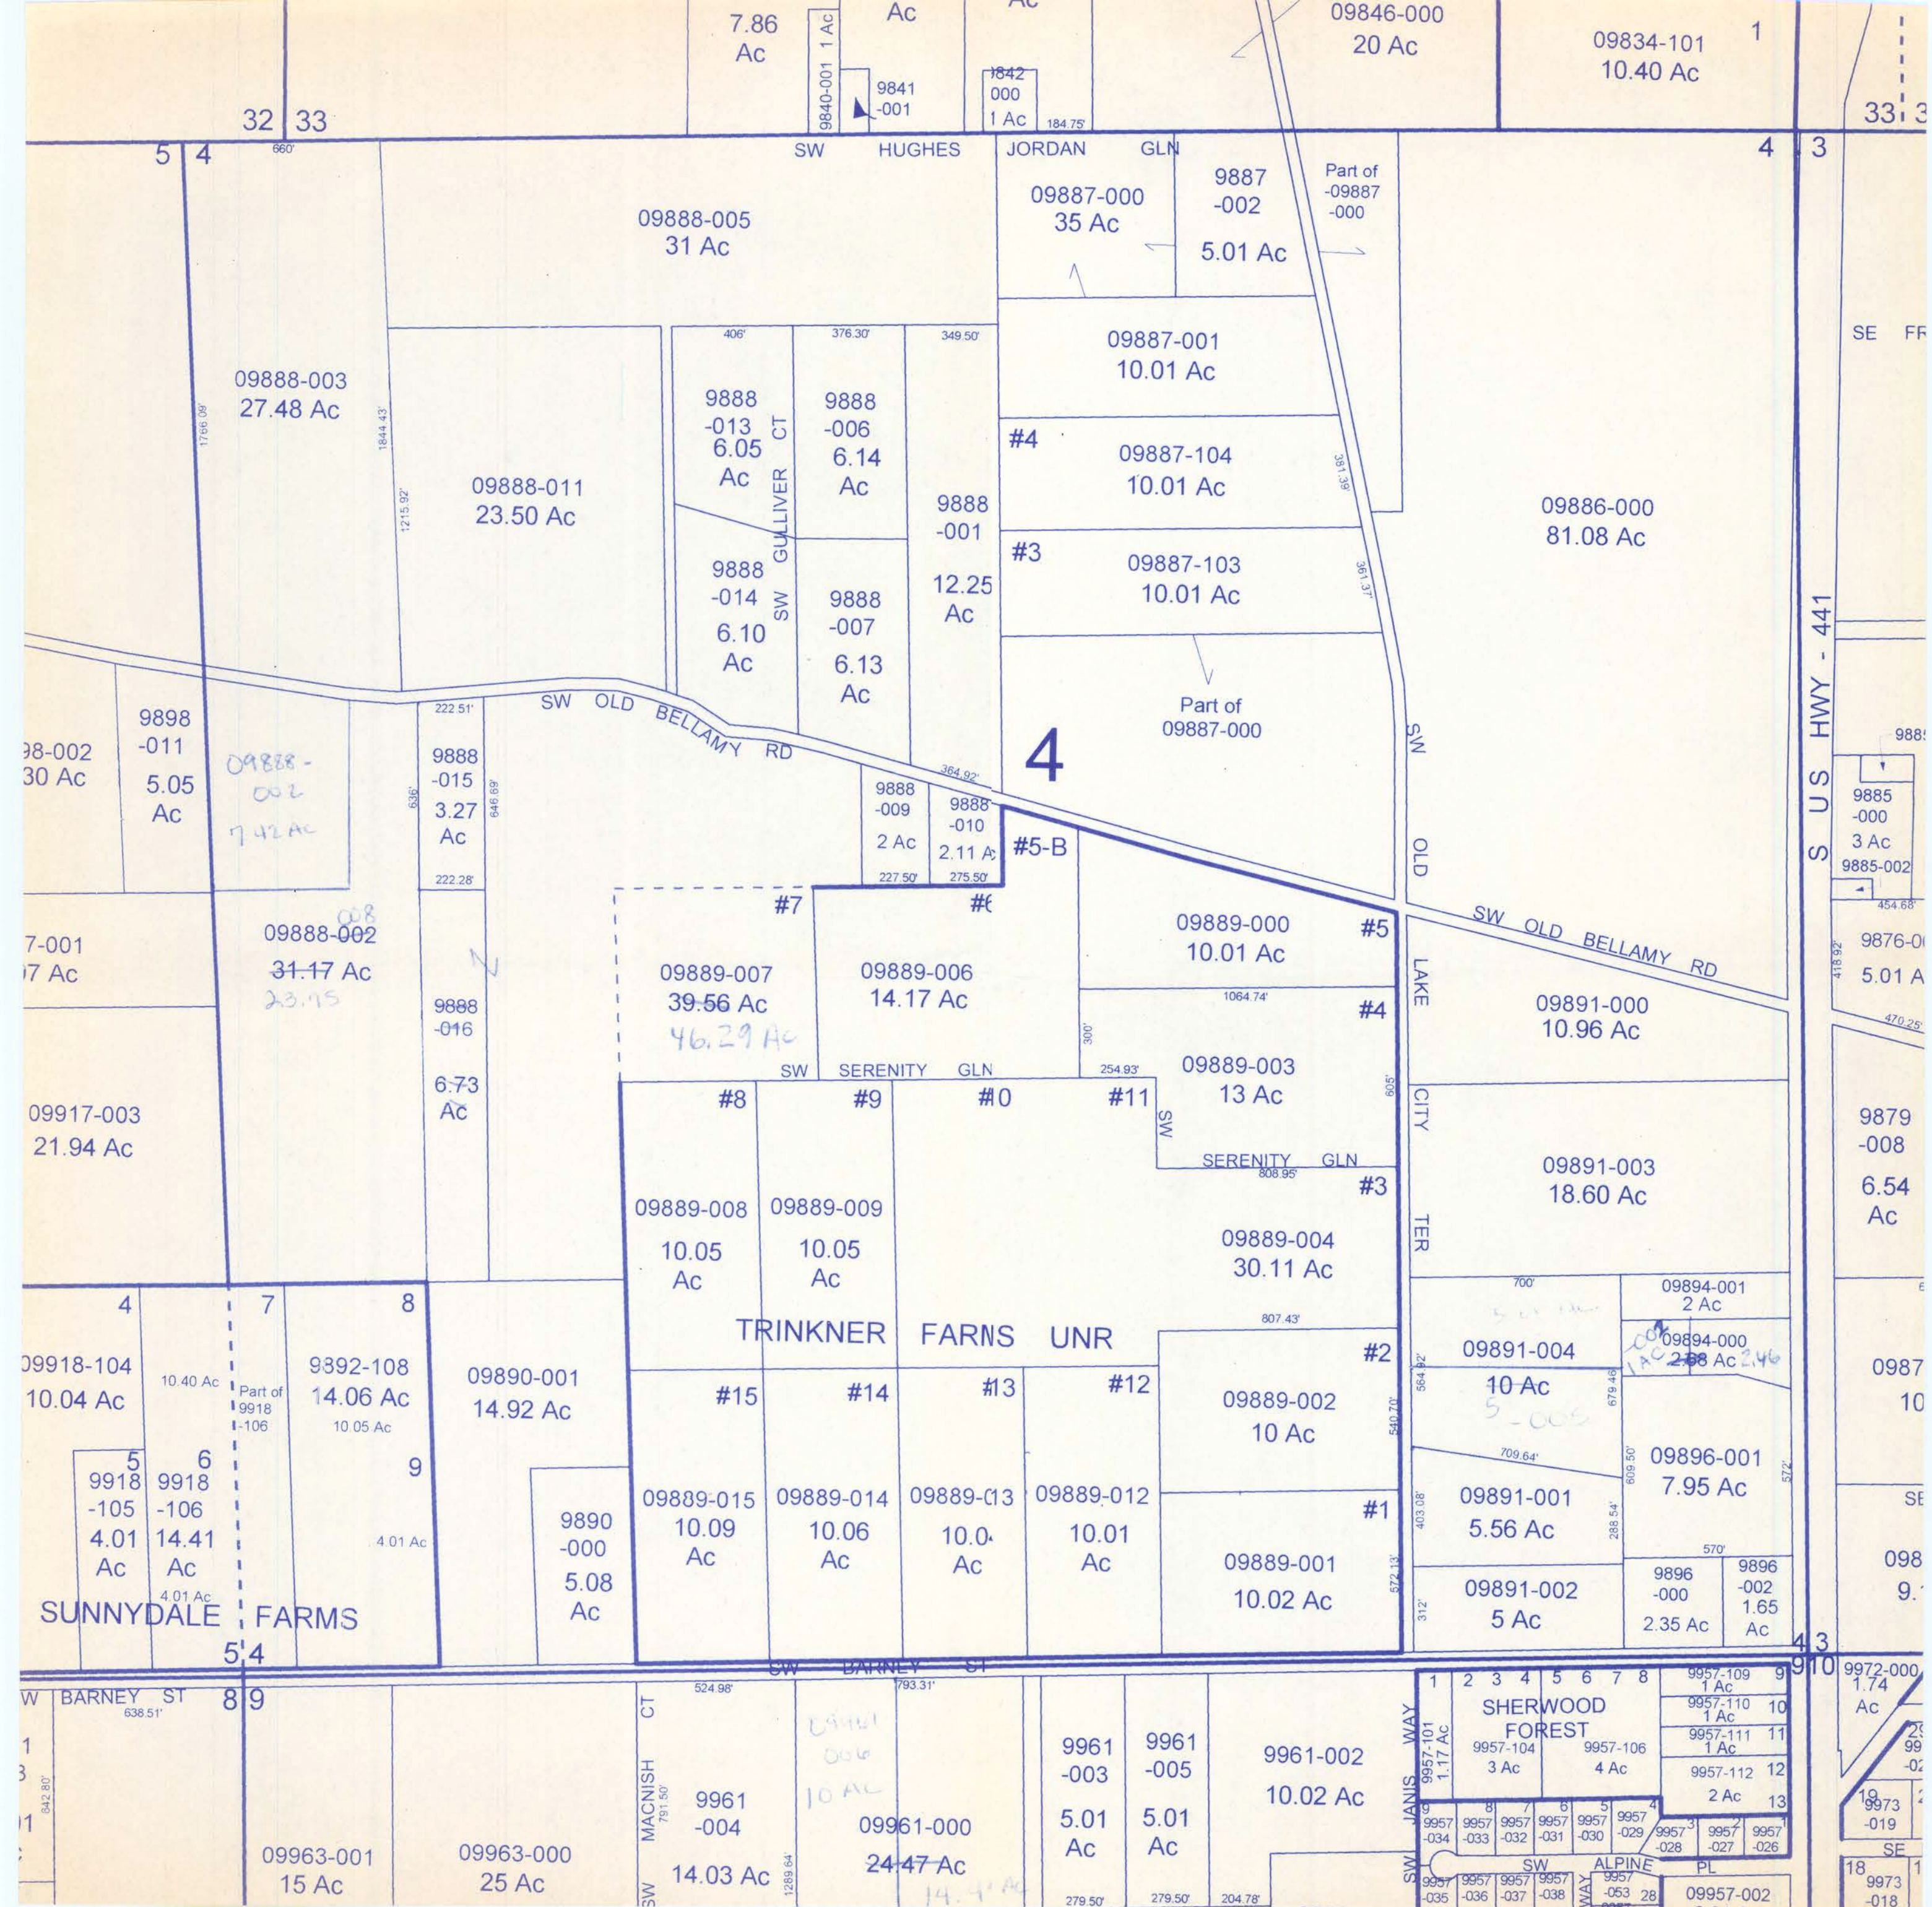

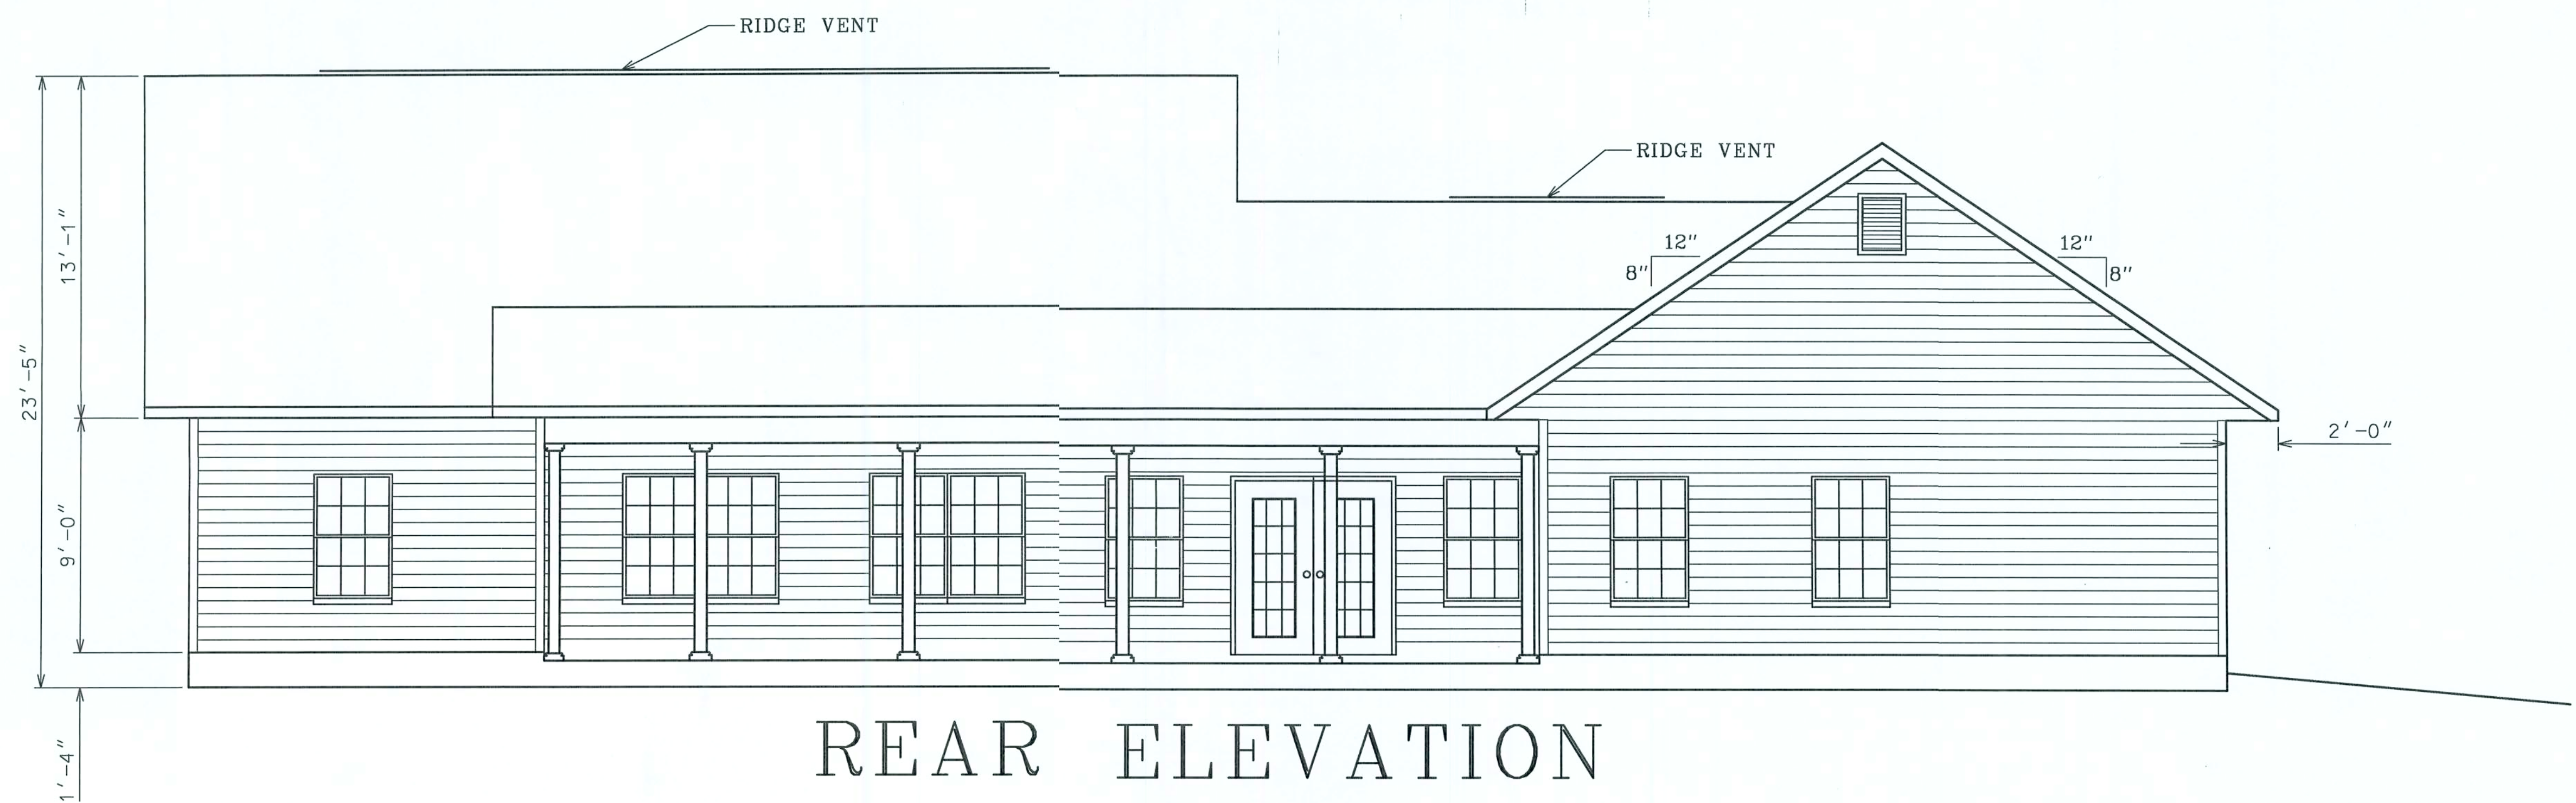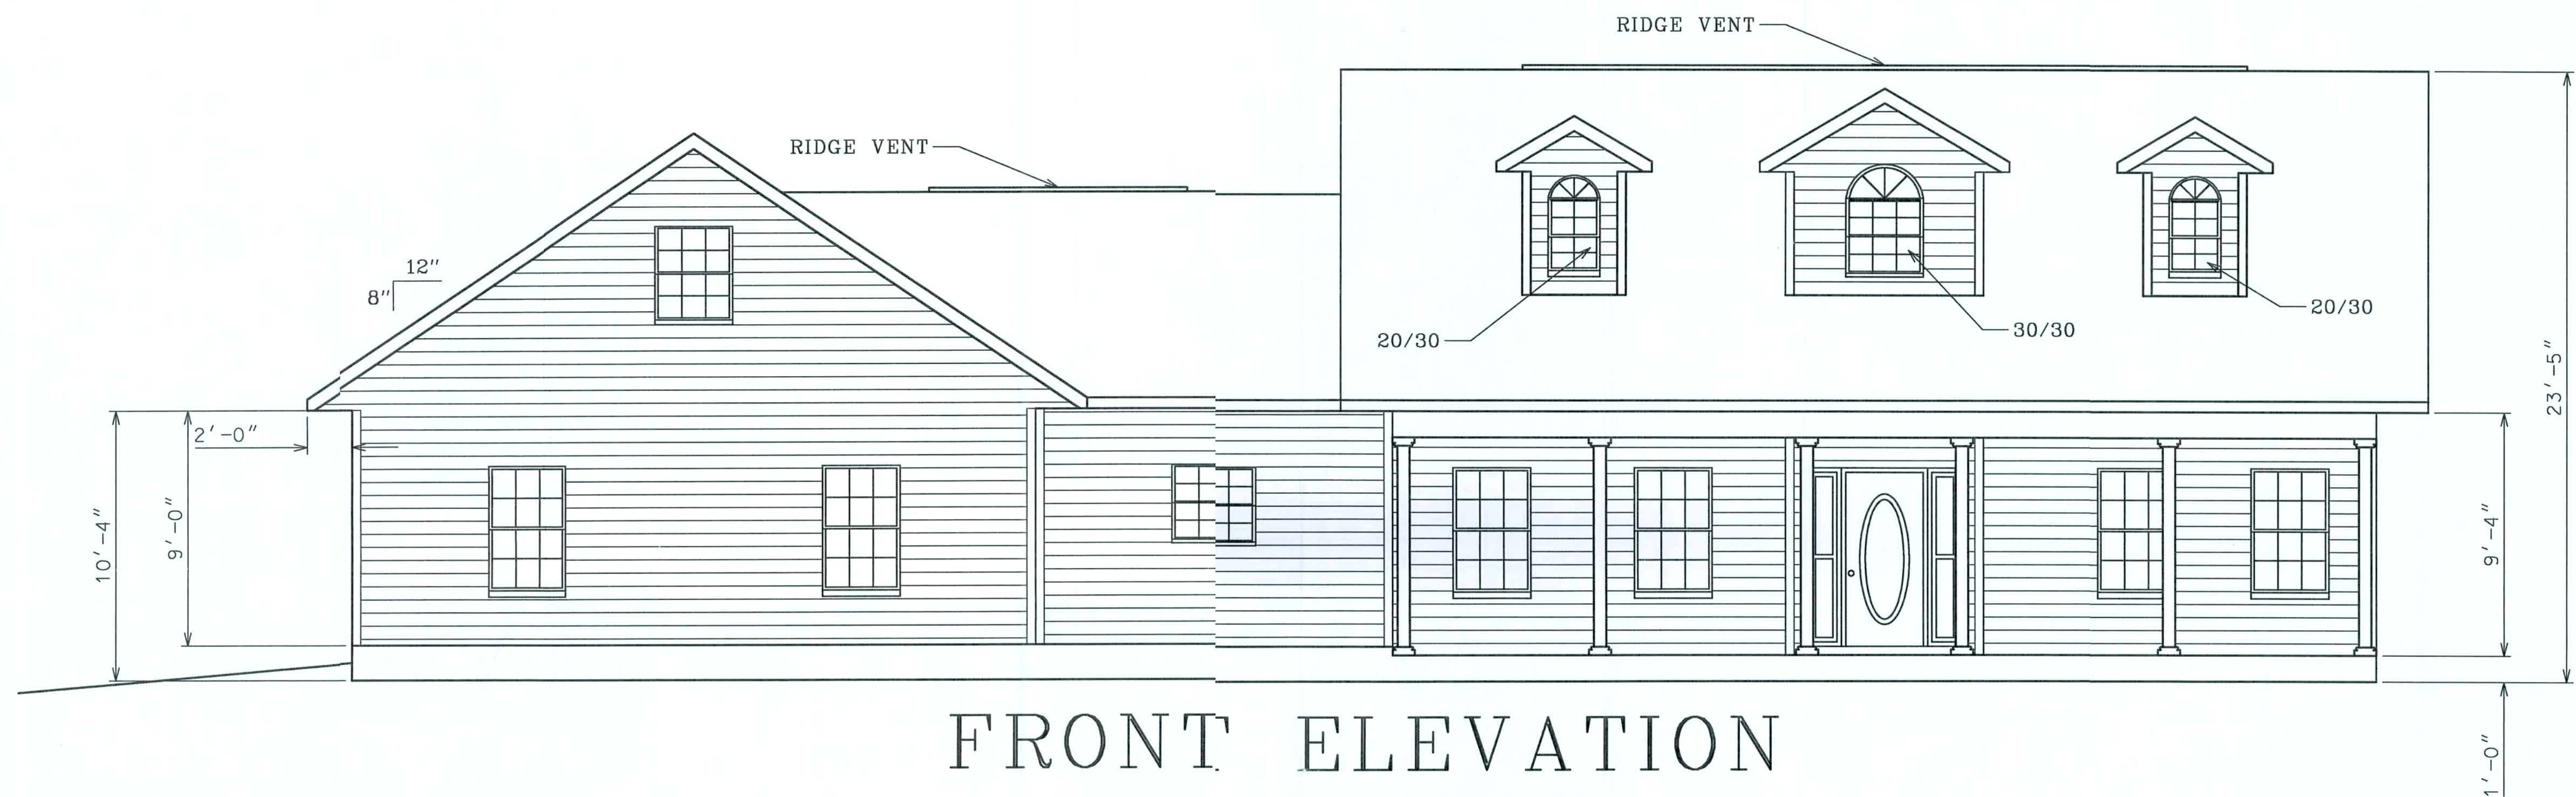

HAYGOOD HOMES INC.

12592 So. U.S. HWY 441
LAKE CITY FL 32025
OFFICE (386) 752-3496
MOBILE (386) 303-1981
CR-C1326715

JOHN AND JESSICA MacLAREN

LAKE CITY FLORIDA


ELEVATION

PLAN No.	SCALE	DATE	SHEET NO.
P 0601	1/4" = 1'	01/01/06	1

Office COPY



RIGHT ELEVATION

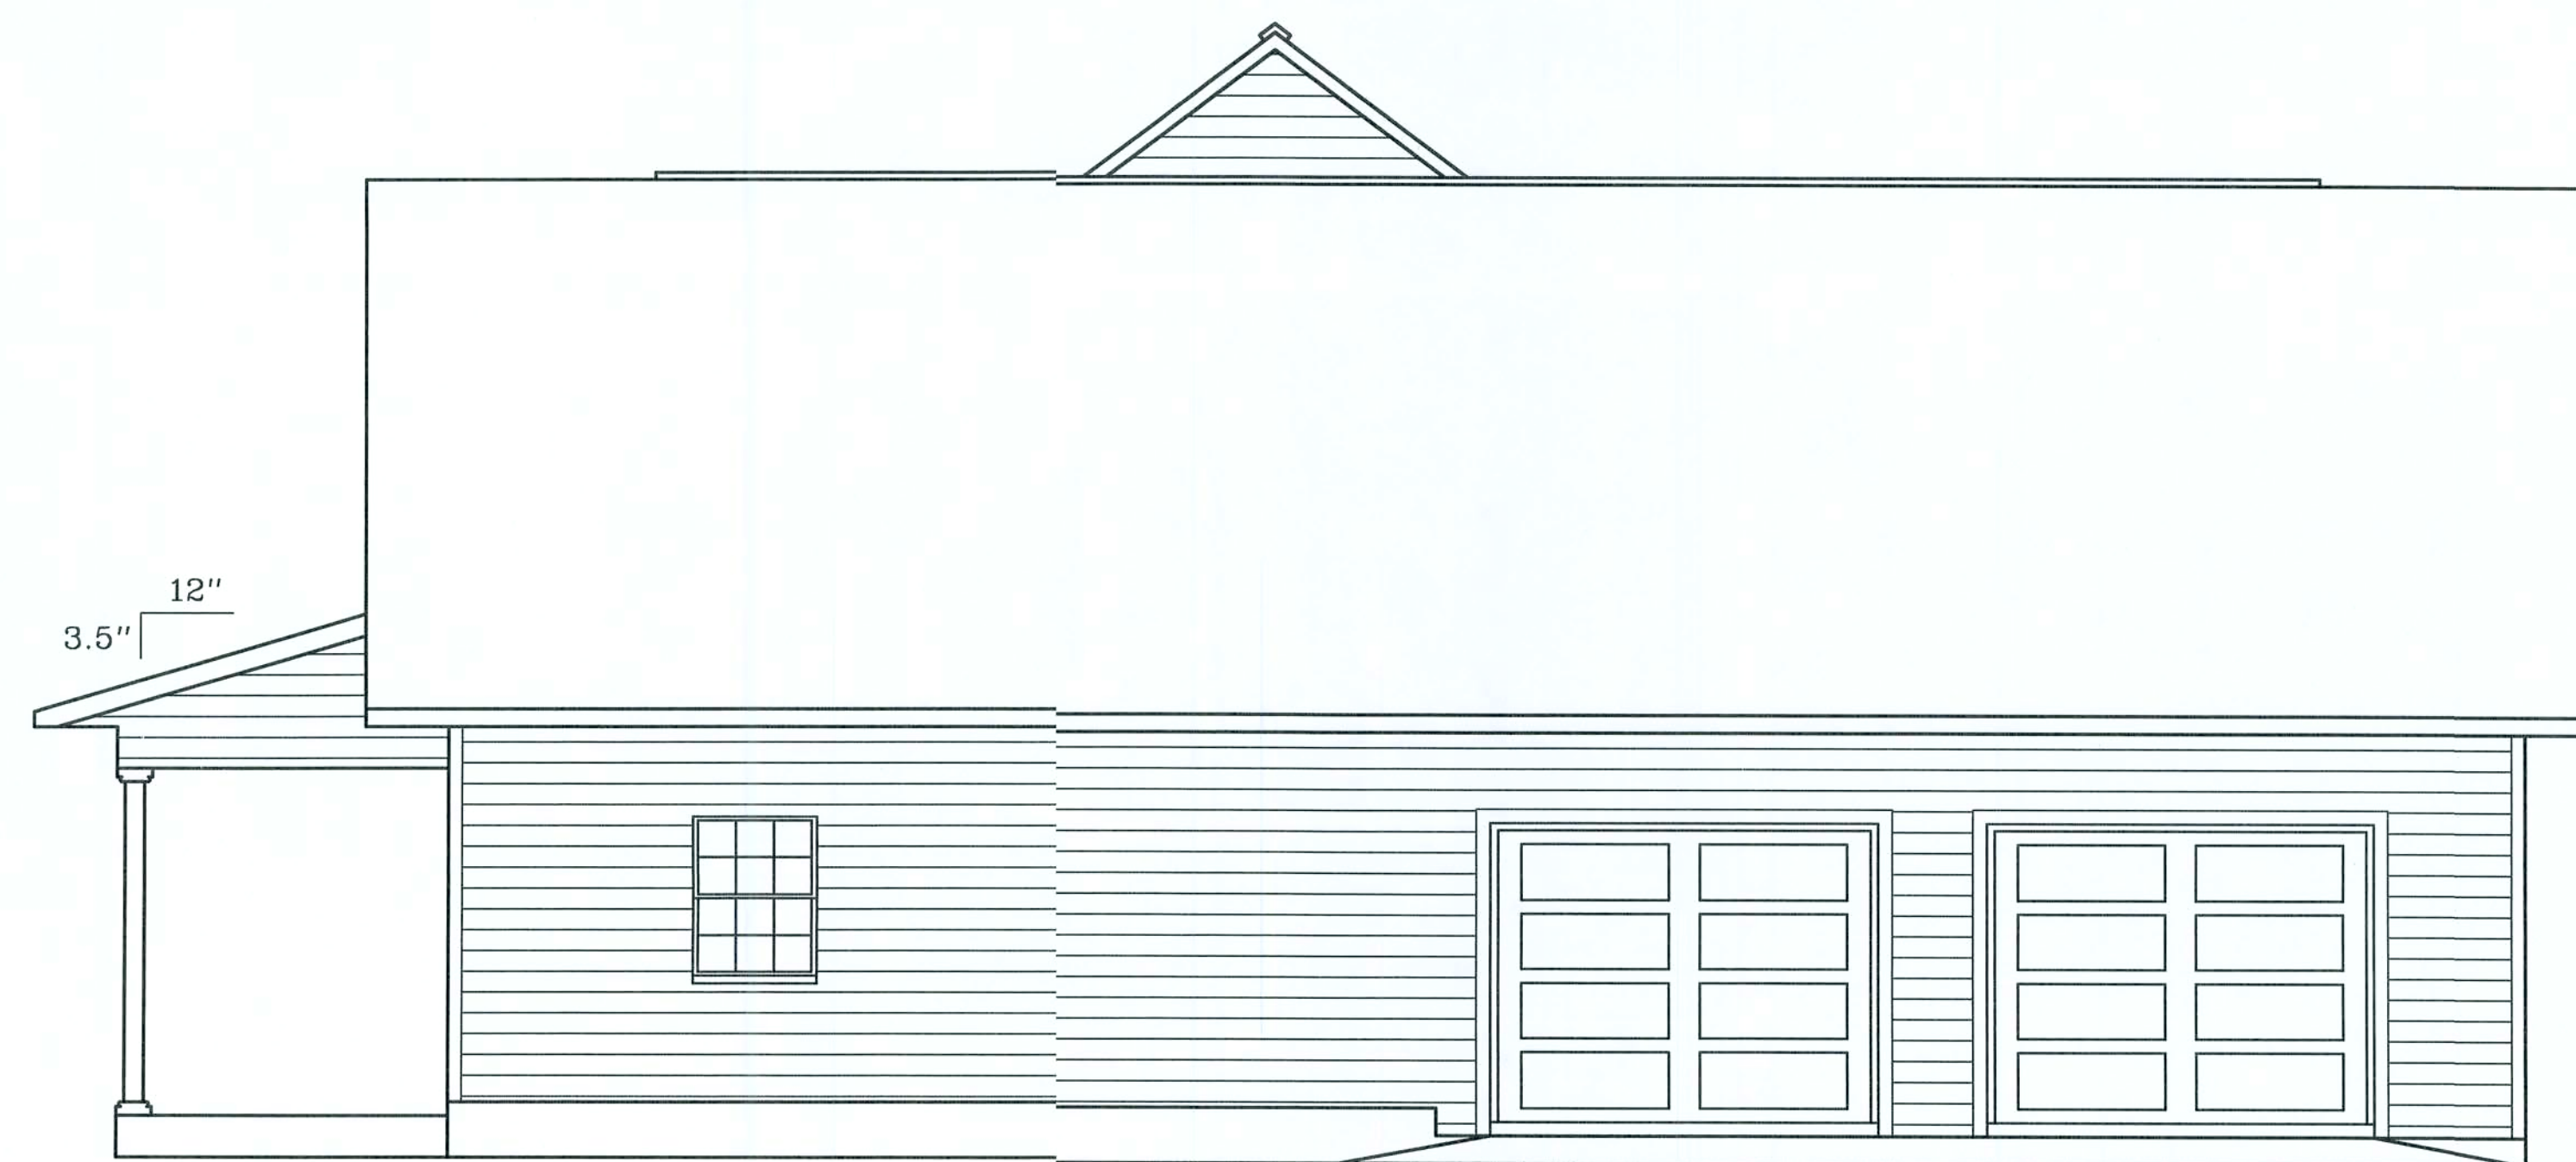

LEFT ELEVATION



HAYGOOD HOMES INC.

12592 So. U.S. HWY 441
LAKE CITY FL. 32025
OFFICE (386) 752-3496
MOBILE (386) 303-1981
CR-C1326715

JOHN AND JESSICA MacLAREN


LAKE CITY FLORIDA

ELEVATION

PLAN No.	SCALE	DATE	SHEET NO.
P 0601	1/4" = 1'	01/01/06	2

DOOR SCHEDULE	
No.	SIZE & TYPE
1	3' - 0" FRONT ENTRY WITH 2 LITES
1	6' - 0" DBL 3/0 FRENCH EXTERIOR 14 LITE
1	3' - 0" FRENCH EXTERIOR 14 LITE
1	3' - 0" 9 LITE ENTRY DOOR EXTERIOR
2	3' - 0" COLONIAL INTERIOR
5	2' - 8" COLONIAL INTERIOR
5	2' - 6" COLONIAL INTERIOR
2	2' - 0" COLONIAL INTERIOR
2	4' - 0" BIFOLD COLONIAL INTERIOR
2	9' - 7" GARAGE
1	2' - 0" SHOWER

WINDOW SCHEDULE	
No.	SIZE & TYPE
2	3' 0" - 5' 0" DBL SINGLE HUNG
13	3' 0" - 5' 0" SINGLE HUNG
2	3' 0" - 4' 0" SINGLE HUNG TEMP.
2	3' 0" - 3' 0" SINGLE HUNG
1	1' 0" - 3' 0" SOLID
2	2' 0" - 3' 0" SINGLE HUNG ARCH
1	3' 0" - 3' 0" SINGLE HUNG ARCH

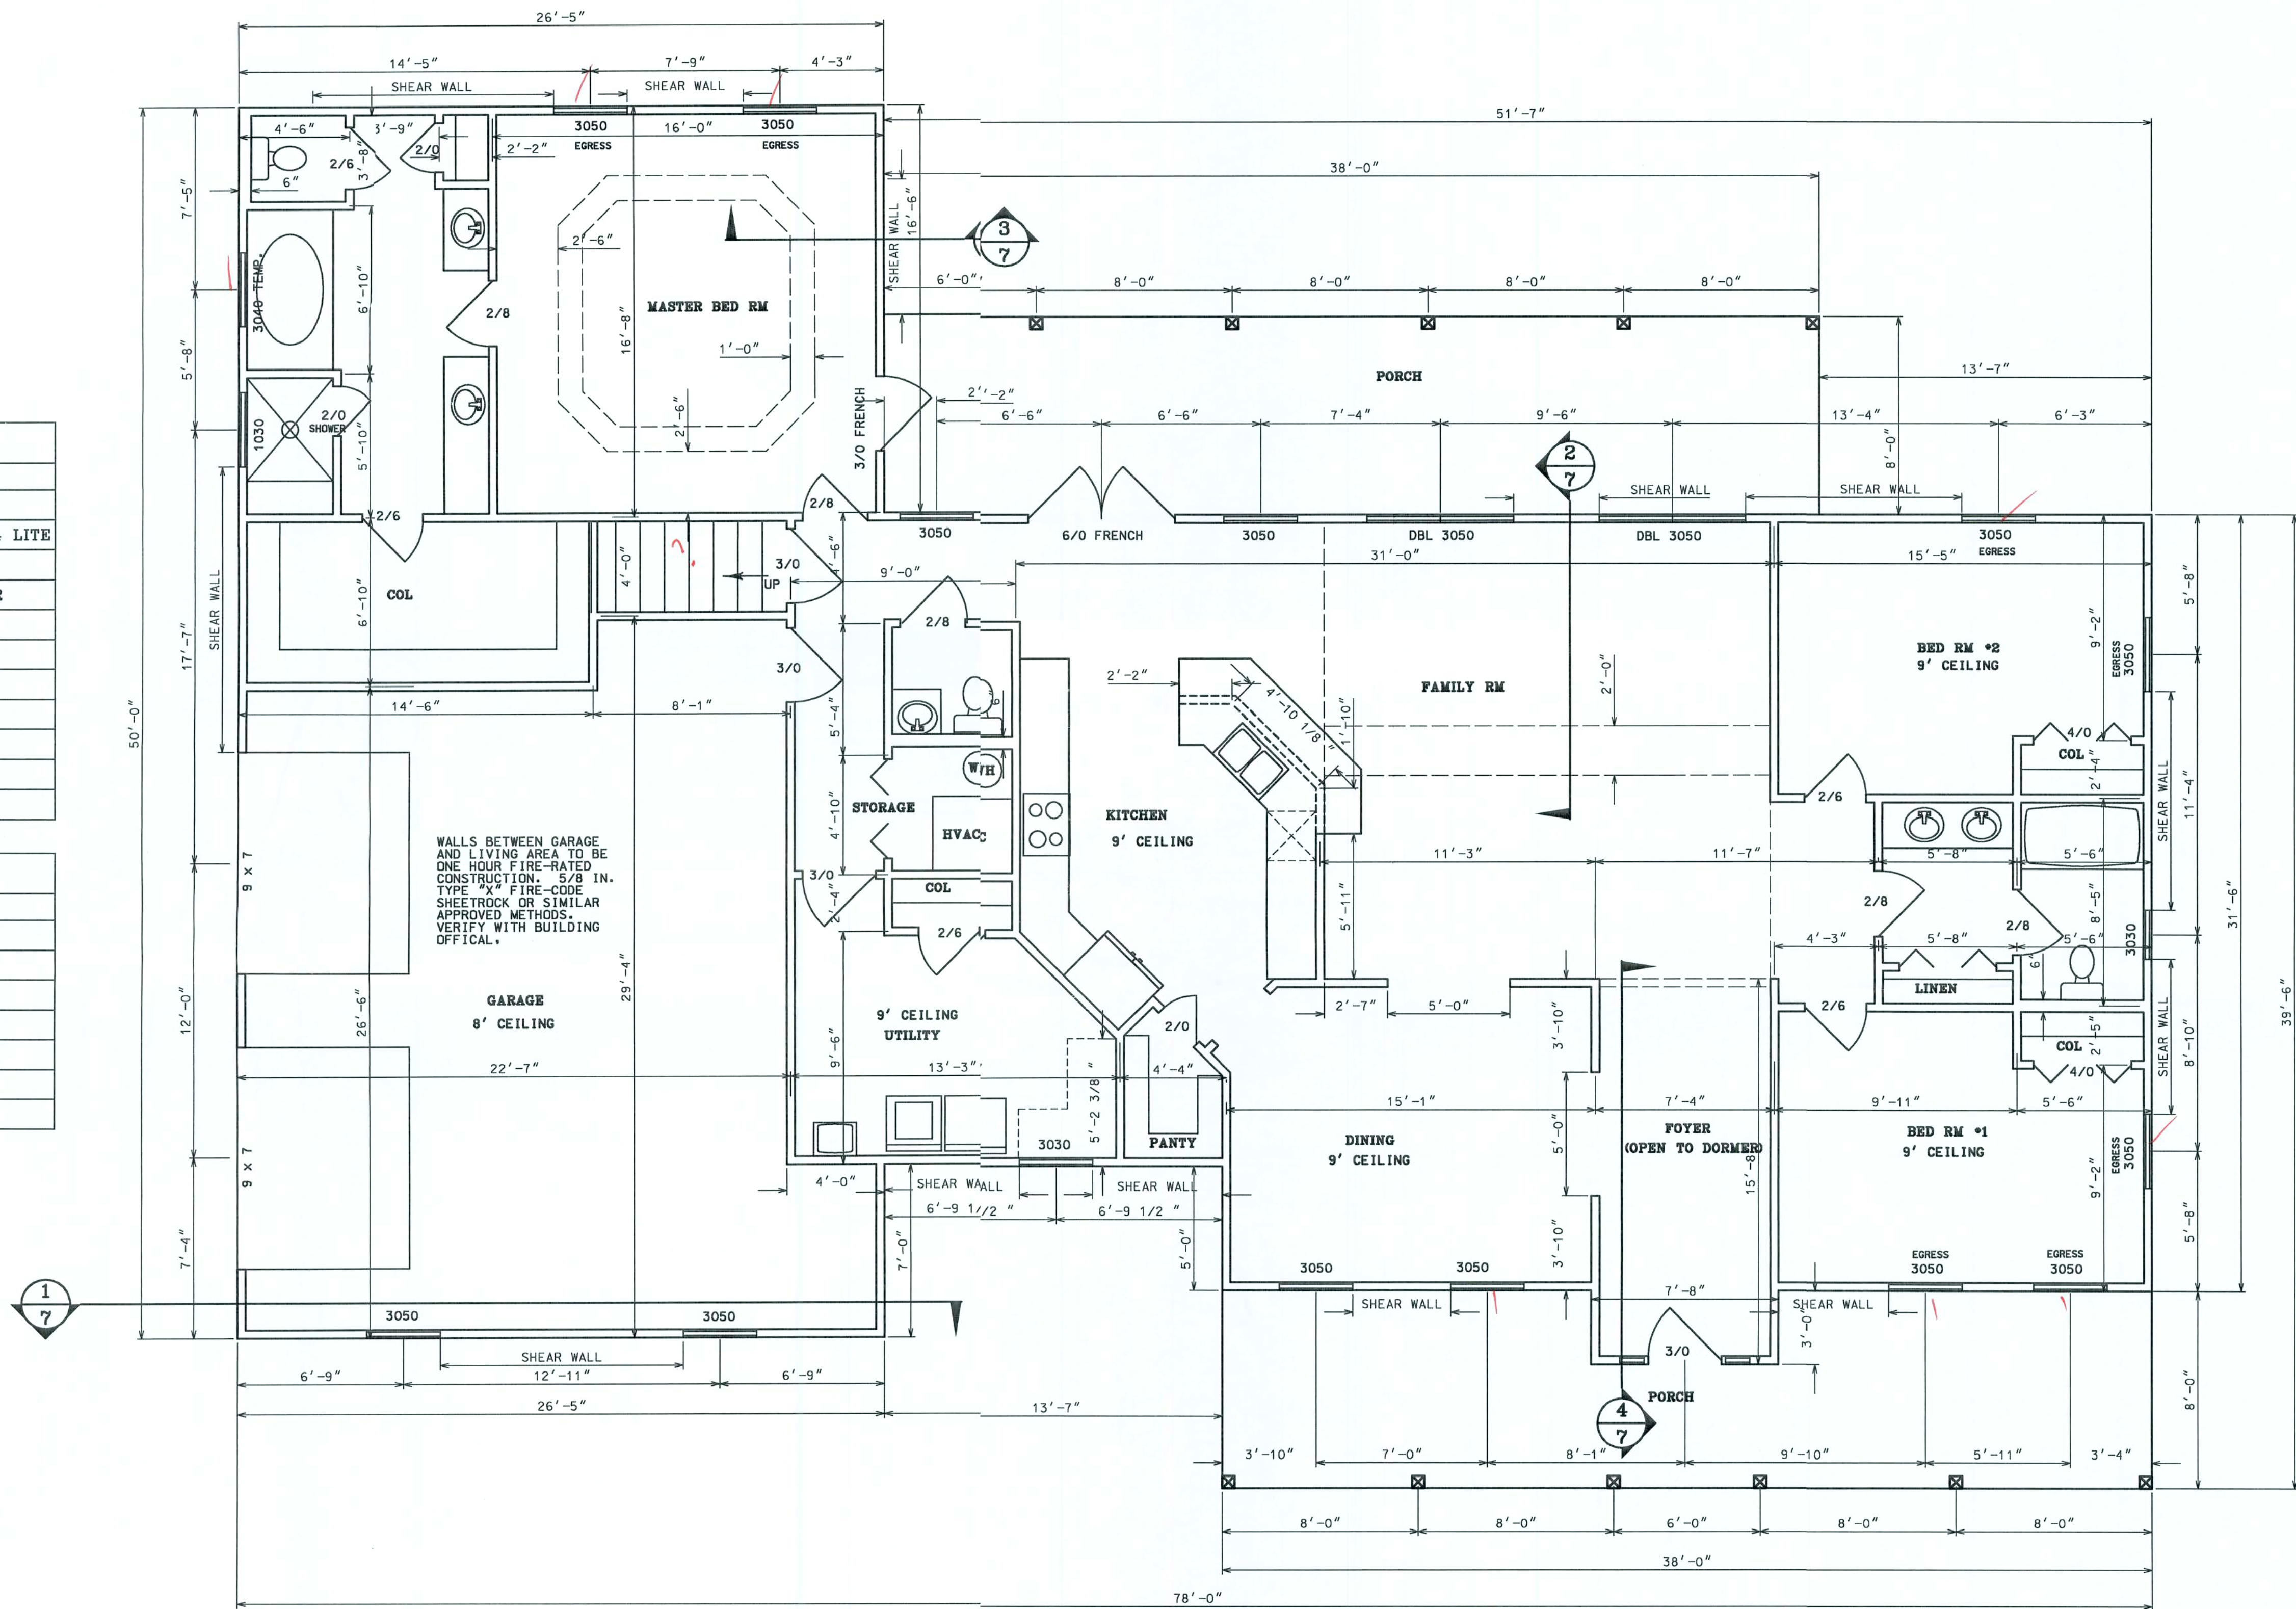

HEATED AREA	2230 SF
BONUS RM AREA	464 SF
GARAGE AREA	647 SF
PORCH AREA	608 SF
TOTAL AREA	3949 SF



HAYGOOD HOMES INC.


12592 So. U.S. HWY 441
LAKE CITY FL. 32025
OFFICE (386) 752-3496
MOBILE (386) 303-1981
CR-C1326715

JOHN AND JESSICA MacLAREN

LAKE CITY FLORIDA

FLOOR PLAN

PLAN No.	SCALE	DATE	SHEET NO.
P 0601	1/4" = 1'	01/15/06	3

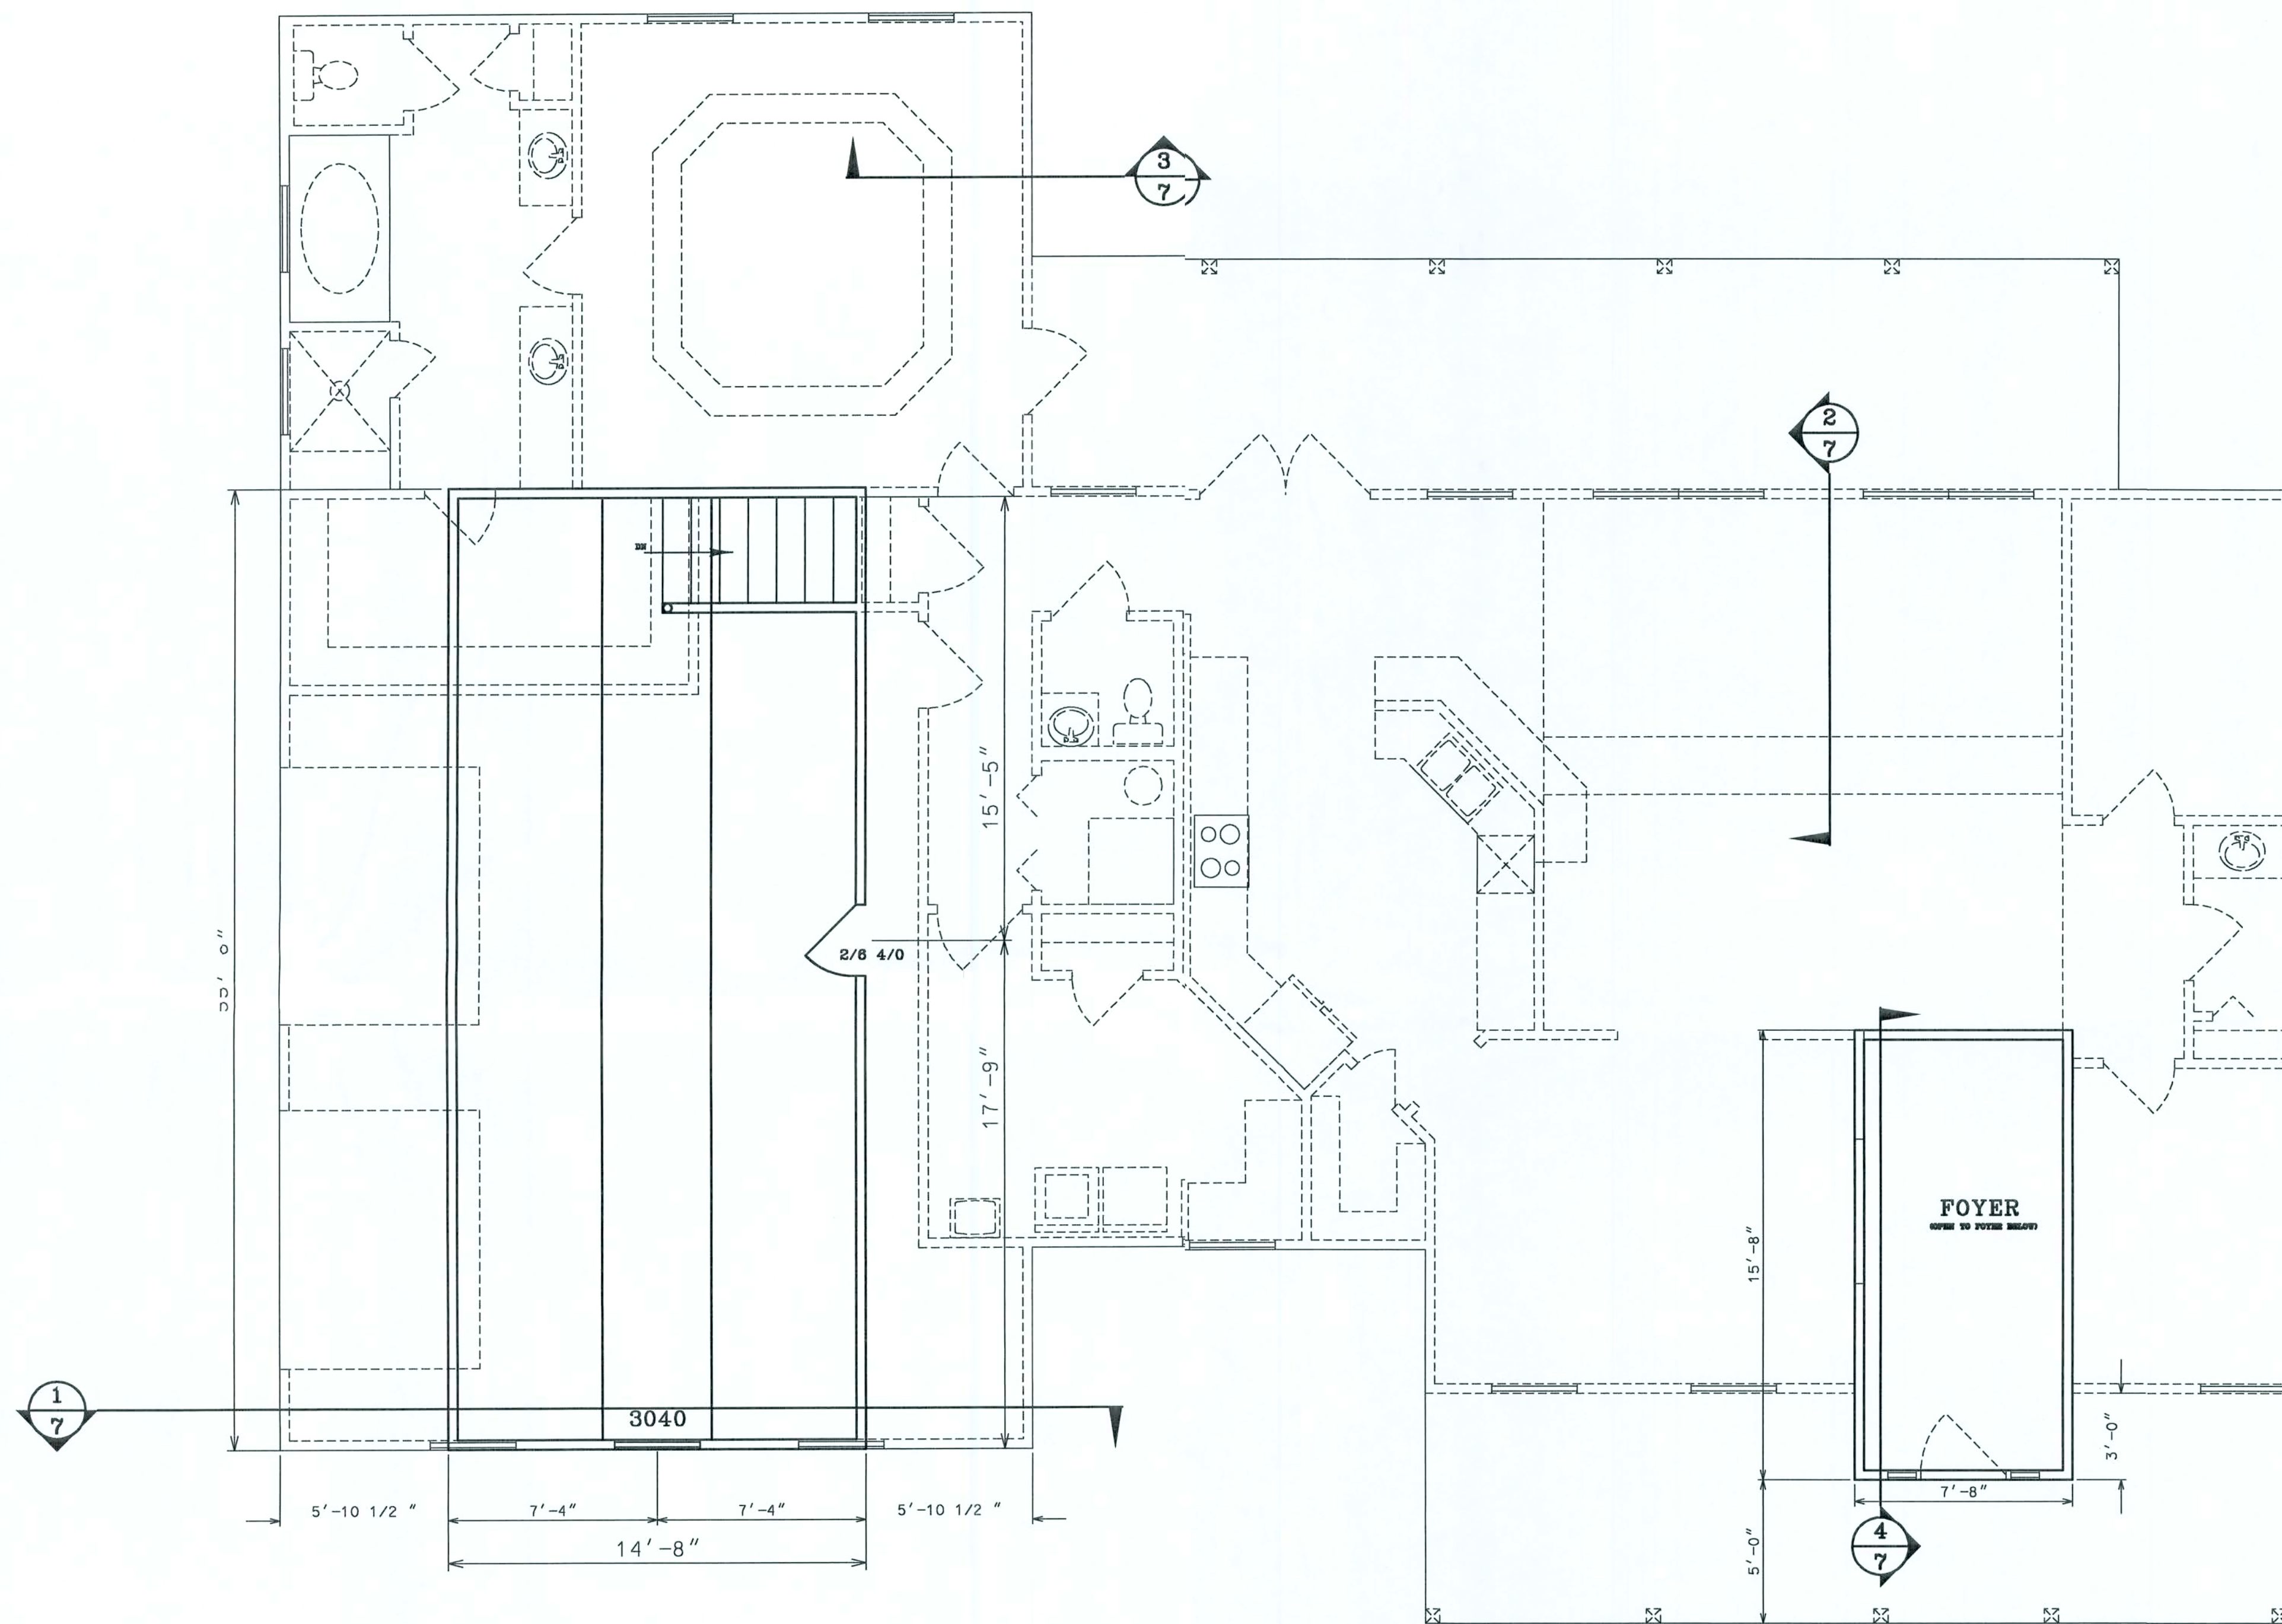

HAYGOOD HOMES INC.


12592 So. U.S. HWY 441
LAKE CITY FL. 32025
OFFICE (386) 752-3496
MOBILE (386) 303-1981
CR-C1326715

JOHN AND JESSICA MacLAREN

LAKE CITY FLORIDA


FLOOR PLAN

PLAN No.	SCALE	DATE	SHEET NO.
P 0601	1/4" = 1'	01/01/06	4

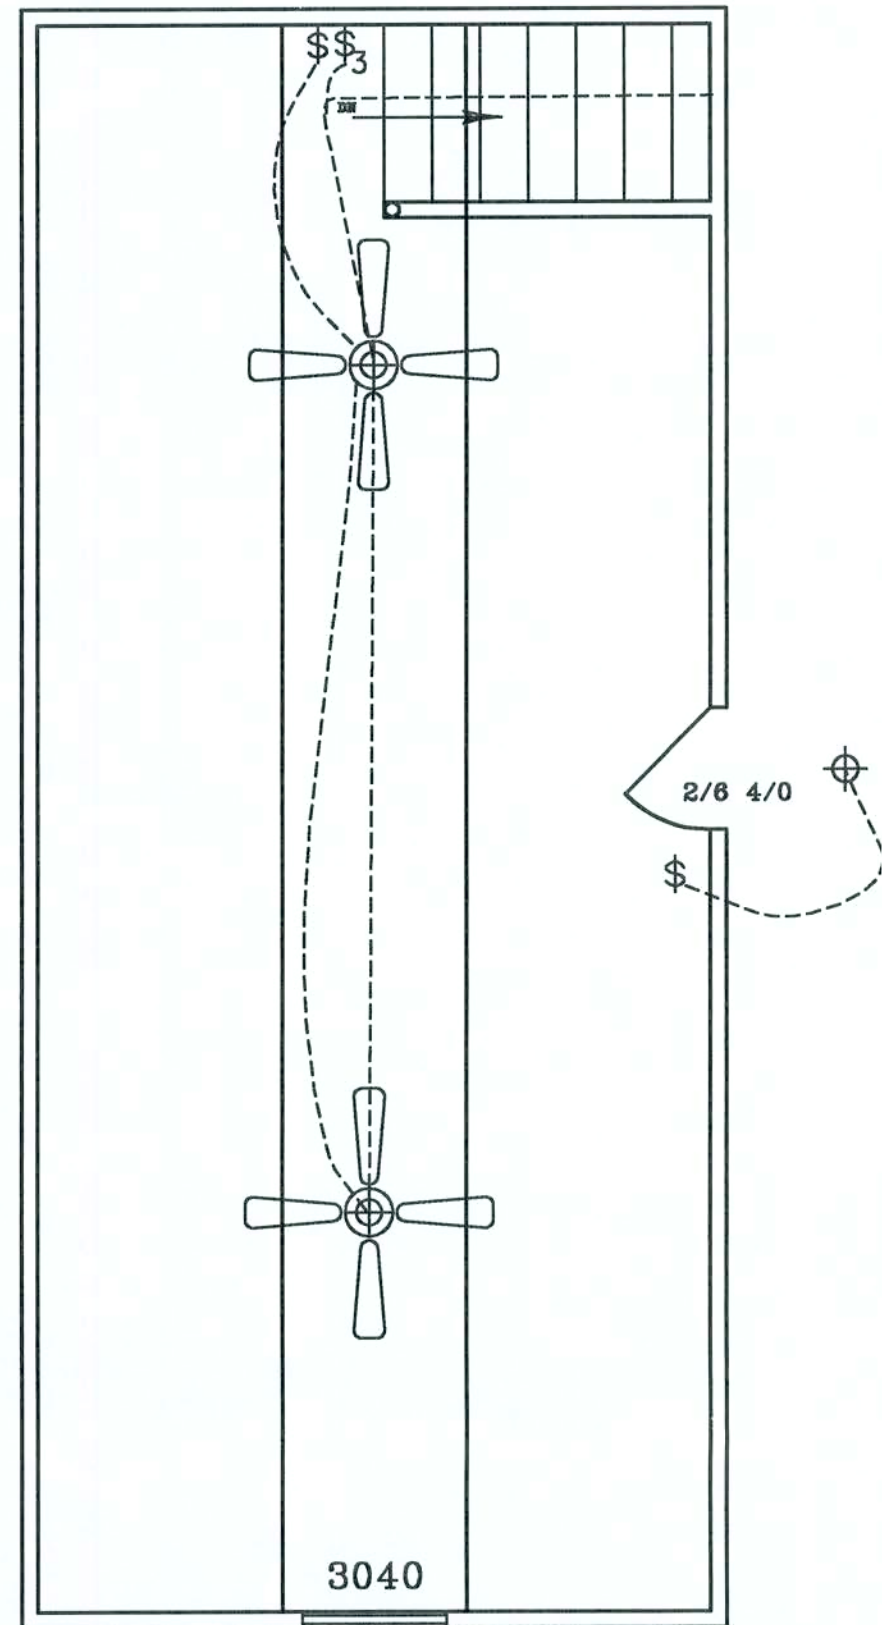

BONUS ROOM

- - METER BASE
- - VANITY LIGHT AS SPECIFIED
- ⊕ - LIGHT FIXTURE
- ⊙ - LIGHT FIXTURE
- \$ - SINGLE POLE SWITCH
- \$₃ - THREE-WAY SWITCH
- ⊕ - RECEPT.
- ⚡ - SECURITY LIGHT
- ⊗ - EXHAUST
- ⊙ - 220 V.
- Ⓢ - SMOKE DETECTOR (AC/DC and interconnected)
- ☎ - TELEPHONE
- ⊕TV - TELEVISION

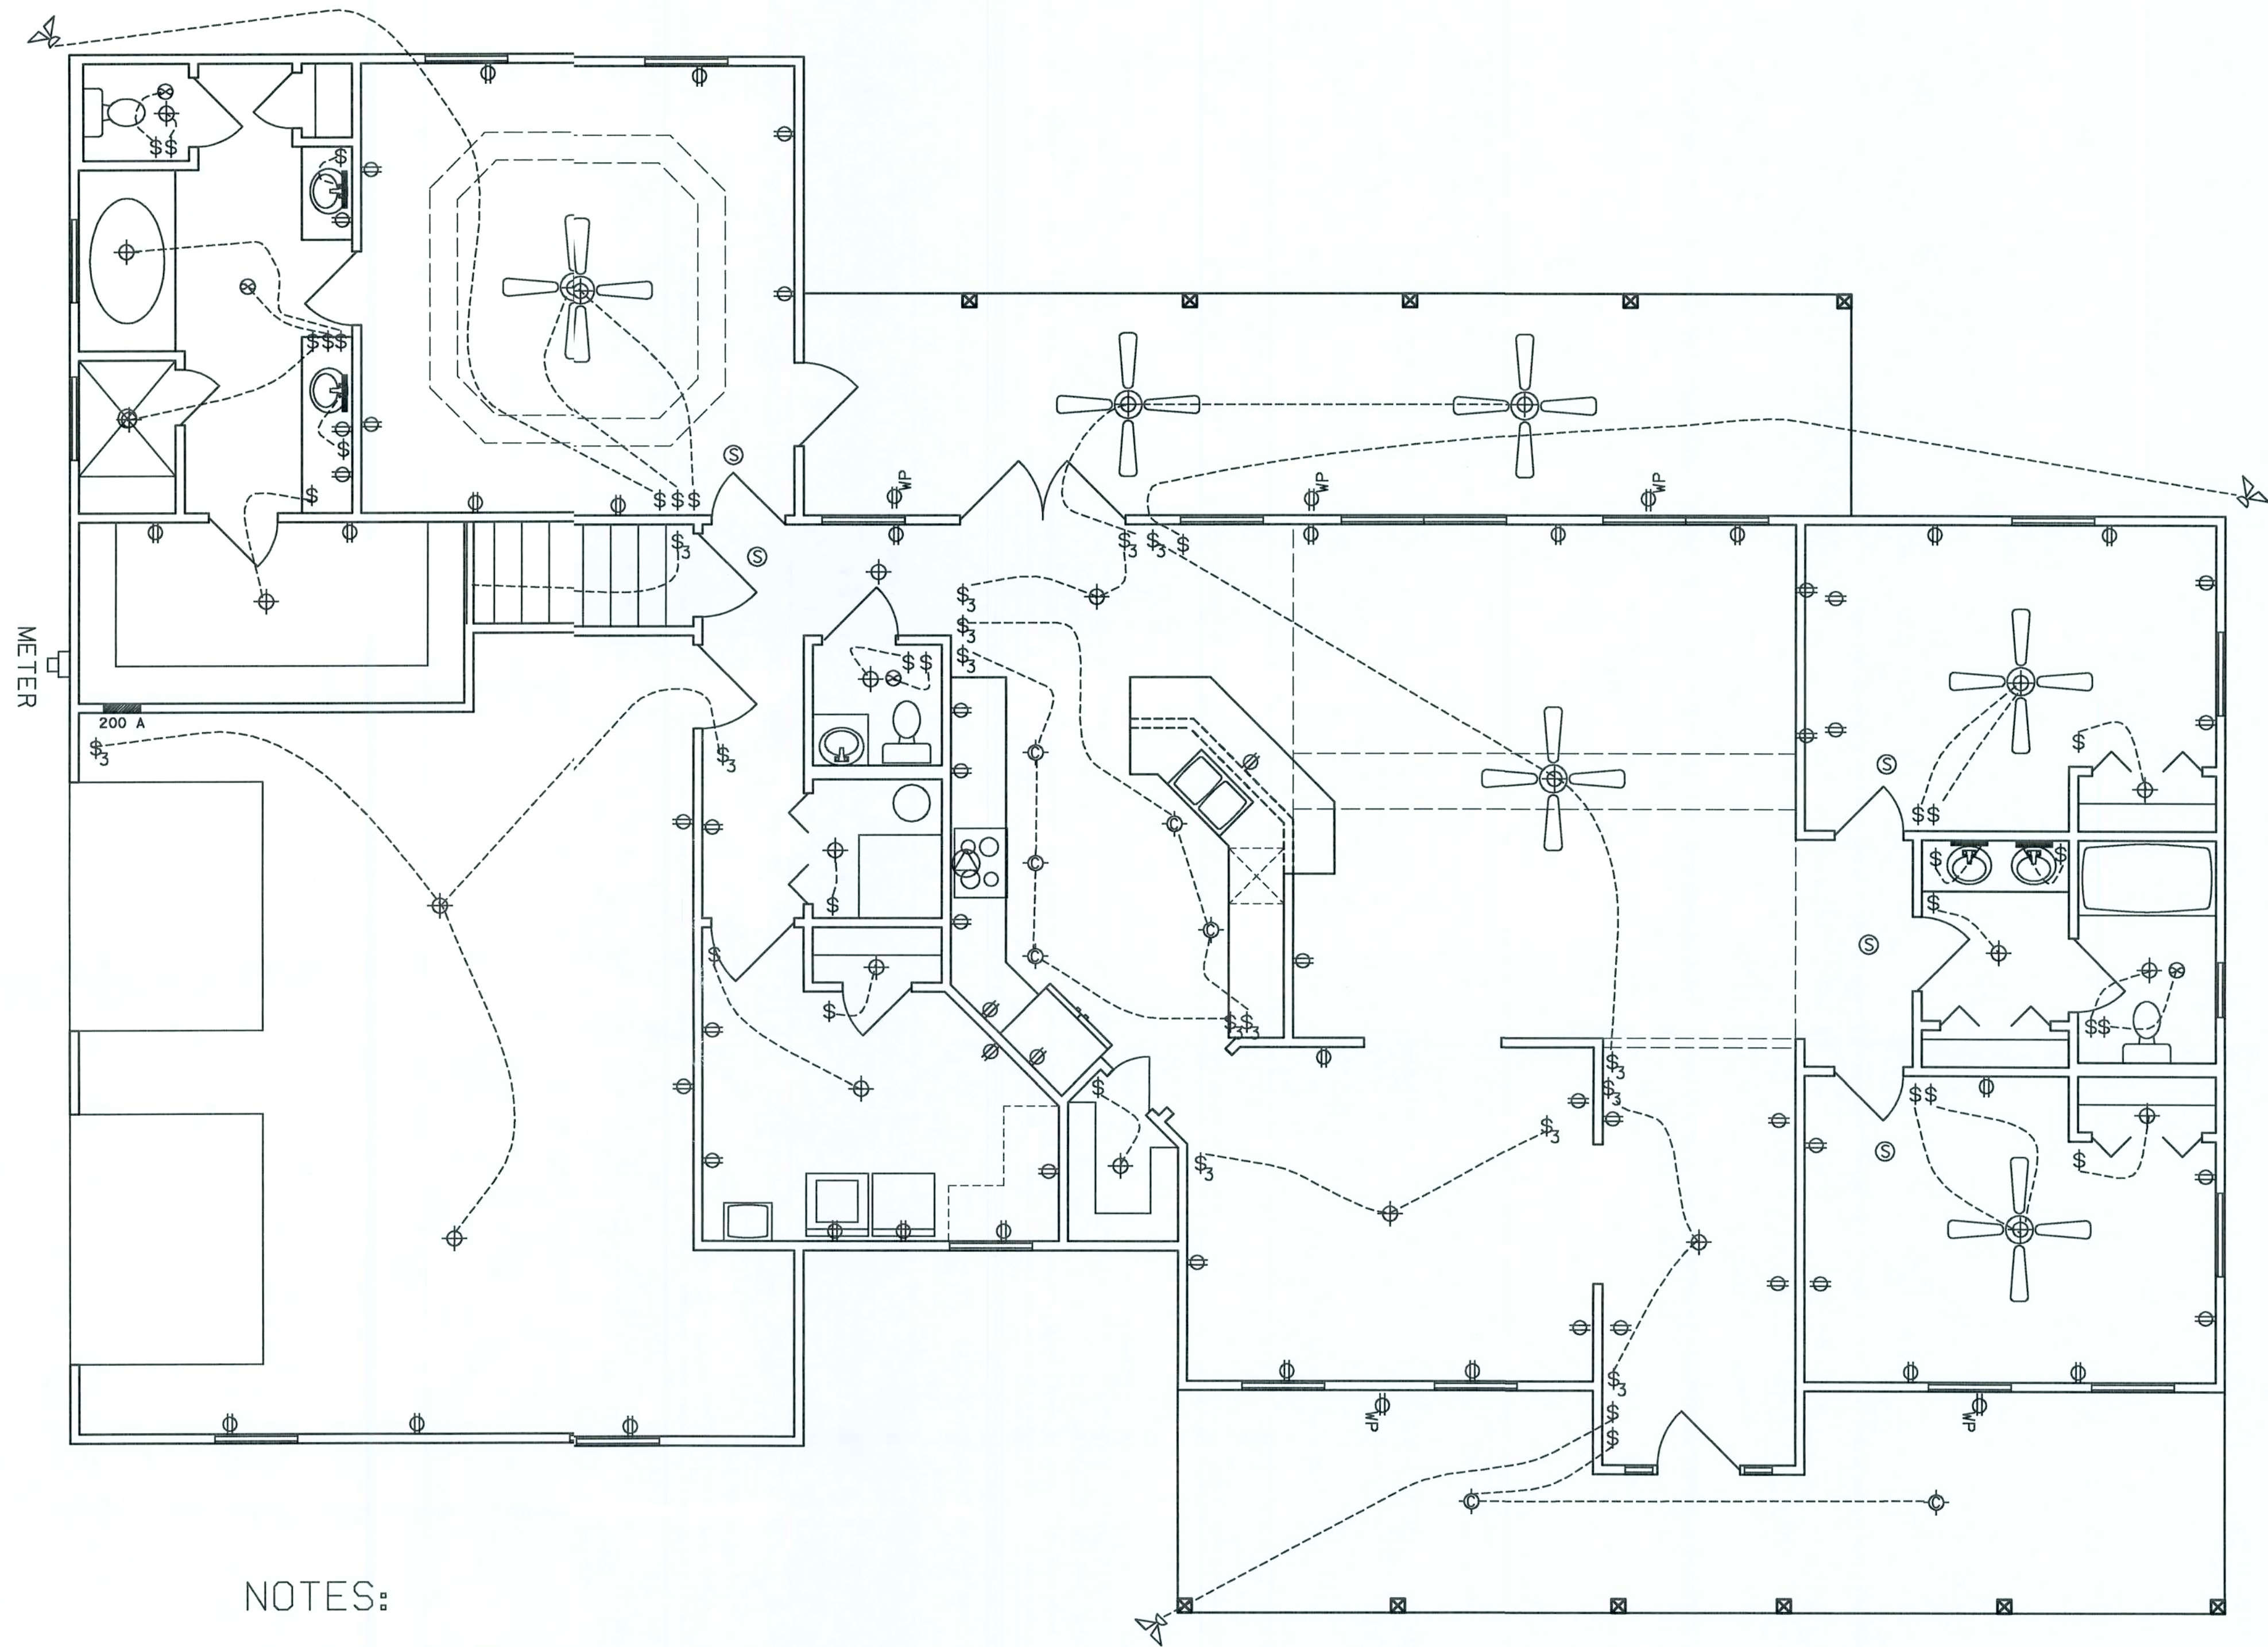

NOTES:

- 1.) PULL HOMERUNS (OF TELEPHONE CABLE AND COAX CABLE TO COMMUNICATION PANEL (NO JUNCTIONS ALLOWED IN ATTIC))
- 2.) ALL EXTERIOR RECEPTACLES SHALL EITHER BE GFI RECPTS OR PART OF A GFI CIRCUIT. ALL EXTERIOR RECEPTACLES SHALL BE WEATHERPROOF.
- 3.) ALL BATHROOM, KITCHEN, AND GARAGE RECEPTS SHALL BE PART OF A GFI CIRCUIT.
- 4.) ALL BEDROOM RECEPTS SHALL BE PART OF AN AFI CIRCUIT.

NOTE:

THE ELECTRICAL PLAN IS INTENDED TO SHOW SCHEMATICALLY THE LAYOUT OF THE ELECTRICAL COMPONENTS. FINAL LOCATIONS AND SIZING OF THE COMPONENTS SHALL BE THE RESPONSIBILITY OF A LICENSED ELECTRICAL CONTRACTOR. ALL WORK SHALL BE PERFORMED IN ACCORDANCE WITH ALL APPLICABLE CODES.



HAYGOOD HOMES INC.


12592 So. U.S. HWY 441
LAKE CITY FL. 32025
OFFICE (386) 752-3496
MOBILE (386) 303-1981
CR-C1326715

JOHN AND JESSICA MacLAREN

LAKE CITY FLORIDA

ELECTRICAL PLAN

PLAN No.	SCALE	DATE	SHEET NO.
P 0506	1/4" = 1'	8/10/05	5

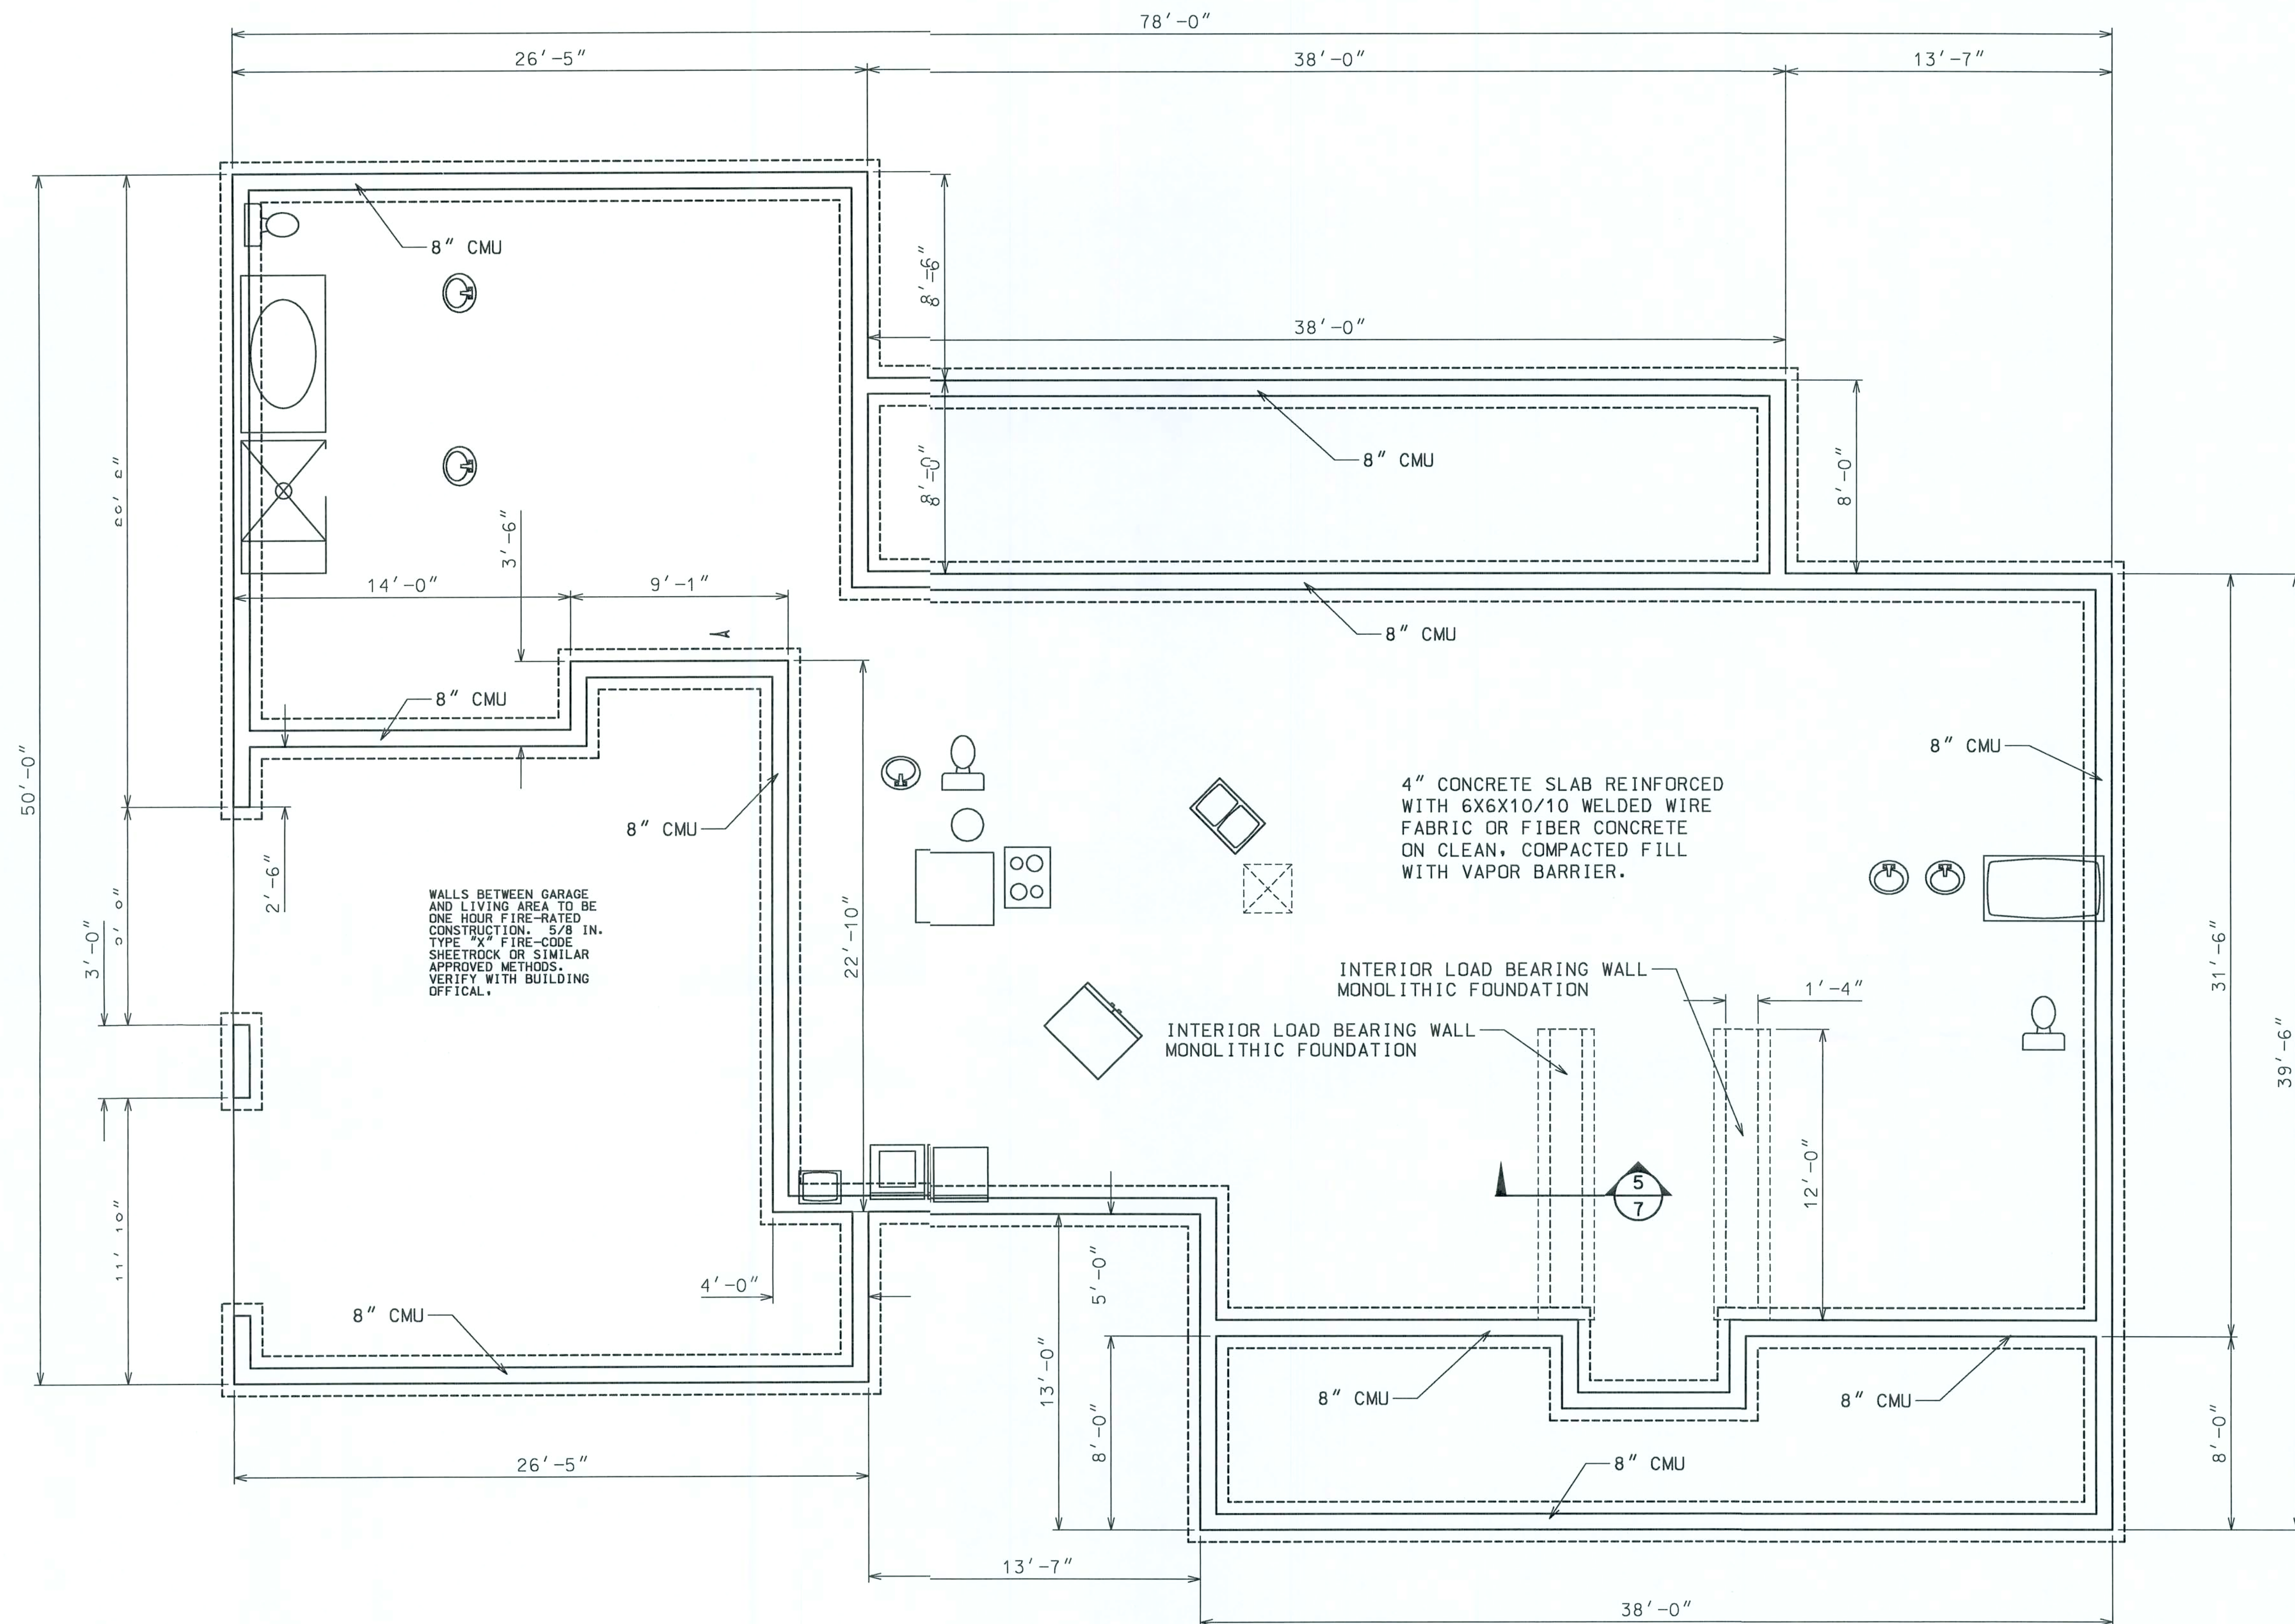

HAYGOOD HCMES INC.


12592 So. U.S. HWY 441
LAKE CITY FL 32025
OFFICE (386) 752-3496
MOBILE (386) 303-1981
CR-C1326715

JOHN AND JESSICA MacLAREN


LAKE CITY FLORIDA

FOUNDATION


PLAN No.	SCALE	DATE	SHEET NO.
P 0601	1/4" = 1'	01/18/06	6

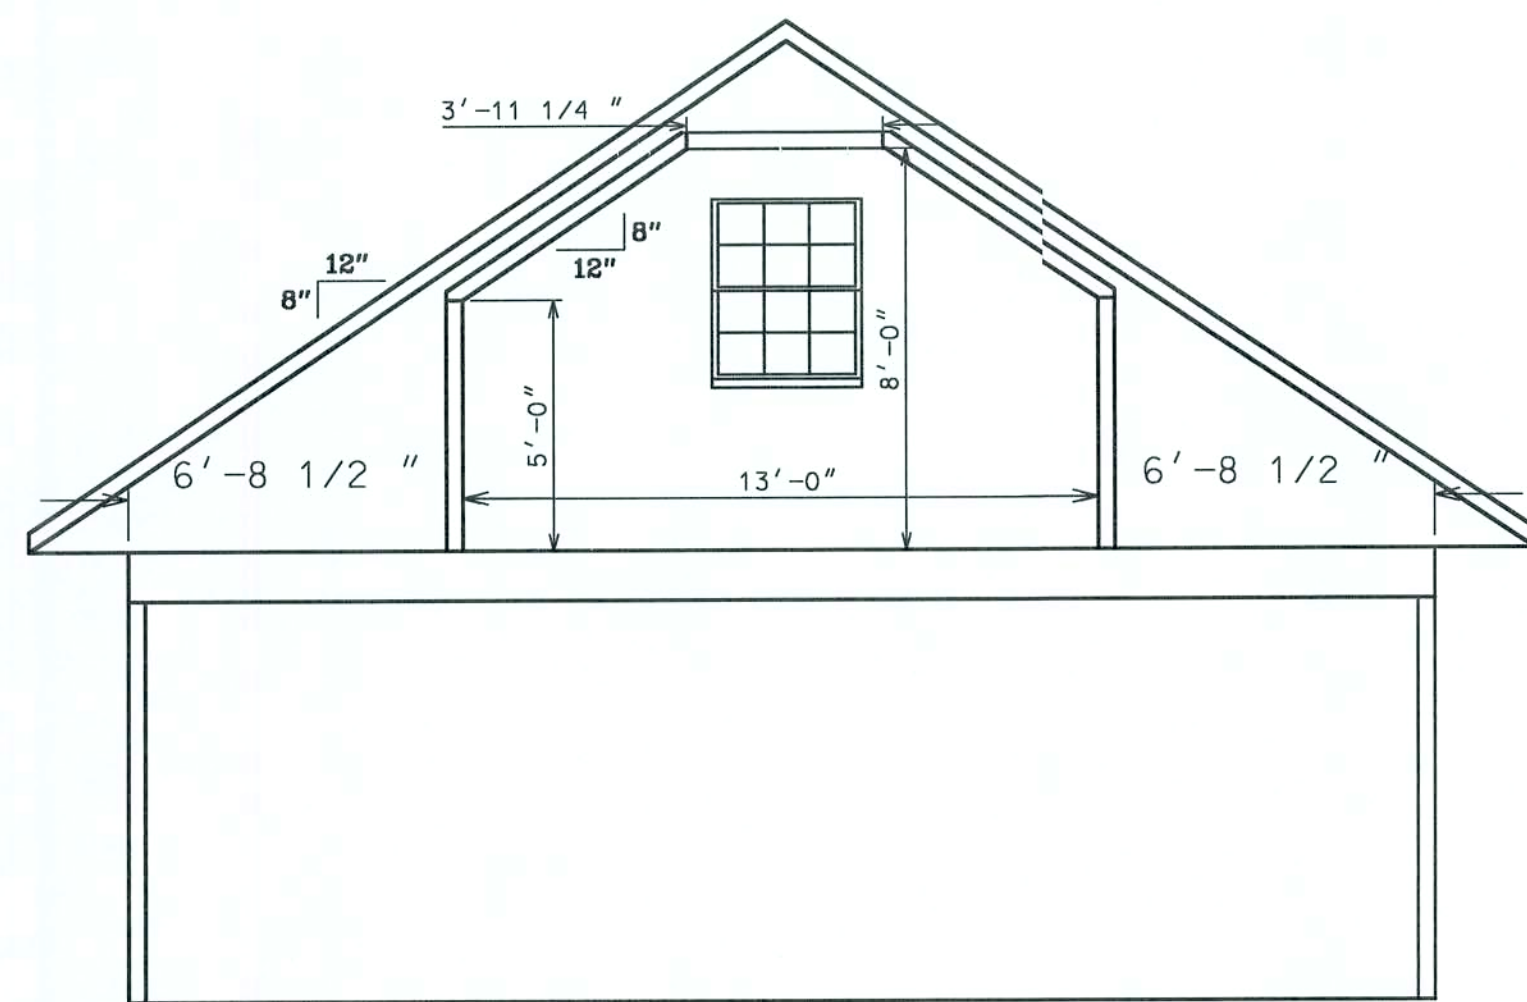


BONUS ROOM (1/7)

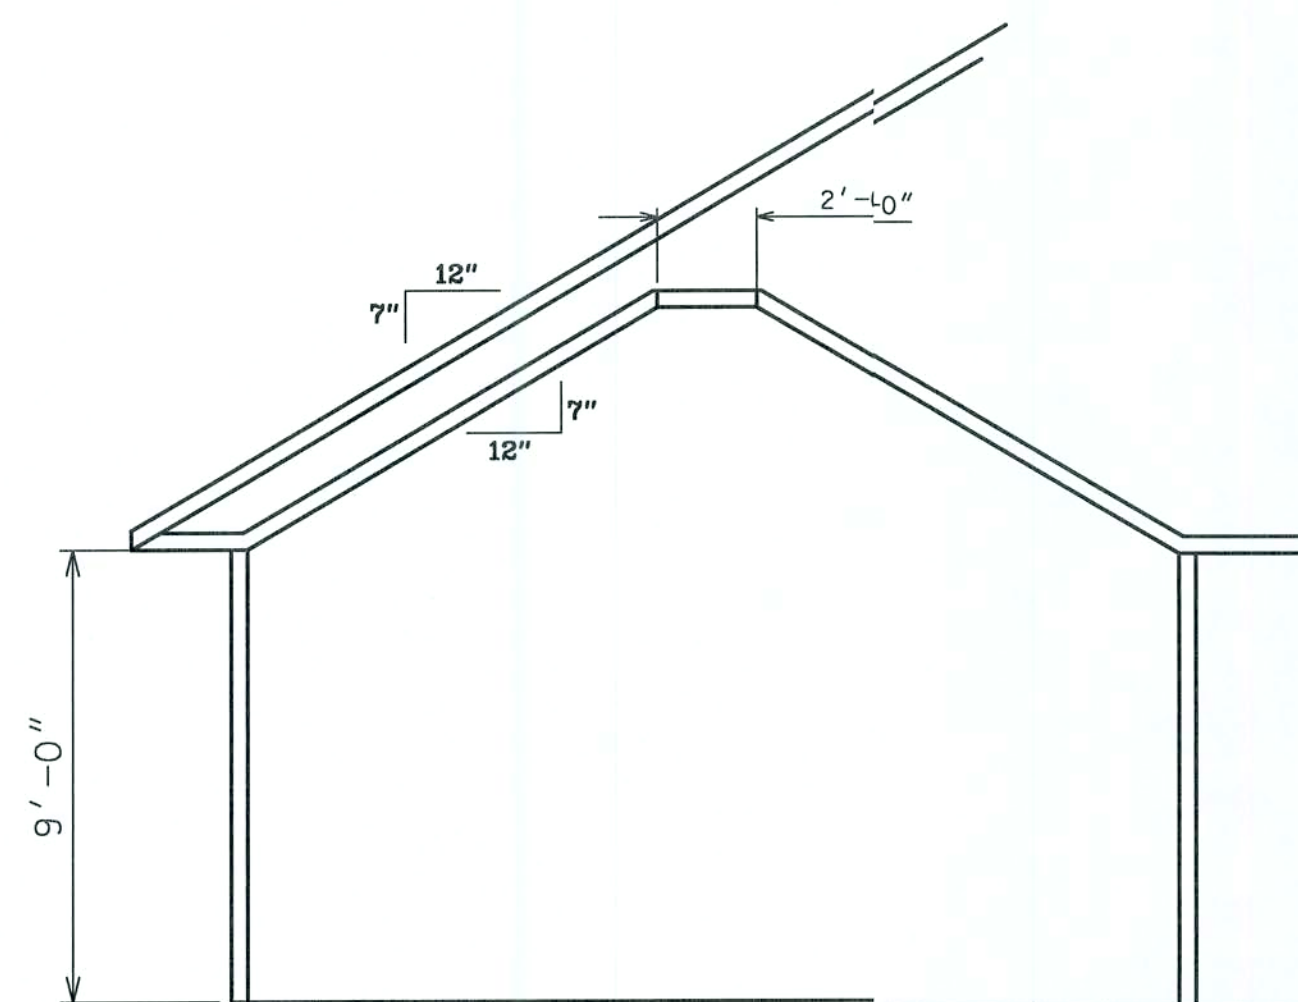


FAMILY ROOM (2/7)

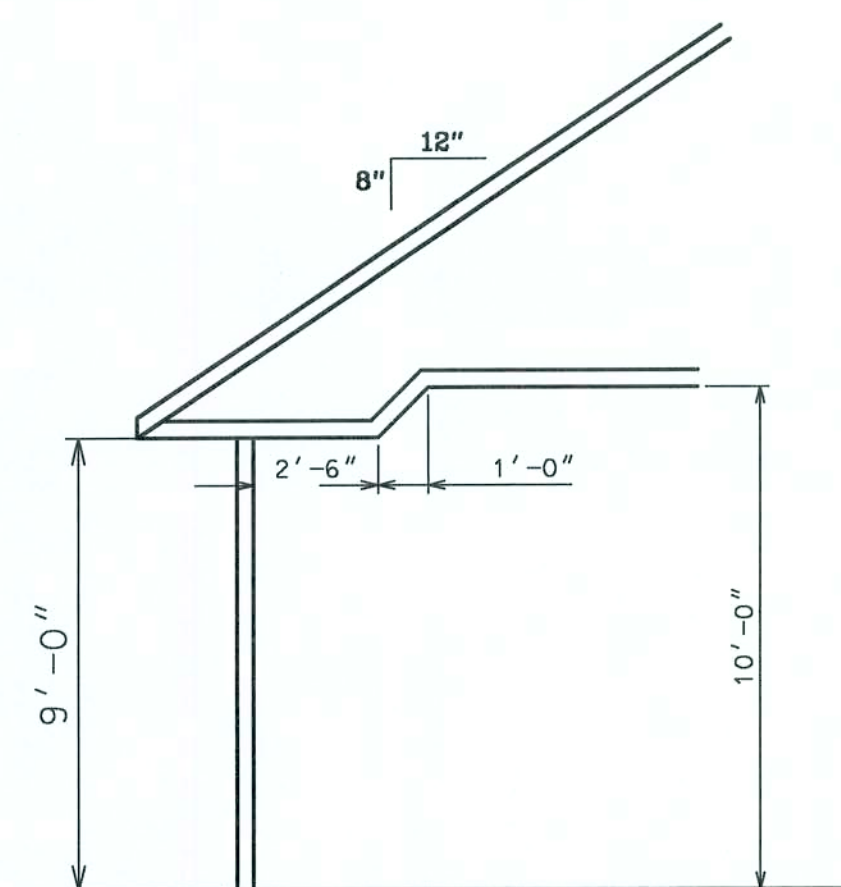


FAMILY ROOM (3/7)

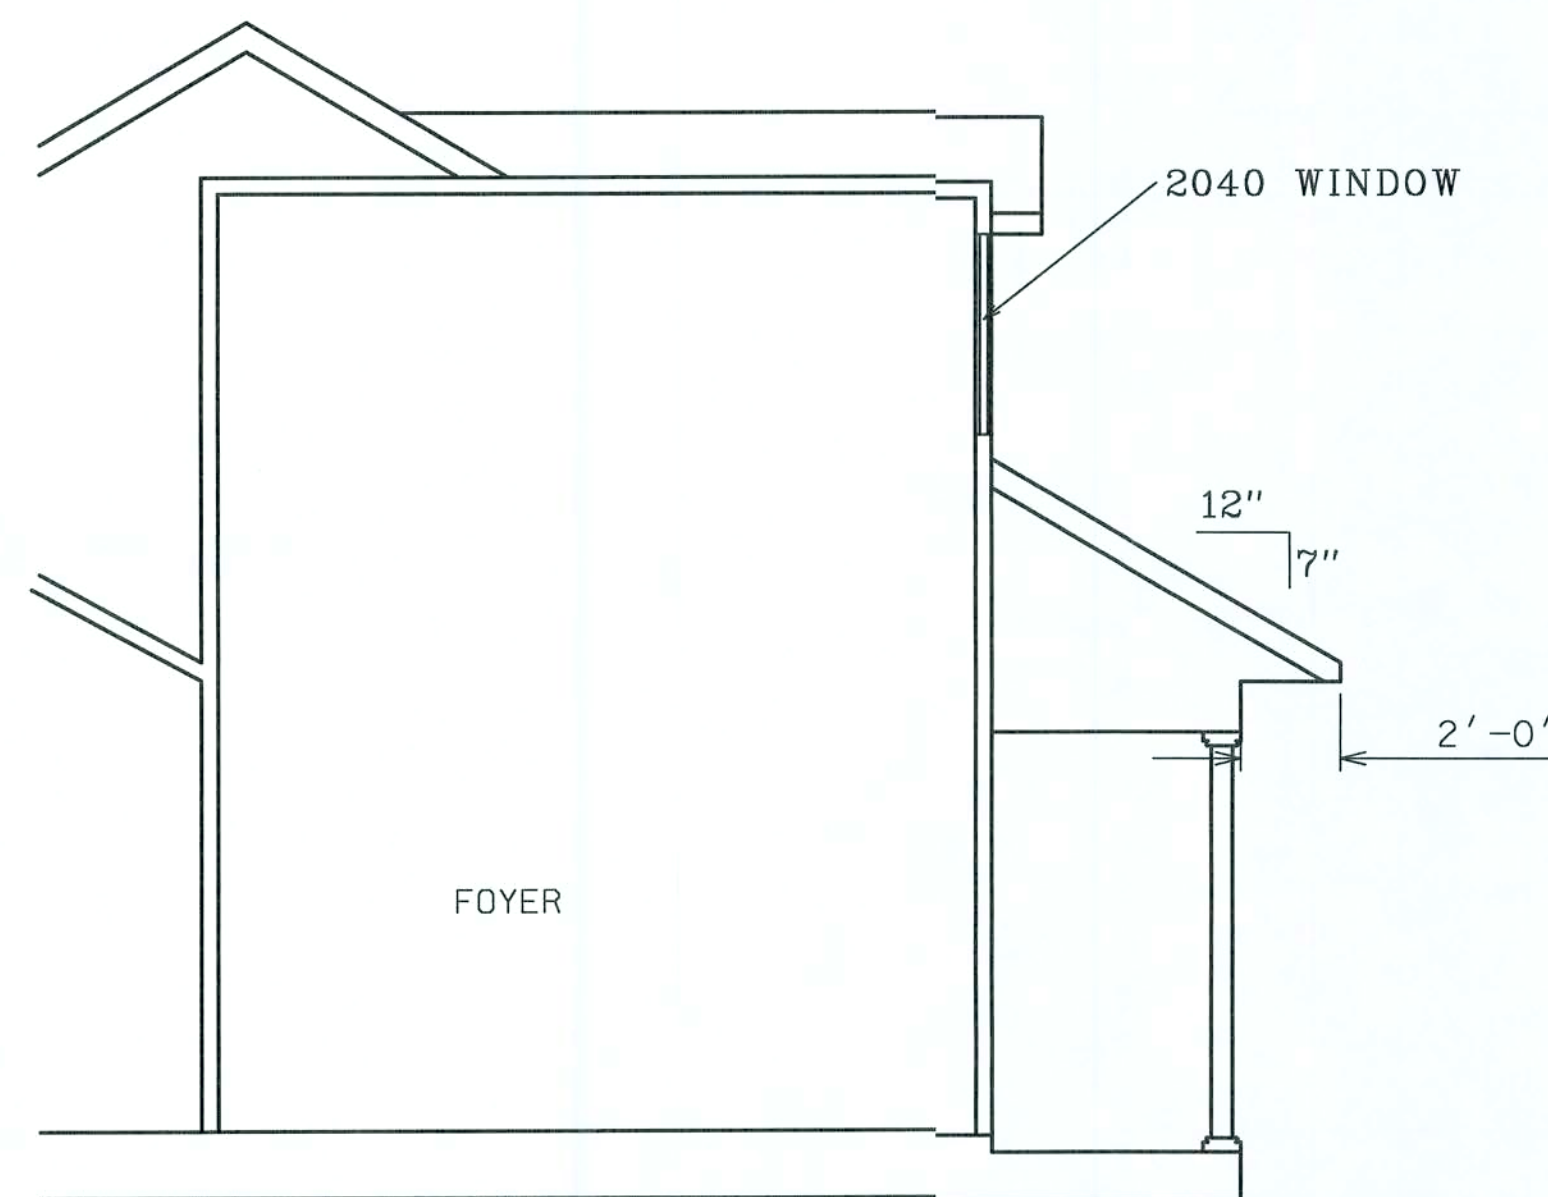


FOYER DETAIL (4/7)

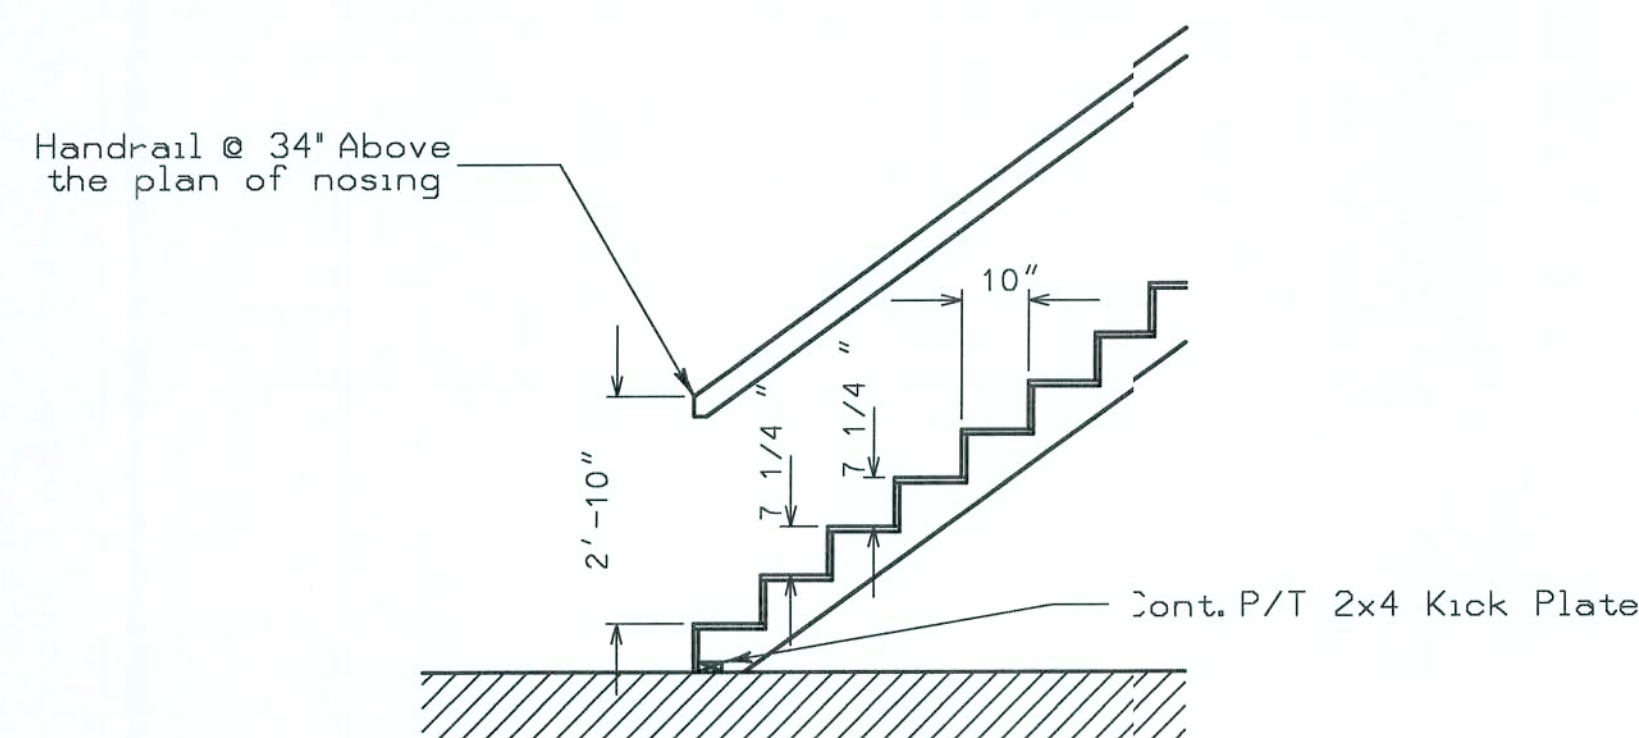

STAIR DETAIL (NTS)

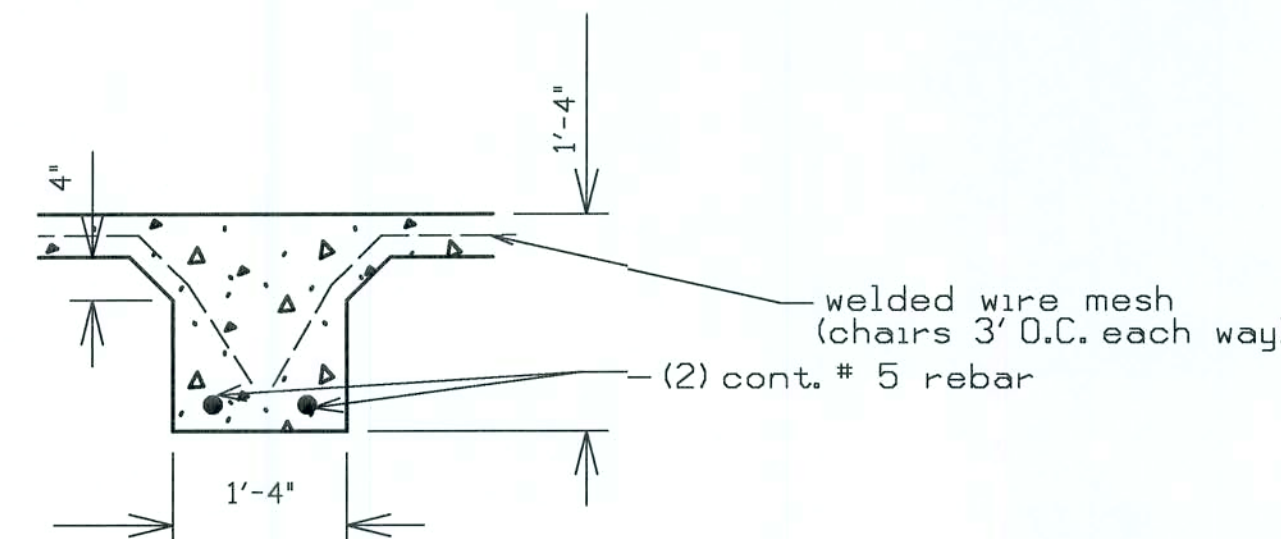


MONOLITHIC FOUNDATION (5/7)

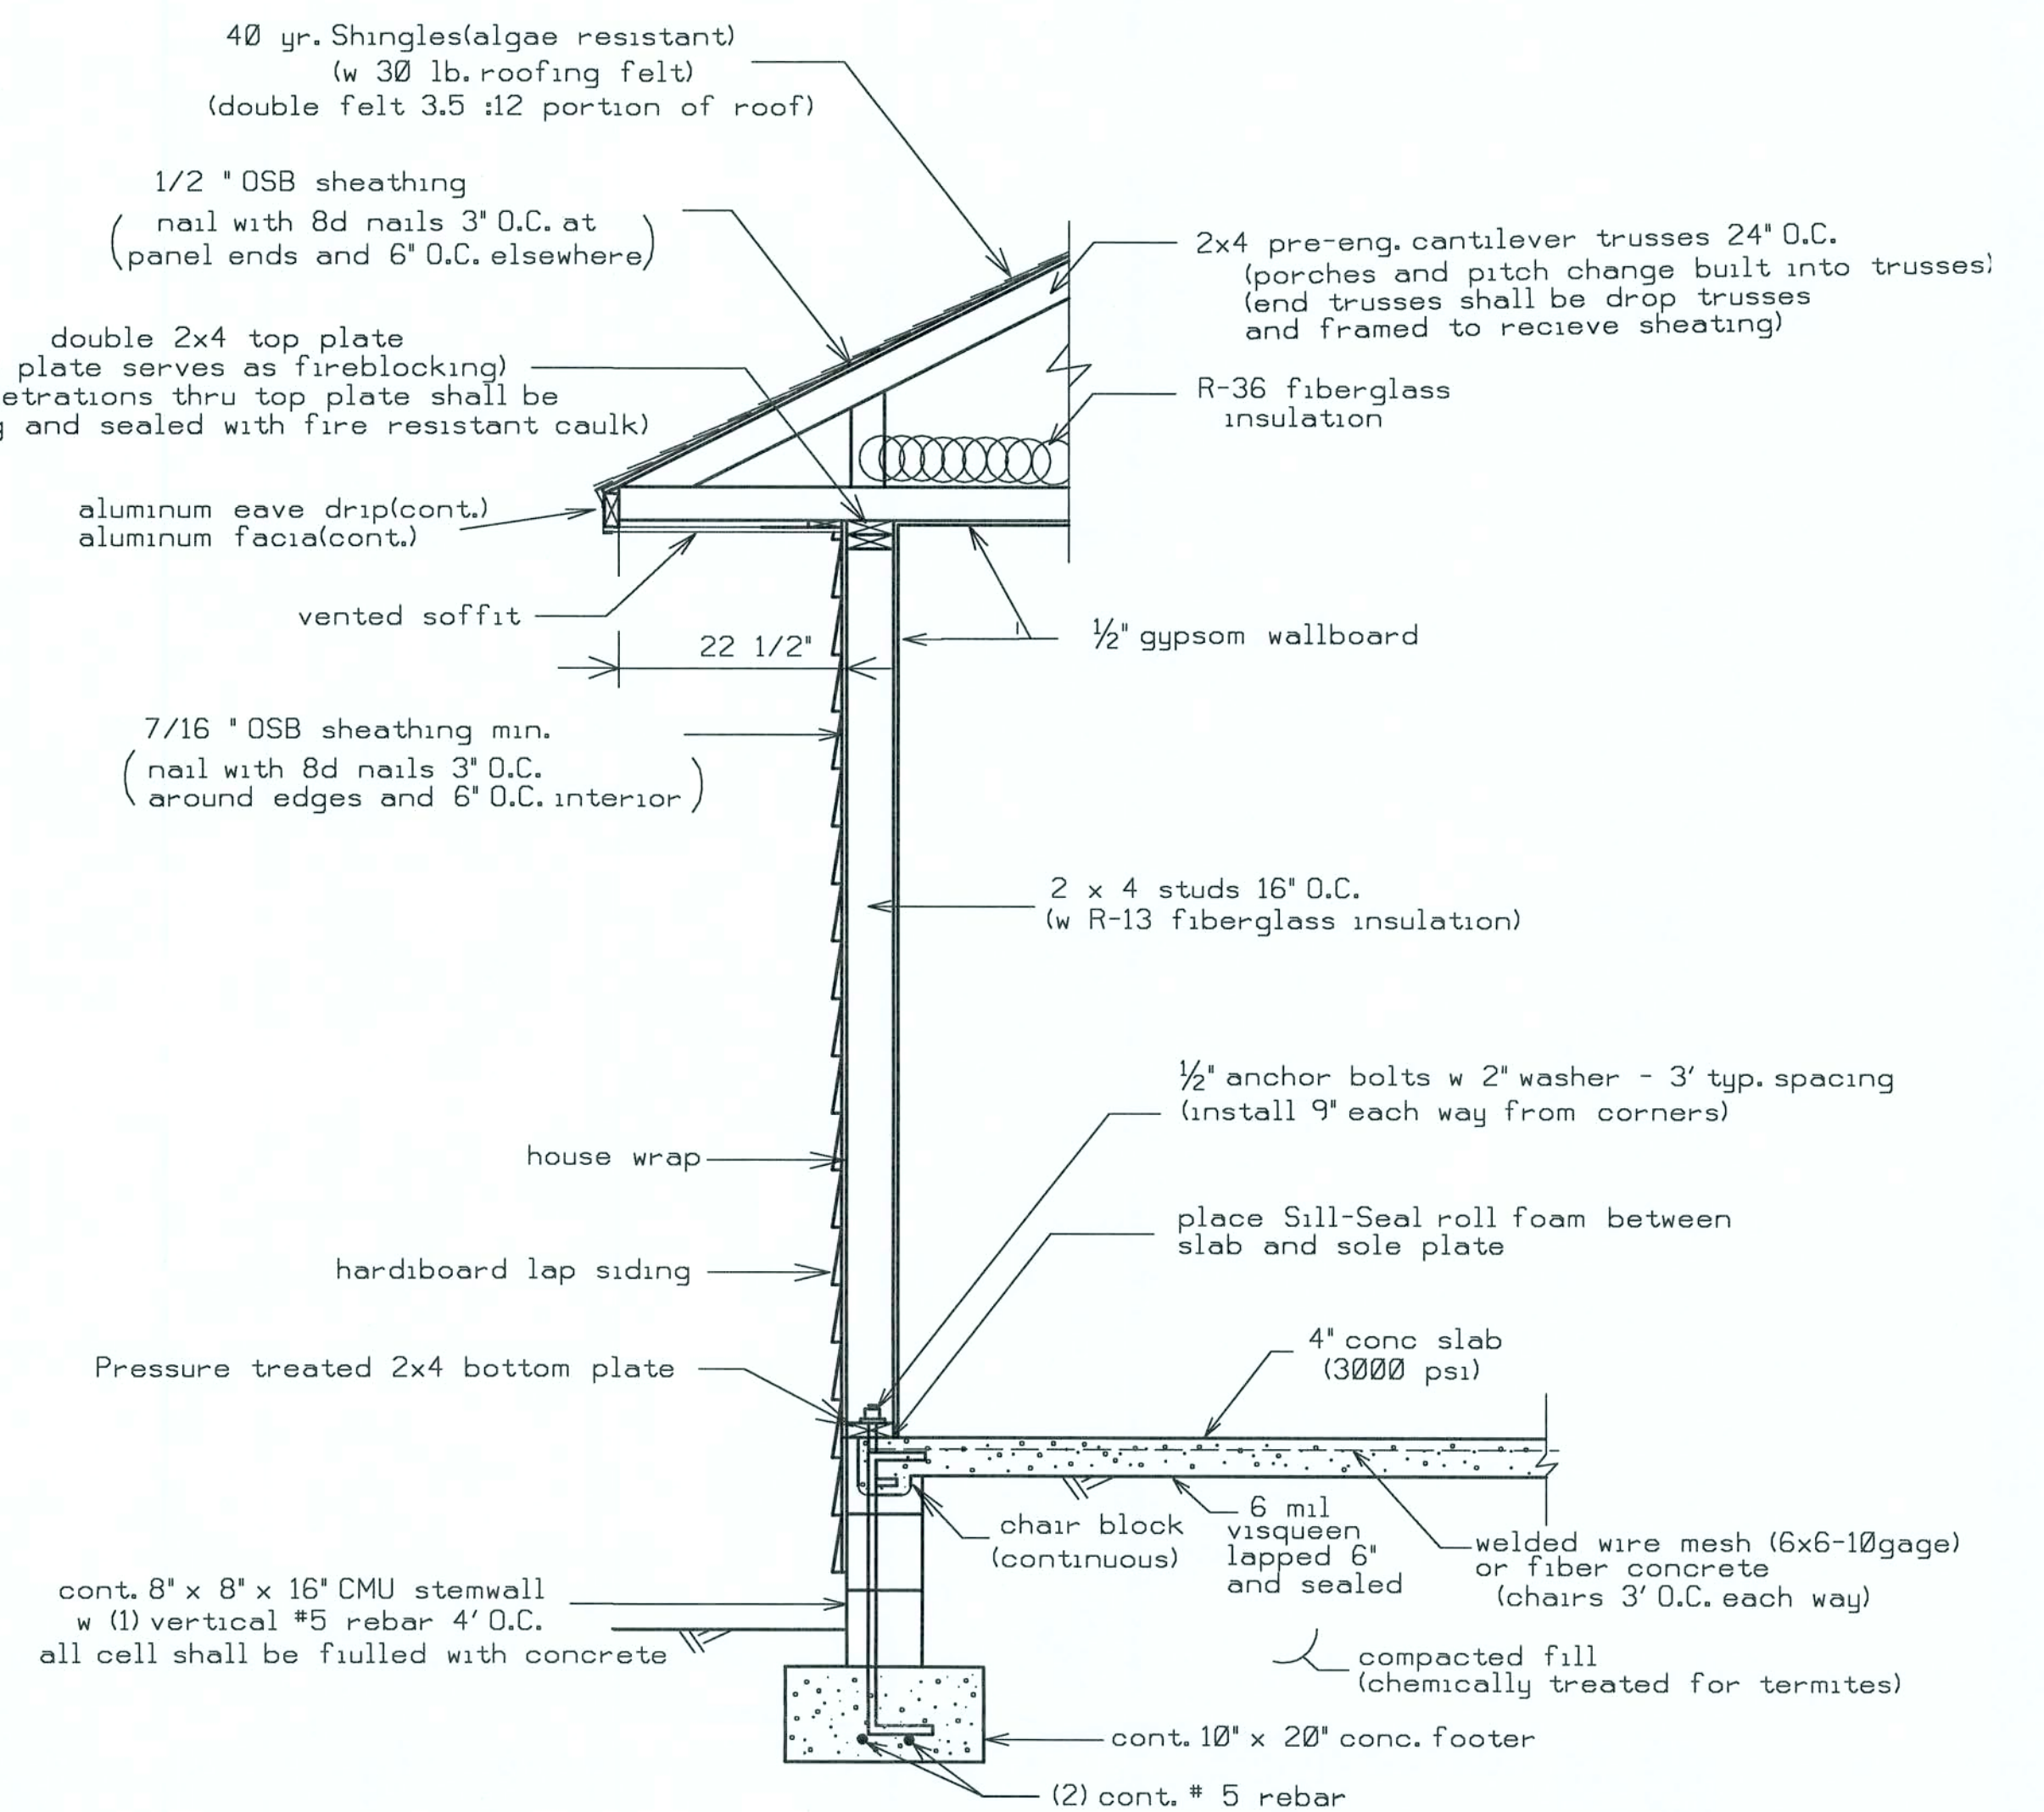

FOOTER DESIGN 1000 PSF
WALL DETAIL(TYP.) (N.T.S.)

HEADER SIZES/MATERIAL SHALL BE AS FOLLOWS:
WINDOW AND DOOR OPENINGS(2 - #2 SYP 2X12's with 1/2" plywood between)
PORCH BEAMS (2 - #2 SYP 2X10's with 1/2" plywood between)

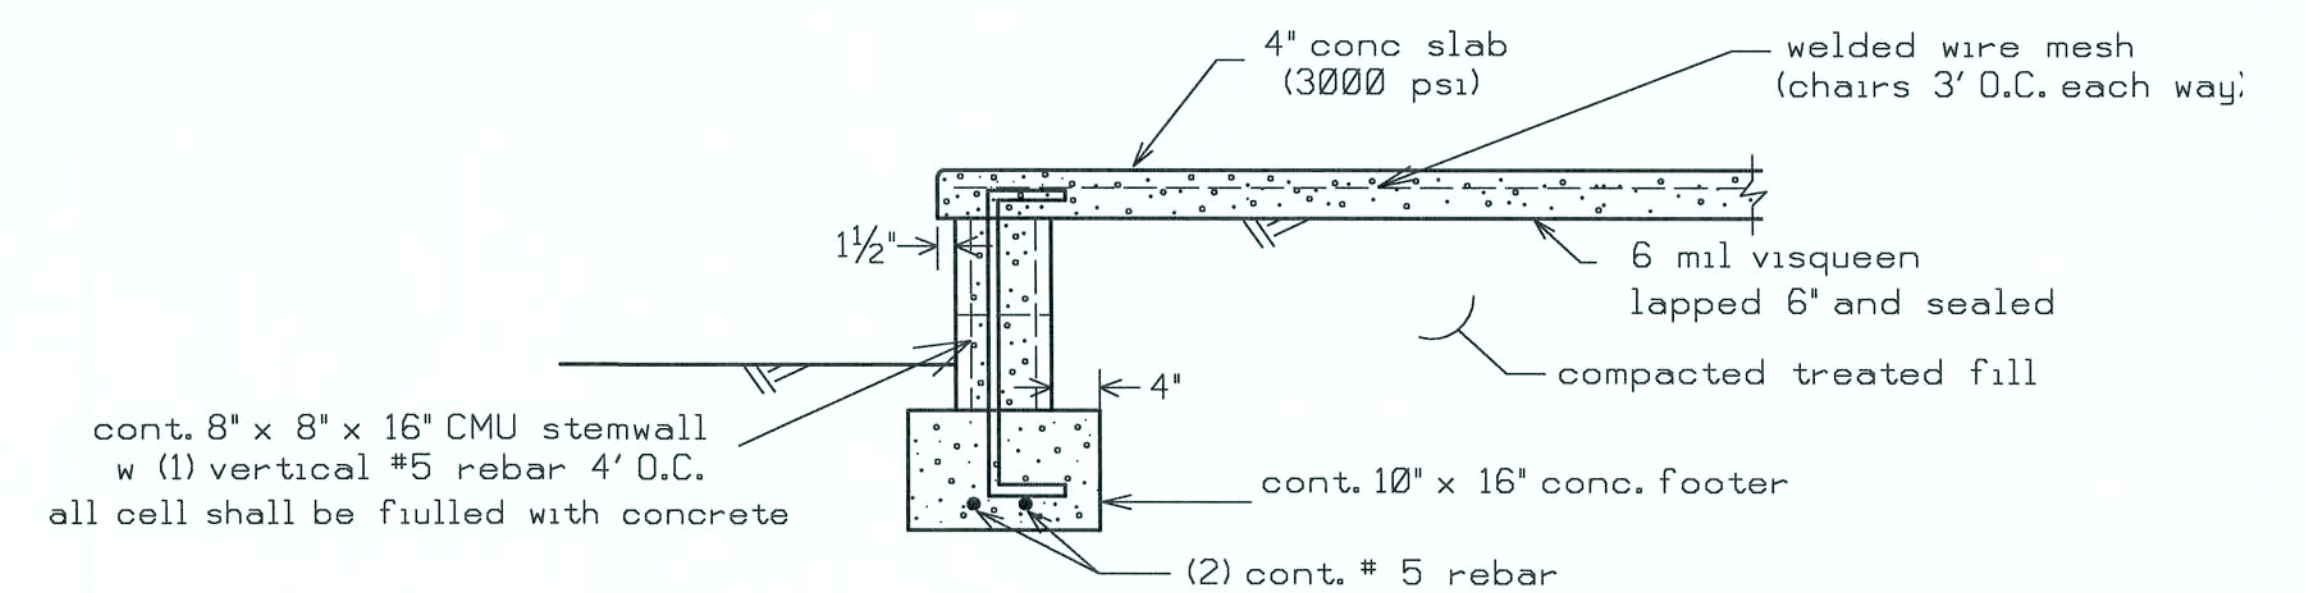

PORCH FOUNDATION (N.T.S.)



HAYGOOD HOMES INC.


12592 So. U.S. HWY 441
LAKE CITY FL 32025
OFFICE (386) 752-3496
MOBILE (386) 303-1981
CR-C1326715

JOHN AND JESSICA MacLAREN


LAKE CITY FLORIDA

DETAILS

PLAN No.	SCALE	DATE	SHEET NO.
P 0601	1/4" = 1'	01/18/06	7

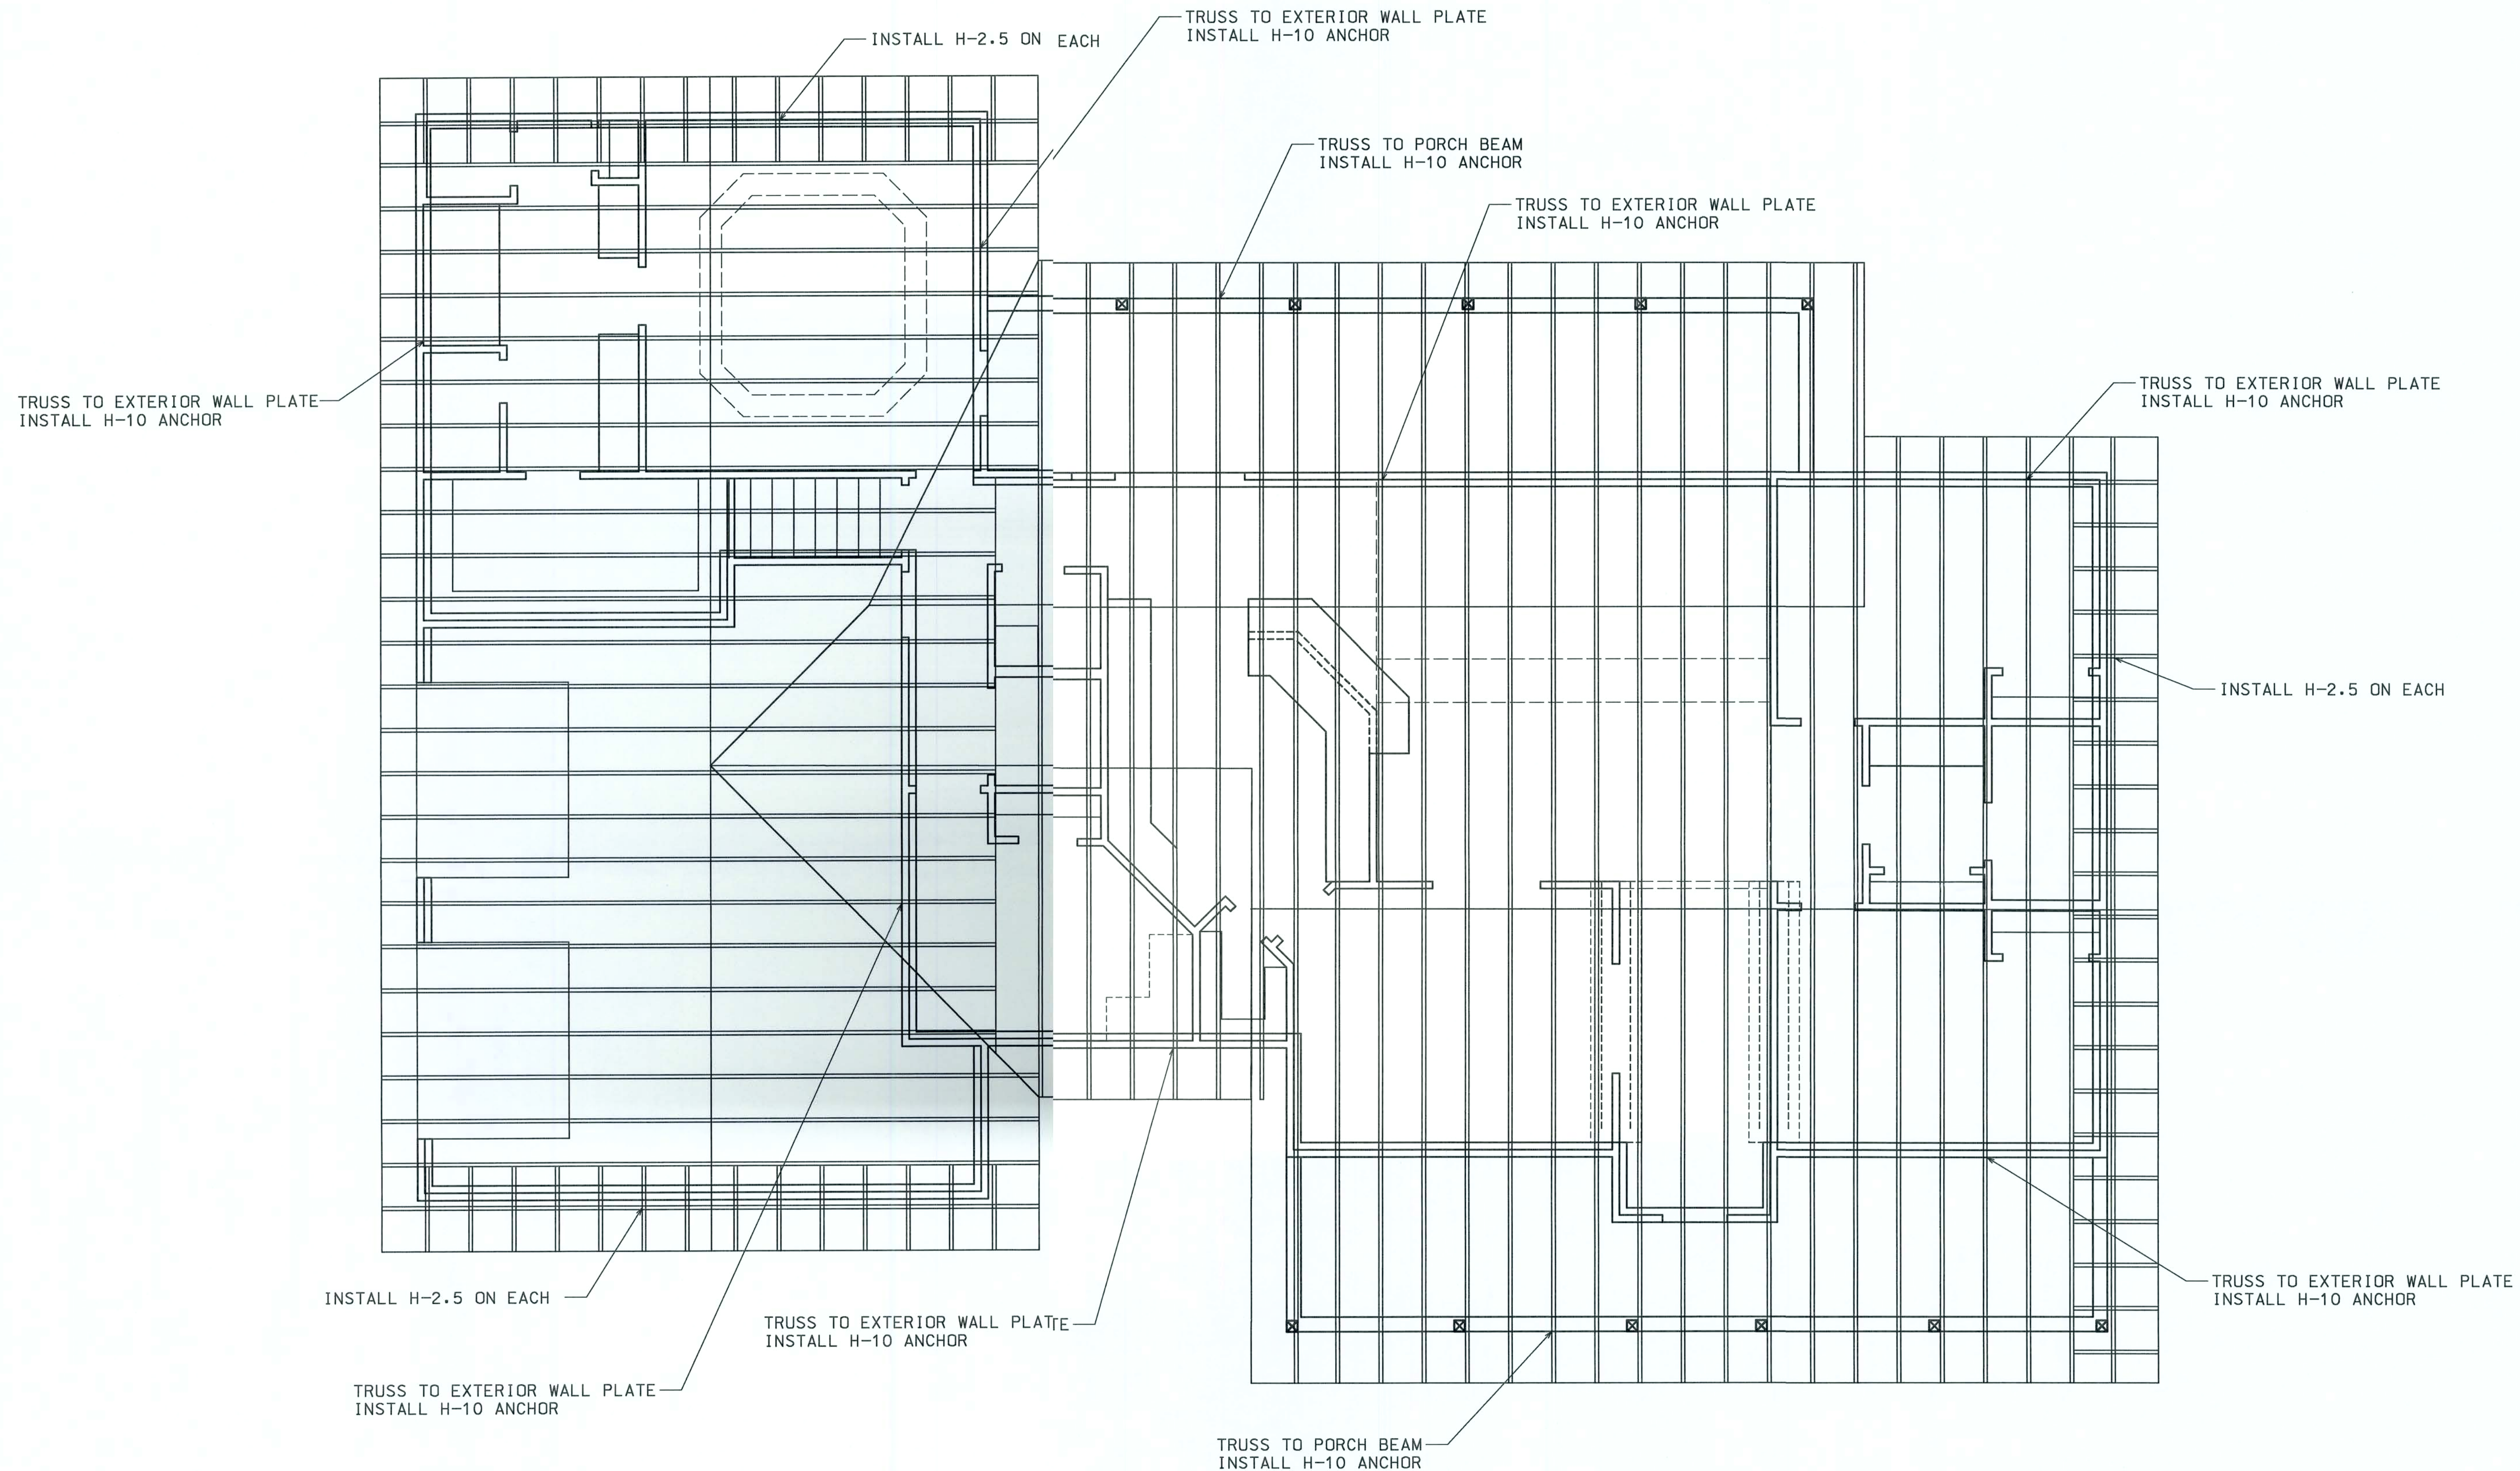

NOTE: SEE ACCOMPANYING TRUSS PLANS AND
WINDLOAD ANALYSIS FOR FURTHER DETAIL.

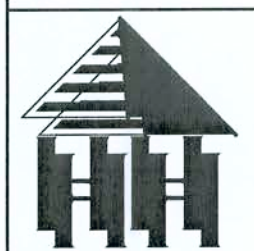

HAYGOOD HCMES INC.

12592 So. U.S. HWY 441
LAKE CITY FL. 32025
OFFICE (386) 752-3496
MOBILE (386) 303-1981
CR-C1326715

JOHN AND JESSICA MACLAREN
JOHN AND JESSICA MACLAREN

LAKE CITY FLORIDA

TRUSS LAYOUT

PLAN No.	SCALE	DATE	SHEET NO.
P 0601	1/4" = 1'	01/15/06	8