




LIGHTING PLAN  
SCALE: 1/4" = 1'-0"

EXISTING BUILDING RENOVATIONS FOR:  
**KINGDOM CULTURE ACADEMY**  
COLUMBIA COUNTY, FLORIDA

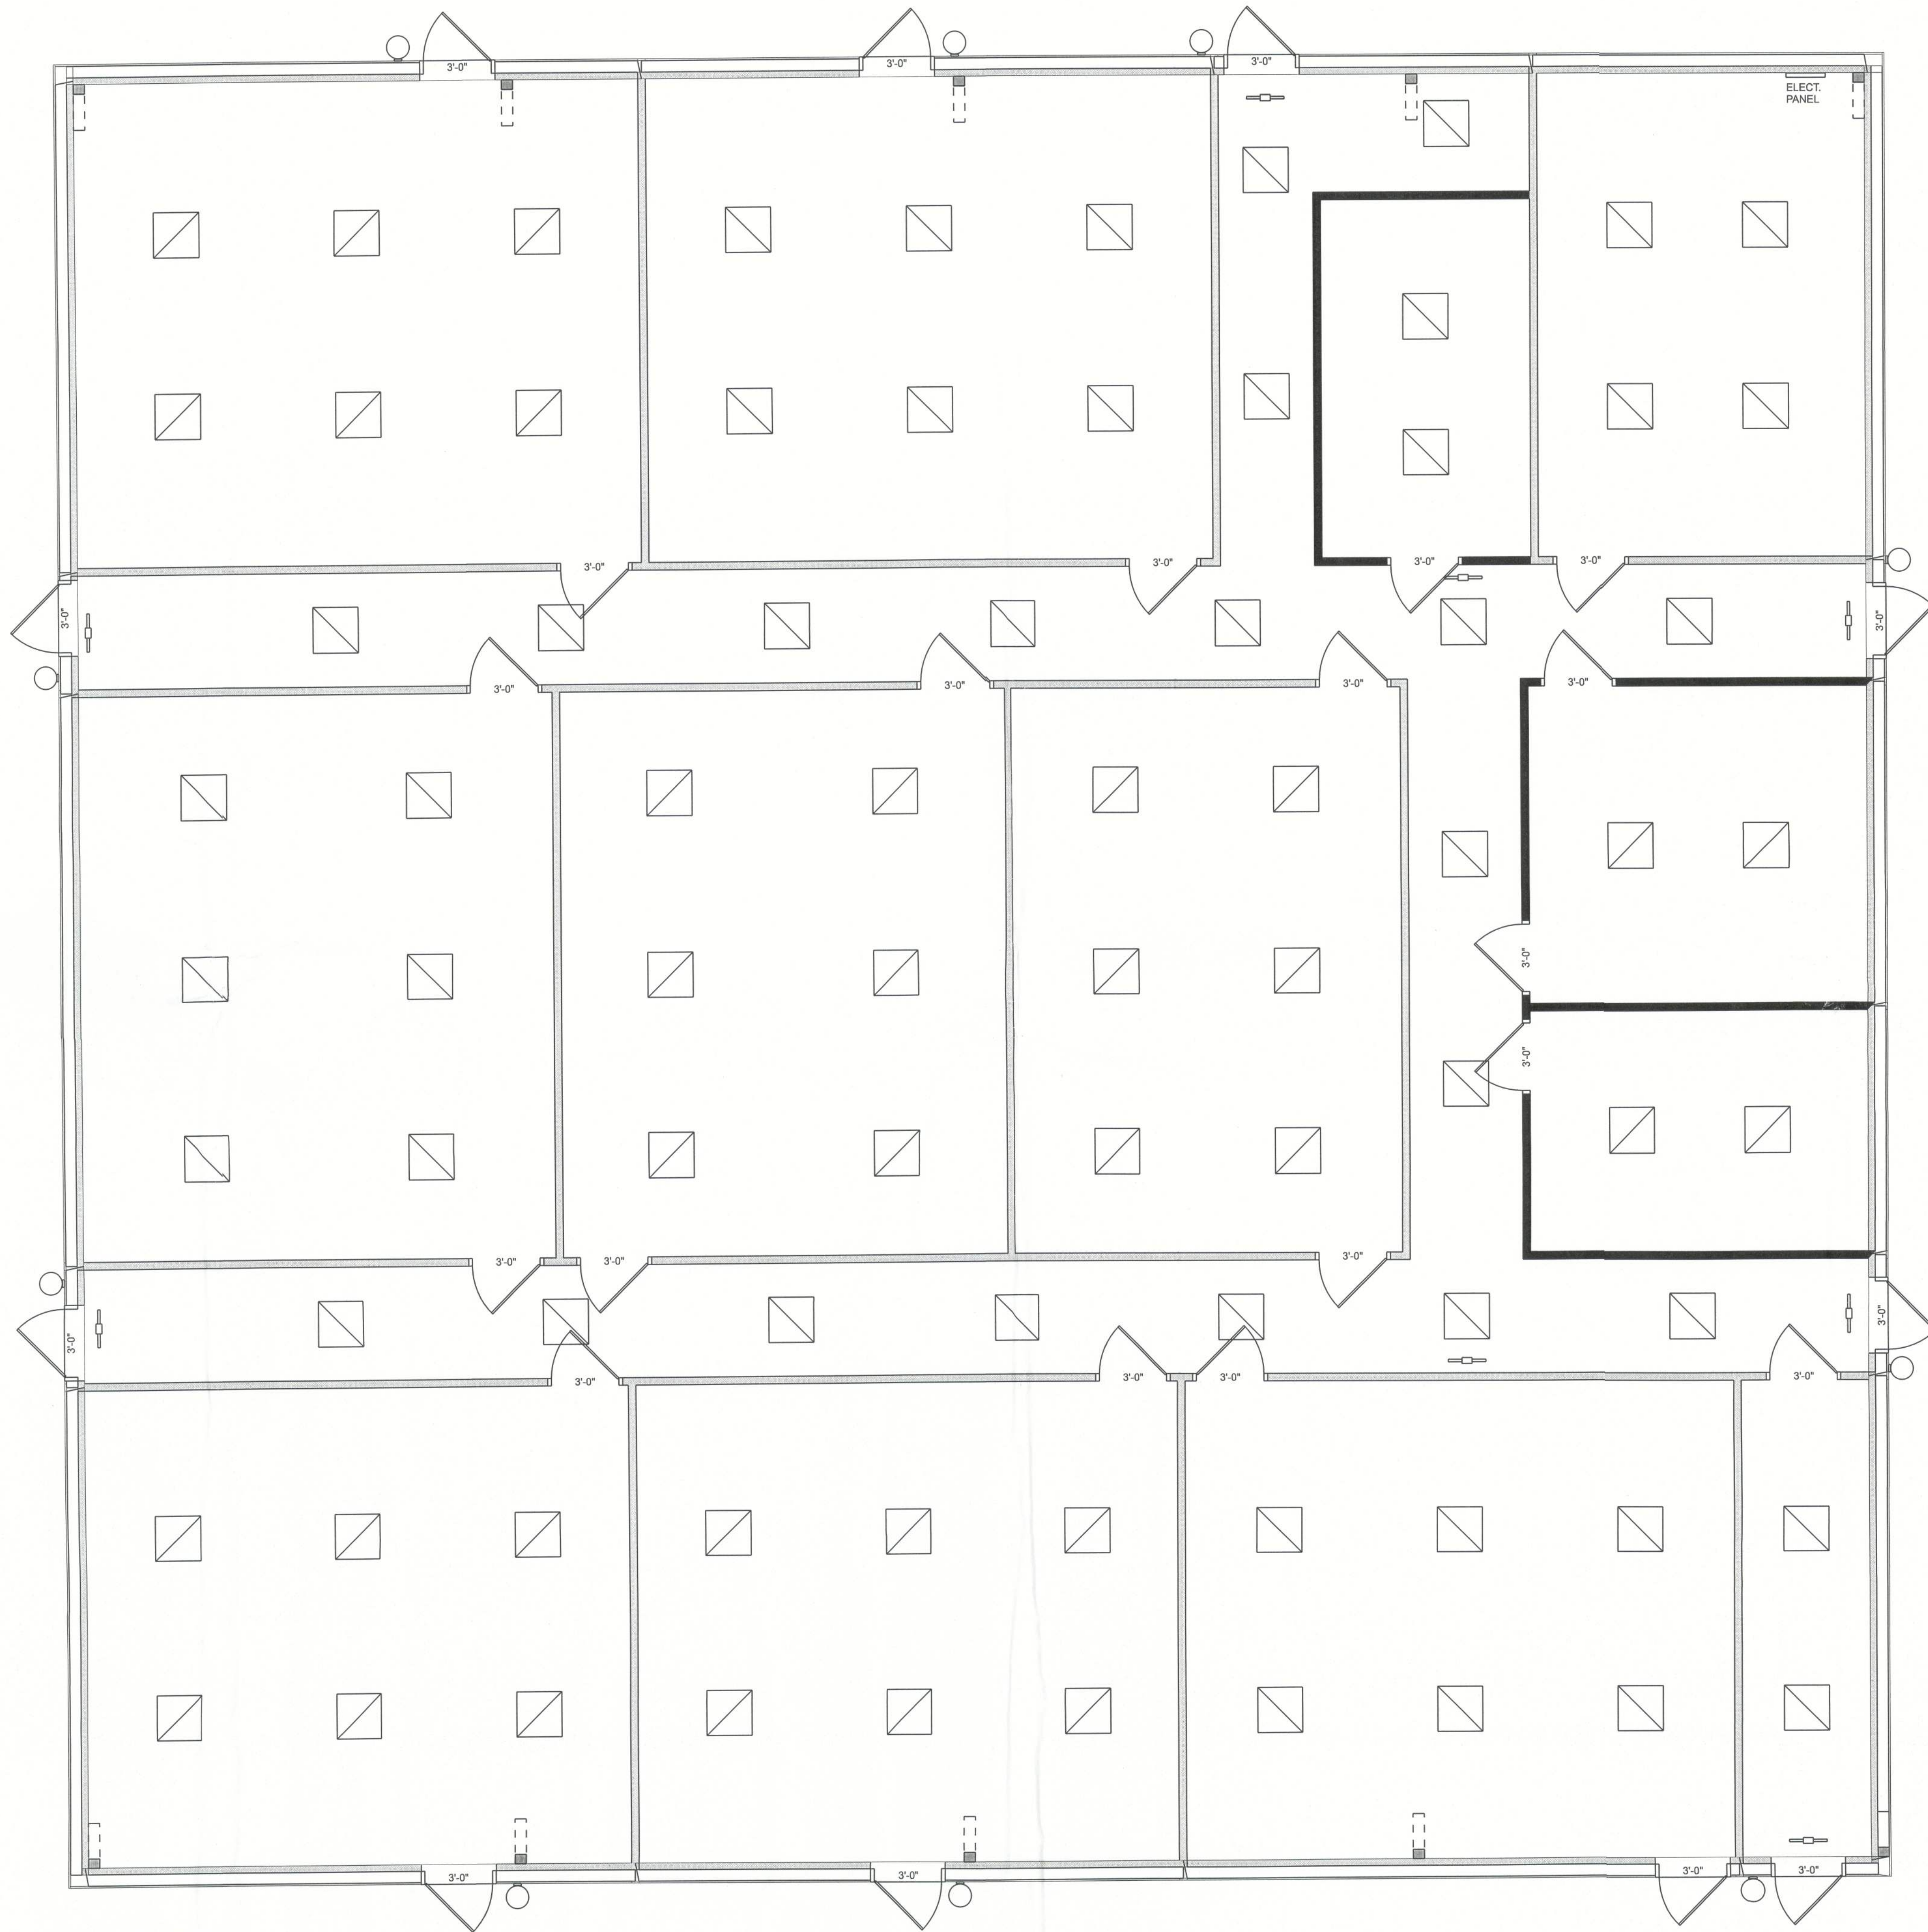

JOINT VENTURED WITH



SHEET NUMBER  
**A.4**  
OF 4 SHEETS

