

* PARTIAL PROPOSED *

* CONCRETE PLAN *

SCALE : 1/4" = 1'-0"

IMPORTANT NOTES:
1. IT IS THE BUILDER'S RESPONSIBILITY TO VERIFY ALL GEOMETRY AND DIMENSIONS BEFORE ORDERING ANY MATERIALS OR BEGINNING CONSTRUCTION.
2. THESE PLANS ARE FOR LAYOUT AND DESIGN PURPOSES ONLY ALL STRUCTURAL NOTES AND DETAILS TO BE PROVIDED BY AN ENGINEER.



ADDITION
for
JOHN BERNOT

686 SW SUNVIEW STREET
FT. WHITE, FL

Teena M. Ruffo
2925 SW SR 47
Lake City Florida, 32025
Cell: (386) 867 - 1191
Email: teenaruffo@gmail.com

PRINTED DATE:
Thursday, February 22, 2024

DRAWN BY: Teena M. Ruffo CHECKED BY:

BUILDING CONTRACTOR
REED/MCDANIELS CONSTRUCTION


FINAL DATE:

JOB NUMBER:

DRAWING NUMBER

A-1

OF 4 SHEETS

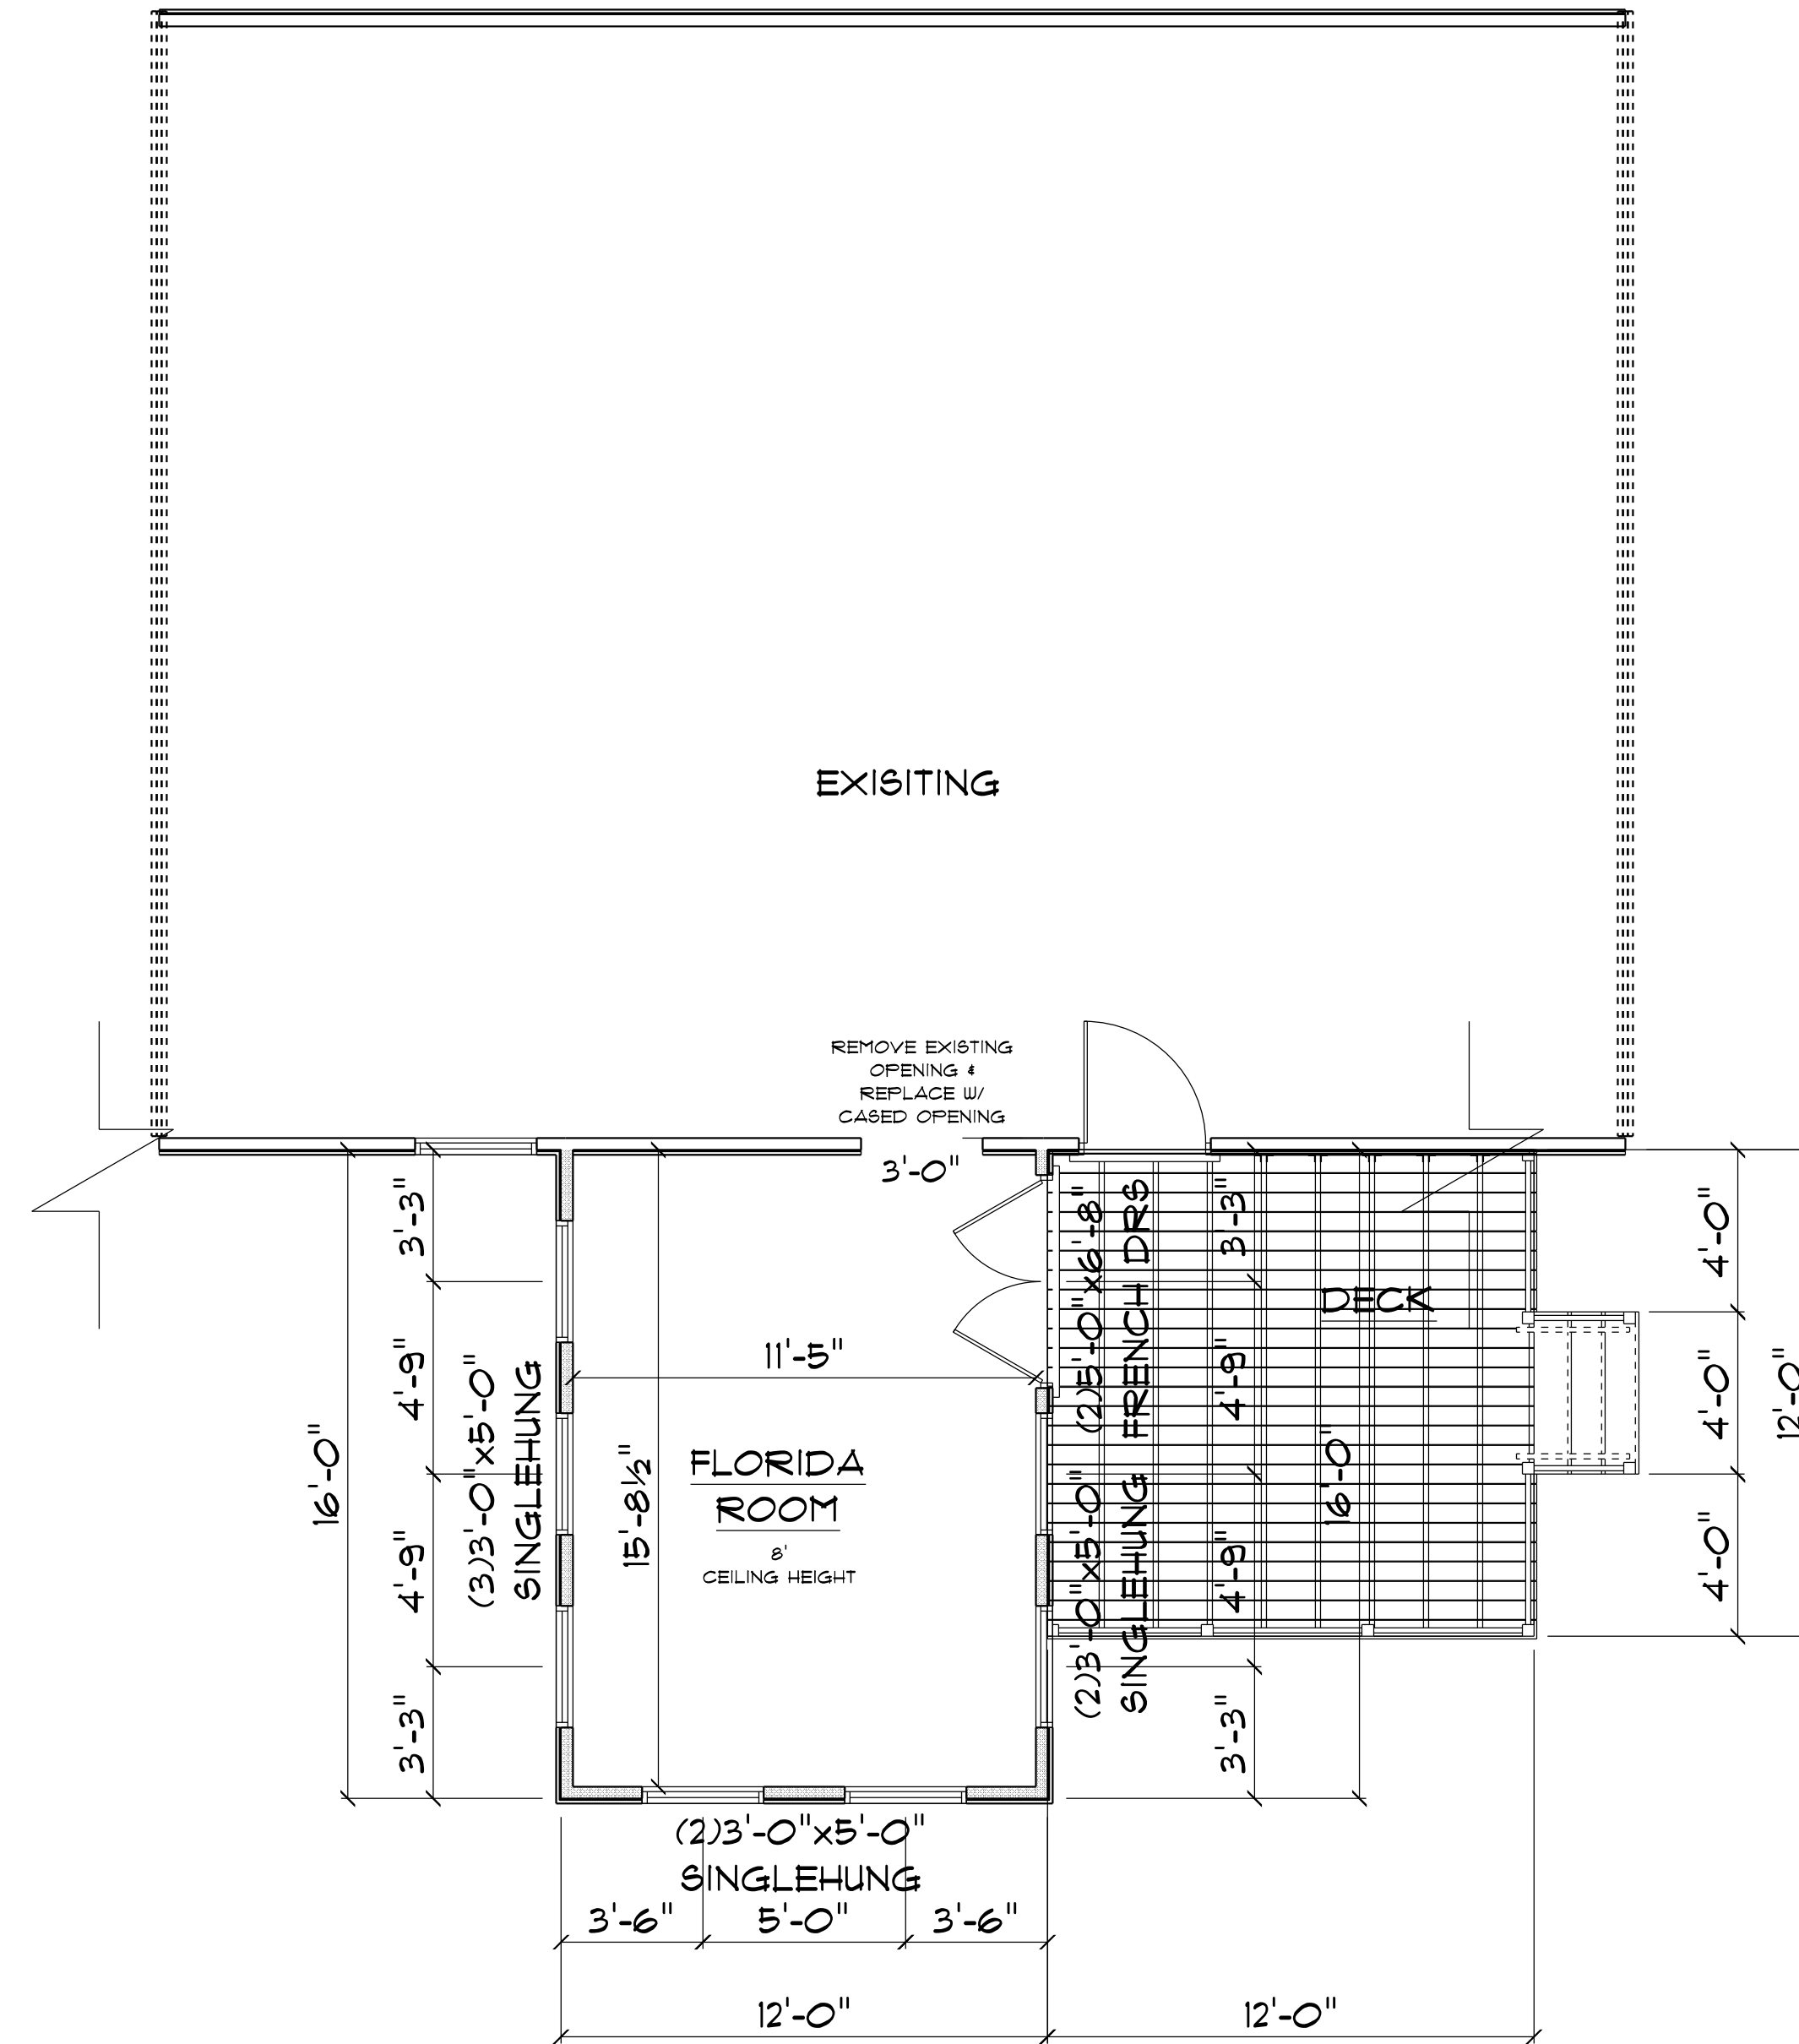

* PARTIAL PROPOSED *

* FLOOR PLAN *

SCALE : 1/4" = 1'-0"

IMPORTANT NOTES:
1. IT IS THE BUILDER'S RESPONSIBILITY TO VERIFY ALL GEOMETRY AND DIMENSIONS BEFORE ORDERING ANY MATERIALS OR BEGINNING CONSTRUCTION.
2. THESE PLANS ARE FOR LAYOUT AND DESIGN PURPOSES ONLY ALL STRUCTURAL NOTES AND DETAILS TO BE PROVIDED BY AN ENGINEER.

TOTAL A/C AREA UNDER ROOF = 192 S.F.
TOTAL AREA UNDER ROOF = 192 S.F.

ADDITION
for
JOHN BERNOT

686 SW SUNVIEW STREET
FT. WHITE, FL

Teena M. Ruffo
2925 SW 8R 41
Lake City Florida, 32025
Cell: (386) 861 - 1191
Email: teenaruffo@gmail.com

PRINTED DATE:
Thursday, February 22, 2024

DRAWN BY: Teena M. Ruffo CHECKED BY:


BUILDING CONTRACTOR
REED/McDANIEL'S CONSTRUCTION

FINAL'S DATE:


JOB NUMBER:

DRAWING NUMBER
A-2


OF 4 SHEETS

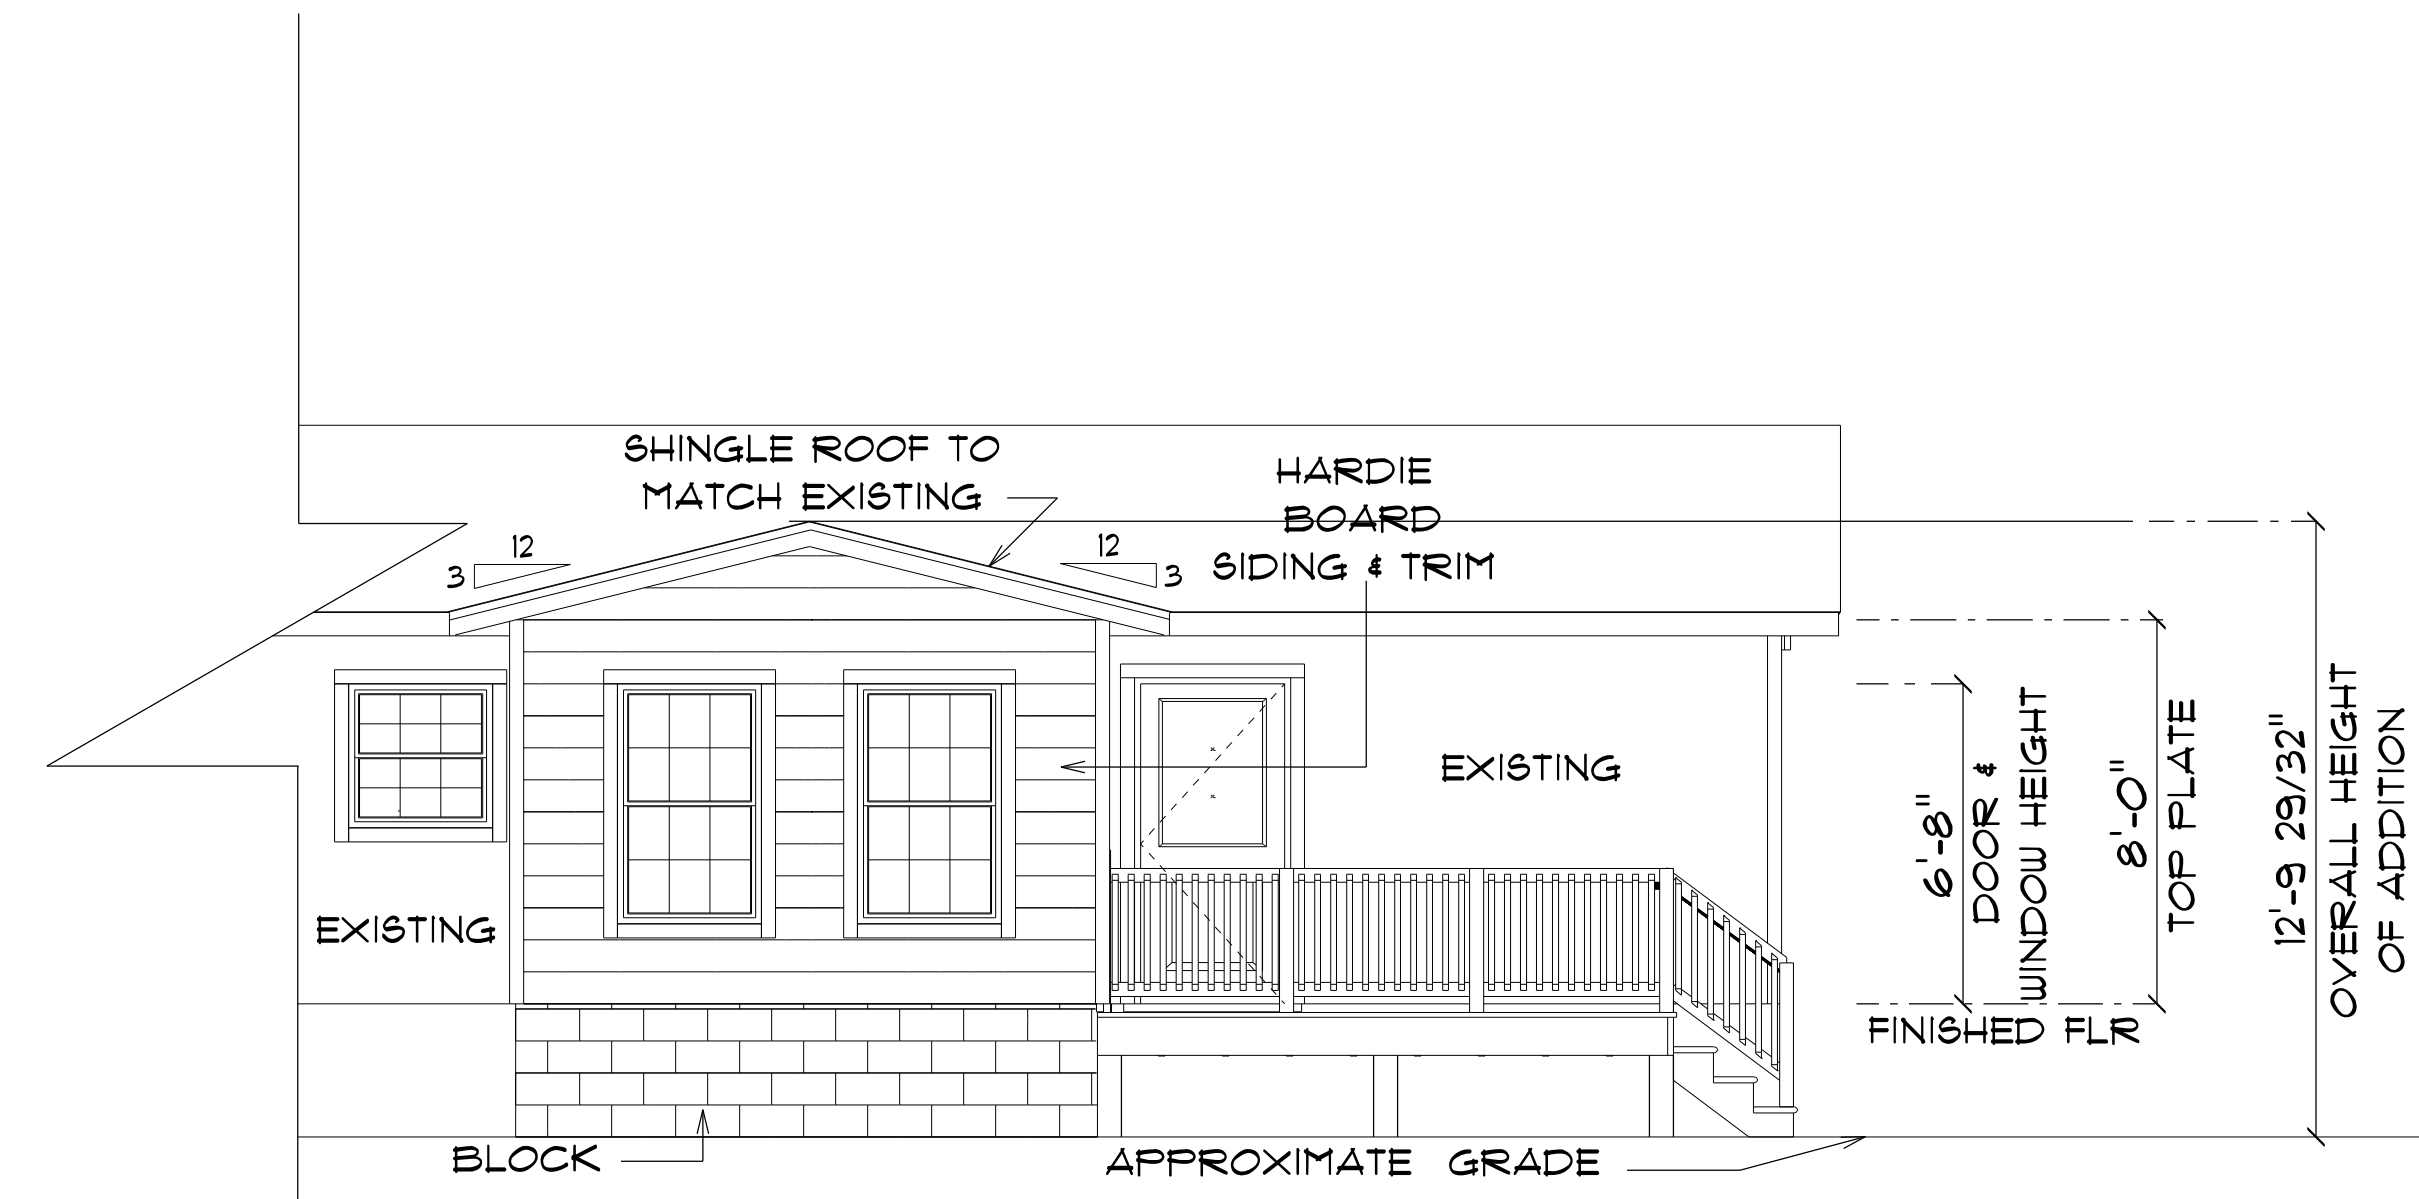

*** PROPOSED PARTIAL ***
*** FRONT ELEVATION ***
SCALE : 1/4" = 1'-0"

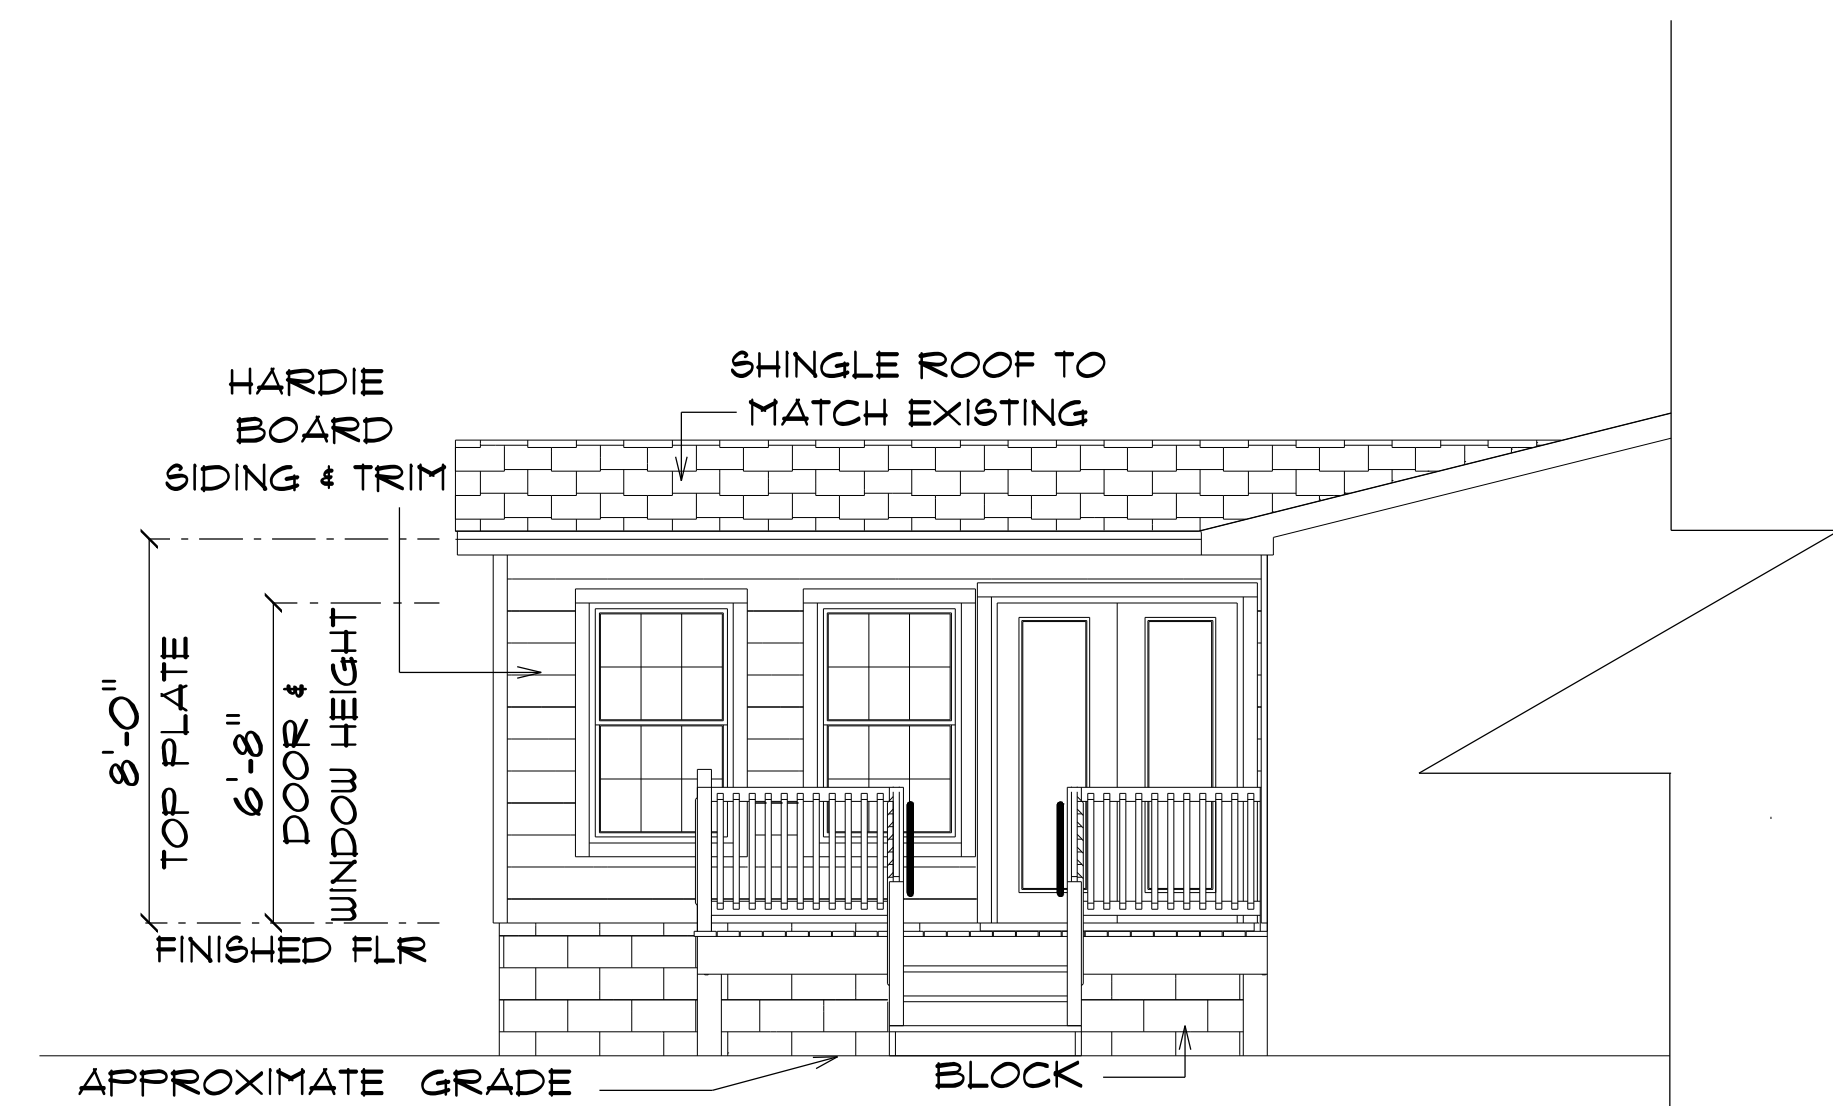


*** PROPOSED PARTIAL ***
*** RIGHT ELEVATION ***
SCALE : 1/4" = 1'-0"

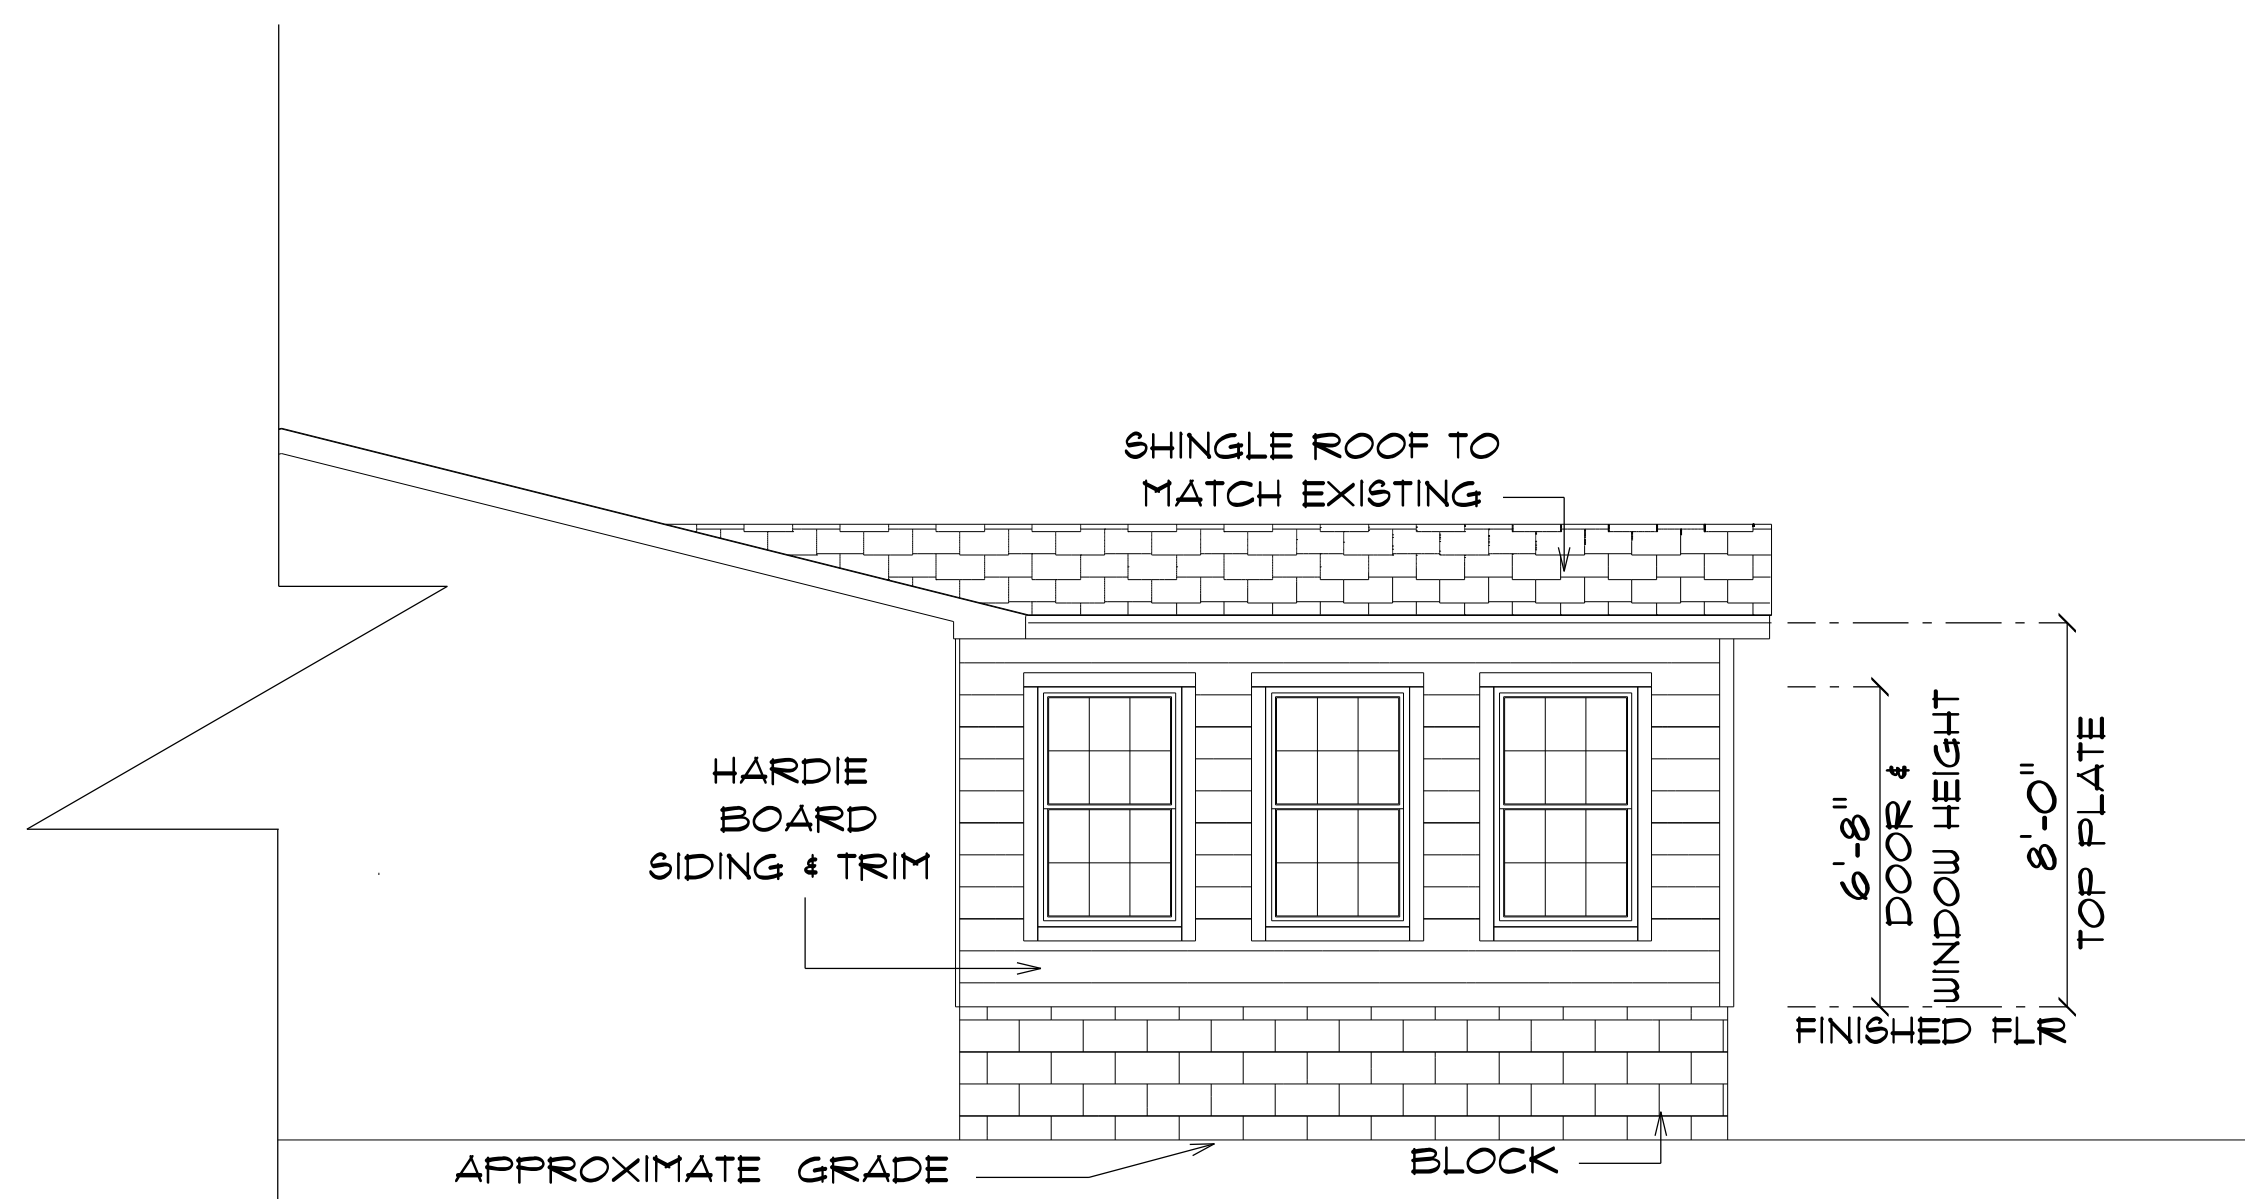

*** PROPOSED PARTIAL ***
*** LEFT ELEVATION ***
SCALE : 1/4" = 1'-0"

ADDITION for JOHN BERNOT	
686 SW SUNVIEW STREET FT. WHITE, FL	
Teena M. Ruffo 2925 SW SR 41 Lake City Florida, 32025 Cell: (386) 861-1191 Email: teenaruffo@gmail.com	
PRINTED DATE: Thursday, February 22, 2024	
DRAWN BY: Teena M. Ruffo	CHECKED BY:
BUILDING CONTRACTOR REED/McDANIEL'S CONSTRUCTION	
FINAL'S DATE:	
JOB NUMBER:	
DRAWING NUMBER A-3	
OF 4 SHEETS	

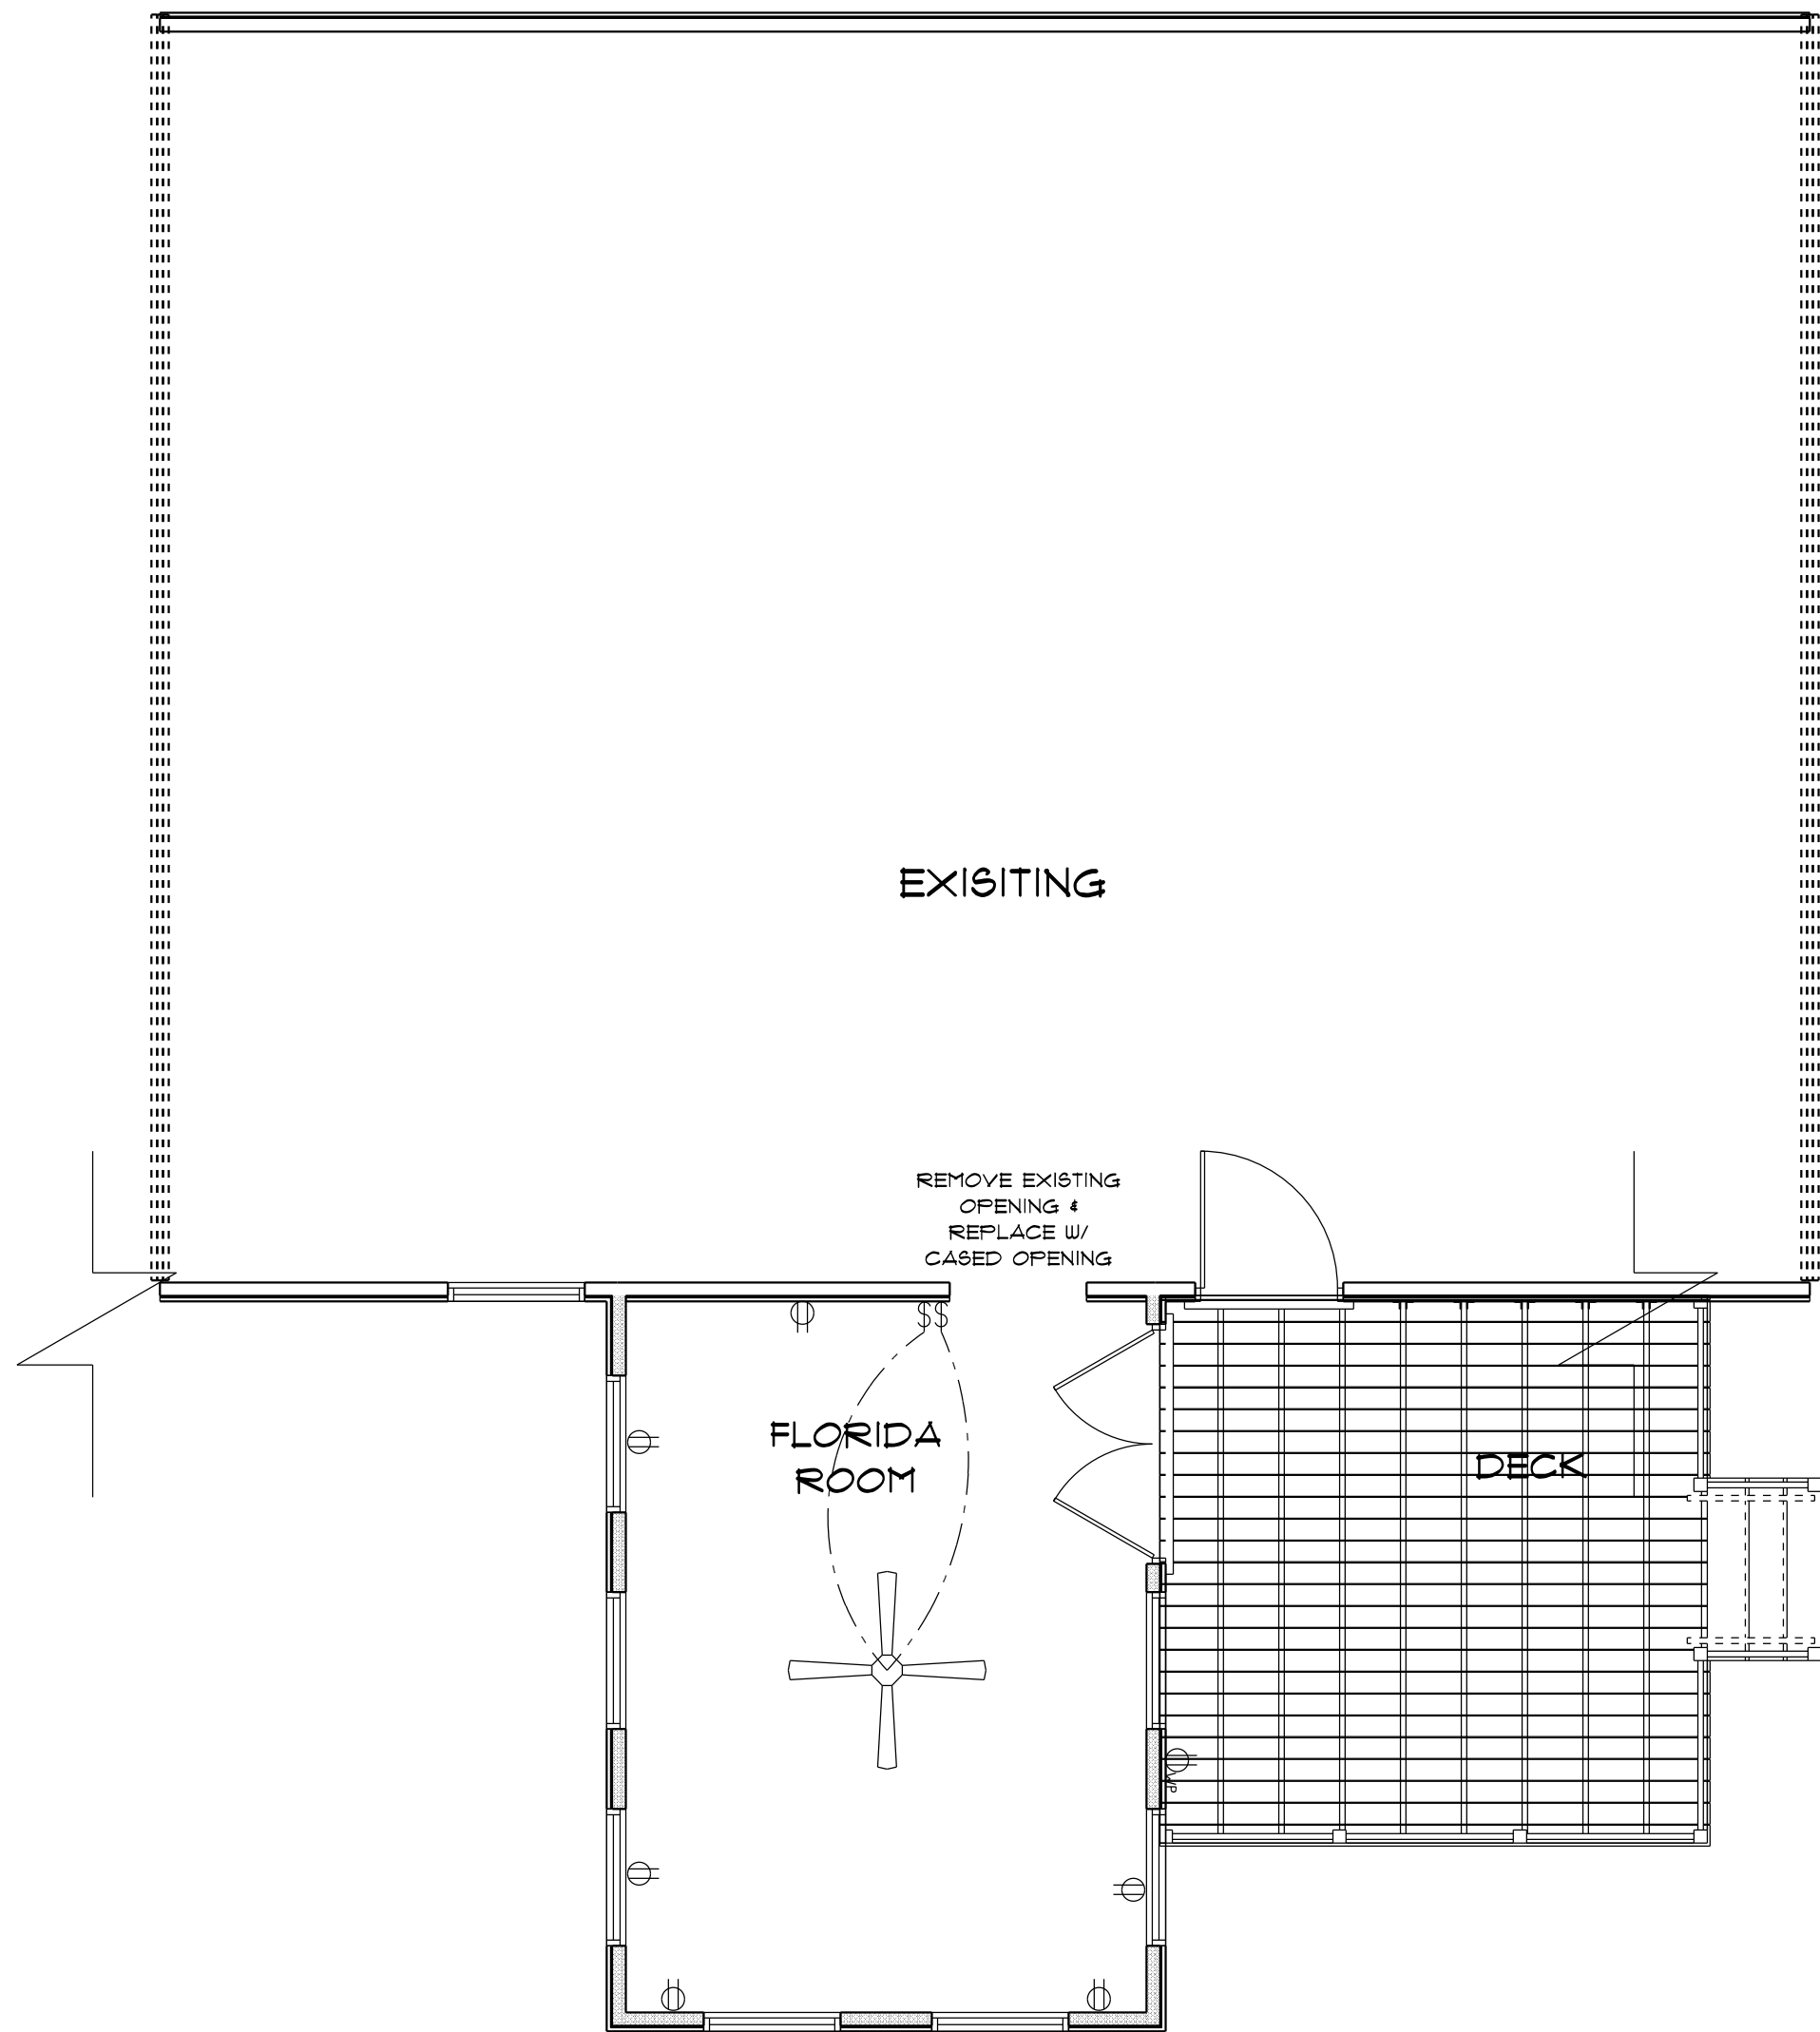

ELECTRICAL LEGEND		
ELECTRICAL	COUNT	SYMBOL
ceiling fan	1	
outlet	6	
outlet wp	1	
switch	2	

ELECTRICAL PLAN NOTES

- E-1 WIRE ALL APPLIANCES, HVAC UNITS AND OTHER EQUIPMENT PER MANUFACTURER'S SPECIFICATIONS.
- E-2 CONSULT THE OWNER FOR THE NUMBER OF SEPERATE TELEPHONE LINES TO BE INSTALLED.
- E-3 ALL INSTALLATIONS SHALL BE PER NATIONAL ELECTRIC CODE.
- E-4 ALL SMOKE DETECTORS SHALL BE 120V W/BATTERY BACKUP OF THE PHOTOELECTRIC TYPE, AND SHALL BE INTERLOCKED TOGETHER, INSTALL INSIDE AND NEAR ALL BEDROOMS.
- E-5 TELEPHONE, TELEVISION AND OTHER LOW VOLTAGE DEVICES OR OUTLETS SHALL BE AS PER THE OWNERS DIRECTION AND IN ACCORDANCE WITH APPLICABLE SECTIONS OF NATIONAL ELCT. CODE LATEST EDITION.
- E-6 ELECTRICAL CONTRACTOR SHALL BE RESPONSIBLE FOR THE DESIGN AND SIZING OF ELECTRICAL SERVICE AND CIRCUITS.
- E-7 ENTRY OF SERVICE UNDERGROUND OR OVERHEAD) IS TO BE DETERMINED BY THE POWER COMPANY.
- E-8 ALL BEDROOM RECEPTICALS ARE TO BE AFCI (ARC FAULT CIRCUIT INTERRUPT)

* PARTIAL PROPOSED *

* ELECTRICAL PLAN *

SCALE : 1/4" = 1'-0"

ADDITION
for
JOHN BERNOT

686 SW SUNVIEW STREET
FT. WHITE, FL

Teena M. Ruffo
2925 SW SR 47
Lake City Florida, 32025
Cell: (386) 867 - 1191
Email: teenaruffo@gmail.com

PRINTED DATE:
Thursday, February 22, 2024

DRAWN BY: Teena M. Ruffo CHECKED BY:

BUILDING CONTRACTOR
REED/McDANIELS CONSTRUCTION

FINAL'S DATE:

JOB NUMBER:

DRAWING NUMBER

A-4

OF 4 SHEETS