


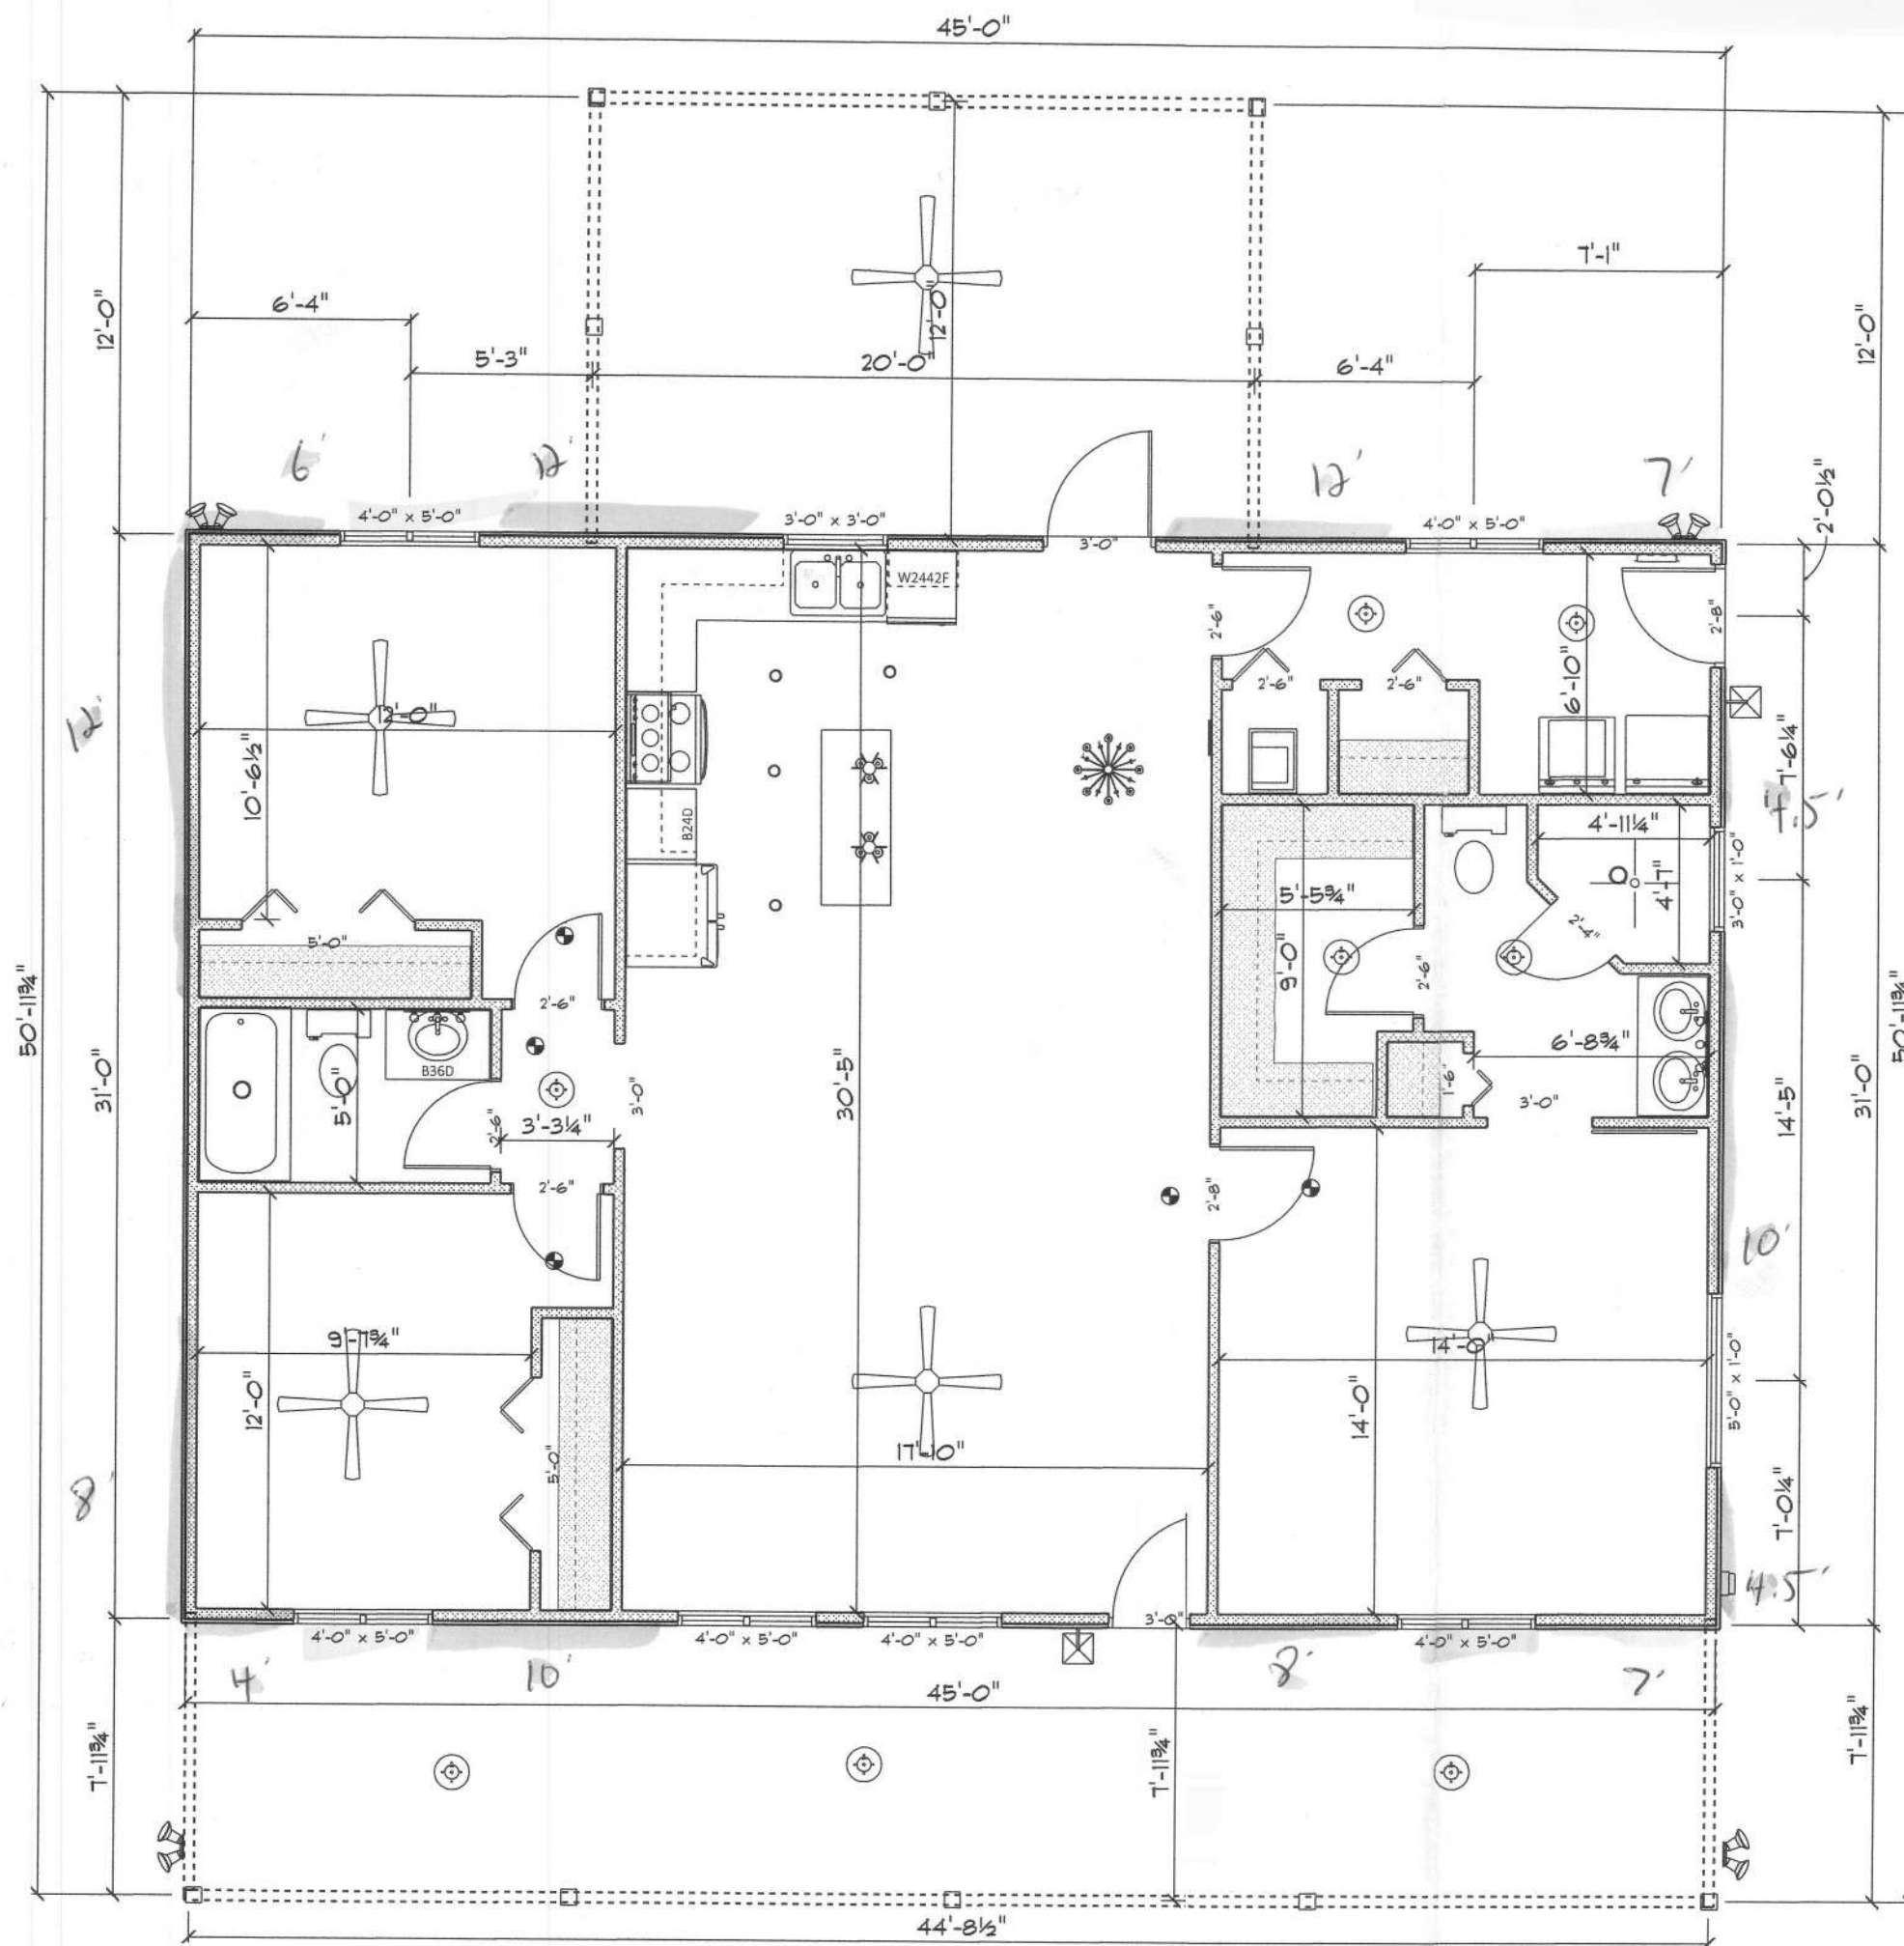

MAIN FLOOR

SCALE: 1/8" = 1'-0"

ELECTRICAL LEGEND		
ELECTRICAL	COUNT	SYMBOL
ceiling fan 4 bladed 01	5	
can light 4inch	4	
can light 6inch w/ exhaust fan	2	
ceiling classic	1	
ceiling light 22	2	
ceiling light 39	8	
exterior craftsman light fixture	4	
spotlight double with motion detector	6	
electrical panel	2	
smoke detector	5	
vanity bar light 02	4	

AREA SCHEDULE	
NAME	AREA
Total Square Footage	2018.0 sq ft.
Heat and Cool	1414.1 sq ft.
Porches	603.9 sq ft.




TR-39
Long-66

John Norris Construction, L.L.C.
Mattox Residence
3401 SE October Rd
Lake City, FL 32025,




Front Elevation

SCALE: $\frac{1}{8}" = 1'-0"$

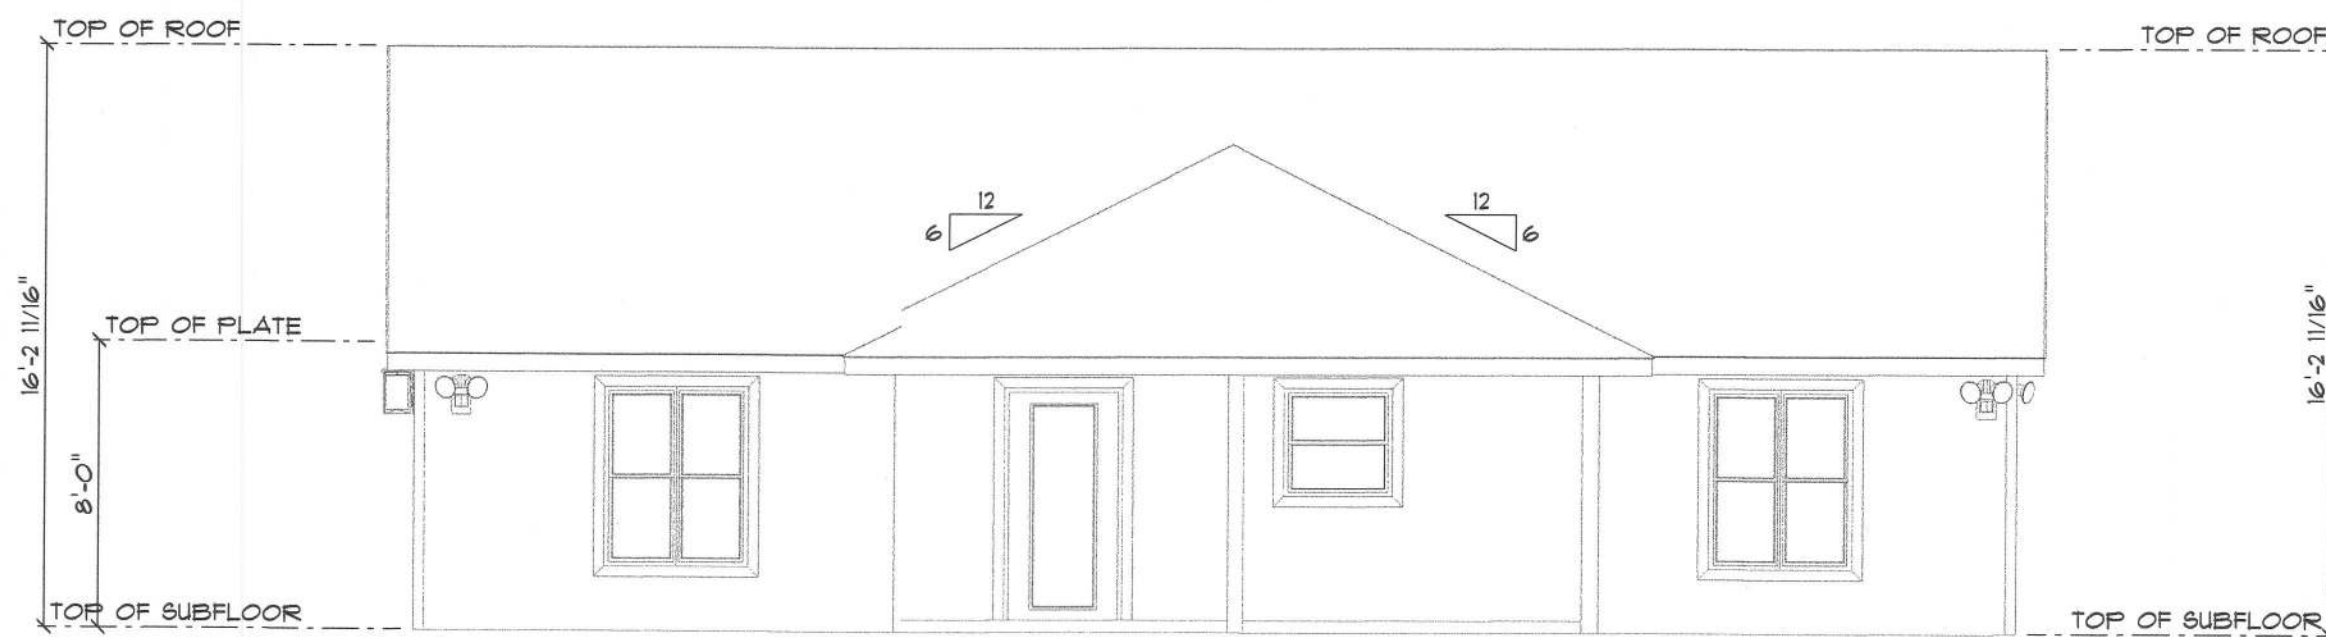


Rear Elevation

SCALE: $\frac{1}{8}" = 1'-0"$

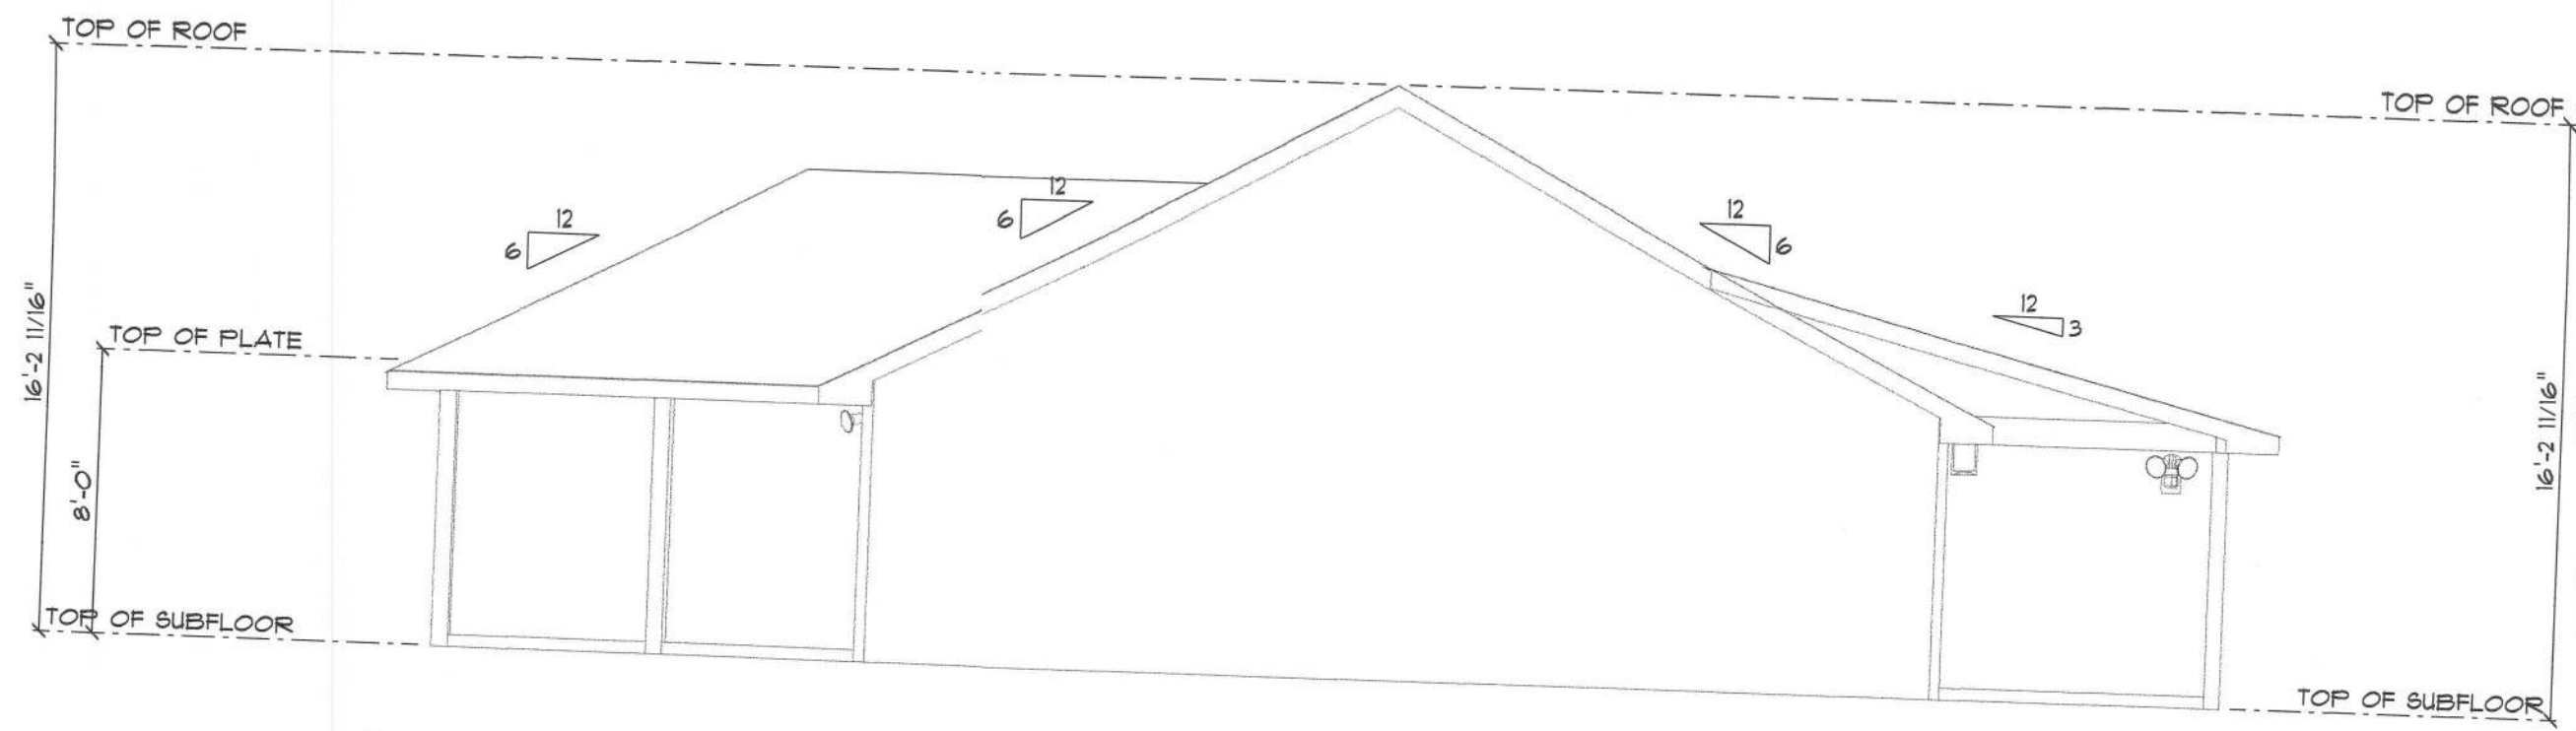

Left Elevation

SCALE: $\frac{1}{8}" = 1'-0"$

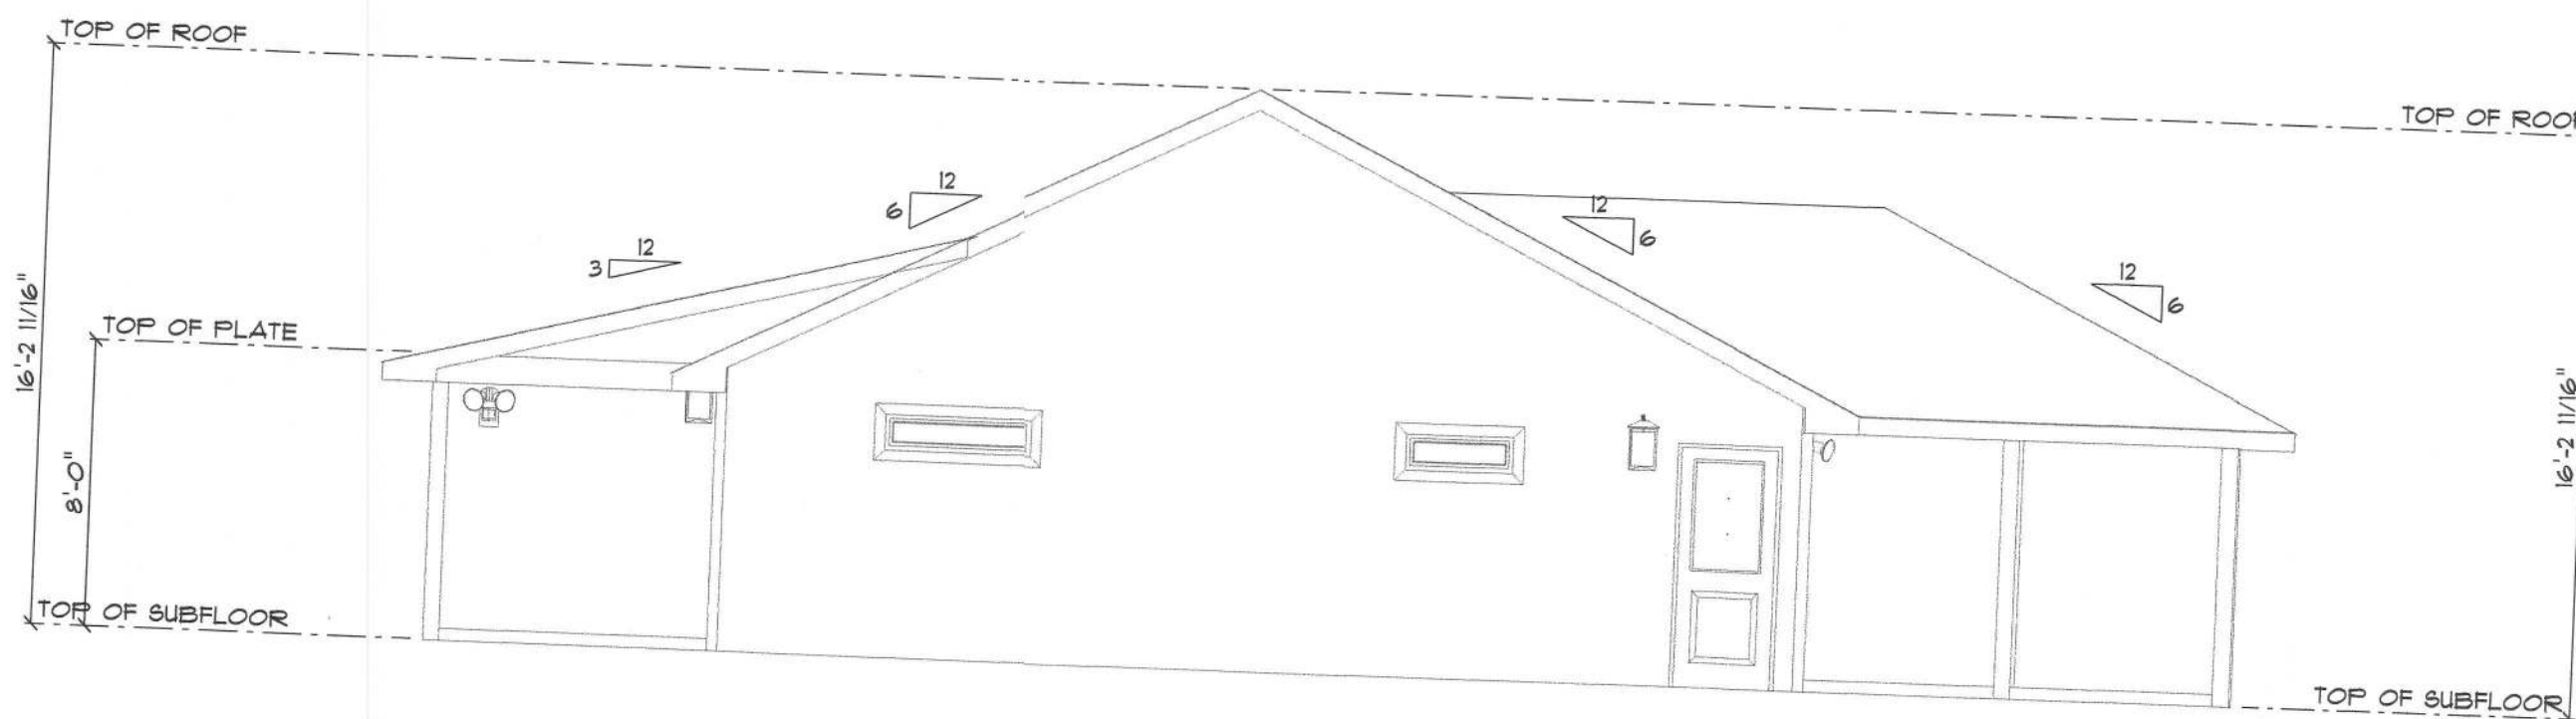

Right Elevation

SCALE: $\frac{1}{8}" = 1'-0"$