


1 BACK ELEV
Scale: 3/16" = 1'-0"

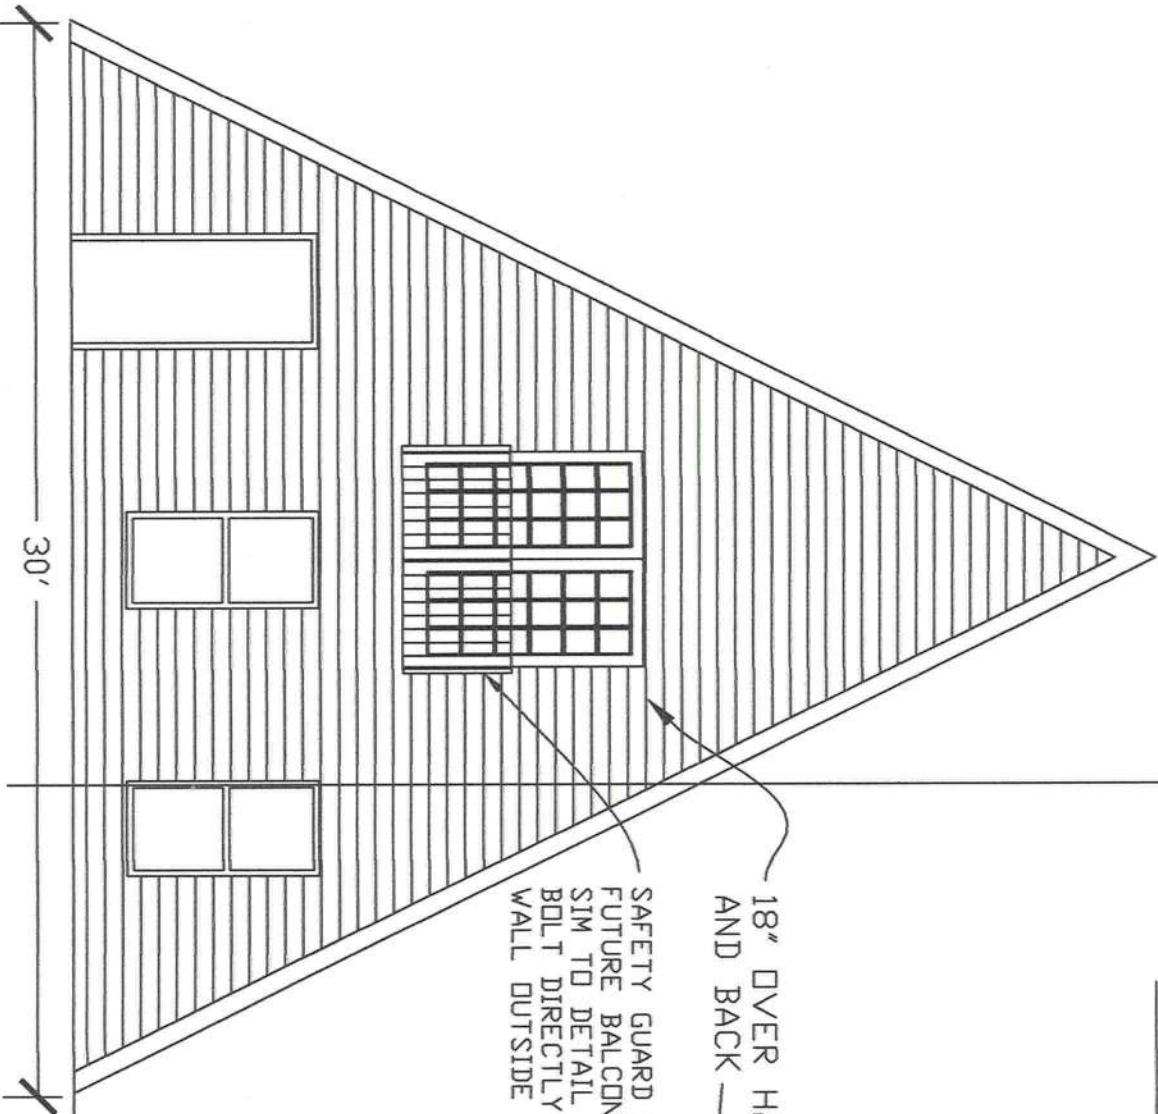

18' OVER HANG FRONT
AND BACK


SAFETY GUARD RAIL AT
FUTURE BALCONY DOORS
SIM TO DETAIL 2/A3
BOLT DIRECTLY TO
WALL OUTSIDE DOORS

12
24

METAL FASCIA

30'

2 FRONT ELEVATIONS
Scale: 3/16" = 1'-0"

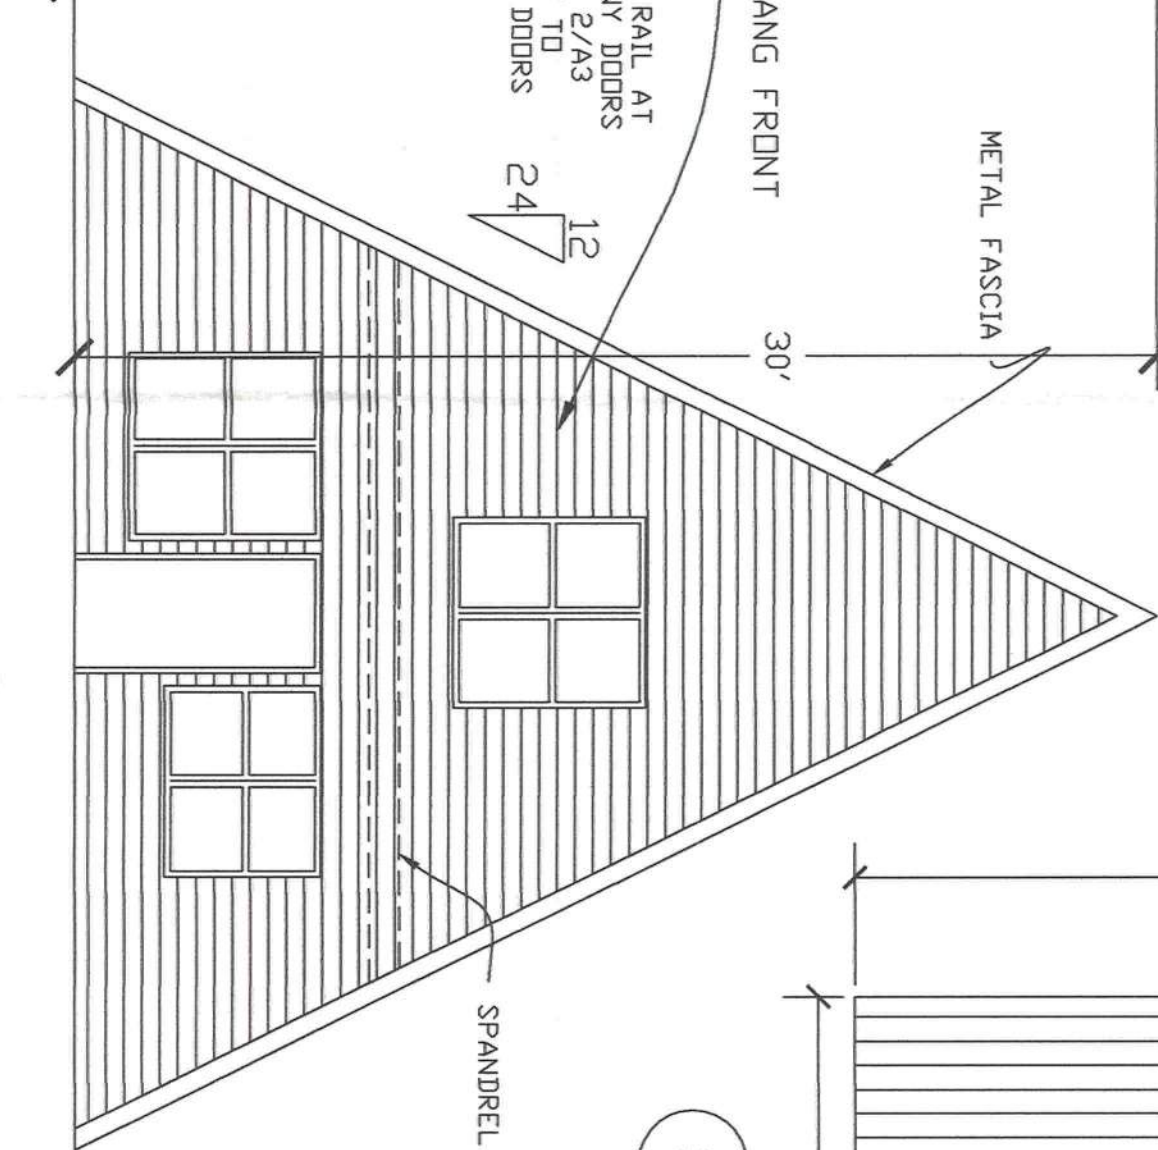


SPANDREL BEAM

PARTIAL SECOND
FLOOR LINE

30'

3 SIDE ELEVATION
Scale: 1/8" = 1'-0"

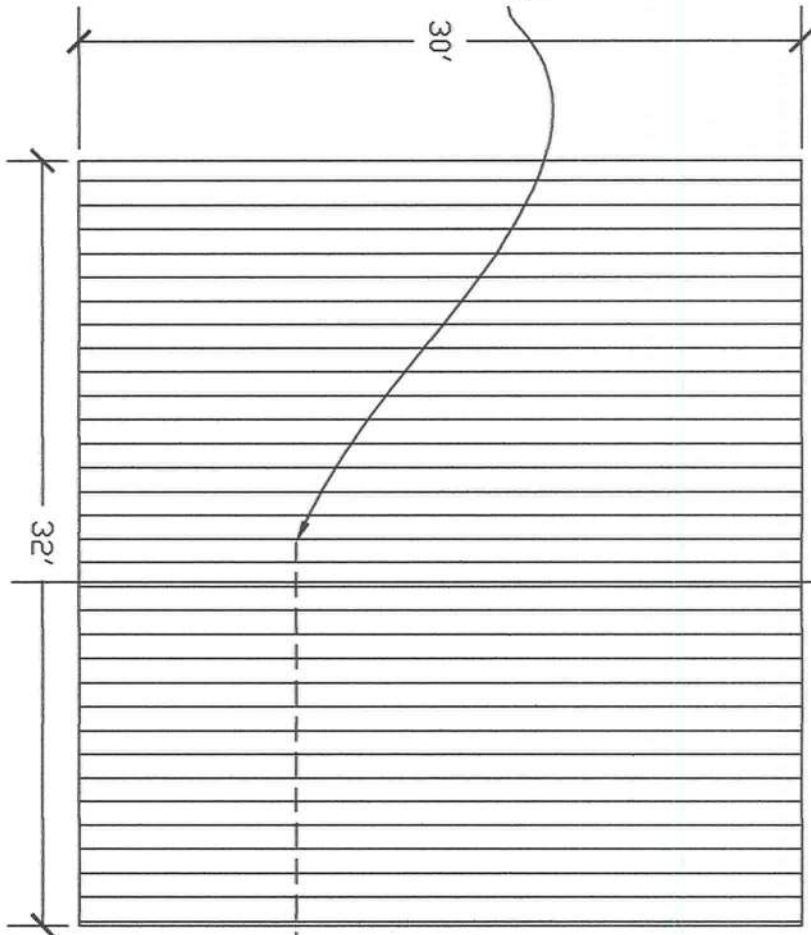



Paige Poole
9/17/05


ROOM FINISH DOT SCHEDULE

NO ROOM NAME	BASE MAT	FLOOR MATL	WALLS					CLG	NOTES	NO
			NORTH	SOUTH	EAST	WEST				
			MATL	MATL	MATL	MATL	MATL			
001 LIVING_RM	WD	CARP	SHT VINYL	HD CT	HD CT	HD CT	HD CT	TEX HD CT		001
002 CLOSET										002
003 CLOSET										003
004 KITCHEN										004
005 BATH										005
006 BED RM										006
007 CLOSET										007
008 LOFT										008

DOOR AND FRAME SCHEDULE



MARK	DOOR			FRAME		HDW	NOTES
	WD	HGT	THK	MATL	TYPE		
001	3'-0"	6'-8"	1 3/8"	STEEL	STL PANEL		
002	6'-0"	6'-8"	1 3/8"	WD HC	FLUSH		
003	3'-0"	6'-8"	1"	STL PANEL			
004	2'-10"	6'-8"	1 3/8"	STEEL			
005	2'-8"	6'-8"	1 3/8"	WD HC	FLUSH		
006	2'-4"	6'-8"	1 3/8"	WD HC	FLUSH		
007	6'-0"	6'-8"	1 3/8"	WD HC	FLUSH		
008	6'-0"	6'-8"	1 3/4"	WD	FRENCH		Tempered glass

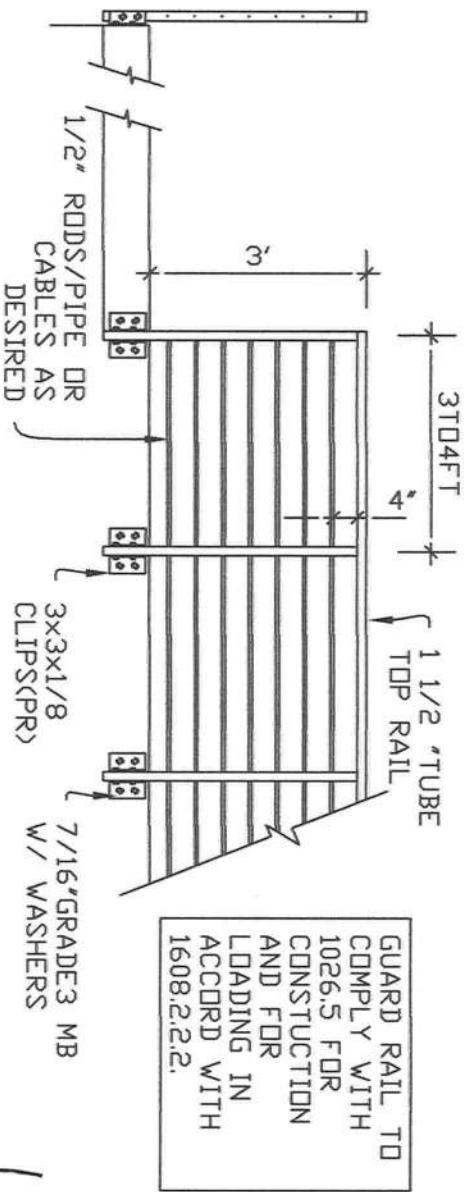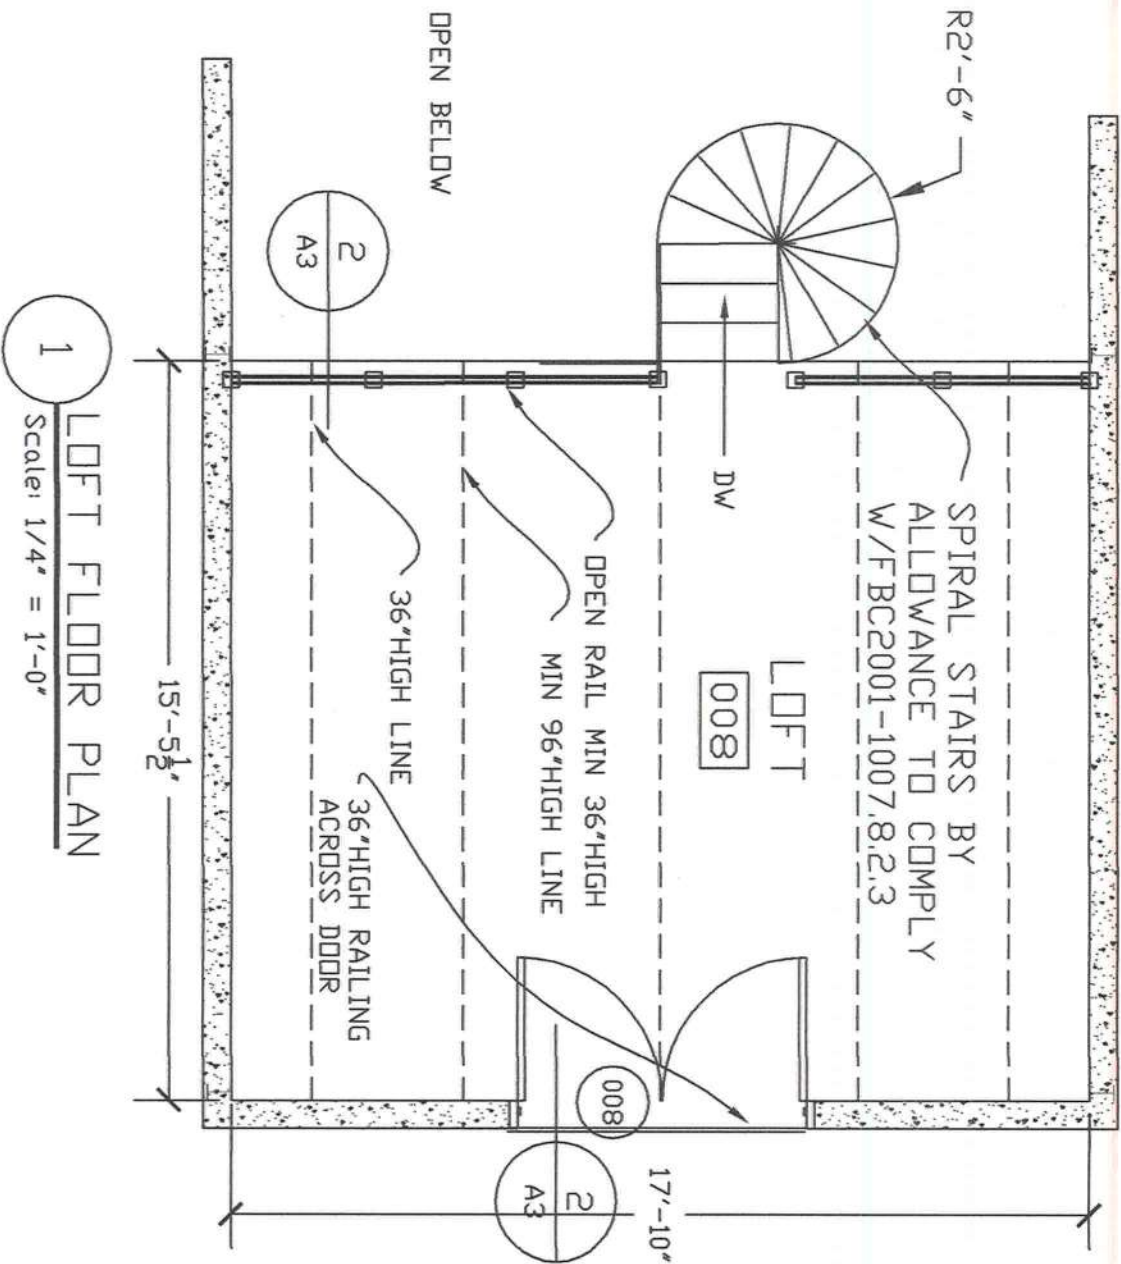

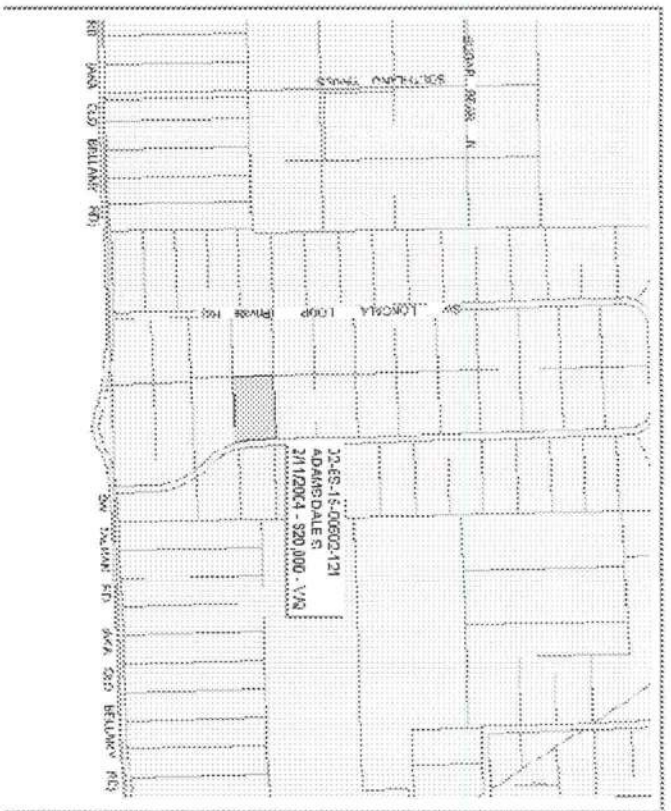

LOCATION MAP

 No Scale!

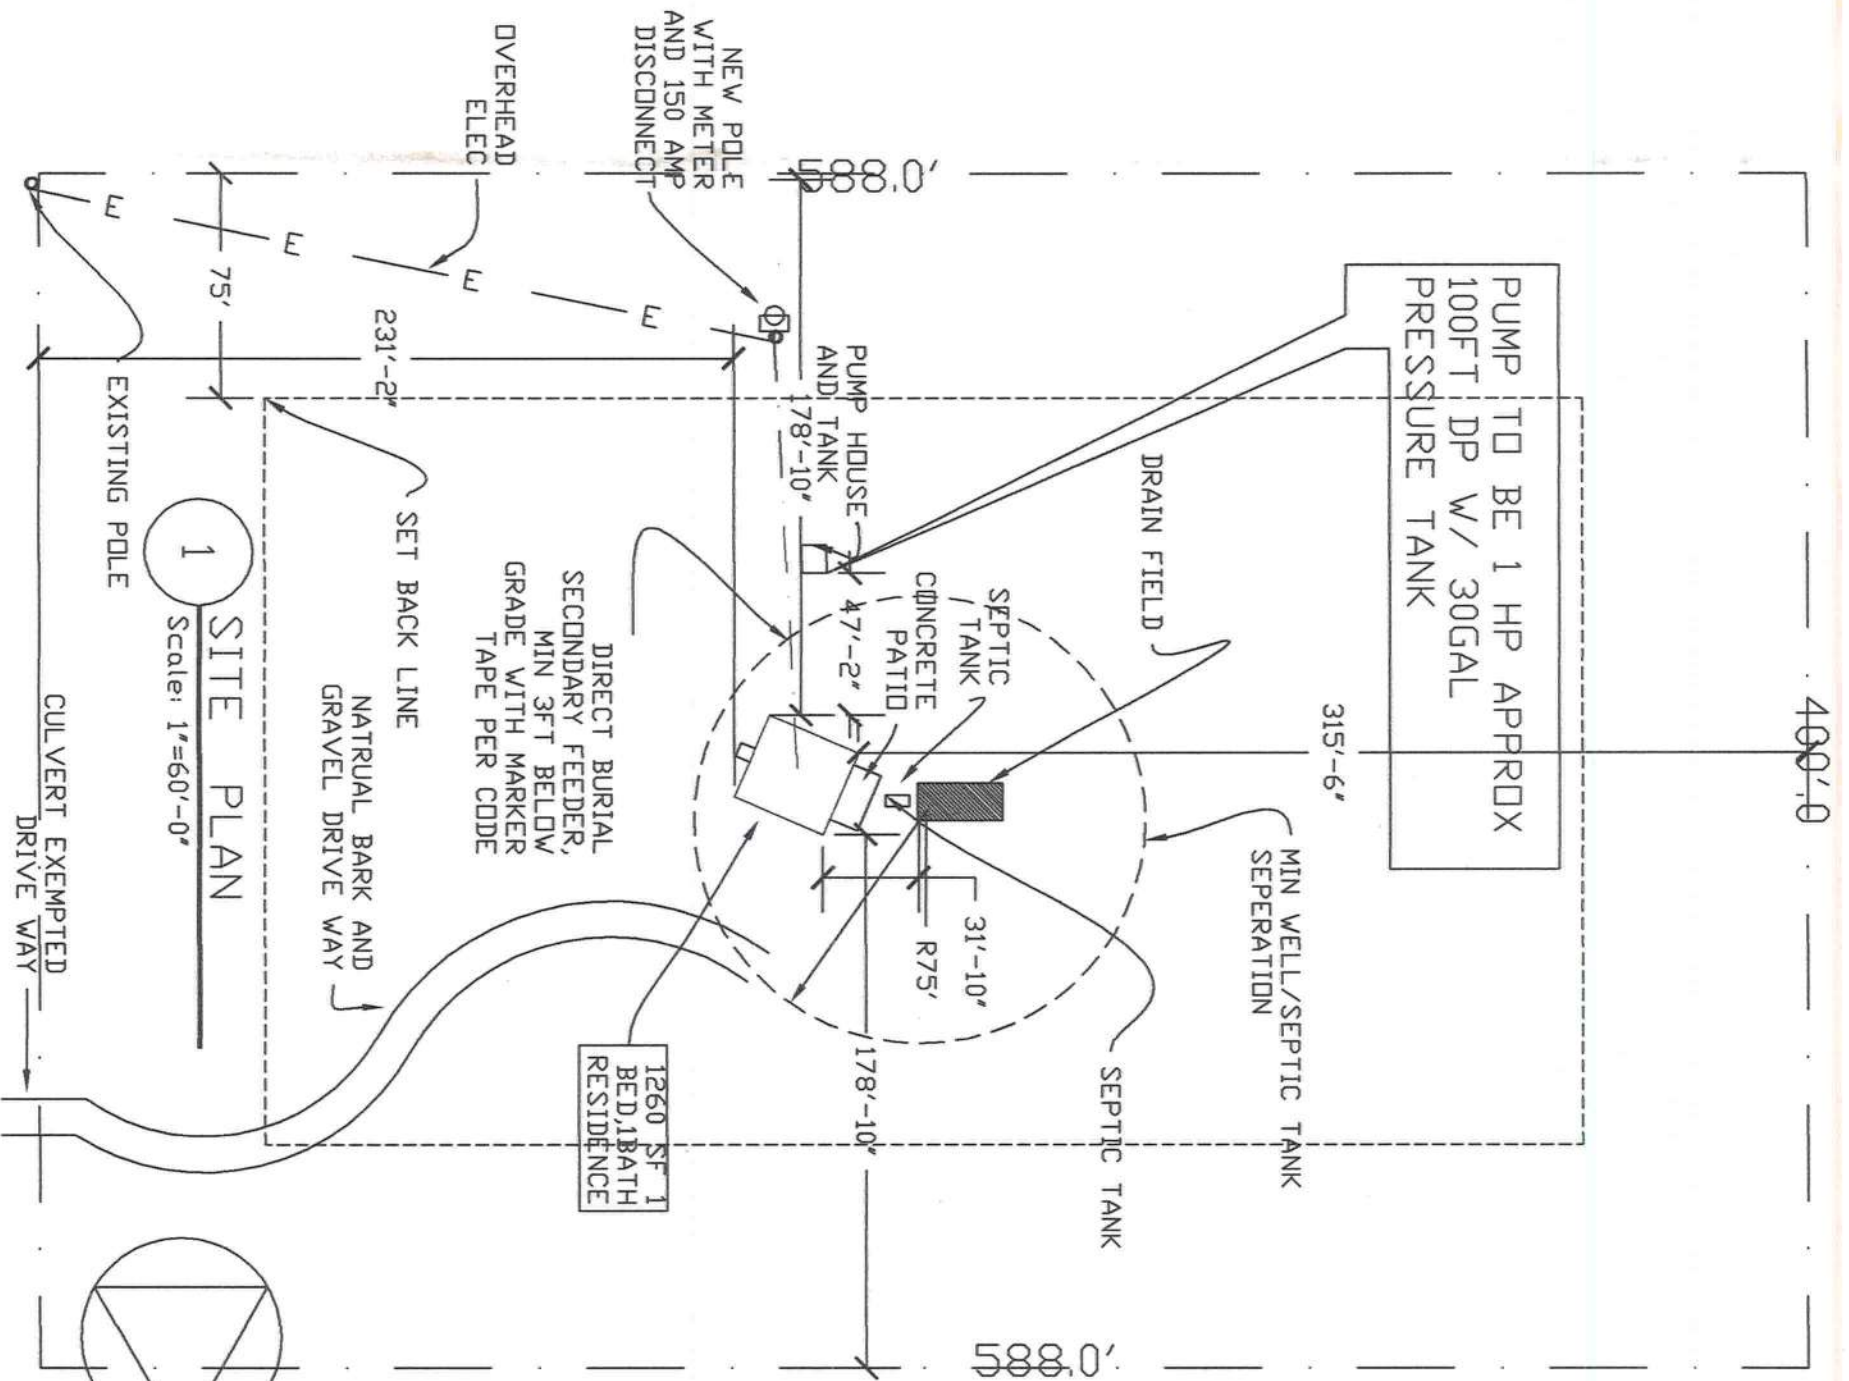

Office copy


REVISIONS	

PAIGE POOLE ARCHITECT
8601 NW 4TH PLACE
GAINESVILLE FLORIDA 32607-1414
352-332-7206 PHONE/FAX


VACATION HOME FOR DALE S ADAMS
358 SW LONCALA LOOP
FORT WHITE FLORIDA
3811 SW 17TH AVE

SHEET TITLE
SITE PLAN

A1 DF	SHEET NO.	DRAWN P.L.P.
		CHECKED L.M.N

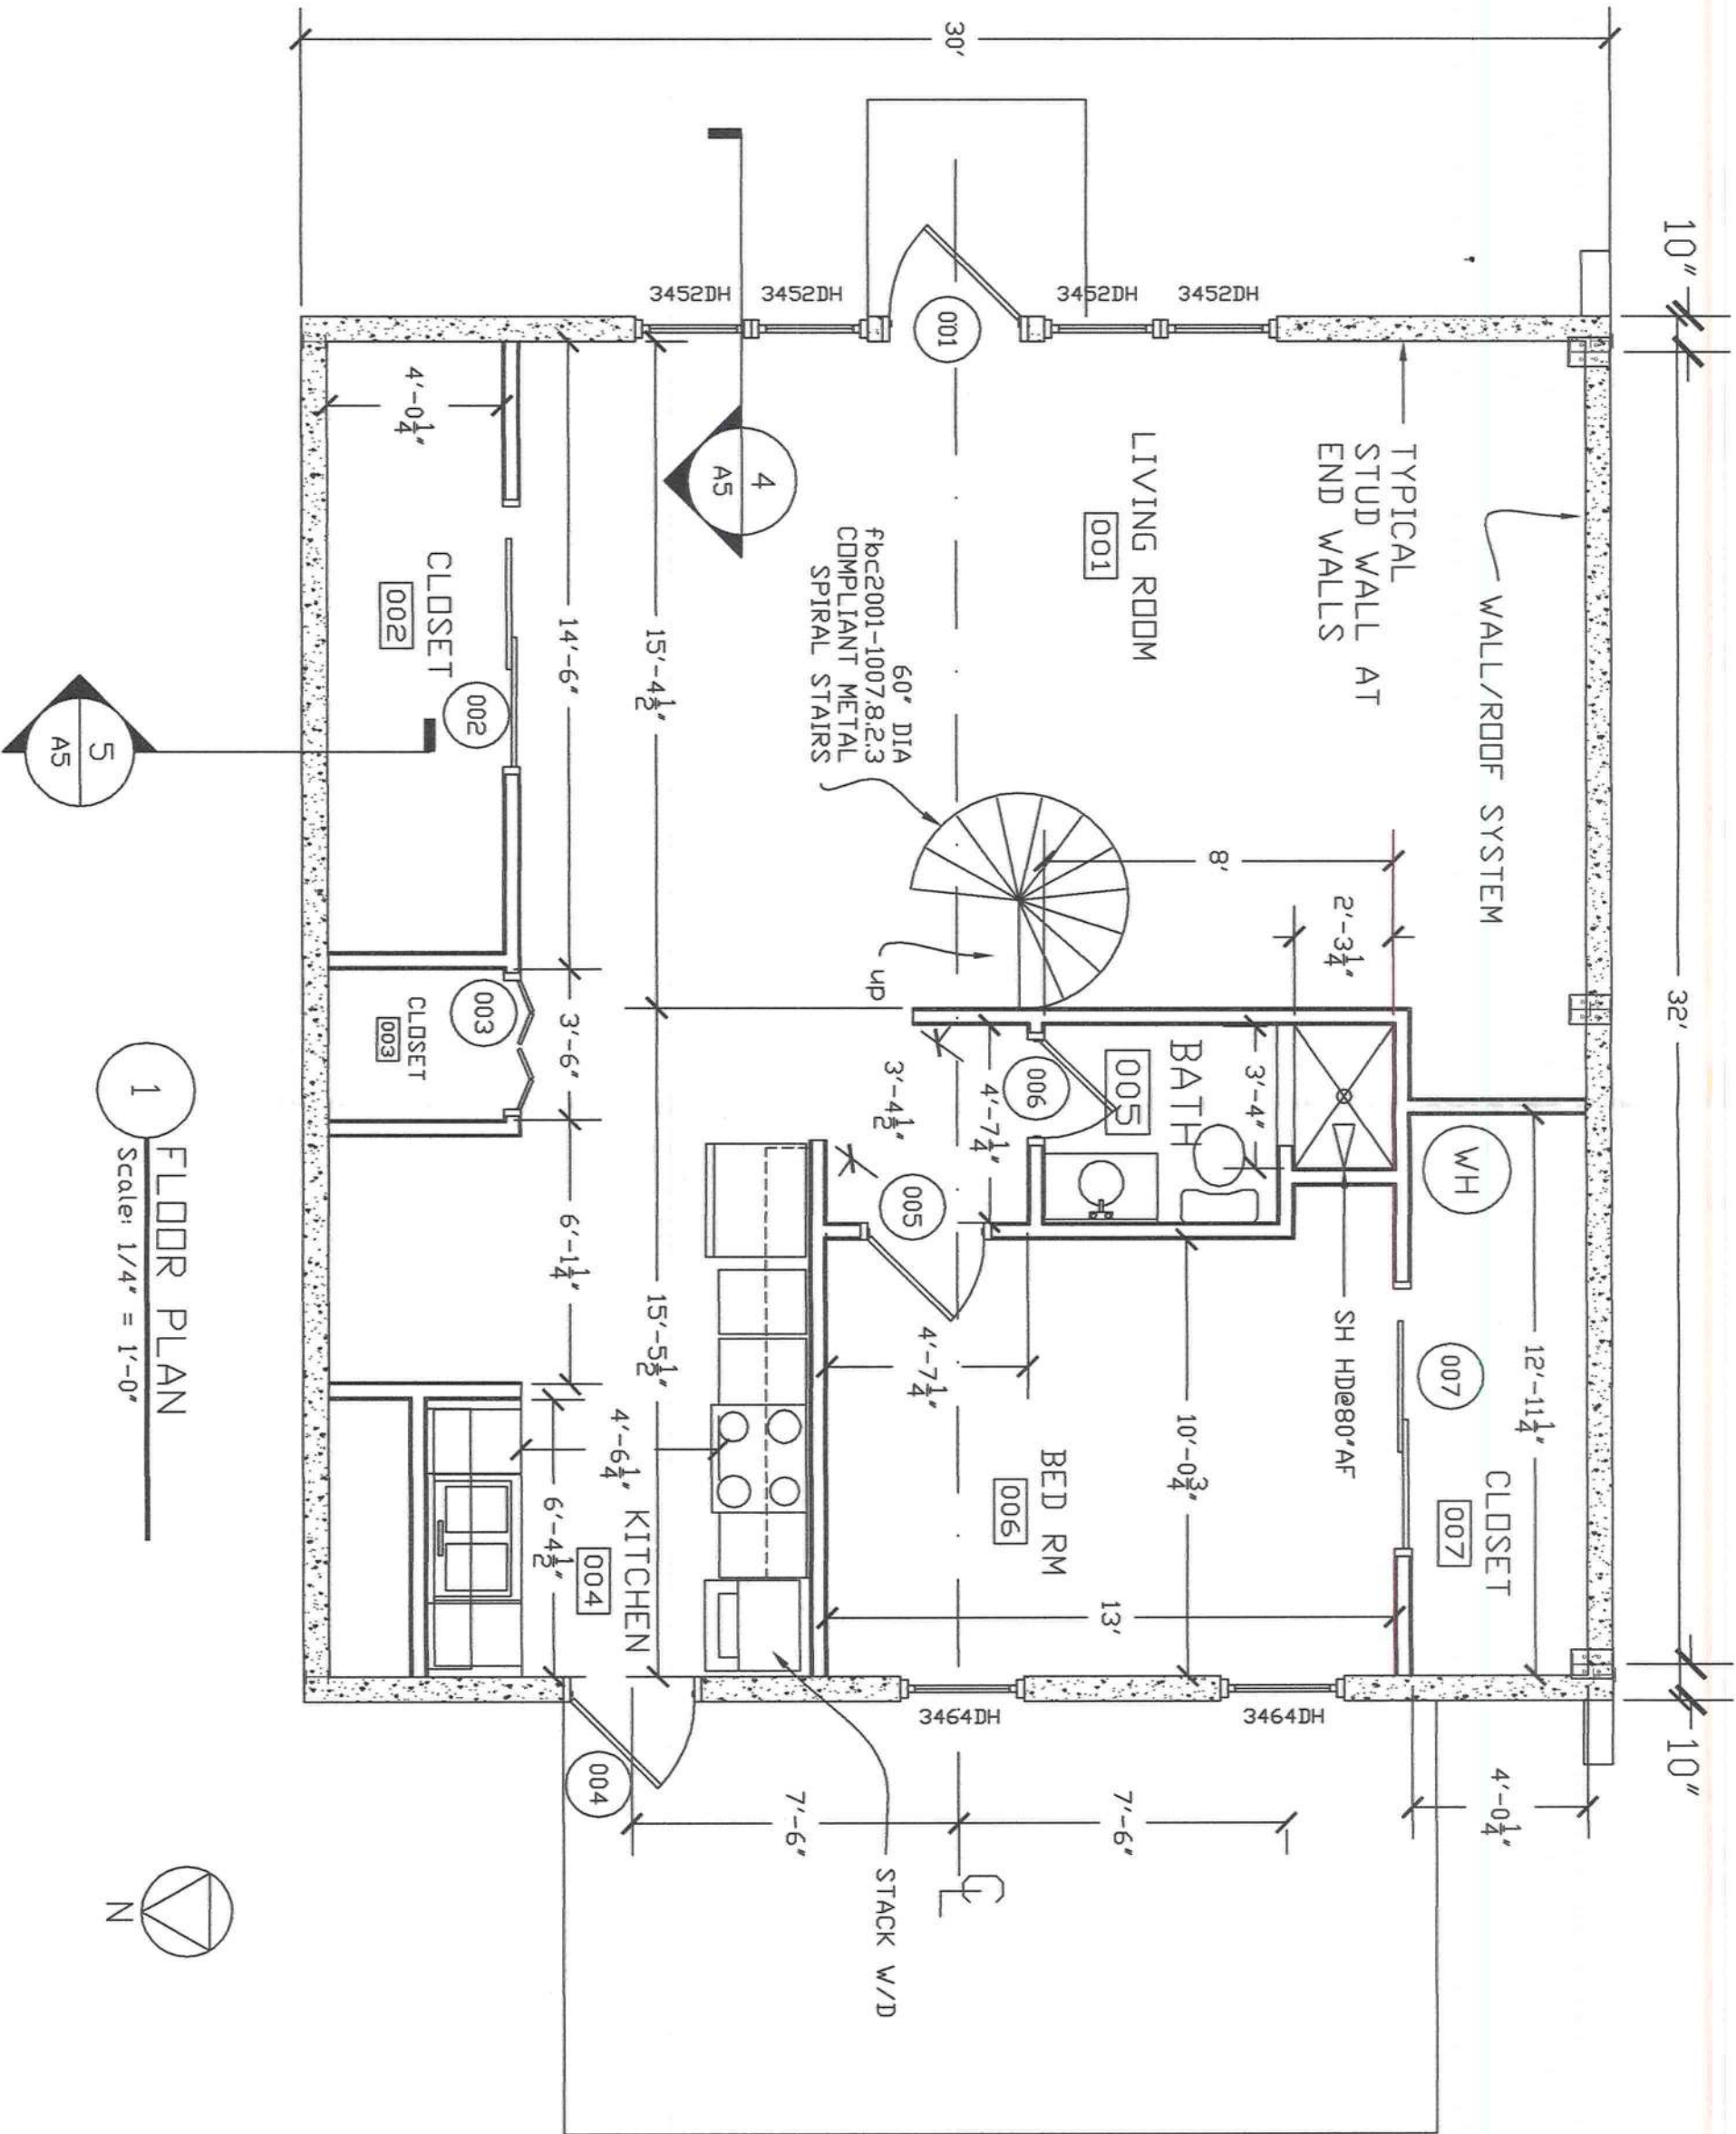



1 FLOOR PLAN
Scale: 1/4" = 1'-0"

 

Paige Poole
9/17/05


NOTE ALL STRUCTURAL MEMEBERS GIVEN ARE FOR DESIGN INTENT. ANY STRUCTURAL SHAPE HAVING A GREATER OR EQUAL MOMENT OF INERTIA AND SECTION MODULAS FOR THE SIZE GIVEN IS ACCEPTABLE.

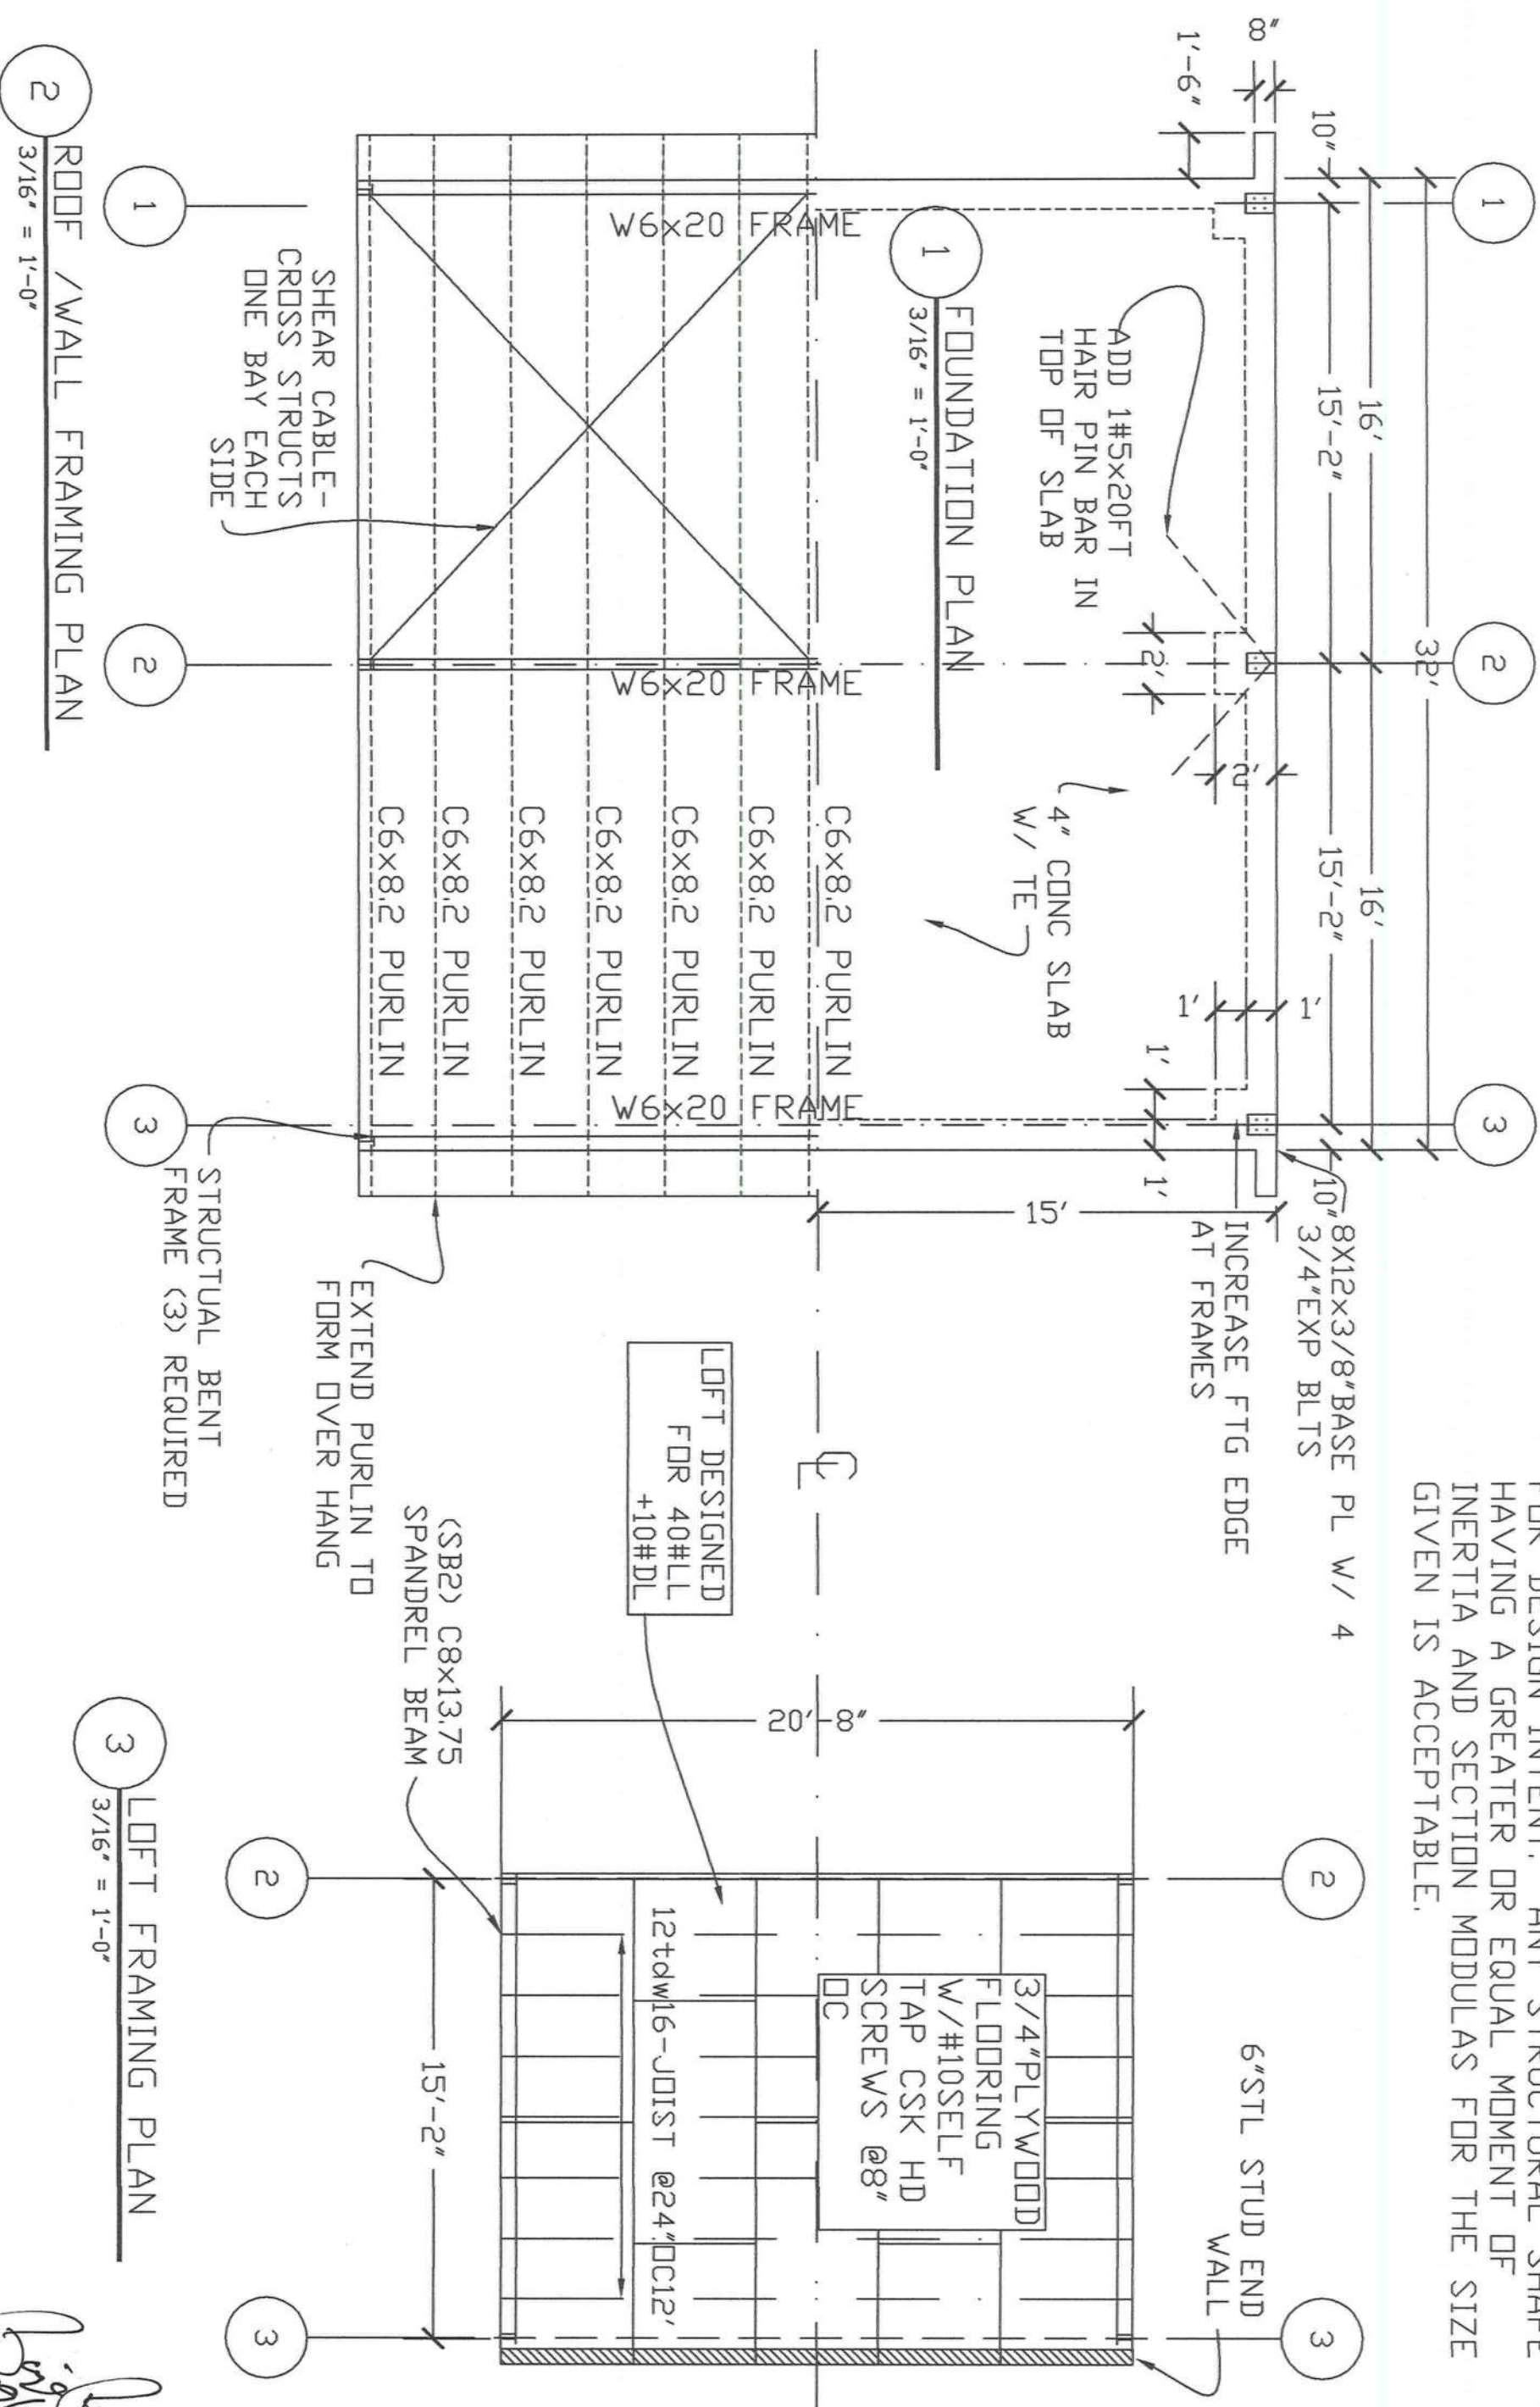

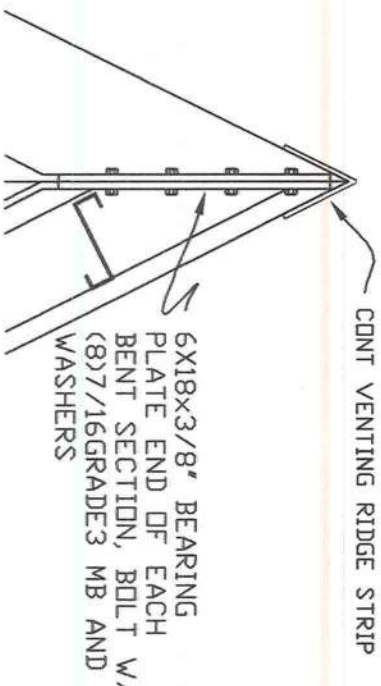




DETAILS

1 Scale: 3/4" = 1'-0"

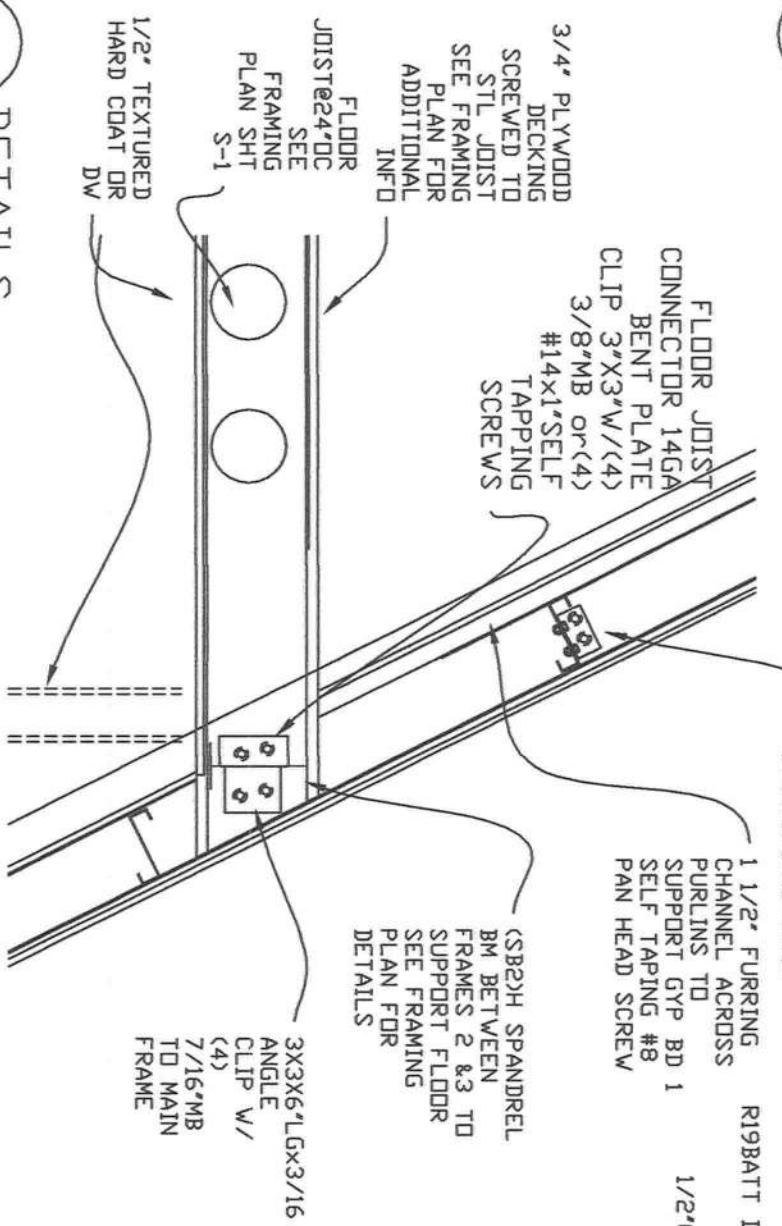

DETAILS

2 Scale: 3/4" = 1'-0"

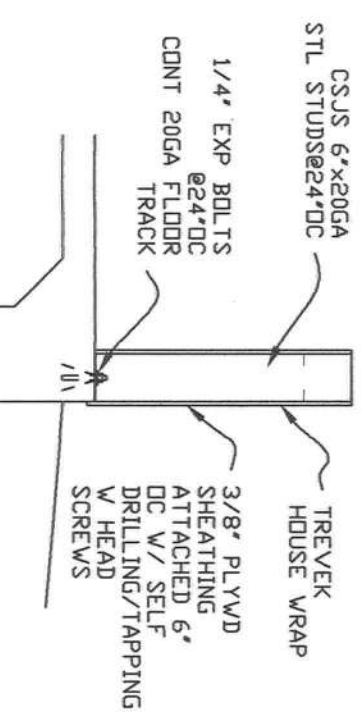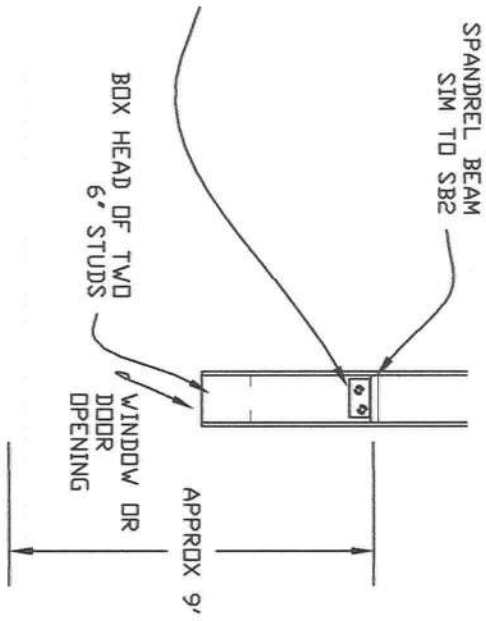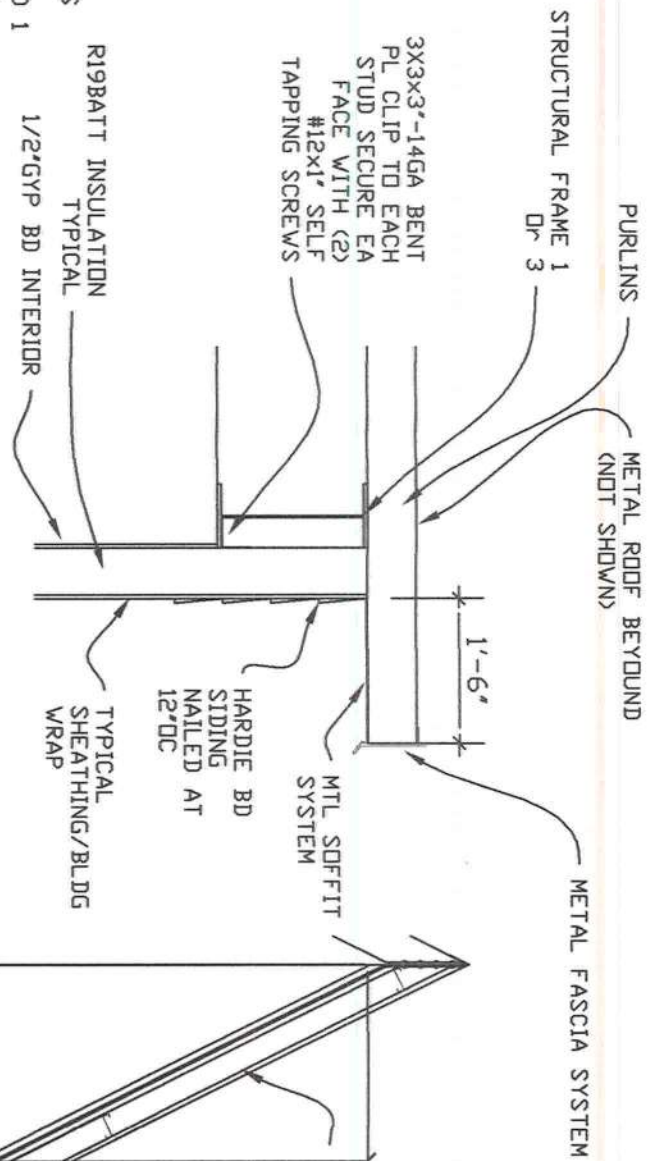

DETAILS


3 Scale: 3/4" = 1'-0"

TYPICAL ENDWALLS DETAIL


4 Scale: 3/8" = 1'-0"

TYPICAL WALL SECTION


5 Scale: 1/4" = 1'-0"

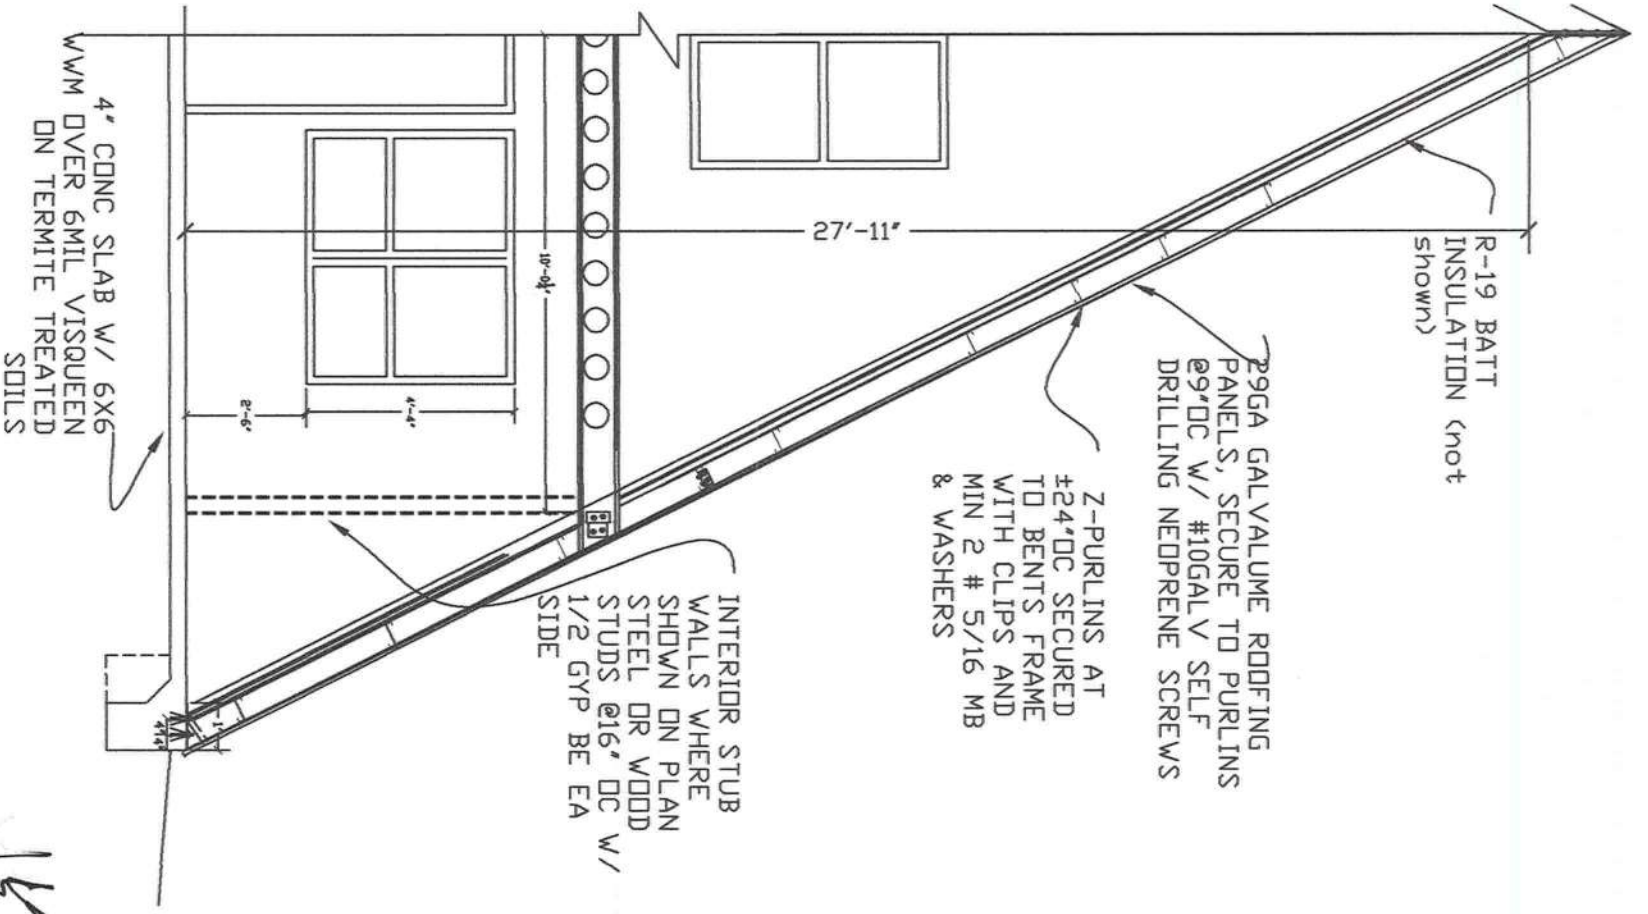

NOTE!
No manual J Or D is required

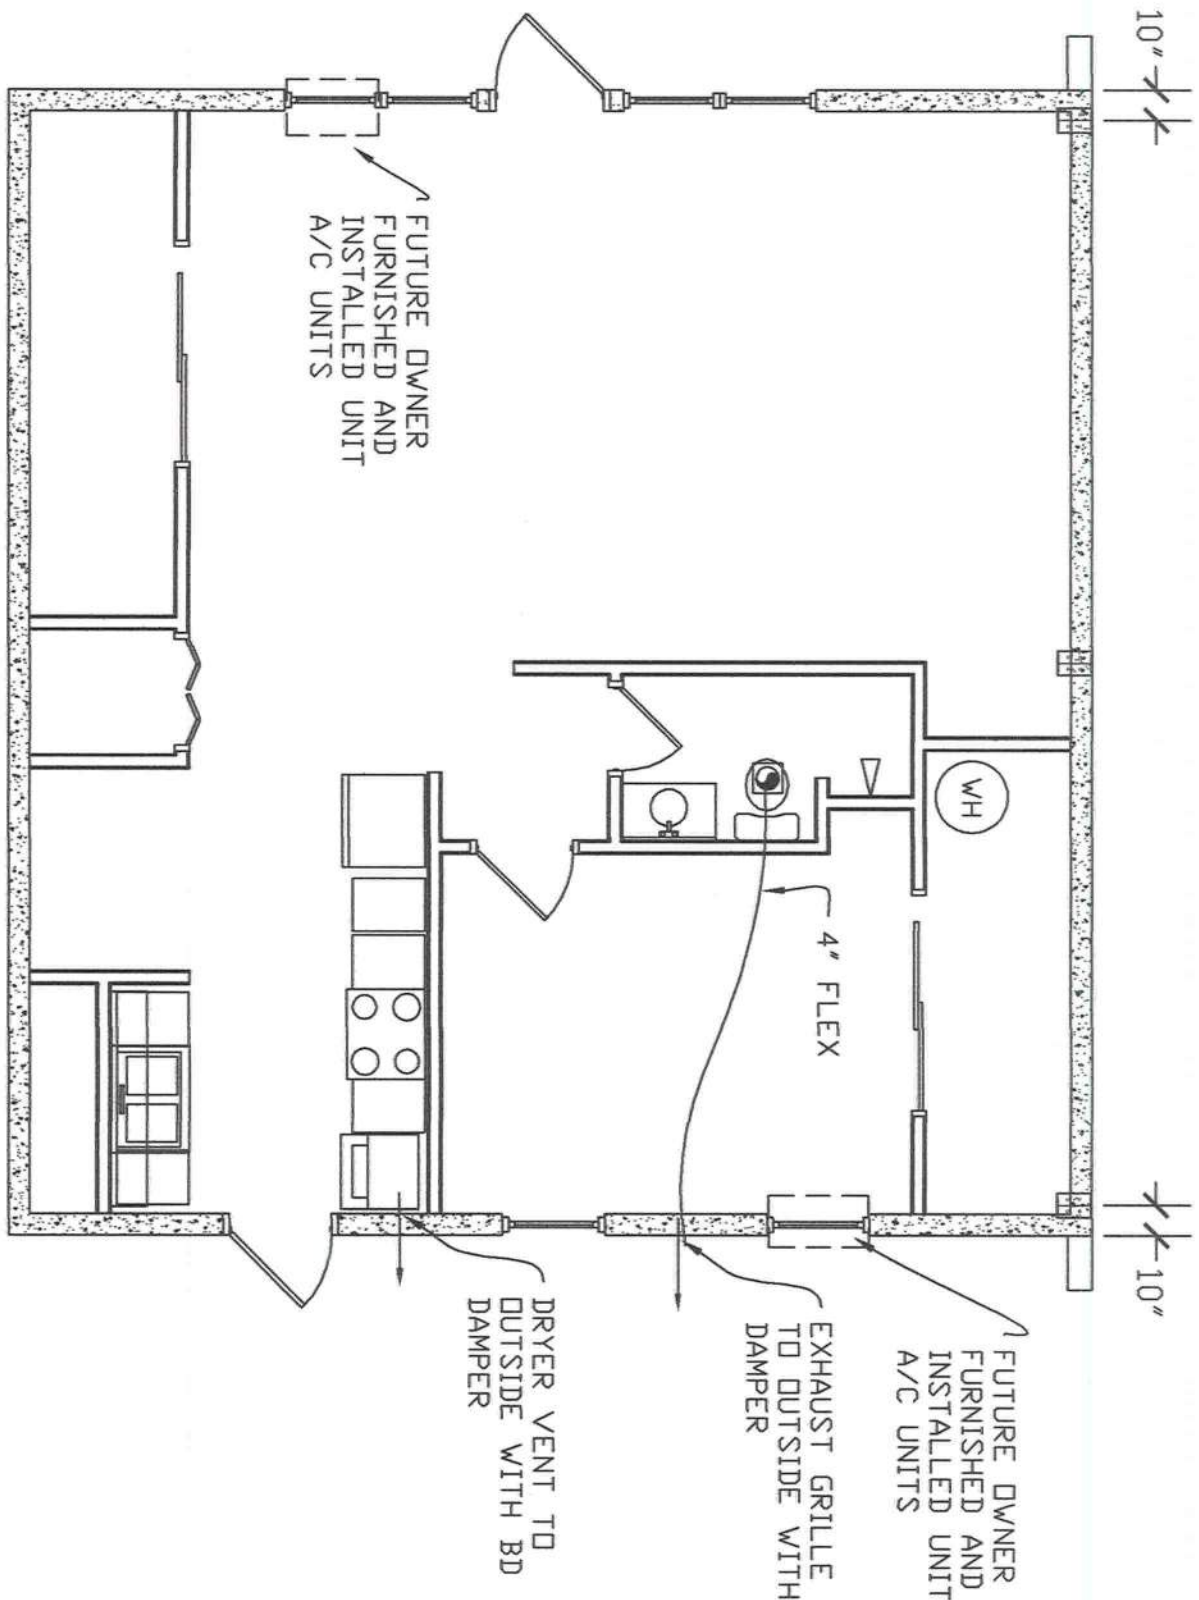


NOTE!
HOUSE IS NOT CONDITIONED UNDER THIS CONTRACT. FUTURE CONDITIONING IS AN OWNER OPTION

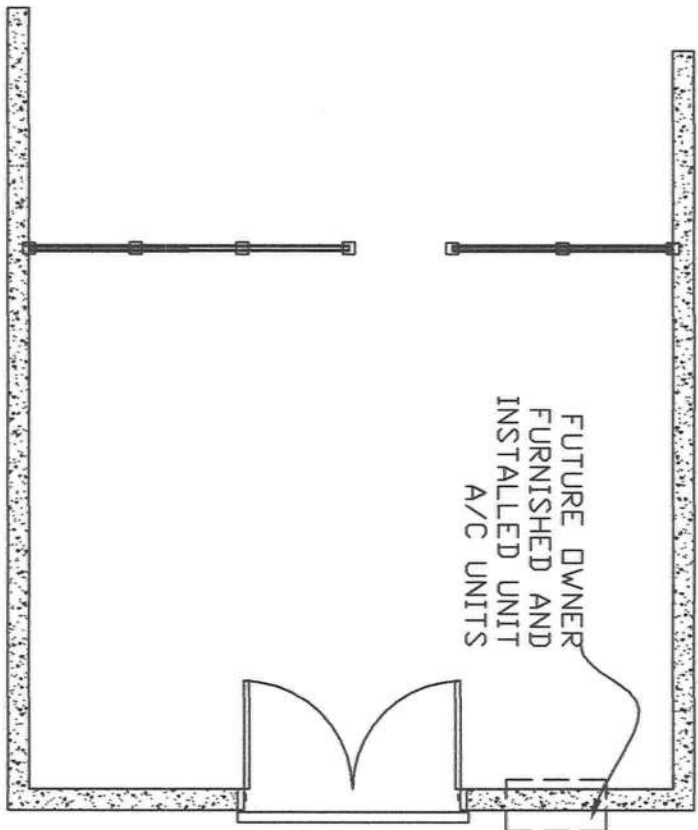


1 MECHANICAL FLOOR PLAN
Scale: 3/16" = 1'-0"

Handwritten signature and date: 9/16/05

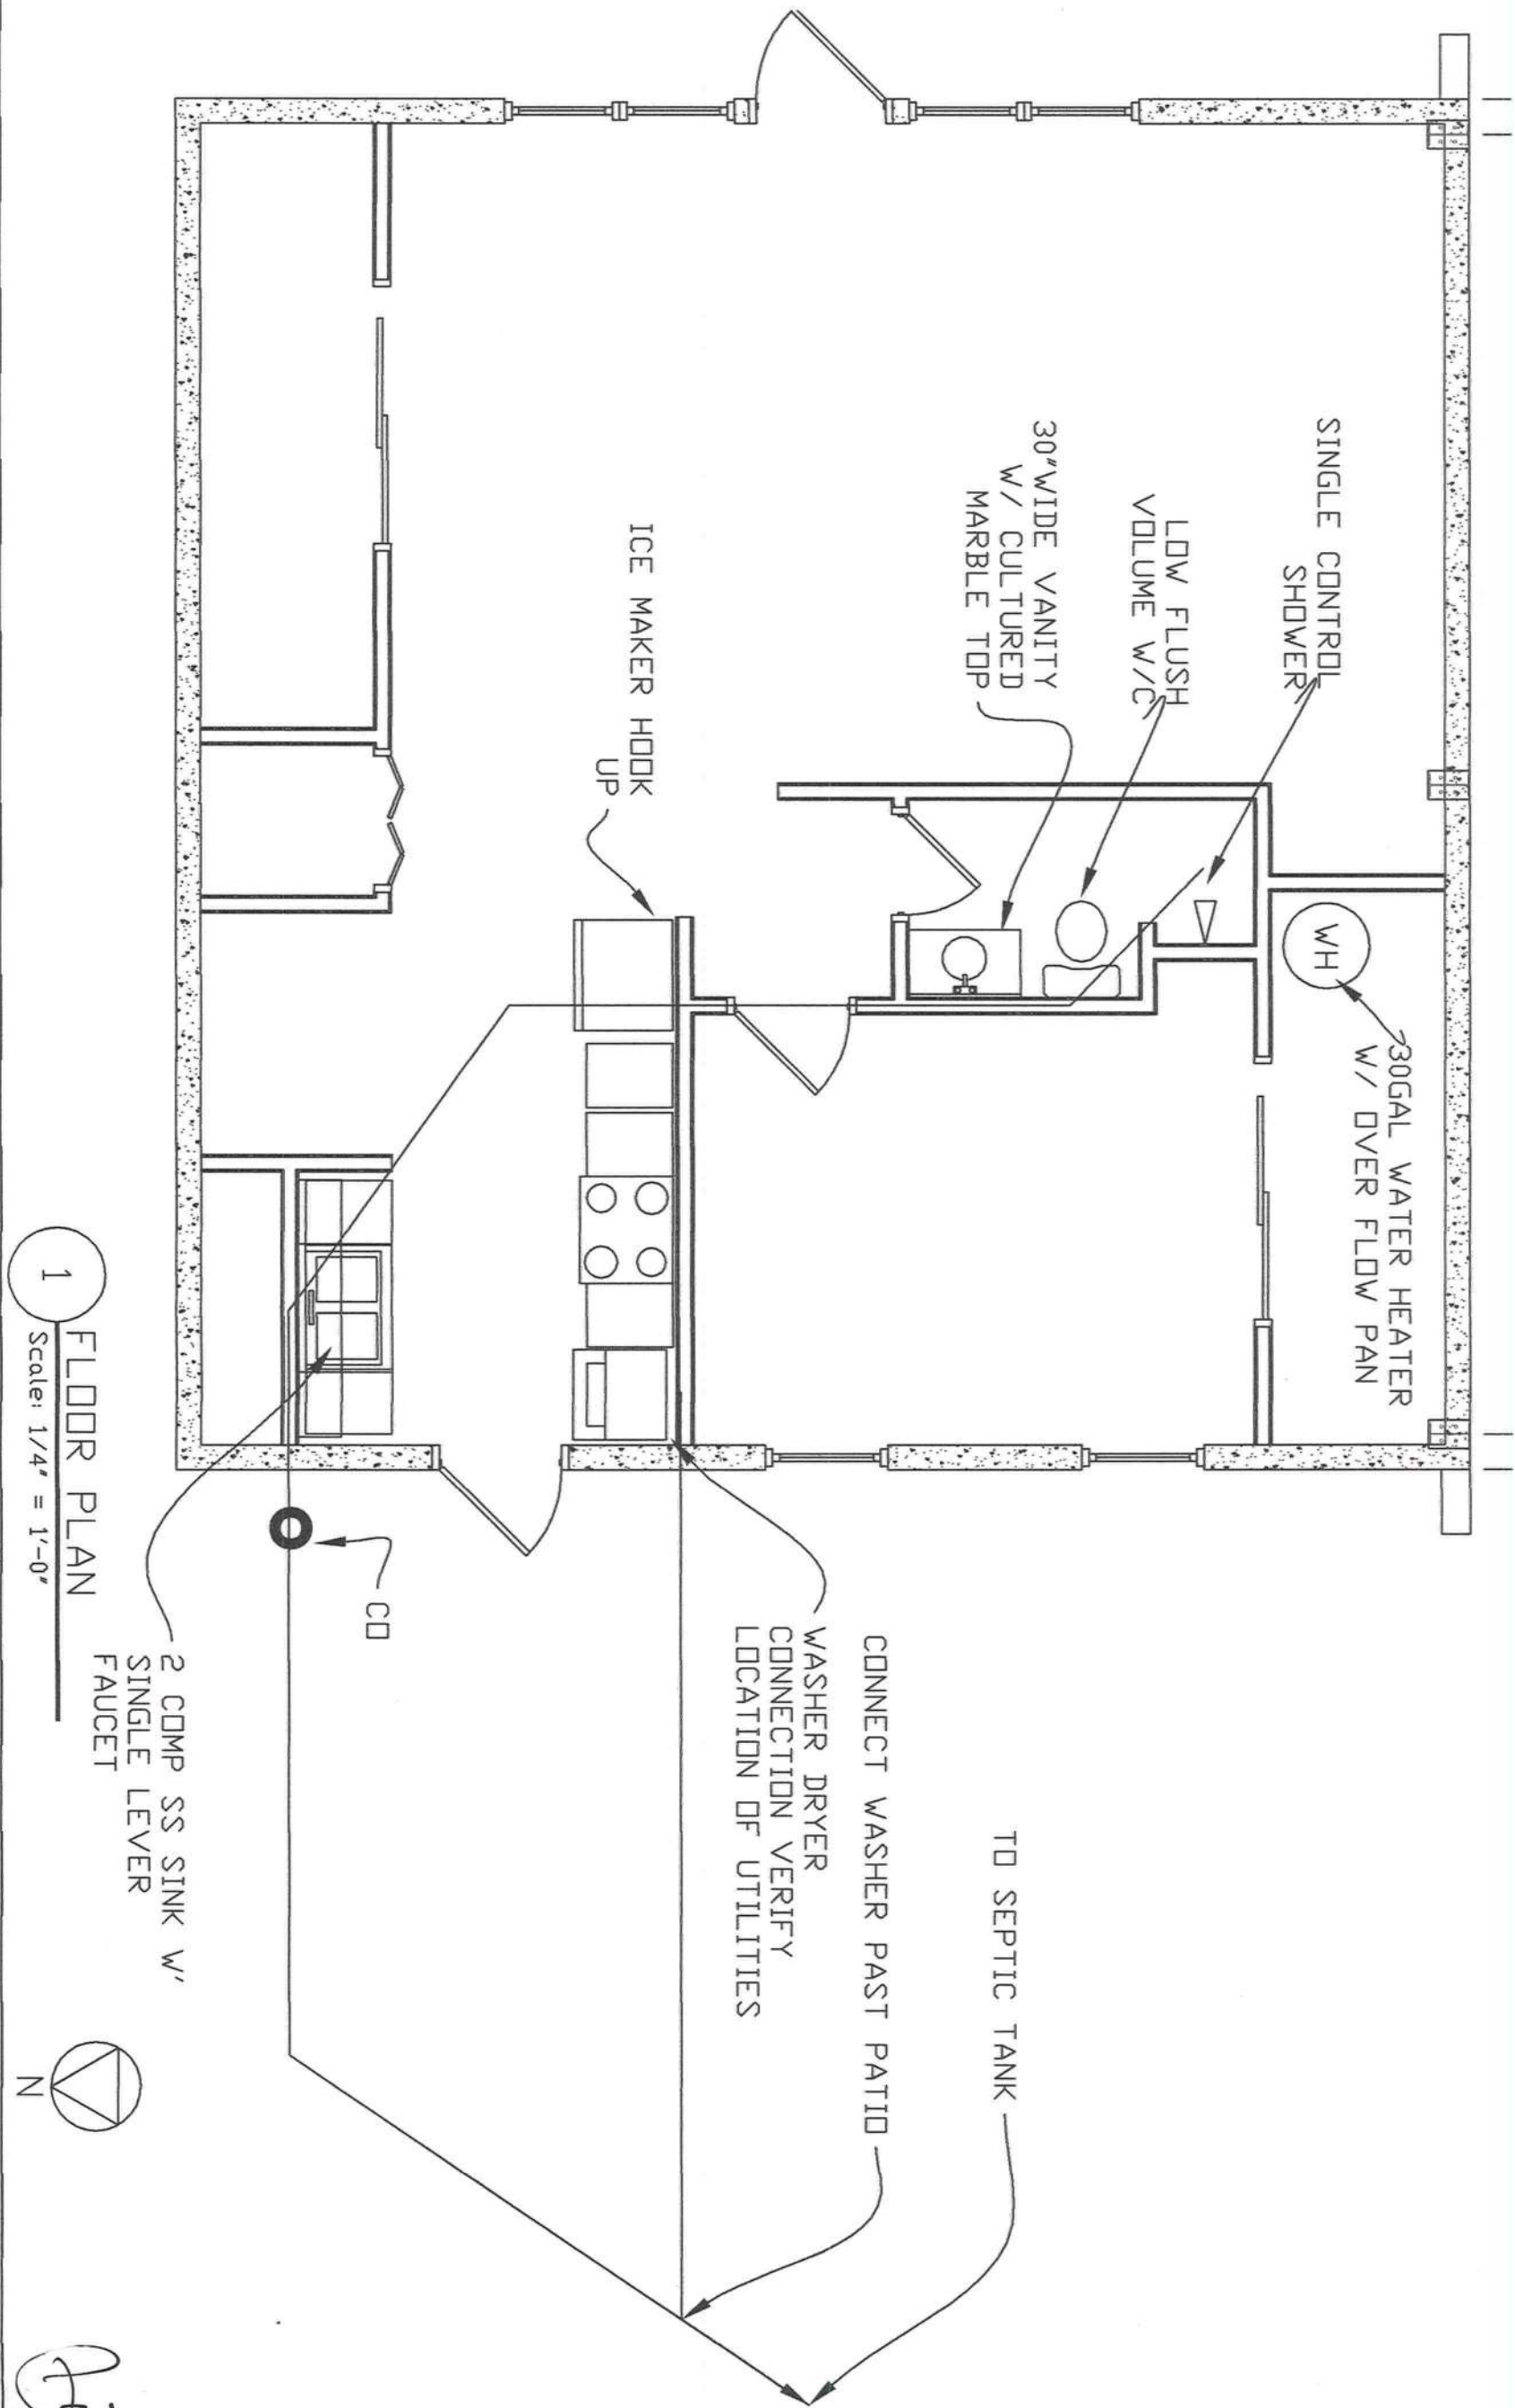


1 FLOOR PLAN
Scale: 1/4" = 1'-0"

 

Paige Poole
9/17/05

DATE 15 AUG 05	FILE NUMBER 056 HERITAGE	REVISIONS		PAIGE POOLE ARCHITECT 8601 NW 4TH PLACE GAINESVILLE FLORIDA 32607-1414 352-332-7206 PHONE/FAX		VACATION HOME FOR DALE S ADAMS 358 SW LONCALA LOOP FORT WHITE FLORIDA 3811 SW 17TH AVE		SHEET TITLE FIRST FLOOR PLAN		DRAWN P.L.P. CHECKED L.M.N.	SHEET NO. P1 OF 1
-------------------	-----------------------------	-----------	--	--	--	---	--	---------------------------------	--	--------------------------------------	-------------------------

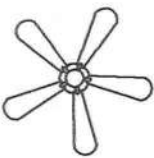

CEILING FAN WITH LIGHT KIT PROVIDE
FAN JUNCTION BOX, DOUBLE SWITCHED

SINGLE TUBE 48" FLOUR W/ WRAP AROUND
LENSE

48" (2) TUBE 40 WATT SURFACE MTG
DECORATIVE FLOUR FIXTURE

RECESSED LIGHT W/ TG PROVIDE CHOICE OF TRIMS
CEILING LIGHT SURFACE MOUNTED

DECORATIVE WALL LIGHT CENTER OVER VANITY
WEATHER PROOF
EXTERIOR LIGHT WALL

110V SMOKE DETECTOR WIRE ALL
DECTORS TO SOUND CONCURRENTLY

STD DUPLEX OUTLET MTD 18" AF
UNLESS OTHERWISE NOTED

ARC FAULT CURRENT INTERRUPTING
DUPLEX OUTLET MTD 18" AF
INSTALLED IN ALL BEDROOMS
220V OUTLET AS REQUIRED BY
APPLANCE VERIFY PLUG CONFIG
REQUIRED

DUPLEX OUTLET GROUND FAULTED
GFI IF NOTED SHADING DENOTES TO
MOUNT MIN 6" ABV COUNTER HEIGHT
EXHAUST FAN MIN 50 CFM SUPPLIED BY MECH SUB SEE
FAN SWITCH FOR WIRING VENT FAN TO END WALL W/ WALL
CAP


PHONE OUTLET TERMINATE AT PHONE
ENTRANCE POINT
SHADED OUTLET INDICATE
TEL. PHONE OUTLET MTD 80" AFF FOR
WALL PHONE
SAT/CABLE TV OUTLET TERMINATE
AT CABLE ENTRANCE POINT, VERIFY
LOCATION

SINGLE POLE SWITCH
3 WAY SWITCH
FAN SWITCH, TWO SWITCHES ONE FOR
FAN ONE FOR LIGHT
METER CAN COMPLY WITH LOCAL STANDARDS

NEW 150A -2P SERVICE PANEL WITH 40 BREAKER CIRCUITS


DIRECT BURIAL CABLE TO
PANEL BD, PROVIDE
CONDUIT FROM UNDER
SLAB TO PNL BD

30A-2P TO
PUMP
HOUSE

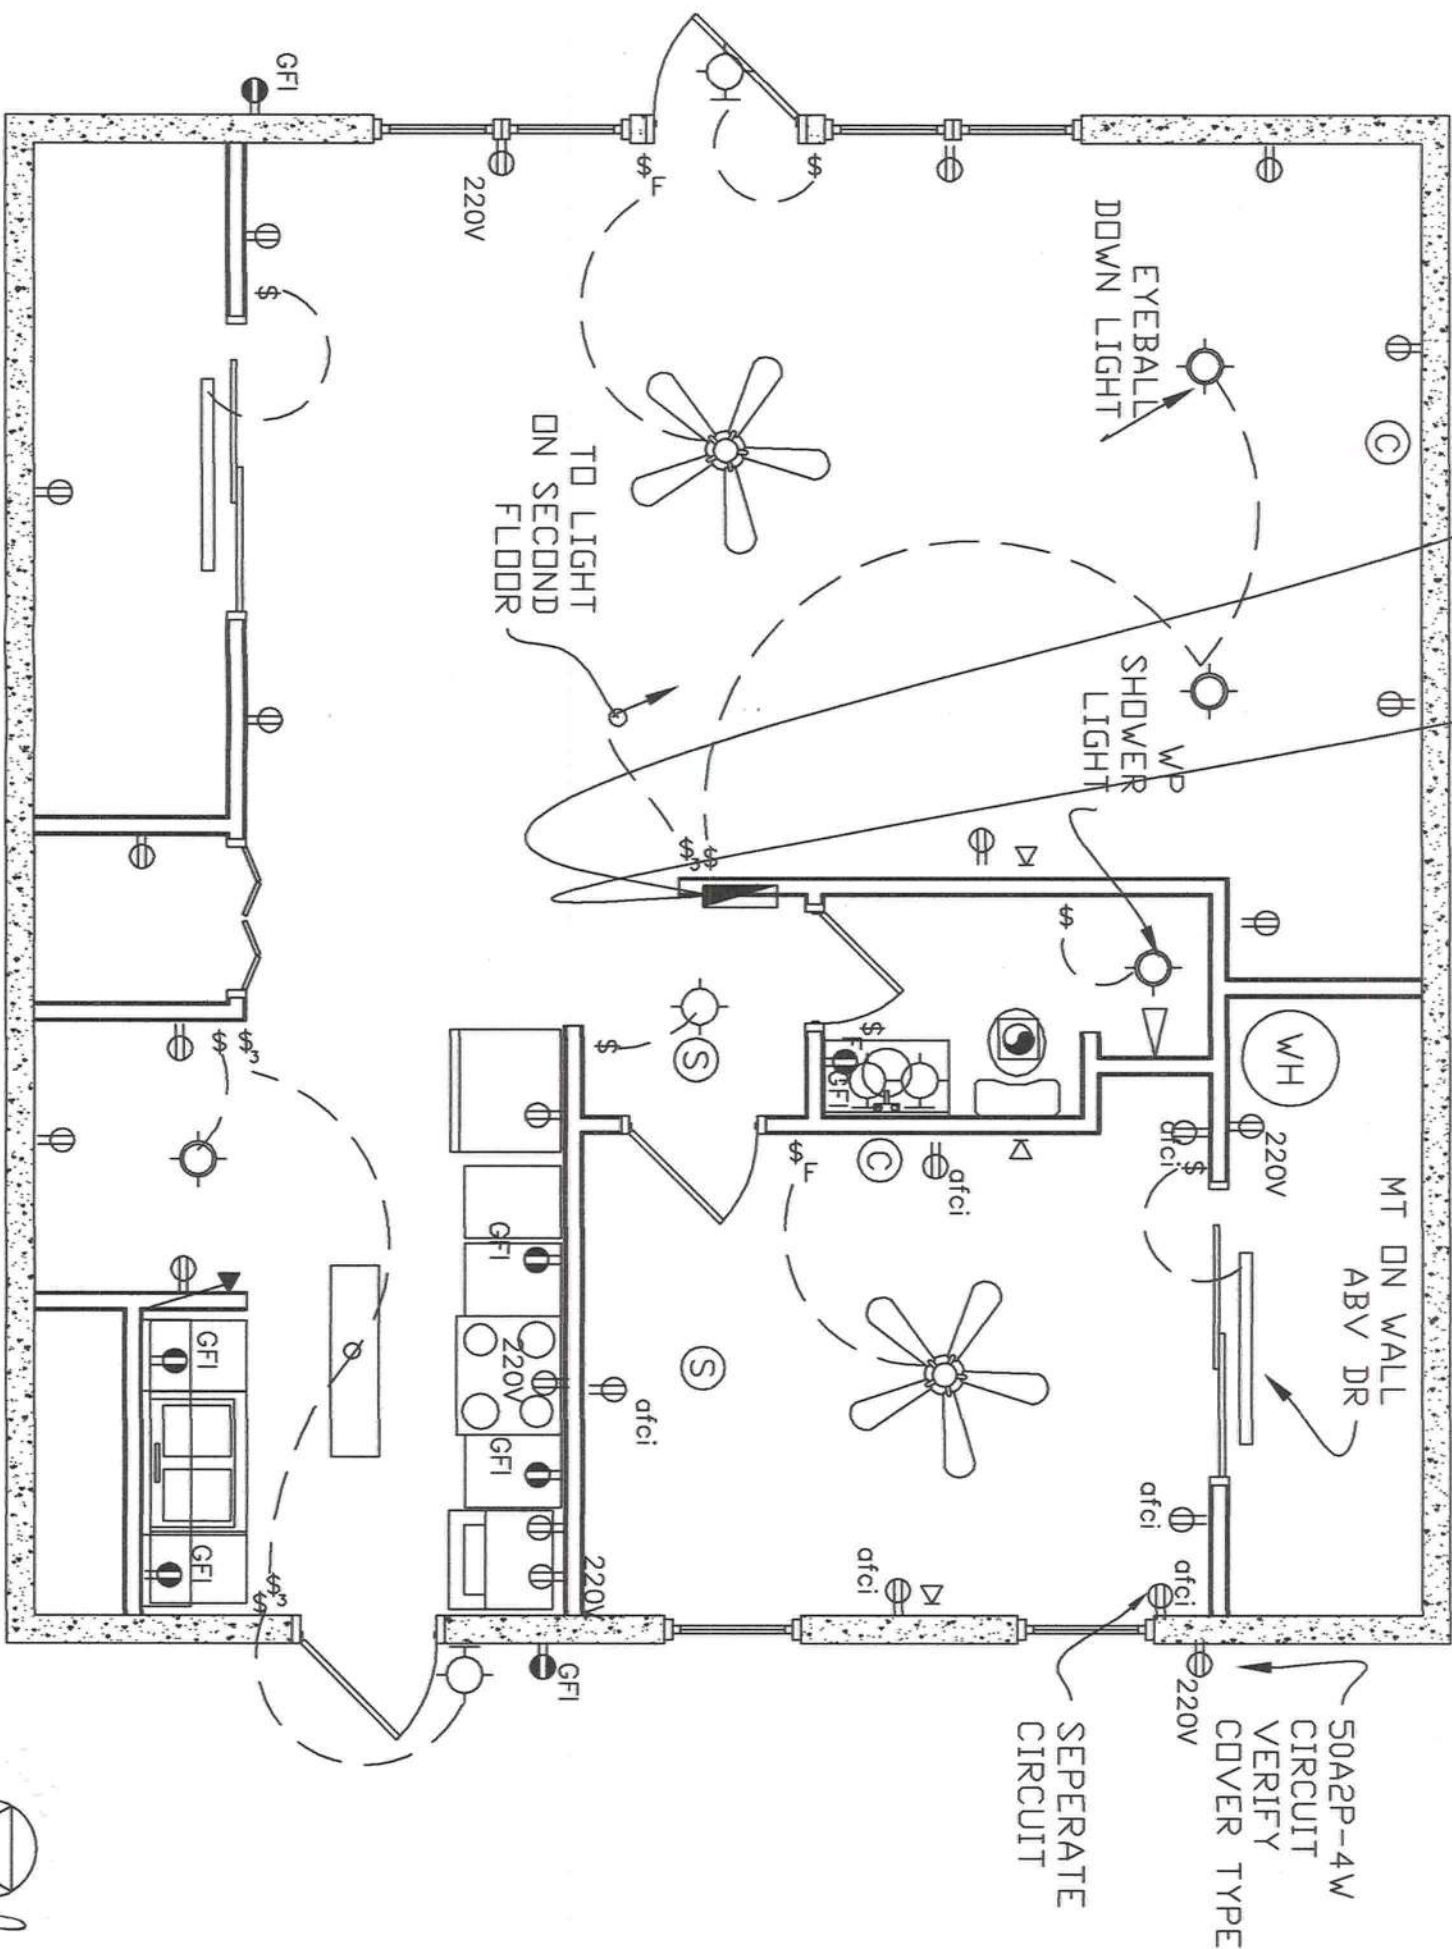

1 ELECTRIC PLAN
Scale: 1/4" = 1'-0"

Handwritten signature and date: 9/16/05

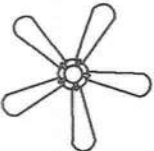

CEILING FAN WITH LIGHT KIT PROVIDE
FAN JUNCTION BOX, DOUBLE SWITCHED

SINGLE TUBE 48" FLOUR W/ WRAP AROUND
LENSE

48" (2) TUBE 40 WATT SURFACE MTG
DECORATIVE FLOUR FIXTURE

RECESSED LIGHT W/ TG PROVIDE CHOICE OF TRIMS

CEILING LIGHT SURFACE MOUNTED

DECORATIVE WALL LIGHT CENTER OVER VANITY

WEATHER PROOF
EXTERIOR LIGHT WALL

110V SMOKE DETECTOR WIRE ALL
DECTORS TO SOUND CONCURRENTLY

STD DUPLEX OUTLET 18" AF
UNLESS OTHERWISE NOTED

ARC FAULT CURRENT INTERRUPTING
DUPLEX OUTLET MTD 18" AF
INSTALLED IN ALL BEDROOMS
220V OUTLET AS REQUIRED BY
APPLANCE VERIFY PLUG CONFIG
REQUIRED

DUPLEX OUTLET GROUND FAULTED
IF NOTED SHADING DENOTES TO
MOUNT MIN 6" ABV COUNTER HEIGHT

EXHAUST FAN MIN 50 CFM SUPPLIED BY MECH SUB SEE
FAN SWITCH FOR WIRING VENT FAN TO END WALL W/ WALL
CAP

PHONE OUTLET TERMINATE AT PHONE
ENTRANCE POINT

SHADED OUTLET INDICATE
TEL-PHONE OUTLET MTD 60" AFF FOR
WALL PHONE

SAT/CABLE TV OUTLET TERMINATE
AT CABLE ENTRANCE POINT, VERIFY
LOCATION


SINGLE POLE SWITCH

3 WAY SWITCH


FAN SWITCH, TWO SWITCHES ONE FOR
FAN ONE FOR LIGHT

METER CAN COMPLY WITH LOCAL STANDARDS

NEW 150A -2P SERVICE PANEL WITH 40 BREAKER CIRCUITS

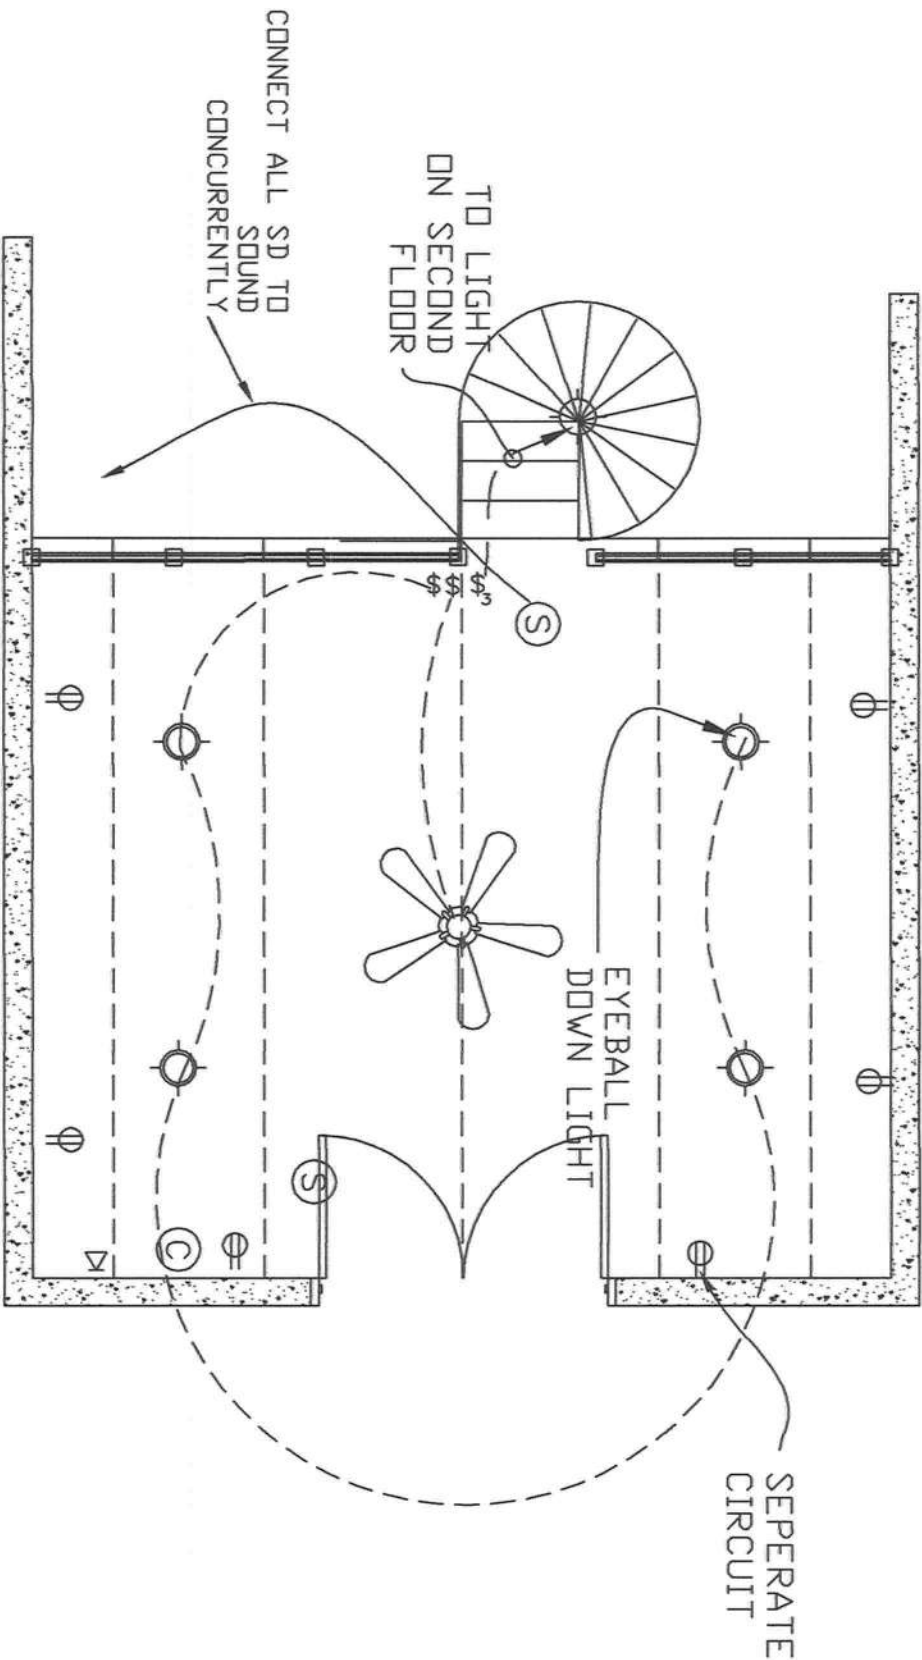

1 FLOOR PLAN
Scale: 1/4" = 1'-0"

 

Paige Poole
9/21/05