
 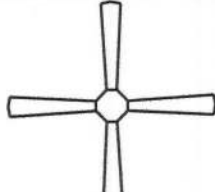
 
 
 
 
 
 
 
 
 



ELECTRICAL LEGEND		
ELECTRICAL	COUNT	SYMBOL
ceiling fan 4 bladed 01	4	
fluorescent light 1 x 4	2	
pendant cube	2	
pot light	8	
spotlight double	3	
fan	2	
light	15	
outlet	28	
outlet 220v	4	
outlet gfi	11	
outlet wp	3	
smoke detector	3	
switch	28	
switch 3 way	4	

NOTE:
ALL BEDROOM RECEPTACLES SHALL BE AFCI
(ARC FAULT CIRCUIT INTERRUPT)

ALL SMOKE DETECTORS SHALL HAVE BATTERY BACKUP POWER
AND ALL WIRED TOGETHER SO IF ANY ONE UNIT IS ACTUATED THEY
ALL ACTIVATE.


NOTE:
UPPER grounding required per N.E.C.
Arc fault breakers required per N.E.C.
GFCI breakers required per N.E.C.
Tamper resistant receptacles required per N.E.C.

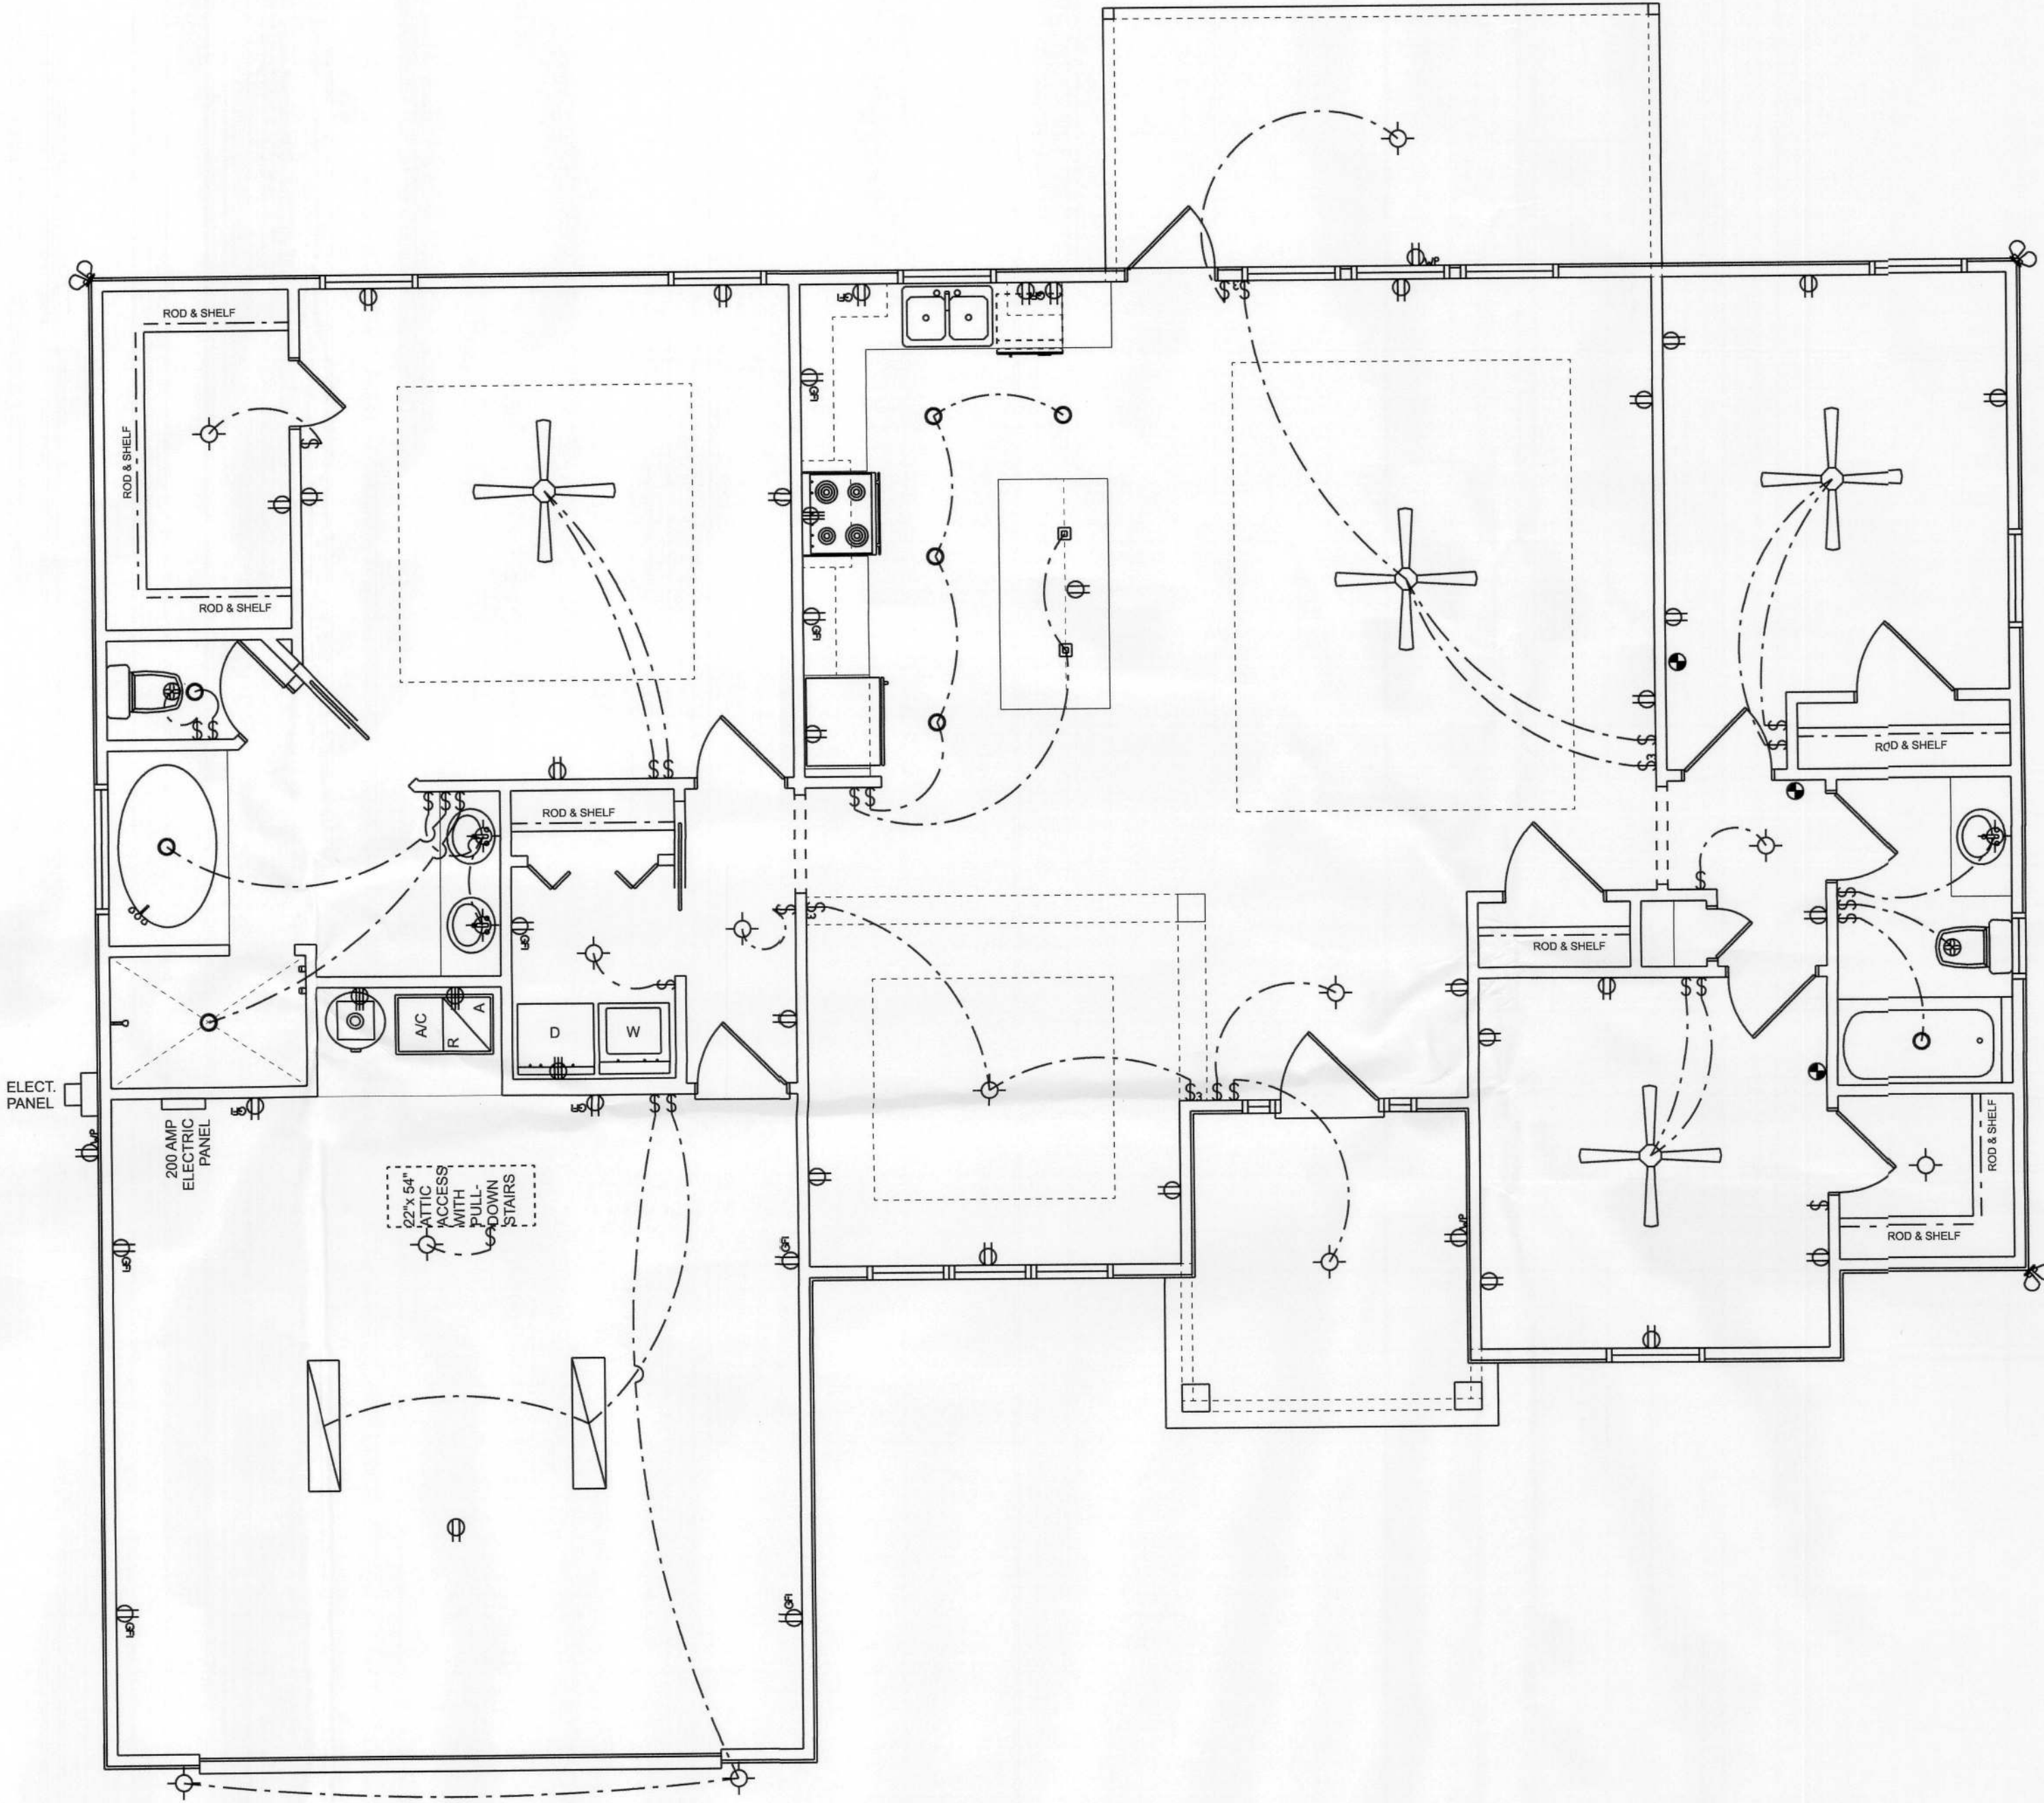

DIMENSIONED FLOOR PLAN
SCALE: 1/4" = 1'-0"

REVISIONS SCHEDULE	
MAY 5th, 2016	ORIGINAL DRAWINGS

ADAM'S CONSTRUCTION

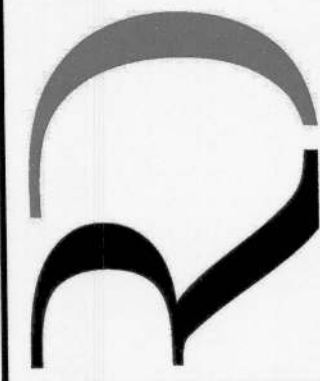

**RIDGEPOINT
DESIGN, INC.**
496 SW RING CT. LAKE CITY, FLORIDA 32025
P: 386-288-1188
E: RIDGEPOINTDESIGN@GMAIL.COM