
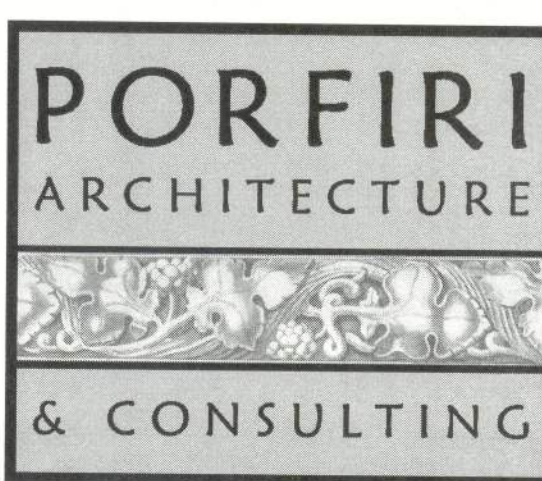


PLUMBING FIXTURE CONNECTION SCHEDULE					
NO.	DESCRIPTION	DRAIN	WATER		MANUFACTURER MODEL
			COLD	HOT	
WC 1	WATER CLOSET TANK, HC	3"	1/2"	---	SELECTED BY OWNER
WC 2	WATER CLOSET TANK, HC	3"	1/2"	---	
WC 3	WATER CLOSET TANK, HC	3"	1/2"	---	
BA 1	BATH TUB	2"	1/2"	1/2"	
BA 2	BATH TUB	2"	1/2"	1/2"	
SHR #1	Master Bath shower	2"	1/2"	1/2"	
SHR #2	Bath #2 HC shower	2"	1/2"	1/2"	
SHR #3	Mud Room shower	2"	1/2"	1/2"	
SK 1	SINK, double	1 1/2"	1/2"	1/2"	
SK 2	SINK, wall mounted	1 1/2"	1/2"	1/2"	
LV 1	LAVATORY, countertop	1 1/2"	1/2"	1/2"	
LV 2	LAVATORY, countertop	1 1/2"	1/2"	1/2"	

TANKLESS WATER HEATER						
UNIT MARK	MANUFACTURER	MODEL	MAX FLOW @ 105°F OUTPUT		MAX FLOW @ 113°F OUTPUT	
			55°F INCOMING	11°F INCOMING	55°F INCOMING	11°F INCOMING
TWH 1	STIEBEL ELTRON	Temptra 20 Plus	2.91 GPM	4.84 GPM	2.42 GPM	3.63 GPM
TWH 2	STIEBEL ELTRON	Temptra 20 Plus	2.91 GPM	4.84 GPM	2.42 GPM	3.63 GPM
TWH 3	STIEBEL ELTRON	Temptra 15 Plus	2.18 GPM	3.63 GPM	1.82 GPM	2.72 GPM
TWH 4	STIEBEL ELTRON	Temptra 12 Plus	1.82 GPM	3.03 GPM	1.51 GPM	2.21 GPM
TOTALS:			9.82 GPM	16.34 GPM	8.17 GPM	12.25 GPM
MIN. FLOW RATE PER Table 5, HUD-FHA = (72 GPH) = <u>120 GPM</u> (3 Bedroom, 3 Bath)						

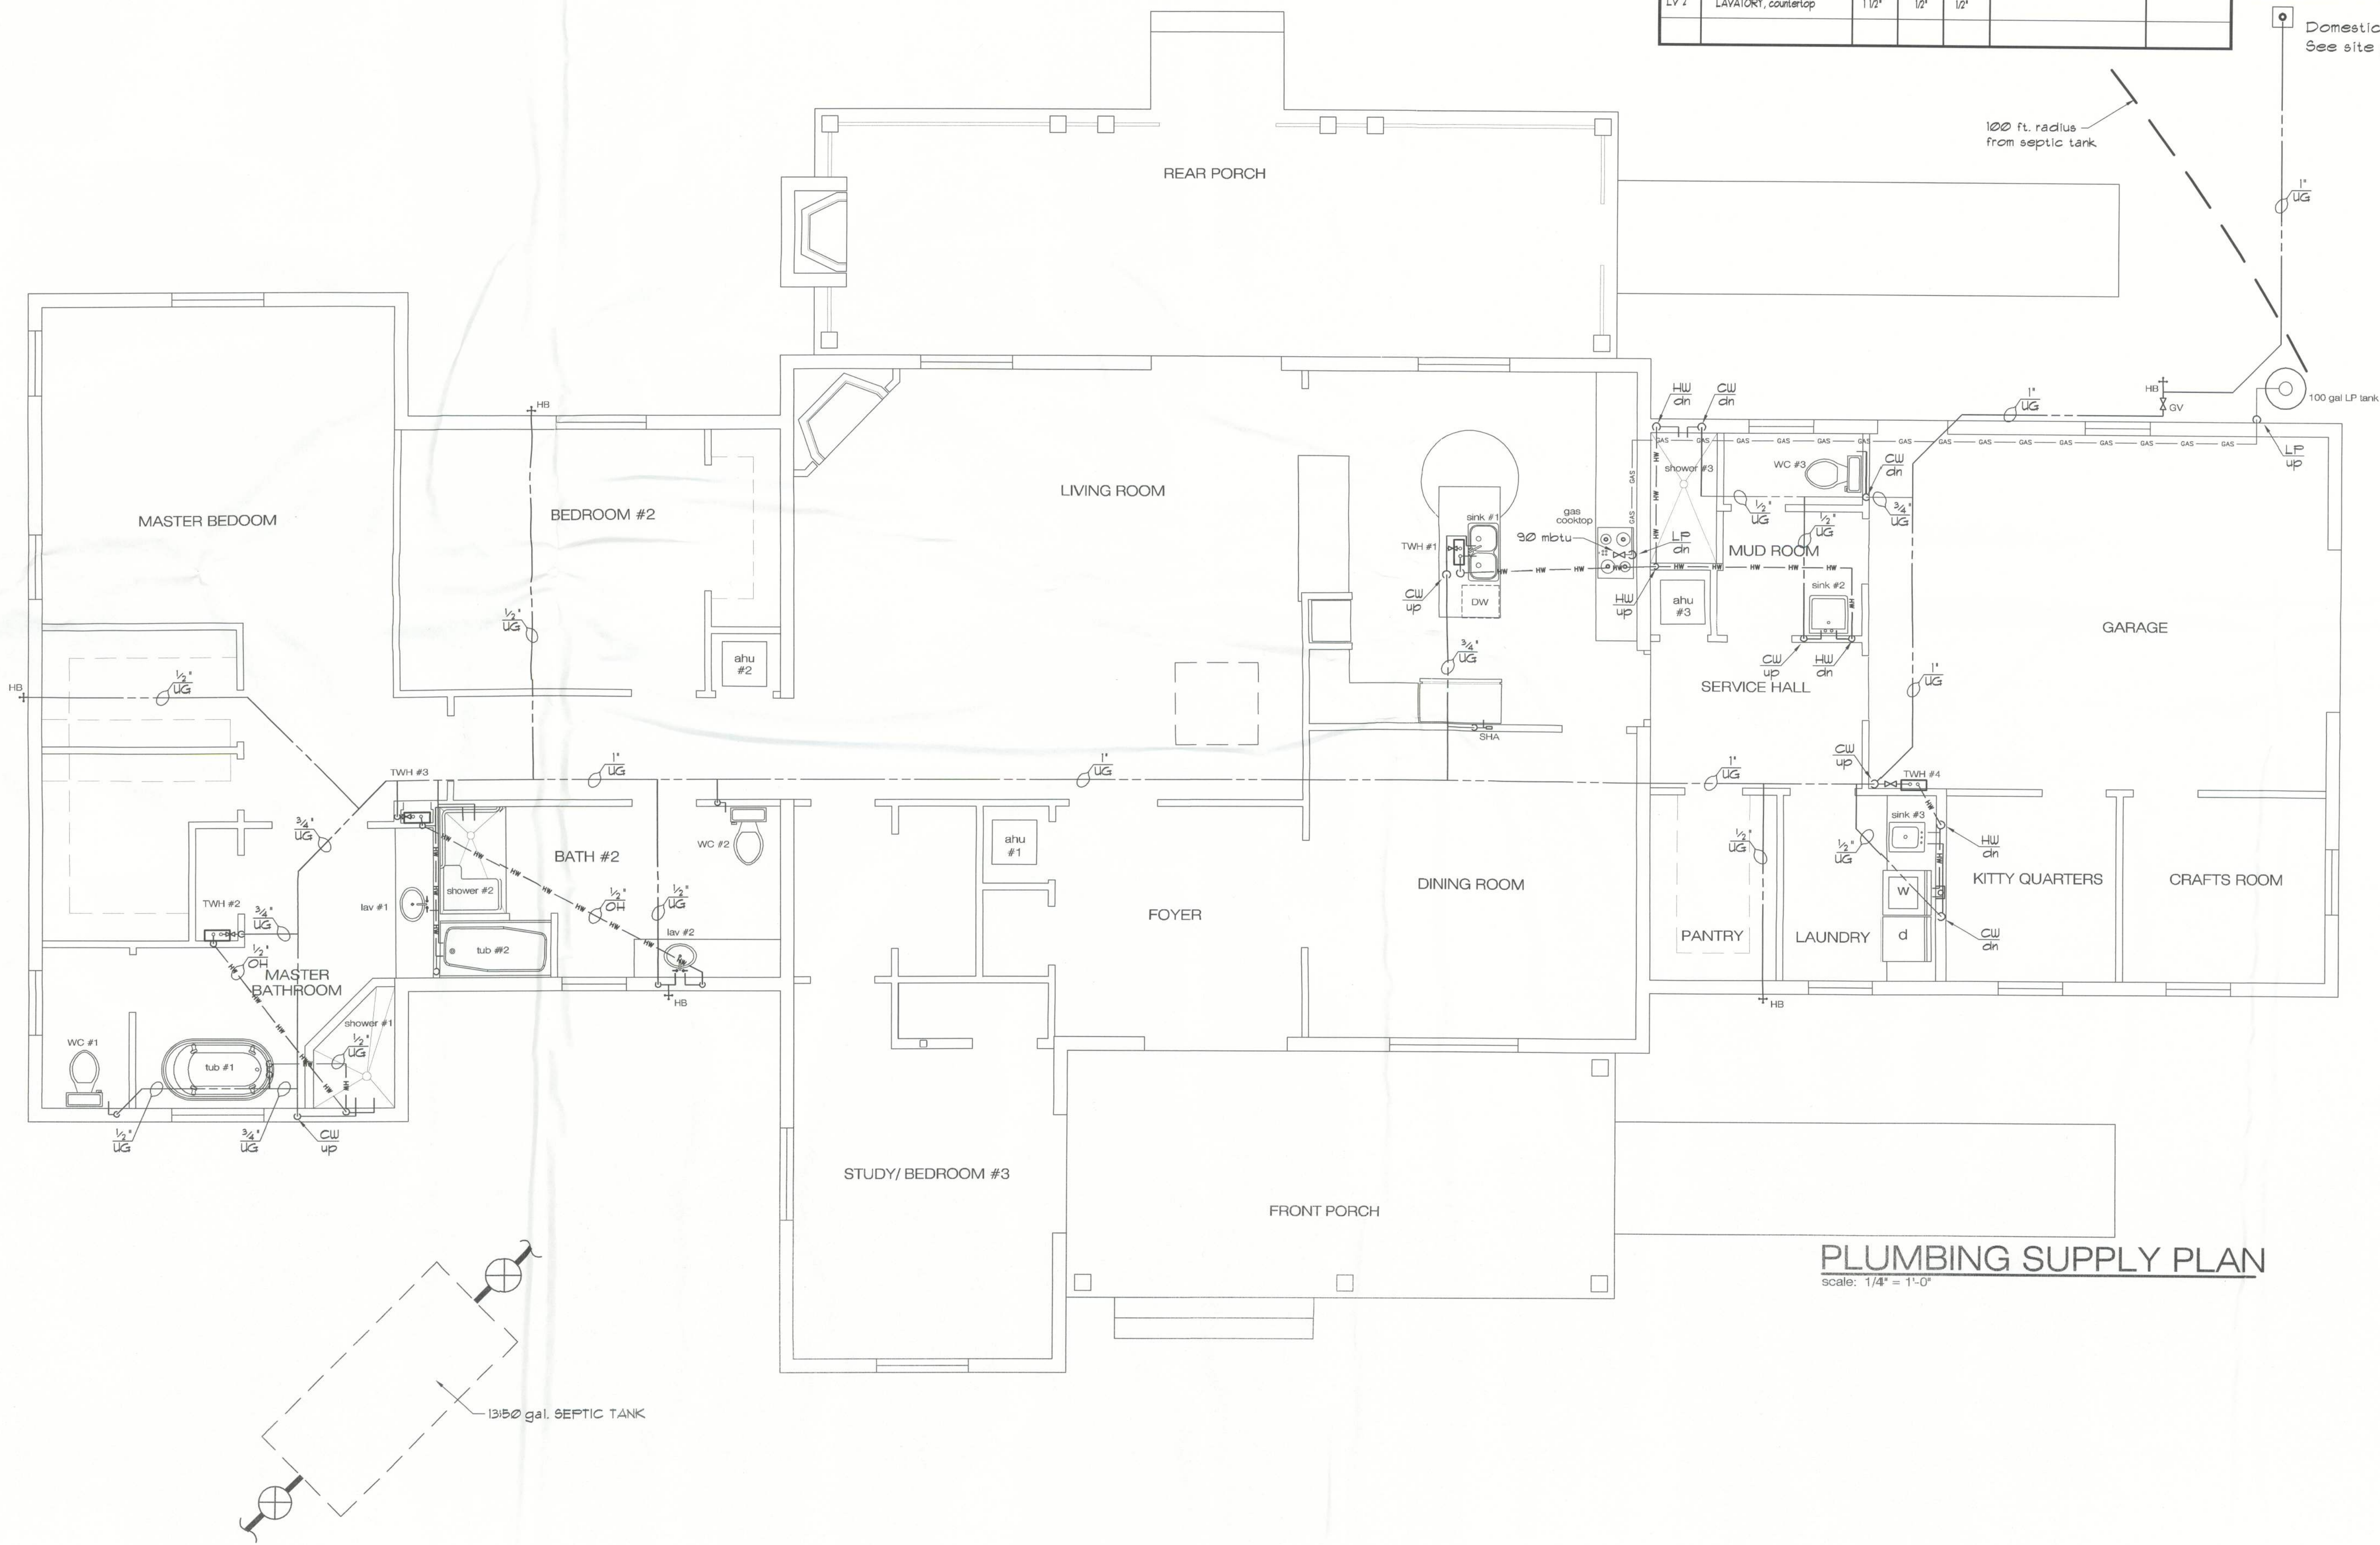

Florida Licenses: AR0008515 / AA26001883
5794 Bird Road, # 225 Miami, Florida 33155
Tel 305.665.5500 / Fax 305.665.5800

seal:

consultants:

Copyright notice:
All graphic and written material appearing herein are instruments of the architect's service for use on this project, and are protected under the Architectural Works Copyright Protection Act of 1990. The material may not be duplicated, used, republished or disclosed without the prior written consent of John R. Porfiri, Architect.
© 2010 John R. Porfiri, Porfiri Architecture & Consulting, LLC

New Residence for
Mr. & Mrs. Wade Schile
319 Singleton Terrace, Columbia County, Florida

Date: July 14, 2011

Project no.

Drawn: JRFP

Checked: JRFP

Revisions:

Sheet title:

PLUMBING SUPPLY PLAN

Sheet no.

P101