



FRONT ELEVATION

SCALE: 1/4" = 1'-0"




LEFT ELEVATION

SCALE: 1/4" = 1'-0"



REAR ELEVATION

SCALE: 1/4" = 1'-0"

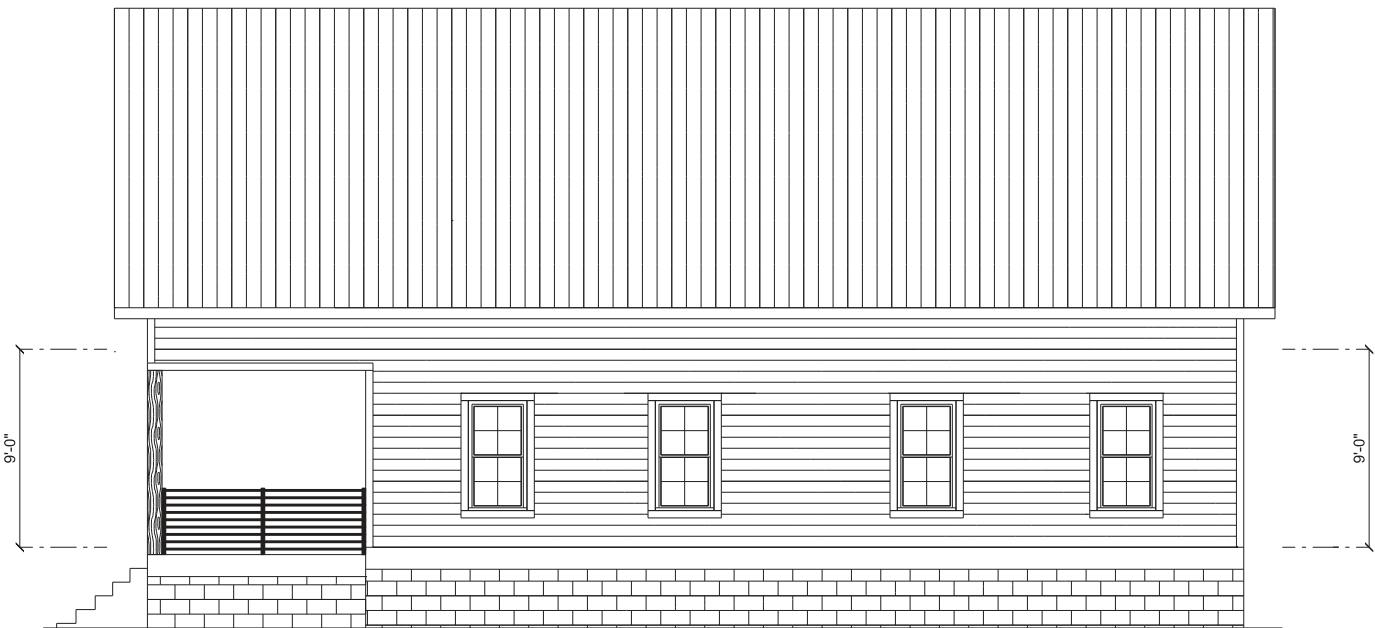

RIGHT ELEVATION

SCALE: 1/4" = 1'-0"

REVISIONS SCHEDULE			
PROPOSAL	Jan. 4th, 2023		
REVISIONS	Mar. 14th, 2023		
PERMIT DRWGS	Feb. 14th, 2024		

CUSTOM HOME FOR:
BEHR RESIDENCE
268 SE STARDUST PLACE, LAKE CITY, FLORIDA 32025


**RIDGEPOINT
DESIGN**

866 SW 23rd AVE, SUITE 100, LAKE CITY, FL 32025
P: 352-285-1188
E: RIDGEPOINTDESIGN@GMAIL.COM


SHEET NUMBER

A.1


OF 3 SHEETS

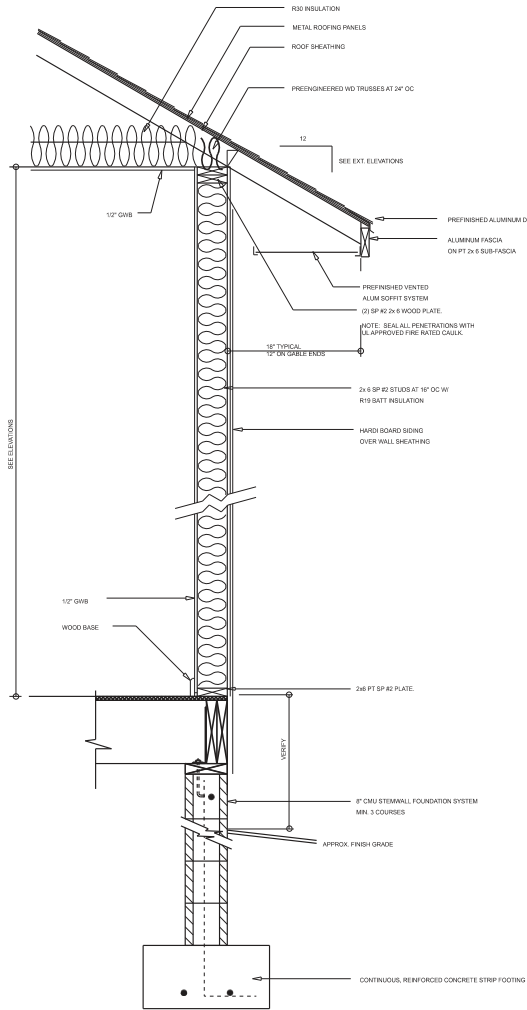

TYPICAL WALL SECTION
SCALE: NOT TO SCALE

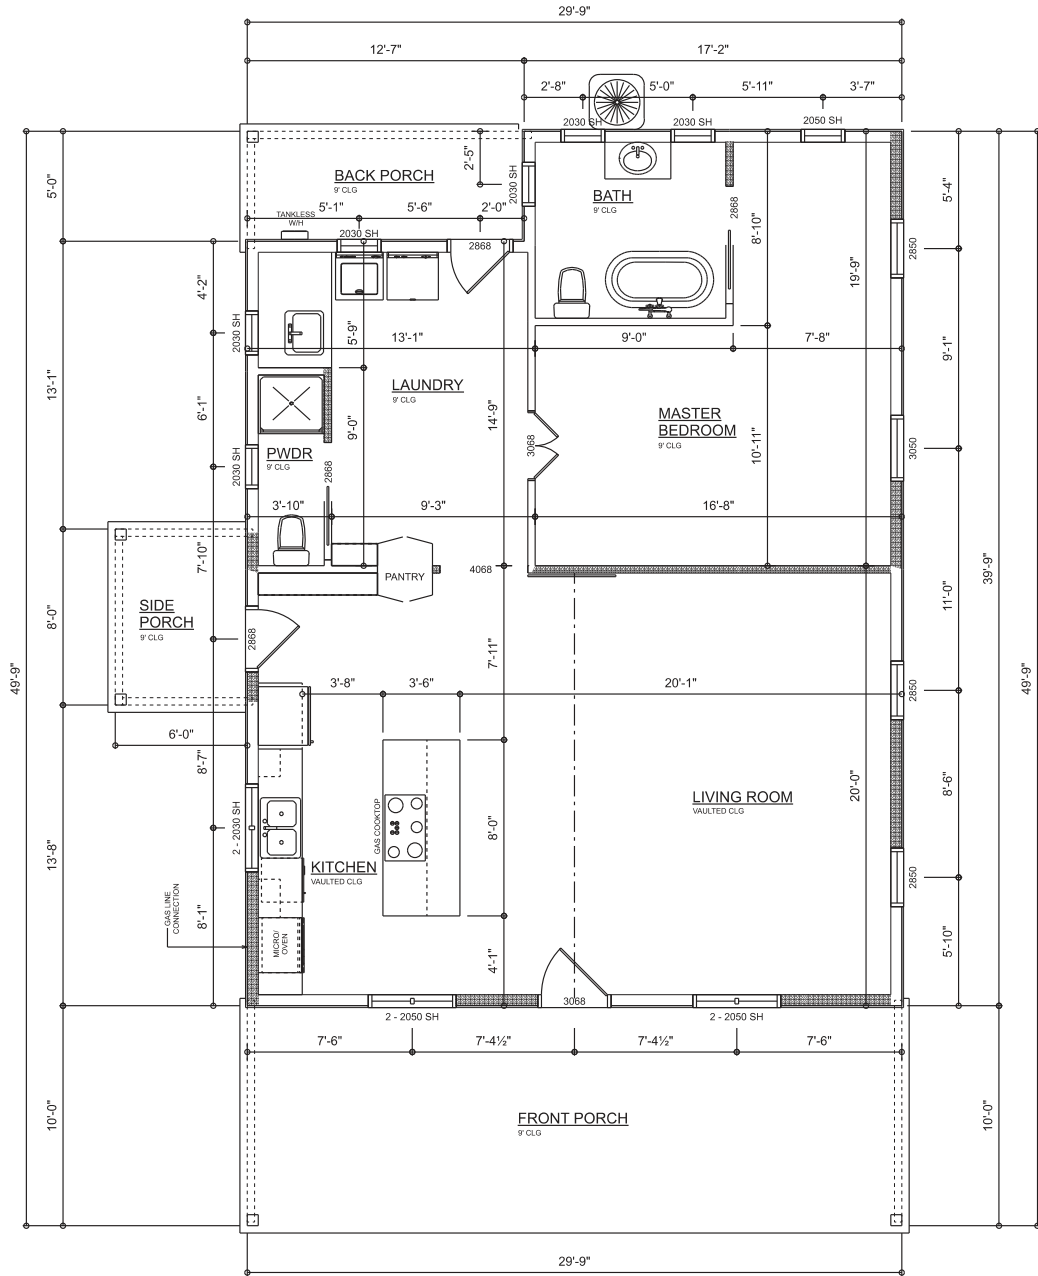

DIMENSIONED FLOOR PLAN
SCALE: 1/4\"/>

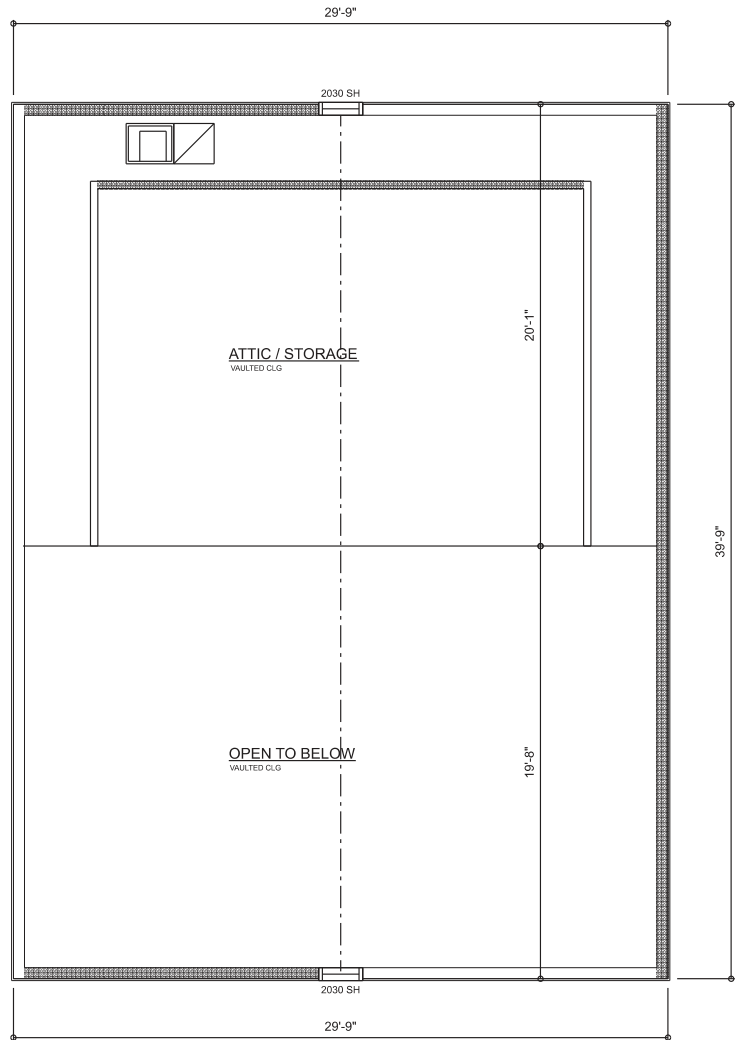

LOFT PLAN
SCALE: 1/4\"/>

AREA SUMMARY

LIVING	1,120	S.F.
ENTRY PORCH	298	S.F.
REAR PORCH	63	S.F.
SIDE PORCH	48	S.F.
TOTAL AREA	1,529	S.F.

REVISIONS SCHEDULE	
PROPOSAL	Jan. 4th, 2023
REVISIONS	Mar. 14th, 2023
PERMIT DRWGS	Feb. 14th, 2024

CUSTOM HOME FOR:
BEHR RESIDENCE
268 SE STARDUST PLACE, LAKE CITY, FLORIDA 32025

RIDGEPOINT DESIGN
846 SW 23RD AVE., SUITE 301, LAKE CITY, FL 32055
P: 352-288-1188
E: RIDGEPOINTDESIGN@GMAIL.COM

SHEET NUMBER
A.2
OF 3 SHEETS

ELECTRICAL LEGEND		
ELECTRICAL	COUNT	SYMBOL
CAN LIGHT 6inch	29	○
PENDANT LIGHT	3	⊞
ELECTRIC PANEL	1	⎓
AC DISCONNECT	2	⏏
CABLE TV OUTLET	2	Ⓜ
EXHAUST FAN	2	⊞
OUTLET	18	⦶
OUTLET 220v	3	⦶
OUTLET GFI	8	⦶
OUTLET WP	6	⦶
SMOKE DETECTOR	3	⦶
SWITCH	12	⦶
SWITCH 3 WAY	8	⦶
VANITY BAR LIGHT - SMALL	1	⦶
CARBON DETECTOR	1	⦶
MOTION SECURITY LIGHT	1	⦶

ELECTRICAL PLAN NOTES:

INSTALLATION SHALL BE PER LATEST NAT'L ELECTRIC CODE.

WIRE ALL APPLIANCES, HVAC UNITS AND OTHER EQUIPMENT PER MANUF. SPECIFICATIONS

CONSULT WITH THE OWNER FOR THE NUMBER OF SEPERATE TELEPHONE LINES TO BE INSTALLED

ALL SMOKE DETECTORS SHALL BE 120v W/ BATTERY BACKUP OF THE PHOTOELECTRIC TYPE, AND SHALL BE INTERLOCKED TOGETHER. INSTALL INSIDE AND NEAR ALL BEDROOMS


TELEPHONE, TELEVISION AND OTHER LOW VOLTAGE DEVICES OR OUTLETS SHALL BE AS PER THE OWNER'S DIRECTIONS, & IN ACCORDANCE W/ APPLICABLE SECTIONS OF NEC-LATEST EDITION.

ALL RECEPTICALS, NOT OTHERWISE NOTED, SHALL BE ARC FAULT INTERRUPTER TYPE, EXCEPT DEDICATED OUTLETS


ALL RECEPTICALS IN WET AREAS SHALL BE GROUND FAULT INTERRUPTER TYPE (GFI)

ALL EXTERIOR RECEPTICALS SHALL BE WEATHERPROOF GROUD FAULT INTERRUPTER TYPE (WP/GFI)

NOTE:
ELECTRICAL CONTR SHALL PREPARE "AS-BUILT" SHOP DWGS INDICATING ALL ELECTRICAL WORK, INCLUDING ANY CHANGES TO THE ELEC. PLAN, ADD'NS TO THE ELEC. PLAN, RISER DIAGRAM, AS-BUILT PANEL SCHEDULE W/ ALL CKTS IDENTIFIED W/ CKT Nr. DESCRIPTION & BRKR. SERVICE ENT. & ALL UNDERGROUND WIRE LOCATIONS/ROUTING / DEPTH. RISER DIA. SHALL INCLUDE WIRE SIZES/TYPE & EQUIPMENT TYPE W/ RATINGS & LOADS
CONTRACTOR SHALL PROVIDE 1 COPY OF AS-BUILT DWGS TO OWNER & 1 COPY TO THE PERMIT ISSUING AUTHORITY

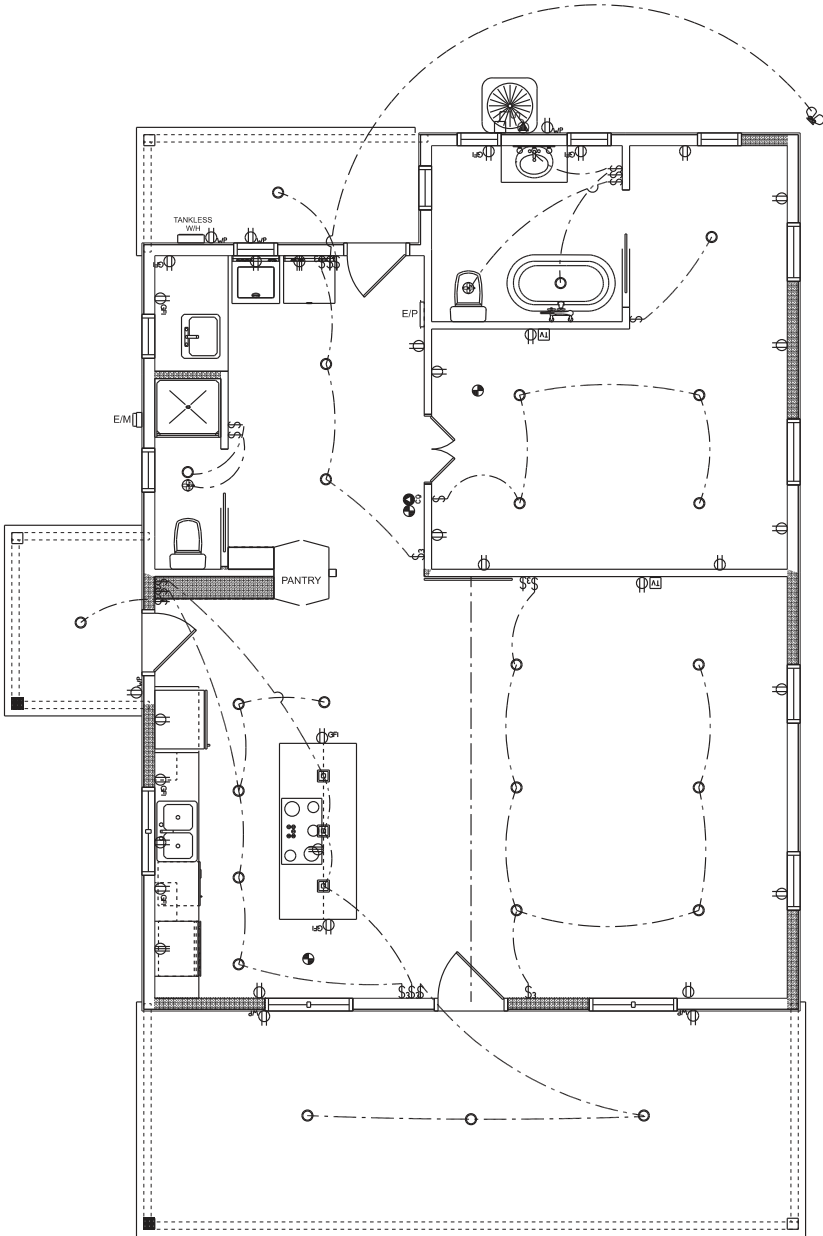

ELECTRICAL PLAN
SCALE: 1/4" = 1'-0"

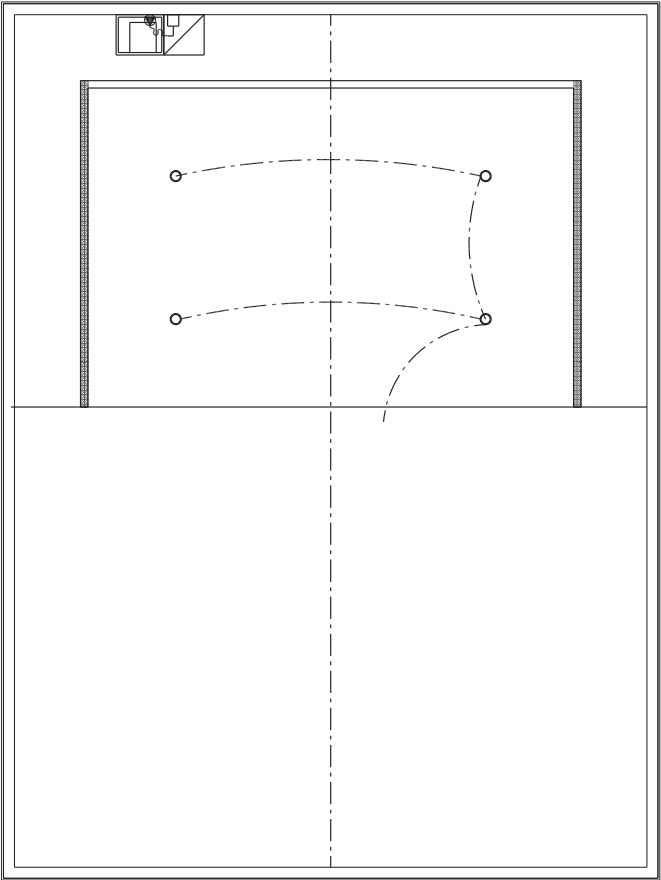

REVISIONS SCHEDULE	
PROPOSAL	Jan. 4th, 2023
REVISIONS	Mar. 14th, 2023
PERMIT DRWGS	Feb. 14th, 2024

CUSTOM HOME FOR:
BEHR RESIDENCE
266 SE STARDUST PLACE, LAKE CITY, FLORIDA 32025

**RIDGEPOINT
DESIGN**
866 SW 23RD AVE, SUITE 301, LAKE CITY, FL 32025
P: 352-285-1188
E: RIDGEPOINTDESIGN@GMAIL.COM