



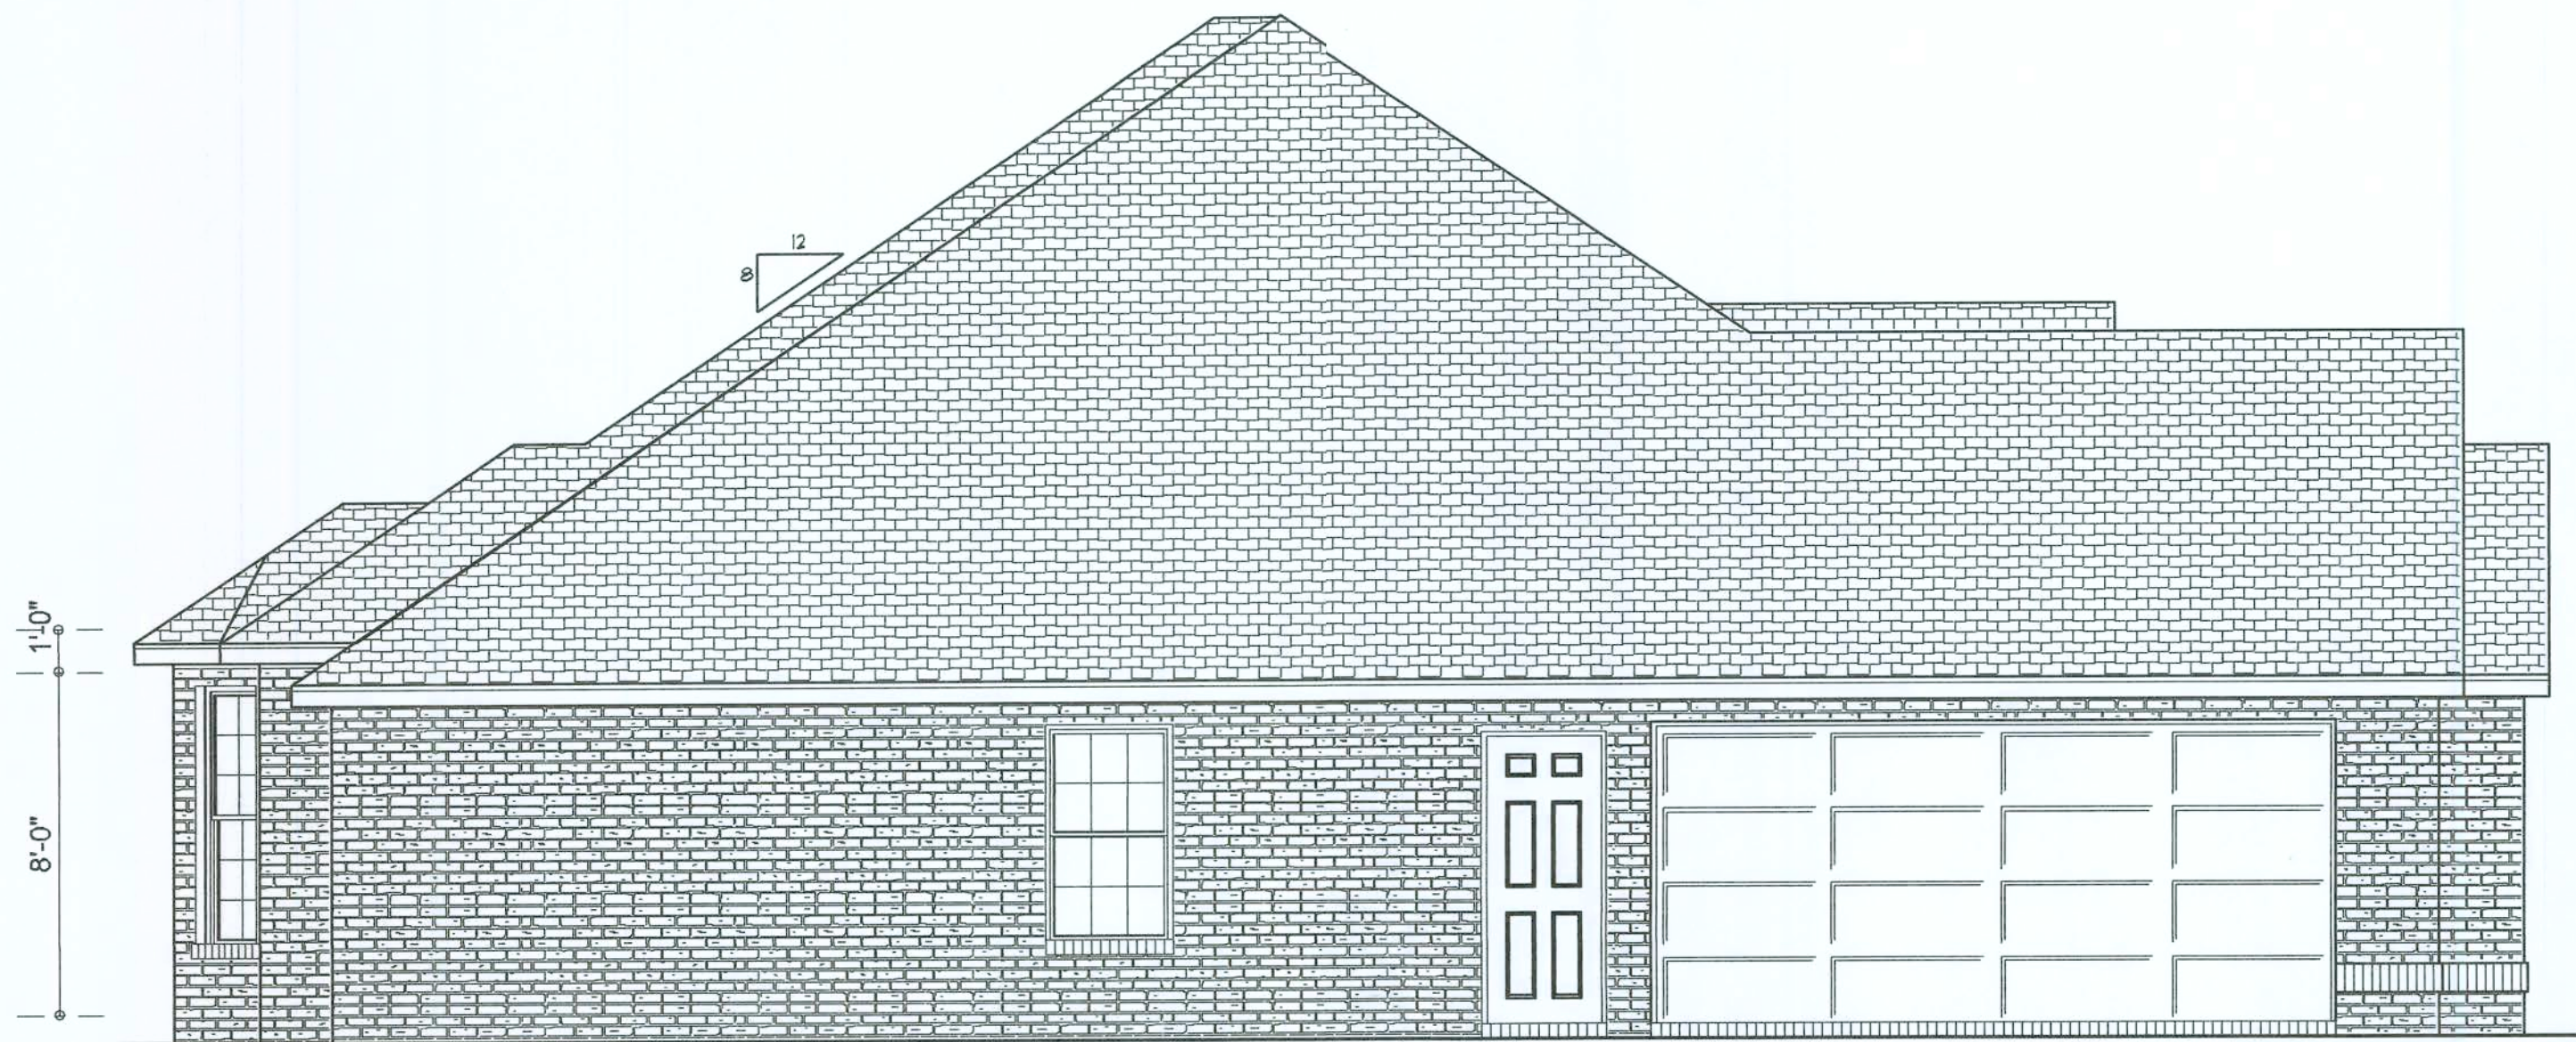


LEFT ELEVATION

SCALE: 1/4" = 1'-0"

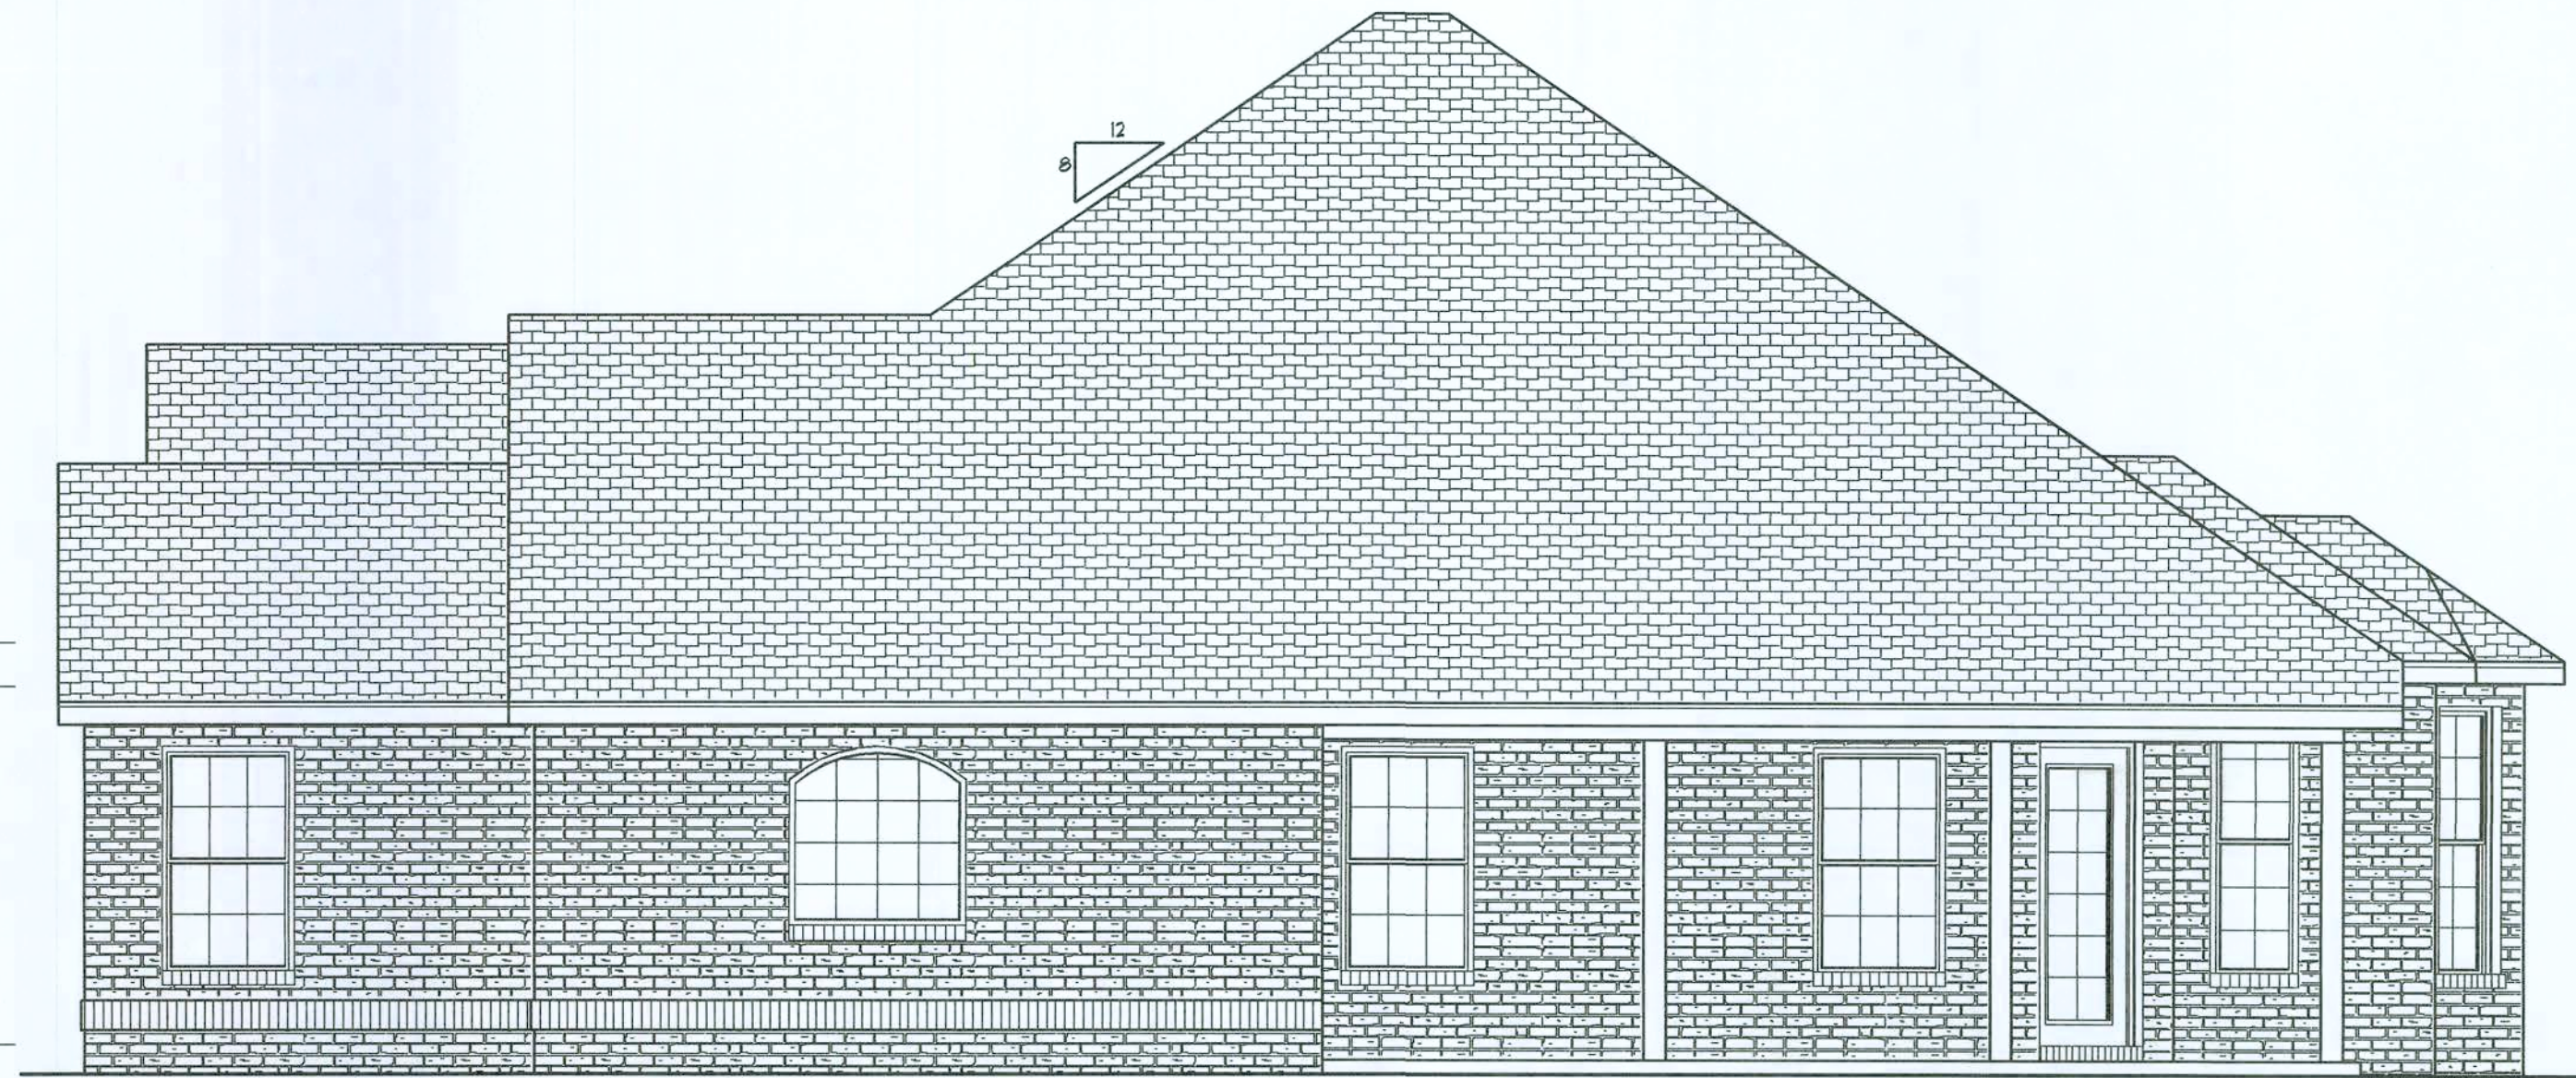


RIGHT ELEVATION

SCALE: 1/4" = 1'-0"

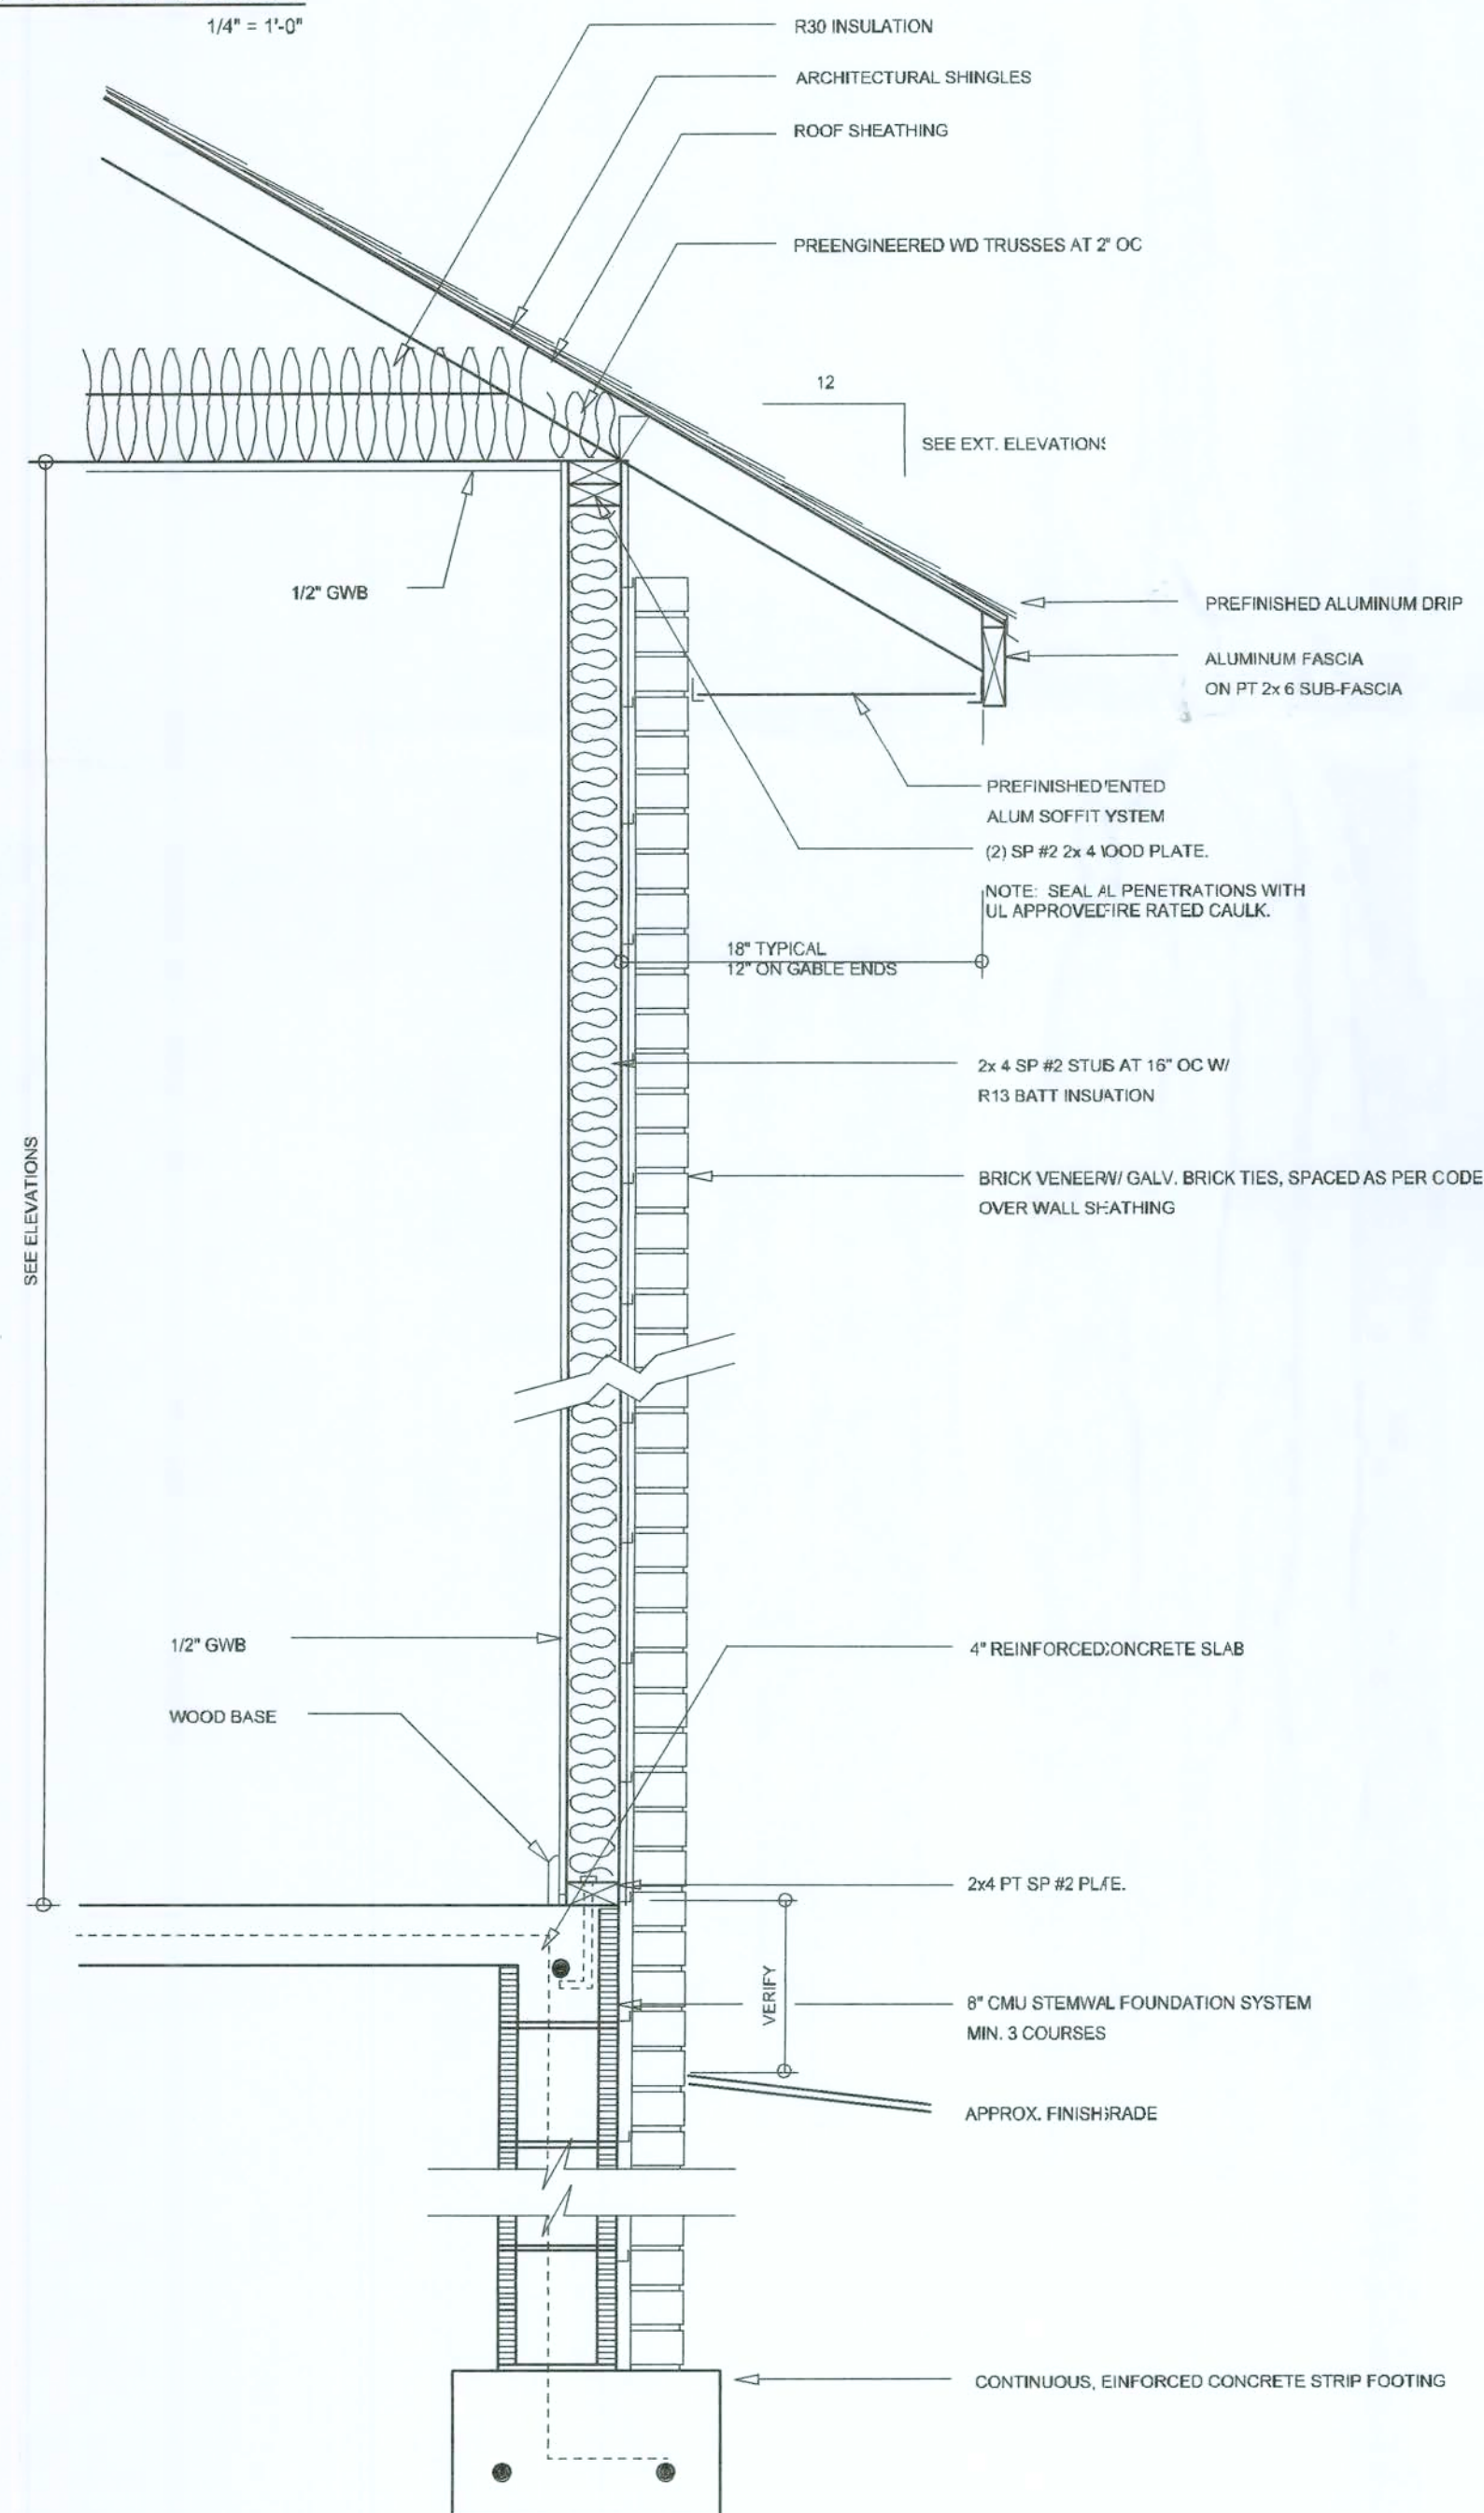


TYPICAL WALL SECTION

SCALE: 1" = 1'-0"

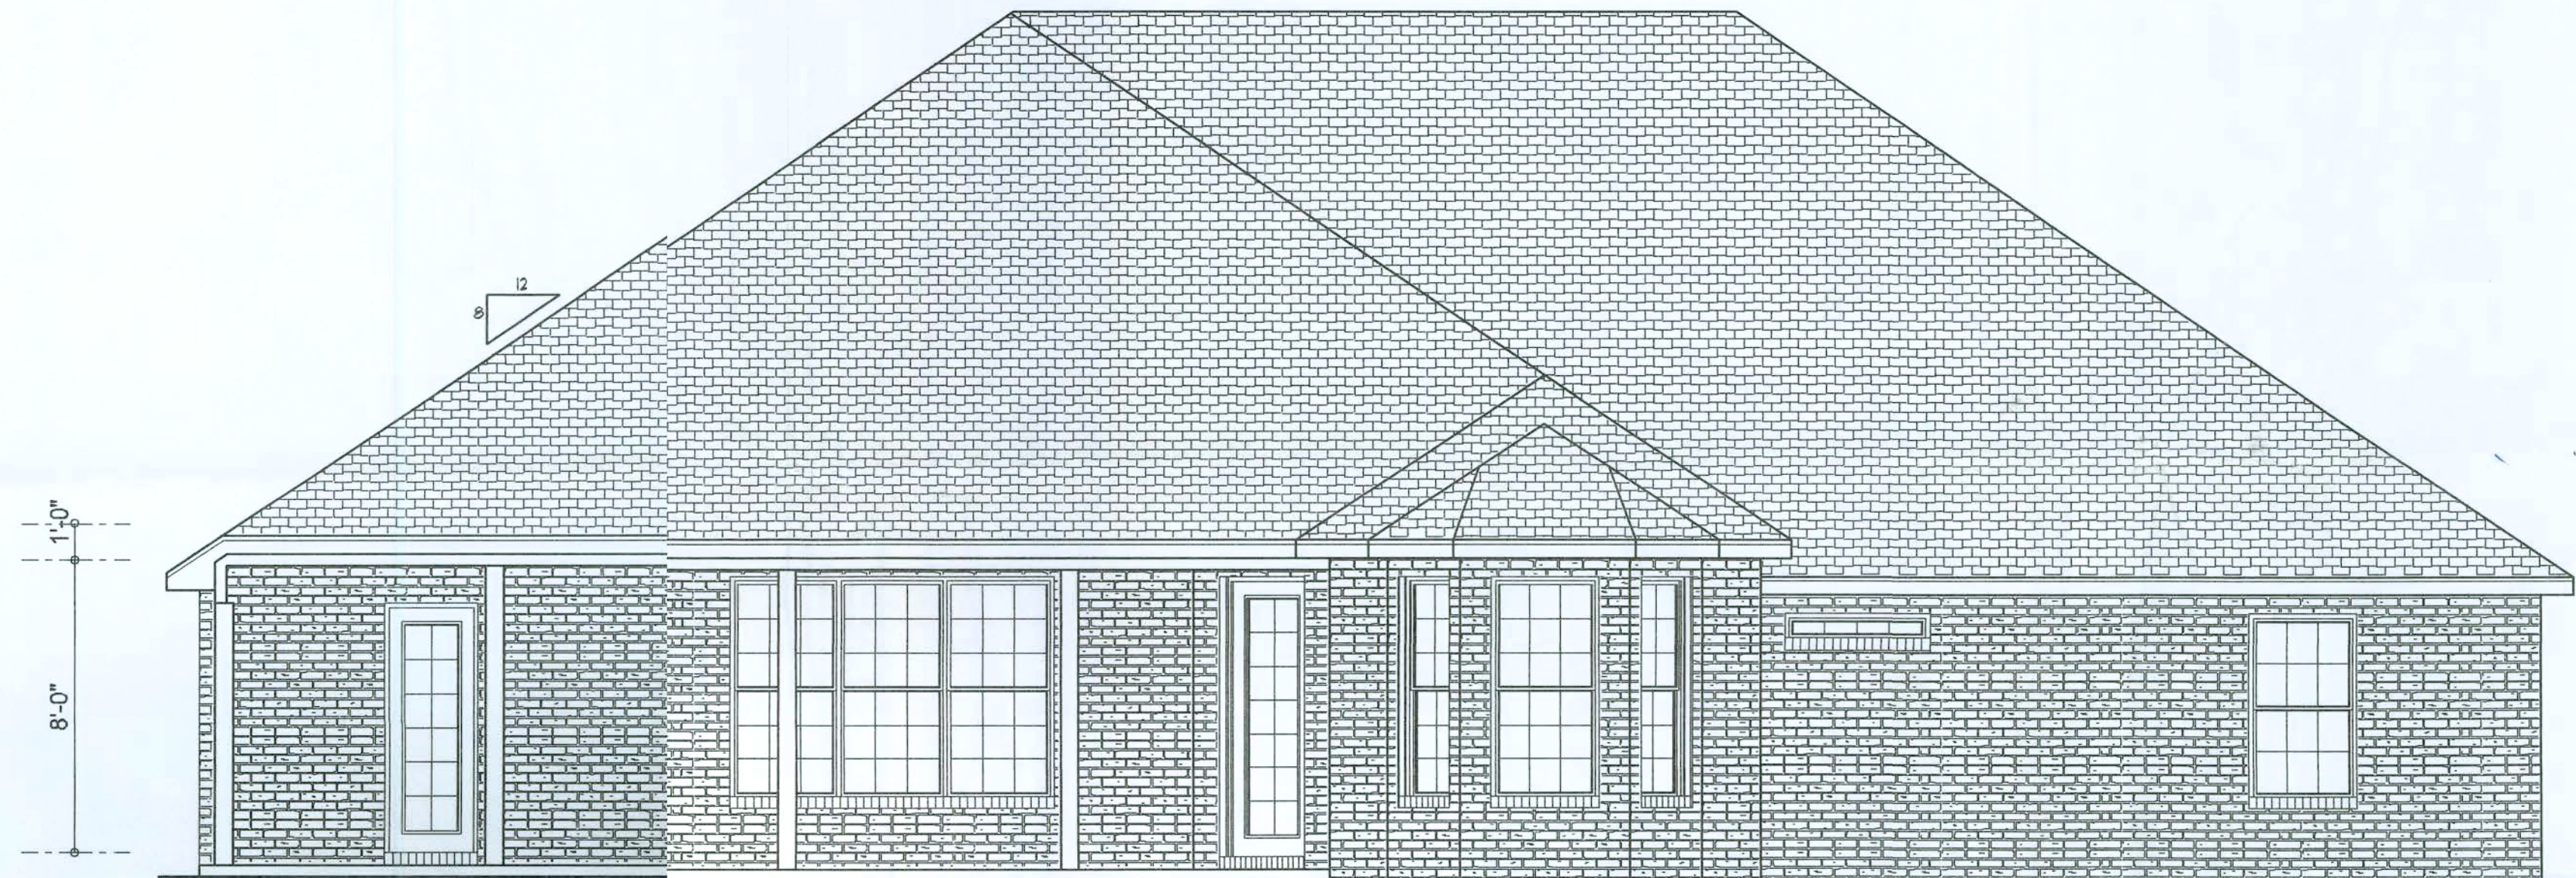

REAR ELEVATION

SCALE: 1/4" = 1'-0"

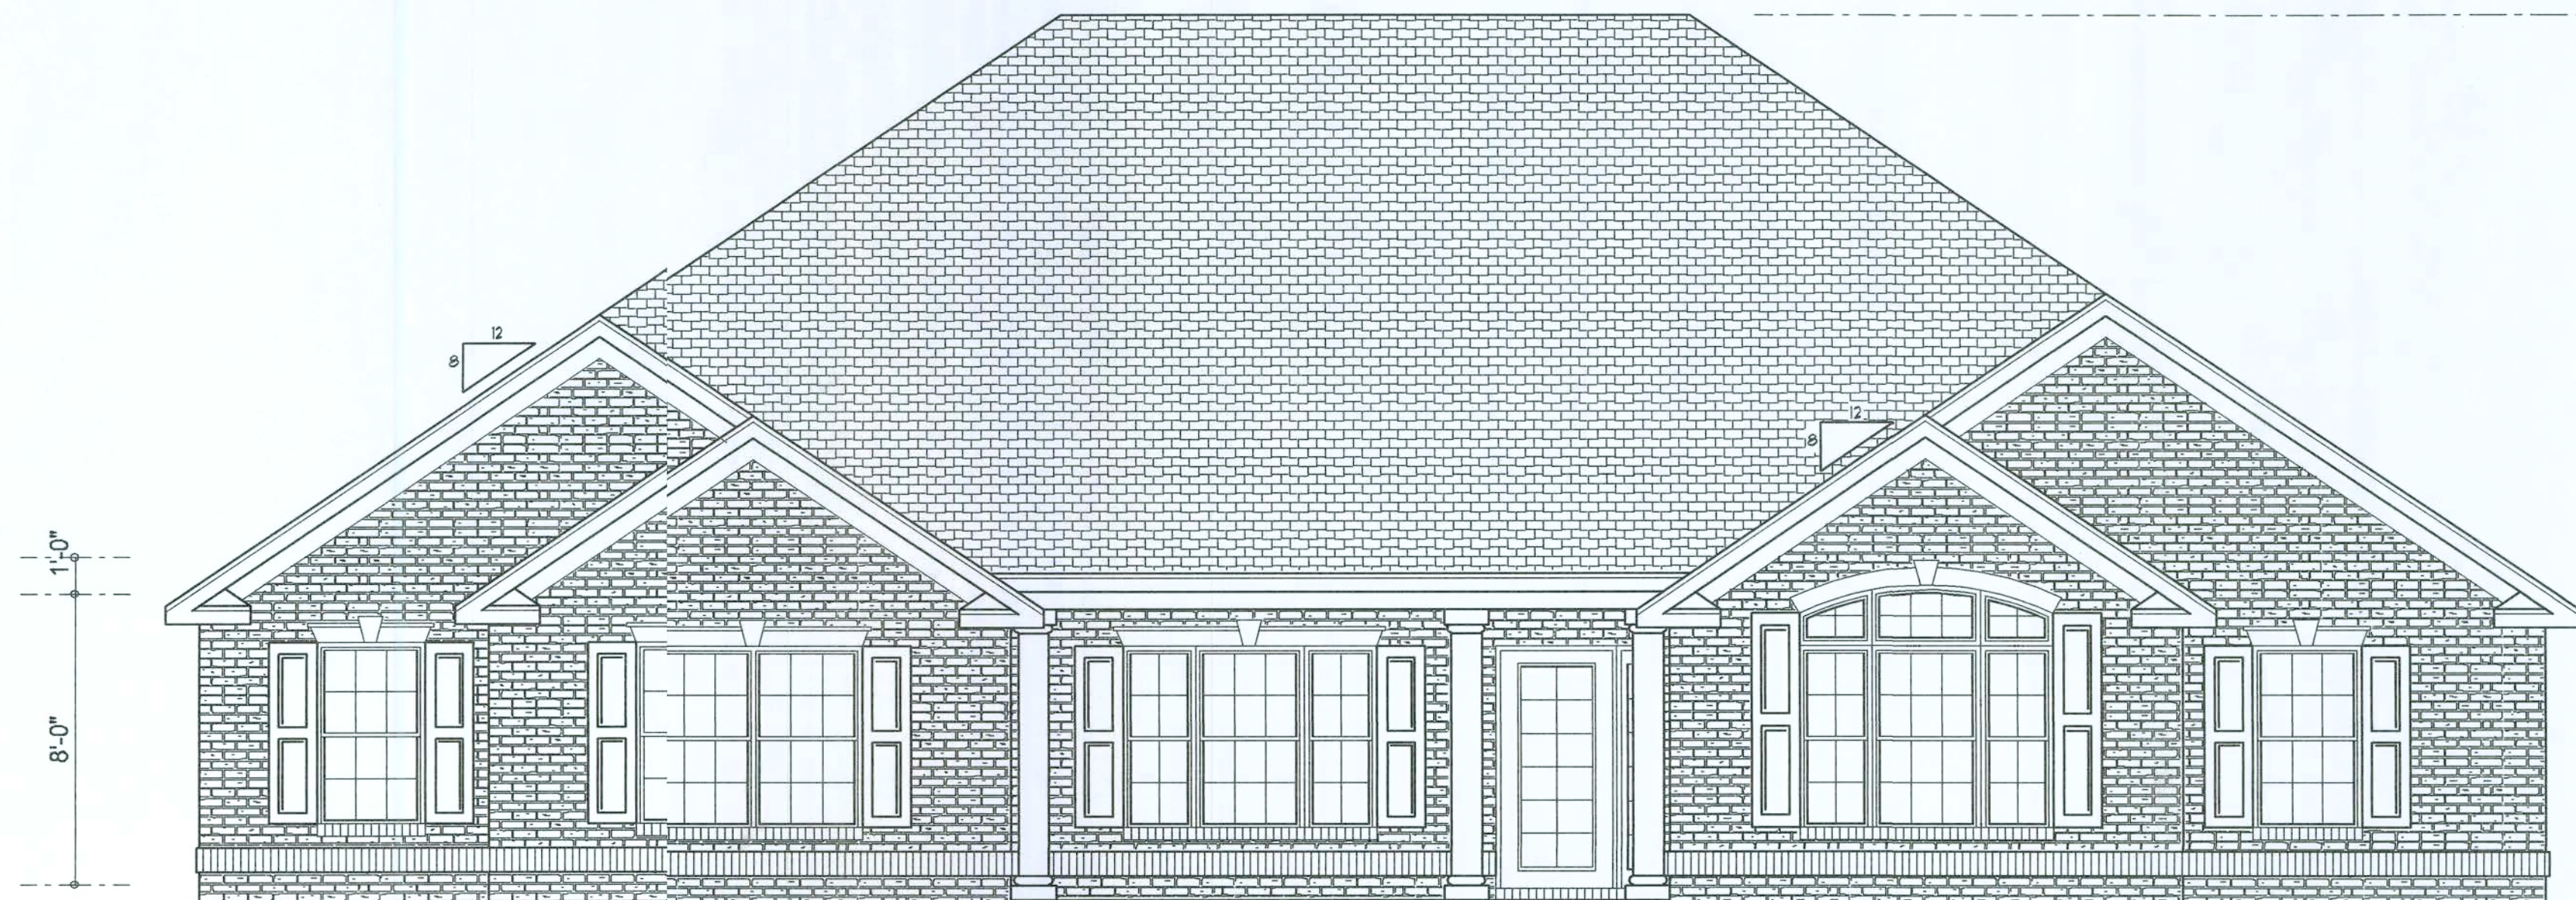

FRONT ELEVATION

SCALE: 1/4" = 1'-0"

REVISIONS

January 24, 2006


SOFTPLAN
ARCHITECTURAL DESIGN SOFTWARE

EXTERIOR ELEVATIONS
SCALE: 1/4" = 1'-0"

TYPICAL WALL SECTION
SCALE: 1" = 1'-0"

A NEW SPEC HOUSE FOR:
SETH HEITZMAN CONST.
PROJECT ADDRESS: LOT 95, ROLLING MEADOWS, LAKE CITY, FLORIDA 32026

©WILLIAM MYERS
DESIGN
P.O. BOX 913
LAKE CITY, FL 32056
(386) 758-8406
will@willmyers.net

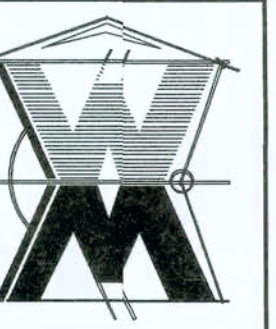

JOB NUMBER
051217

SHEET NUMBER

A.1
OF 4 SHEETS

Will Myers

OFFICE COPY


OFFICE COPY

WLC mg

AREA SUMMARY	
LIVING AREA	1986 S.F.
GARAGE AREA	515 S.F.
ENTRY PORCH AREA	152 S.F.
COVERED PORCH AREA	364 S.F.
TOTAL AREA	3017 S.F.

SHEET NUMBER
A.2
OF 3 SHEETS

JOB NUMBER
051217

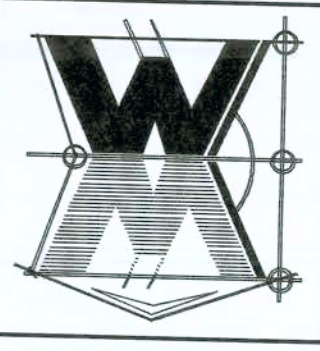


© WILLIAM MYERS & SONS, INC.
DESIGN
P.O. BOX 1513
LAKE CITY, FL 32866
(386) 758-8408
will@willmyers.net


A NEW SPEC HOUSE FOR:
SETH HEITZMAN CONST.
PROJECT ADDRESS: LOT 55, ROLLING MEADOWS, LAKE CITY, FLORIDA 32825

FLOOR PLAN
SCALE: 1/4" = 1'-0"

REVISIONS	
January 24, 2006	

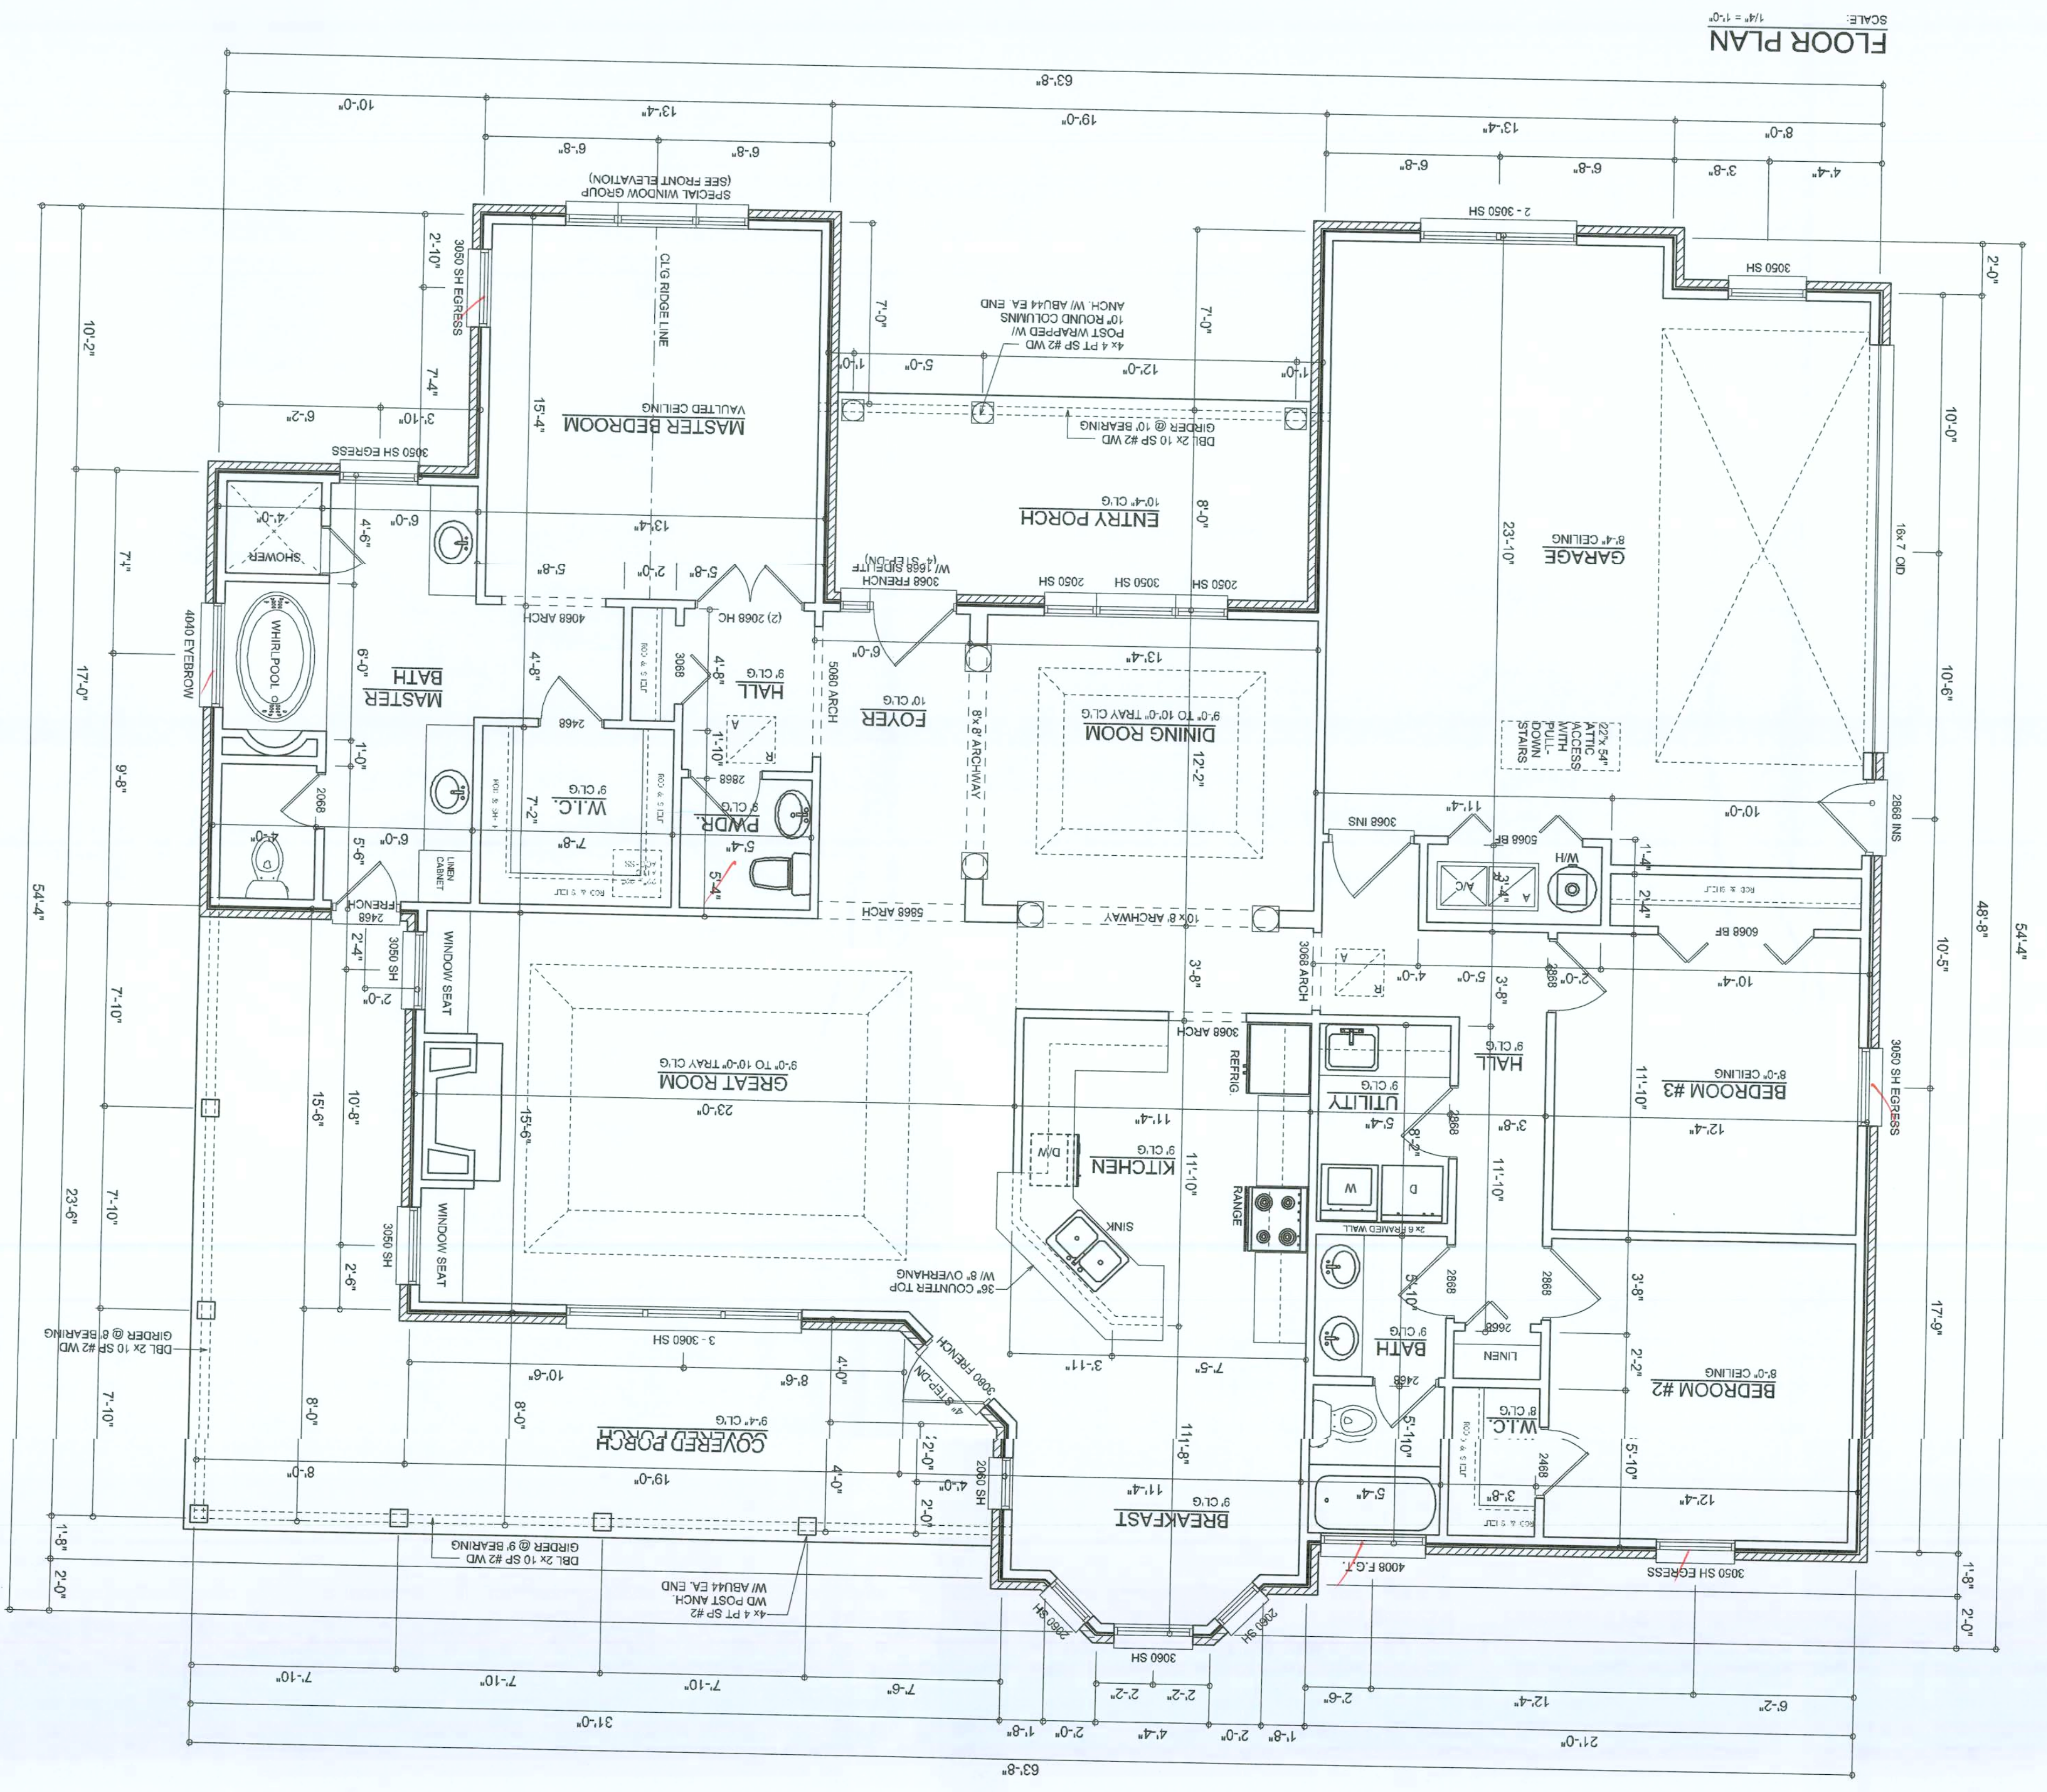

FLOOR PLAN
SCALE: 1/4" = 1'-0"

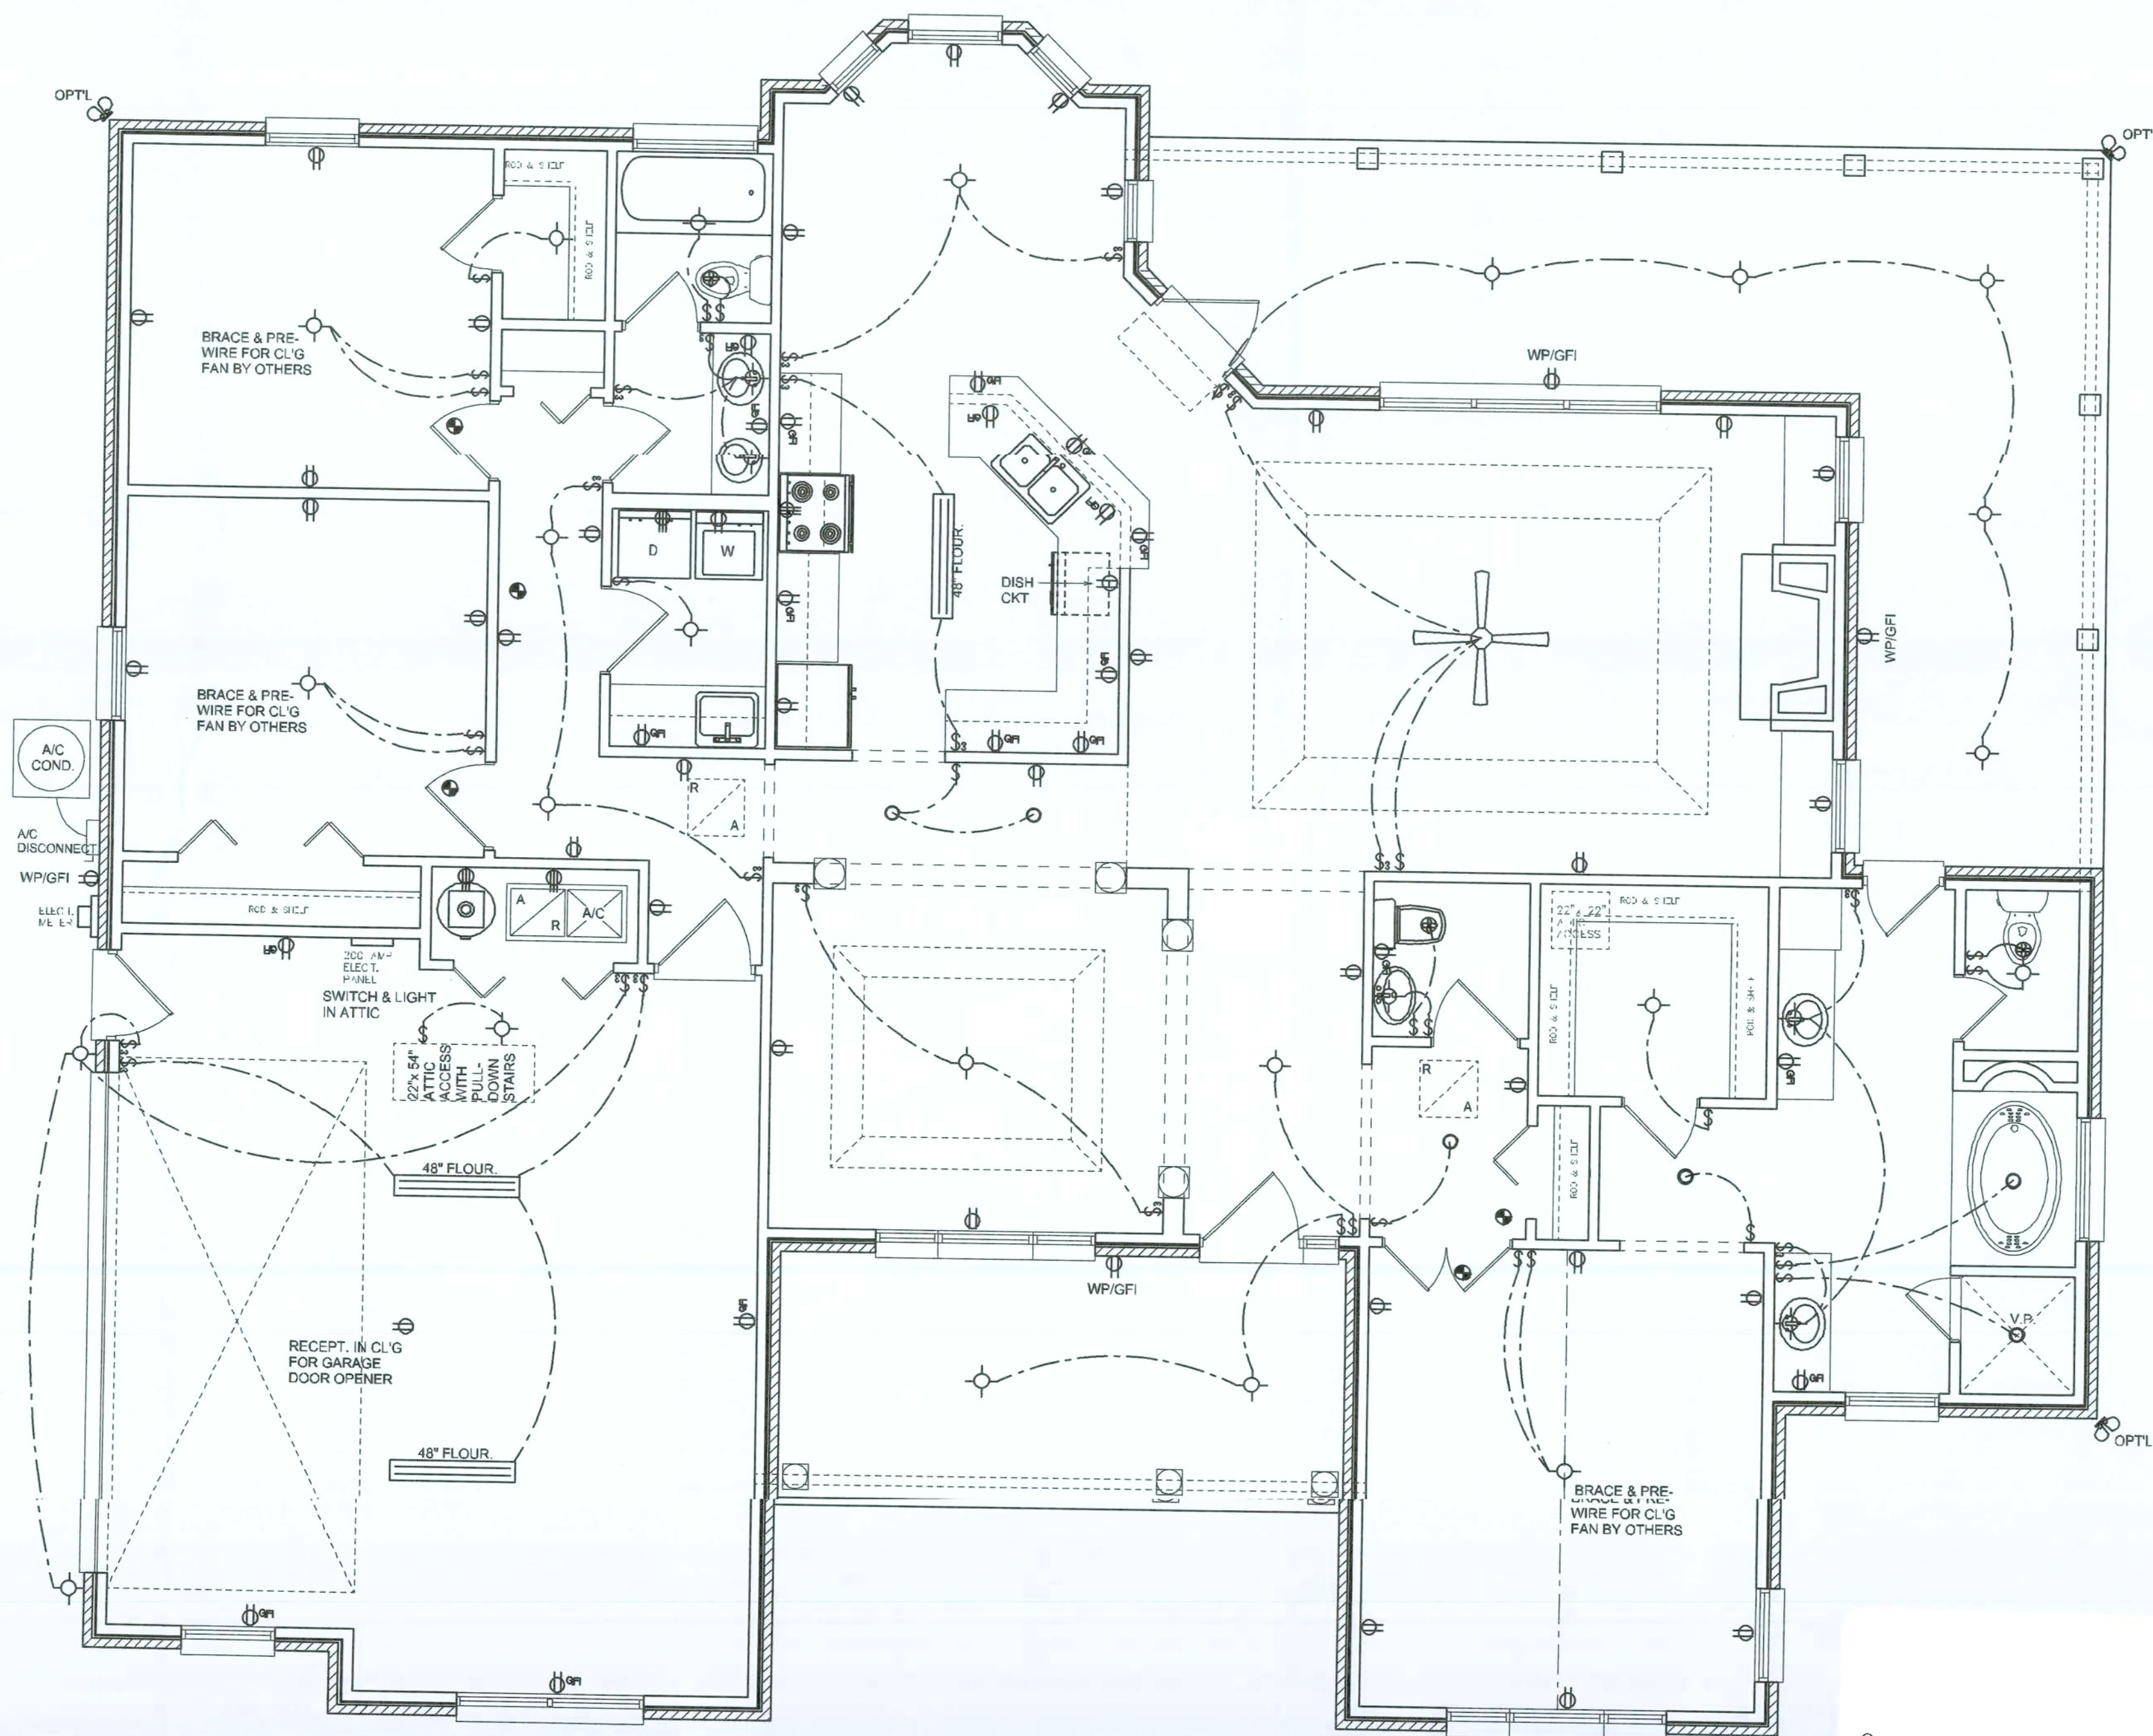

ELECTRICAL PLAN
SCALE: 1/4" = 1'-0"

ELECTRICAL LEGEND	
	CEILING FAN (PRE-WIRE FOR LIGHT KIT)
	DOUBLE SECURITY LIGHT
	RECESSED CAN LIGHT
	BATH EXHAUST FAN
	LIGHT FIXTURE
	DUPLEX OUTLET
	220v OUTLET
	GFI DUPLEX OUTLET
	SMOKE DETECTOR (see note below)
	WALL SWITCH
	3 WAY WALL SWITCH
	WATER PROOF GFI OUTLET
	2 OR 4 TUB FLUORESCENT FIXTURE

NOTE:
ALL BEDROOM RECEPTACLES SHALL BE AFCI
(ARC FAULT CIRCUIT INTERRUPT)
ALL SMOKE DETECTORS SHALL HAVE BATTERY BACKUP POWER
AND ALL WIRED TOGETHER SO IF ANY ONE UNIT IS ACTUATED THEY
ALL ACTIVATE.

Overcurrent protection device shall be installed on the exterior of structures to serve as a disconnecting means. Conductors used from the exterior disconnecting means to a panel or sub panel shall have four-wire conductors, of which one conductor shall be used as an equipment ground.


REVISIONS
January 24, 2006

SOFTPLAN
ARCHITECTURAL DESIGN SOFTWARE

ELECTRICAL PLAN
SCALE: 1/4" = 1'-0"

A NEW SPEC HOUSE FOR:
SETH HEITZMAN CONST.
PROJECT ADDRESS: LOT 55, ROLLING MEADOWS, LAKE CITY, FLORIDA 32025

©WILLIAM MYERS
DESIGN
P.O. BOX 1513
LAKE CITY, FL 32056
(386) 758-8406
wll@willmyers.net

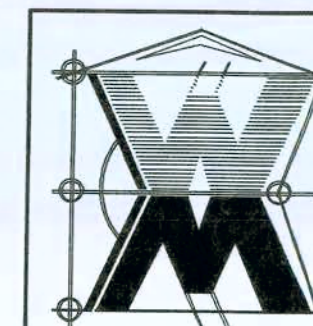

JOB NUMBER
051217

SHEET NUMBER


A.3

OF 3 SHEETS


Wm Myers

REVISIONS


SOFTPLAN
ARCHITECTURAL DESIGN SOFTWARE

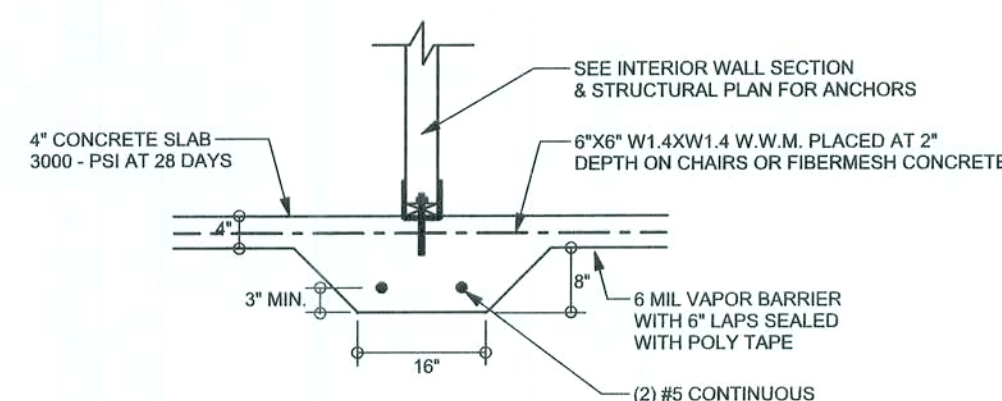


F2
S-2 INTERIOR BEARING FOOTING
SCALE: 1/2" = 1'-0"

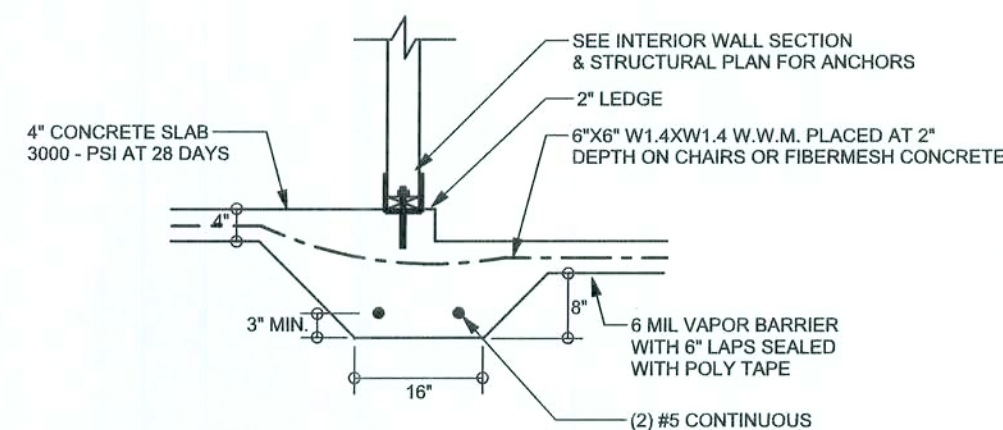


F3
S-2 INTERIOR BEARING STEP FOOTING WITH 2" LEDGE
SCALE: 1/2" = 1'-0"

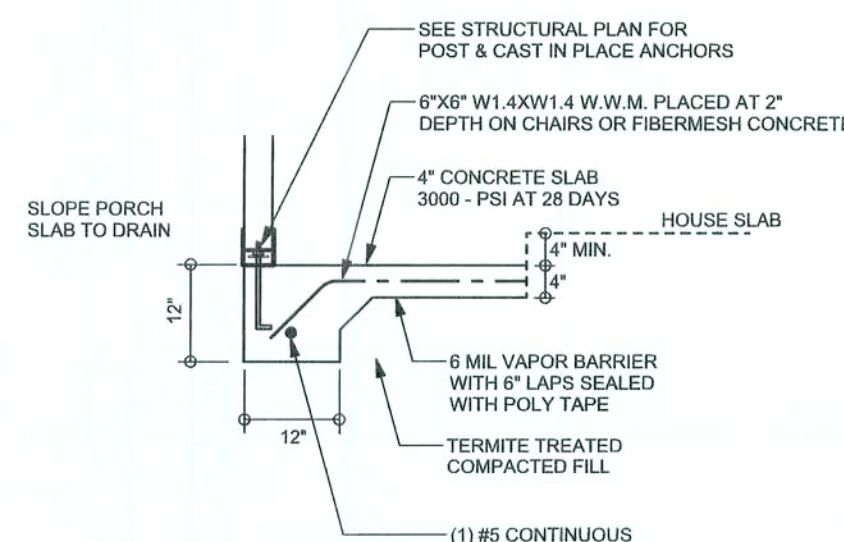


F5
S-2 PORCH FOOTING
SCALE: 1/2" = 1'-0"

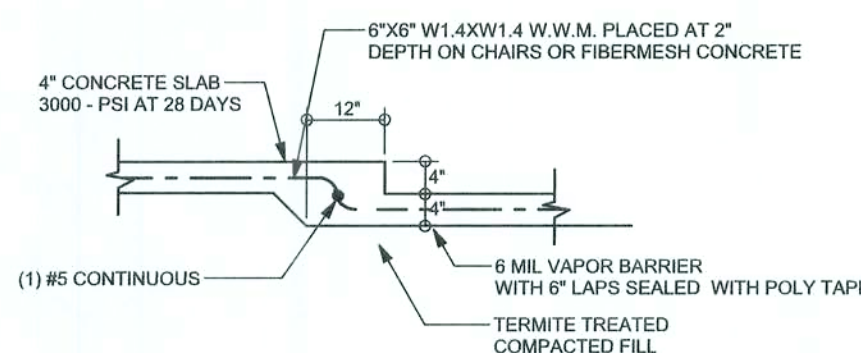


F6
S-2 TYPICAL NON - BEARING STEP FOOTING
SCALE: 1/2" = 1'-0"

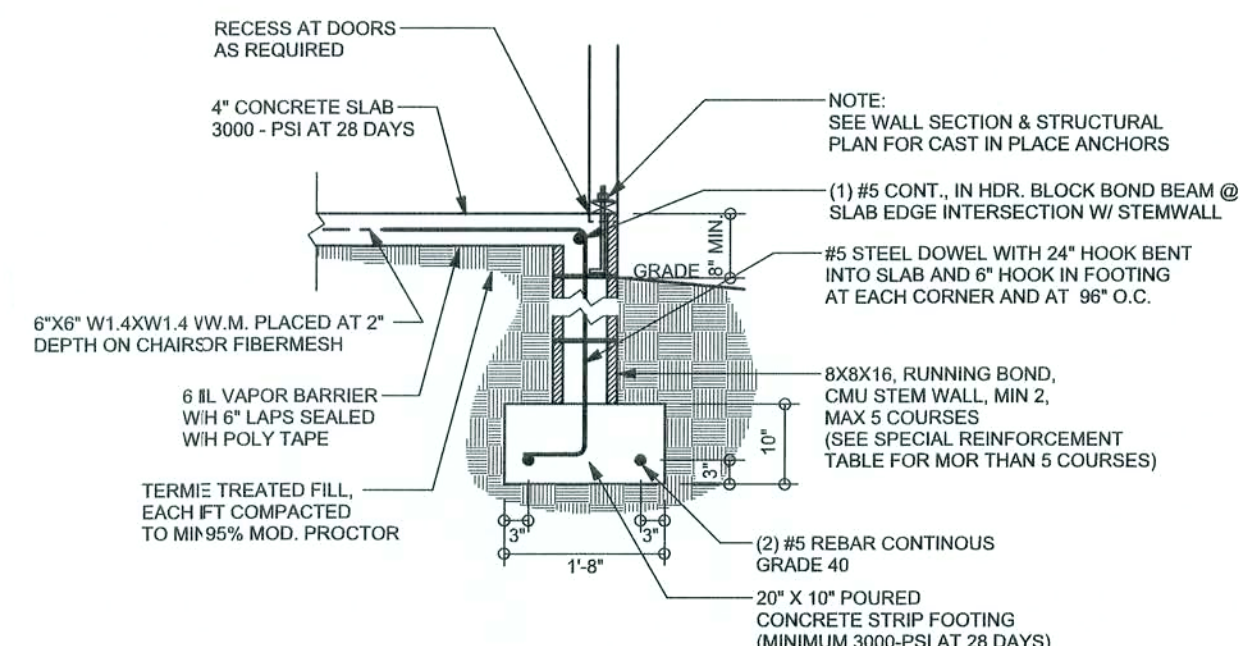


F9
S-2 STEM WALL FOOTING
SCALE: 1/2" = 1'-0"

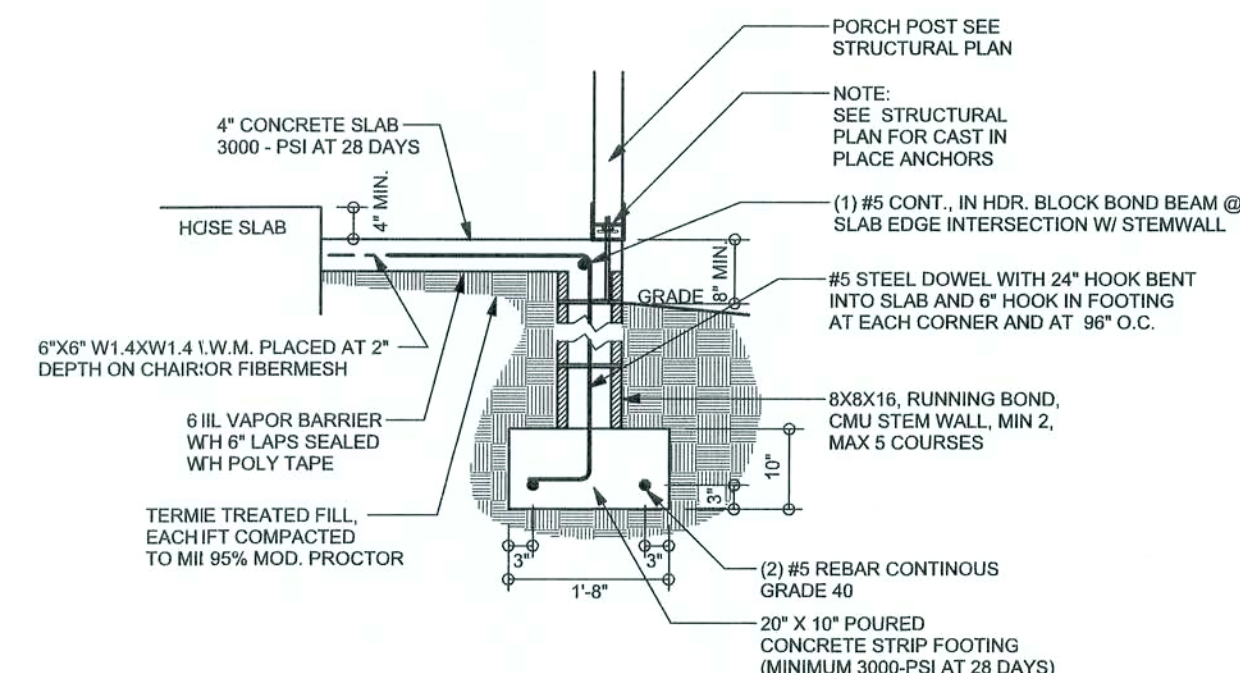

F12
S-2 ALT. STEM WALL PORCH FOOTING
SCALE: 1/2" = 1'-0"

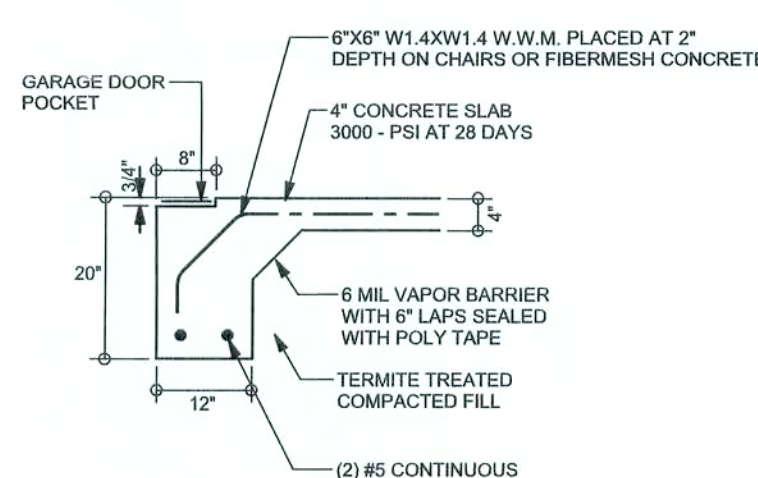

F13
S-2 ALT. STEM WALL GARAGE DOOR FOOTING
SCALE: 1/2" = 1'-0"

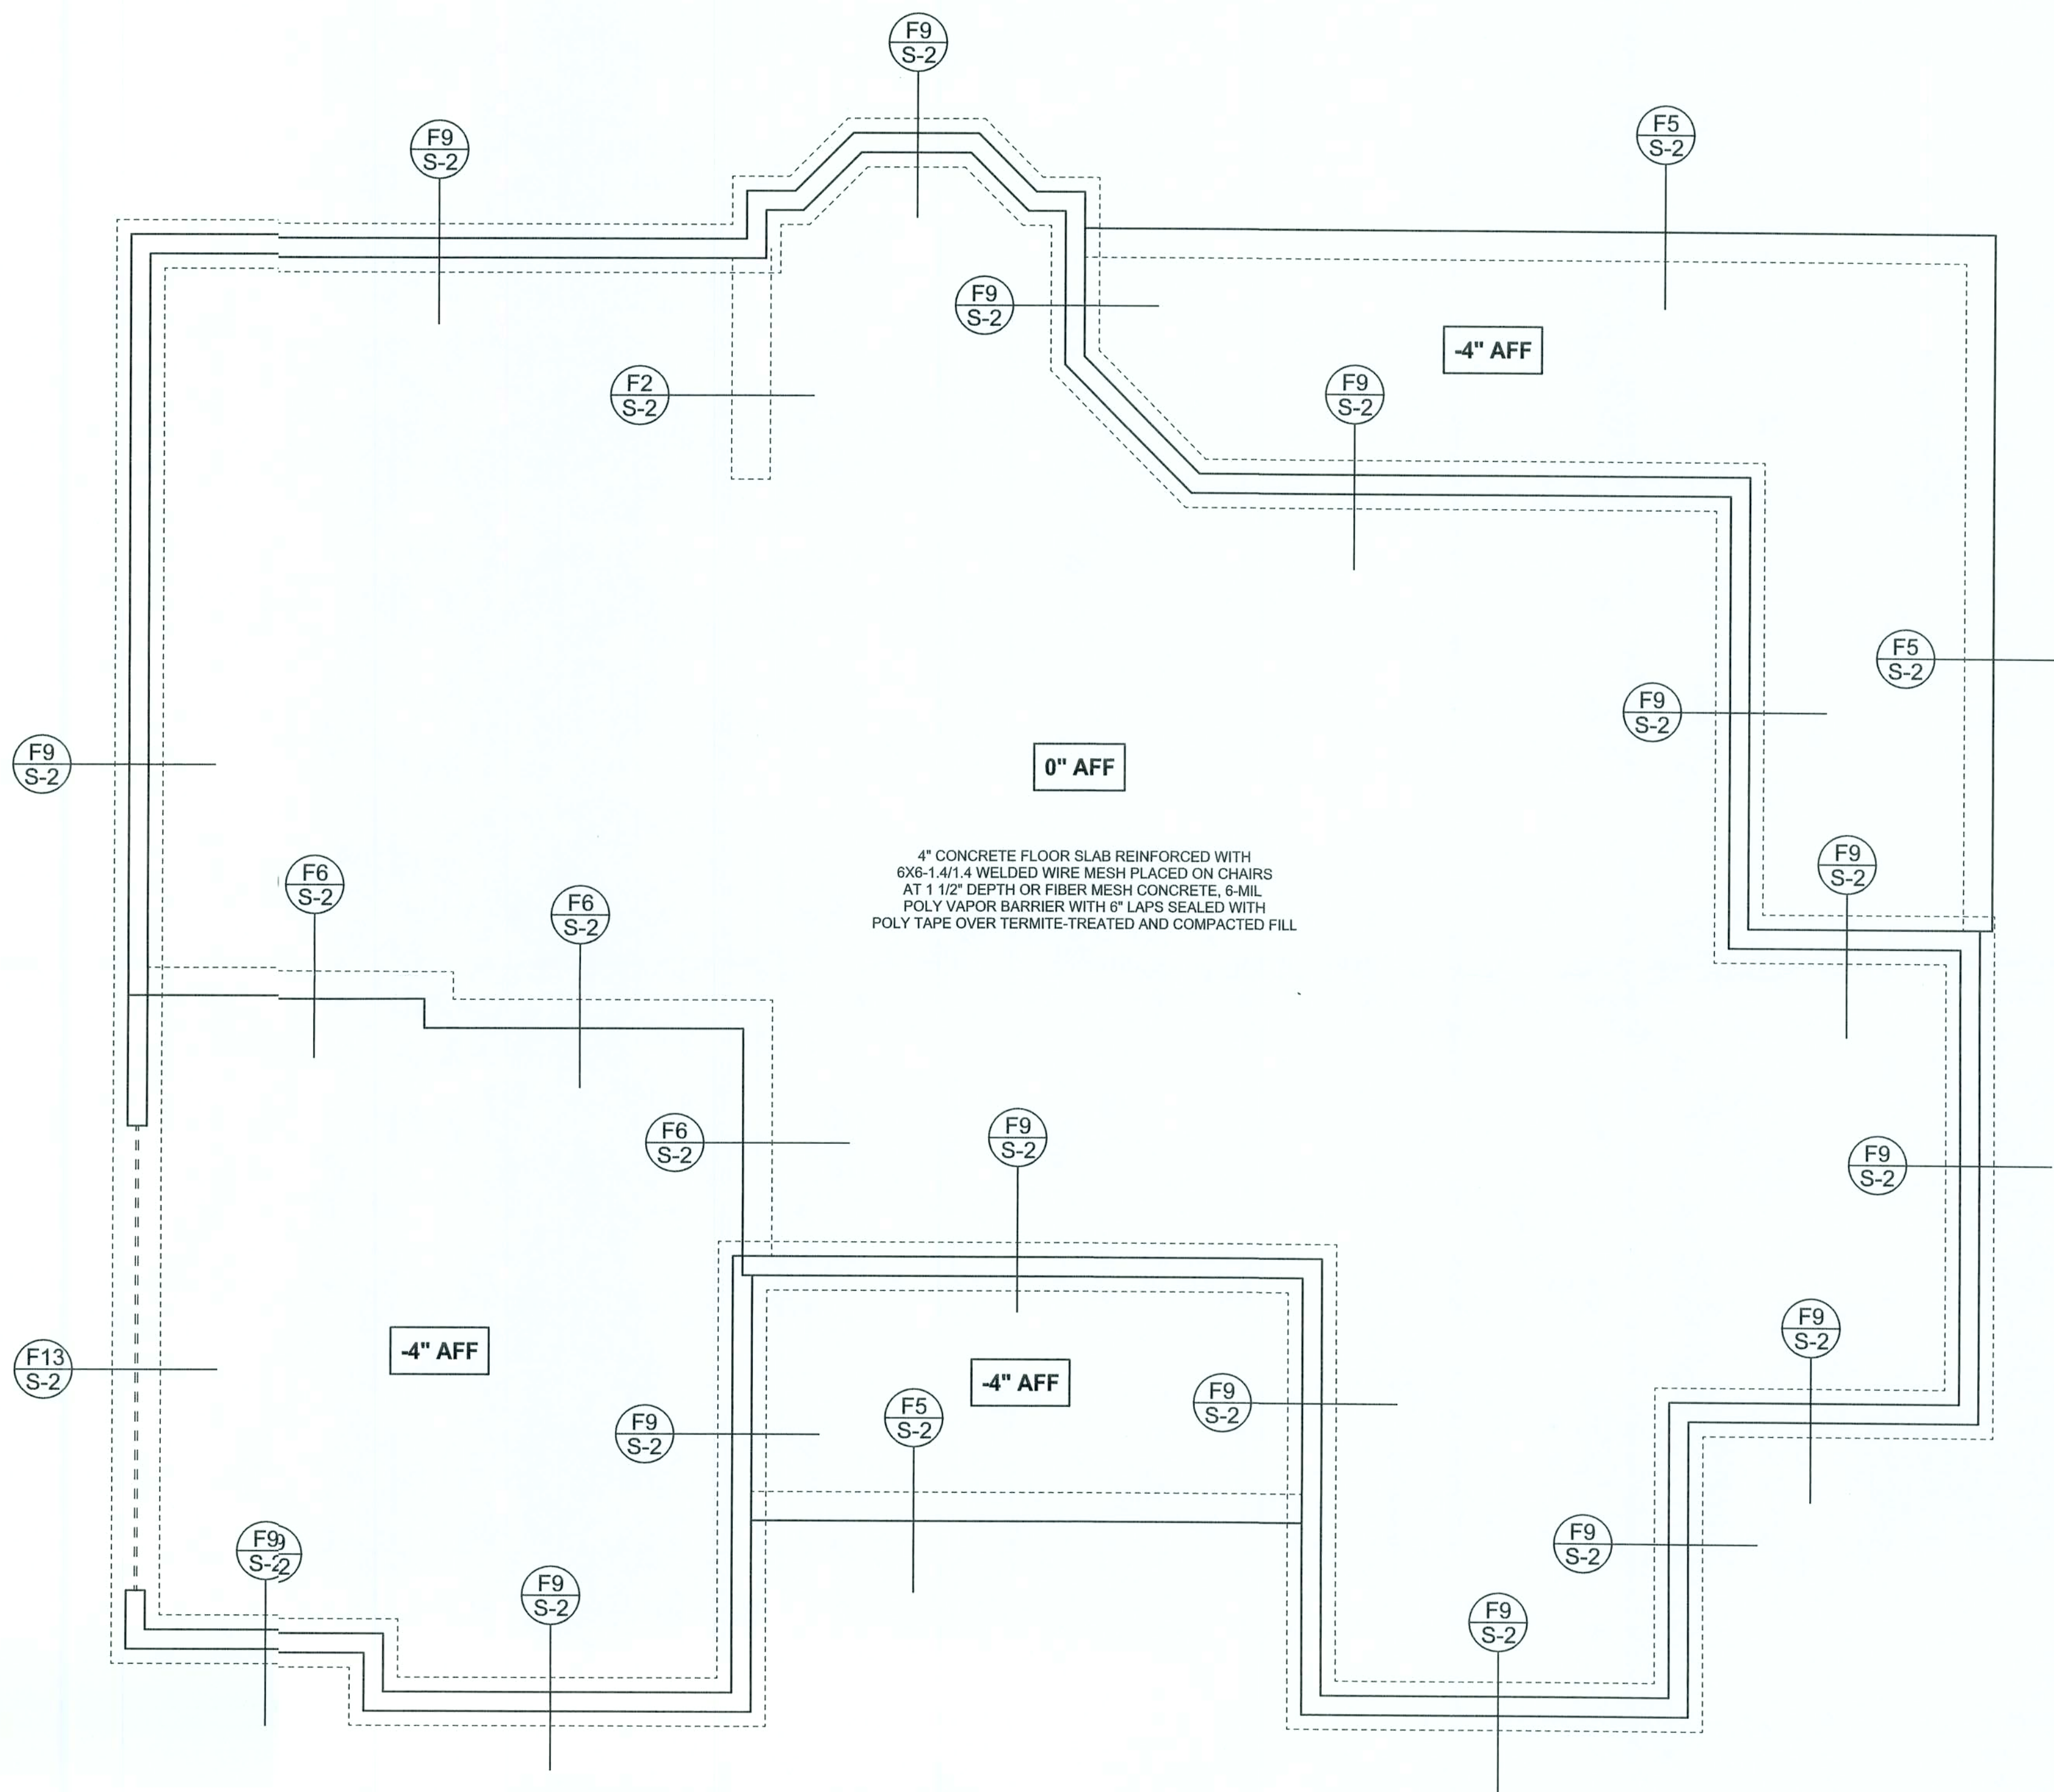

FOUNDATION PLAN

SCALE: 1/4" = 1'-0"

DIMENSIONS ON STRUCTURAL SHEETS
ARE NOT EXACT. REFER TO ARCHITECTURAL
FLOOR PLAN FOR ACTUAL DIMENSIONS

WINDLOAD ENGINEER: Mark Disoway,
P.E. No. 53815, P.O. Box 868, Lake City, FL
32056, (386) 754-5419

DIMENSIONS:
Stated dimensions supersede scaled
dimension. Refer all questions to
Mark Disoway, P.E. for resolution.
Do not proceed without clarification.

COPYRIGHTS AND PROPERTY RIGHTS:
Mark Disoway, P.E. hereby expressly reserves
its common law copyrights and property right in
these instruments of service. This document is
not to be reproduced, altered or copied in any
form or manner without first the express written
permission and consent of Mark Disoway.

CERTIFICATION: I hereby certify that I have
examined this plan, and that the applicable
portions of the plan, relating to wind engineering
comply with section F301.2.1, Florida building
code residential 2004, to the best of my
knowledge.

LIMITATION: This design is valid for one
building, at specified location.

MARK DISOWAY
P.E. 53815

Mark Disoway
1/19/06
SEAL

Jeth Heitzman

Spec House
Lot 55
Rolling Meadows S/D

ADDRESS:
Lot 55 Rolling Meadows
Columbia County, Florida

Mark Disoway P.E.
P.O. Box 868
Lake City, Florida 32056
Phone: (386) 754 - 5419
Fax: (386) 269 - 4871

PRINTED DATE:
January 19, 2006

DRAWN BY: STRUCTURAL BY:
David Disoway

FINAL DATE:
19 / Jan / 06

JOB NUMBER:
512211

DRAWING NUMBER

S-2

OF 3 SHEETS

