
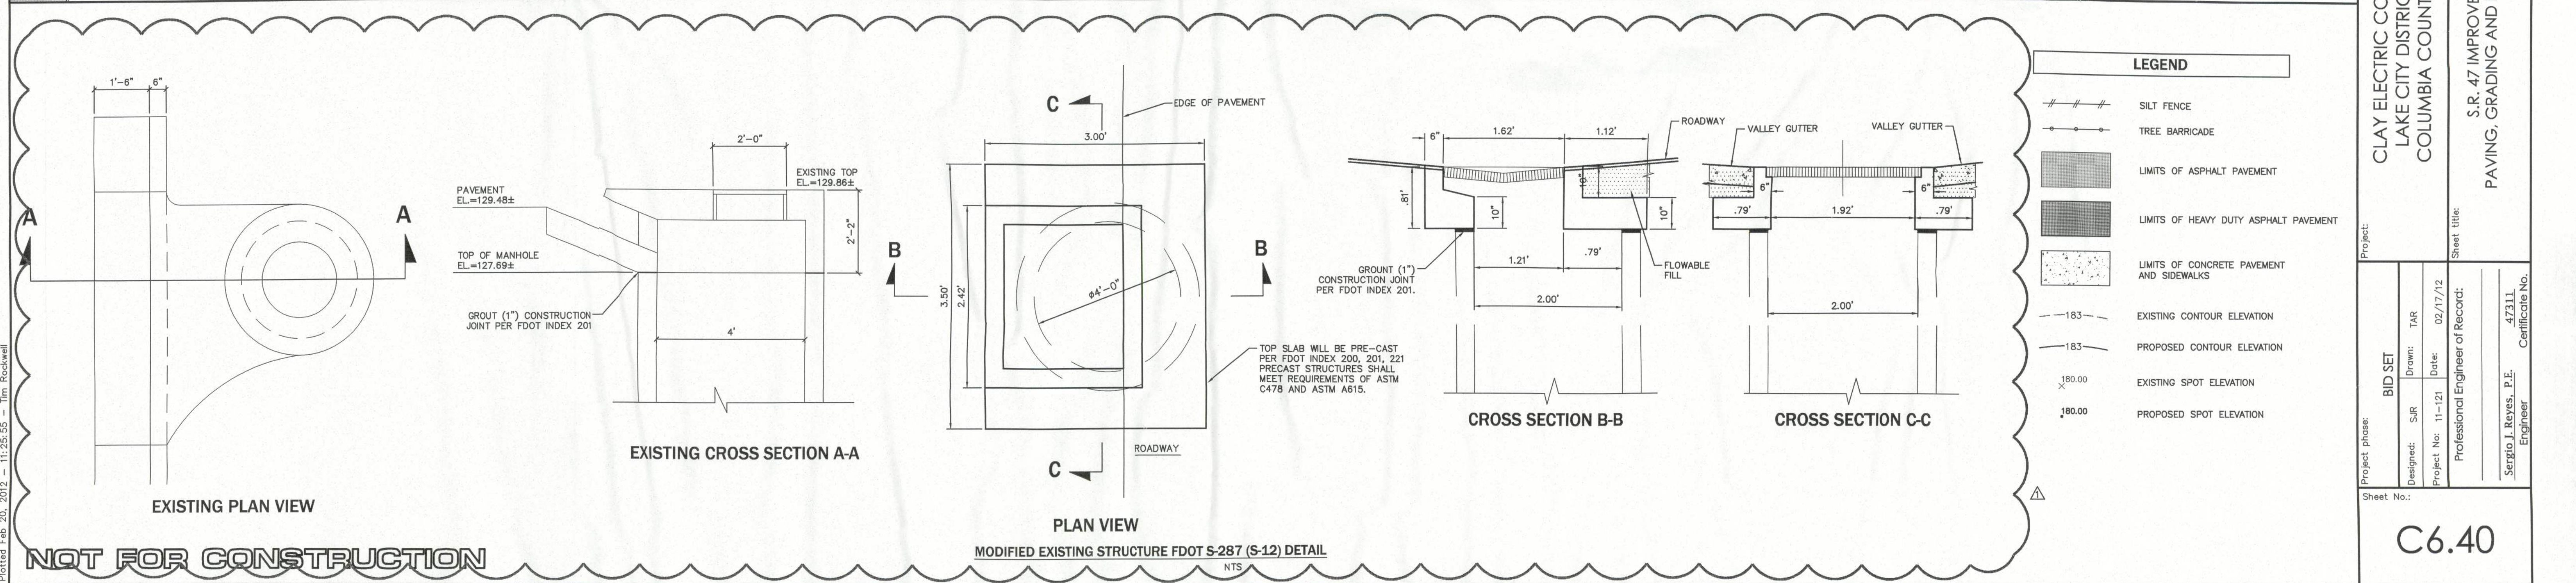


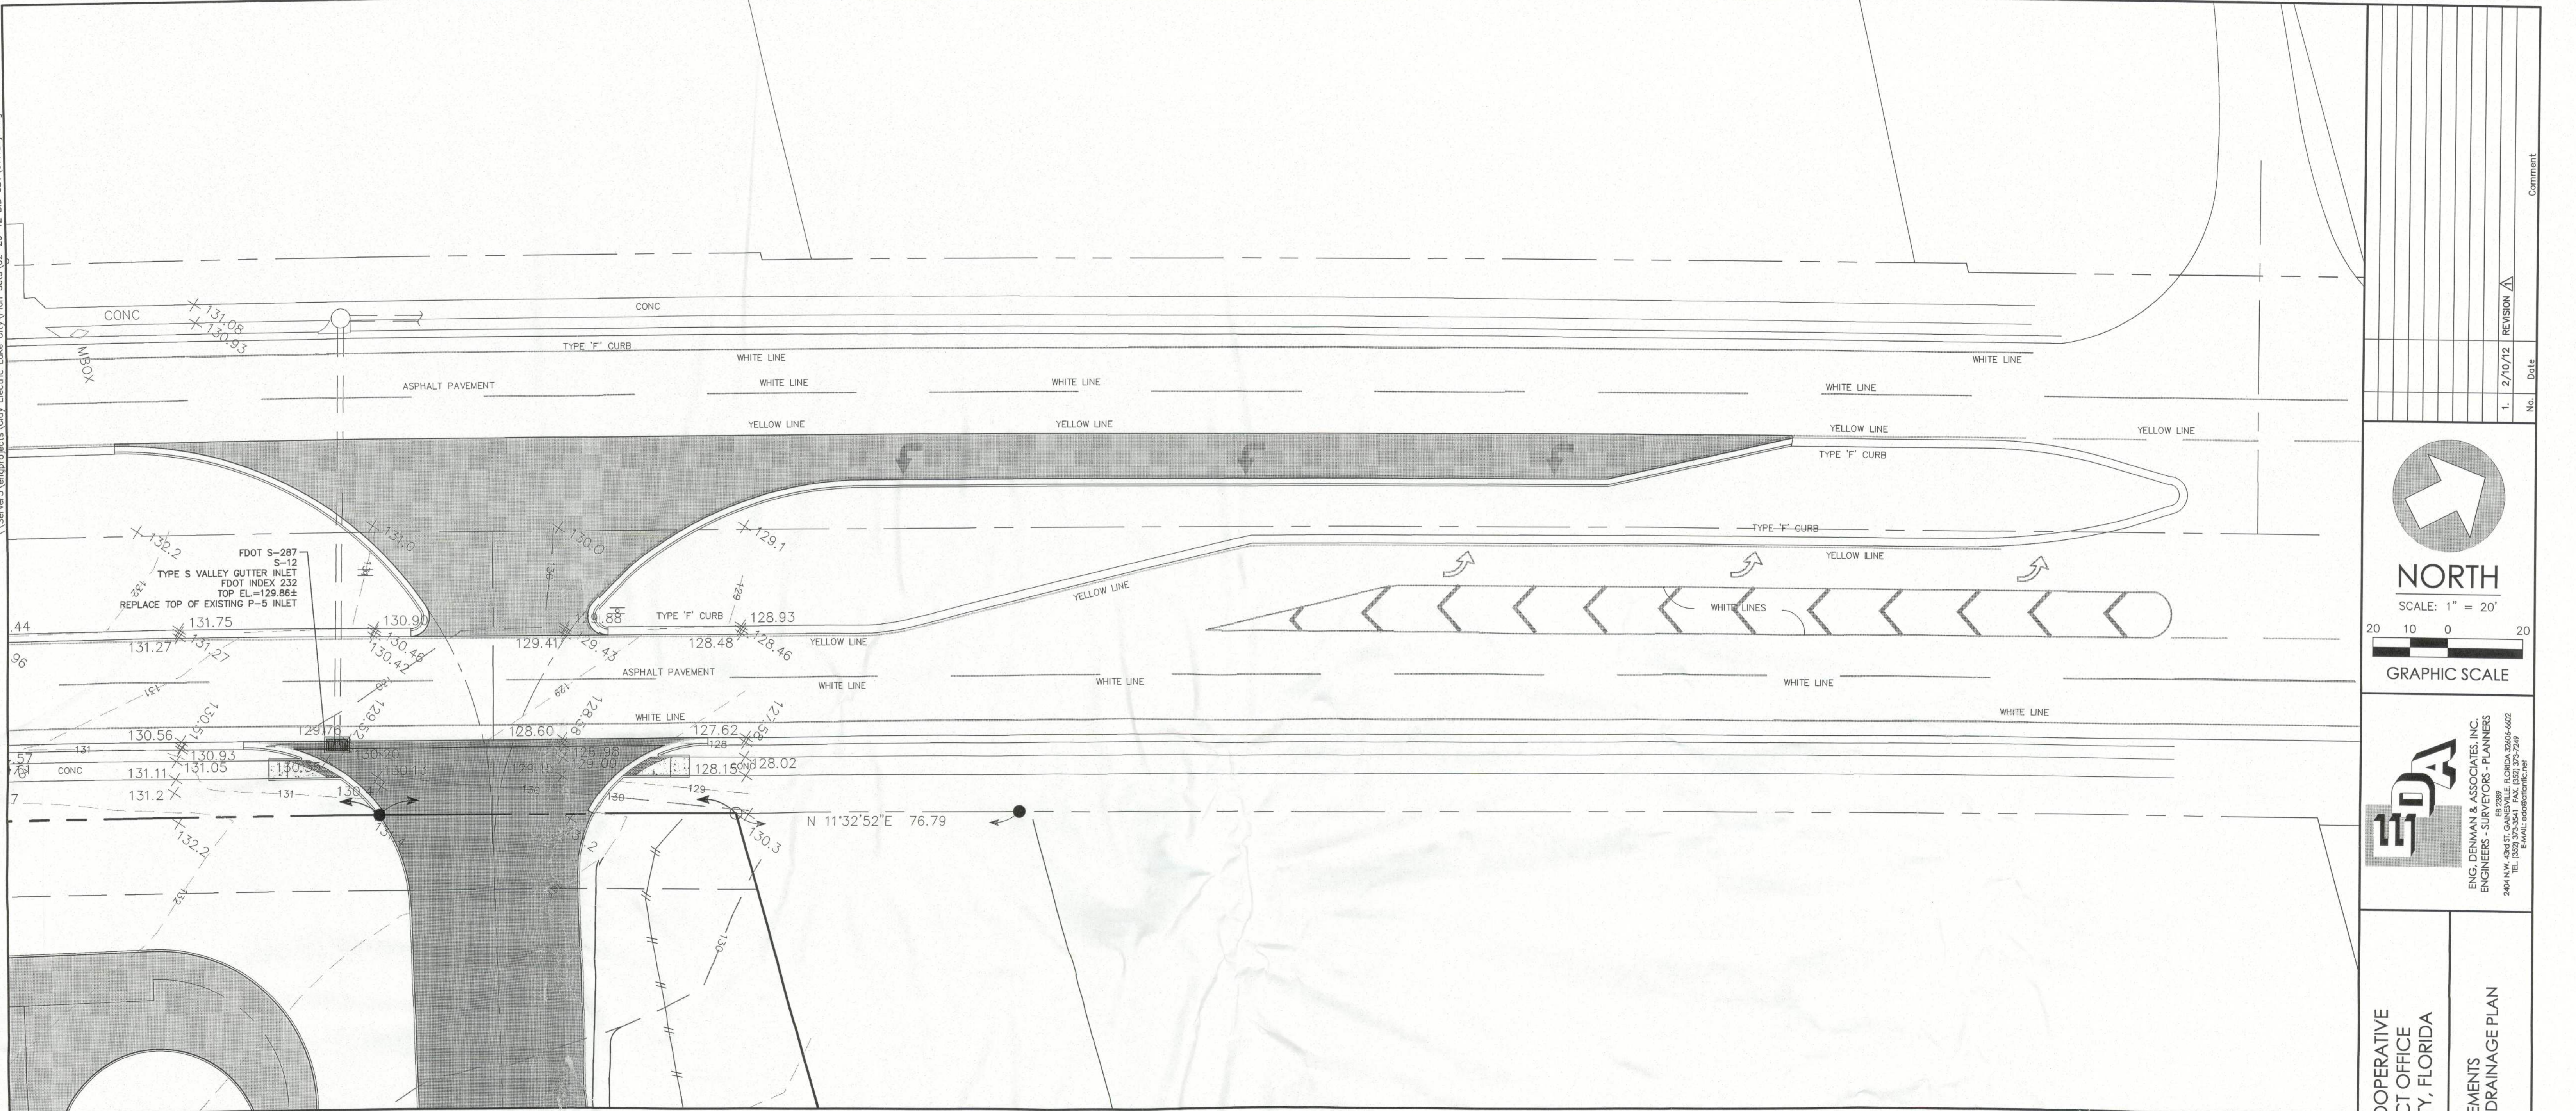

Project phase: BID SET

Designed: SJR

Drawn: TAR

Project No: 11-121

Professional Engineer of Record:

Sheet No.:

2/10/12

REVISION

No.

Date

Comment

CLAY ELECTRIC COOPERATIVE
LAKE CITY DISTRICT OFFICE
COLUMBIA COUNTY, FLORIDA

S.R. 47 IMPROVEMENTS
PAVING, GRADING AND DRAINAGE PLAN

EDA

ENG. DENMAN & ASSOCIATES, INC.
ENGINEERS - SURVEYORS - PLANNERS
2004 NW 10th St. Lake City, FL 33709
TEL: (813) 375-5441 FAX: (813) 375-5442
E-MAIL: eda@denmaninc.com

C6.40