



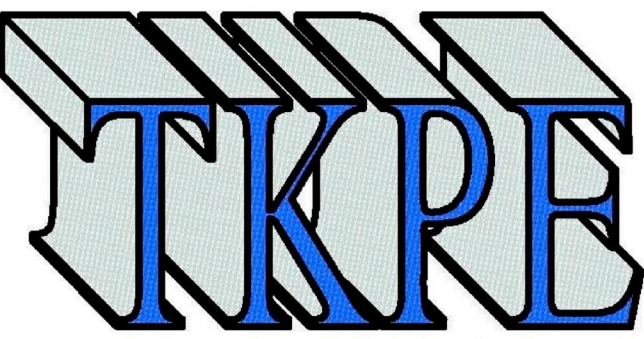

Thomas M. Kelaher, P.E.  
Structural Consultants  
Florida Rg. No 40159  
1108 S.E. 14th Terrace  
Deerfield Beach, FL 33441  
Phone (954) 360.9628  
Fax (954) 360.0173  
tkelaherengr@comcast.net

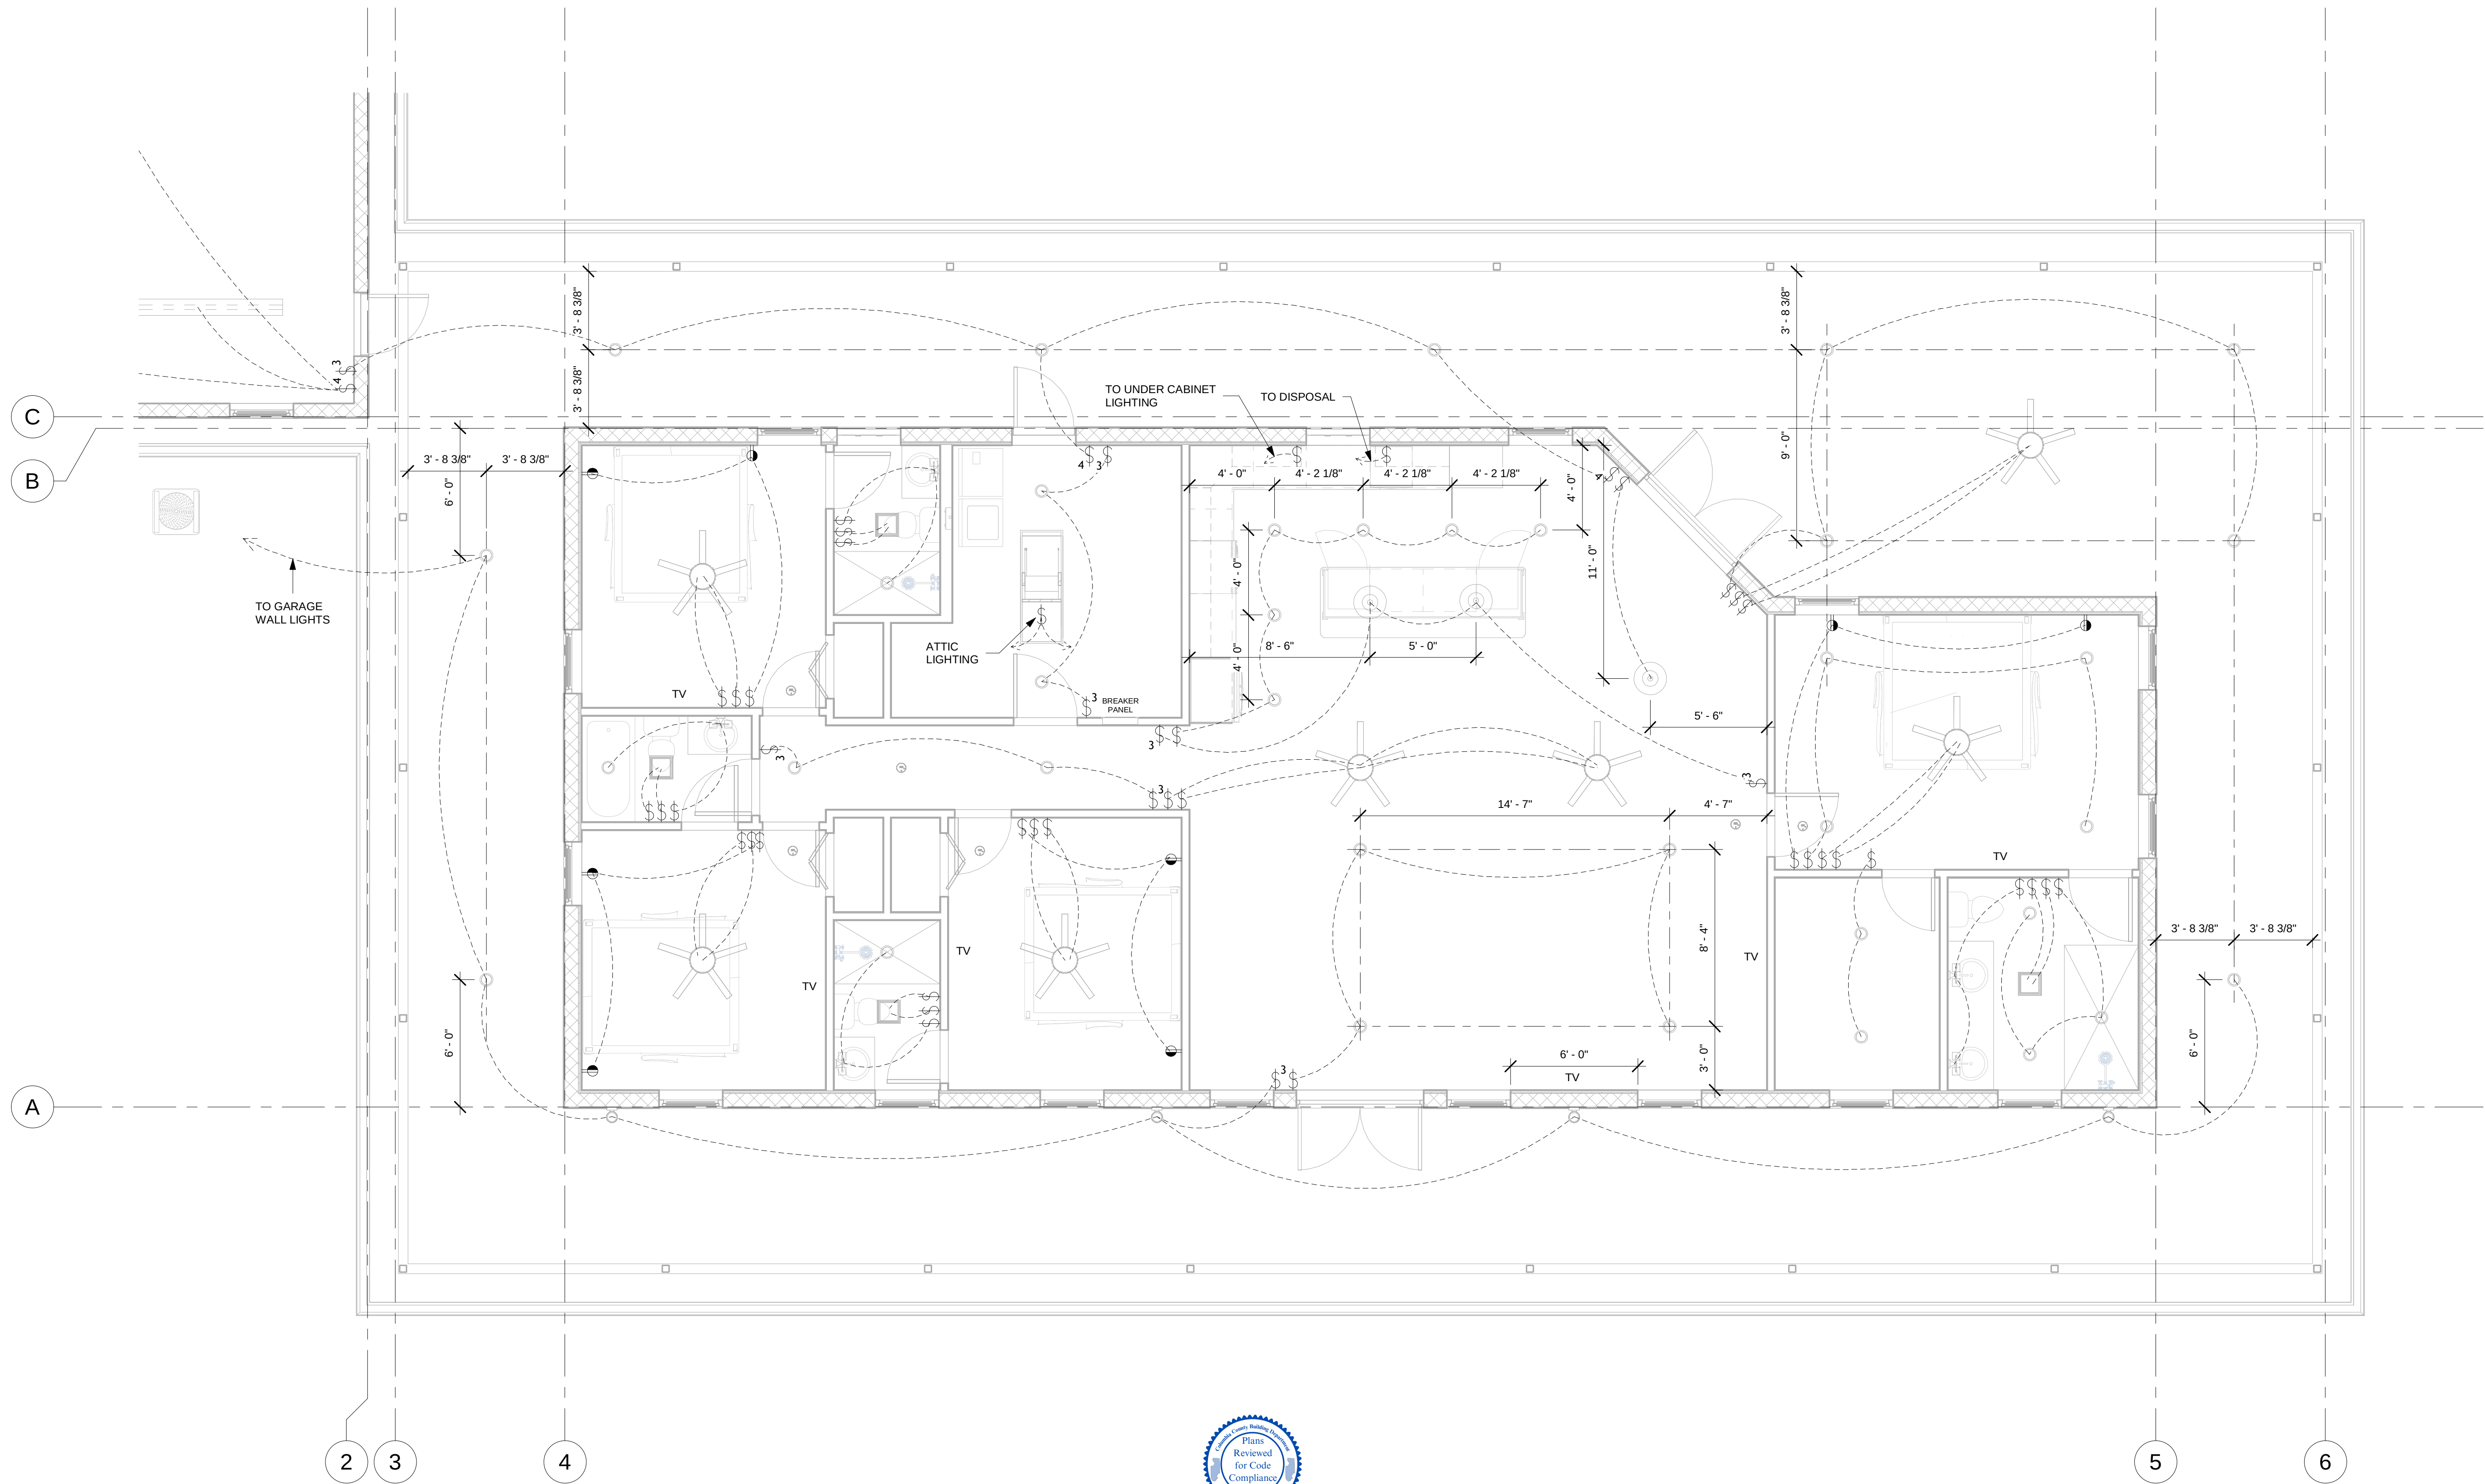

1 **Lighting Plan**  
1/4" = 1'-0"



Dana & Carol (Wendy) Anderson  
Residence

SW Meadowlands Drive  
Lake City, Florida

| No. | Description | Date |
|-----|-------------|------|
|     |             |      |
|     |             |      |
|     |             |      |

Proposed Residence

Electric - Lighting Plan

|                |            |
|----------------|------------|
| Project number | 24-045     |
| Date           | 12/25/2024 |
| Drawn by       | A.O.       |
| Checked by     | T.K.       |

E101

Scale 1/4" = 1'-0"