




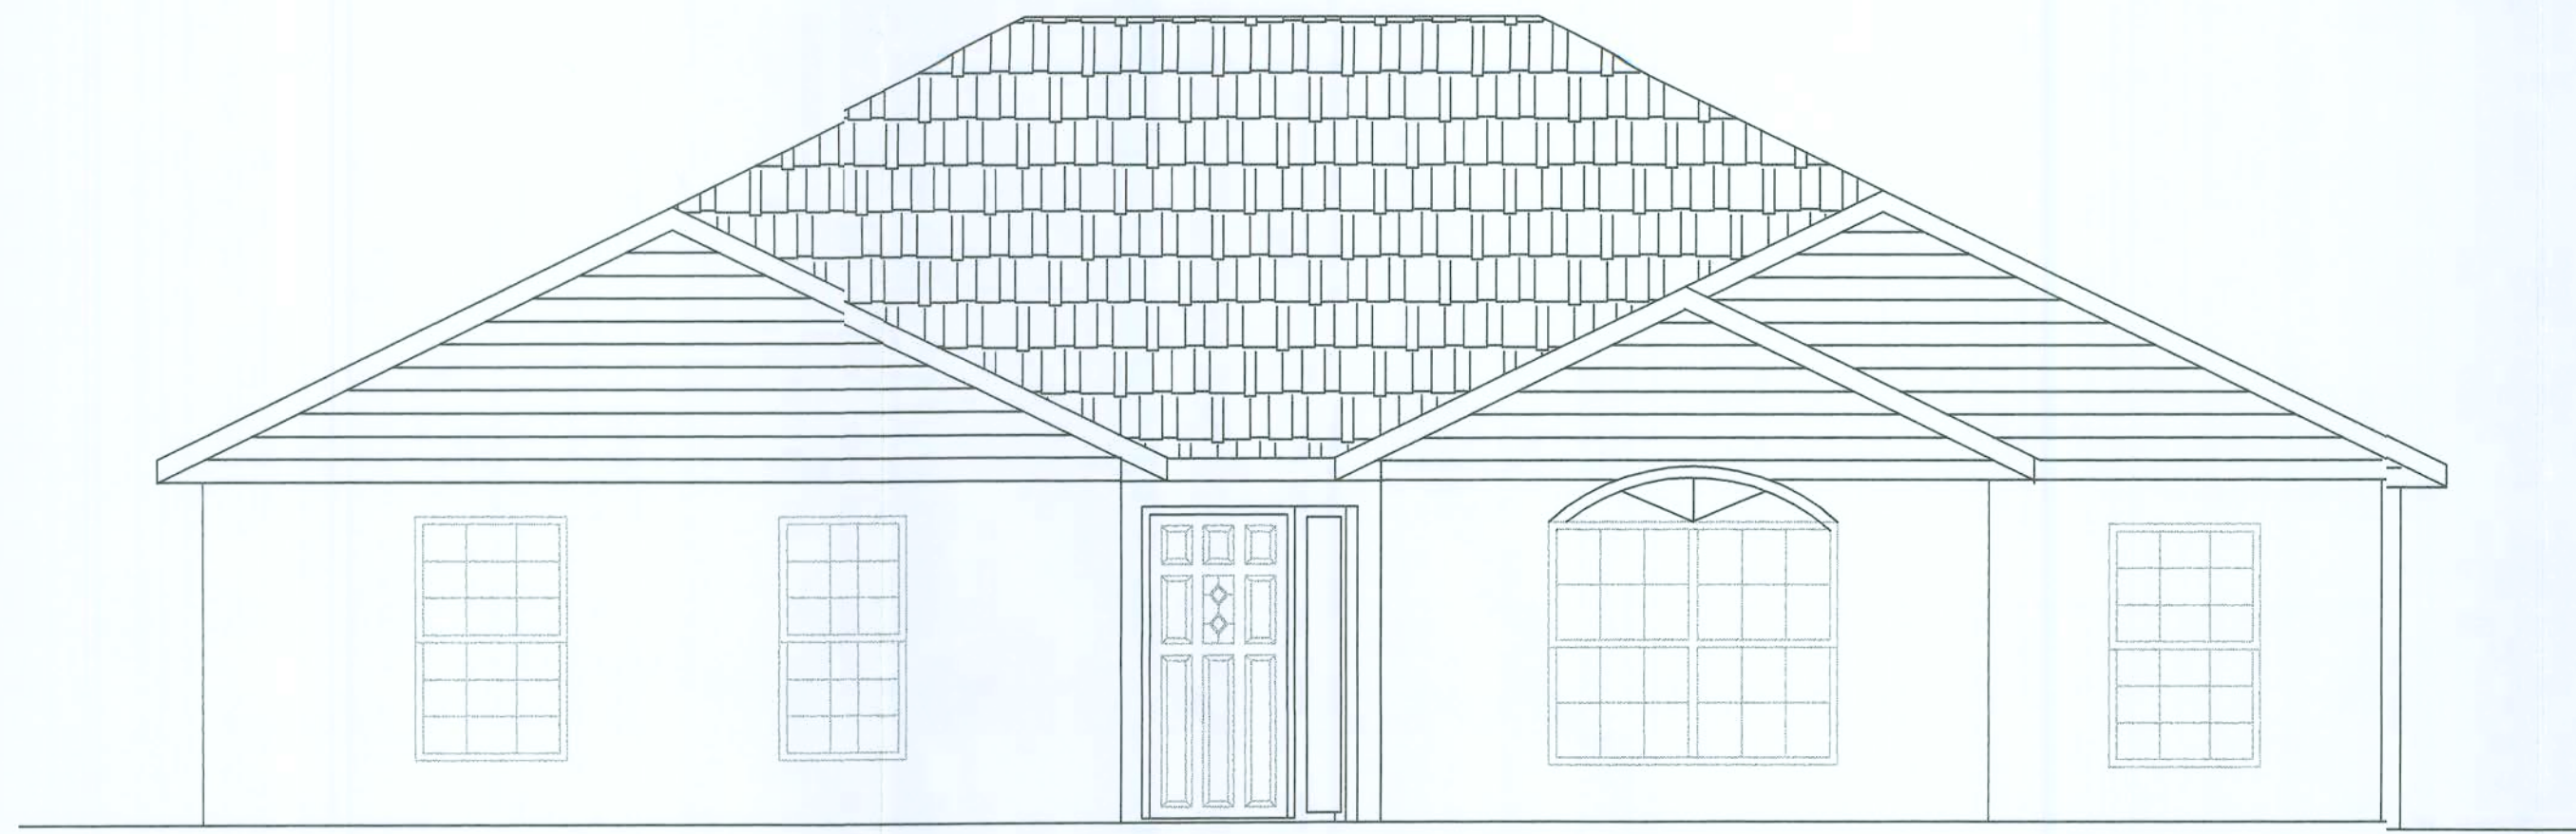


FRONT ELEVATION
SCALE: 1/4"=1'-0"

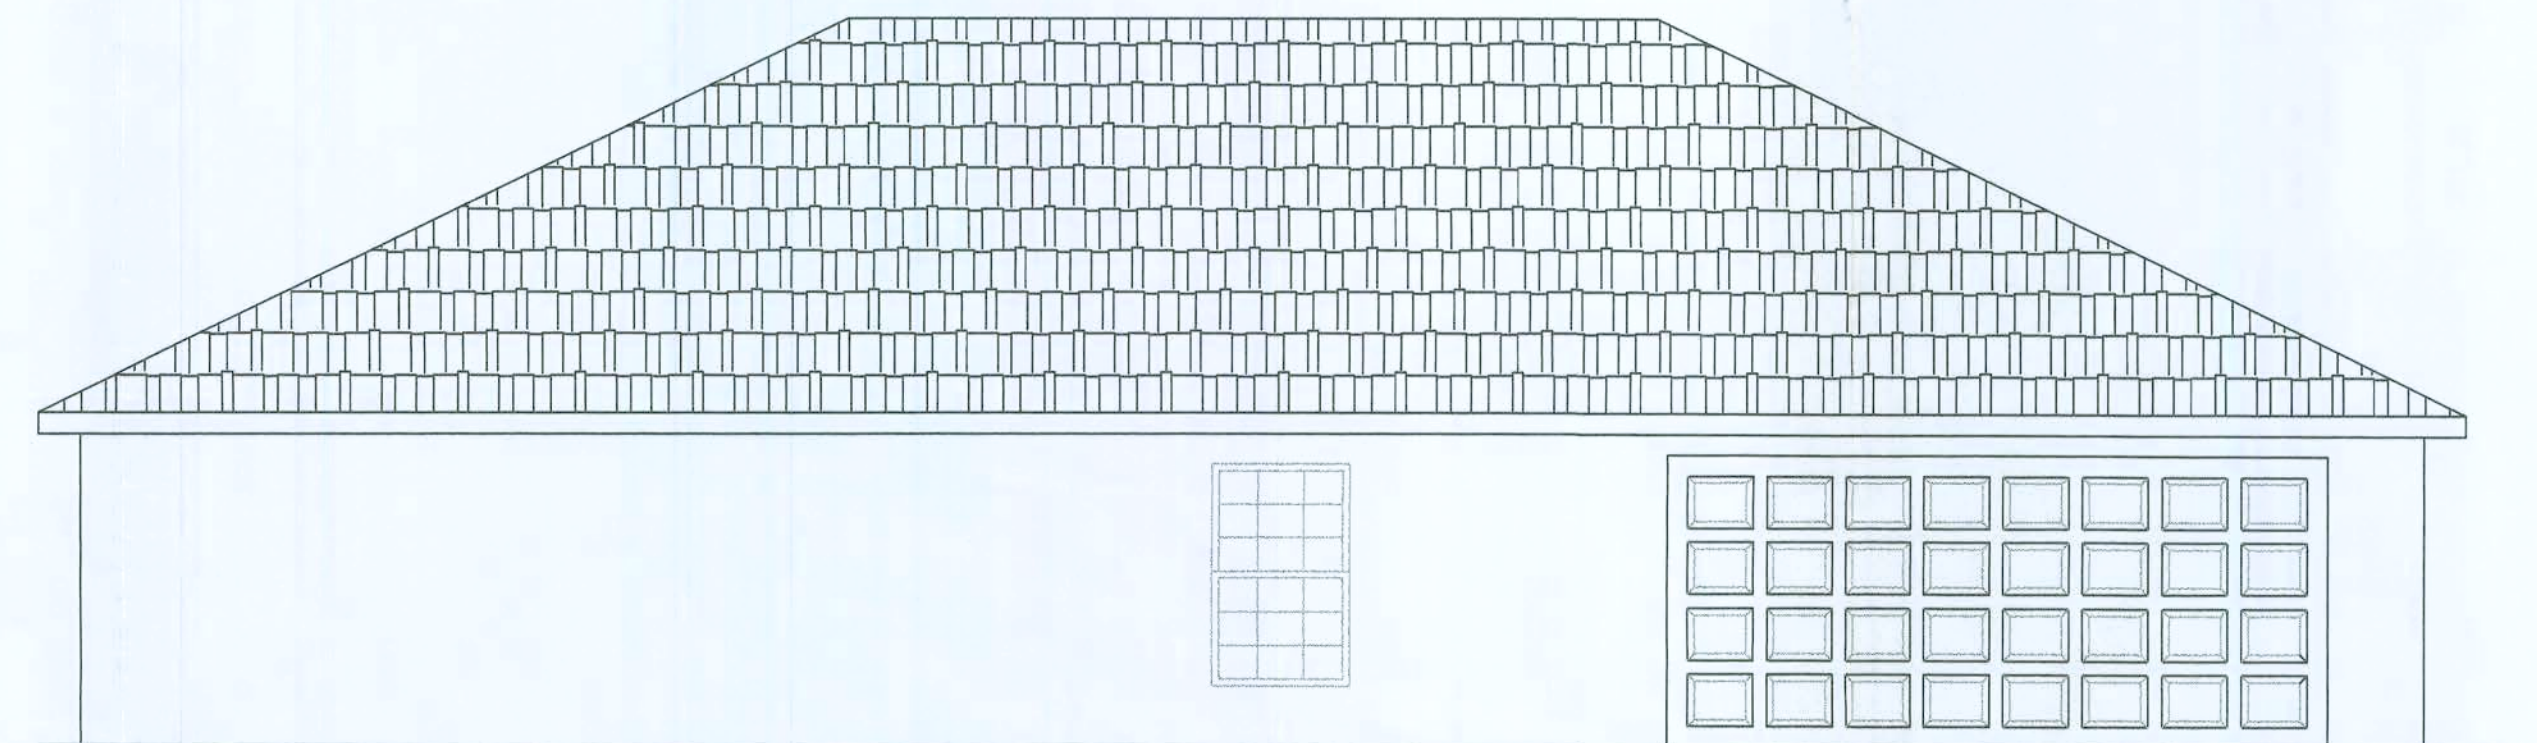

LEFT ELEVATION
SCALE: 1/4"=1'-0"

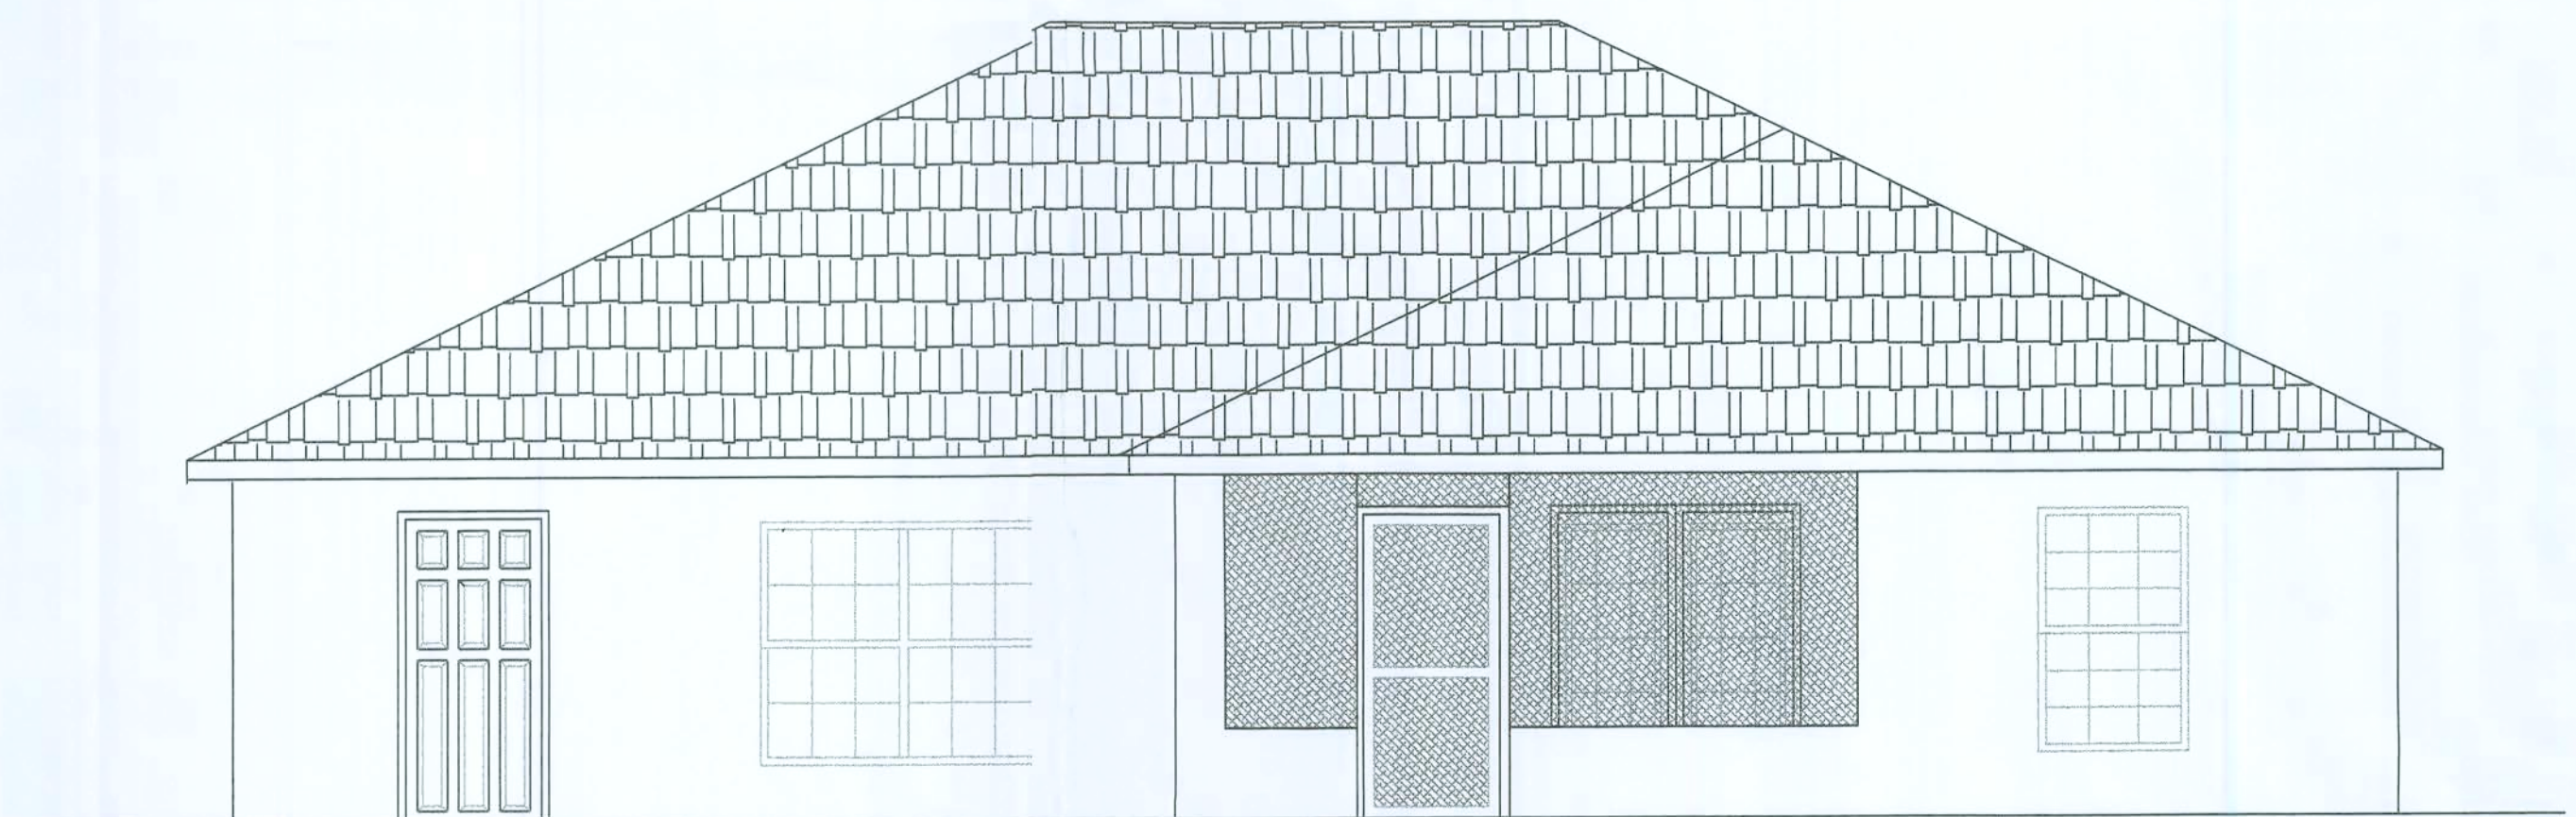

BACK ELEVATION
SCALE: 1/4"=1'-0"

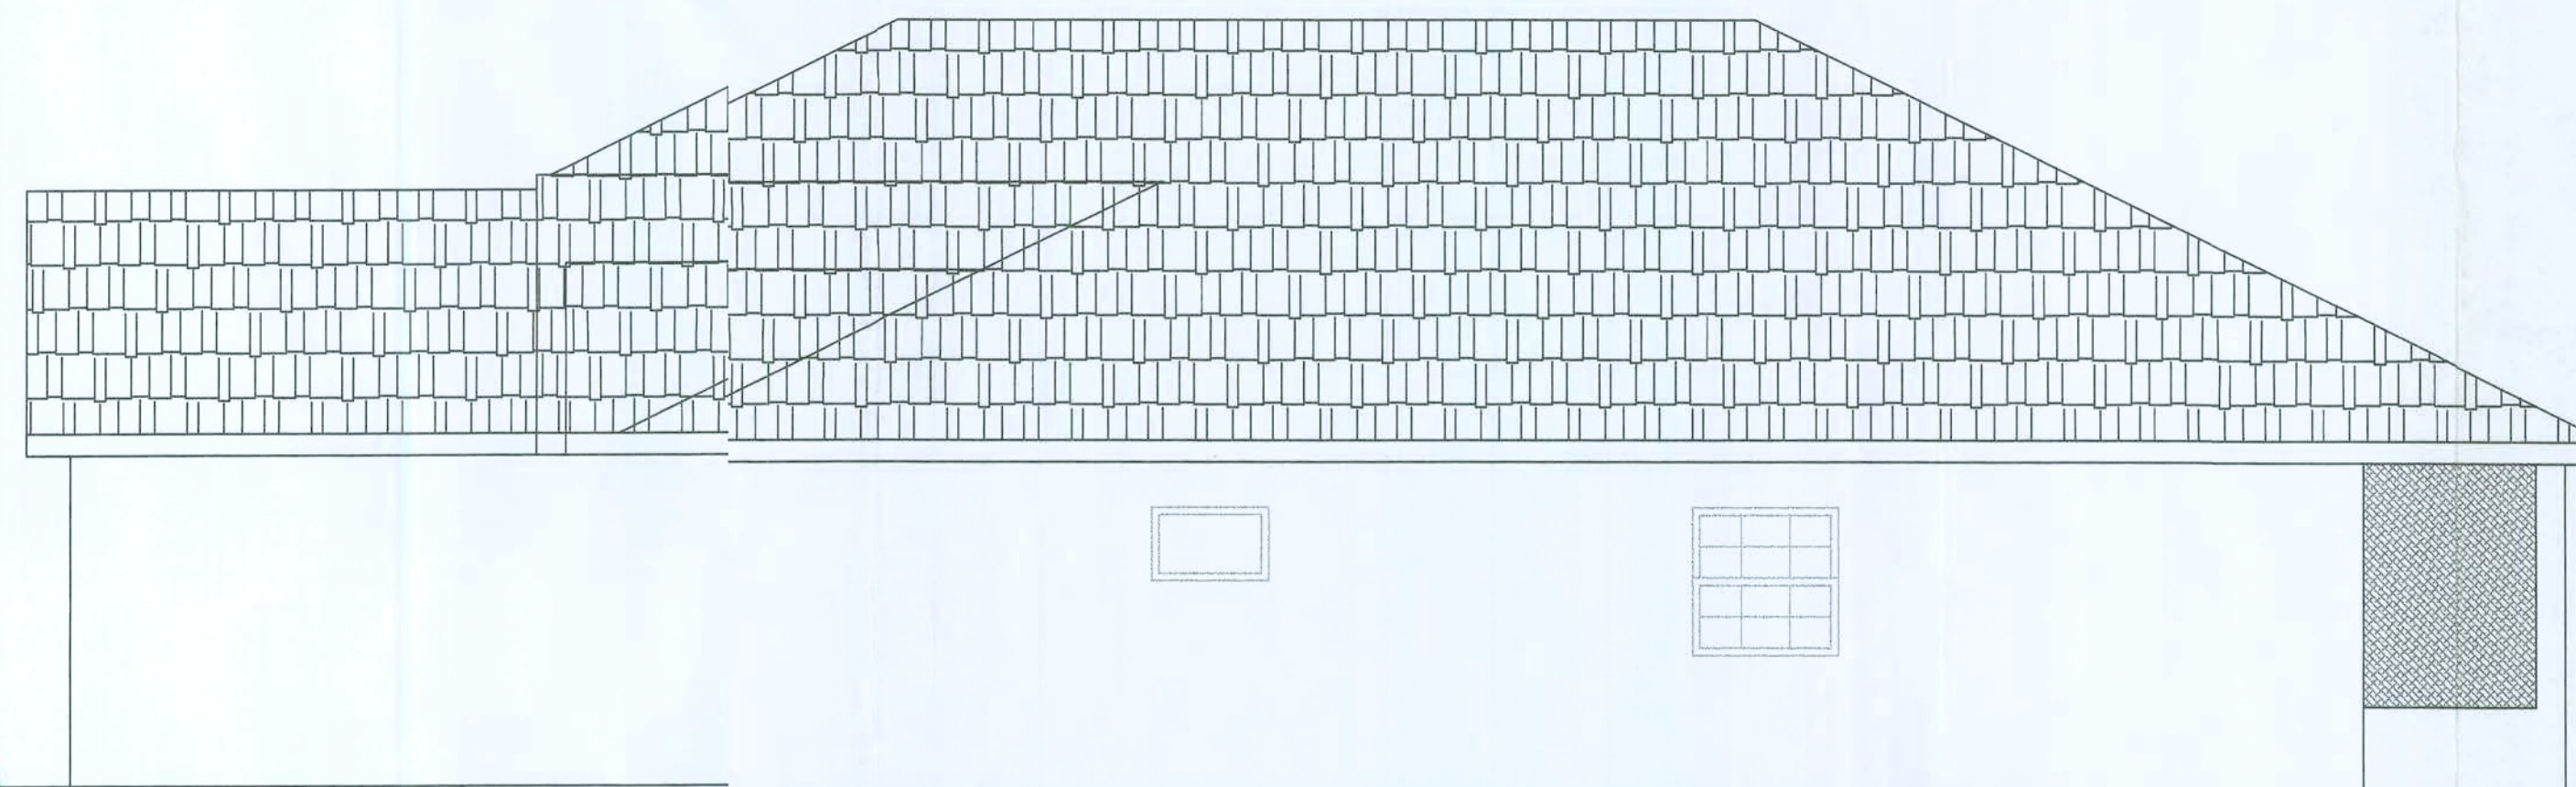

RIGHT ELEVATION
SCALE: 1/4"=1'-0"

ROOF VENT SCHEDULE

0,000 SQ. FT./300 = 00.00 SQ. FT. VENT REQUIRED
000 L. FT. x2/35 = 0.00 SQ. FT. VENT PROVIDED
00 STANDARD ROOF VENTS x 0.72 = 0.00 SQ. FT. PROVIDED
0.00 REQUIRED = 00.00 PROVIDED



HOUSE CRAFT HOMES, L.L.C.
12523 NW U.S. Hwy. 441 - Alachua, FL 32615
Phone: (386) 462-5323/FAX: (386) 462-1509

Job name: **FARRIMOND**
Model: CUSTOM Type: ELEVATIONS
Location: COLUMBIA COUNTY Drawn By: J.D.H.
Checked By: J.D.H. Revision Date: Date
Scale: 1/4"=1' Date: 10/20/09 Sheet: 3 of 3

Office Copy



HOMES BY HOUSE CRAFT, L.L.C.

12523 U.S. Highway 441 - Alachua, FL 32615 Phone: (904) 462-5323/FAX: (904) 46-1509

Client Name: FARRIMOND Model: CUSTOM

BANK: CASH LOAN TYPE: ☒ Cash
☐ Conventional
☐ F.H.A.
☐ V.A.

CABINET COLOR SELECTIONS:

Kitchen: _____ Toilets: _____ Colc: _____
Countertop: _____ Master: _____
Cabinet Base: _____ Hall: _____
Master Bath: _____ Other: _____
Countertop: _____
Cabinet Base: _____
Hall Bath: _____
Countertop: _____
Cabinet Base: _____

NOTES:

GAS COOKTOP, HOT WATER
42" UPPER CABINETS
WHIRLPOOL MAS BATH

BATHROOM TILE SELECTION:

Master Bath: _____ Color: _____ Tub Choices: _____ Pum: _____
Shower: _____ Master: _____
Shower Floor: _____ Hall: _____
Grout: _____ Bath 3: _____
Hall Bath: _____ Tub Surround: _____
Tub Surround: _____ Tile Selection: _____
Tile Selection: _____ Tile Selection: _____
Grout: _____ Tile Selection: _____

VAULTS:

* _____
* CARPET _____ VINYL/TILE _____
* _____
* _____
* _____
* _____
* _____
* _____

PAINT SELECTIONS:

Interior Wall Color: _____
Interior Trim: _____
Window Sills: ☐ Wood
☐ Flatcut Marble
☐ Hardiplank Siding Woc Sill


RANGE SELECTIONS:

Range/Color: _____
Hood/Color: _____

OPTIONAL APPLIANCES:

EXTERIOR FEATURE SELECTIONS:

Acrocrete/Main House: _____
Trim Package: _____
Trim Color: _____
Exterior Door Colors: _____
Siding: _____
Soffit: _____
Shingles: _____
Style/Color: _____
Window Color: _____
Trim Type Colonial w/Classique Doors Std.
Colonial Grills Front Windows Standard

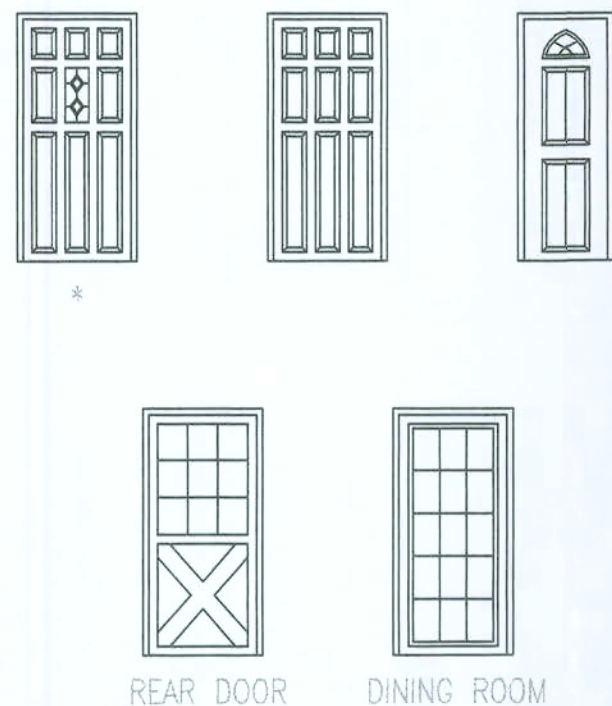

BATH WINDOWS:

Master ☒ Obscure ☐ Clear Glass
Hall ☐ Obscure ☐ Clear Glass

SUPER Energy Pac: Yes ☒ No ☐

Well Allowance Yes ☒ No ☐
Septic Allowance Yes ☒ No ☐

Extras: _____


Power Company: _____ ☐ Overhead ☐ Undergrnd

Fireplace: _____ Screenroom Color: _____

We have reviewed this plan and all notes on it. All items we have discussed with House Crc and its representatives are indicated on this "Master Copy". We understand that any additional items not on this print can be done for a \$250.00 plan change fee plus the cost of the change.

Purchaser: * _____ Date: * _____

REV.	DESCRIPTION	D/E

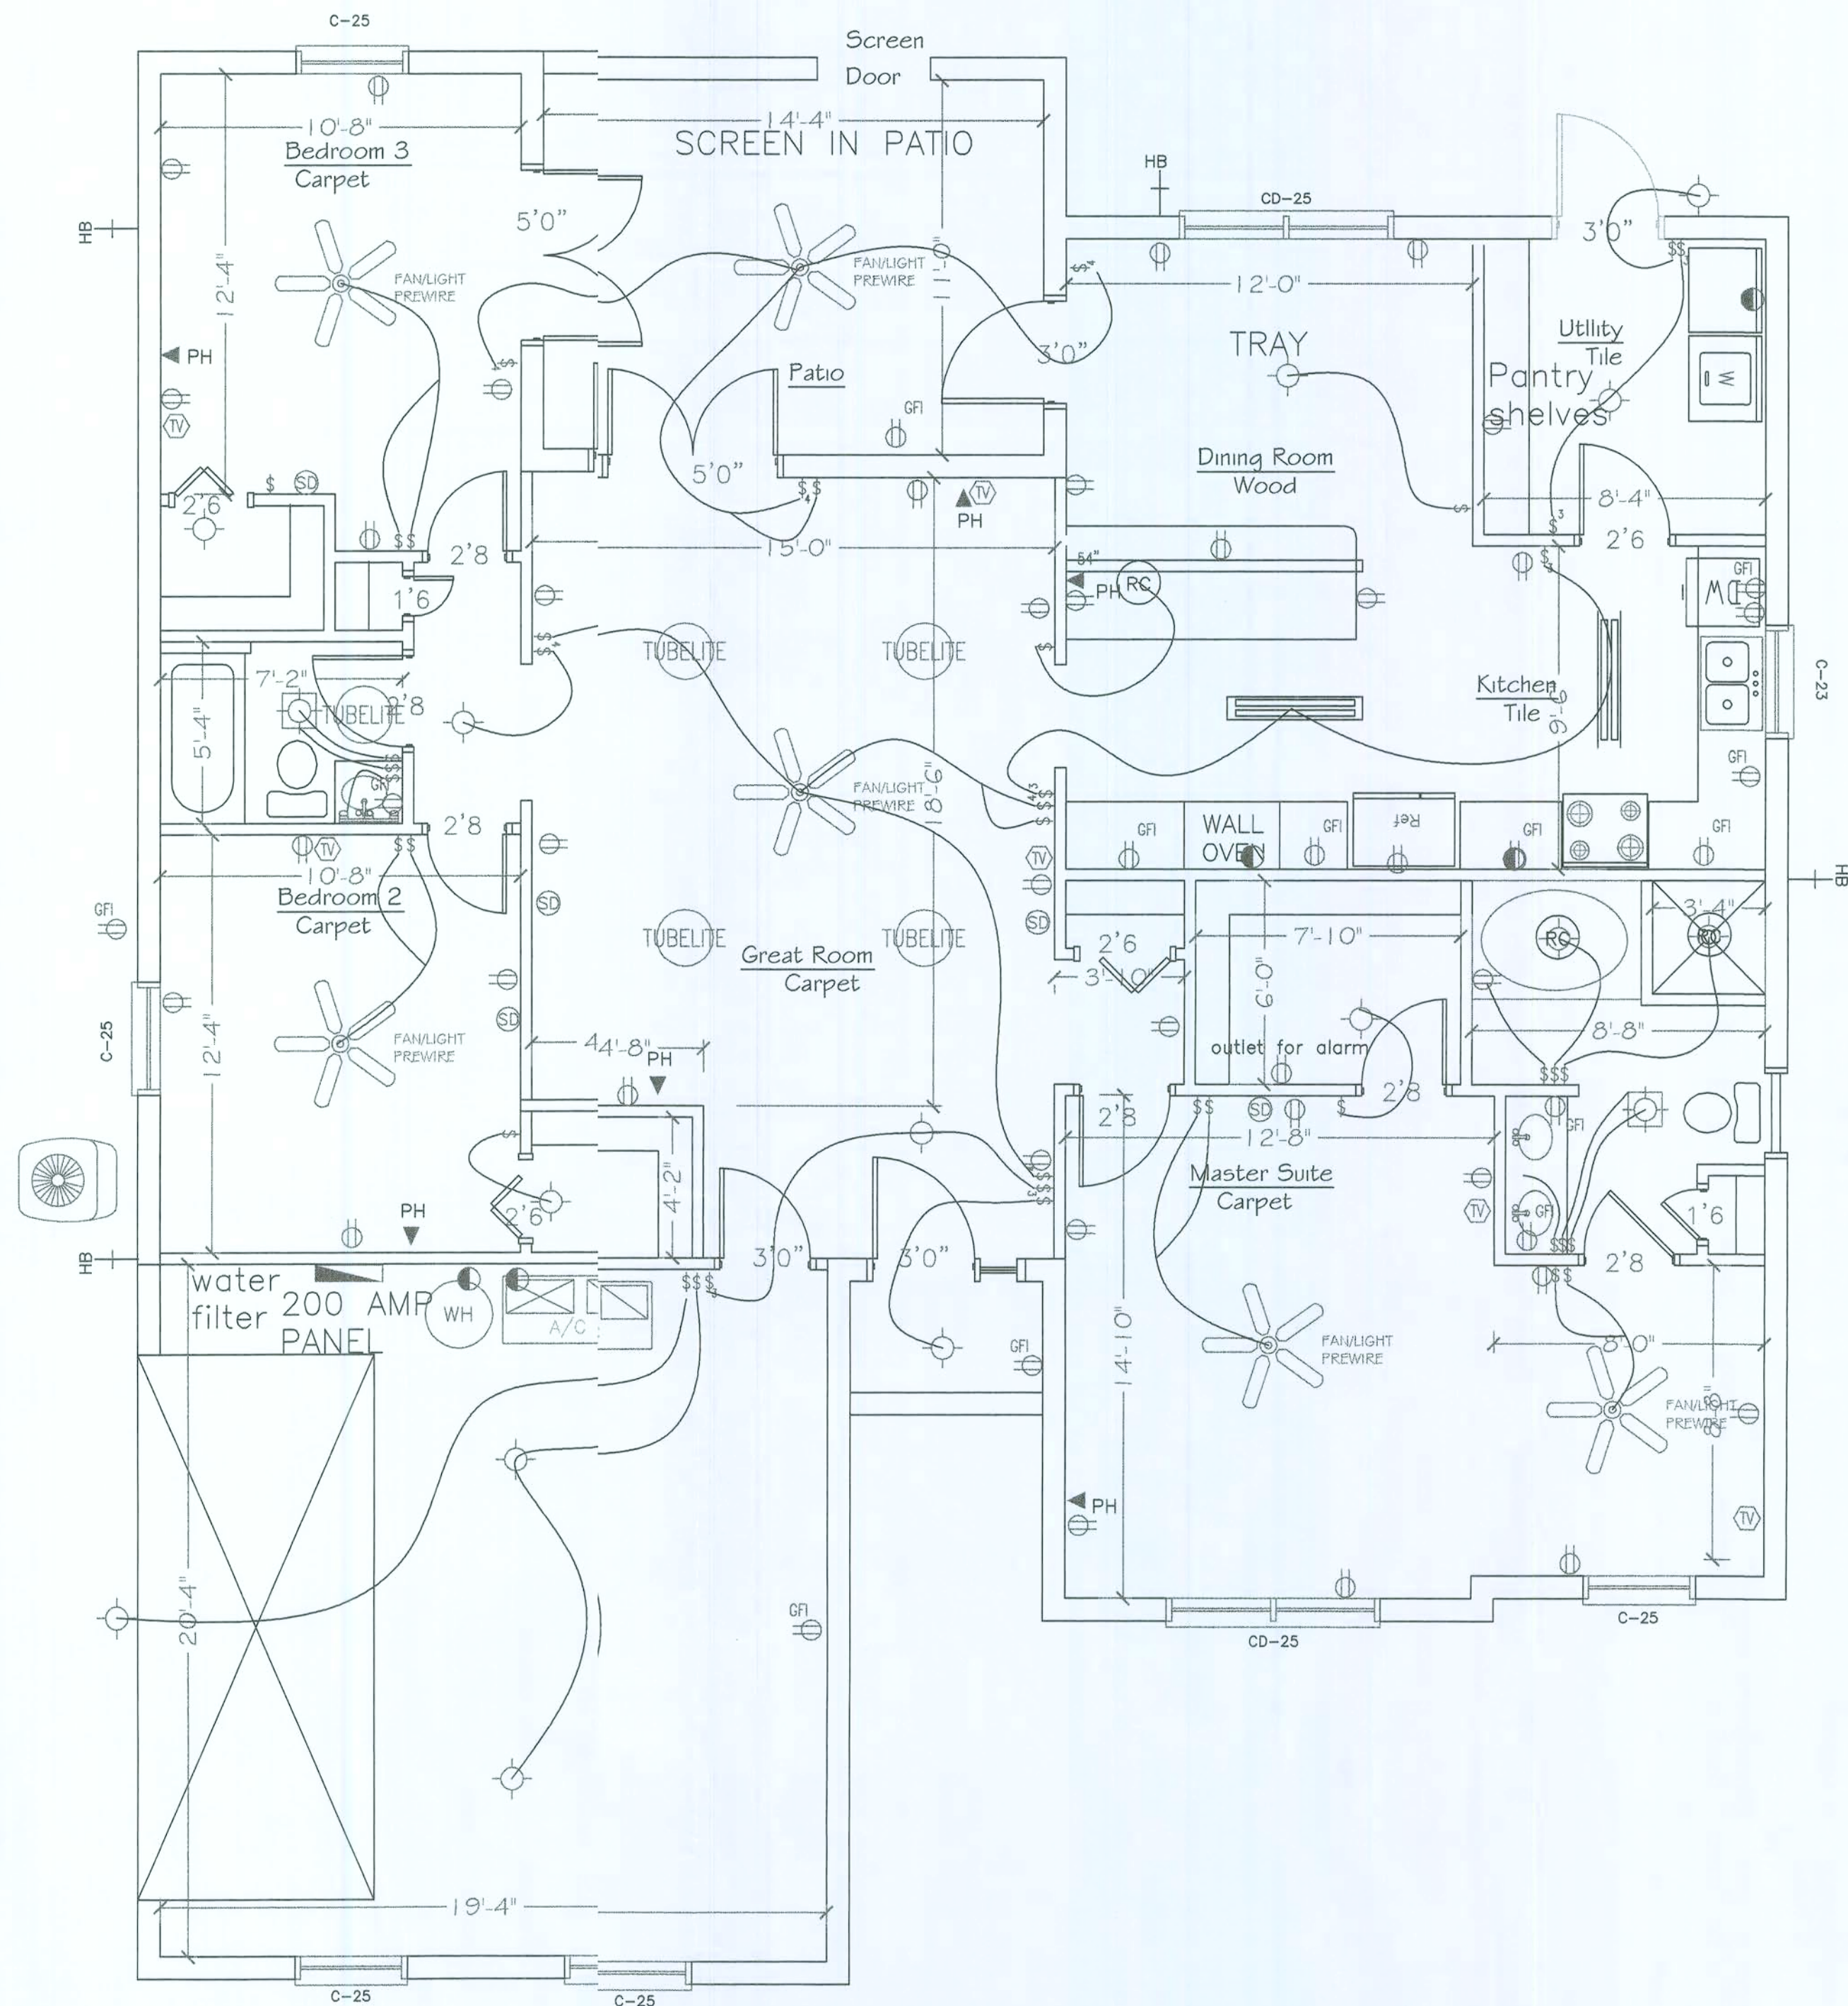

FLOOR PLAN

SCALE: 1/4"=1'-0"

LIGHTING FIXTURE SCHEDULE

FIXTURE	DESCRIPTION
	SURFACE MOUNTED INCANDESCENT FIXTURE
	PRE-WIRED CEILING FAN
	DOUBLE FLOOD LIGHT FIXTURE
	FAN LIGHT VENTED TO EXTERIOR
	SURFACE MOUNTED INCANDESCENT FIXTURE

TYPICAL SPECIAL CIRCUIT ELECTRIC SCHEDULE

TWO GFI'S CIRCUITS IN KITCHEN
ONE OR TWO GFI'S IN BATHS LOOPED TOGETHER
GFI IN GARAGE, FRONT ENTRY, AND REAR PORCH LOOPED TOGETHER
ONE GFI FOR JETTED TUB (OPTIONAL)
TWO AFCI CIRCUITS PROVIDED FOR BEDROOMS

CODE COMPLIANCE: This building is designed in compliance with the requirements of the Florida Building Code, 2007. Structural members, cladding, fasteners and systems providing for the structural integrity of the building are designed to resist gravity loads prescribed Chapter 16 and wind loads prescribed in Section 15 and wind loads prescribed in Section 1609.6 Simplified Provisions for Low Rise Building

DESIGN LOADS

a. Uniformly Distributed Live Loads		(Section 1604.1)
Floor Live Load	na	psf
b. Roof Live Loads		(Section 1604.6)
6:12 Pitch	16	psf
c. Wind Loads		(Section 1605.2)
1.) Enclosure Classification		Enclosed
2.) Basic Wind Speed (3 second gust)	110	mph
3.) Wind Importance Factor, Iw	1.0	
4.) Exposure Category	B	
5.) Internal Pressure Coefficients:	+0.18, -0.18	
6.) Design Wind Pressures for Doors and Windows		
Opening Area	Inward Pressure	Outward Pressure
(sf)	(psf)	(psf)
0-10	21.8	-29.1
11-20	20.8	-27.2
21-50	19.5	-24.6
51-100	18.5	-22.6

ELECTRICAL LEGEND

- 44" DUPLEX CONVENIENCE RECEPTACLE WITH GROUND (44" DENOTES HEIGHT A.S.F., IF OTHER THAN STD.) (GFI/GFCI DENOTES GROUND FAULT CIRCUIT INTERRUPTER) (WP DENOTES WEATHER PROOF)
- SPECIAL RECEPTACLE WITH GROUND, SEE SPECIFICATIONS
- SINGLE POLE SWITCH AT STANDARD HEIGHT
- THREE WAY SWITCH AT STANDARD HEIGHT
- TELEPHONE OUTLET
- CEILING MOUNTED EXHAUST FAN VENTED TO EXTERIOR
- CABLE TV OUTLET
- ELECTRICAL DISTRIBUTION PANEL
- SMOKE DETECTOR
- THERMOSTAT

2008 NEC.

NOTES: "UFER" Footing Steel
GROUNDING REQUIRED!

NEW ARC-FAULT PROTECTION REQUIRED



Square Footage

Living... 1,677
Garage... 433
Entry... 23
Porch... 170
Total... 2,303



HOUSE CRAFT HOMES, L.L.C.

12523 NW U.S. Hwy. 441 - Alachua, FL 32615
Phone: (386) 462-5323/FAX: (386) 462-1509

Job name: FARRIMOND
Model: CUSTOM Type: PLAN
Location: COLUMBIA COUNTY Drawn By: J.D.H.
Checked By: J.D.H. Revision Date: Date
Scale: 1/4"=1' Date: 10/20/09 Sheet: 3 of 3

