


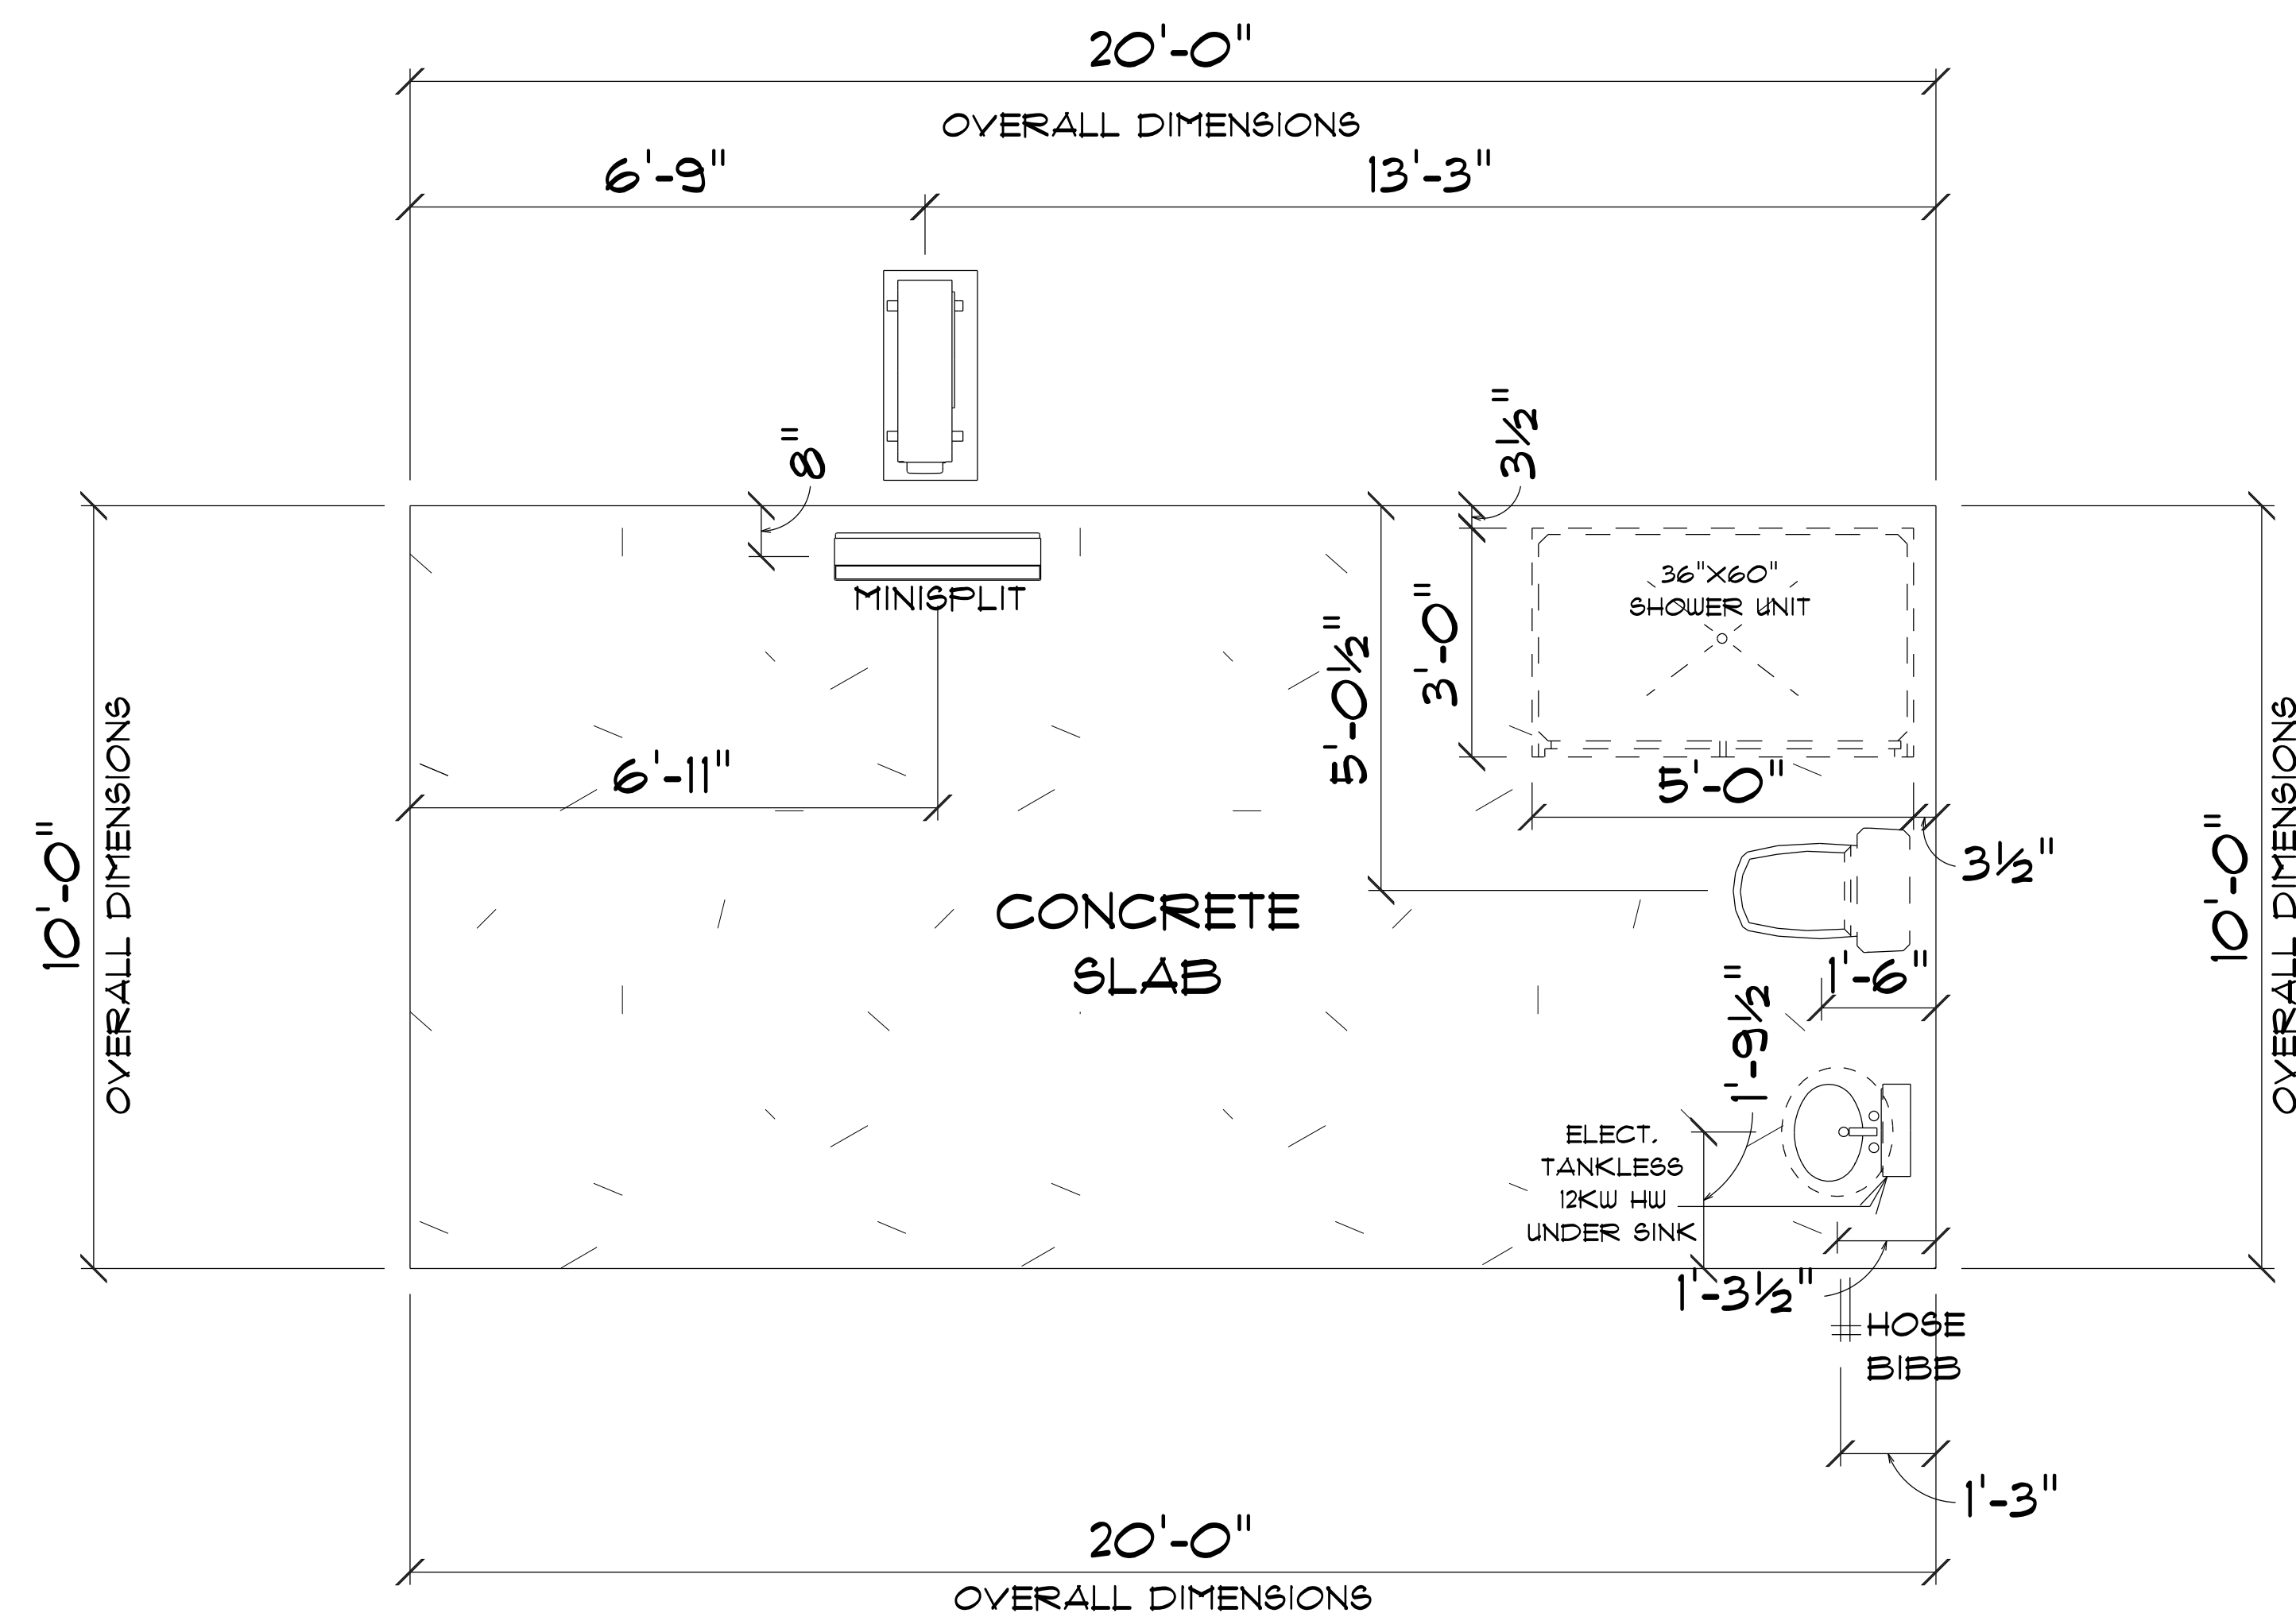

* PLUMBING & *

* CONCRETE PLAN *

SCALE: 1/2" = 1'-0"

IMPORTANT NOTE:

1. IT IS THE BUILDERS RESPONSIBILITY TO VERIFY ALL GEOMETRY AND DIMENSIONS BEFORE ORDERING ANY MATERIALS OR BEGINNING CONSTRUCTION.
2. THESE PLANS ARE FOR LAYOUT AND DESIGN PURPOSES ONLY ALL STRUCTURAL NOTES AND DETAILS TO BE PROVIDED BY AN ENGINEER.

POOL HOUSE
FOR
STEVEN & KAREN
BEALS

282 SW BREEZY DR
LAKE CITY, FL
32025

Teena M. Ruffo
2925 SW SR 47
Lake City Florida, 32025
Cell: (386) 867 - 1191
Email: teenaruffo@gmail.com

PRINTED DATE:
Wednesday, July 30, 2025

DRAWN BY: Teena and Kara CHECKED BY:


BUILDING CONTRACTOR
ZECHER CONSTRUCTION

FINAL DATE:

JOB NUMBER:

DRAWING NUMBER
A-1

OF 4 SHEETS

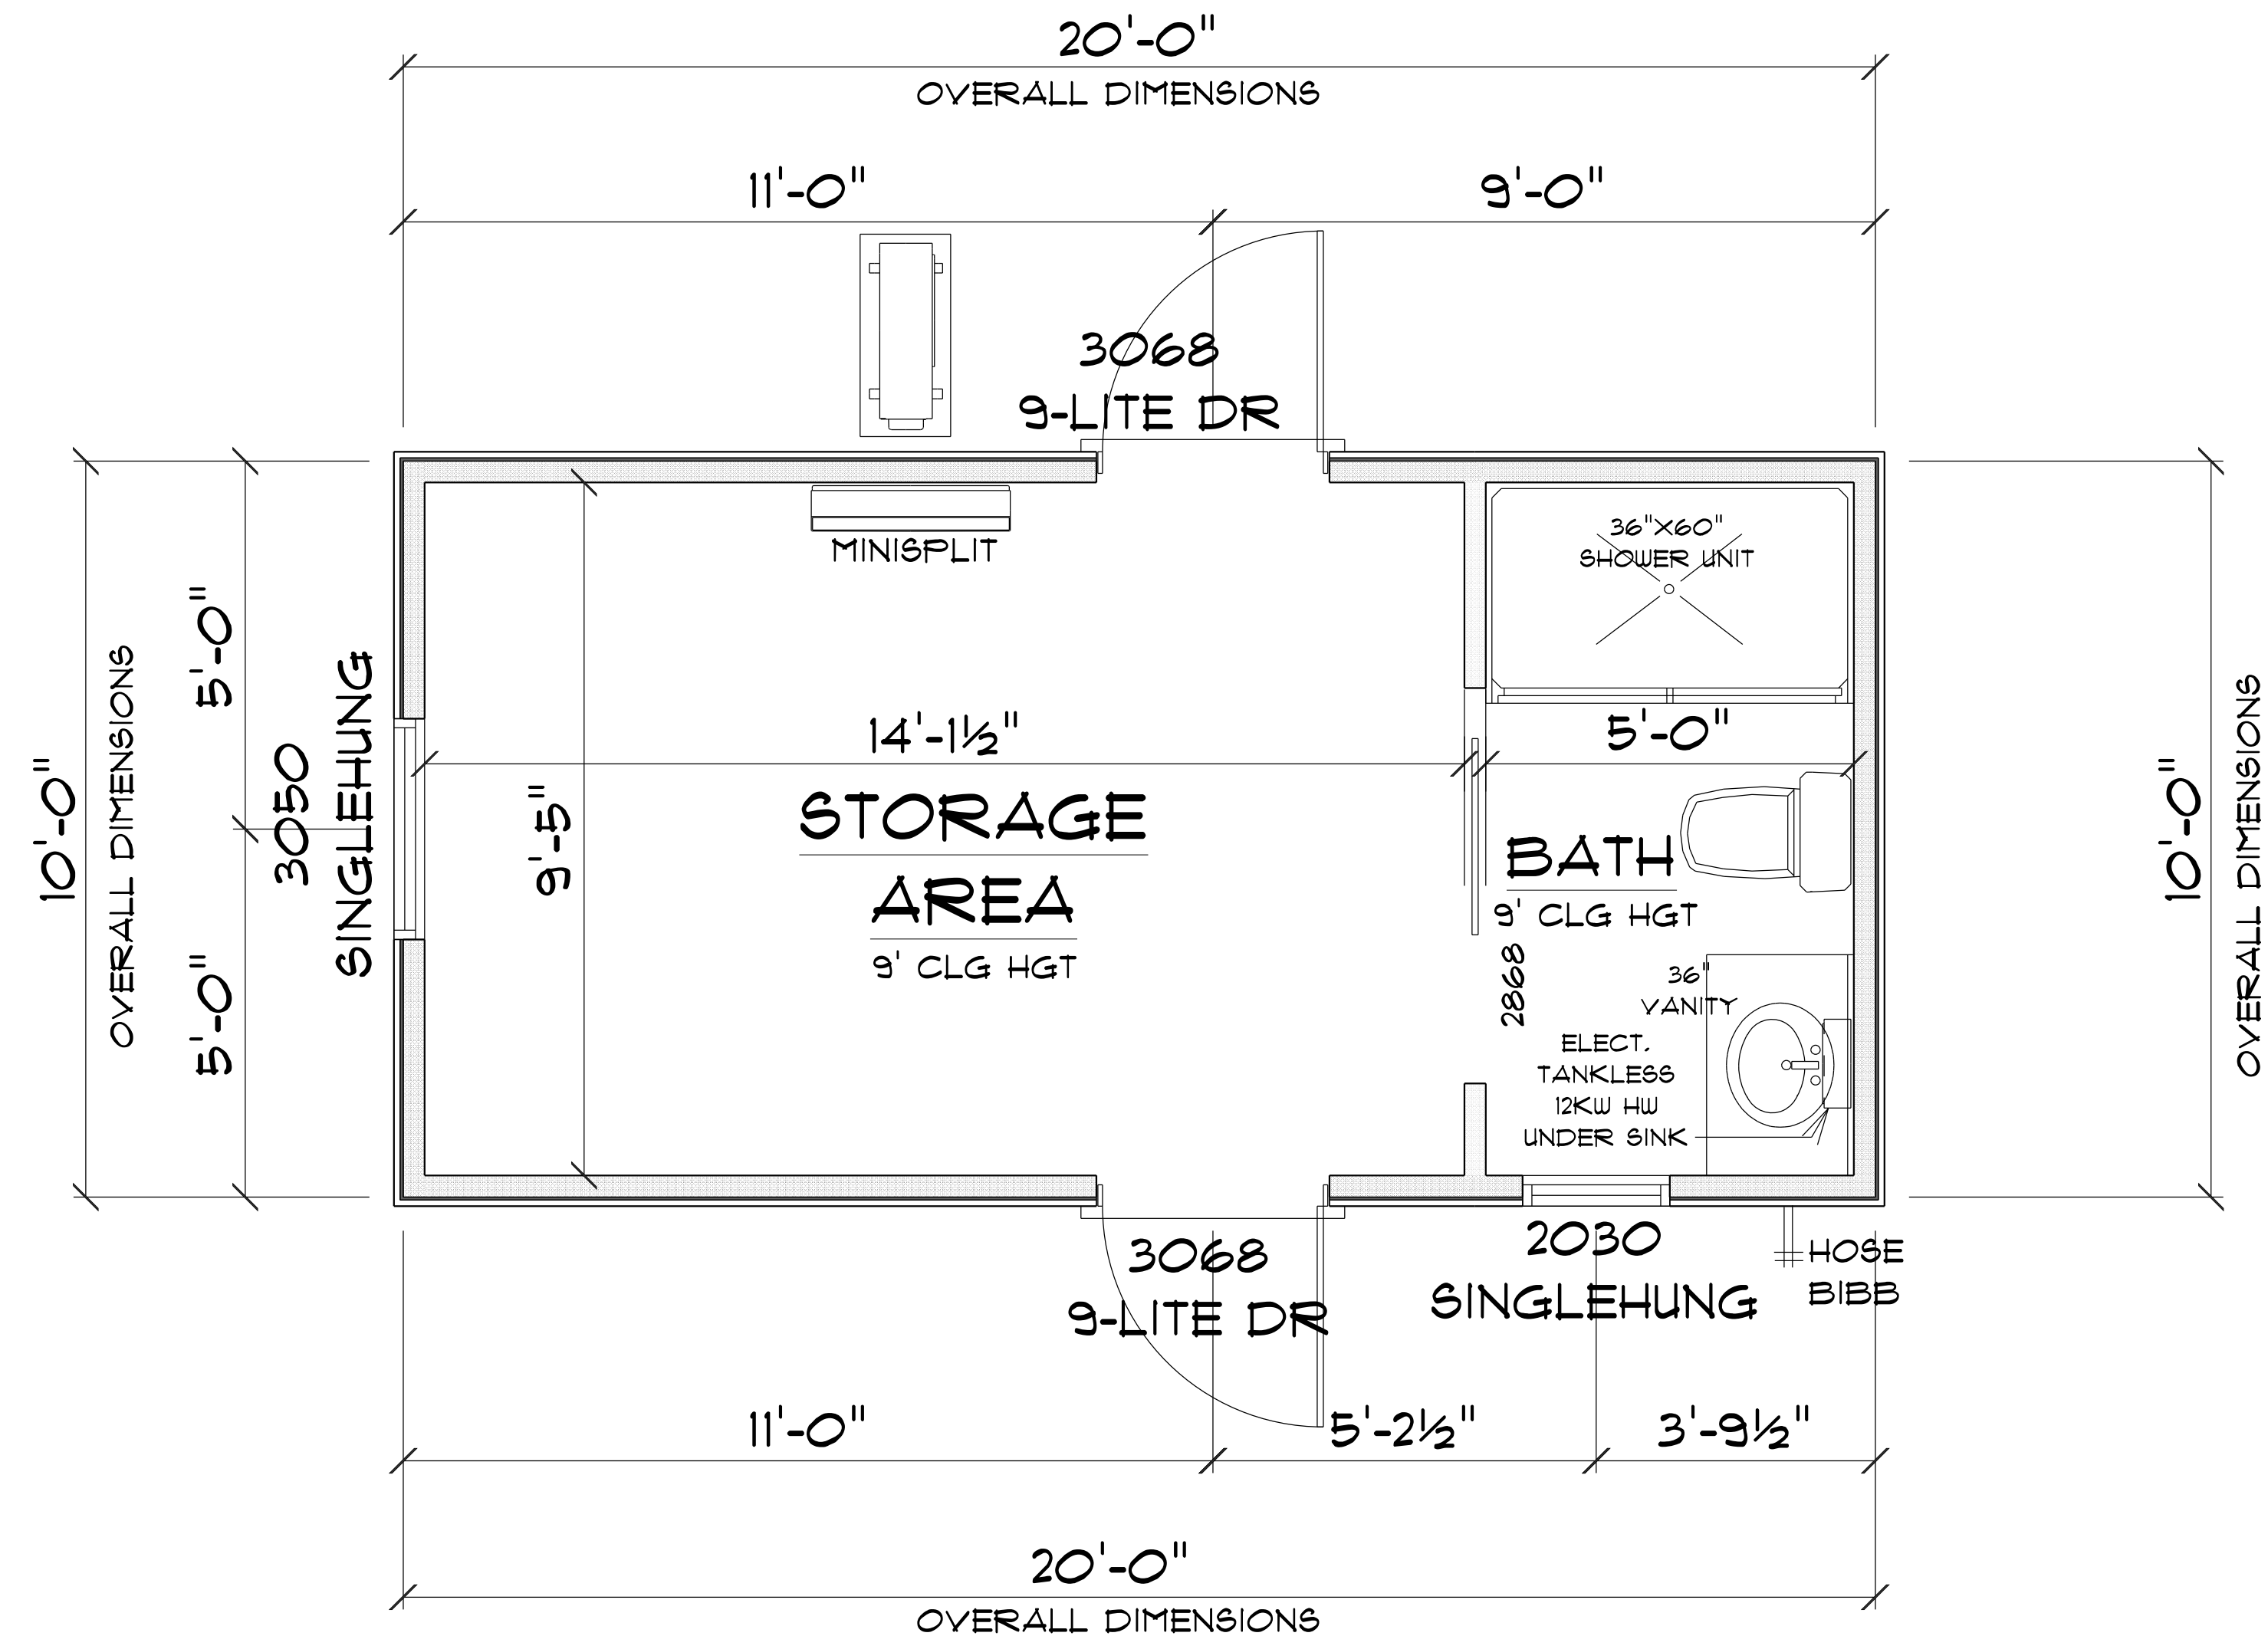

* FLOOR PLAN *

SCALE: 1/2" = 1'-0"

A/C LIVING AREA = 200 S.F.

TOTAL AREA UNDER ROOF = 200 S.F.

IMPORTANT NOTE:

1. IT IS THE BUILDERS RESPONSIBILITY TO VERIFY ALL GEOMETRY AND DIMENSIONS BEFORE ORDERING ANY MATERIALS OR BEGINNING CONSTRUCTION.
2. THESE PLANS ARE FOR LAYOUT AND DESIGN PURPOSES ONLY ALL STRUCTURAL NOTES AND DETAILS TO BE PROVIDED BY AN ENGINEER.
3. 2X4 EXTERIOR STUD WALLS 2X4 INTERIOR WALLS

POOL HOUSE
FOR
STEVEN & KAREN
BEALS

282 SW BREEZY DR
LAKE CITY, FL
32025

Teena M. Ruffo
2925 SW SR 47
Lake City Florida, 32025
Cell: (386) 867-1191
Email: teenaruffo@gmail.com

PRINTED DATE:
Wednesday, July 30, 2025

DRAWN BY: Teena and Kara CHECKED BY:

BUILDING CONTRACTOR
ZECHER CONSTRUCTION


FINALS DATE:

JOB NUMBER:

DRAWING NUMBER

A-2


OF 4 SHEETS

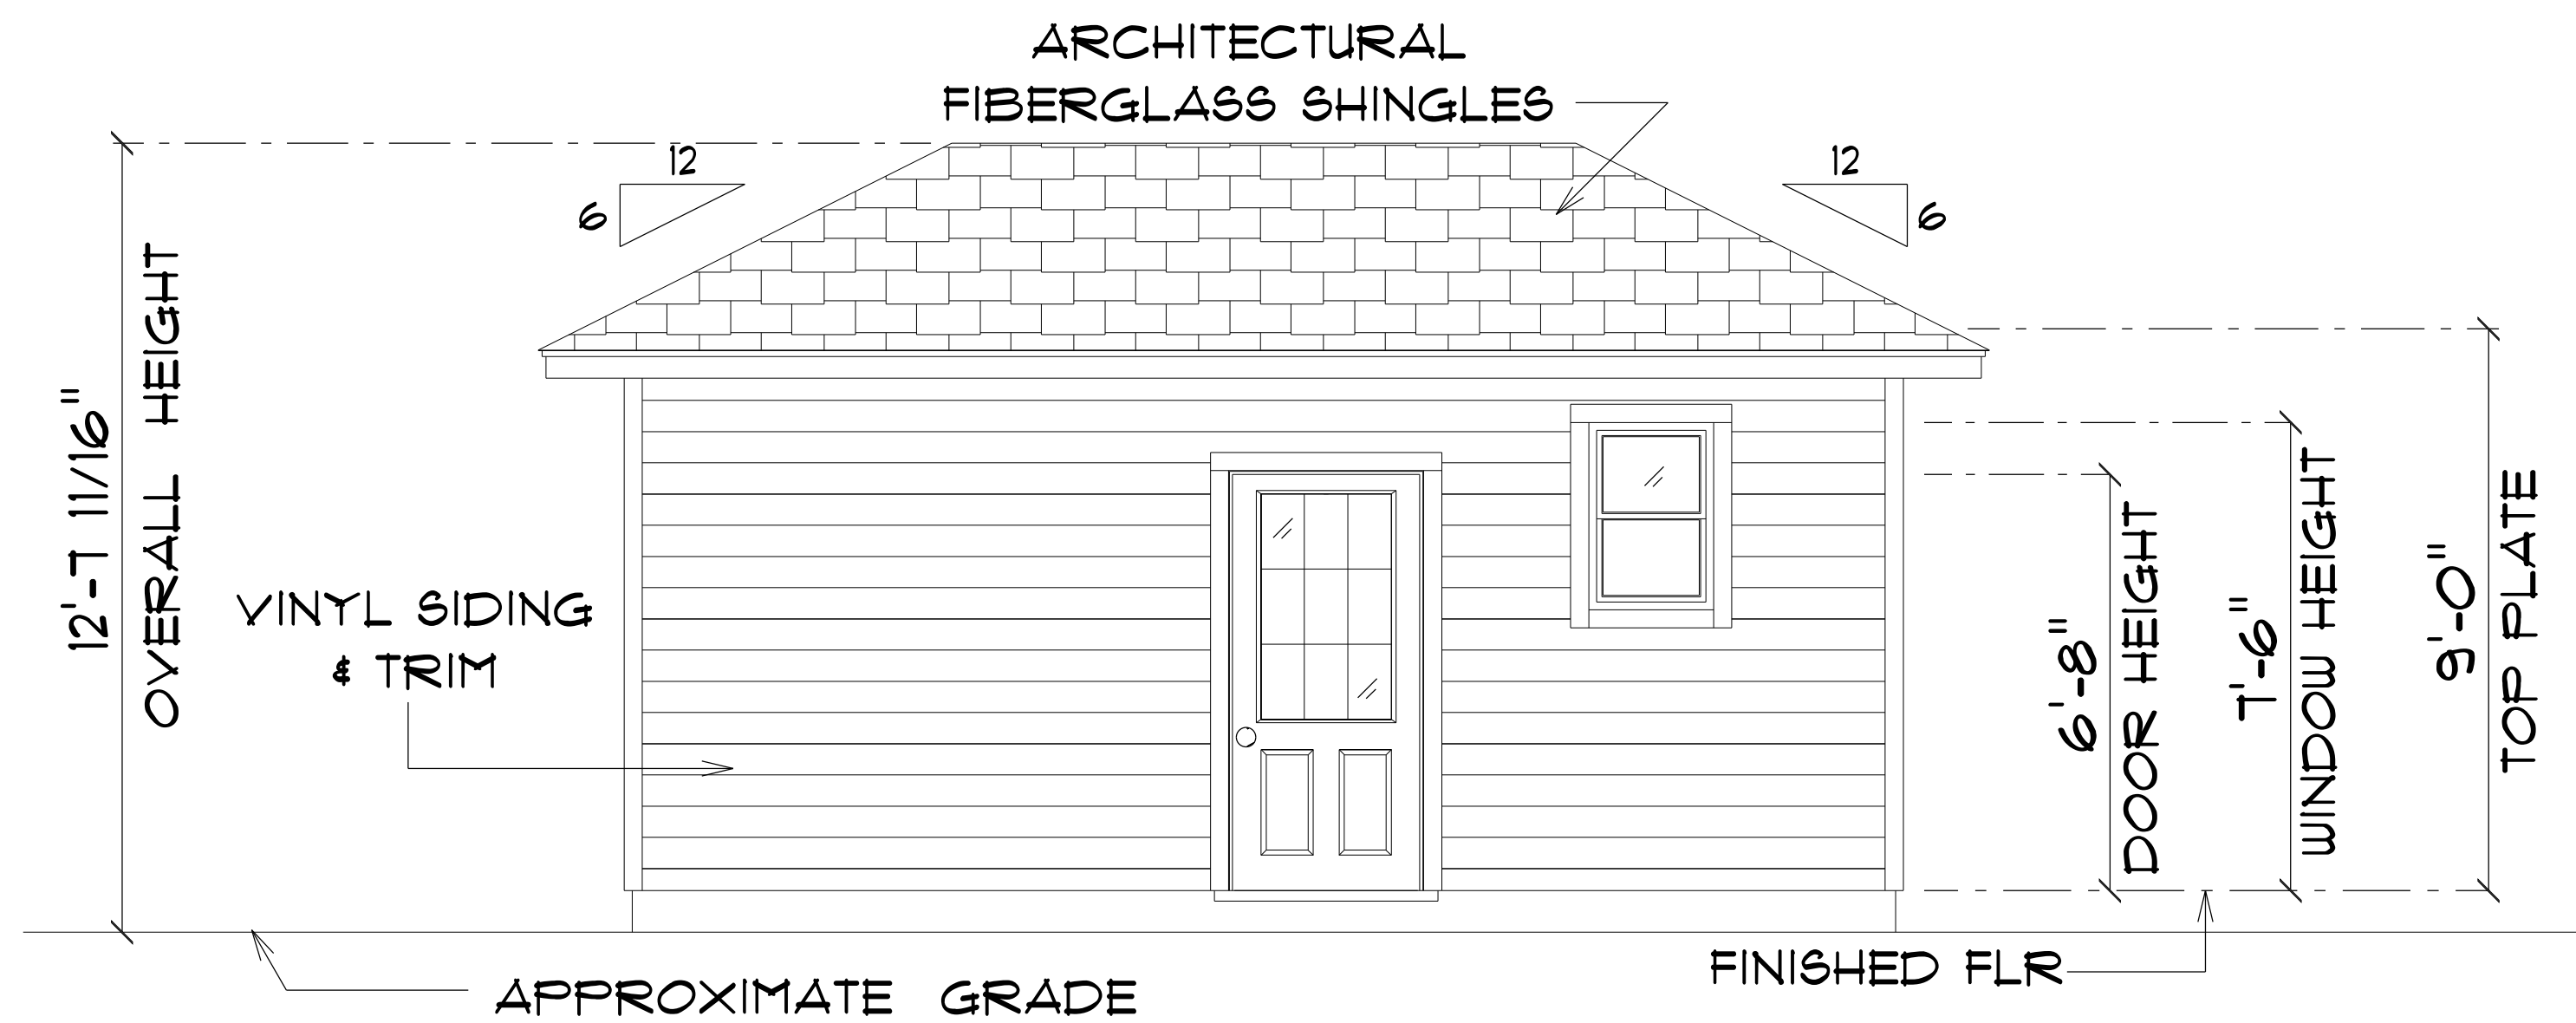

* FRONT ELEVATION *

SCALE : 3/8" = 1'-0"


NOTE: 18" OVERHANGS

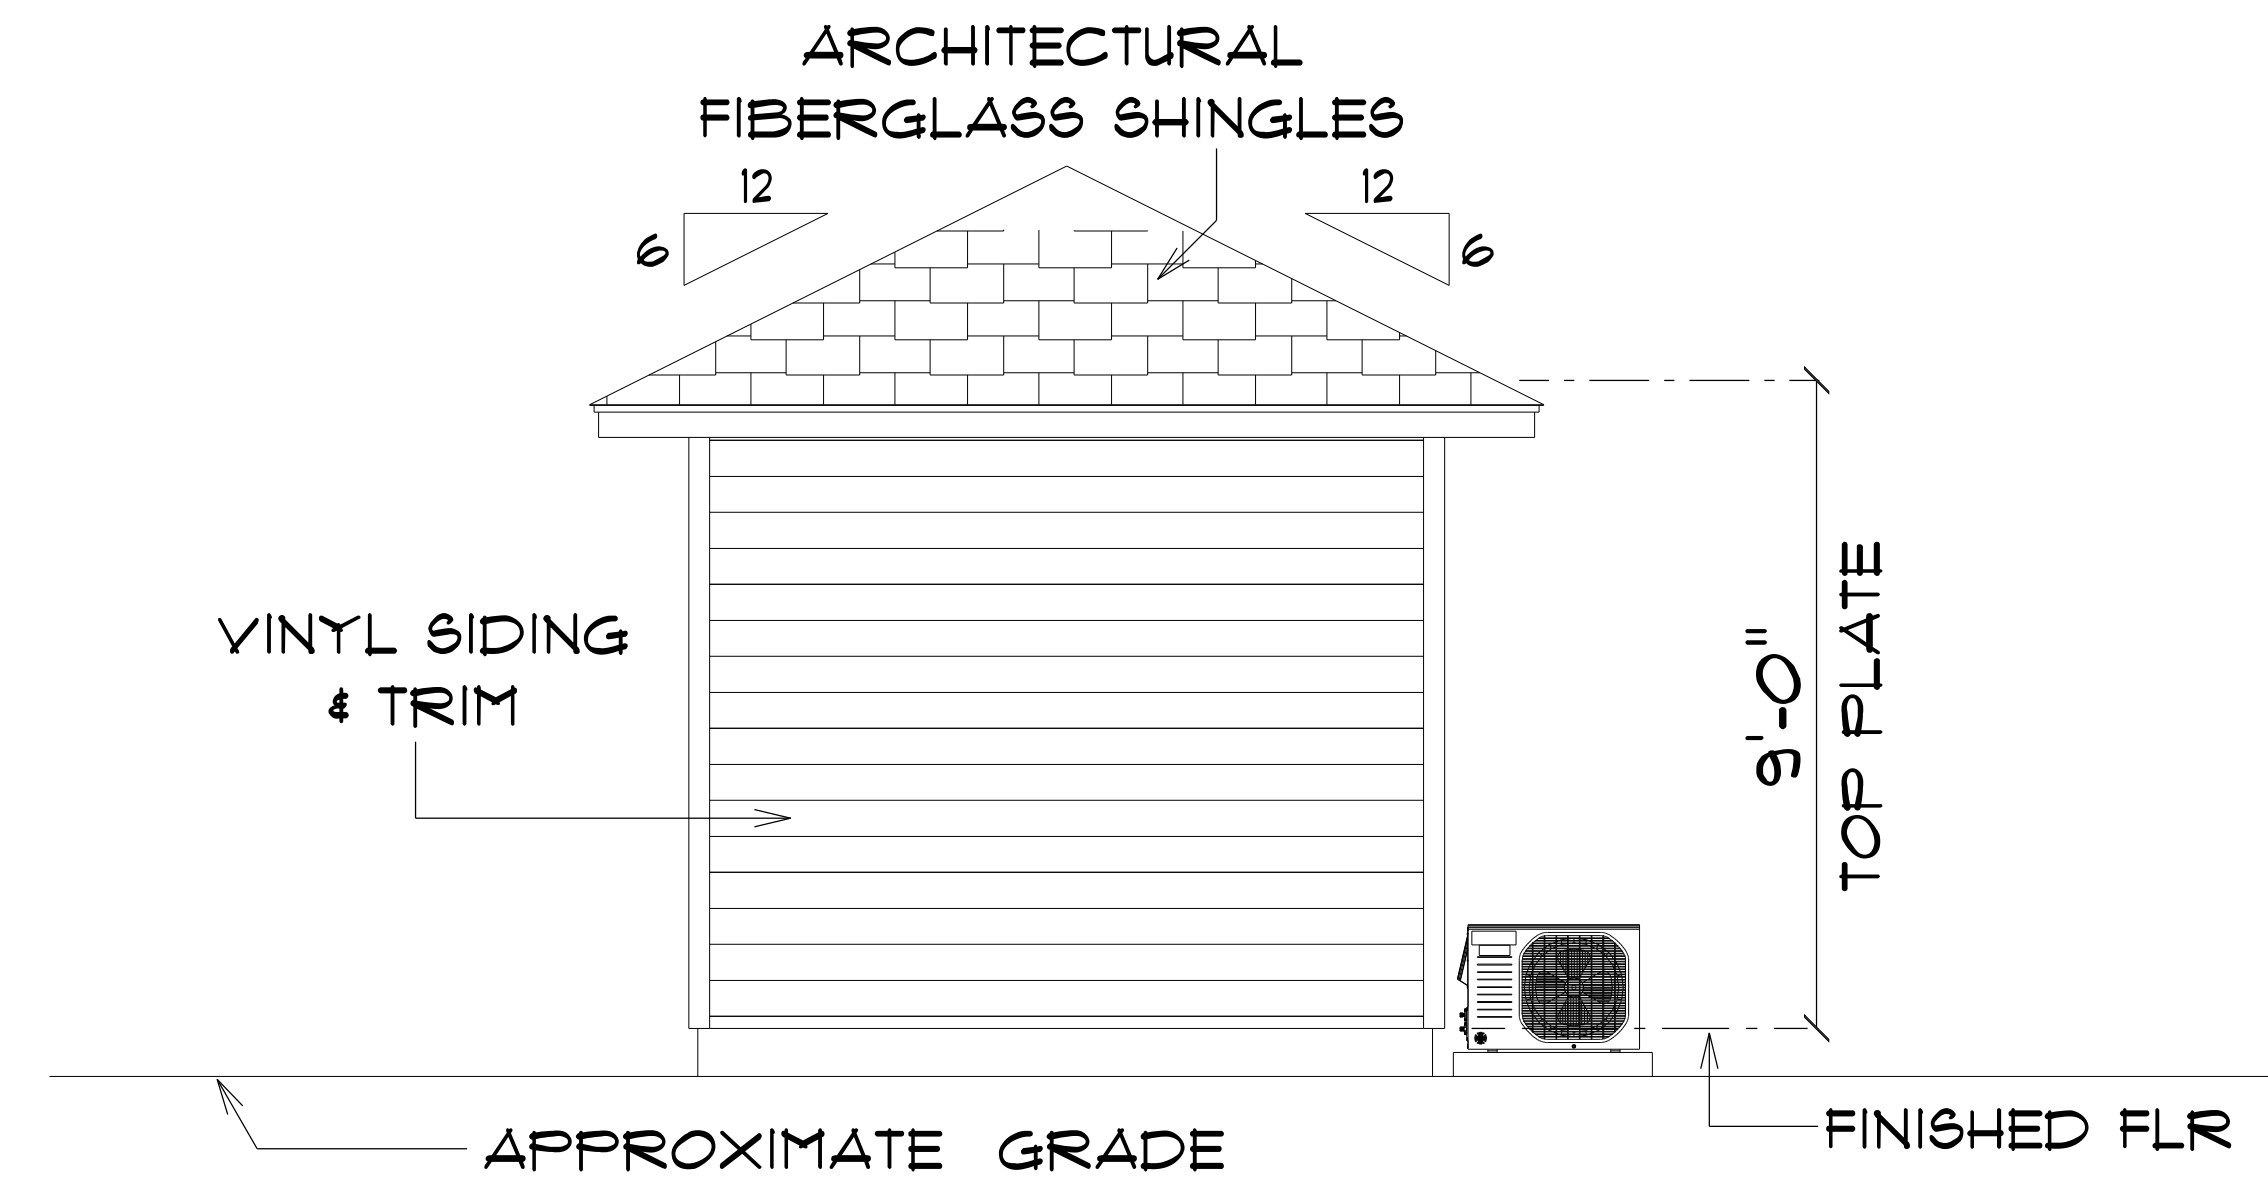

* RIGHT ELEVATION *

SCALE : 3/8" = 1'-0"


NOTE: 18" OVERHANGS

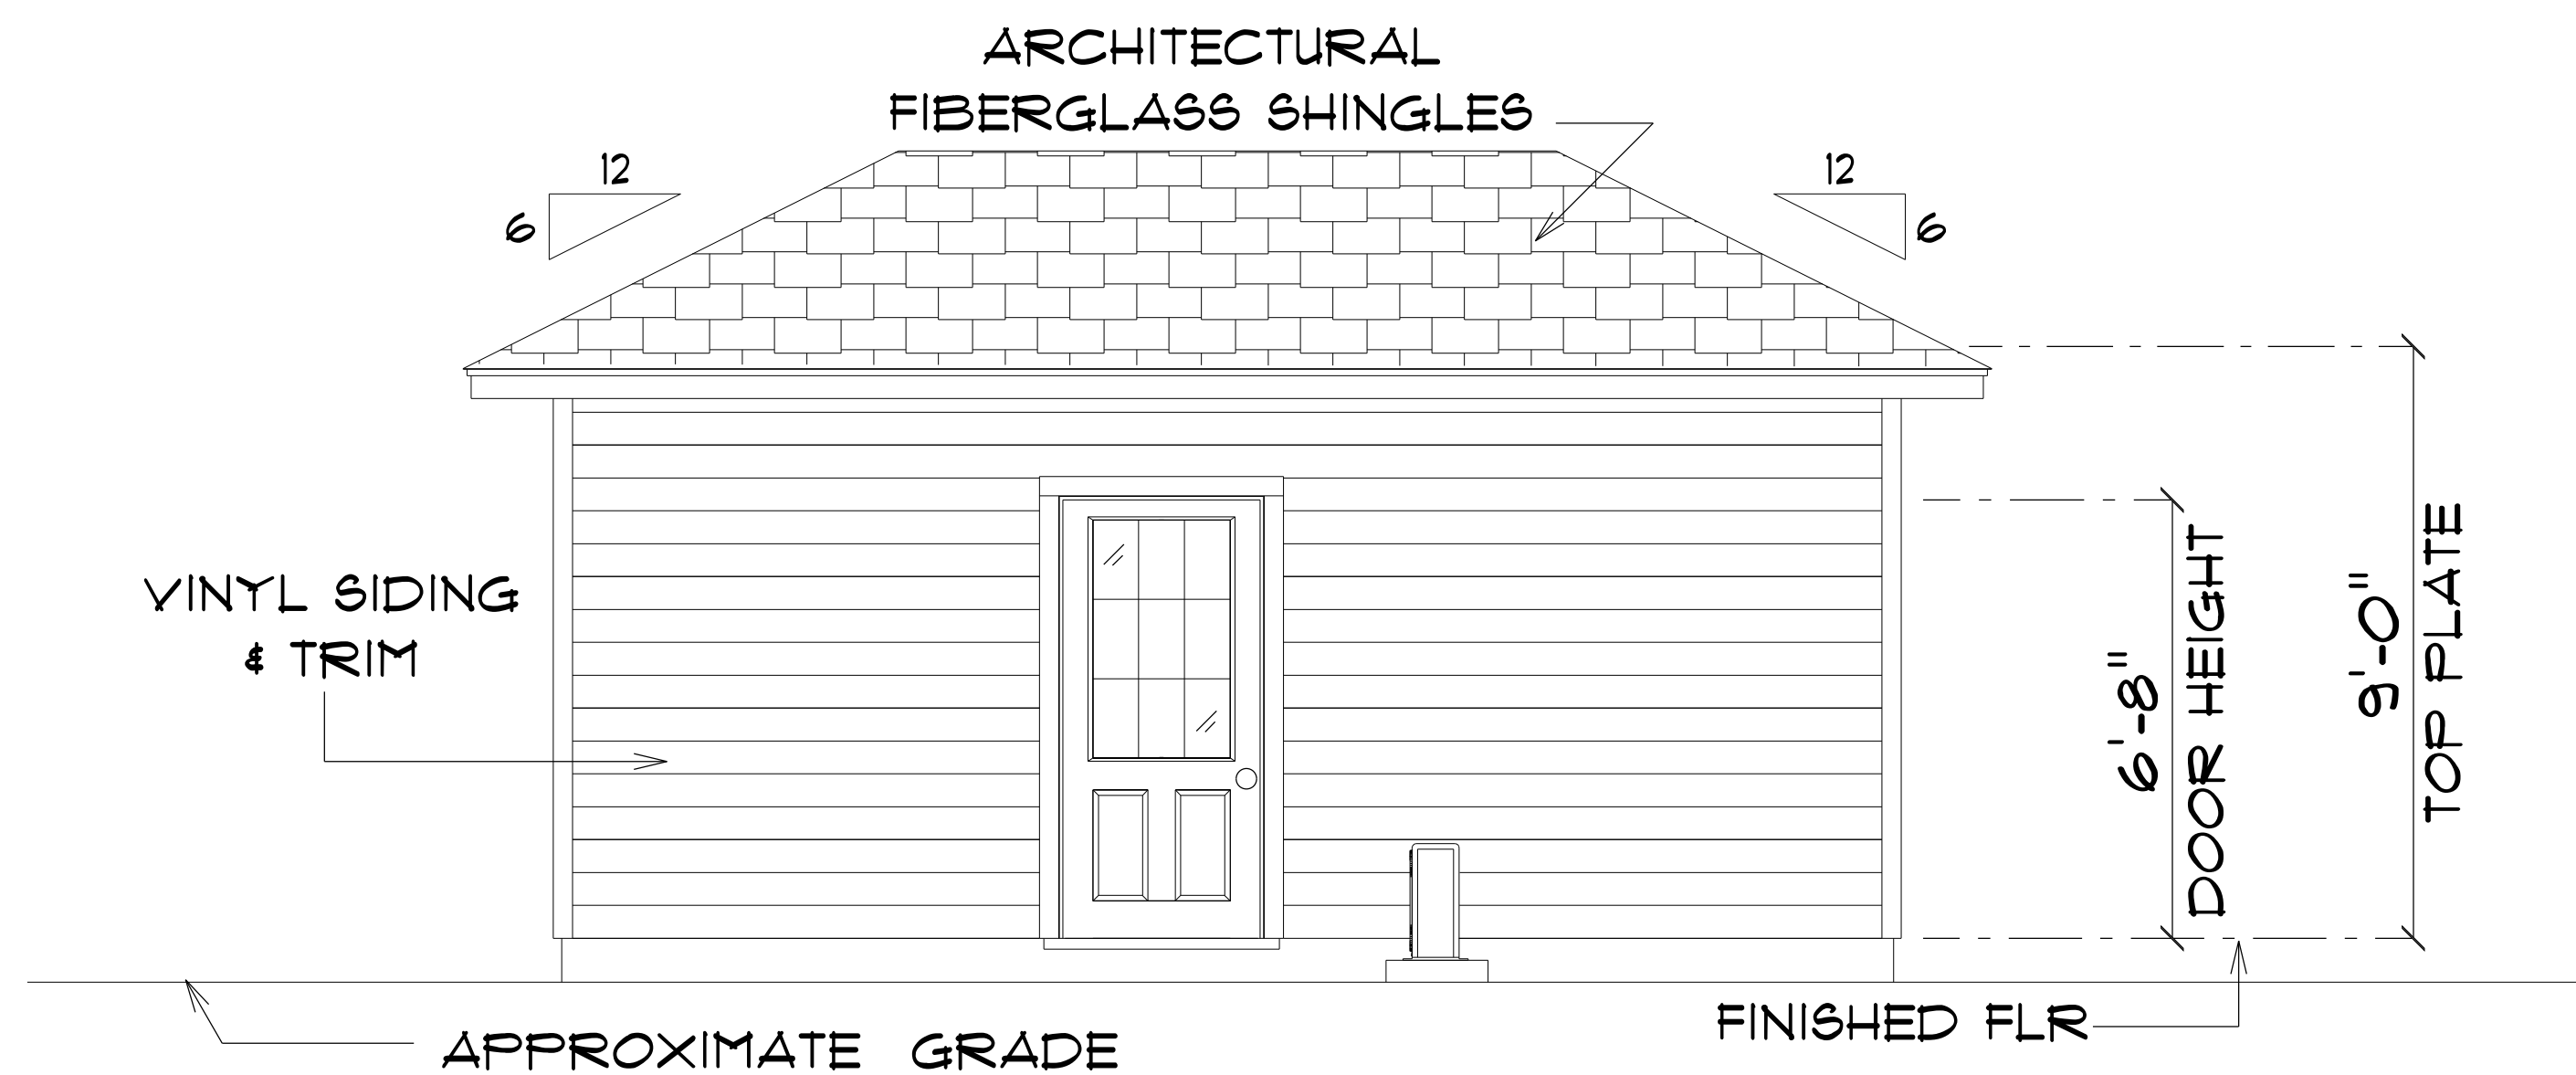

* REAR ELEVATION *

SCALE : 3/8" = 1'-0"

NOTE: 18" OVERHANGS

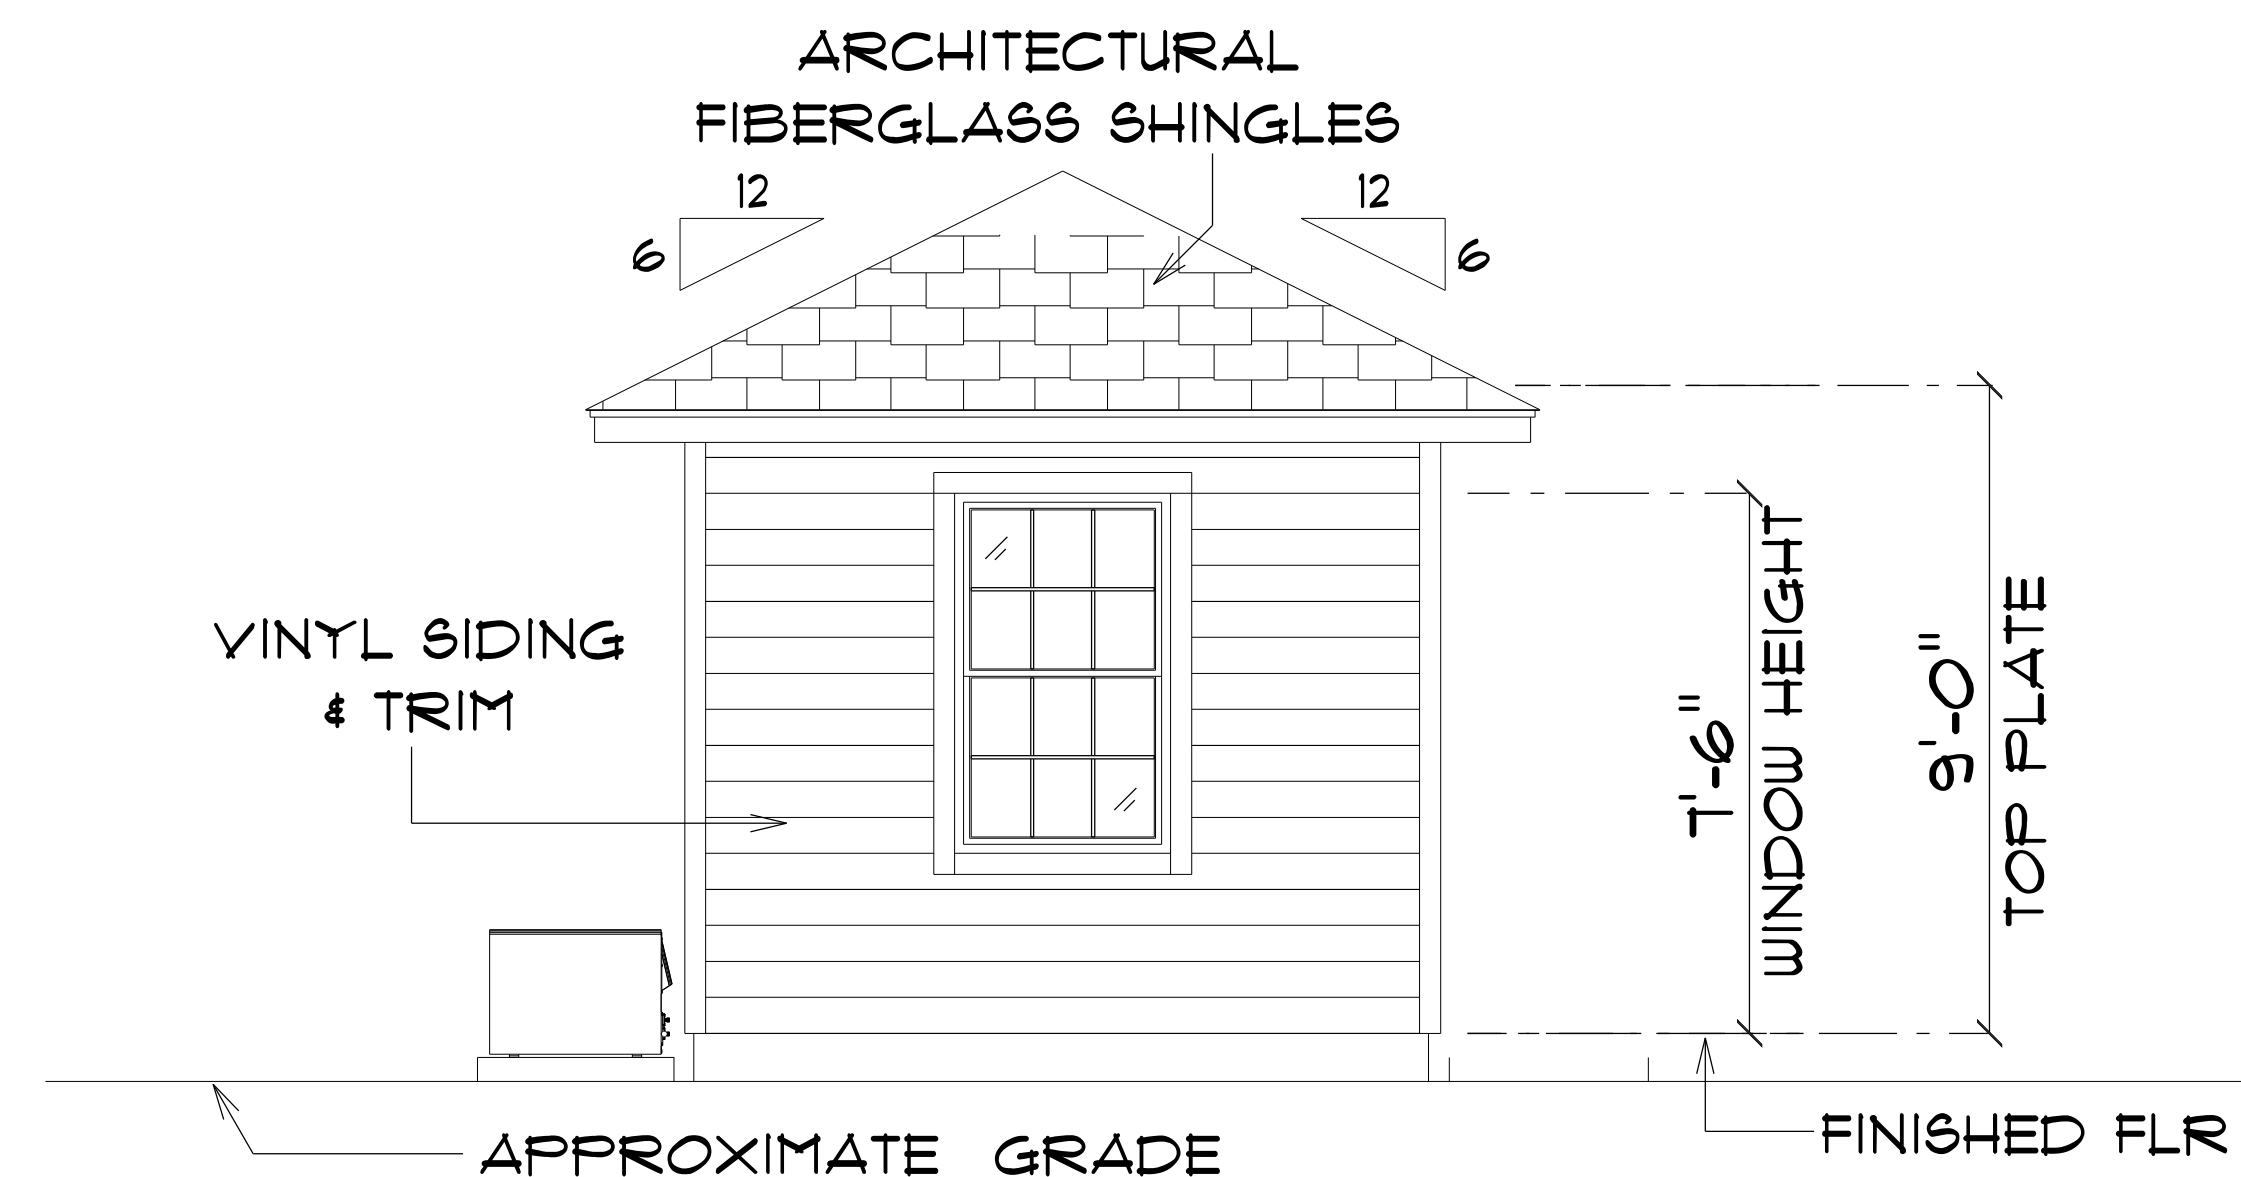

* LEFT ELEVATION *

SCALE : 3/8" = 1'-0"

NOTE: 18" OVERHANGS

POOL HOUSE
FOR
STEVEN & KAREN
BEALS

282 SW BREEZY DR
LAKE CITY, FL
32025

Teena M. Ruffo
2925 SW SR 47
Lake City Florida, 32025
Cell: (386) 867-1191
Email: teenaruffo@gmail.com

PRINTED DATE:
Wednesday, July 30, 2025

DRAWN BY: Teena and Kara

BUILDING CONTRACTOR
ZECHER CONSTRUCTION


FINAL DATE:

JOB NUMBER:

DRAWING NUMBER
A-3

OF 4 SHEETS

ELECTRICAL LEGEND		
ELECTRICAL	COUNT	SYMBOL
arts and craft exterior light	2	
ceiling fan globe Ol	1	
exhaust vent/fan	1	
light	1	
outlet	4	
outlet 220v	3	
outlet gfi	1	
outlet wp	1	
pot light	1	
switch	6	

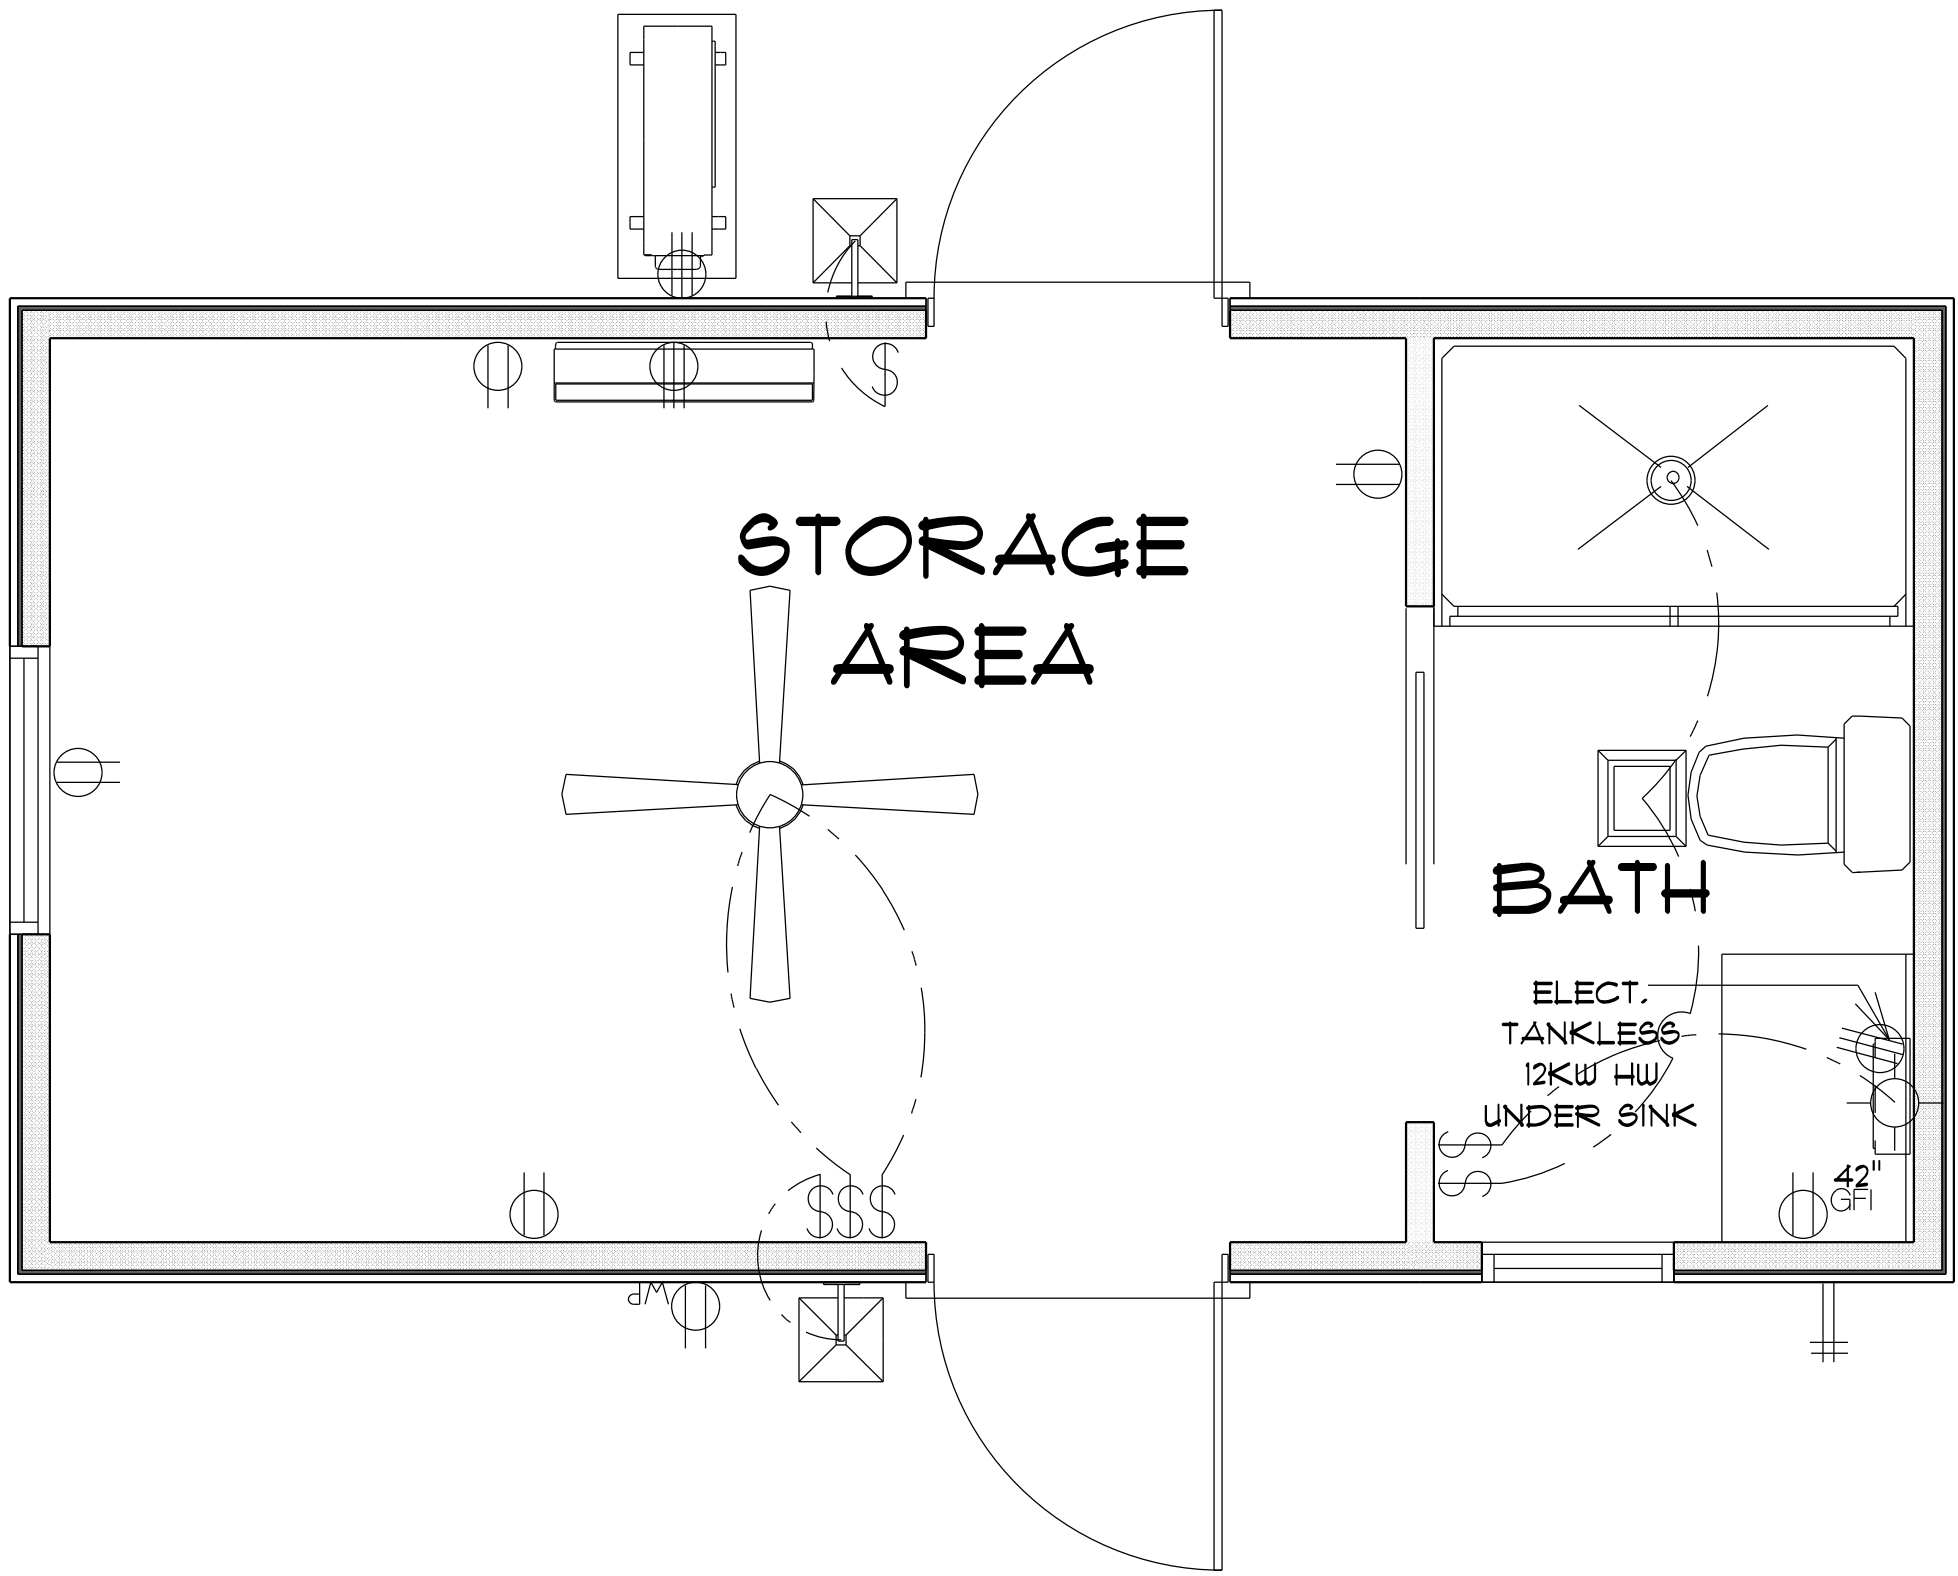

ELECTRICAL PLAN NOTES

- E-1 WIRE ALL APPLIANCES, HVAC UNITS AND OTHER EQUIPMENT PER MANUFACTORS SPECIFICATIONS.
- E-2 ALL INSTALLATIONS SHALL BE PER NATIONAL ELECTRIC CODE.
- E-3 ALL SMOKE /CARBON MONOXIDE DETECTORS SHALL BE 120V W/BATTERY BACKUP OF THE PHOTOELECTRIC TYPE, AND SHALL BE INTERLOCKED TOGETHER. INSTALL INSIDE AND NEAR ALL BEDROOMS AS PER CODE.
- E-4 TELEPHONE, TELEVISION AND OTHER LOW VOLTAGE DEVICES OR OUTLETS SHALL BE AS PER THE OWNERS DIRECTION AND IN ACCORDANCE WITH APPLICABLE SECTIONS OF NATIONAL ELCT. CODE LATEST EDITION.
- E-5 ELECTRICAL CONTRACTOR SHALL BE RESPONSIBLE FOR THE DESIGN AND SIZING OF ELECTRICAL SERVICE AND CIRCUITS.
- E-6 ENTRY OF SERVICE UNDERGROUND OR OVERHEAD) IS TO BE DETERMINED BY THE POWER COMPANY.
- E-7 ALL BEDROOM RECEPTICALS ARE TO BE AFCI (ARC FAULT CIRCUIT INTERRUPT)
- E-8 75% OF ALL PERMANENT LIGHTS TO BE ENERGY EFFECIENT.

* ELECTRICAL PLAN *

SCALE: 1/2" = 1'-0"

POOL HOUSE FOR STEVEN & KAREN BEALS	
282 SW BREEZY DR LAKE CITY, FL 32025	
Teena M. Ruffo 2925 SW SR 47 Lake City Florida, 32025 Cell: (386) 867 - 1191 Email: teenaruffo@gmail.com	
PRINTED DATE: Wednesday, July 30, 2025	
DRAWN BY: Teena and Kara	CHECKED BY:
BUILDING CONTRACTOR ZECHER CONSTRUCTION	
FINAL DATE:	
JOB NUMBER:	
DRAWING NUMBER A-4	
OF 4 SHEETS	