


ALL DRAWINGS NOT TO BE SCALED, WRITTEN DIMENSIONS TAKE PRECEDENCE OVER SCALED DIMENSIONS

Daniel Shaheen
Daniel Shaheen

January 04, 2010

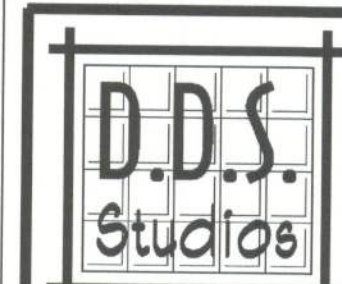

ARCHITECTURAL
DESIGN
P.O. BOX 273
LAKE CITY FL 32056
(386) 754-0181

COPYRIGHTED BY:

MARK DISOWAY, P.E.
POB 868, LAKE CITY, FL 32056
PH: (804) 754-5419
PH: (804) 754-6749
FLORIDA P.E. 59915

ENGINEERED BY:

A SPECULATIVE HOME BY EUPH INC.
THE NICOLAS
LOT 31, ROLLING MEADOWS
COPYRIGHT: 2004 DDS STUDIOS

PROJECT INFO:

ELECTRICAL PLAN
ROOF PLAN


SHEET NUMBER
3 of 36

All work shall comply with the standard building code, and all applicable local codes and ordinances.
Contractor shall verify all dimensions prior to commencing construction.

NOTE:
THIS ELECTRICAL PLAN IS A SCHEMATIC WITH SUGGESTED SWITCH, RECEPTACLE, AND LIGHT FIXTURE LOCATIONS. DUE TO VARYING LOCAL AND STATE CODES, REGULATIONS, AND STATUTES, IT IS THE RESPONSIBILITY OF THE OWNER AND/OR CONTRACTOR TO COMPLY WITH ALL LOCAL AND STATE CODES, REGULATIONS AND STATUTES.

ROOF PLAN NOTES
R-1 ALL ROOF PITCH AND UNLESS OTHERWISE NOTED
R-2 ALL OVERHANGS 8" AND 2" AT GABLES UNLESS OTHERWISE NOTED
R-3 PROVIDE ATTIC VENTILATION IN ACCORDANCE WITH CODE REQUIREMENTS
R-4 SEE EXTERIOR ELEVATIONS AND FLOOR PLANS TO VERIFY PLATE AND HILL HEIGHTS
R-5 MOVE ALL VENTS AND OTHER ROOF PENETRATIONS TO REAR

ROOF PLAN
SCALE: 1/8" = 1'

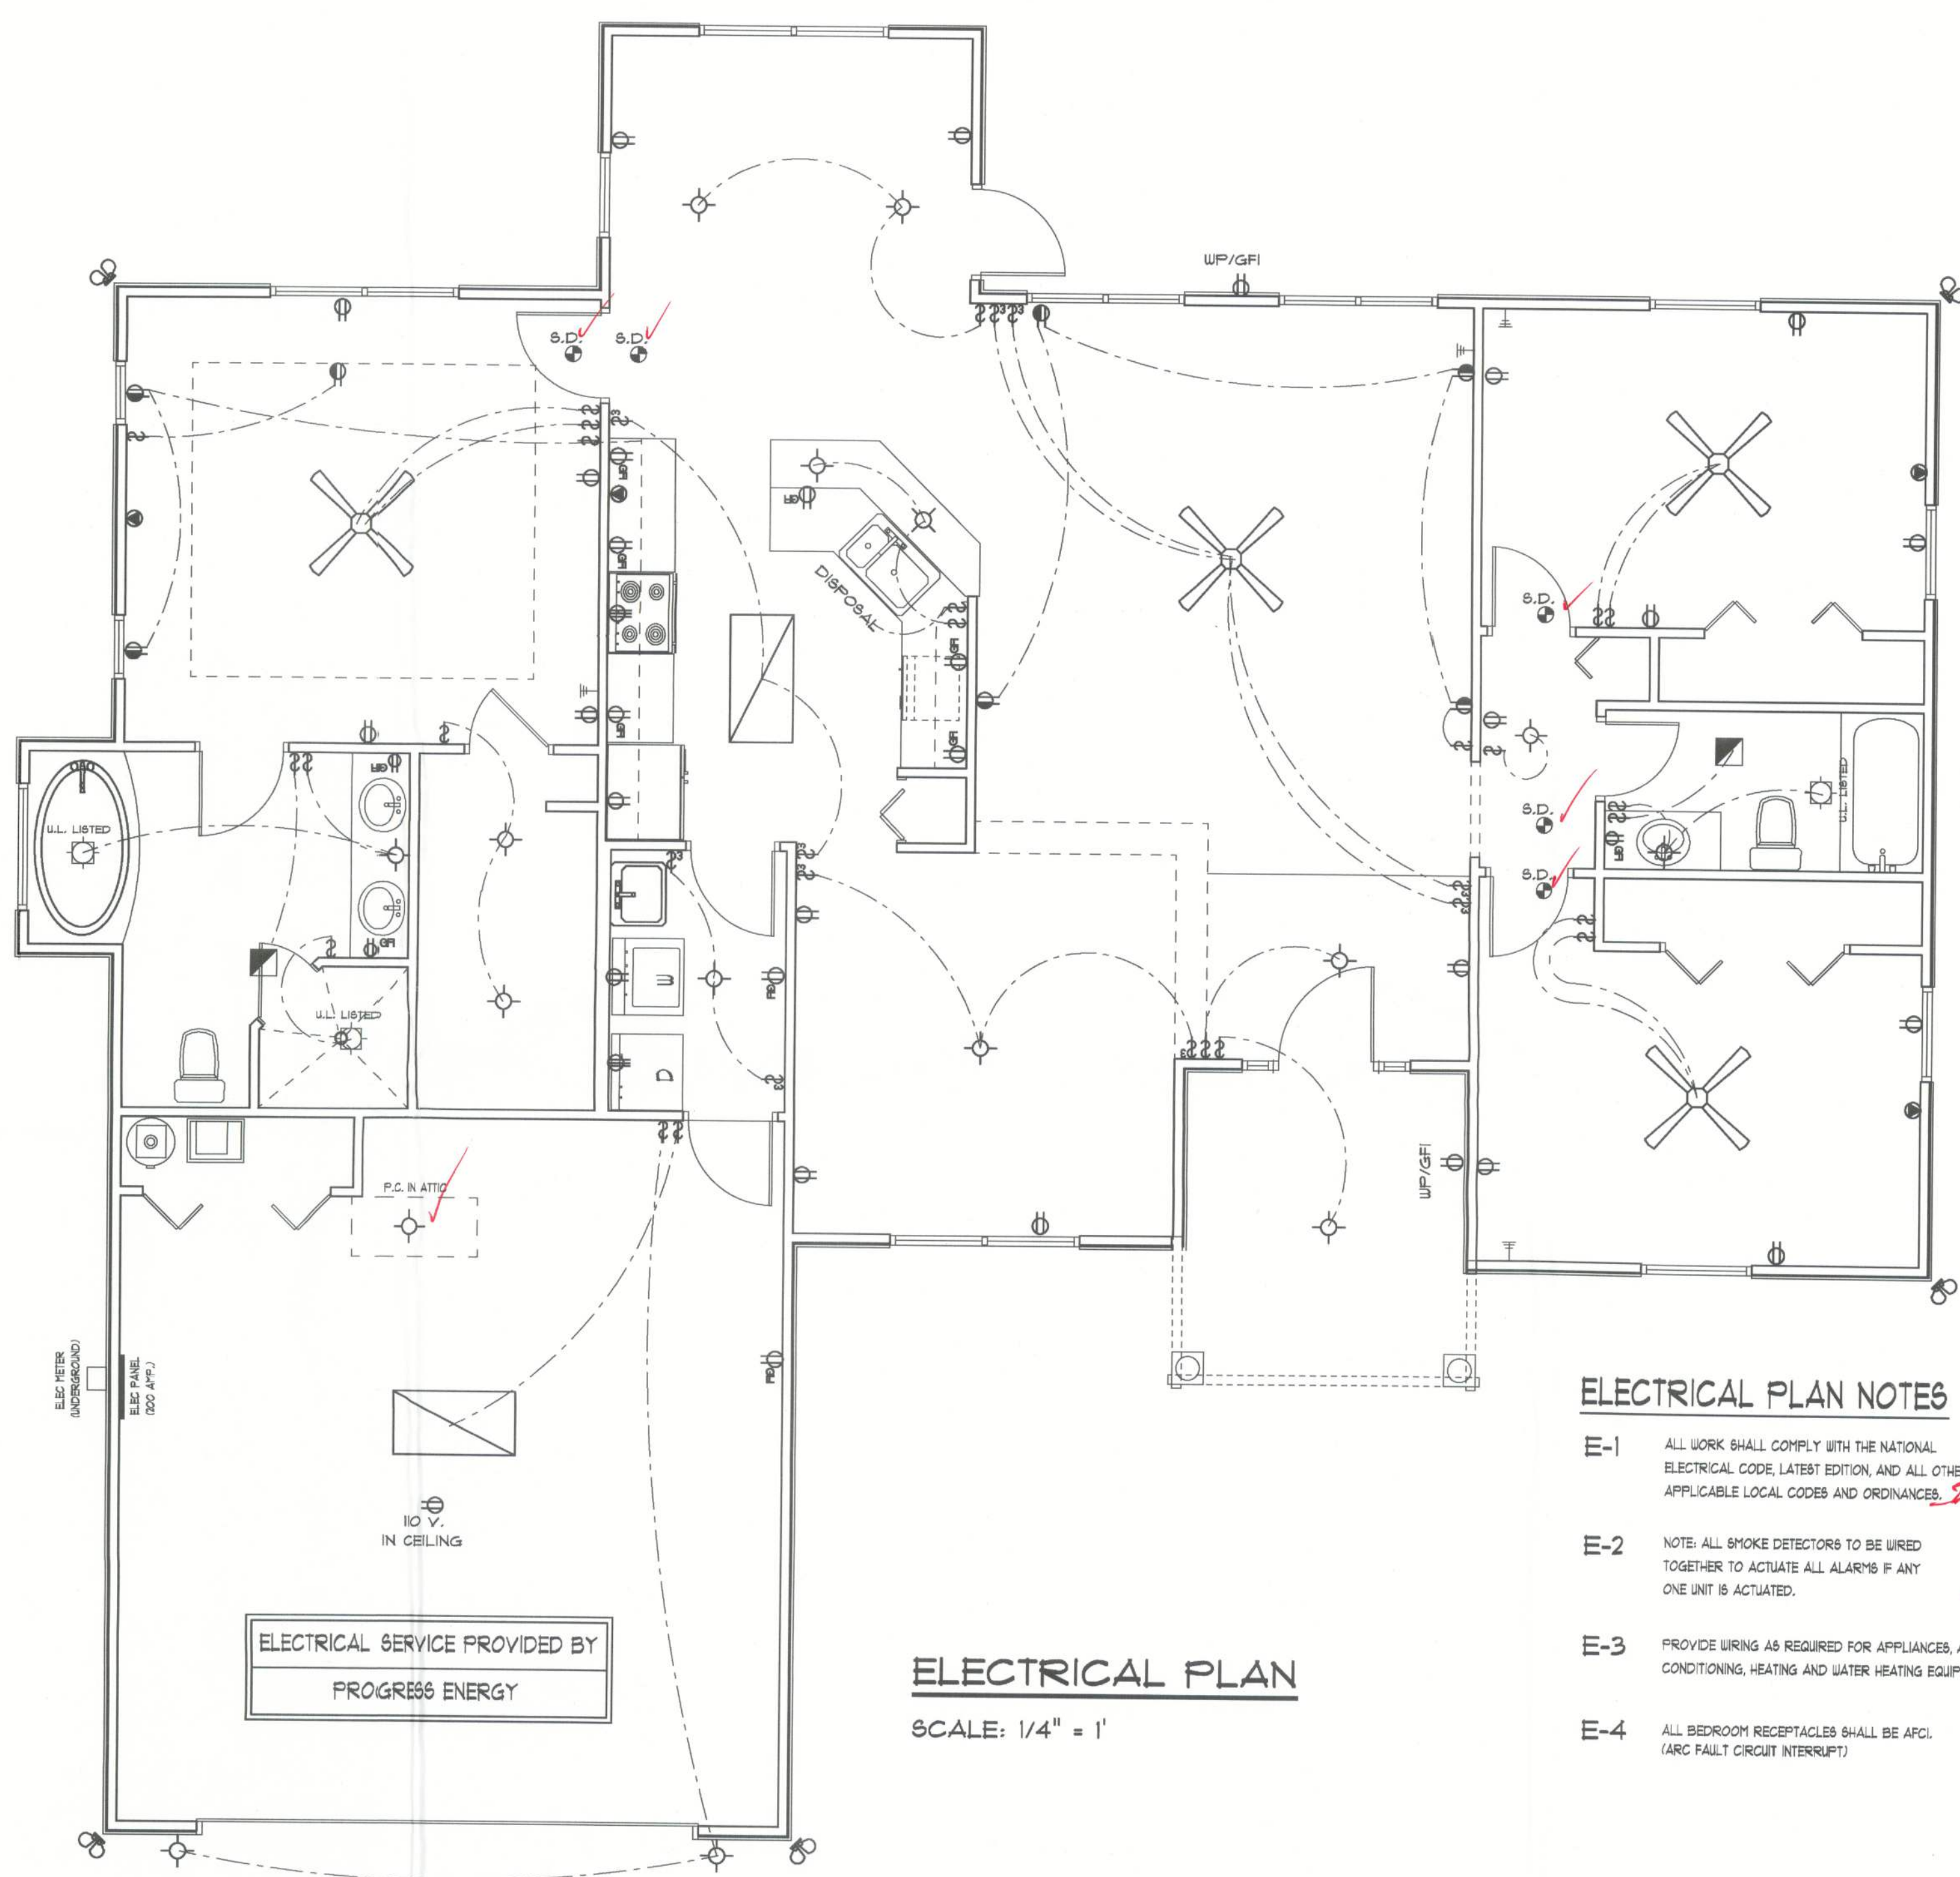

ELECTRICAL PLAN
SCALE: 1/4" = 1'

ELECTRICAL PLAN NOTES

- E-1 ALL WORK SHALL COMPLY WITH THE NATIONAL ELECTRICAL CODE, LATEST EDITION, AND ALL OTHER APPLICABLE LOCAL CODES AND ORDINANCES. *2008 - ALL NEW circuit changes apply*
- E-2 NOTE: ALL SMOKE DETECTORS TO BE WIRED TOGETHER TO ACTIVATE ALL ALARMS IF ANY ONE UNIT IS ACTIVATED. *- "VFC" Grounding system Req'd*
- E-3 PROVIDE WIRING AS REQUIRED FOR APPLIANCES, AIR CONDITIONING, HEATING AND WATER HEATING EQUIPMENT. *- Temp. Roof Req'd*
- E-4 ALL BEDROOM RECEPTACLES SHALL BE AFCI. (ARC FAULT CIRCUIT INTERRUPT) *- Combo Arc-Fault Req'd as Per 2008 N.E.C.*