


Electrical Plan Notes:

- E-1 Wire all appliances, HVAC units and other equipment per manufactures specifications.
- E-2 Consult the owner for the number or seprate telephone lines to be installed. Owner : responsible for all overages not notedn plan.
- E-3 All installations shall be per national cde 2008.
- E-4 All smoke detectors shall be 120v withbattery back-up of the photoelectric type, aneshall be interlocked together. Install inside andnear all bedrooms.
- E-5 Telephone, television and other low vdtage devices or outlets shall be as per the wires directions and in accordance with appliable sections of the National Electric Code latest edition. Owner is responsible for all ovrages not noted on plan.
- E-6 Electrical contractor shall be responsible for the design and sizing of electrical serce and circuits.
- E-7 Entry of service (underground or overhead) to be determined by contractor agreement.
- E-8 All outlets located in residential to be tamper-resistant per NEC.
- E-9 All outlets to be located above base load elevation.
- E-10 All exterior GFI outlets shall be weatherproof.
- E-11 Overcurrent Protection device shall b installed on the exterior of structures c the load side of the meter to serve as a disconnecting means. Conductors used from the exterior disconnecting means to a pnel or sub panel shall have four-wire conducto, of which one conductor shall be used as e equipment ground.
- E-12 All 120-VOLT, single phase, 15 and 20 amere branch circuits supplying outlets installed in dwelling unit family rooms,dining rooms, living rocs, parlors, libraries, dens, bedrooms, sun rooms, recsation rooms, closets, hallways, or similar rooms or arez shall be protected by a listed arc-fault circuit interrupter, combination-type installed to provide ptection of the branch circuit.
- E-13 Carbon Monoxide alarms shall be requird within 10' of all rooms for sleeping purposes in bldings having a fossil-fuel burning heater or appliances fireplace or attached garage.

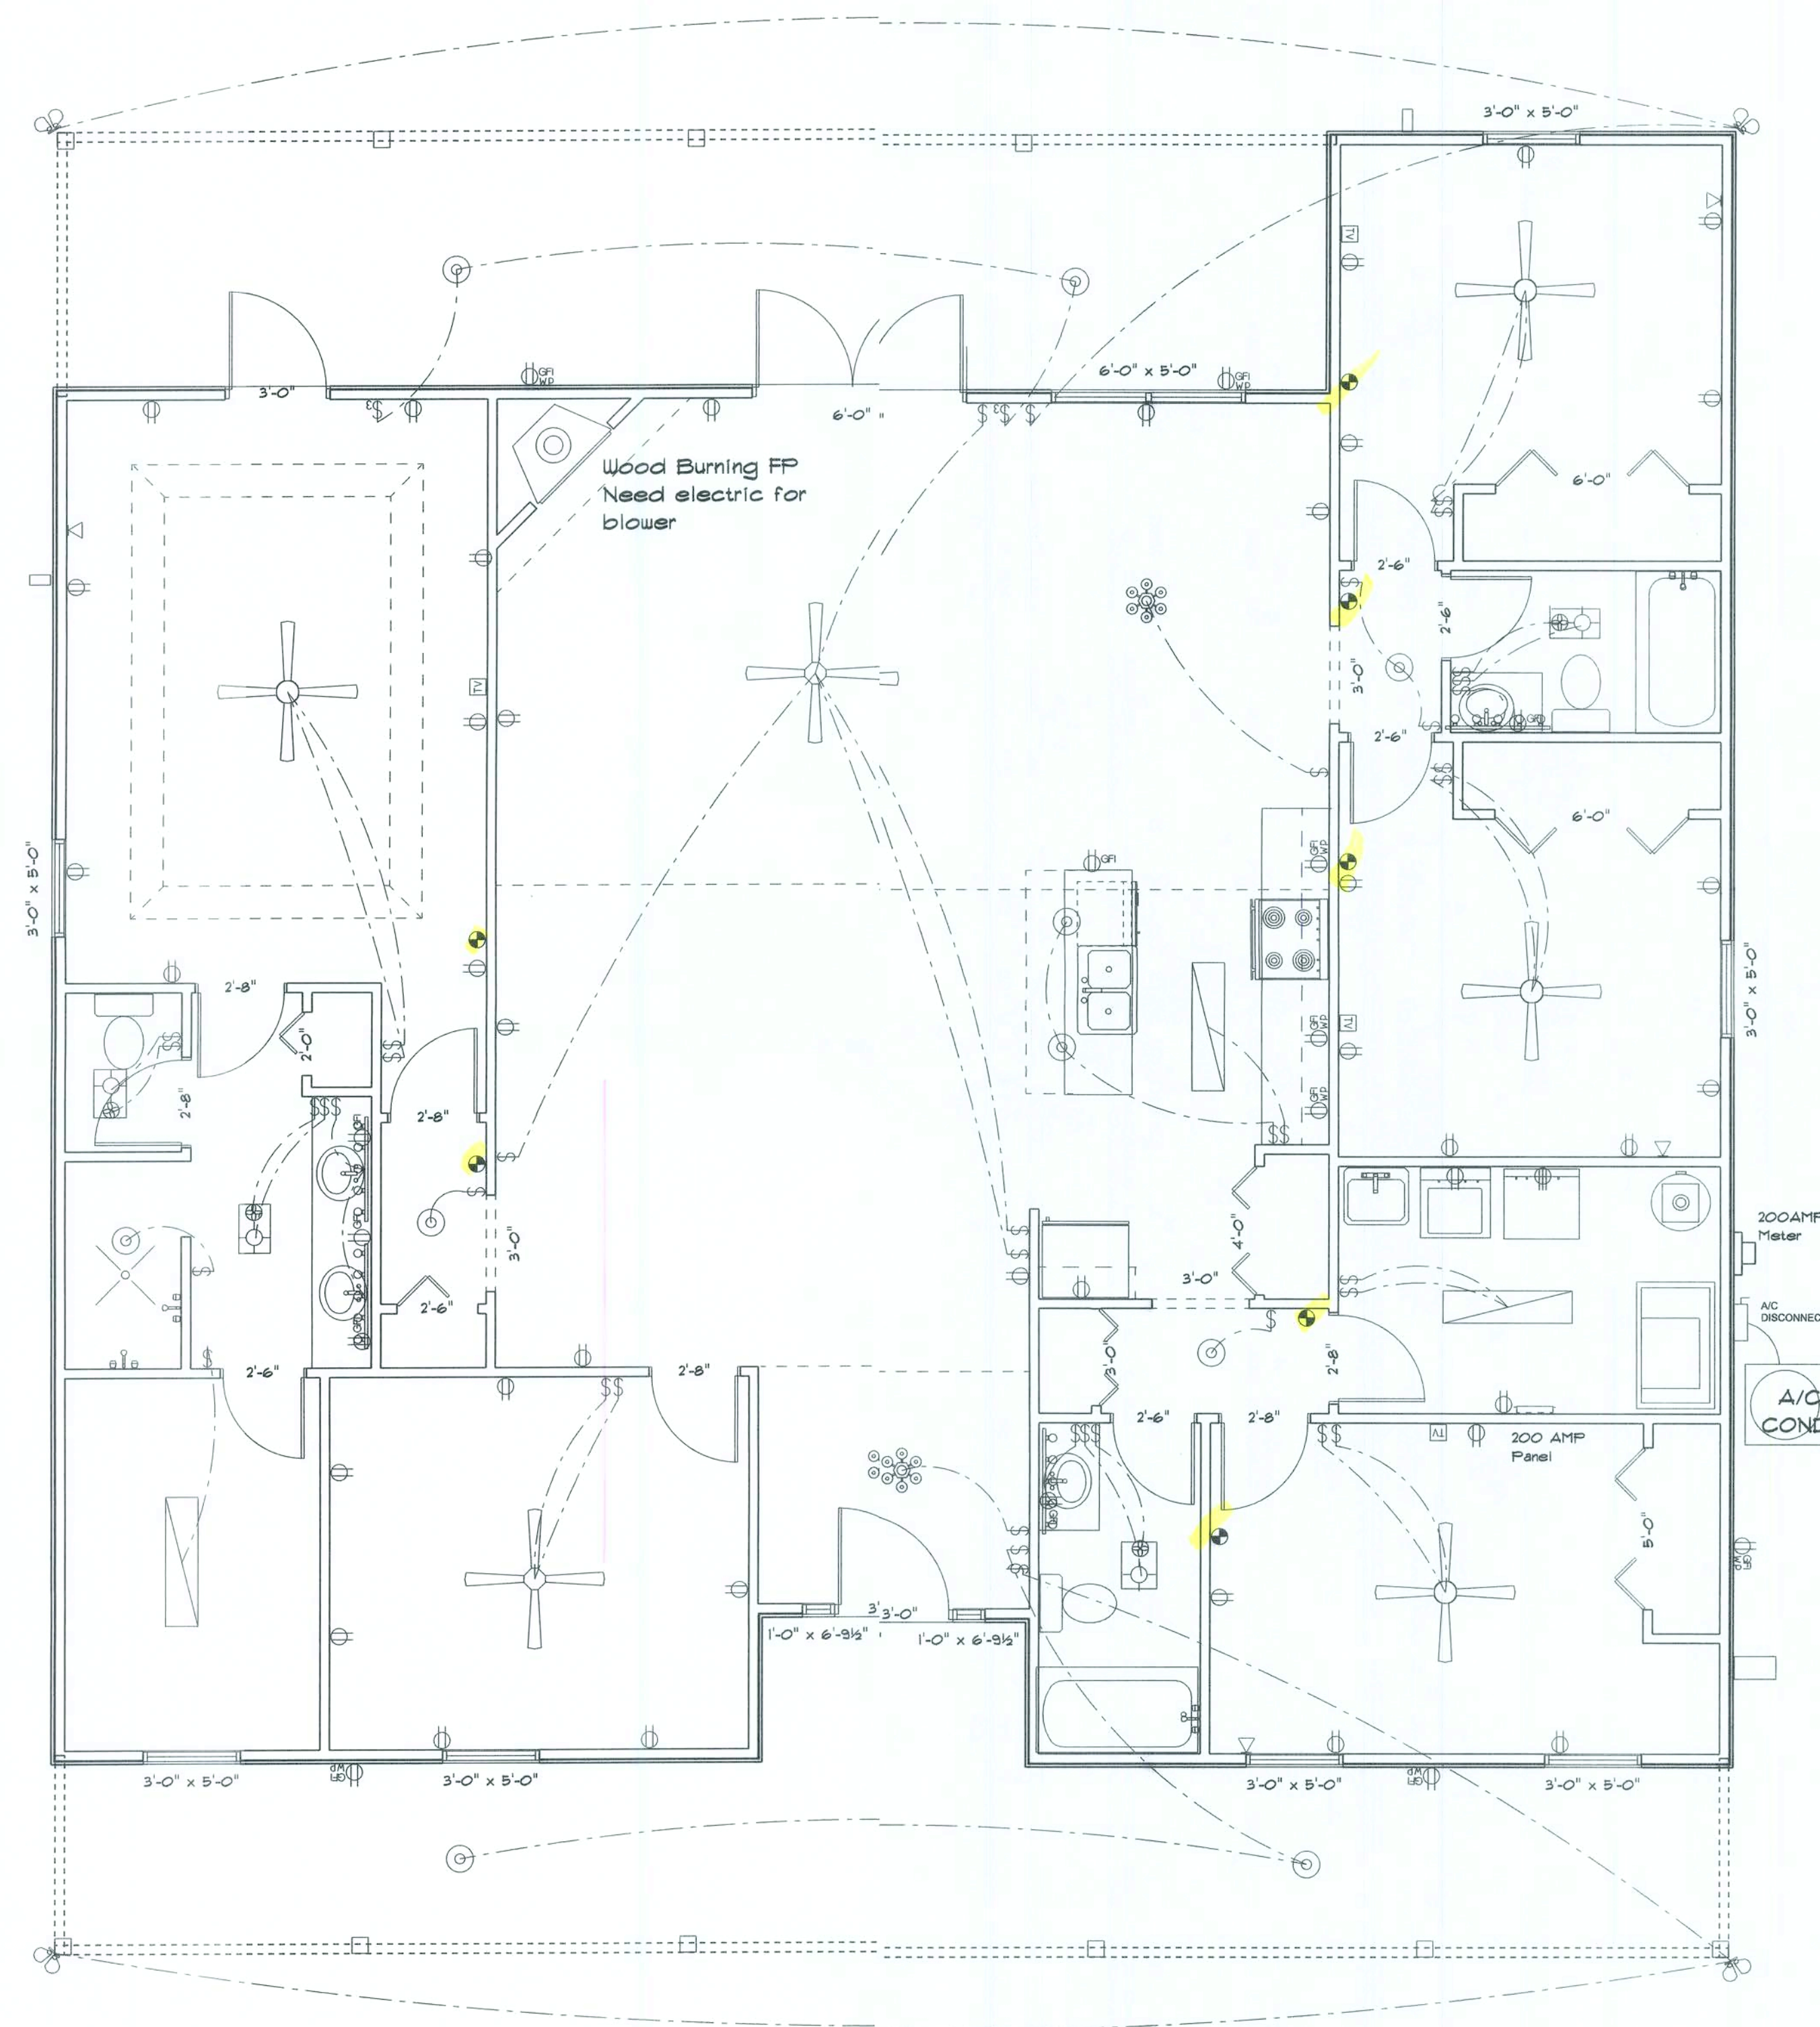

Electrical pLAN

ELECTRICAL	SYMBOL
ceiling fan	
ceiling fan globe 1	
ceiling globe light	
chandelier	
double spotlight	
fluorescent fixture	
vanity bar light	
electrical panel	
AC Disconnect	
Outlet WP GFI	
cable tv outlet	
fan	
light	
outlet	
outlet 220v	
outlet gfi	
smoke detector	
switch	
switch 3 way	
telephone	

RESIDENCE

Minnett
719 SW Happy Jack Tr.
Lake City, FL 32024

ADDRESS:
Columbia County, Florida

Woodmar Park Builders, Inc.
Lake City, Florida
Phone: (386) 755 - 2411
Fax: (386) 755-8684
Email:

PRINTED DATE:
Thursday, March 11, 2021


DESIGNED BY:
Mark Haddox

DRAWING NUMBER

A-2


REVISIONS	

SOFTPLAN
ARCHITECTURAL DESIGN SOFTWARE

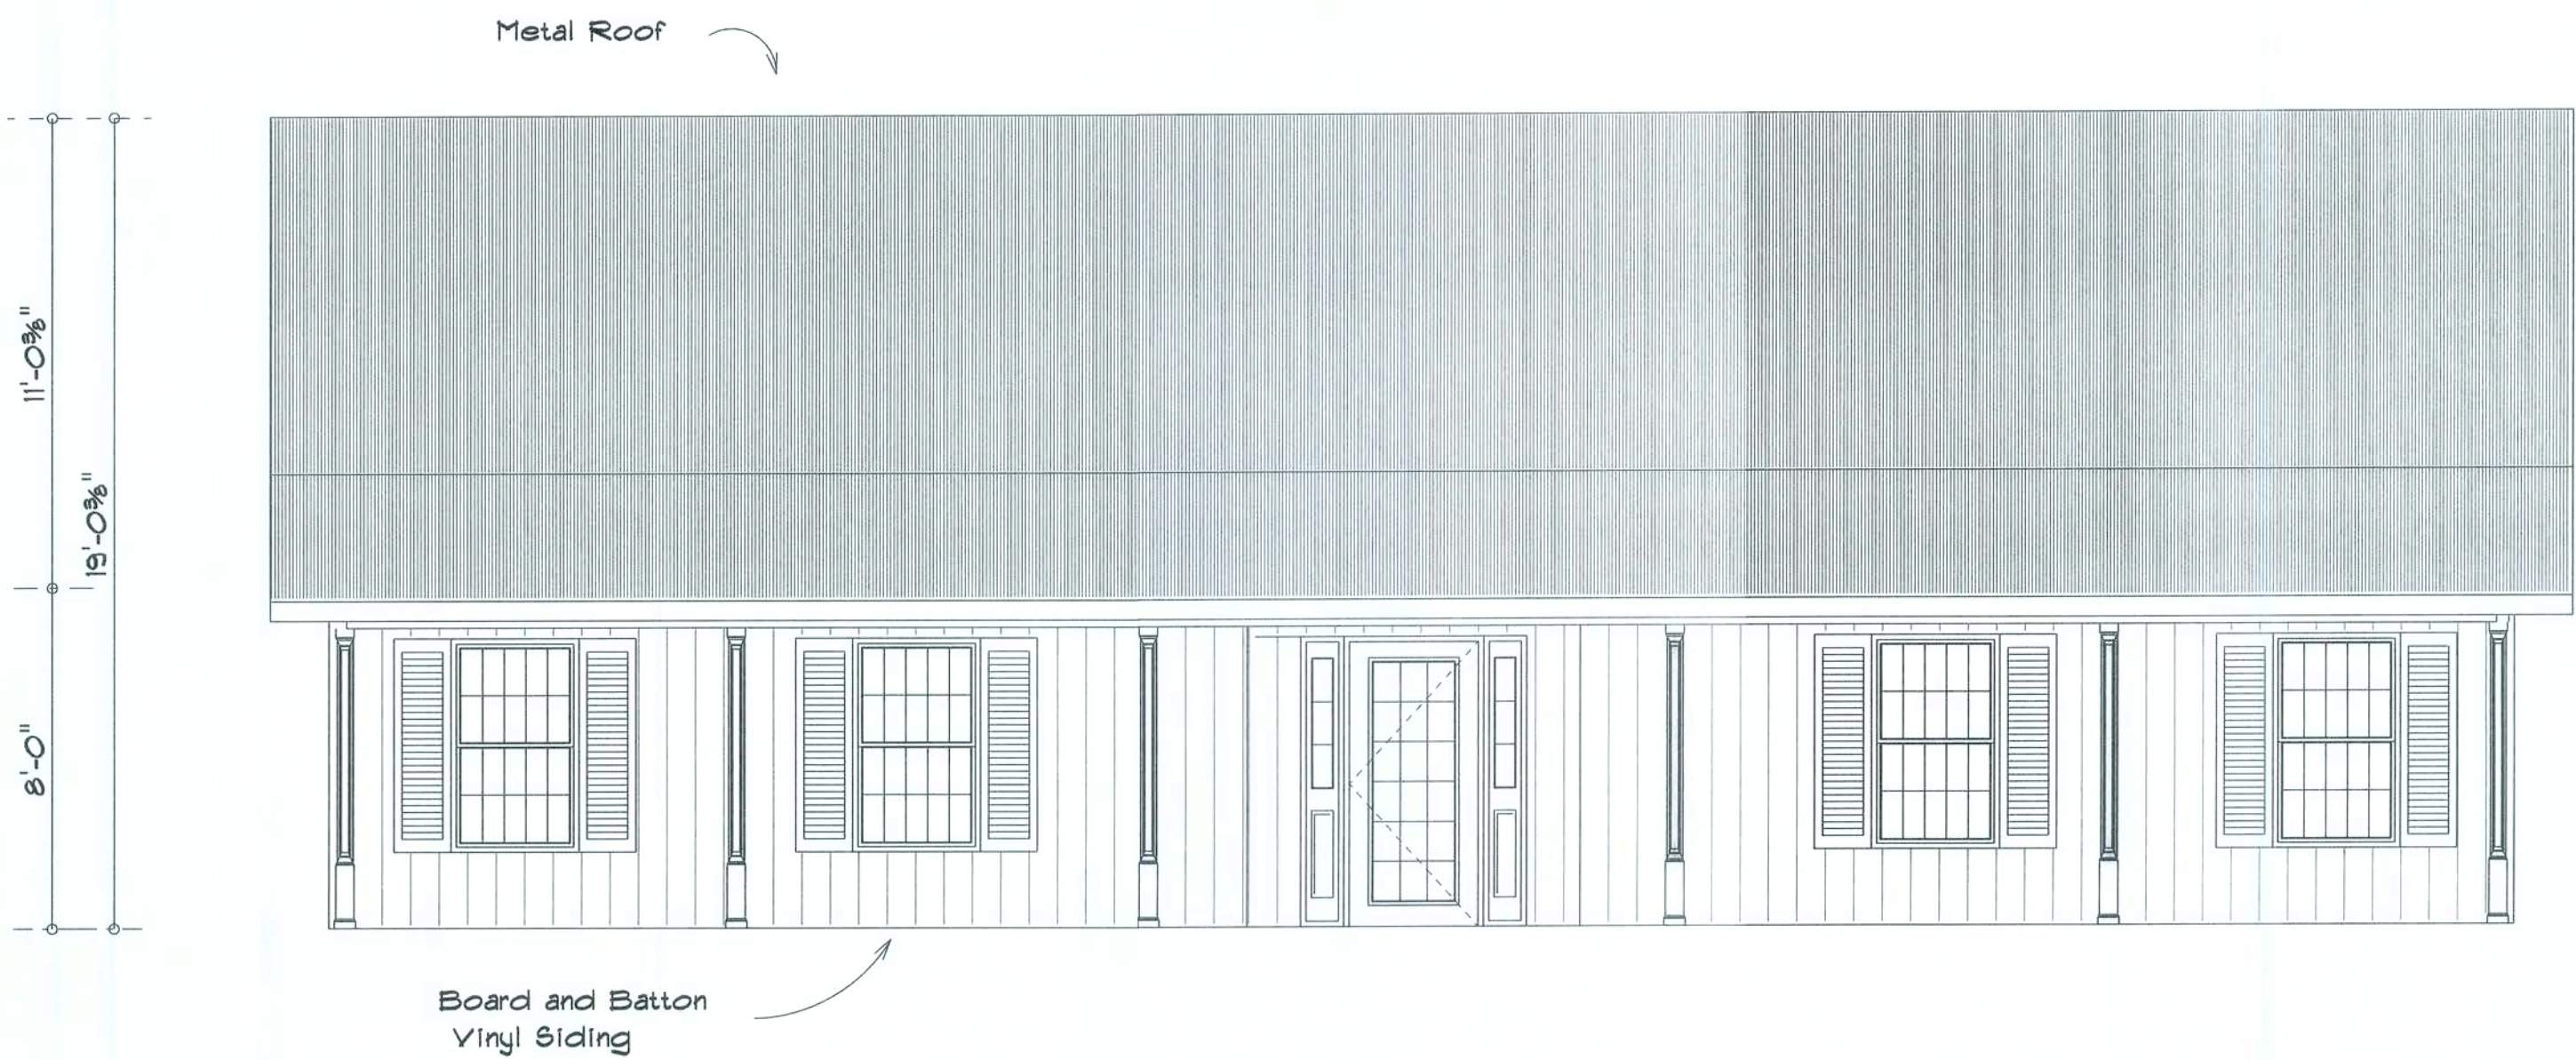

Front Elevation

- Notes:
- R-1 All roof pitches shall be 6/12 unless otherwise noted.
 - R-2 All overhangs shall be 24" except on gables 18".
 - R-3 Provide attic ventilation in accordance with code requirements (1/300th insulated attic).

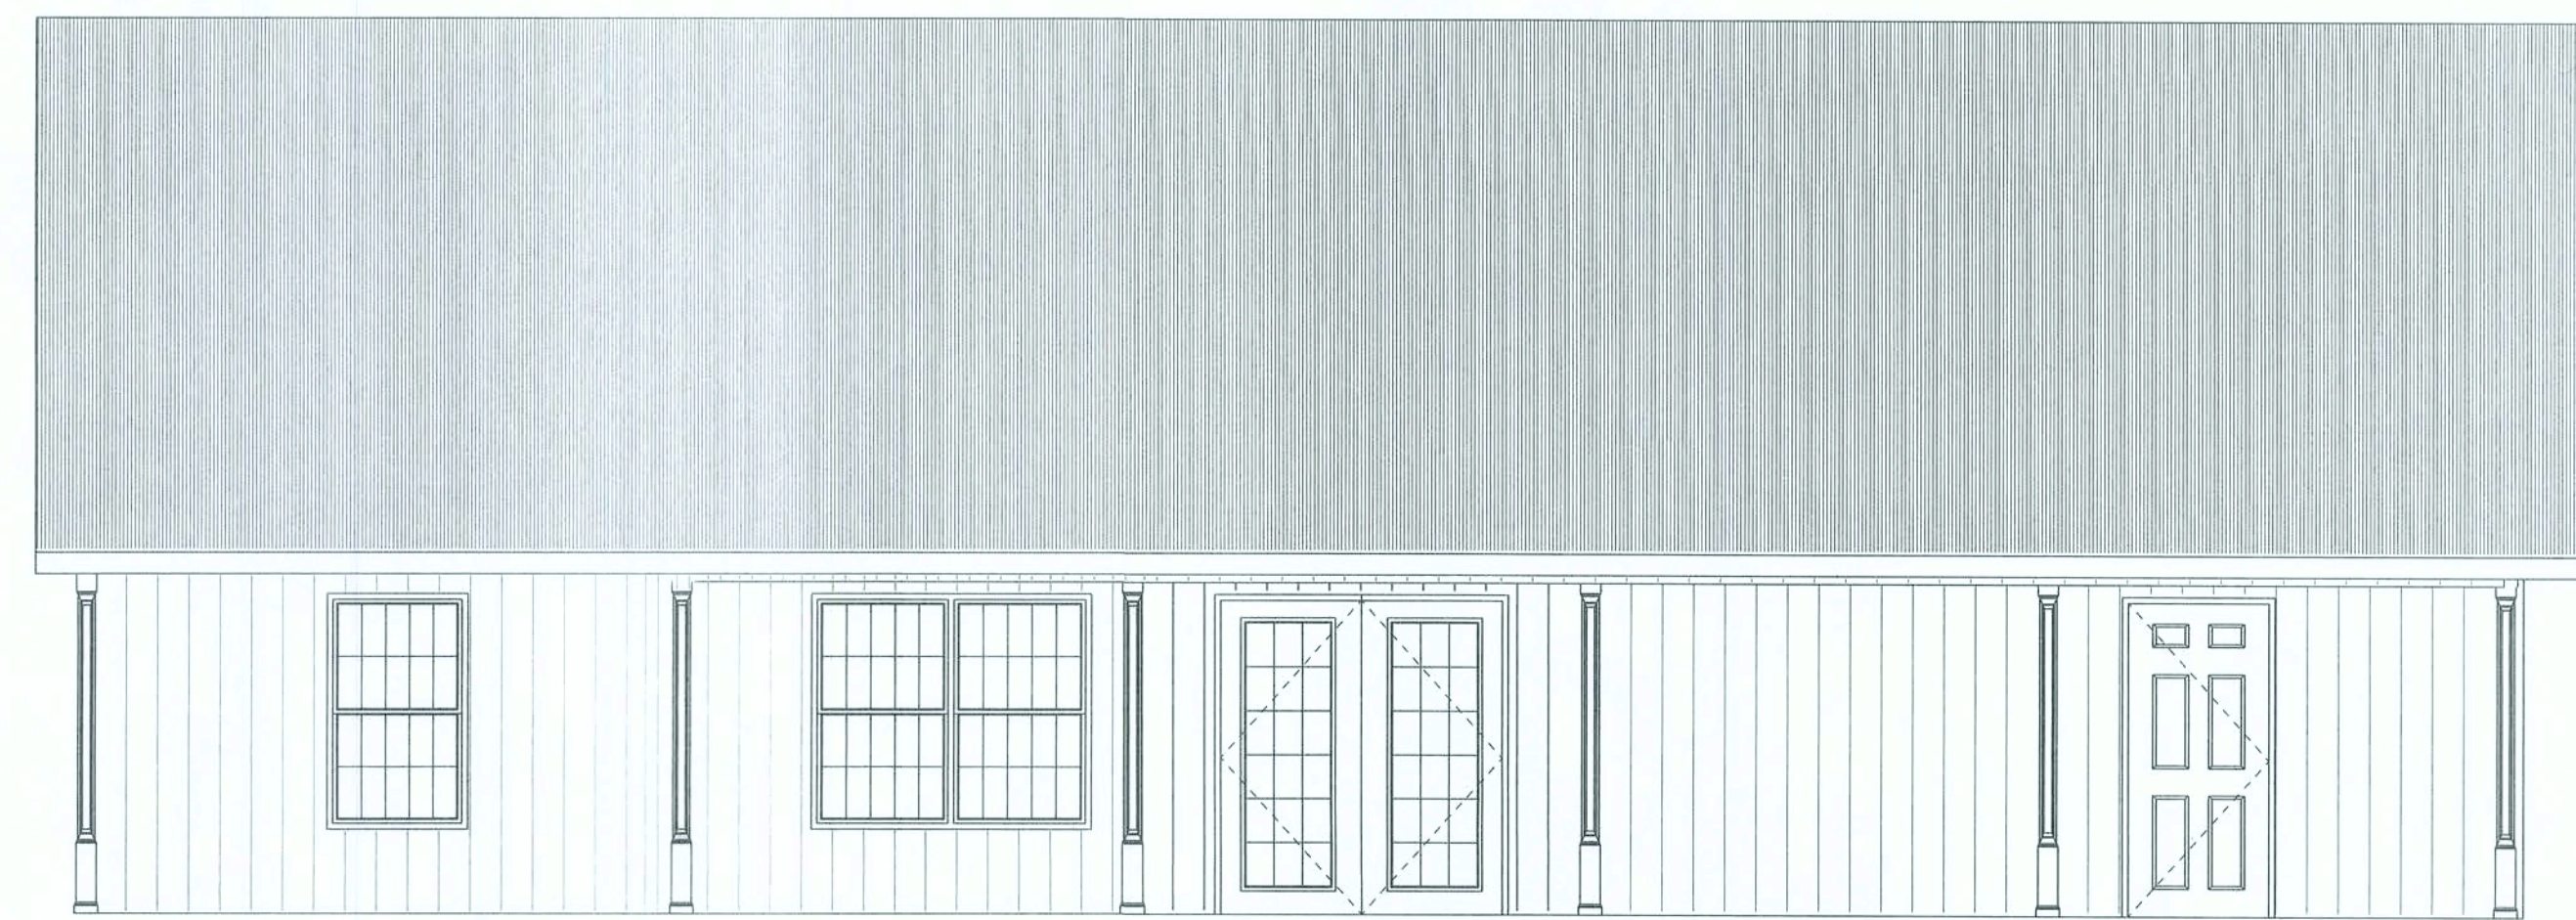

Rear Elevation



Right Elevation



Left Elevation

RESIDENCE

Winnett

719 SW Happy Jack Tr.
Lake City, FL 32024

ADDRESS:
Columbia County, Florida

Woodma Park Builders, Inc.
Lake City, Florida
Phone: (386) 755 - 2411
Fax: (386) 755-8684
Email:

PRINTED DATE:
Thursday, March 11, 2021

DESIGNED BY:
Mark Haddox

DRAWING NUMBER

A-3