



HOMES BY HOUSE CRAFT, L.L.C.

12523 U.S. Highway 441 - Alachua, FL 32615 Phone: (904) 462-5323/FAX: (904) 462-1509

Client Name: WINGFIELD Model: CUSTOM

BANK: TBD LOAN TYPE: () Cash
(X) Conventional
() F.H.A.
() V.A.

CABINET COLOR SELECTIONS:

Kitchen:
Countertop IC02 6x6 ARROW HEAD INCLUDE SPLASH, GROUT 01 ALABASTER MAPEI
Cabinet Base BRUNSWICK WHEAT CHOCOLATE
Master Bath:
Countertop SANDS OF ACAPULCO
Cabinet Base FLORENCE WHEAT A.H.
Hall Bath:
Countertop SANDS OF ACAPULCO
Cabinet Base FLORENCE WHEAT A.H.

Toilets Color
Master BISQUE
Hall BISQUE
Other HALL BATH

NOTES:
HALL BATH (DECOS-SC40 ACCENT STRIP)
MASTER BATH (DECOS-SC42 WALNUT ACCENT STRIP)
GENE MEET W/HOMEOWNER FOR STAIN COLOR
MASTER BATH SC42 12x12 FLORAL BORDER SC 42 (MEET W/ OWNER)

BATHROOM TILE SELECTION:

Master Bath:
Shower SC 42 WALNUT 8x10
Shower Floor SC 42 6x6
Grout BUSQUIT # 14
Hall Bath:
Tub Surround SC 40 CREAM
Tile Selection 8x10
Grout BUSQUIT # 14

Color	Tub Choices	Pump
Master	Style	
Hall	<u>BISQUE</u> <u>STEEL</u>	
Bath 3		

VAULTS:

KITCHEN, GREAT ROOM

CARPET

MASTER BED & BEDROOM 2
LWF MAM 301 MAINE MAPLE NATURAL
DINING ROOM G0301 GOERSIA RED OAK

VINYL/FLOOR TILE

RUST RD05 18x18
GREAT ROOM
RUST RD05
KITCHEN 3 74 CAMEL

PAINT SELECTIONS:

Interior Wall Color GENE MEET W/ HOMEOWNER
Interior Trim SW 6378 CRISP LINEN- WALLS AND CEILING

Window Sills:

(X) Wood
() Flatcut Marble
() Hardiplank Siding Wood Sill


RANGE SELECTIONS:

Range/Color
Hood/Color

OPTIONAL APPLIANCES:

EXTERIOR FEATURE SELECTIONS:

Hardiplank Color SW 6660 HONEYBUSH
Trim Package
Trim Color SW6662 SUMMER DAY
Exterior Door Colors
Siding
Soffit CHOCOLATE BROWN A1
Shingles 1)DRIFWOOD, 2)RUSTIC CEDAR, 3)PAINTED DESERT
Style/Color
Window Color BRONZE
Trim Type Colonial w/Classique Doors Std.
Colonial Grills ALL AROUND HOUSE

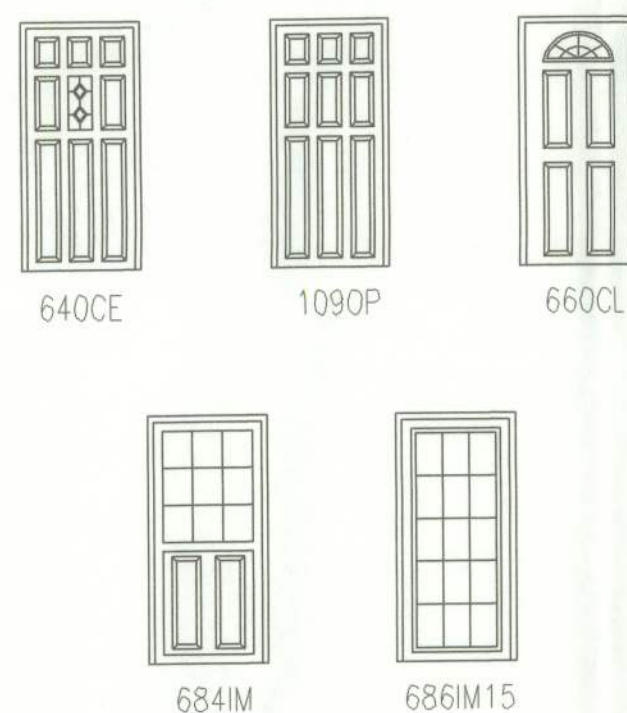

BATH WINDOWS:

Master (X) Obscure () Clear Glass
Hall (X) Obscure () Clear Glass

SUPER Energy Pac: Yes () No (X)

Well Allowance Yes (X) No ()
Septic Allowance Yes (X) No ()

Extras:


Power Company: CLAY ELECTRIC () Overhead (X) Underground

Fireplace RUST RD 05 2 BLOCK HT HEARTH Screenroom Color N/A

We have reviewed this plan and all notes on it. All items we have discussed with House Craft and its representatives are indicated on this "Master Copy". We understand that any additional items that are not on this print can be done for a \$250.00 plan change fee plus the cost of the change.

Purchaser: * Date: *

REV.	DESCRIPTION	DATE

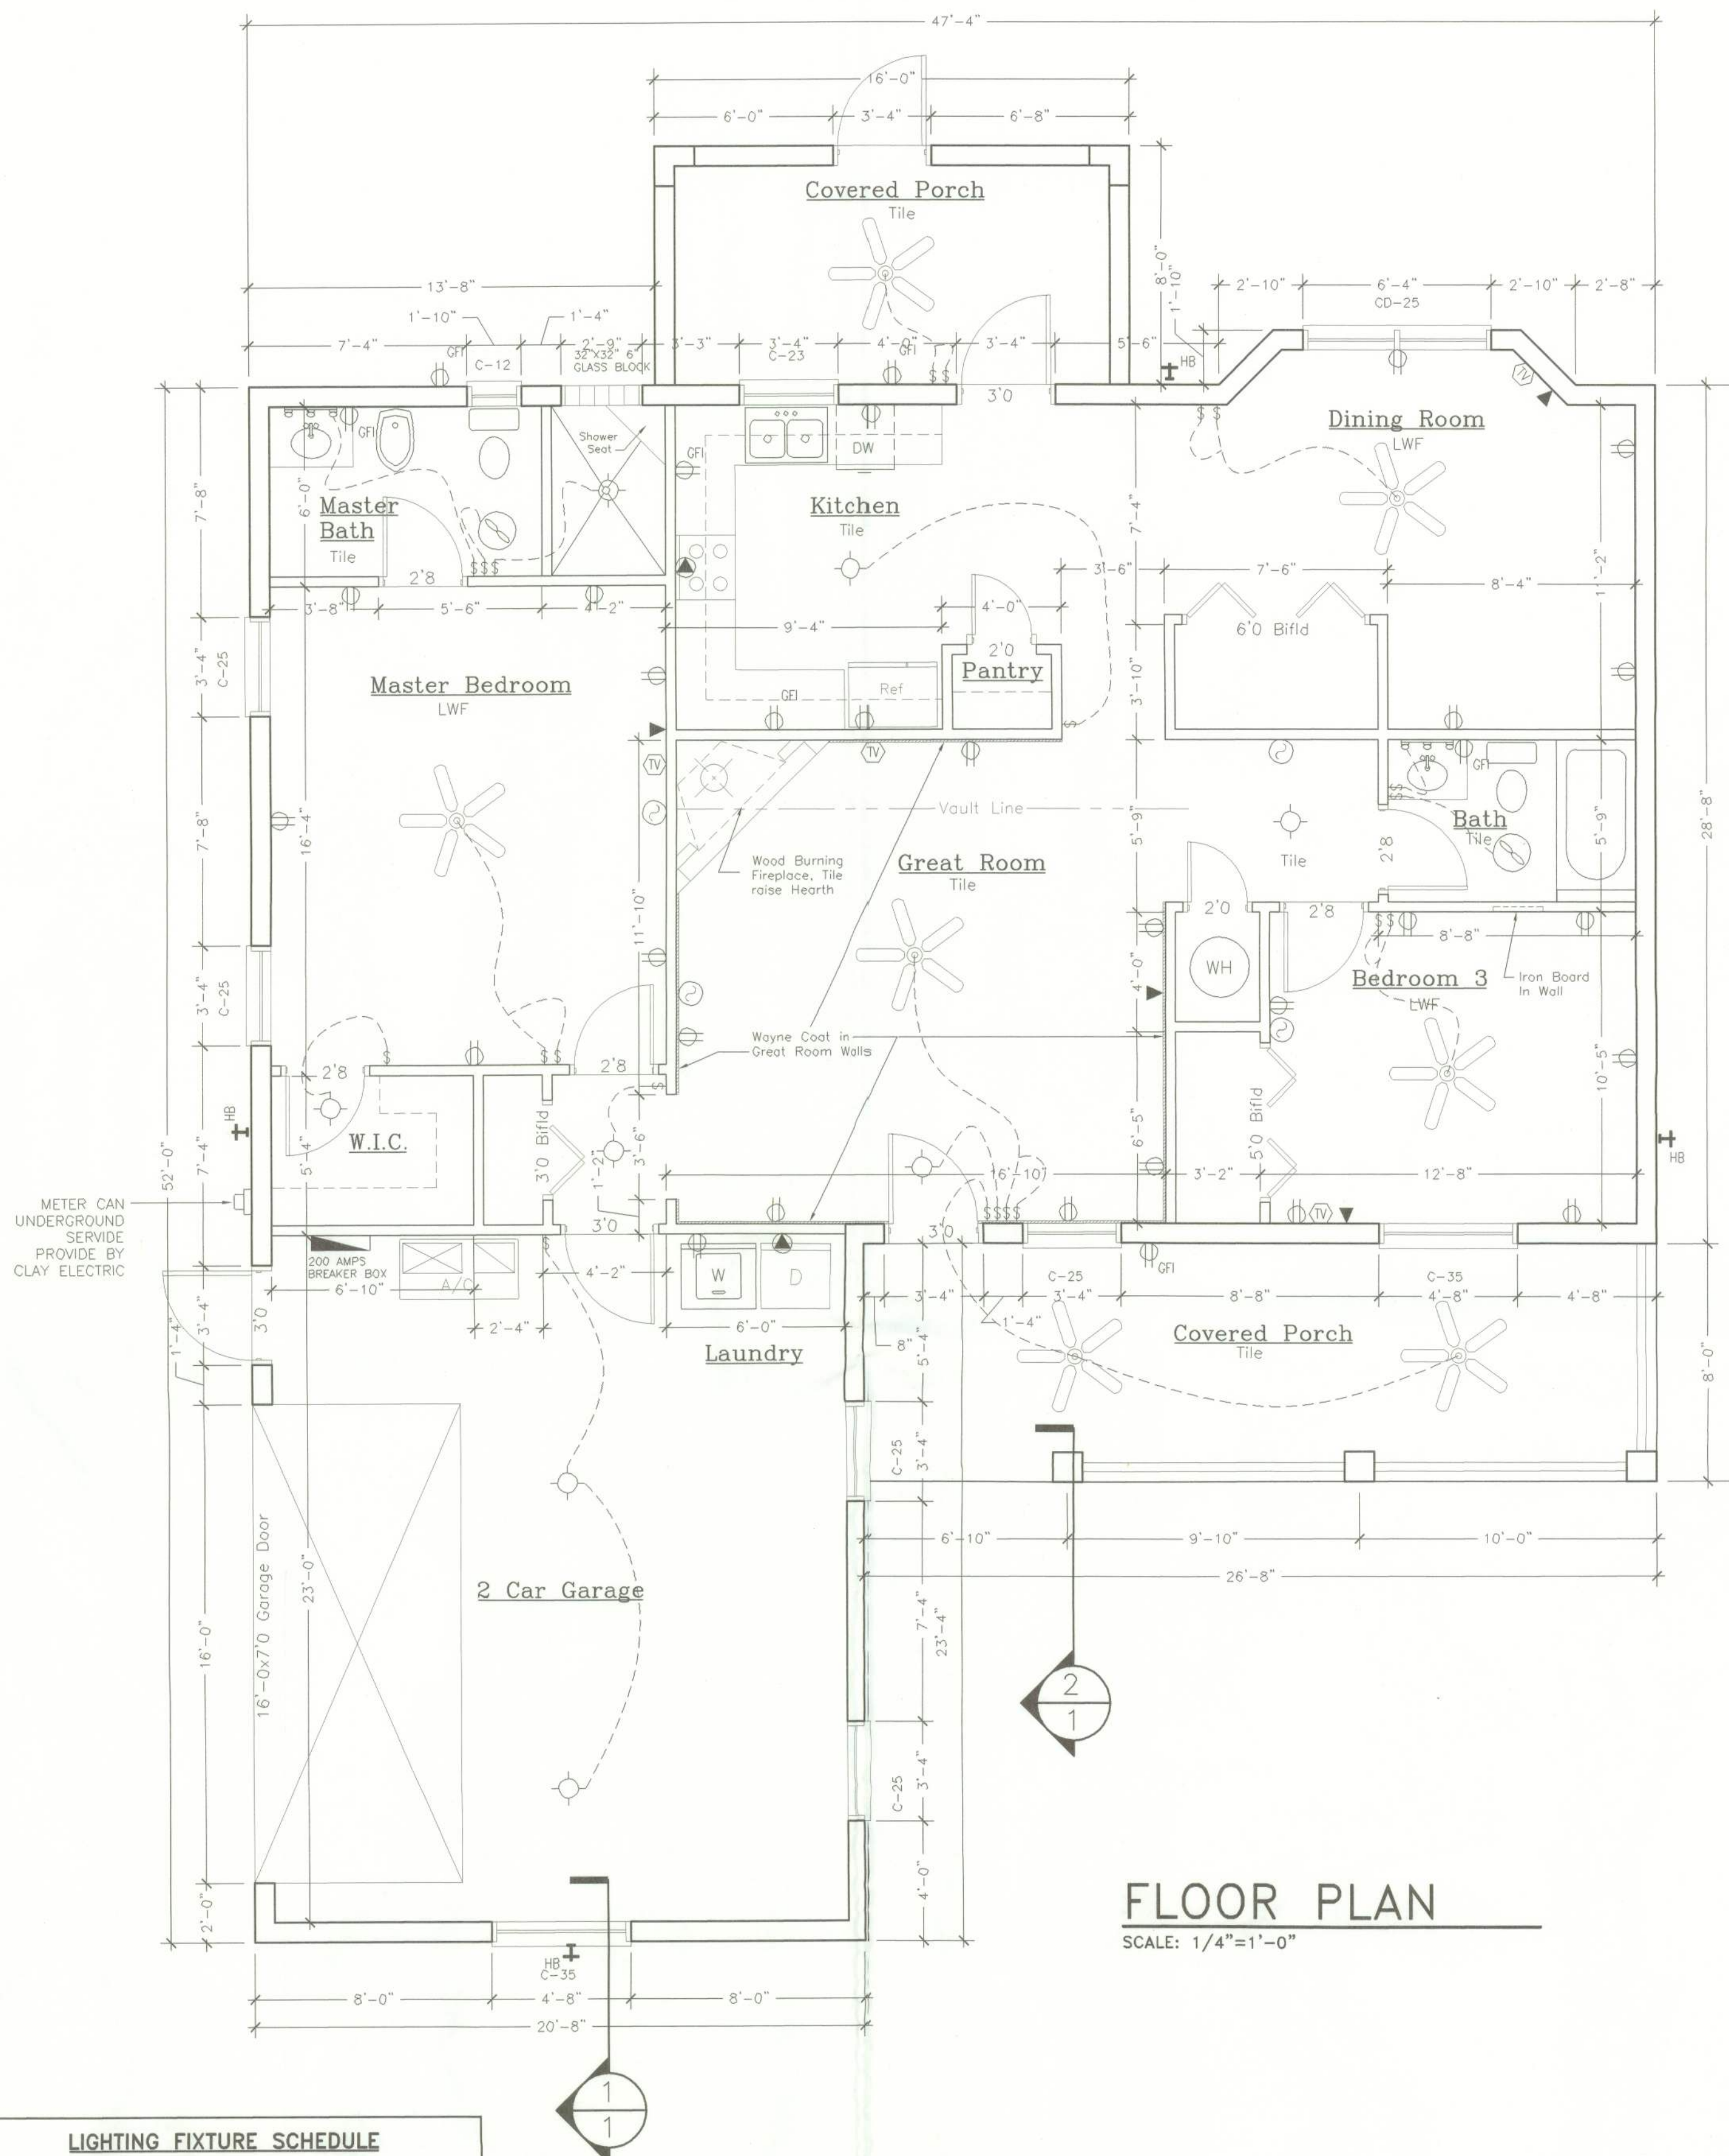

FLOOR PLAN

SCALE: 1/4"=1'-0"

ELECTRICAL LEGEND

- 44" DUPLEX CONVENIENCE RECEPTACLE WITH GROUND (44" DENOTES HEIGHT A.F.F. IF OTHER THAN STD.) (GFI/GFCI DENOTES GROUND FAULT CIRCUIT INTERRUPTER) (WP DENOTES WEATHER PROOF)
- SPECIAL RECEPTACLE WITH GROUND, SEE SPECIFICATIONS
- SINGLE POLE SWITCH AT STANDARD HEIGHT
- THREE WAY SWITCH AT STANDARD HEIGHT
- TELEPHONE OUTLET
- CEILING MOUNTED EXHAUST FAN VENTED TO EXTERIOR
- CABLE TV OUTLET
- ELECTRICAL DISTRIBUTION PANEL
- SMOKE DETECTOR
- THERMOSTAT

NOTES:

- * GRILL IN ALL WINDOWS
- * STAIN GRADE DOORS, TRIM WINDOW SILL, AND WAYNE COAT
- * HOMEOWNER WILL WIRE ALL TELEPHONES, SPEAKERS COMPUTERS

LIGHTING FIXTURE SCHEDULE

FIXTURE	DESCRIPTION
	SURFACE MOUNTED INCANDESCENT FIXTURE
	PRE-WIRED CEILING FAN
	DOUBLE FLOOD LIGHT FIXTURE
	FAN LIGHT VENTED TO EXTERIOR
	SURFACE MOUNTED INCANDESCENT FIXTURE

TYPICAL SPECIAL CIRCUIT ELECTRIC SCHEDULE

TWO GFI'S CIRCUITS IN KITCHEN
ONE OR TWO GFI'S IN BATHS: LOOPED TOGETHER
GFI IN GARAGE, FRONT ENTRY, AND REAR PORCH LOOPED TOGETHER
ONE GFI FOR JETTED TUB (OPTIONAL)
TWO AFI CIRCUITS PROVIDED FOR BEDROOMS

Square Footage

Living...	1,369
Garage...	490
Entry...	128
Porch...	212
Total...	2,199



HOMES BY HOUSE CRAFT, L.L.C.

12523 NW U.S. Hwy. 441 - Alachua, FL 32615
Phone: (386) 462-5323/FAX: (386) 462-1509

Job name: <u>WINGFIELD</u>	
Model: <u>CUSTOM</u>	Type: <u>FLOOR PLAN</u>
Location:	Drawn By: <u>M.A.B.</u>
Checked By: <u>J.D.H.</u>	Revision Date:
Scale: 1/4" = 1'-0"	Date: 7/06/2005 Sheet: 2 of 3