


* SITE PLAN *

SCALE : 1" = 20'

DESCRIPTION:
LOT 14, FOREST COUNTRY 6TH ADDITION, A
SUBDIVISION ACCORDING TO THE PLAT THEREOF,
RECORDED IN PLAT BOOK 9, PAGES 66-67,
PUBLIC RECORDS OF COLUMBIA COUNTY, FLORIDA.

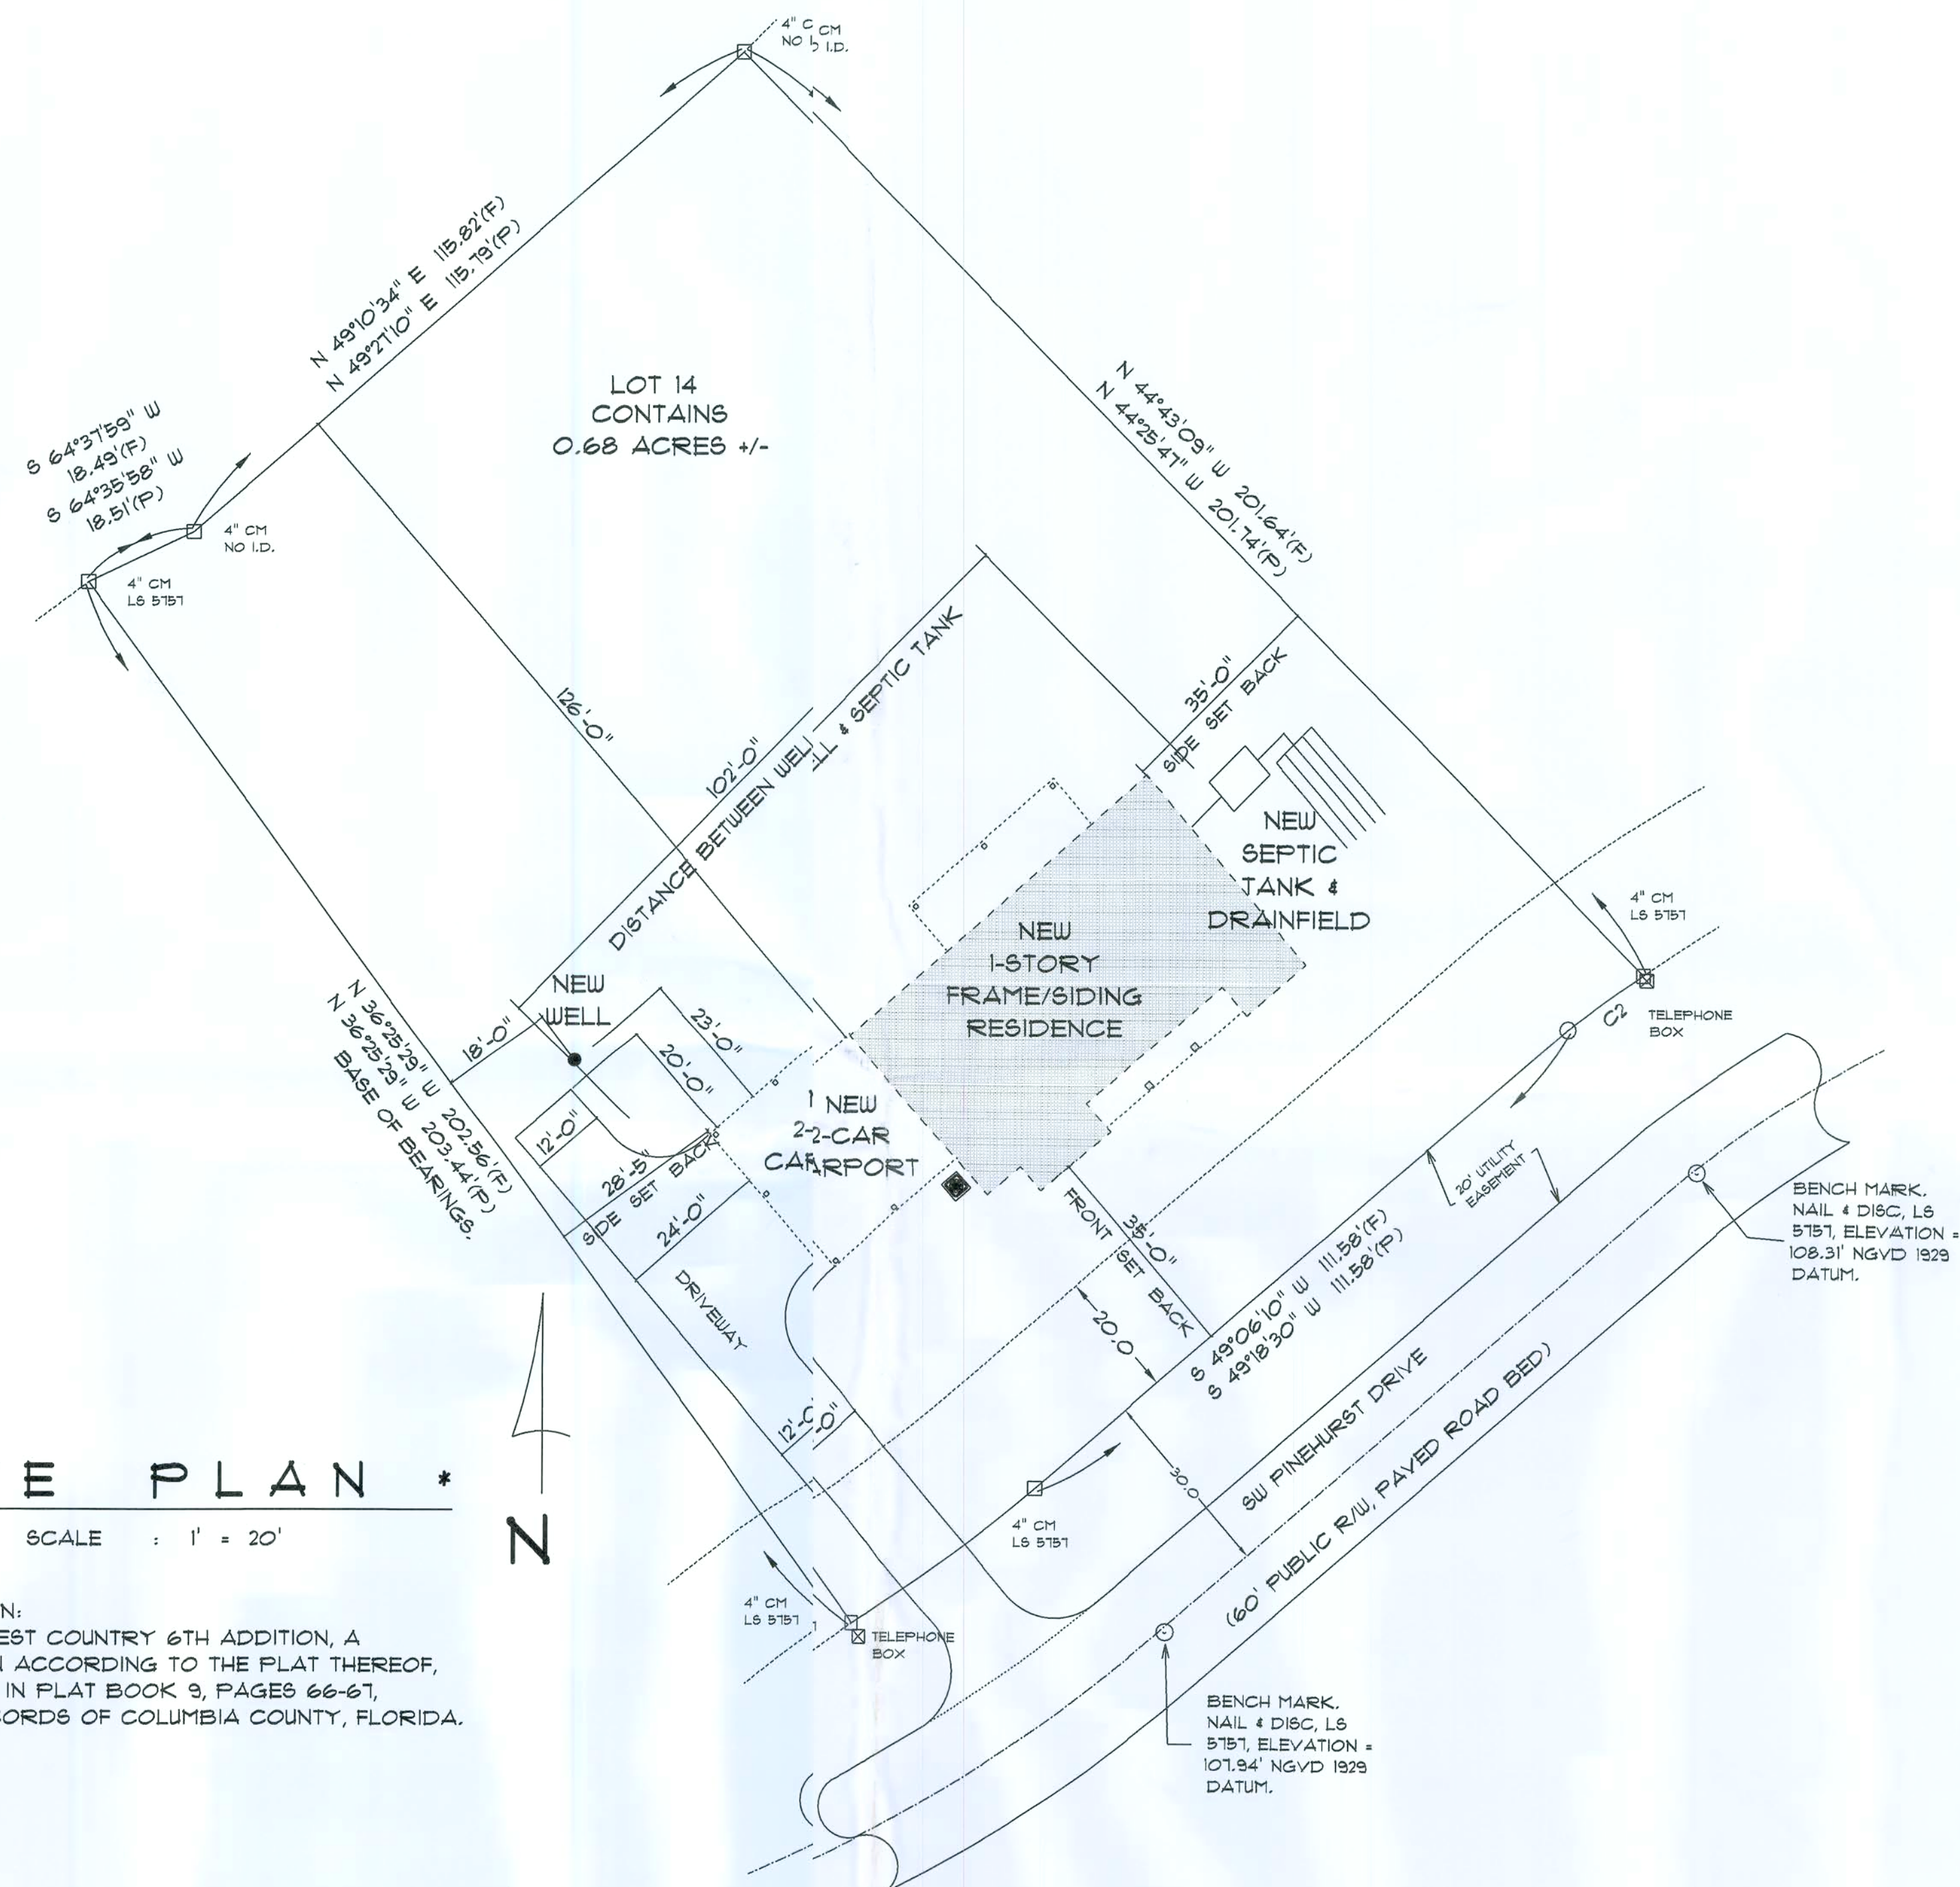

RESIDENCE
for
CLINTON & KELSEY
STANDRIDGE

BRANDFORD, FLORIDA

Teresa M. Ruffo
2925 SW 6R 41
Lake City Florida, 32025
Cell: (386) 867-1181
Email: teresaruffo@gmail.com

PRINTED DATE:
Thursday, March 25, 2011

DRAWN BY: Teresa M. Ruffo CHECKED BY:

BUILDING CONTRACTOR


FINALS DATE:

JOB NUMBER:

DRAWING NUMBER


A-1

OF 6 SHEETS

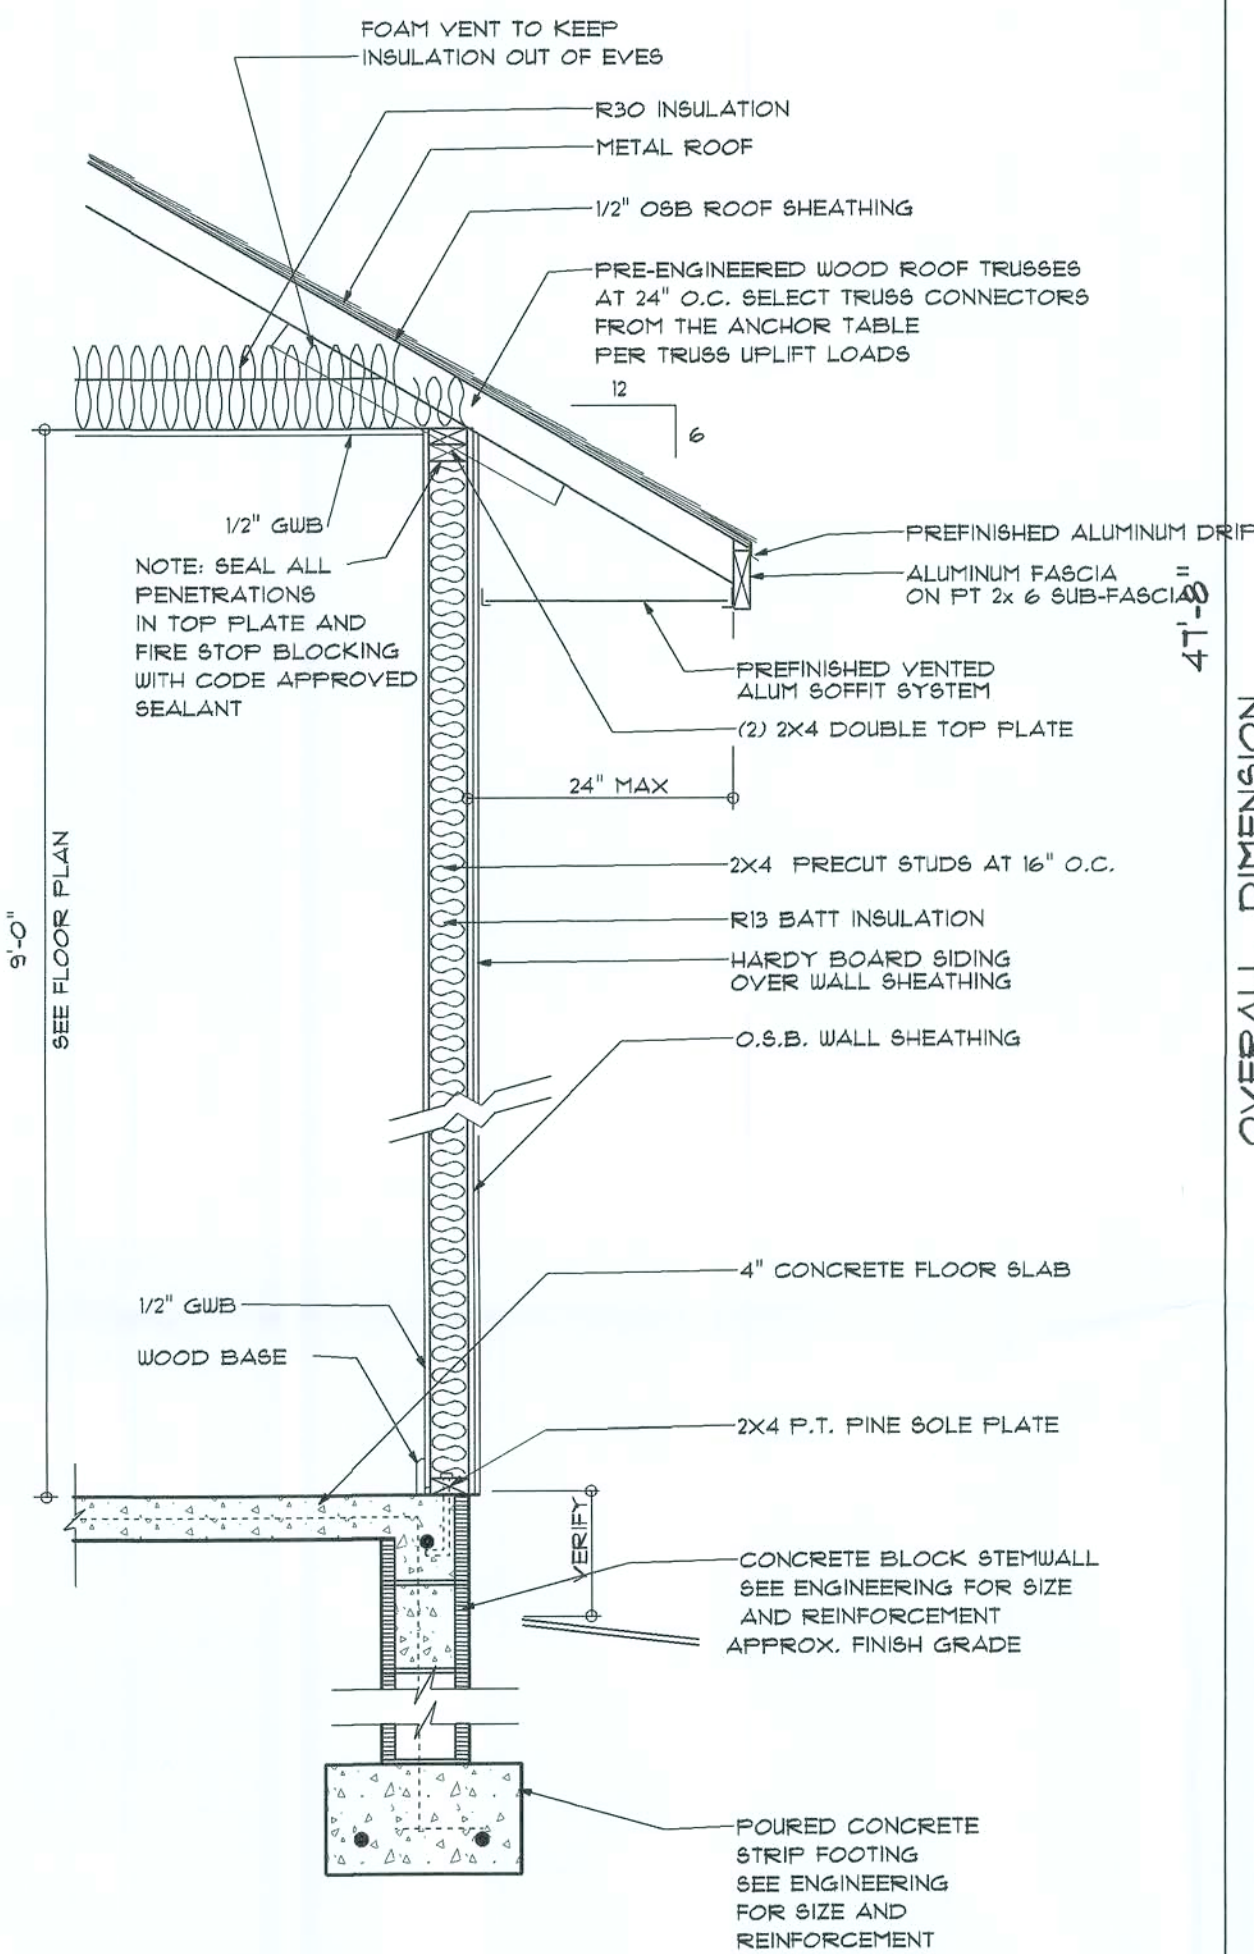

TYPICAL DESIGN WALL SECTION
NON - STRUCTURAL DATA

N.T.S.

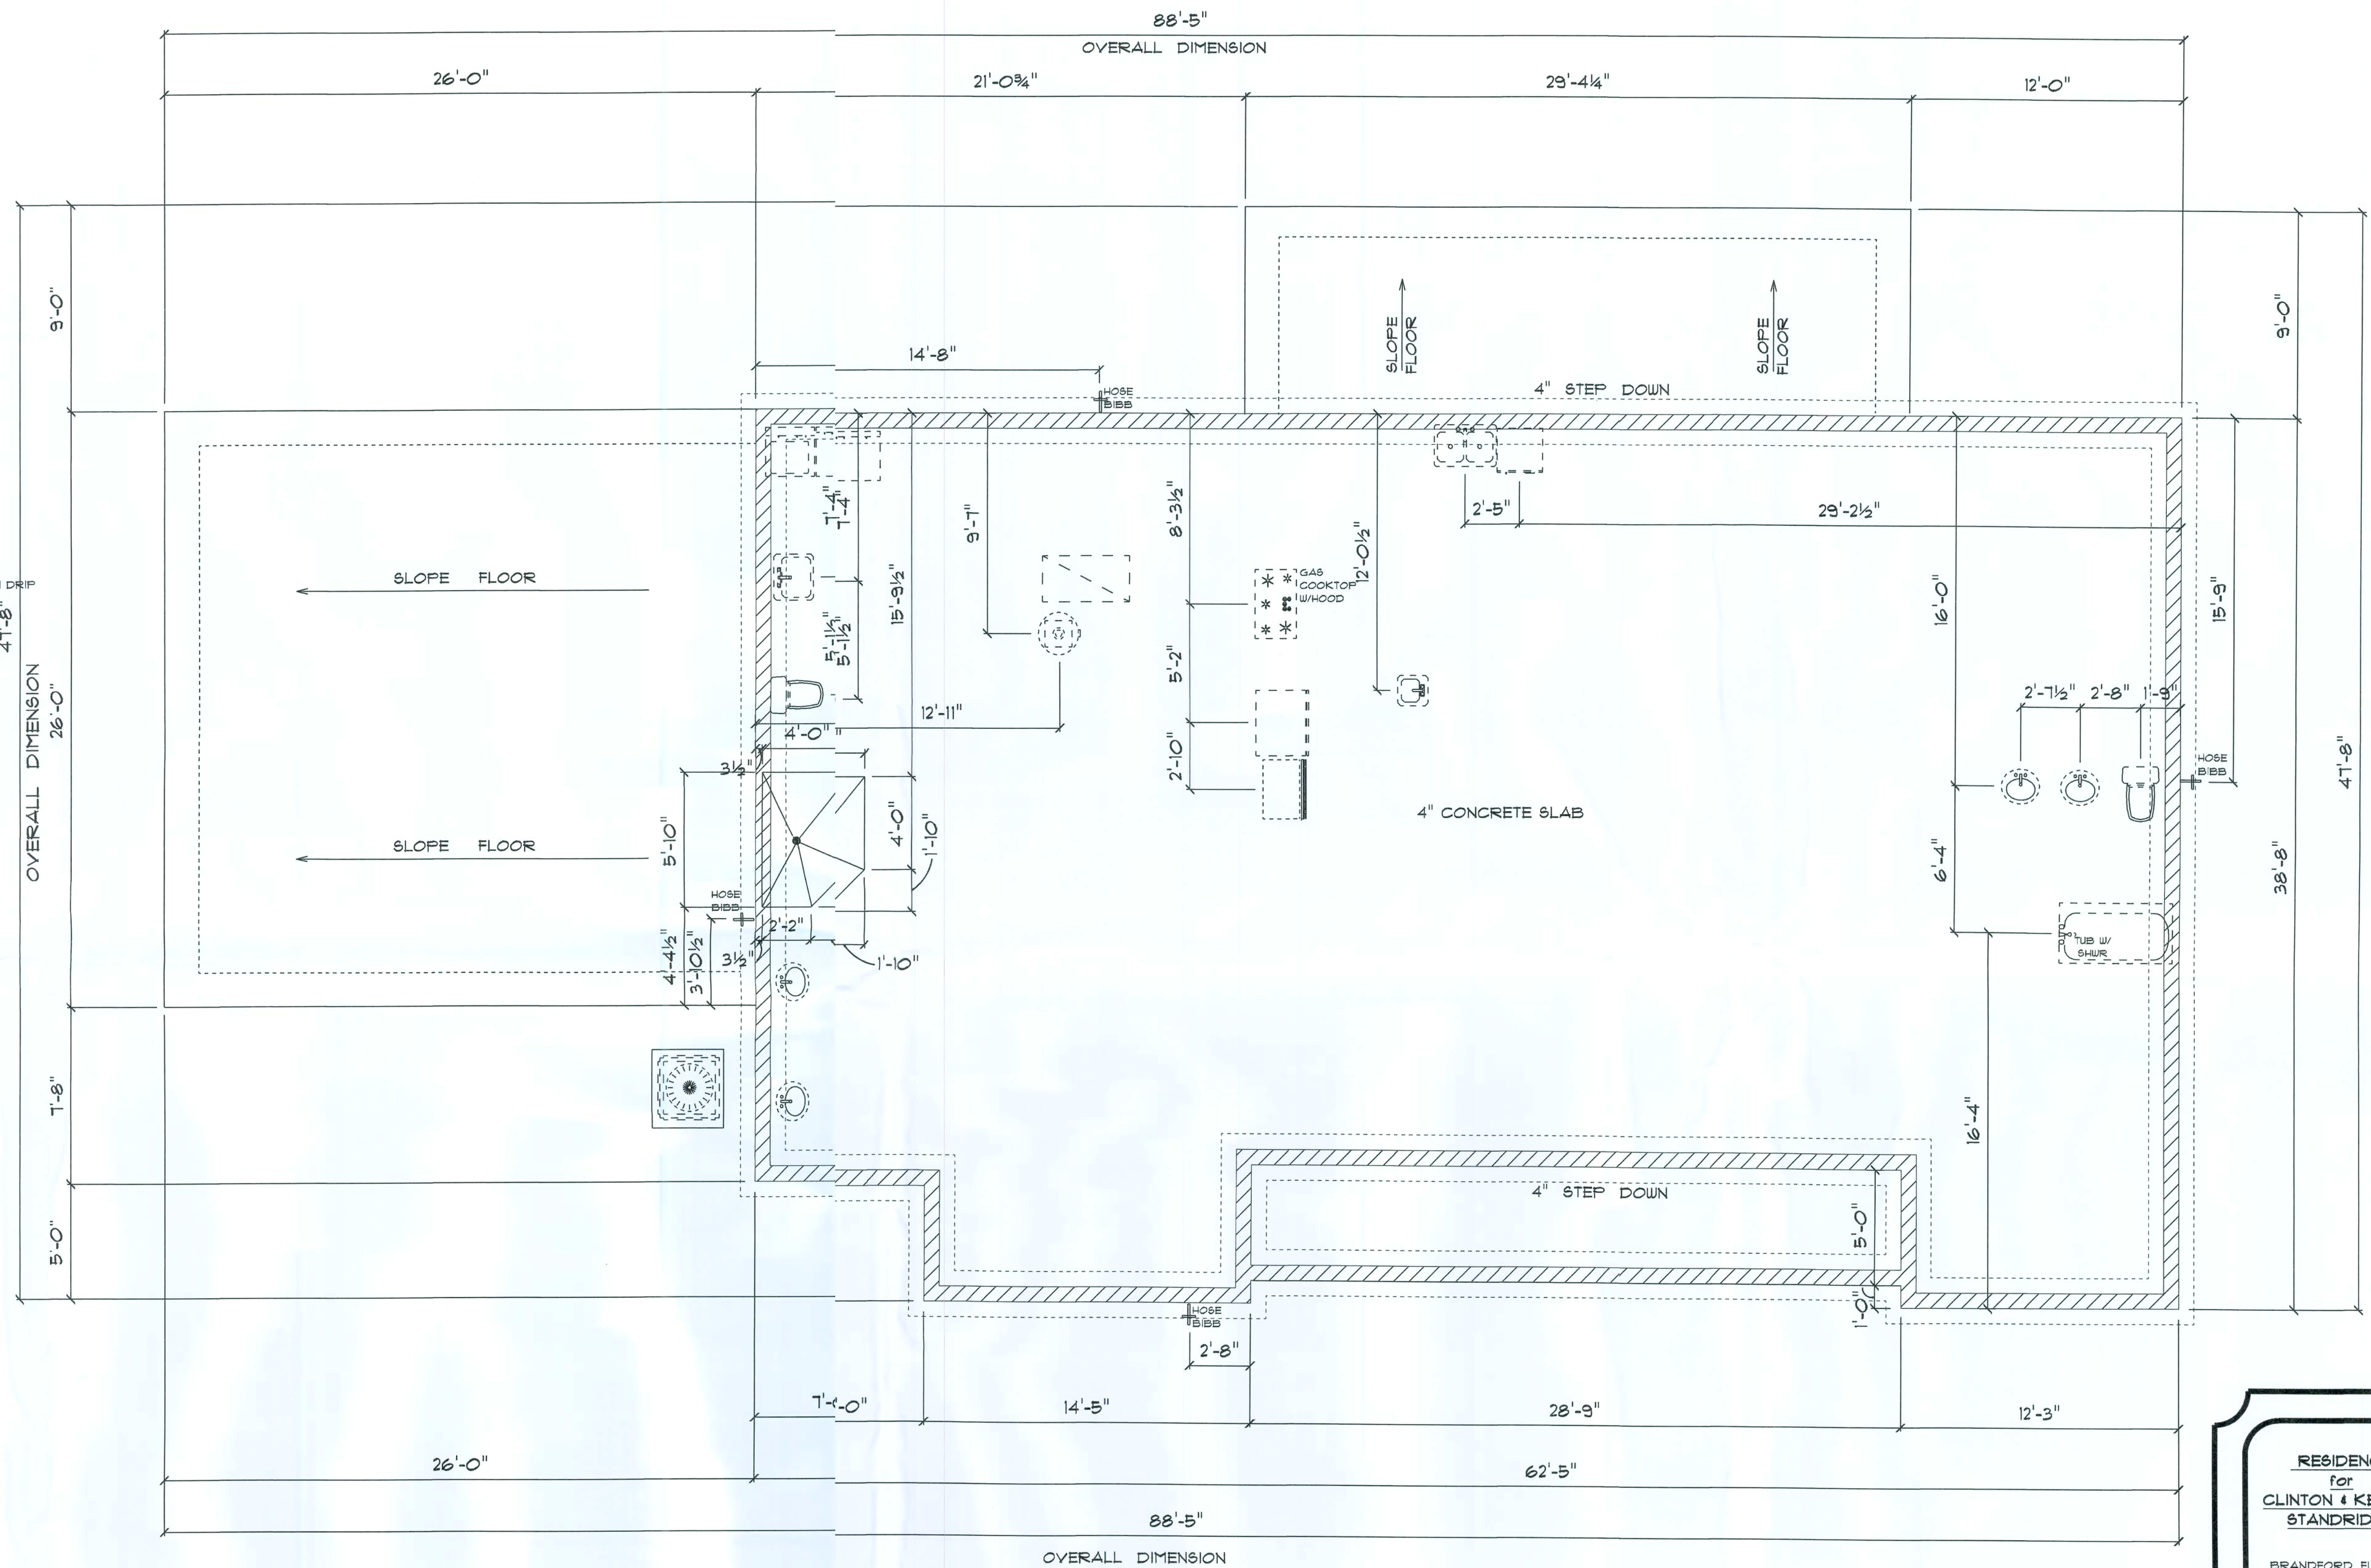

*** FOUNDATION / PLUMBING PLAN ***

SCALE : 1/4" = 1'-0"

- IMPORTANT NOTES:**
1. IT IS THE BUILDER'S RESPONSIBILITY TO VERIFY ALL GEOMETRY AND DIMENSIONS BEFORE ORDERING ANY MATERIALS OR BEGINNING CONSTRUCTION.
 2. THESE PLANS ARE FOR LAYOUT AND DESIGN PURPOSES ONLY ALL STRUCTURAL NOTES AND DETAILS TO BE PROVIDED BY AN ENGINEER.

RESIDENCE
for
CLINTON & KELSEY
STANDRIDGE

BRANDFORD, FLORIDA

Teana M. Ruffo
2825 SW SR 47
Lake City Florida, 3205
Cell: (386) 867-1191
Email: teanaruffo@gmail.com

PRINTED DATE:
Thursday, March 25, 2021

DRAWN BY: Teana M. Ruffo CHECKED BY:

BUILDING CONTRACTOR


FINALS DATE:

JOB NUMBER:

DRAWING NUMBER

A-2

OF 6 SHEETS

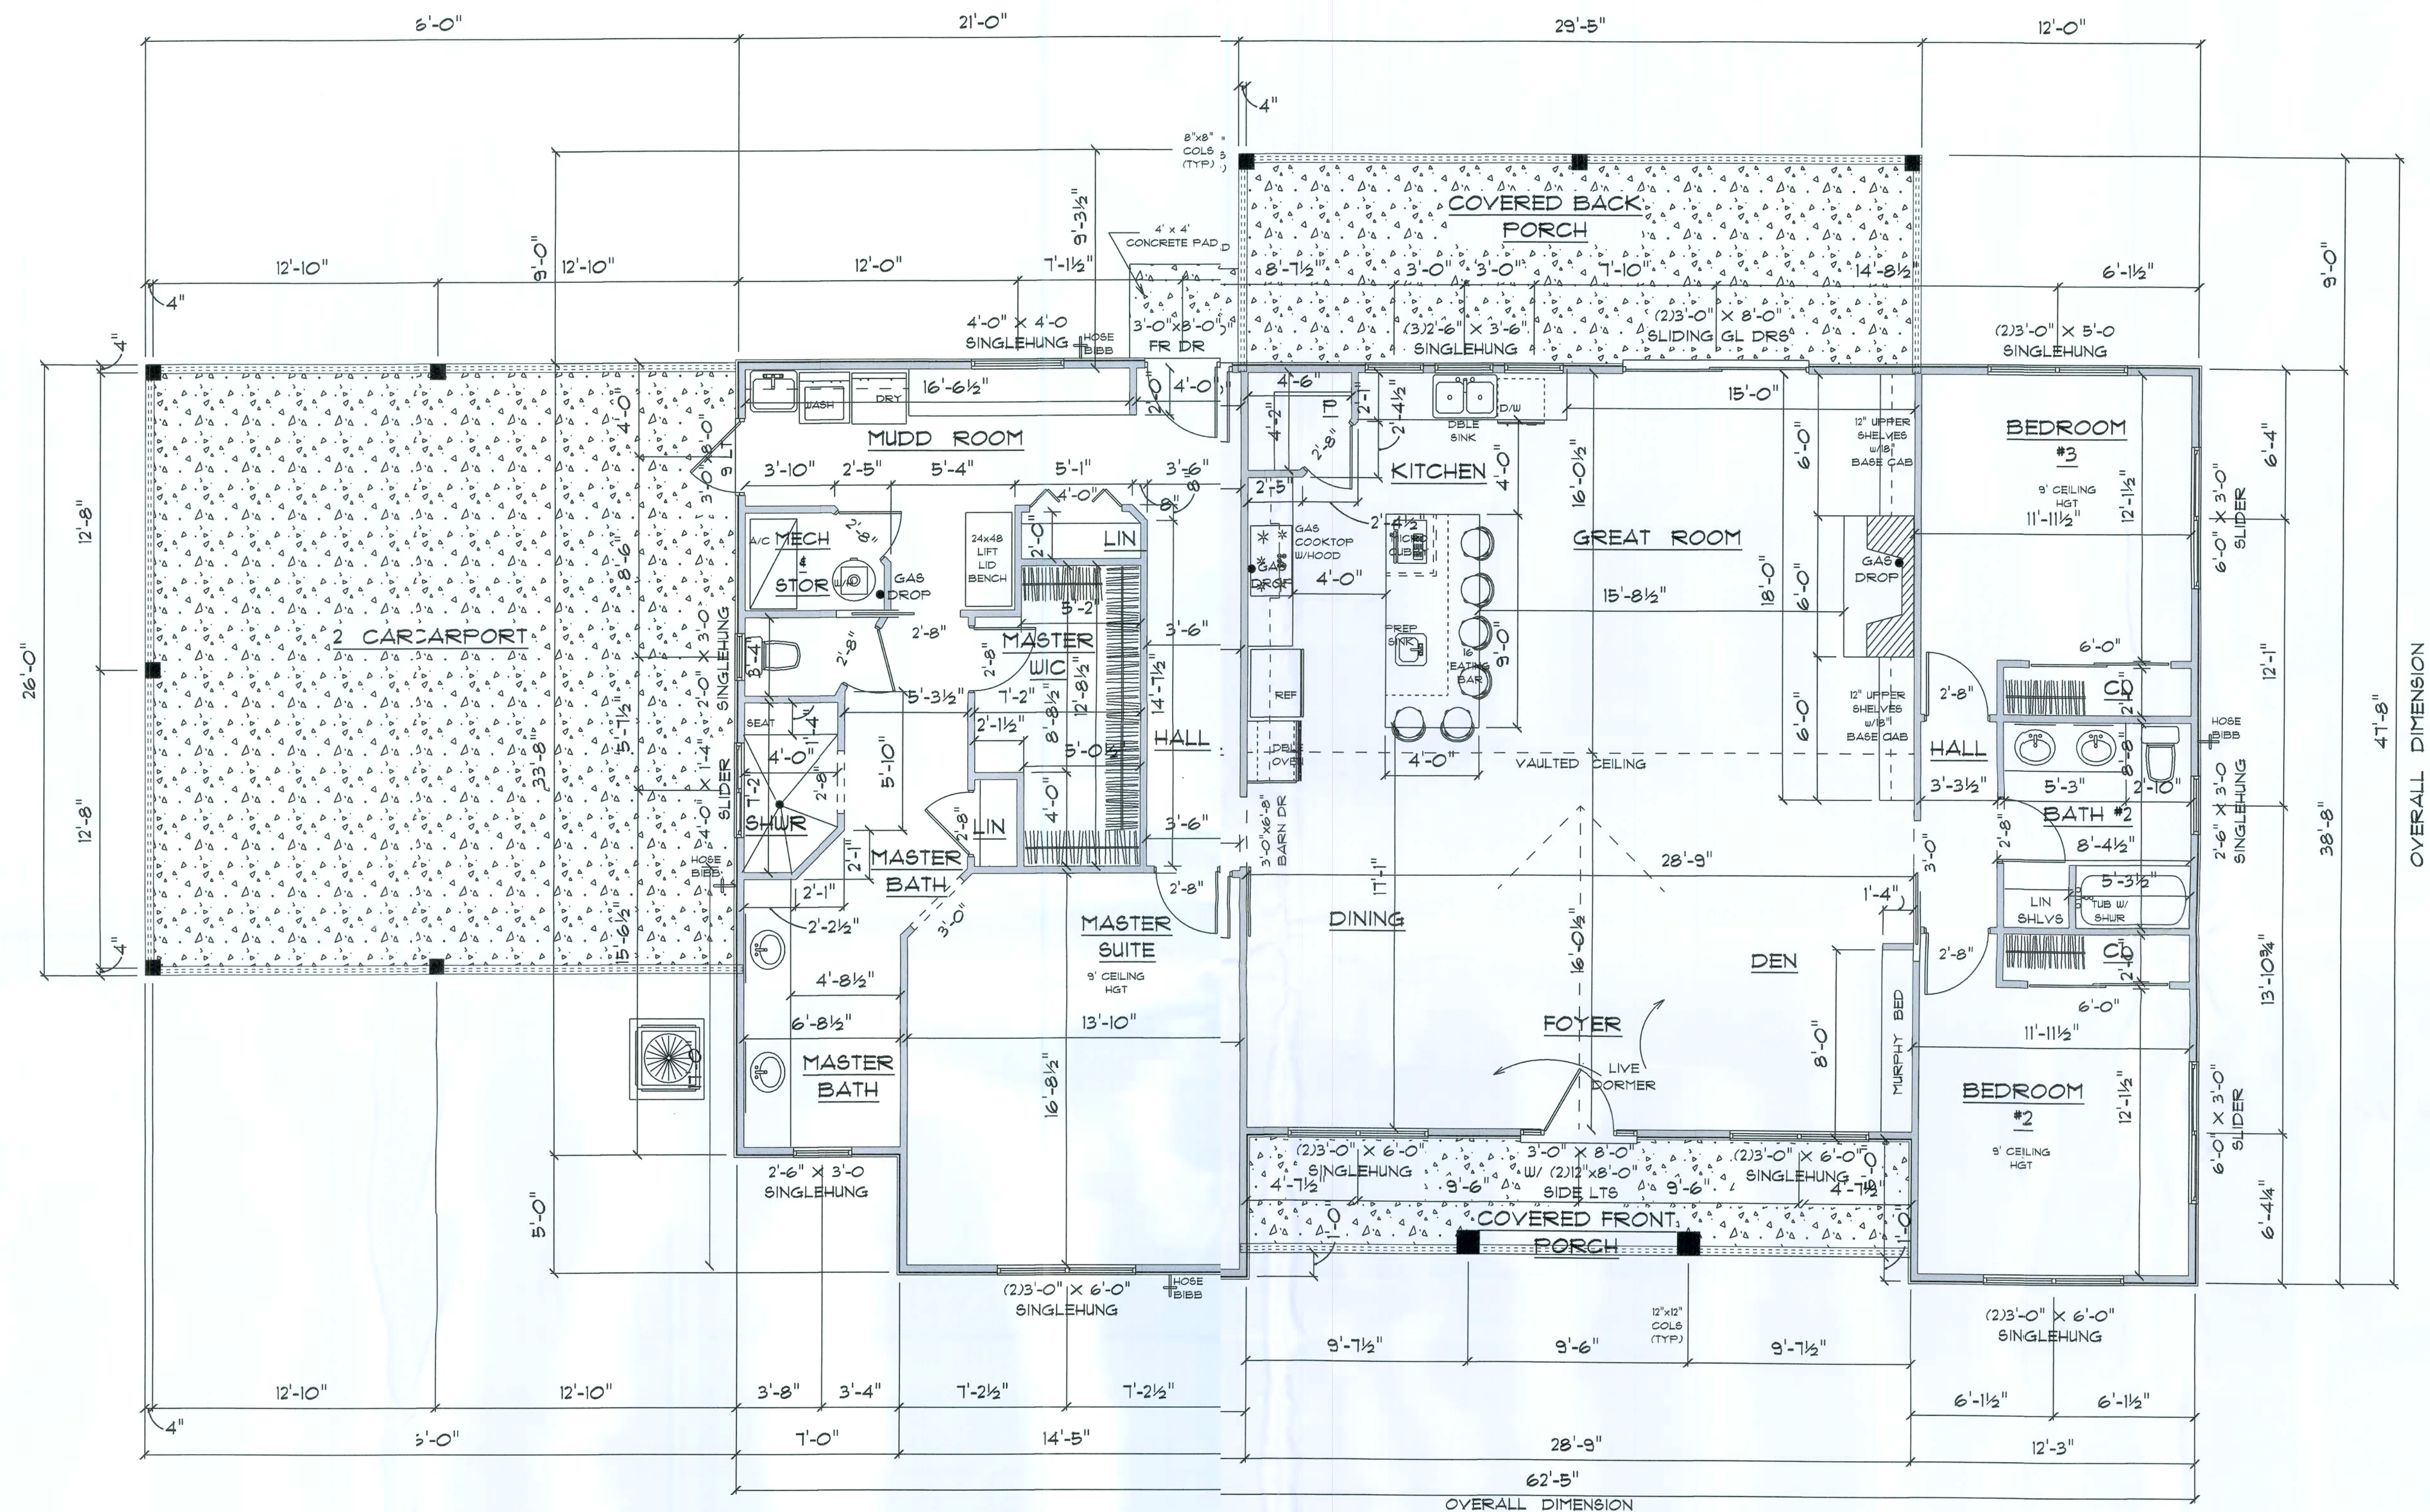

* FLOOR PLAN *

SCALE : 1/4" = 1'-0"

IMPORTANT NOTES:

1. IT IS THE BUILDERS RESPONSIBILITY TO VERIFY ALL GEOMETRY AND DIMENSIONS BEFORE ORDERING ANY MATERIALS OR BEGINNING CONSTRUCTION.
2. THESE PLANS ARE FOR LAYOUT AND DESIGN PURPOSES ONLY ALL STRUCTURAL NOTES AND DETAILS TO BE PROVIDED BY AN ENGINEER.

A/C LIVING AREA	=	2216 S.F.
COVERED ENTRY	=	139 S.F.
COVERED BACK PORCH	=	265 S.F.
2 CAR CARPORT	=	676 S.F.
TOTAL AREA UNDER ROOF	=	3,296 S.F.

RESIDENCE
for
CLINTON & KELLEY
STANDRIDGE

BRANDFORD, FLORIDA

Teresa M. Ruffo
2925 SU GR 41
Lake City Florida, 32025
Cell: (386) 861-181
Email: tesaruffo@gmail.com

PRINTED DATE:
Thursday, March 21, 2021

DRAWN BY: T. M. Ruffo CHECKED BY:

BUILDING CONTRACTOR


FINALS DATE:

JOB NUMBER:

DRAWING NUMBER

A-3


OF 6 SHEETS

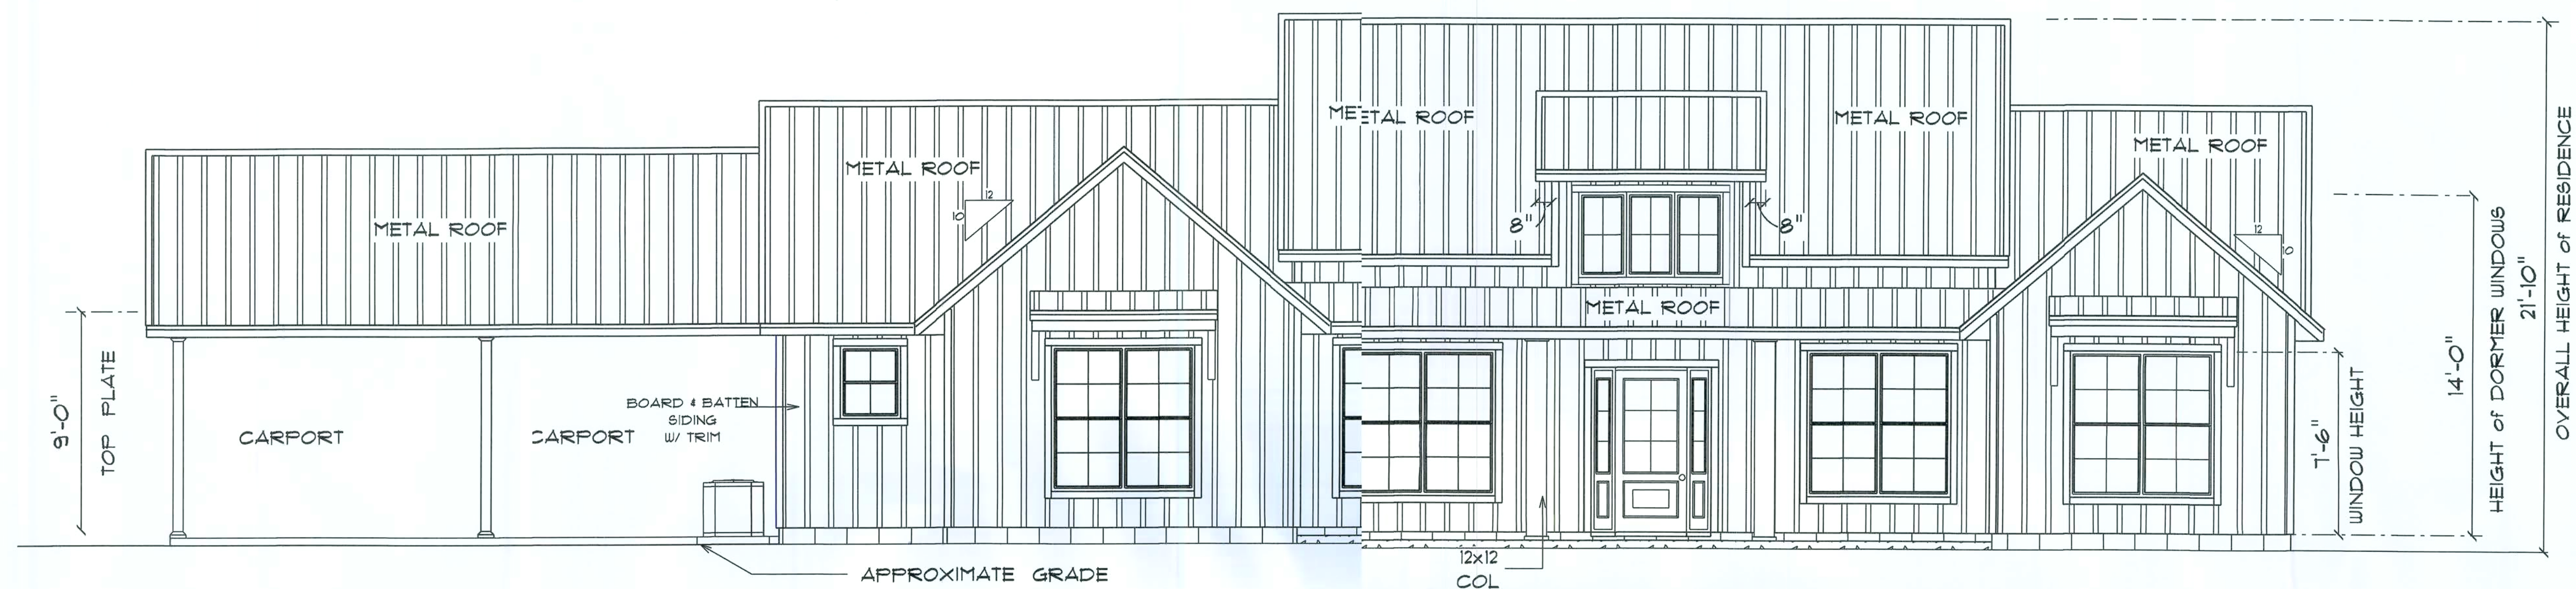

* FRONT ELEVATION *

NOTE:
12" OVERHANG ON GABLE ENDS
18" ON ALL OTHER EAVES

SCALE : 1/4" = 1'-0"

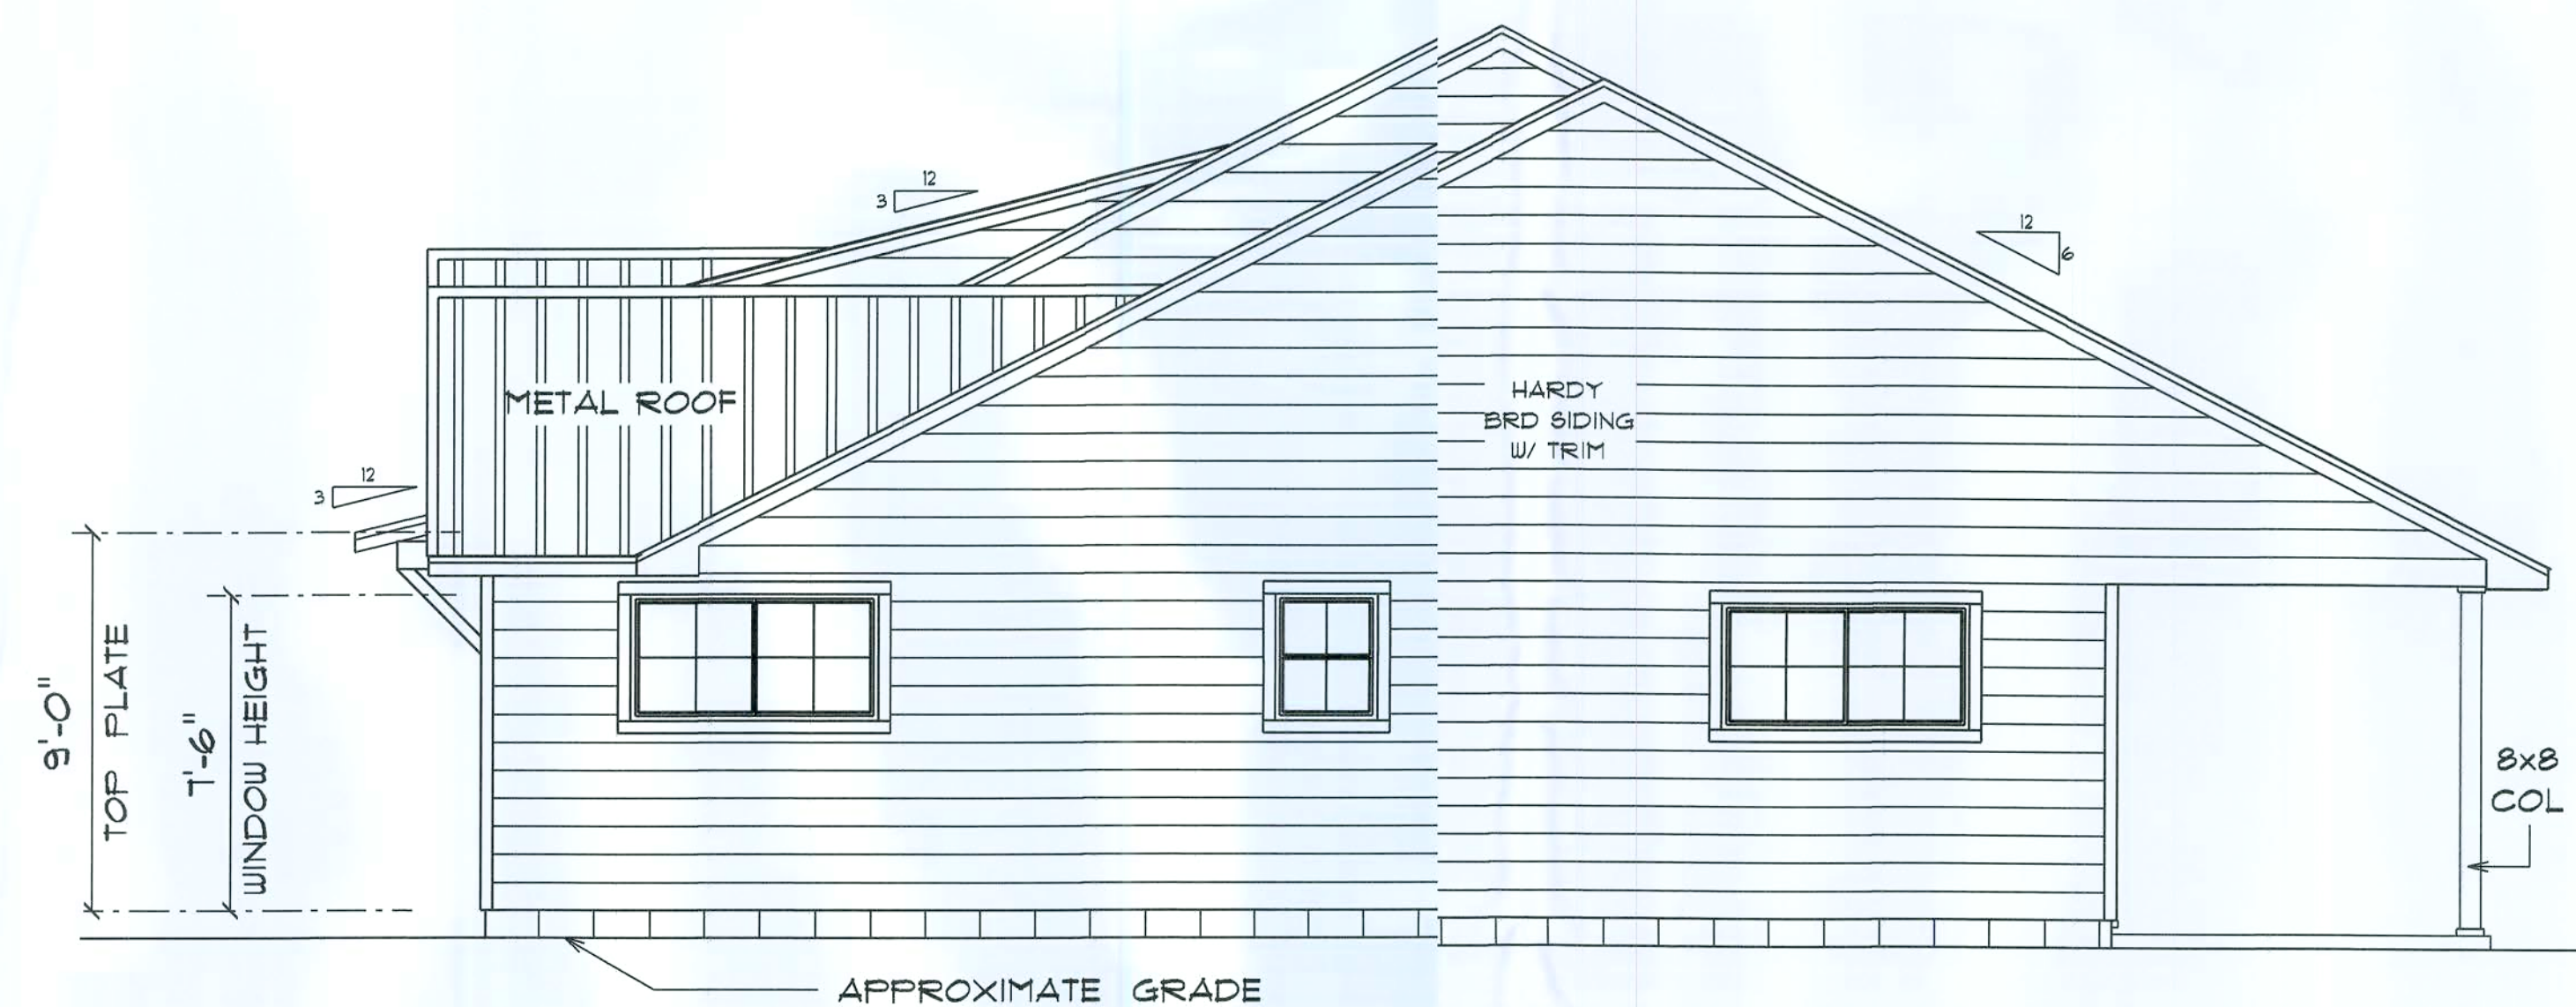

* RIGHT SIDE ELEVATION *

SCALE : 1/4" = 1'-0"

RESIDENCE
for
CLINTON & KELSEY
STANDRIDGE

BRANDFORD, FLORIDA

Teena M. Ruffo
2925 SW 5th St. 411
Lake City, Florida, 3203
Cell: (386) 861-1181
Email: teenaruffo@gmail.com

PRINTED DATE:
Thursday, March 25, 2021

DRAWN BY: Teena M. Ruffo CHECKED BY:

BUILDING CONTRACTOR

FINALS DATE:

JOB NUMBER:


DRAWING NUMBER

A-4
OF 6 SHEETS



* REAR ELEVATION *

SCALE : 1/4" = 1'-0"

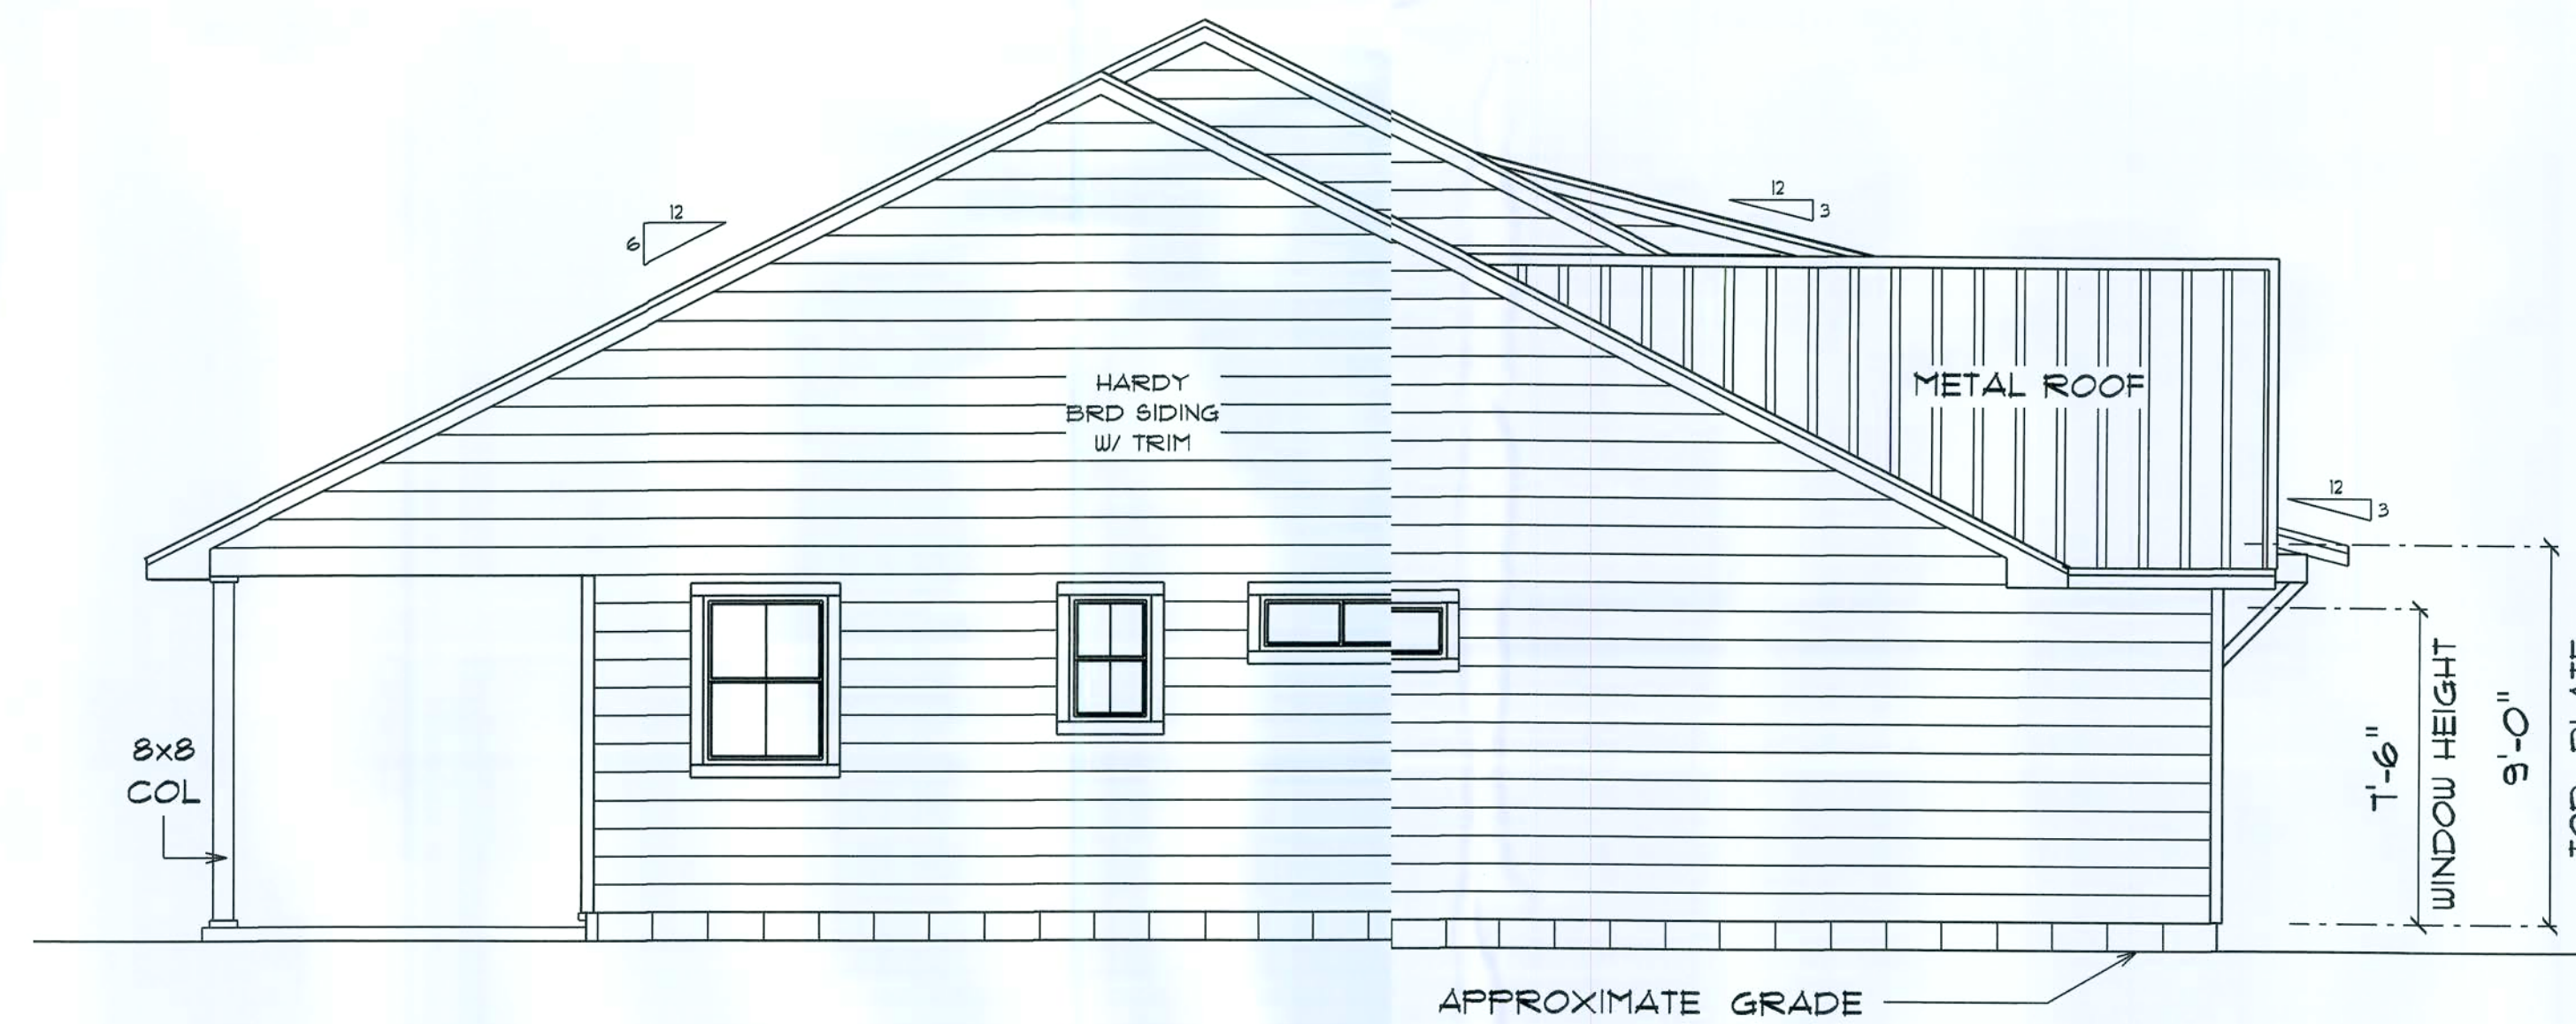

* LEFT SIDE ELEVATION *

SCALE : 1/4" = 1'-0"

RESIDENCE
for
CLINTON & KELSER
STANDRIDGE

BRANDFORD, FLORIDA

Teena M. Ruffo
2925 SW 5R 41
Lake City, Florida, 32025
Call: (386) 861-1191
Email: teenaruffo@gmail.com

PRINTED DATE:
Thursday, March 25, 2021

DRAWN BY: Teena M. Ruffo
CHECKED BY:


BUILDING CONTRACTOR

FINALS DATE:

JOB NUMBER:

DRAWING NUMBER

A-5
OF 6 SHEETS

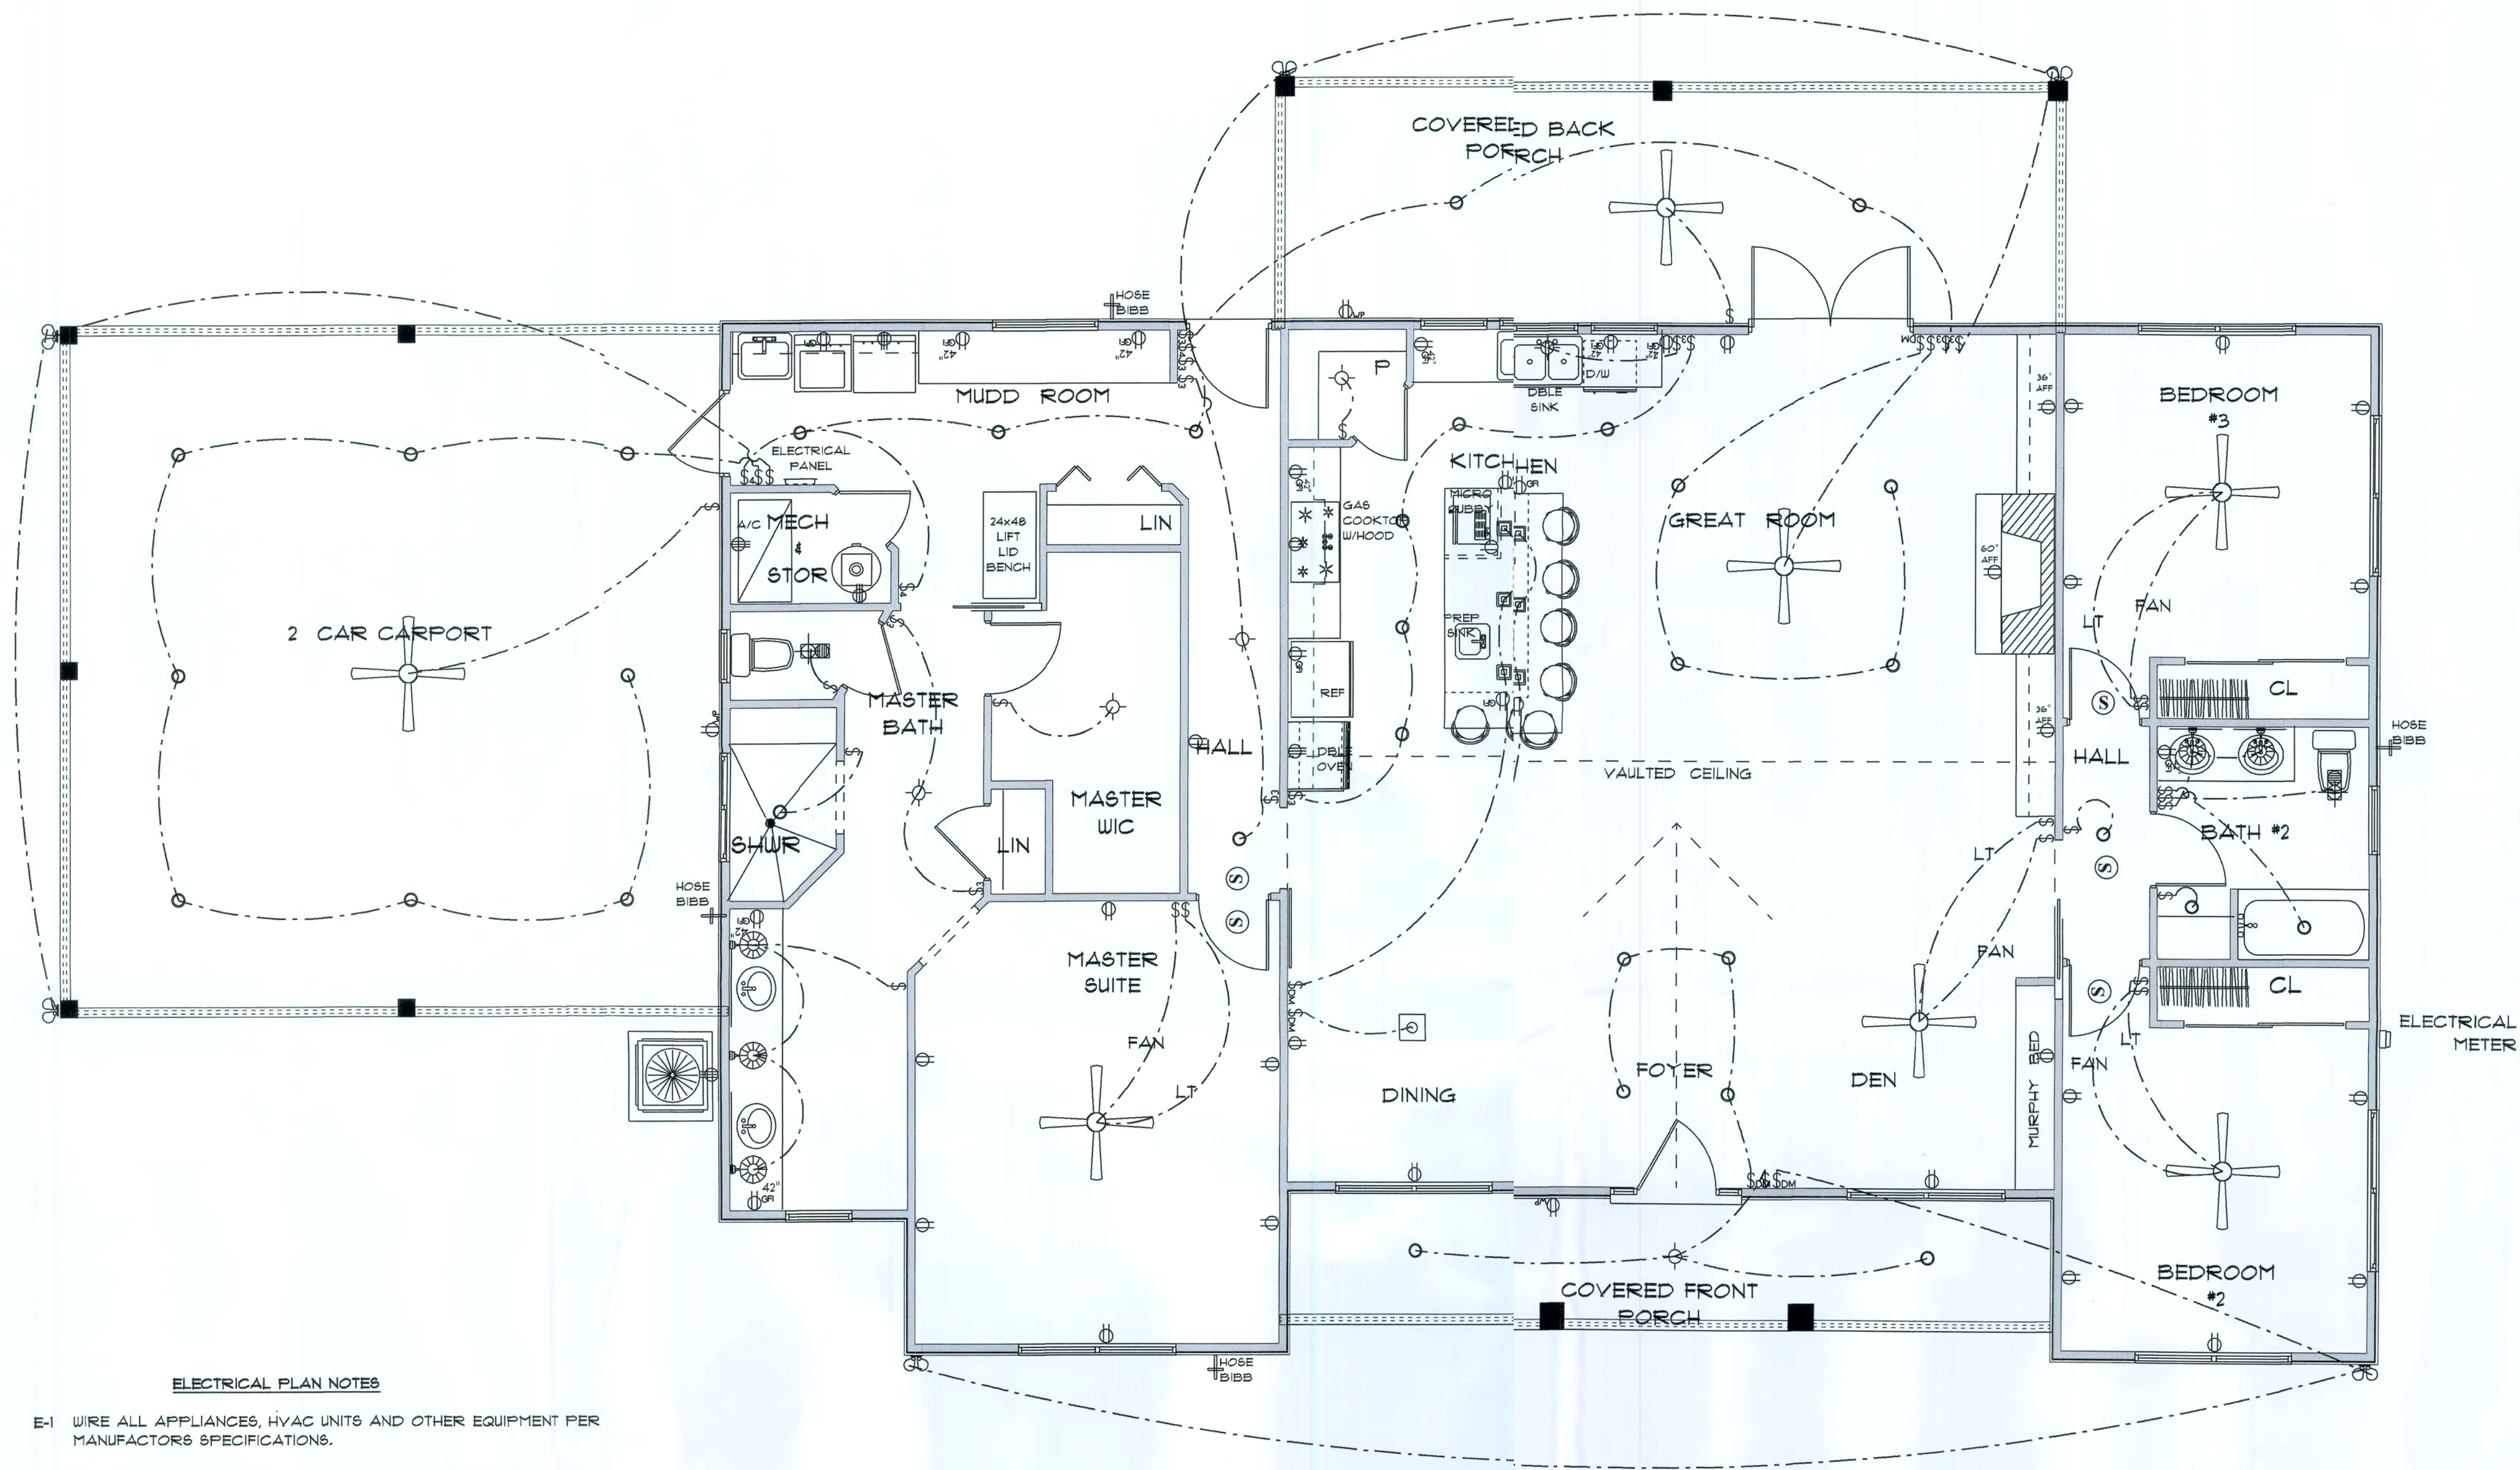

ELECTRICAL LEGEND		
ELECTRICAL	COUNT	SYMBOL
ceiling fan globe 01	7	
ceiling dish square	1	
pendant large	3	
pot light	33	
spotlight double	6	
Smoke Detector	5	
electrical panel	1	
dimmer switch	5	
light	6	
outlet	27	
outlet 220v	5	
outlet gfi	14	
outlet wp	3	
switch	26	
switch 3 way	10	
switch 4 way	3	
vent light combo	2	
wall mounted 12 1 light	5	

ELECTRICAL PLAN NOTES

- E-1 WIRE ALL APPLIANCES, HVAC UNITS AND OTHER EQUIPMENT PER MANUFACTURER'S SPECIFICATIONS.
- E-2 ALL INSTALLATIONS SHALL BE PER NATIONAL ELECTRIC CODE.
- E-3 ALL SMOKE /CARBON MONOXIDE DETECTORS SHALL BE 120V W/BATTERY BACKUP OF THE PHOTOELECTRIC TYPE, AND SHALL BE INTERLOCKED TOGETHER. INSTALL INSIDE AND NEAR ALL BEDROOMS AS PER CODE.
- E-4 TELEPHONE, TELEVISION AND OTHER LOW VOLTAGE DEVICES OR OUTLETS SHALL BE AS PER THE OWNER'S DIRECTION AND IN ACCORDANCE WITH APPLICABLE SECTIONS OF NATIONAL ELCT. CODE LATEST EDITION.
- E-5 ELECTRICAL CONTRACTOR SHALL BE RESPONSIBLE FOR THE DESIGN AND SIZING OF ELECTRICAL SERVICE AND CIRCUITS.
- E-6 ENTRY OF SERVICE UNDERGROUND OR OVERHEAD) IS TO BE DETERMINED BY THE POWER COMPANY.
- E-7 ALL BEDROOM RECEPTICALS ARE TO BE AFCI (ARC FAULT CIRCUIT INTERRUPT)
- E-8 75% OF ALL PERMANENT LIGHTS TO BE ENERGY EFFICIENT.

* ELECTRICAL PLAN *

SCALE : 1/4" = 1'-0"

RESIDENCE for CLINTON & KELSEY STANDRIDGE

BRANDFORD, FLORIDA

Teresa M. Ruffo
2325 SW 5th St. 41
Lake City, Florida 32025
Cell: (386) 867-1191
Email: tesaruffo@gmail.com

PRINTED DATE:
Thursday, March 25, 2021

DRAWN BY: Teresa M. Ruffo CHECKED BY:

BUILDING CONTRACTOR

FINALS DATE:


JOB NUMBER:

DRAWING NUMBER

A-6
OF 6 SHEETS

IF VENT CALCULATION				
FORMULA				
1 SQUARE INCH EVERY 300 SQUARE INCHES OF CEILING 1.44 SQUARE INCHES = 1 SQUARE FOOT BUILDING CEILING (FT) X 1.44 = BUILDING (SQ IN) BUILDING (SQ IN) ÷ 300 = SQ IN OF VENT REQUIRED SQ IN OF VENT DIVIDED BY 50 = SQ FT VENT AND 30% AT LOW				
PER REC. SECTION 2, 40% MIN, BUT NOT MORE THAN 30% OF VENTILATION MUST BE PROVIDED BY VENTILATORS LOCATED A MIN 3'-0" ABOVE				
BASE OF CALCUL:				
(A) OFF EDGE VENT - STAMPED W/ 34 SQ IN (NPV) PER LINEAL FT				
(B) SLOTTED VENT 13-1/8" FULL VENT PERFORATED W/ 9-1/8 SQ IN NPV PER LINEAL FT				
CALCULATED UNFOOT OF SLOTTED VENT SHALL NOT INCLUDE NON-VENTED PARTED SLOTTED LOCATED LESS THAN 9' FROM PROPERTY LINE				
AREA (SQ FT)	REQUIRED (SQ IN)	PROVIDED (SQ IN)	LINEAL (FT)	LOW (SQ IN)
100	144	144	10	144
200	288	288	20	288
300	432	432	30	432
10000	14400	14400	1000	14400

NOTE
7/16" O.S.B. NAILED WITH 8D 6"
O.C. IN FIELD 4" O.C. ON EDGES

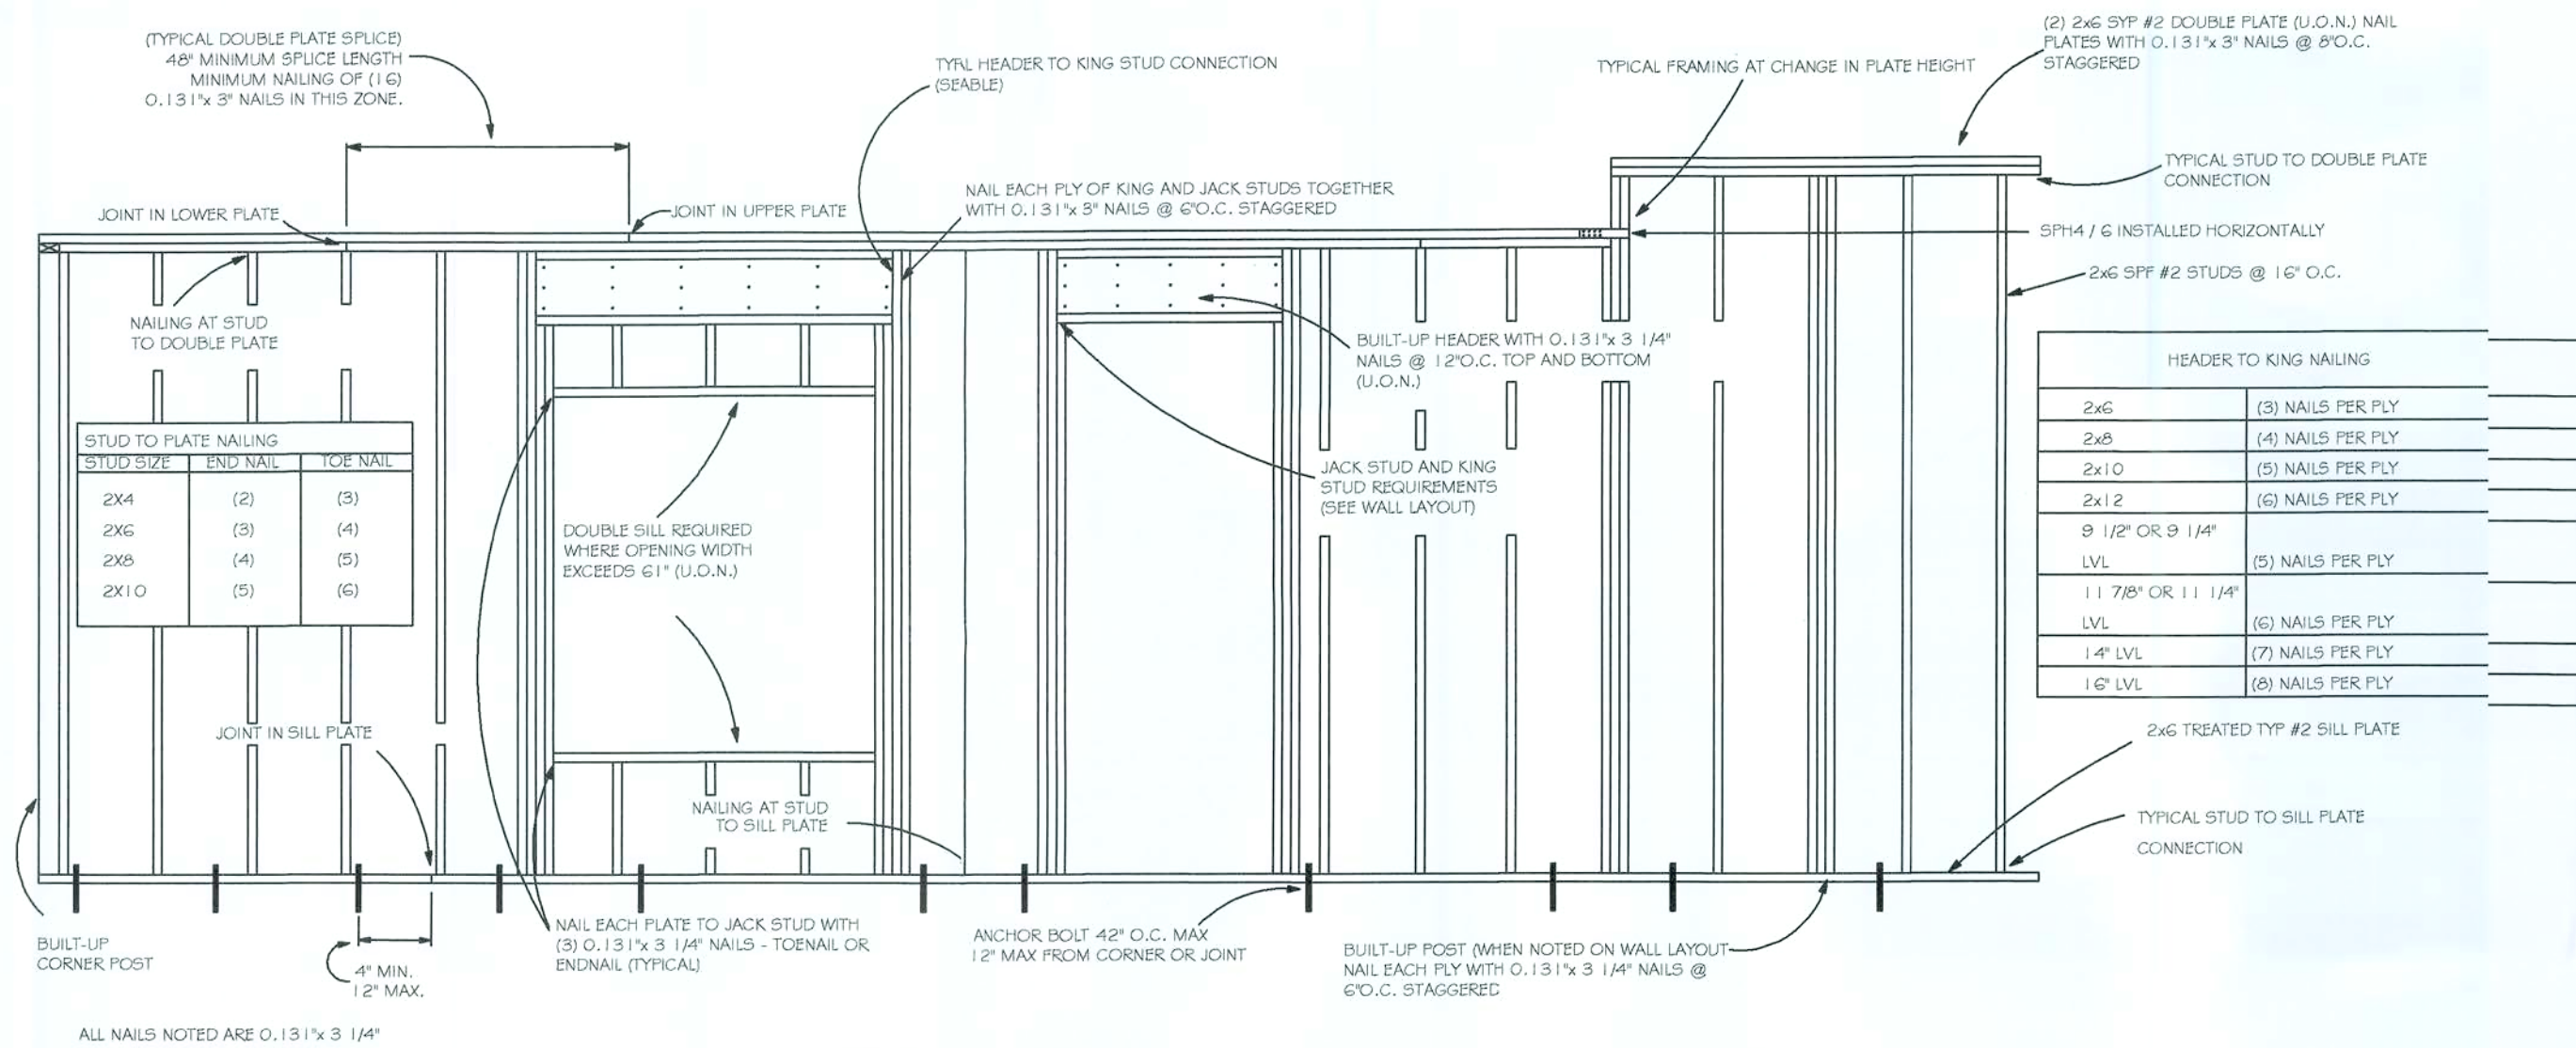

TYPICAL ALL FRAMING
NOT TO SCALE

NOTE

Simpson Strong-Tie Co. Strong-Drive SDWC TRUSS Screws may be used for uplift connection in lieu of straps. Strong-Drive SDWC TRUSS Screws to be installed per manufacturer's specifications.

Simpson Strong-Tie Co. Titen HD Heavy-Duty Screw Anchors 5/8" x 8", maximum spacing of 42" o.c., may be used in lieu of 5/8"x10" anchor bolts with 3/32"x1/8" washers. Titen HD Heavy-Duty Screw Anchors shall be installed per manufacturer's specifications.

ROOF SHEATHING FASTENING

- 4" O.C. GABLE END
 - 6" O.C. EDGES (ALL ZONES)
 - 6" O.C. INTERMEDIATE FRAMING (ZONE 3)
 - 12" O.C. INTERMEDIATE FRAMING (ZONES 1 & 2)
- SEE FIGURE R803.2.3.1, SECTION R803.1, 2017 FLORIDA BUILDING CODE - RESIDENTIAL, SIXTH EDITION FOR ROOF SHEATHING NAILING ZONES

ROOF NOTES

ROOF PITCH LESS THAN 4/12 DEL. LAYER OF UNDERLAYMENT IS REQUIRED OVERLAP ROOFING UNDERLAYMENT 4" MIN. OVER HIP AND RIDGES


BUTTON CAP NAILS ARE USED TO FASTEN UNDERLAYMENT TO ROOF DECK WHEN SHINGLES NOT INSTALLED SAME DAY

DRIP EDGE INSTALLED OVER THE UNDERLAYMENT AT RAKES AND UNDER THE UNDERLAYMENT AT EAVES


ALL ROOF PENETRATIONS ARE PROPERLY FLASHED W/ FLASHING OF THE CORRECT SIZE FOR THE PENETRATION

METAL ROOFING ATTACHED W/ CORRECT FASTENERS PER CODE AND MANUFACTURER'S SPECS


1" SPACE IS MAINTAINED BETWEEN THE END OF THE GUTTER AND THE WALL CLADDING

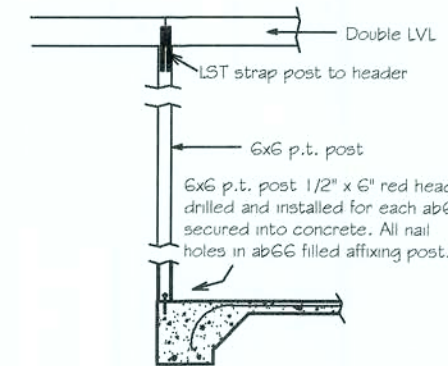


LVL CONNECTION DETAIL
NOT TO SCALE

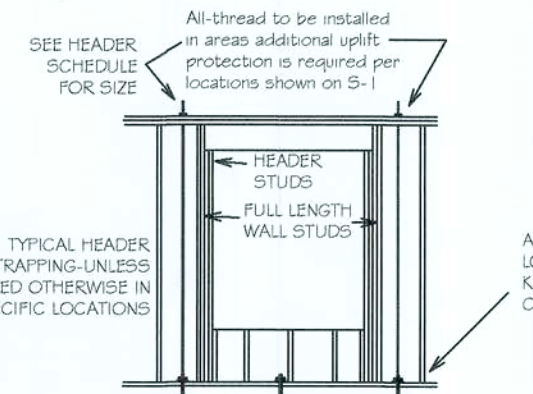


TYPICAL ALL THREAD DETAIL
NOT TO SCALE

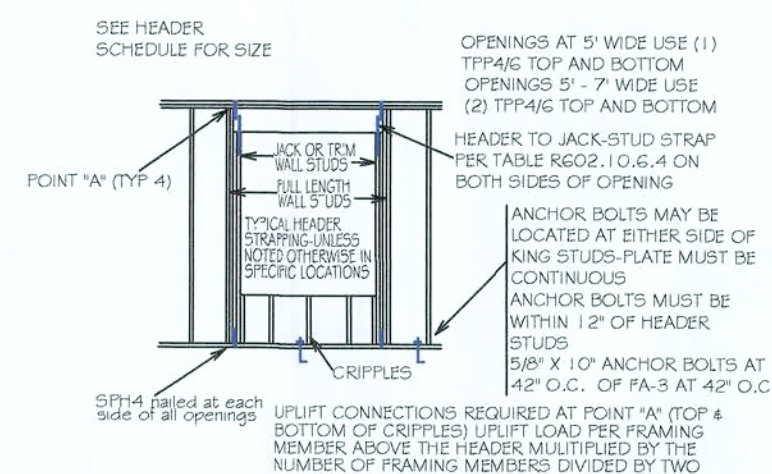

TYPICAL HEADER STRAPPING
NOT TO SCALE

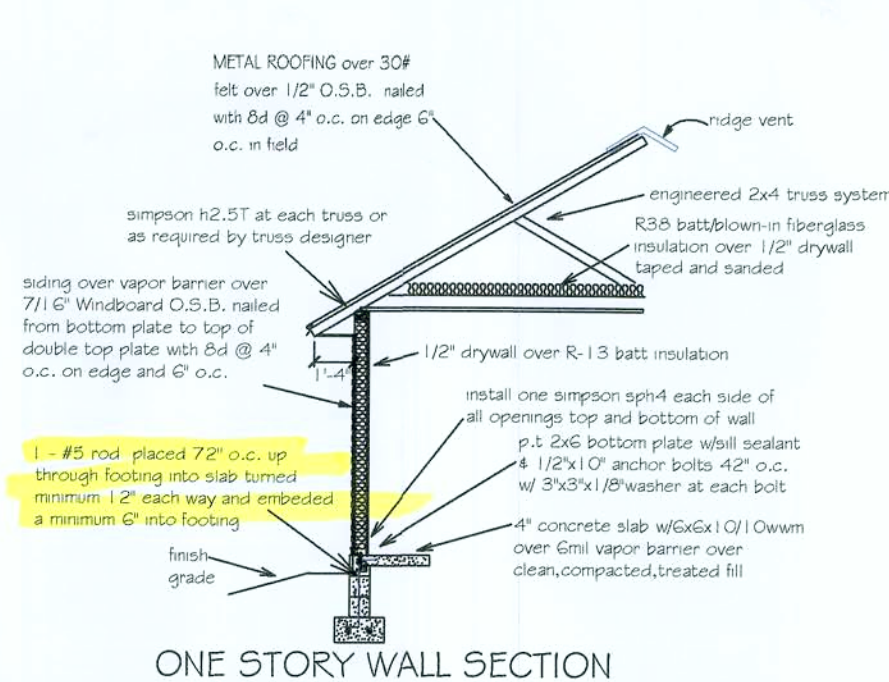

ONE STORY WALL SECTION

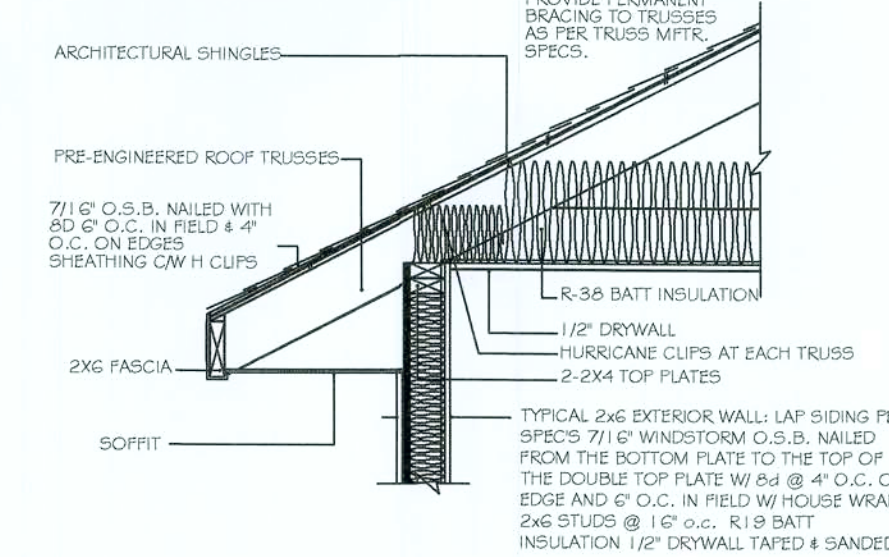

4" STUD EAVE

HEADER SCHEDULE		
2X STUD CONTINUOUS TO TOP PLATE	HEADER - CONTINUOUS	
2X STUDS UNDER LVL WITH OPENINGS LARGER THAN 5'-0"		
NOTE: UPLIFT CONNECTION IS REQUIRED AT EACH END OF HEADER AND AT BOTTOM OF HEADERS STUDS IN ADDITION TO CONNECTORS AT WALL STUDS AND AT TOP AND BOTTOM OF CRIPPLES		
MAXIMUM HEADER SPAN		
0'-0" TO 3'-0"	2'-2 x 6s	2'-2 x 4s
3'-1" TO 9'-0"	2'-2 x 10s	2'-2 x 8s
9'-1" TO 7'-0"	2'-2 x 10s	2'-2 x 8s
7'-1" TO 10'-0"	2'-2 x 10s	2'-2 x 10s
NUMBER OF HEADER STUDS (JACKS) SUPPORTING END OF HEADER		
1	2	2
NUMBER OF FULL LENGTH STUDS (KINGS) AT END OF HEADER		
2		




Carol Chadwick, PE
c=Carol
Chadwick, PE
=This item has
been electronically
signed and sealed
by Carol Chadwick,
PE using a digital
signature. c=U
mail.com, c=US
2021.05.11
11:22:31-0400'

CAROL CHADWICK
CLINTON & KELSEY STANDARDS
3545 5th Ave. S.W.
Tomball, TX 77375
www.carolchadwick.com






STANDRIDGE RESIDENCE
FRAMING DETAILS

DATE: 5-2

- DESIGN SPECIFICATIONS
- DESIGN CODES:
 - 2020 FLORIDA BUILDING CODE (FBC) - RESIDENTIAL
 - ASCE 7-10, 2005
 - ND5, ACI, ATC, AWPA, APA, ICC 600-08
 - OCCUPANCY: RESIDENTIAL GROUP R-3 (ONE- AND TWO-FAMILY DWELLINGS)
 - DESIGN LOADS:
 - ROOF TRUSSES:
 - LL 20 PSF TOP CHORD
 - LL 0 PSF BOTTOM CHORD
 - DL 7 PSF TOP CHORD
 - DL 5 PSF BOTTOM CHORD
 - ROOF CONVENTIONAL FRAMING:
 - LL 20 PSF RAFTERS
 - LL 20 PSF CEILING JOISTS
 - DL 10 PSF RAFTERS
 - DL 10 PSF CEILING JOISTS
 - DL 30 PSF ATTICS WITH STORAGE
 - DL 10 PSF ATTICS W/O STORAGE
 - FLOORS:
 - LL 40 PSF TOP CHORD
 - LL 0 PSF BOTTOM CHORD
 - DL 10 PSF TOP CHORD
 - DL 5 PSF BOTTOM CHORD
 - MAXIMUM HEIGHT OF STRUCTURE: 20'-11"
 - NUMBER OF STORIES: 1
 - TYPE OF CONSTRUCTION: TYPE V-G, UNPROTECTED, UNSPRINKLERED
 - WIND ZONE INFORMATION:
 - BUILDING: ENCLOSED STRUCTURE
 - ULTIMATE DESIGN WIND SPEED: 130 MPH
 - NOMINAL DESIGN WIND SPEED: 110 MPH
 - BUILDING RISK CATEGORY: II
 - WIND EXPOSURE CATEGORY: C
 - INTERNAL PRESSURE COEFFICIENT: 0.18 CGPI ±

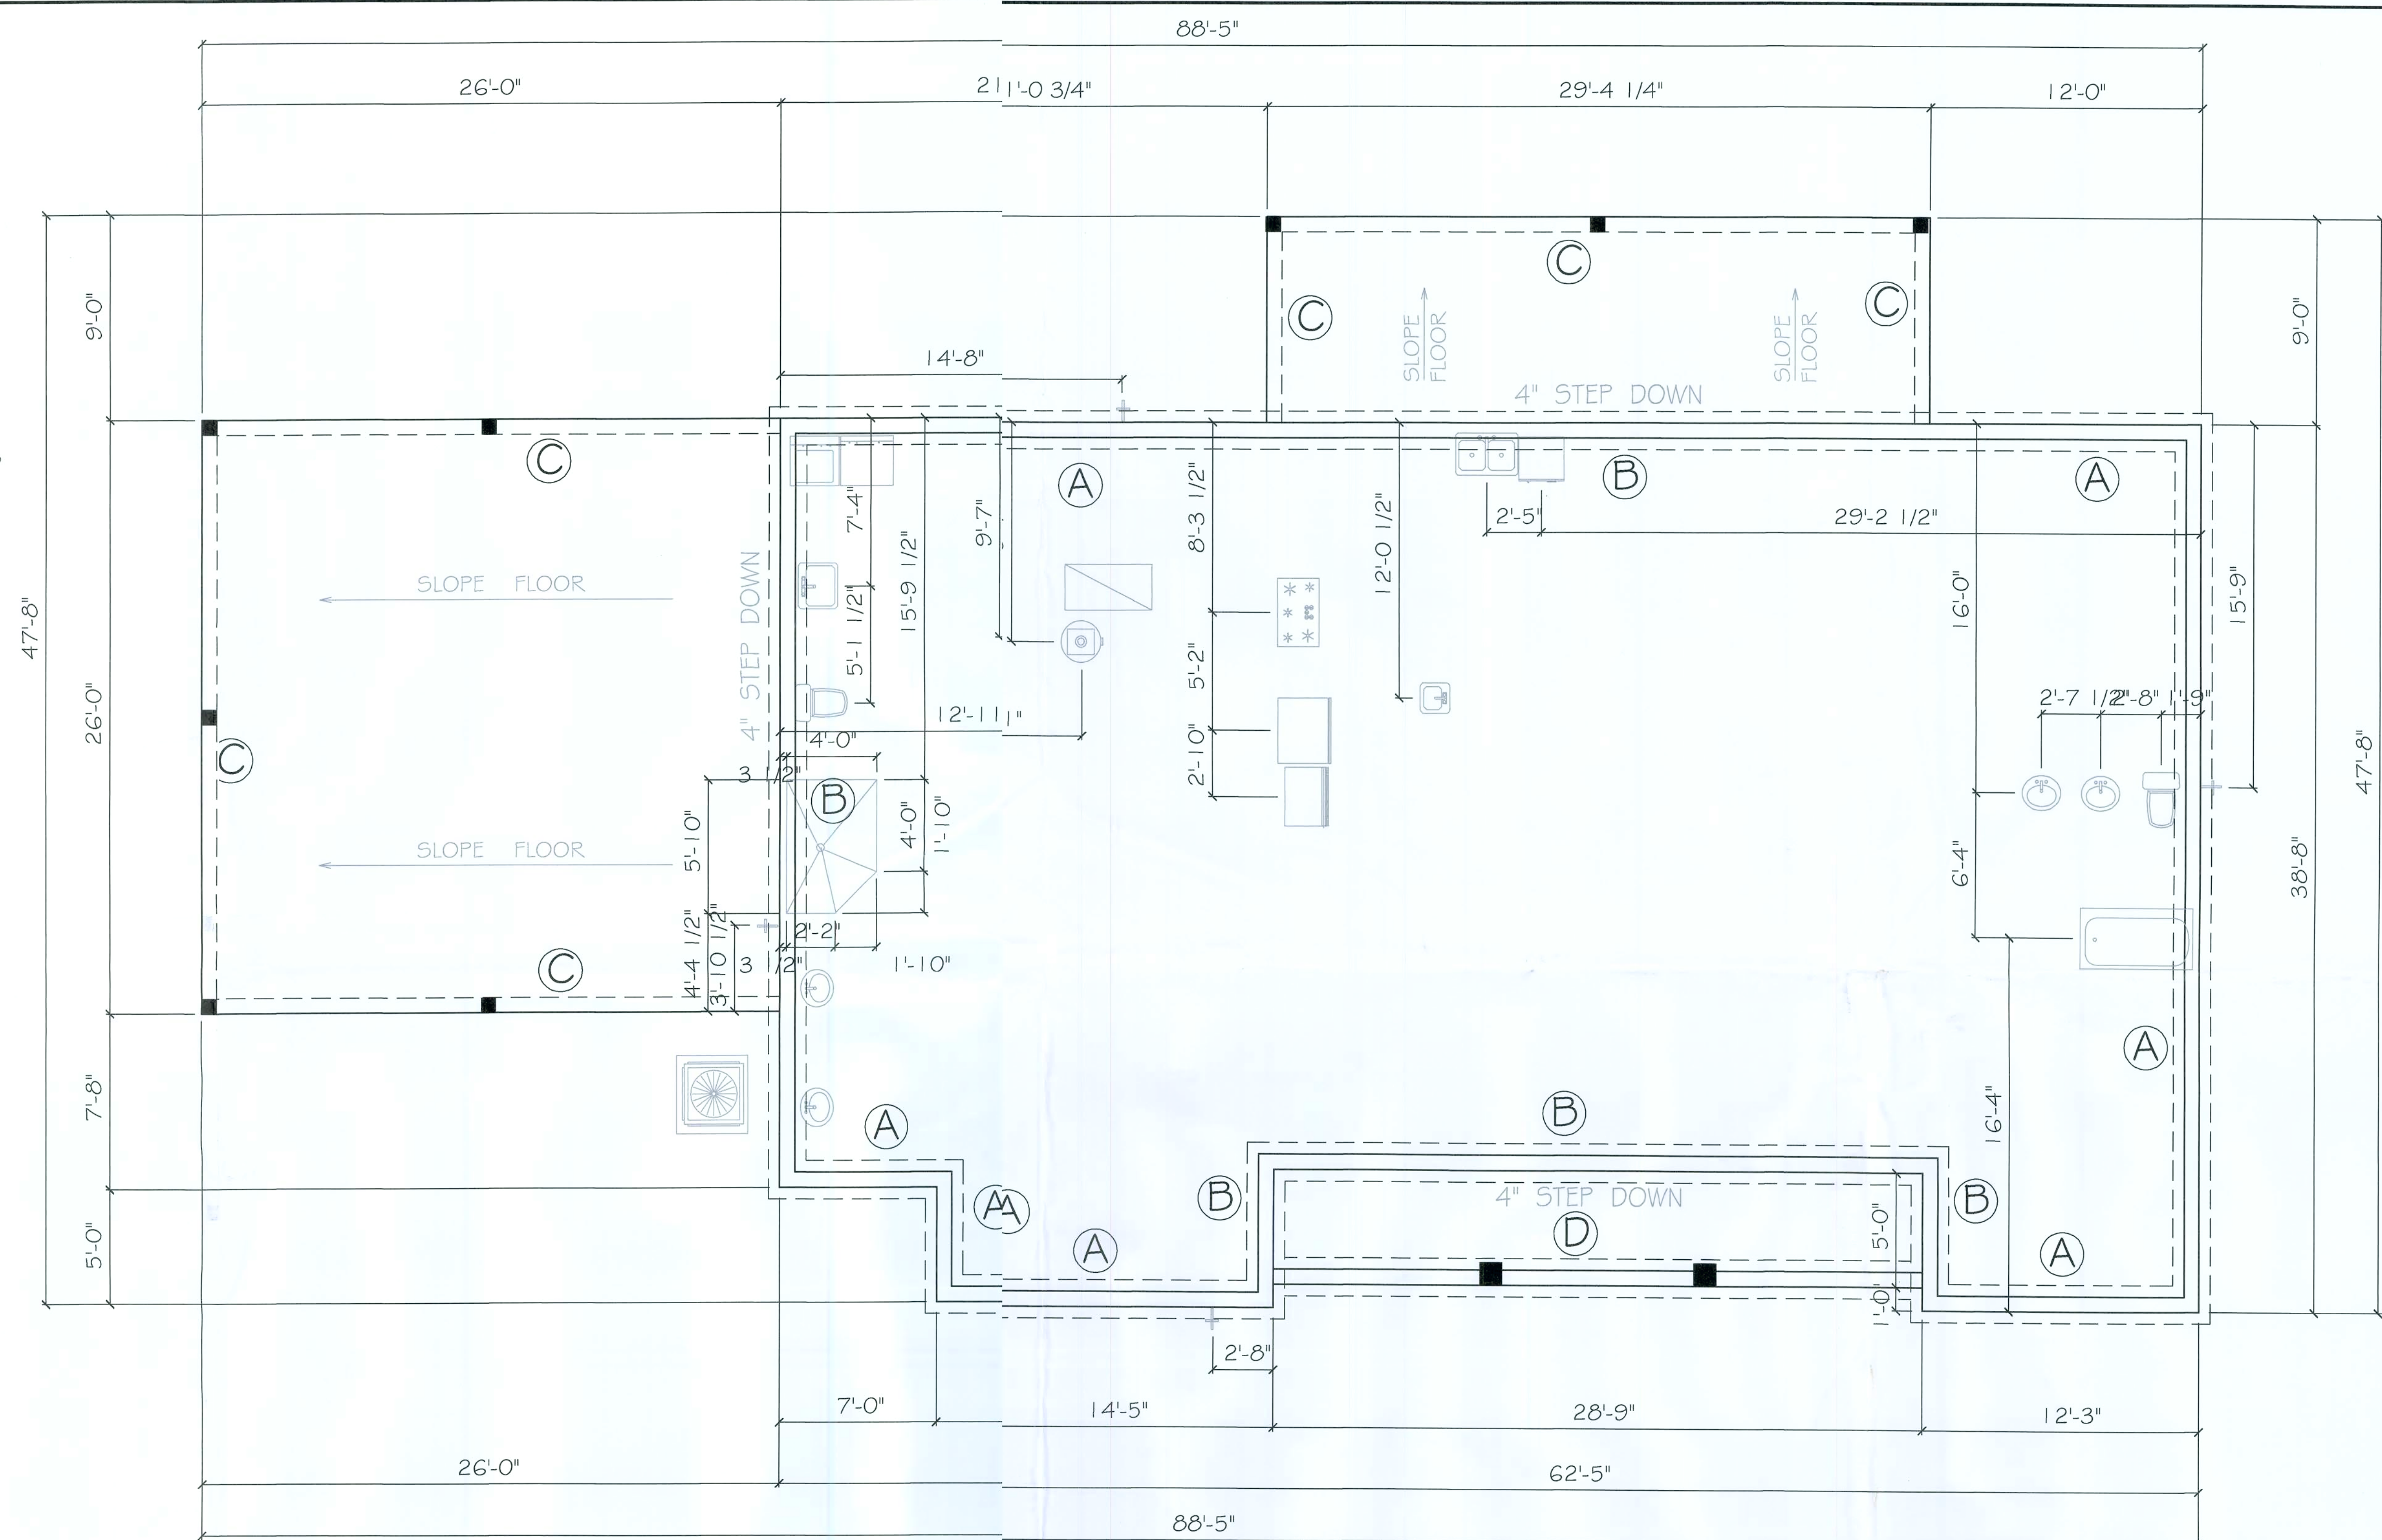

FOUNDATION PLAN
SCALE: 1/4" = 1'

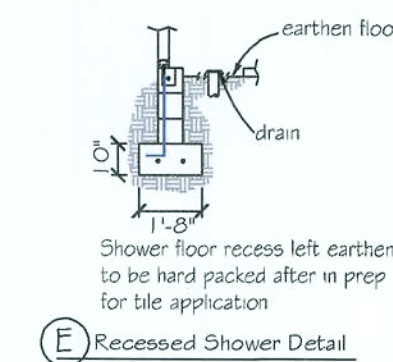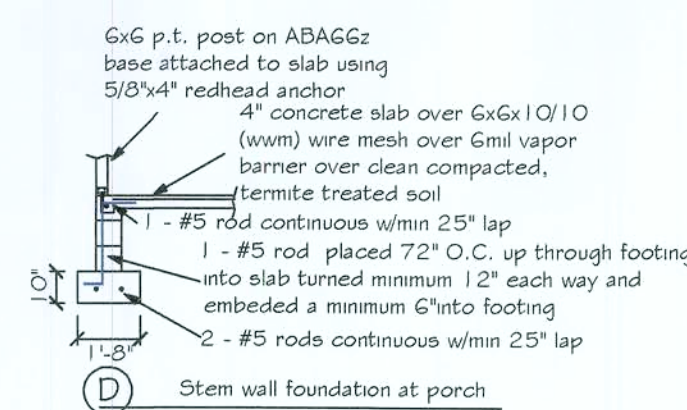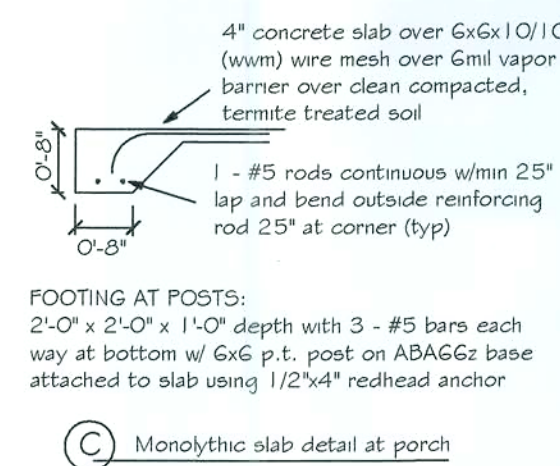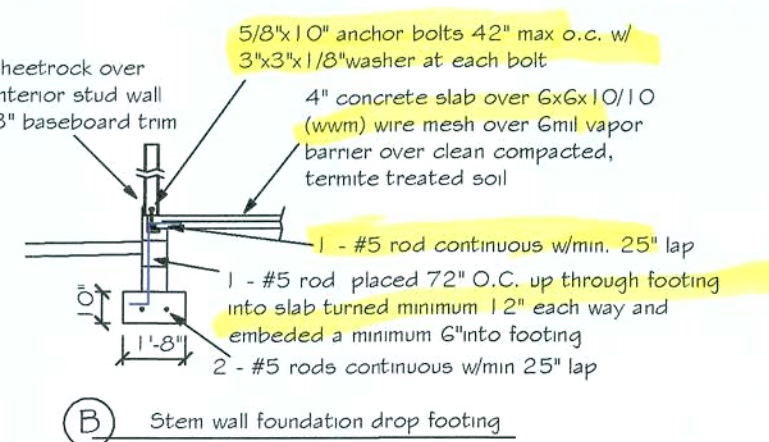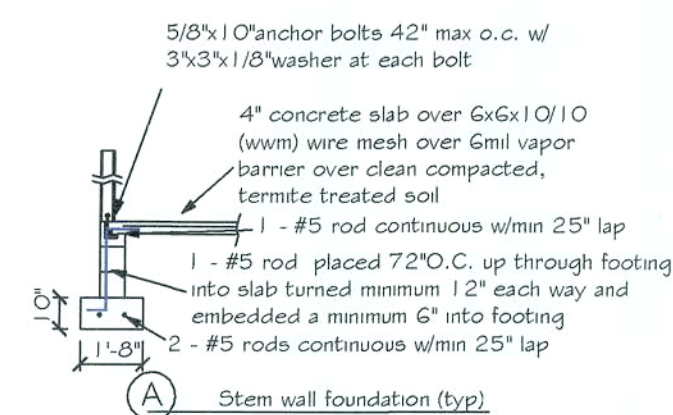

FOUNDATION NOTES

- REFER TO ARCHITECTURAL & BUILDING PLANS FOR ACTUAL DIMENSIONS, RECESSES IN SLAB, STEP DOWNS, ETC.
- CONTRACTOR SHALL VERIFY ALL ROUGH PLUMBING LOCATIONS WITH OWNER PRIOR TO POURING SLAB.
- THE SLAB SHALL BE 4" CONCRETE SLAB REINFORCED W/ 6X6-1.4/1.4 WELDED WIRE MESH PLACED ON CHAIRS 1 1/2" DEPTH OR FIBER MESH CONCRETE, 6-MIL POLY VAPOR BARRIER W/ 6" LAPS SEALED W/ POLY TAPE OVER TERMITE-TREATED & COMPACTED FILL.
- BOTTOM OF EXTERIOR FOOTINGS SHALL BE A MINIMUM OF 12" BELOW UNDISTURBED SOIL OR ENGINEERED FILL PER FBC-RES. SECTION R403.1.4

NOTE:
SOIL UNDER FOOTING SHALL BE COMPRESSED TO 2000 PSF AT 95% DENSITY. CONCRETE STRENGTH SHALL BE 2500 PSI



Card Chadwick, PE
on this item has been electronically signed and sealed by Card Chadwick, PE using a digital signature, cccpewoing mail.com, c4US 2021.05.11 11:22:10 -0400

STANDRIDGE RESIDENCE
FOUNDATION DETAILS

STANDRIDGE RESIDENCE
FOUNDATION DETAILS

