




Reviewed
3-29-12
#29724

Ossi & Myler, Inc.
CONSULTING ENGINEERS

LAWRENCE OSSI, P.E.
FL LIC #51463
ALONZO MYLER, P.E.
FL LIC #65533

Ossi & Myler, Inc.
No part of this work may be used,
reproduced, distributed, displayed
or otherwise communicated in any
form or by any means without
prior written consent of
Ossi & Myler, Inc.

CORPORATE OFFICE FOR:
CADY & CADY STUDIOS
496 SW RING COURT
LAKE CITY, FLORIDA 32025

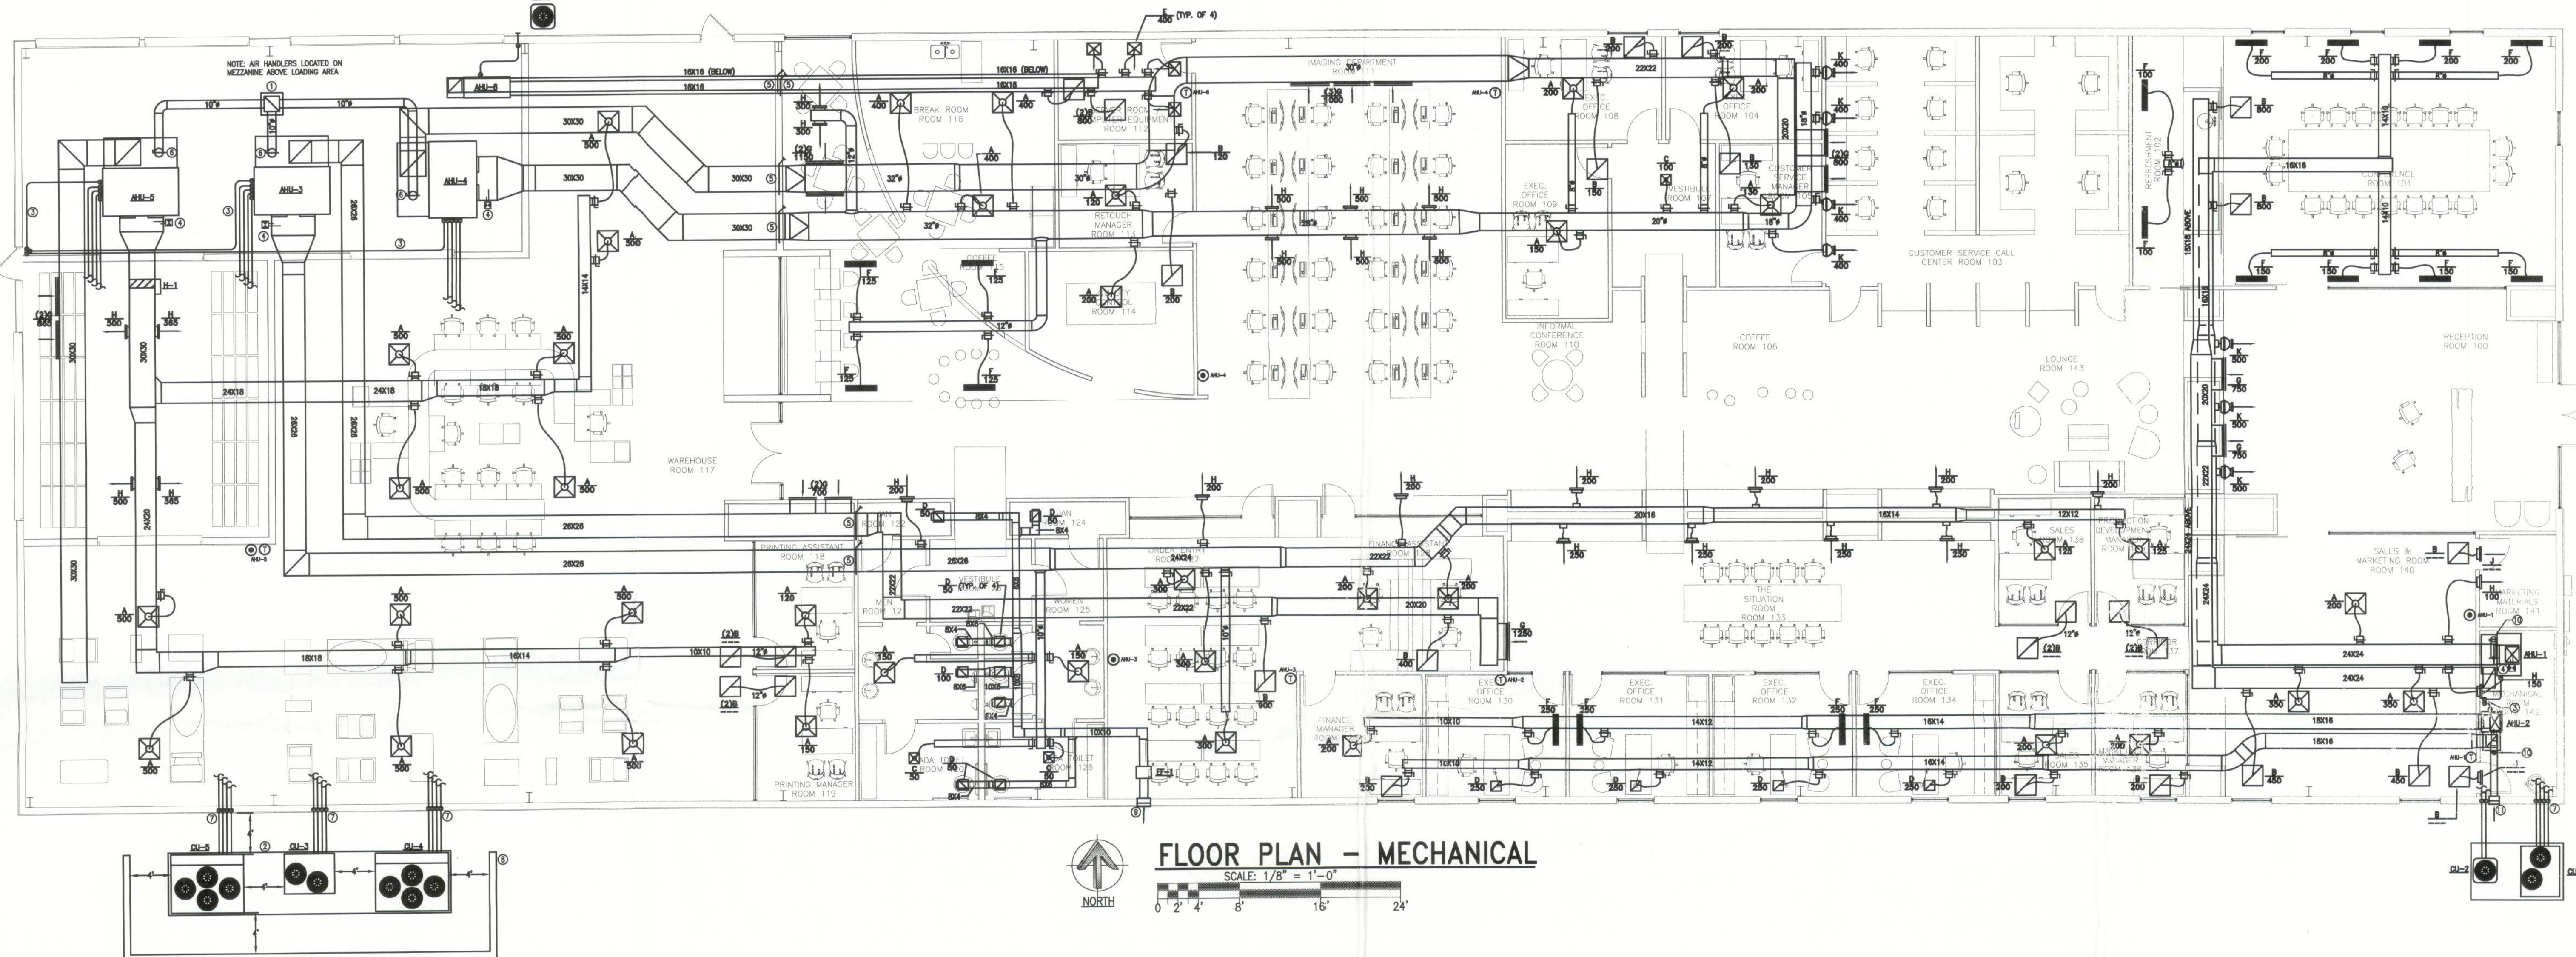

PLAN NOTES

- 18X18 GRAVITY INTAKE VENT, GREENHECK FABRA HOOD OR EQUAL, PROVIDE INSECT SCREEN AND MANUFACTURER'S ROOF CURB
- PROVIDE 4" CONCRETE HOUSEKEEPING PAD FOR CONDENSING UNITS, COORDINATE WITH GC AND STRUCTURAL, ALLOW CLEARANCES BETWEEN UNITS AND BUILDING WALL, PER MANUFACTURER'S REQUIREMENTS
- 1" CONDENSATE DRAIN TO HUB DRAIN, COORDINATE WITH PLUMBING CONTRACTOR FOR EXACT LOCATION OF HUB DRAIN
- DUST SMOKE DETECTOR, DETECTORS AND INDICATORS SHALL BE PROVIDED, INSTALLED, AND WIRED BY MECHANICAL CONTRACTOR, IN AN ALARM CONDITION DETECTOR SHALL RELAY A SIGNAL TO THE AUDIBLE-VISUAL INDICATOR
- FIRE DAMPER WITH ACCESS DOOR
- MANUAL VOLUME DAMPER
- REFRIGERANT LINES SIZED PER MANUFACTURER'S RECOMMENDATION, PROVIDE SEALED ESCUTCHEON AT PENETRATION THRU EXTERIOR WALL
- FILL SUPPORT AND RETAINING WALL BY G.C.
- 12X12 EXHAUST AIR LOUVER, RUSKING MODEL ELF81530 OR EQUAL, PROVIDE SHEET-METAL PLENUM DUCT CONNECTION
- 6"9" OUTSIDE AIR WITH MANUAL DAMPER ON TO PLENUM
- 12X12 OUTSIDE AIR LOUVER, RUSKING MODEL ELF81530 OR EQUAL, PROVIDE SHEET-METAL PLENUM DUCT CONNECTION

THIS SHEET REVISED IN ITS ENTIRETY

FLOOR PLAN -
MECHANICAL

PROJECT NO:
1113
DRAWN/DESIGNED BY:
AEM
CHECKED BY:
AEM
DRAWING SCALE:
AS NOTED
DRAWING NUMBER:

M-2