



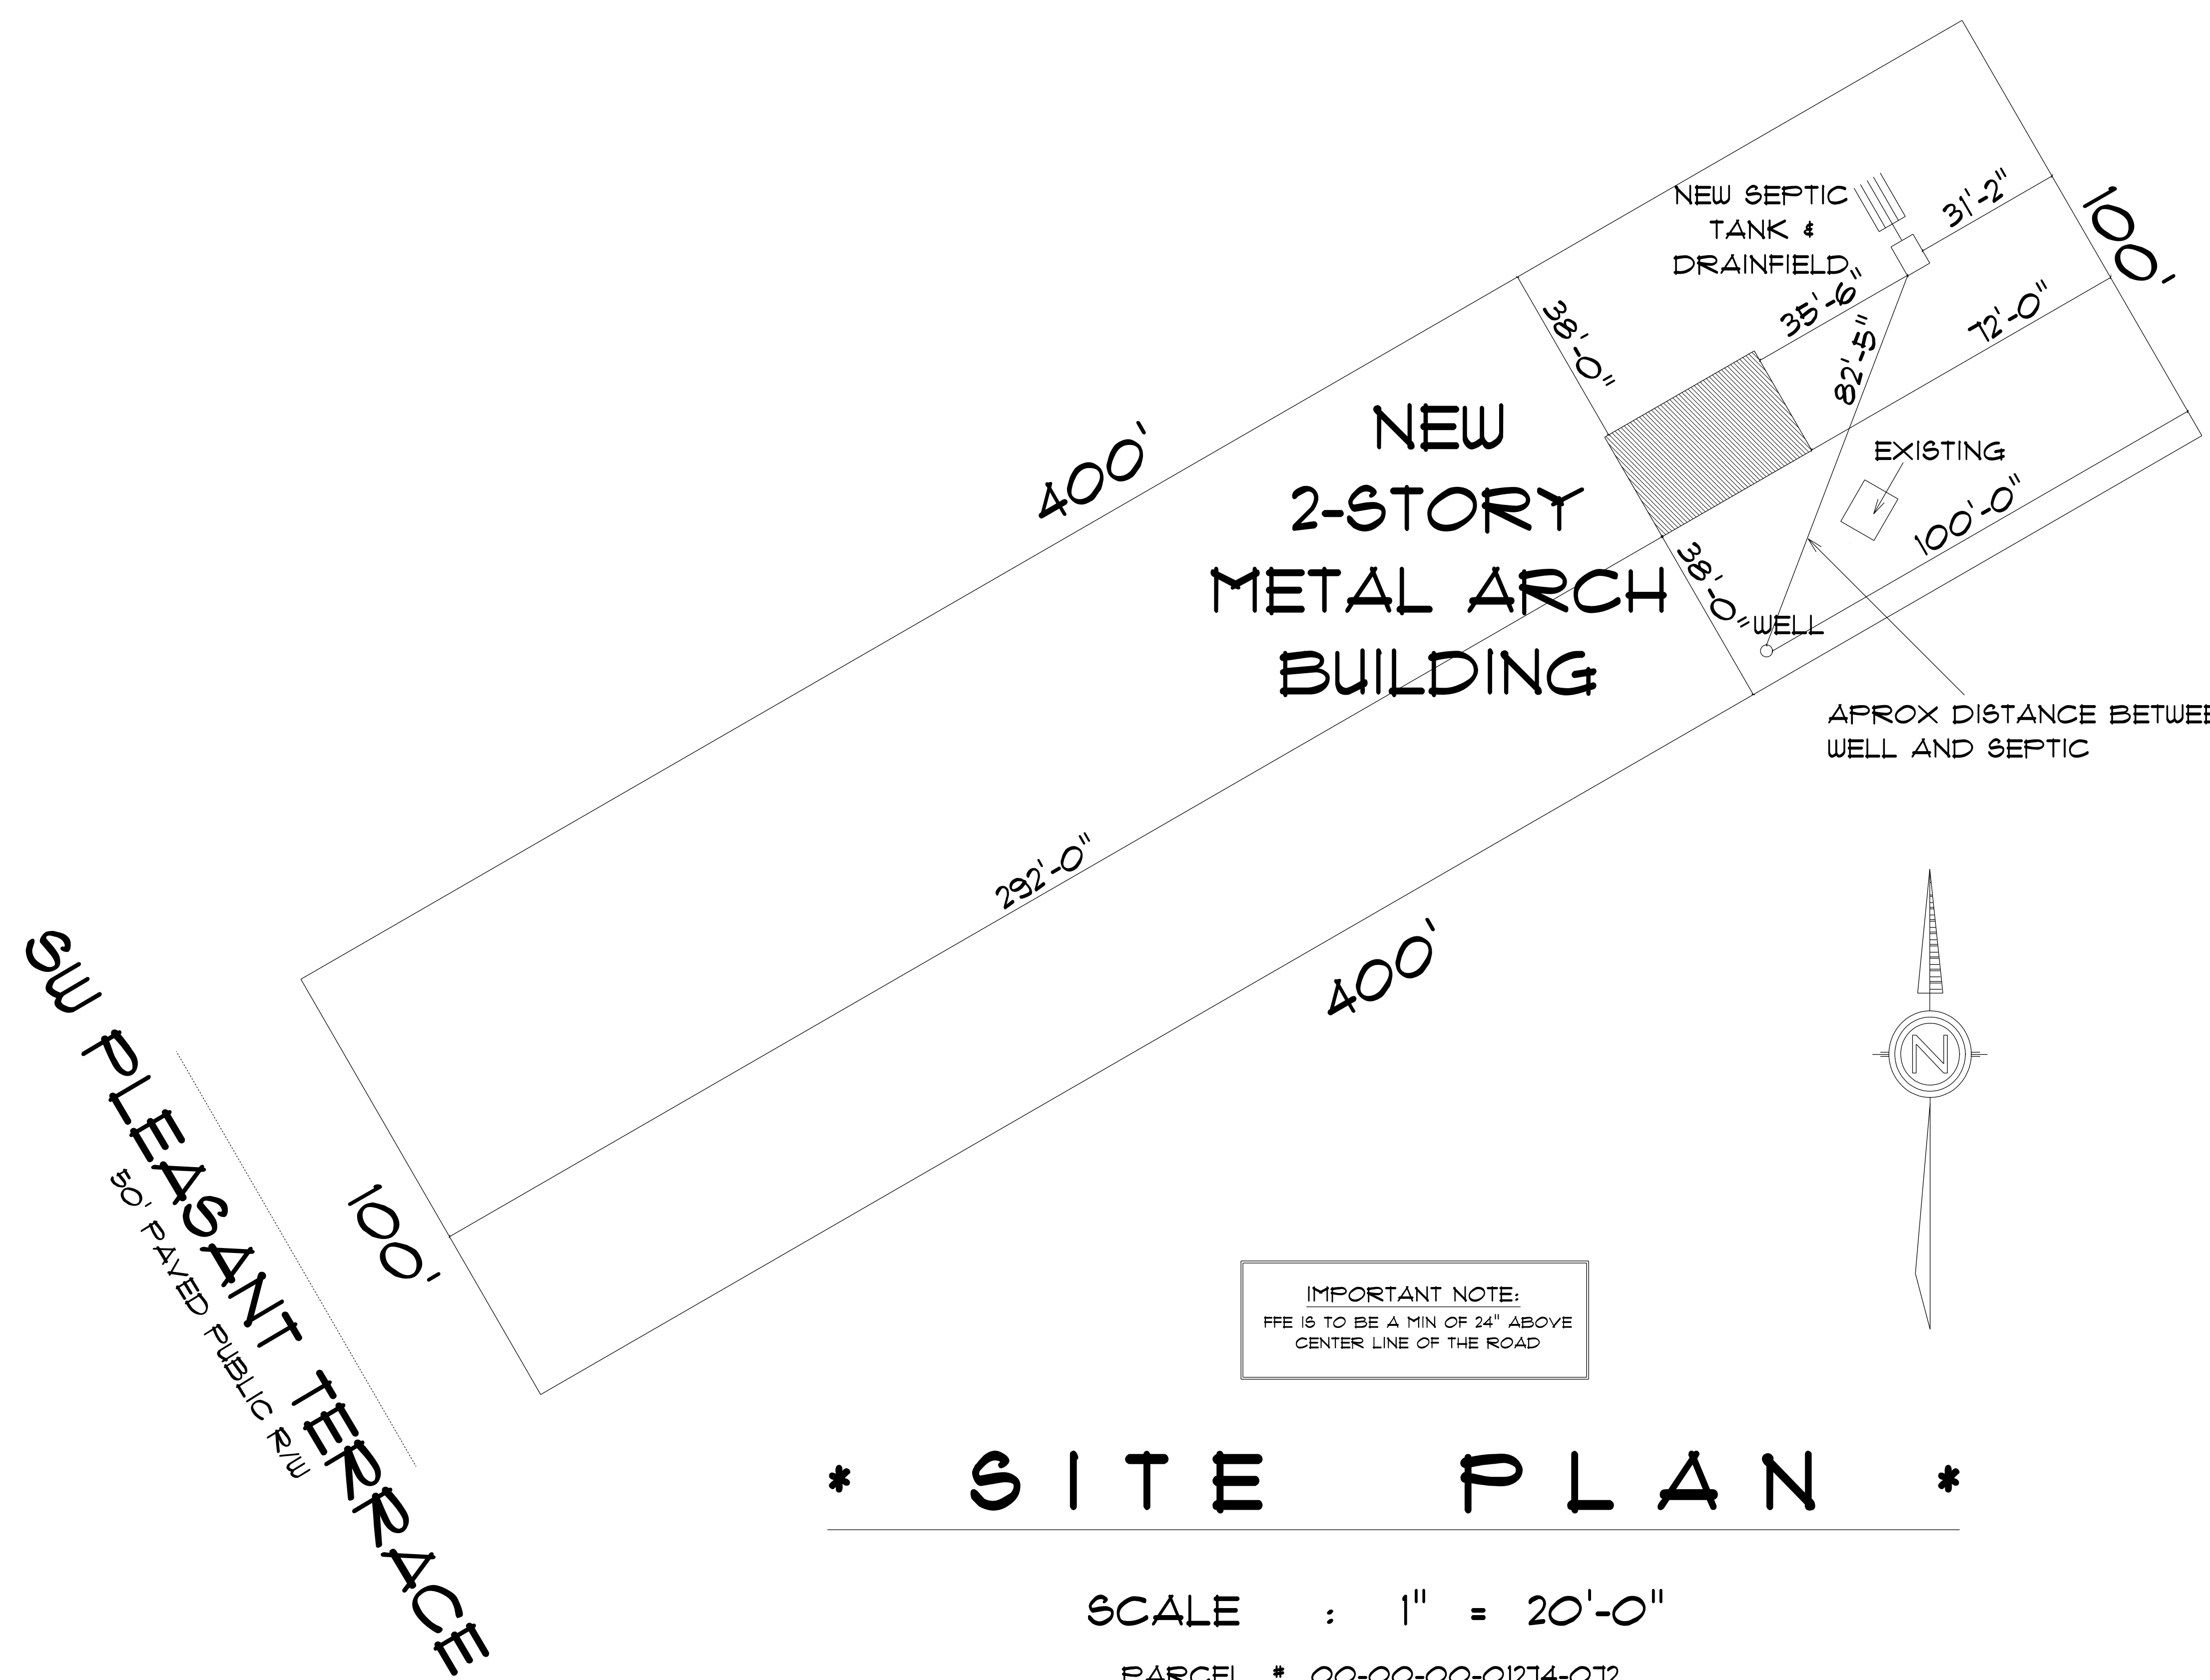

|                                                                                                                                                         |             |
|---------------------------------------------------------------------------------------------------------------------------------------------------------|-------------|
| <b>RESIDENCE</b><br>for<br><b>AMY FOUCHER</b><br>669 SW Pleasant Terrace<br>Ft. White, FL, 32038<br>Cell: (386) 867-1191<br>Email: teanaruffo@gmail.com |             |
| Teana M. Ruffo<br>2925 SW SR 47<br>Lake City Florida, 32025<br>Cell: (386) 867-1191<br>Email: teanaruffo@gmail.com                                      |             |
| PRINTED DATE:<br>Tuesday, November 12, 2024                                                                                                             |             |
| DRAWN BY:<br>Teana & Kara                                                                                                                               | CHECKED BY: |
| BUILDING CONTRACTOR                                                                                                                                     |             |
| FINAL DATE:                                                                                                                                             |             |
| JOB NUMBER:                                                                                                                                             |             |
| DRAWING NUMBER<br><b>A - 1</b><br>OF 8 SHEETS                                                                                                           |             |

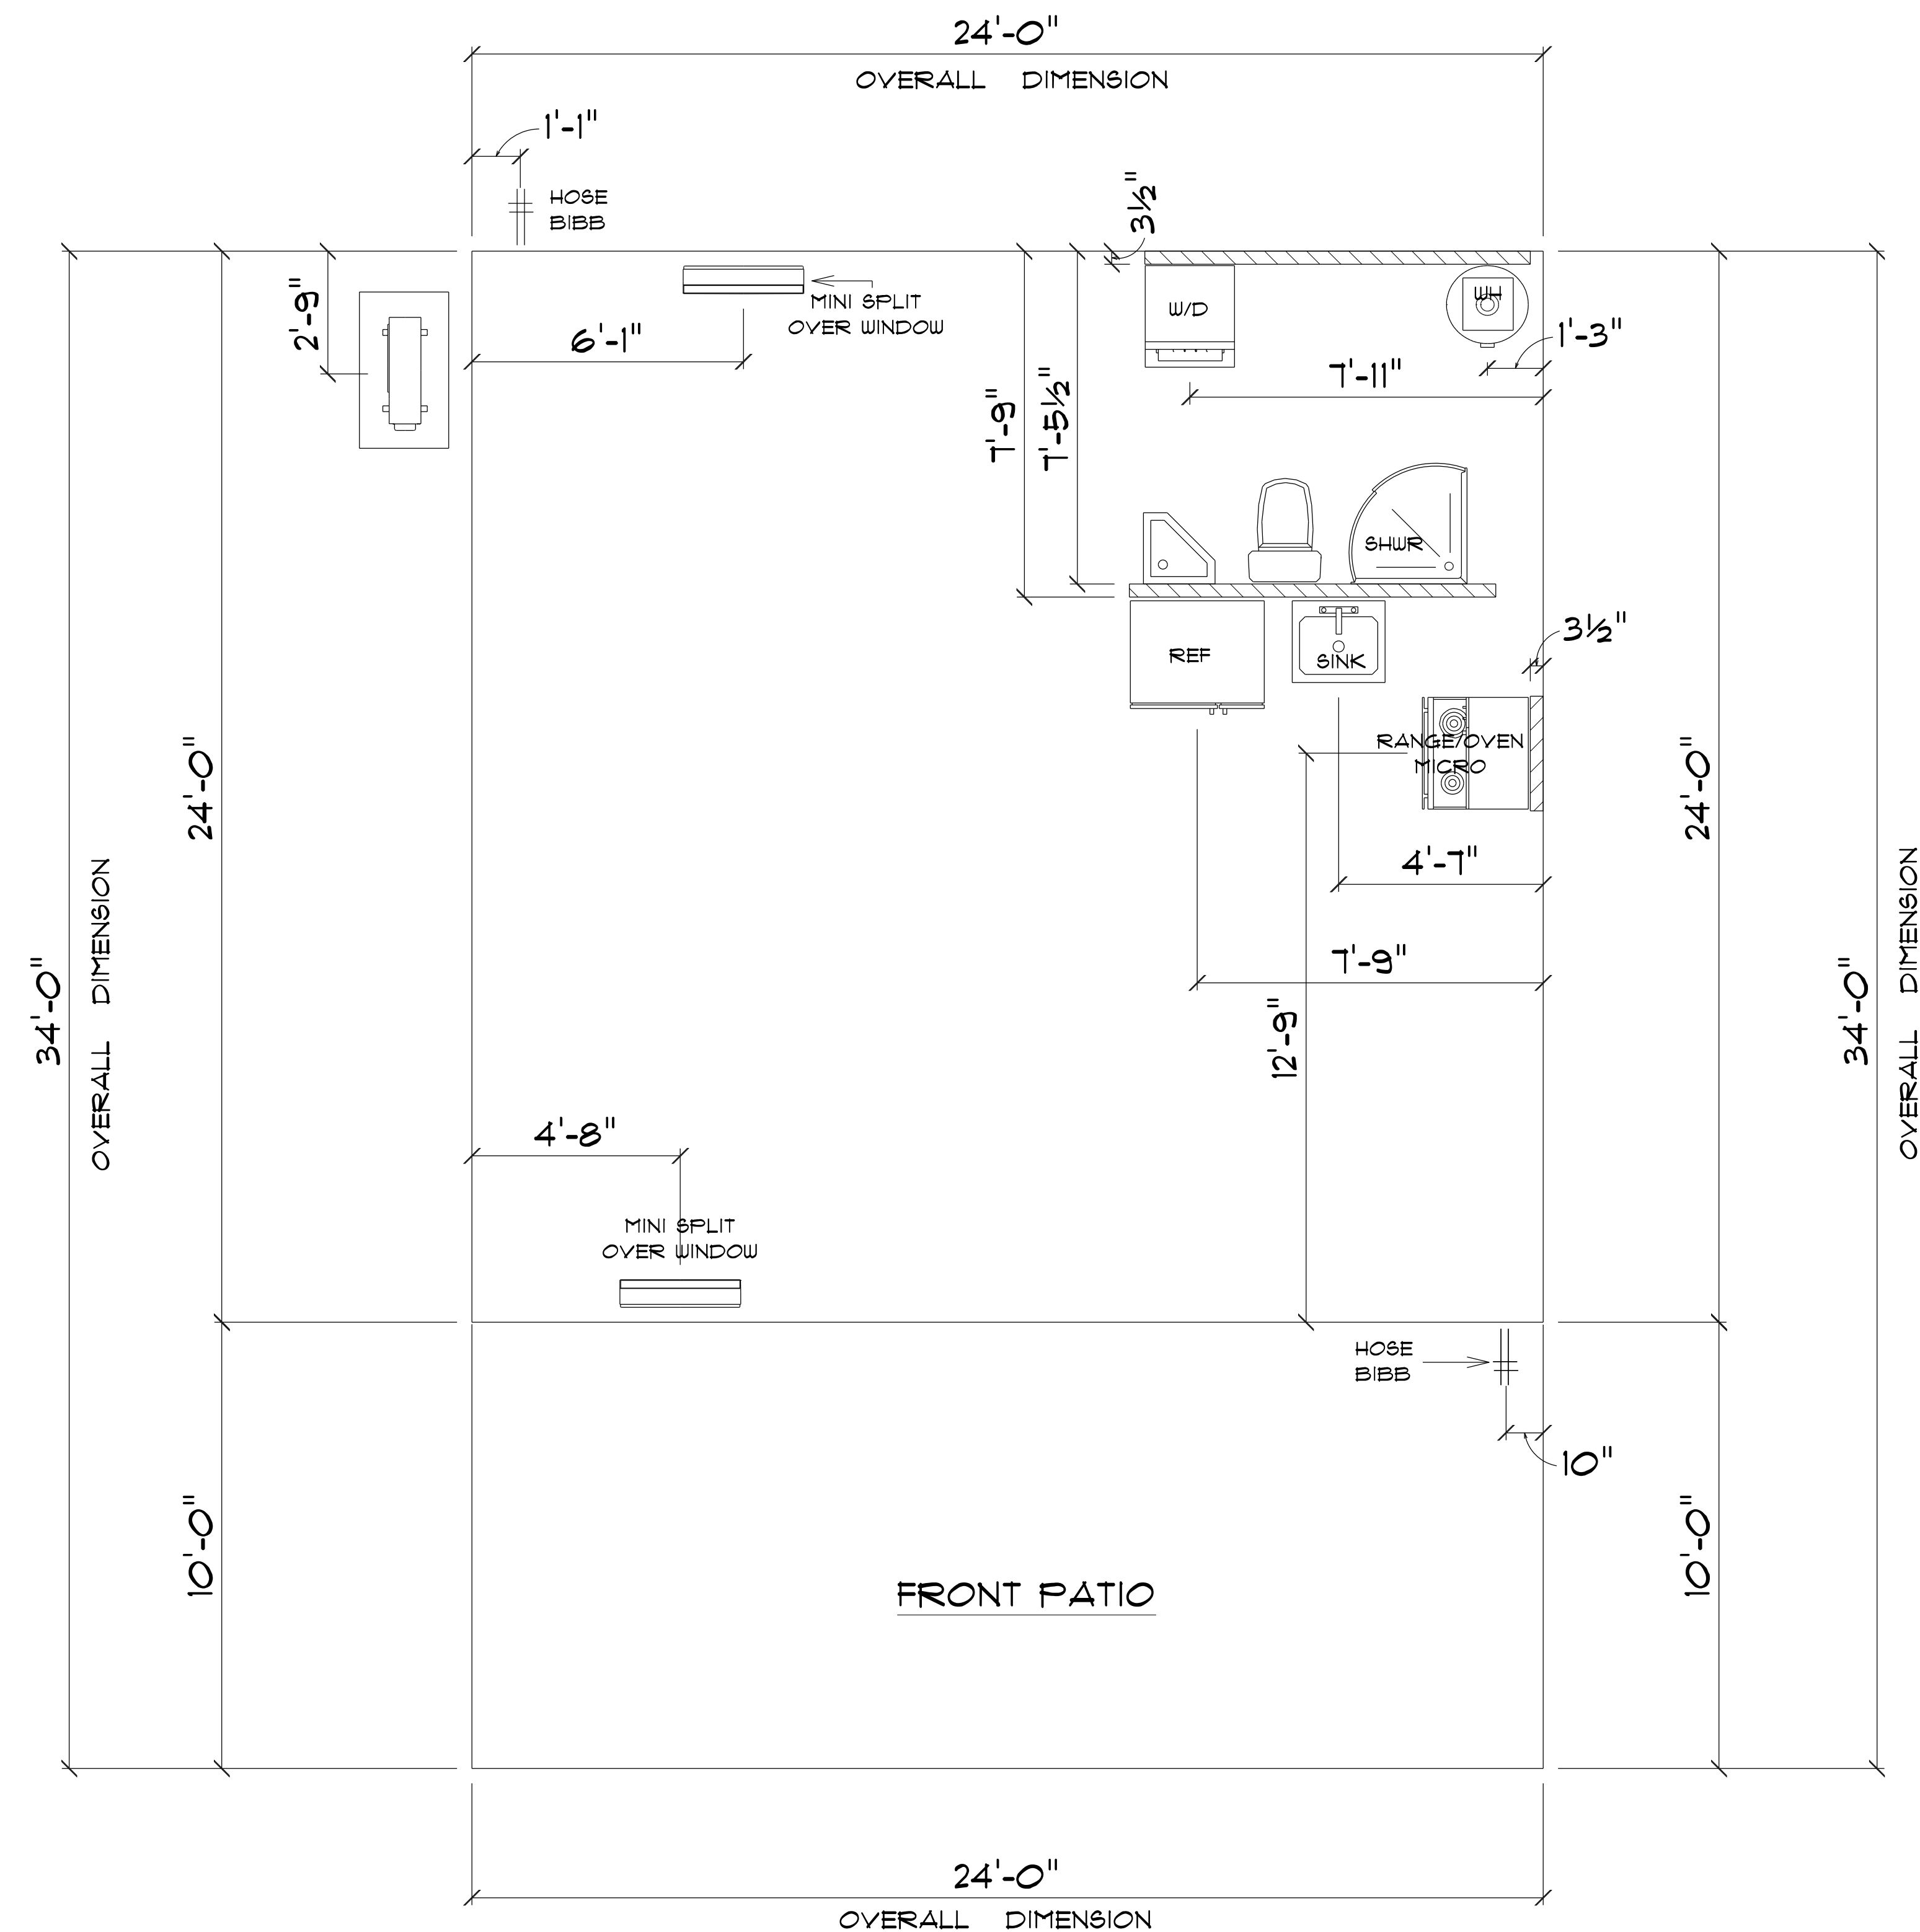



\* PLUMBING & \*  
\* FOUNDATION PLAN \*

SCALE : 3/8" = 1'-0"

IMPORTANT NOTE:

1. IT IS THE BUILDERS RESPONSIBILITY TO VERIFY ALL GEOMETRY AND DIMENSIONS BEFORE ORDERING ANY MATERIALS OR BEGINNING CONSTRUCTION.
2. THESE PLANS ARE FOR LAYOUT AND DESIGN PURPOSES ONLY ALL STRUCTURAL NOTES AND DETAILS TO BE PROVIDED BY AN ENGINEER.
3. 2X6 EXTERIOR STUD WALLS 2X4 INTERIOR WALLS

|                       |   |            |
|-----------------------|---|------------|
| MAIN A/C LIVING AREA  | = | 516 S.F.   |
| LOFT AREA             | = | 226 S.F.   |
| TOTAL AREA UNDER ROOF |   | = 802 S.F. |

RESIDENCE  
for  
AMY FOUCHER

669 SW Pleasant Terrace  
Ft. White, FL, 32038  
Cell:  
Email:

Teena M. Ruffo  
2925 SW SR 47  
Lake City Florida, 32025  
Cell: (386) 861 - 1191  
Email: teenaruffo@gmail.com

PRINTED DATE:  
Tuesday, November 12, 2024

DRAWN BY: Teena & Kara CHECKED BY:

BUILDING CONTRACTOR

FINAL DATE:


JOB NUMBER:

DRAWING NUMBER

A - 2

OF 8 SHEETS



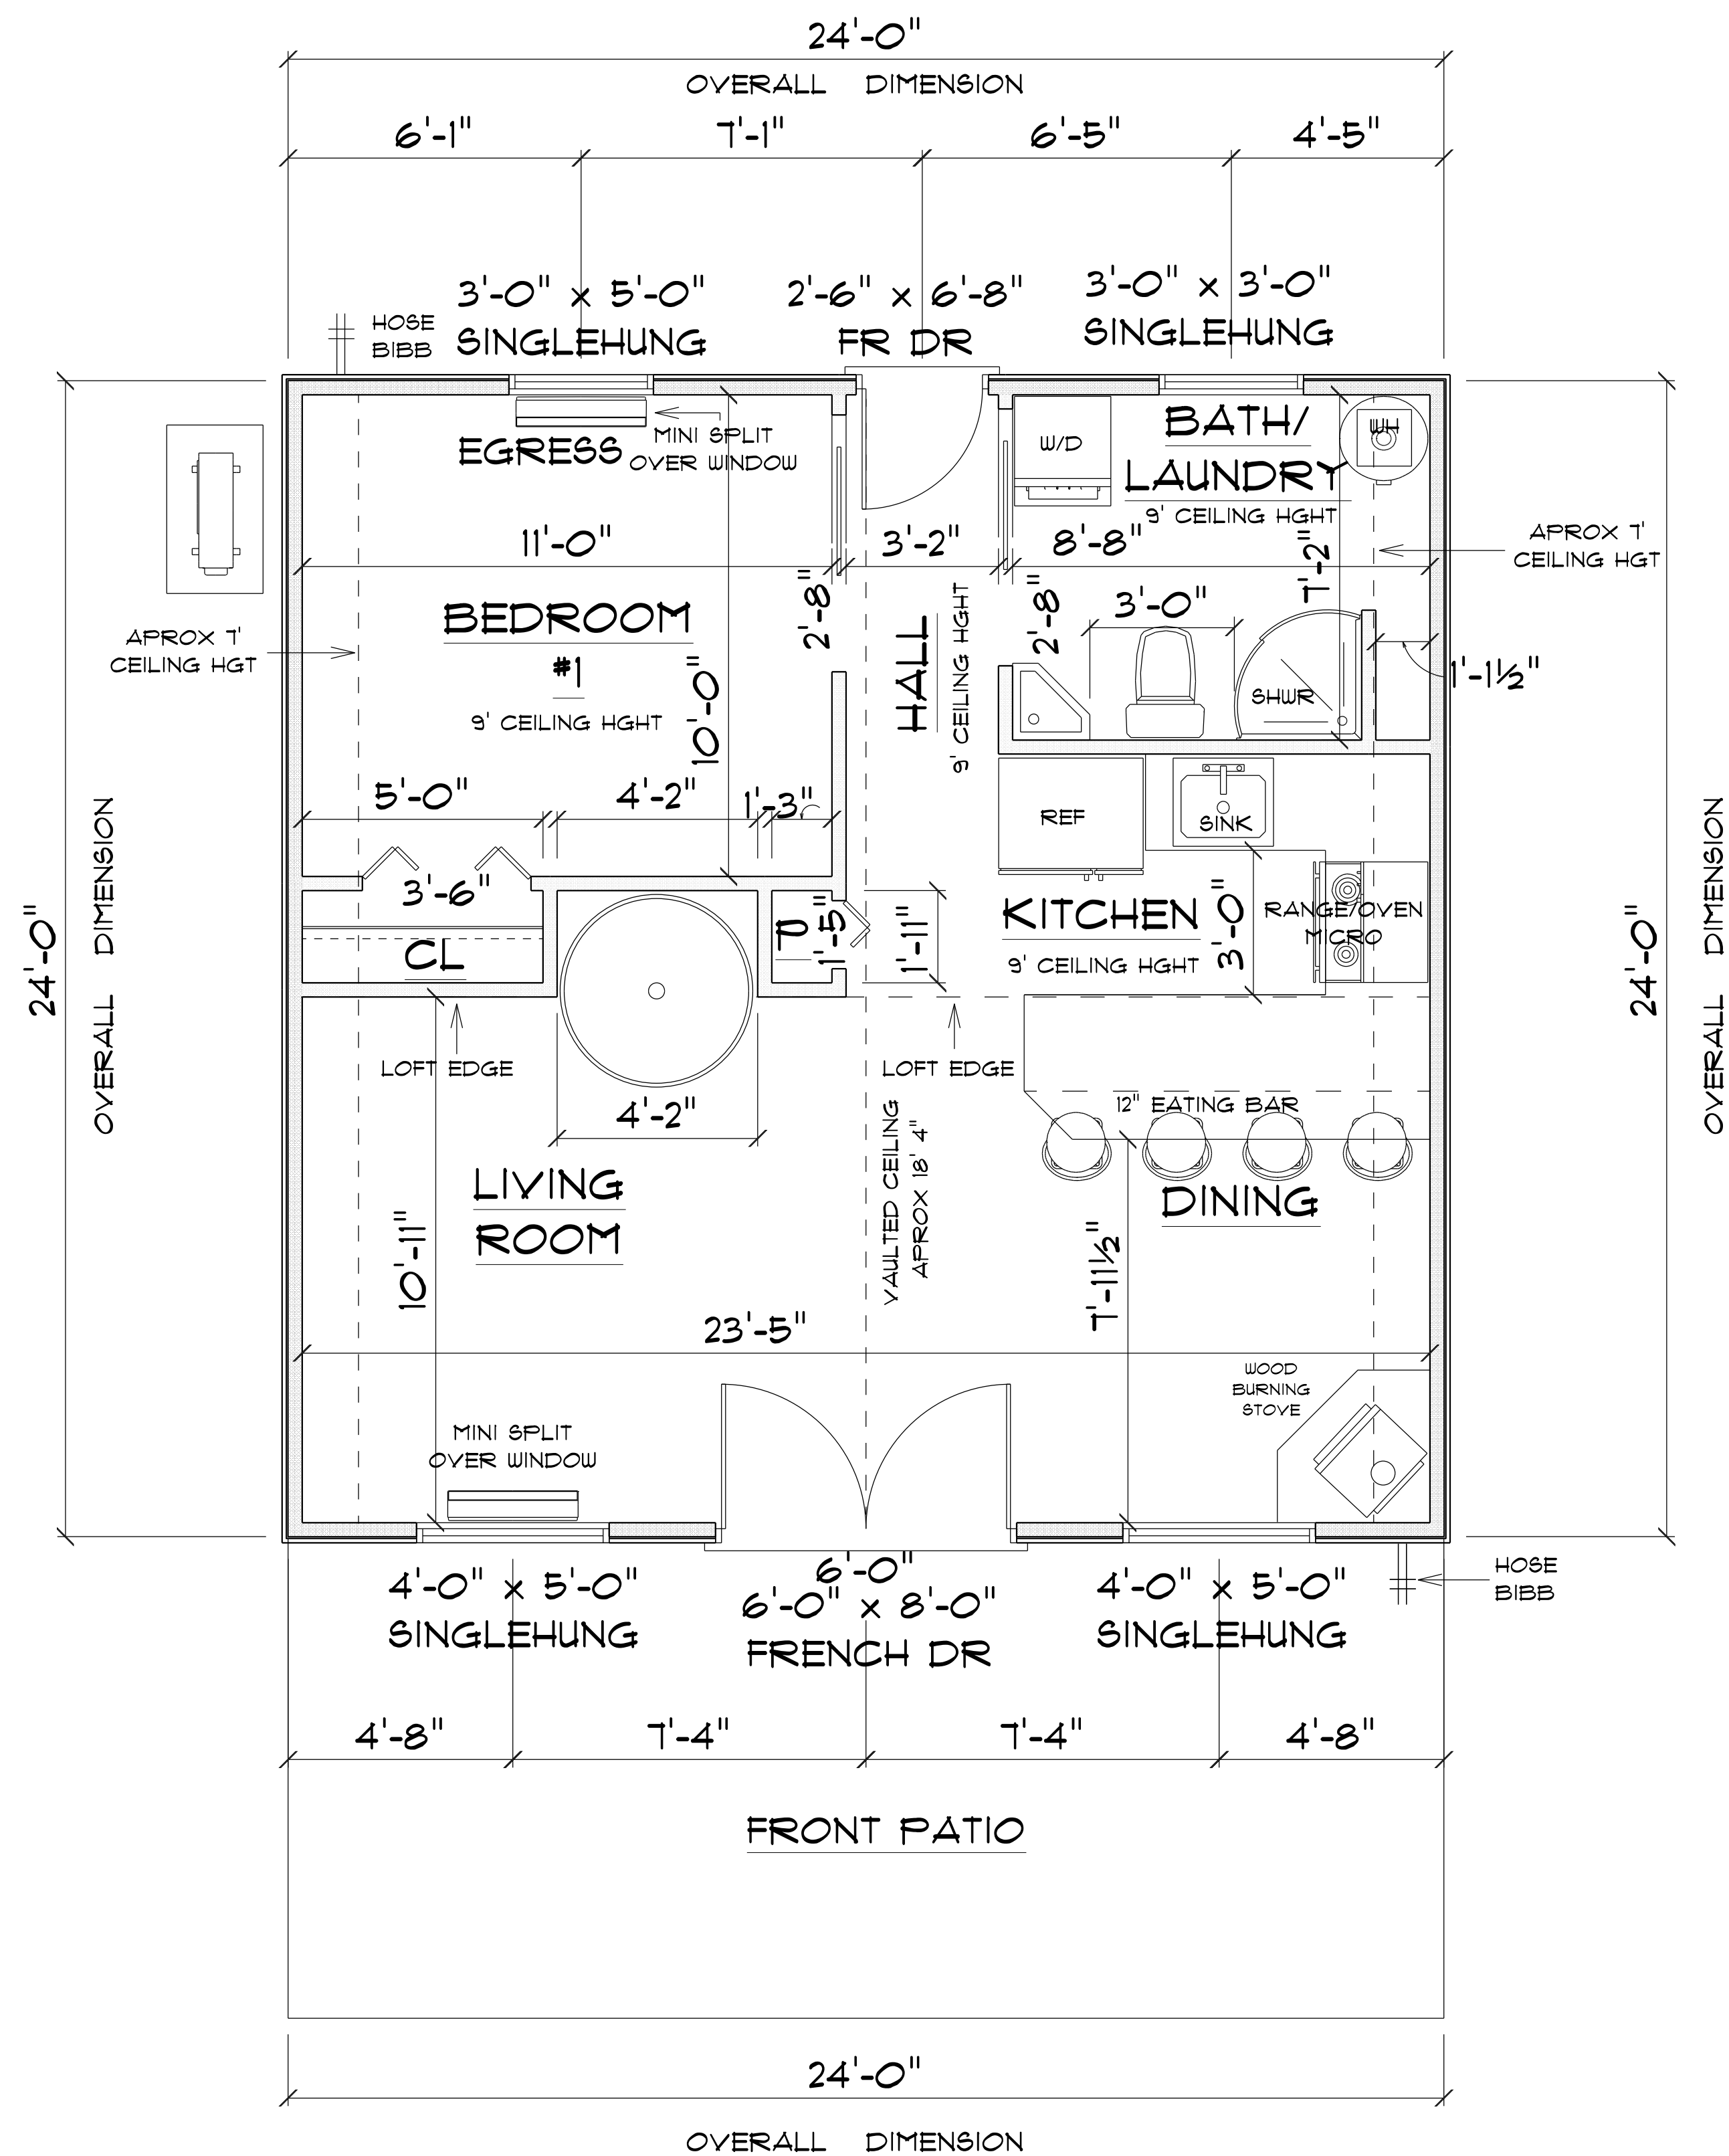


\* MAIN FLOOR \*

SCALE : 3/8" = 1'-0"

IMPORTANT NOTE:

1. IT IS THE BUILDERS RESPONSIBILITY TO VERIFY ALL GEOMETRY AND DIMENSIONS BEFORE ORDERING ANY MATERIALS OR BEGINNING CONSTRUCTION.
2. THESE PLANS ARE FOR LAYOUT AND DESIGN PURPOSES ONLY ALL STRUCTURAL NOTES AND DETAILS TO BE PROVIDED BY AN ENGINEER.
3. 2X6 EXTERIOR STUD WALLS 2X4 INTERIOR WALLS

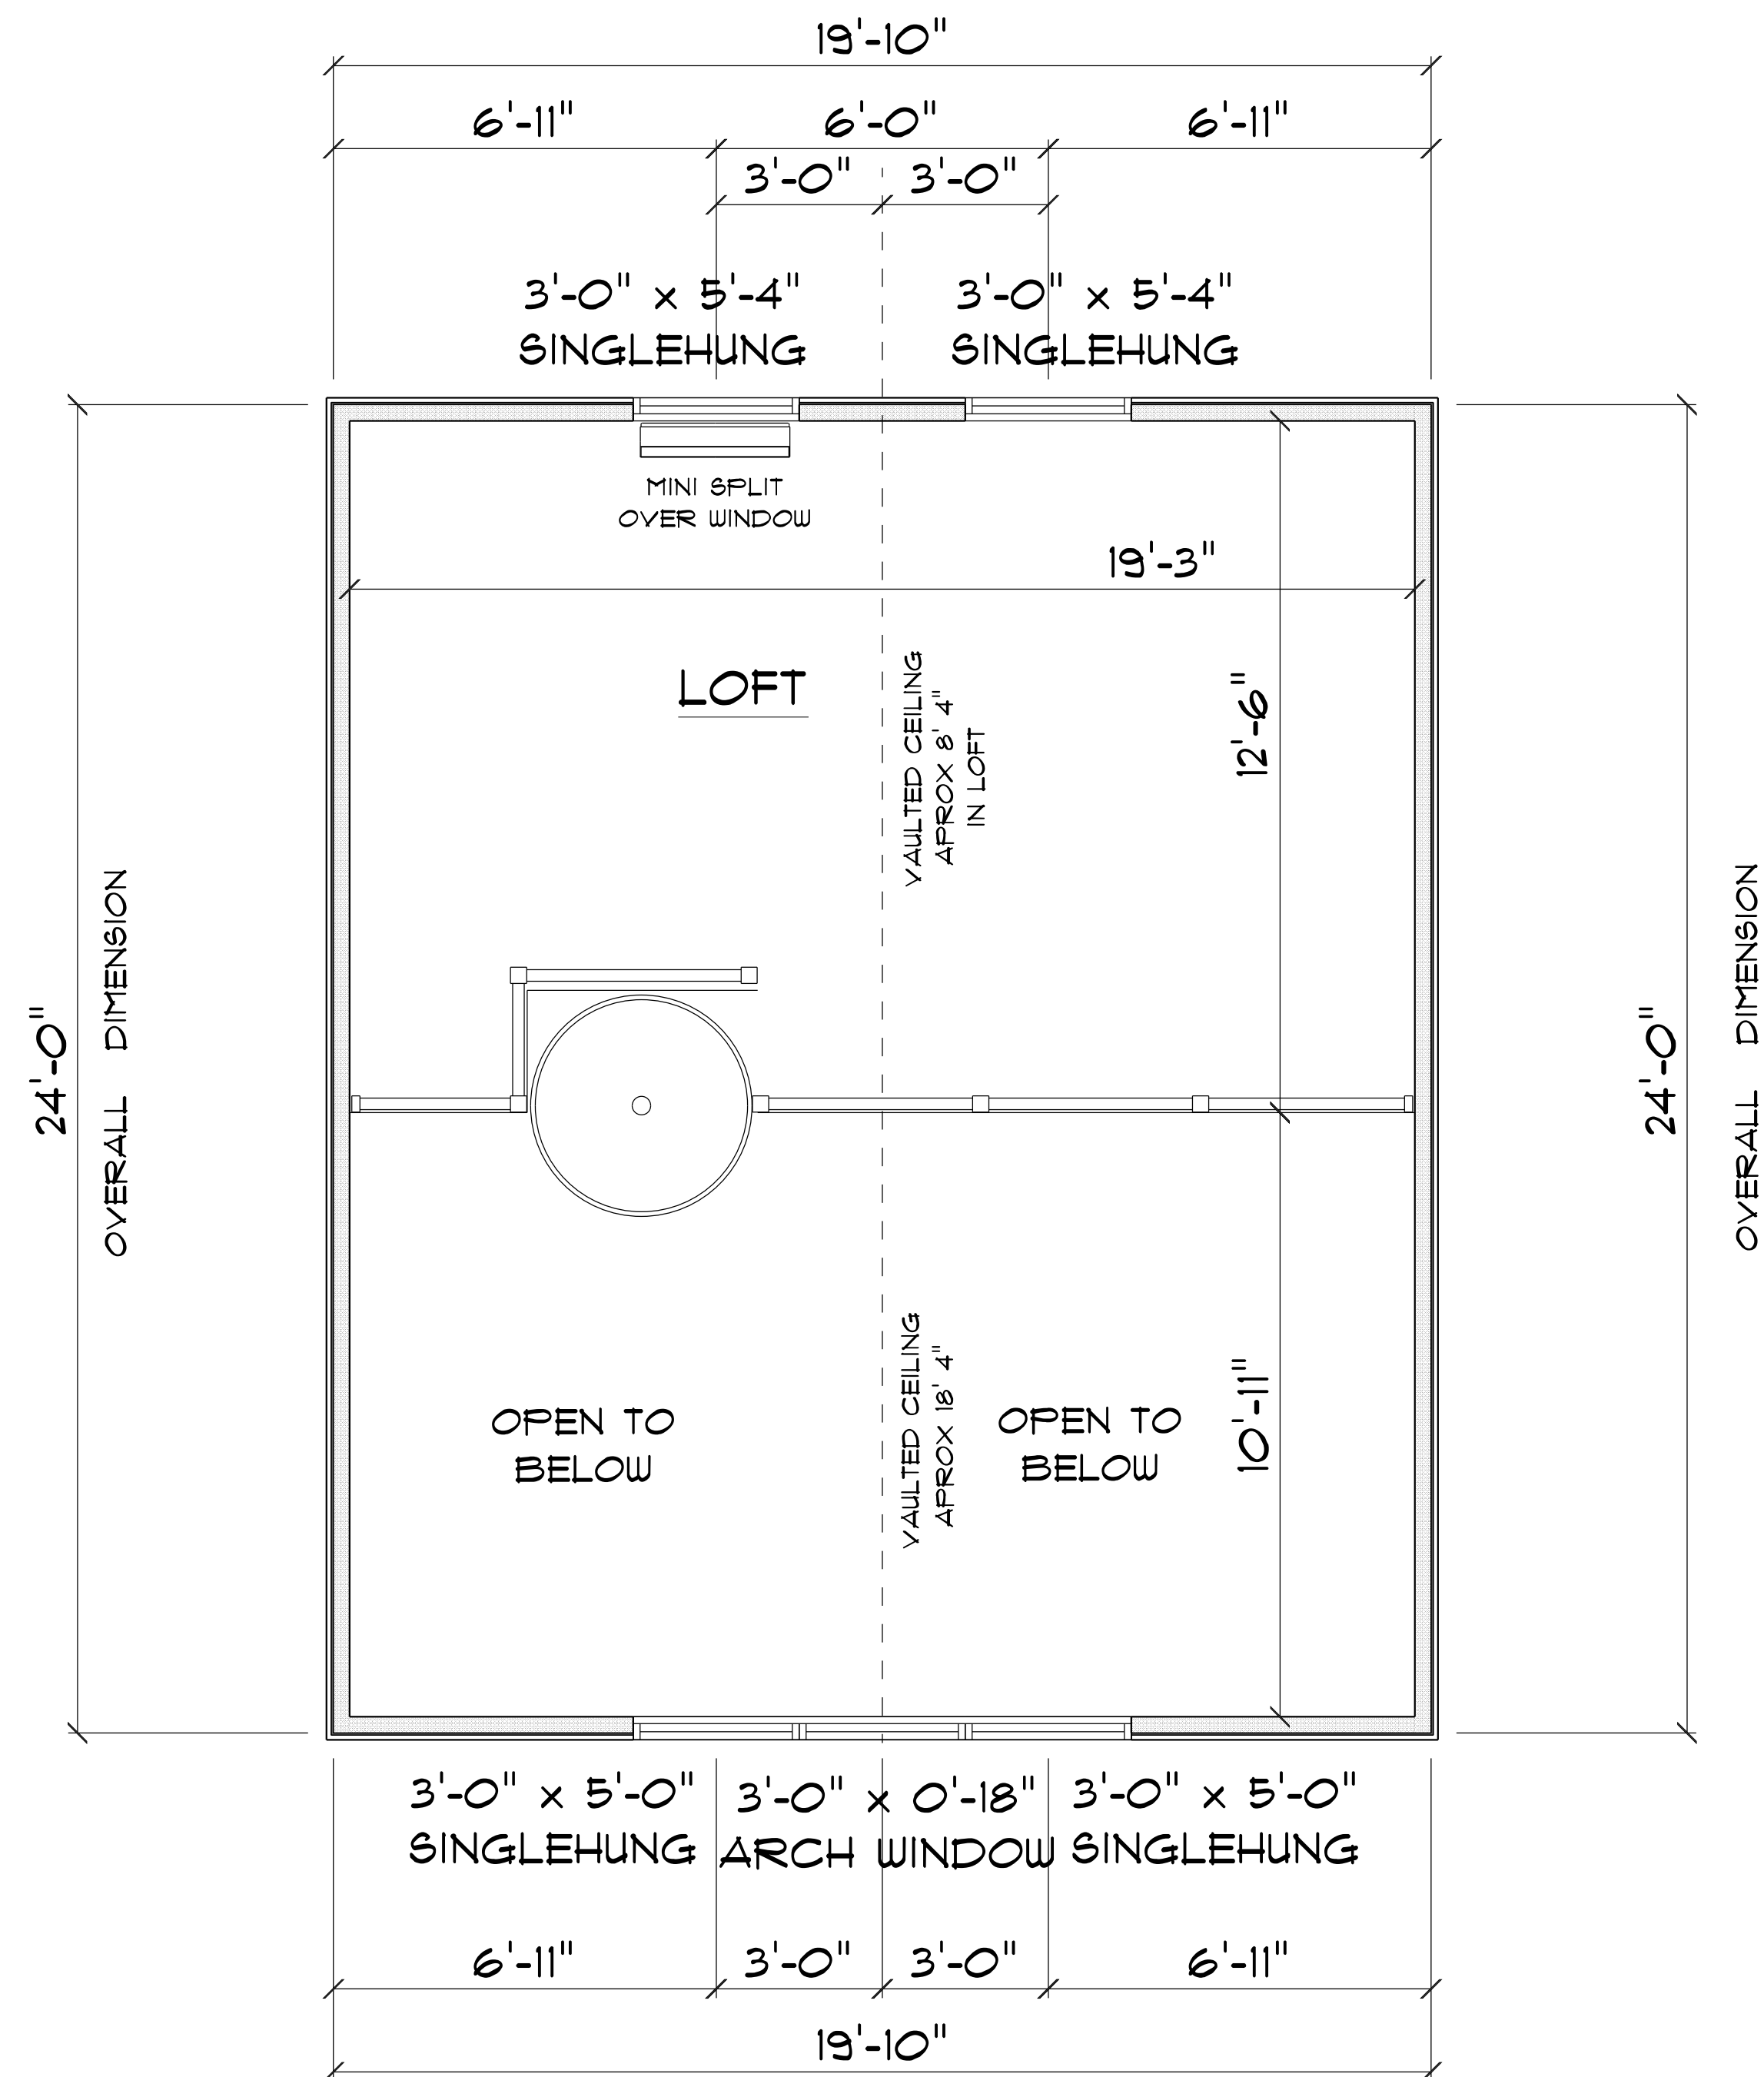

\* SECOND FLOOR \*

SCALE : 3/8" = 1'-0"

|                       |   |            |
|-----------------------|---|------------|
| MAIN A/C LIVING AREA  | = | 576 S.F.   |
| LOFT AREA             | = | 226 S.F.   |
| TOTAL AREA UNDER ROOF |   | = 802 S.F. |

RESIDENCE  
for  
AMY FOUCHER

669 SW Pleasant Terrace  
Ft. White, FL, 32038  
Cell: (386) 867-1191  
Email: teanaruffo@gmail.com

Teana M. Ruffo  
2925 SW SR 47  
Lake City Florida, 32025  
Cell: (386) 867-1191  
Email: teanaruffo@gmail.com

PRINTED DATE:  
Tuesday, November 12, 2024

DRAWN BY: Teana & Kara

CHECKED BY:

BUILDING CONTRACTOR

FINALS DATE:


JOB NUMBER:

DRAWING NUMBER

A - 3

OF 8 SHEETS



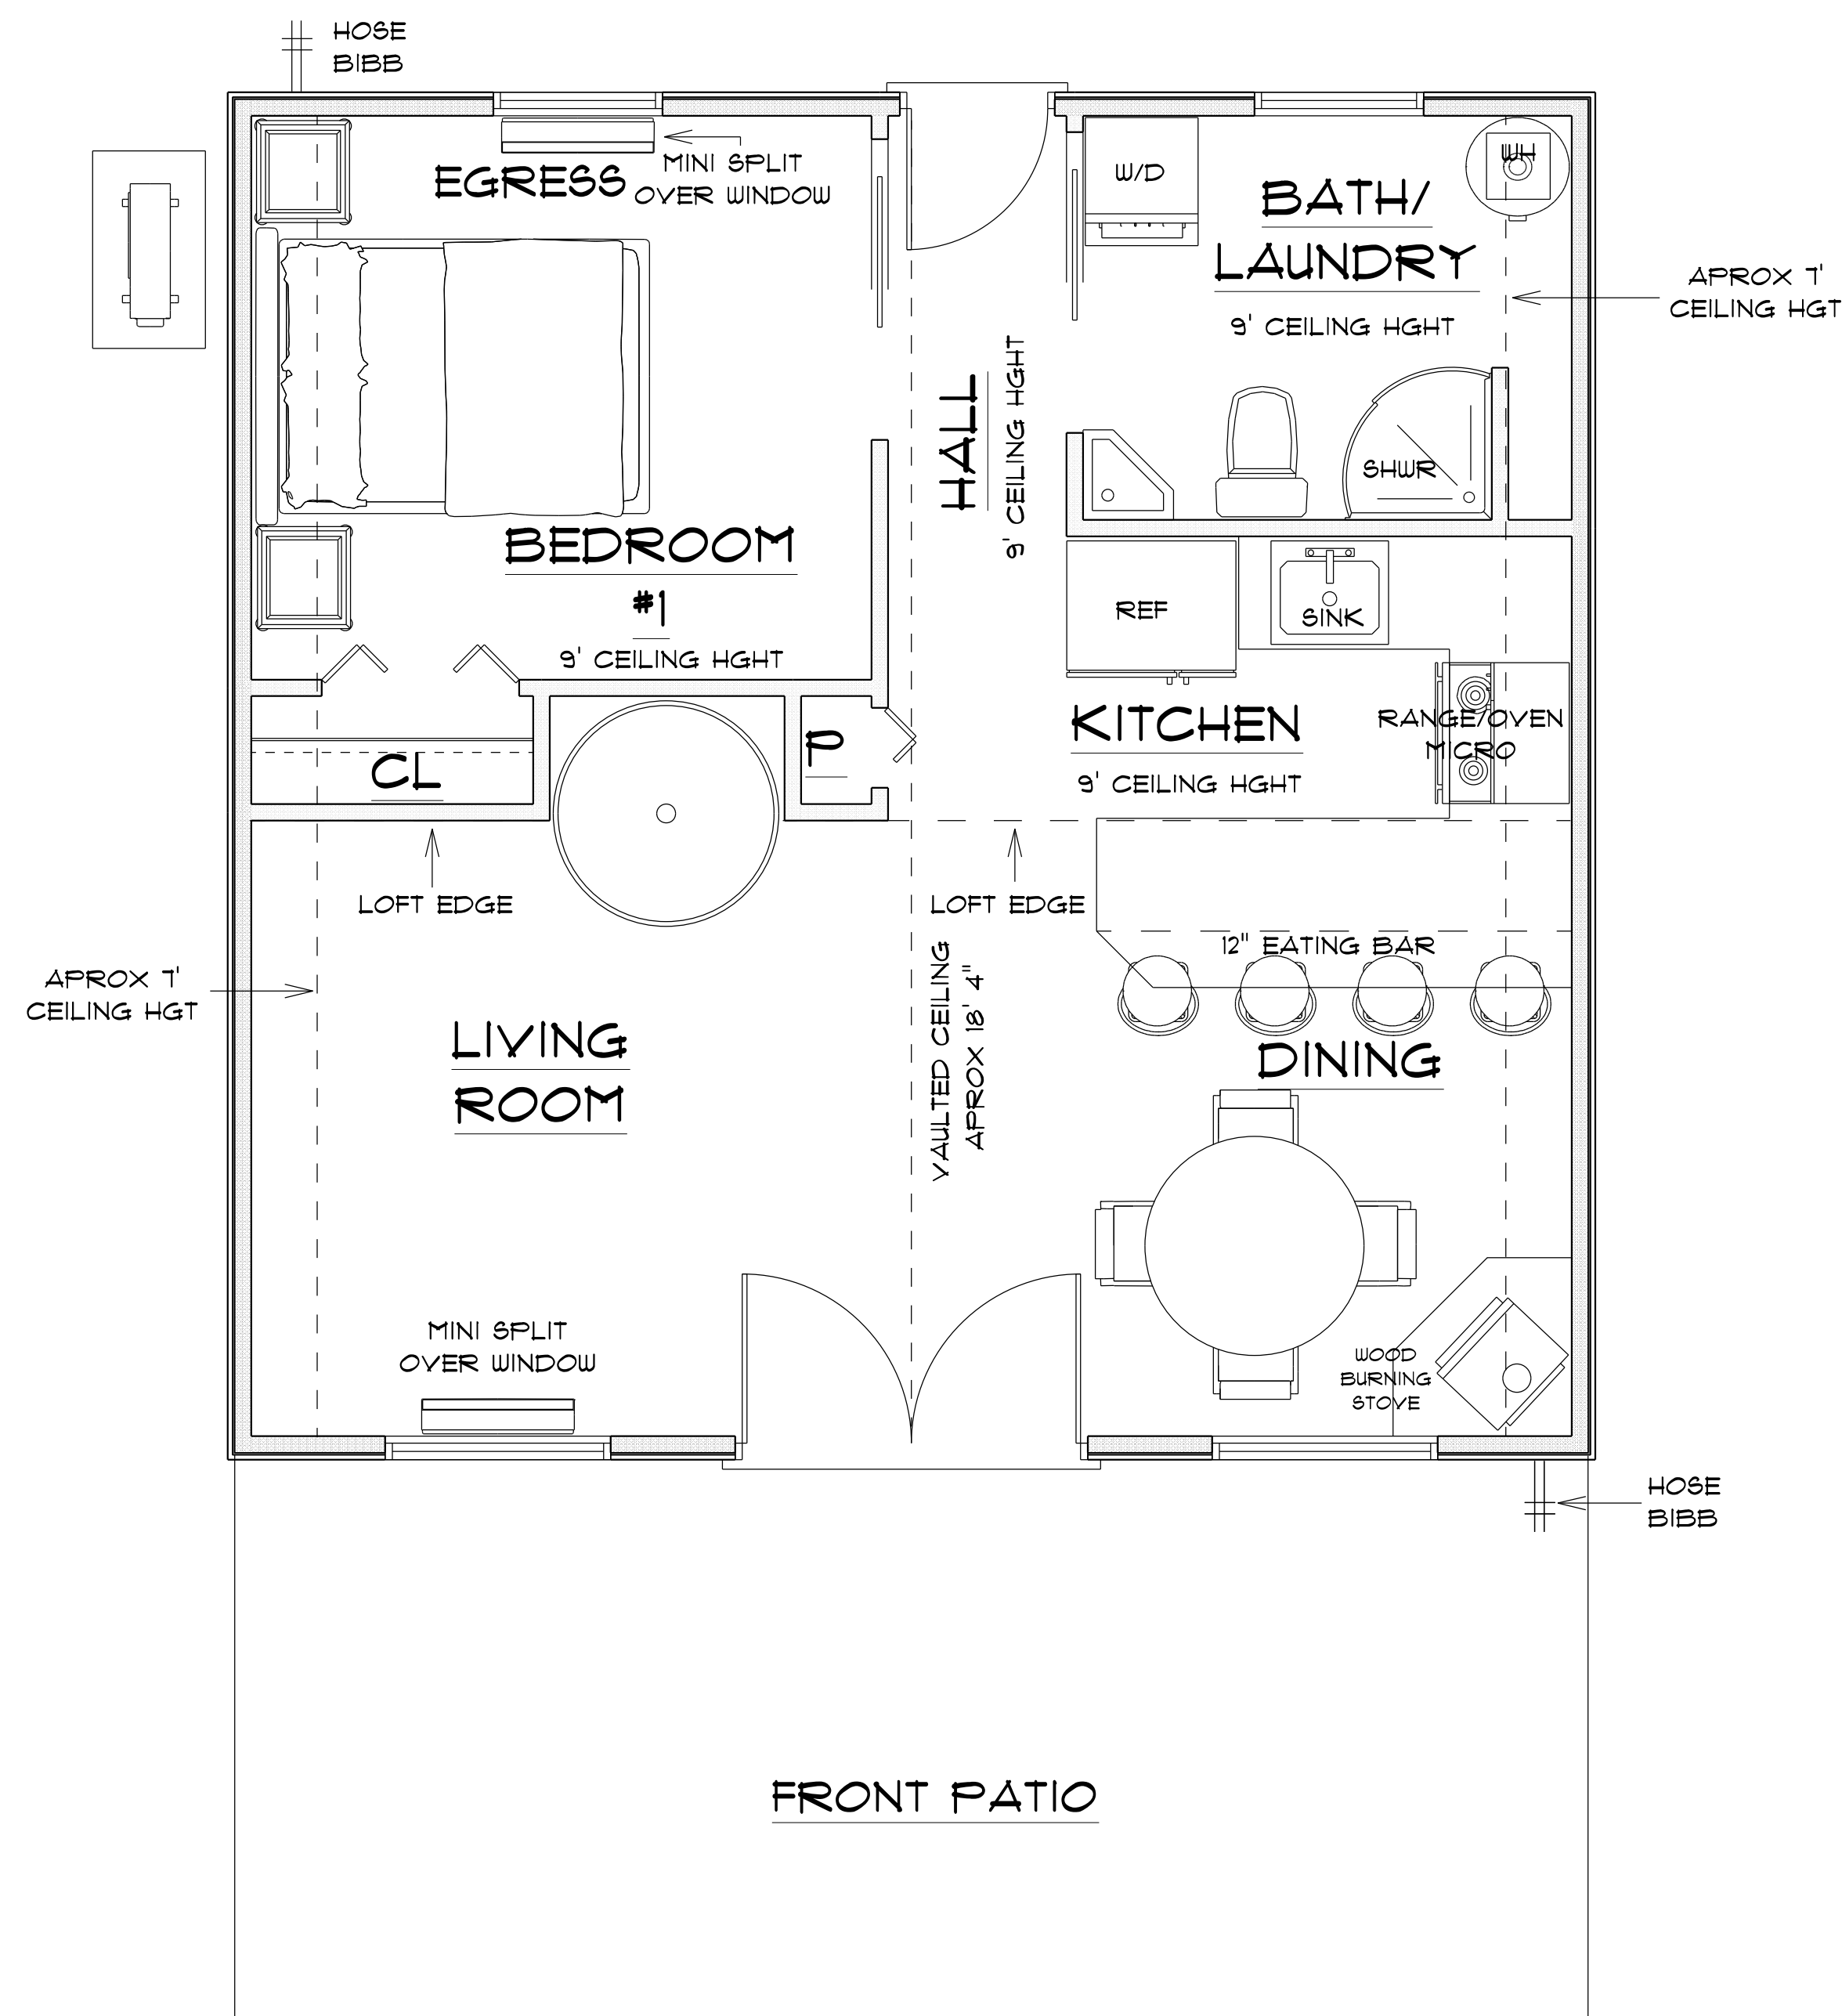


\* MAIN FLOOR \*

\* NO DIMENSIONS \*

IMPORTANT NOTE:

1. IT IS THE BUILDERS RESPONSIBILITY TO VERIFY ALL GEOMETRY AND DIMENSIONS BEFORE ORDERING ANY MATERIALS OR BEGINNING CONSTRUCTION.
2. THESE PLANS ARE FOR LAYOUT AND DESIGN PURPOSES ONLY ALL STRUCTURAL NOTES AND DETAILS TO BE PROVIDED BY AN ENGINEER.
3. 2X6 EXTERIOR STUD WALLS 2X4 INTERIOR WALLS

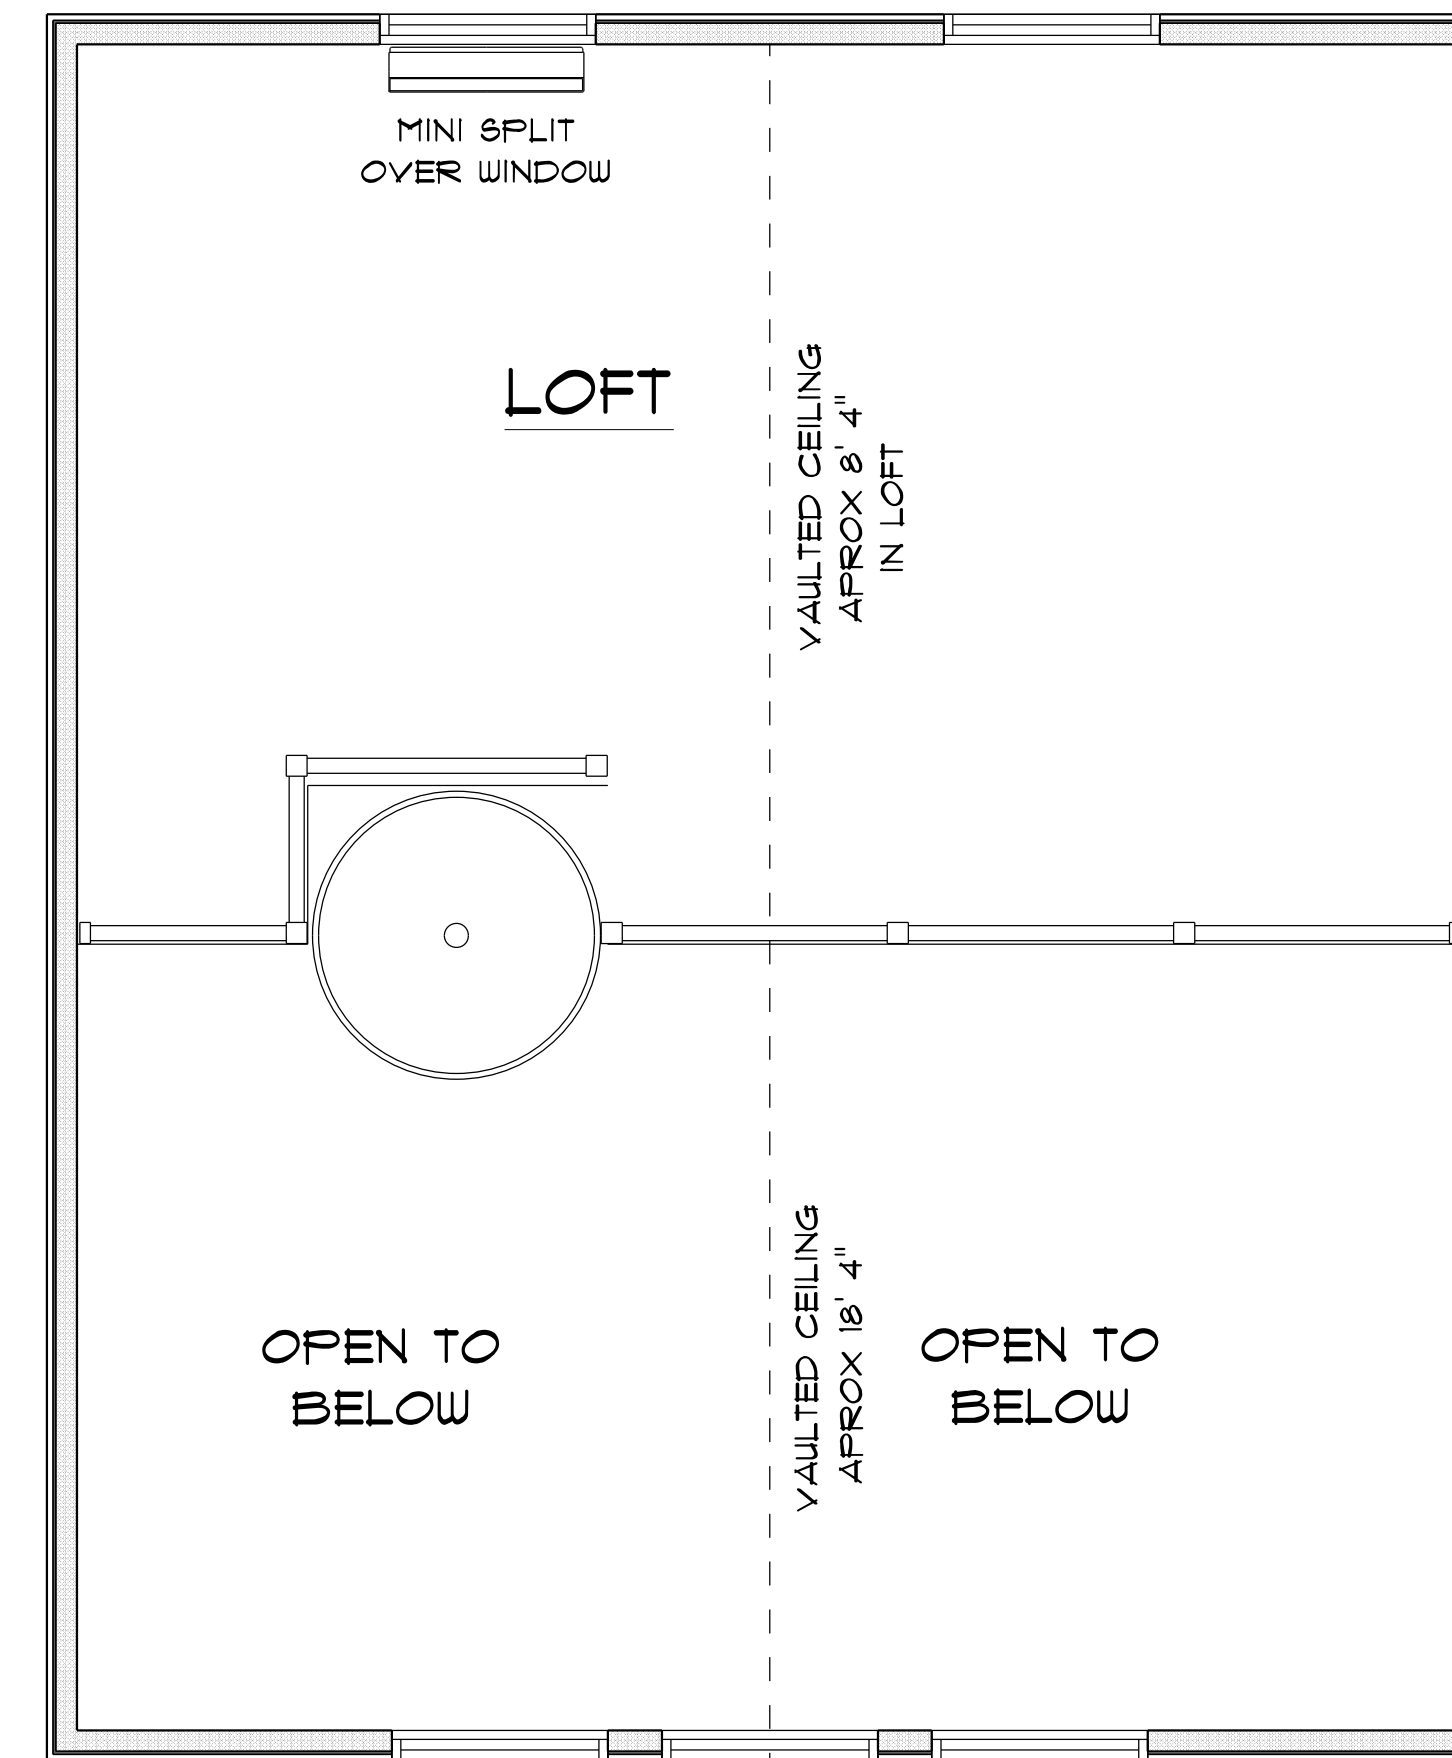

\* SECOND FLOOR \*

\* NO DIMENSIONS \*

SCALE : 3/8" = 1'-0"

|                       |   |            |
|-----------------------|---|------------|
| MAIN A/C LIVING AREA  | = | 576 S.F.   |
| LOFT AREA             | = | 226 S.F.   |
| TOTAL AREA UNDER ROOF |   | = 802 S.F. |

RESIDENCE  
for  
AMY FOUCHER

669 SW Pleasant Terrace  
Ft. White, FL, 32038  
Cell:  
Email:

Teena M. Ruffo  
2925 SW SR 47  
Lake City Florida, 32025  
Cell: (386) 867-1191  
Email: teenaruffo@gmail.com

PRINTED DATE:  
Tuesday, November 12, 2024

DRAWN BY: Teena & Kara CHECKED BY:

BUILDING CONTRACTOR

FINAL DATE:


JOB NUMBER:

DRAWING NUMBER


A - 4

OF 8 SHEETS



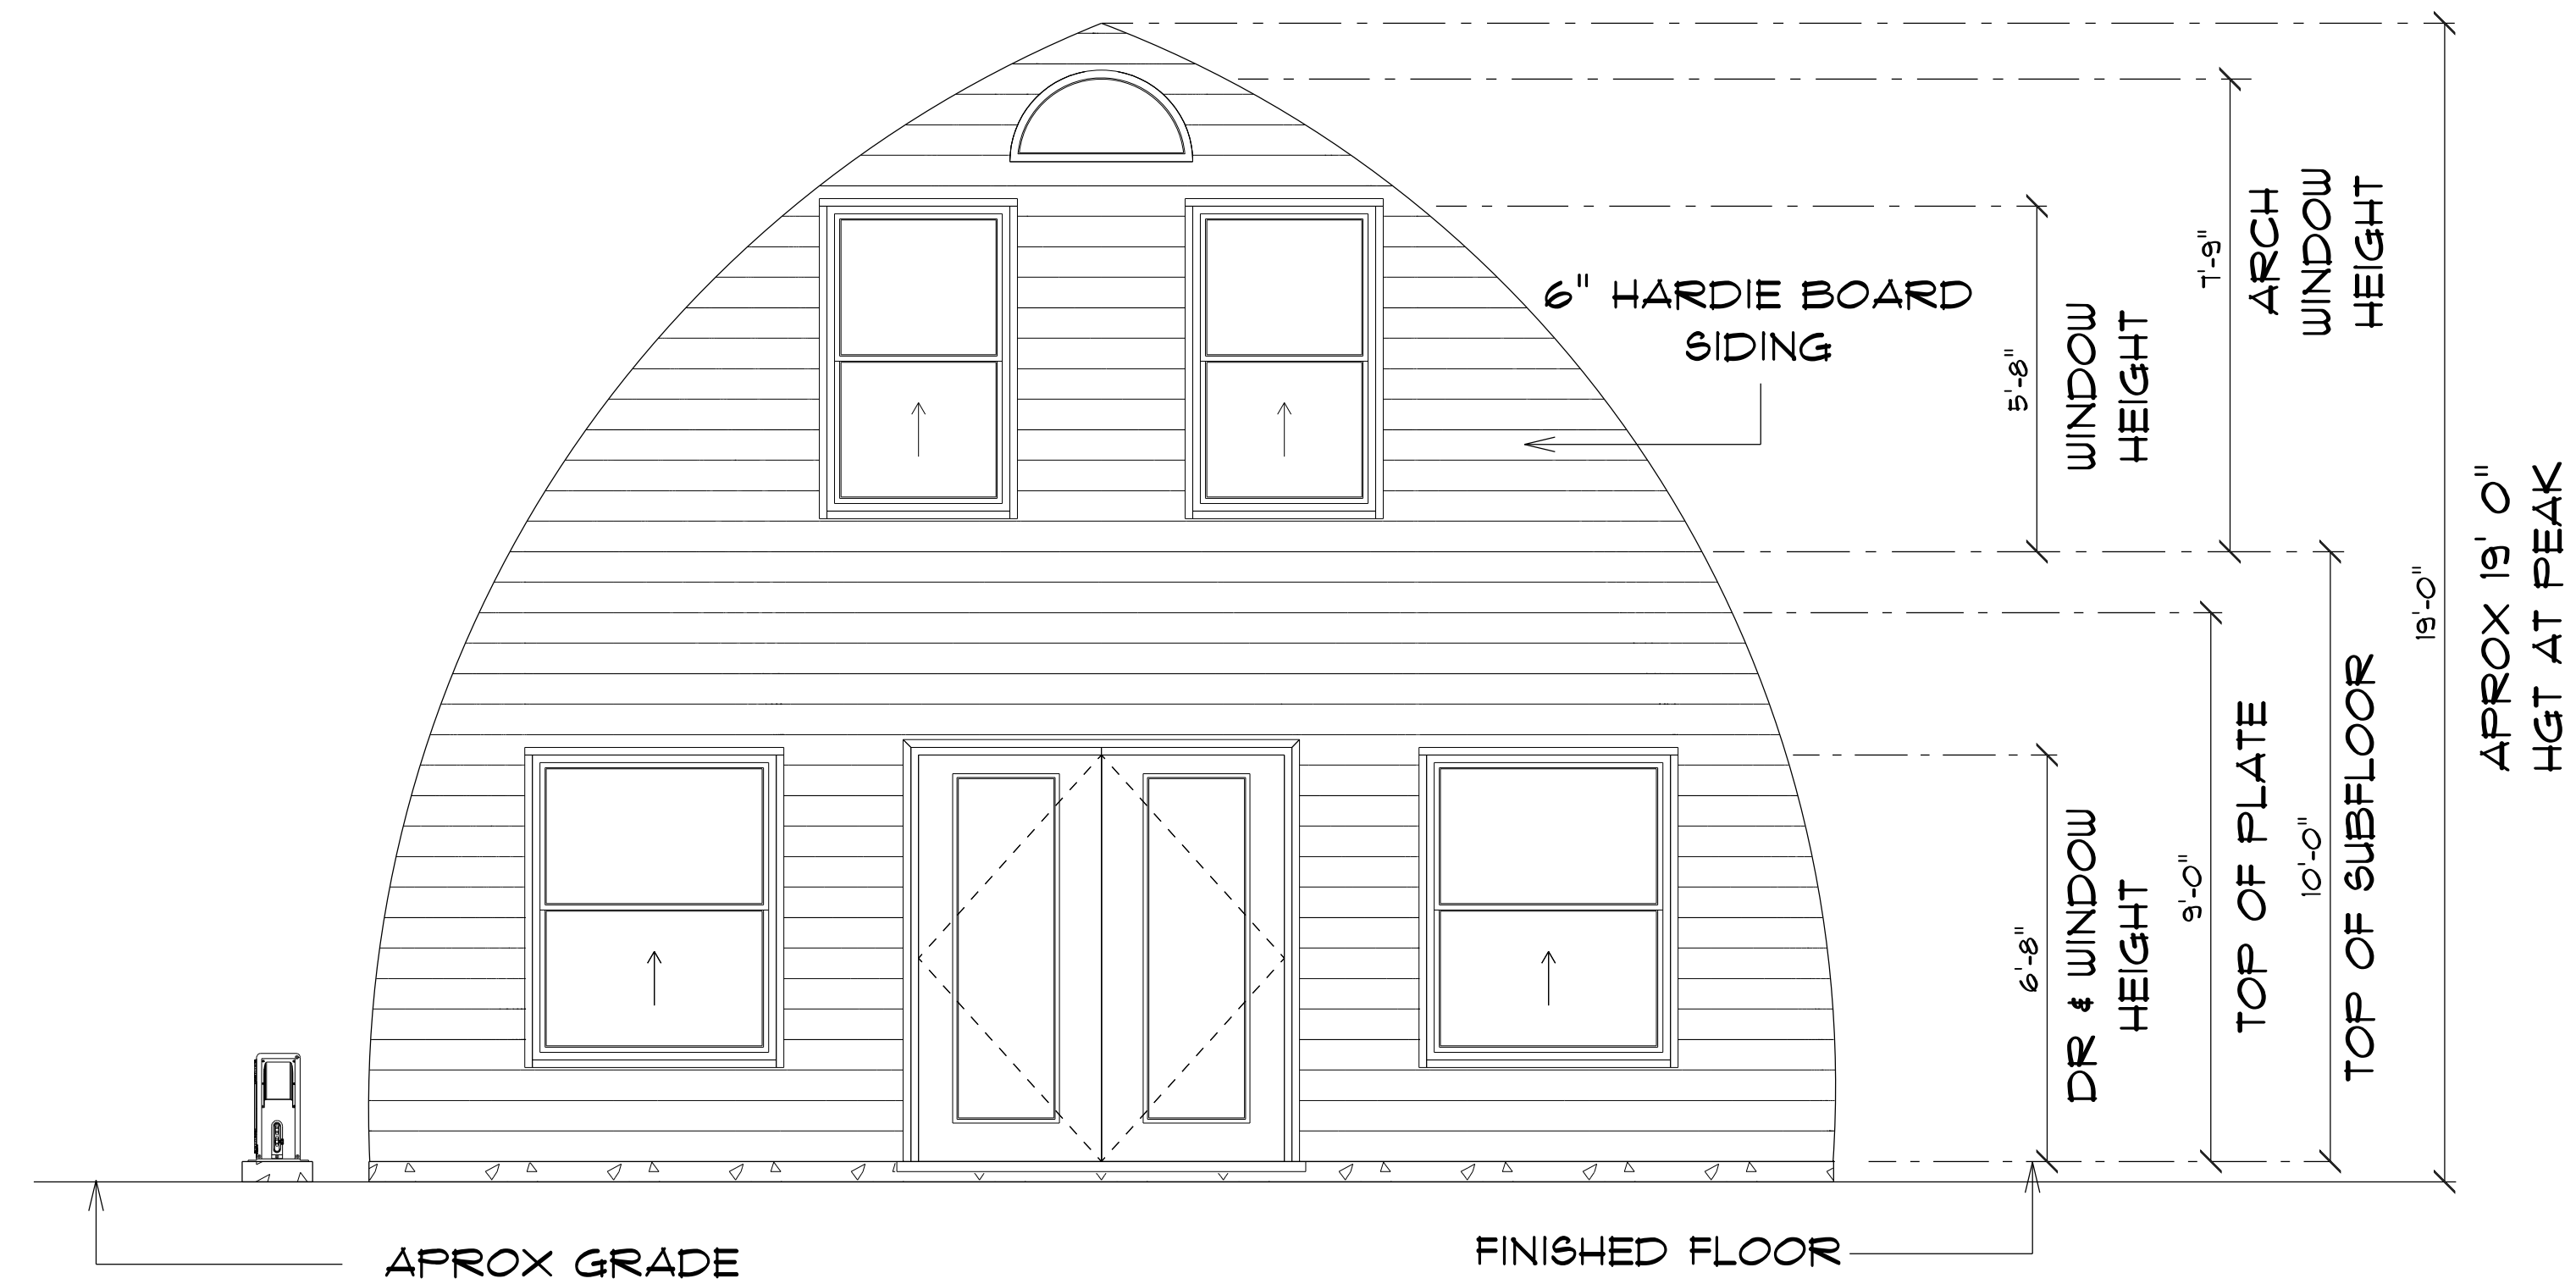

\* FRONT ELEVATION \*

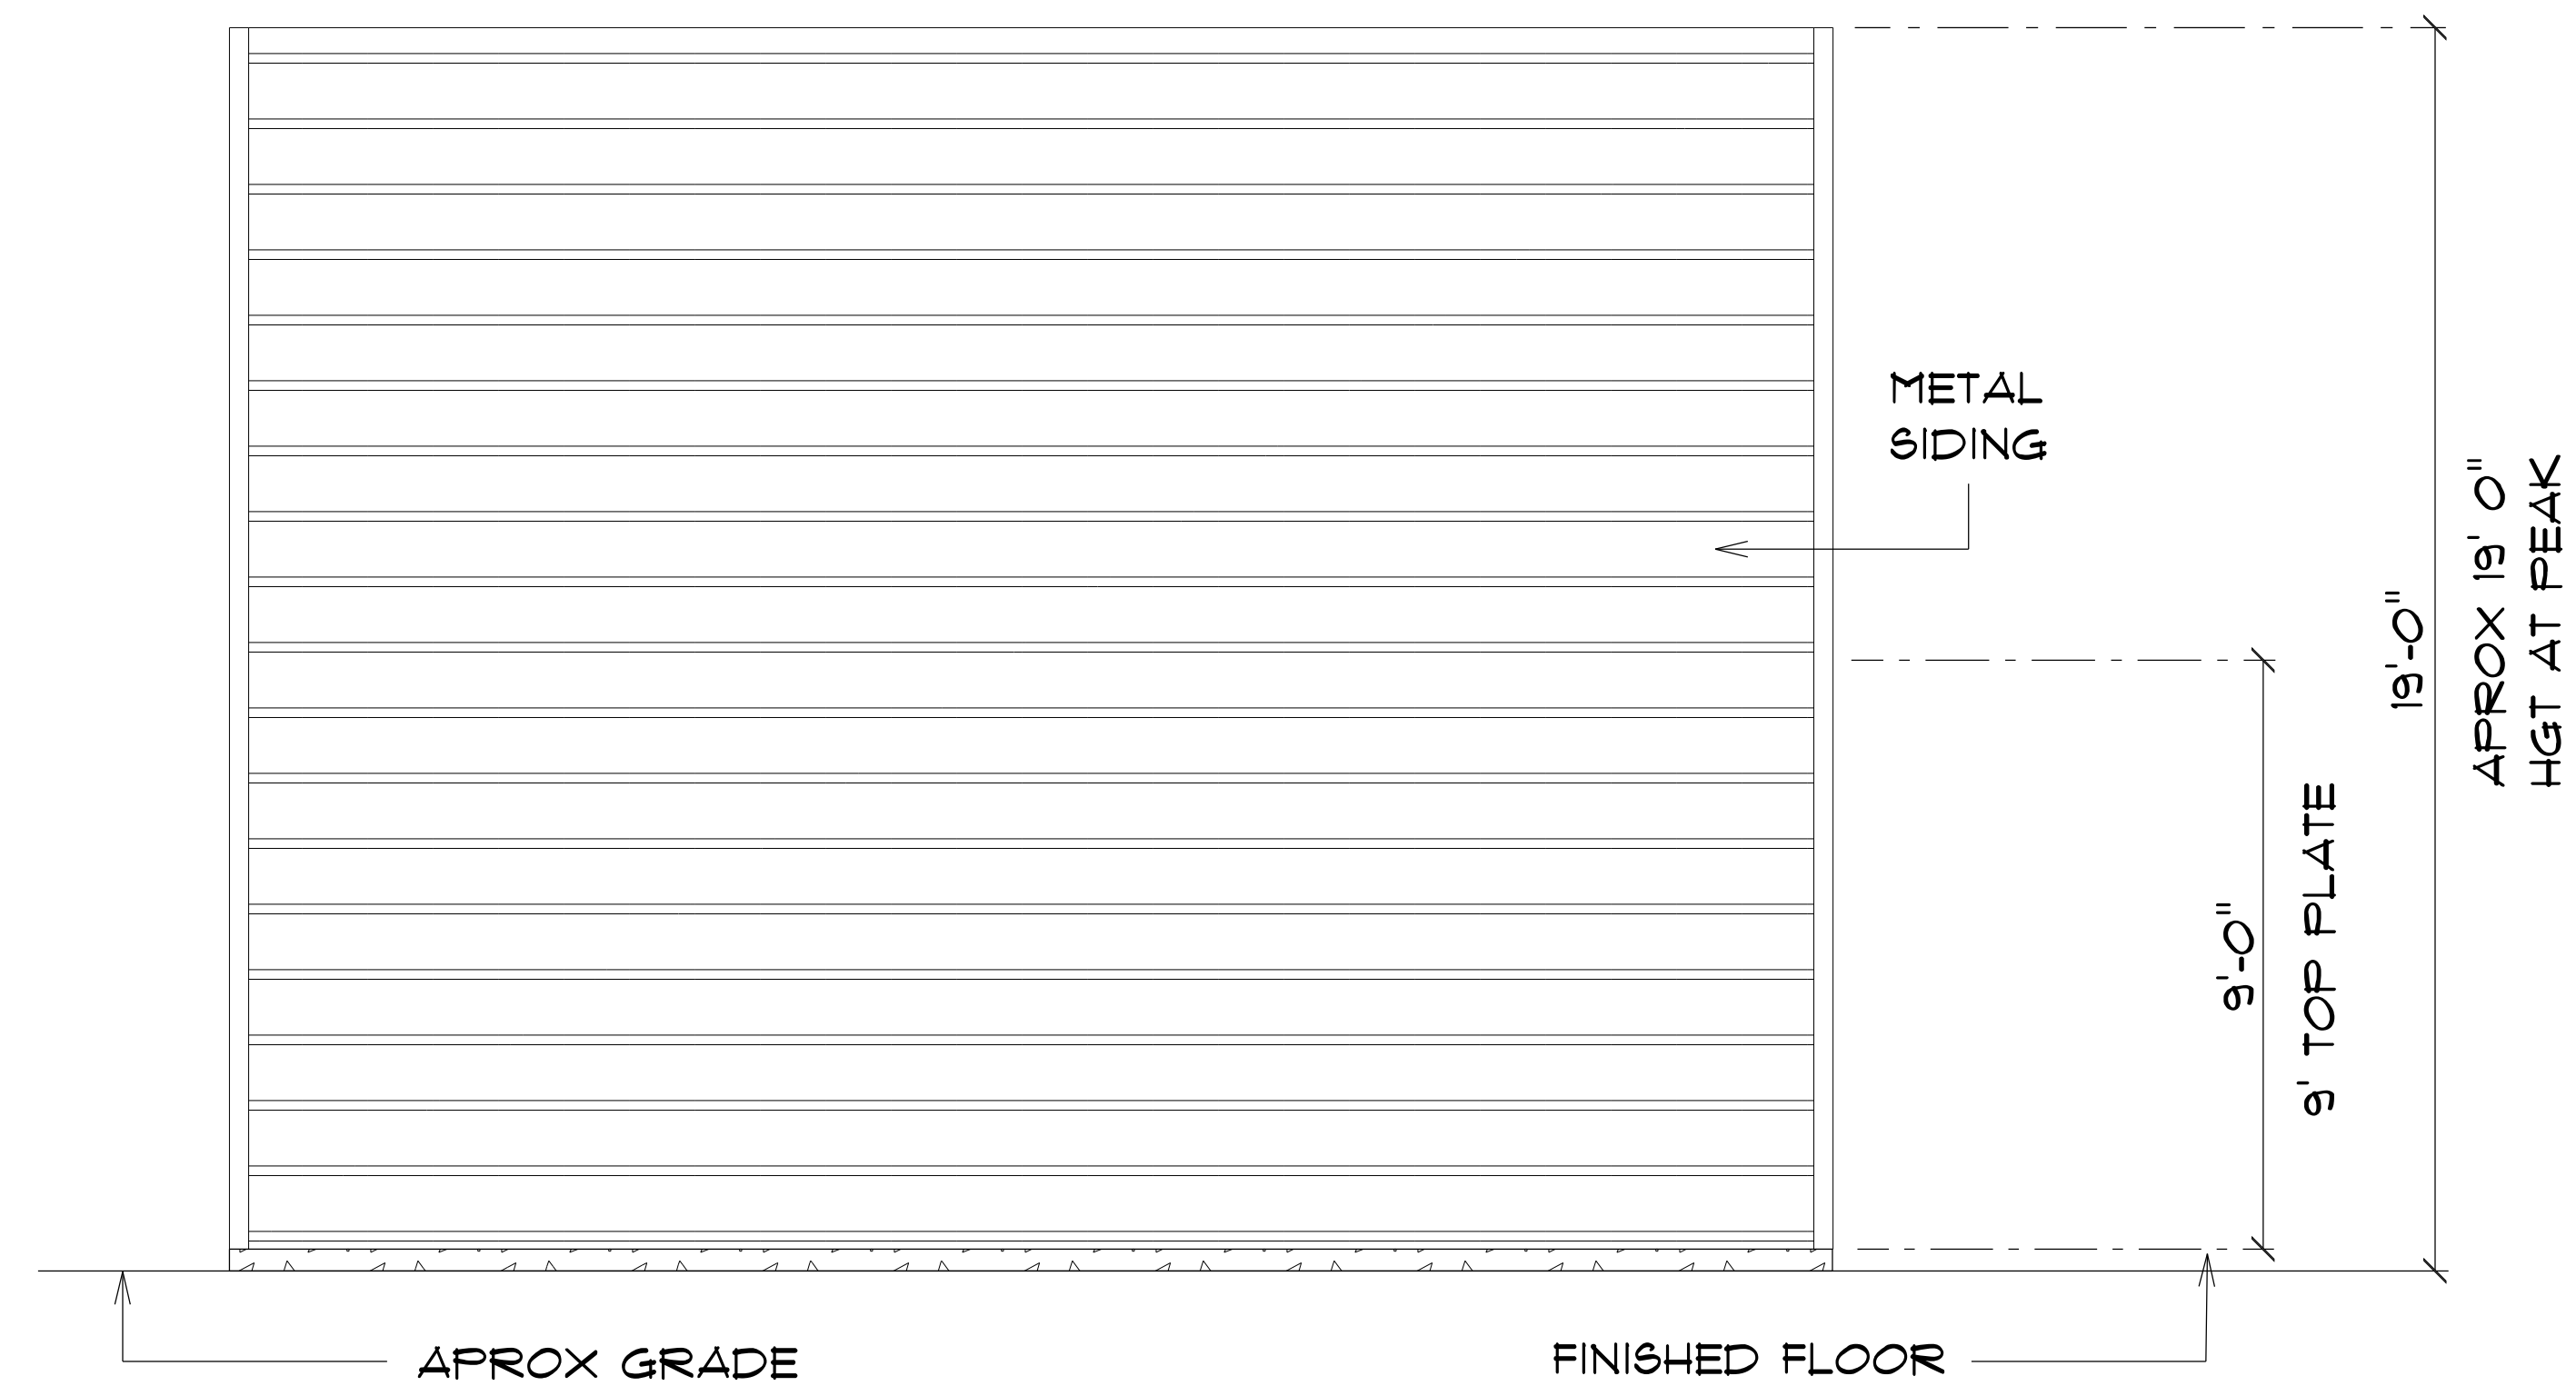

\* RIGHT ELEVATION \*

RESIDENCE  
for  
AMY FOUCHER

669 SW Pleasant Terrace  
Ft. White, FL, 32038  
Cell: (386) 867-1191  
Email: teanaruffo@gmail.com

Teana M. Ruffo  
2925 SW SR 47  
Lake City Florida, 32025  
Cell: (386) 867-1191  
Email: teanaruffo@gmail.com

PRINTED DATE:  
Tuesday, November 12, 2024

DRAWN BY: Teana & Kara CHECKED BY:

BUILDING CONTRACTOR

FINAL DATE:


JOB NUMBER:

DRAWING NUMBER


A - 5

OF 8 SHEETS



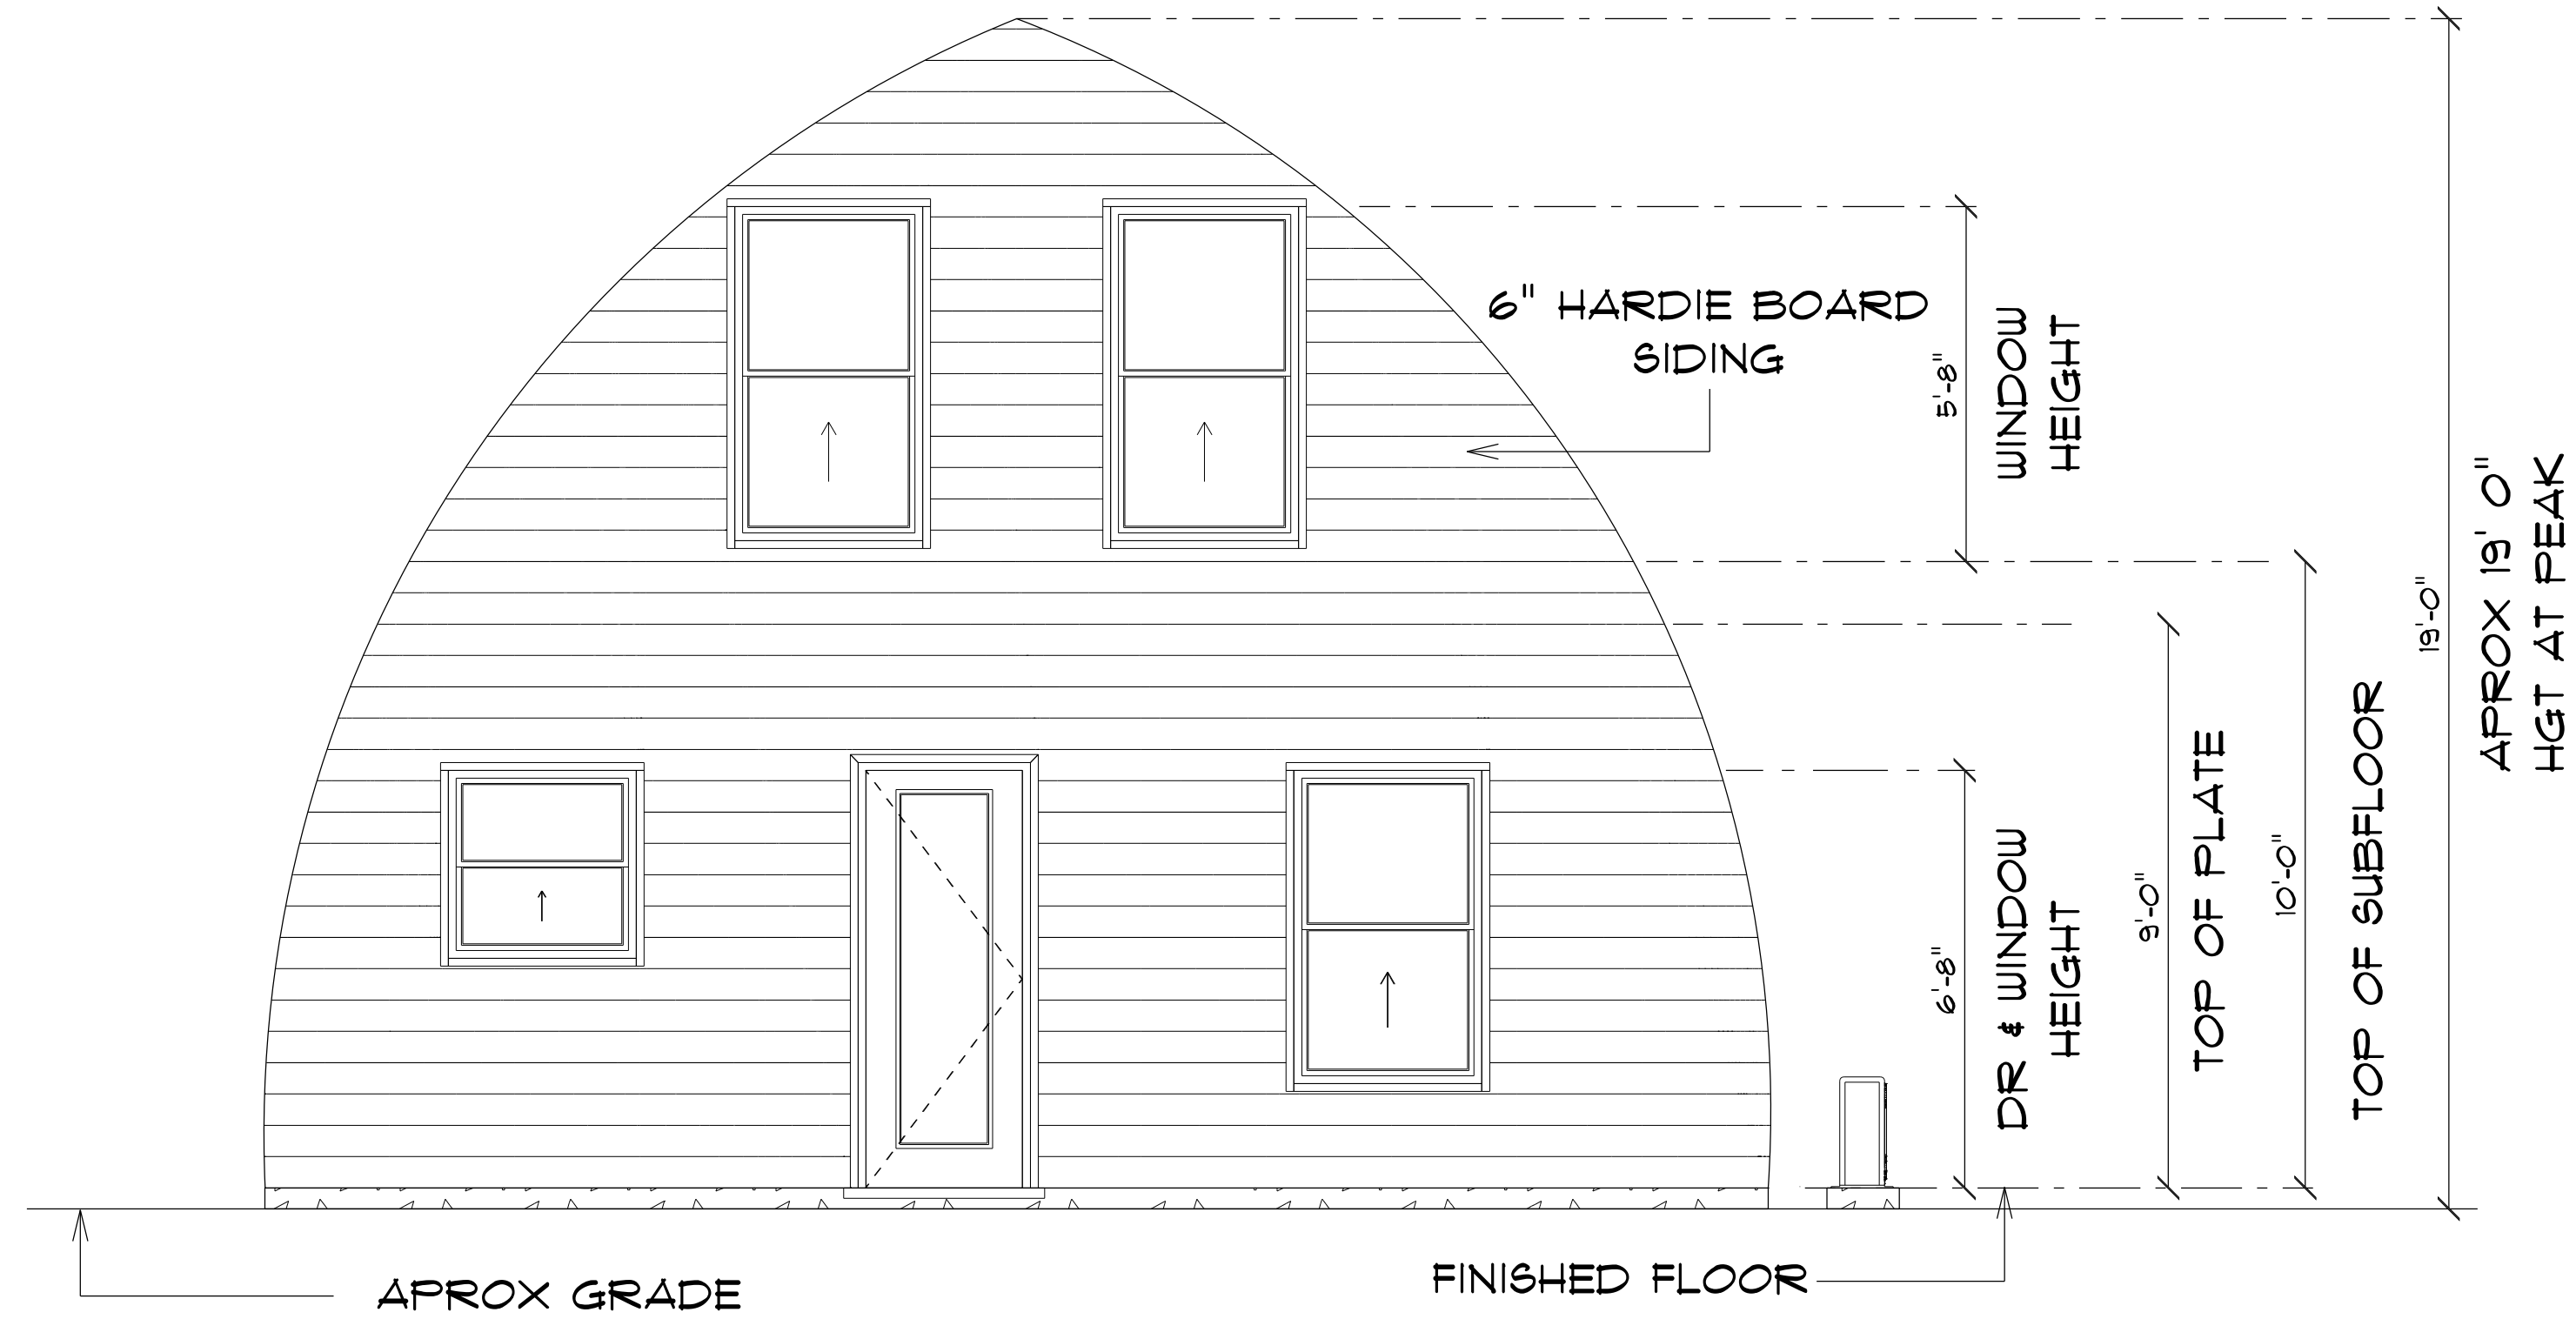

\* REAR ELEVATION \*

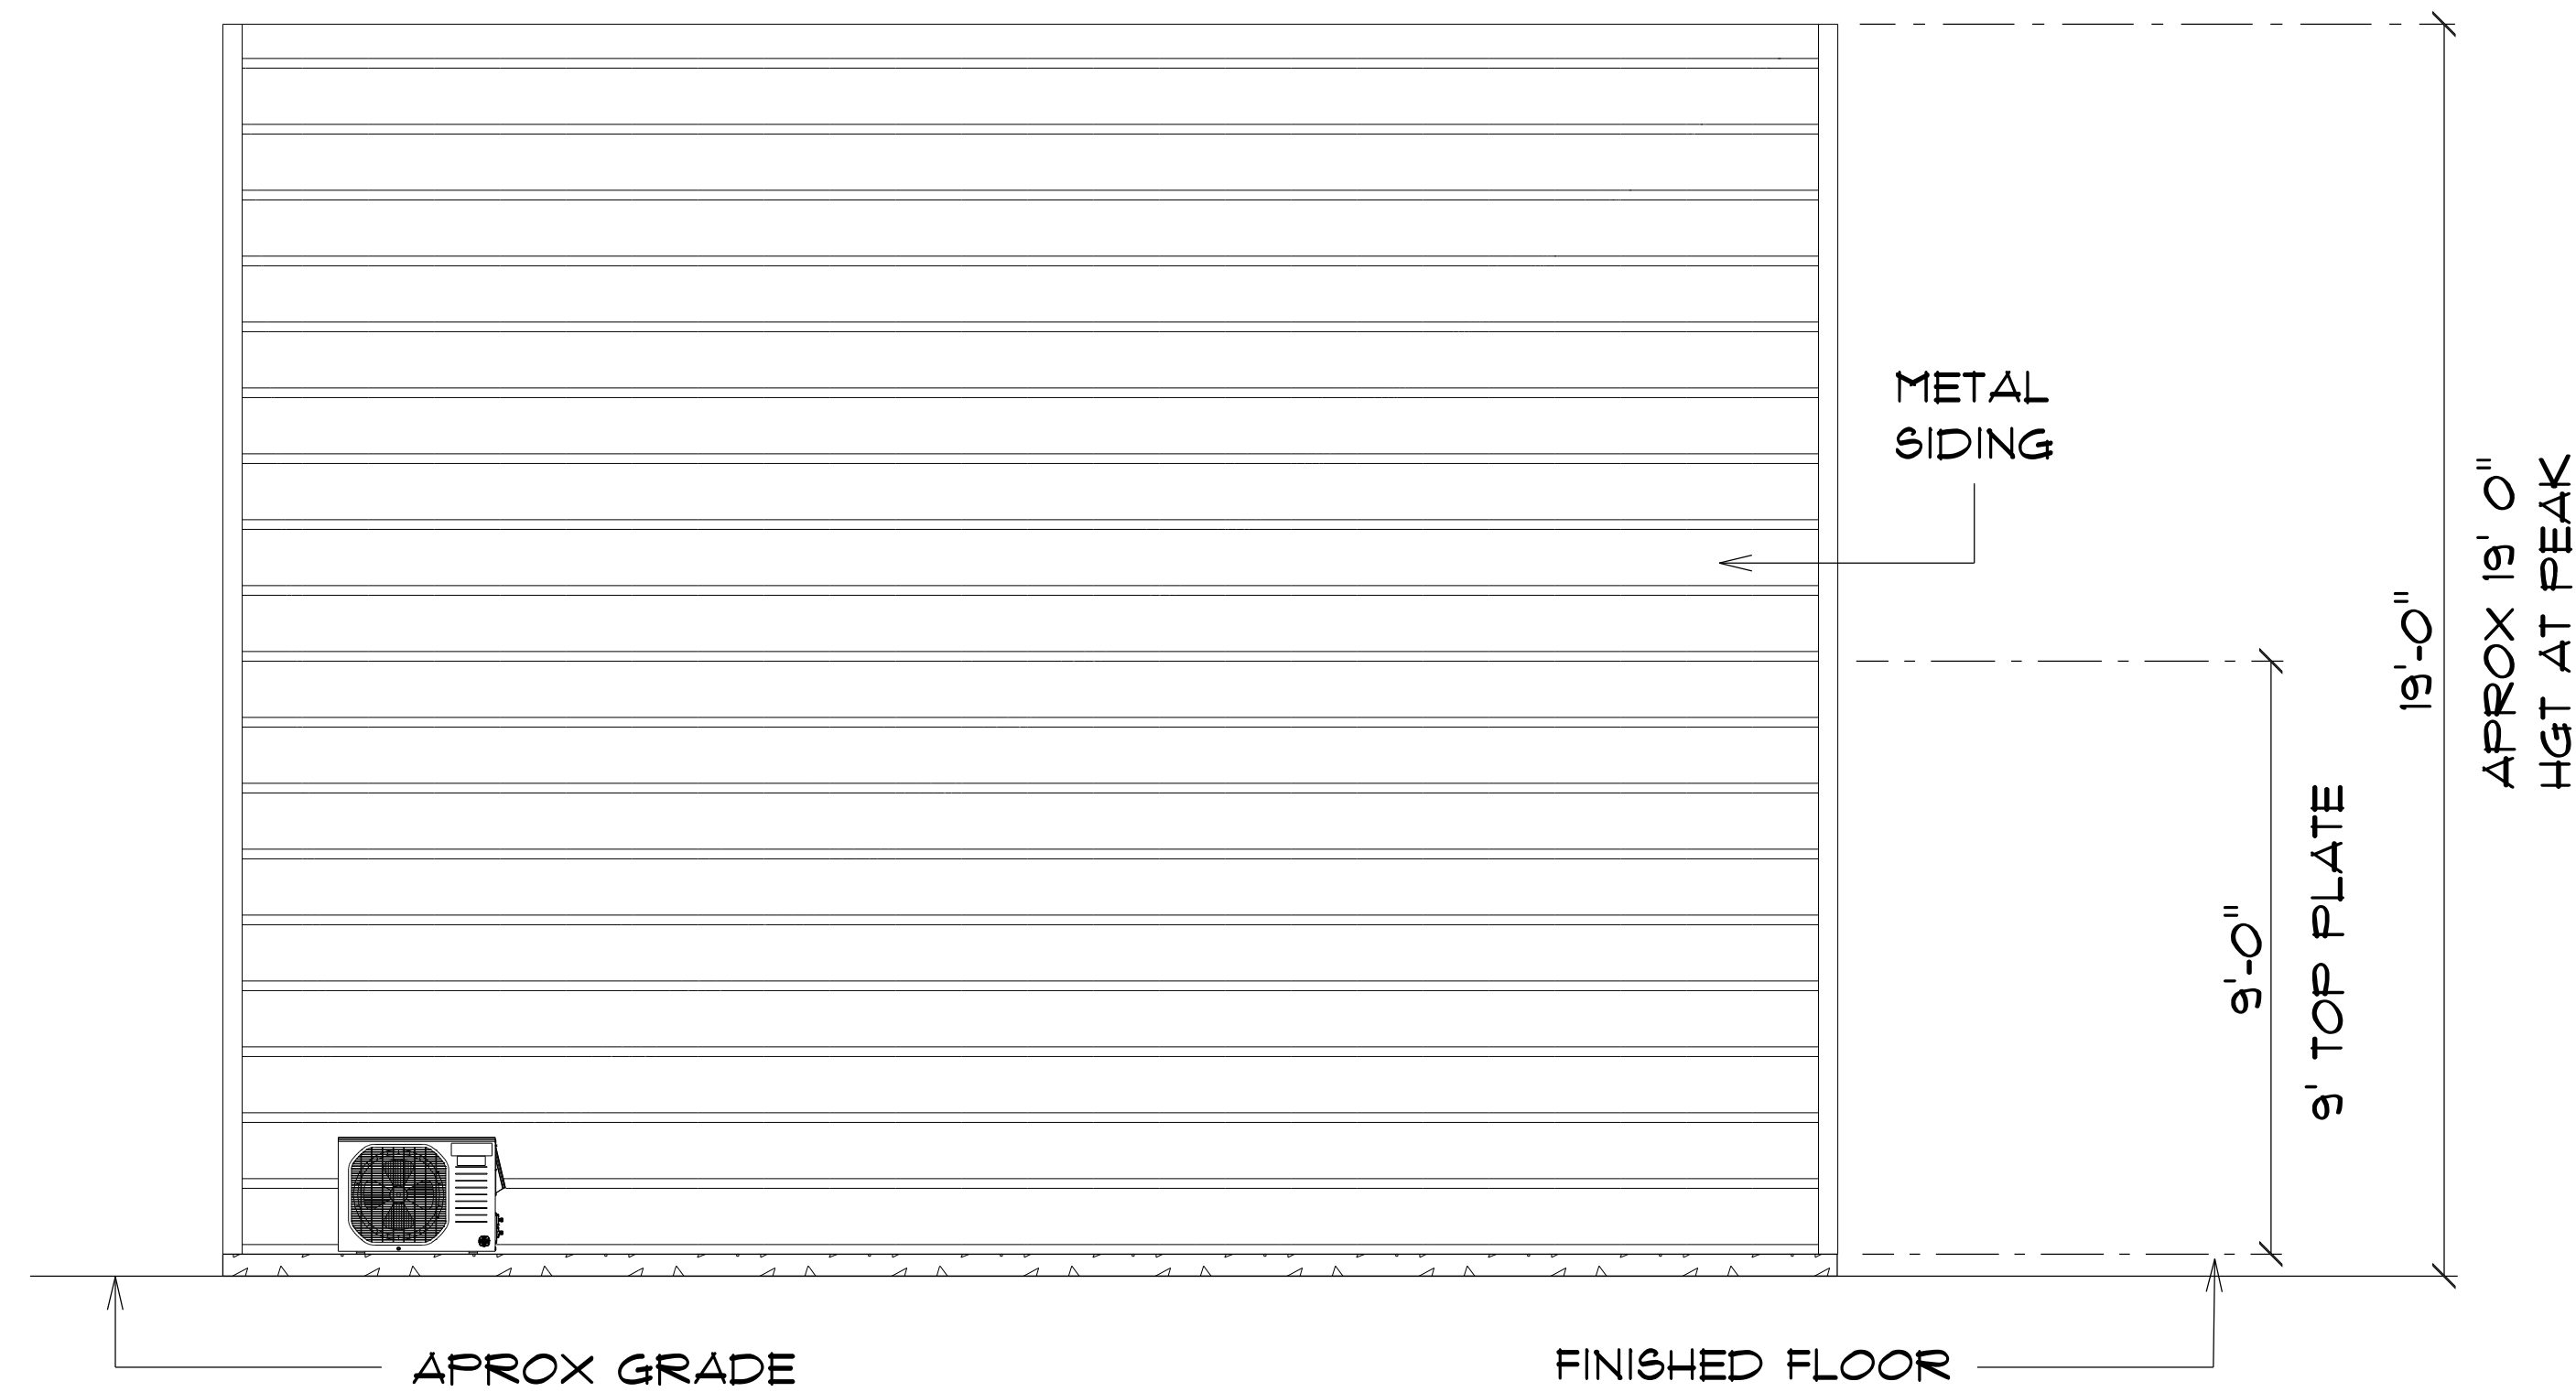

\* LEFT ELEVATION \*

RESIDENCE  
for  
AMY FOUCHER

669 SW Pleasant Terrace  
Ft. White, FL, 32038  
Cell:  
Email:

Teena M. Ruffo  
2925 SW SR 41  
Lake City Florida, 32025  
Cell: (386) 861-1191  
Email: teenaruffo@gmail.com

PRINTED DATE:  
Tuesday, November 12, 2024

DRAWN BY: Teena & Kara CHECKED BY:

BUILDING CONTRACTOR

FINAL DATE:

JOB NUMBER:

DRAWING NUMBER

A - 6

OF 8 SHEETS




| ELECTRICAL LEGEND   |       |        |
|---------------------|-------|--------|
| ELECTRICAL          | COUNT | SYMBOL |
| ceiling classic     | 1     |        |
| ceiling fan         | 3     |        |
| electrical panel    | 1     |        |
| GENERATOR INLET BOX | 1     |        |
| outlet              | 25    |        |
| outlet 220v         | 4     |        |
| outlet gfi          | 6     |        |
| outlet up           | 2     |        |
| pendant large       | 2     |        |
| pot light           | 3     |        |
| smoke detector      | 2     |        |
| spotlight double    | 2     |        |
| switch              | 13    |        |
| switch 3 way        | 5     |        |
| vanity bar light O2 | 1     |        |
| vent light combo    | 1     |        |

ELECTRICAL PLAN NOTES

- E-1 WIRE ALL APPLIANCES, HVAC UNITS AND OTHER EQUIPMENT PER MANUFACTORS SPECIFICATIONS.
- E-2 CONSULT THE OWNER FOR THE NUMBER OF SEPERATE TELEPHONE LINES TO BE INSTALLED.
- E-3 ALL INSTALLATIONS SHALL BE PER NATIONAL ELECTRIC CODE.
- E-4 ALL SMOKE DETECTORS SHALL BE 120V W/BATTERY BACKUP OF THE PHOTOELECTRIC TYPE, AND SHALL BE INTERLOCKED TOGETHER. INSTALL INSIDE AND NEAR ALL BEDROOMS.
- E-5 TELEPHONE, TELEVVISION AND OTHER LOW VOLTAGE DEVICES OR OUTLETS SHALL BE AS PER THE OWNERS DIRECTION AND IN ACCORDANCE WITH APPLICABLE SECTIONS OF NATIONAL ELCT. CODE LATEST EDITION.
- E-6 ELECTRICAL CONTRACTOR SHALL BE RESPONSIBLE FOR THE DESIGN AND SIZING OF ELECTRICAL SERVICE AND CIRCUITS.
- E-7 ENTRY OF SERVICE UNDERGROUND OR OVERHEAD) IS TO BE DETERMINED BY THE POWER COMPANY.
- E-8 ALL BEDROOM RECEPTICALS ARE TO BE AFCI (ARC FAULT CIRCUIT INTERRUPT)

|                       |   |          |
|-----------------------|---|----------|
| MAIN A/C LIVING AREA  | = | 576 S.F. |
| LOFT AREA             | = | 226 S.F. |
| <hr/>                 |   |          |
| TOTAL AREA UNDER ROOF | = | 802 S.F. |

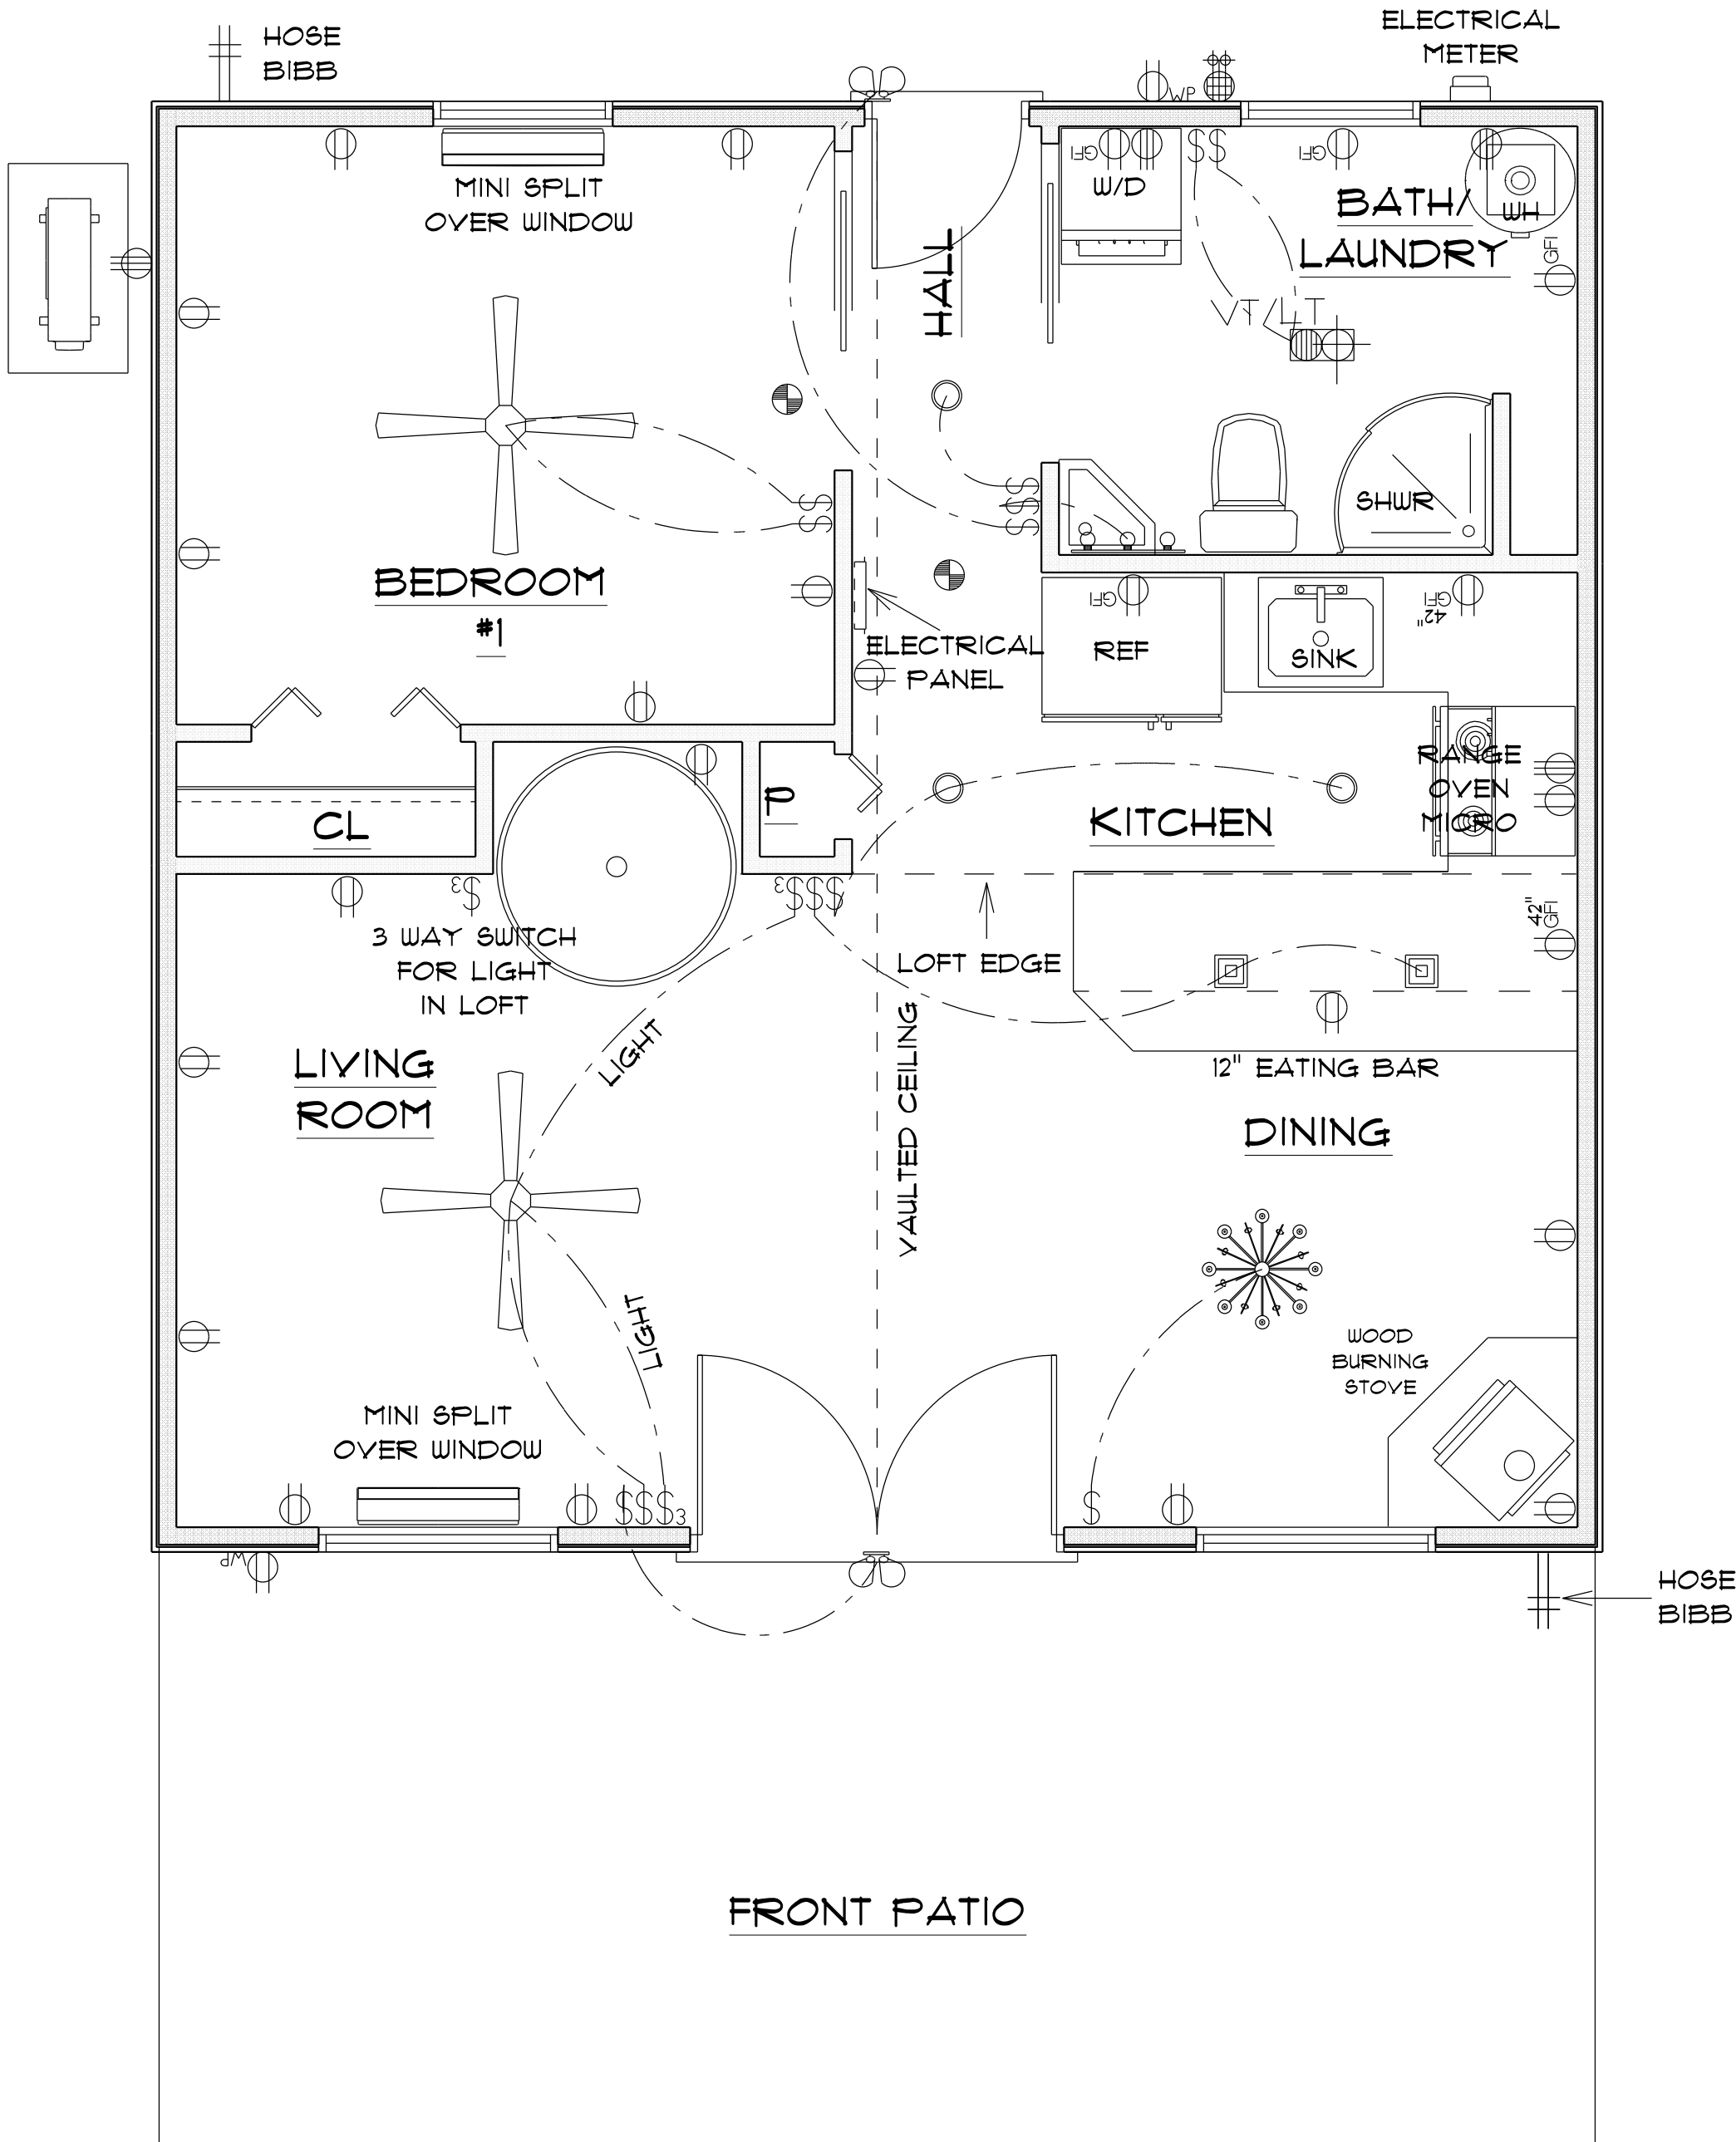

\* MAIN FLOOR \*  
\* ELECTRICAL PLAN \*

SCALE : 3/8" = 1'-0"

IMPORTANT NOTE:

1. IT IS THE BUILDERS RESPONSIBILITY TO VERIFY ALL GEOMETRY AND DIMENSIONS BEFORE ORDERING ANY MATERIALS OR BEGINNING CONSTRUCTION.
2. THESE PLANS ARE FOR LAYOUT AND DESIGN PURPOSES ONLY ALL STRUCTURAL NOTES AND DETAILS TO BE PROVIDED BY AN ENGINEER.
3. 2X6 EXTERIOR STUD WALLS 2X4 INTERIOR WALLS

RESIDENCE  
for  
AMY FOUCHER  
669 SW Pleasant Terrace  
Ft. White, FL, 32038  
Cell:  
Email:

Teena M. Ruffo  
2925 SW SR 47  
Lake City Florida, 32025  
Cell: (386) 867 - 1191  
Email: teenaruffo@gmail.com

PRINTED DATE:  
Tuesday, November 12, 2024

DRAWN BY: CHECKED BY:


Teena & Kara BUILDING CONTRACTOR

FINAL& DATE:

JOB NUMBER:

DRAWING NUMBER  
A - 1  
OF 2 SHEETS



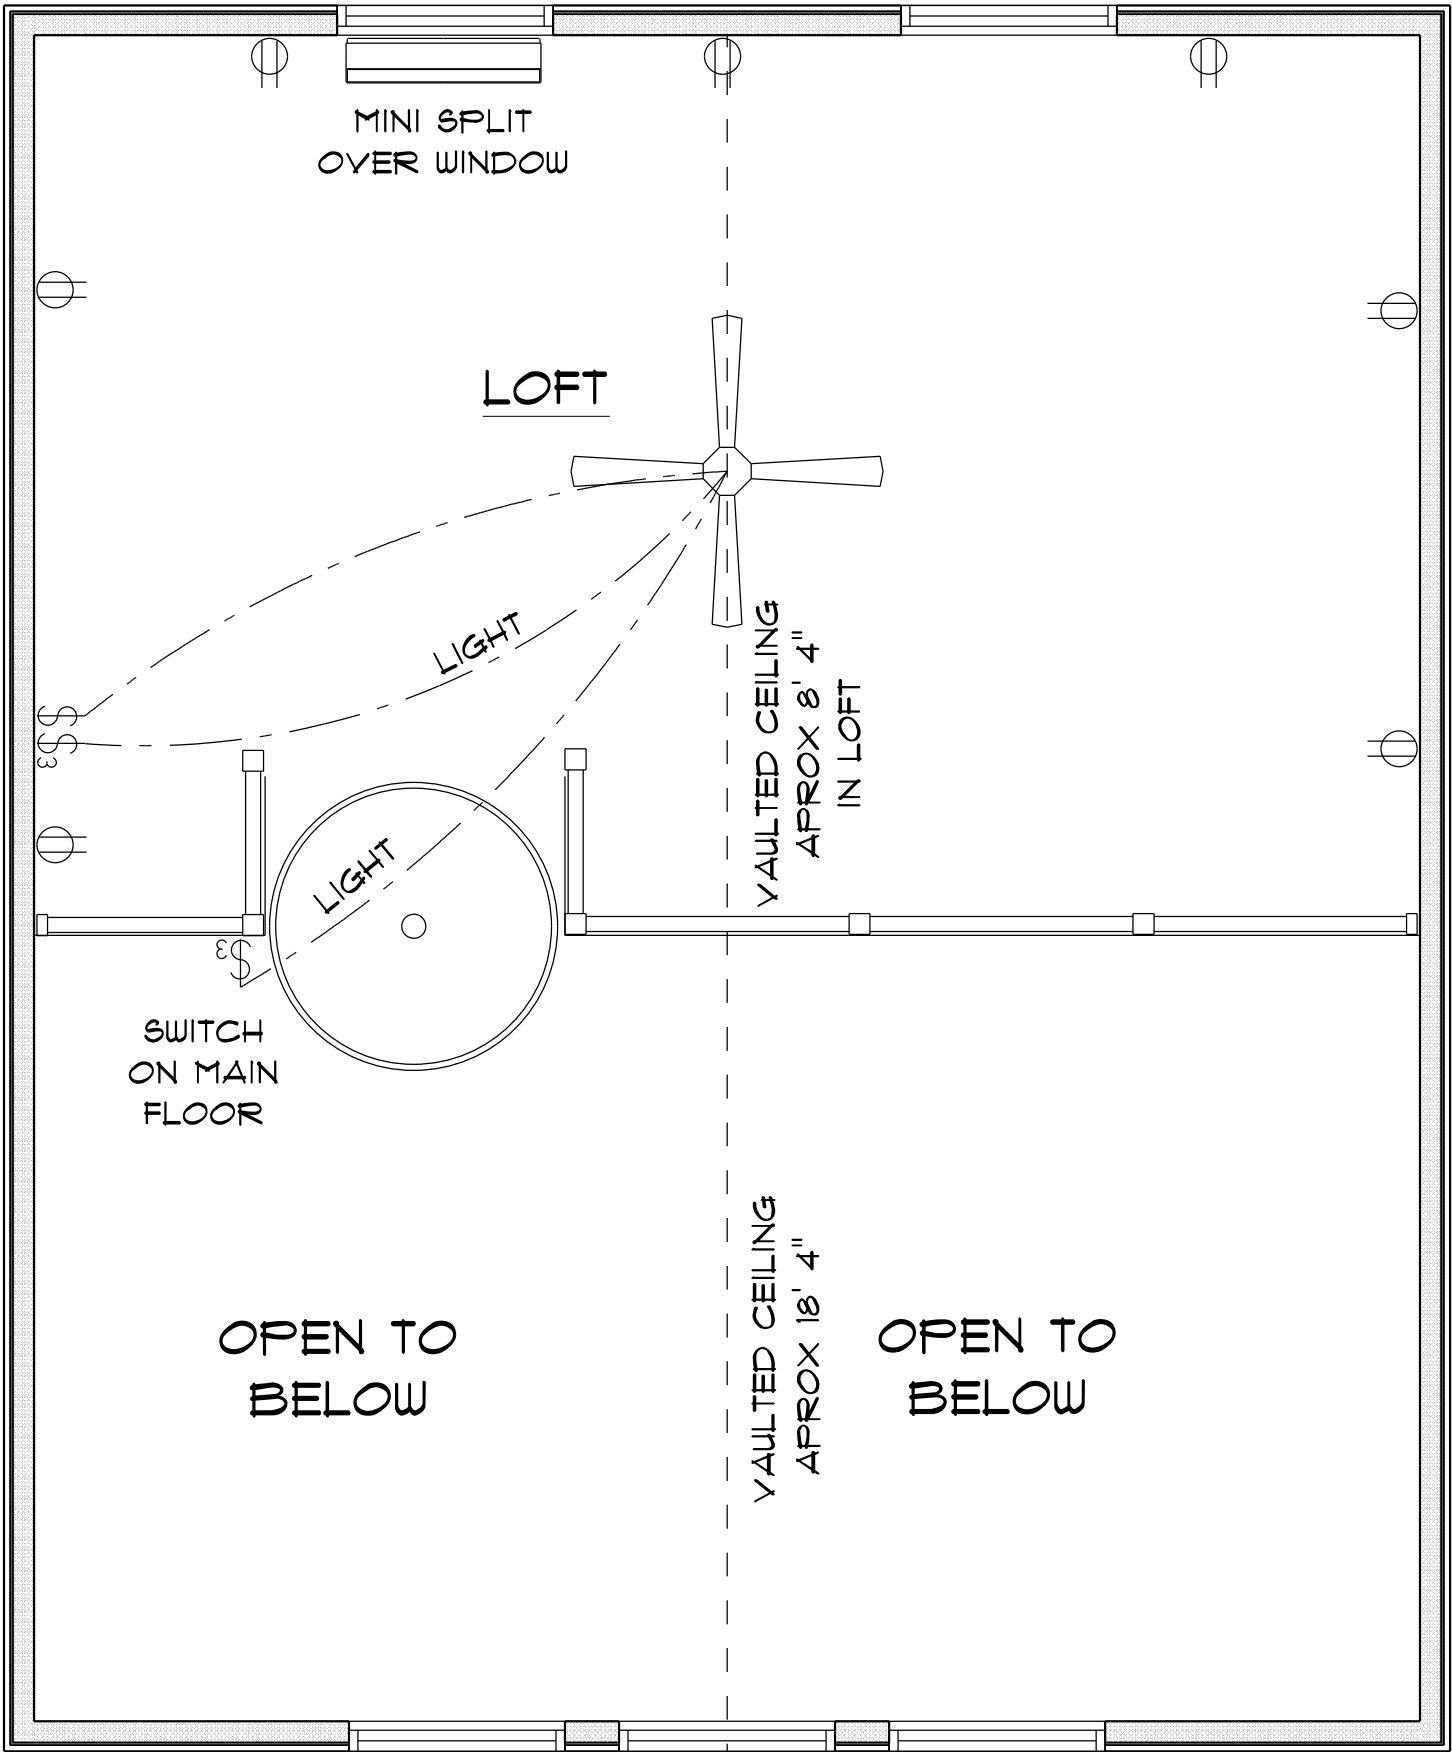

\* SECOND FLOOR \*  
\* ELECTRICAL PLAN \*

|                                                                                                                      |             |
|----------------------------------------------------------------------------------------------------------------------|-------------|
| RESIDENCE<br>for<br>AMY FOUCHER                                                                                      |             |
| 669 SW Pleasant Terrace<br>Ft. White, FL, 32038<br>Cell:<br>Email:                                                   |             |
| Teena M. Ruffo<br>2925 SW SR 47<br>Lake City Florida, 32025<br>Cell: (386) 867 - 1191<br>Email: teenaruffo@gmail.com |             |
| PRINTED DATE:<br>Tuesday, November 12, 2024                                                                          |             |
| DRAWN BY:<br>Teena & Kara                                                                                            | CHECKED BY: |
| BUILDING CONTRACTOR                                                                                                  |             |
| FINAL \$ DATE:                                                                                                       |             |
| JOB NUMBER:                                                                                                          |             |
| DRAWING NUMBER<br>A - 8<br>OF 8 SHEETS                                                                               |             |