



TR3-24'

long-36'


R&M CONSTRUCTION
& DEVELOPMENT LLC
PHONE: 352-538-9697
E randomconstruction@yahoo.com

NOAH & TIFFANY YOST


NOTES: COLUMBIA COUNTY

SECTION
LETTER

PAGE
NUMBER

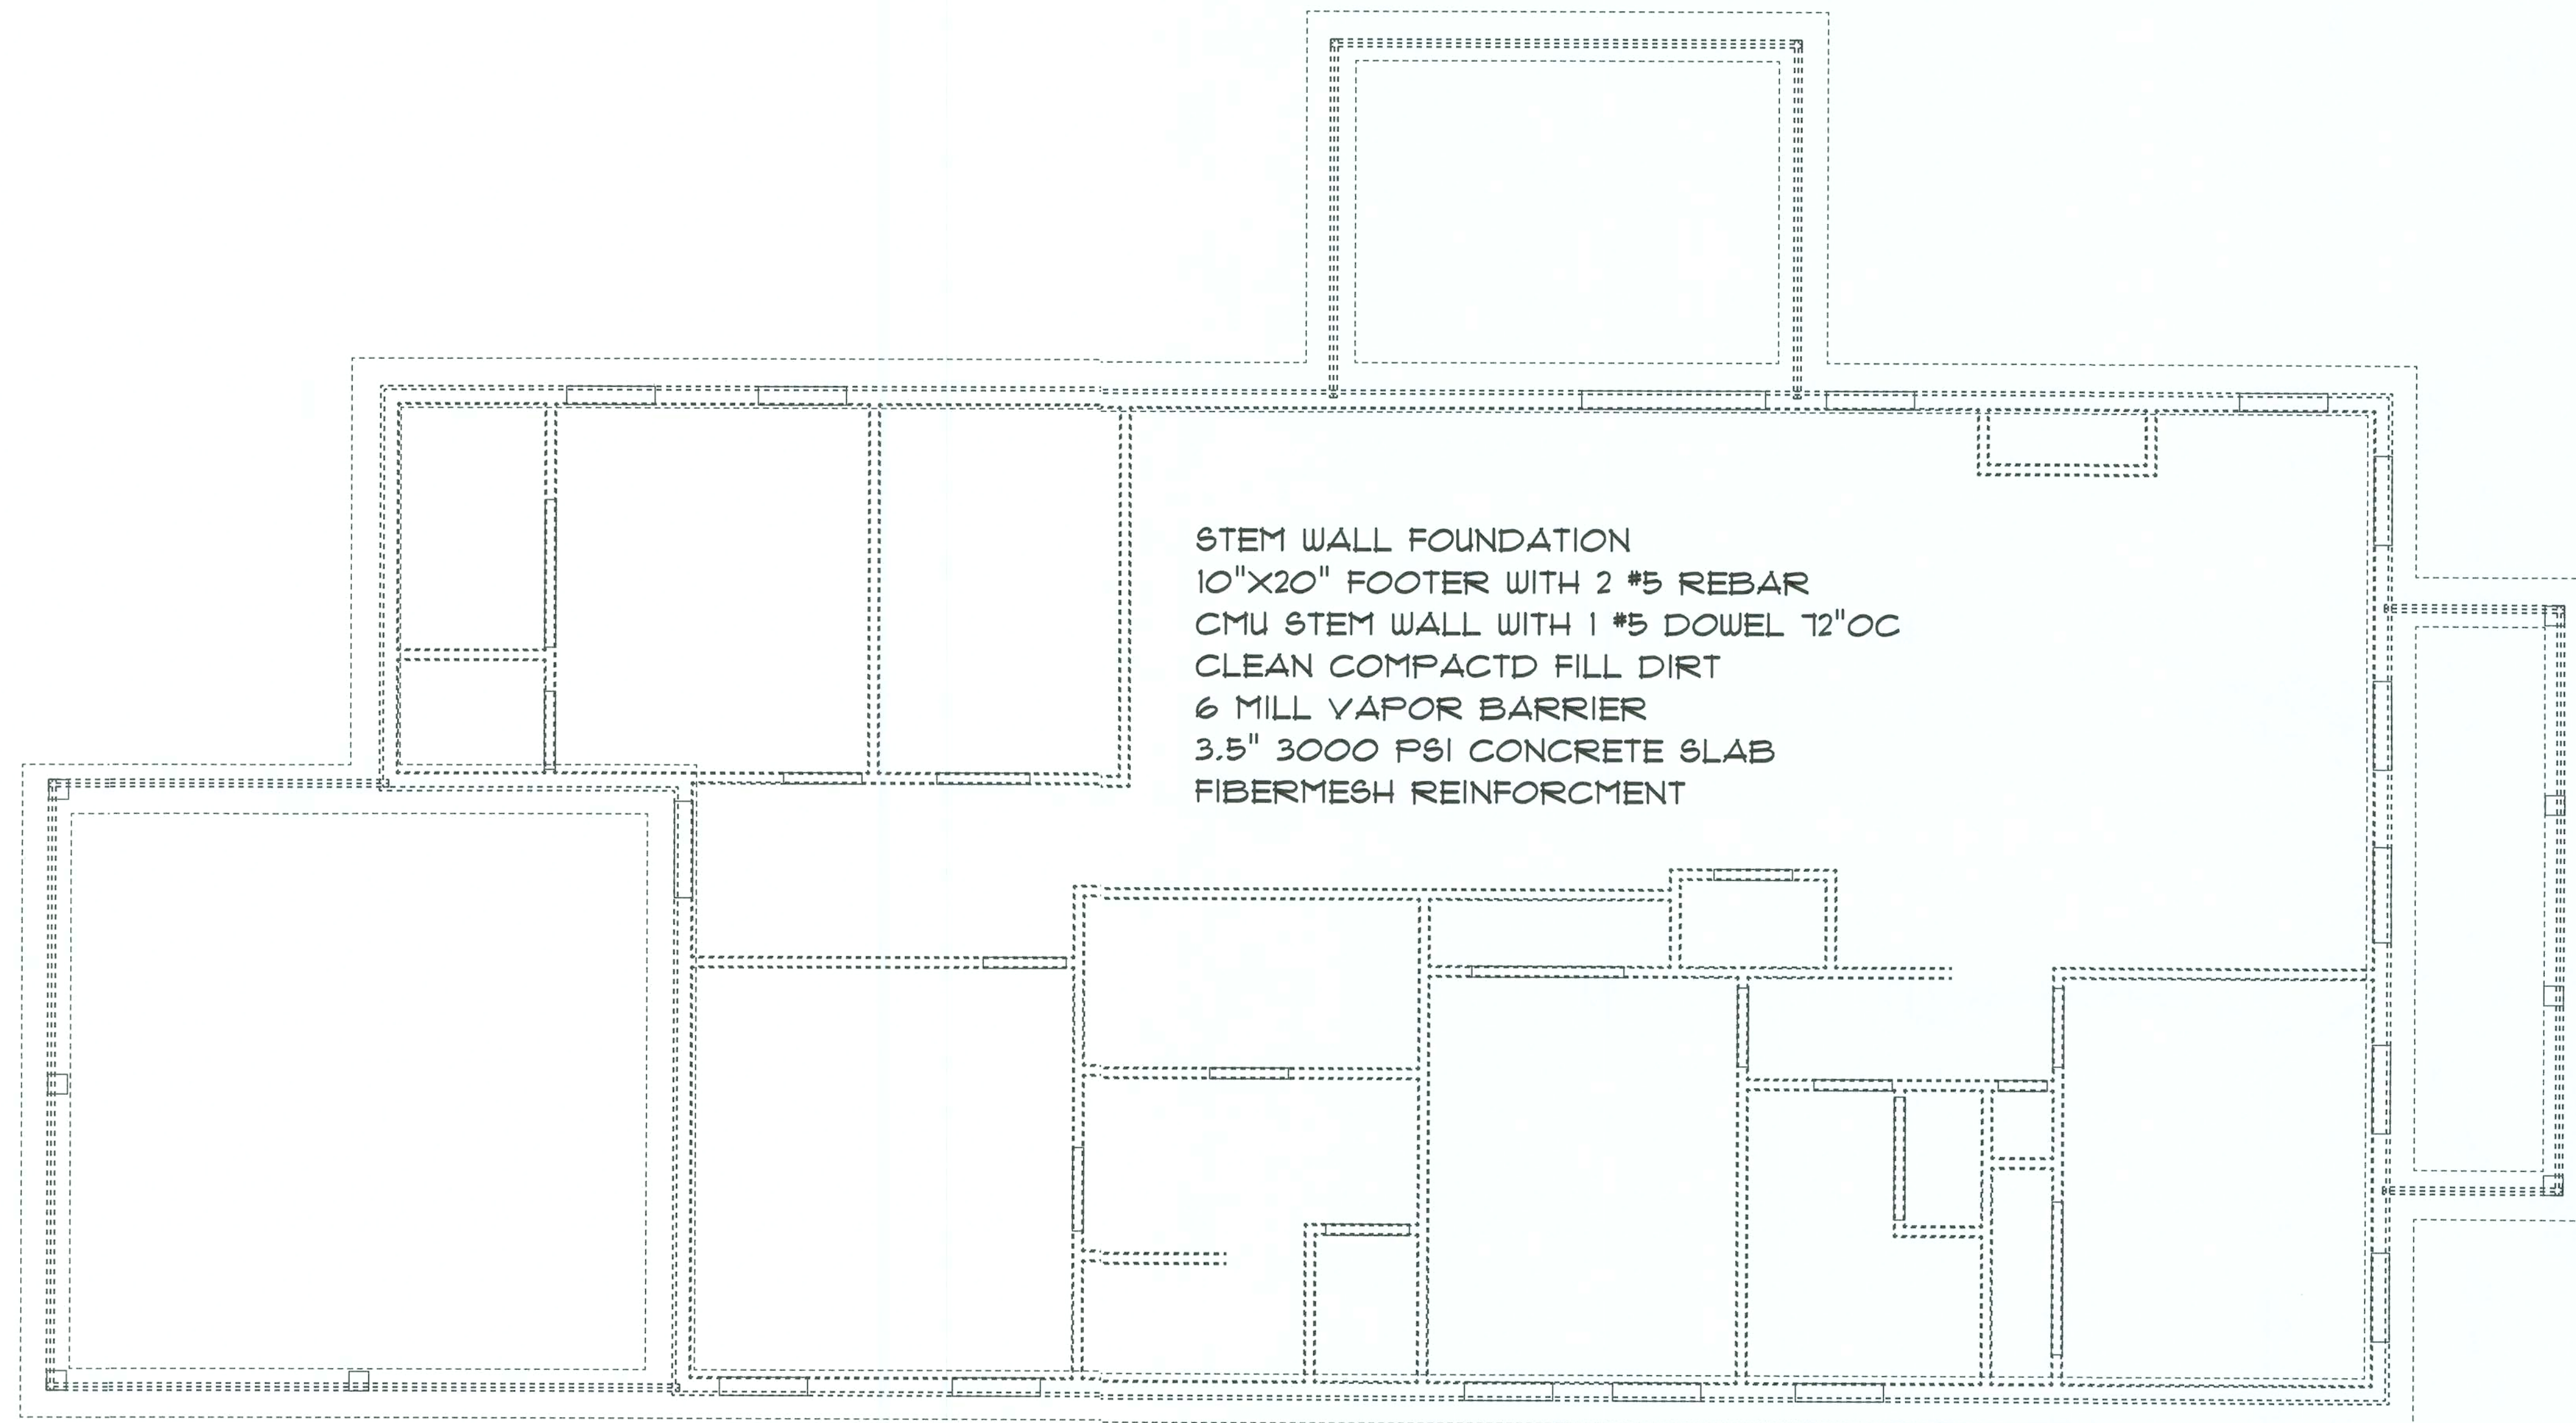


STEM WALL FOUNDATION
10"X20" FOOTER WITH 2 #5 REBAR
CMU STEM WALL WITH 1 #5 DOWEL 12"OC
CLEAN COMPACTD FILL DIRT
6 MILL VAPOR BARRIER
3.5" 3000 PSI CONCRETE SLAB
FIBERMESH REINFORCMENT

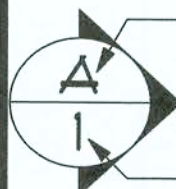SOFTPLAN ARCHITECTURAL DESIGN SOFTWARE	R&M CONSTRUCTION & DEVELOPMENT LLC PHONE: 352-538-9691 randmconstruction@yahoo.com	
	NOAH & TIFFANY YOST	
DRAWN BY: ROBERT CLARK	NOTES: COLUMBIA COUNTY	 SECTION LETTER PAGE NUMBER
SCALE: 1/4"=1'		
DATE: 04/18/2019		
REVISED:		




FRONT ELEVATION

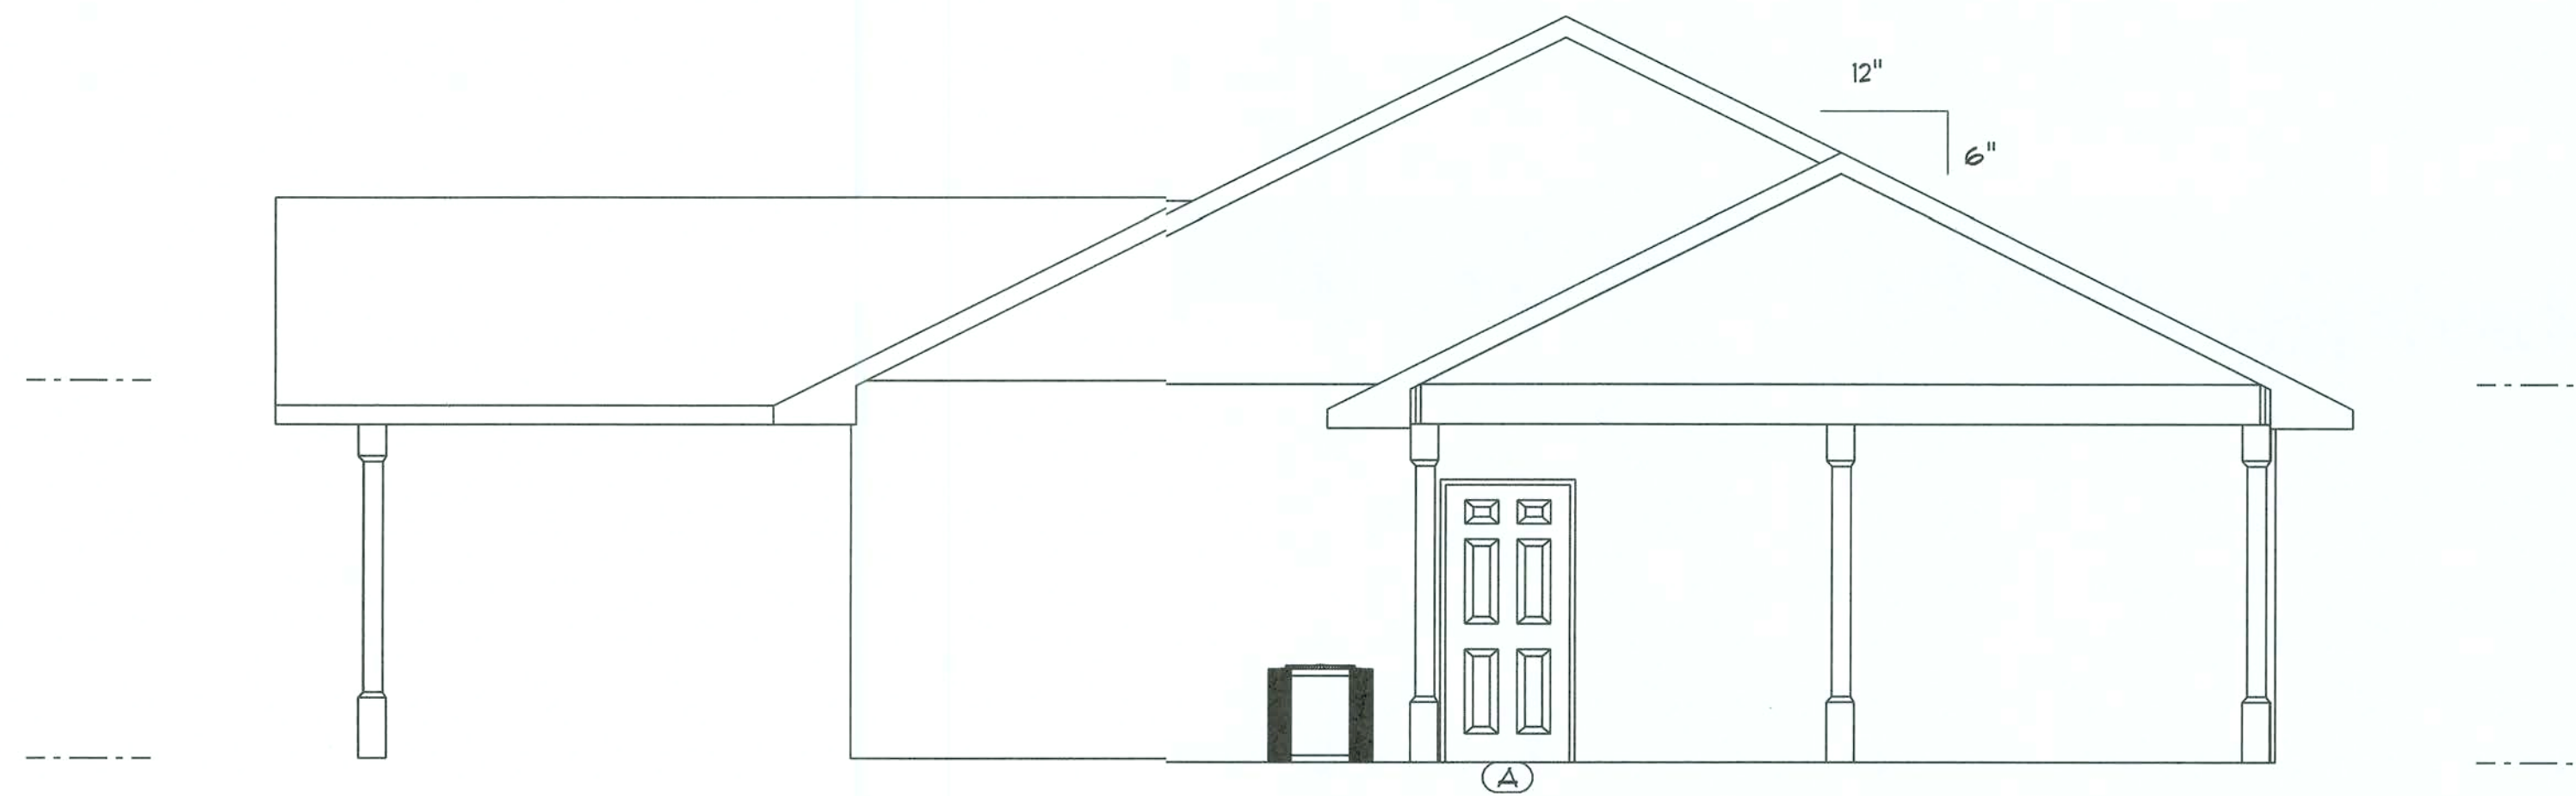

REAR ELEVATION

SOFTPLAN ARCHITECTURAL DESIGN SOFTWARE		R&M CONSTRUCTION & DEVELOPMENT LLC PHONE: 352-538-9691 randmconstruction@yahoo.com	
		NOAH & TIFFANY YOST NOTES: COLUMBIA COUNTY	
DRAWN BY: ROBERT CLARK SCALE: 1/4"=1' DATE: 04/18/2019 REVISED:		SECTION LETTER A PAGE NUMBER	

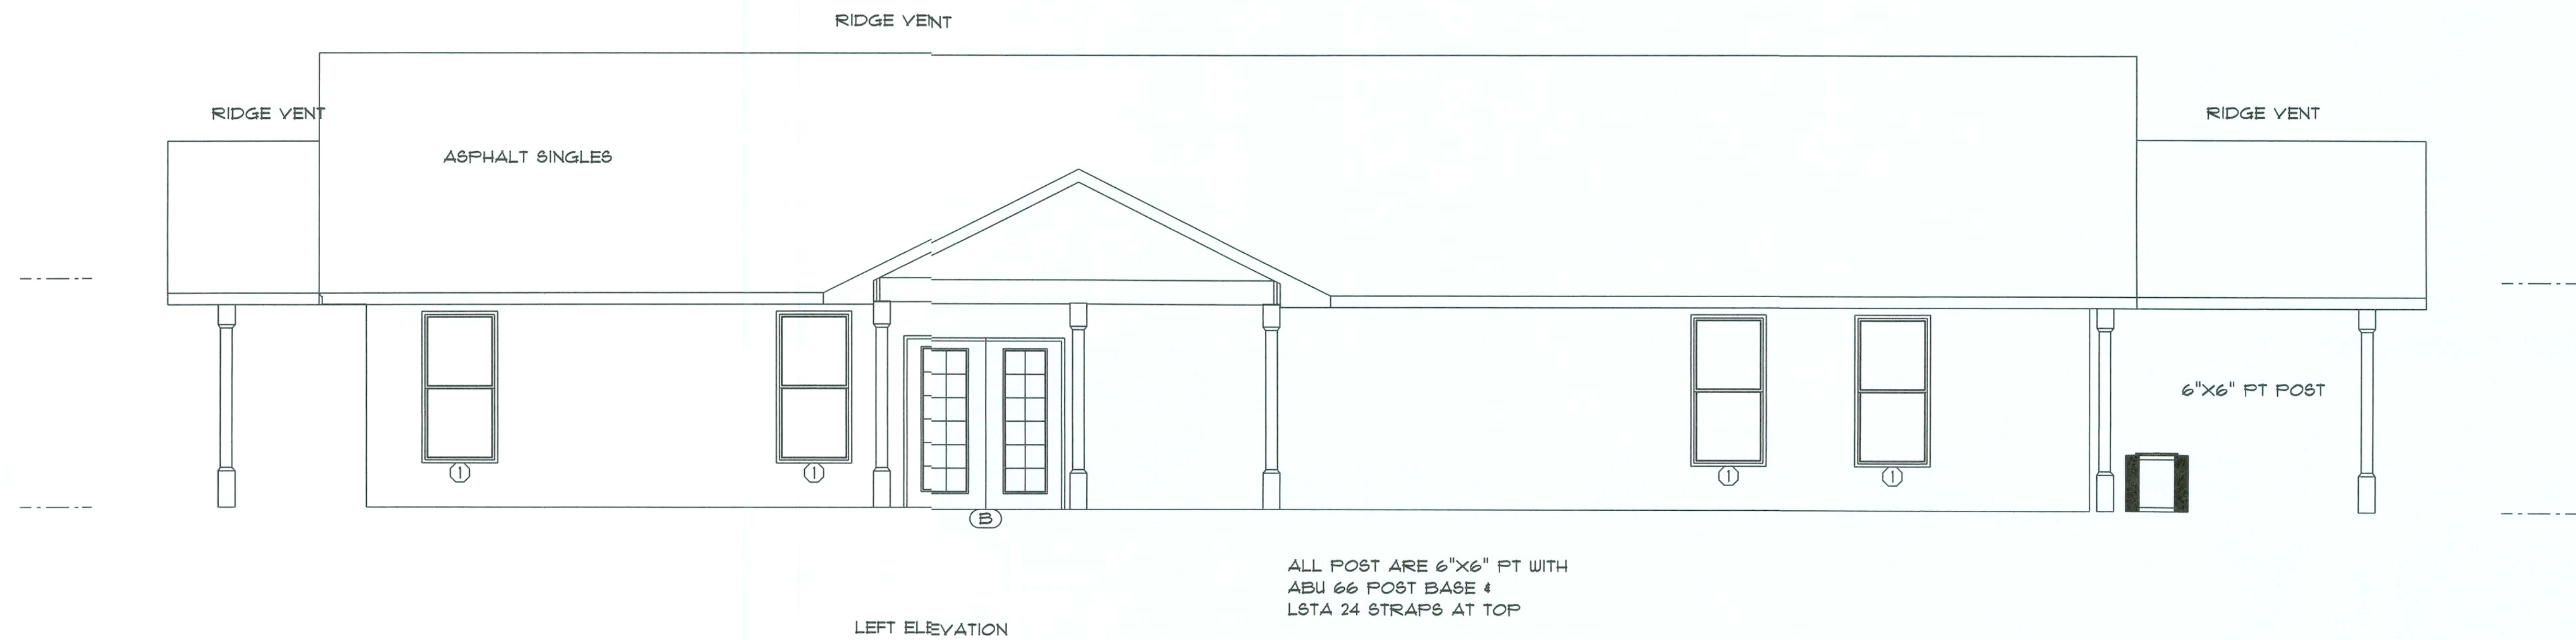


SOFTPLAN ARCHITECTURAL DESIGN SOFTWARE		R#M CONSTRUCTION & DEVELOPMENT LLC PHONE: 352-538-9691 randmconstruction@yahoo.com	
DRAWN BY: ROBERT CLARK		NOAH & TIFFANY YOST	
SCALE: 1/4"=1'		NOTES: COLUMBIA COUNTY	
DATE: 04/18/2019			
REVISED:			

SECTION
LETTER
A

PAGE
NUMBER
1

ELECTRICAL NOTES
INSTALLATION SHAL BE PER 2011 NATL ELECTRIC CODE
SMOKE & CARBON MONOXIDE ALARMS SHALL BE LISTED
IN ACCORDANCE WITH UL 217 & 234
ALL 15 & 20 AMP BRANCH CIRCUITS IN HABITAL ROOMS SHALL
BE AFCI PROTECTED

200 AMP
METER CAN
CLAY ELECTRIC POWER
UNDER GROUND SERVICE

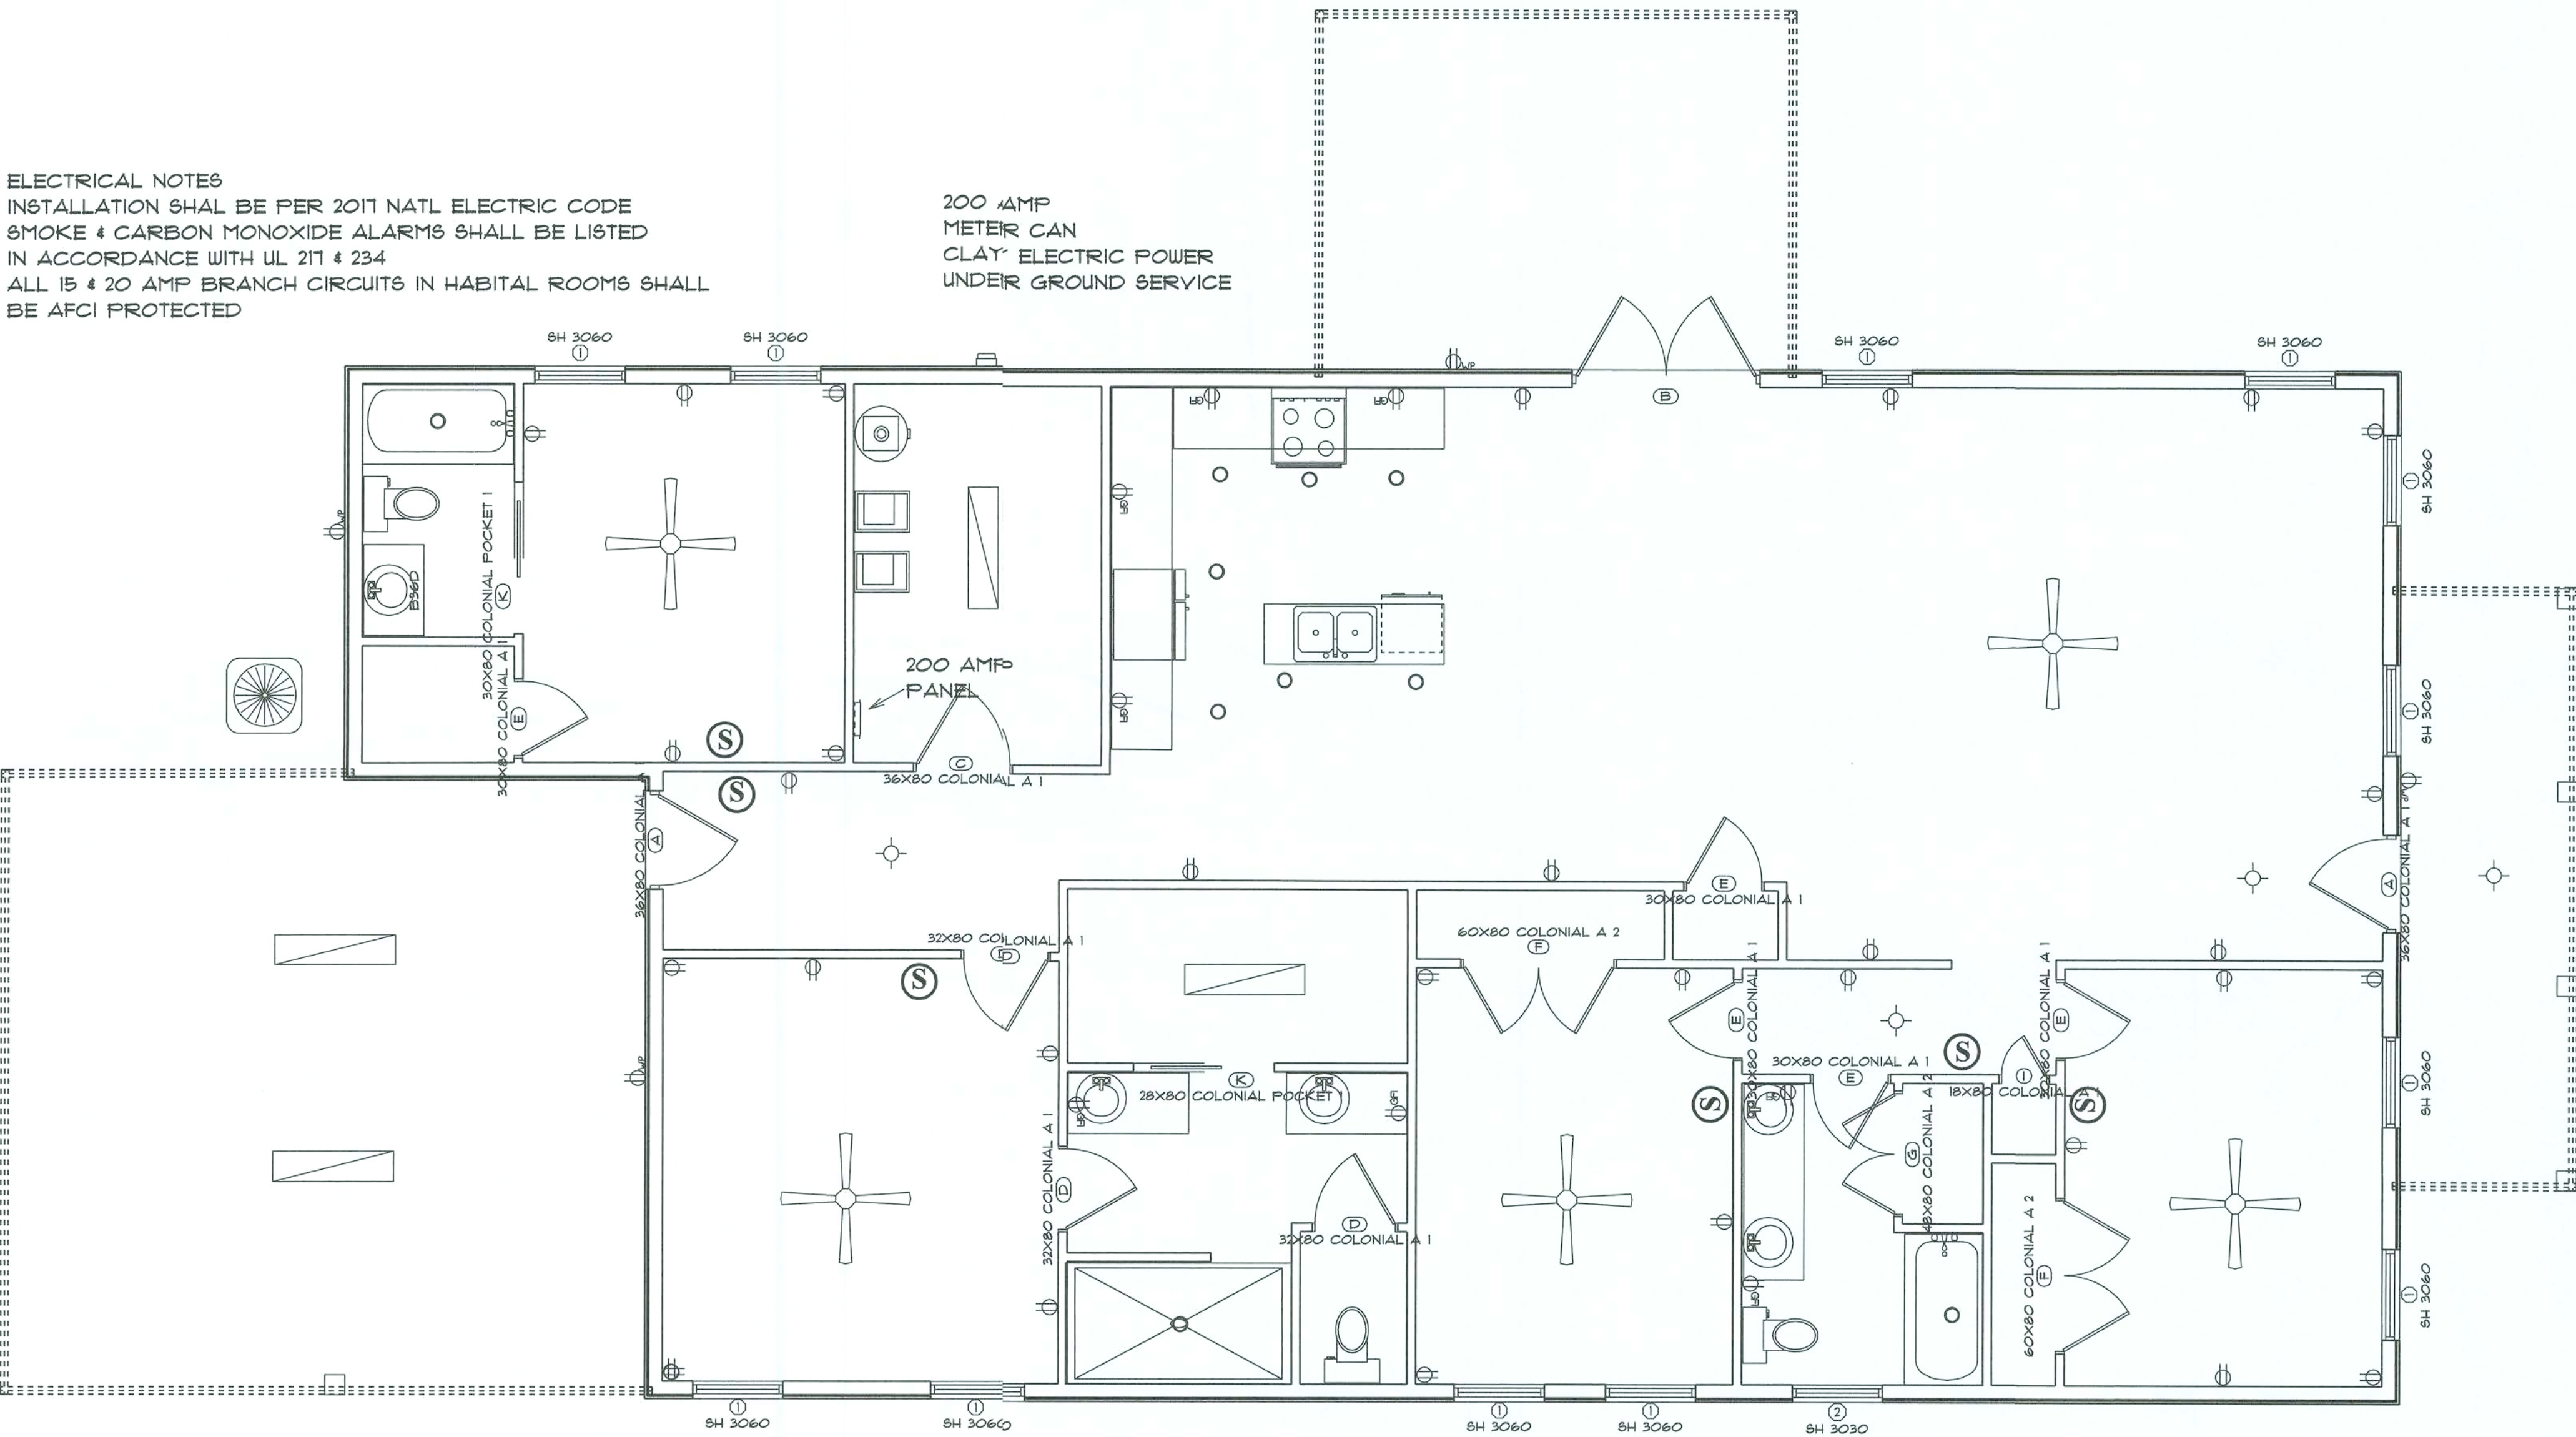

SOFTPLAN ARCHITECTURAL DESIGN SOFTWARE	R&M CONSTRUCTION & DEVELOPMENT LLC		
	PHONE: 352-538-9691		
	randmconstruction@yahoo.com		
	NOAH & TIFFANY YOST		
DRAWN BY: ROBERT CLARK		NOTES: COLUMBIA COUNTY	SECTION LETTER A PAGE NUMBER 1
SCALE: 1/4"=1'			
DATE: 04/18/2013			
REVISED:			