


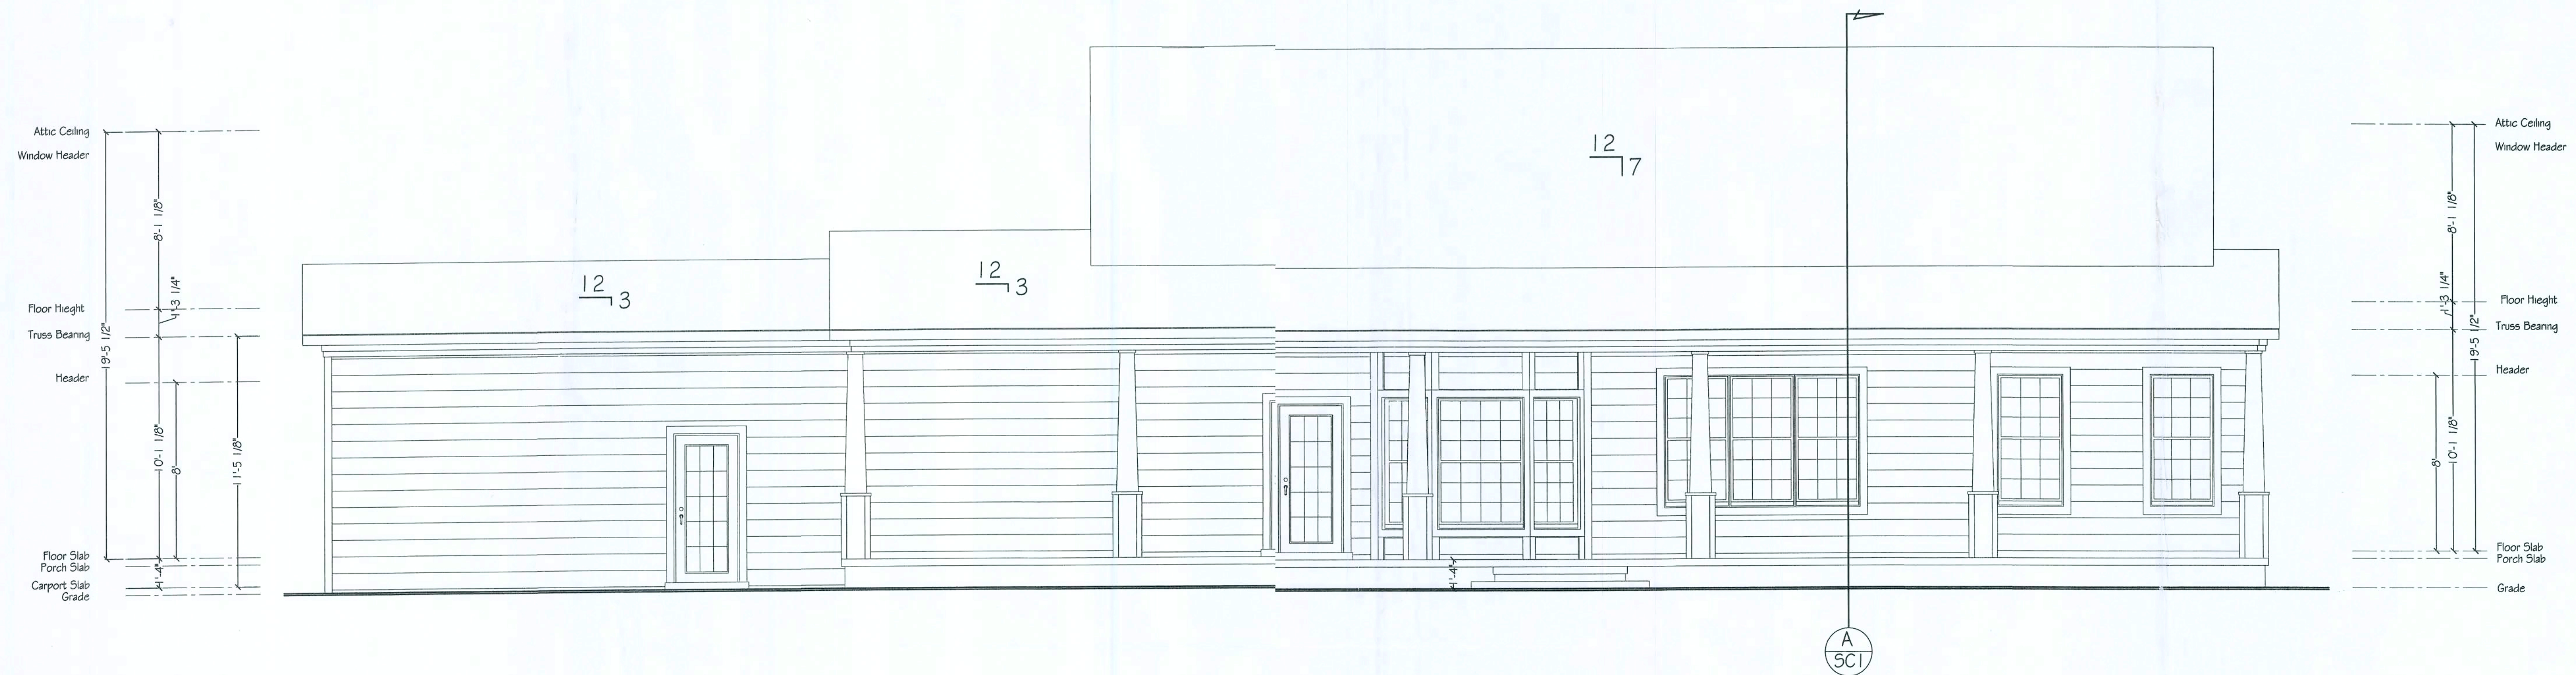
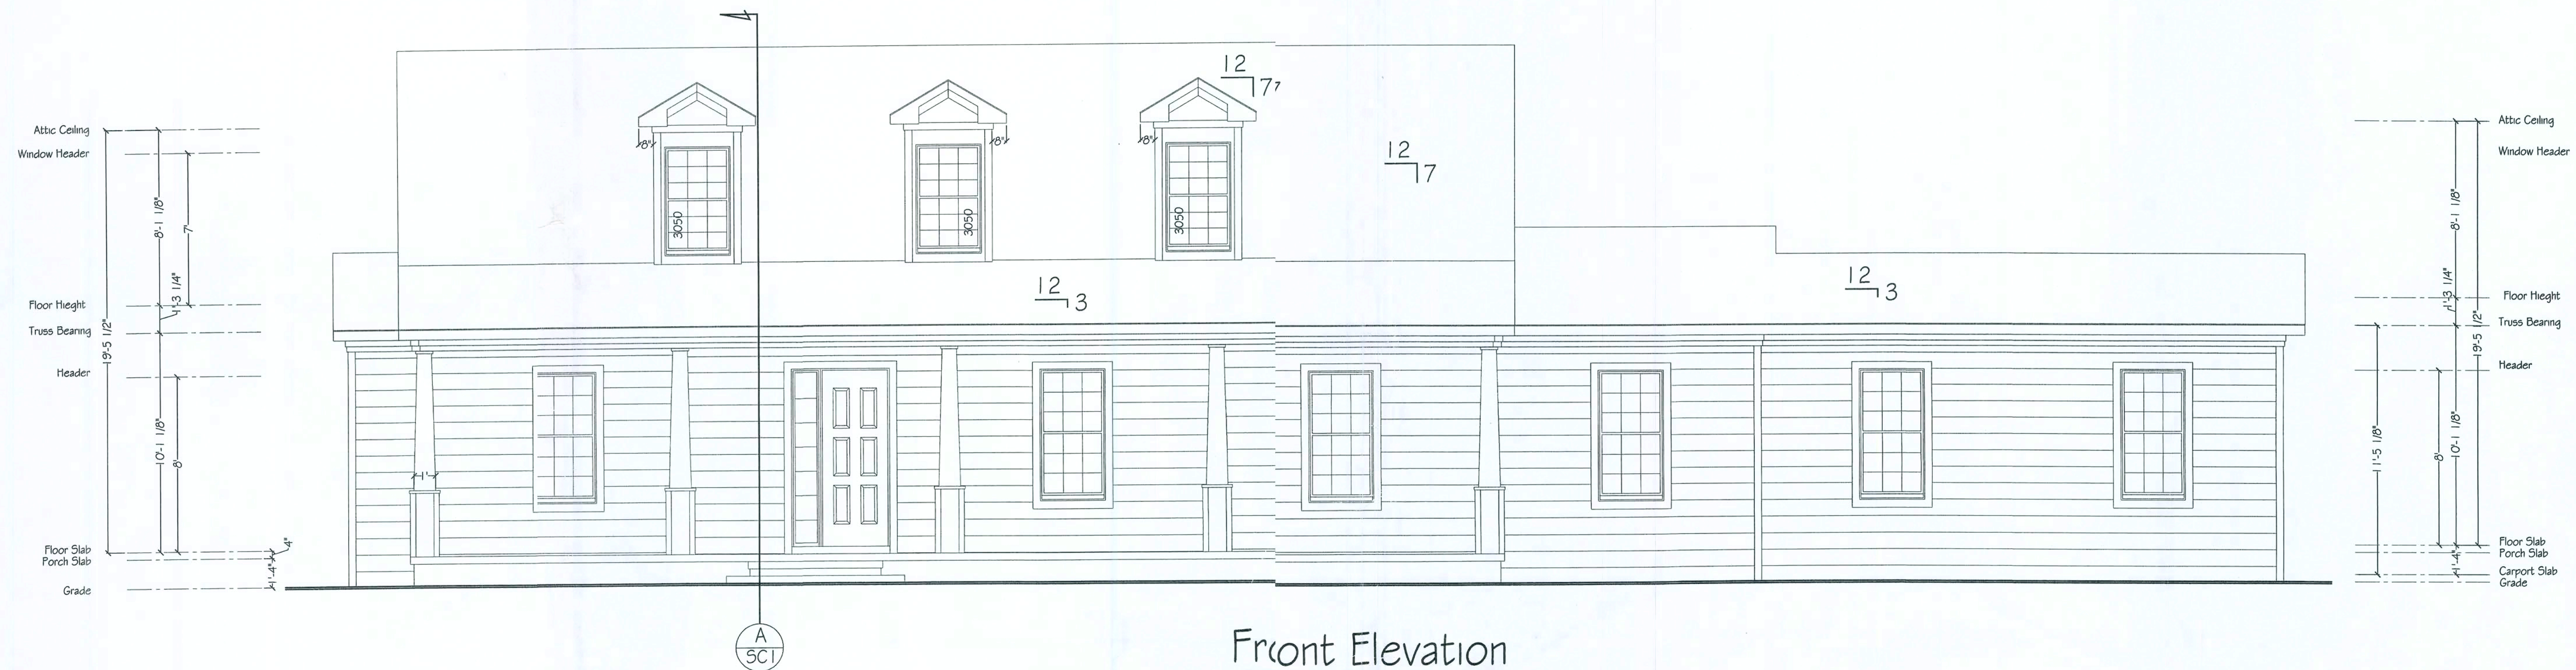
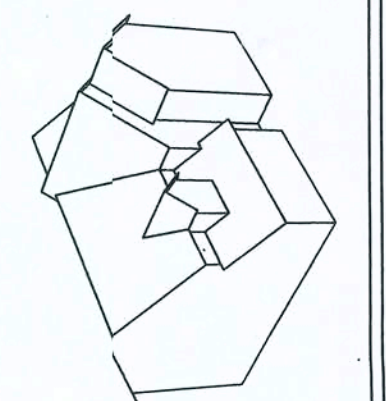
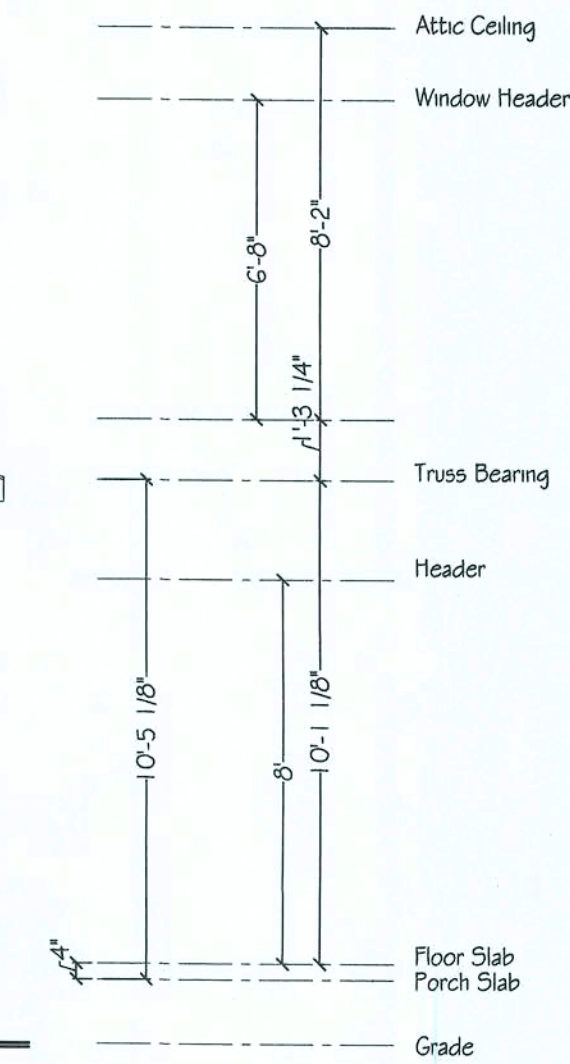


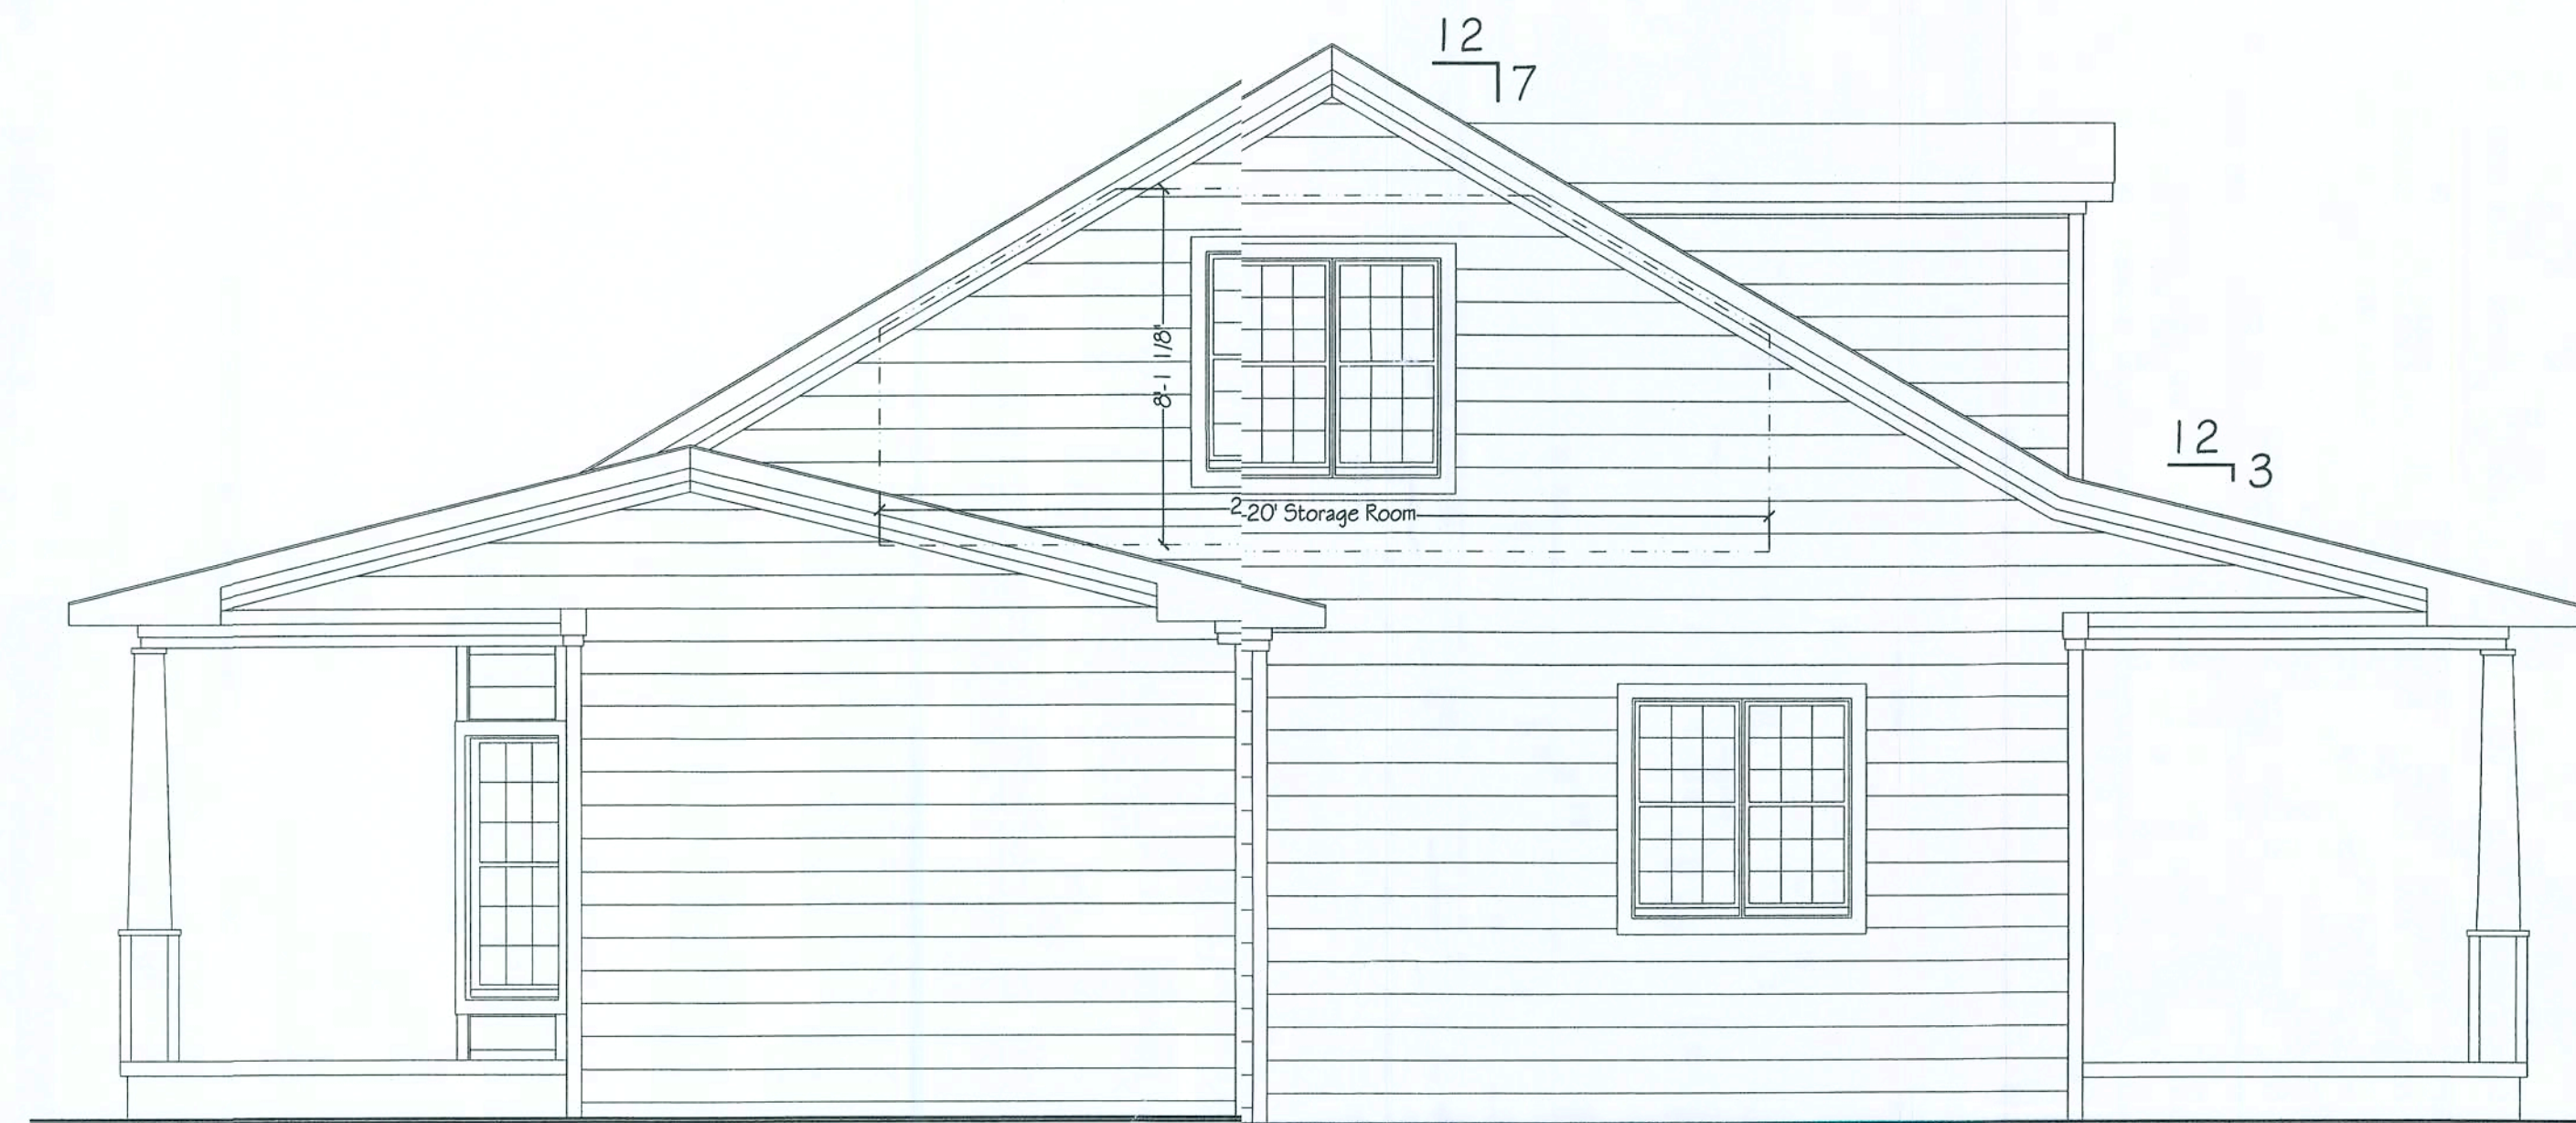

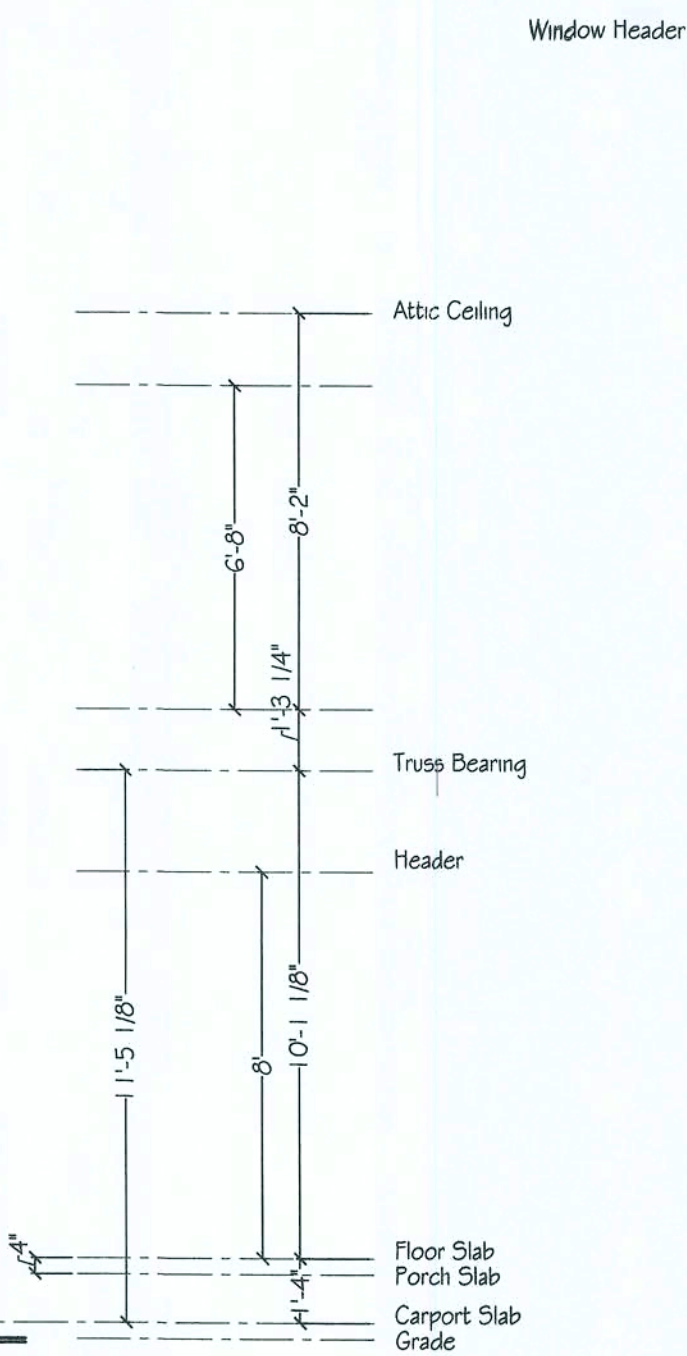

Left Elevation

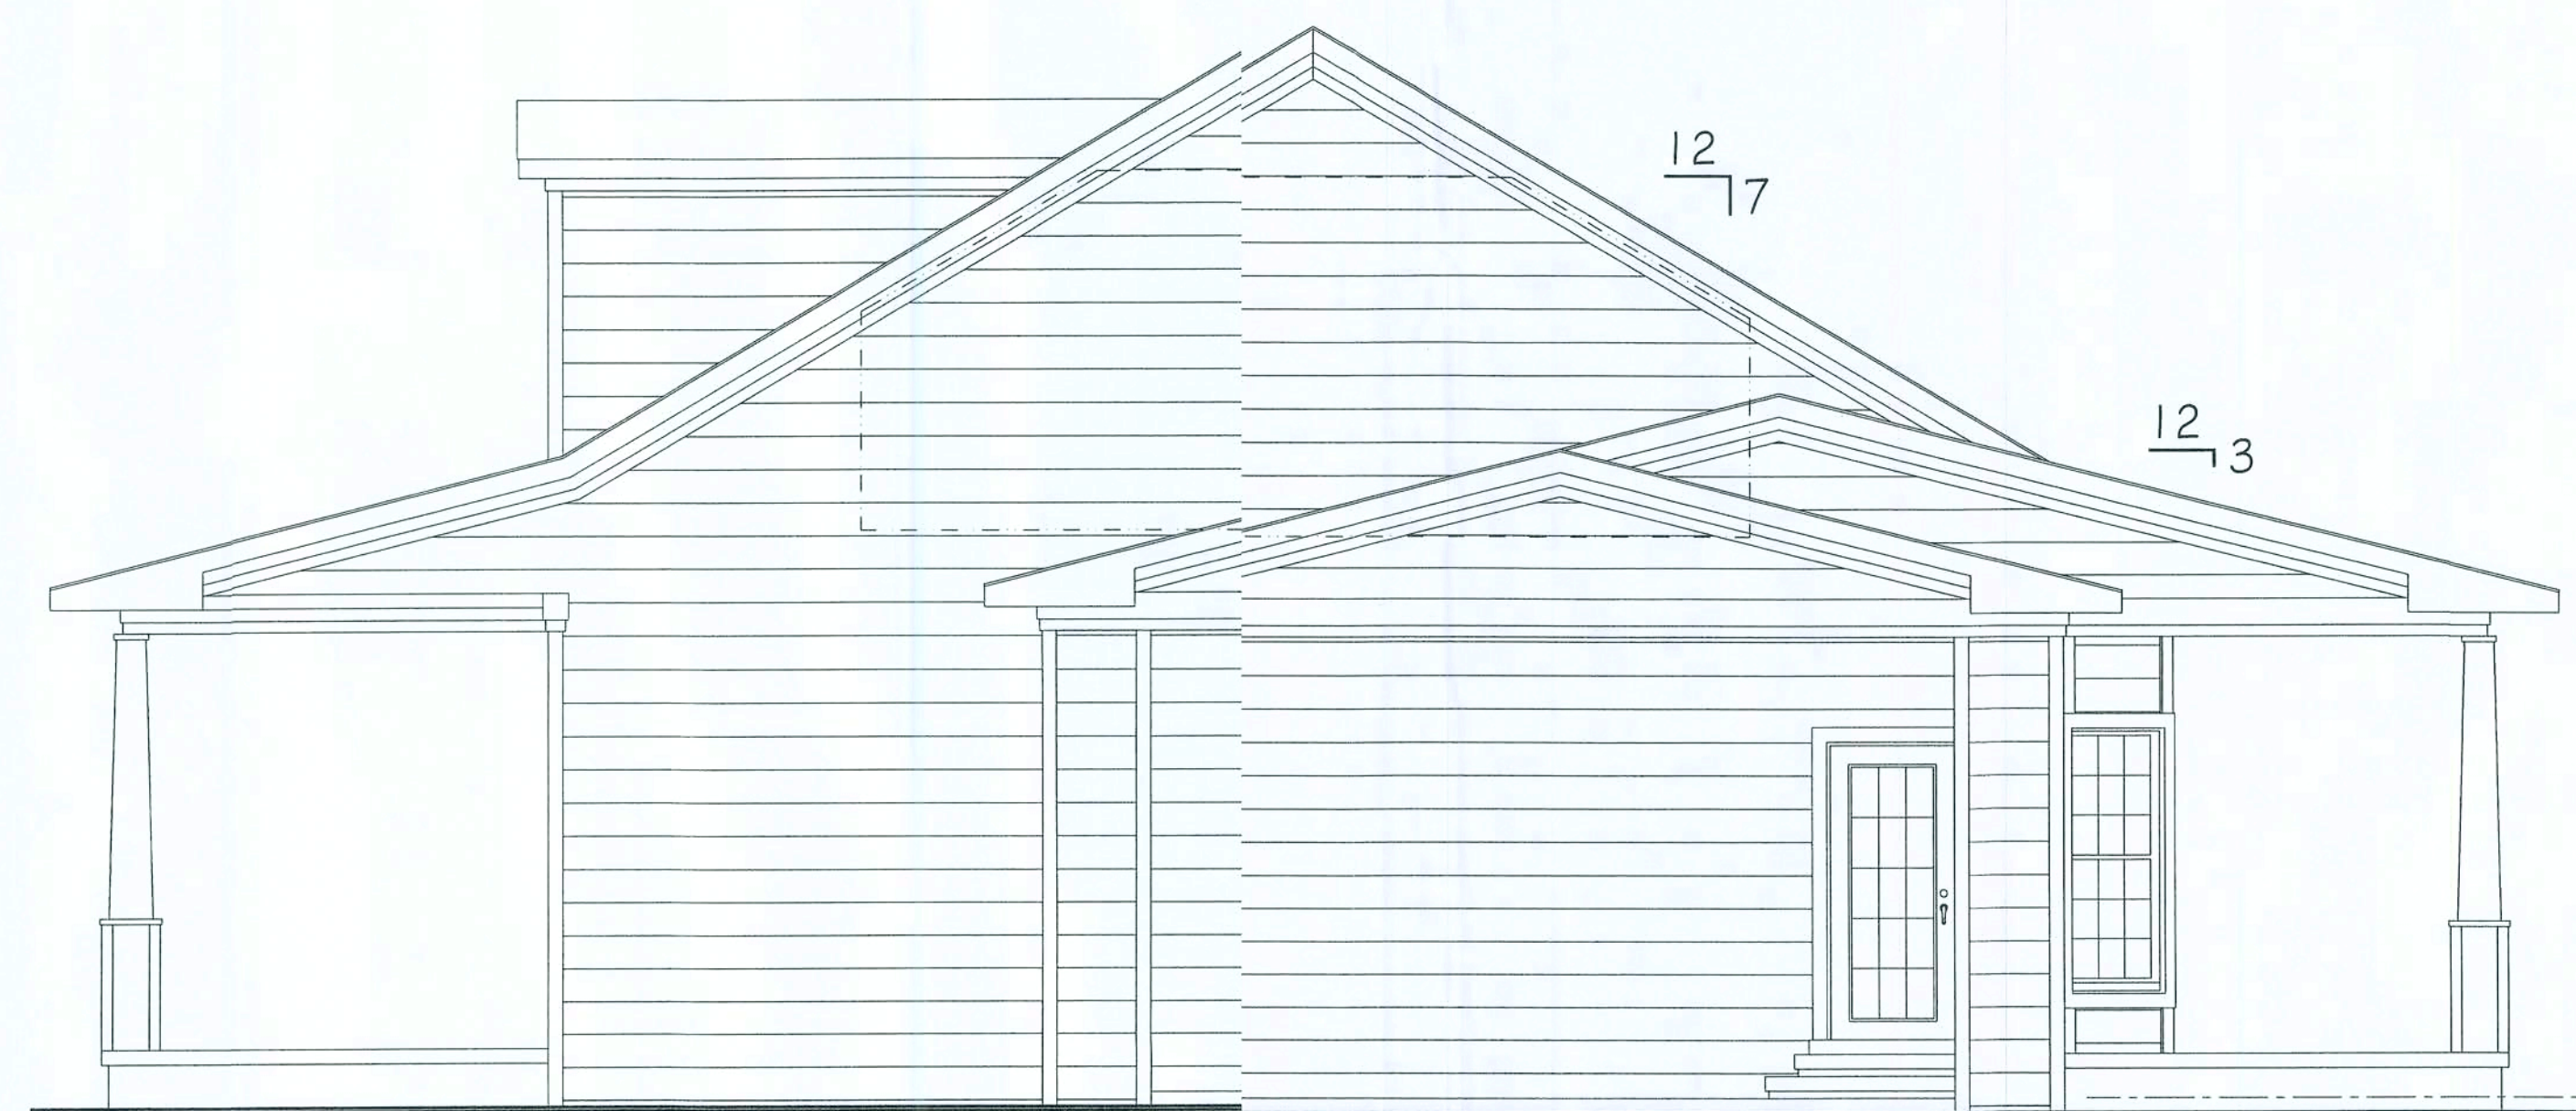

Right Elevation



Rye Construction Company, Inc.
State Certified Custom Home Builder
CCC #151121
Gainesville, Florida
KLUJ001@cox.net
PH: (352) 378-3006
Fax: (352) 378-3003

Custom Home Design for:
Walt & Krissy Smith
Lake City, Florida

PROJ.#
Plan # WSmith
SCALE: 1/4" = 1'-0"
DATE: 2-27-2007
DRAWN BY: BRAD A. MUNN



Wall Legend	
	10'-1 1/8" Bearing
	Non-Bearing





Rye Construction Company, Inc.
 State Certified Custom Home Builder
 CCC #1511121
 Gainesville, Florida
 RCCCI@Com.net
 PH: (352) 378-3006
 Fax: (352) 578-9005

Custom Home Design for:
Walt & Krissy Smith
 Lake City, Florida

PROJ.#
 Plan # V5Smith
 SCALE: 1/4" = 1'-0"
 DATE: 2-27-2007
 DRAWN BY: BRAD A. MUNN

MUNN DESIGN
 RESIDENTIAL DRAFTING & DESIGN
 P.O. Box 773063
 OCALA, FL 34477-3063
 PH: (352) 875-5575
 Fax: (352) 861-1463
 Brad@MunnDesign.com
 www.MunnDesign.com

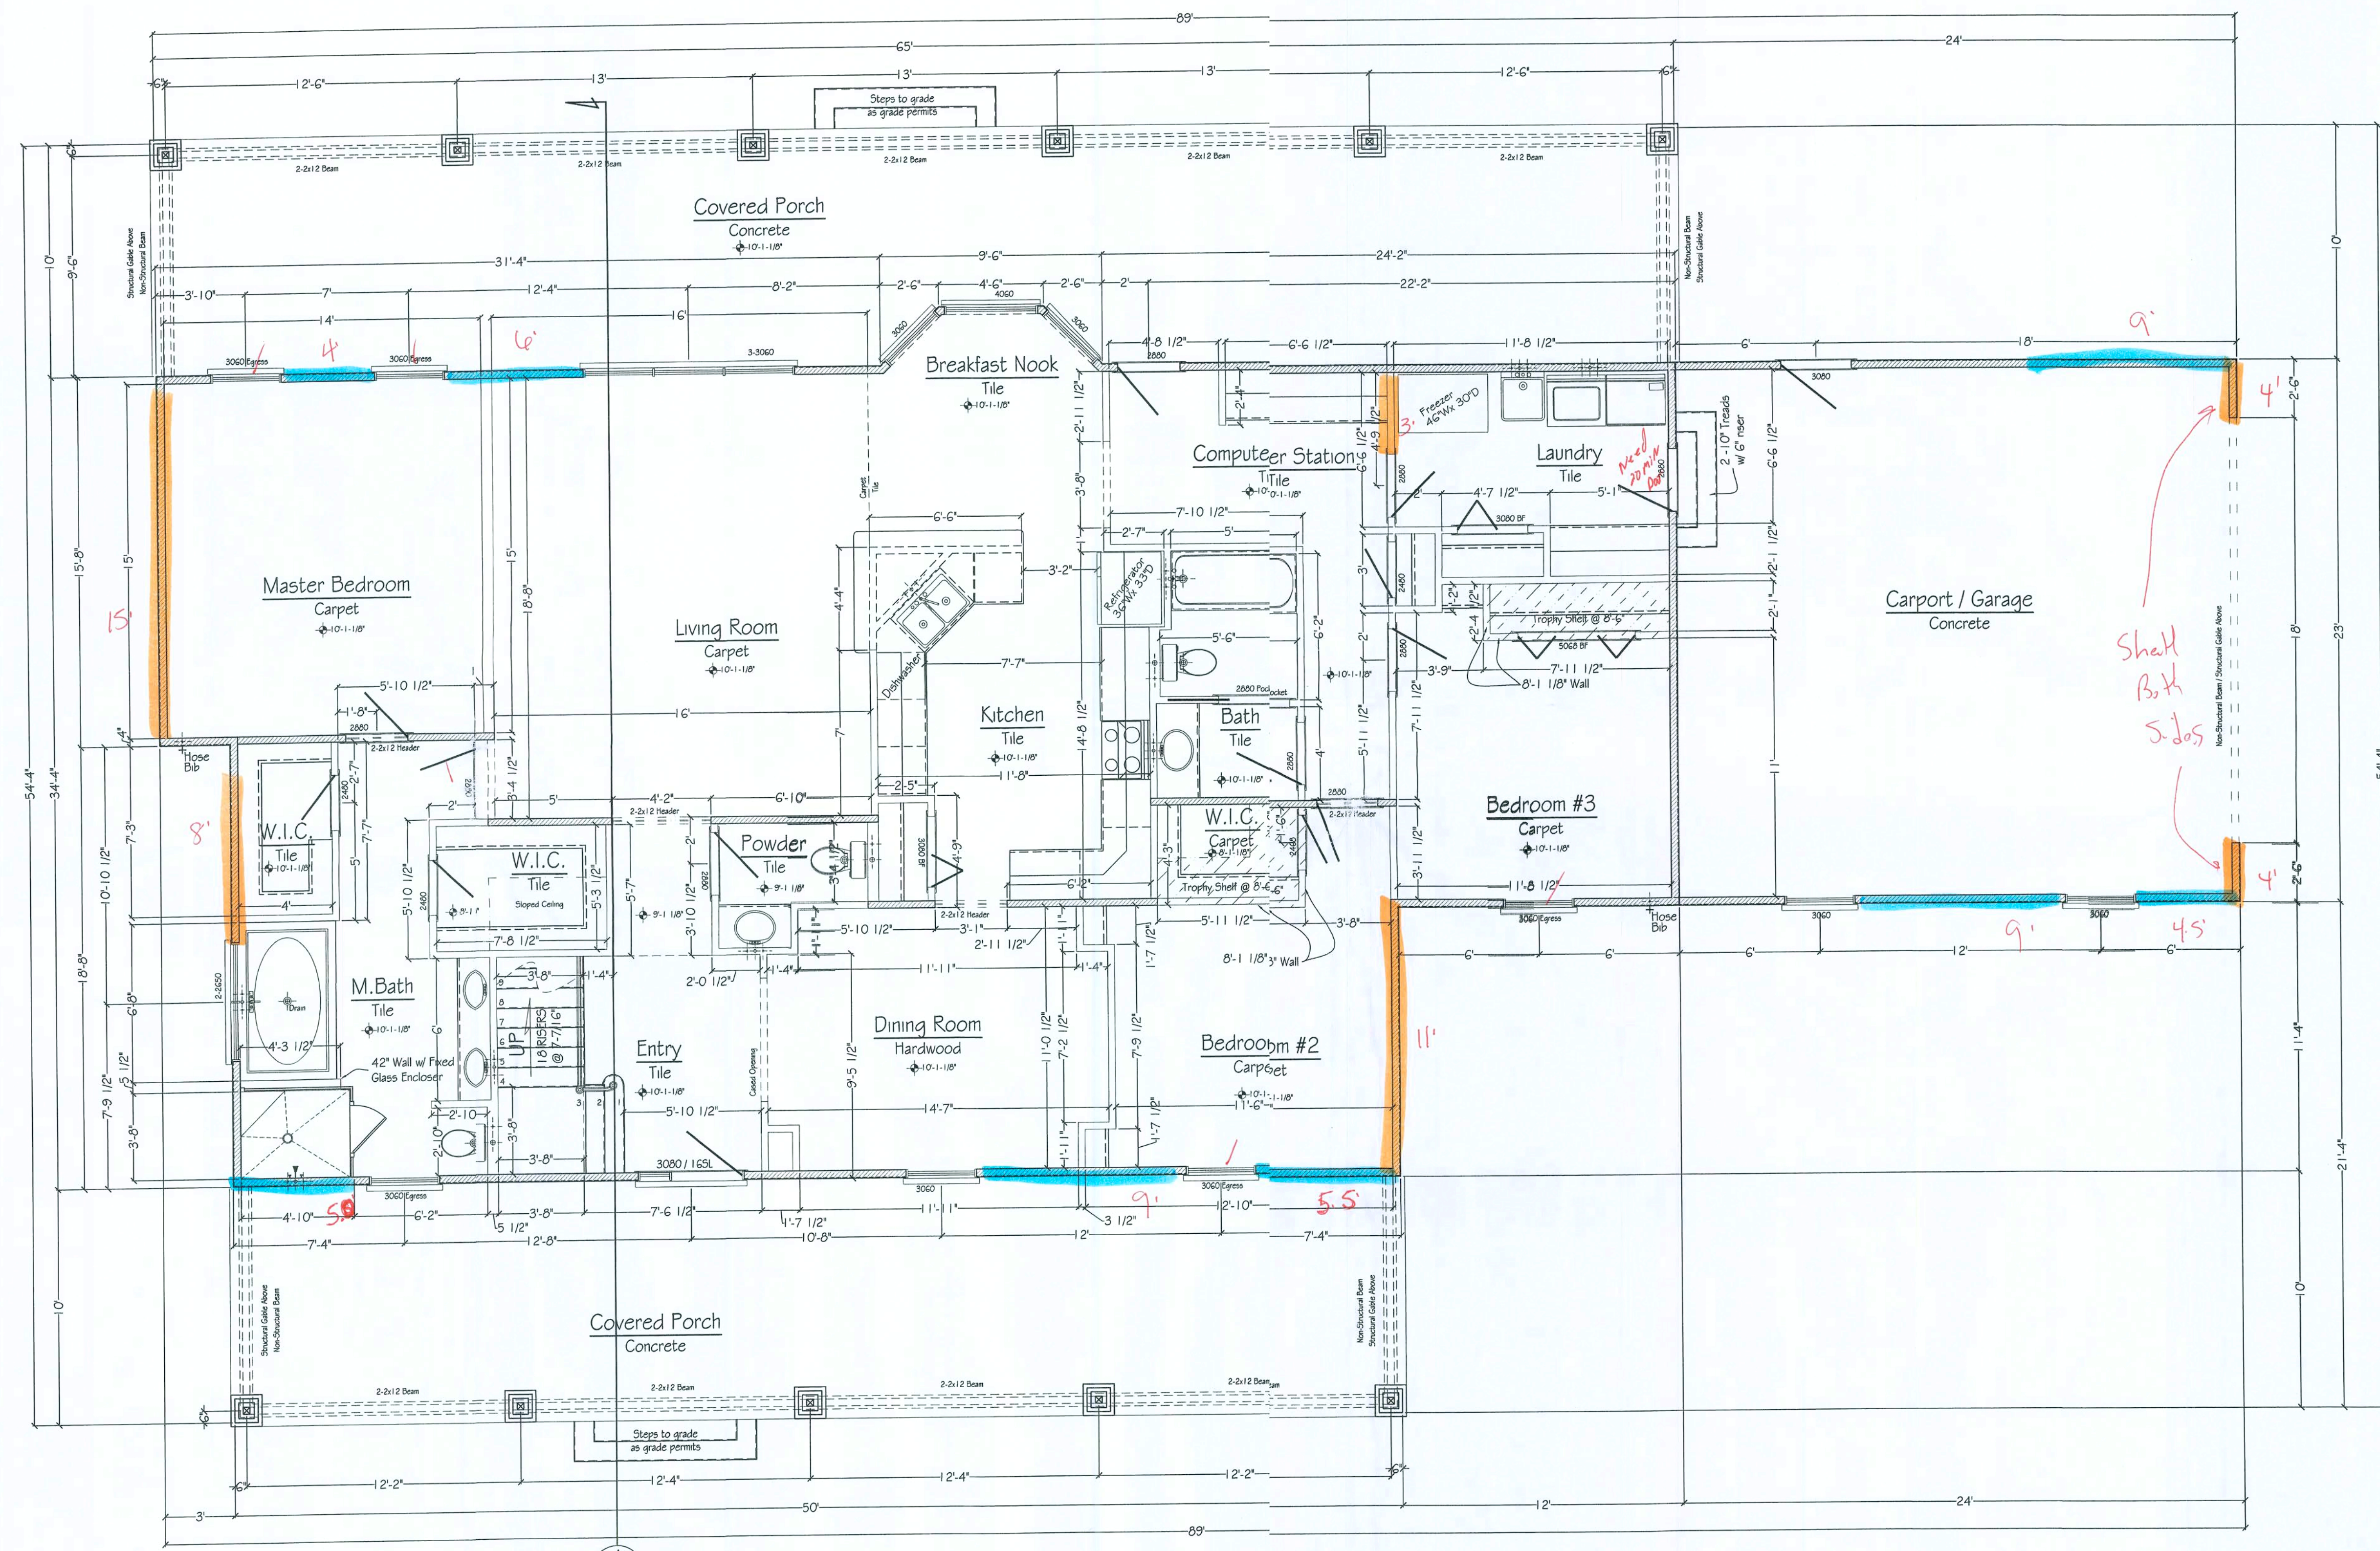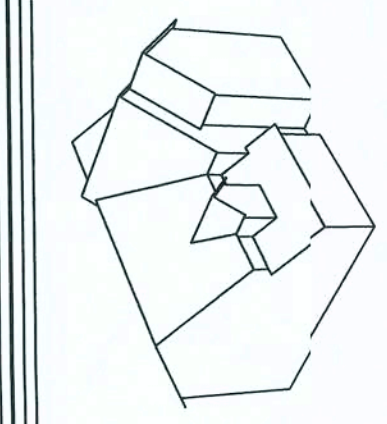


1st FLOOR PLAN

1/4" = 1'-0"
 Note:
 Typical Exterior Wall:
 3-1/2" Frame Wall w/ 1/2" Sheathing
 - Dimensions to outside of Sheathing
 3-1/2" Interior Frame Wall UNO
 - Dimensions Frame to Frame

2,057 SQ.FT. Living Area
 1,006 SQ.FT. Unfinished
 1,133 SQ.FT. Porches
 506 SQ.FT. Carport
 900 SQ.FT. Garage
 5,602 Total

E Long S.W. = 552'
 E Trans. S.W. = 45'

Property of MunnDesign / Rye Construction Co., Inc. - Duplication is in violation of Copyright Laws

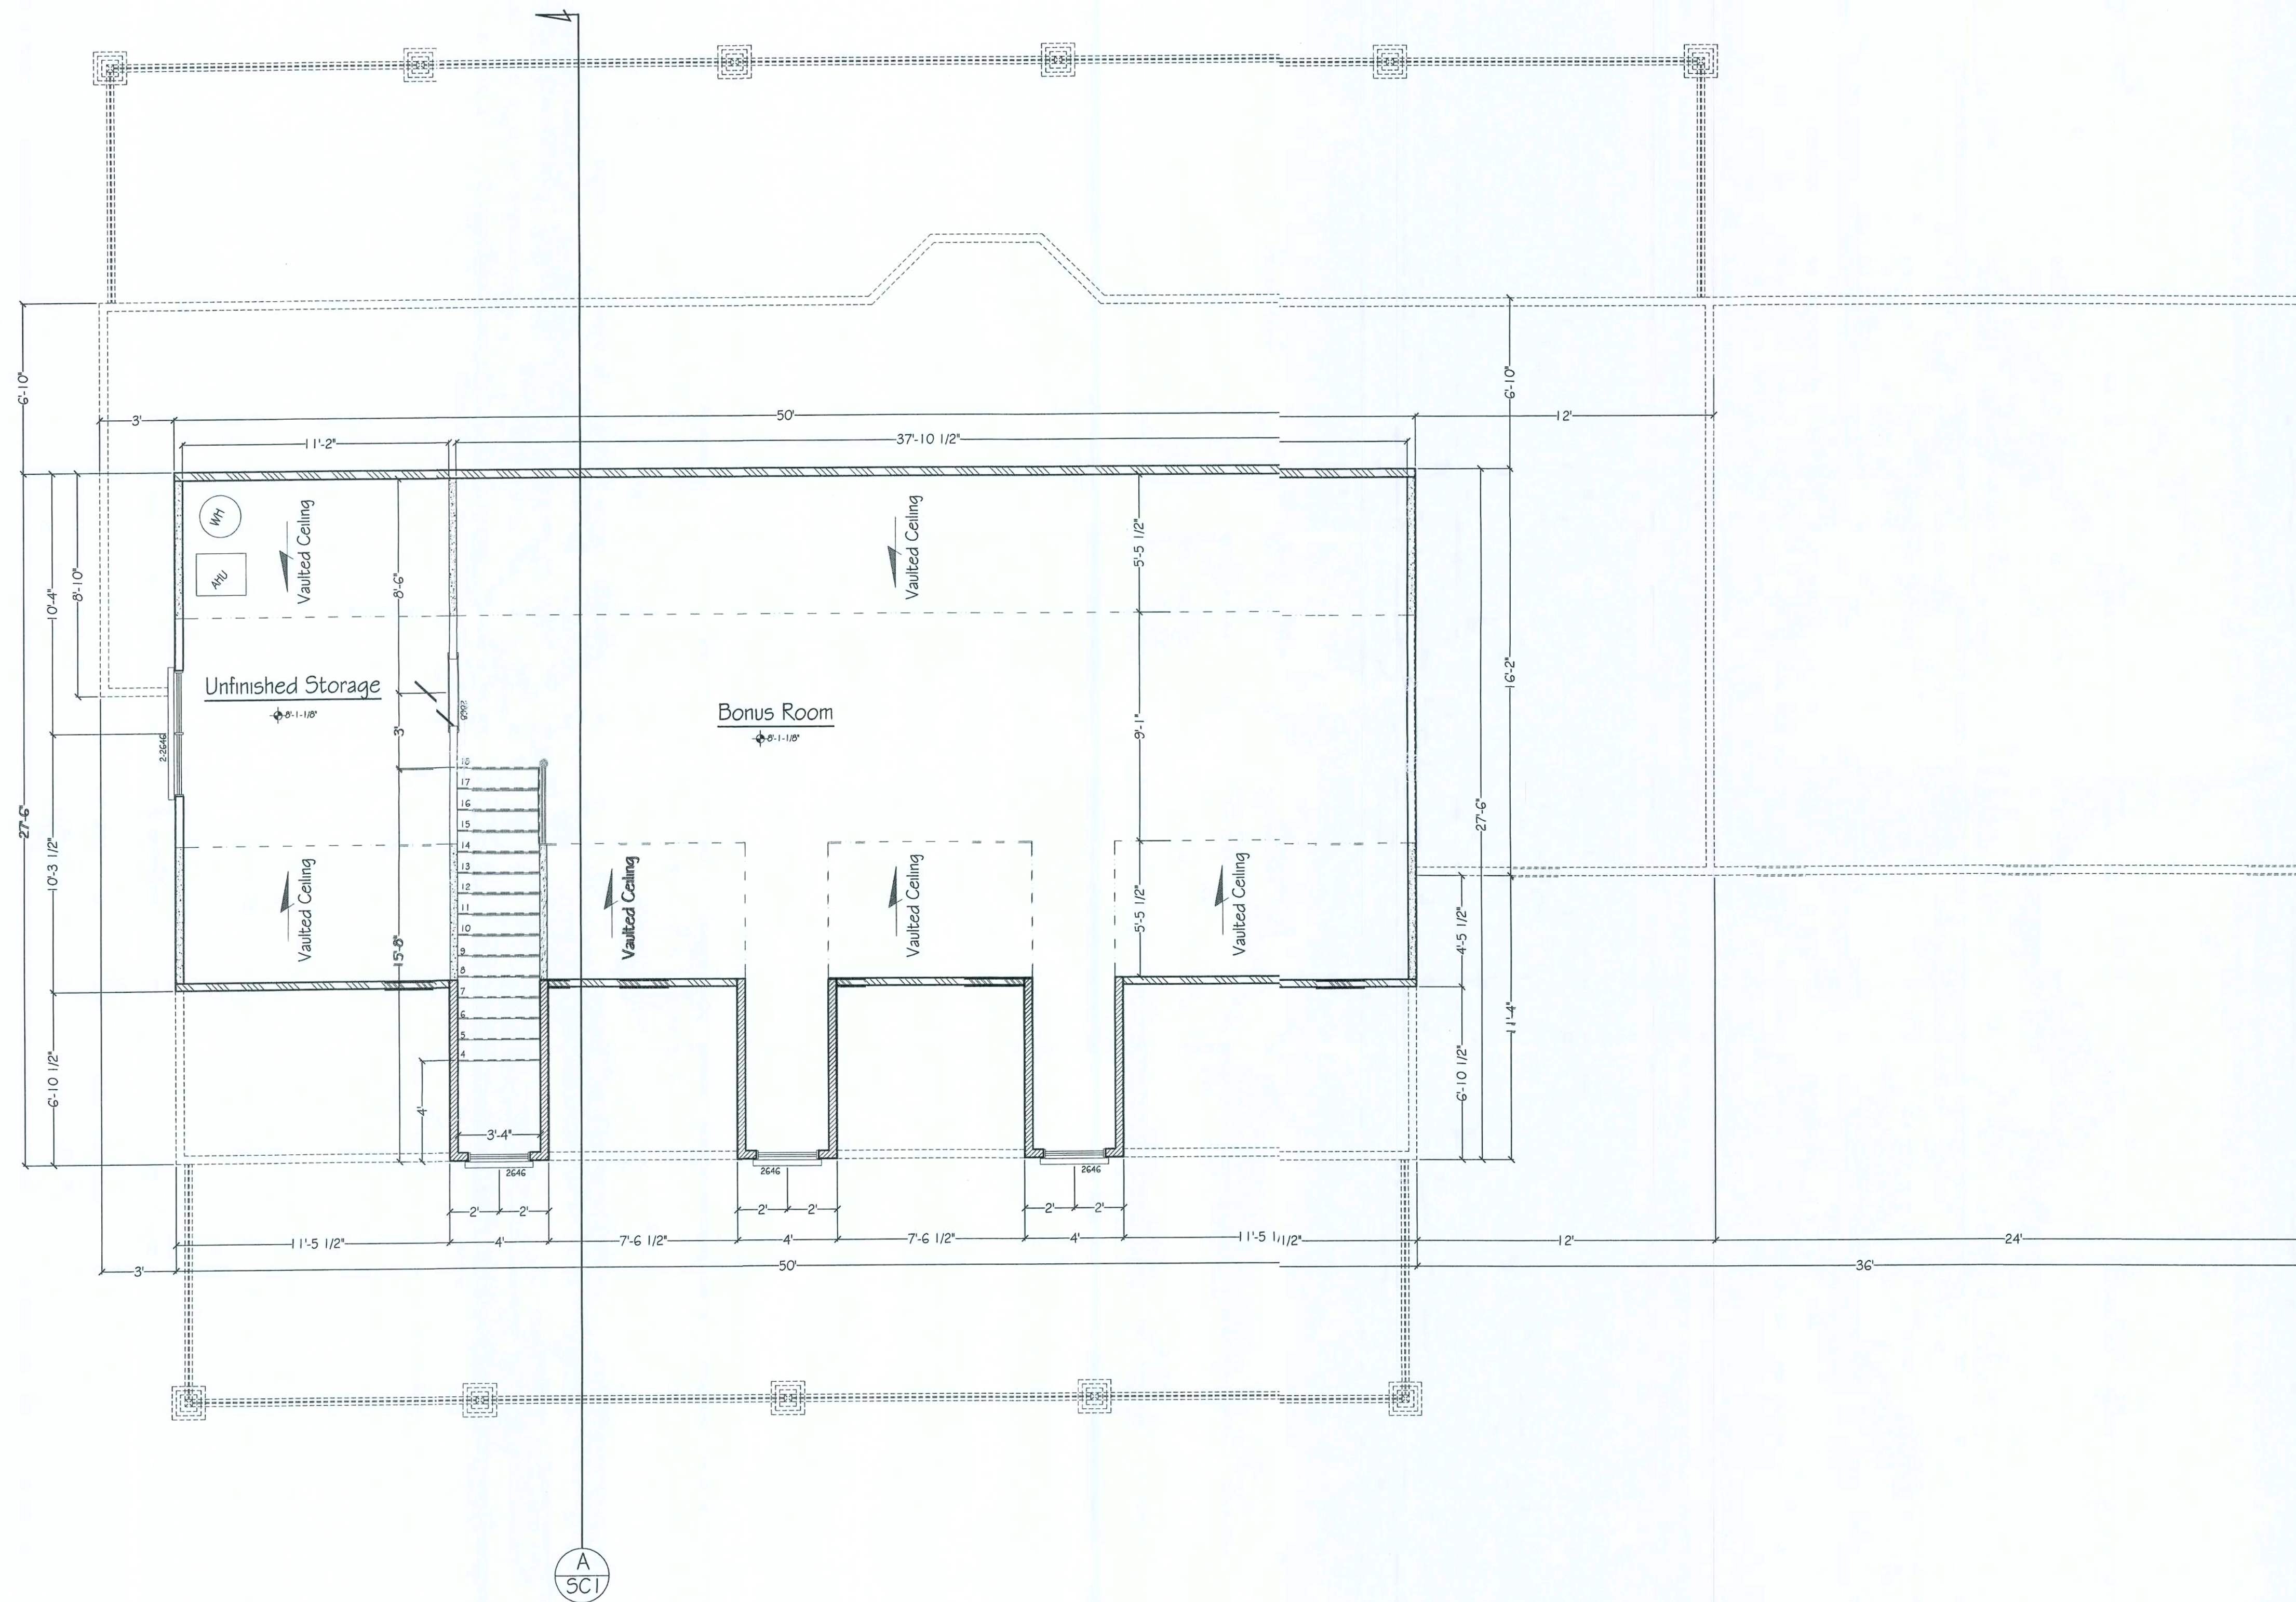

2nd FLOOR PLAN

1/4" = 1'-0"
 Note:
 4" exterior walls - Dimensions to
 exterior of sheathing
 3-1/2" interior walls - Dimensions
 to frame

Wall Legend	
	8'-1 1/8" Bearing
	First Floor Wall
	Non-Bearing
	Sloped Wall
	Low Walls (part of trusses)
	20'-5 7/8" Bearing




Rye Construction Company, Inc.
 State Certified Custom Home Builder
 CCC #1511121
 Gainesville, Florida
 RCCIB@Cor.net
 PH:352.378-3006
 Fax:352.378-9003

Custom Home Design for:
Walt & Krissy Smith
 Lake City, Florida


PROJ.#
 Plan # VSmith
 SCALE: 1/4" = 1'-0"
 DATE: 2-27-2007
 DRAWN BY:
 BRAD A. MUNN

MUNN DESIGN
 RESIDENTIAL DRAFTING & DESIGN
 P.O. Box 773023
 Ocala, FL 34477-3023
 PH:352.2067-4831
 Fax:352.2067-4831
 Brad@MunnDesign.com
 www.MunnDesign.com

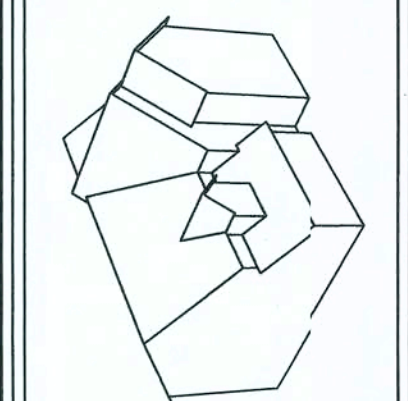

PAGE 1
 © Munn Design / Rye Cons. 2007

Property of MunnDesign / Rye Construction Co., Inc. - Duplication is in violation of Copyright laws

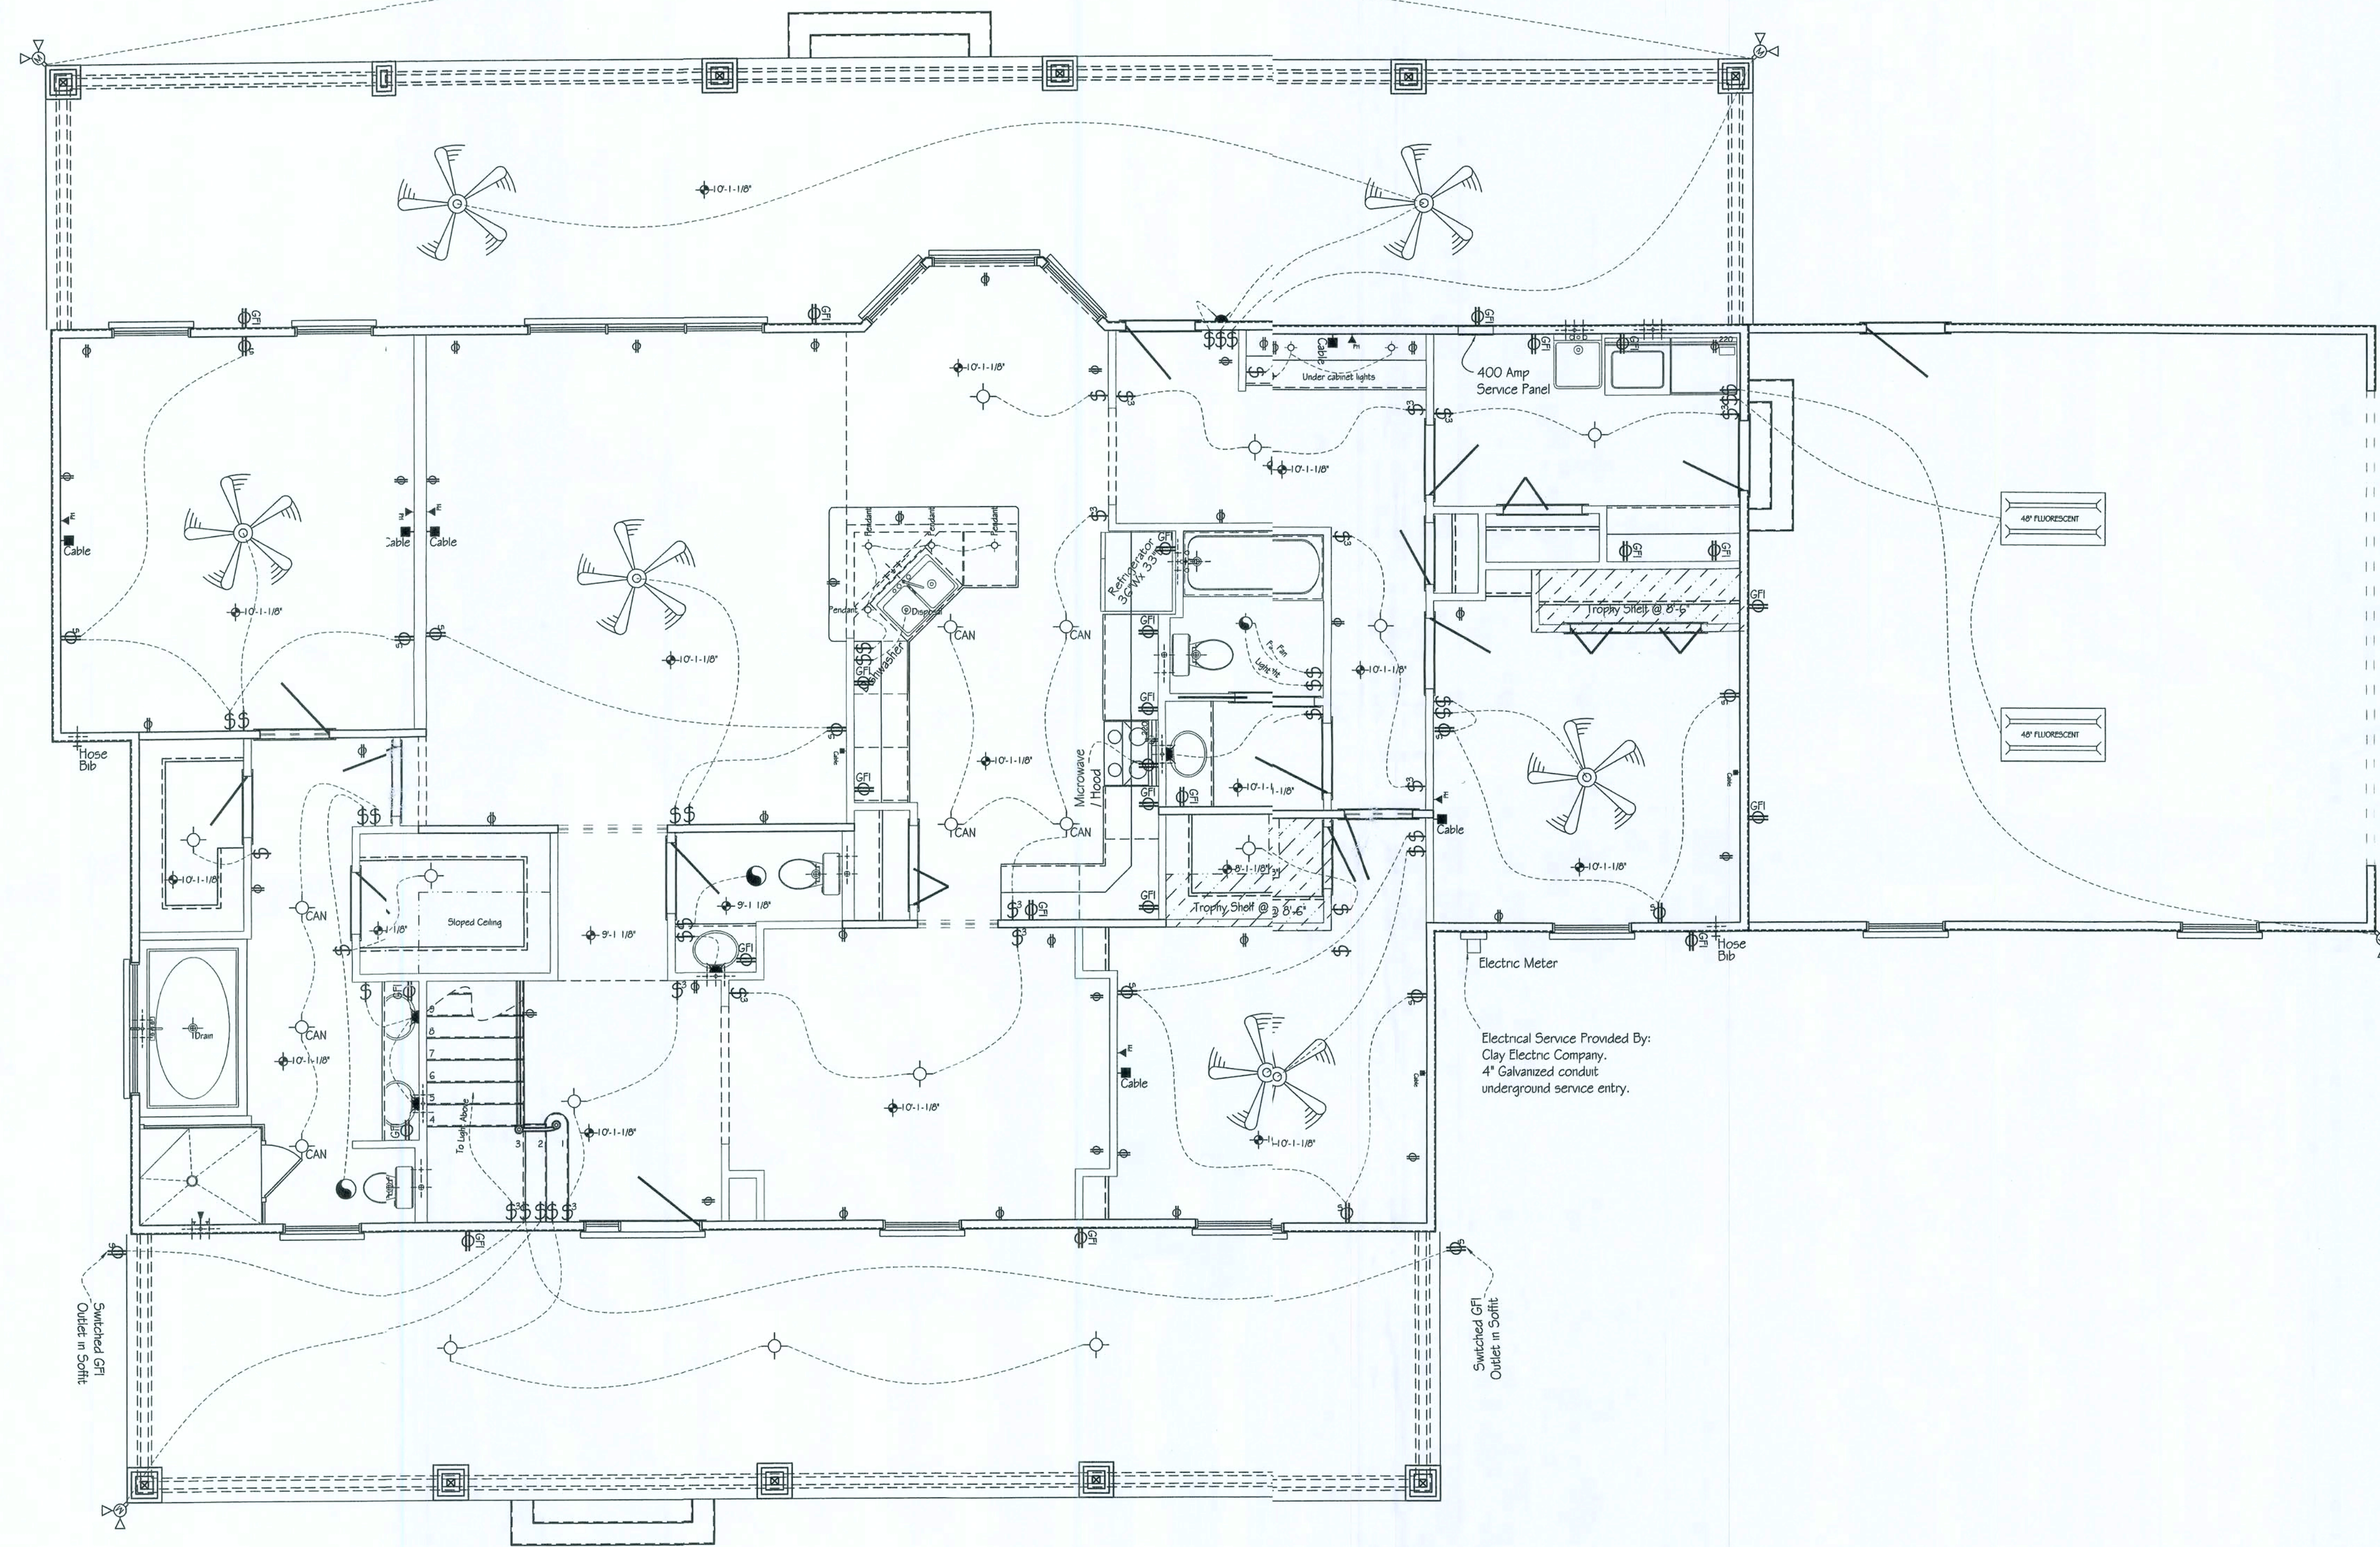

Electrical Legend	
⌚	Switch
⌚⌚	3-way Switch
⌚⌚⌚	4-way Switch
⌚	Outlet
⌚⌚	Outlet - Switched
⌚⌚⌚	Ground Fault Outlet
⌚⌚⌚⌚	220 Volt Outlet
⌚⌚⌚⌚⌚	Smoke Detector
⌚⌚⌚⌚⌚⌚	Cable / TV Outlet
⌚⌚⌚⌚⌚⌚⌚	Phone
⌚⌚⌚⌚⌚⌚⌚⌚	Wall Light
⌚⌚⌚⌚⌚⌚⌚⌚⌚	Ceiling Light
⌚⌚⌚⌚⌚⌚⌚⌚⌚⌚	Can Light
⌚⌚⌚⌚⌚⌚⌚⌚⌚⌚⌚	Can Light - Moisture Proof
⌚⌚⌚⌚⌚⌚⌚⌚⌚⌚⌚⌚	Bath Fan / Light
⌚⌚⌚⌚⌚⌚⌚⌚⌚⌚⌚⌚⌚	Bath Fan
⌚⌚⌚⌚⌚⌚⌚⌚⌚⌚⌚⌚⌚⌚	Flood Light
⌚⌚⌚⌚⌚⌚⌚⌚⌚⌚⌚⌚⌚⌚⌚	Flood Light w/ Motion Sensor




Rye Construction Company, Inc.
 State Certified Custom Home Builder
 CCC # 1511121
 Gainesville, Florida
 RCCB@cox.net

Custom Home Design for:

Walt & Krissy Smith

Lake City, Florida


PROJ.#	
Plan #	W5Smith
SCALE:	1/4" = 1'-0"
DATE:	2-27-2007
DRAWN BY:	BRAD A. MUNN

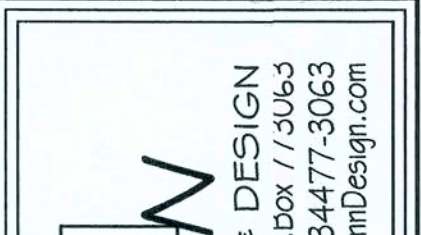

MUNN DESIGN
 RESIDENTIAL DRAFTING & DESIGN
 P.O. Box 773063
 Ocala, FL 34477-3063
 Fax: (352) 861-4831
 Brad@MunnDesign.com

FIRST FLOOR
 ELECTRICAL PLAN
 1/4" = 1'-0"

Property of MunnDesign / Rye Construction Co., Inc. - Duplication is in violation of Copyright laws

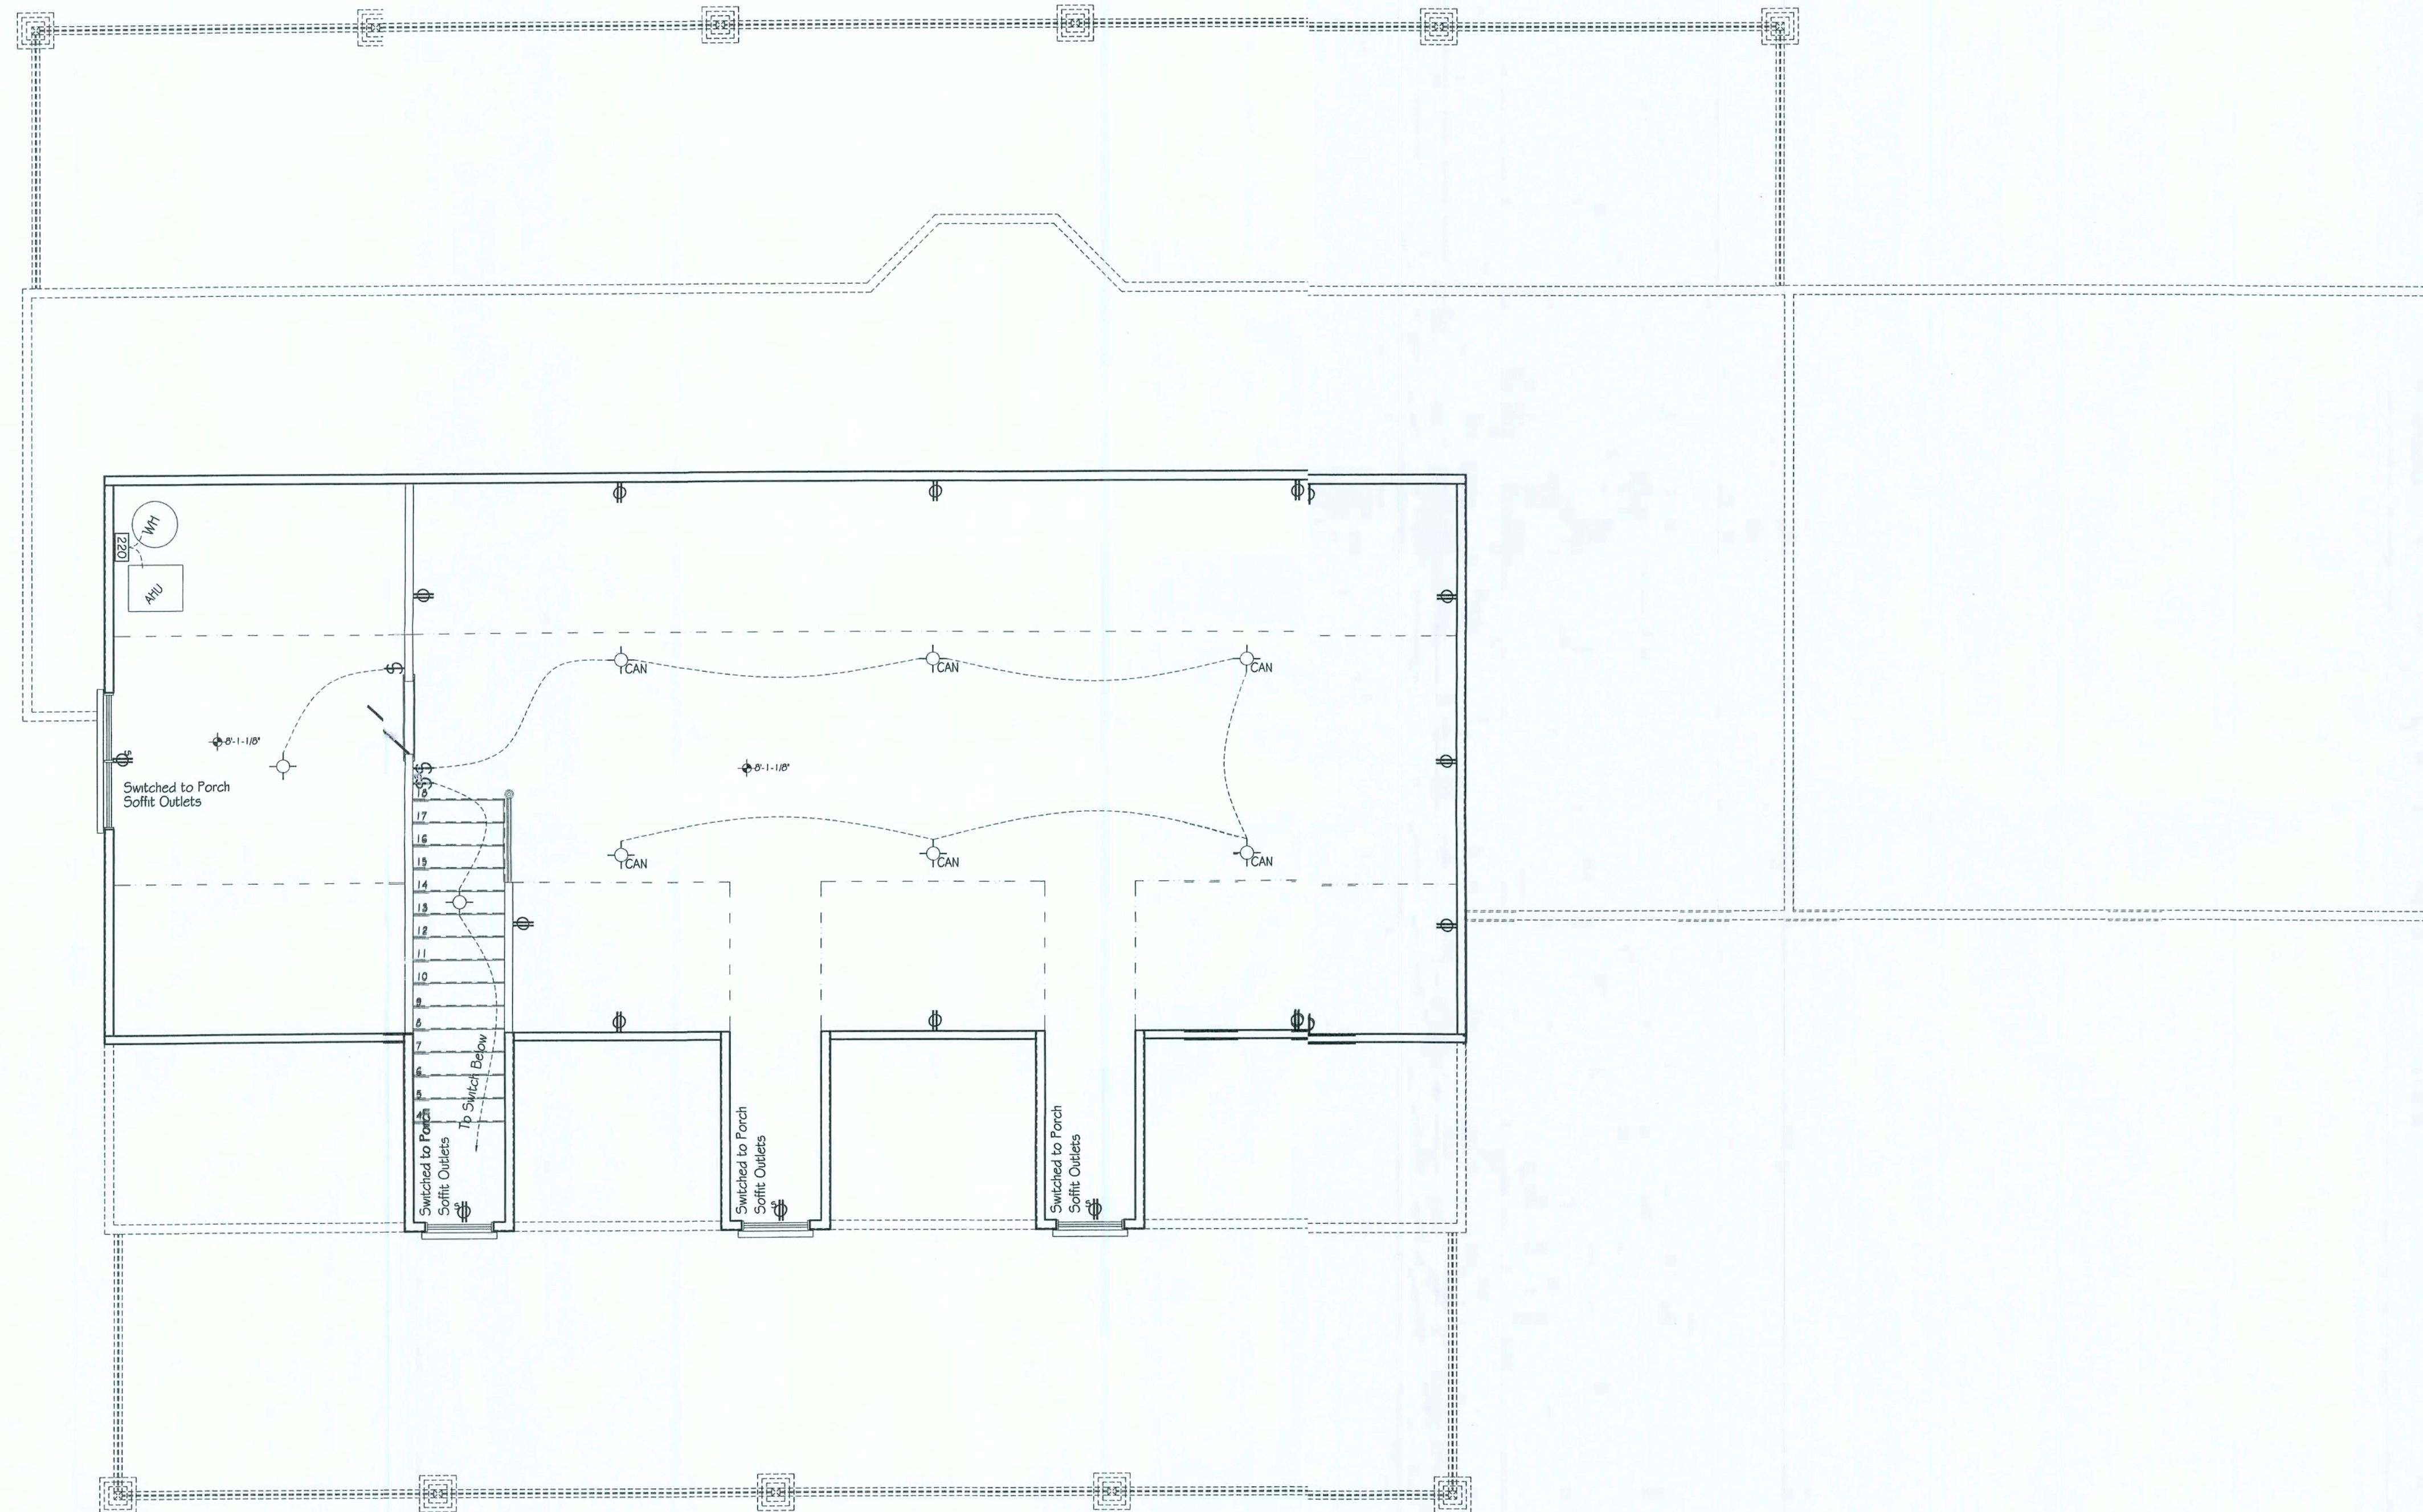

Electrical Legend	
	Switch
	3-way Switch
	4-way Switch
	Outlet
	Outlet - Switched
	Ground Fault Outlet
	220 Volt Outlet
	Smoke Detector
	Cable / TV Outlet
	Phone
	Wall Light
	Ceiling Light
	Can Light
	Can Light - Moisture Proof
	Bath Fan / Light
	Bath Fan
	Flood Light
	Flood Light w/ Motion Sensor



Rye Construction Company, Inc.
 State Certified Custom Home Builder
 CCC #1511121
 Gainesville, Florida
 RCCCI@Cox.net

Custom Home Design for:
Walt & Krissy Smith
 Lake City, Florida

PROJ.#	
Plan #	VSmith
SCALE:	1/4" = 1'-0"
DATE:	2-27-2007
DRAWN BY:	BRAD A MUNN










MUNN DESIGN
 RESIDENTIAL DRAFTING & DESIGN
 P.O. Box 772063
 Ocala, FL 34477-3063
 PH: (352) 675-5575
 Fax: (352) 661-4831
 Brad@MunnDesign.com
 www.MunnDesign.com



PAGE 1
EL 2




SECOND FLOOR
 ELECTRICAL PLAN
 1/4" = 1'-0"

Property of MunnDesign / Rye Construction Co., Inc. - Duplication is in violation of Copyright laws

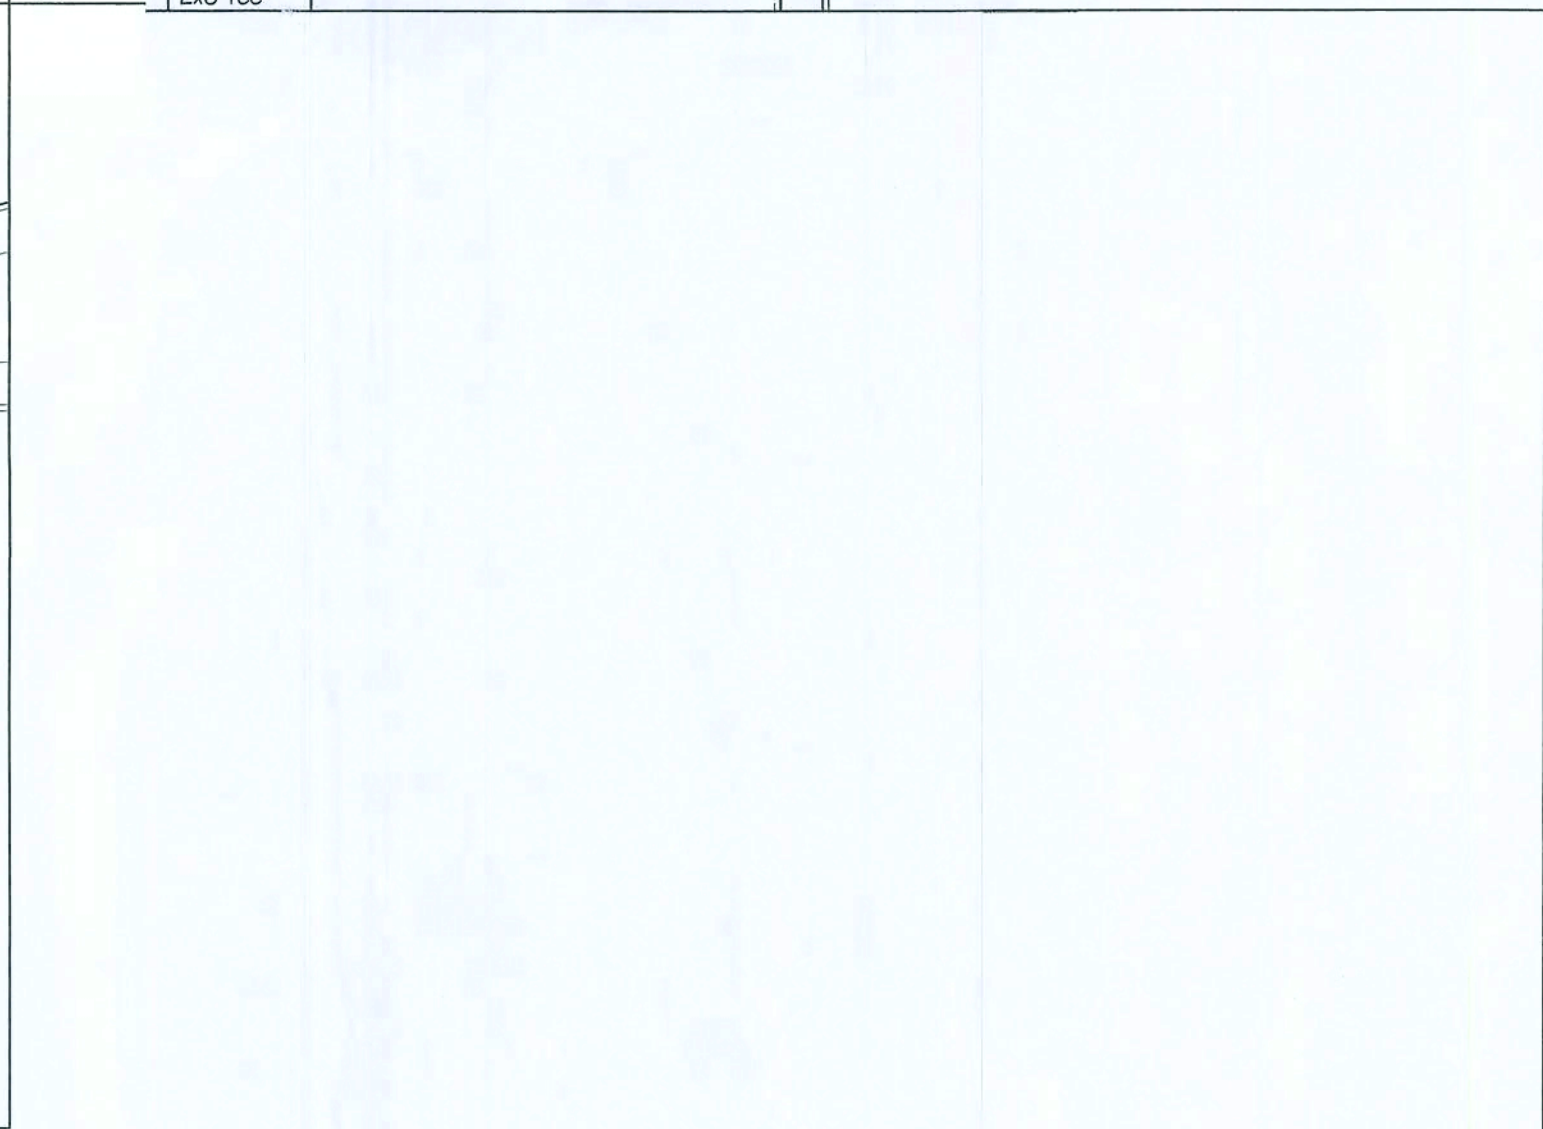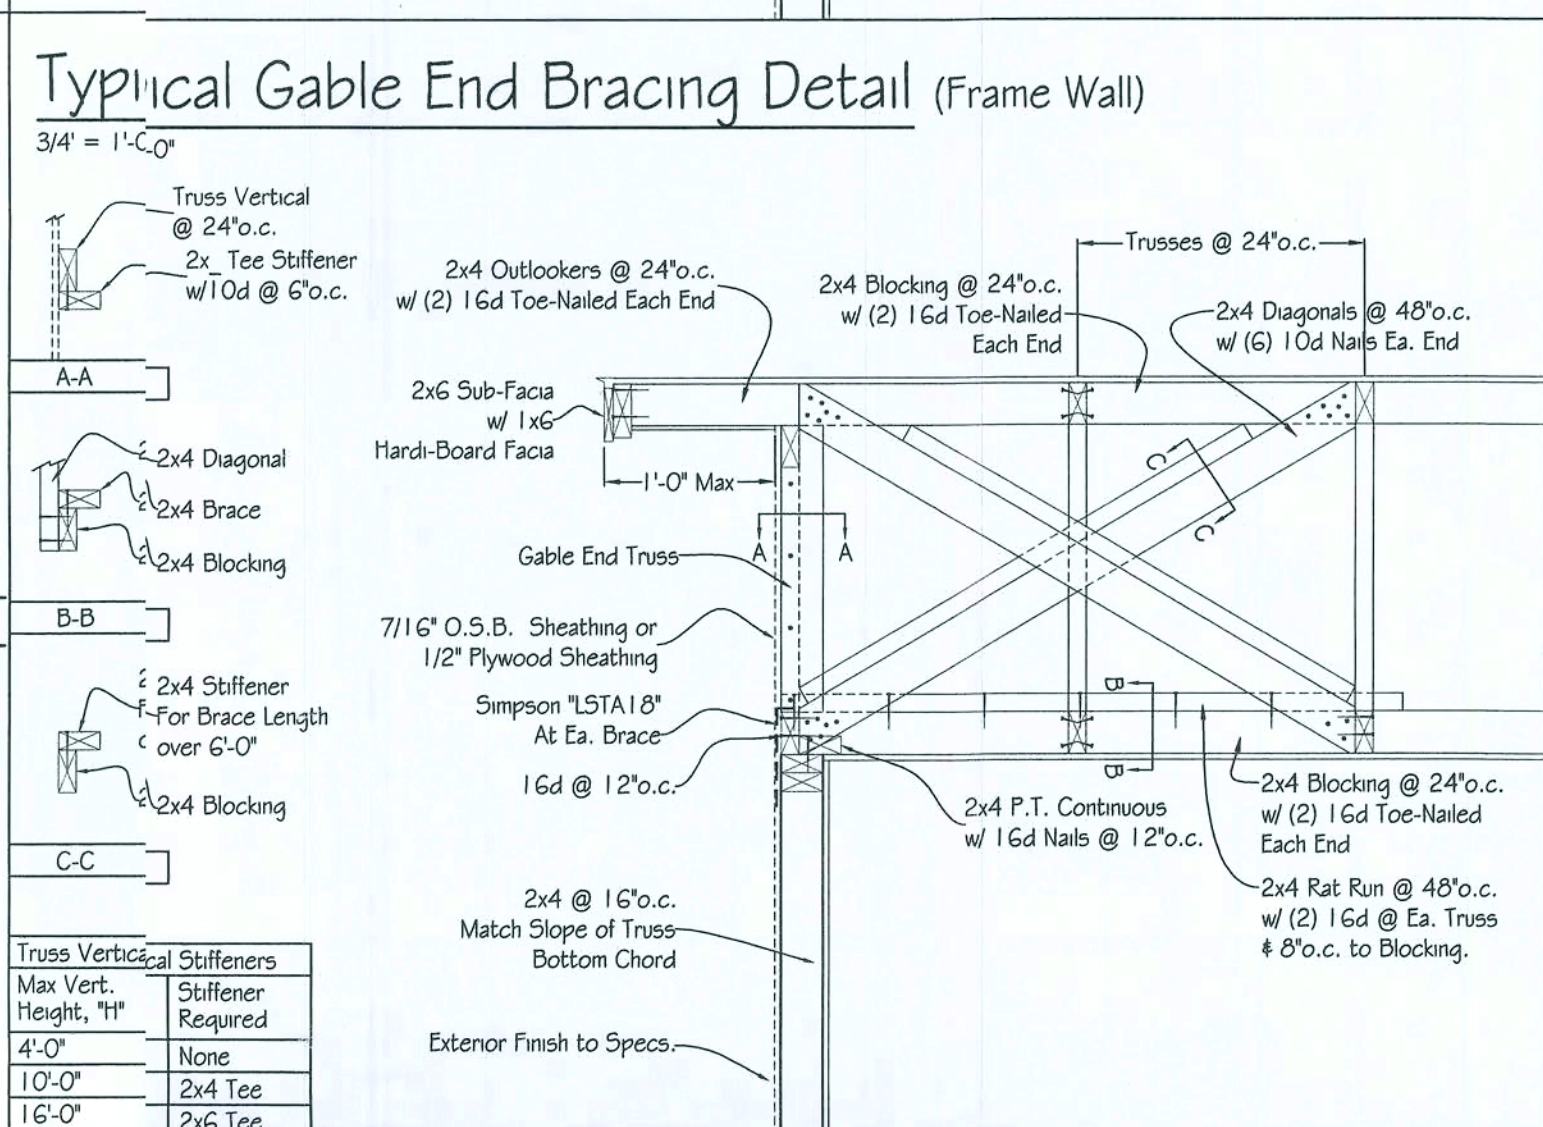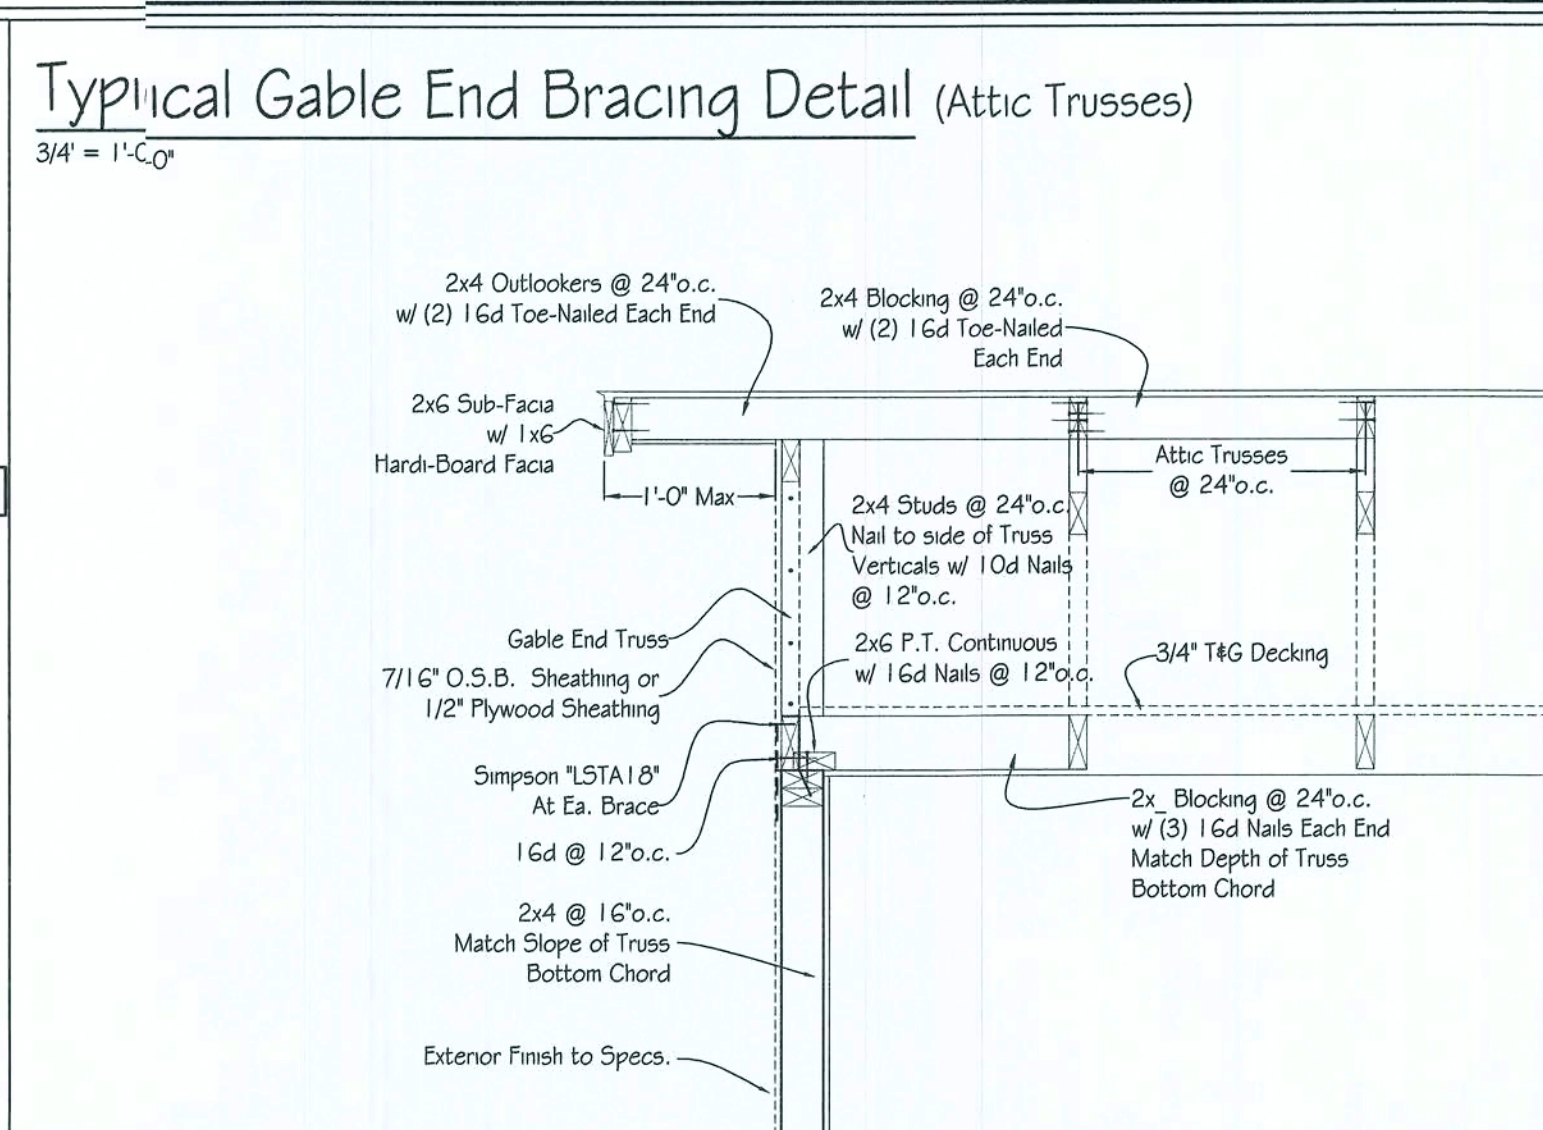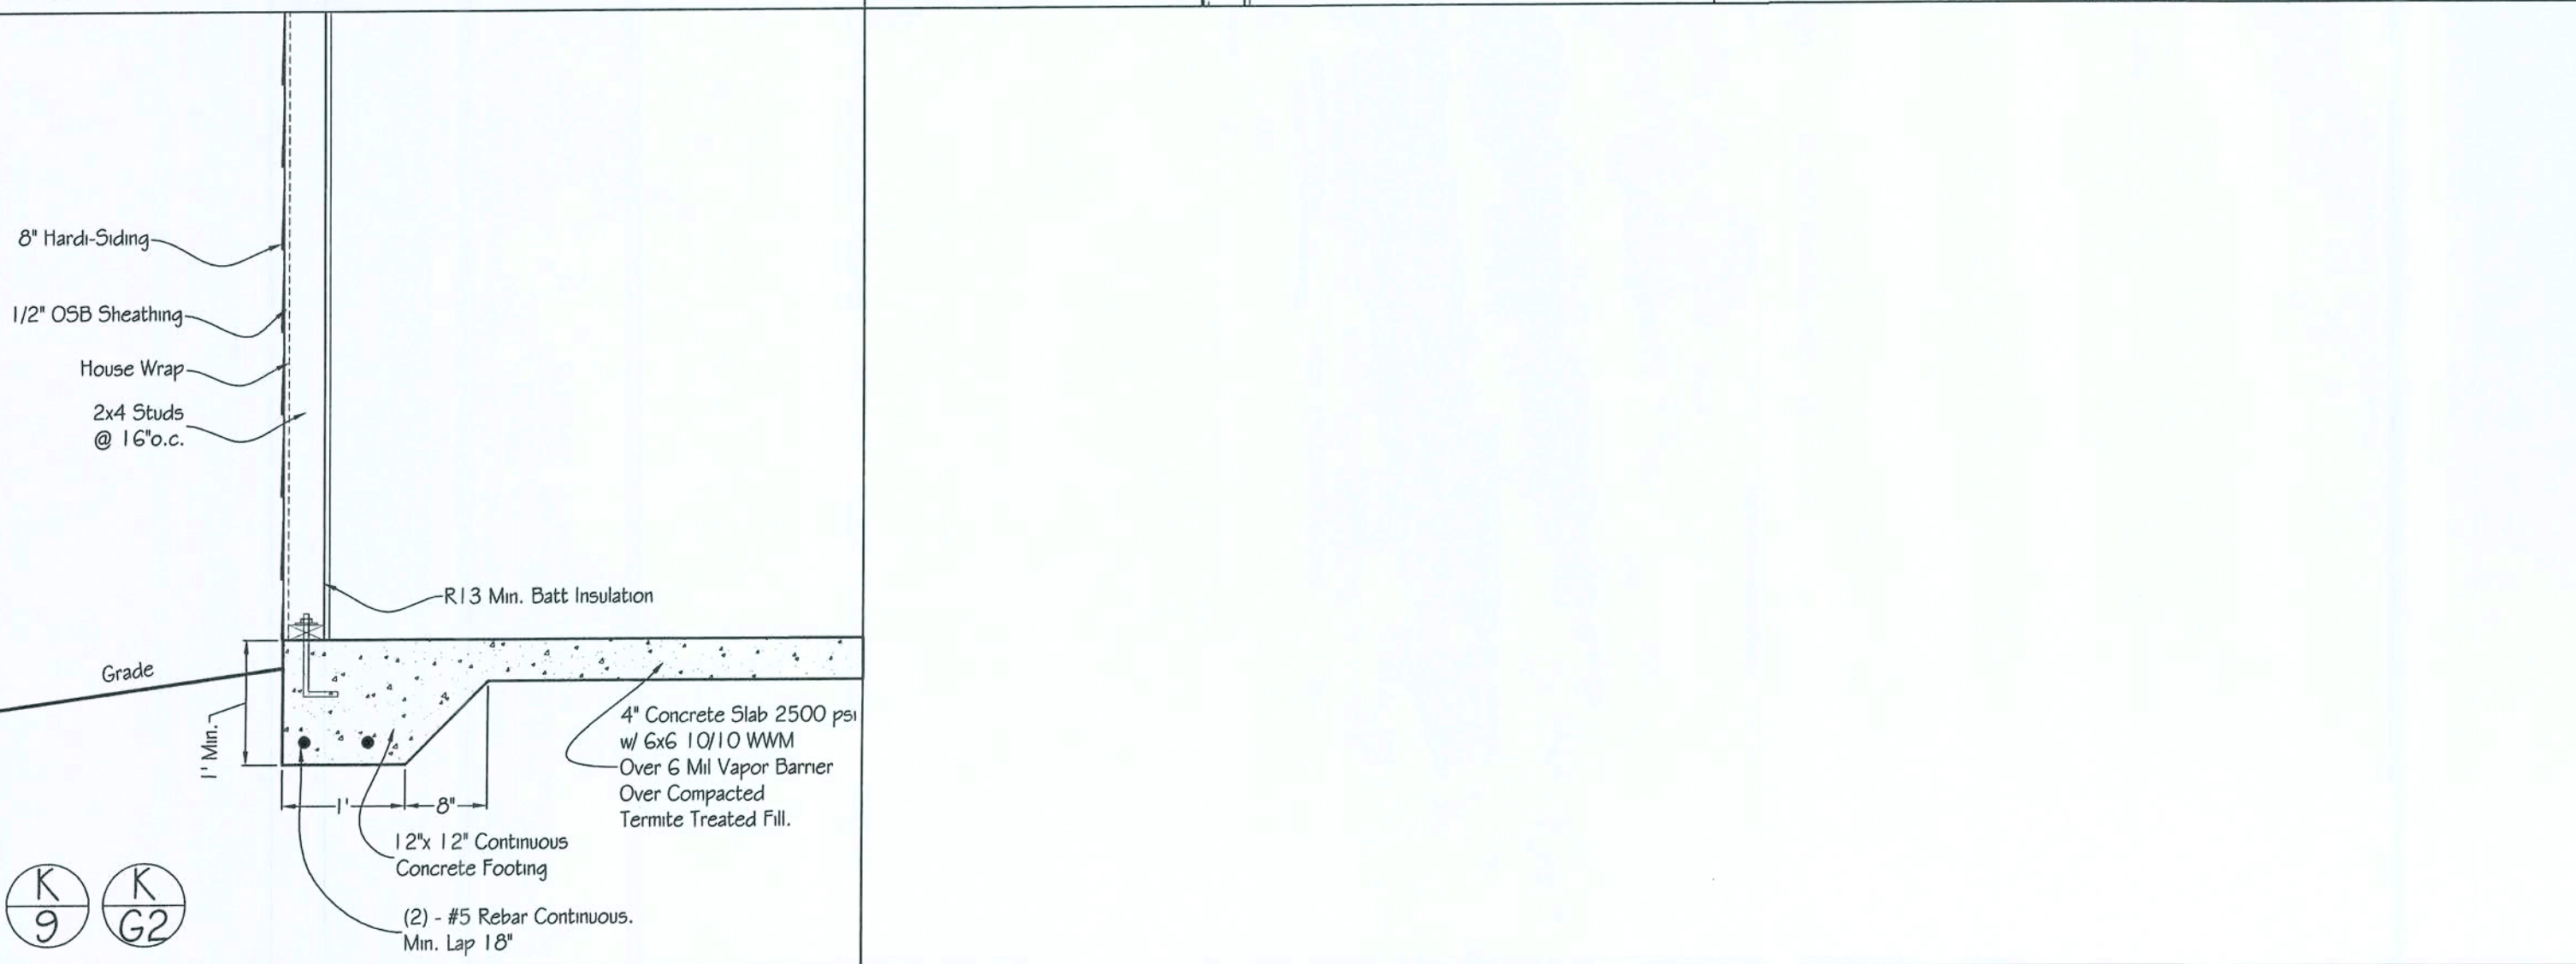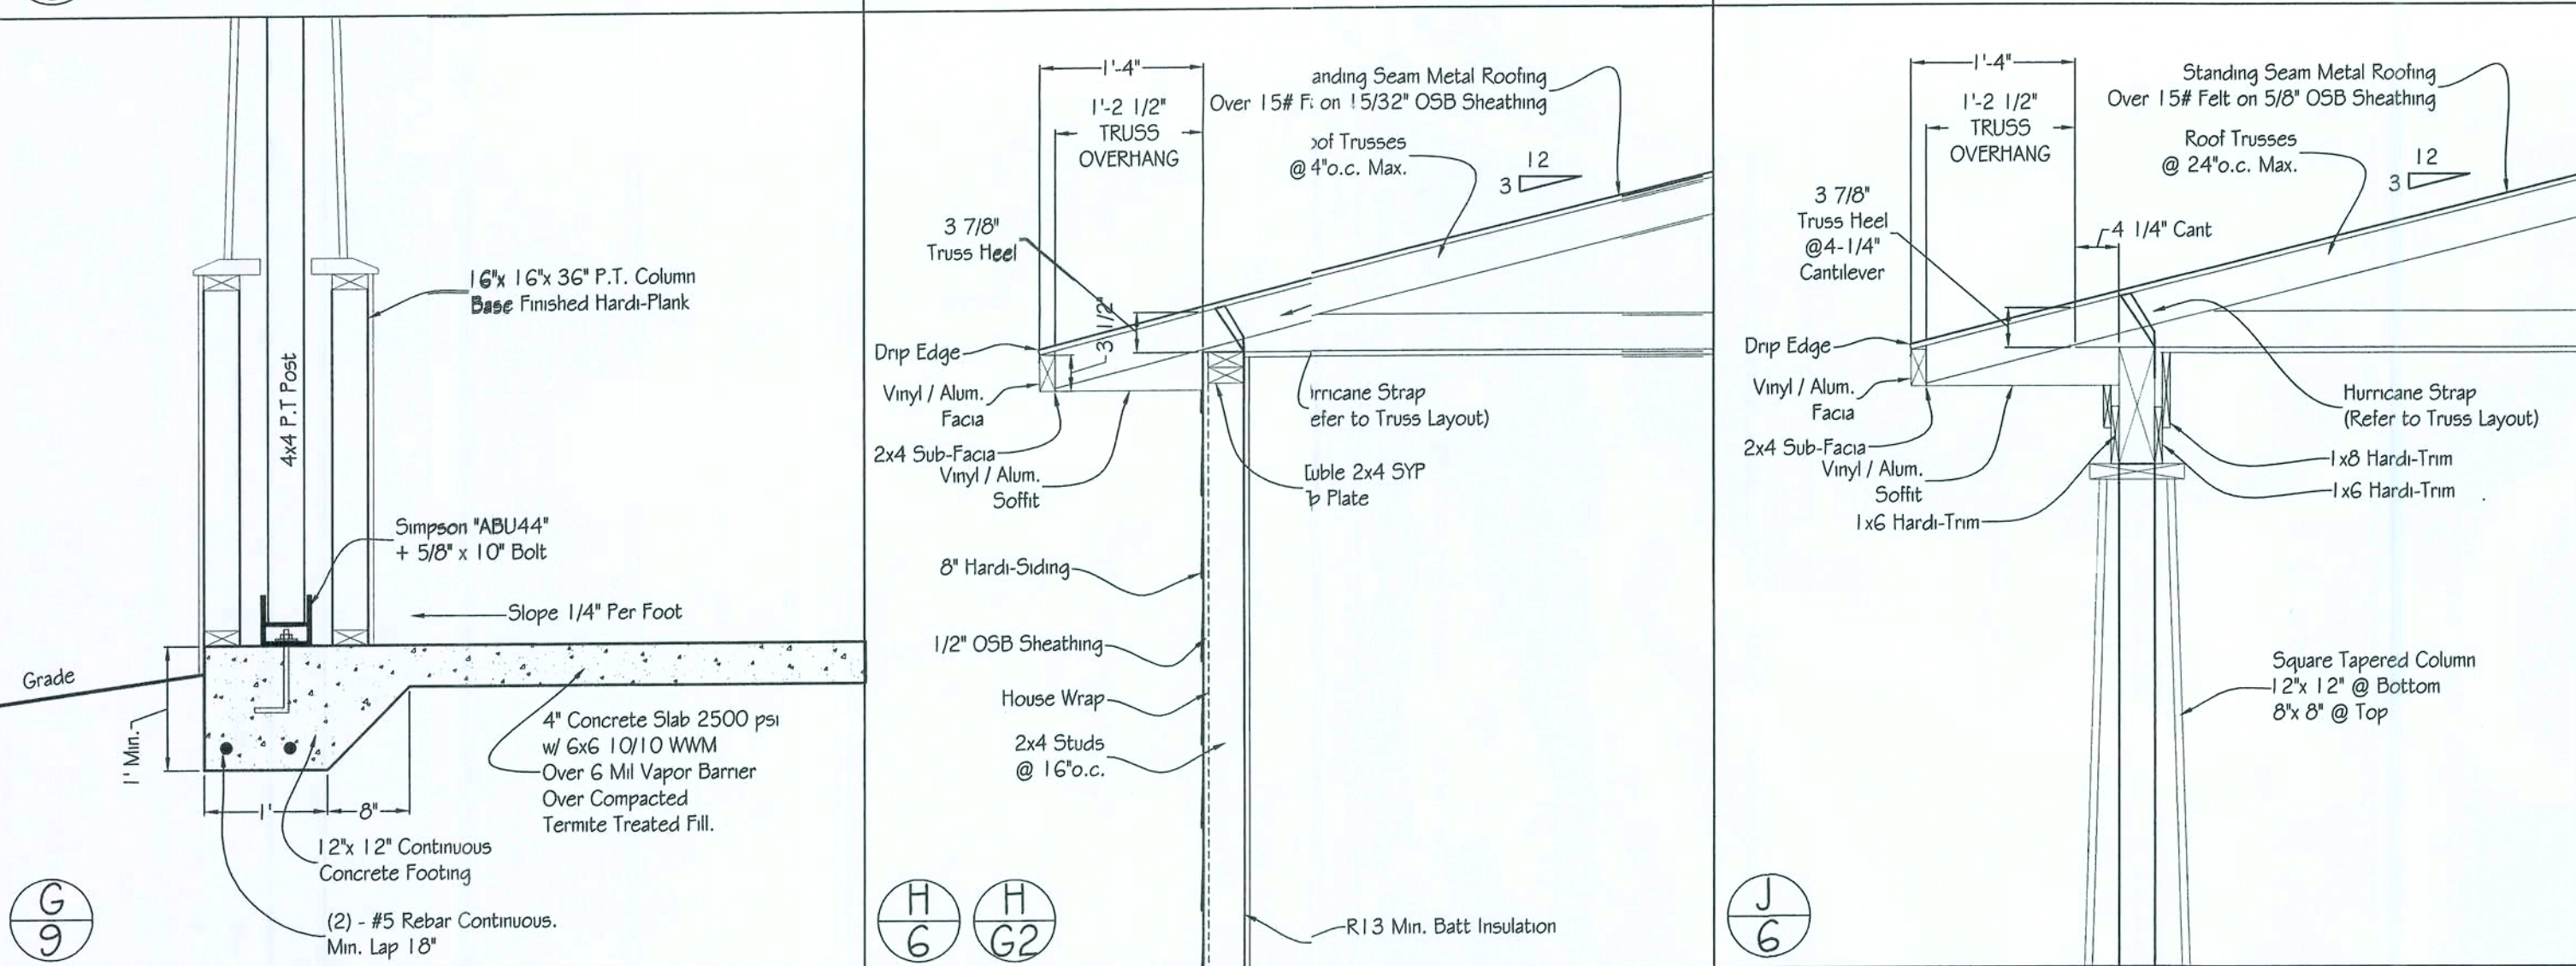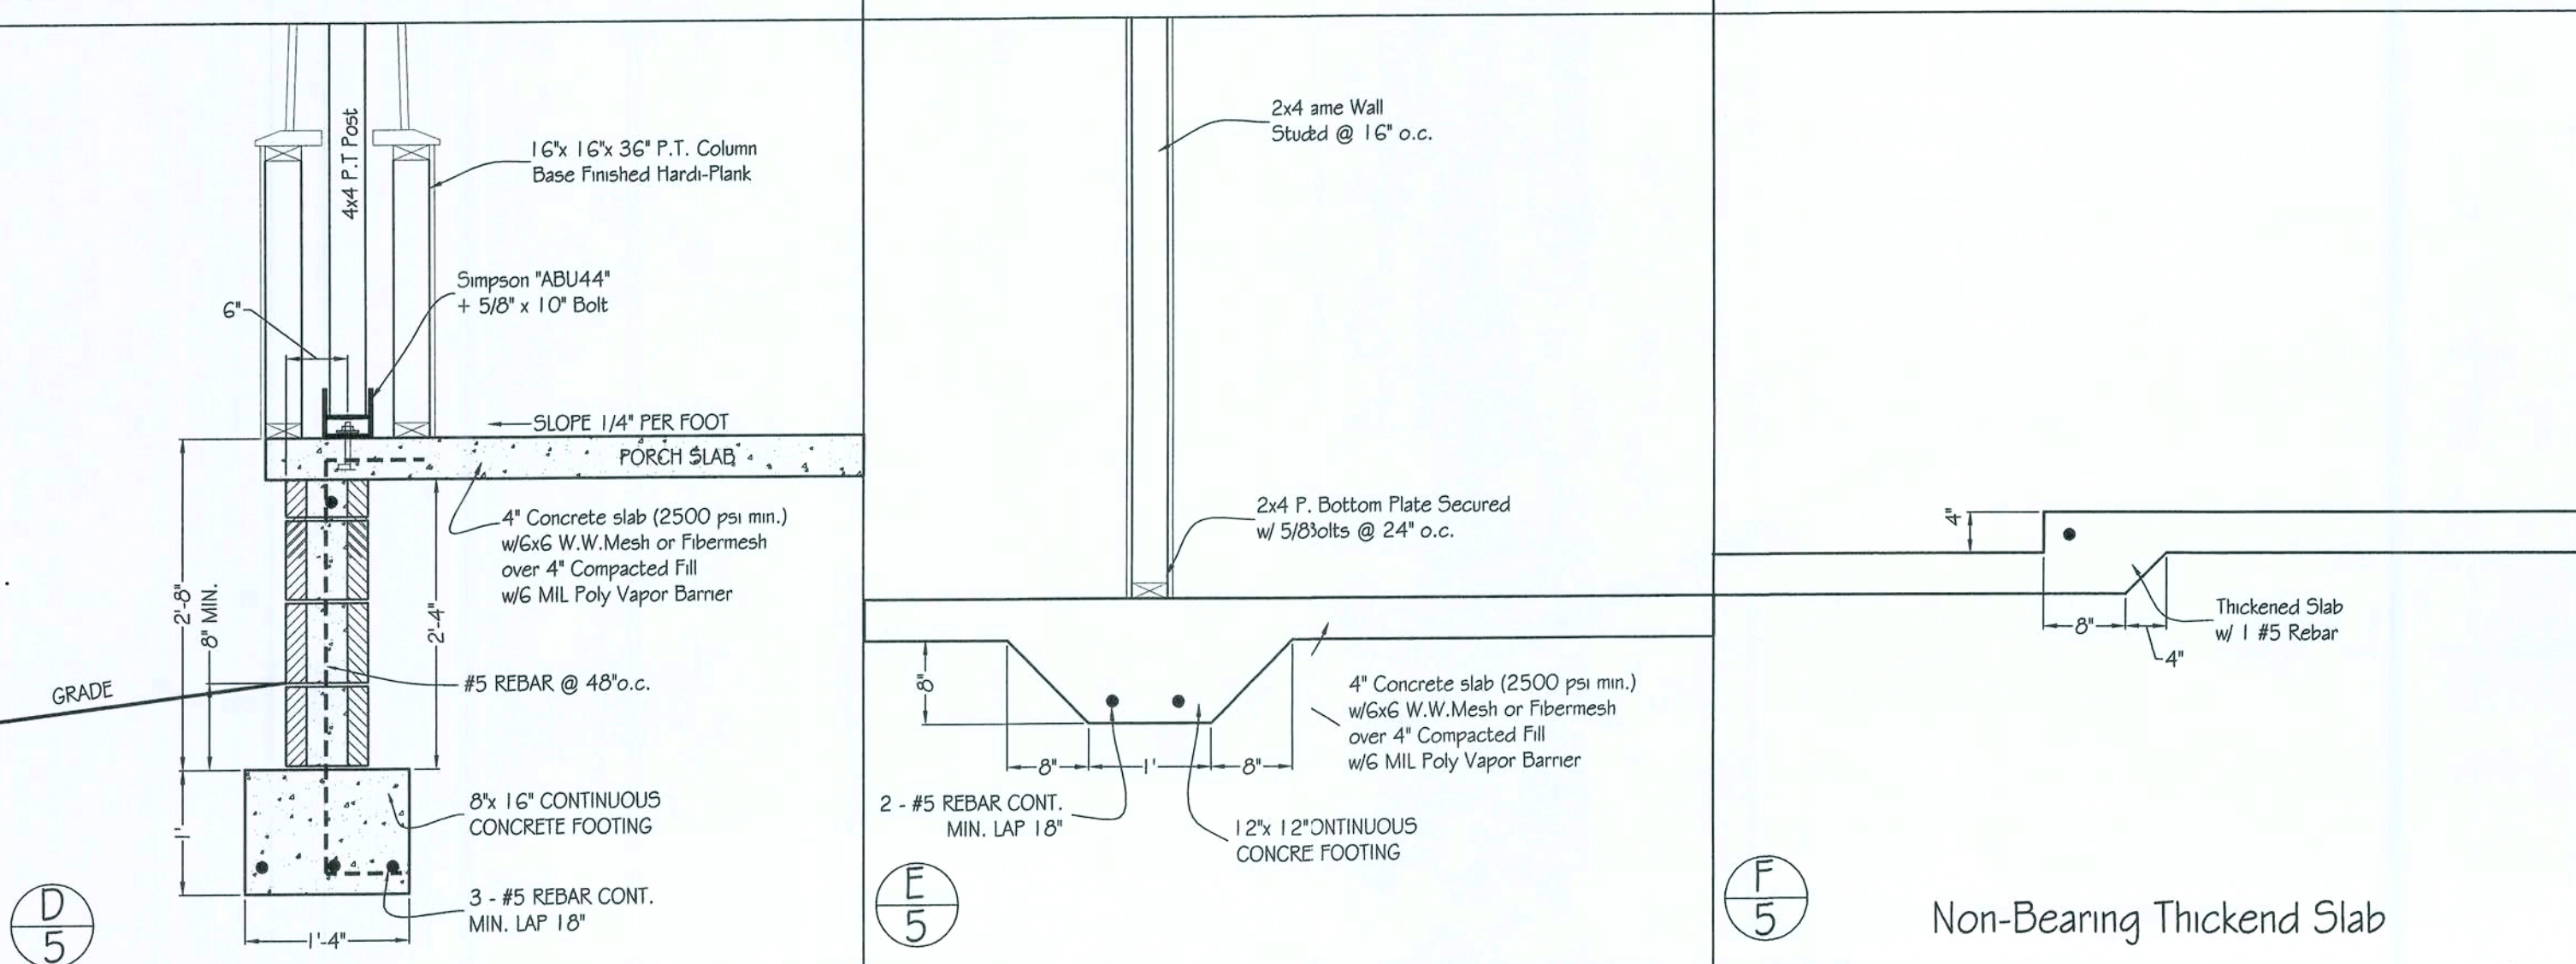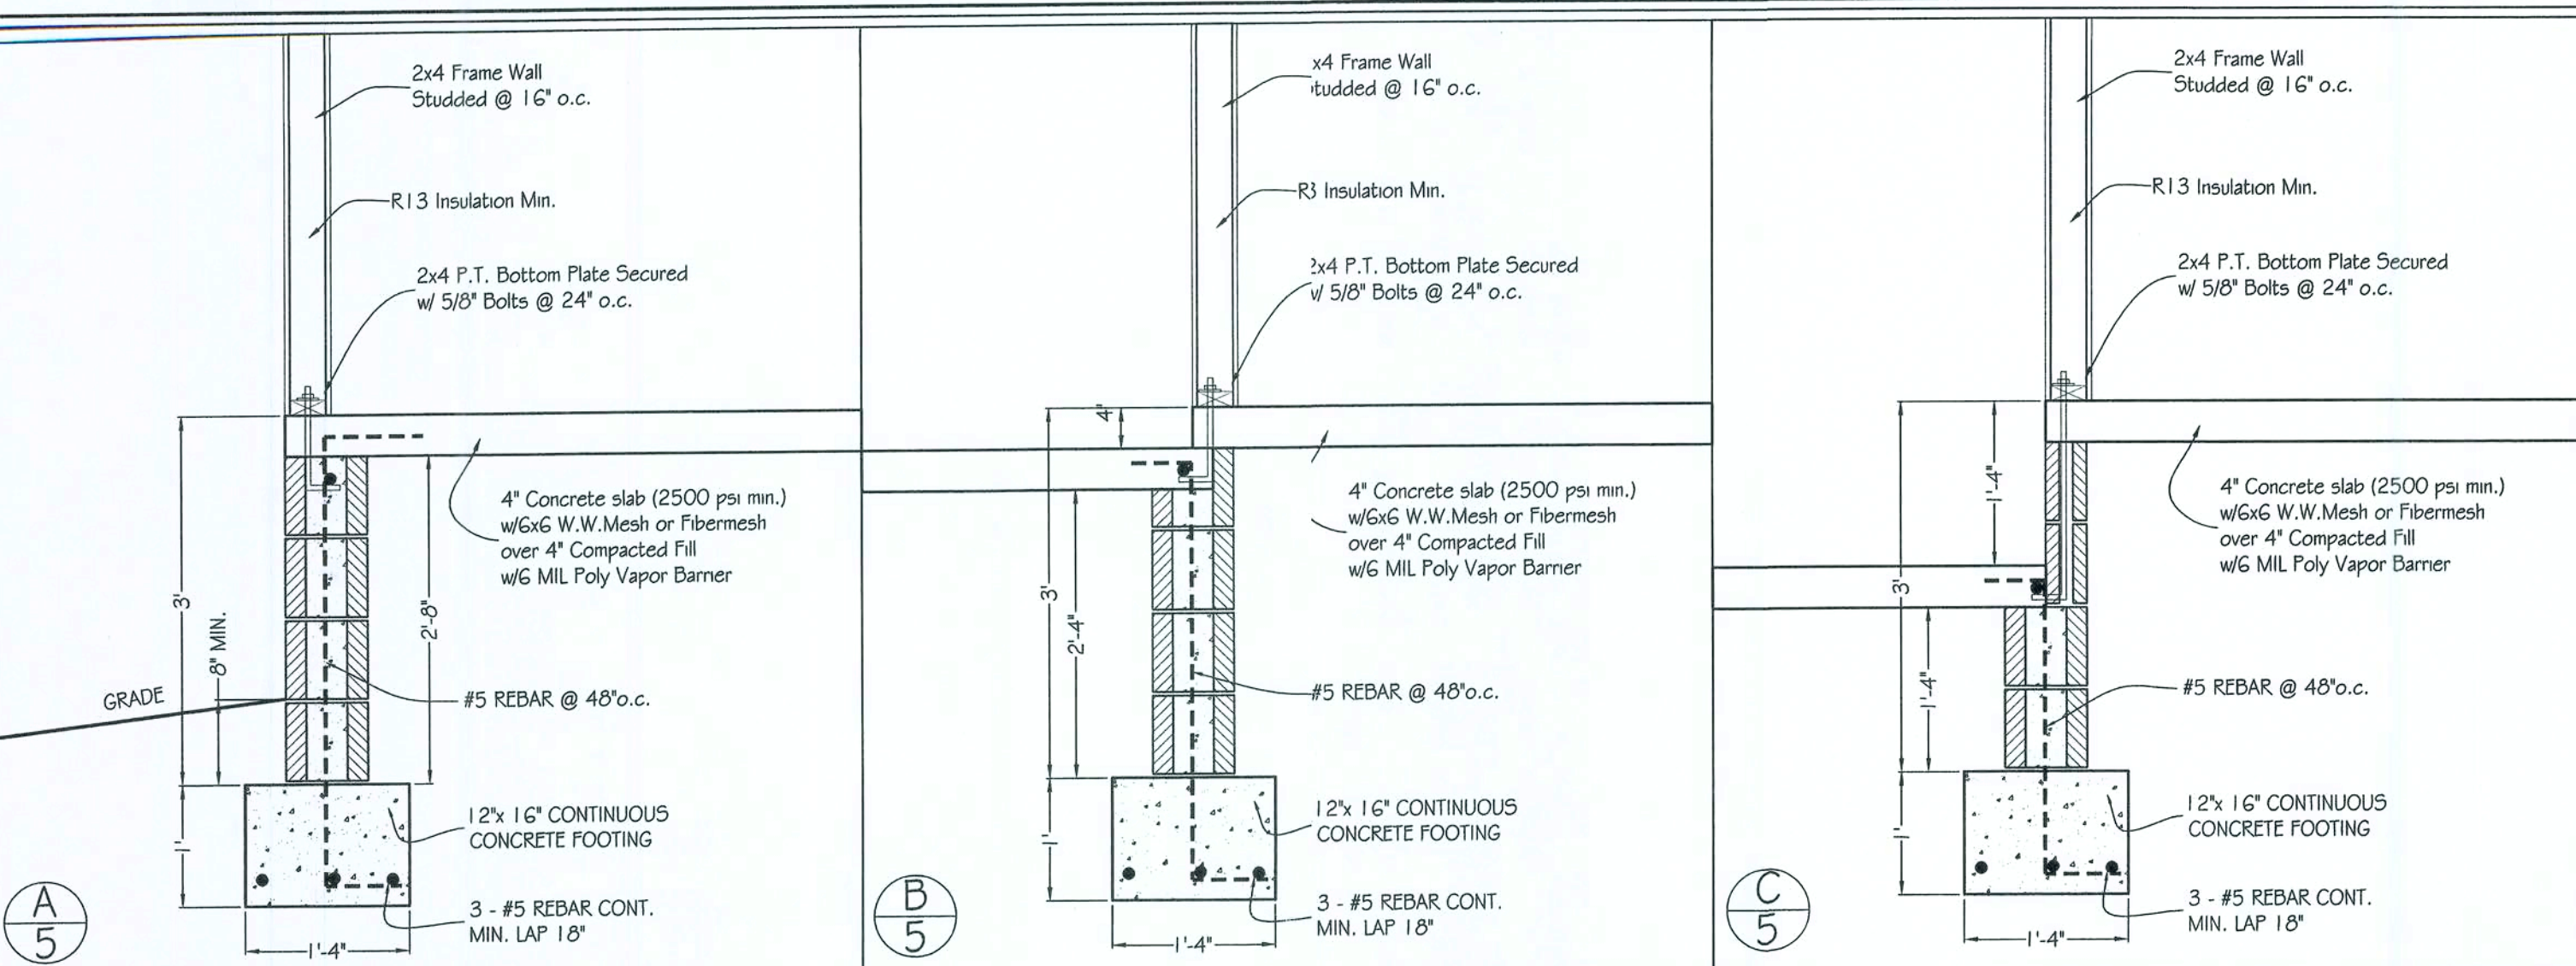

Code Compliance:
This building is designed in compliance with the requirements of the Florida Building code, 2004. Structural members, cladding, fasteners and systems providing for the structural integrity of the building are designed to resist gravity loads prescribed in Chapter 16, and wind loads prescribed in Section 1606.2 Simplified provisions for low rise buildings.

Design Loads:
Roof Live Loads: 20 psf
Wind Loads:
Basic wind speed = 110 MPH
Importance factor = 1.0
Exposure category = B
Internal pressure coefficient = +/- 0.18 fully enclosed.

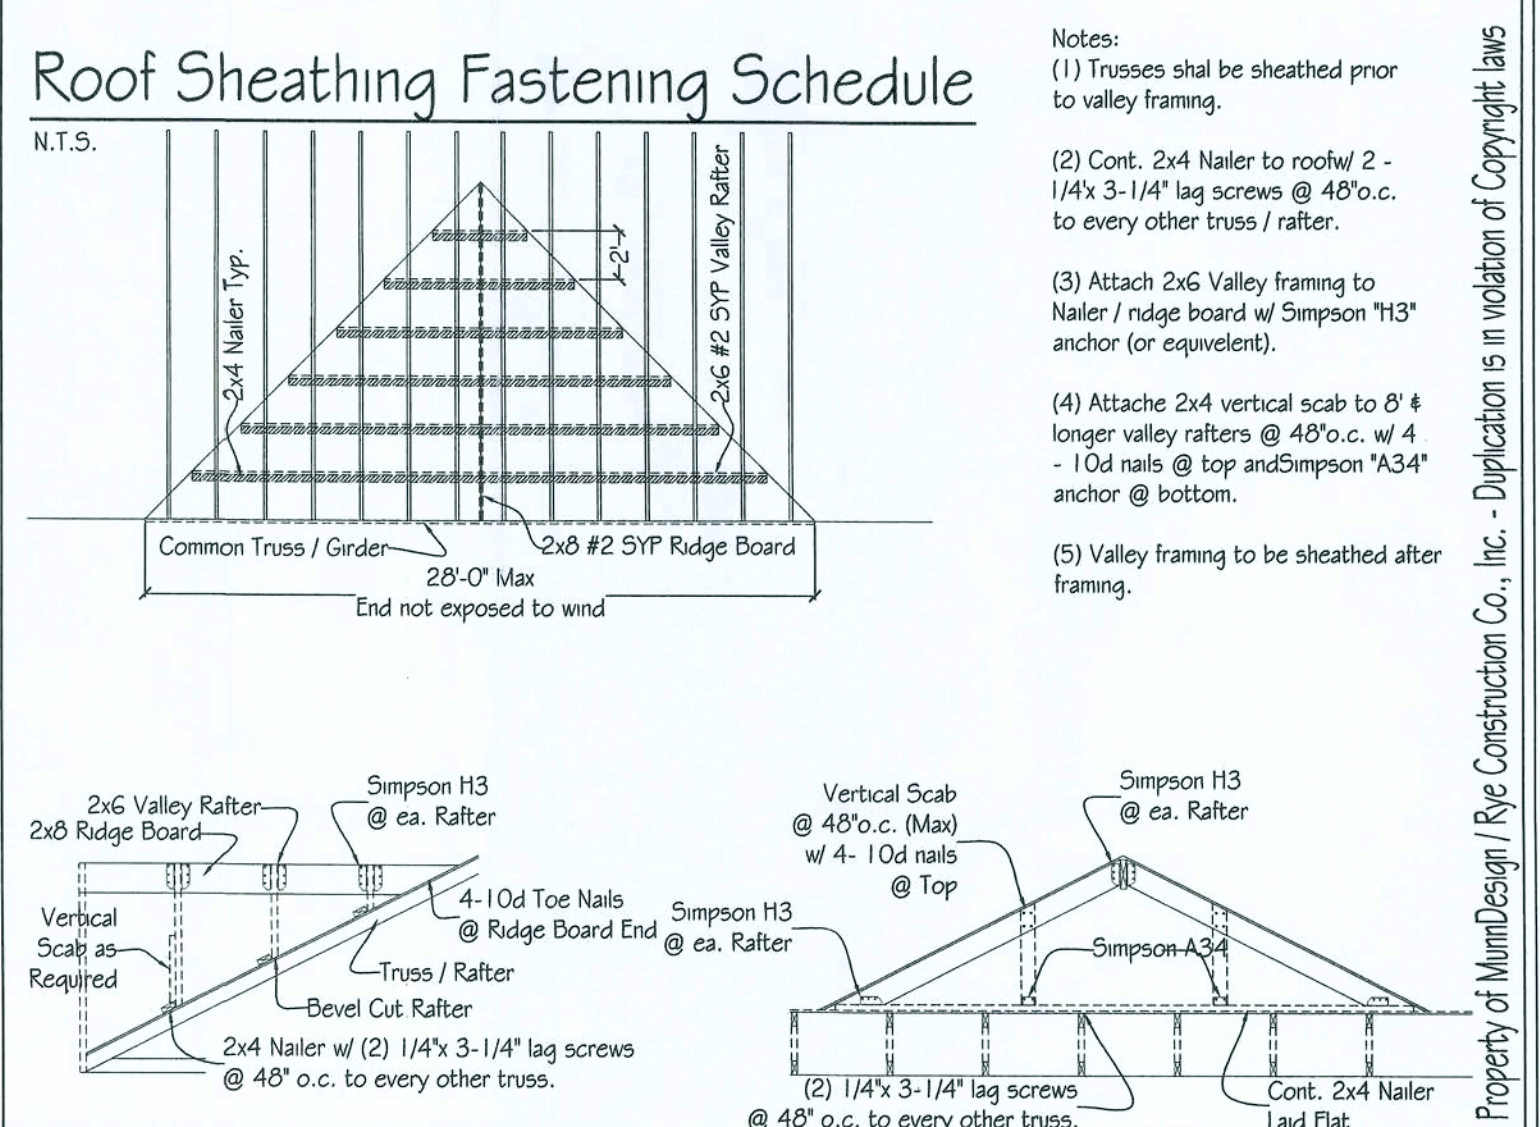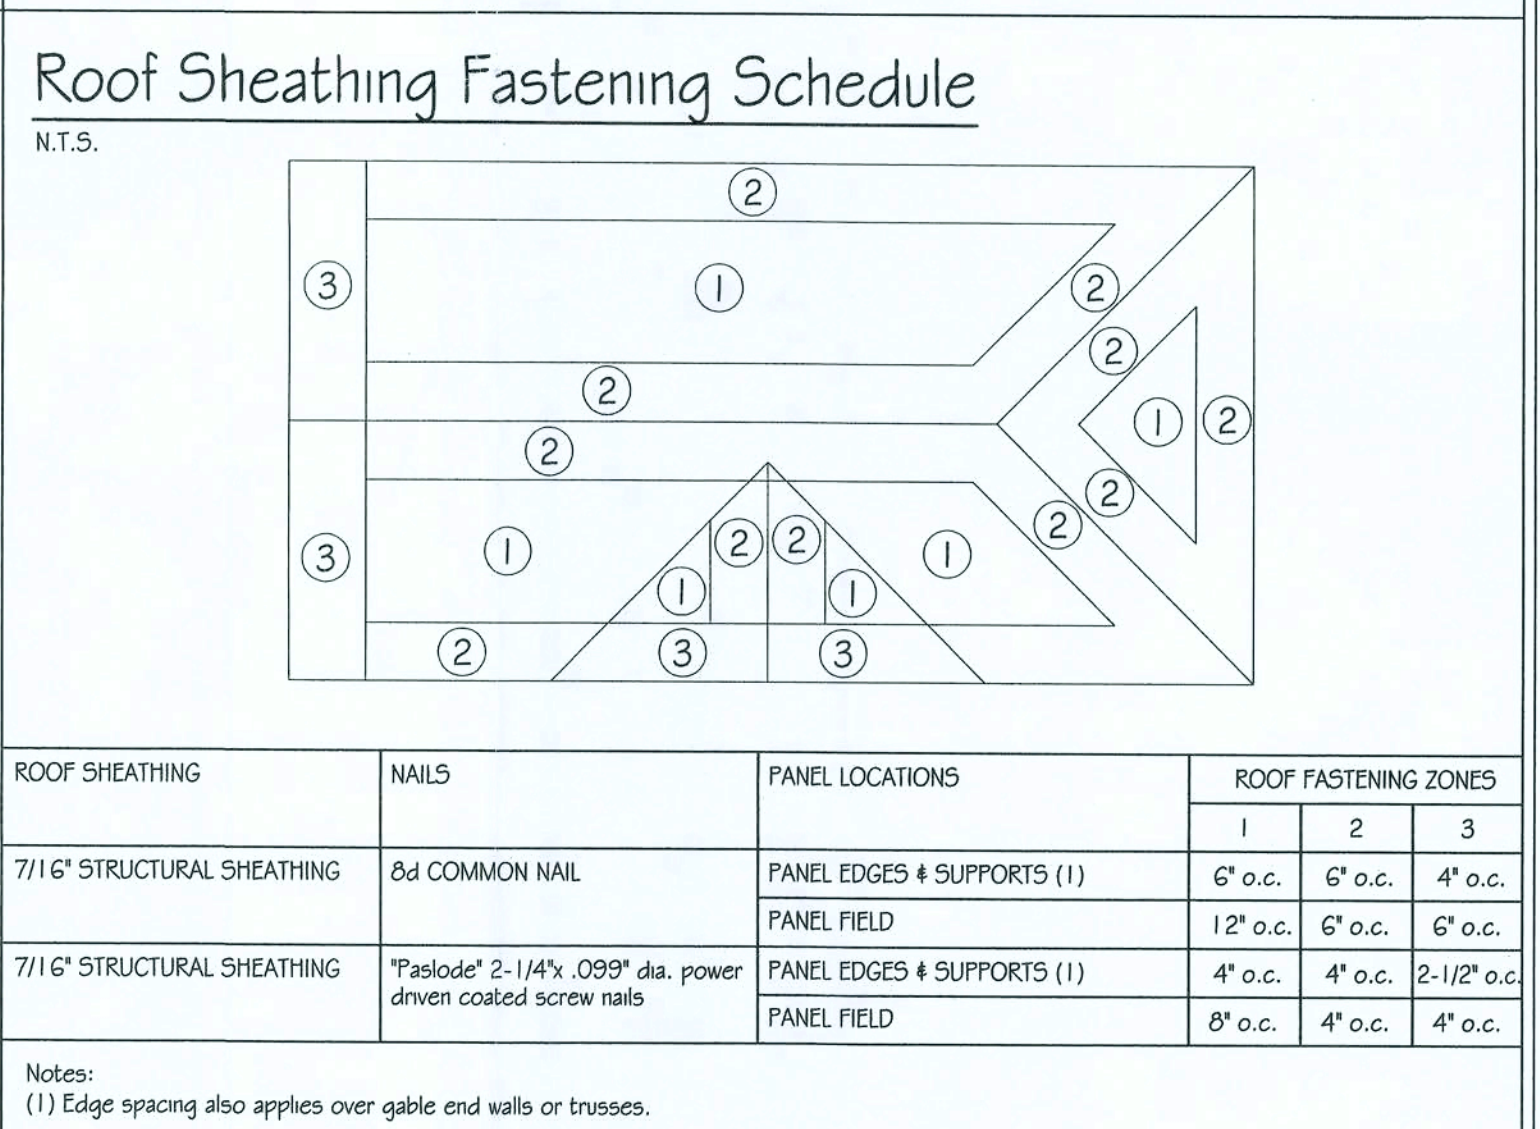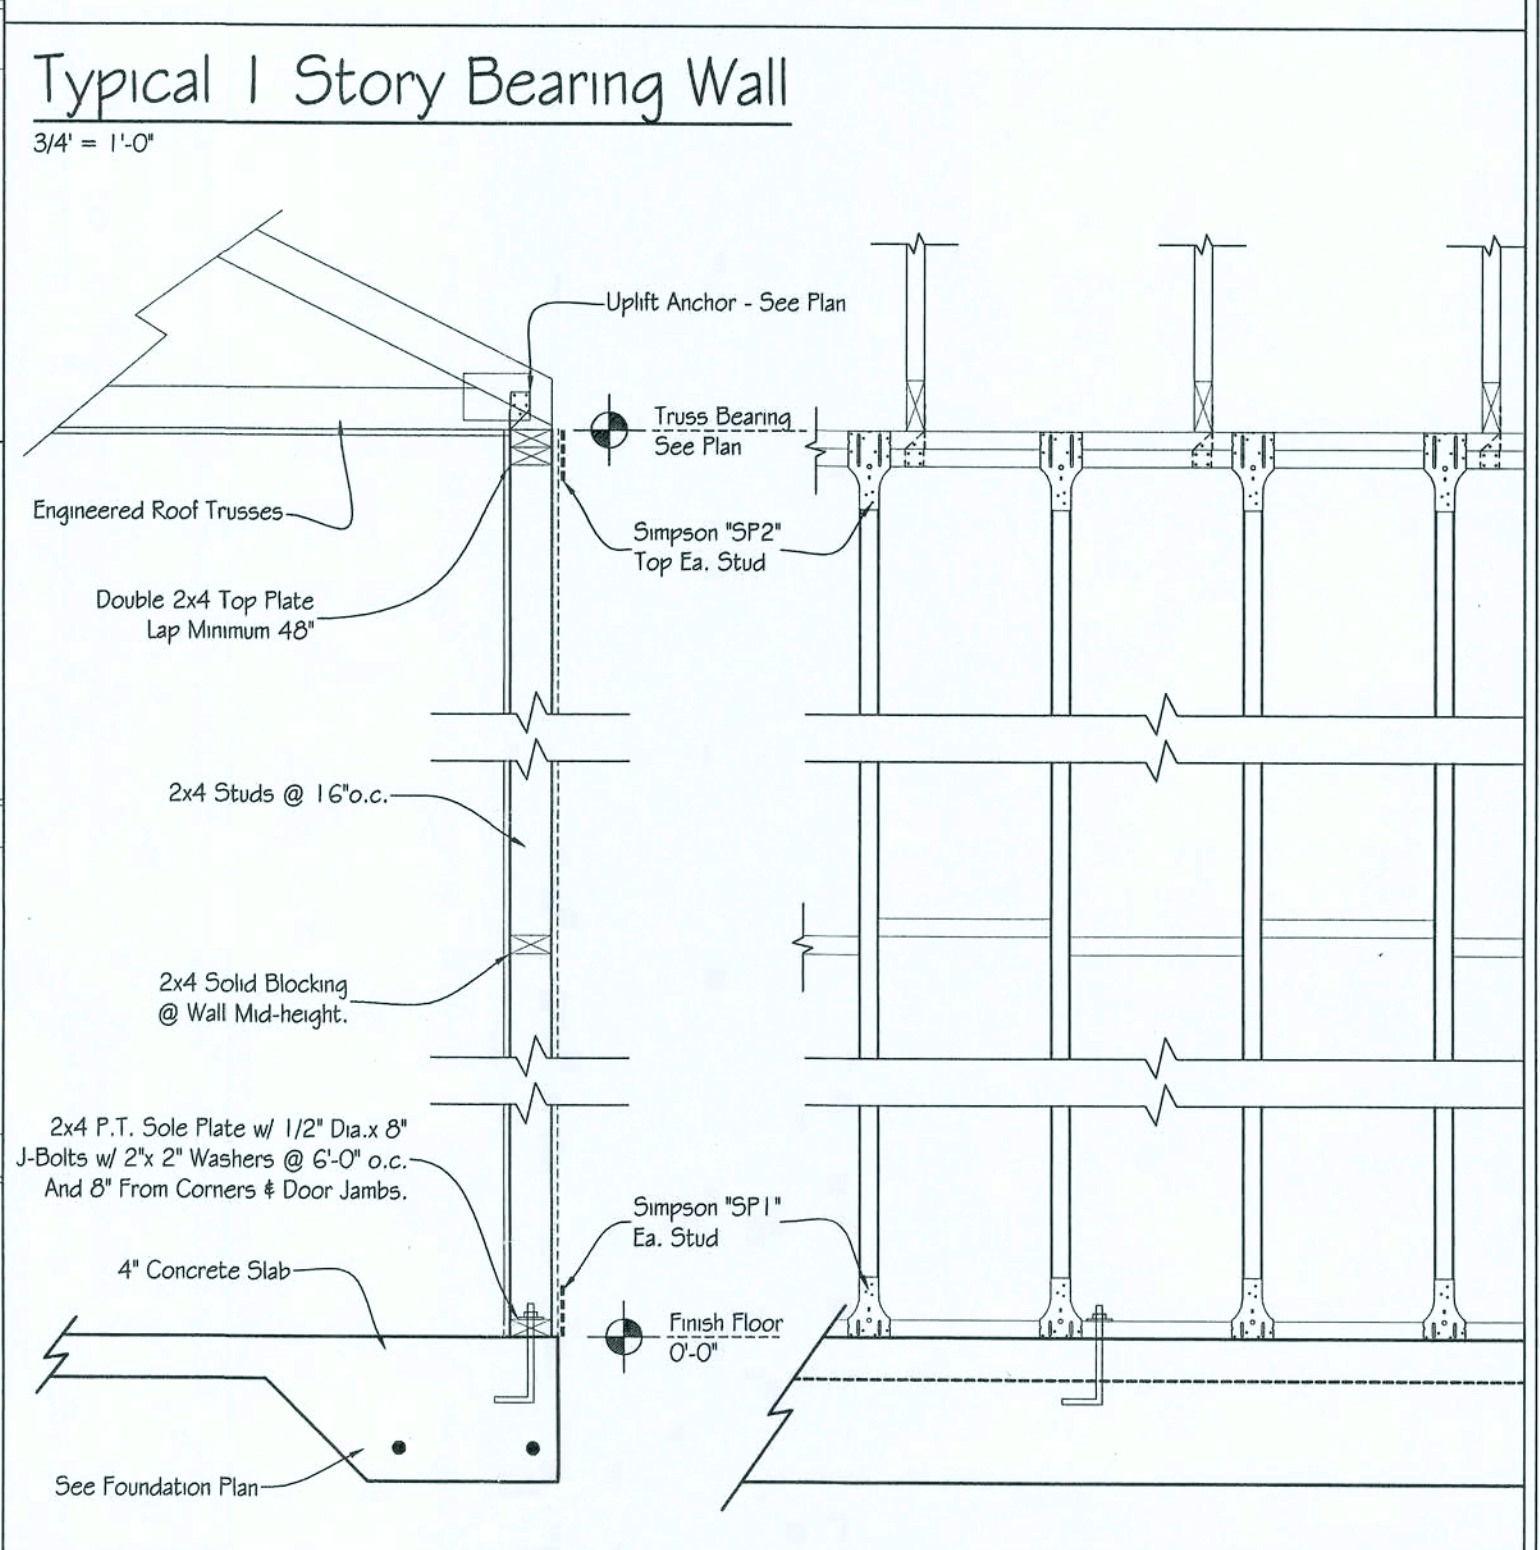

Rye Construction Company, Inc.
State Certified Custom Home Builder
CCG #1511121
Gainesville, Florida
RCCBI@cox.net

Custom Home Design for:

Walt & Krissy Smith

Lake City, Florida

PROJ. #

Plan # **VS**Smith

SCALE: **3/4" = 1'-0"**

DATE: **2-27-2007**


DRAWN BY: **BRAD A. MUNN**

MUMM DESIGN

RESIDENTIAL DRAFTING & DESIGN
P.O. Box 773063
Orlando, FL 32877-3063
www.MumDesign.com

PAGE 1

© Mumm Design / Rye Cont. 2007

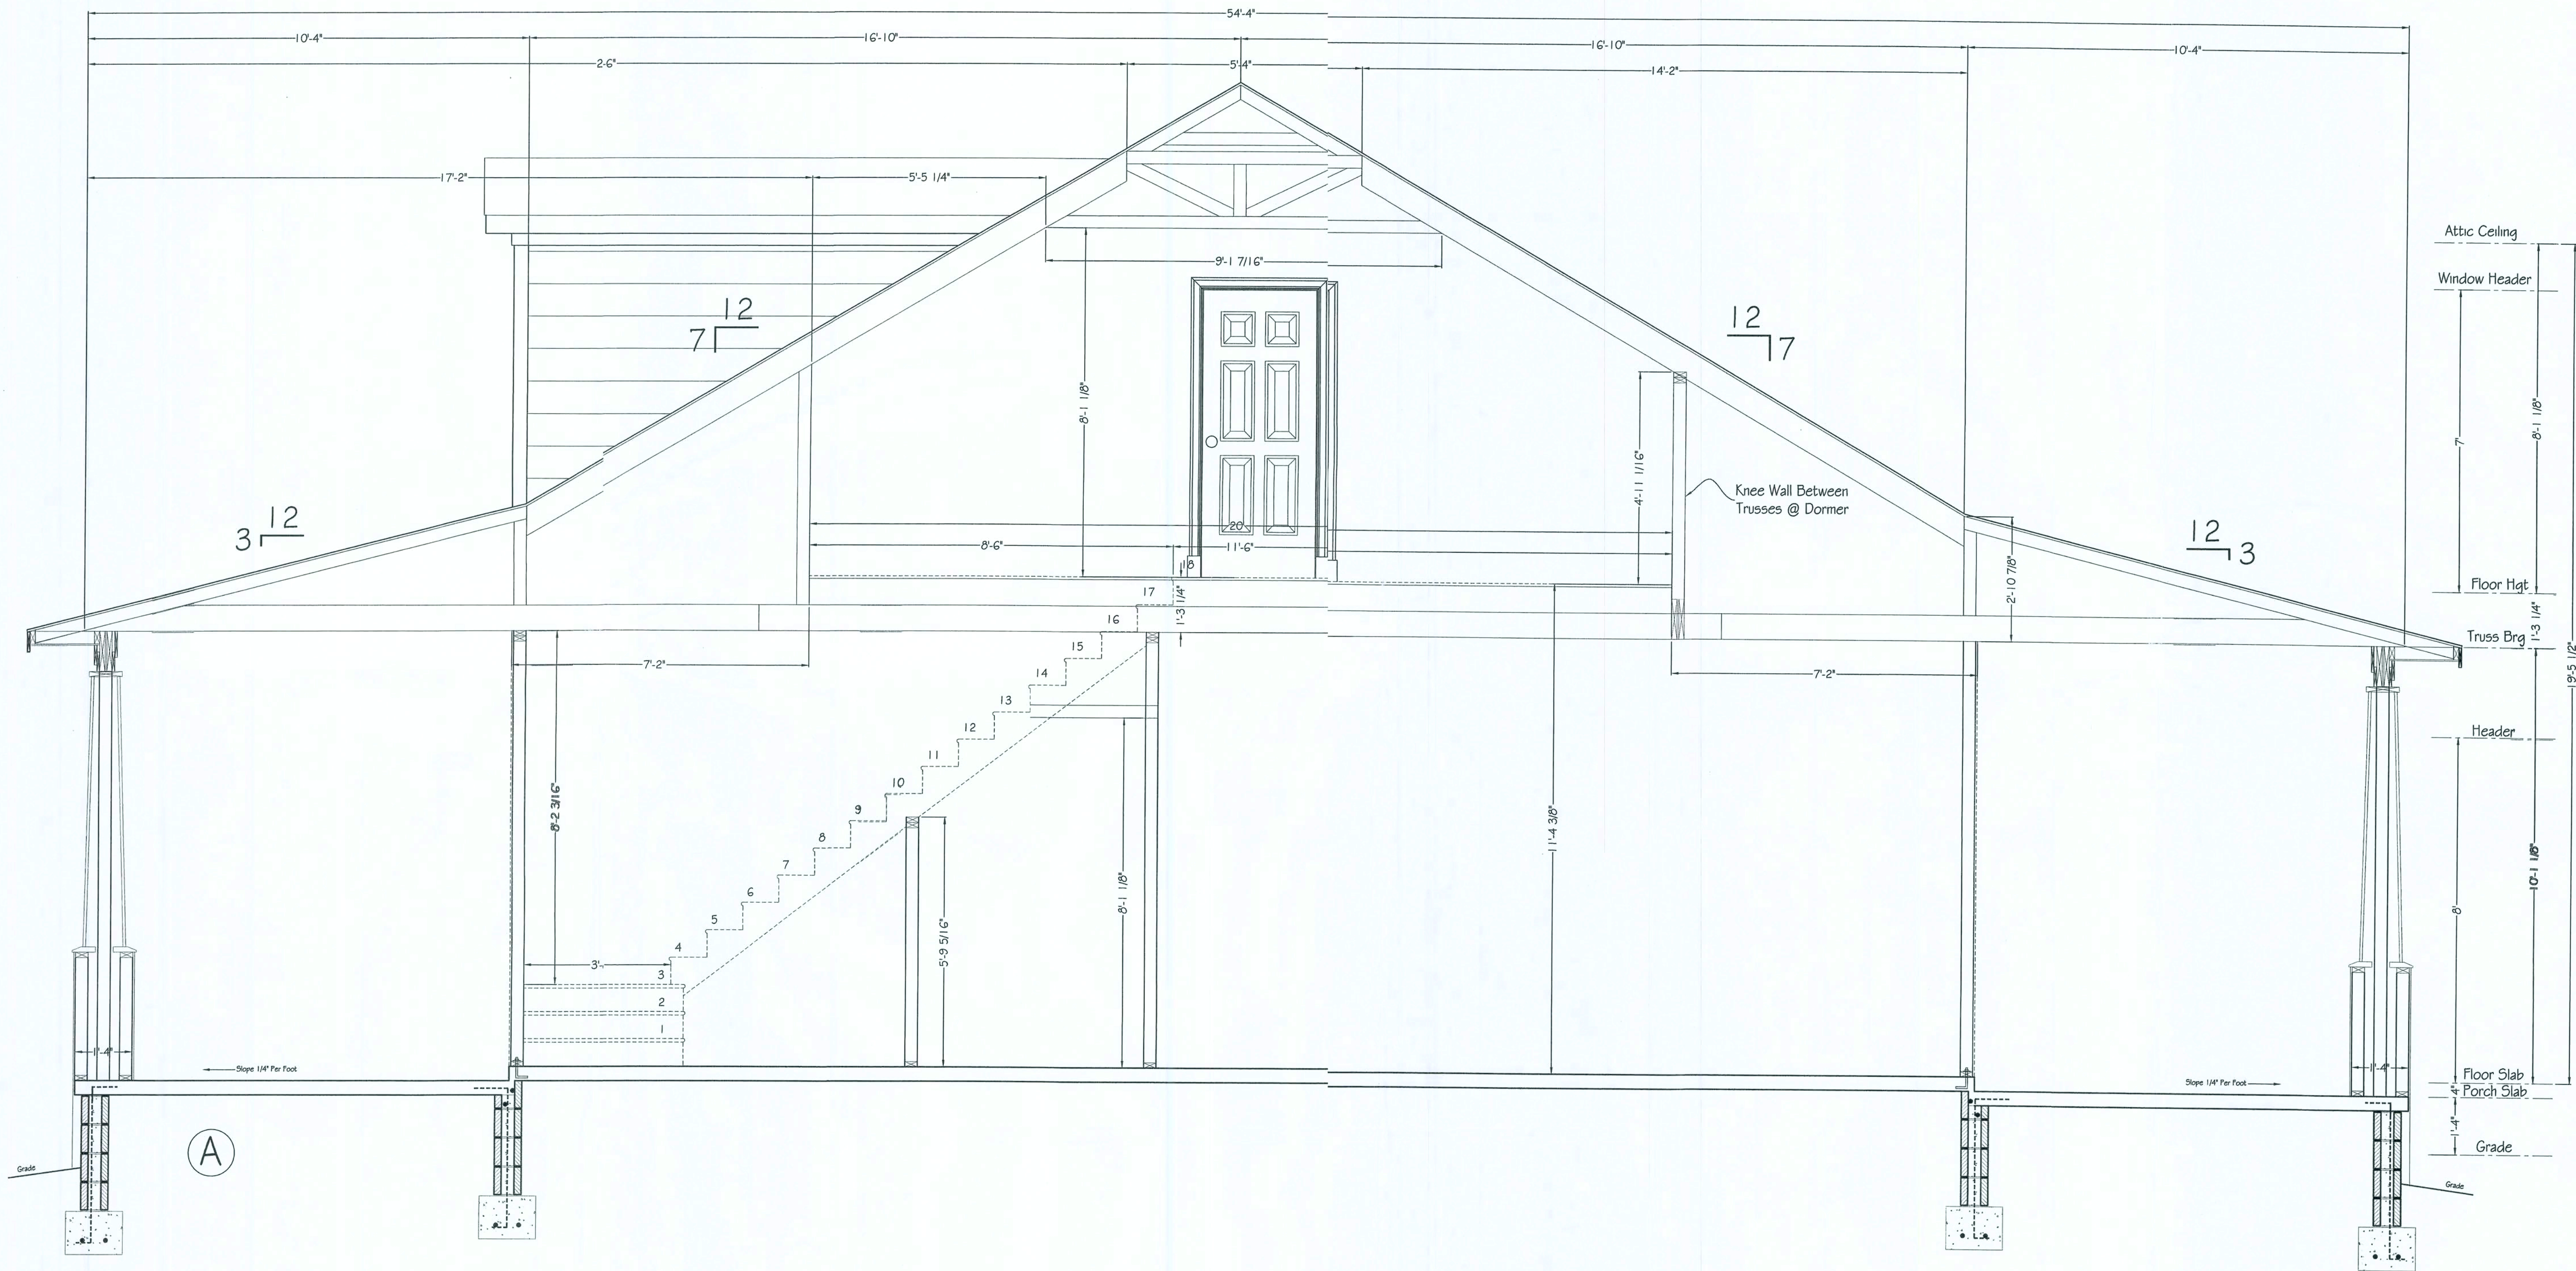


Rye Construction Company, Inc.
State Certified Custom Home Builder
CSC #1511121
Gainesville, Florida
RCCBI@Cox.net
PH: (352) 378-3006
Fax: (352) 378-9003

Custom Home Design for:
Walt & Krissy Smith
Lake City, Florida

PROJ.#
Plan # WSmith
SCALE: 1/2" = 1'-0"
DATE: 2-27-2007
DRAWN BY:
BRAD J. MUNN

MUNN DESIGN
RESIDENTIAL DRAFTING & DESIGN
P.O. Box 770063
OCALA, FL 34477-3063
PH: (352) 875-5575
Fax: (352) 861-4831
www.MunnDesign.com
Brad@MunnDesign.com

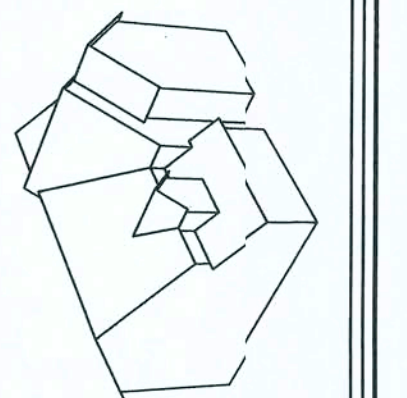

PAGE 501

© Munn Design / Rye Const. 2007