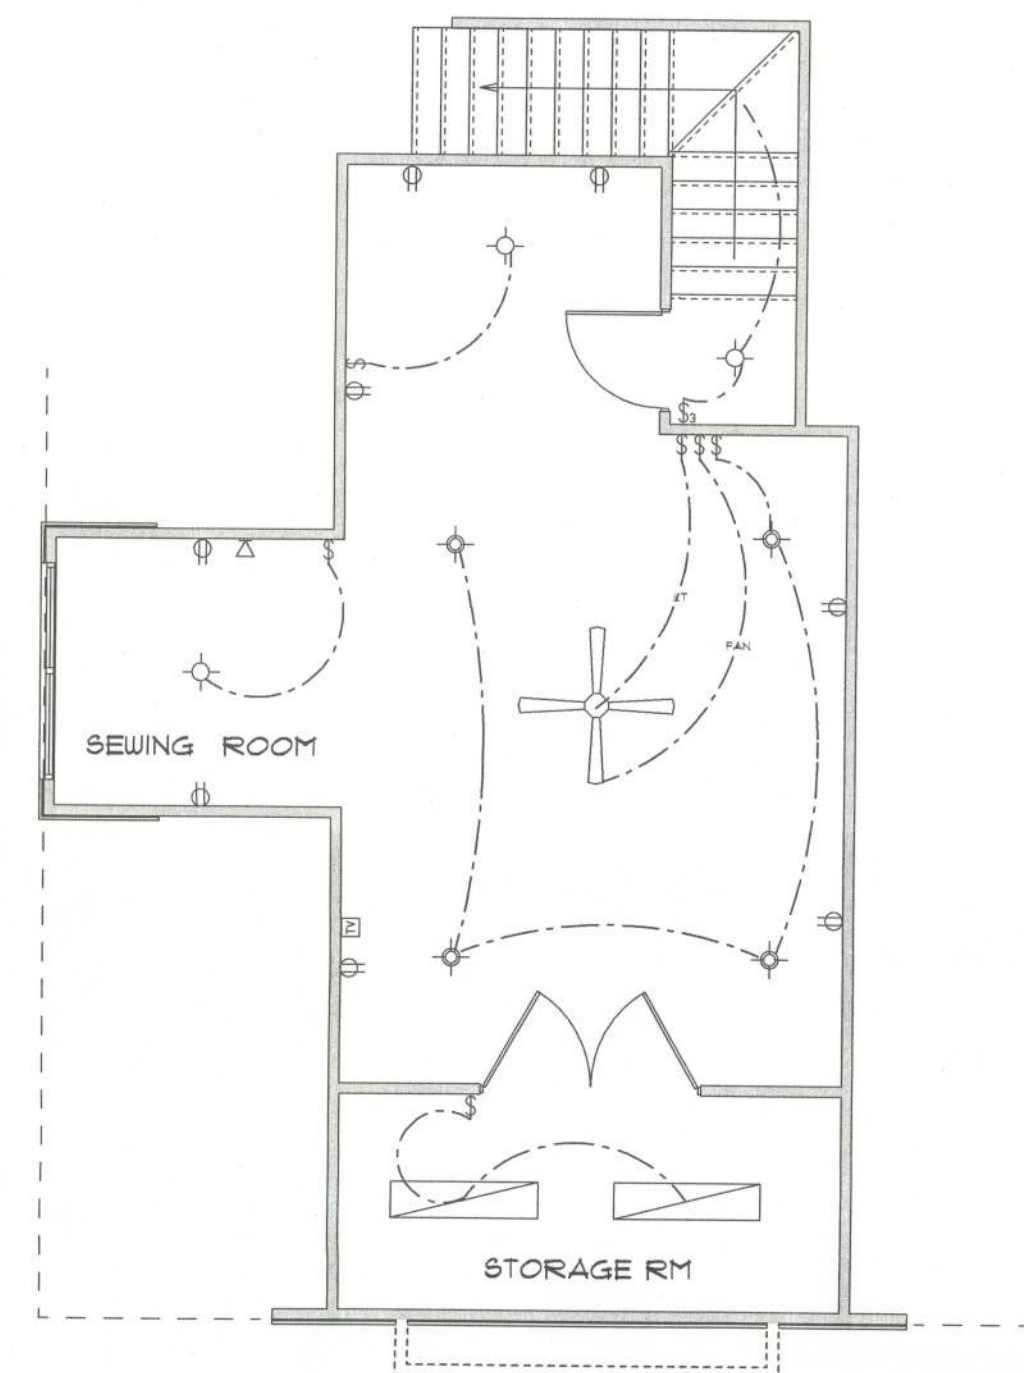
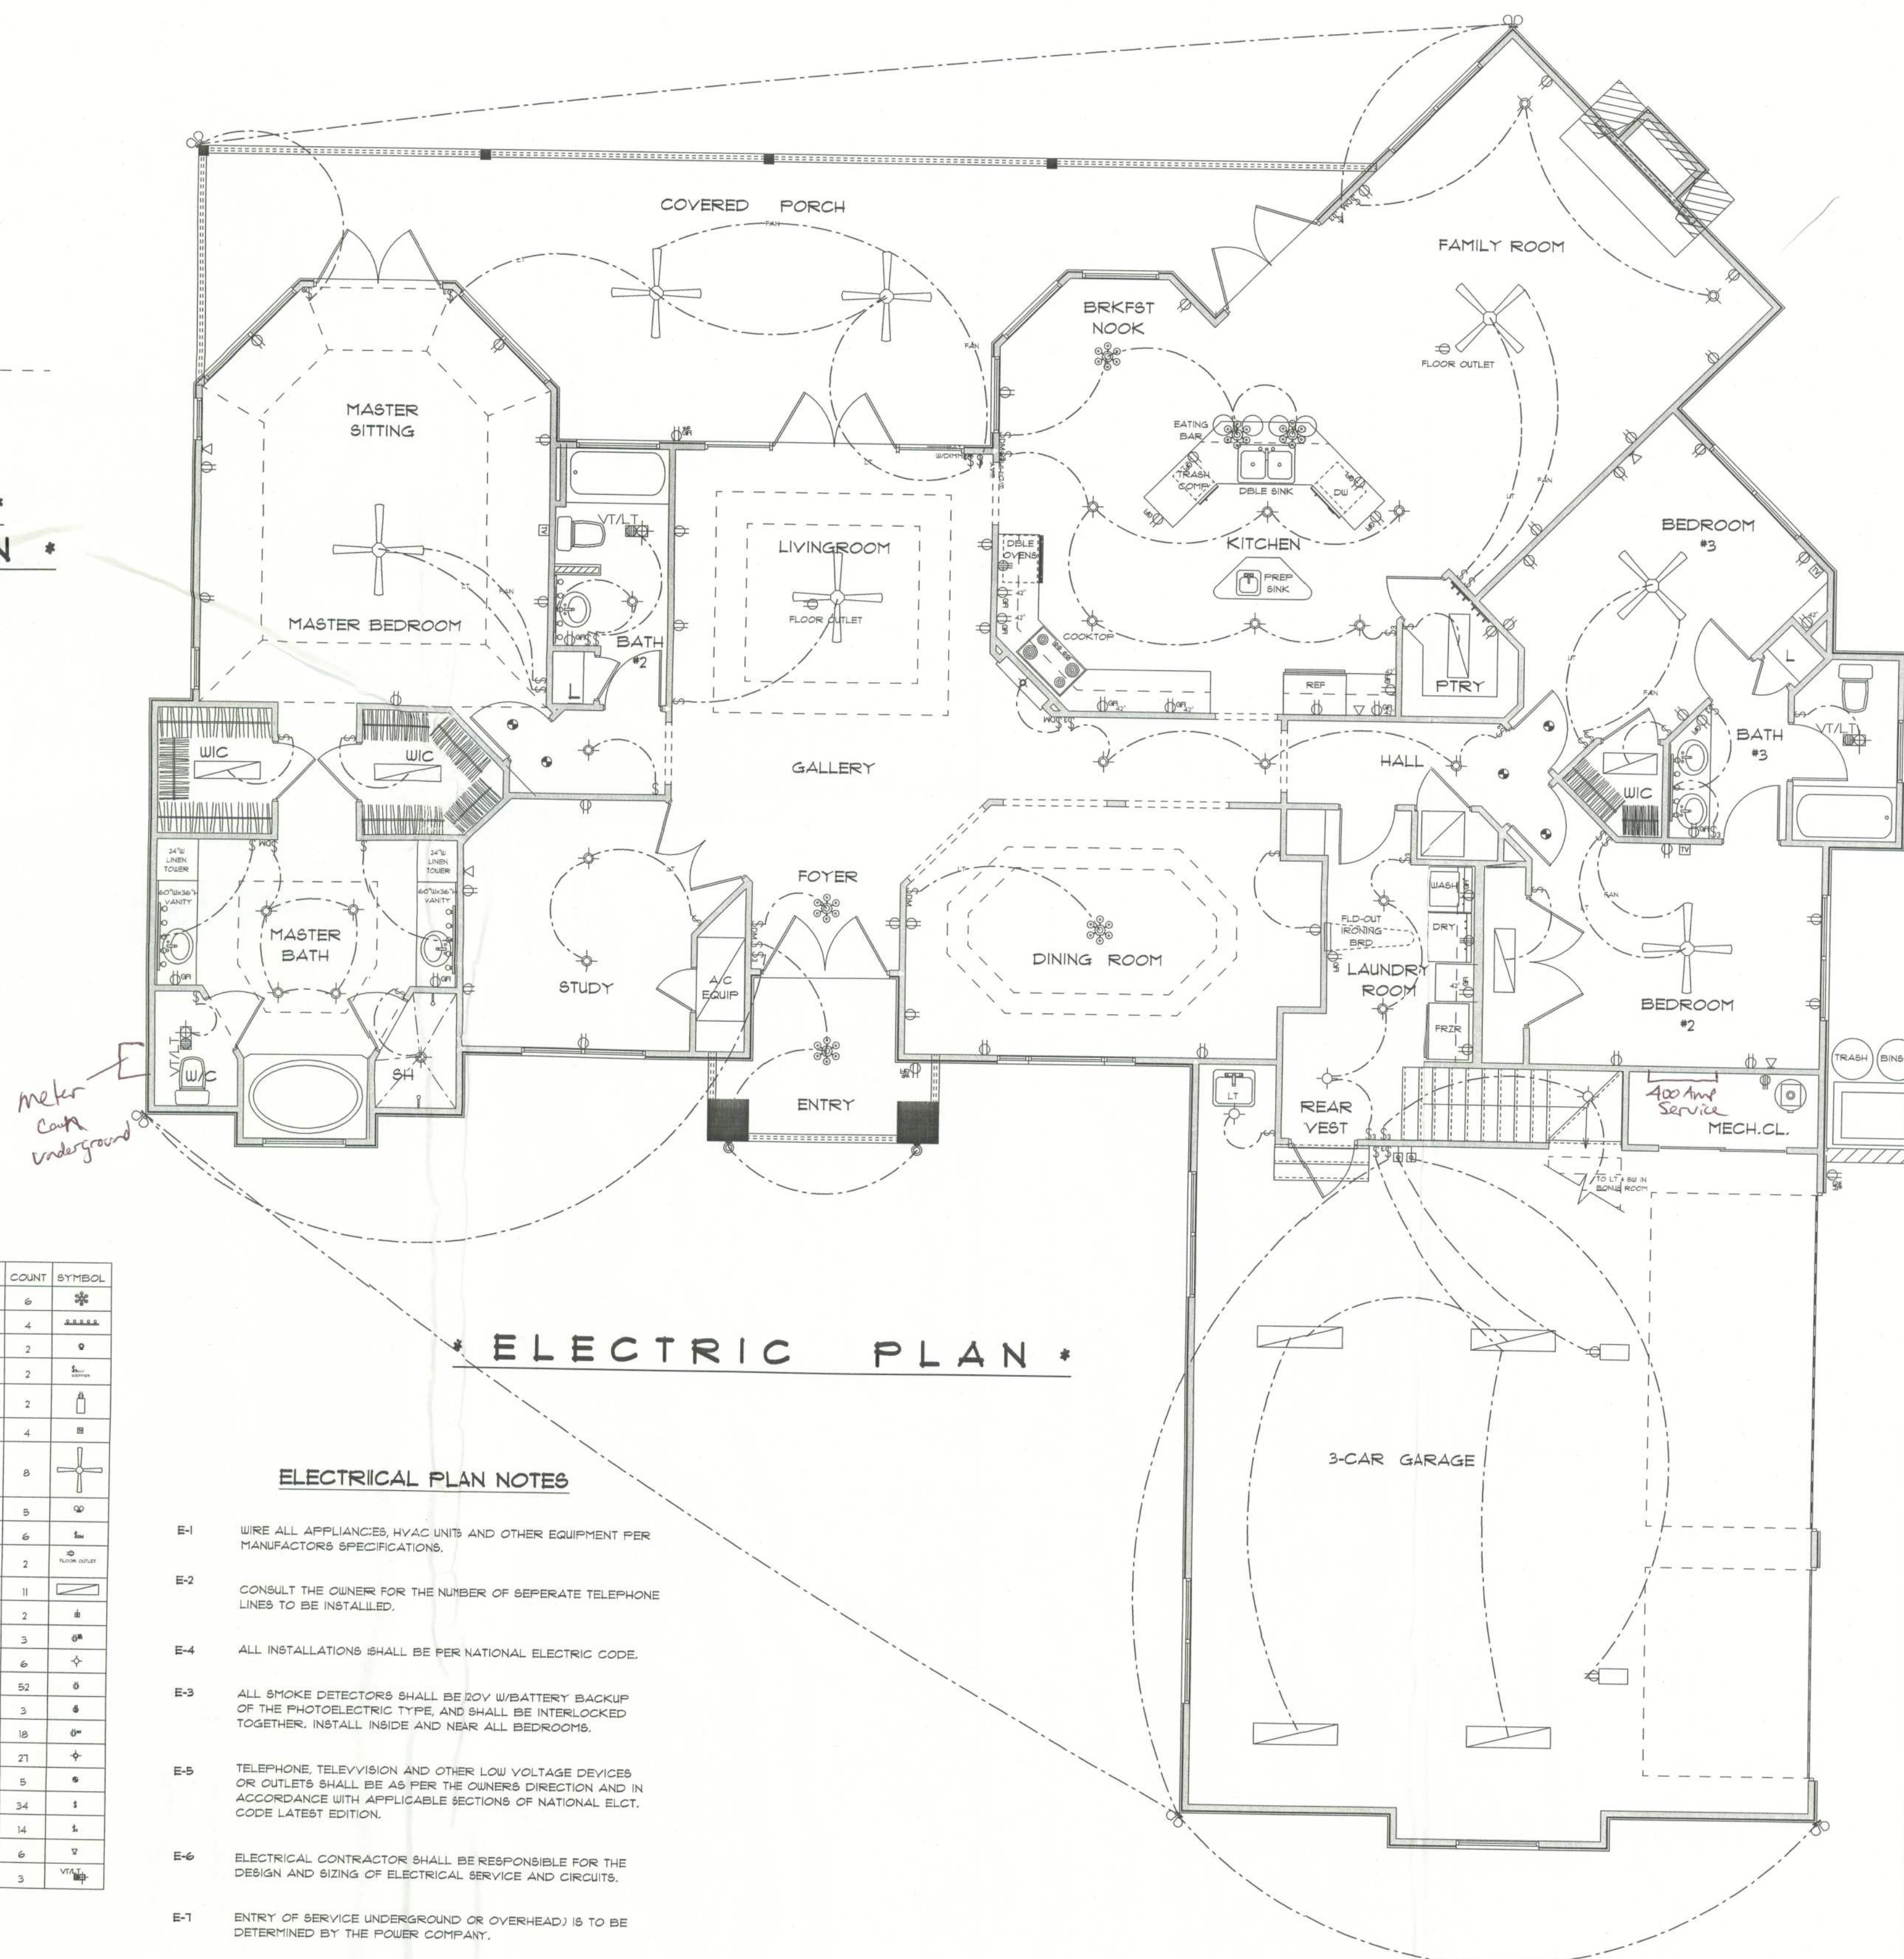


REVISIONS

SOFTPLAN
ARCHITECTURAL DESIGN SOFTWARE

* BONUS ROOM *
* ELECTRIC PLAN *


* ELECTRIC PLAN *

ELECTRICAL	COUNT	SYMBOL
chandelier	6	☼
vanity bar light	4	AAAAA
wall mount l	2	○
3 way switch with dimmer	2	⋈
automatic garage dr opener	2	⬆
cable tv outlets	4	Ⓜ
ceiling fan	8	✚
drab flood lights	5	☼
dimmer switch	6	⋈
floor outlet	2	Ⓜ
fluorescent lt fixture	11	Ⓜ
garage dr opener	2	⬆
gfi waterproof outlets	3	Ⓜ
light	6	✚
outlet	52	○
outlet 220v	3	Ⓜ
outlet gfi	18	Ⓜ
recessed can light	21	✚
smoke detector	5	Ⓜ
switch	34	⋈
switch 3 way	14	⋈
telephone	6	Ⓜ
vent light combo	3	Ⓜ

ELECTRICAL PLAN NOTES

- E-1 WIRE ALL APPLIANCES, HVAC UNITS AND OTHER EQUIPMENT PER MANUFACTURER'S SPECIFICATIONS.
- E-2 CONSULT THE OWNER FOR THE NUMBER OF SEPERATE TELEPHONE LINES TO BE INSTALLED.
- E-4 ALL INSTALLATIONS SHALL BE PER NATIONAL ELECTRIC CODE.
- E-3 ALL SMOKE DETECTORS SHALL BE 20V W/BATTERY BACKUP OF THE PHOTOELECTRIC TYPE, AND SHALL BE INTERLOCKED TOGETHER. INSTALL INSIDE AND NEAR ALL BEDROOMS.
- E-5 TELEPHONE, TELEVISION AND OTHER LOW VOLTAGE DEVICES OR OUTLETS SHALL BE AS PER THE OWNERS DIRECTION AND IN ACCORDANCE WITH APPLICABLE SECTIONS OF NATIONAL ELCT. CODE LATEST EDITION.
- E-6 ELECTRICAL CONTRACTOR SHALL BE RESPONSIBLE FOR THE DESIGN AND SIZING OF ELECTRICAL SERVICE AND CIRCUITS.
- E-7 ENTRY OF SERVICE UNDERGROUND OR OVERHEAD IS TO BE DETERMINED BY THE POWER COMPANY.
- E-8 ALL BEDROOM RECEPTALS ARE TO BE AFCI (ARC FAULT CIRCUIT INTERRUPT).

LOT 15
5.03 ACRES

318.1'

20'-0"

317'-8"

REAR SETBACK

PP

130'-8"

SIDE SETBACK FROM PROPERTY LINE

562.12'

POWER LINES

50'-0"

5' WIDE SIDEWALK

150'-0"

FRONT SETBACK

30'-0"

334.96'

70'-0"

CL

SW HILL CREEK DRIVE

* SITE PLAN *

SCALE : 1" = 50'

RESIDENCE
for
JOHN & ELAINE
DUNN

Teresa M. Ruffo
251 NW Hall of Fame Dr.
Lake City, Florida 32025
Phone: (386) 755 - 9993
Cell: (386) 867 - 1191
Email: essjstreet@att.net

PRINTED DATE:
August 12, 2005

DRAWN BY: Teresa M. Ruffo CHECKED BY:

BUILDING CONTRACTOR:
BRYAN ZECHER CONSTRUCTION

FINALS DATE:
AUGUST 2005

JOB NUMBER:

DRAWING NUMBER

A-4

OF 4 SHEETS