



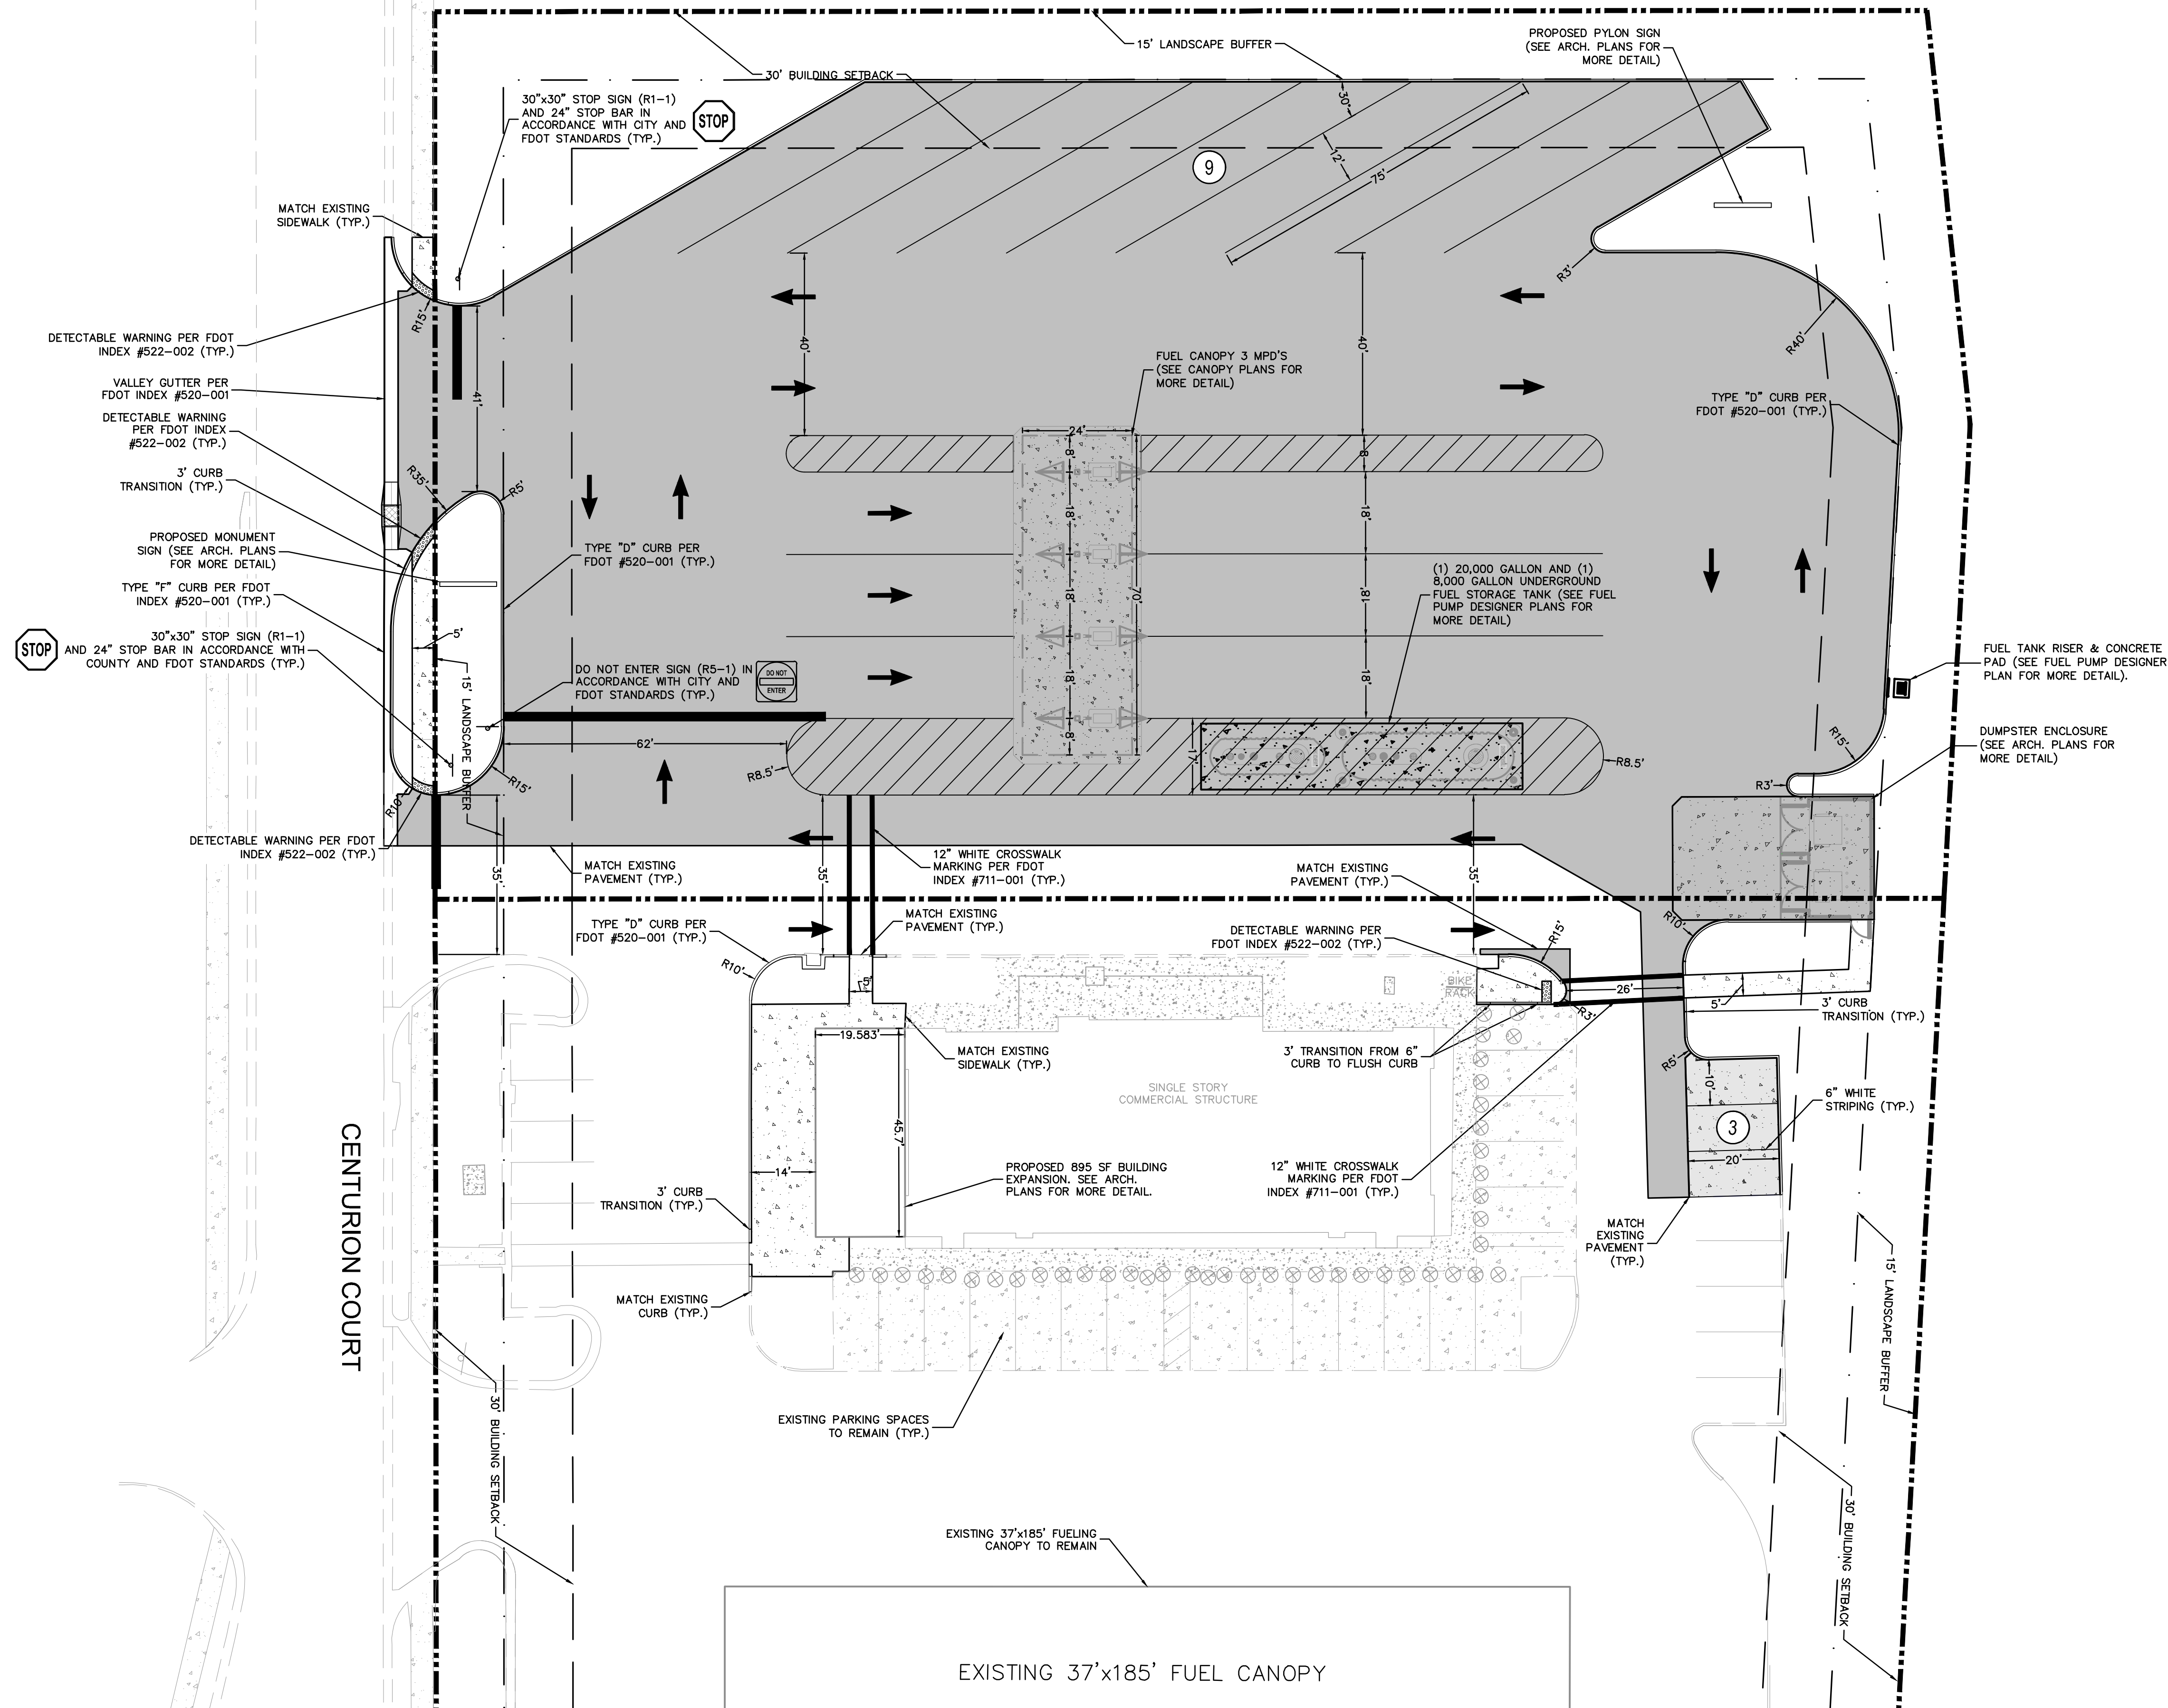

INTERSTATE 75 OFF-RAMP

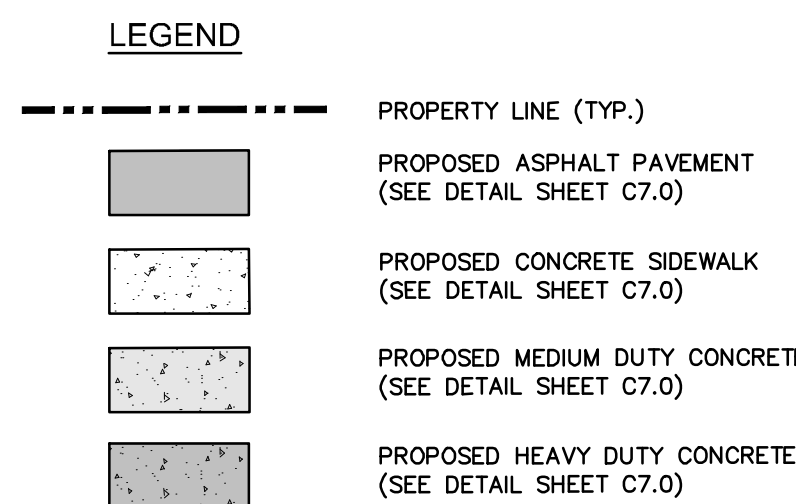


VERTICAL DATUM:
ELEVATIONS ARE REFERENCED TO
PLAT BENCHMARKS AS SHOWN ON
THE FACE OF THE PLAT OF
GATEWAY CROSSING REPLAT OF
LOTS 2 AND 3, PLAT
BOOK 9, PAGE 151

CALL 48 HOURS
BEFORE YOU DIG



IT'S THE LAW!
DIAL 811

SUNSHINE STATE ONE CALL OF FLORIDA, INC.

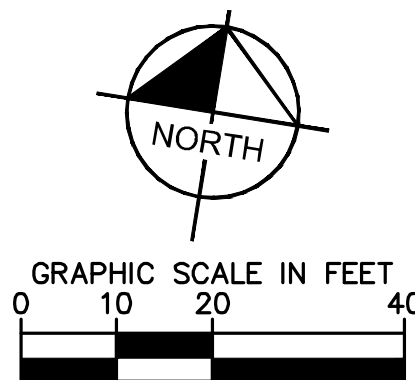


NOTES:

1. ALL CURB DIMENSIONS ARE TO THE FACE OF CURB UNLESS OTHERWISE NOTED.
2. BUILDING DIMENSIONS ARE TO THE OUTSIDE FACE OF BUILDING UNLESS OTHERWISE NOTED.
3. REFER TO ARCHITECTURAL AND STRUCTURAL PLANS TO VERIFY ALL BUILDING DIMENSIONS.
4. REFER TO SIGNAGE PLANS FOR MONUMENT SIGN DETAILS.
5. SEE MEP PLANS FOR ELECTRICAL DRAWINGS.
6. ALL PROPOSED ON-SITE STRIPING AND PAVEMENT MARKING WILL BE PAINTED UNLESS OTHERWISE NOTED AND IN ACCORDANCE WITH FDOT INDEX 711-001.
7. REFER TO ARCHITECTURAL PLANS FOR PROPOSED TRASH CAN LOCATIONS AND DESIGN.
8. BOLLARDS IN SIDEWALK ADJACENT TO BUILDING SHALL BE COVERED WITH RED PLASTIC COVERS TO BE SUPPLIED BY CONTRACTOR.
9. BOLLARDS UNDER CANOPY SHALL BE COVERED WITH GRAY PLASTIC COVERS TO BE SUPPLIED BY CONTRACTOR (SEE FUEL PUMP DESIGNER PLANS FOR MORE DETAIL).
10. REFER TO ARCHITECTURAL PLANS FOR SITE LIGHTING AND ELECTRICAL PLANS.
11. ALL SIGNAGE AND PAVEMENT MARKINGS SHALL MEET MUTCD AND FDOT STANDARDS.
12. ALL SIGNAGE SHALL MEET THE REQUIREMENTS OF CITY OF LAKE CITY LAND DEVELOPMENT CODE, CHAPTER 7, SEC. 760

**CIRCLE K - US HWY
90 & I-75 FUEL
EXPANSION**

SE SITE PLAN

KHA PROJECT	DATE
149880040	05/04/2022
SCALE AS SHOWN	
DESIGNED BY	EJFF
DRAWN BY	EJFF
CHECKED BY	ICS

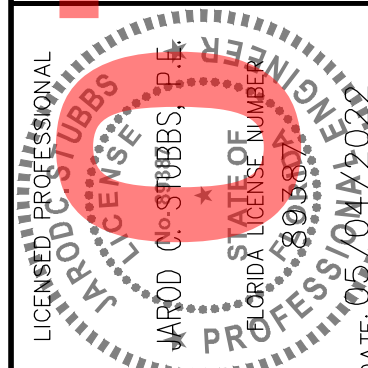

Kimley»Horn
© 2022 KIMLEY-HORN AND ASSOCIATES, INC.
139 S. ORANGE AVENUE, SUITE 1000, ORLANDO, FL 32801
PHONE: 407-898-1511

NO	REVISIONS	DATE	BY
----	-----------	------	----