


- - FLORESCENT LIGHT FIXTURE
- - METER BASE
- - VANITY LIGHT AS SPECIFIED
- ⊕ - LIGHT FIXTURE
- \$ - SINGLE POLE SWITCH
- \$₃ - THREE-WAY ROCKER SWITCH
- ⊕ - RECEPT.
- ⚡ - SECURITY LIGHT
- ⊗ - EXHAUST
- ⊕ - 220 V.
- Ⓢ - SMOKE DETECTOR (AC/DC and interconnected)
- Ⓢ - CARBON MONOXIDE DETECTOR
- Ⓢ - TELEPHONE
- ⚡ - TELEVISION

NOTES:

- 1.) PULL HOMERUNS OF TELEPHONE CABLE AND COAX CABLE TO COMMUNICATION PANEL (NO JUNCTIONS ALLOWED IN ATTIC)
- 2.) ALL EXTERIOR RECEPTACLES SHALL EITHER BE GFI RECPTS OR PART OF A GFI CIRCUIT. ALL EXTERIOR RECEPTACLES SHALL BE WEATHERPROOF.
- 3.) ALL BATHROOM, KITCHEN, AND GARAGE RECEPTS SHALL BE PART OF A GFI CIRCUIT.
- 4.) ALL BEDROOM RECEPTS SHALL BE PART OF AN AFI CIRCUIT.

NOTE:

THE ELECTRICAL PLAN IS INTENDED TO SHOW SCHEMATICALLY THE LAYOUT OF THE ELECTRICAL COMPONENTS. FINAL LOCATIONS AND SIZING OF THE COMPONENTS SHALL BE THE RESPONSIBILITY OF A LICENSED ELECTRICAL CONTRACTOR. ALL WORK SHALL BE PERFORMED IN ACCORDANCE WITH ALL APPLICABLE CODES.

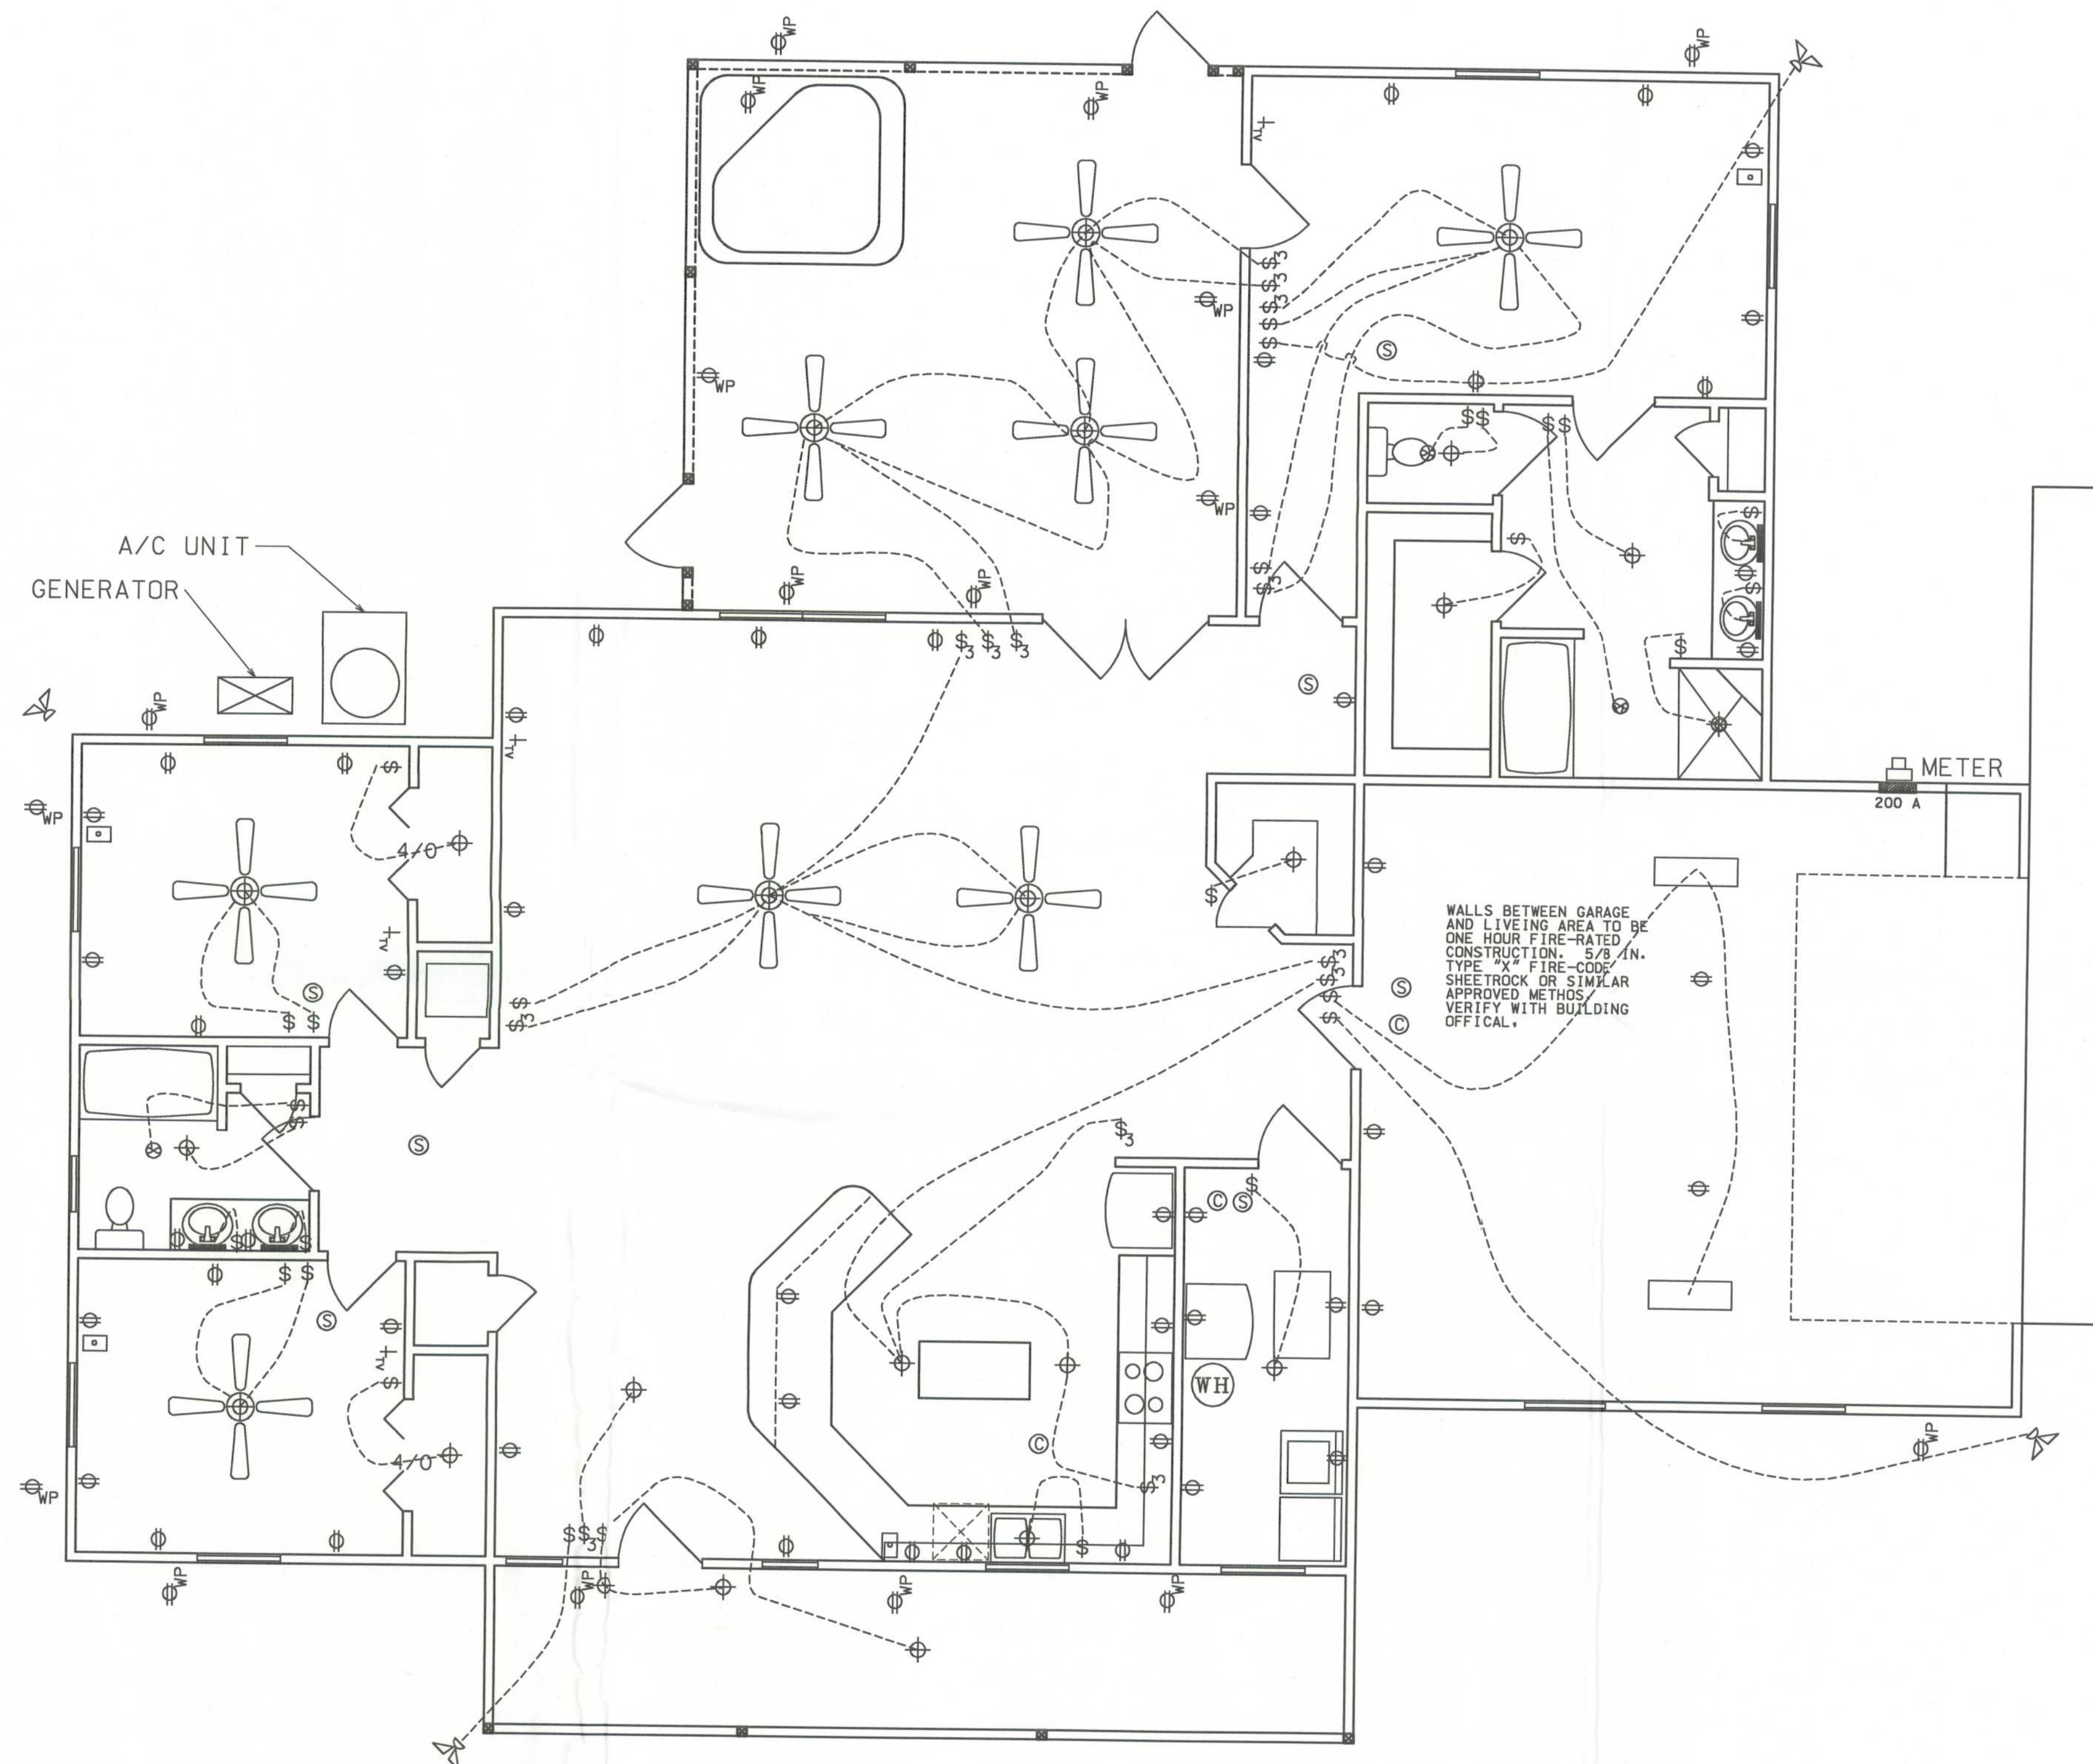

HAYGOOD HOMES INC.

12592 So. U.S. HWY 441
LAKE CITY FL 32025
OFFICE (386) 752-3496
MOBILE (386) 303-1981
CR-C1326715

JERRY AND MARTHA LEVERETT
CLOUMBIA COUNTY FLORIDA

ELECTRICAL PLAN

PLAN No.	SCALE	DATE	SHEET NO.
P 0506	1/4" = 1'	8/10/05	5