

JOB NO.: 0906		
DRAWN: PMM		
CHECKED: PMM		
DATE: 03/10/10		
REVISIONS :		
#	DATE	REMARK

NEW FT. WHITE BRANCH LIBRARY
FT. WHITE, FLORIDA


CLIENT:
COLUMBIA COUNTY
BOARD OF
COUNTY
COMMISSIONERS

PROJ. PHASE:
CONSTRUCTION
DOCUMENTS

SHEET TITLE:
ROOF
FRAMING
PLAN

SCALE:
AS SHOWN

SHEET NO.:
S2.0

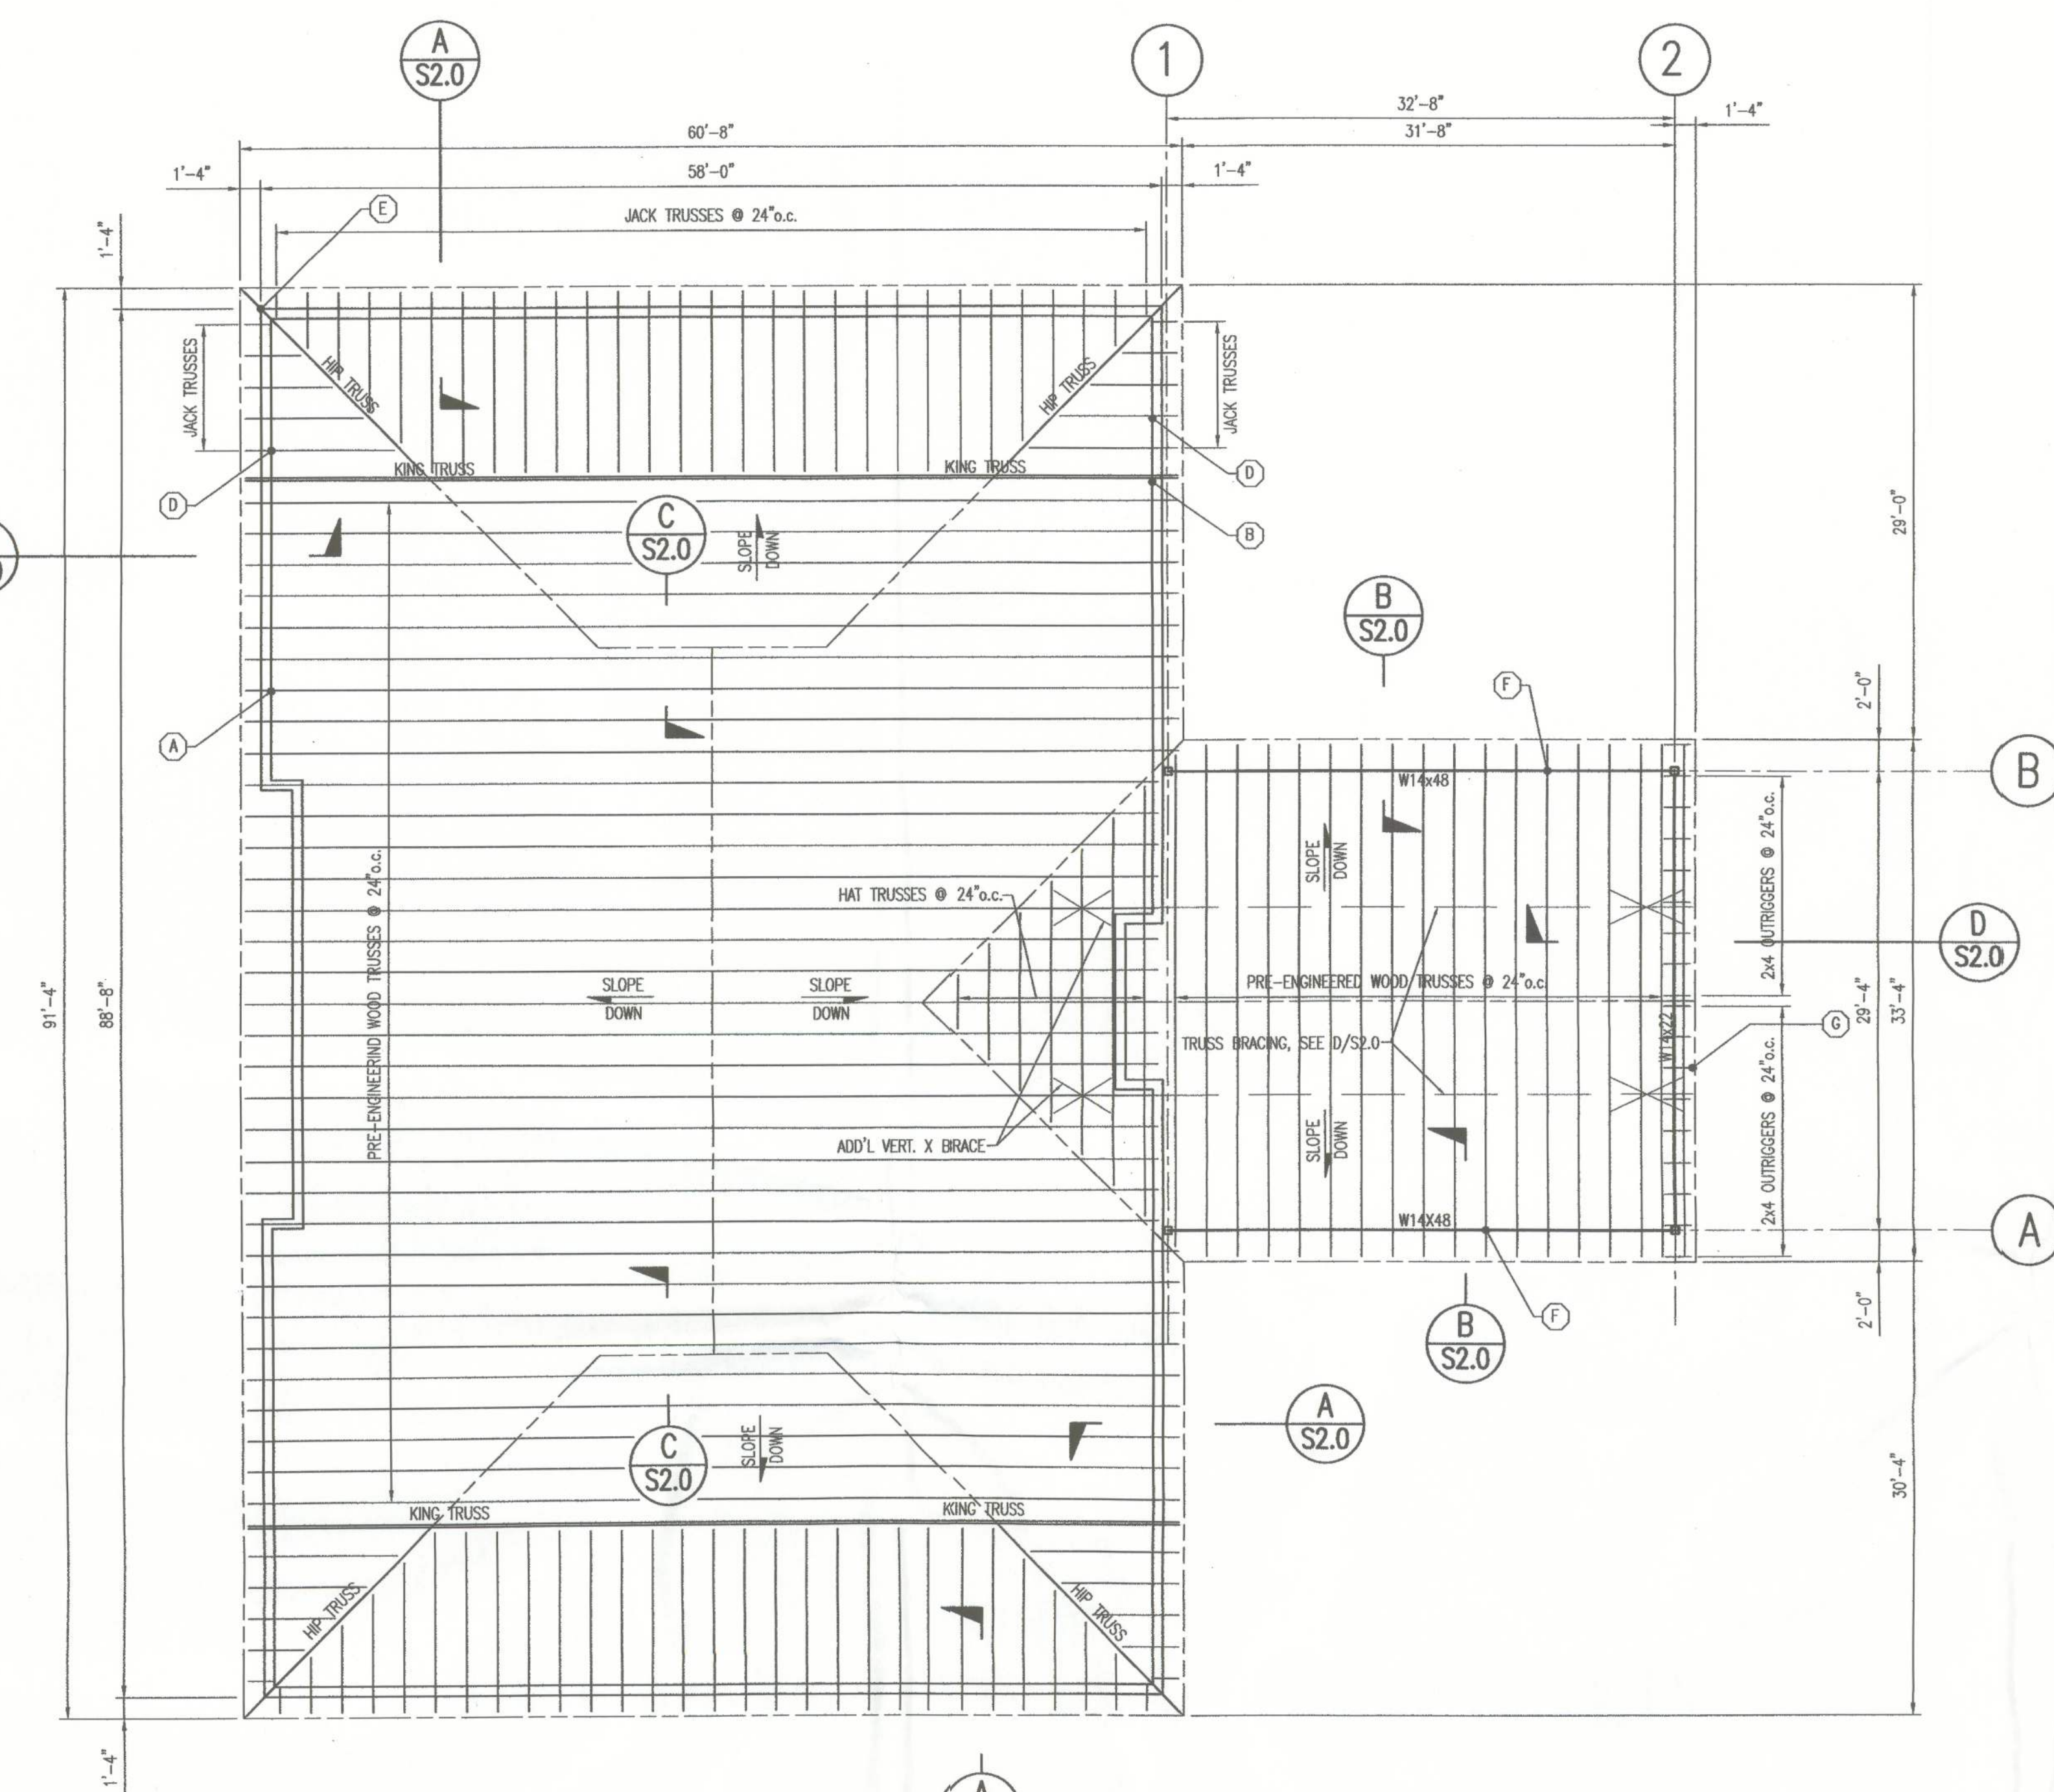


HURRICANE CLIP SCHEDULE		
CONNECTION MARK	TRUSS-TO-PLATE CONNECTOR	REMARKS
(A)	H2.5A*	* PROVIDE H10 CLIPS FOR ALL TRUSSES LOCATED WITHIN 14' FROM NORTH AND SOUTH END OF BUILDING
(B)	HT116 W/ 3/8" ROD*	* PROVIDE 3/8" HEADED BOLT WITH 12" EMBEDMENT INTO THE CMU.
(D)	HCP*	* FOR KING TRUSS SPA "D" GREATER THEN 13' USE (2) HCP. FOR "D" GREATER THEN 19' USE CONN. SIM TO B.
(E)	H2.5A	
(F)	H10	
(G)	H2.5A OR H1	


NOTES:
1. CONNECTORS INDICATED SHALL BE SIMPSON STRONG TIE PRODUCTS OR APPROVED EQUIVALENT.
2. SEE CONNECTION MANUFACTURER'S LITERATURE FOR THE REQUIRED FASTENERS.

ROOF FRAMING PLAN
SCALE: 3/8" = 1'-0"


(X) DENOTES REQ'D TYP. HURRICANE CLIP (H.C.) FOR INDICATED TRUSS CONDITION. ALL ROOF MEMBER BRG. POINTS REQ'D H.C., SEE SCHEDULE THIS SHT.

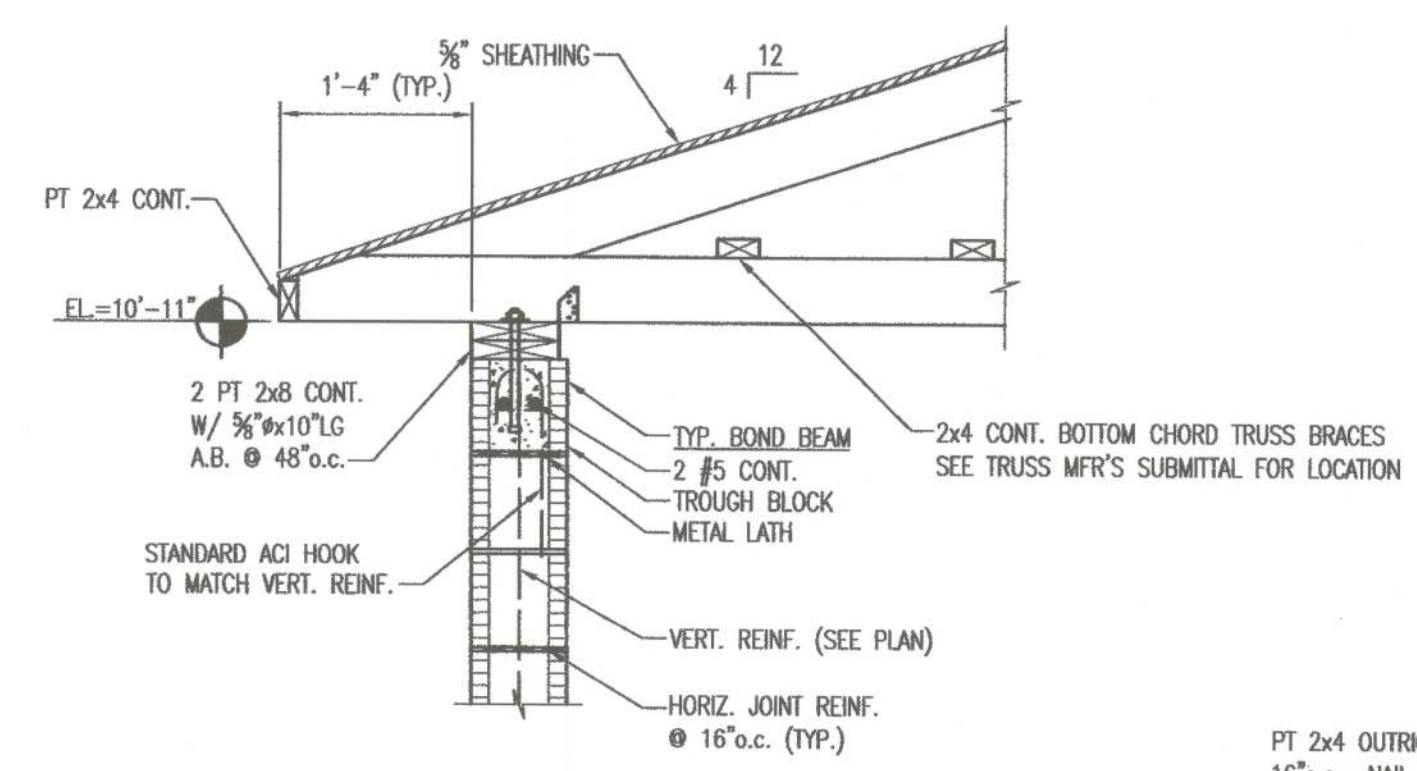


SECTION A
SCALE: 3/8" = 1'-0"

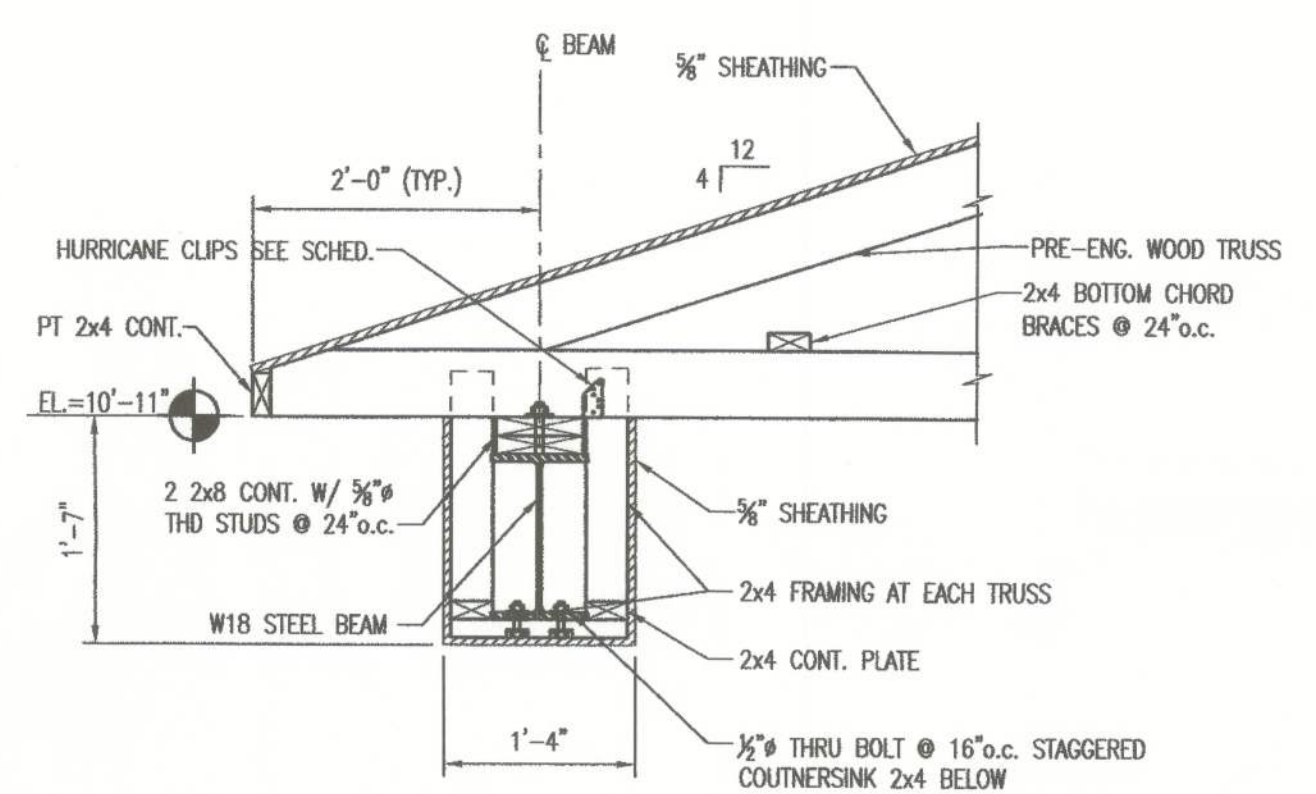


SECTION B
SCALE: 3/8" = 1'-0"

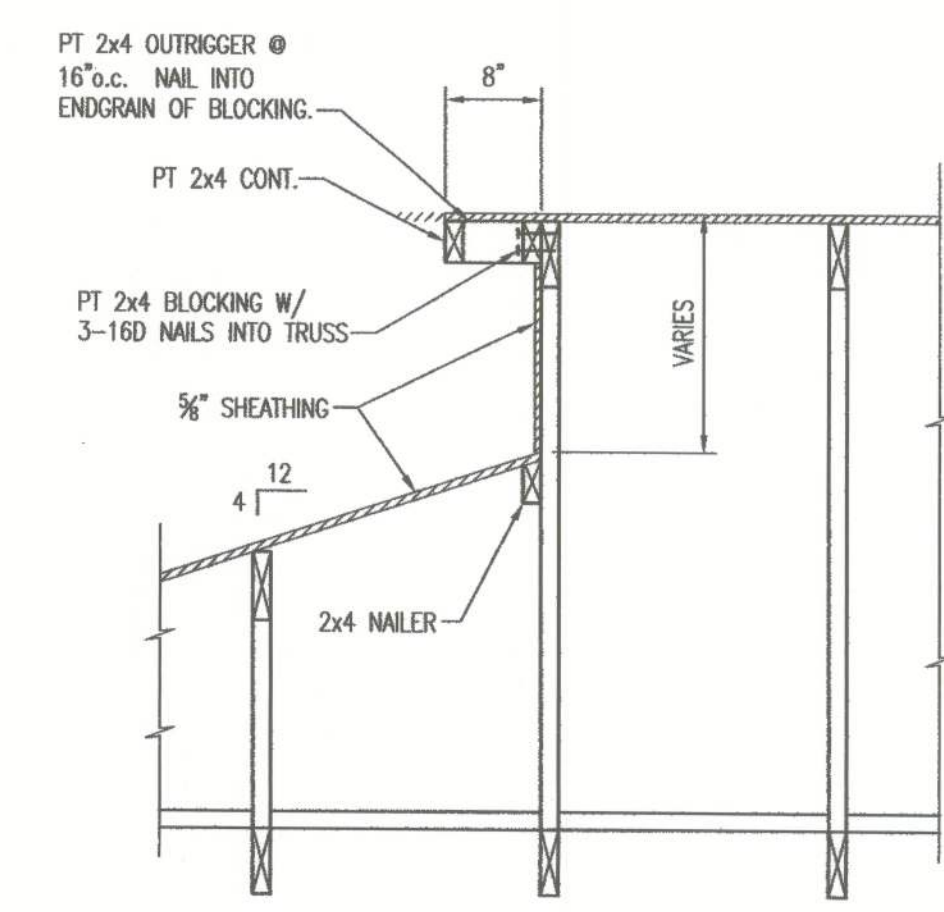

SECTION C
SCALE: 3/8" = 1'-0"

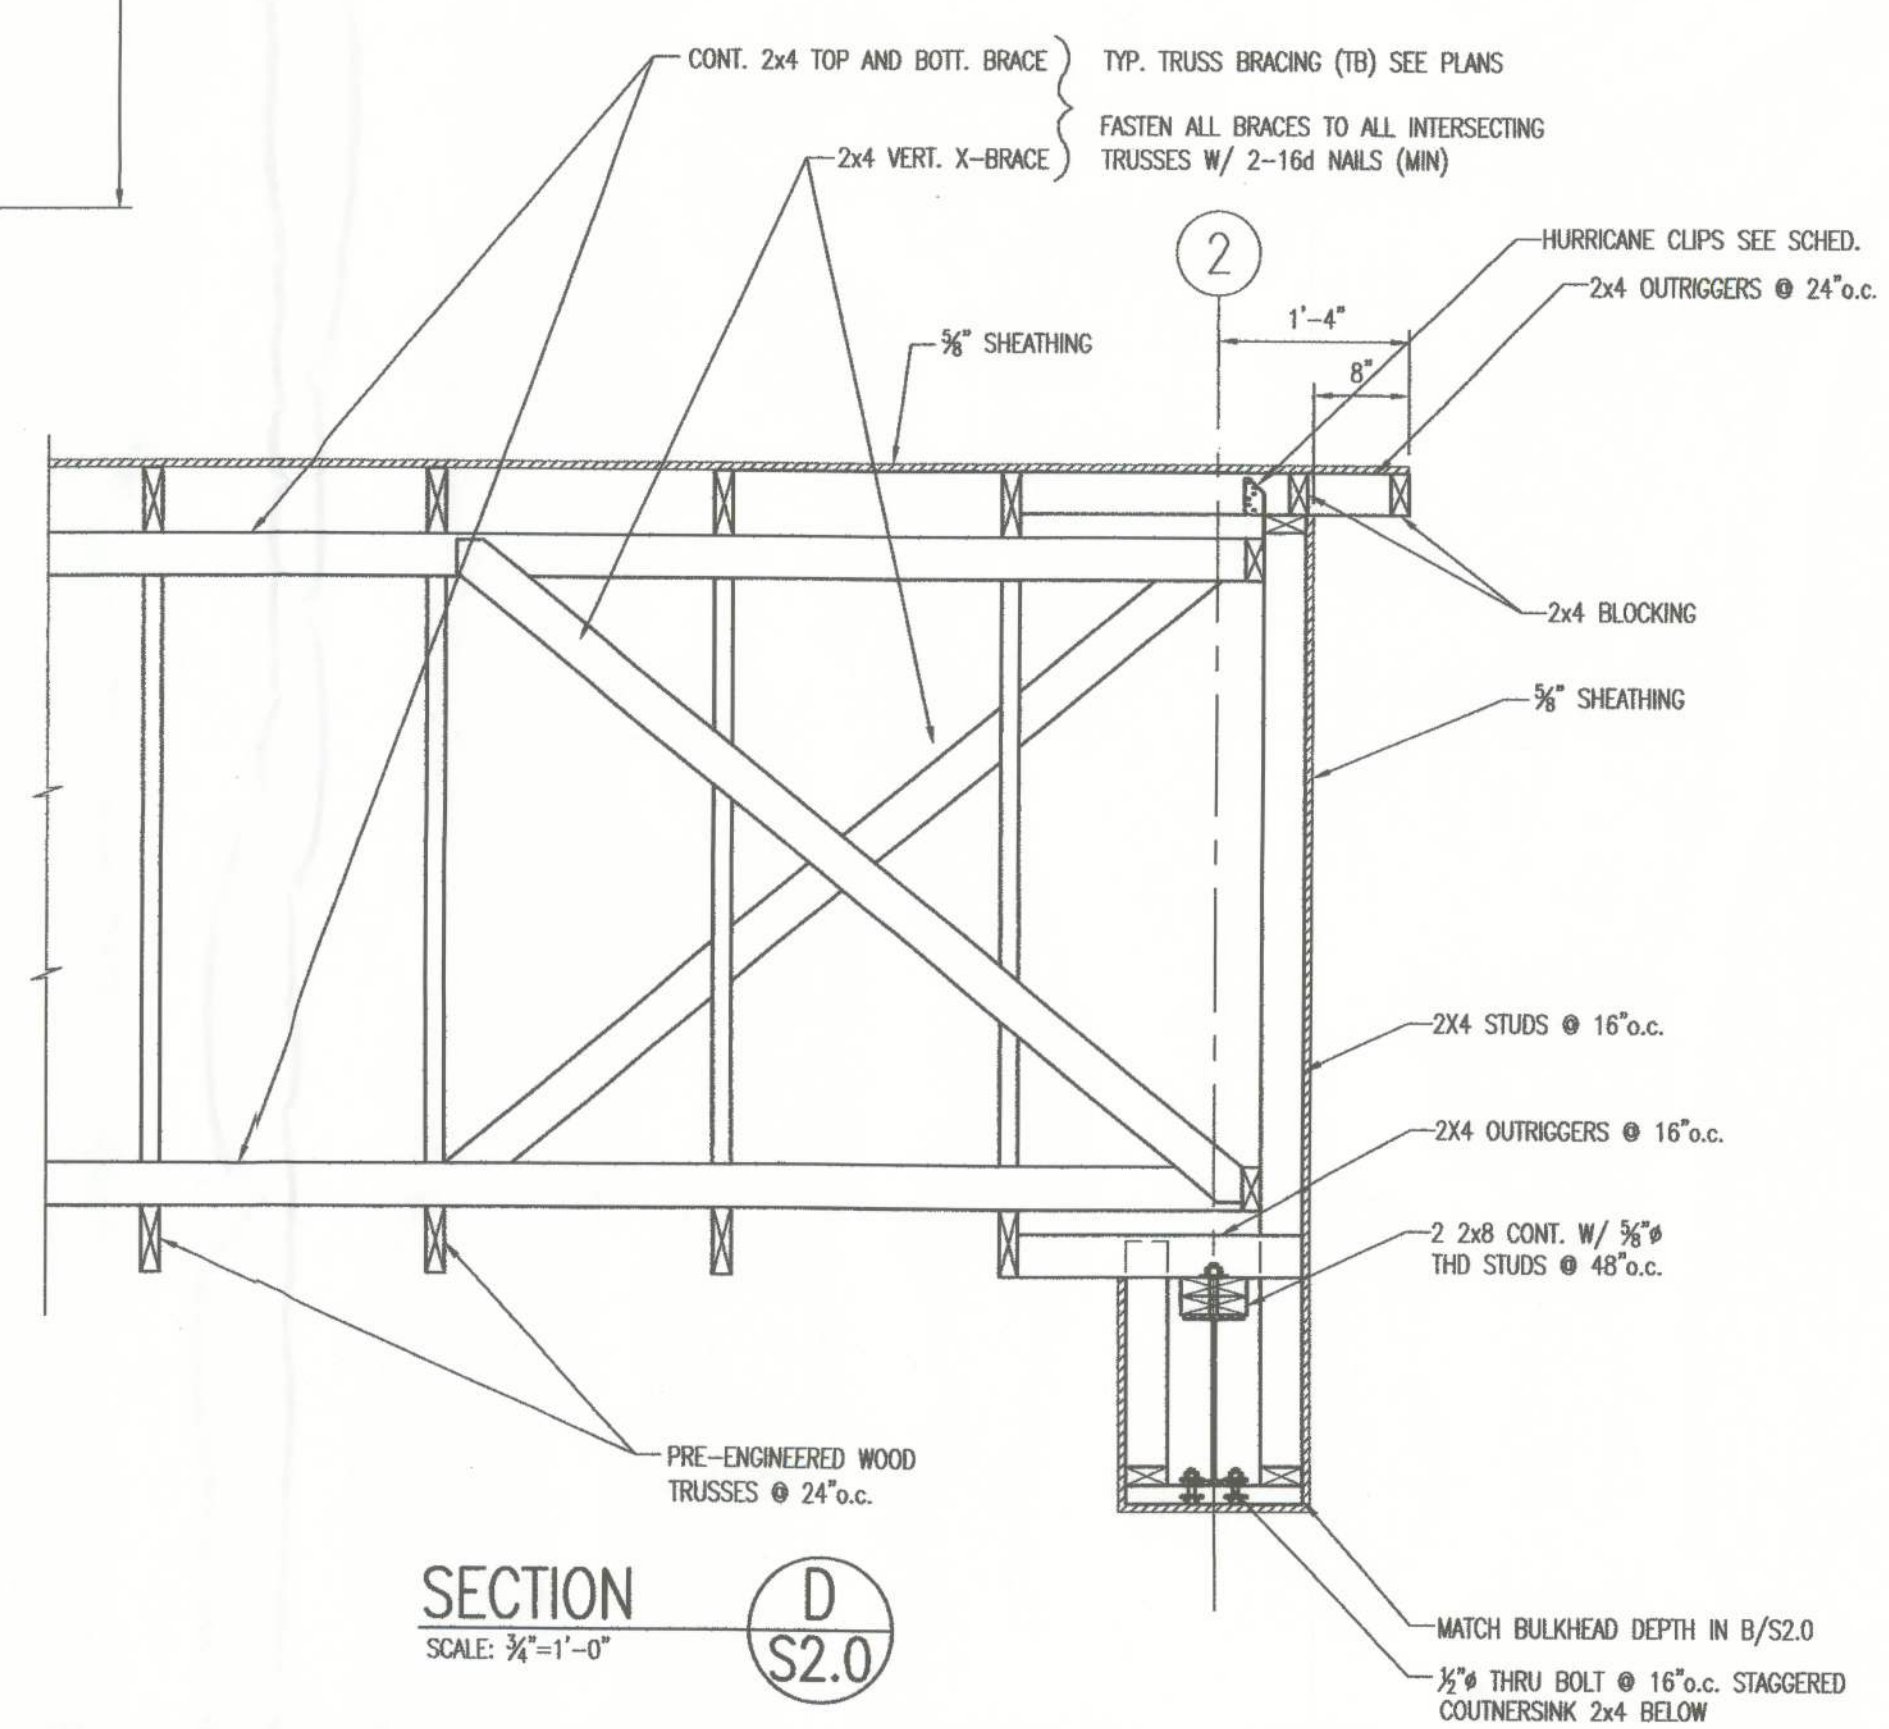

SECTION D
SCALE: 3/8" = 1'-0"

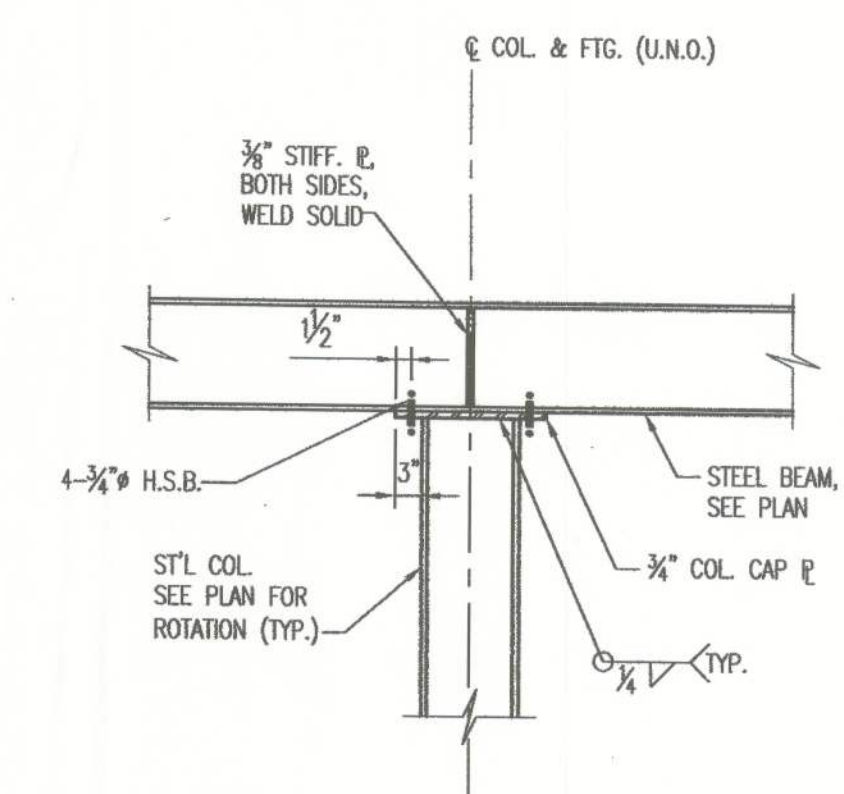

TYPICAL STEEL COLUMN CAP DETAIL
NO SCALE

ROSENBAUM ENGINEERING, INCORPORATED
Structural & Civil Engineering
1705 South Gadsden Street, Suite 100
Tallahassee, Florida 32301
Phone # (850) 671-7230
Fax # (850) 671-7279
Authorization #: 00007815
E.O.R.: Patrick M. McKee
Florida Registration #: 63122

Del
3-10-10