



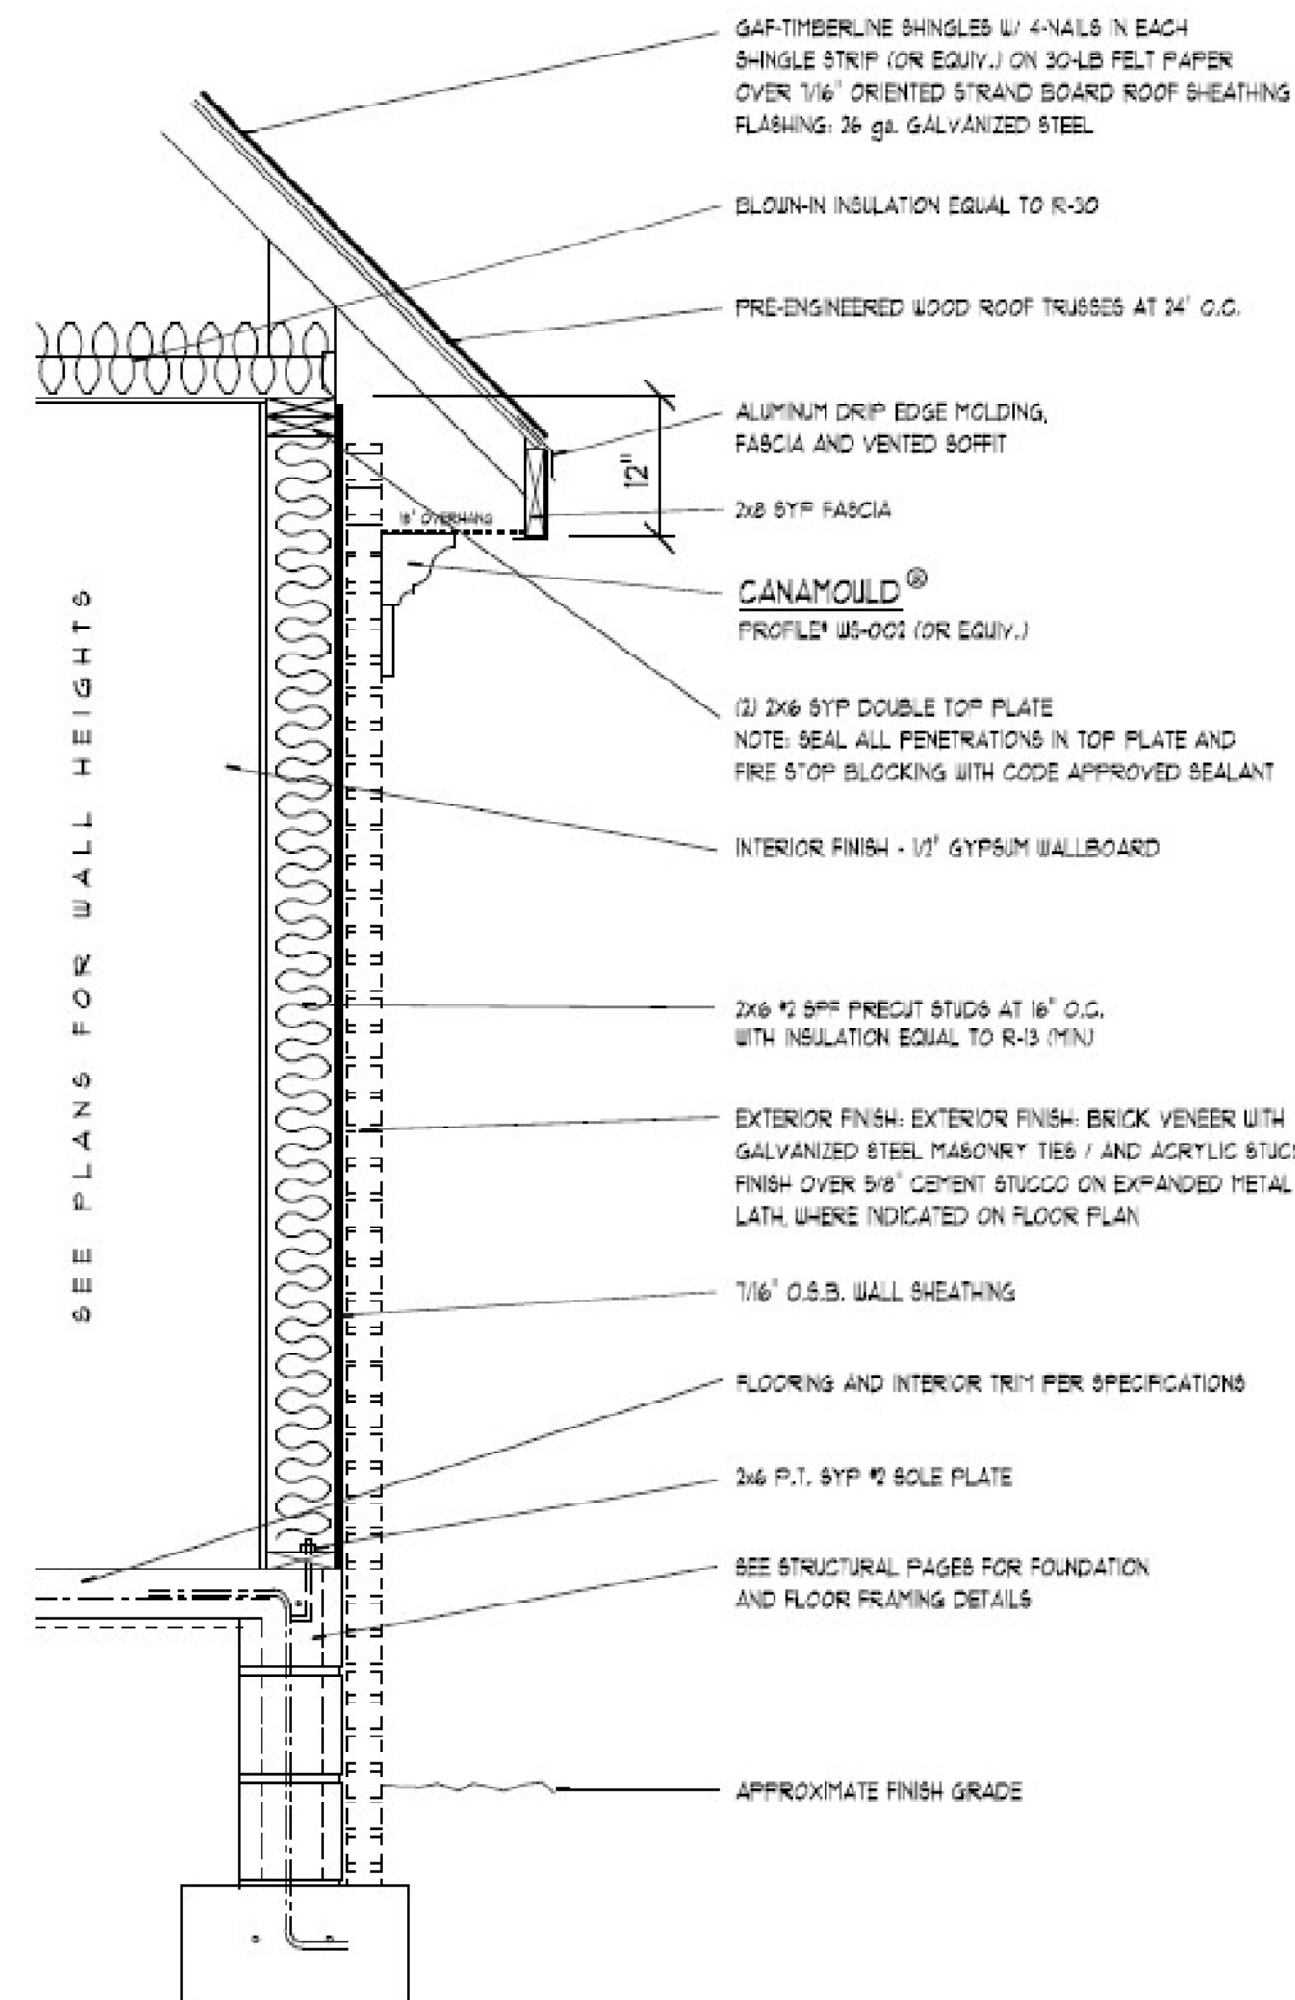

**TYPICAL WALL SECTION**  
SCALE: 1" = 10"  
REFER TO STRUCTURAL PAGE FOR STRUCTURAL SPECIFICATIONS

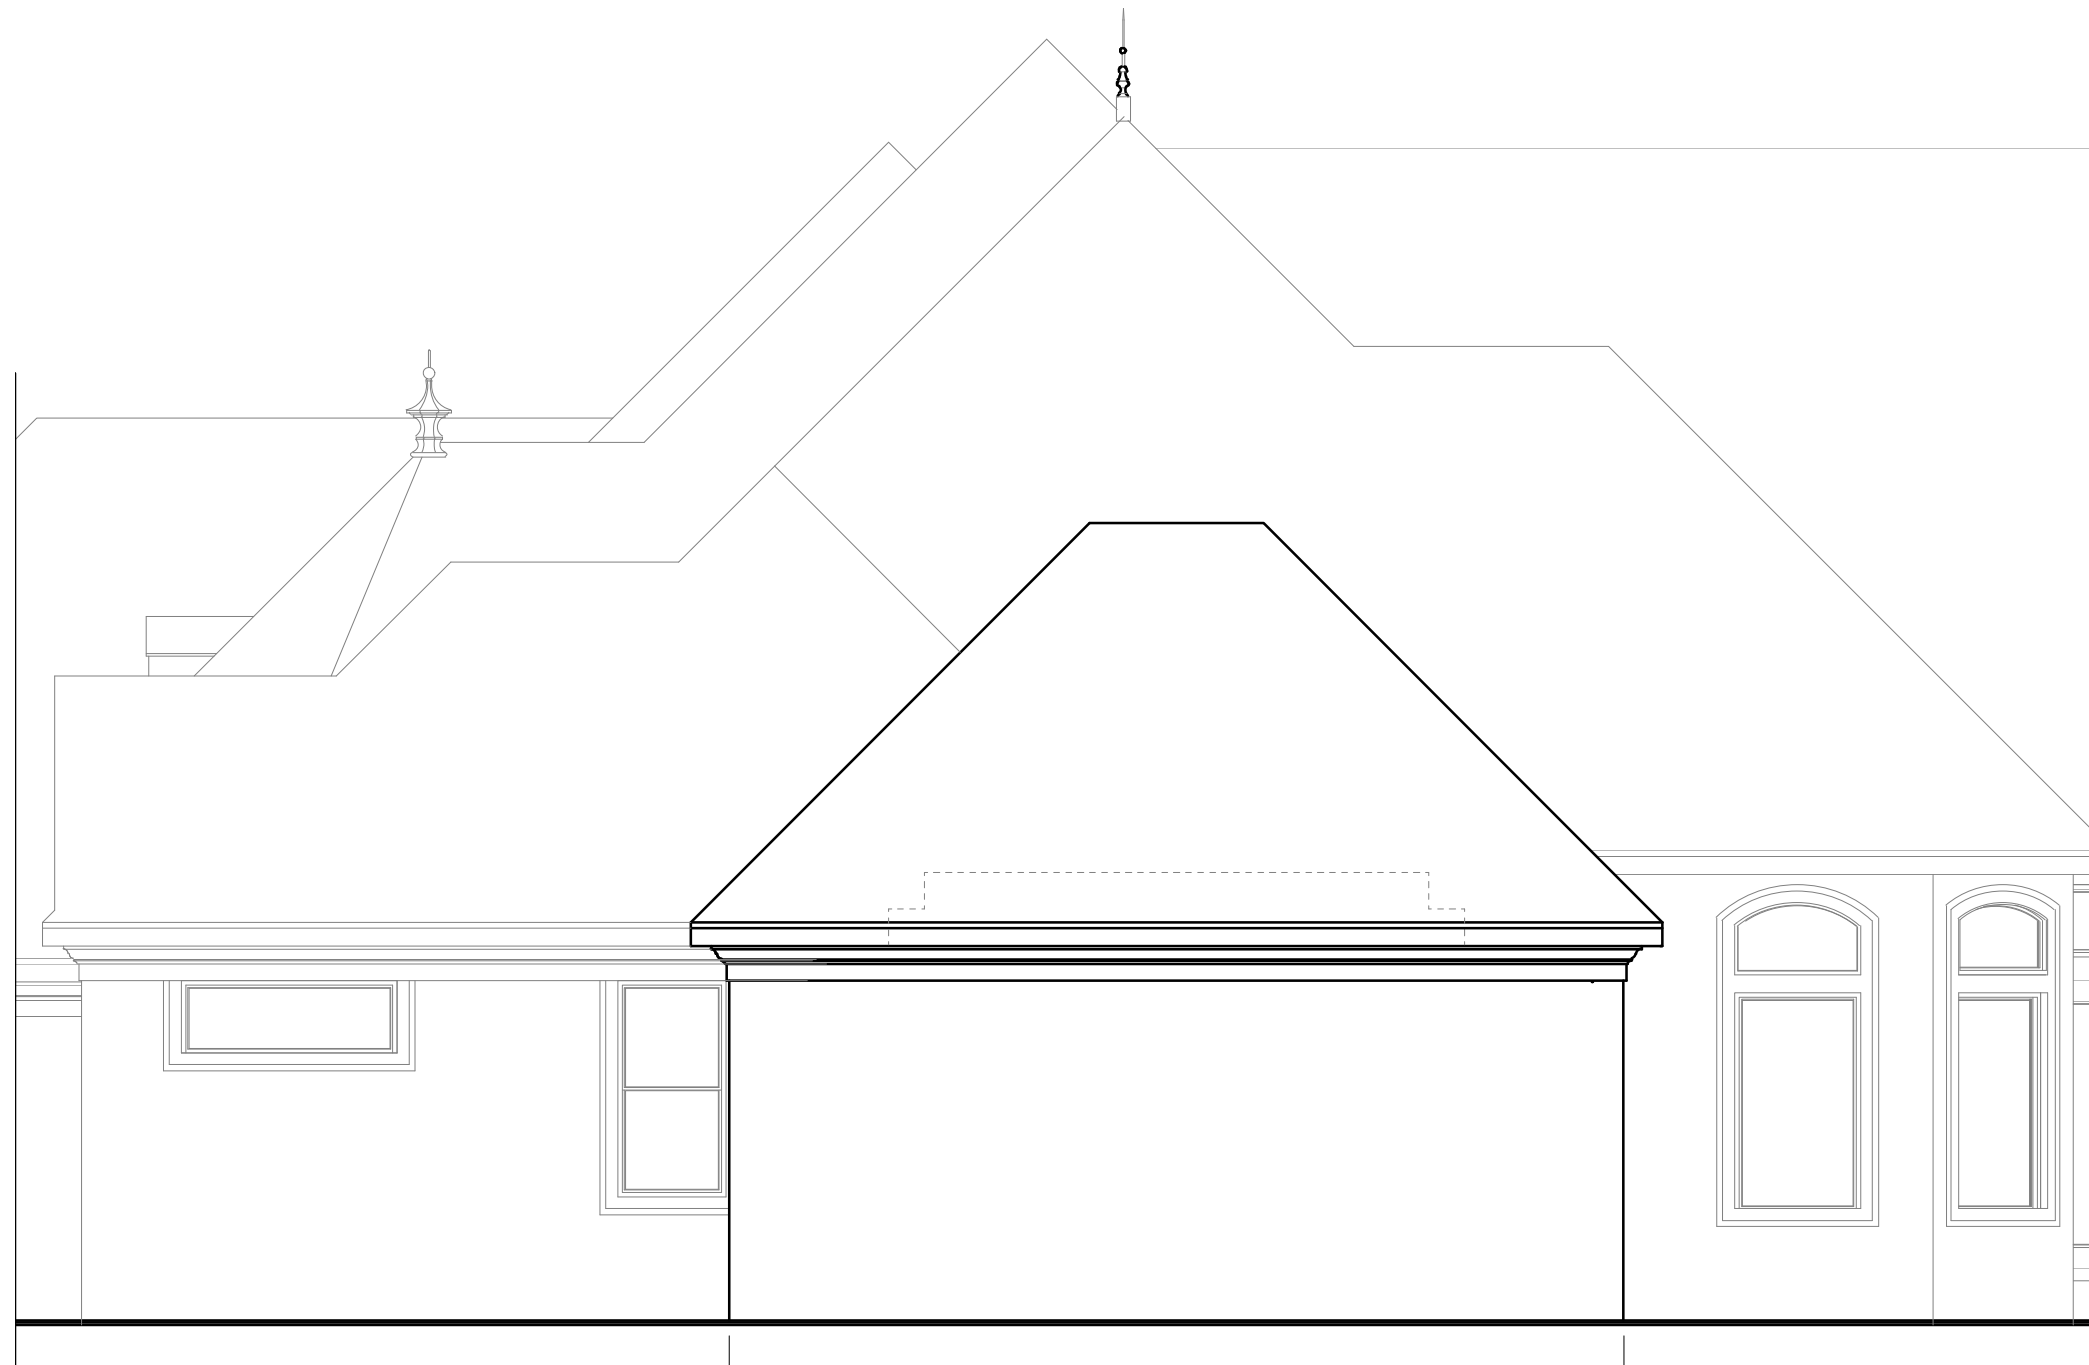


**PARTIAL RIGHT**  
SCALE: 3/16" = 1'-0"

CURRENT HOME NEW ADDITION

NEW ADDITION CURRENT HOME



**PARTIAL FRONT**  
SCALE: 3/16" = 1'-0"

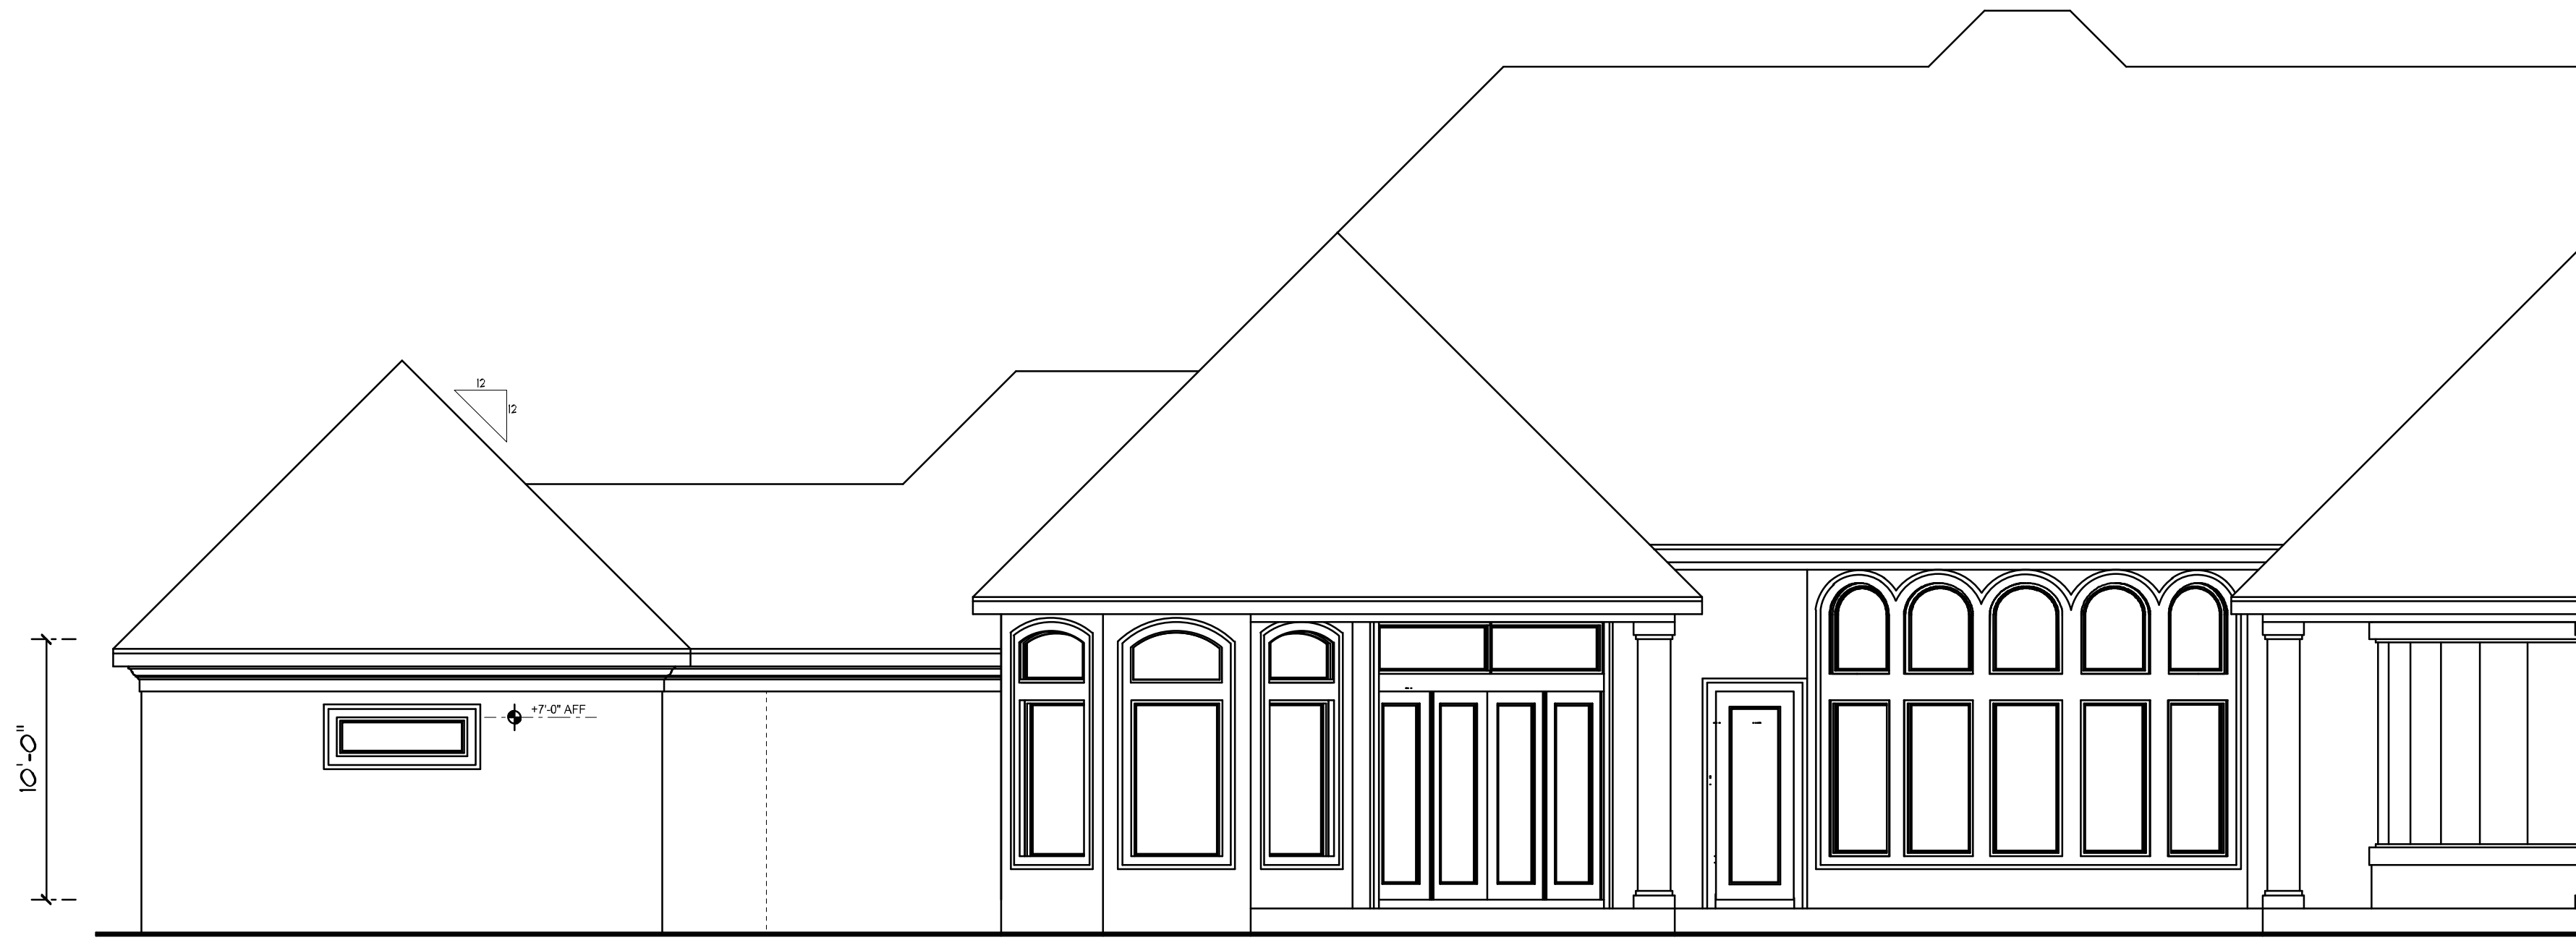

**PARTIAL REAR**  
SCALE: 3/16" = 1'-0"

NEW ADDITION CURRENT HOME



| REVISIONS          |
|--------------------|
| September 11, 2024 |
|                    |
|                    |
|                    |

SOFTPLAN  
ARCHITECTURAL DESIGN SOFTWARE

PROPOSED MASTER CLOSET ADDITION FOR:  
**Miguel & Kelly Tepedino**  
PROJECT ADDRESS: 135 SW STONERIDGE DR. LAKE CITY, FLORIDA 32024

© WM DESIGN & ASSOCIATES, INC.  
426 SW COMMERCE DR. STE 130  
LAKE CITY, FL 32025  
(386) 758-8406  
wm@willmyers.net




JOB NUMBER  
20240327


SHEET NUMBER  
**A.1**

Wm C. Myers


NOTE: ALL DRAWINGS NOT TO BE SCALED, WRITTEN DIMENSIONS TAKE PRECEDENCE OVER SCALED DIMENSIONS

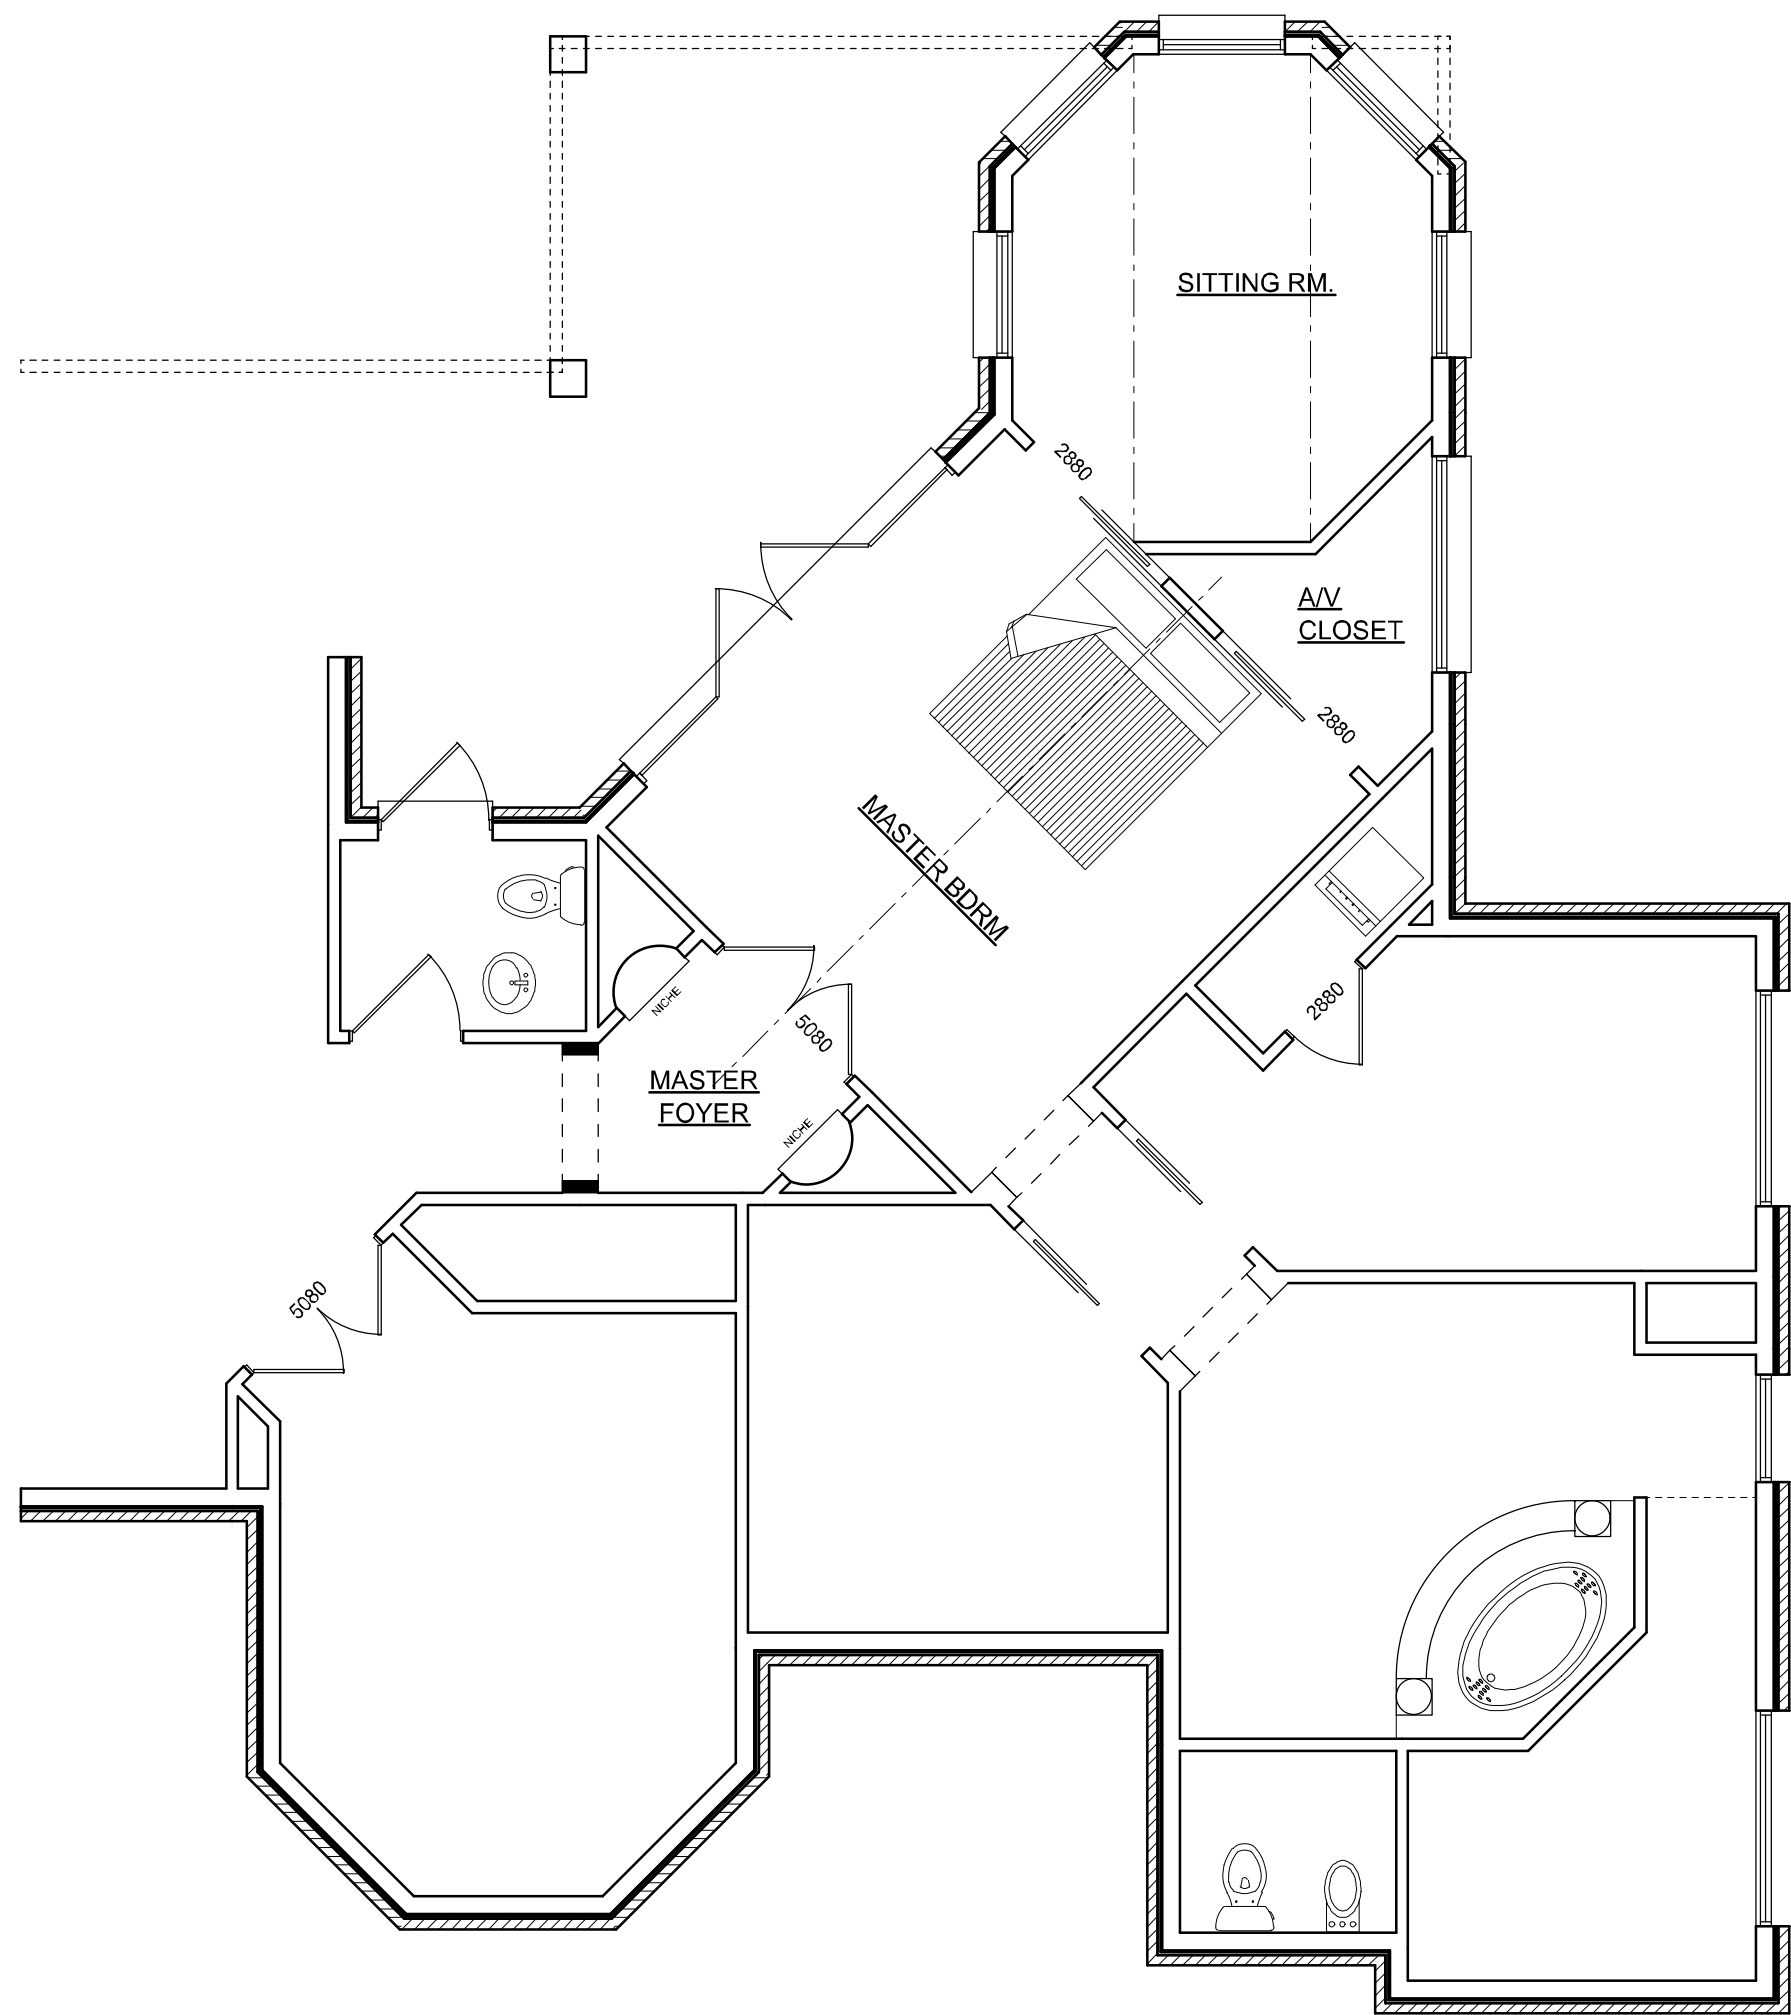

AS-BUILT EAST HALF  
SCALE: 3/16" = 1'-0"

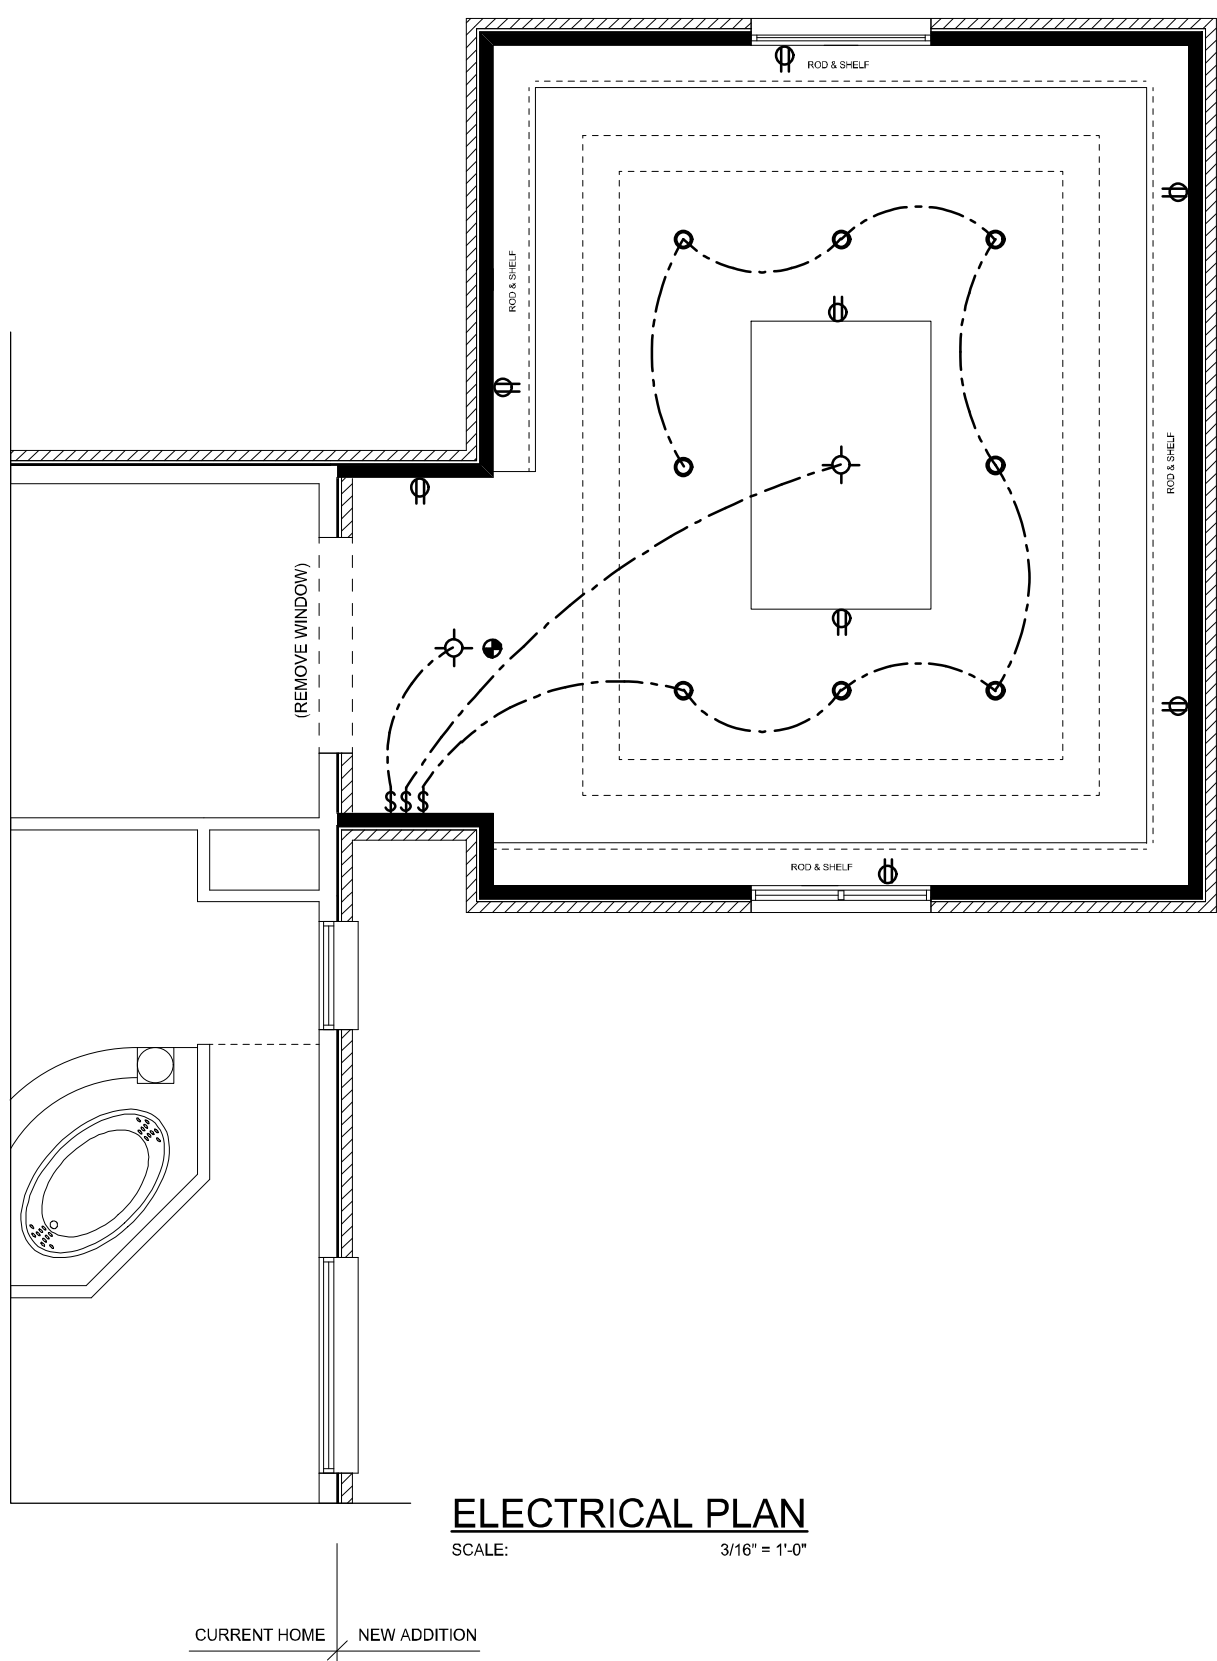

ELECTRICAL PLAN  
SCALE: 3/16" = 1'-0"

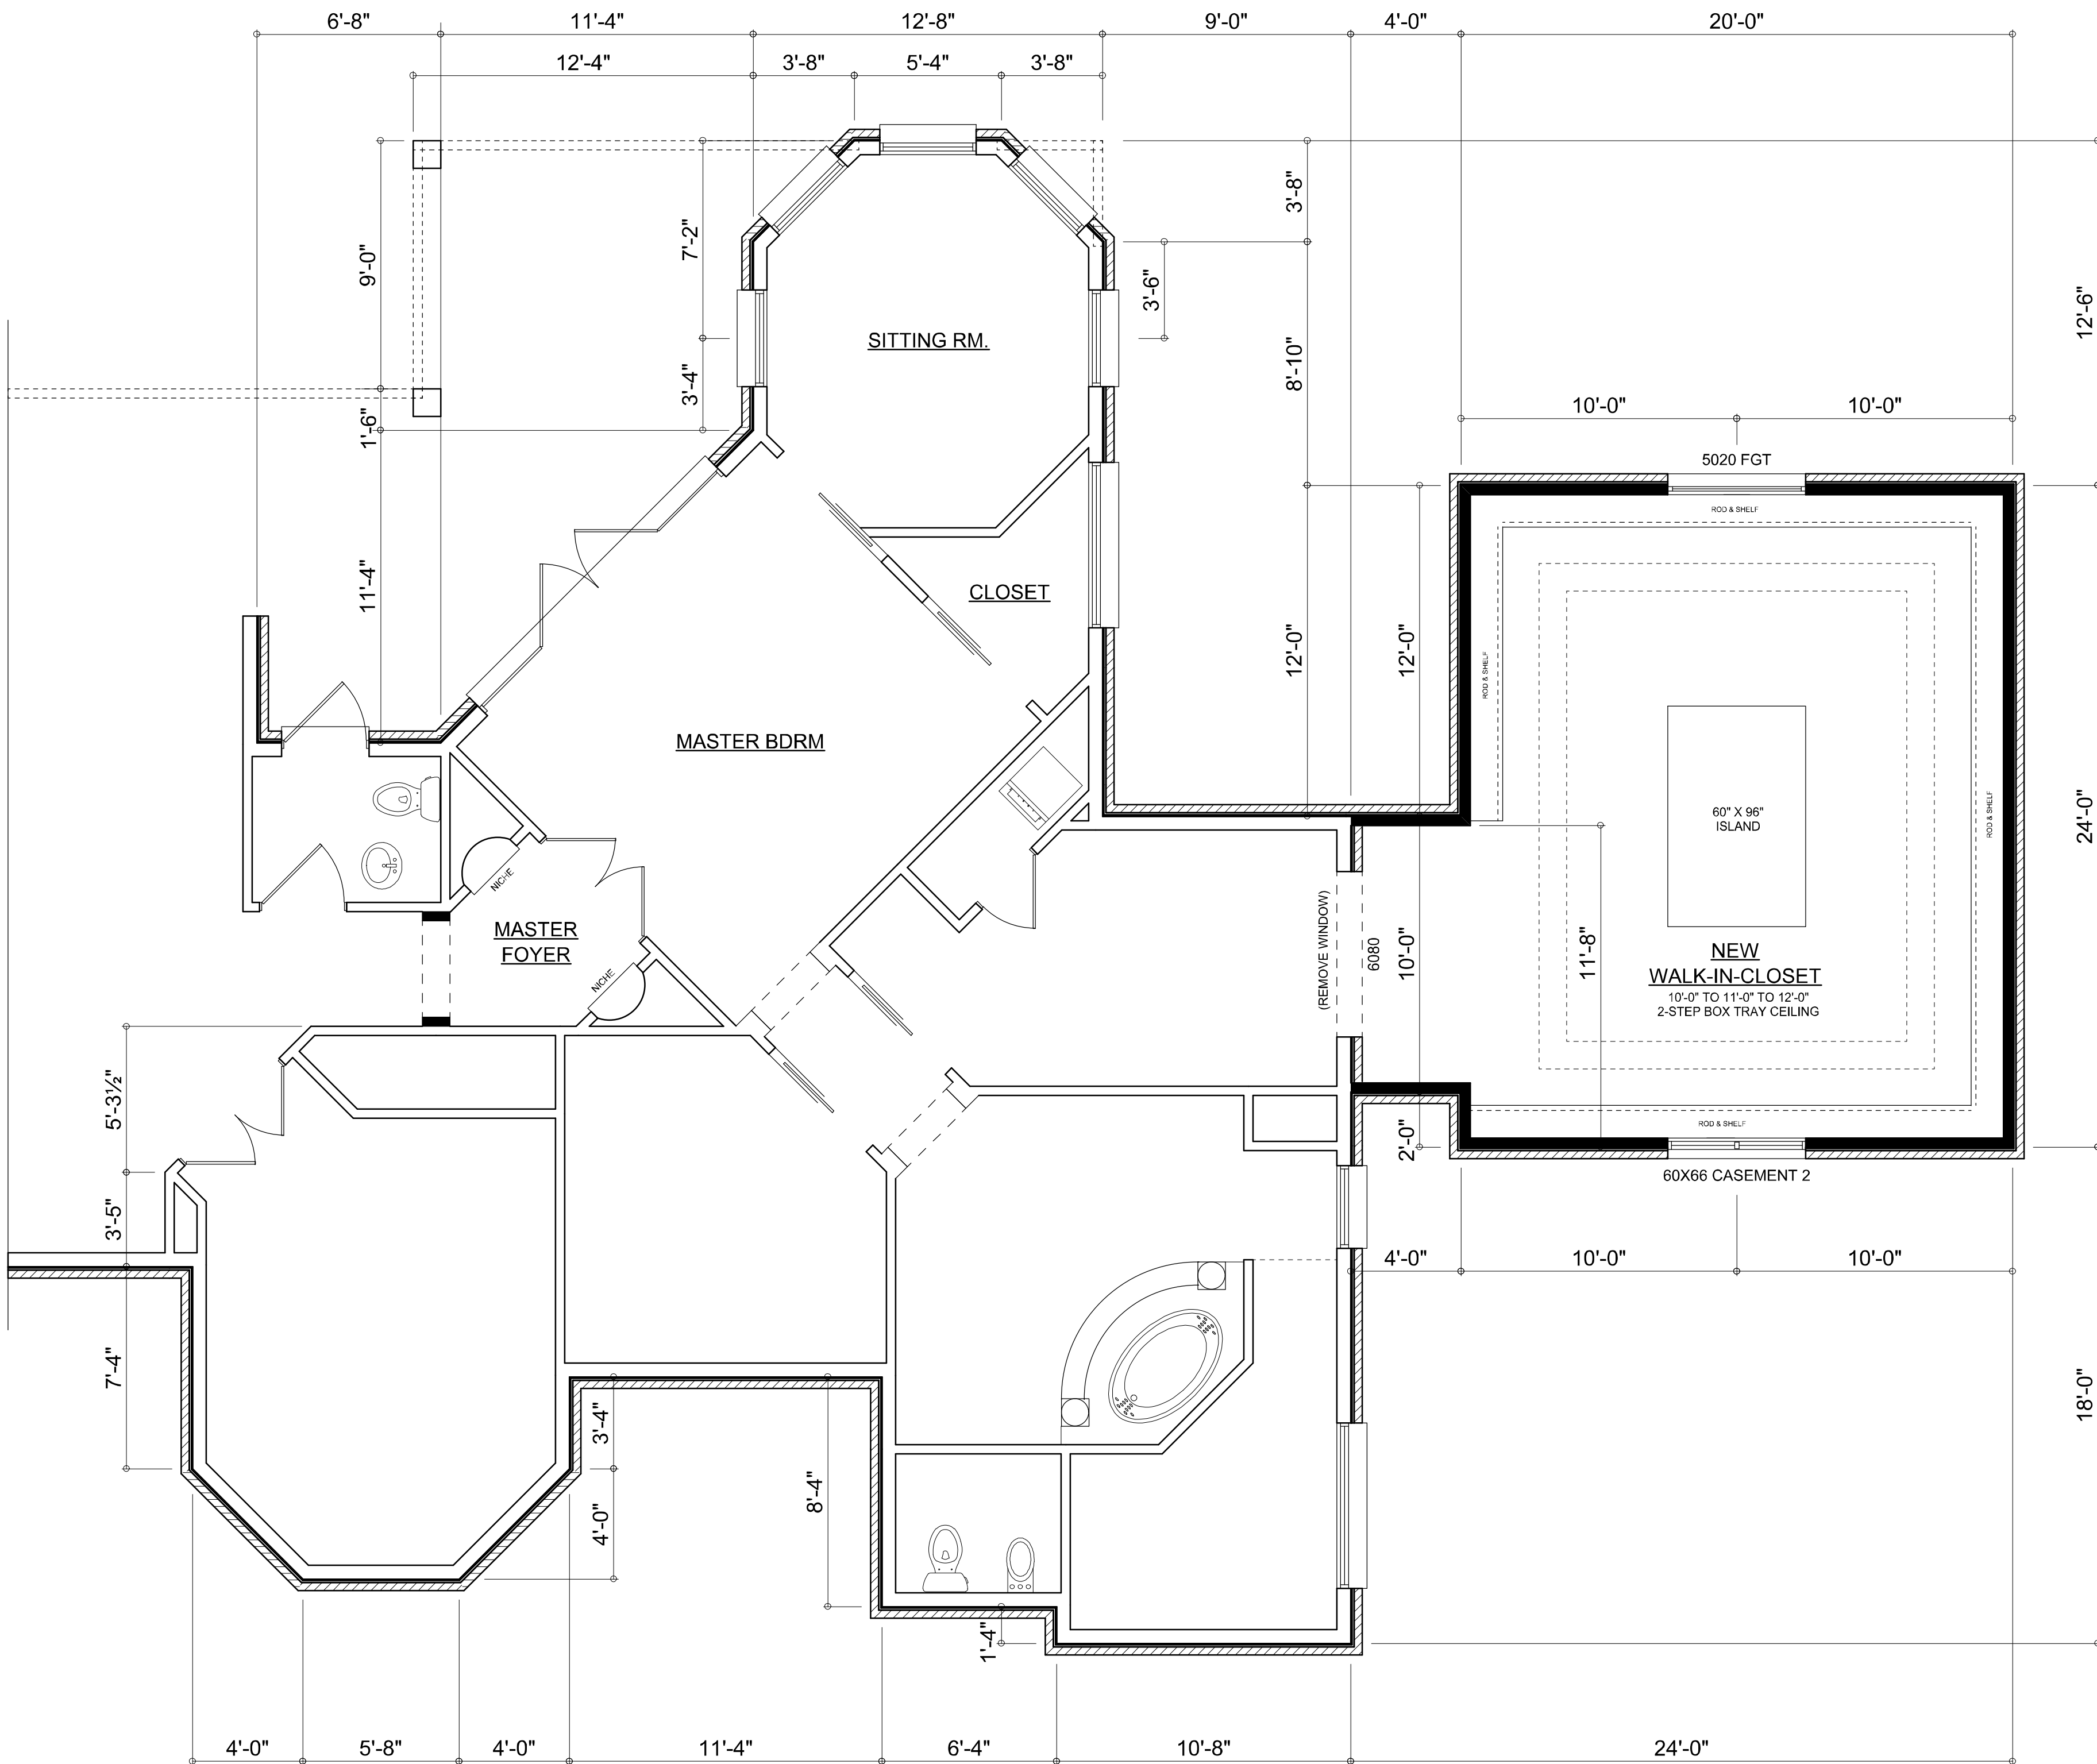

PROPOSED DESIGN  
SCALE: 1/4" = 1'-0"

ADDITION AREA: 520 SF.

WALL LEGEND

- EXISTING 2x 6 EXTERIOR WALL TO REMAIN
- EXISTING FRAMED INTERIOR WALL TO REMAIN
- NEW 2x 4 FRAMED INTERIOR WALL
- NEW 2x 6 FRAMED EXTERIOR WALL WITH SIDING
- EXISTING FRAMED INTERIOR WALL TO BE REMOVED

NOTE: ALL DRAWINGS NOT TO BE SCALED, WRITTEN DIMENSIONS TAKE PRECEDENCE OVER SCALED DIMENSIONS

| REVISIONS          |
|--------------------|
| September 11, 2024 |
|                    |
|                    |
|                    |



| AS-BUILT PLAN        | ELECTRICAL PLAN      | PROPOSED ADDITION PLAN |
|----------------------|----------------------|------------------------|
| SCALE: 3/16" = 1'-0" | SCALE: 3/16" = 1'-0" | SCALE: 1/4" = 1'-0"    |

PROPOSED MASTER CLOSET ADDITION FOR:  
**Miguel & Kelly Tepedino**  
PROJECT ADDRESS: 135 SW STONERIDGE DR. LAKE CITY, FLORIDA 32024

© WM DESIGN & ASSOCIATES INC.  
426 SW COMMERCE DR. STE 130  
LAKE CITY, FL 32025  
(386) 758-8406  
wm@wmymyers.net



JOB NUMBER  
20240327

SHEET NUMBER  
**A.2**

Wm C. Myers