

FW



STATE OF FLORIDA
DEPARTMENT OF HEALTH
ONSITE SEWAGE TREATMENT AND DISPOSAL
SYSTEM
APPLICATION FOR CONSTRUCTION PERMIT

PERMIT NO: 20-0567
DATE PAID: 7/17/20
FEE PAID: 310.00
RECEIPT #: 1524354

APPLICATION FOR:

- New System
- Existing System
- Holding Tank
- Innovative
- Repair
- Abandonment
- Temporary

APPLICANT: Jerry Clark (Ironwood)

AGENT: North Florida Septic Tank INC TELEPHONE: 155-6372

MAILING ADDRESS: 741 SE State Rd 100 Lake City, FL 32025

TO BE COMPLETED BY APPLICANT OR APPLICANT'S AUTHORIZED AGENT. SYSTEMS MUST BE CONSTRUCTED BY A PERSON LICENSED PURSUANT TO 489.105(3)(m) OR 489.552, FLORIDA STATUTES. IT IS THE APPLICANT'S RESPONSIBILITY TO PROVIDE DOCUMENTATION OF THE DATE THE LOT WAS CREATED OR PLATTED (MM/DD/YY) IF REQUESTING CONSIDERATION OF STATUTORY GRANDFATHER PROVISIONS.

PROPERTY INFORMATION

LOT: 9 BLOCK: C SUBDIVISION: Ichetucknee Pines PLATTED: _____

PROPERTY ID #: 16-65-16-03832-117 ZONING: _____ I/M OR EQUIVALENT: [Y N]

PROPERTY SIZE: 4.01 ACRES WATER SUPPLY: [X] PRIVATE PUBLIC [] <=2000GPD [] >2000GPD

IS SEWER AVAILABLE AS PER 381.0065, FS? [Y N] DISTANCE TO SEWER: _____ FT

PROPERTY ADDRESS: 1851 Centerville Ave, FW Fla.

DIRECTIONS TO PROPERTY: 475 to CR 238 (TR) to Centerville Ave, TR on 1st New site on (R)

BUILDING INFORMATION

[X] RESIDENTIAL [] COMMERCIAL

Unit No	Type of Establishment	No. of Bedrooms	Building Area Sqft	Commercial/Institutional System Design Table 1, Chapter 64E-6, FAC
1	m.home	3	1941	
2	Garage	-	720	
3				
4				

[] Floor/Equipment Drains [] Other (Specify) _____


SIGNATURE: William D. Bishop II DATE: 7-16-2020

STATE OF FLORIDA
DEPARTMENT OF HEALTH
APPLICATION FOR CONSTRUCTION PERMIT

Permit Application Number 20-0547

~~PART II - SITE PLAN~~ CLARK

Scale: Each block represents 10 feet and 1 inch = 40 feet.

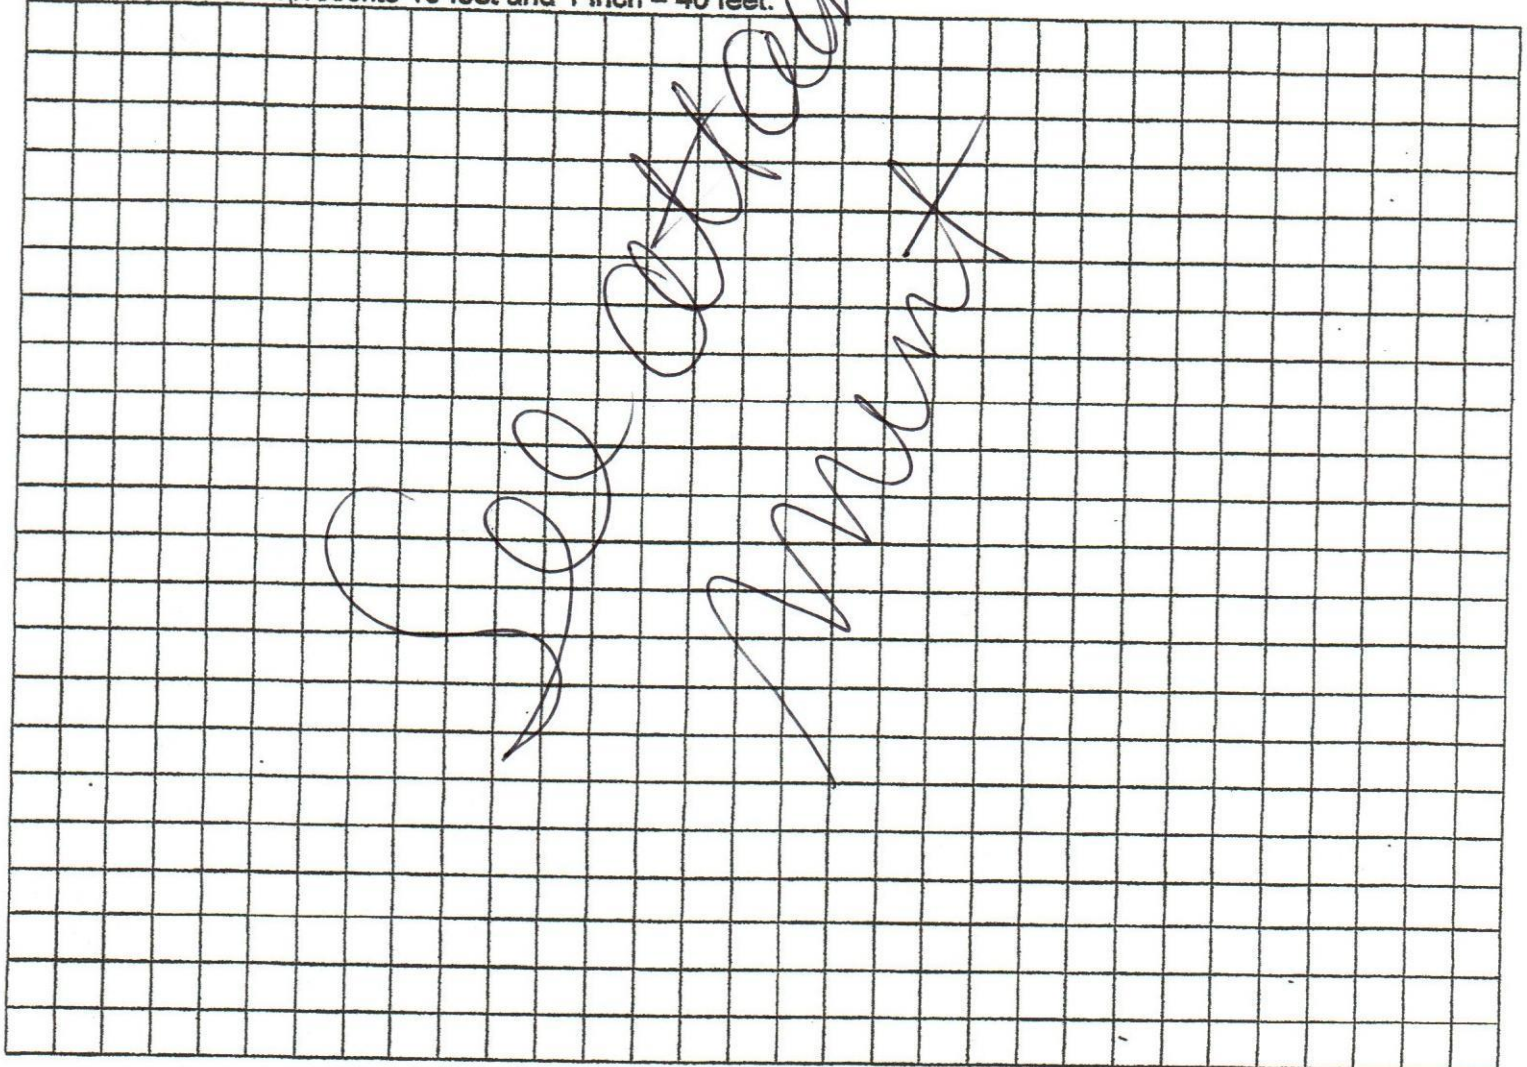

Notes: _____

William D. Bishop II

Site Plan submitted by: Robert W. Ford III DATE 7-11-2020

Plan Approved _____ Not Approved _____ Date 7/24/20

By [Signature] Columbia County Health Department

ALL CHANGES MUST BE APPROVED BY THE COUNTY HEALTH DEPARTMENT

20-0547




METAL GARAGE
36 x 20

Jerry Clark
8.13.2020

← 46' FROM SEPTIC

JR

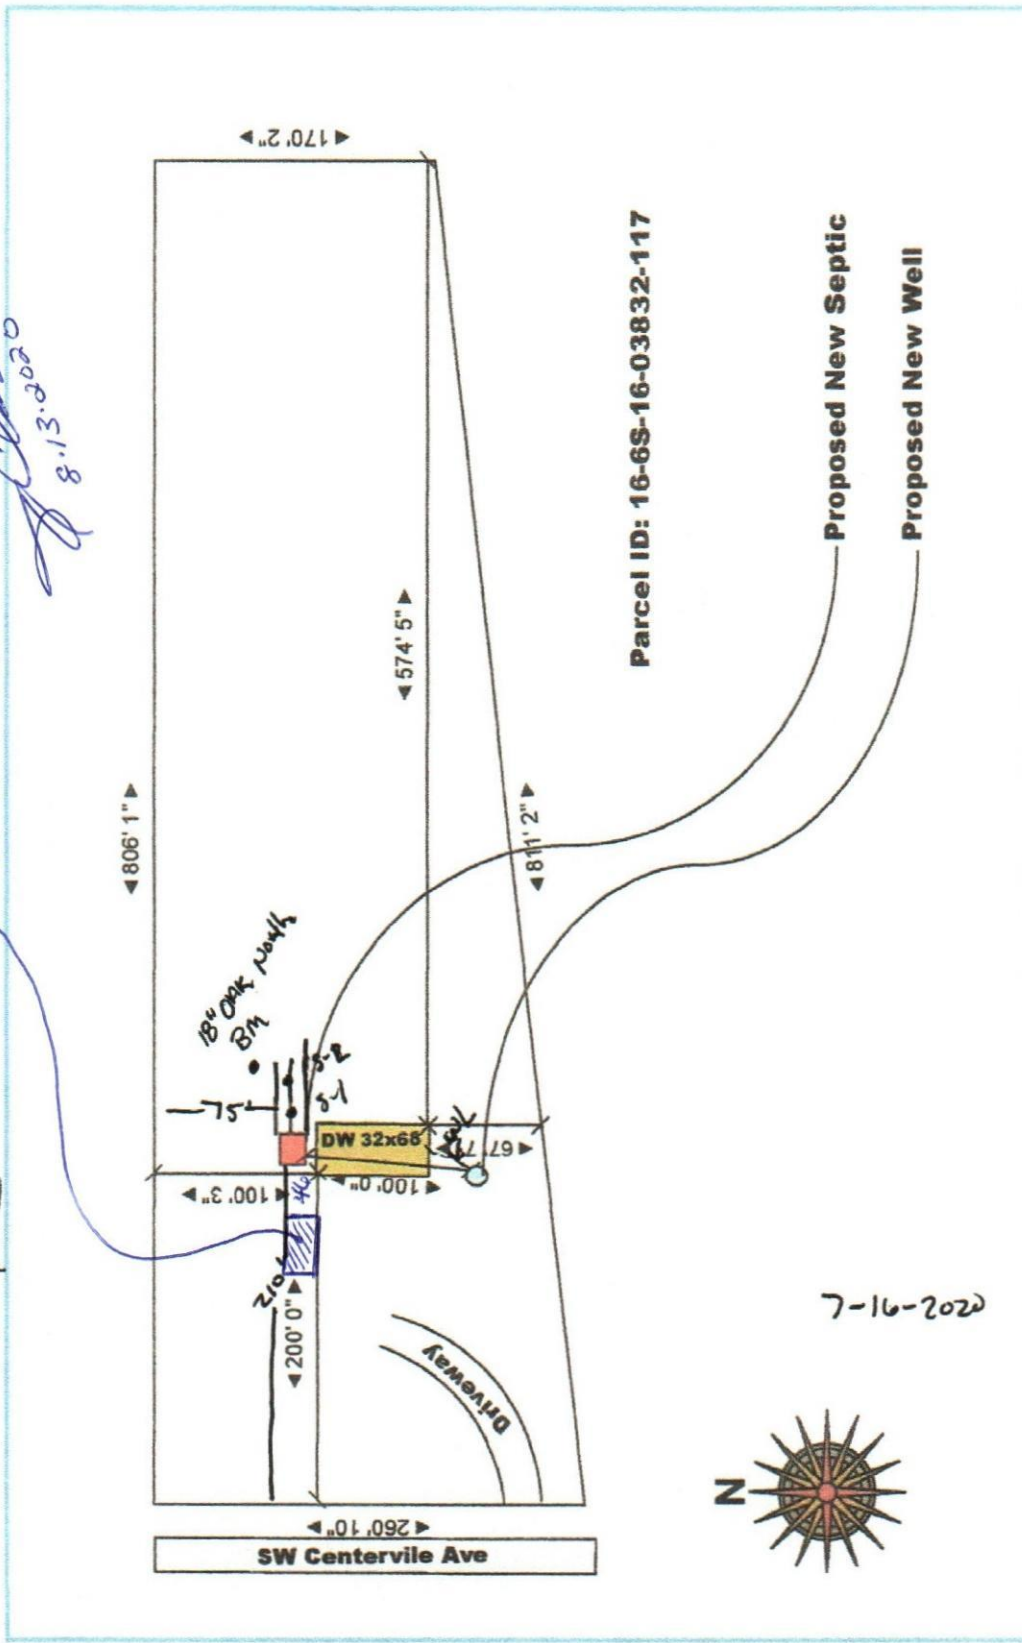

Site:	1851 SW Centerville Ave, Fort White	Project:	0001851	Drawn:	Heide M	Notes:	H&L Customer Service, LLC 301 SW Faul Ct Lake City, FL 32024 386-984-9334
Title:	Jerry Clark	Drawing:	801851	Date:	06/30/20	Rev:	A
		Scale:	1"=100'				

William D. Bishop II