


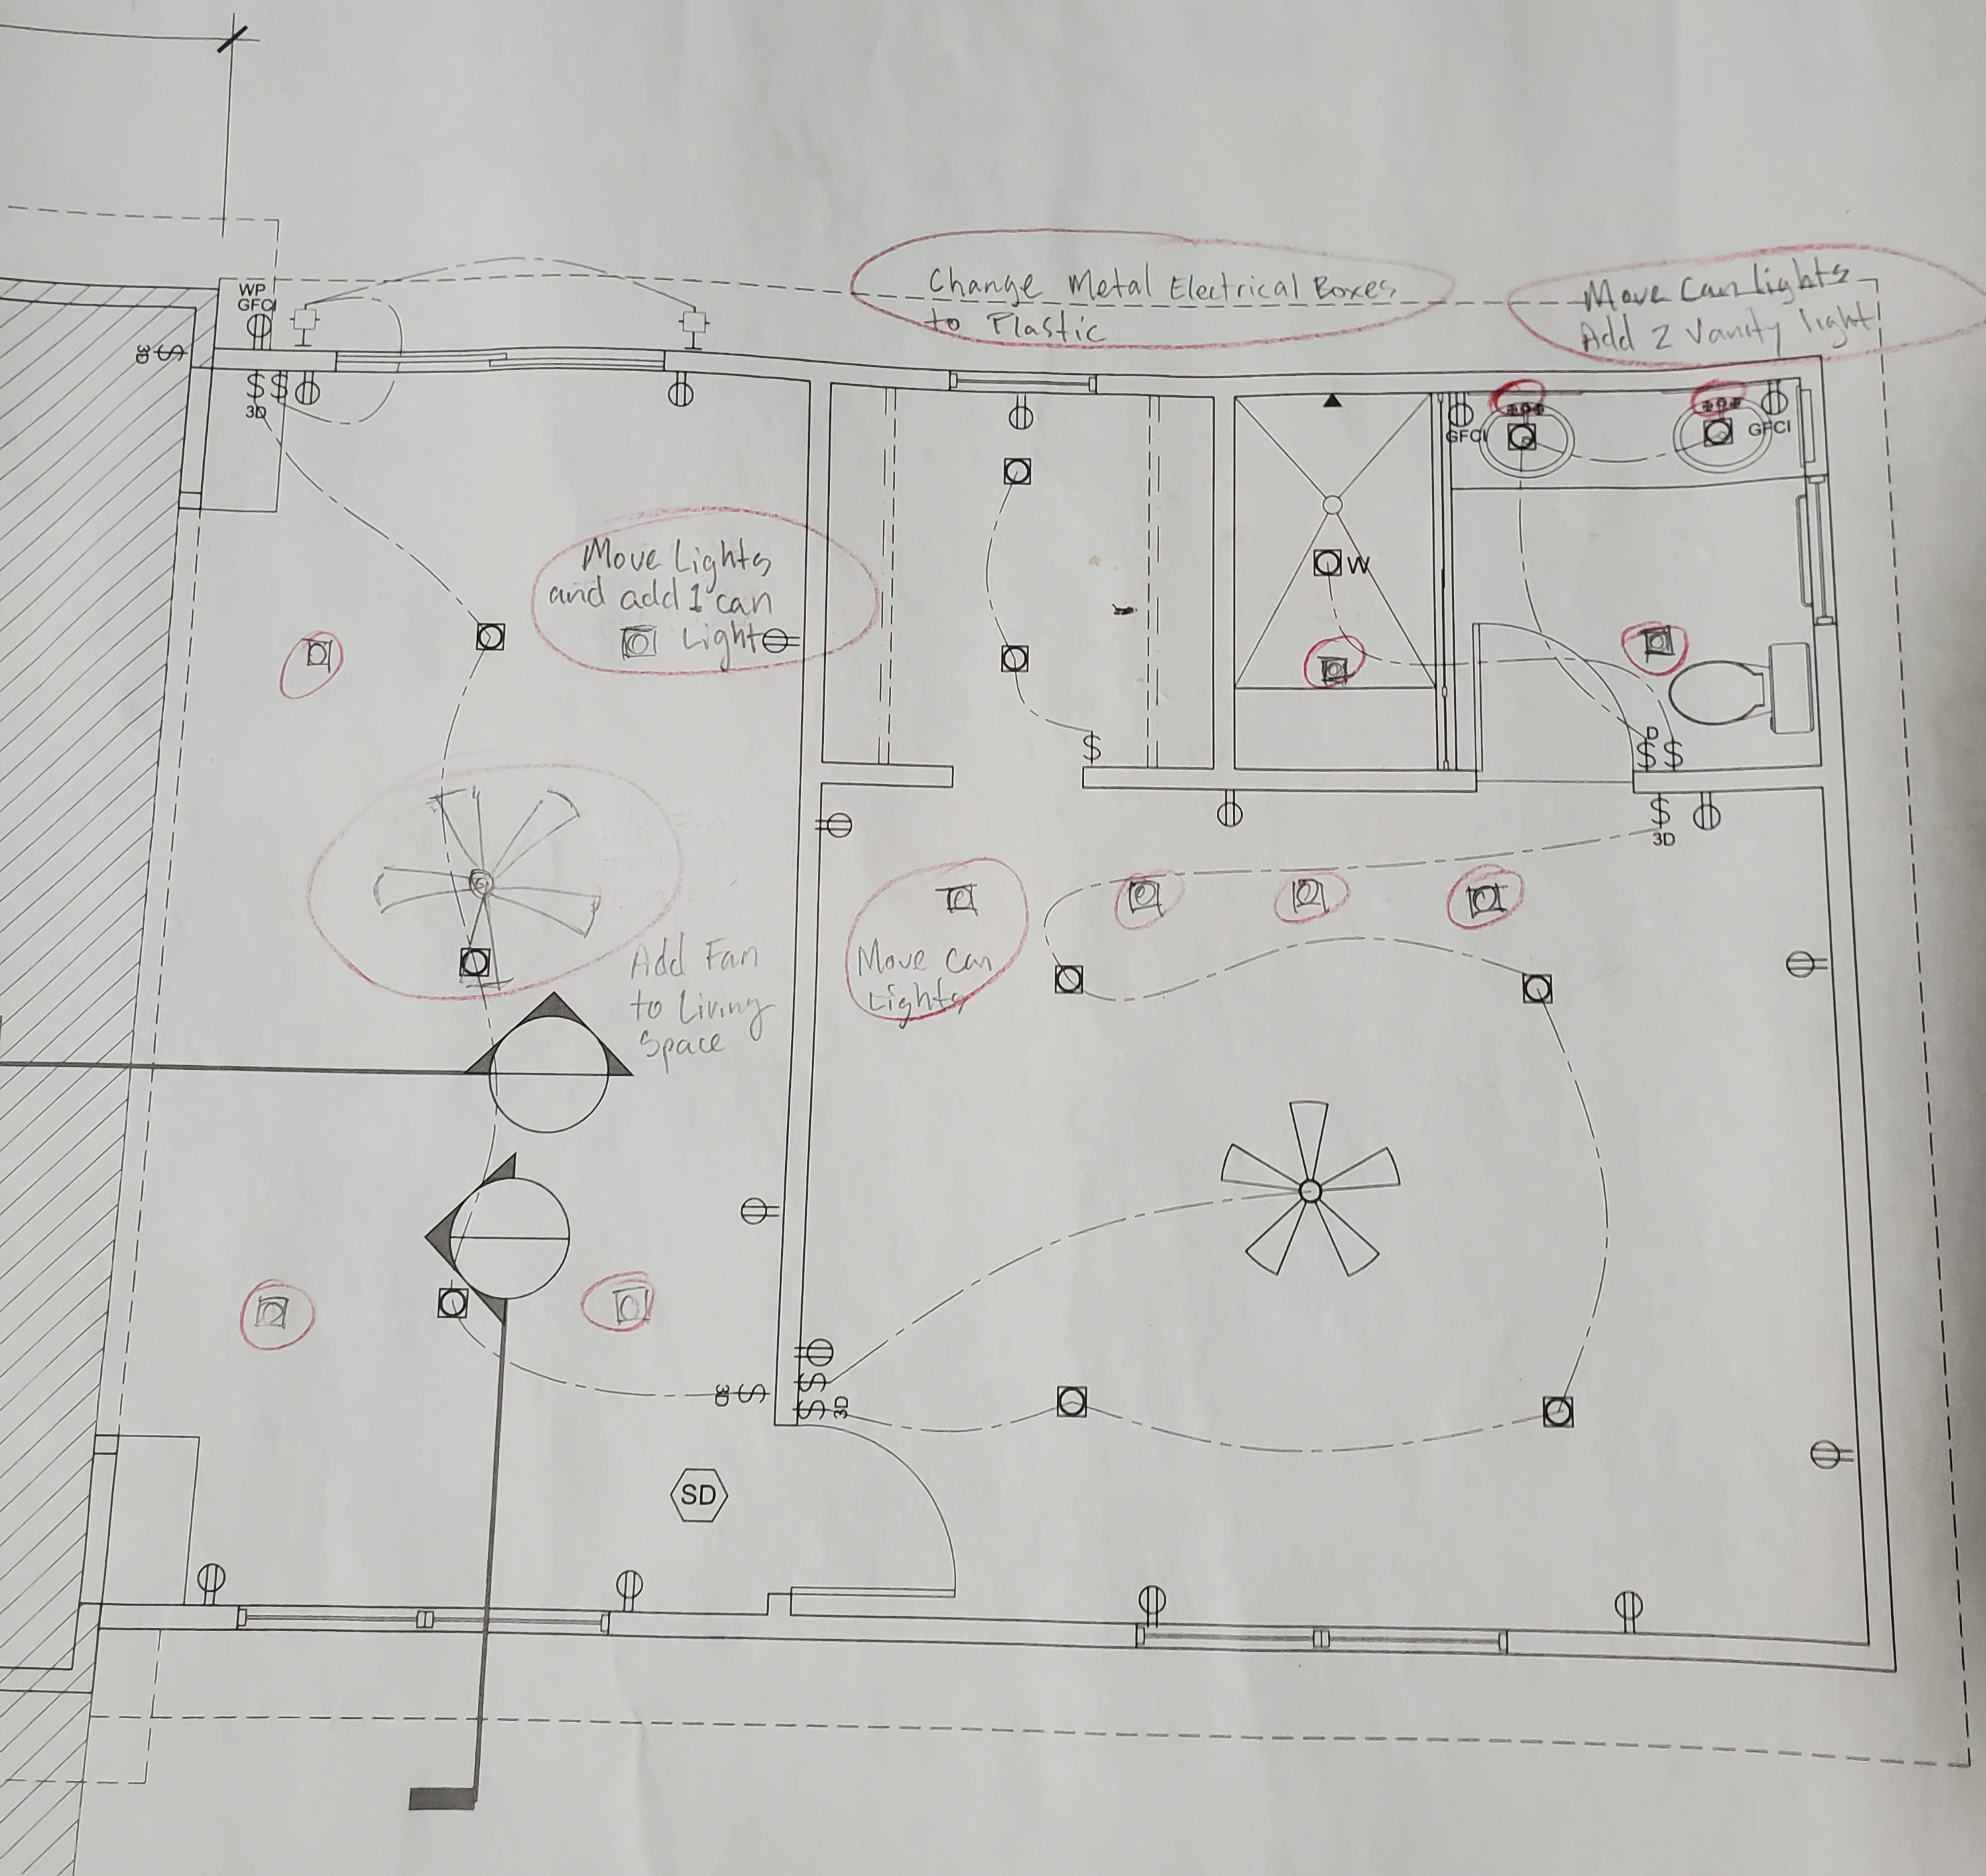

ELECTRIC POWER & LIGHTING PLAN

SCALE: 3/8" = 1'-0"