
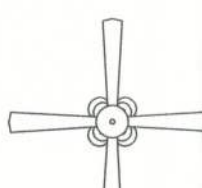


ELECTRICAL	COUNT	SYMBOL
ceiling fan spotlights 2	4	
can light	2	
chandelier	1	
fluorescent fixture	6	
vanity bar light	1	
wall mount 1	1	
fan with light	3	
light	12	
outlet	30	
outlet gfi	15	
switch	28	
switch 3 way	8	

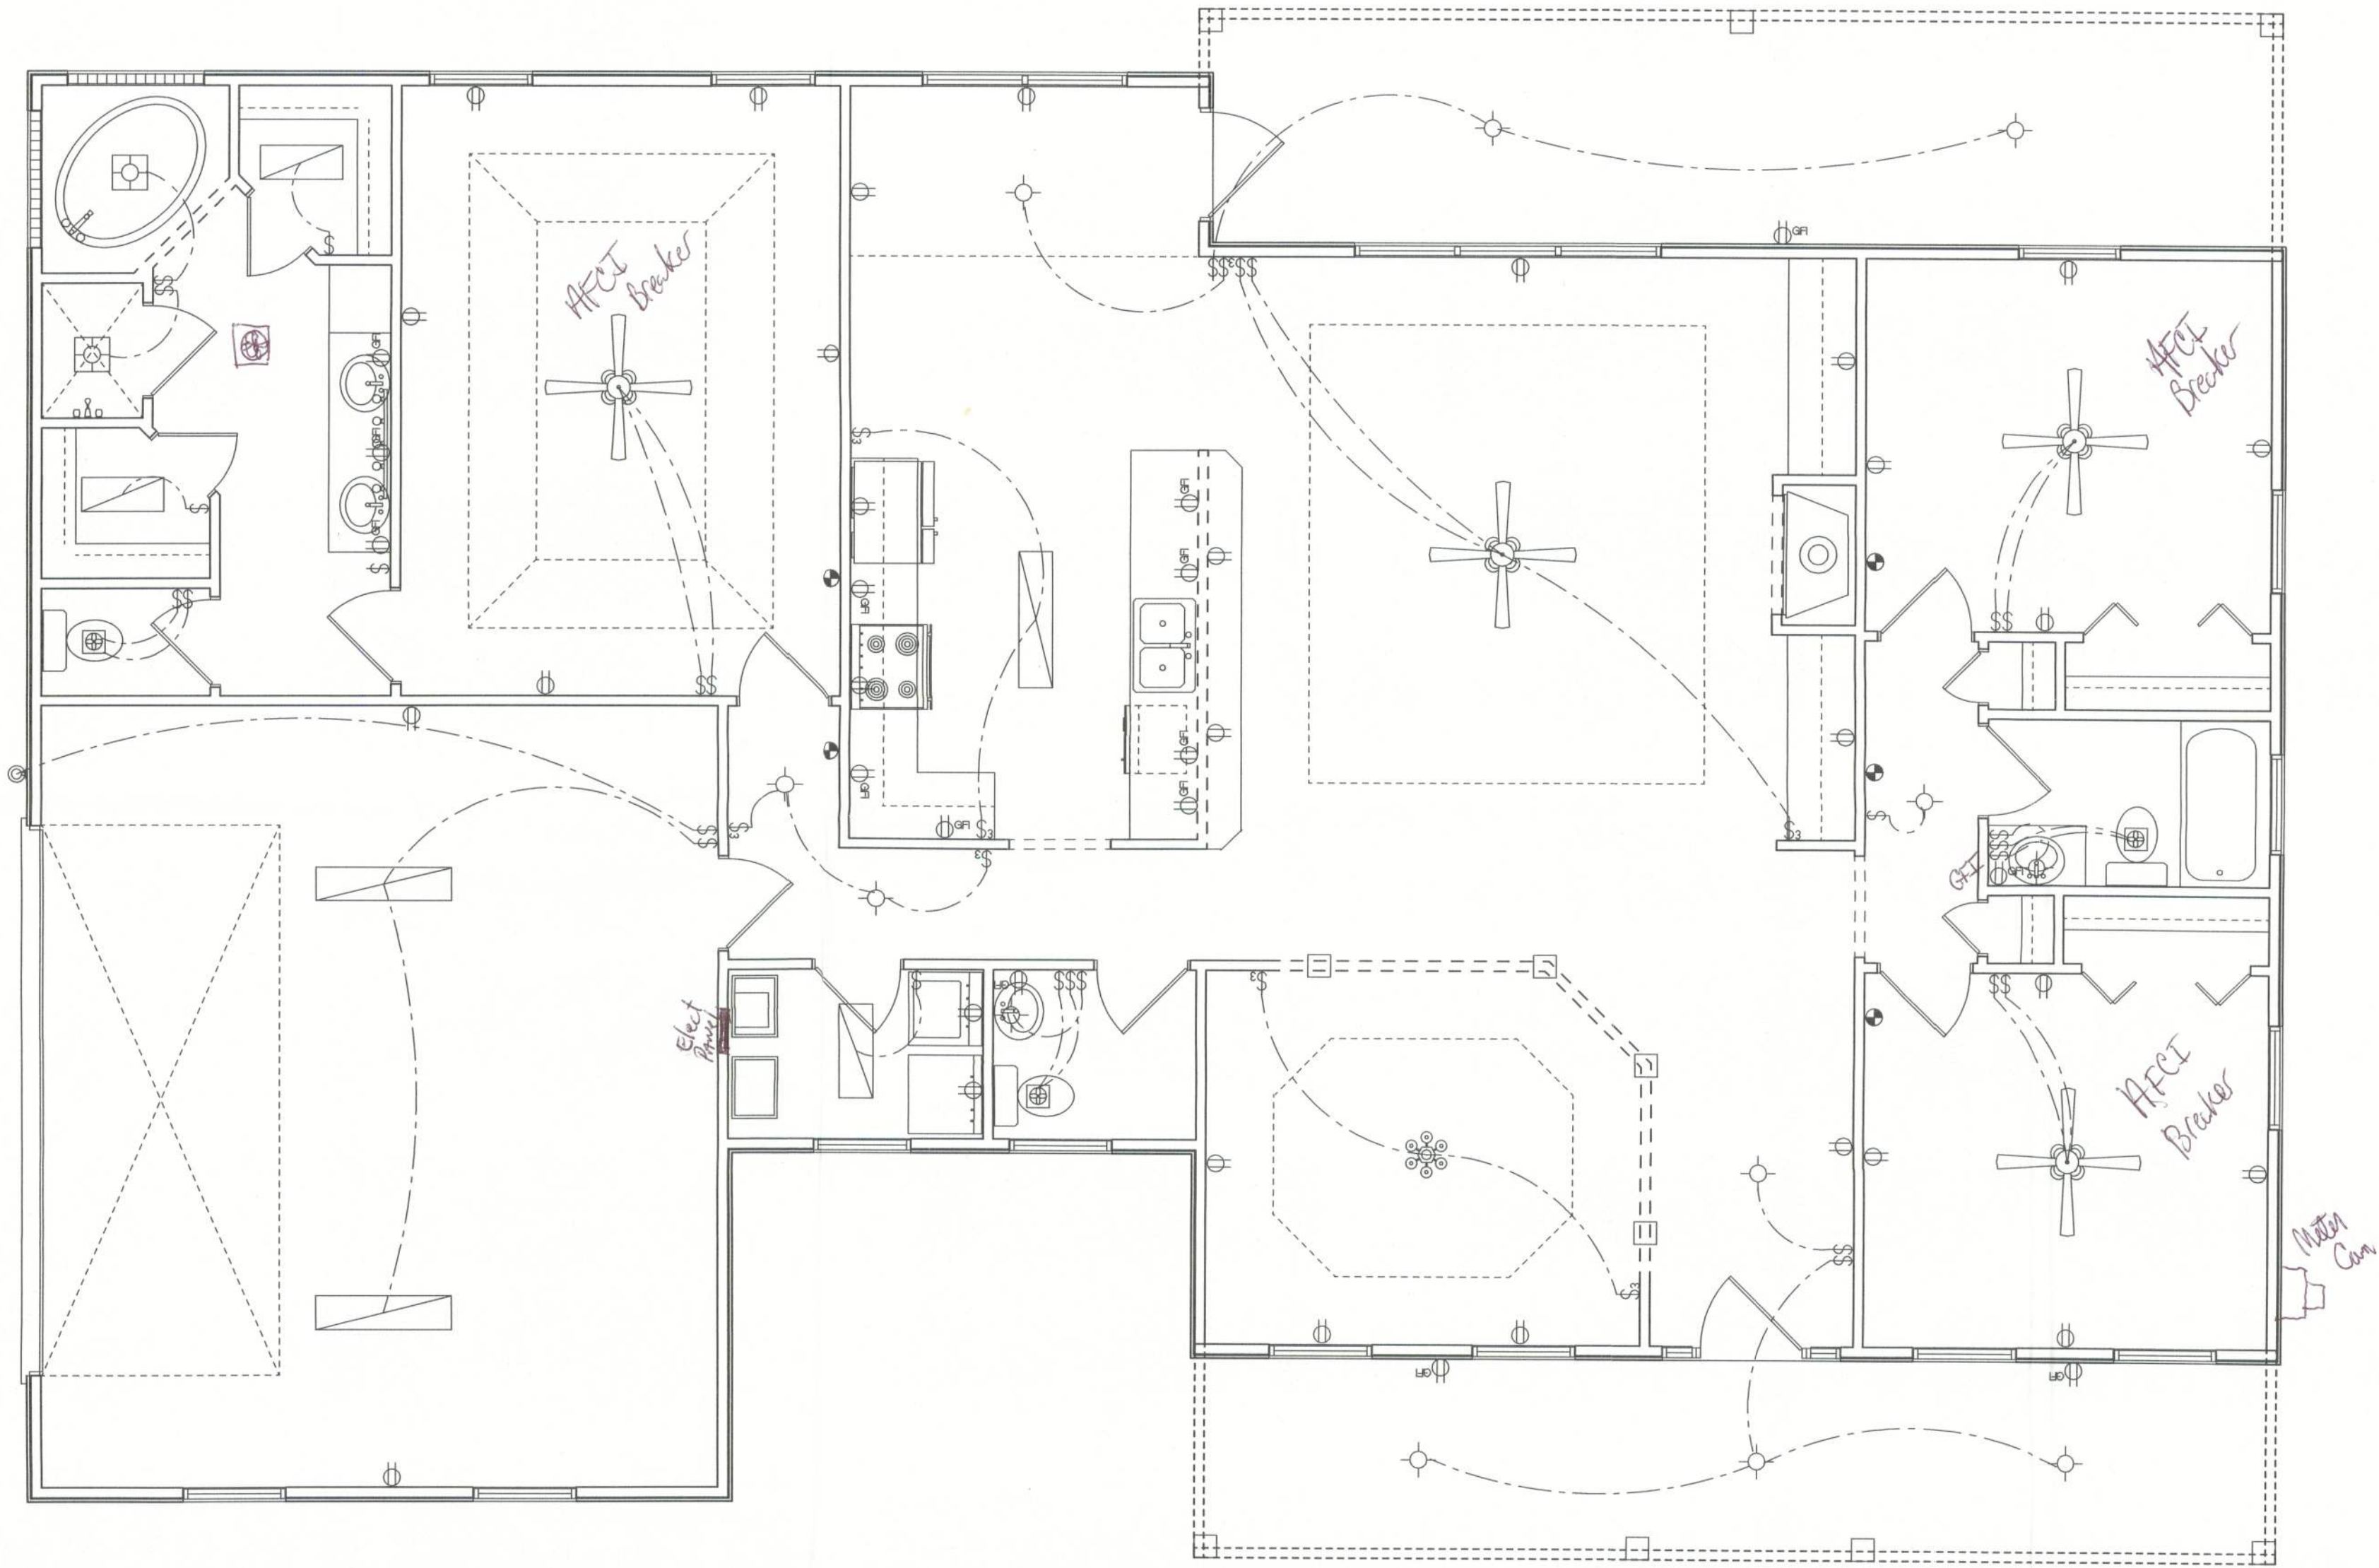

AREA SUMMARY	
LIVING AREA	1871.1 SF
CARPORT	520.9 SF
PORCHES	414.0 SF
TOTAL AREA	2812.6 SF
ELECTRICAL PLAN	
SCALE: 1/4"=1'-0"	

FIRST IMPRESSIONS
ARCHITECTURAL DESIGN, LLC
DESIGNER: BRIAN CRAWFORD
PHONE: (386) 755-8887

DATE:
CHECKED BY:
SHEET NUMBER

A-4
OF 4 SHEETS

NEW SPEC HOME FOR:
THORNWOOD LOT 15