



REVISIONS	

SOFTPLAN
ARCHITECTURAL DESIGN SOFTWARE

ELECTRICAL LEGEND	
ELECTRICAL	SYMBOL
com - data TV	▼
fan - Bath fan light	⊙
light - can light	○
light - exterior spotlights	⊙
light - fluorescent 1 x 4	▬
outlet	⊕
outlet - 220v	⊕
outlet - W/P	⊕
outlet - gfi	⊕
switch	⊕
switch - 3 way	⊕
ceiling fan 5 bladed 02	⊕
ceiling fan globe 02	⊕
ceiling or square	⊕
ceiling shade square	⊕
chandelier 01	⊕
fluorescent light 2 x 2	⊕
pendant large	⊕
pull chain light	⊕
wall mounted 01 3 lights	⊕
AC Disconnect	⊕
detector - CO	⊕
detector - smoke	⊕

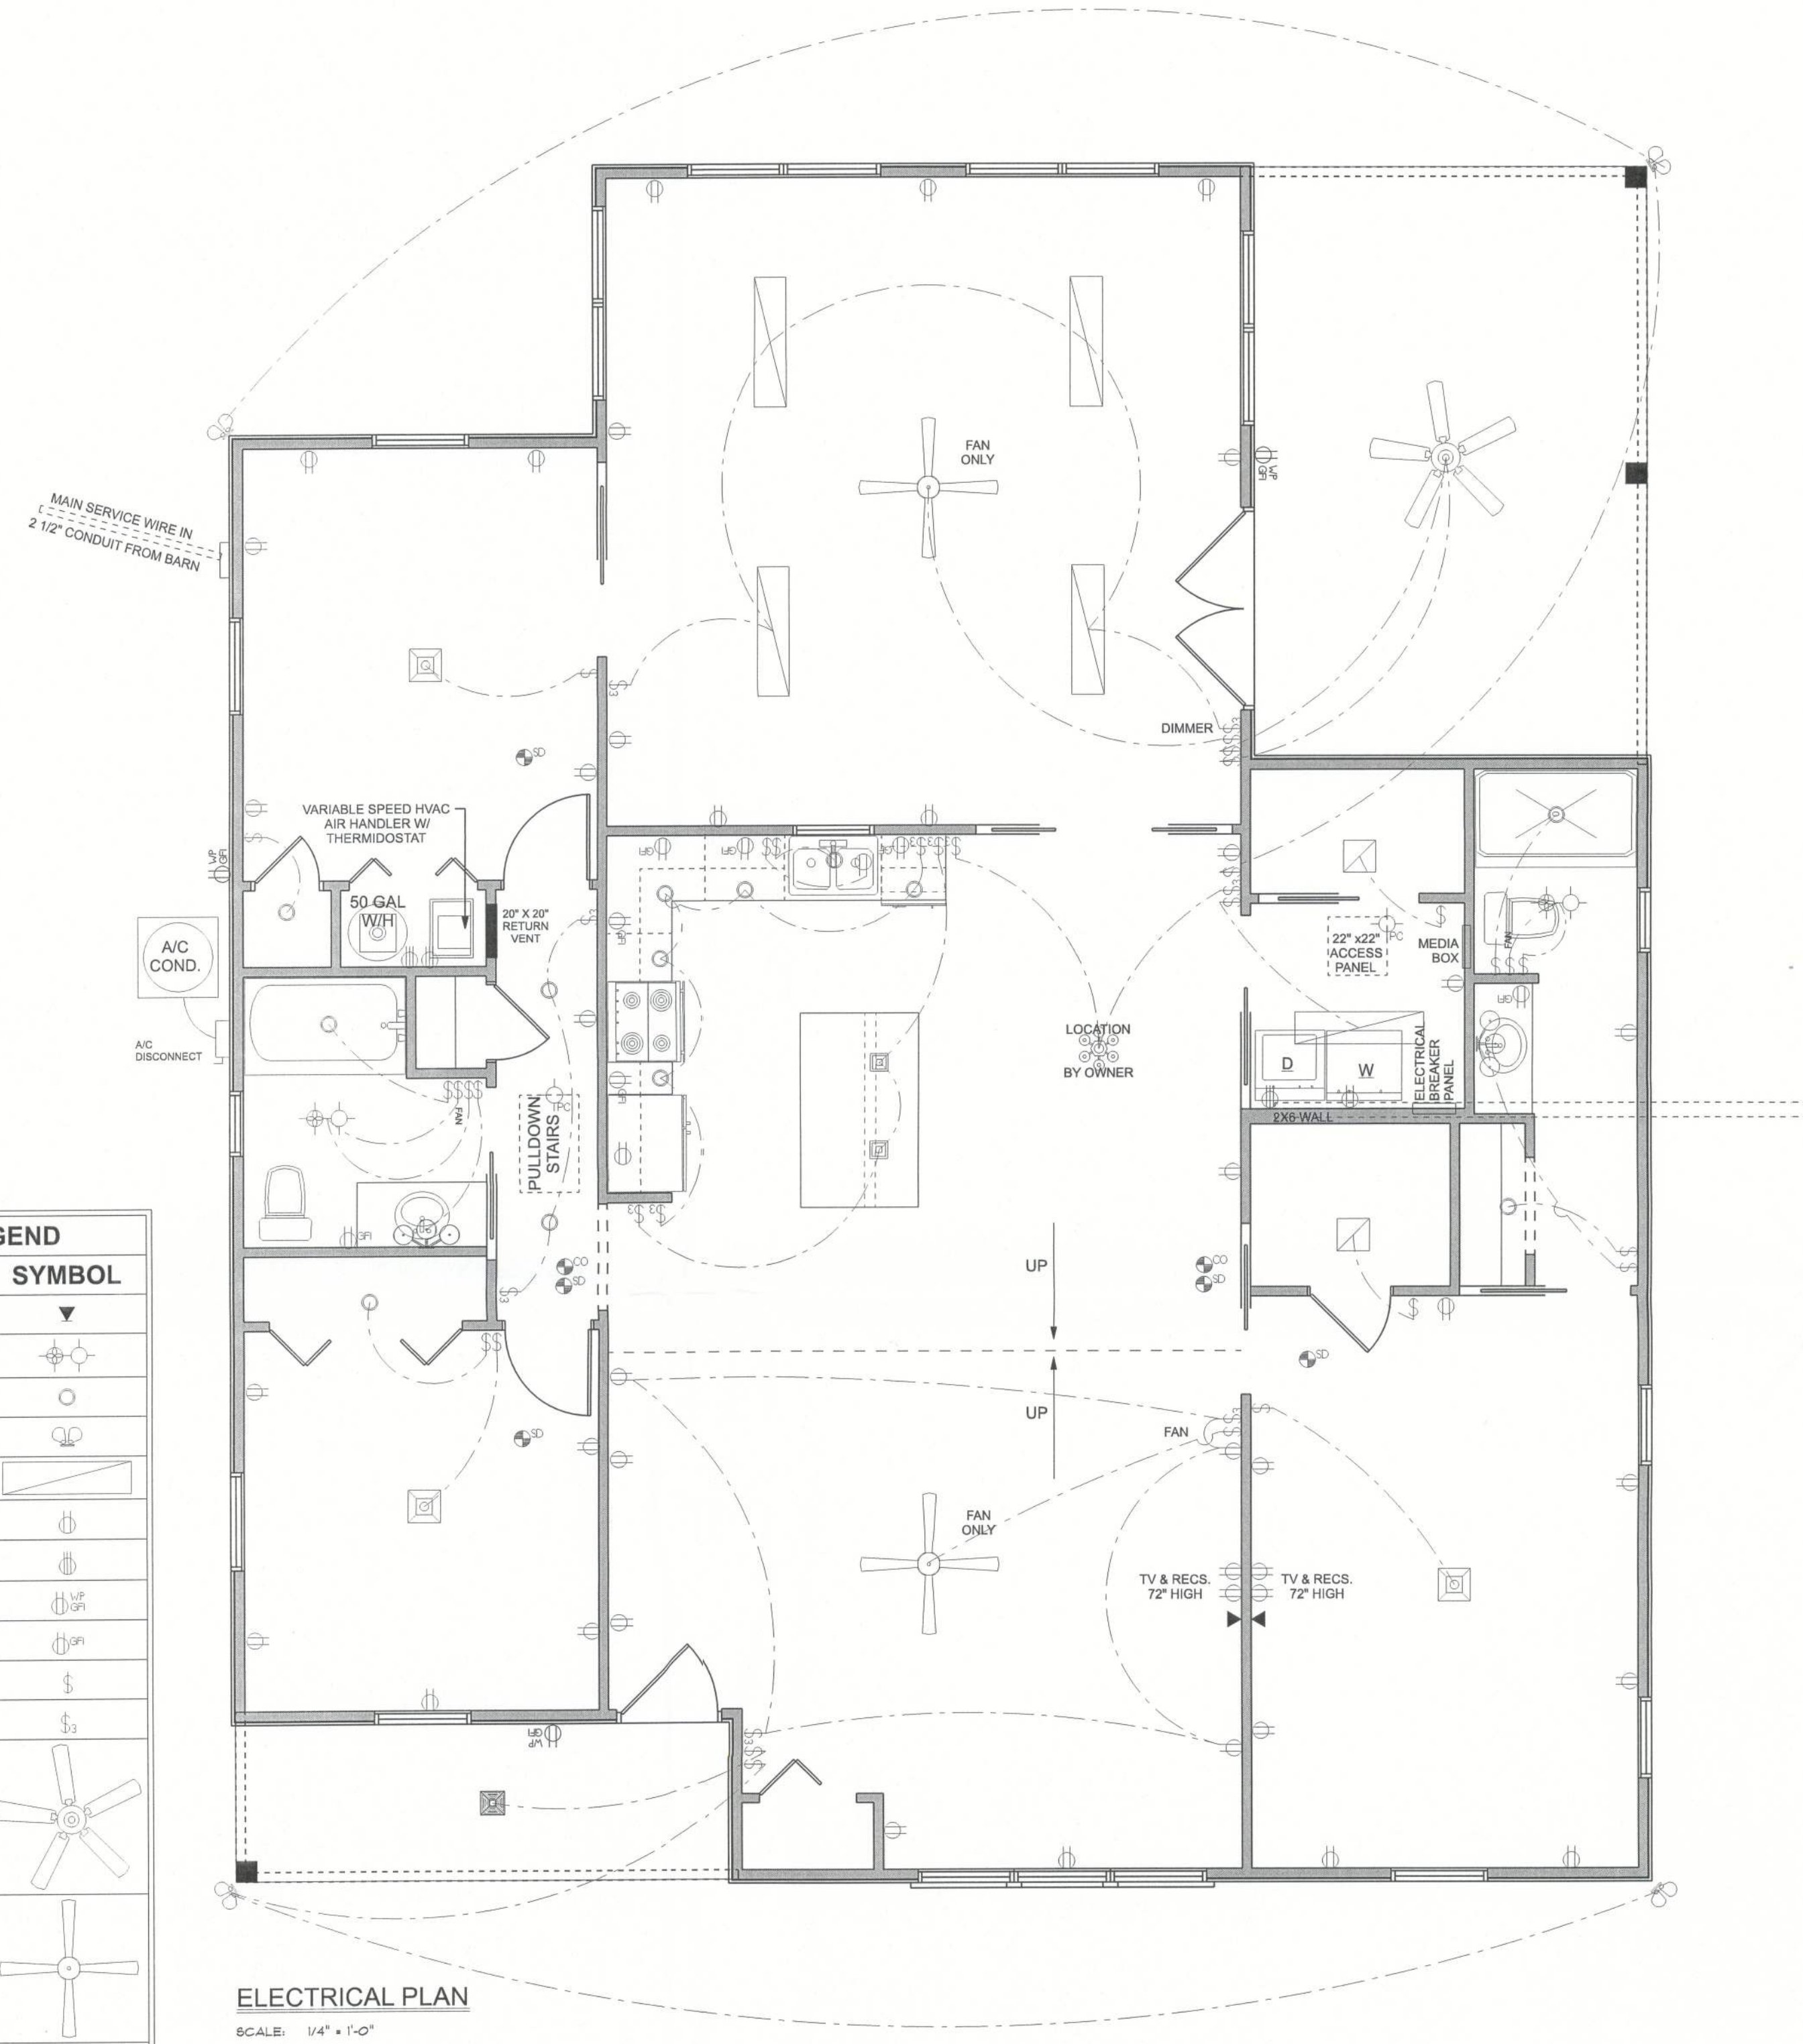

ELECTRICAL PLAN
SCALE: 1/4" = 1'-0"

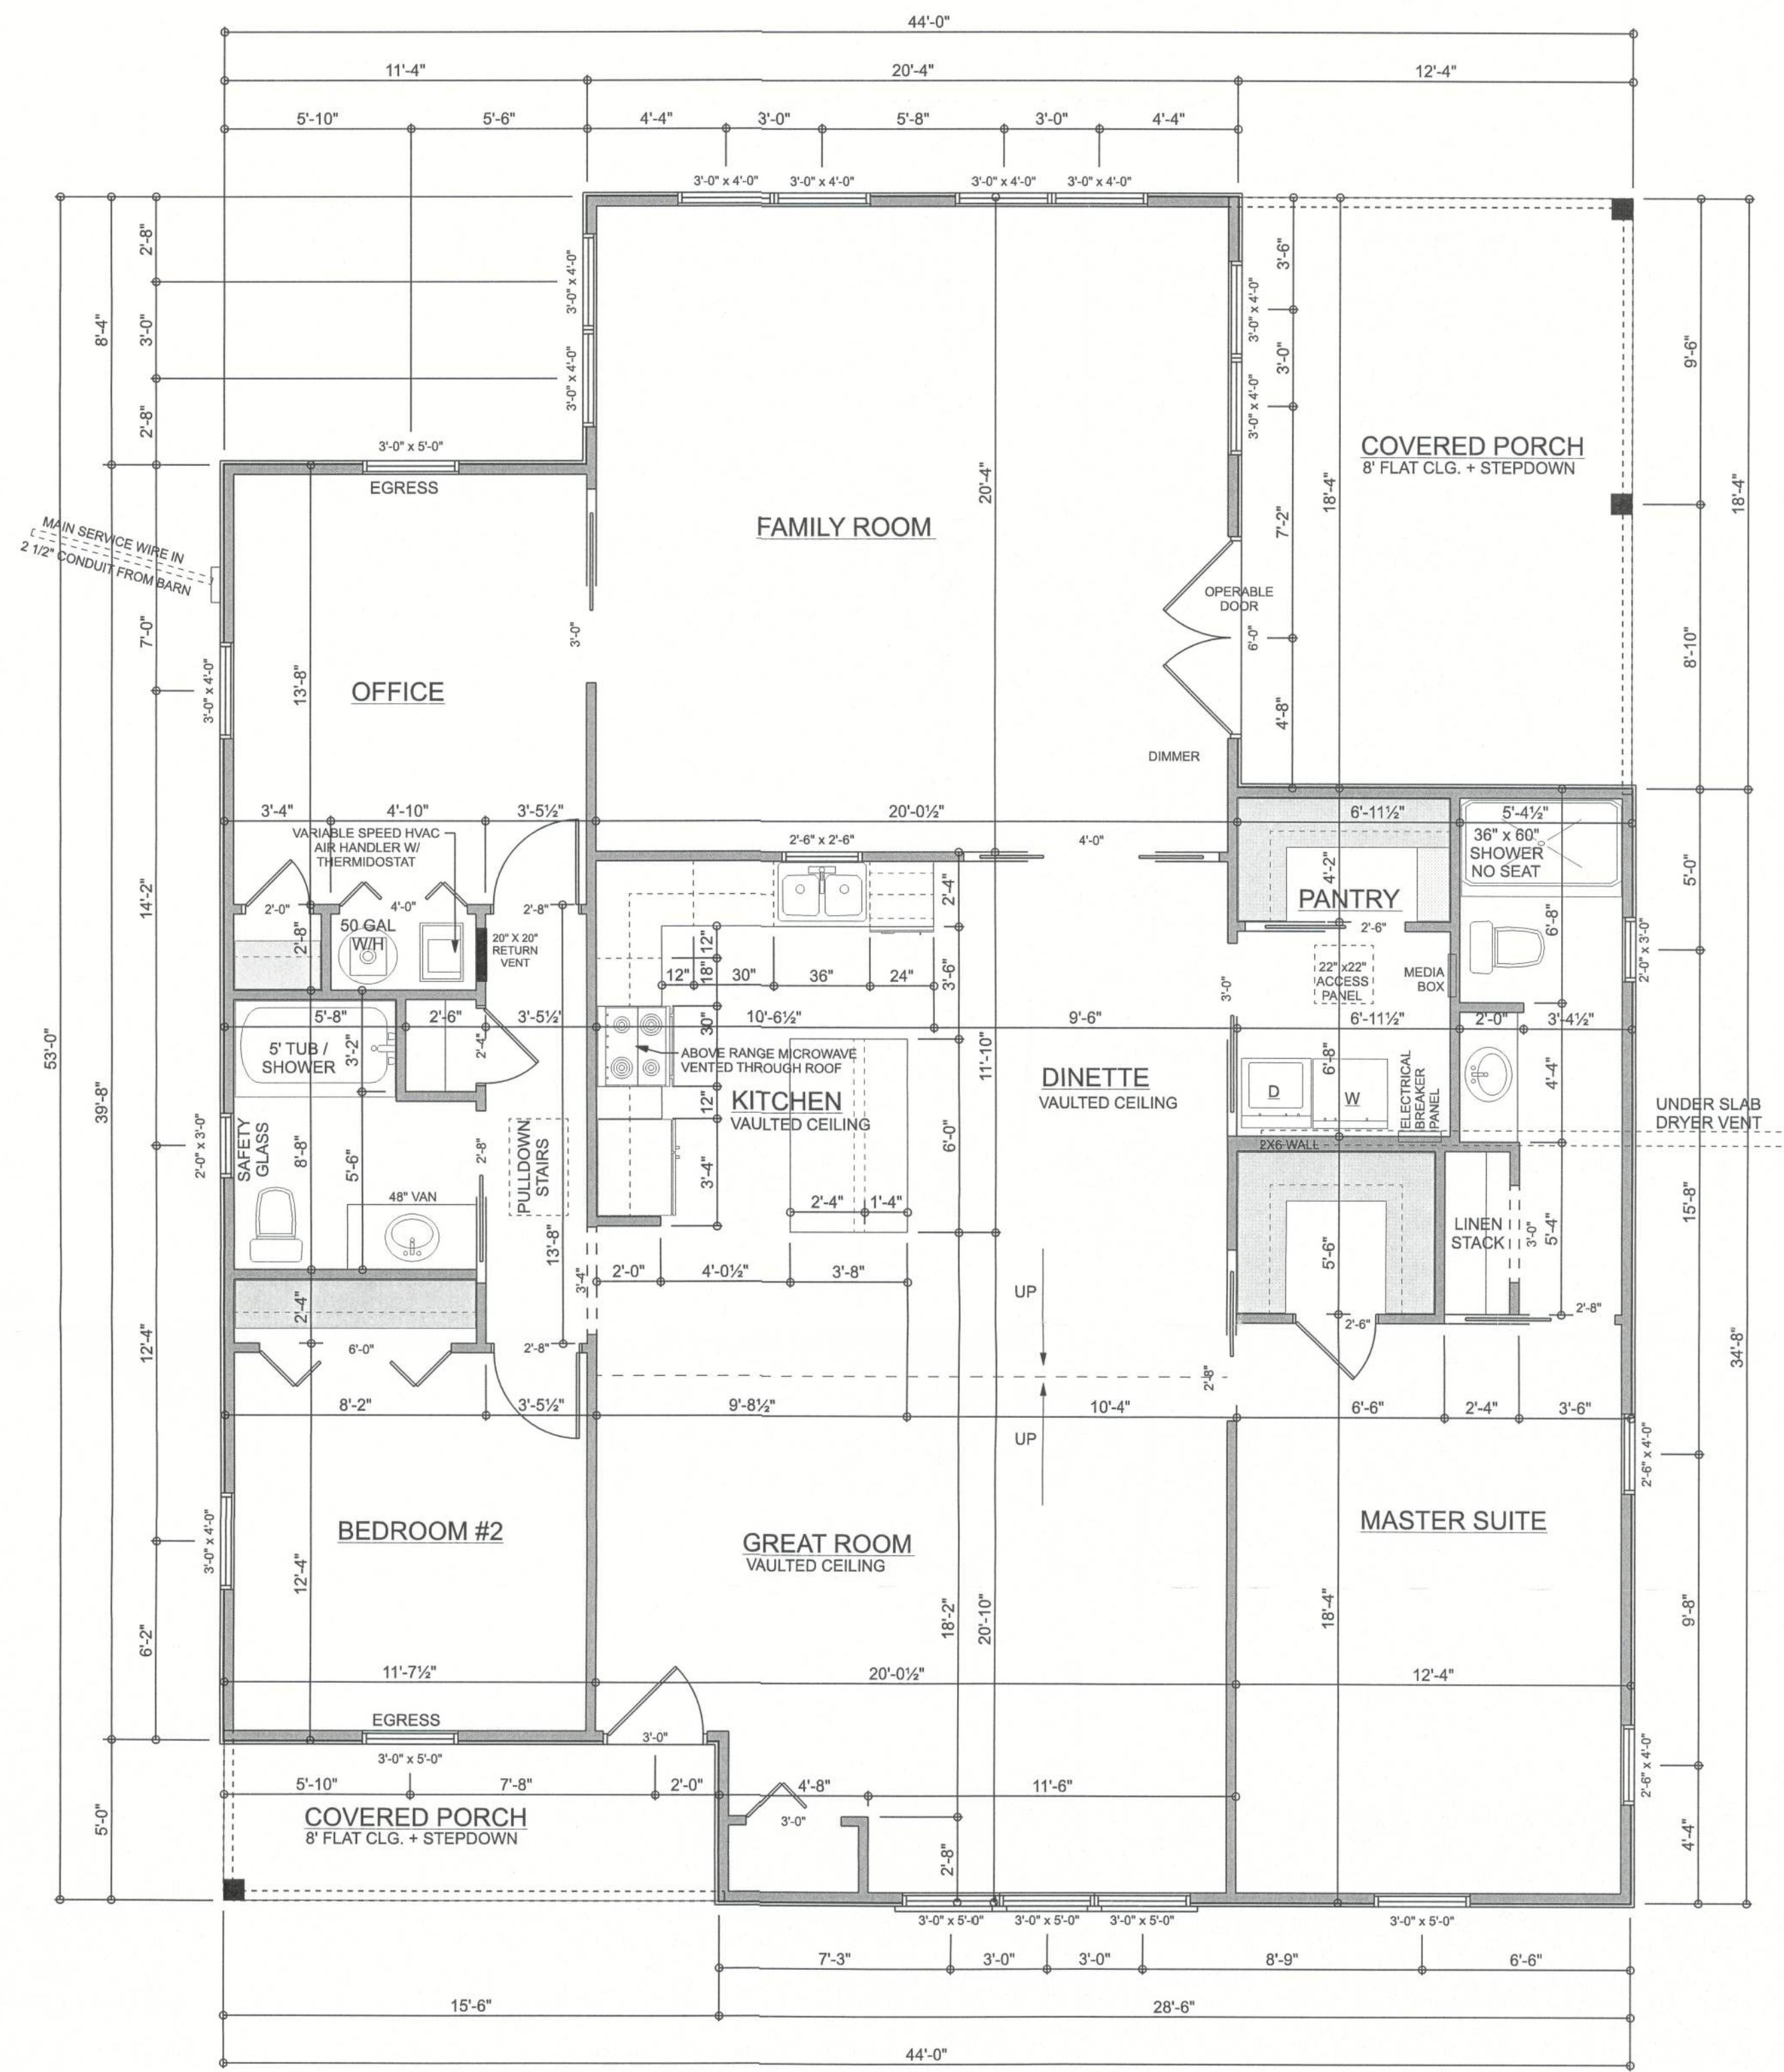

FLOOR PLAN
SCALE: 1/4" = 1'-0"
8' FLAT CLG. UNLESS NOTED

AREA SUMMARY

AREA IS TO OUTSIDE OF EXTERIOR FINISH	
LIVING AREA	1,958 S. F.
COVERED PORCH AREA	298 S. F.
TOTAL AREA UNDER ROOF	2,256 S. F.

ERKINGER
CONSTRUCTION
GROUP
JAMES AND ASHLEY
JONES
ADDRESS:
TBD SW Leo Peagle Glen
Lake City, FL Columbia County
PARCEL ID:
06-06S-17-09613-004 (46652)

PRINTED DATE:
Wednesday, May 22, 2024
DRAWN BY: Matthew A. Erkinger Sr.
STRUCTURAL BY: Evan Beamsley

DRAWING NUMBER
#2
OF 2 SHEETS