


STATE CODES: FLORIDA

7TH EDITION (2020 FLORIDA BUILDING CODE RESIDENTIAL
7TH EDITION (2020) FLORIDA BUILDING CODE ENERGY CONSERVATION

Sheet List Table	
Sheet Number	Sheet Title
A-000	COVER SHEET
A-100	FLOOR PLAN
A-200	ELEVATIONS
A-201	ELEVATIONS
E-100	ELECTRICAL PLAN
S-100	FOUNDATION NOTES
S-200	FOUNDATION PLAN
S-300	FOUNDATION DETAILS
S-400	CEILING PLAN

JONES RESIDENCE

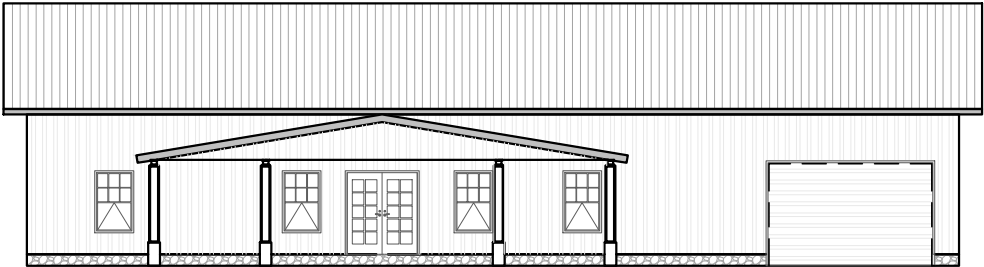

PLANS PREPARED FOR:

ADAM AND TARA JONES
442 SW TUNSIL ST
LAKE CITY, FL 32024

THE DRAWINGS HEREIN ARE ONLY APPLICABLE AT THE LOCATION
SPECIFIED BY THE ADDRESS: 442 SW TUNSIL STREET LAKE CITY, FL 32025.
THESE DRAWINGS ARE ARE NOT VALID FOR CONSTRUCTION ELSEWHERE.


REVISIONS			
NO.	DESCRIPTION	DATE	BY
1			
2			
3			
4			
5			

PLANS PREPARED BY:



17627 89TH ROAD, MCALPIN, FLORIDA 32062
P:386.688.7555
WWW.POURNELLECO.COM
COMPANY NUMBER: L20000107644


q:\ace - projects\21.019.200\jpc-jones\Cadd\20.019.zPlan-ARCH.dwg, ADAM, 6/9/2021 12:24 PM

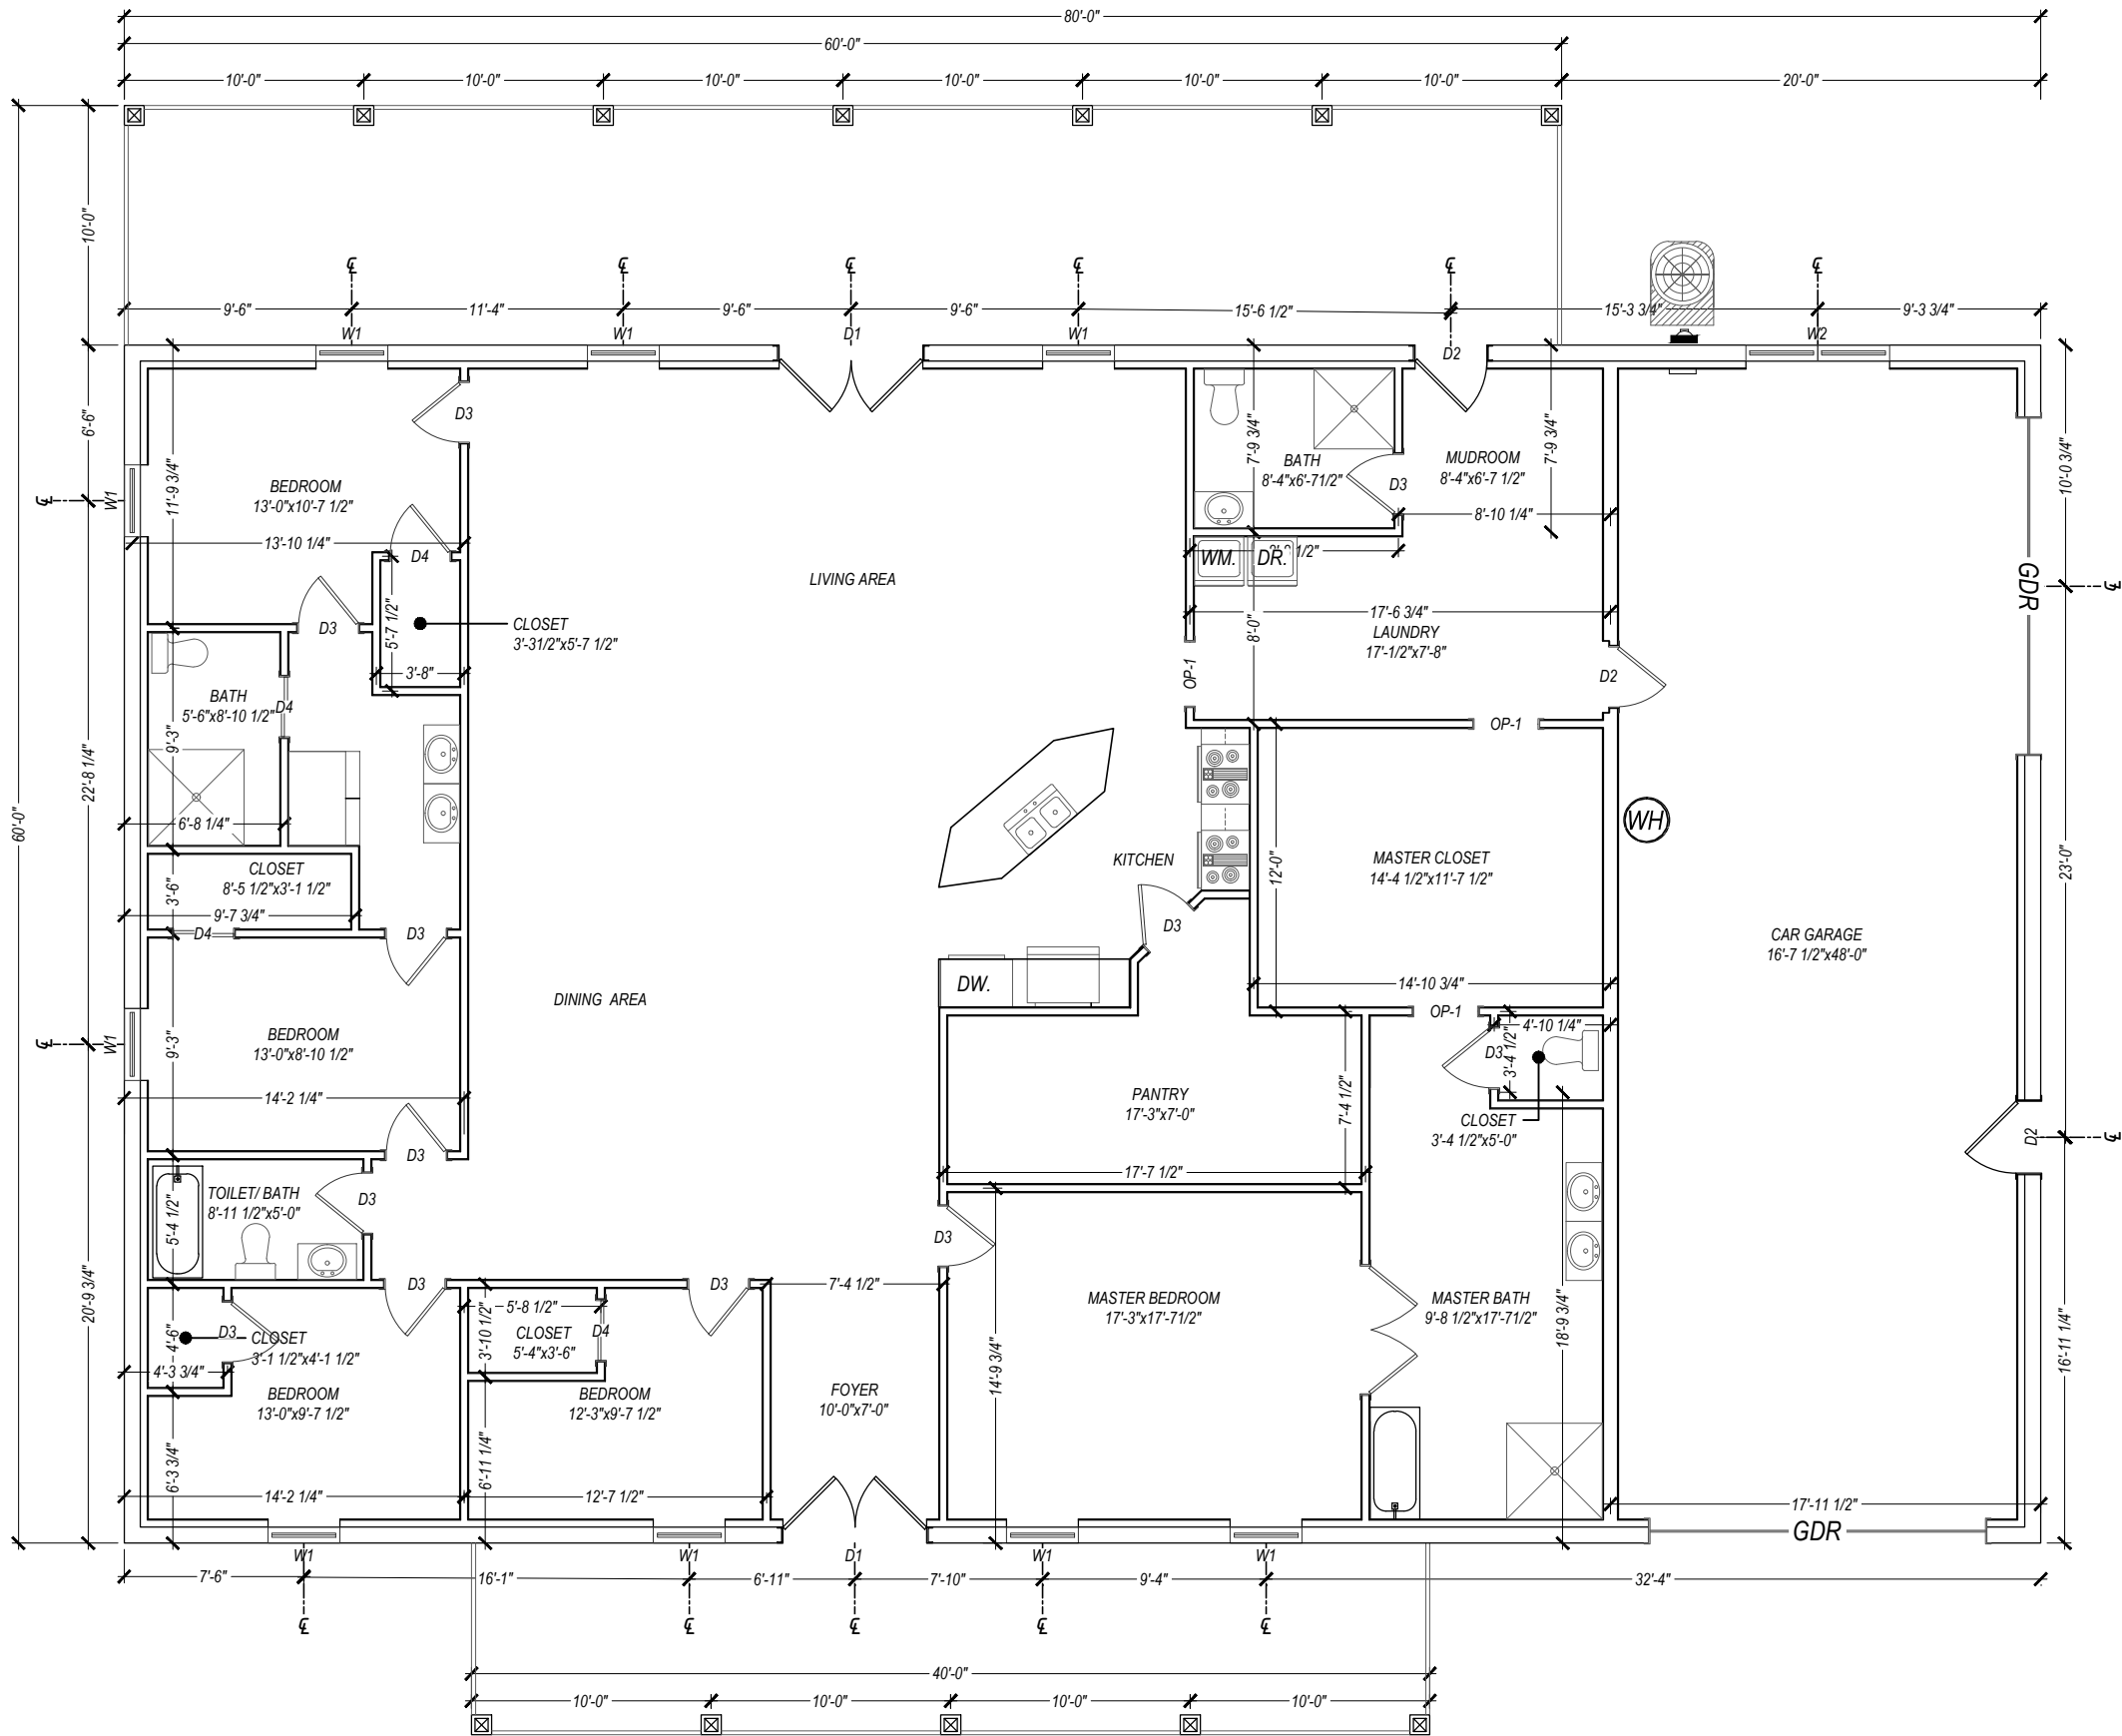

1 FLOOR PLAN
A-100 SCALE: 1/8" = 1'

SCHEDULE OF OPENING			
TYPE	SIZE OF OPENING	REMARKS	QUANTITY IN NOS.
DOORS			
D1	6'-0" x 7'-0"	FRENCH DOOR	2
D2	3'-0" x 7'-0"	EXTERIOR DOOR	2
D3	2'-6" x 7'-0"	INTERIOR DOOR	11
D4	2'-6" x 7'-0"	SLIDING DOOR	5
D5	2'-0" x 7'-0"	SLIDING DOOR	1
GDR	14'-0" x 8'-0"	ROLLING SHUTTER	2
OPENING			
OP-1	2'-8" x 7'-0"	OPENING	3
OP-2	3'-0" x 7'-0"	OPENING	1
WINDOWS			
W1	3'-0" x 6'-0"	WOOD	5
W2	6'-0" x 6'-0"	WOOD	2

NO.	REVISIONS	BY	DATE	DATE	2021.06.08	SUBMITTALS	DATE	PREPARED BY	CLIENT	SHEET TITLE	PROJECT	REVISION NUMBER
			202.06.08	DRAWN	ATC			 POURNELLE COMPANY, LLC P: 386.688.7555 ~ WWW.POURNELLECO.COM	ADAM AND TARA JONES 442 SW TUNSIL ST LAKE CITY, FL 32024	FLOOR PLAN	JONES RESIDENCE	SHEET NO.
				DESIGNED	ATC							A-100
				CHECKED	ATC							
				JOB No.	20.019							

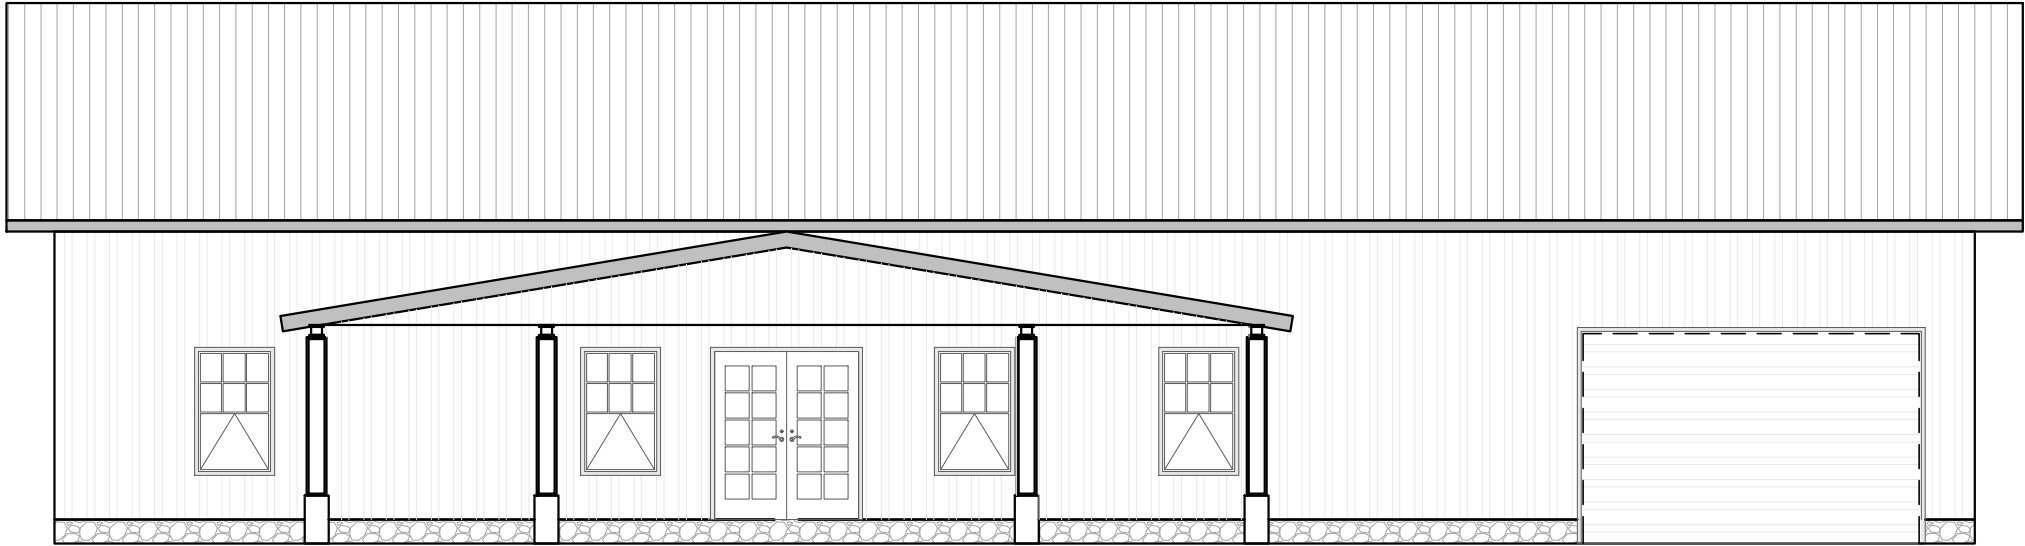

1
A-200

ELEVATION-I
SCALE: 1/8" = 1'




2
A-200

ELEVATION-II
SCALE: 1/8" = 1'


q:\ace - projects\21_019_200-jpc-jones\Cadd\20.019.zPlan-ARCH.dwg, ADAM, 6/9/2021 12:24 PM

NO.	REVISIONS	BY	DATE	DATE	2021.06.08	SUBMITTALS	DATE	PREPARED BY	CLIENT	SHEET TITLE	PROJECT	REVISION NUMBER
				DRAWN	ATC			PCPOURNELLE COMPANY, LLC P: 386.688.7555 ~ WWW.POURNELLECO.COM	ADAM AND TARA JONES 442 SW TUNSIL ST LAKE CITY, FL 32024	ELEVATIONS	JONES RESIDENCE	SHEET NO.
				DESIGNED	ATC							A-200
				CHECKED	ATC							
				JOB No.	20.019							

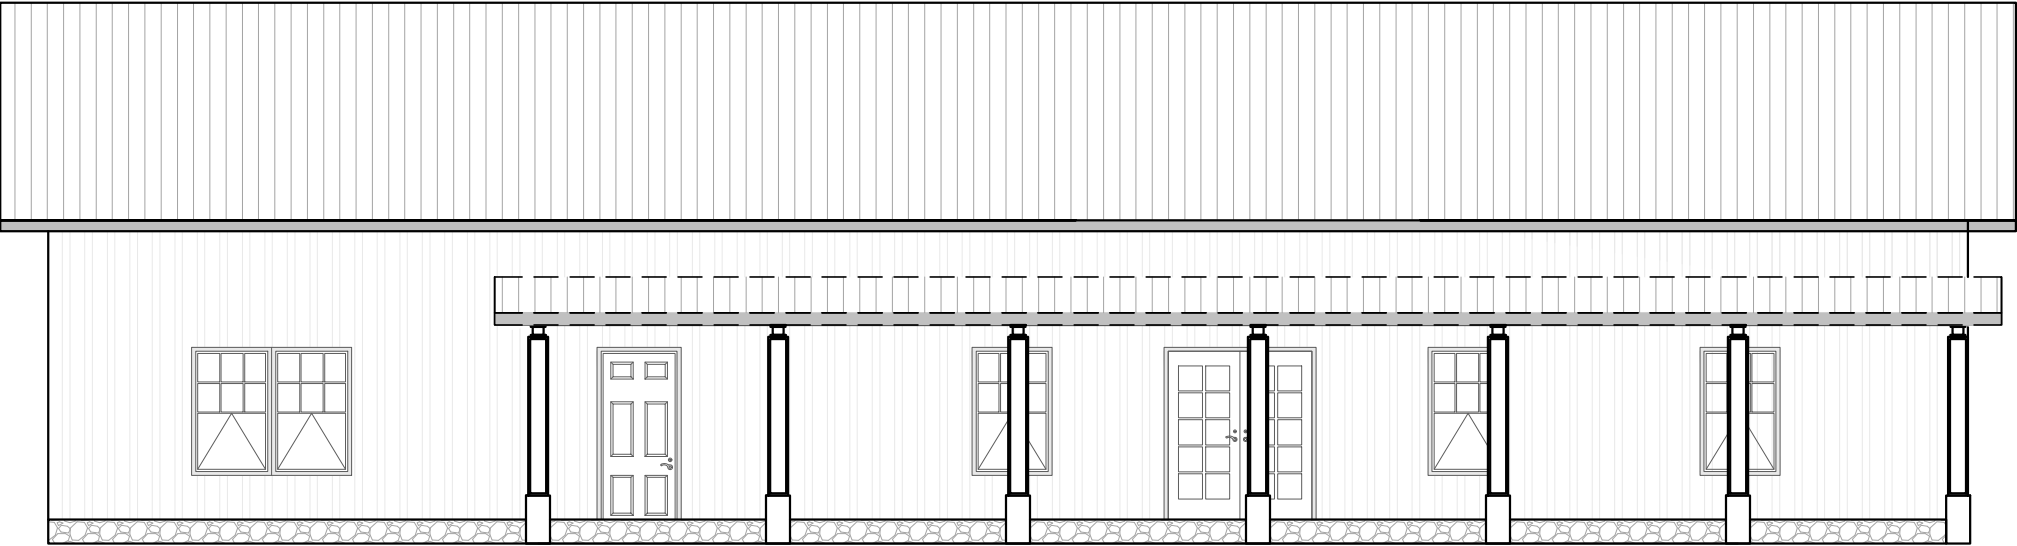

4
A-201

ELEVATION-III
SCALE: 1/8" = 1'

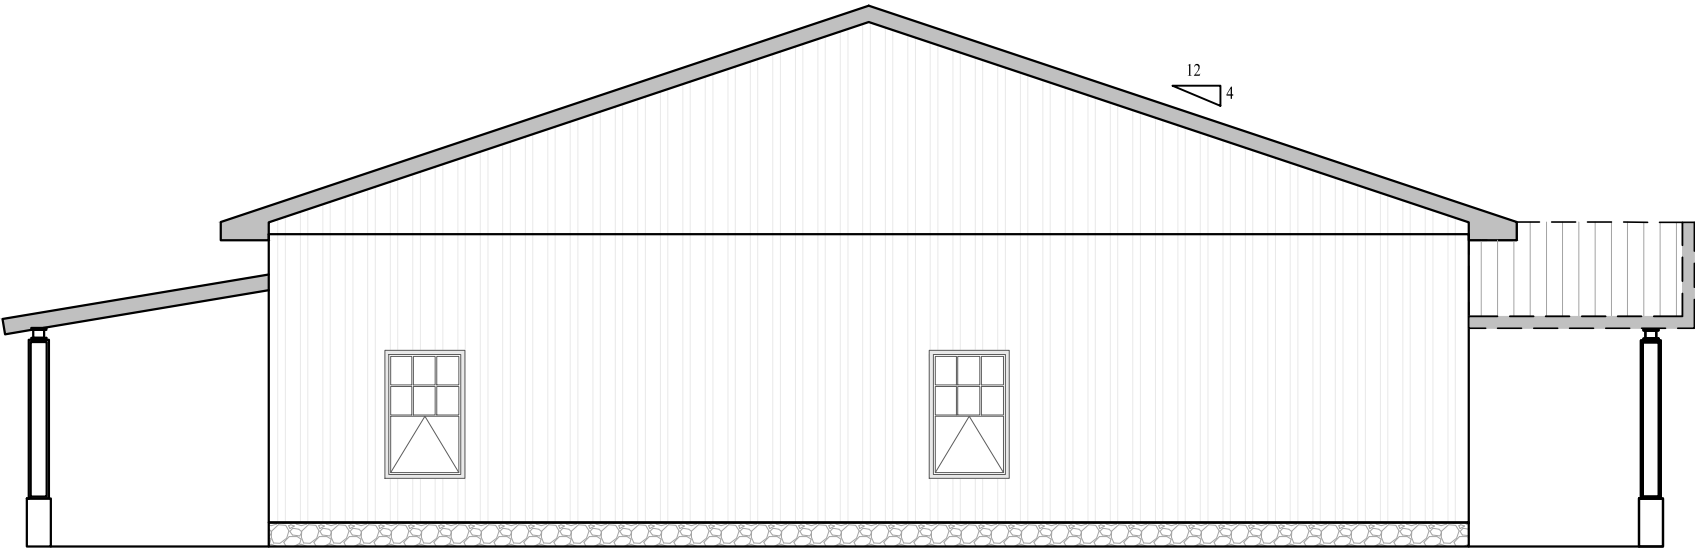

4
A-201

ELEVATION-IV
SCALE: 1/8" = 1'

q:\ace - projects\21_019_200-jpc-jones\Cadd\20.019.zPlan-ARCH.dwg, ADAM, 6/9/2021 12:24 PM

NO.	REVISIONS	BY	DATE	DATE	2021.06.08	SUBMITTALS	DATE	PREPARED BY	CLIENT	SHEET TITLE	PROJECT	REVISION NUMBER
				DRAWN	ATC			 POURNELLE COMPANY, LLC P: 386.688.7555 ~ WWW.POURNELLECO.COM	ADAM AND TARA JONES 442 SW TUNSIL ST LAKE CITY, FL 32024	ELEVATIONS	JONES RESIDENCE	SHEET NO.
				DESIGNED	ATC							A-201
				CHECKED	ATC							
				JOB No.	20.019							

