


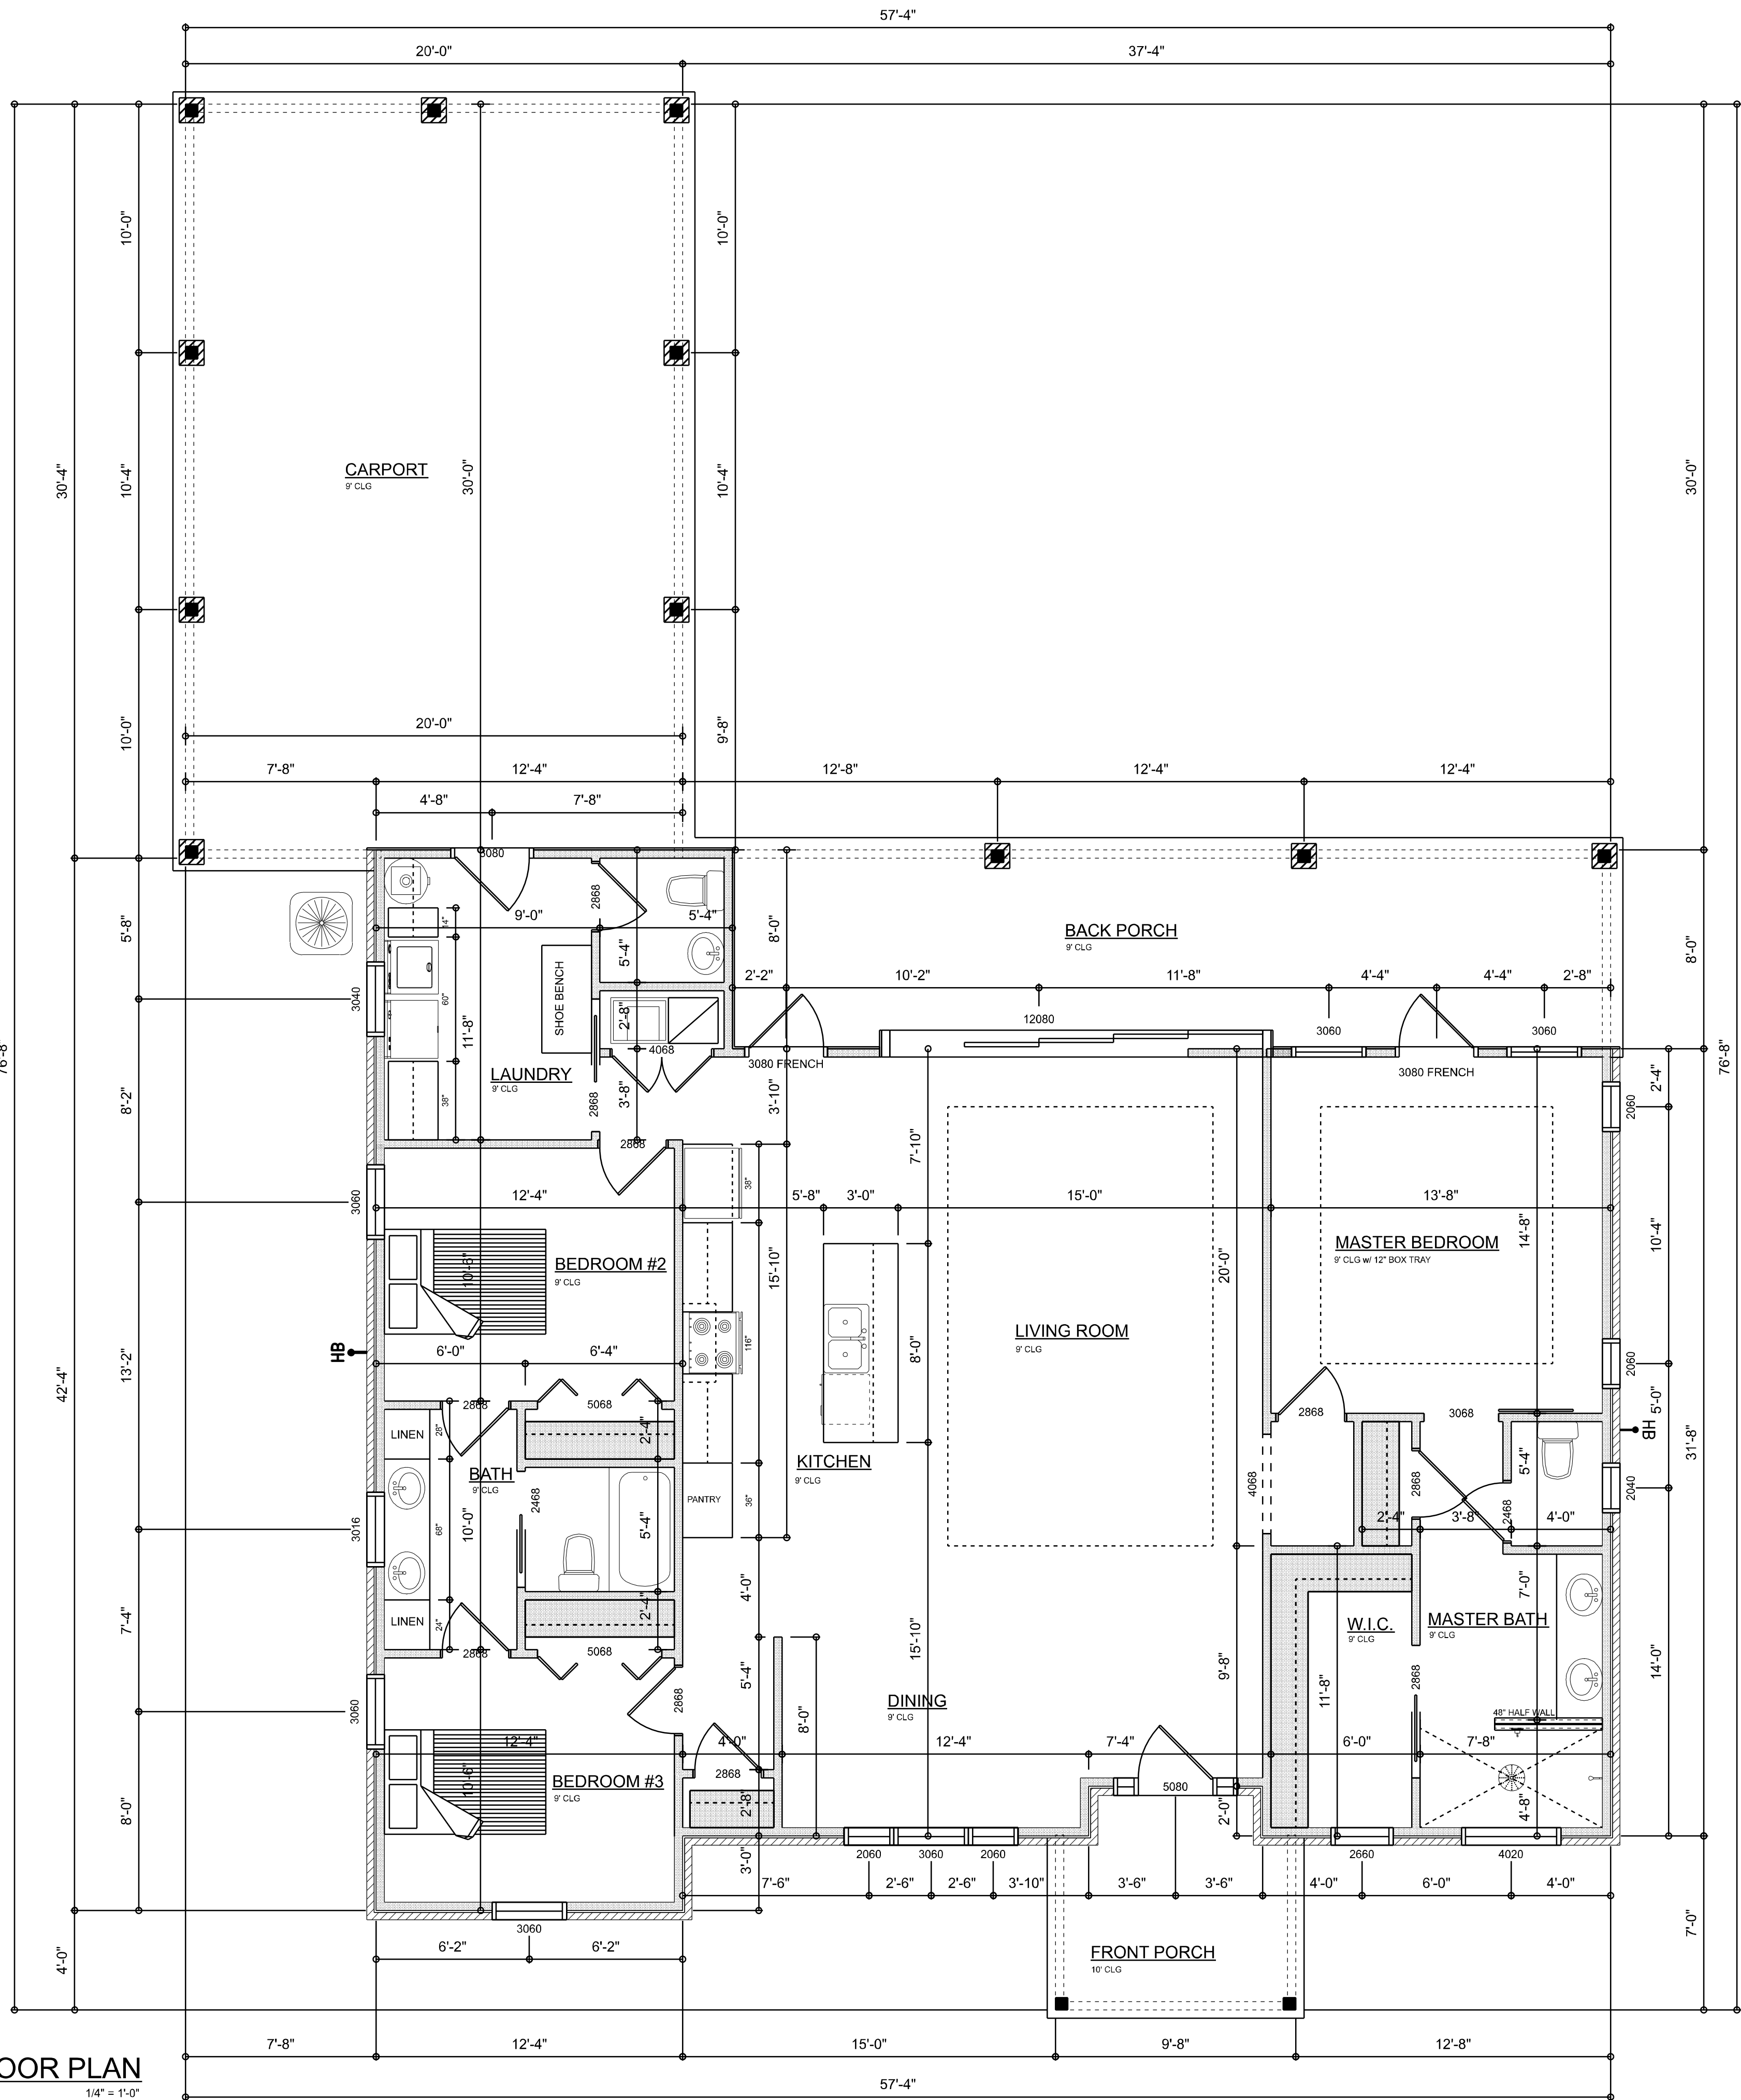

DIMENSIONED FLOOR PLAN

SCALE: 1/4" = 1'-0"

AREA SUMMARY

LIVING	1,710	S.F.
FRONT PORCH	82	S.F.
BACK PORCH	283	S.F.
CARPORT	600	S.F.

TOTAL AREA 2,675 S.F.

TOTAL CUBIC FOOTAGE OF CONDITIONED SPACE IS: 15,674

REVISIONS SCHEDULE	
March 26th, 2020	PERMIT DRAWINGS

William Residence

Columbia County, Florida

Bryan Zecher Homes

465 NW Orange St, Lake City, FL 32055

RIDGEPOINT
DESIGN

818 WEST DUVAL STREET, LAKE CITY, FLORIDA 32055
P: 386-288-1188
E: RIDGEPOINTDESIGN@GMAIL.COM

SHEET NUMBER

A.3

OF 4 SHEETS




REVISIONS SCHEDULE	
March 26th, 2020	PERMIT DRAWINGS


William Residence
Columbia County, Florida

Bryan Zecher Homes
465 NW Orange St, Lake City, FL 32055

**RIDGEPOINT
DESIGN**
818 WEST DUVAL STREET, LAKE CITY, FLORIDA 32085
P: 386-288-1188
E: RIDGEPOINTDESIGN@GMAIL.COM

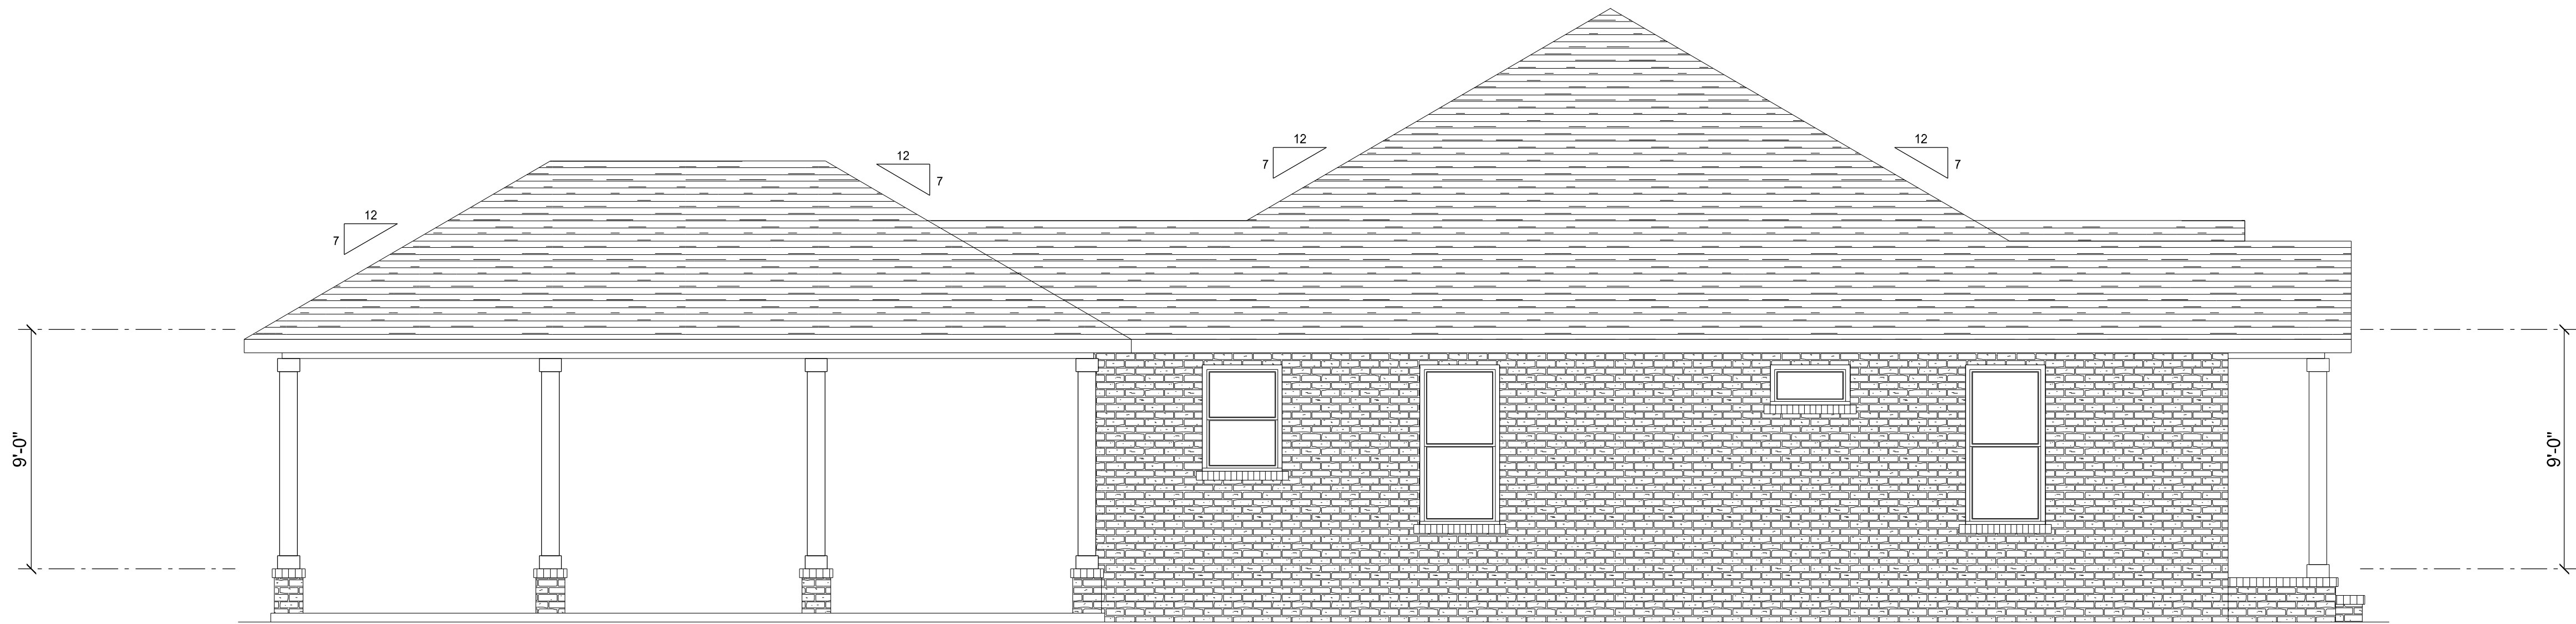


LEFT ELEVATION
SCALE: 1/4" = 1'-0"

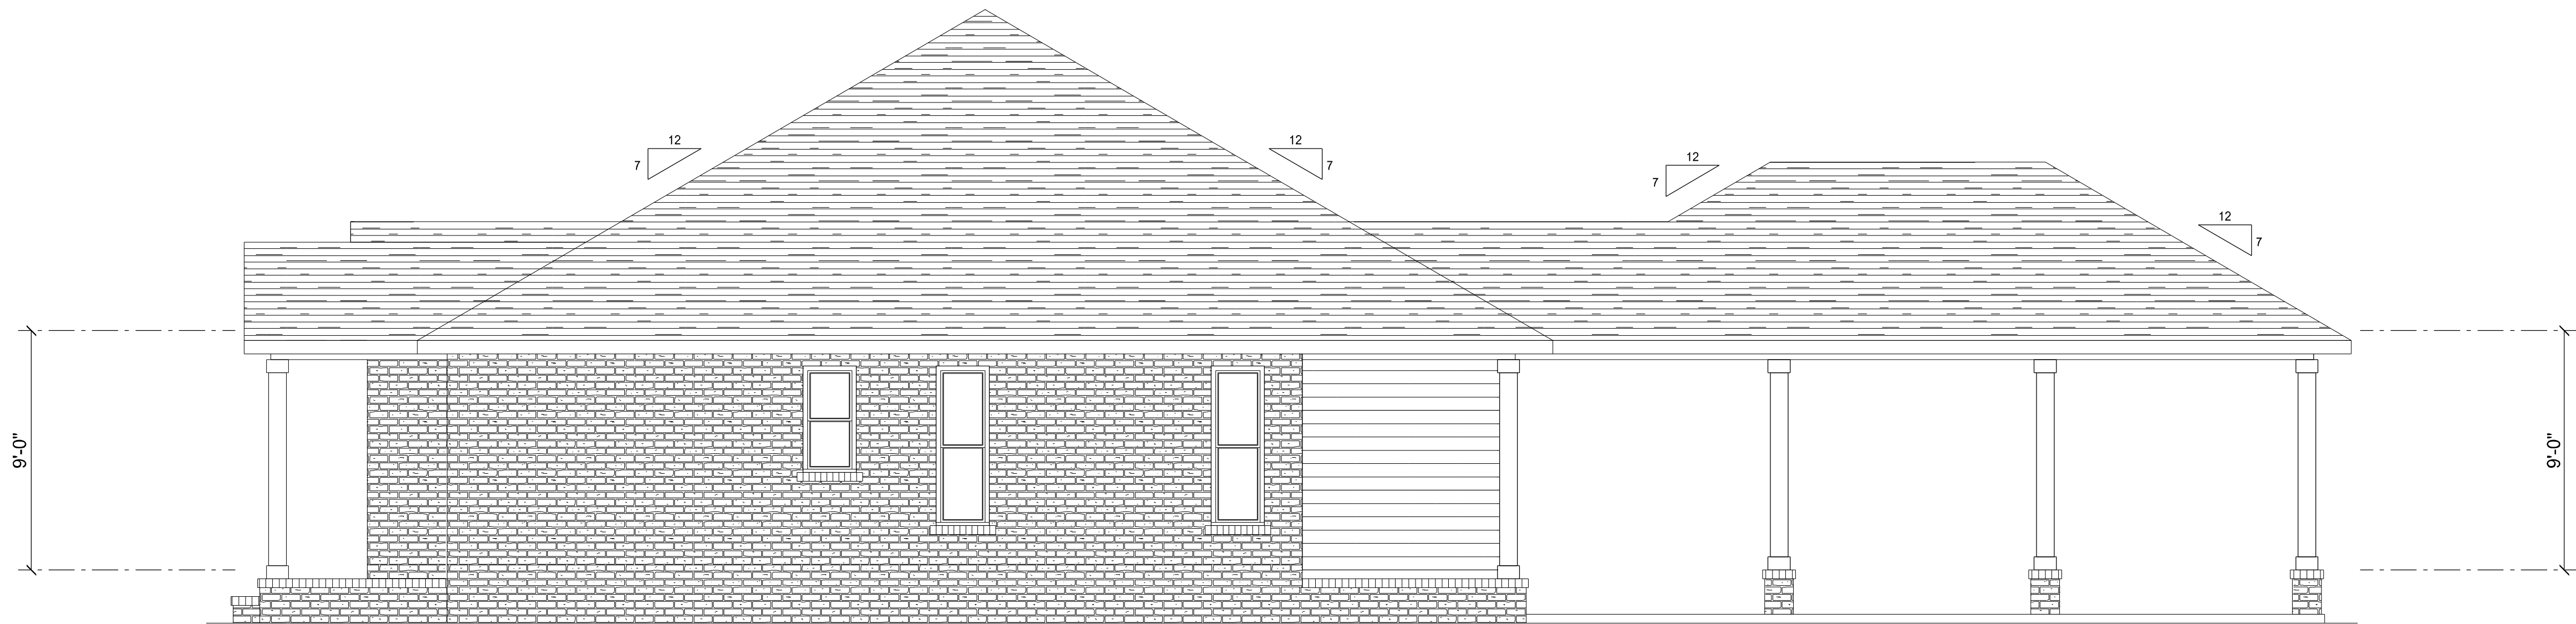

RIGHT ELEVATION
SCALE: 1/4" = 1'-0"

REVISIONS SCHEDULE	
March 26th, 2020	PERMIT DRAWINGS



William Residence
Columbia County, Florida
Bryan Zecher Homes
465 NW Orange St, Lake City, FL 32055

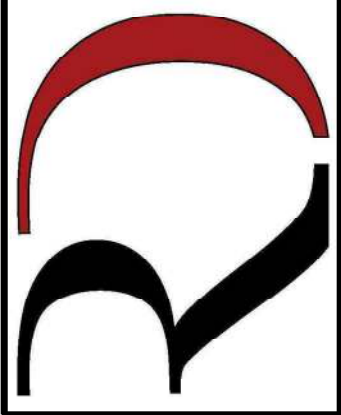

RIDGEPOINT

DESIGN

 818 WEST DUVAL STREET, LAKE CITY, FLORIDA 32055
P: 386-288-1188
E: RIDGEPOINTDESIGN@GMAIL.COM

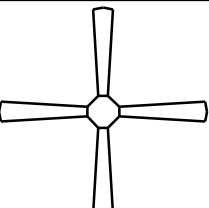ELECTRICAL LEGEND		
ELECTRICAL	COUNT	SYMBOL
CEILING FAN	6	
CAN LIGHT 6inch	23	
CHANDELIER	2	
LED CEILING LIGHT 1x4	6	
PENDANT LIGHT	2	
EXTERIOR SCONCE	1	
MOTION SECURITY LIGHT	5	
CABLE TV OUTLET	5	
EXHAUST FAN	1	
EXHAUST FAN & LIGHT COMBO	3	
FLOOR OULET DUPLEX	2	
OUTLET	32	
OUTLET 220v	4	
OUTLET GFI	8	
OUTLET WP	8	
SMOKE DETECTOR	5	
STANDARD LIGHT	4	
SWITCH	18	
SWITCH 3 WAY	22	
VANITY BAR LIGHT - SMALL	1	

ELECTRICAL PLAN NOTES:

INSTALLATION SHALL BE PER 2011 NAT'L ELECTRIC CODE.

WIRE ALL APPLIANCES, HVAC UNITS AND OTHER EQUIPMENT PER MANUF. SPECIFICATIONS

CONSULT WITH THE OWNER FOR THE NUMBER OF SEPERATE TELEPHONE LINES TO BE INSTALLED

ALL SMOKE DETECTORS SHALL BE 120v W/ BATTERY BACKUP OF THE PHOTOELECTRIC TYPE, AND SHALL BE INTERLOCKED TOGETHER. INSTALL INSIDE AND NEAR ALL BEDROOMS


TELEPHONE, TELEVISION AND OTHER LOW VOLTAGE DEVICES OR OUTLETS SHALL BE AS PER THE OWNER'S DIRECTIONS, & IN ACCORDANCE W/ APPLICABLE SECTIONS OF NEC-LATEST EDITION.

ALL RECEPTICALS, NOT OTHERWISE NOTED, SHALL BE ARC FAULT INTERRUPTER TYPE, EXCEPT DEDICATED OUTLETS

ALL RECEPTICALS IN WET AREAS SHALL BE GROUND FAULT INTERRUPTER TYPE (GFI)


ALL EXTERIOR RECEPTICALS SHALL BE WEATHERPROOF GROUD FAULT INTERRUPTER TYPE (WP/GFI)

NOTE:
ELECTRICAL CONT'R SHALL PREPARE "AS-BUILT" SHOP DWGS INDICATING ALL ELECTRICAL WORK, INCLUDING ANY CHANGES TO THE ELEC. PLAN, ADD'NS TO THE ELEC. PLAN, RISER DIAGRAM, AS-BUILT PANEL SCHEDULE W/ ALL CKTS IDENTIFIED W/ CKT Nr. DESCRIPTION & BRKR, SERVICE ENT. & ALL UNDERGROUND WIRE LOCATIONS/ROUTING / DEPTH. RISER DIA. SHALL INCLUDE WIRE SIZES/TYPE & EQUIPMENT TYPE W/ RATINGS & LOADS. CONTRACTOR SHALL PROVIDE 1 COPY OF AS-BUILT DWGS TO OWNER & 1 COPY TO THE PERMIT ISSUING AUTHORITY

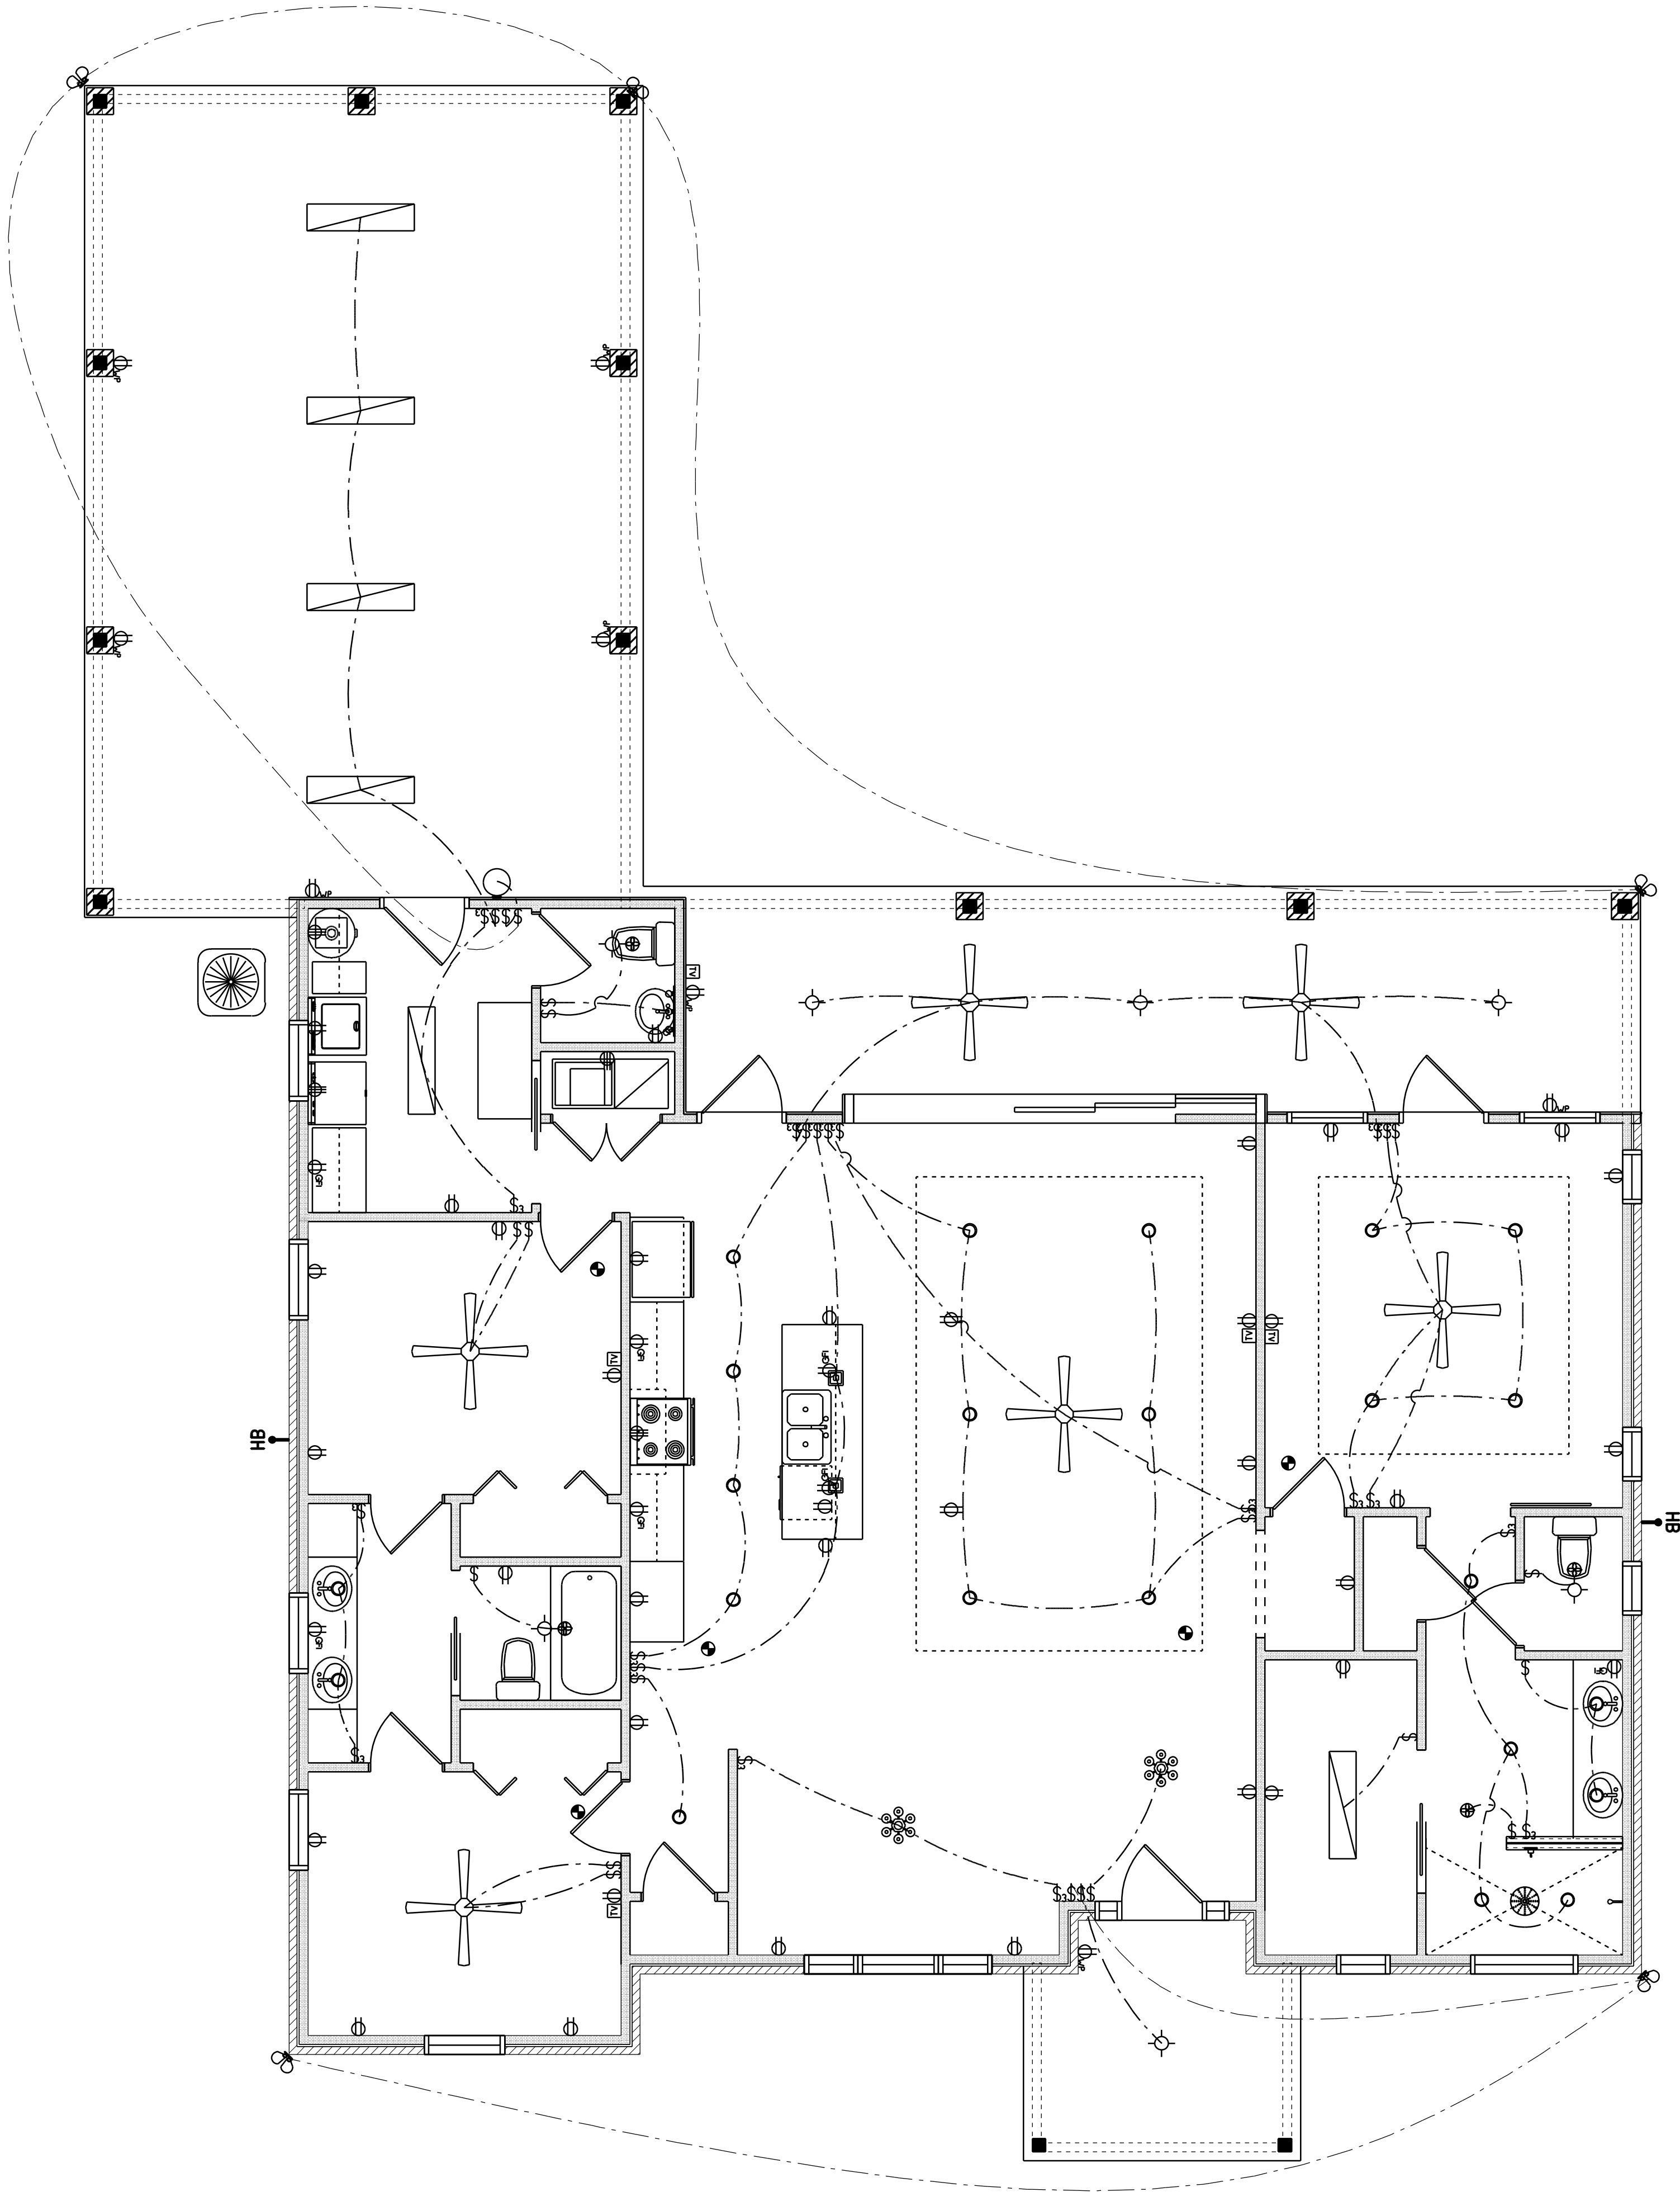

REVISIONS SCHEDULE	
March 26th, 2020	PERMIT DRAWINGS

William Residence
Columbia County, Florida
Bryan Zecher Homes
465 NW Orange St, Lake City, FL 32055

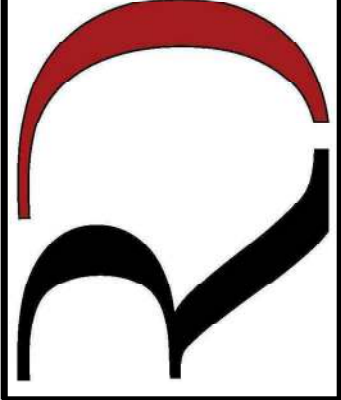

**RIDGEPOINT
DESIGN**

818 WEST DUVAL STREET, LAKE CITY, FLORIDA 32055
P: 386-288-1188
E: RIDGEPOINTDESIGN@GMAIL.COM

SHEET NUMBER
A.4
OF 4 SHEETS