

口
く
カ

Aaron & Lisa Butler

Electrical PLAN



DAVID J. ROYAL
ARCHITECTURAL DESIGNER
Branford, Florida • 386-365-2391

**NICHOLAS
PAUL
GEISLER
ARCHITECT**
N.C.A.R.B. Certified

1758 NW Brown Rd.
Lake City, FL 32055
386-365-4355

DATE: 09/22/2023


COM:

SHEET:

 $\frac{\Delta}{\sqrt{t}}$
$$\frac{\mathcal{O}}{\mathcal{O}}$$

Electricity Symbols

- ① 5PST WALL SWITCH
 - ② DPDT WALL SWITCH (3-WAY)
 - ③ DUPLEX WALL RECEPTACLE
 - ④ DUPLEX WALL RECEPT., BELOW COUNTER
 - ⑤ 240V OUTLET
 - ⑥ GND FAULT INTERRUPTER DUPLEX RECEPT.
 - ⑦ WEATHER PROOF GFI DUPLEX RECEPT.
 - ⑧ ARC FAULT INTERRUPTER DUPLEX RECEPT.
 - ⑨ DUPLEX WALL RECEPTACLE, 1/2 SWITCHED
 - ⑩ MOTOR
 - ⑪ ELECTRICAL PANEL
 - ⑫ EXHAUST FAN / LIGHT
 - ⑬ EXHAUST FAN
 - ⑭ DBL. LAMP INC. FLOOD LIGHT
 - ⑮ LED LIGHT FIXTURE
 - ⑯ SMOKE DETECTOR, 120V
 - ⑰ CHIME
 - ⑱ MOMENTARY PUSHBUTTON SWITCH, LIGHTED
 - ⑲ SWITCH/FIXTURE WIRING
 - ⑳ CONTROL WIRE - LOW VOLTAGE
 - ㉑ NON-FUSED DISC. SWITCH
 - ㉒ TELEPHONE
 - ㉓ TELEVISION OUTLET
 - ㉔ HVAC THERMOSTAT, @ 60° AFF
 - ㉕ CEILING FAN, W/ INC. LIGHT FIXTURE
 - ㉖ RECESSED LED LIGHT FIXTURE
 - ㉗ RECESSED LED LIGHT FIXTURE, WATERPROOF
 - ㉘ PENDANT LED LIGHT FIXTURE
 - ㉙ 2 TUBE LED FRIGIDATIC WARM SURFACE FIXTURE
 - ㉚ 500MM MTD. GFI SWITCHED RECEPT. FOR CHRISTMAS LIGHTS

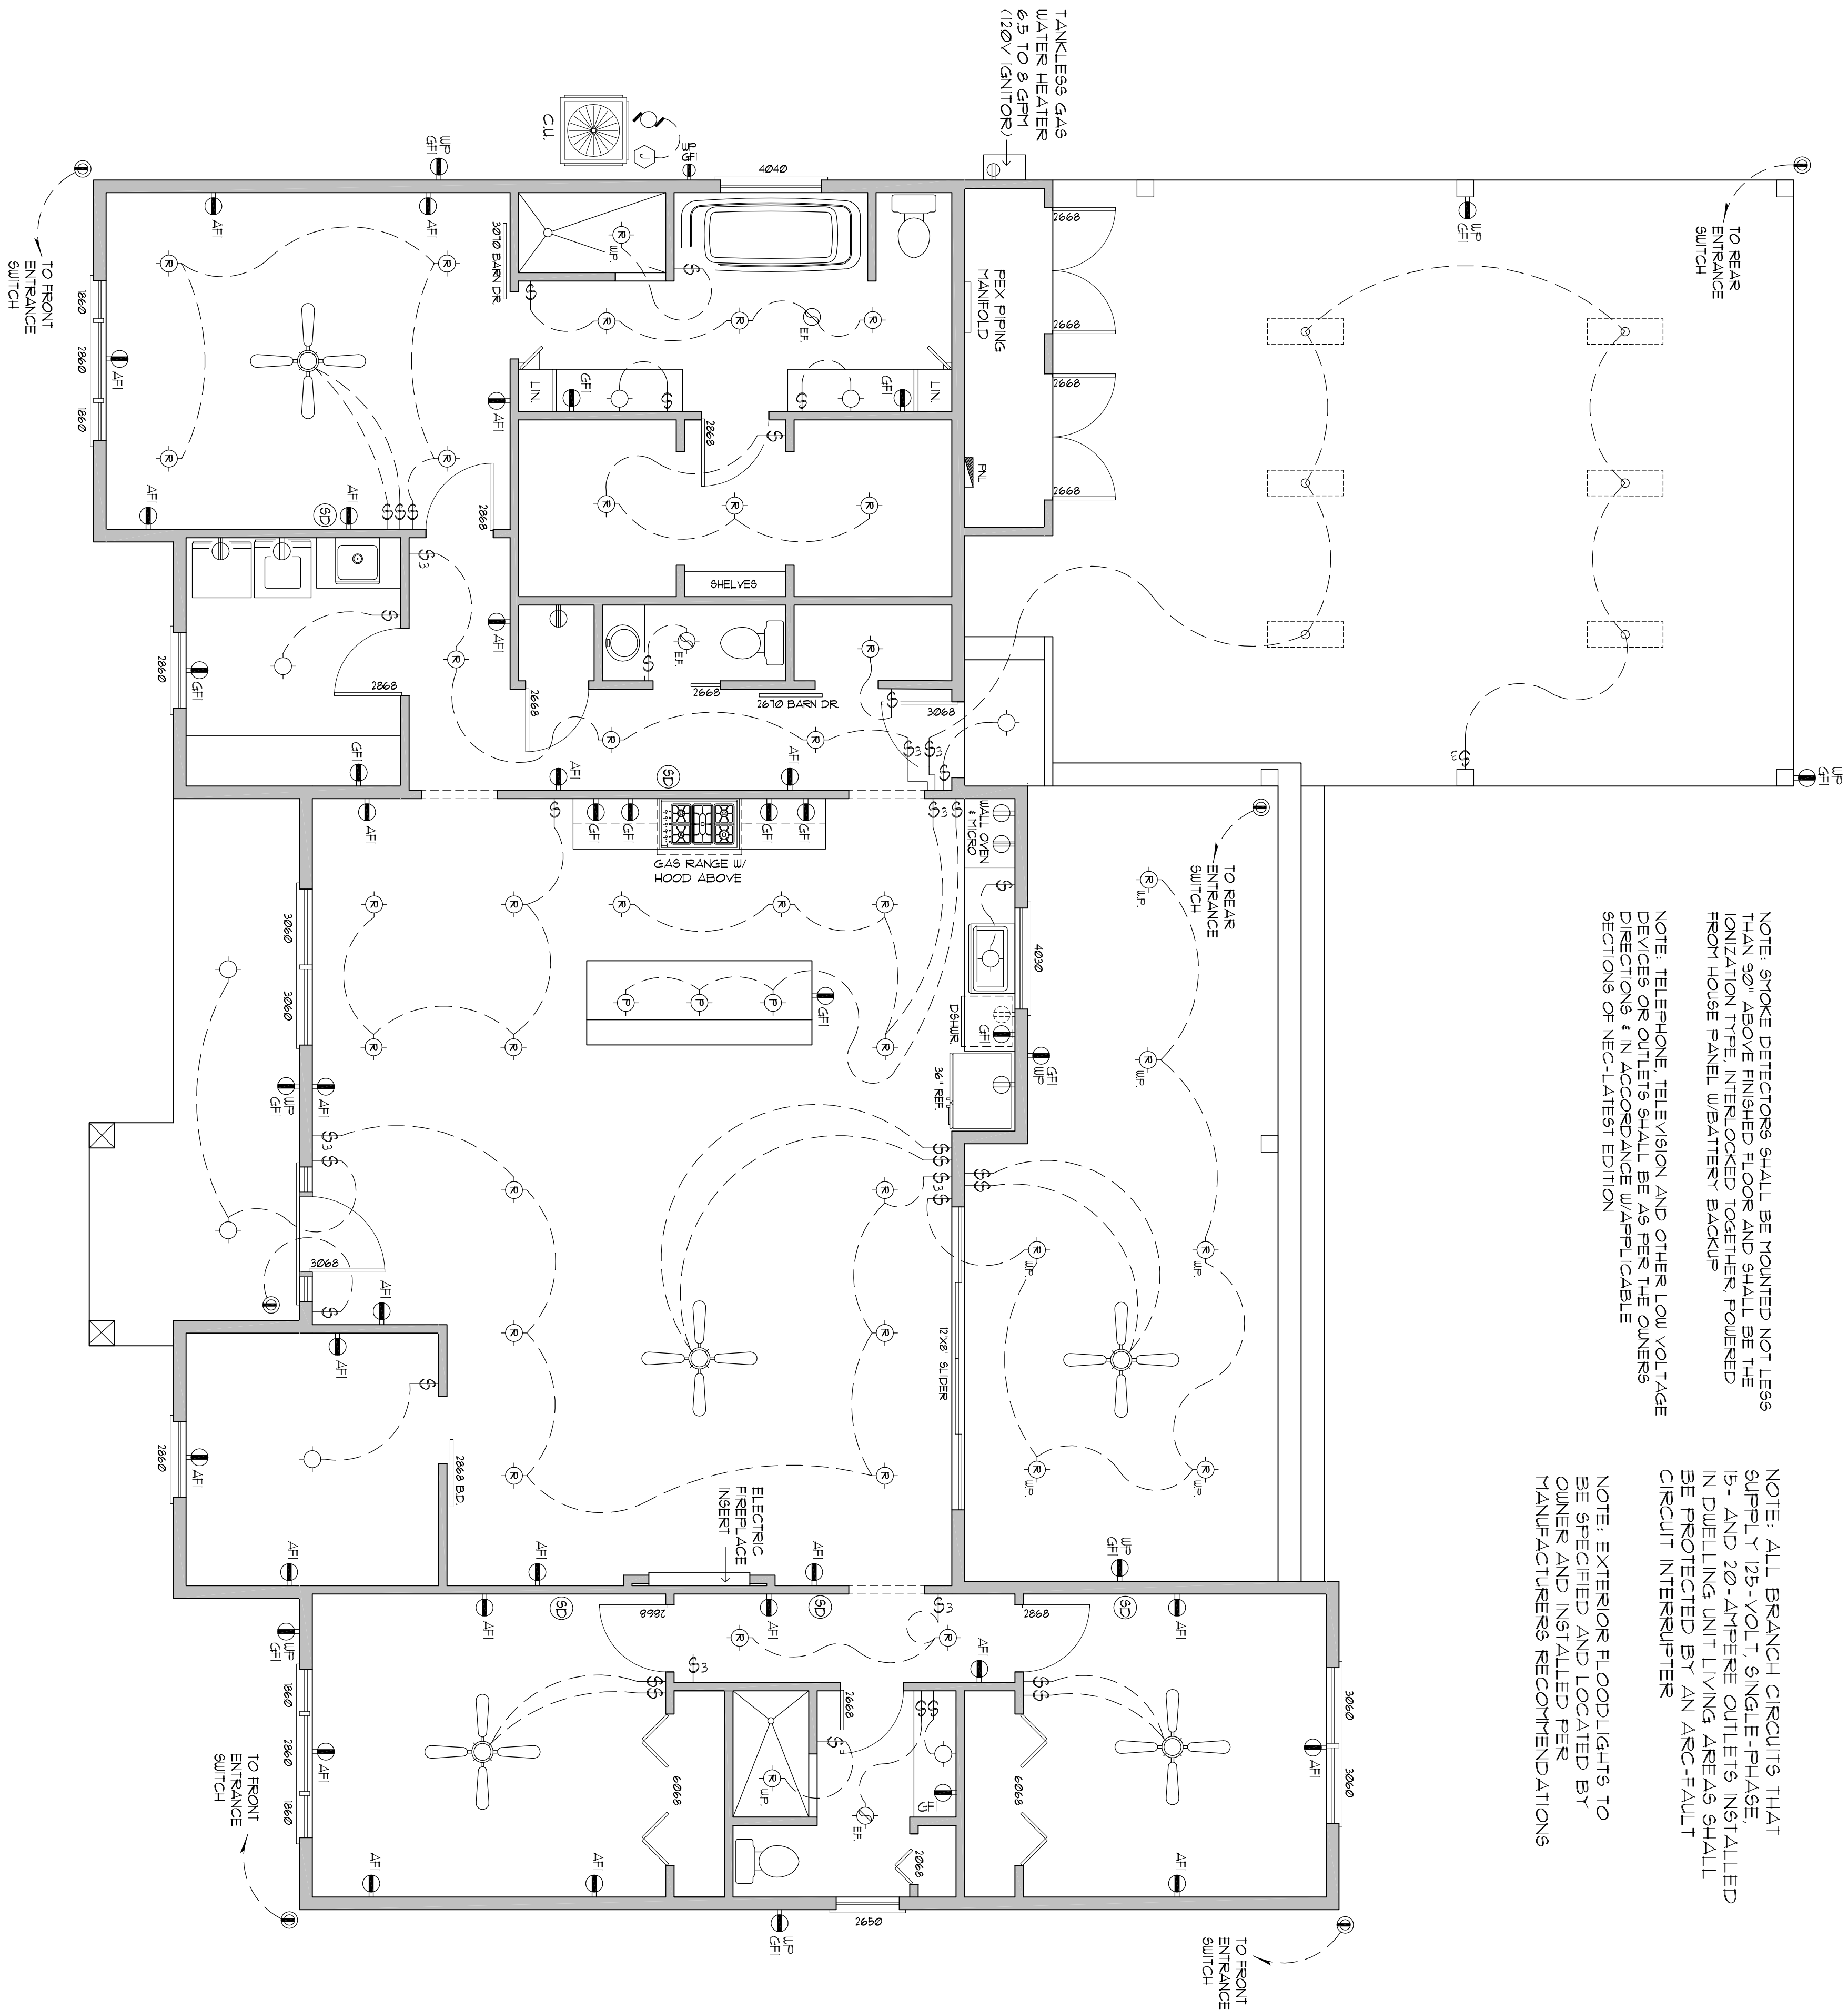

III — O O r r — O B — U T A Z

SCALE : 1/4" = 1'-0"

Digitally signed by: N. P. GEISLER
DN: CN = N. P. GEISLER C = US
O = AR0007005 OU = ARCHITECT
Date: 2023.09.14 14:15:00 -05'00'

AR0007005