

Note:
These Plans Shall Conform to
the 2017 Florida Building Code
(Sixth Edition) and all Local
Ordinances

It is the Responsibility of the
Builder to verify all Dimensions
and Roof Slopes Prior to
Construction

CEM

DESIGNED BY:

TRAVIS & LOGAN HART

THE HART RESIDENCE

COLUMBIA COUNTY, FL

PROJECT NAME:

REVISION: 02-22-2020/001
03-15-2020/002
03-27-2020/003
03-31-2020/004

DATE: APR - 30 - 2020

FILE #: 2417/3649T.HART



All
Structural
See
Wind load
Analysis !!


FRJ - 39'
Cory - 39'

FLOOR PLAN

1/4" = 1'-0"

HEATED AREA	=	2417 SQ. FT.
CARPORT	=	608 SQ. FT.
FRONT PORCH	=	348 SQ. FT.
REAR PORCH	=	276 SQ. FT.
TOTAL AREA	=	3649 SQ. FT.

1

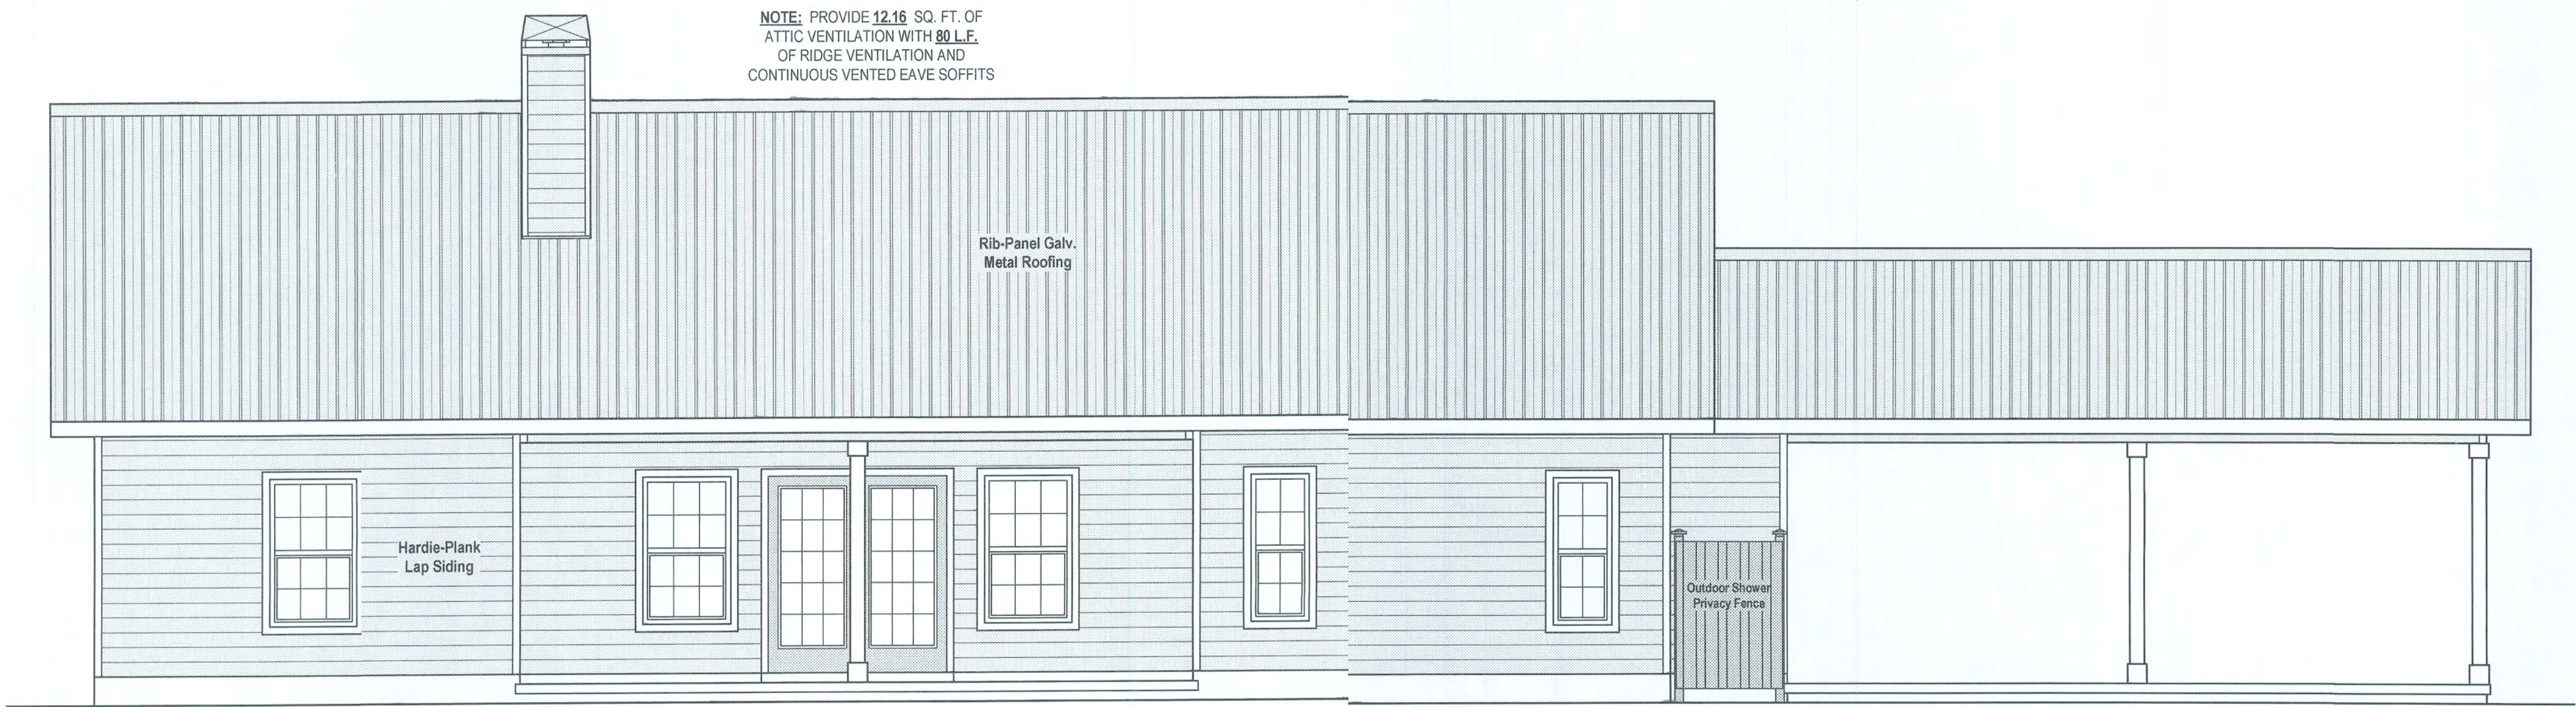

REAR ELEVATION
1/4" = 1'-0"



FRONT ELEVATION
1/4" = 1'-0"

Note:
These Plans Shall Conform to
the 2017 Florida Building Code
(Sixth Edition) and all Local
Ordinances

It is the Responsibility of the
Builder to Verify all Dimensions
and Roof Shapes Prior to
Construction

DRAWN BY:
CEM

DESIGNED BY:
TRAVIS & LOGAN HART

PROJECT NAME:
THE HART RESIDENCE
COLUMBIA COUNTY, FL

REVISION:
02-22-2020/001
03-15-2020/002
03-27-2020/003
03-21-2021/004

DATE:
APR - 30 - 2020

FILE #:
2417/3649T.HART

Note:
These Plans Shall Conform to
the 2017 Florida Building Code
(Sixth Edition) and all Local
Ordinances

It is the Responsibility of the
Builder to verify all Dimensions
and Roof Slopes Prior to
Construction

DRAWN BY:	CEM
DESIGNED BY:	TRAVIS & LOGAN HART

THE HART RESIDENCE

COLUMBIA COUNTY, FL



PROJECT NAME:

REVISION: 02-22-2020/001
03-15-2020/002
03-27-2020/003
03-31-2020/004

DATE: APR - 30 - 2020


FILE #: 2417/3649T.HART

3

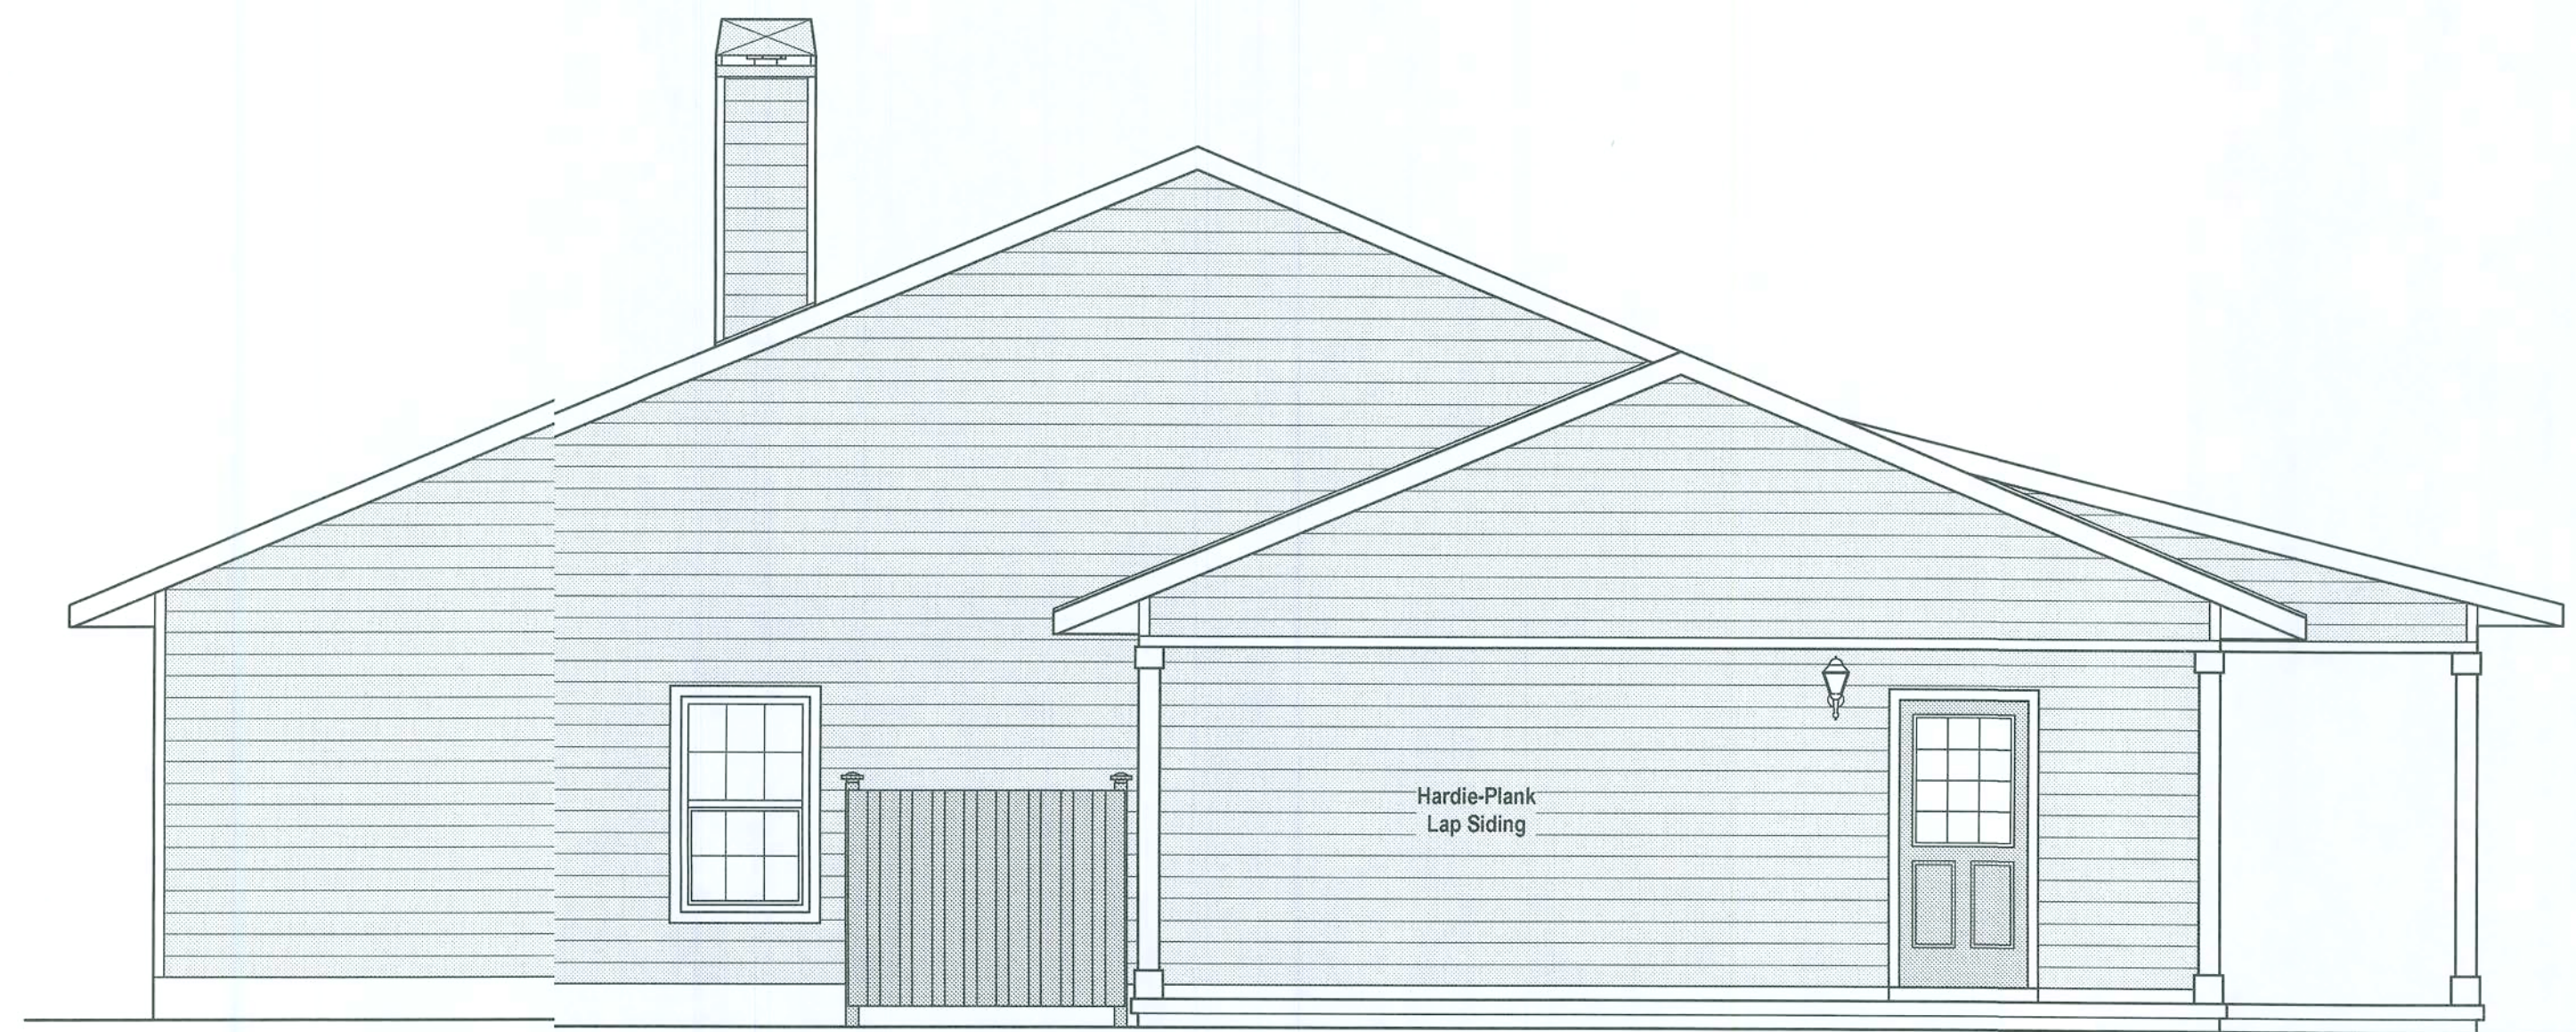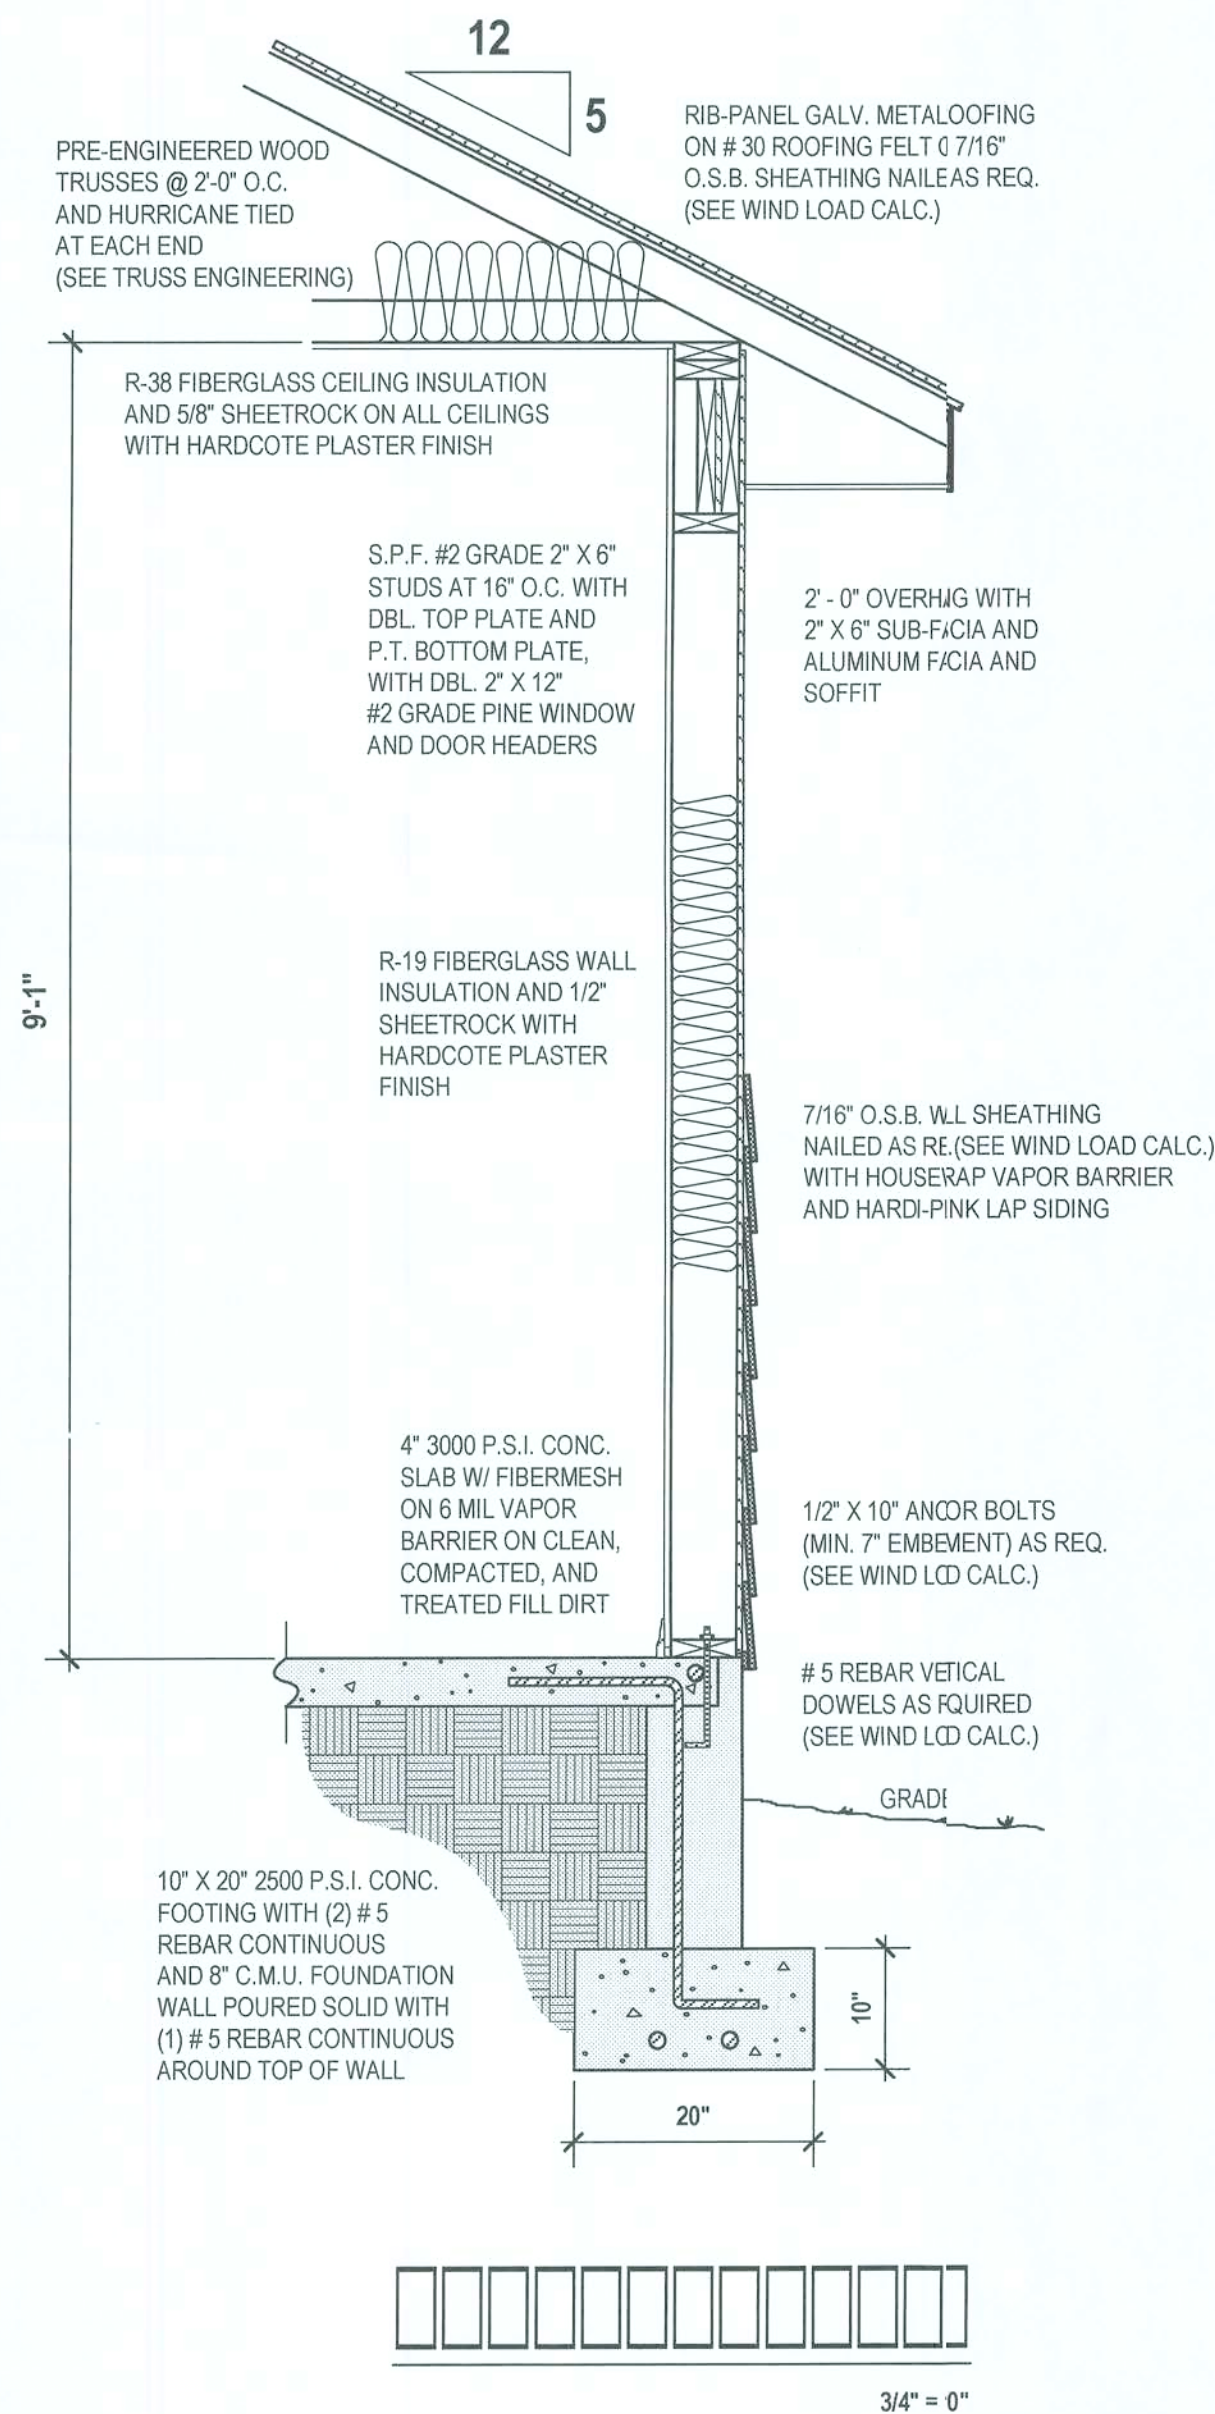


LEFT SIDE ELEVATION

1/4" = 1'-0"

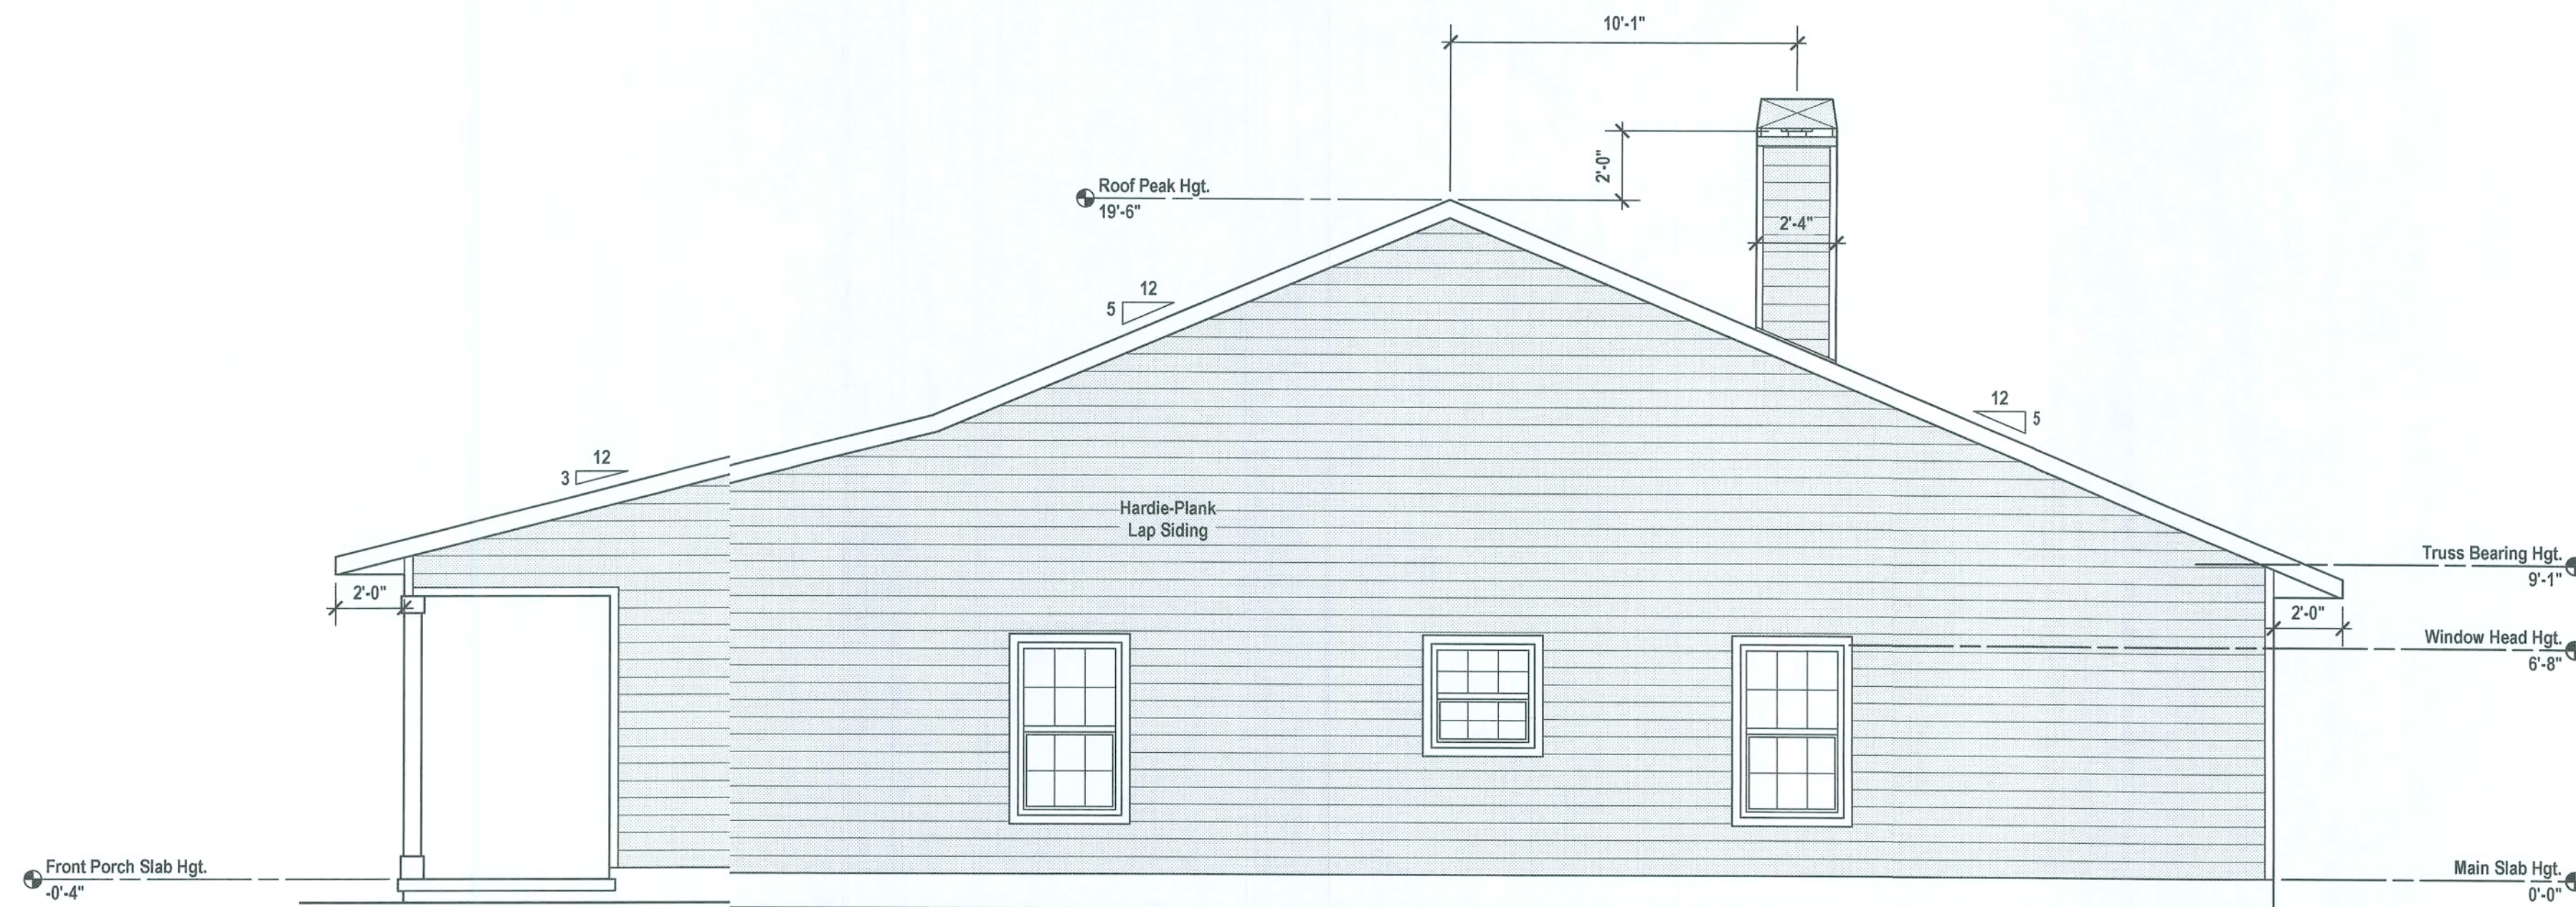

RIGHT SIDE ELEVATION

1/4" = 1'-0"

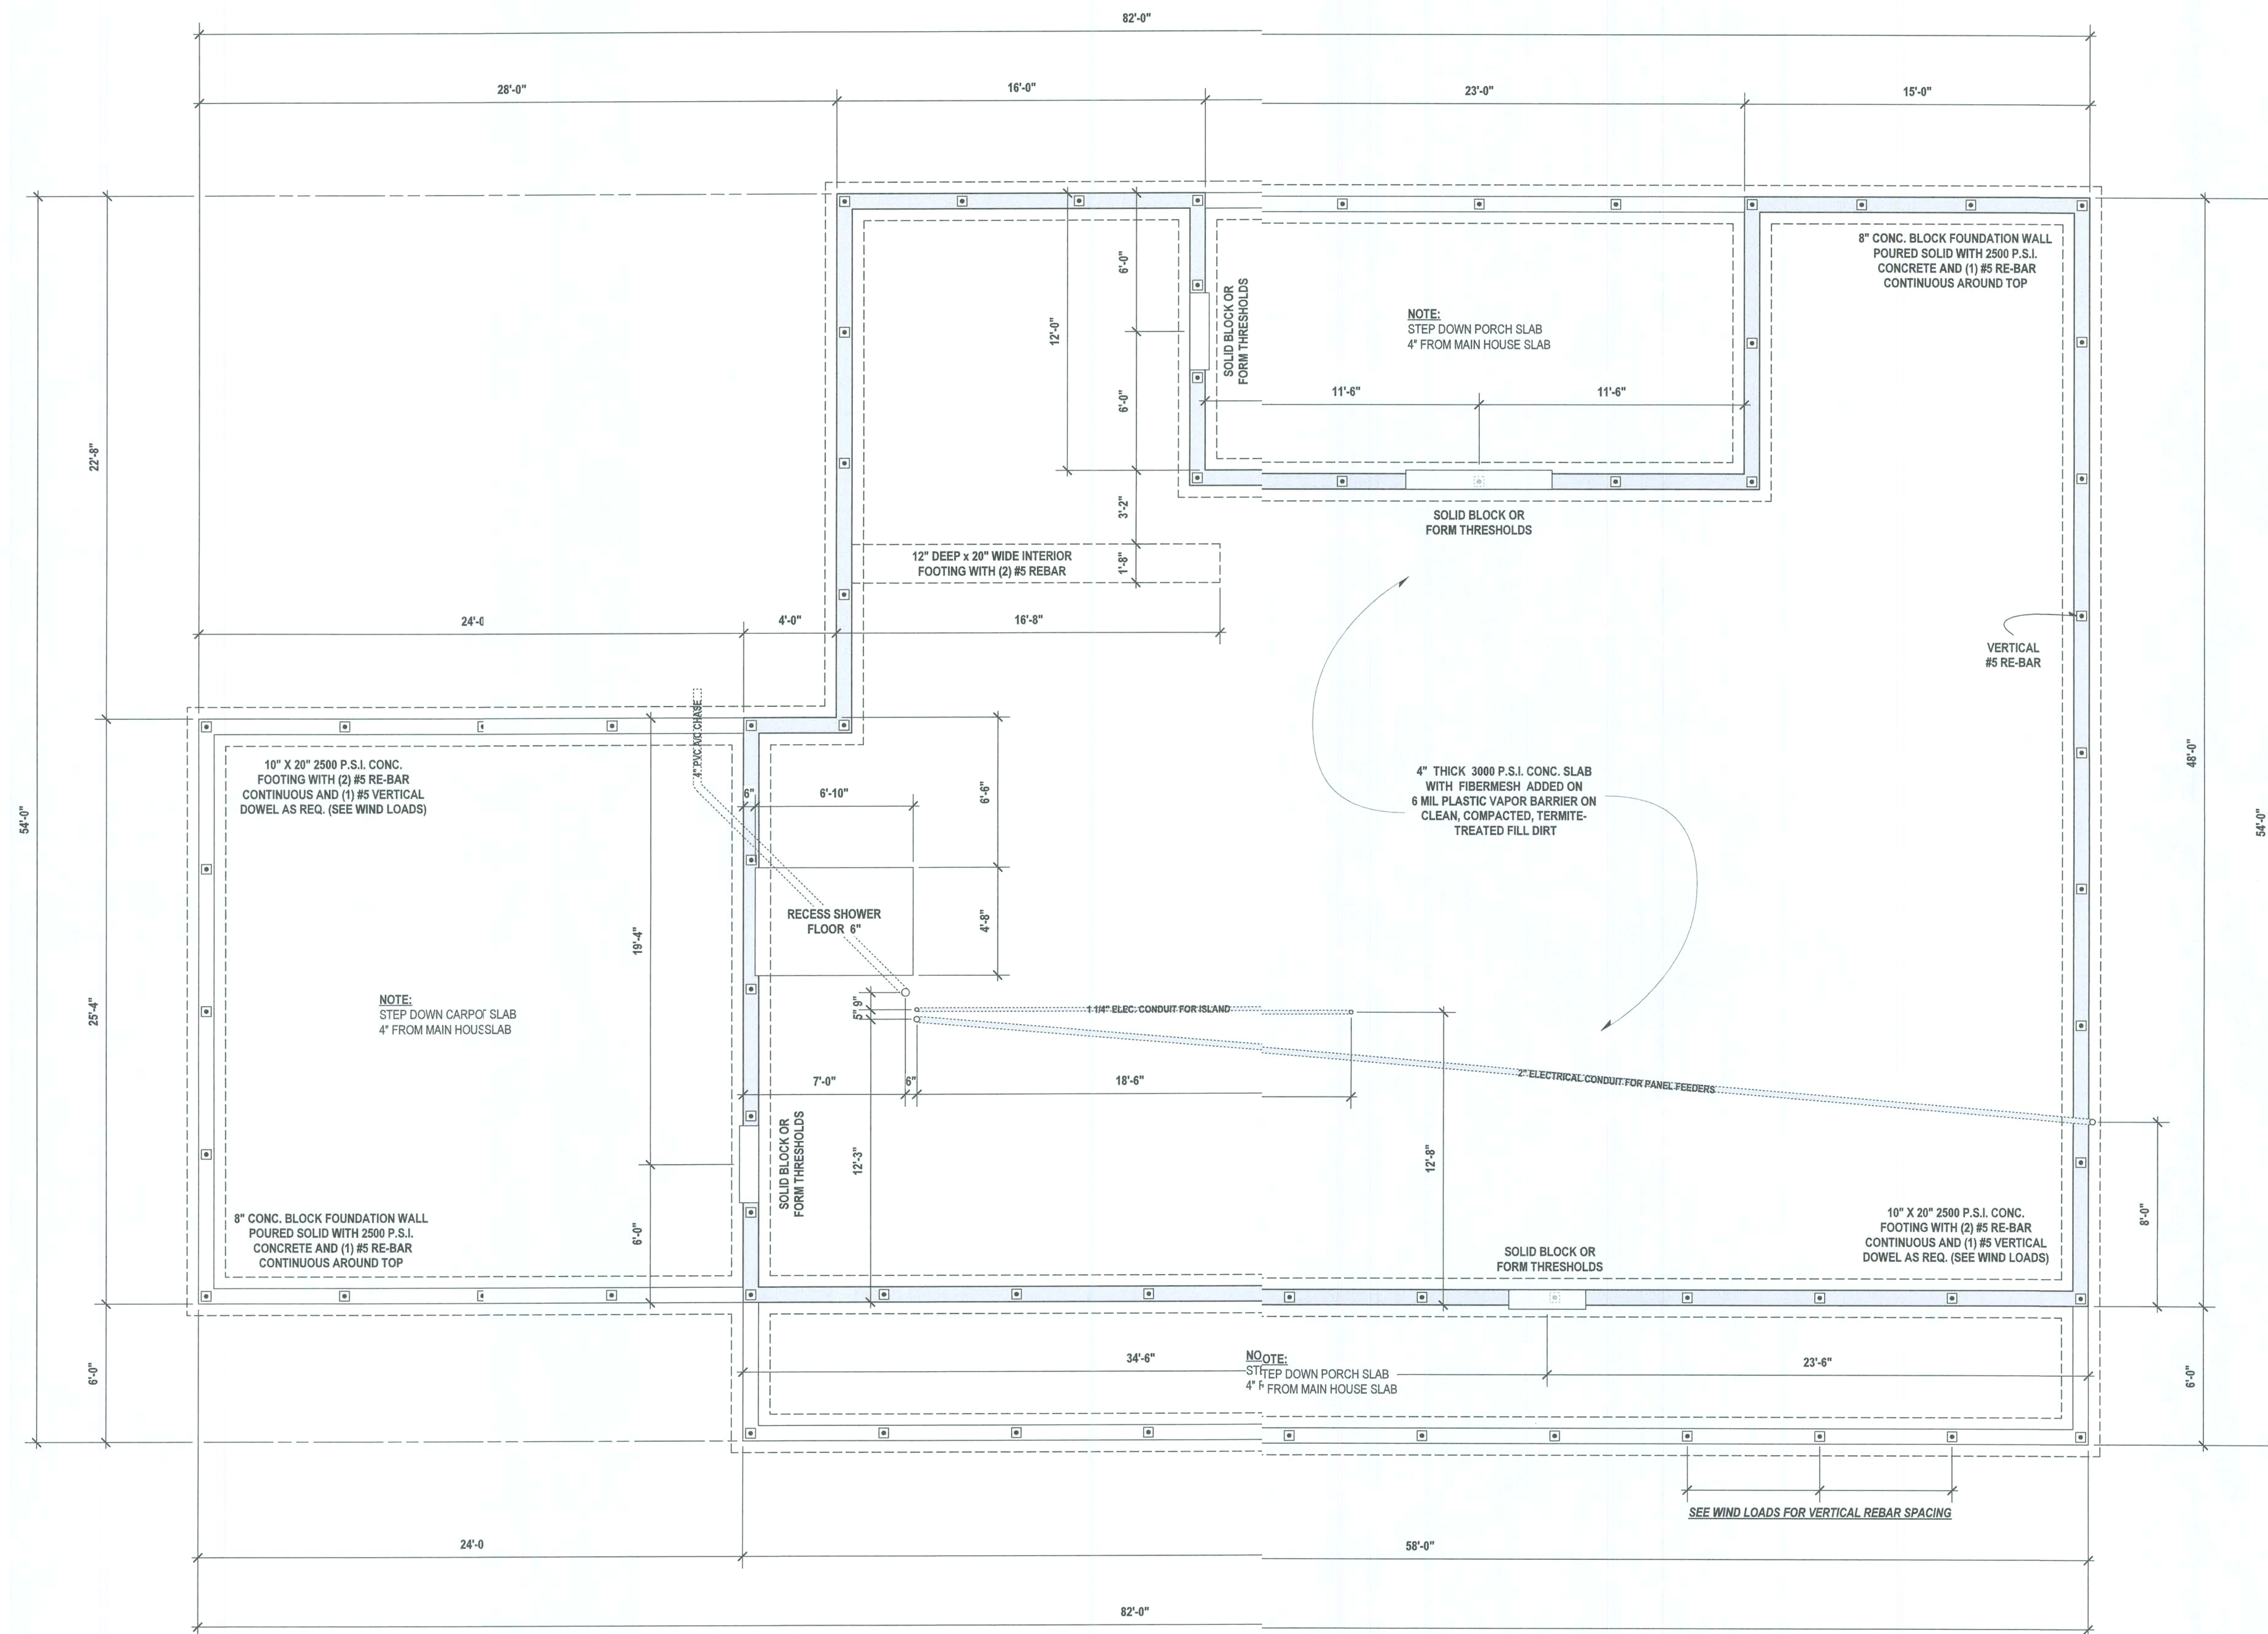

Note:
These Plans Shall Conform to
the 2017 Florida Building Code
(Sixth Edition) and all Local
Ordinances


DRAWN BY: _____

THE HART RESIDENCE

PROJECT NAME:

DATE: APR - 30 - 2020

4

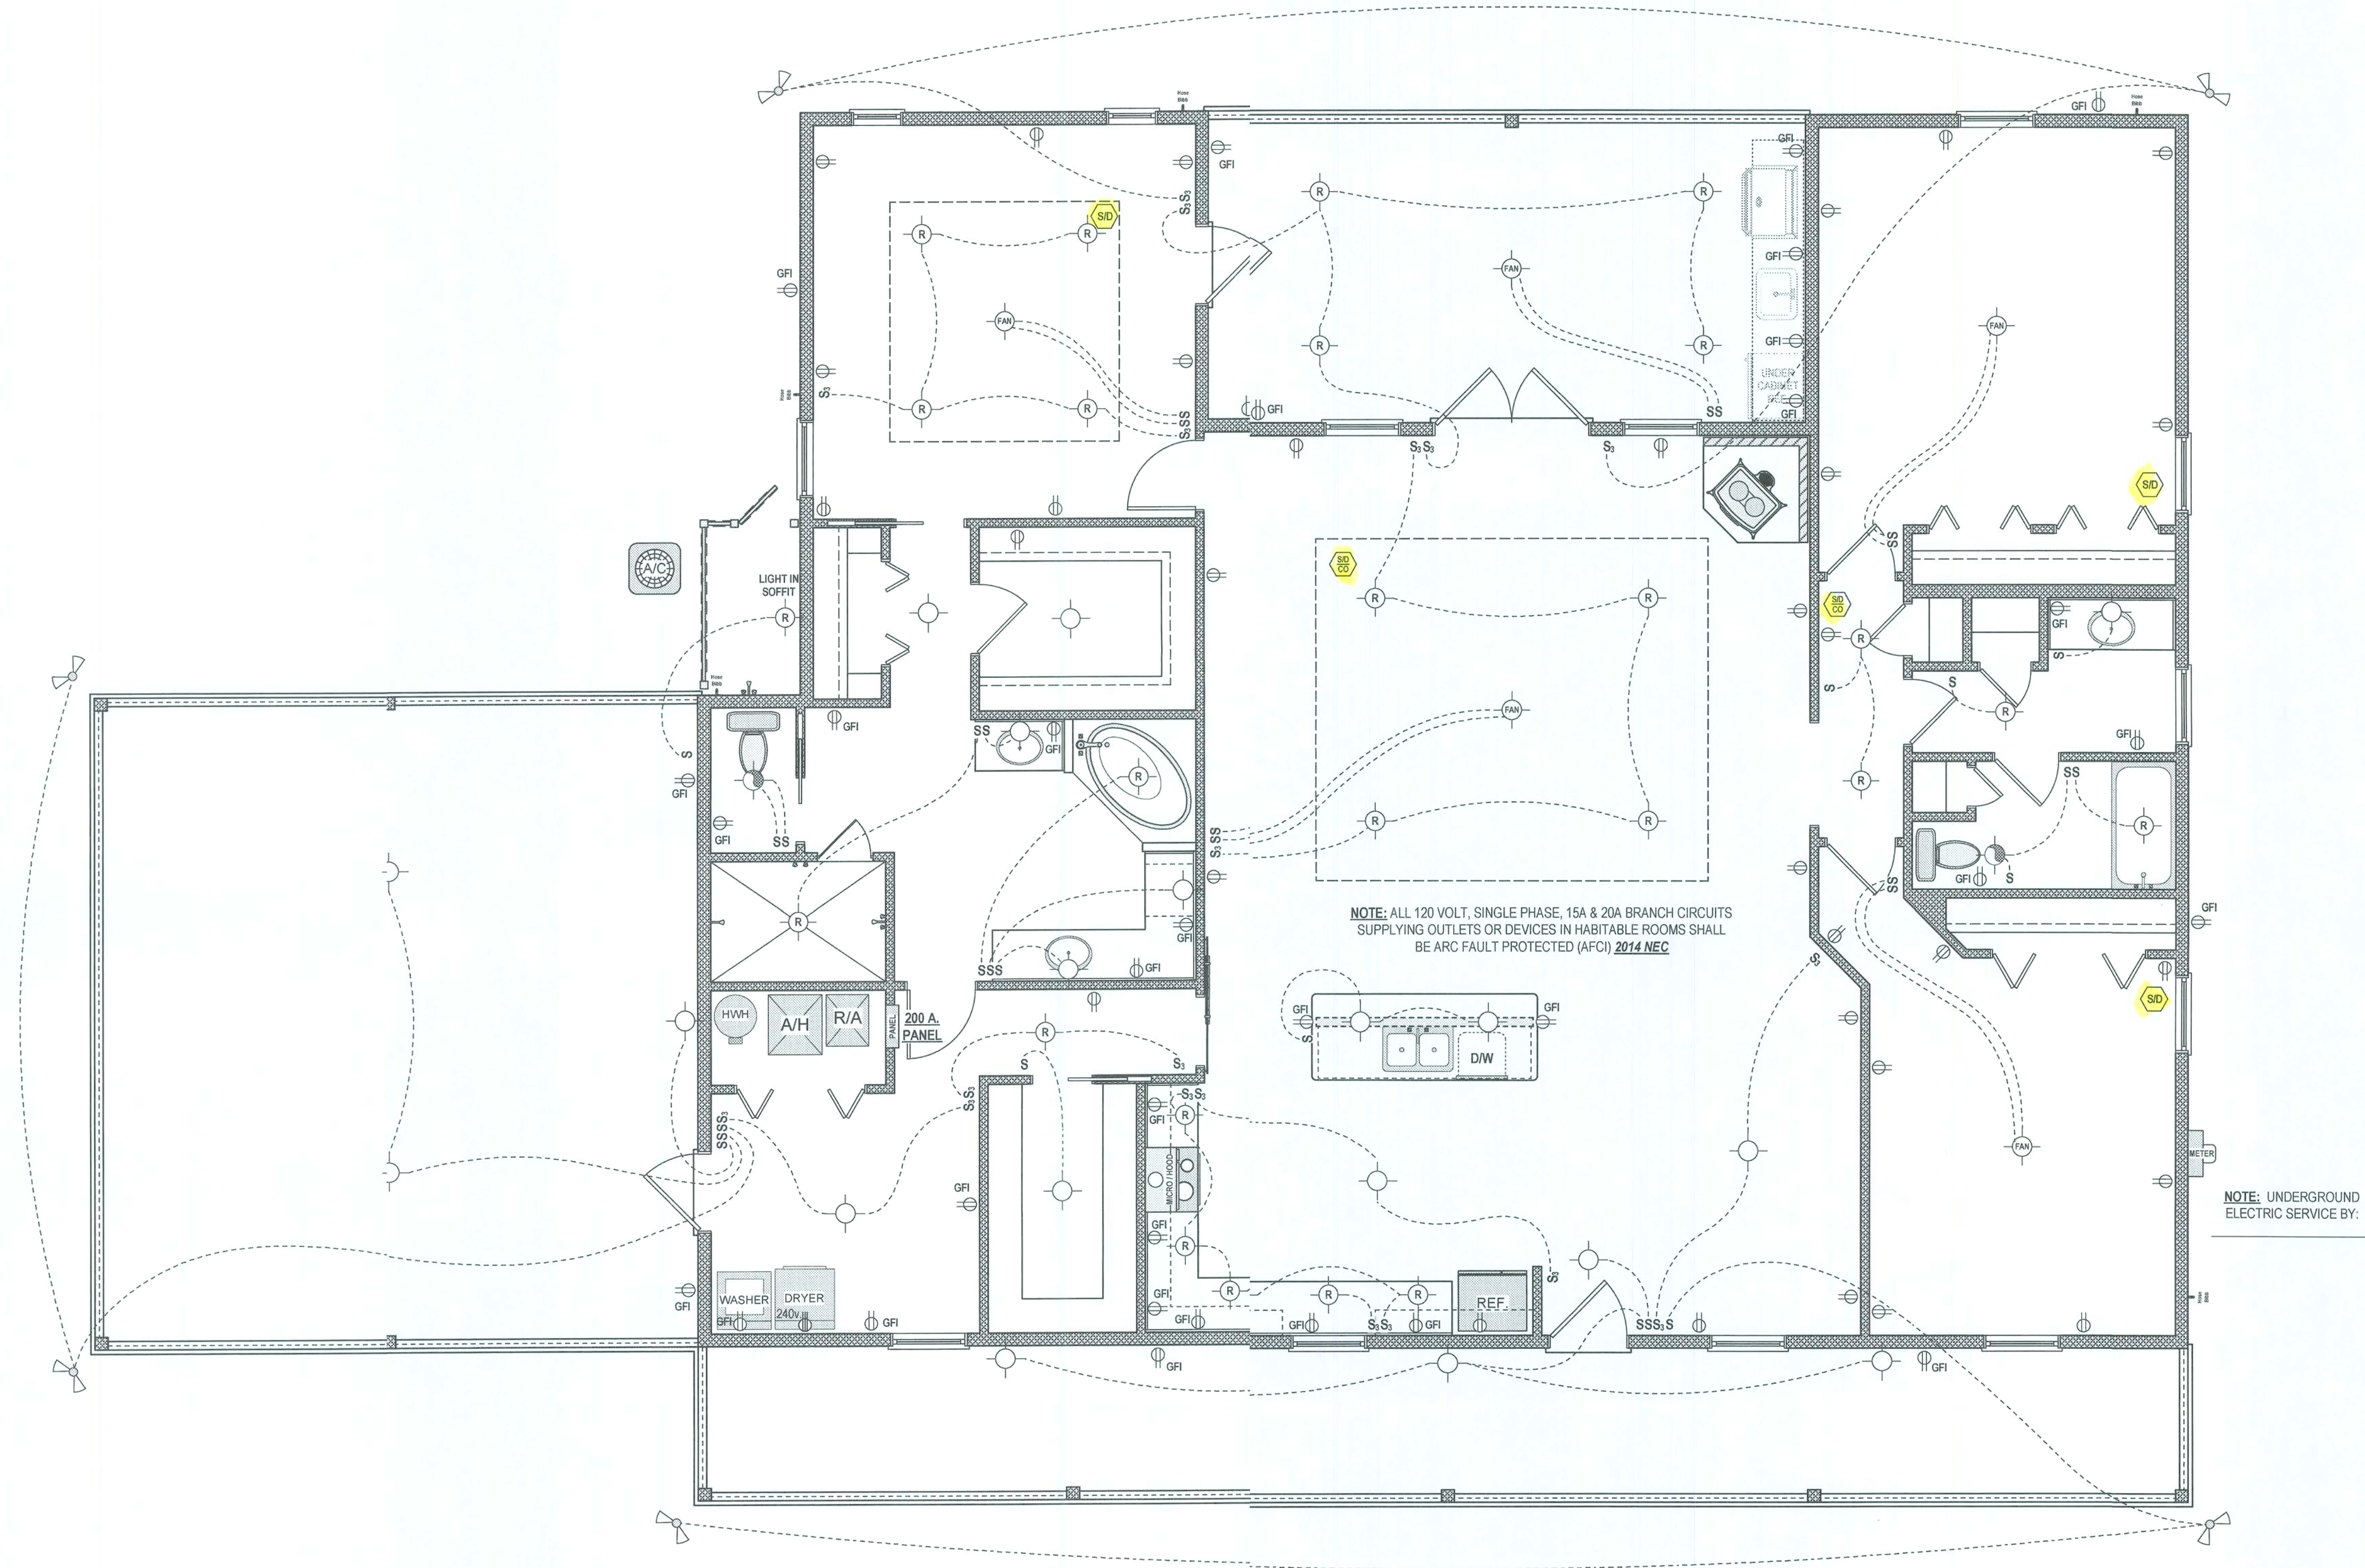

ELECTRICAL PLAN
1/4" = 1'-0"

SYMBOL LEGEND	
	120 v. Electrical Outlet
	240 v. Electrical Outlet
	Light Fixture
	Recessed Light Fixture
	Ceiling Fan Outlet
	Bathroom Exhaust Fan
	Exhaust Fan & Light
	Smoke Detector
	Smoke and Carbon Monoxide Detector
	Flood Light
	Light Switch
	3-Way Light Switch
	4-Way Light Switch
	Ground Fault Protected Electrical Outlet
	Electric Meter
	Circuit Breaker Panel

PROJECT NAME:
THE HART RESIDENCE
COLUMBIA COUNTY, FL

DATE:
APR - 30 - 2020

FILE #:
2417/3649T.HART

REVISION:
02-22-2020/001
03-15-2020/002
03-27-2020/003
03-31-2020/004


DESIGNED BY:
TRAVIS & LOGAN HART

DRAWN BY:
CEM

5

Note:
These Plans Shall Conform to
the 2017 Florida Building Code
(Sixth Edition) and all Local
Ordinances

It is the responsibility of the
Builder to Verify all Dimensions
and Room Slopes Prior to
Construction

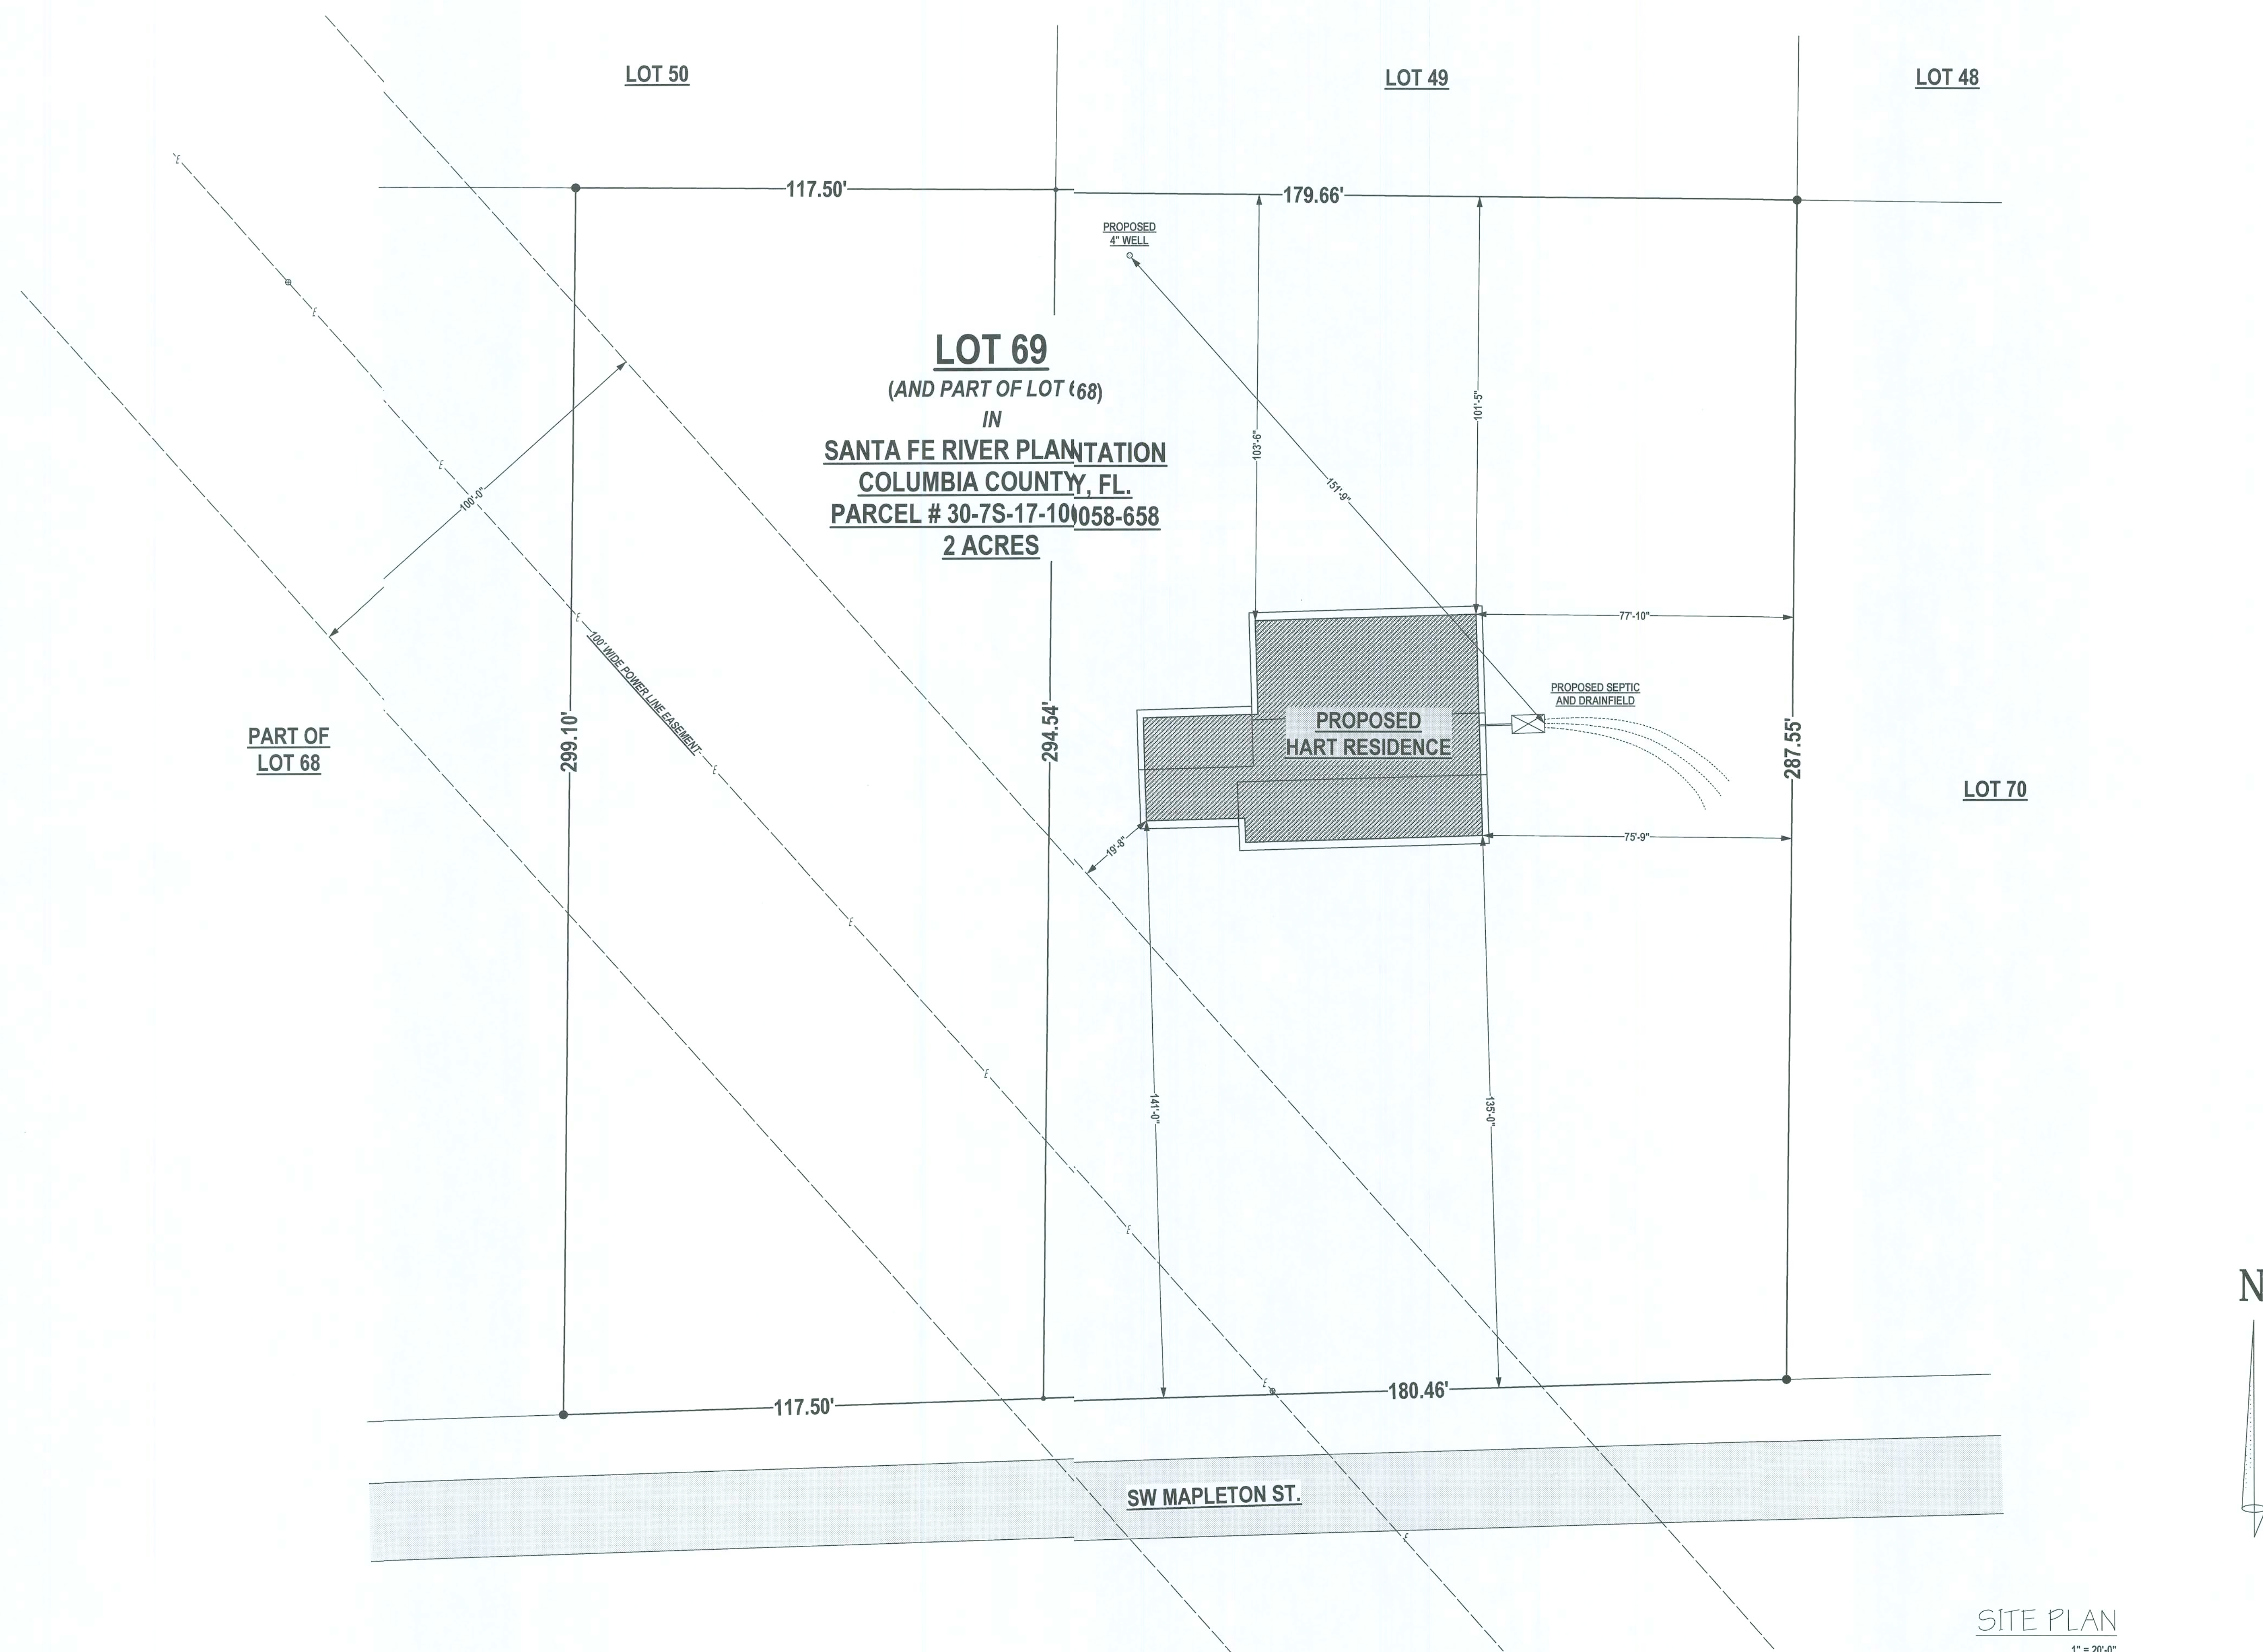

SITE PLAN
1" = 20'-0"

DATE:
APR - 30 - 2020

REVISION:
02-22-2020/001
03-15-2020/002
03-27-2020/003
03-27-2020/004

FILE #:
2417/3649T.HART

PROJECT NAME:
THE HART RESIDENCE
COLUMBIA COUNTY, FL

DRAWN BY:
CEM

DESIGNED BY:
TRAVIS & LOGAN HART

Note:
These Plans Shall Conform to
the 2017 Florida Building Code
(Sixth Edition) and all Local
Ordinances

It is the Responsibility of the
Builder to Verify all Dimensions
and Roof Slopes Prior to
Construction

6